

RELEASE FOR CONSTRUCTION
AS NOTED FOR PLAN REVIEW
DEVELOPMENT SERVICES
LEE'S SUMMIT, MISSOURI
07/25/2025



ELEVATION 1



ELEVATION 2

WINDOW SCHEDULE													
NUMBER	ROOM NAME	QTY	SIZE	DIMENSIONS	DESCRIPTION	FLOOR	EGRESS	TEMPERED	HEADER	AREA, STANDARD (SQ FT)	SHGC	U-FACTOR	3D EXT RIOR ELEV ATIO N
W01	BEDROOM	1	3040SG	36"X48"SG	SINGLE CASEMENT-HL	1	YES		2"X6"X40"	12	0.3	0.3	
W02	REC RM	2	3050DH	36"X60"DH	DOUBLE HUNG	1			2"X6"X40"	15	0.3	0.3	
TOTALS:										42			

DOOR SCHEDULE													
NUMBER	ROOM NAME	QTY	SIZE	DIMENSIONS	DESCRIPTION	FIRE	FLOOR	HEADER	AREA, STANDARD (SQ FT)	SHGC	U-FACTOR	3D EXT ER OR ELE VATI ON	
D01	BATH/HALL	1	2868 R IN	32"X80"X1 3/8" R IN	HINGED-DOOR P08		1	2"X6"X36 1/2"	17.18	0.3	0.3		
D02	BEDROOM/WATER HEATER	1	3068 R IN	36"X80"X1 3/8" R IN	HINGED-DOOR P08		1	2"X6"X40 1/2"	20	0.3	0.3		
D03	BEDROOM/HALL	1	3068 R IN	36"X80"X1 3/8" R IN	HINGED-DOOR P08		1	2"X6"X40 1/2"	20	0.3	0.3		
D04	MECHANICAL/HALL	1	3068 R IN	36"X80"X1 3/8" R IN	HINGED-DOOR P08		1	2"X6"X40 1/2"	20	0.3	0.3		
D05	BEDROOM/CLOSET	1	5068 L IN	(2) 31"X80"X1 3/8" L IN	SLIDER-DOOR P04		1	2"X8"X68"	33.33	0.3	0.3		
TOTALS:										111.11			


ELECTRICAL SCHEDULE					
2D SYMBOL	DESCRIPTION	FLOOR	QTY	ROOM NAME	ATTACHED TO
	CO/SMOKE DETECTOR	1	1	HALL	CEILING
	SMOKE DETECTOR	1	1	BEDROOM	CEILING

FIXTURE SCHEDULE							
NUMBER	LABEL	QTY	FLOOR	WIDTH	DEPTH	HEIGHT	DESCRIPTION
A01	OVAL SINK	1	1	20 13/16"	11 9/16"	10 1/4"	OVAL SINK
A02	SINGLE BASIN SINK	1	1	23"	22"	20 3/16"	SINGLE BASIN SINK
A03	STANDARD TOILET	1	1	20"	26 5/16"	29 9/16"	STANDARD TOILET
A04	TUB-SHOWER	1	1	60 1/4"	30 1/2"	74 9/16"	TUB-SHOWER
A05	WCR23 3/8"	1	1	23 3/8"	26 1/8"	33 1/8"	UNDERCOUNTER WINE CELLAR

CABINET SCHEDULE											
NUMBER	ROOM NAME	LABEL	QTY	FLOOR	WIDTH	DEPTH	HEIGHT	DESCRIPTION	3D ELE V/A TO N		
C01	BATH	SB4521	1	1	45"	21"	36"	BASE CABINET			
C03	REC RM	SB48	1	1	48"	24"	36"	BASE CABINET			
C04	REC RM	W2124	1	1	21"	12"	24"	WALL CABINET			
C05	REC RM	W4542	1	1	45"	12"	42"	WALL CABINET			

SCHEDULES

SCHEDULES

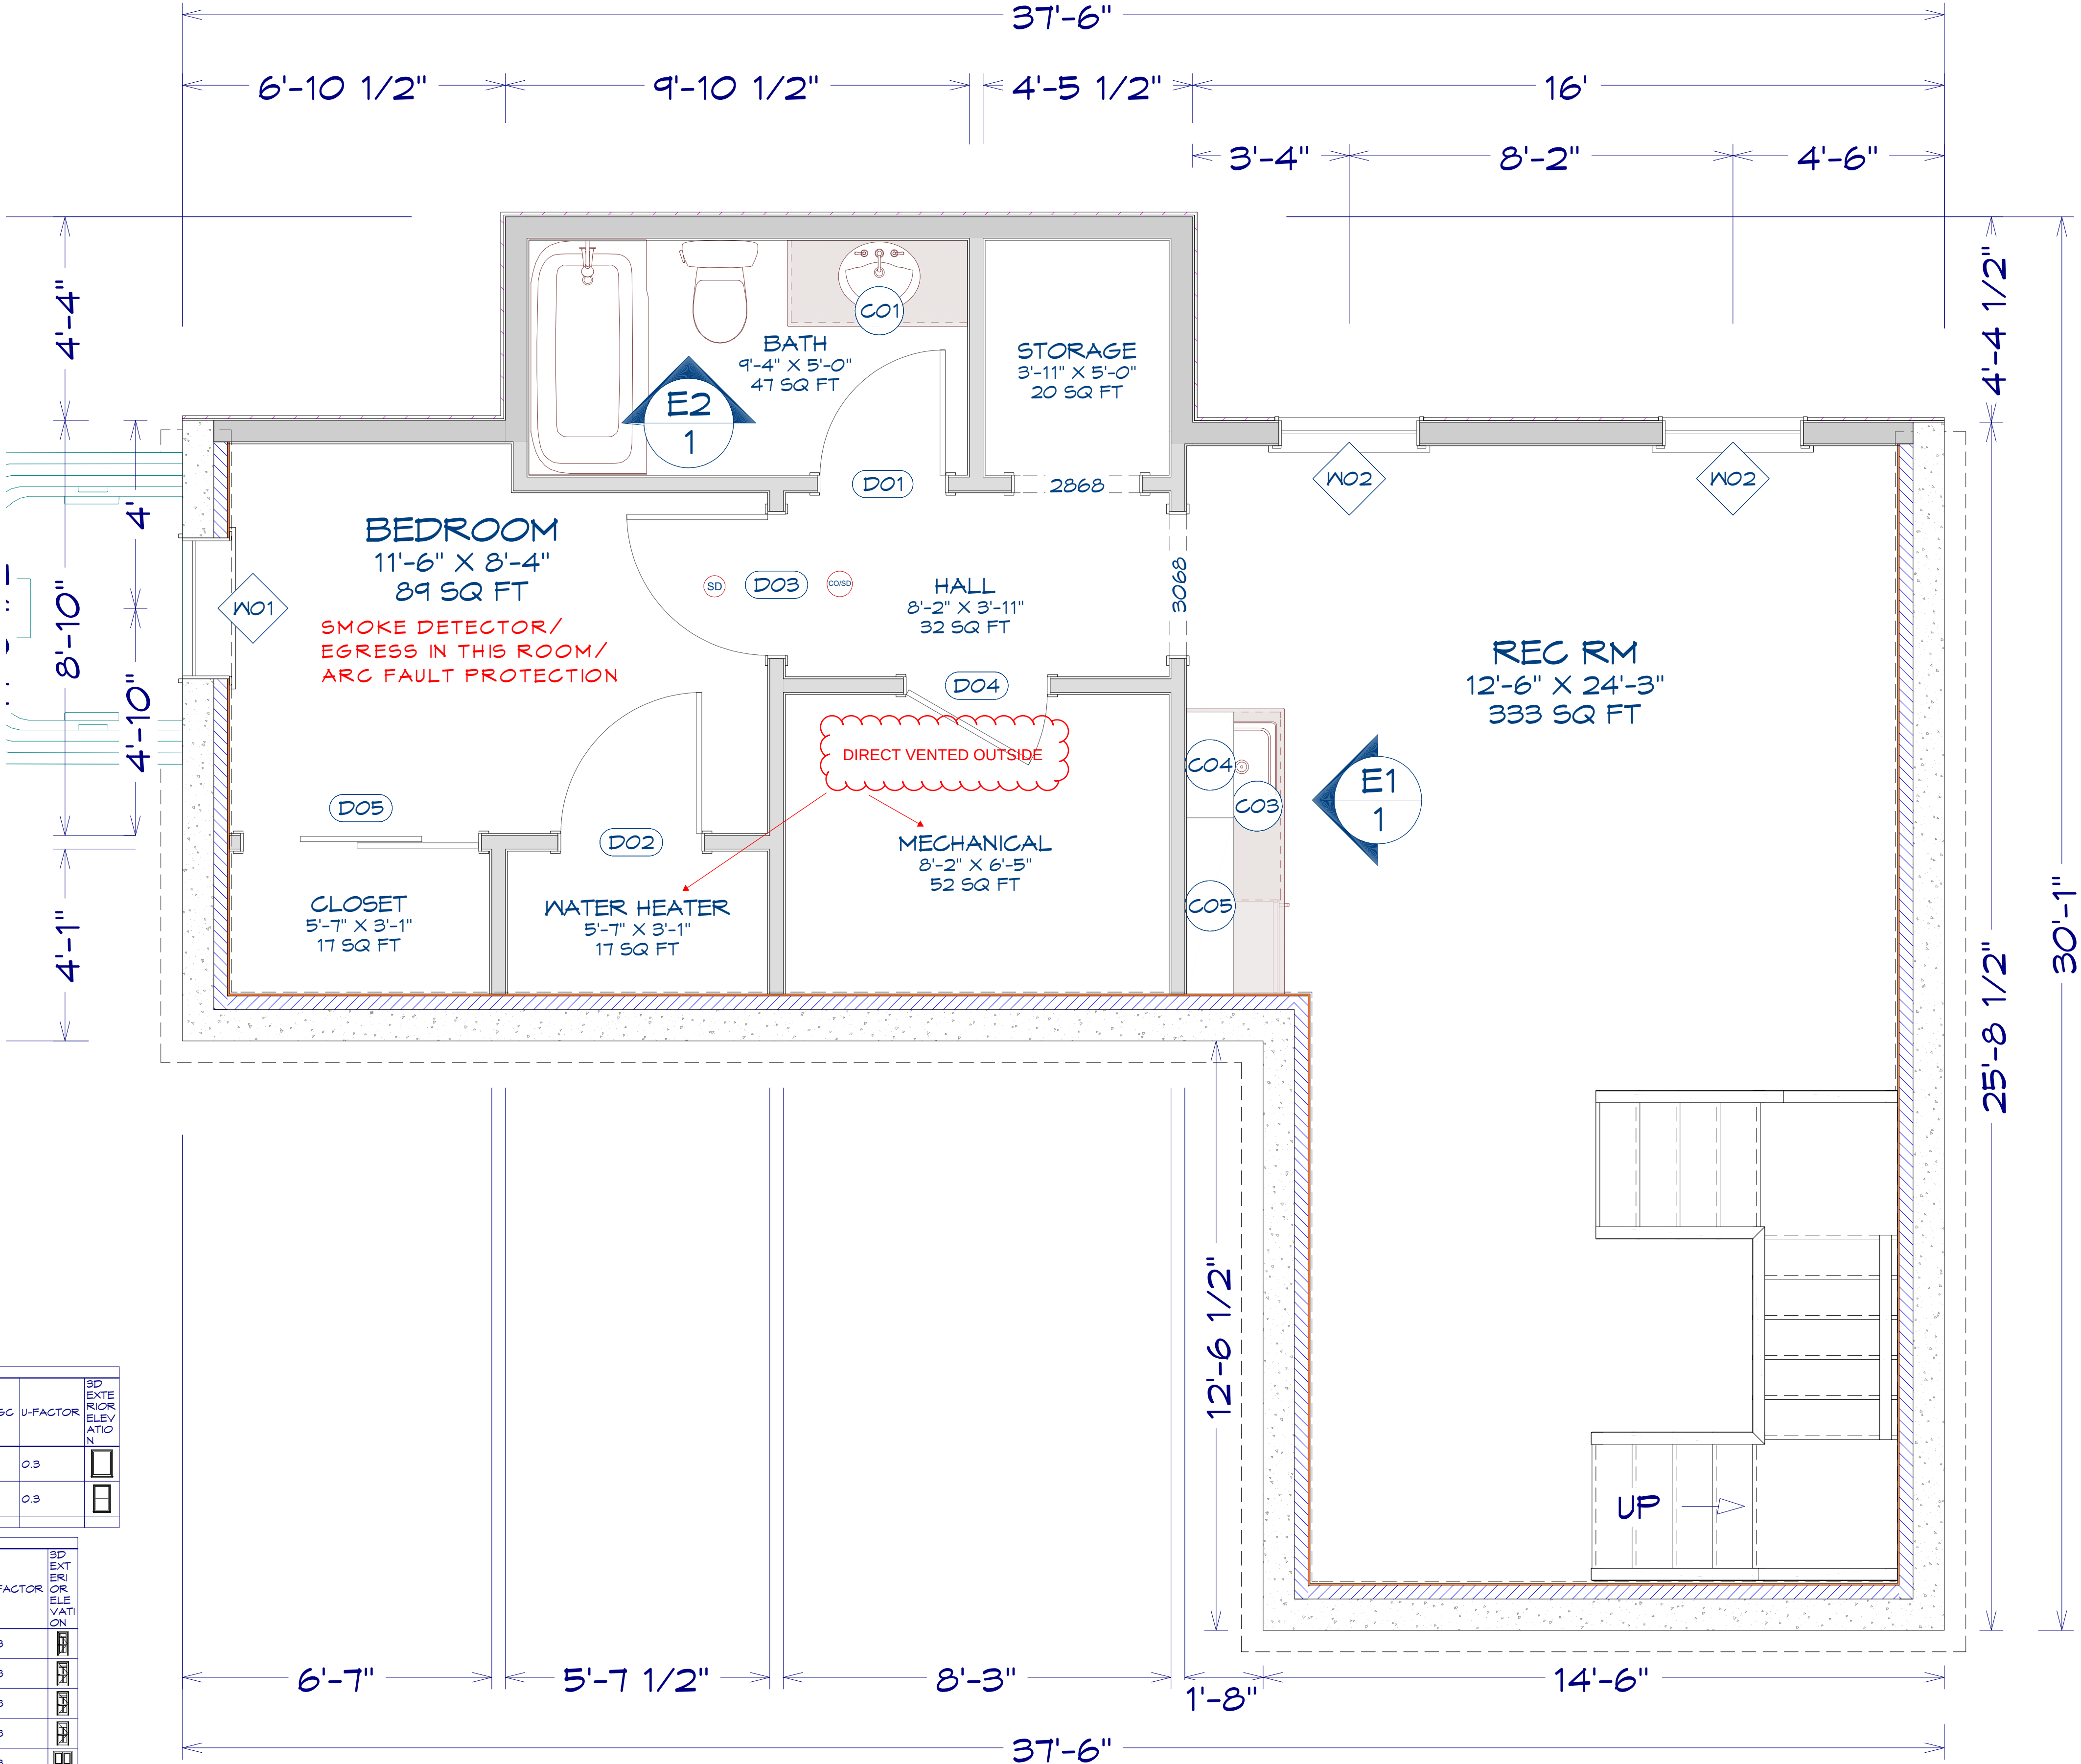

LIVING AREA
740 SQ FT

FINISHED PLAN VIEW

CODE ANALYSIS		
APPROVAL SIGNATURES:		
1.)	2.)	3.)
PROJECT DESCRIPTION:		
FINISHED BASEMENT		
CONTRACTOR:		
CLIENT INFORMATION:		
DRAWINGS PROVIDED BY:		
DATE:		
7/10/2025		
SCALE:		
1/2"=1'		
SHEET:		
1		