


RELEASED FOR CONSTRUCTION
As Noted on Plan Review

Lee's Summit Fire Department
Lee's Summit, Missouri
12/09/2025

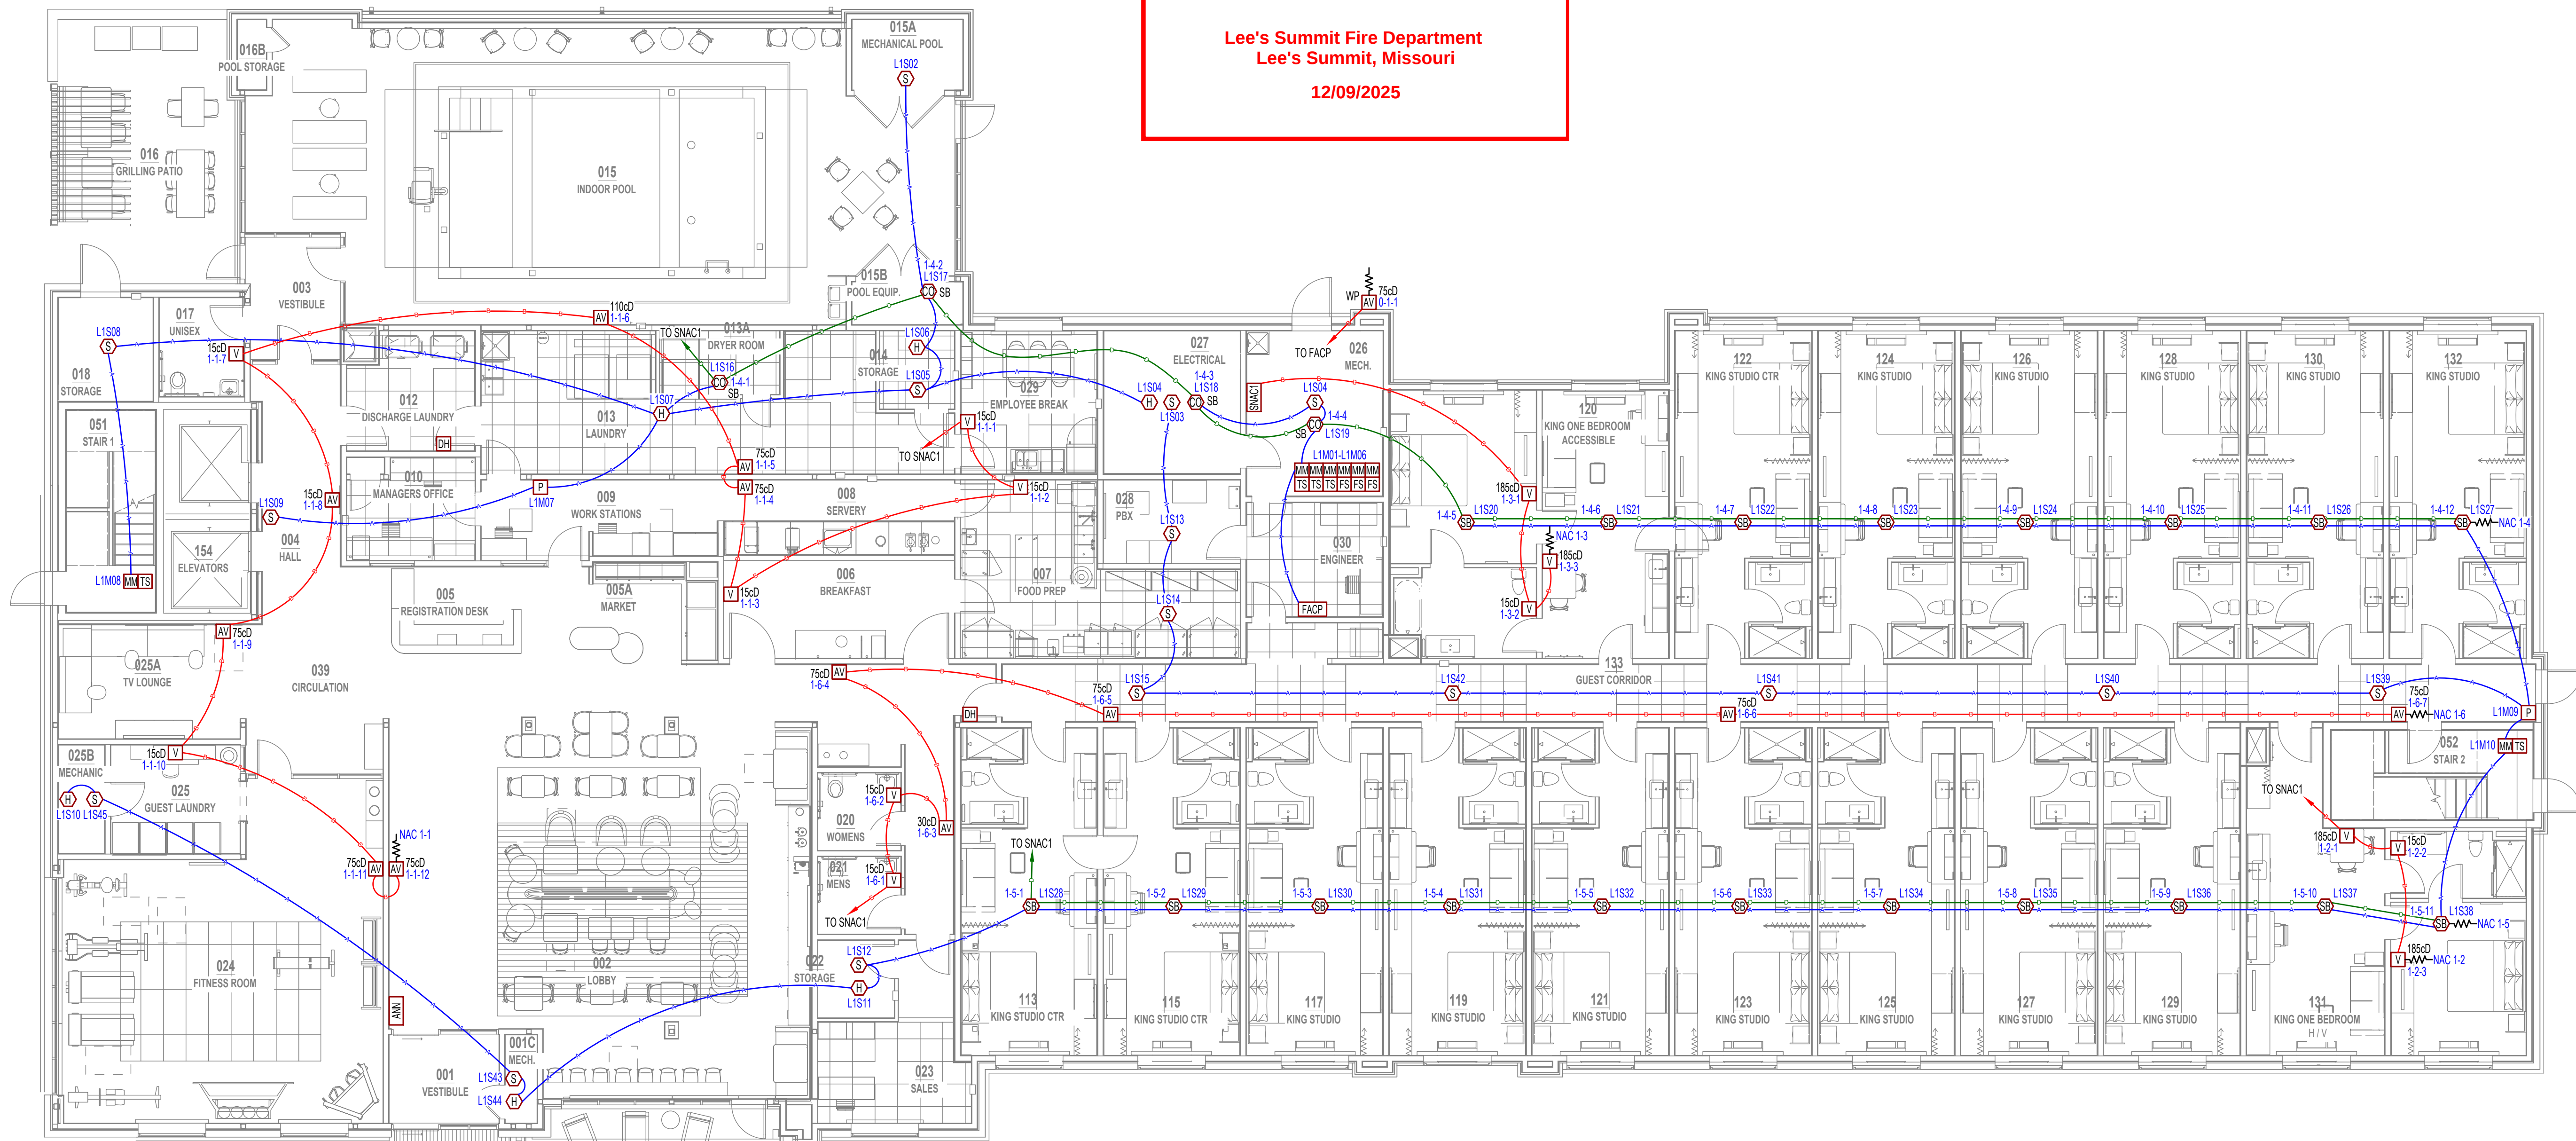


FIRST FLOOR FIRE ALARM PLAN
SCALE : 1/8" = 1'-0"

GENERAL NOTES

- CORRIDOR SMOKE DETECTORS SHALL BE SPACED MAXIMUM 30 FEET APART. PROVIDE ADDITIONAL DETECTORS IF NECESSARY TO MAINTAIN MAXIMUM SPACING DUE TO CEILING CONSTRUCTION.
- IF FIRE SPRINKLER HEAD(S) ARE INSTALLED IN THE ELEVATOR SHAFT, INSTALL A HEAT DETECTOR LOCATED WITHIN 2 FT FOR ACTIVATION OF THE SHUNT-TRIP DISCONNECT IN ACCORDANCE WITH ASME A17.1 ELEVATOR CODE.
- IF THE ELEVATOR SHAFT CONTAINS COMBUSTIBLE MATERIALS OR FLAMMABLE HYDRAULIC FLUIDS, INSTALL A SMOKE DETECTOR AT THE TOP OF THE SHAFT TO INITIATE PHASE I RECALL IN ACCORDANCE WITH ASME A17.1 ELEVATOR CODE.

WIRE KEY:

TAG	CABLE	DESCRIPTION
A	182 TWISTED FPLP	ADDRESSABLE "SLC" CIRCUIT
B	14/2 FPLP	"NAC" HORN/STROBE CIRCUIT
C	18/4 FPLP	ANNUNCIATOR CIRCUIT
D	14/2 FPLP	SOUNDER BASE POWER CIRCUIT
E	18/2 FPLP	CARBON MONOXIDE DETECTOR POWER CIRCUIT
F	14/2 FPLP	DOOR HOLDER CIRCUIT

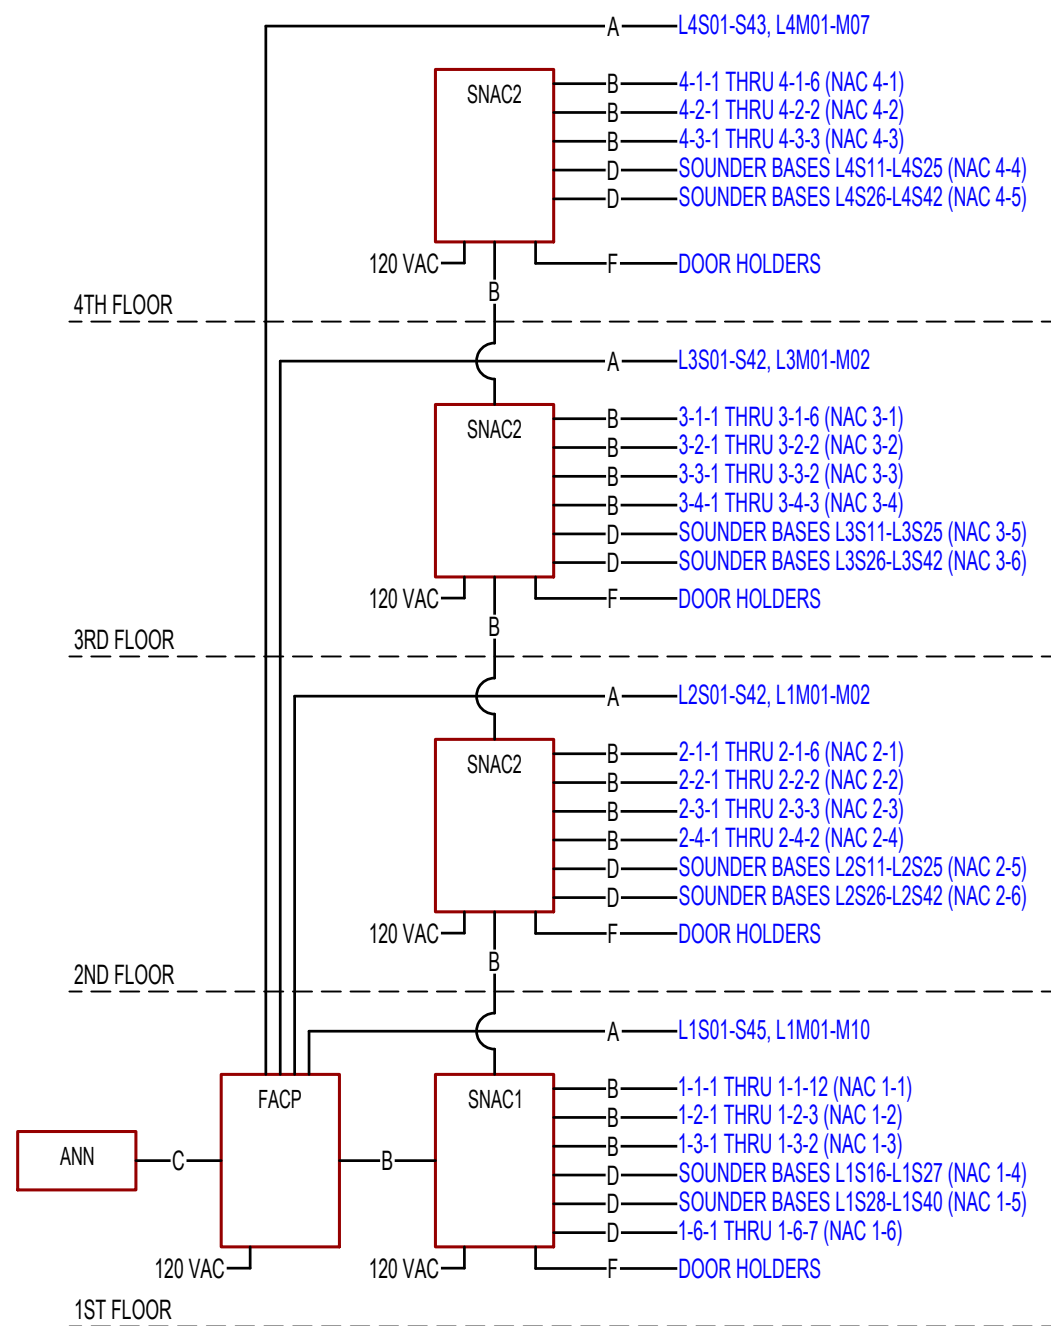

FIRE ALARM RISER DIAGRAM

SYMBOL KEY:

SYMBOL	DESCRIPTION
FACP	FIRE ALARM CONTROL PANEL
ANN	REMOTE ANNUNCIATOR PANEL
SNAC	POWER SUPPLY
P	PULL STATION - DOUBLE ACTION
S	SMOKE DETECTOR
SB	SMOKE DETECTOR WITH LOW FREQUENCY SOUNDER BASE
H	HEAT DETECTOR
CO	CARBON MONOXIDE DETECTOR WITH SOUNDER BASE
RM	ADDRESSABLE RELAY MODULE
MM	ADDRESSABLE SINGLE MONITOR MODULE
DH	DOOR HOLDER
AV	HORN-STROBE, CEILING MOUNT, WHITE, MULTI-CANDELA
V	STROBE, CEILING-MOUNT, WHITE, MULTI-CANDELA
AV WP	WEATHERPROOF SPRINKLER HORN/STROBE, WALL-MOUNT, RED WITH INCLUDED BACKBOX
FS	SPRINKLER WATER FLOW SWITCH
TS	SPRINKLER VALVE TAMPER SWITCH

DRAWINGS ARE THE PROPERTY OF
TIMBERLAKE ENGINEERING AND MAY NOT BE COPIED OR USED
IN WHOLE OR PART WITHOUT THE WRITTEN PERMISSION
OF TIMBERLAKE ENGINEERING.

DO NOT SCALE THIS DRAWING.
SOME DEVIATION FROM SCALE MAY OCCUR.

ISSUE TITLE	DATE

Midwest
electronic systems, inc.
2000 Forum Blvd. #6
Columbia, MO 65203
(573) 443-5343

THE PROFESSIONAL ENGINEER'S SEAL ON THIS DRAWING
HAS BEEN AFFIXED IN ACCORDANCE WITH
THE REQUIREMENTS OF CHAPTER 327, RSMO.
IN AFFIXING THIS SEAL, THE ENGINEER TAKES
RESPONSIBILITY FOR THE WORK SHOWN
ON THIS DRAWING ONLY, AND HEREBY DISCLAIMS
ANY AND ALL RESPONSIBILITY FOR OTHER
PROJECT DRAWINGS NOT DIRECTLY BEARING THIS SEAL.



Russell Vinson, P.E.
2011015810
MO Certificate of Authority #000239



A Custom Engineering Company
912 Old 63 South Columbia, MO 65201
ph: 573.875.4365

PROJECT No. COL25399 DESIGNED BY RVN
DRAWN BY RAV CHECKED BY RAV

PROJECT
**HOME 2 SUITES
BY HILTON**
Village at Discovery Park Lot 2
Lee's Summit, MO

SHEET TITLE
FIRST FLOOR FIRE ALARM PLAN

SHEET NUMBER
FA1

ISSUE TITLE	DATE

Midwest
electronic systems, inc.
2000 Forum Blvd. #6
Columbia, MO 65203
(573) 443-5343



SECOND FLOOR FIRE ALARM PLAN


SCALE : 1/8" = 1'-0"

GENERAL NOTES

- CORRIDOR SMOKE DETECTORS SHALL BE SPACED MAXIMUM 30 FEET APART. PROVIDE ADDITIONAL DETECTORS IF NECESSARY TO MAINTAIN MAXIMUM SPACING DUE TO CEILING CONSTRUCTION.
- IF FIRE SPRINKLER HEAD(S) ARE INSTALLED IN THE ELEVATOR SHAFT, INSTALL A HEAT DETECTOR LOCATED WITHIN 2 FT FOR ACTIVATION OF THE SHUNT-TRIP DISCONNECT IN ACCORDANCE WITH ASME A17.1 ELEVATOR CODE.
- IF THE ELEVATOR SHAFT CONTAINS COMBUSTIBLE MATERIALS OR FLAMMABLE HYDRAULIC FLUIDS, INSTALL A SMOKE DETECTOR AT THE TOP OF THE SHAFT TO INITIATE PHASE I RECALL IN ACCORDANCE WITH ASME A17.1 ELEVATOR CODE.

WIRE KEY:

TAG	CABLE	DESCRIPTION
A	182 TWISTED FPLP	ADDRESSABLE "SLC" CIRCUIT
B	14/2 FPLP	"NAC" HORN/STROBE CIRCUIT
C	18/4 FPLP	ANNUNCIATOR CIRCUIT
D	14/2 FPLP	SOUNDER BASE POWER CIRCUIT
E	18/2 FPLP	CARBON MONOXIDE DETECTOR POWER CIRCUIT
F	14/2 FPLP	DOOR HOLDER CIRCUIT

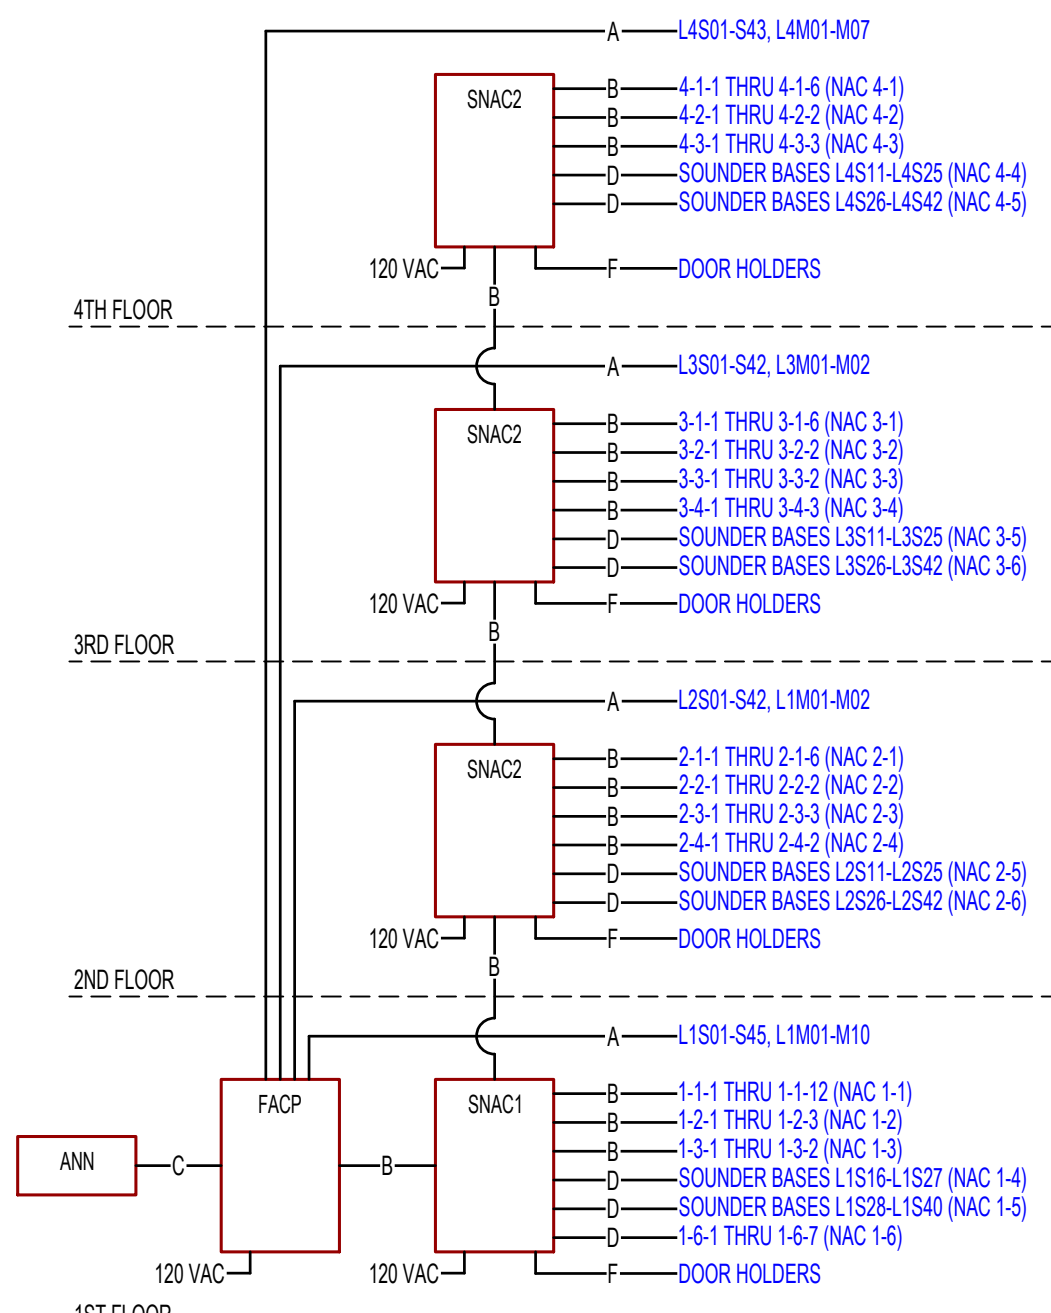

FIRE ALARM RISER DIAGRAM

SYMBOL KEY:

SYMBOL	DESCRIPTION
FACP	FIRE ALARM CONTROL PANEL
ANN	REMOTE ANNUNCIATOR PANEL
SNAC	POWER SUPPLY
P	PULL STATION - DOUBLE ACTION
S	SMOKE DETECTOR
SS	SMOKE DETECTOR WITH LOW FREQUENCY SOUNDER BASE
H	HEAT DETECTOR
CD	CARBON MONOXIDE DETECTOR WITH SOUNDER BASE
RM	ADDRESSABLE RELAY MODULE
MM	ADDRESSABLE SINGLE MONITOR MODULE
DH	DOOR HOLDER
AV	HORN-STROBE, CEILING MOUNT, WHITE, MULTI-CANDELA
V	STROBE, CEILING-MOUNT, WHITE, MULTI-CANDELA
AVWP	WEATHERPROOF SPRINKLER HORN/STROBE, WALL-MOUNT, RED WITH INCLUDED BACKBOX
FS	SPRINKLER WATER FLOW SWITCH
TS	SPRINKLER VALVE TAMPER SWITCH

THE PROFESSIONAL ENGINEER'S SEAL ON THIS DRAWING
HAS BEEN AFFIXED IN ACCORDANCE WITH
THE REQUIREMENTS OF CHAPTER 327, RSMO.
IN AFFIXING THIS SEAL, THE ENGINEER TAKES
RESPONSIBILITY FOR THE WORK SHOWN
ON THIS DRAWING ONLY, AND HEREBY DISCLAIMS
ANY AND ALL RESPONSIBILITY FOR OTHER
PROJECT DRAWINGS NOT DIRECTLY BEARING THIS SEAL.



Russell Vinson, P.E.
2011015810
MO Certificate of Authority #000239



A Custom Engineering Company

912 Old 63 South Columbia, MO 65201
ph: 573.875.4365

PROJECT No. COL25399 DESIGNED BY RVN
DRAWN BY RAV CHECKED BY RAV



PROJECT
**HOME 2 SUITES
BY HILTON**
Village at Discovery Park Lot 2
Lee's Summit, MO

SHEET TITLE
**SECOND FLOOR FIRE ALARM
PLAN**

SHEET NUMBER
FA2

ISSUE TITLE	DATE

 Midwest
electronic systems, inc.
2000 Forum Blvd. #6
Columbia, MO 65203
(573) 443-5343

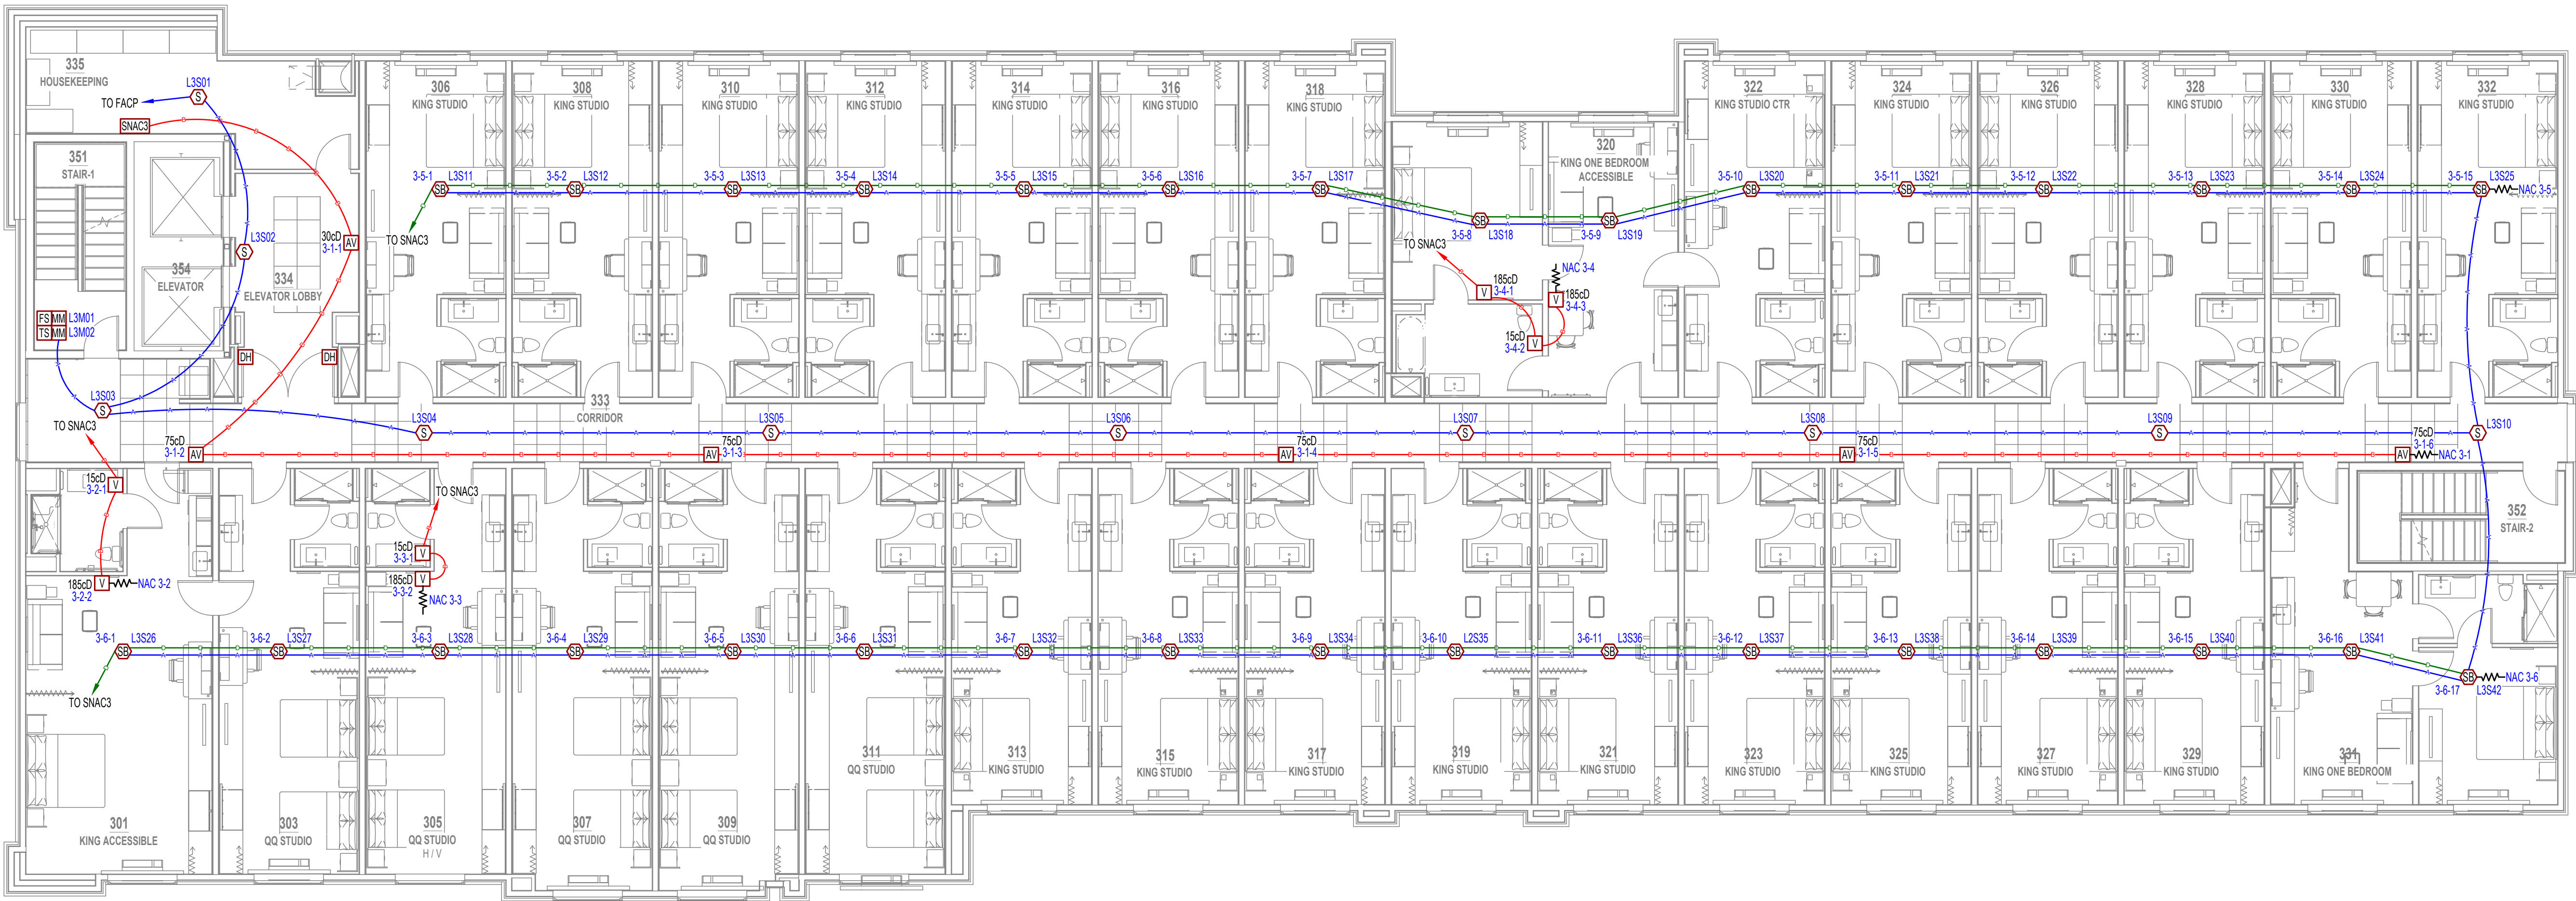


THIRD FLOOR FIRE ALARM PLAN
SCALE : 1/8" = 1'-0"

GENERAL NOTES

- CORRIDOR SMOKE DETECTORS SHALL BE SPACED MAXIMUM 30 FEET APART. PROVIDE ADDITIONAL DETECTORS IF NECESSARY TO MAINTAIN MAXIMUM SPACING DUE TO CEILING CONSTRUCTION.
- IF FIRE SPRINKLER HEAD(S) ARE INSTALLED IN THE ELEVATOR SHAFT, INSTALL A HEAT DETECTOR LOCATED WITHIN 2 FT FOR ACTIVATION OF THE SHUNT-TRIP DISCONNECT IN ACCORDANCE WITH ASME A17.1 ELEVATOR CODE.
- IF THE ELEVATOR SHAFT CONTAINS COMBUSTIBLE MATERIALS OR FLAMMABLE HYDRAULIC FLUIDS, INSTALL A SMOKE DETECTOR AT THE TOP OF THE SHAFT TO INITIATE PHASE I RECALL IN ACCORDANCE WITH ASME A17.1 ELEVATOR CODE.

WIRE KEY:

TAG	CABLE	DESCRIPTION
A	182 TWISTED FPLP	ADDRESSABLE "SLC" CIRCUIT
B	14/2 FPLP	"NAC" HORN/STROBE CIRCUIT
C	184 FPLP	ANNUNCIATOR CIRCUIT
D	14/2 FPLP	SOUNDER BASE POWER CIRCUIT
E	182 FPLP	CARBON MONOXIDE DETECTOR POWER CIRCUIT
F	14/2 FPLP	DOOR HOLDER CIRCUIT

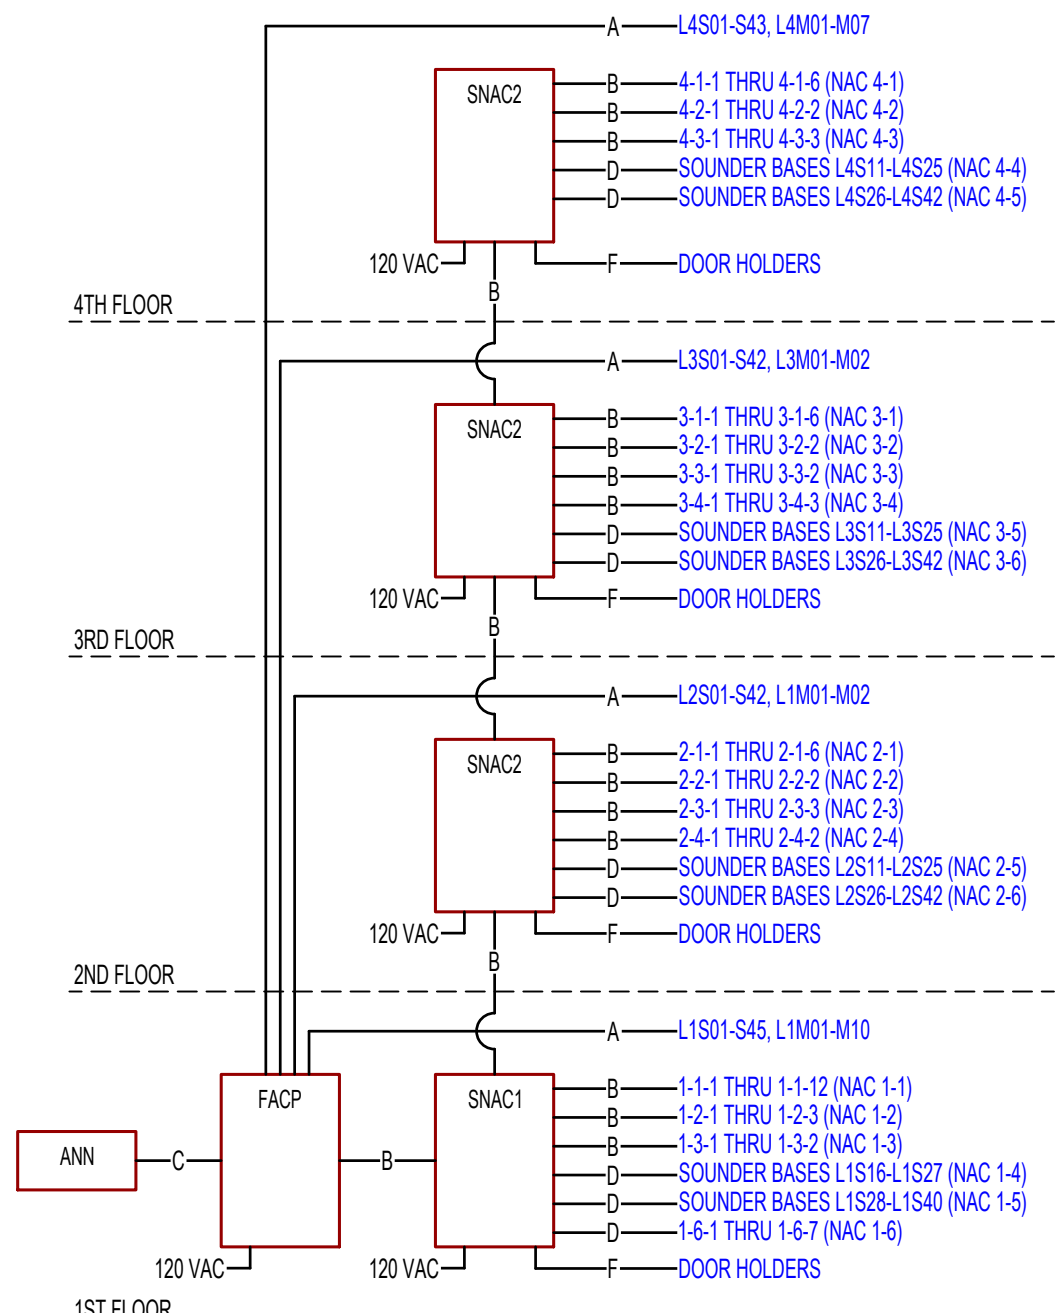

FIRE ALARM RISER DIAGRAM

SYMBOL KEY:

SYMBOL	DESCRIPTION
	FIRE ALARM CONTROL PANEL
	REMOTE ANNUNCIATOR PANEL
	POWER SUPPLY
	PULL STATION - DOUBLE ACTION
	SMOKE DETECTOR
	SMOKE DETECTOR WITH LOW FREQUENCY SOUNDER BASE
	HEAT DETECTOR
	CARBON MONOXIDE DETECTOR WITH SOUNDER BASE
	ADDRESSABLE RELAY MODULE
	ADDRESSABLE SINGLE MONITOR MODULE
	DOOR HOLDER
	HORN-STROBE, CEILING MOUNT, WHITE, MULTI-CANDELA
	STROBE, CEILING-MOUNT, WHITE, MULTI-CANDELA
	WEATHERPROOF SPRINKLER HORN/STROBE, WALL-MOUNT, RED WITH INCLUDED BACKBOX
	SPRINKLER WATER FLOW SWITCH
	SPRINKLER VALVE TAMPER SWITCH

THE PROFESSIONAL ENGINEER'S SEAL ON THIS DRAWING
HAS BEEN AFFIXED IN ACCORDANCE WITH
THE REQUIREMENTS OF CHAPTER 327, RSMO.
IN AFFIXING THIS SEAL, THE ENGINEER TAKES
RESPONSIBILITY FOR THE WORK SHOWN
ON THIS DRAWING ONLY, AND HEREBY DISCLAIMS
ANY AND ALL RESPONSIBILITY FOR OTHER
PROJECT DRAWINGS NOT DIRECTLY BEARING THIS SEAL.



Russell Vinson, P.E.
2011015810
MO Certificate of Authority #000239



A Custom Engineering Company

912 Old 63 South Columbia, MO 65201
ph: 573.875.4365

PROJECT No. COL25399 DESIGNED BY RVN
DRAWN BY RAV CHECKED BY RAV



PROJECT
**HOME 2 SUITES
BY HILTON**
Village at Discovery Park Lot 2
Lee's Summit, MO

SHEET TITLE
THIRD FLOOR FIRE ALARM PLAN

SHEET NUMBER
FA3

ISSUE TITLE	DATE

Midwest
electronic systems, inc.
2000 Forum Blvd. #6
Columbia, MO 65203
(573) 443-5343

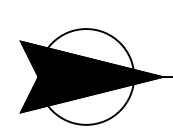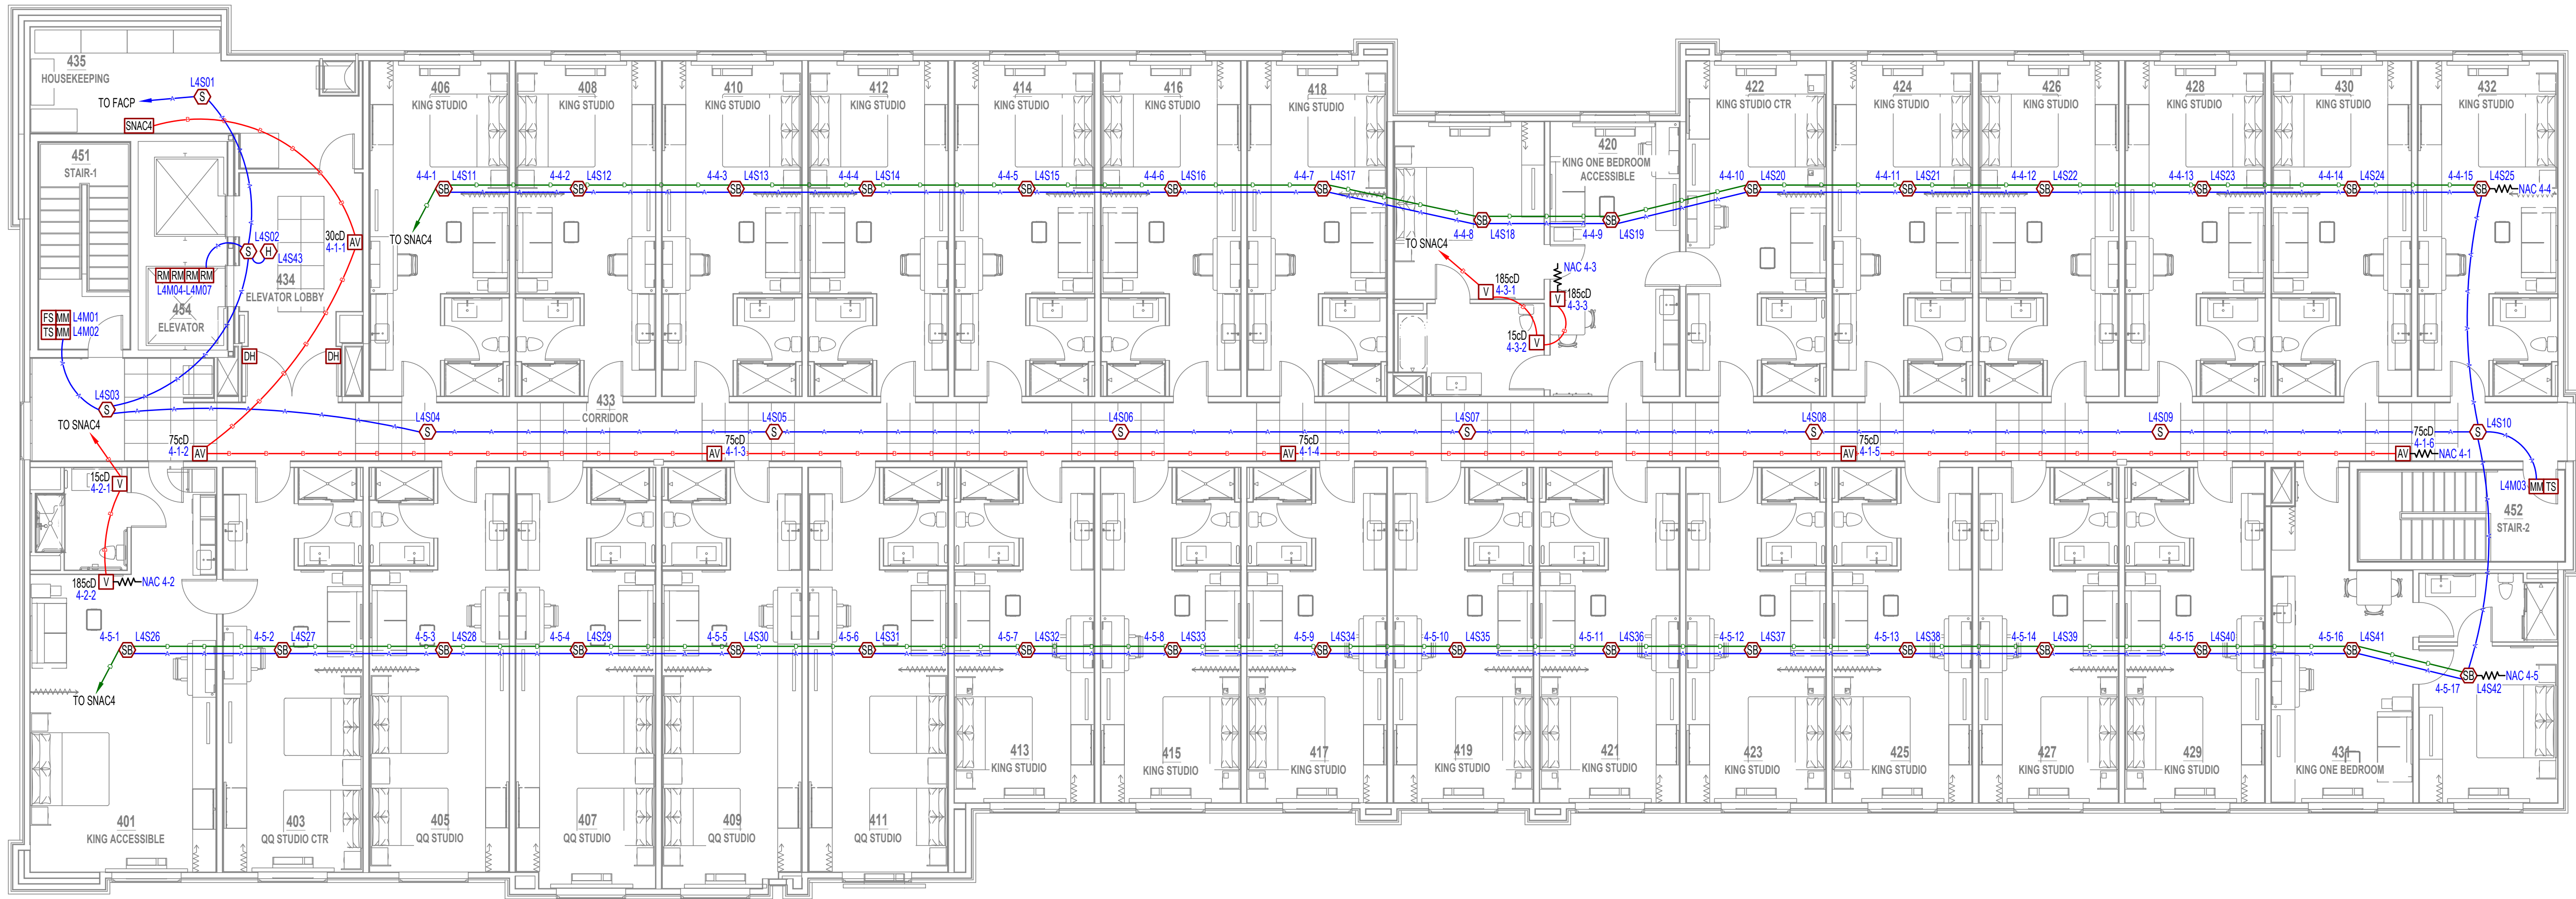

FOURTH FLOOR FIRE ALARM PLAN


SCALE : 1/8" = 1'-0"

GENERAL NOTES

- CORRIDOR SMOKE DETECTORS SHALL BE SPACED MAXIMUM 30 FEET APART. PROVIDE ADDITIONAL DETECTORS IF NECESSARY TO MAINTAIN MAXIMUM SPACING DUE TO CEILING CONSTRUCTION.
- IF FIRE SPRINKLER HEAD(S) ARE INSTALLED IN THE ELEVATOR SHAFT, INSTALL A HEAT DETECTOR LOCATED WITHIN 2 FT FOR ACTIVATION OF THE SHUNT-TRIP DISCONNECT IN ACCORDANCE WITH ASME A17.1 ELEVATOR CODE.
- IF THE ELEVATOR SHAFT CONTAINS COMBUSTIBLE MATERIALS OR FLAMMABLE HYDRAULIC FLUIDS, INSTALL A SMOKE DETECTOR AT THE TOP OF THE SHAFT TO INITIATE PHASE I RECALL IN ACCORDANCE WITH ASME A17.1 ELEVATOR CODE.

WIRE KEY:

TAG	CABLE	DESCRIPTION
A	182 TWISTED FPLP	ADDRESSABLE "SLC" CIRCUIT
B	14/2 FPLP	"NAC" HORN/STROBE CIRCUIT
C	184 FPLP	ANNUNCIATOR CIRCUIT
D	14/2 FPLP	SOUNDER BASE POWER CIRCUIT
E	18/2 FPLP	CARBON MONOXIDE DETECTOR POWER CIRCUIT
F	14/2 FPLP	DOOR HOLDER CIRCUIT

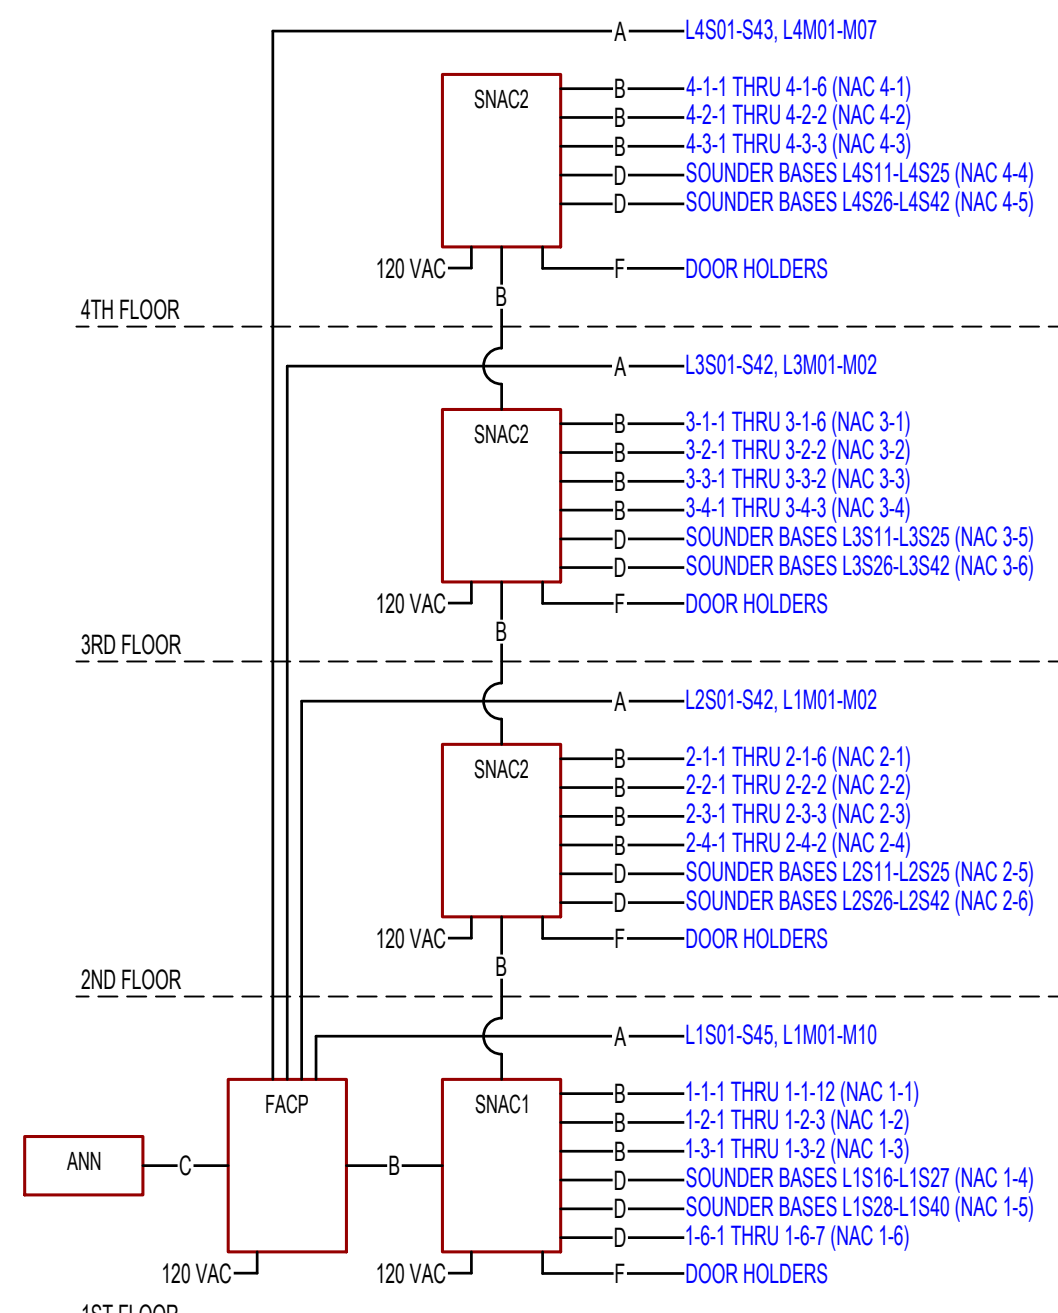

FIRE ALARM RISER DIAGRAM

SYMBOL KEY:

SYMBOL	DESCRIPTION
FACP	FIRE ALARM CONTROL PANEL
ANN	REMOTE ANNUNCIATOR PANEL
SNAC	POWER SUPPLY
P	PULL STATION - DOUBLE ACTION
S	SMOKE DETECTOR
SB	SMOKE DETECTOR WITH LOW FREQUENCY SOUNDER BASE
H	HEAT DETECTOR
CO	CARBON MONOXIDE DETECTOR WITH SOUNDER BASE
RM	ADDRESSABLE RELAY MODULE
MM	ADDRESSABLE SINGLE MONITOR MODULE
DH	DOOR HOLDER
AV	HORN-STROBE, CEILING MOUNT, WHITE, MULTI-CANDELA
V	STROBE, CEILING-MOUNT, WHITE, MULTI-CANDELA
AVWP	WEATHERPROOF SPRINKLER HORN/STROBE, WALL-MOUNT, RED WITH INCLUDED BACKBOX
FS	SPRINKLER WATER FLOW SWITCH
TS	SPRINKLER VALVE TAMPER SWITCH

THE PROFESSIONAL ENGINEER'S SEAL ON THIS DRAWING
HAS BEEN AFFIXED IN ACCORDANCE WITH
THE REQUIREMENTS OF CHAPTER 327, RSMO.
IN AFFIXING THIS SEAL, THE ENGINEER TAKES
RESPONSIBILITY FOR THE WORK SHOWN
ON THIS DRAWING ONLY, AND HEREBY DISCLAIMS
ANY AND ALL RESPONSIBILITY FOR OTHER
PROJECT DRAWINGS NOT DIRECTLY BEARING THIS SEAL.



Russell Vinson, P.E.
2011015810
November 11, 2025
MO Certificate of Authority #000239



A Custom Engineering Company

912 Old 63 South Columbia, MO 65201
ph: 573.875.4365

PROJECT No. COL25399 DESIGNED BY RVN
DRAWN BY RAV CHECKED BY RAV

PROJECT
**HOME 2 SUITES
BY HILTON**
Village at Discovery Park Lot 2
Lee's Summit, MO

SHEET TITLE
**FOURTH FLOOR FIRE ALARM
PLAN**

SHEET NUMBER
FA4