

RENDERING FOR CONCEPTUAL REFERENCE ONLY. IMAGE MAY NOT REFLECT LATEST DESIGN. REFERENCE ELEVATIONS AND SCHEDULES FOR FINISHES.



DRAWING INDEX

ARCHITECTURAL

- A0.00 COVER SHEET
- A0.01 LEGENDS & GENERAL NOTES
- A0.02 ADA DETAILS
- A0.20 ARCHITECTURAL SITE PLAN & DETAILS
- A1.00 FLOOR PLAN
- A1.50 ROOF PLAN & RCP
- A2.00 EXTERIOR ELEVATIONS
- A3.00 WALL AND BUILDING SECTIONS
- A3.50 DETAILS
- A4.00 INTERIOR ELEVATIONS
- A8.00 DOOR AND FINISH SCHEDULE
- A9.00 EQUIPMENT PLAN

STRUCTURAL

- S0.0 GENERAL NOTES
- S0.1 ISOMETRIC
- S1.1 FOUNDATION PLAN
- S2.2 ROOF FRAMING PLAN
- S3.1 TYPICAL FOUNDATION DETAILS
- S4.1 TYPICAL FRAMING DETAILS

PLUMBING

- P1.01 GENERAL PLUMBING NOTES
- P2.01 FIRST FLOOR PLUMBING PLAN
- PE0.01 COVER SHEET

ELECTRICAL

- E1.01 ELECTRICAL PLAN
- E2.01 ELECTRICAL SCHEDULES & DETAILS

MECHANICAL

- M-1 MECHANICAL PLAN

PROJECT TEAM

ARCHITECT
FINKLE + WILLIAMS ARCHITECTURE
8787 Renner Blvd., Suite 100
Lenexa, Kansas 66219
PH. 913.498.1550

STRUCTURAL
BSE Structural Engineers
11320 W. 79th St.
Lenexa, KS 66214
PH. 913.492.7400

MECHANICAL
DESIGN / BUILD BY CONTRACTOR

PLUMBING
PKMR
13300 W. 98th St.
Lenexa, KS 66215
PH. 913.492.2400

ELECTRICAL
PKMR
13300 W. 98th St.
Lenexa, KS 66215
PH. 913.492.2400



FINKLE +
WILLIAMS
ARCHITECTURE

PARAGON STAR RR-CONCESSIONS

PROJECT ADDRESS
1401 NW River Rd
Lee's Summit, MO 64081

PROJECT NUMBER
19050.04b

RELEASE DATE
12.08.2025

ISSUED FOR
PERMIT

CURRENT REVISION

1401 NW River Rd
Lee's Summit, MO 64081

[illegible]

ARCHITECT	FINKLE+WILLIAMS ARCHITECTURE
STRUCTURAL	BSE
PLUMBING	PKMR
MECHANICAL	CONTRACTOR
ELECTRICAL	PKMR


FINKLE + WILLIAMS
ARCHITECTURE
8787 RENNER BLVD., SUITE 100
LENEXA, KANSAS 66219
913.498.1550
www.finklewilliams.com

ADA DETAILS

A0.02


CHAPTER 4: ACCESSIBLE ROUTES

DOORWAYS SHALL HAVE A CLEAR OPENING WIDTH OF 32 INCHES MINIMUM AND REQUIRED MANEUVERING CLEARANCES. CLEAR OPENING WIDTH OF DOORWAYS WITH SWINGING DOORS SHALL BE MEASURED BETWEEN THE FACE OF DOOR AND STOP, WITH THE DOOR OPEN 90 DEGREES. OPENINGS MORE THAN 24 INCHES IN DEPTH AT DOORS AND DOORWAYS WITHOUT DOORS SHALL PROVIDE A CLEAR OPENING WIDTH OF 36 INCHES MINIMUM.

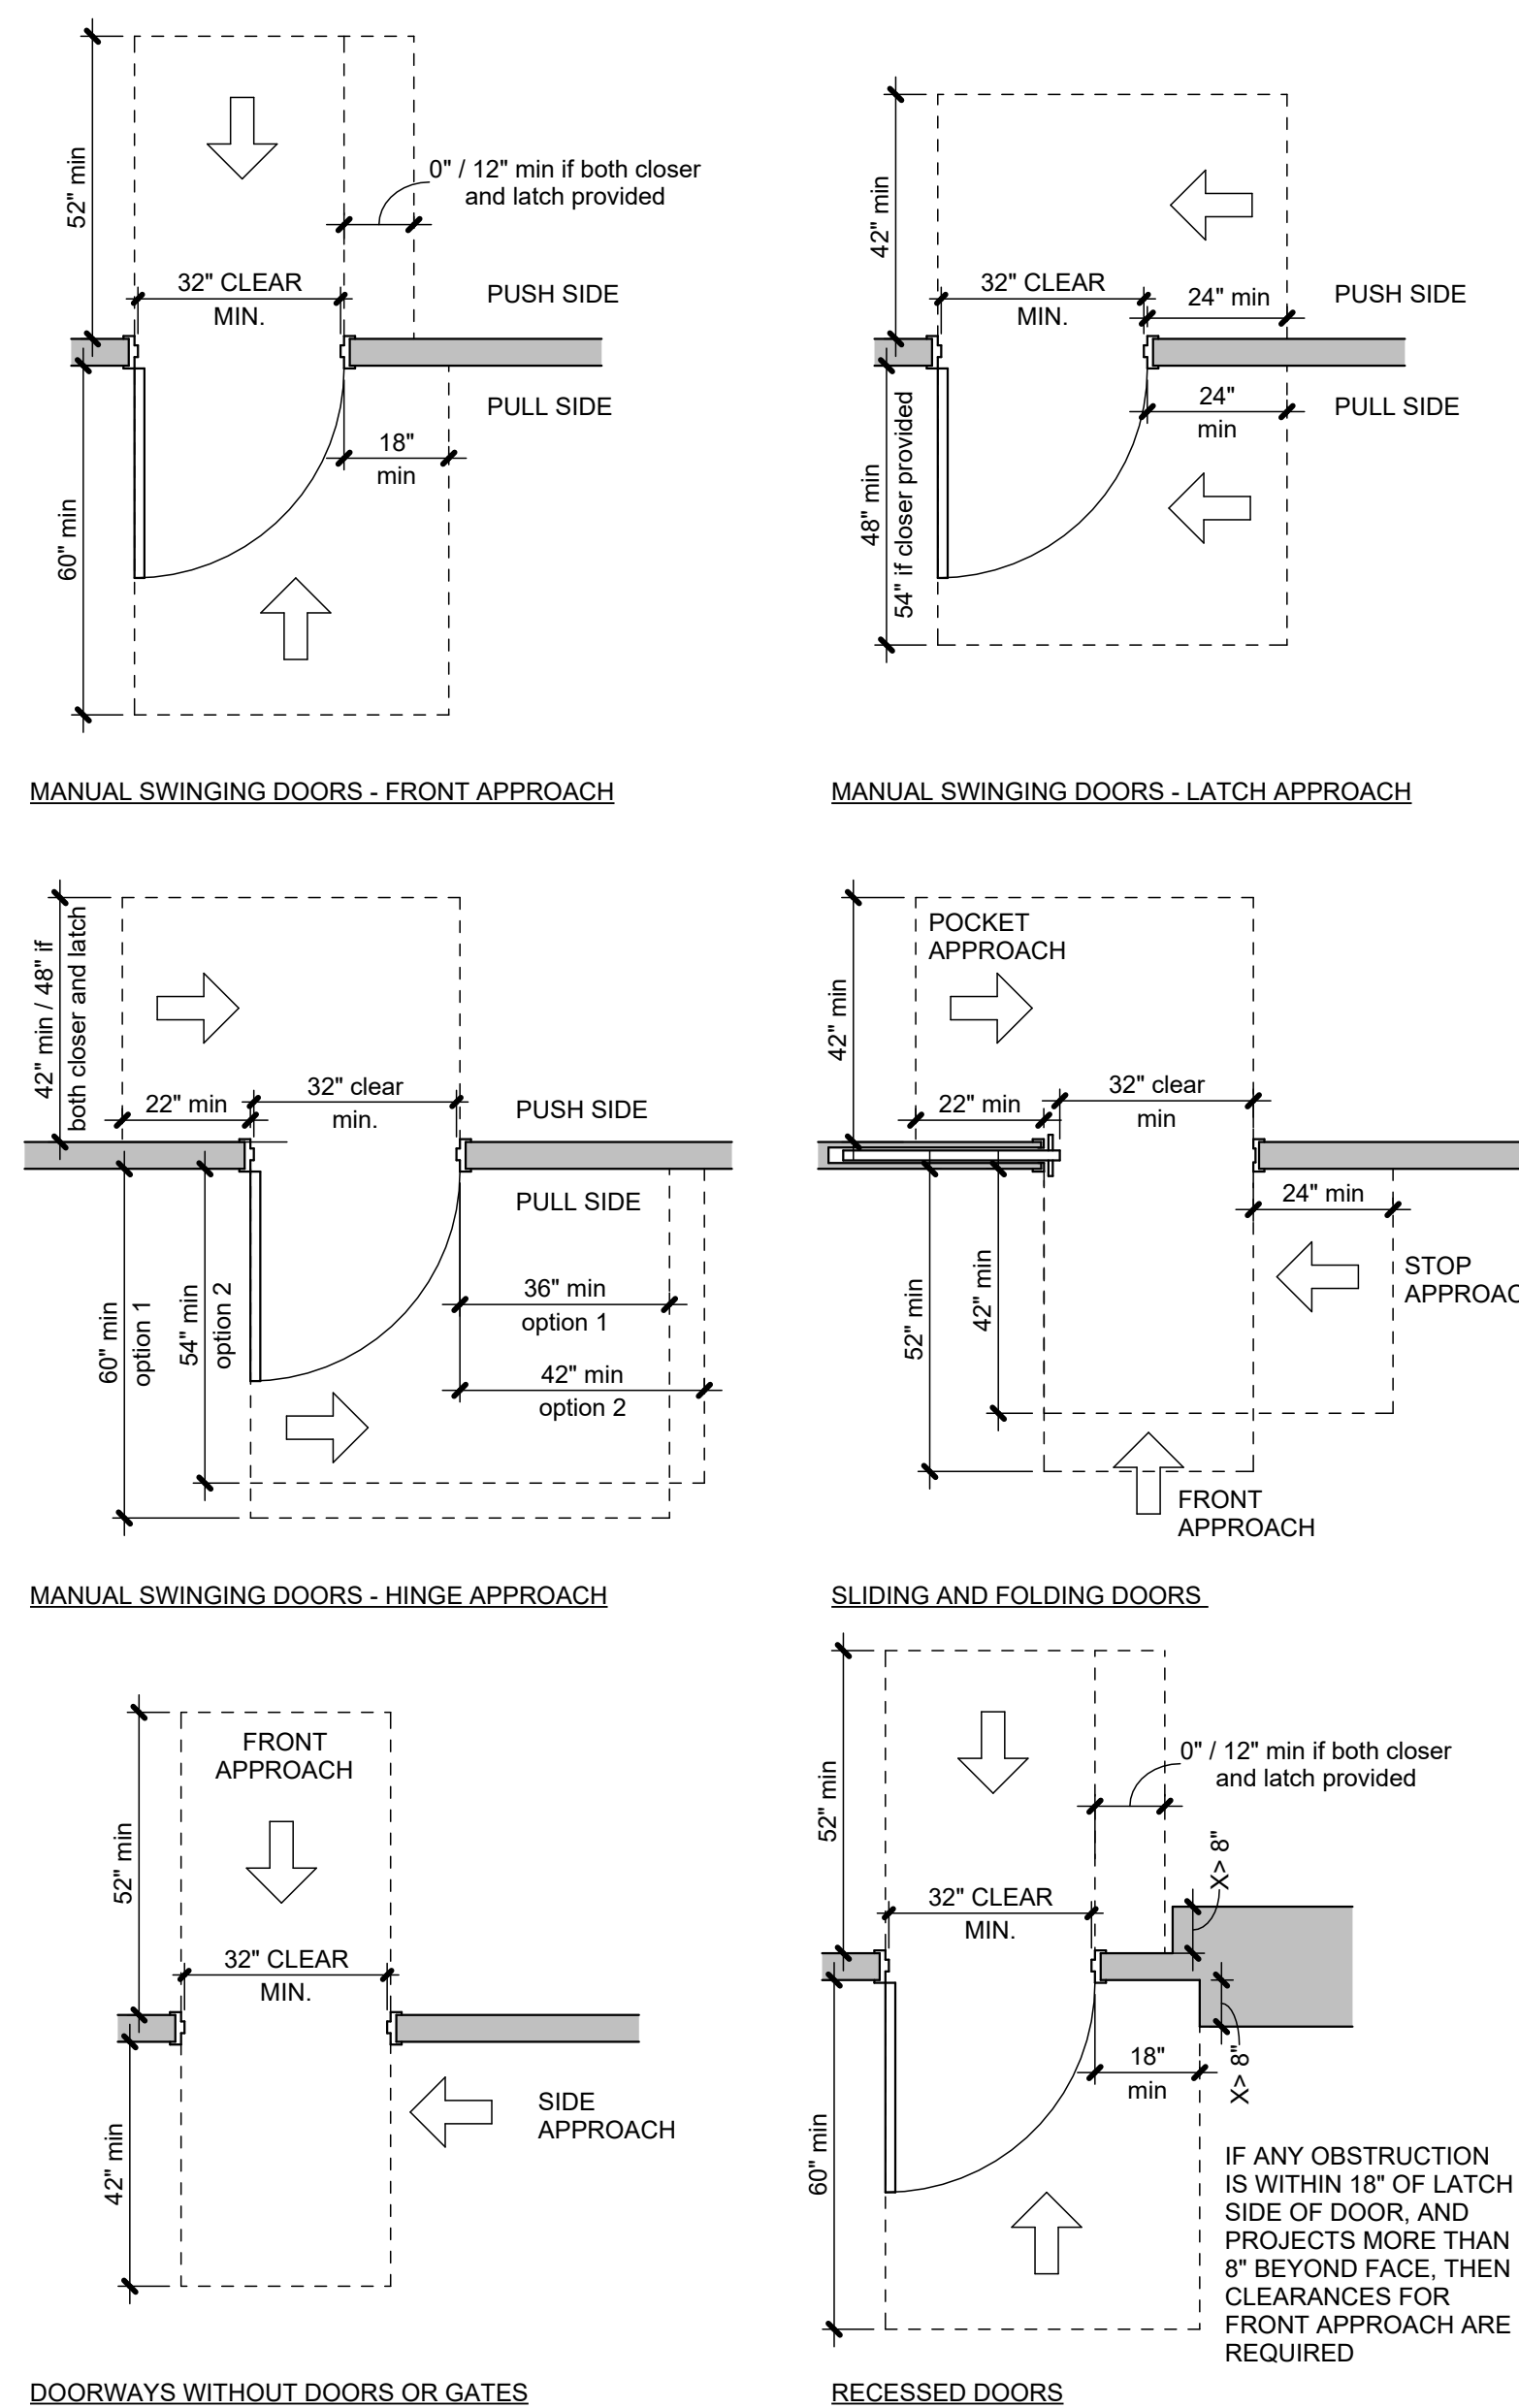


602 DRINKING FOUNTAINS AND BOTTLE FILLING STATIONS

NO FEWER THAN TWO DRINKING FOUNTAINS SHALL BE PROVIDED. ONE DRINKING FOUNTAIN SHALL COMPLY WITH LOW SPOUT HEIGHT REQUIREMENTS AND ONE WITH HIGH SPOUT REQUIREMENTS.

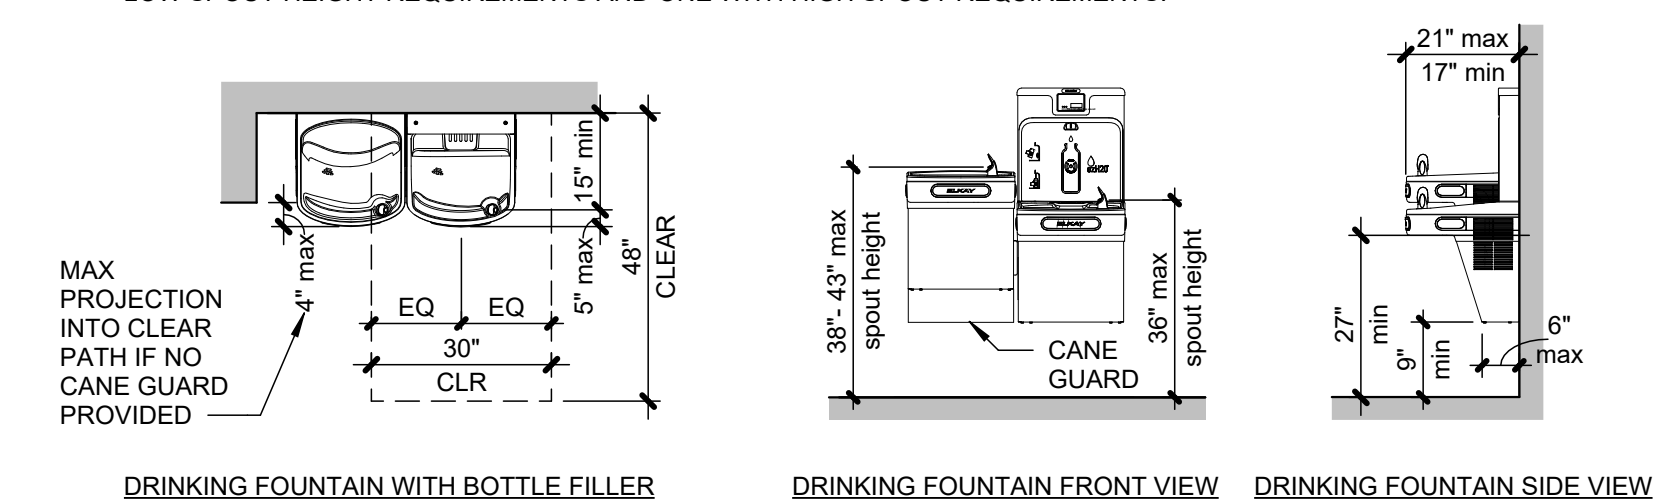

603 TOILET AND BATHING ROOMS - REACH RANGES

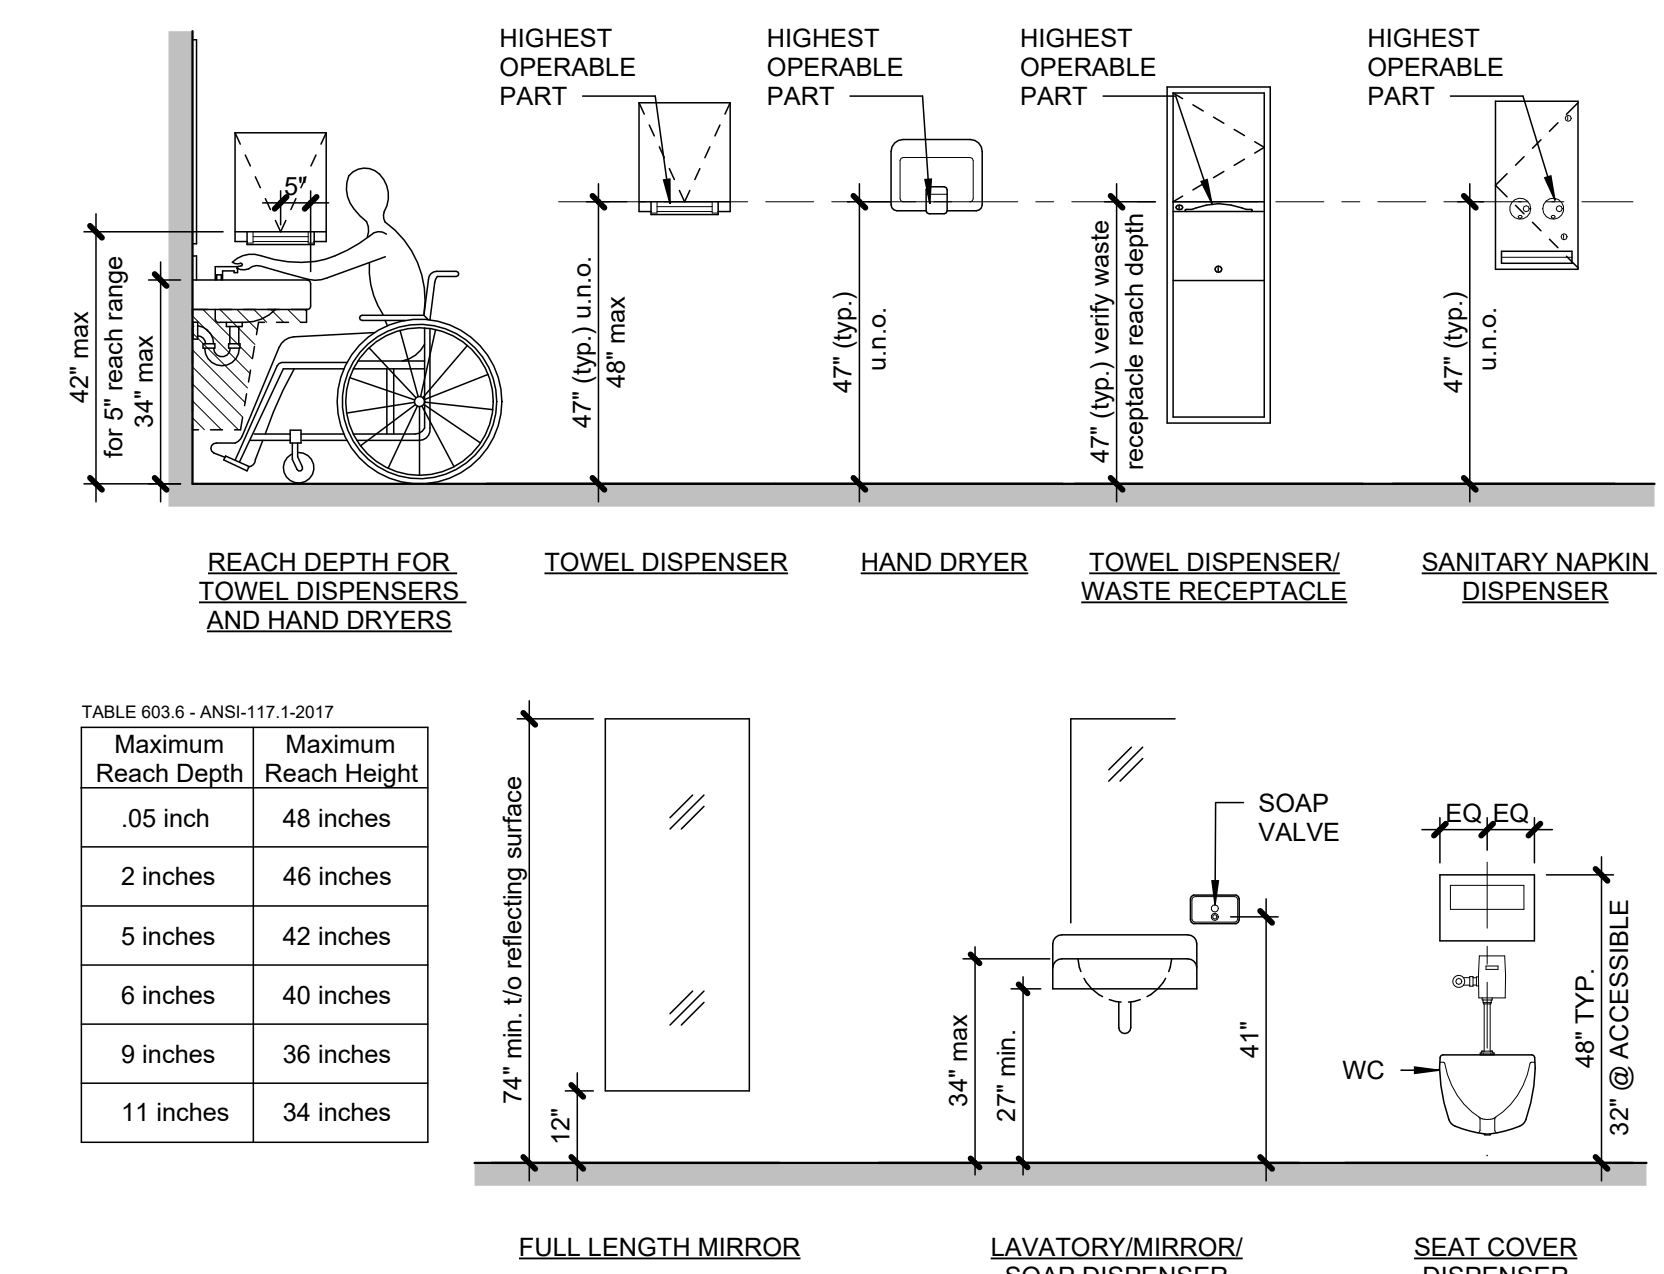

1. ALL NEW CONSTRUCTION SHALL COMPLY WITH THE AMERICANS WITH DISABILITIES ACT ACCESSIBILITY GUIDELINES (ADAAG) AND CHAPTER 11 OF THE INTERNATIONAL BUILDING CODE (INCLUDES IFC A117.1 PER IBC).

2. NOT ALL CONDITIONS ARE IDENTIFIED ON ACCESSIBILITY SHEETS AND DO NOT REMOVE RESPONSIBILITY TO COMPLY WITH THE AMERICAN WITH DISABILITIES ACT REQUIREMENTS.

3. NOT ALL CONDITIONS OF THE ACCESSIBILITY SHEETS MAY APPLY TO THIS PROJECT. REFER TO THE DRAWINGS FOR ANY DISCREPANCY WHICH MAY OCCUR BETWEEN ARCHITECTURAL DIMENSIONS AND DIMENSIONS ON ACCESSIBILITY SHEETS.


4. IF ANY DISCREPANCY IS DISCOVERED BETWEEN ARCHITECTURAL DIMENSIONS AND DIMENSIONS ON THE ACCESSIBILITY SHEETS, IMMEDIATELY NOTIFY THE ARCHITECT FOR CLARIFICATION. CONSTRUCTION NOT MEETING ACCESSIBILITY REQUIREMENTS WILL BE THE RESPONSIBILITY OF THE CONTRACTOR AT THE TIME OF CONSTRUCTION.

5. REFER TO CIVIL DRAWINGS FOR SITE ACCESSIBILITY STANDARDS AND DETAILS. NOTIFY ARCHITECT OF ANY DISCREPANCIES WITH ARCHITECTURAL DETAILS.

6. DIMENSIONS ARE SHOWN FOR ADULT FACILITIES. DIMENSIONS MAY VARY FOR FACILITIES FOR CHILDREN.


303 CHANGES IN LEVEL

CHANGES IN LEVEL UP TO 1/4": REQUIRES NO EDGE TREATMENT (VERTICAL EDGE PERMITTED). CHANGES IN LEVEL 1/4" TO 1/2": EDGE SHALL BE BEVELED WITH A SLOPE NO GREATER THAN 1:2. CHANGES IN LEVEL GREATER THAN 1/2": REQUIRES CURB RAMP, RAMP, ELEVATOR, OR PLATFORM LIFT.

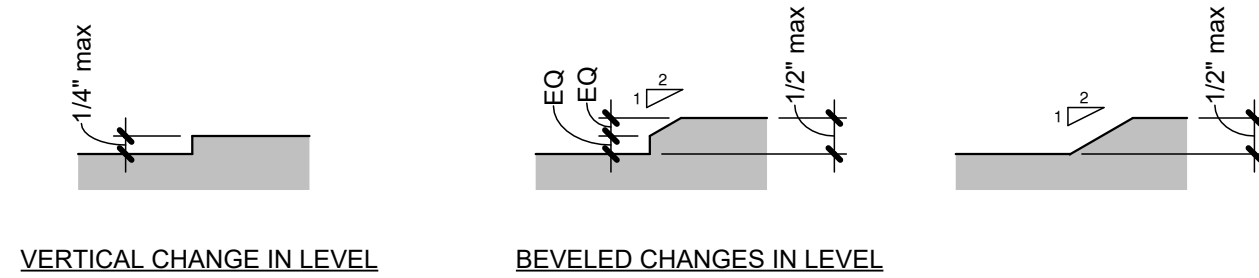


305 CLEAR FLOOR SPACE

IF CLEAR FLOOR SPACE IS IN AN ALCOVE OR OTHERWISE CONFINED ON ALL OR PART OF THREE SIDES, ADDITIONAL MANEUVERING CLEARANCES SHALL BE PROVIDED

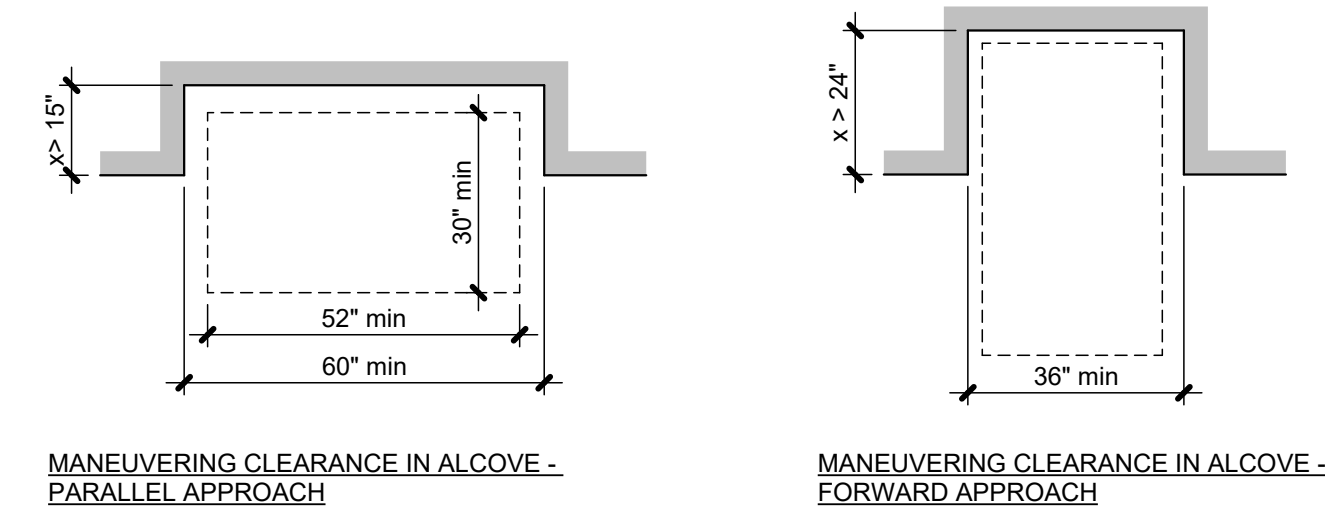


306 KNEE AND TOE CLEARANCE

WHERE SPACE BENEATH AN ELEMENT IS INCLUDED AS PART OF THE CLEAR FLOOR SPACE, CLEARANCE AT A ELEMENT, OR A TURNING SPACE, THE SPACE SHALL COMPLY WITH ALL KNEE AND TOE CLEARANCE REQUIREMENTS. ADDITIONAL SPACE SHALL NOT BE PROHIBITED BENEATH AN ELEMENT BUT SHALL NOT BE CONSIDERED AS PART OF THE CLEAR FLOOR OR GROUND SPACE OR TURNING SPACE

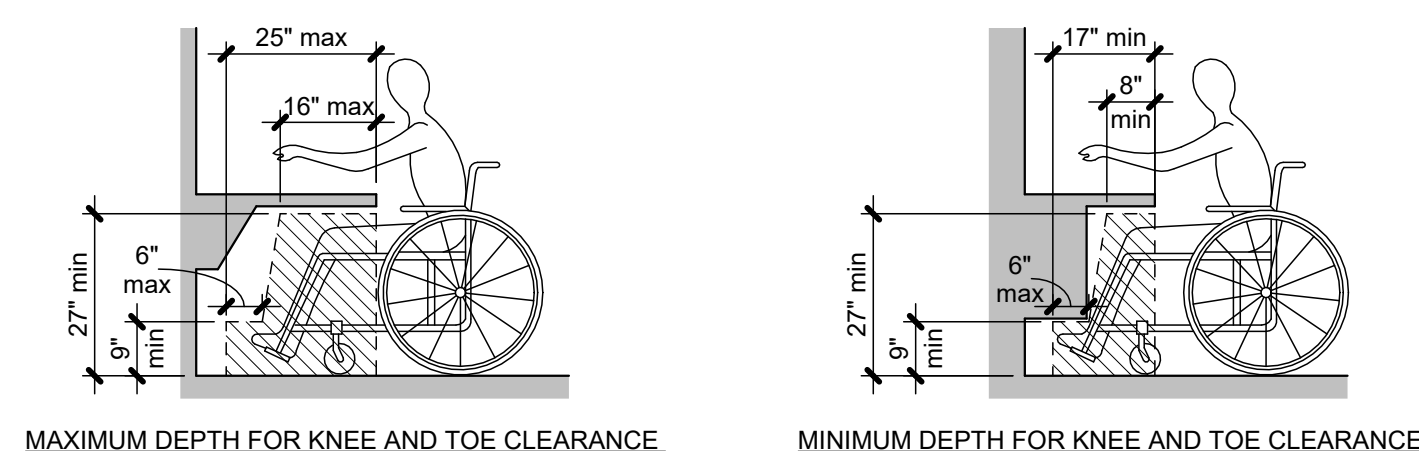


307 PROTRUDING OBJECTS

OBJECTS WITH LEADING EDGES MORE THAN 27 INCHES AND NOT MORE THAN 80 INCHES ABOVE THE FINISH FLOOR OR GROUND SHALL PROTRUDE 4 INCHES MAXIMUM HORIZONTALLY INTO THE CIRCULATION PATH

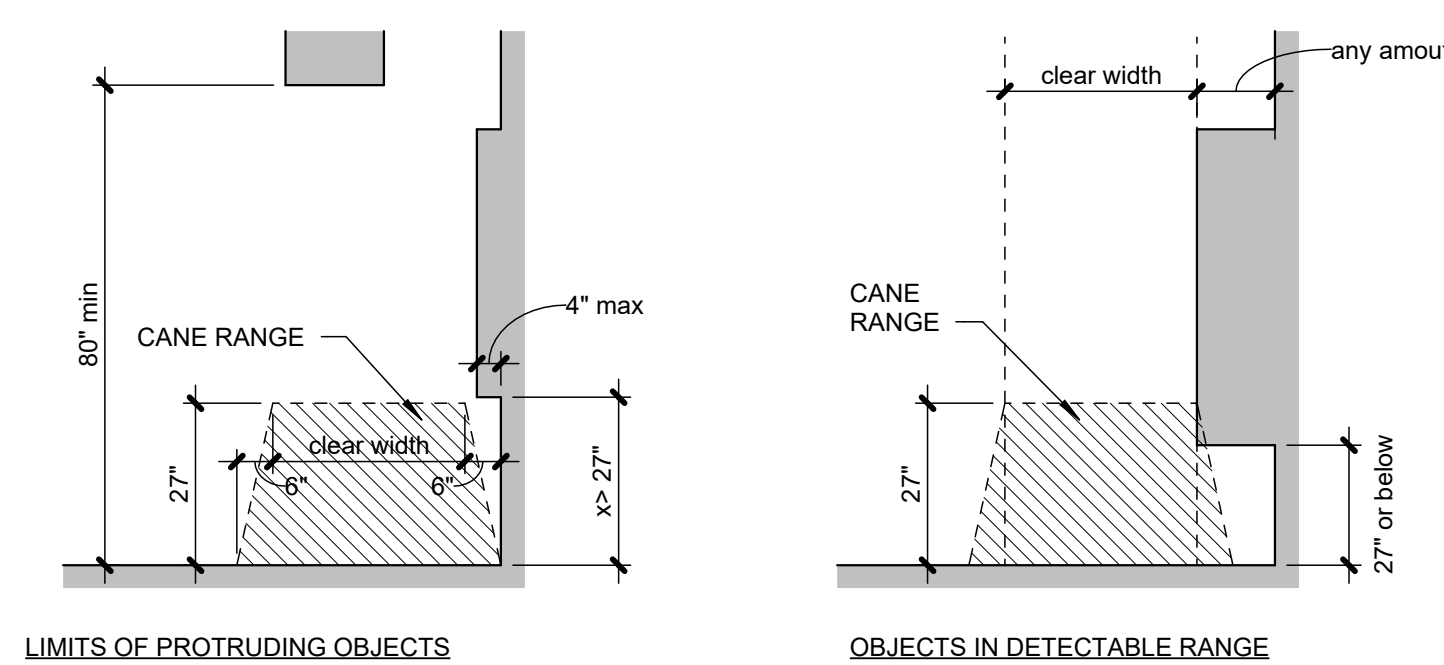

308 REACH RANGES

WHERE A HIGH FORWARD REACH IS OVER AN OBSTRUCTION, THE CLEAR FLOOR SPACE COMPLYING WITH KNEE AND TOE CLEARANCE REQUIREMENTS SHALL EXTEND BENEATH THE ELEMENT FOR A DISTANCE NOT LESS THAN THE REQUIRED REACH DEPTH OVER THE OBSTRUCTION.

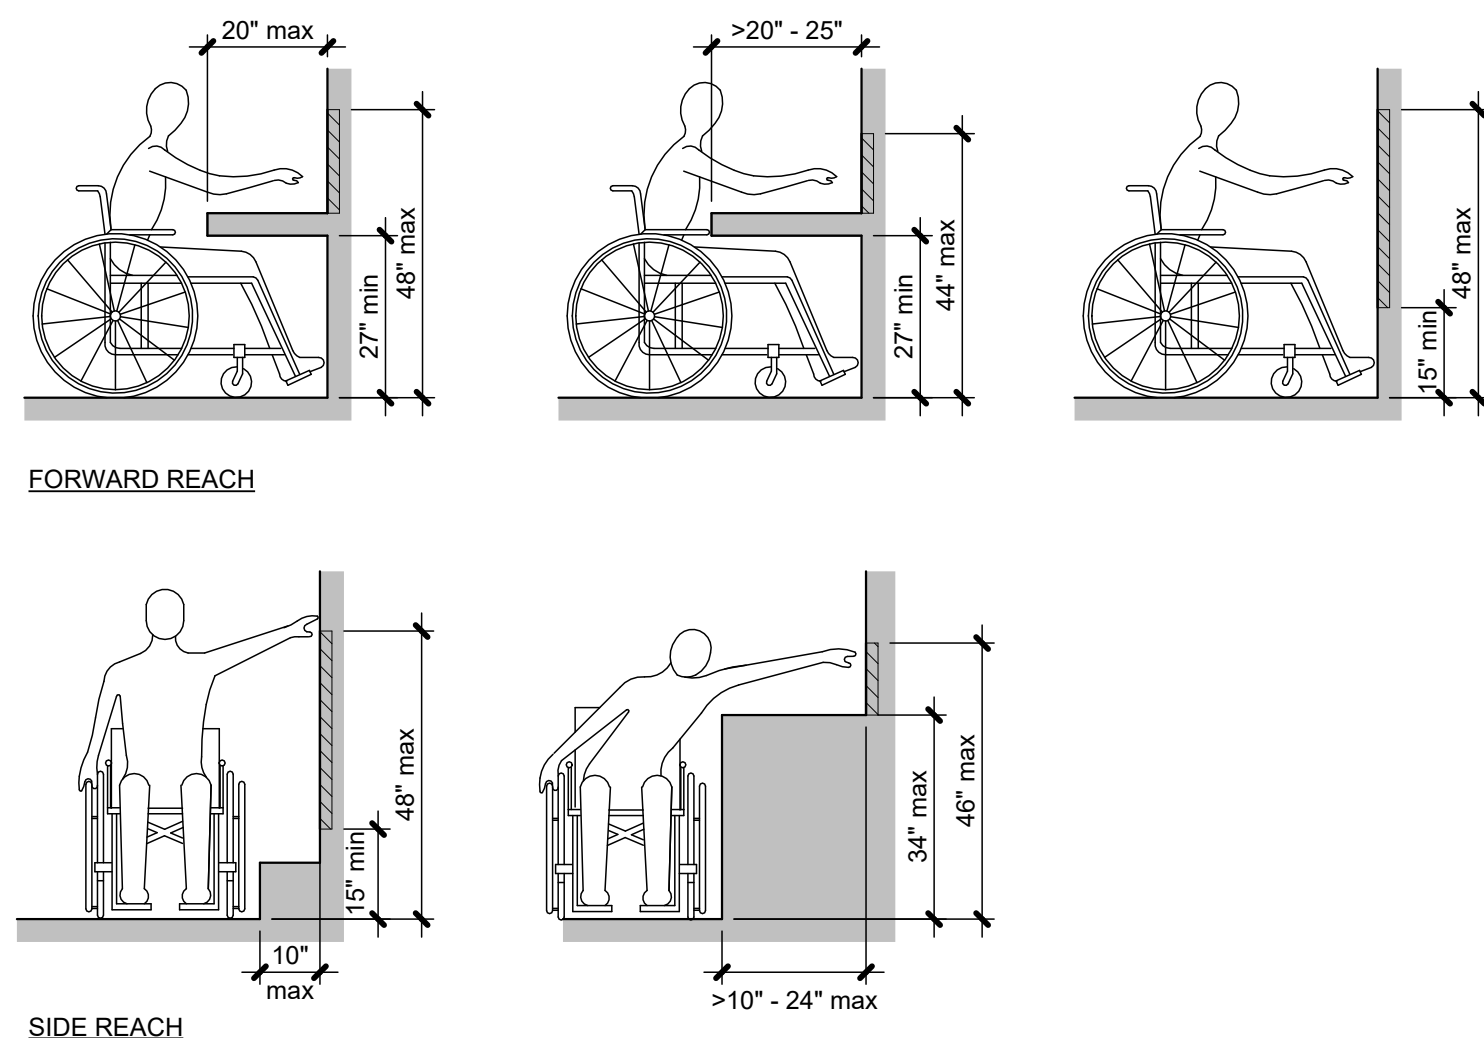

1401 NW River Rd
Lee's Summit, MO 64081

1401 NW River Rd
Lee's Summit, MO 64081


Project No.: 19050.04b

Date: 12.08.2025

REVISIONS

[illegible]

REGISTRATION

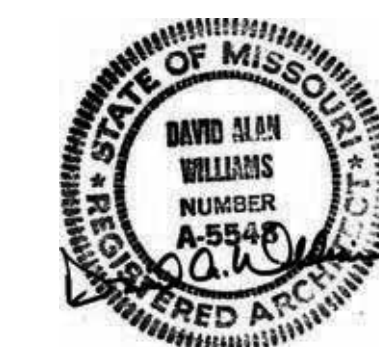

PROJECT TEAM

ARCHITECT FINKLE+WILLIAMS
ARCHITECTURE

STRUCTURAL BSE

PLUMBING PKMR

MECHANICAL CONTRACTOR

ELECTRICAL PKMR

FINKLE + WILLIAMS
ARCHITECTURE

8787 RENNER BLVD., SUITE 100
LENEXA, KANSAS 66219
913.498.1550
www.finklewilliams.com



SHEET TITLE

ARCHITECTURAL SITE PLAN & DETAILS

SHEET NUMBER

A0.20

1. CONTROL JOINT SEALANT FOR CONCRETE PAVING AND BETWEEN BUILDING AND PAVING TO BE GRAY COLOR TO MATCH CONCRETE.

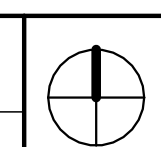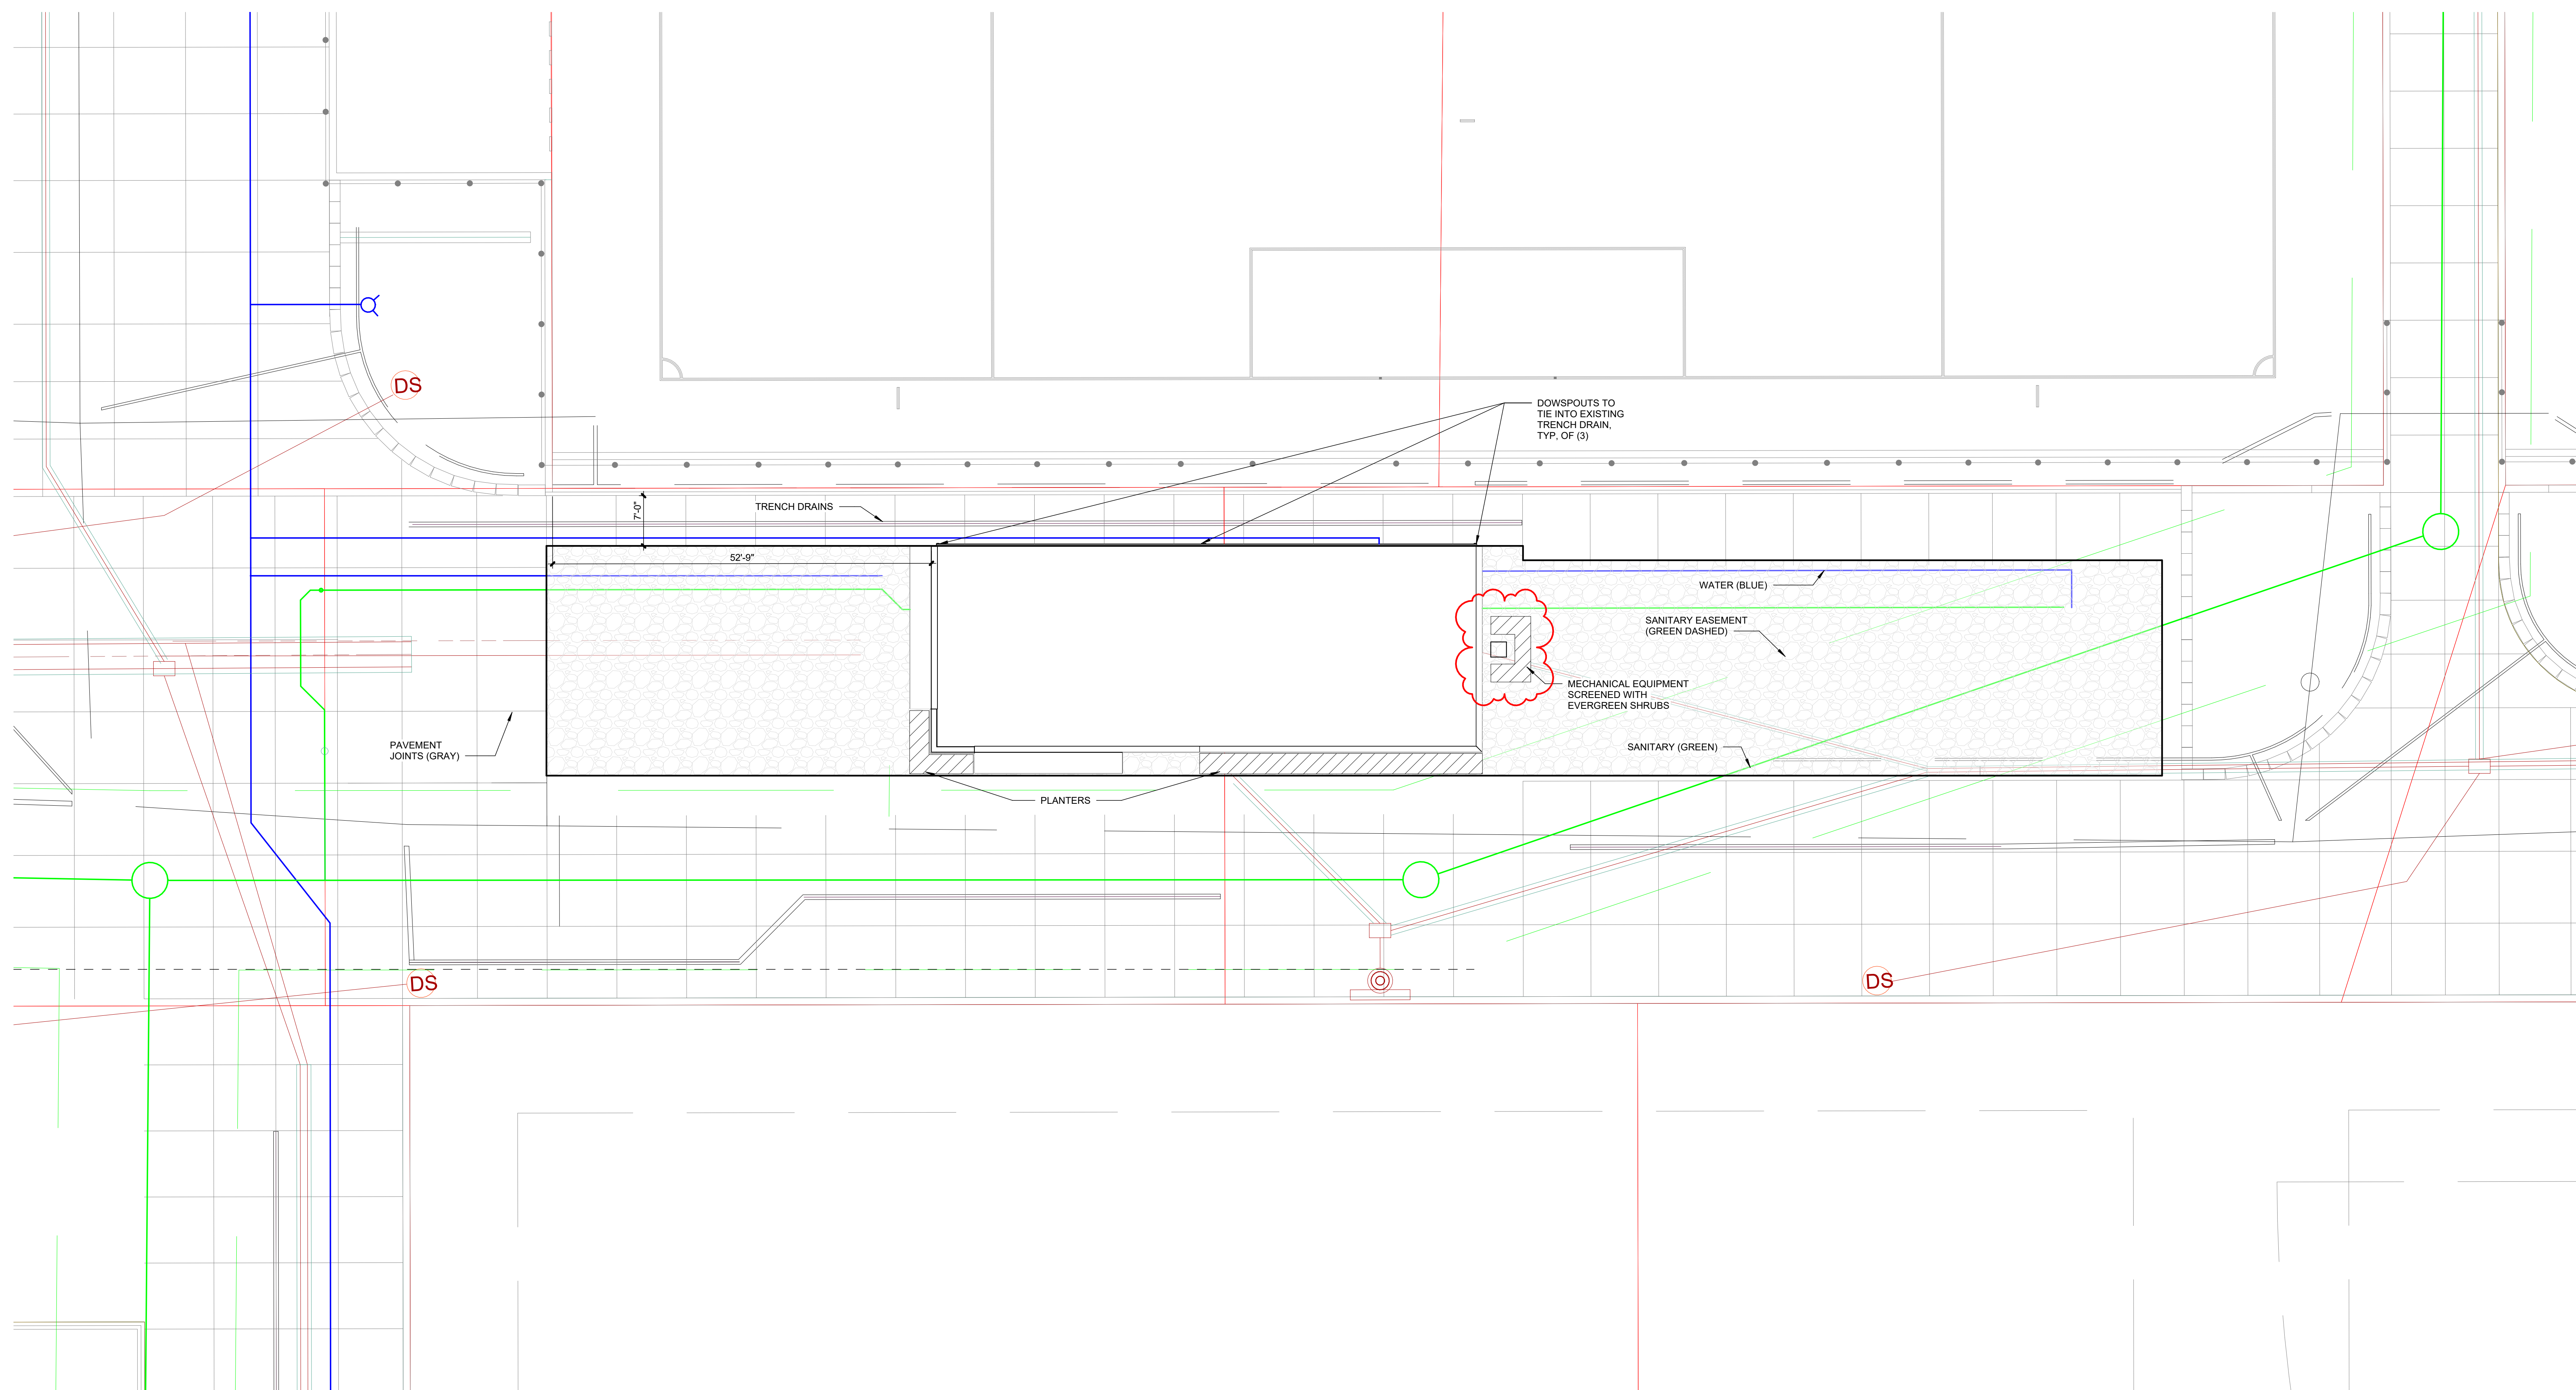

1401 NW River Rd
Lee's Summit, MO 64081

[illegible]

ARCHITECT	FINKLE+WILLIAMS ARCHITECTURAL
STRUCTURAL	BSE
PLUMBING	PKMR
MECHANICAL	CONTRACTOR
ELECTRICAL	PKMR



FLOOR PLAN

A1.00

1401 NW River Rd
Lee's Summit, MO 64081

1401 NW River Rd
Lee's Summit, MO 64081

Project No.:	19050.04b
Date:	12.08.2025
Issued For:	PERMIT

[illegible]

REGISTRATION



PROJECT TEAM

ARCHITECT FINKLE+WILLIAMS
ARCHITECTURE

STRUCTURAL BSE

PLUMBING PKMR

MECHANICAL CONTRACTOR

ELECTRICAL PKMR

**FINKLE +
WILLIAM**
ARCHITECTURE

8787 RENNER BLVD., SUITE 100
LENEXA, KANSAS 66219
913.498.1550
www.finklewilliams.com



SHEET TITLE

ROOF PLAN &
RCP


SHEET NUMBER

A1.50


1. THE SINGLE PLY ROOF SHALL BE TPO, 60 MIL, WHITE MEMBRANE, RHINO-BOND FASTENED, W/ A 20 YEAR NO DOLLAR LIMIT MANUFACTURER'S WARRANTY.
2. ROOF DRAINS ARE TO BE COLLECTED UNDERGROUND AND CONTINUED PER CIVIL ENGINEERING PLANS.
3. SEE SHEET A1.51 FOR TYPICAL ROOF DETAILS.
4. SEE PLUMBING AND MECHANICAL PLANS FOR ROOF TOP EQUIPMENT AND PENETRATION LOCATIONS.

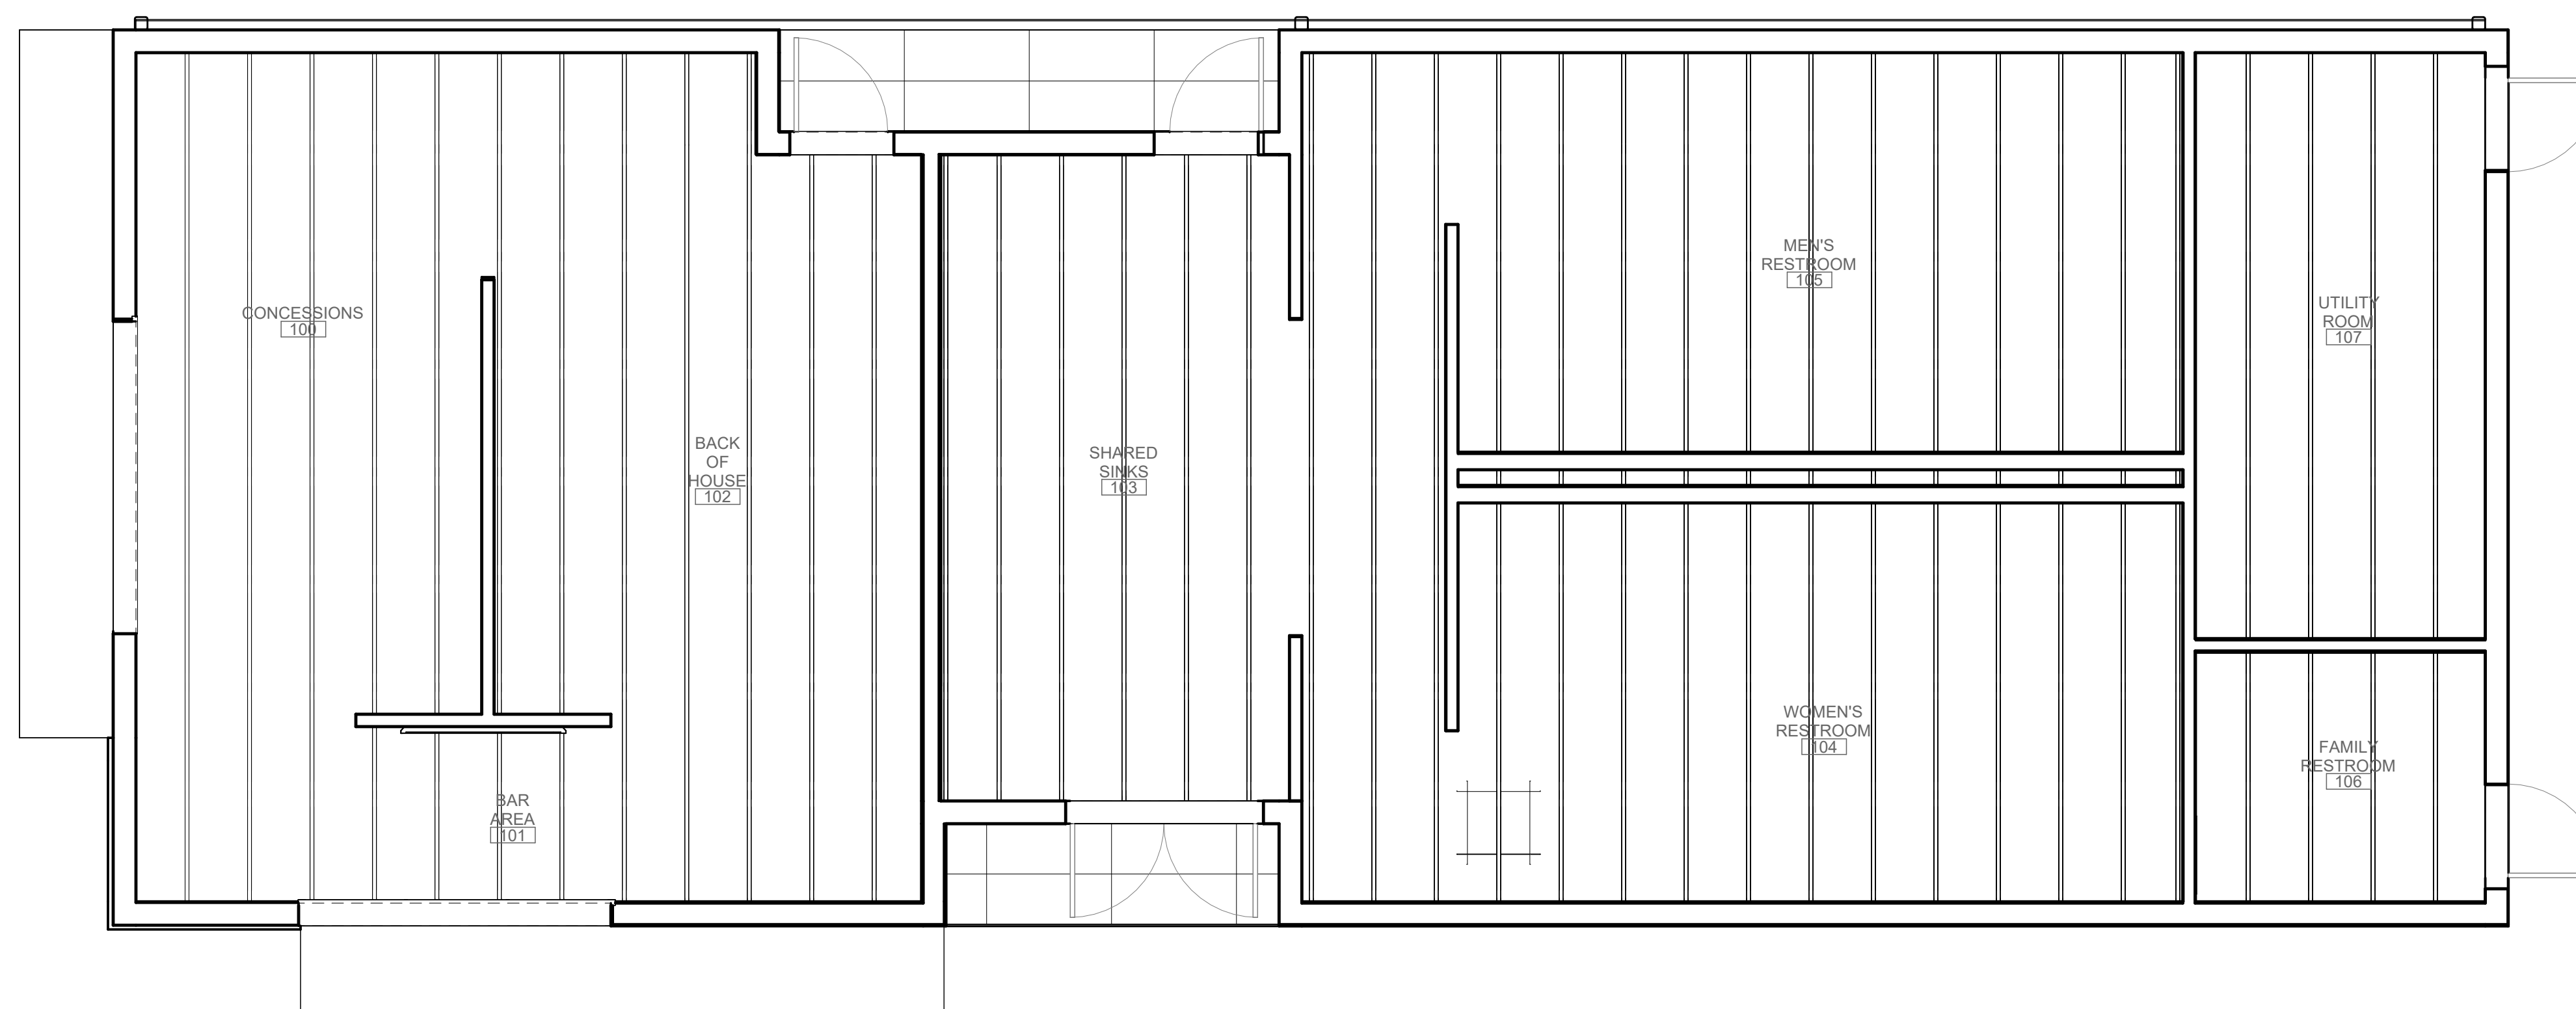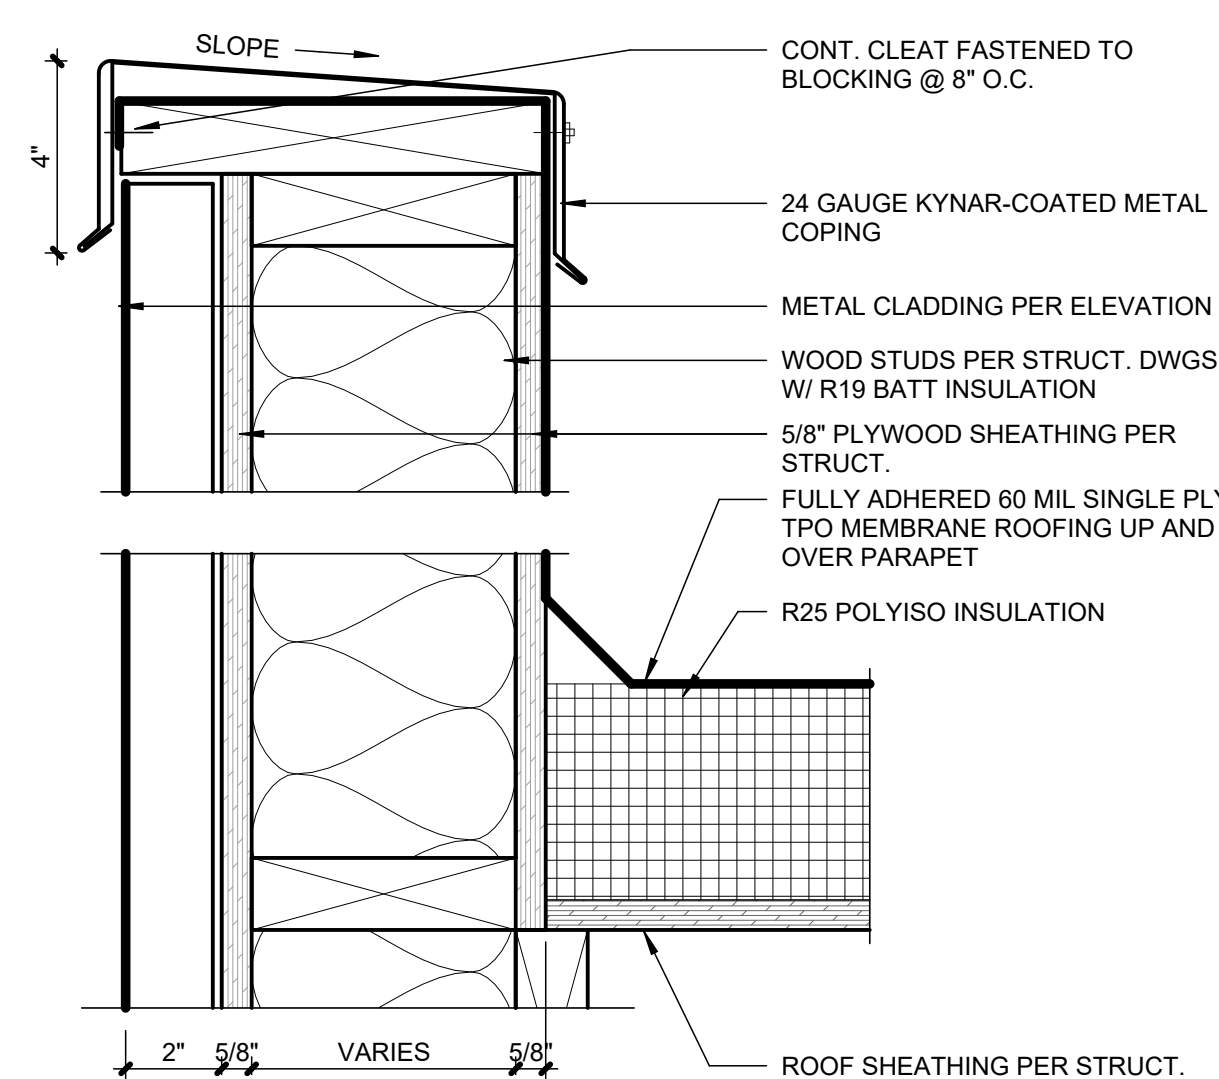


A1.50	SCALE : 3" = 1'-0"
--------------	--------------------

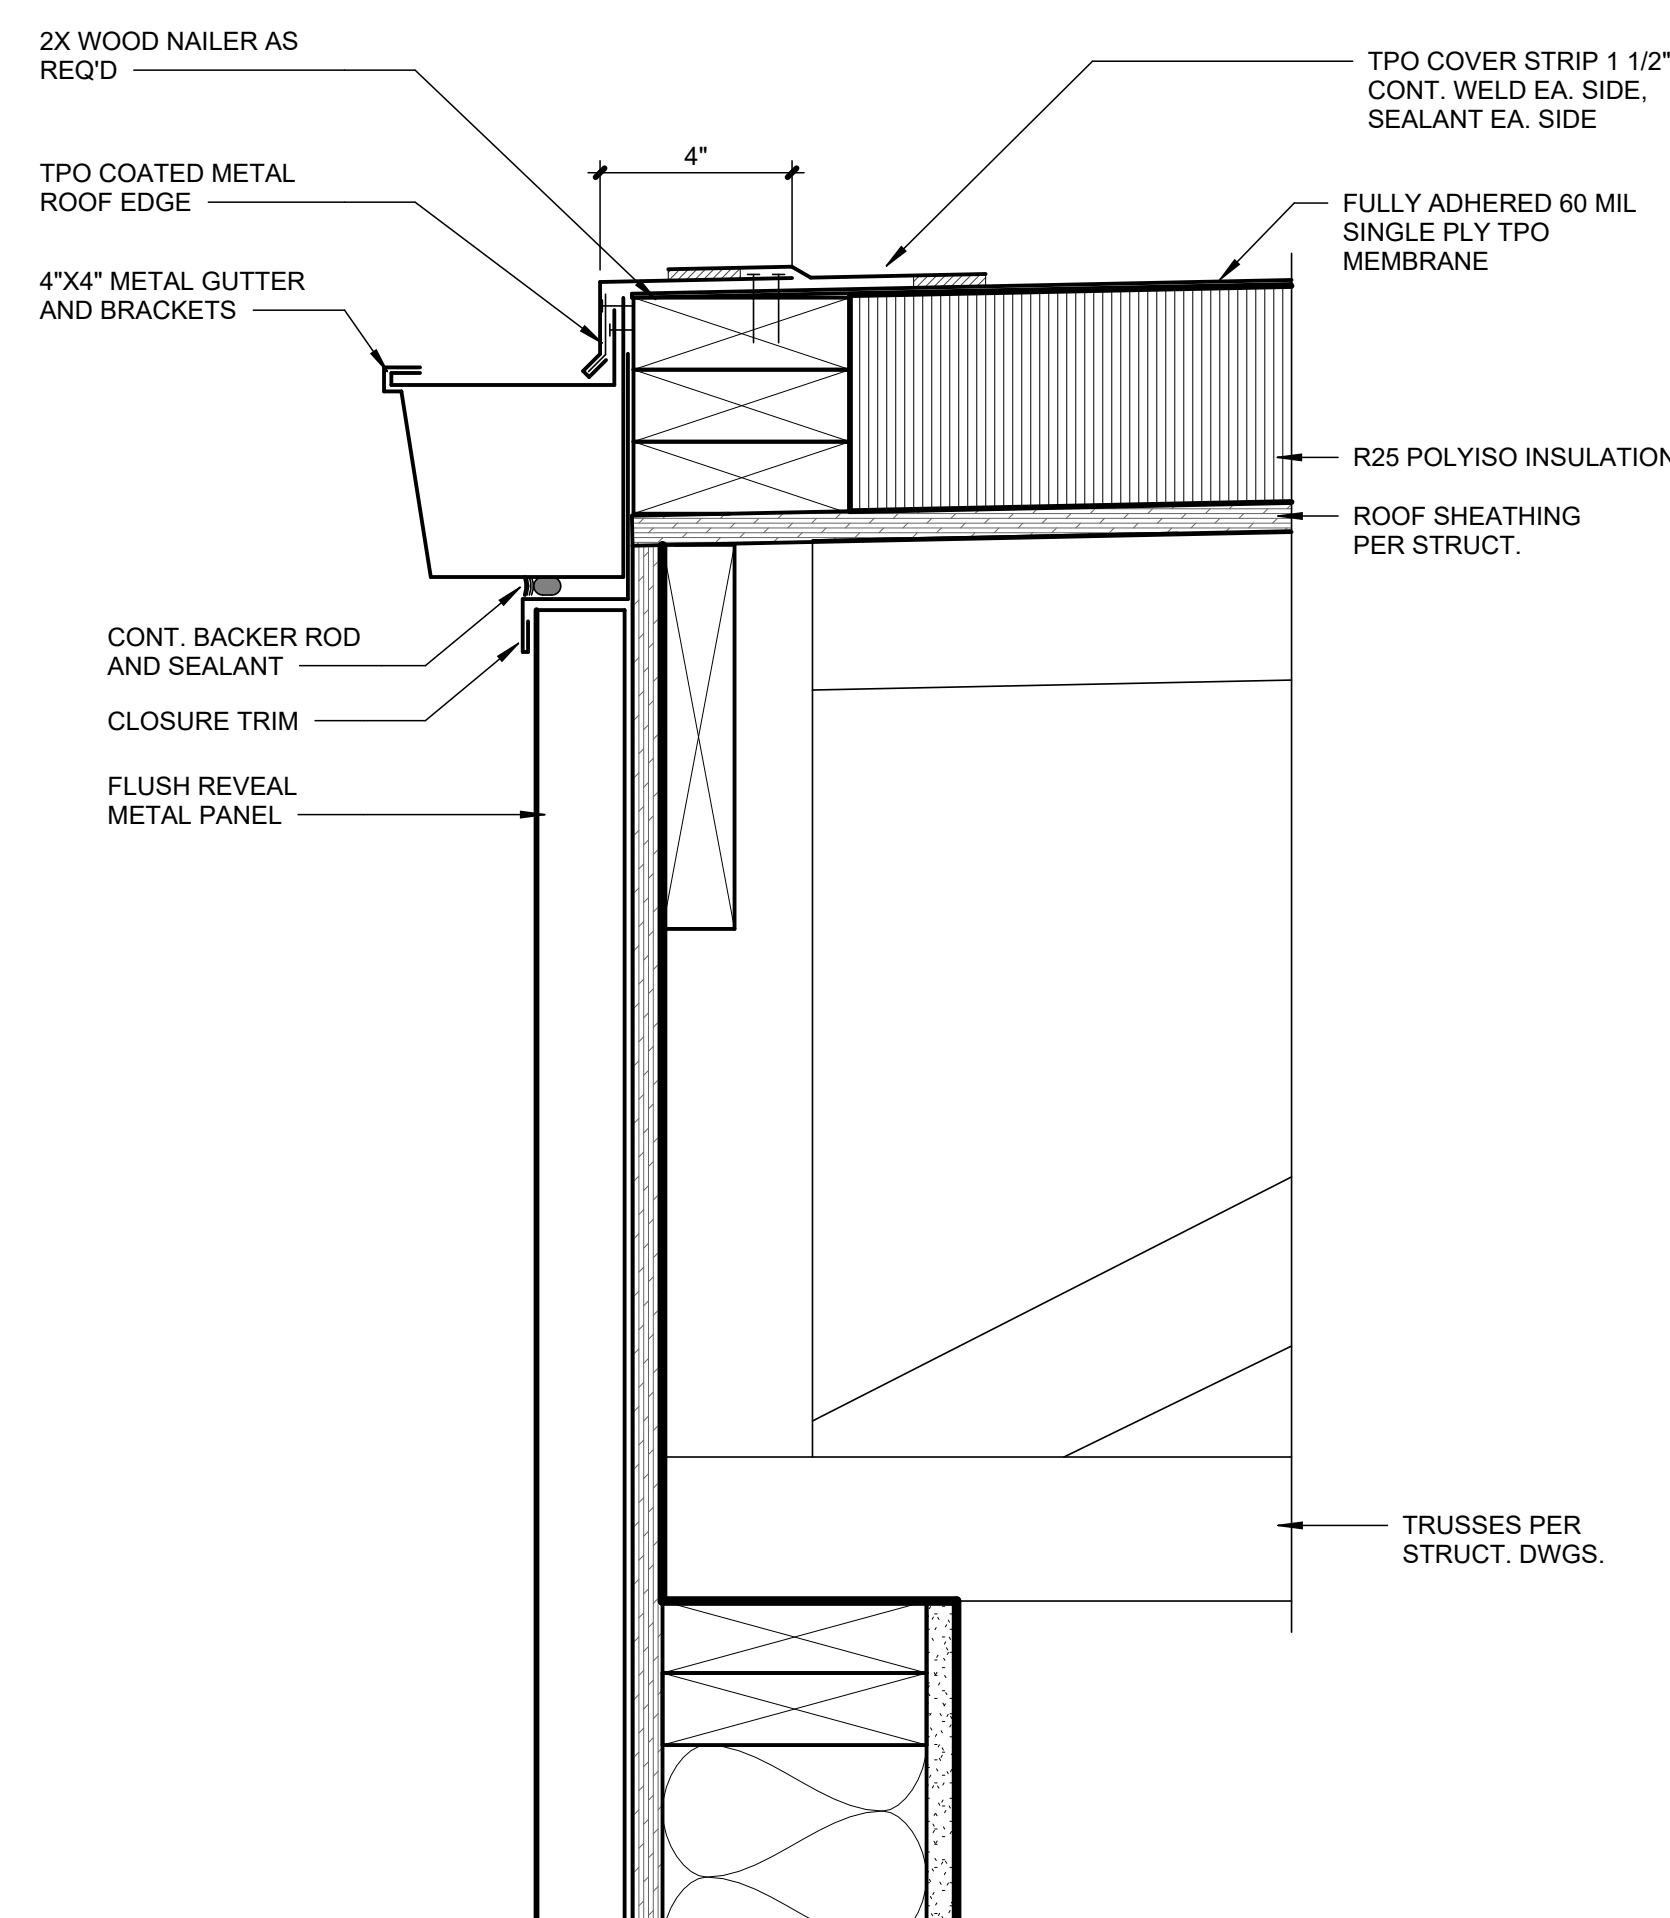

A1.50	SCALE : 1/4" = 1'-0"
--------------	----------------------

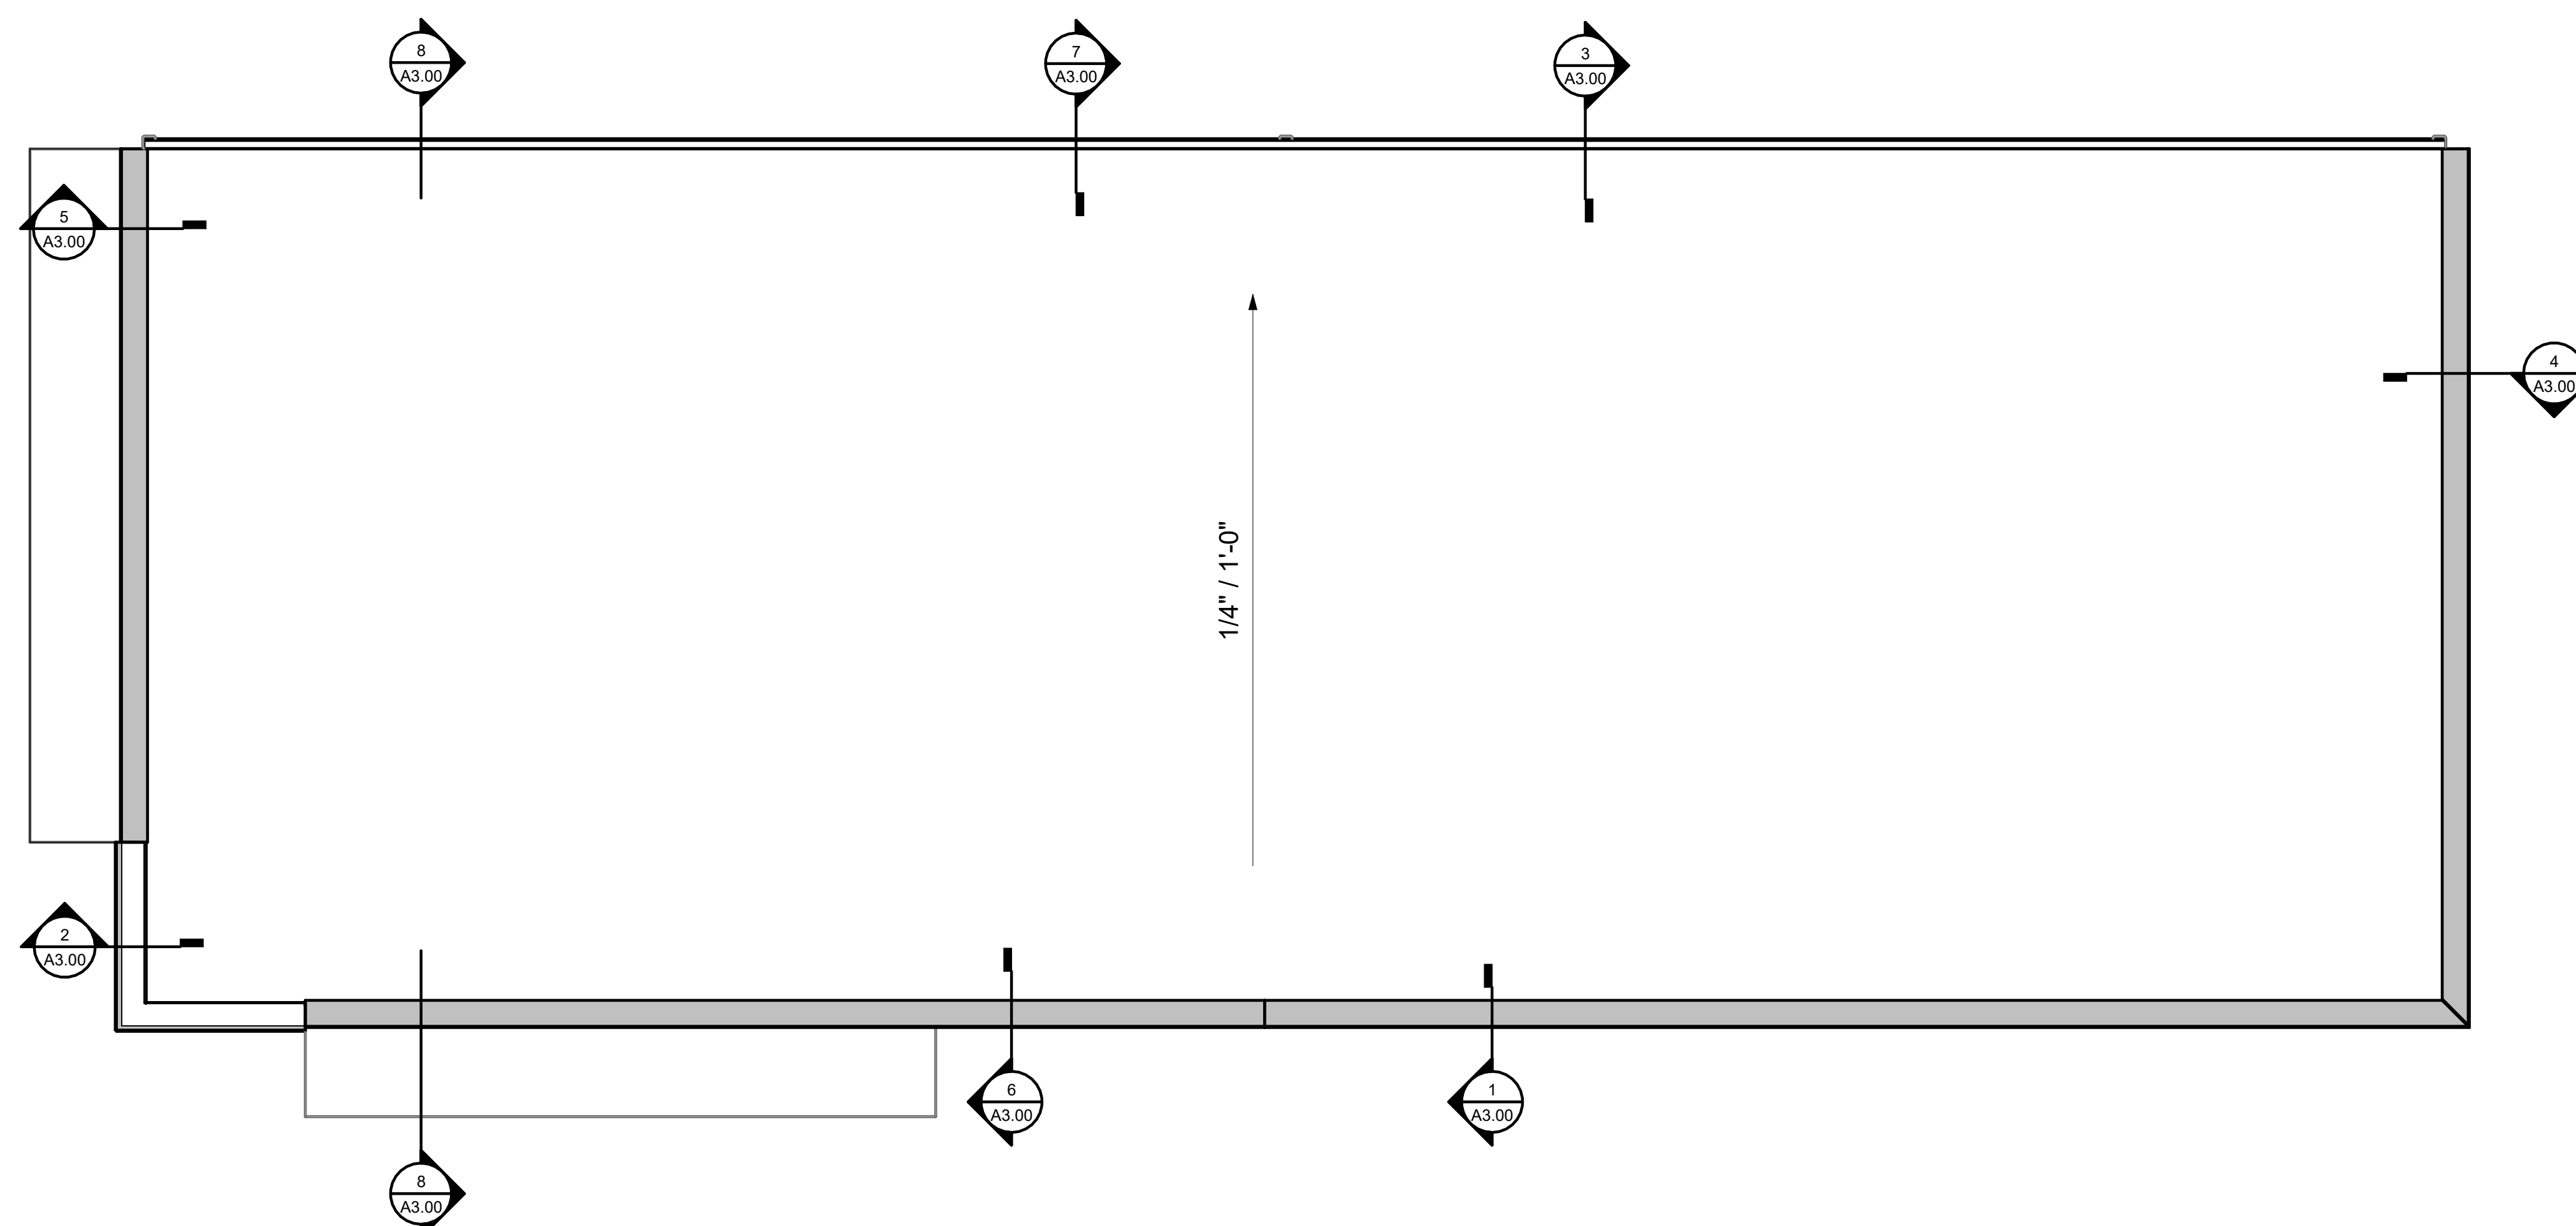

A1.50	SCALE : 3" = 1'-0"
--------------	--------------------

 

1401 NW River Rd
Lee's Summit, MO 64083

1401 NW River Rd
Lee's Summit, MO 64081

Project No.: 19050.04b


Date: 12.08.2025

Issued For: PERMIT

REVISIONS

[illegible]

REGISTRATION

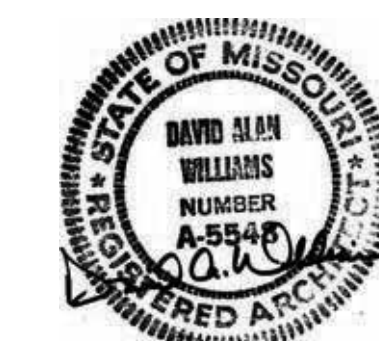

PROJECT TEAM

ARCHITECT FINKLE+WILLIAMS
ARCHITECTURE

STRUCTURAL BSE

PLUMBING	PKMR
----------	------

MECHANICAL CONTRACTOR

ELECTRICAL PKMR

**FINKLE +
WILLIAM**
ARCHITECTURE

8787 RENNER BLVD., SUITE 100
LENEXA, KANSAS 66219
913.498.1550
www.finklewilliams.com

SHEET TITLE

EXTERIOR ELEVATIONS

SHEET NUMBER

A2.00


MP-1 FLUSH SEAM METAL PANEL; BASIS OF DESIGN: PAC-CLAD, COLOR: GRAY

MP-1 FLUSH SEAM METAL PANEL; BASIS OF DESIGN: PAC-CLAD, COLOR: GRAY

MP-2 VERTICAL EXPOSED FASTENER CORRUGATED METAL PANEL, COLOR
TEAL (PARAGON BRAND COLOR)


(MTL-1) PRE-FABRICATED METAL AWNING, COLOR: BLACK

(CMU-1) CMU BLOCK, PAINTED BLACK

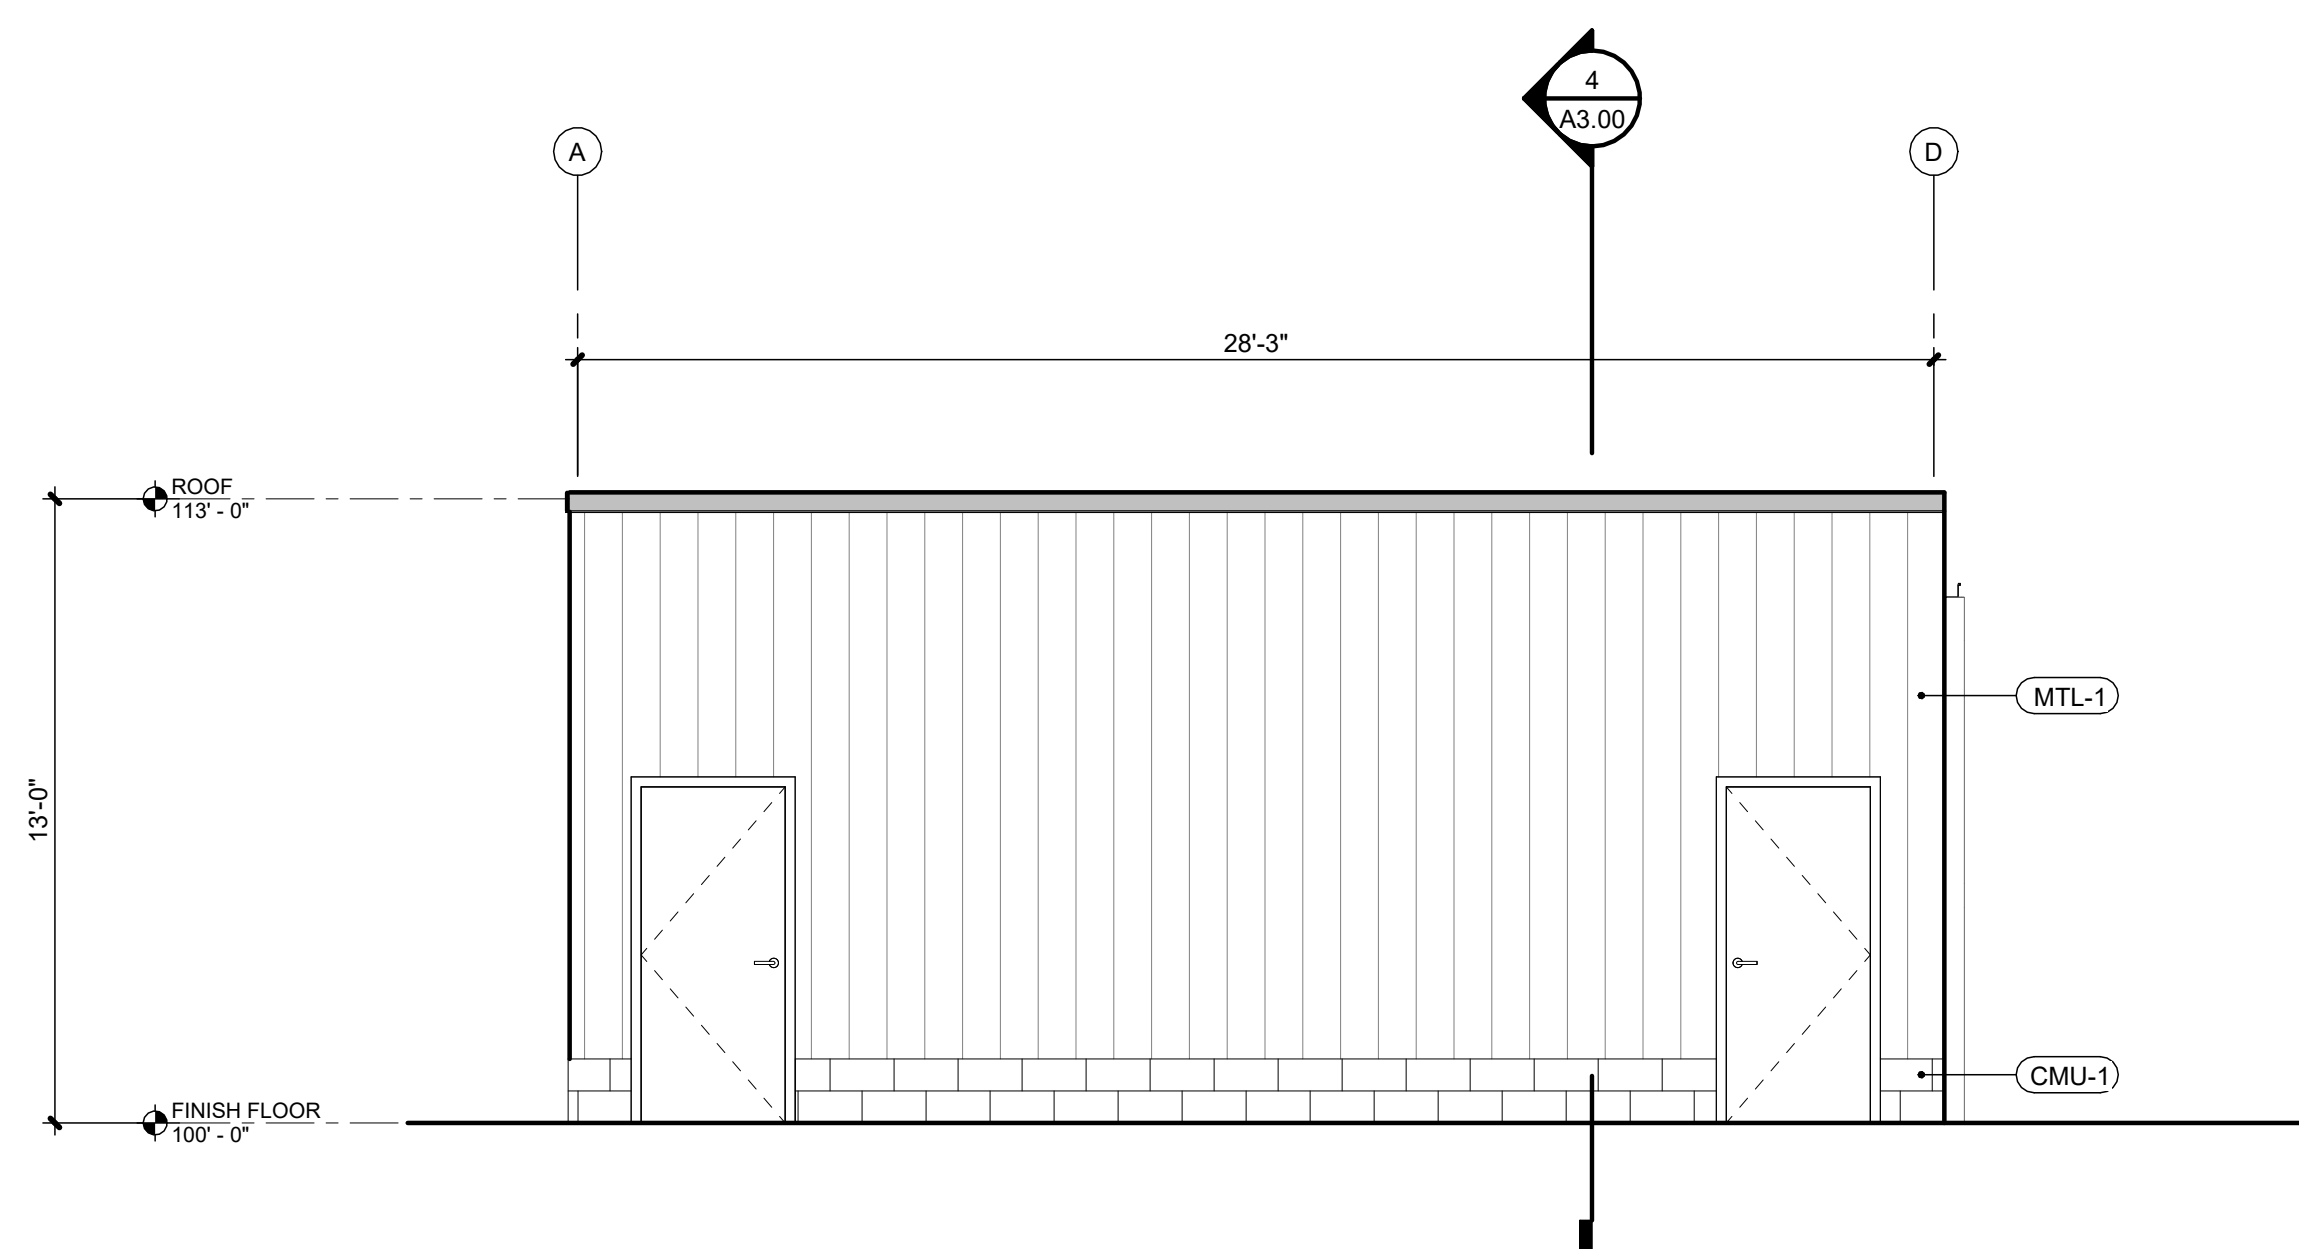


4	EAST ELEVATION
---	----------------

A2.00	SCALE : 1/4" = 1'-0"
--------------	----------------------

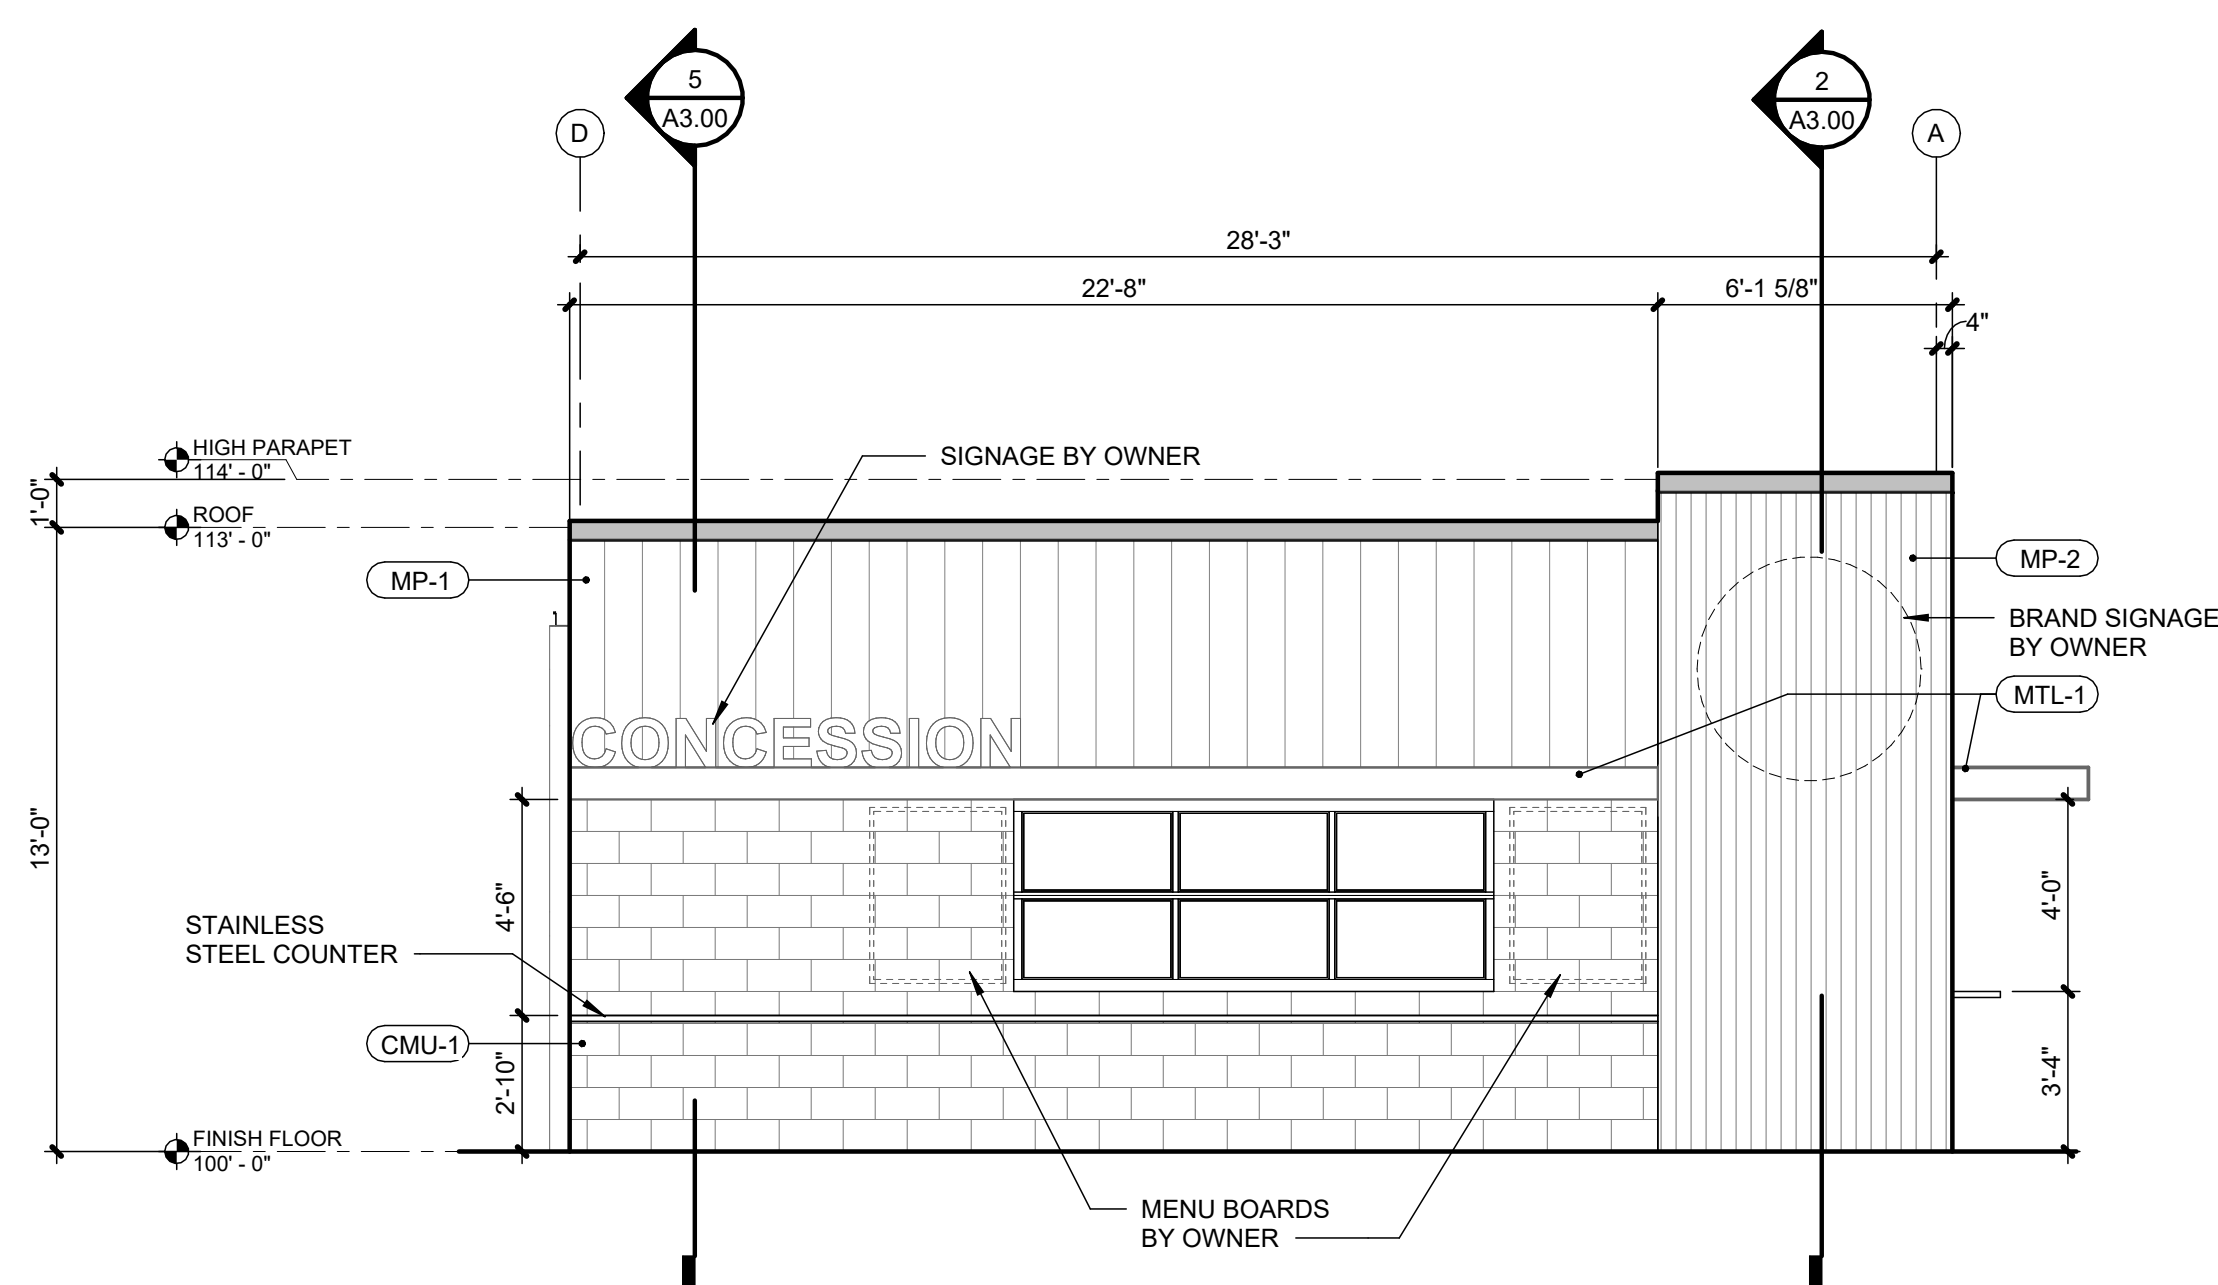


3	WEST ELEVATION
---	----------------

A2.00	SCALE : 1/4" = 1'-0"
--------------	----------------------

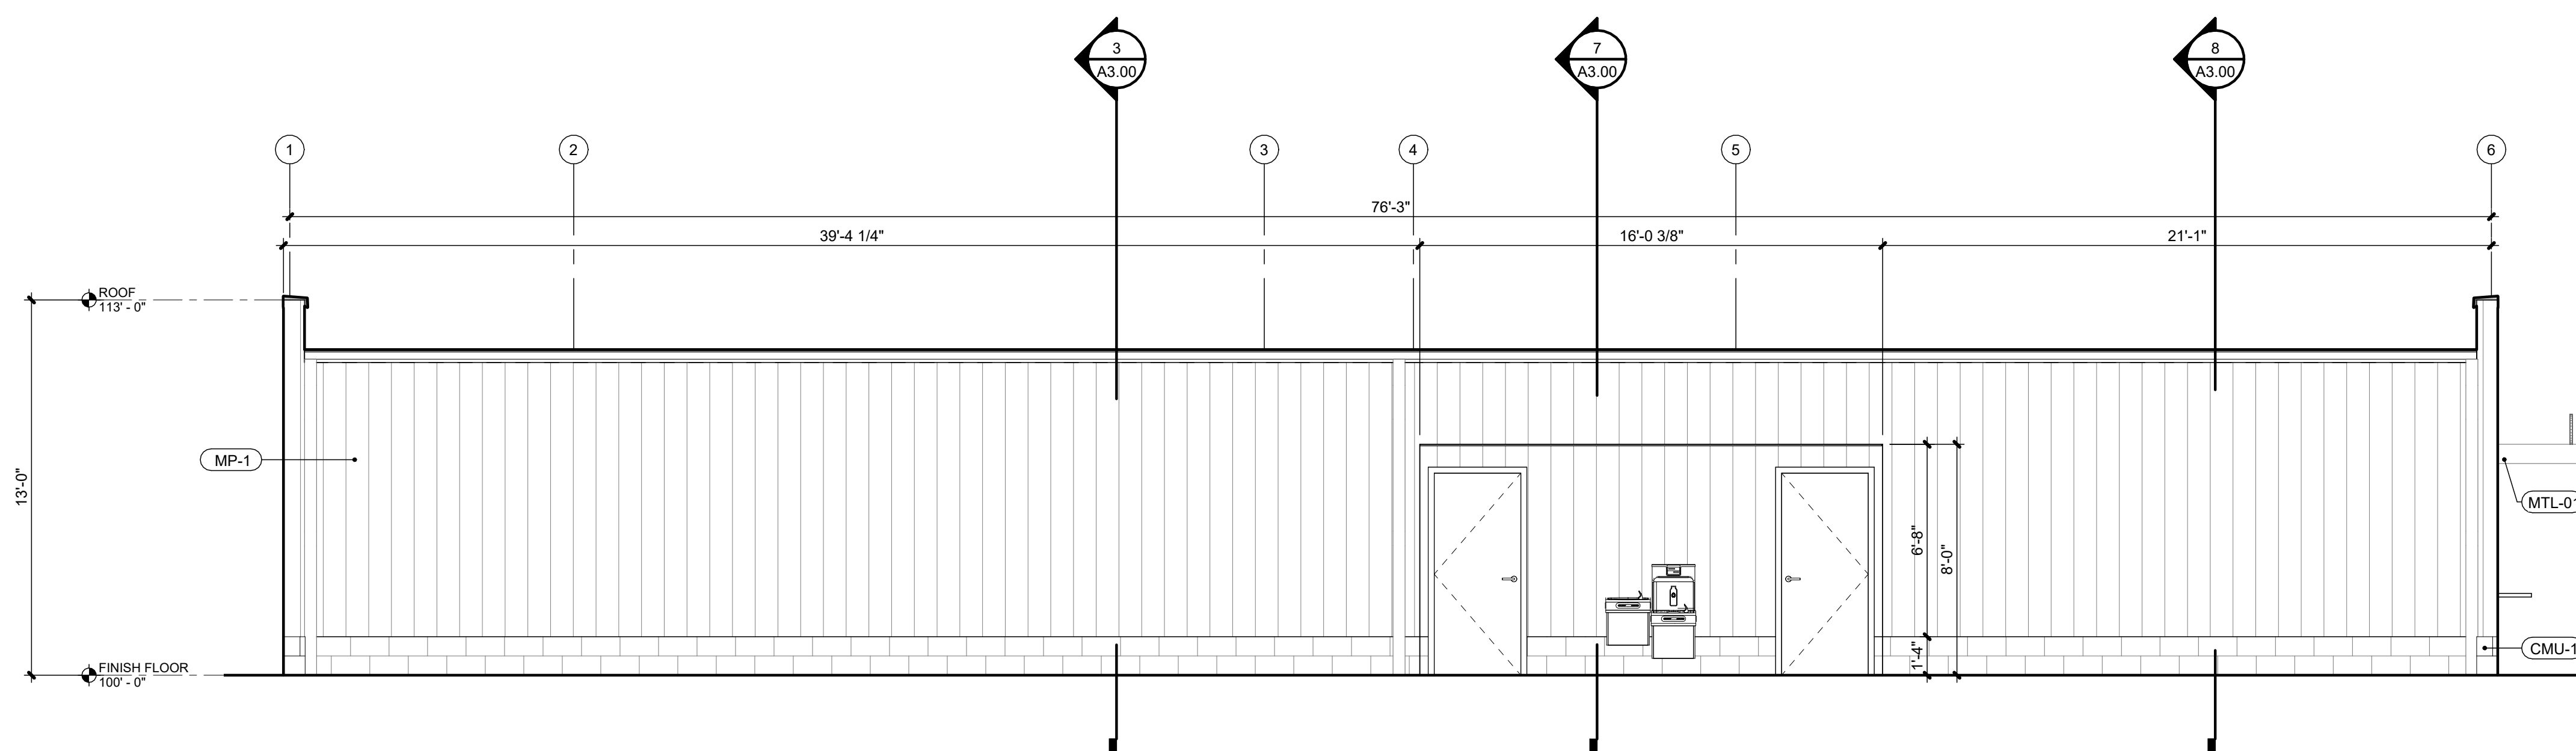

2	NORTH ELEVATION
---	-----------------

A2.00	SCALE : 1/4" = 1'-0"
--------------	----------------------

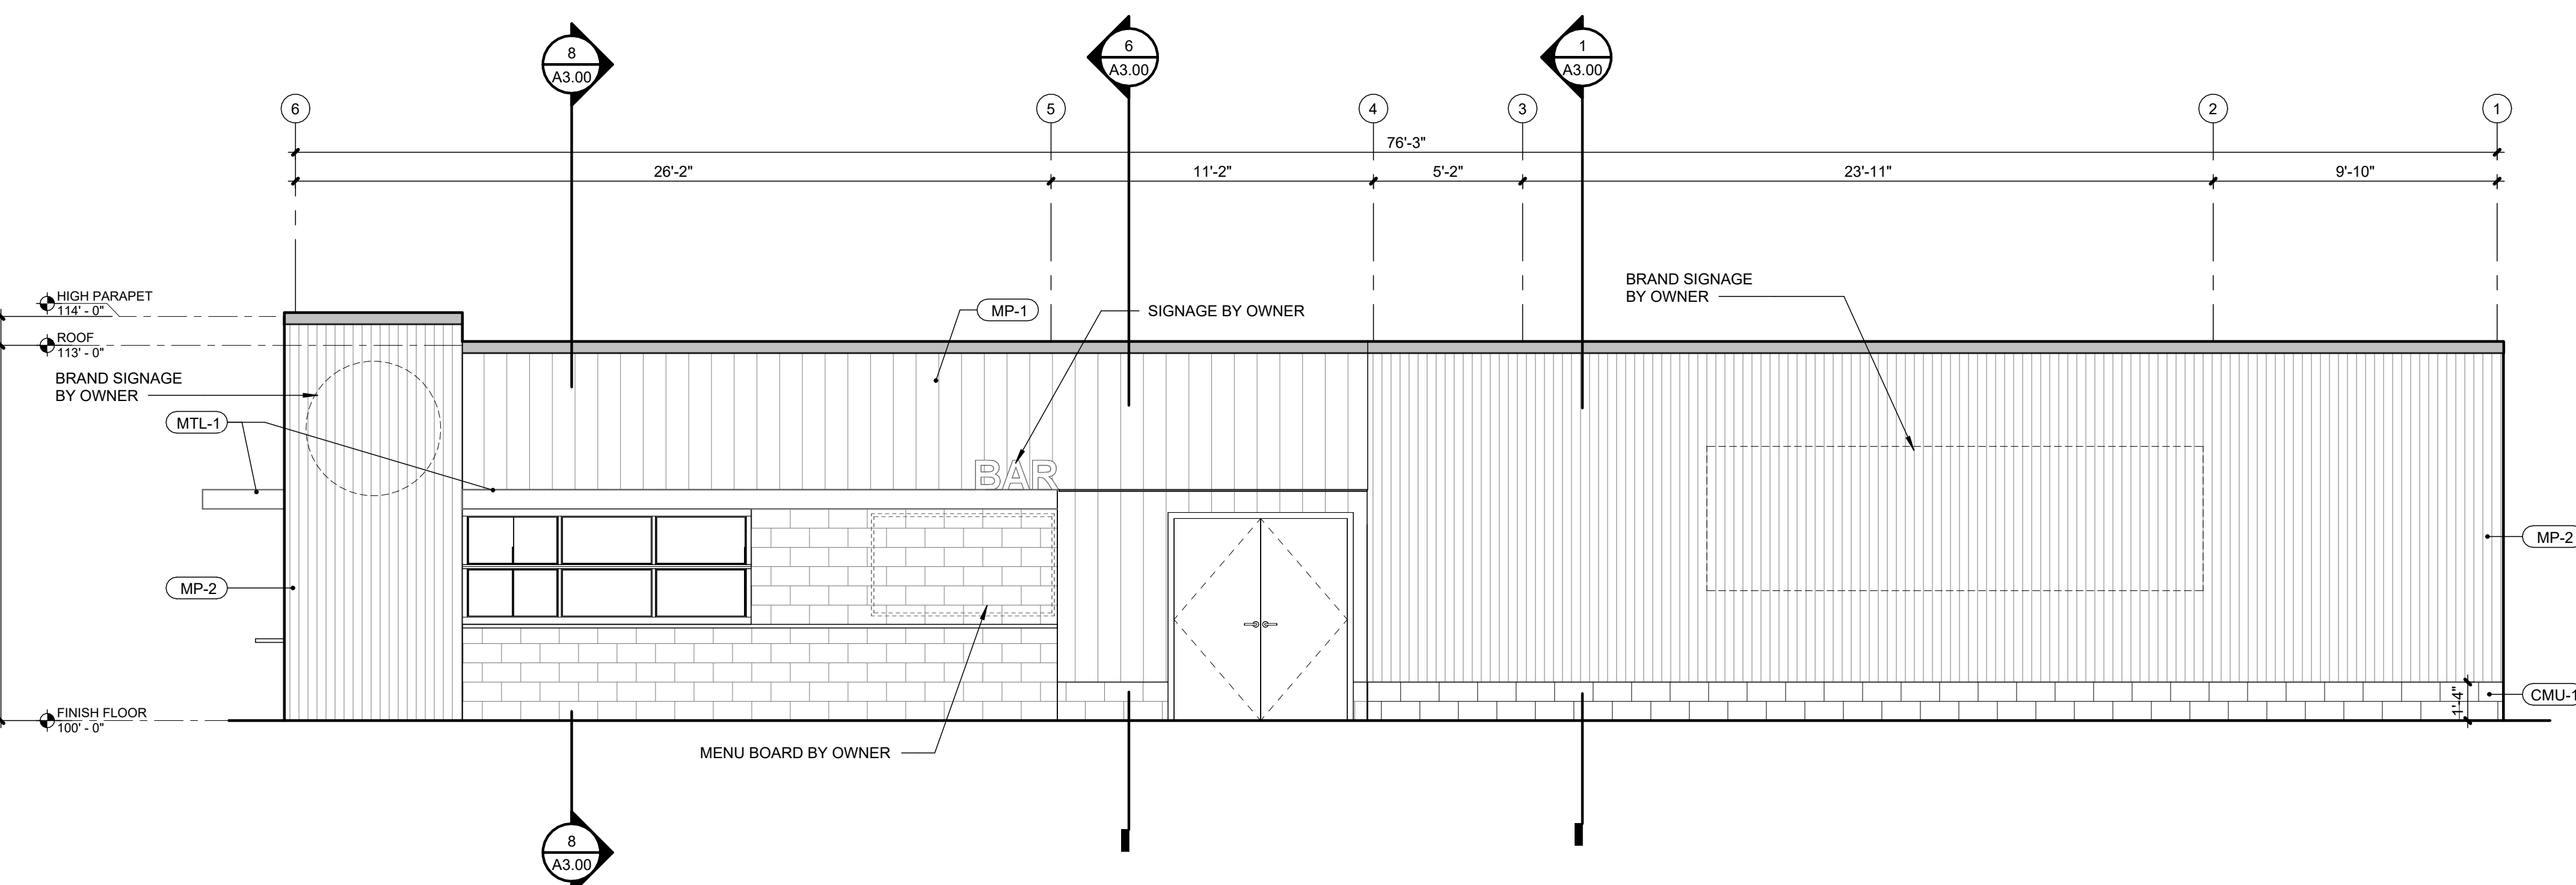

1	SOUTH ELEVATION
---	-----------------

A2.00	SCALE : 1/4" = 1'-0"
--------------	----------------------

1401 NW River Rd
Lee's Summit, MO 64081

1401 NW River Rd
Lee's Summit, MO 64081


Project No.: 19050.04b

Date: 12.08.2025

Issued For: PERMIT

REVISIONS[illegible]

REGISTRATION

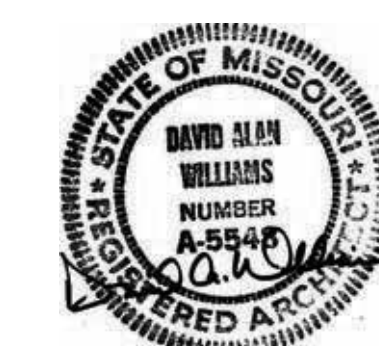

PROJECT TEAM

ARCHITECT FINKLE+WILLIAMS
ARCHITECTURE

STRUCTURAL BSE

PLUMBING PKM

MECHANICAL CONTRACTOR

ELECTRICAL PKM

**FINKLE +
WILLIAM**
ARCHITECTURE


8787 RENNER BLVD., SUITE 100
LENEXA, KANSAS 66219
913.498.1550
www.finklewilliams.com

SHEET TITLE

WALL AND BUILDING SECTIONS


SHEET NUMBER

A3.00

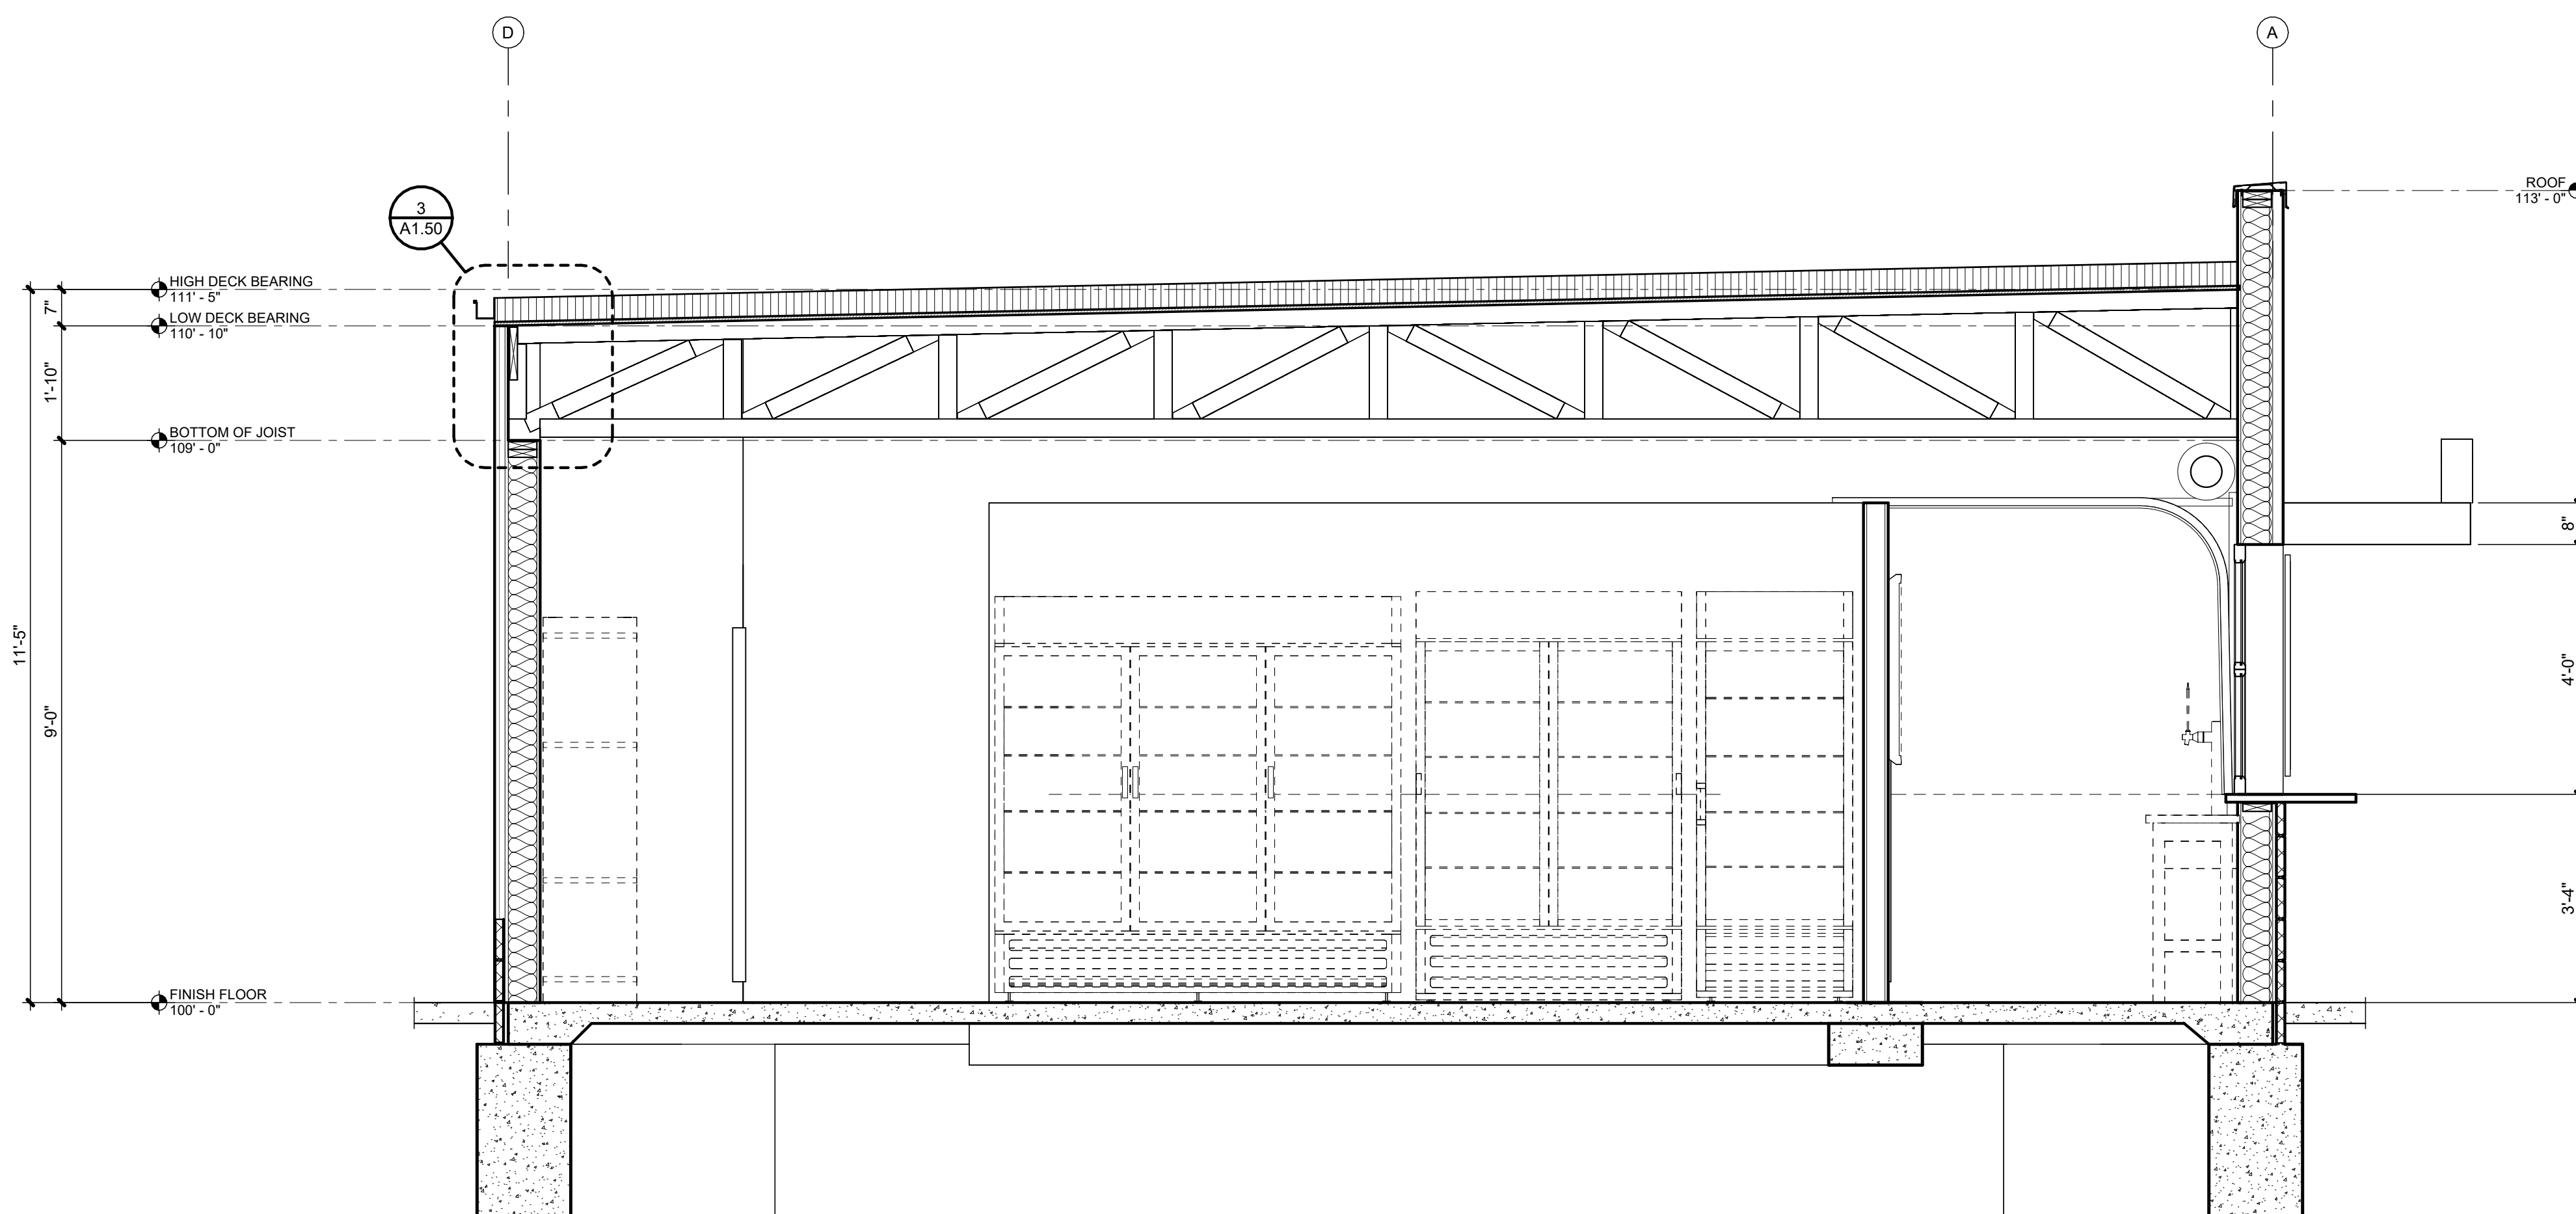


8	BUILDING SECTION
---	------------------

A3.00	SCALE : 1/2" = 1'-0"
--------------	----------------------

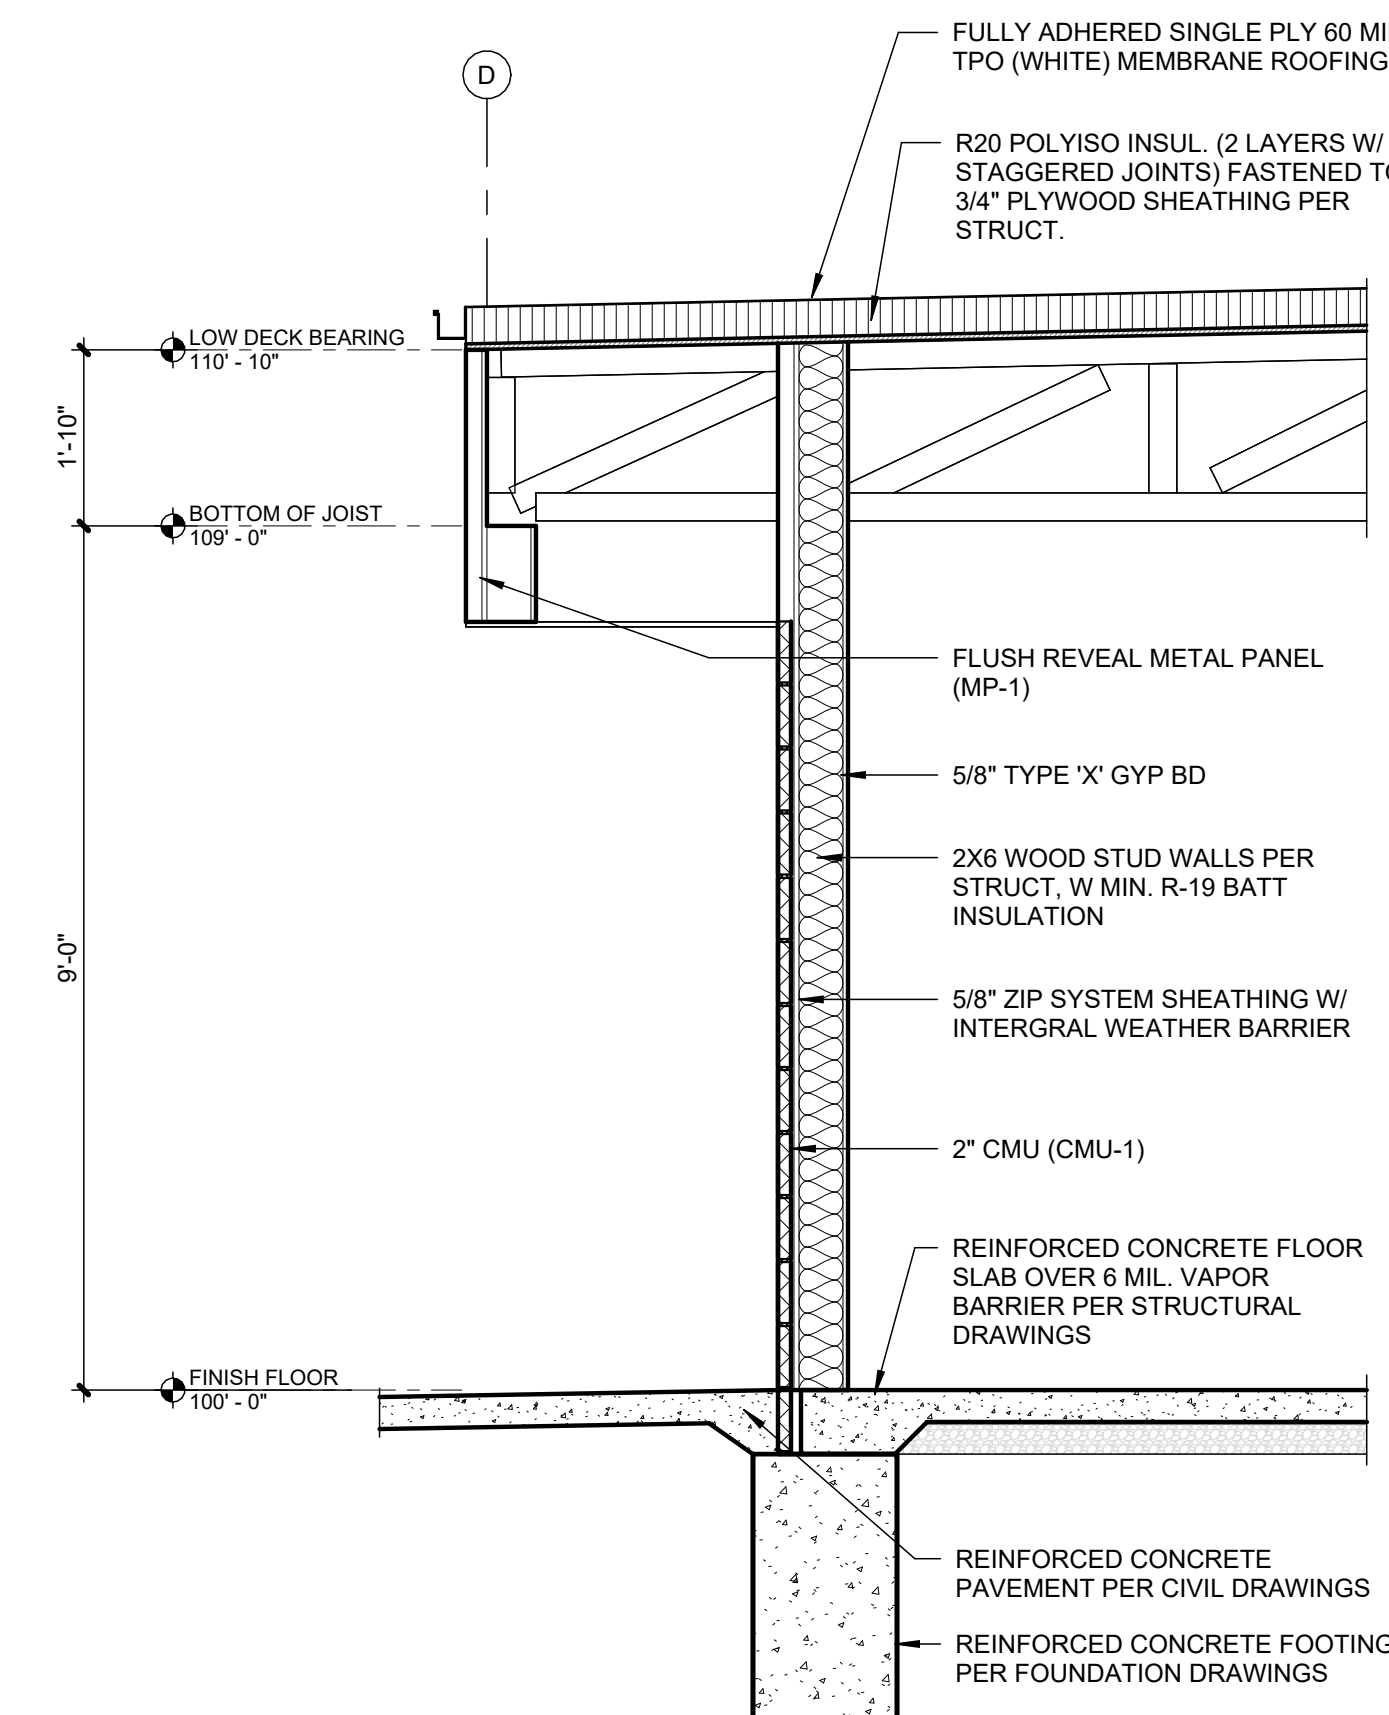


7	WALL SECTION
---	--------------

A3.00	SCALE : 1/2" = 1'-0"
--------------	----------------------

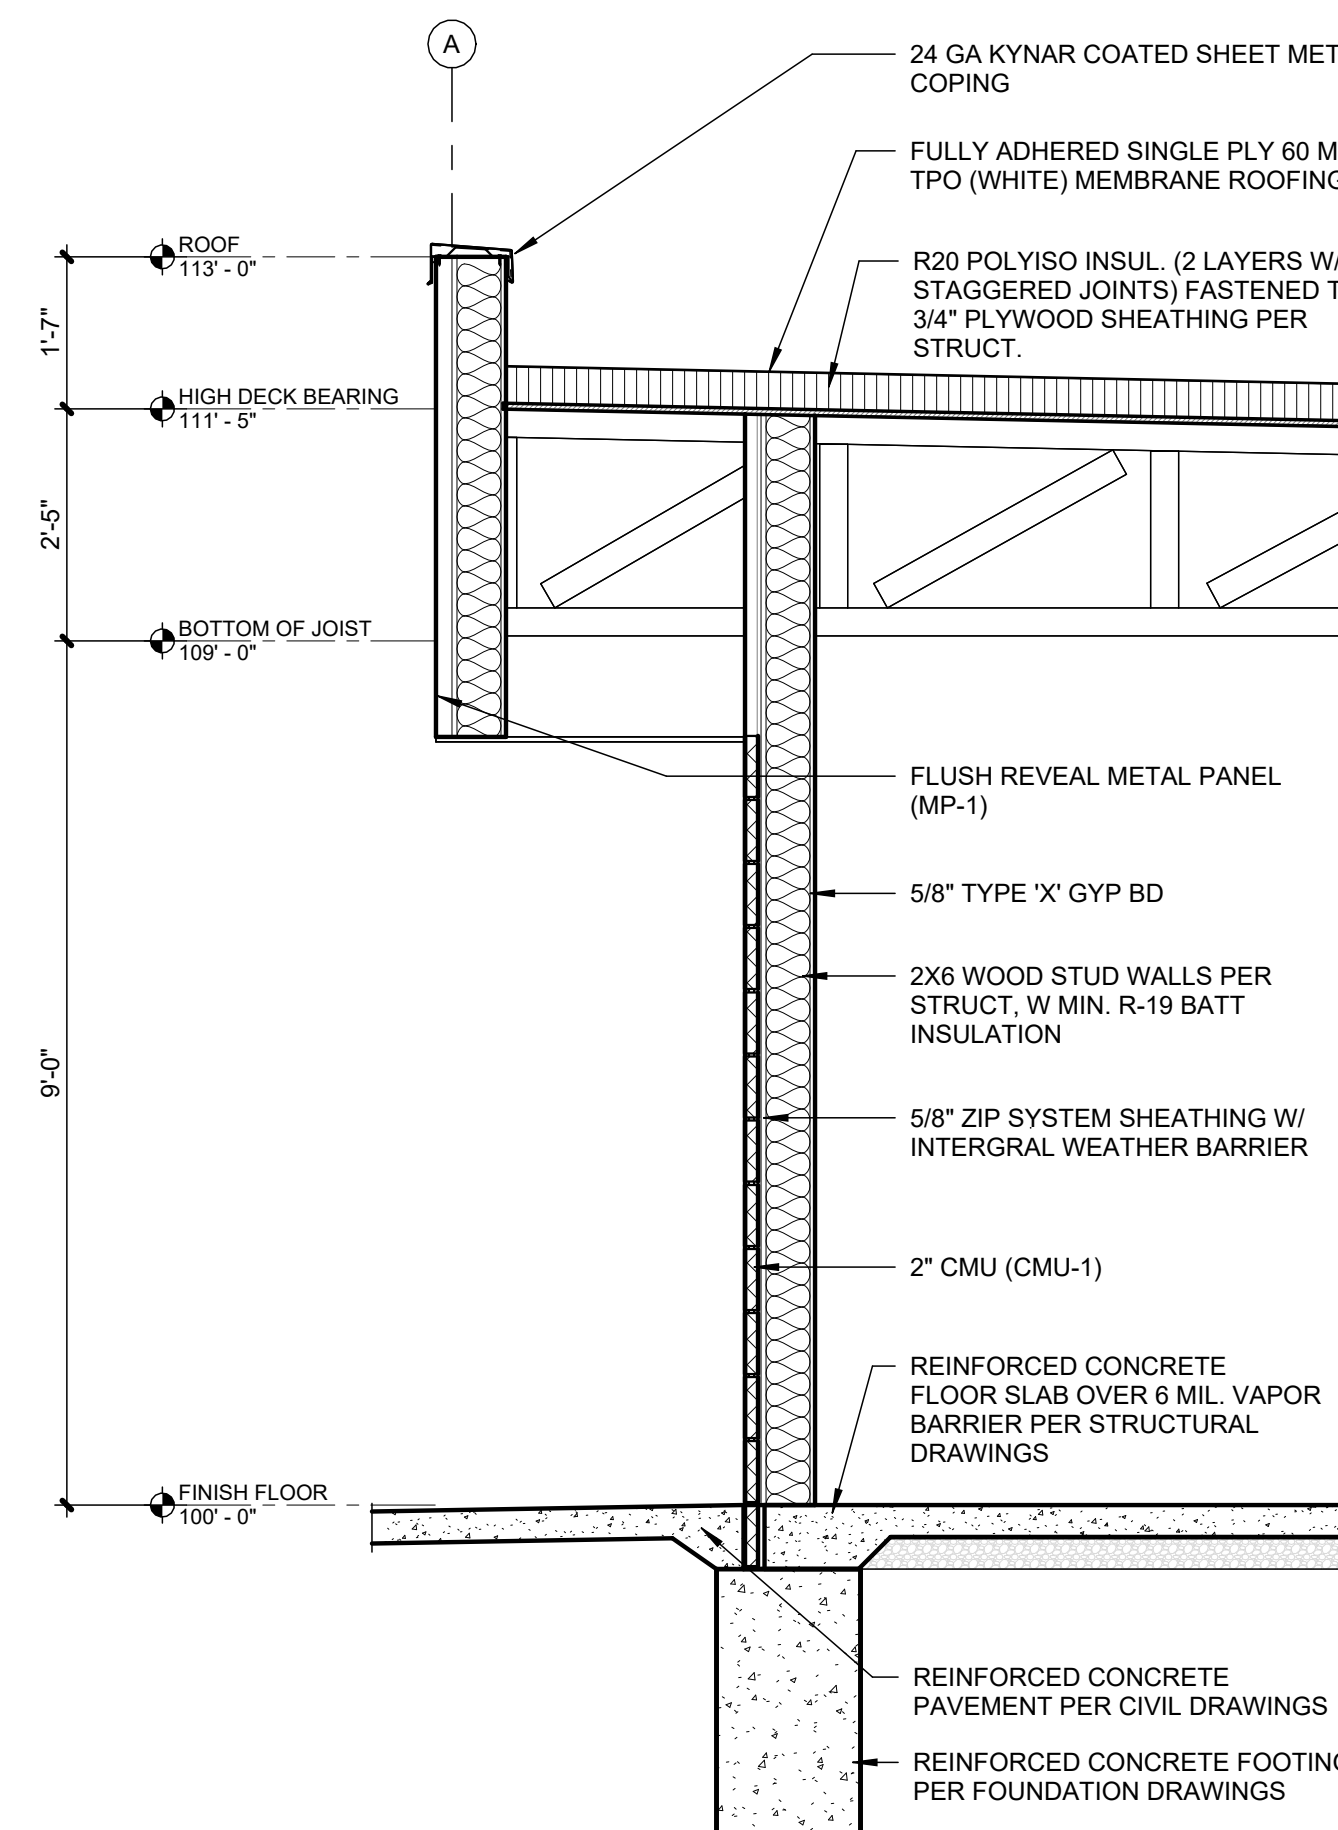


6	WALL SECTION
---	--------------

A3.00	SCALE : 1/2" = 1'-0"
--------------	----------------------

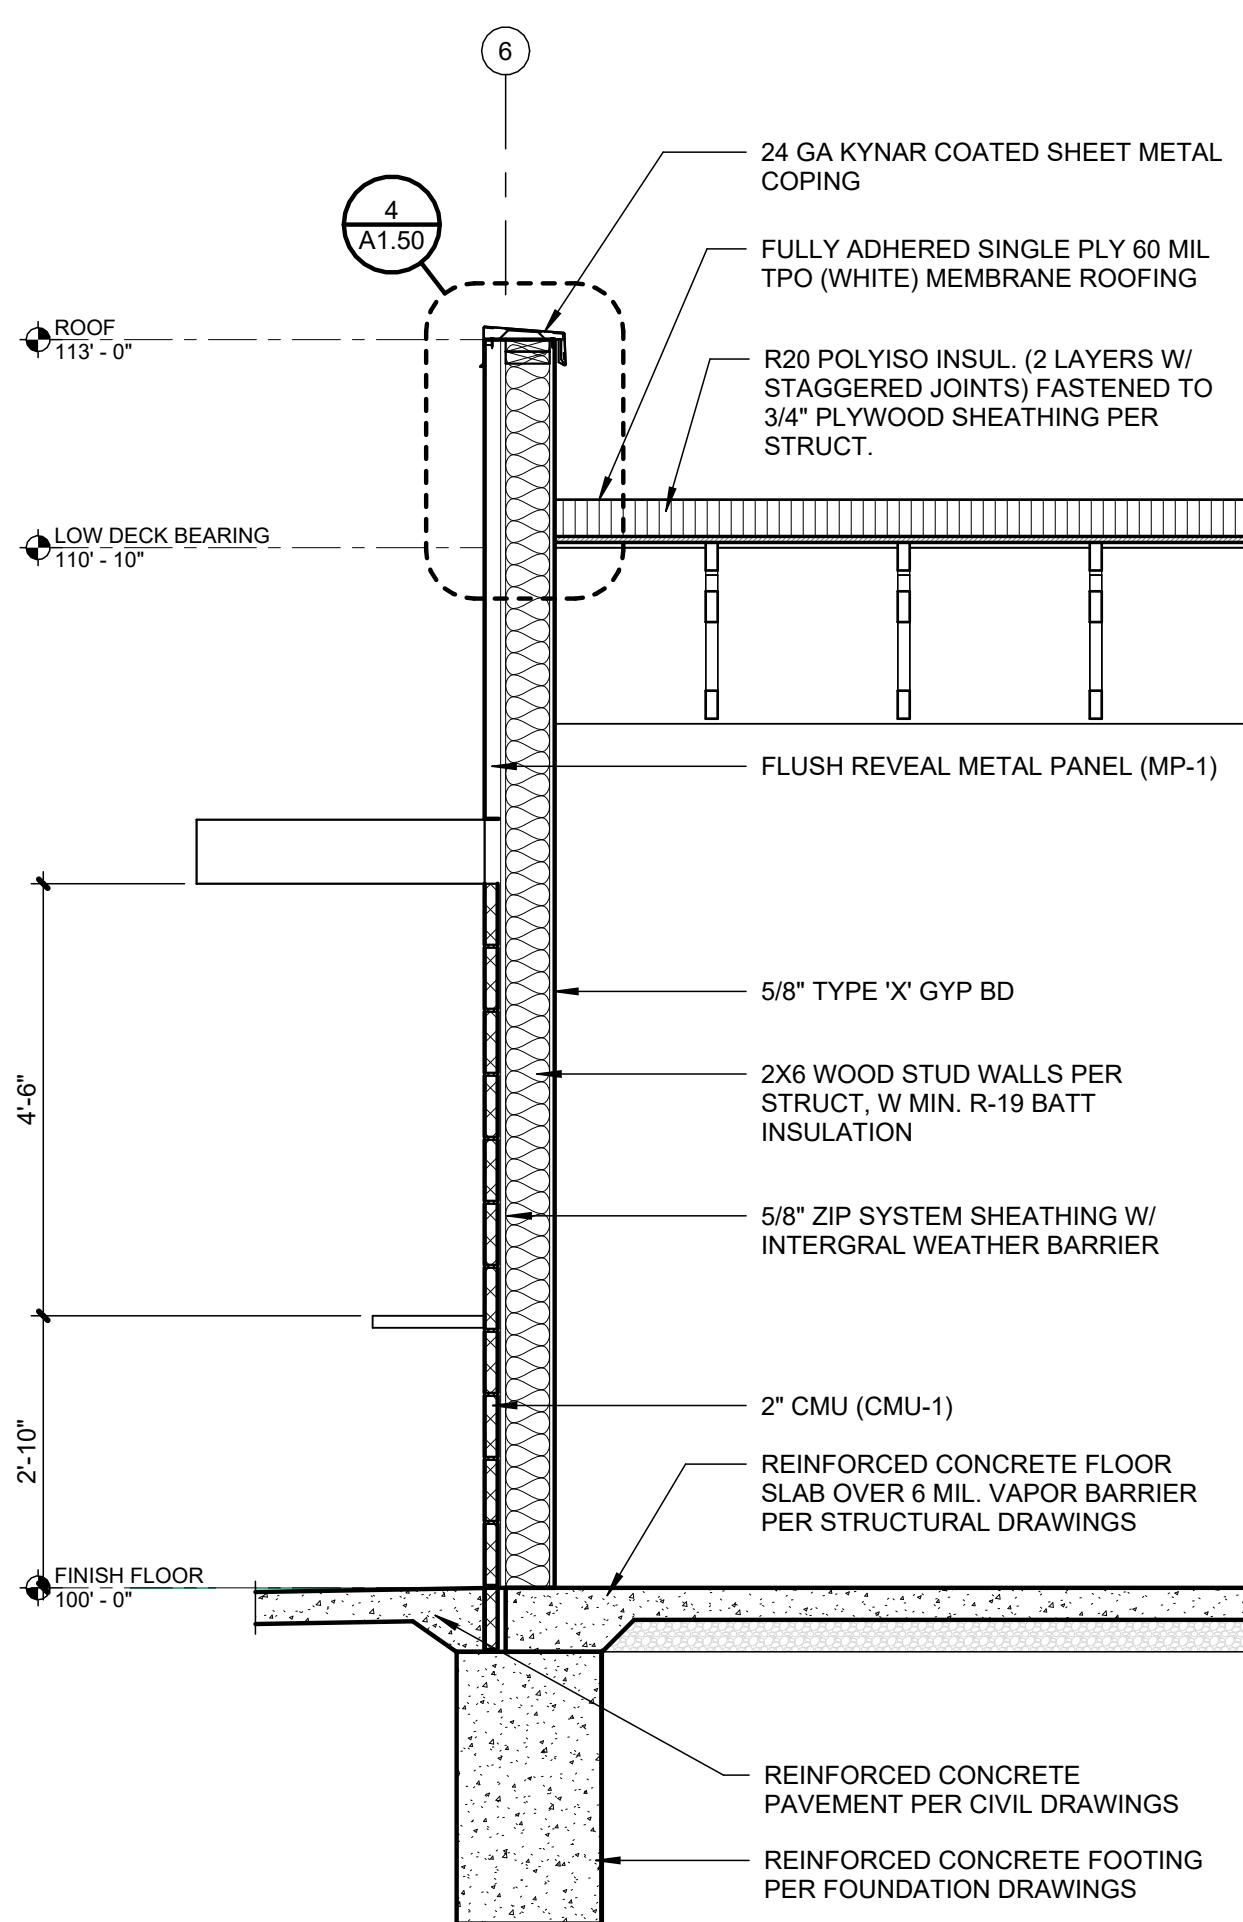


5	Section 6
---	-----------

A3.00	SCALE : 1/2" = 1'-0"
--------------	----------------------

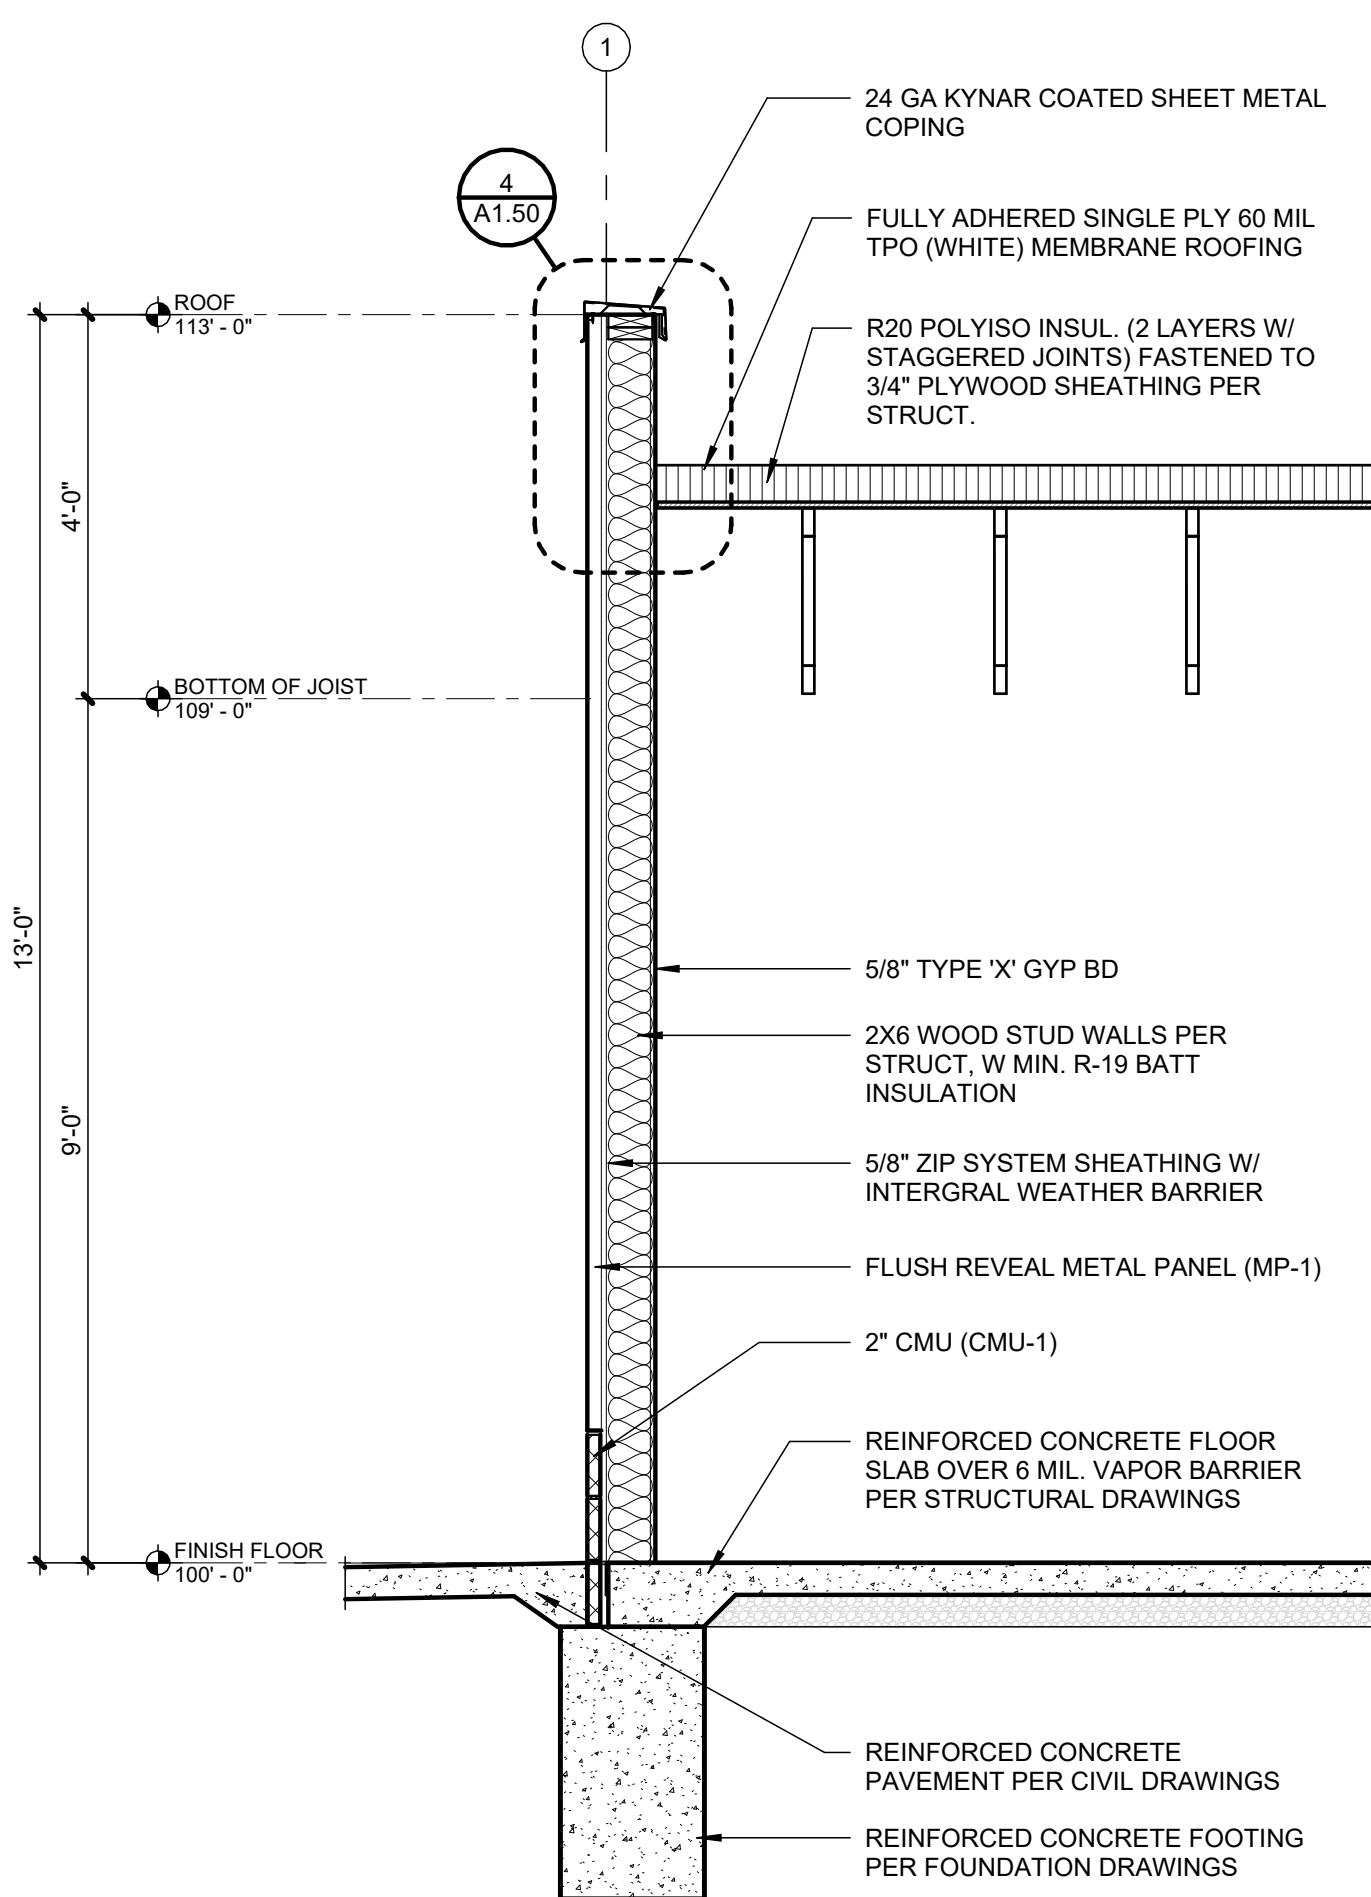


4	Section 5
---	-----------

A3.00	SCALE : 1/2" = 1'-0"
--------------	----------------------

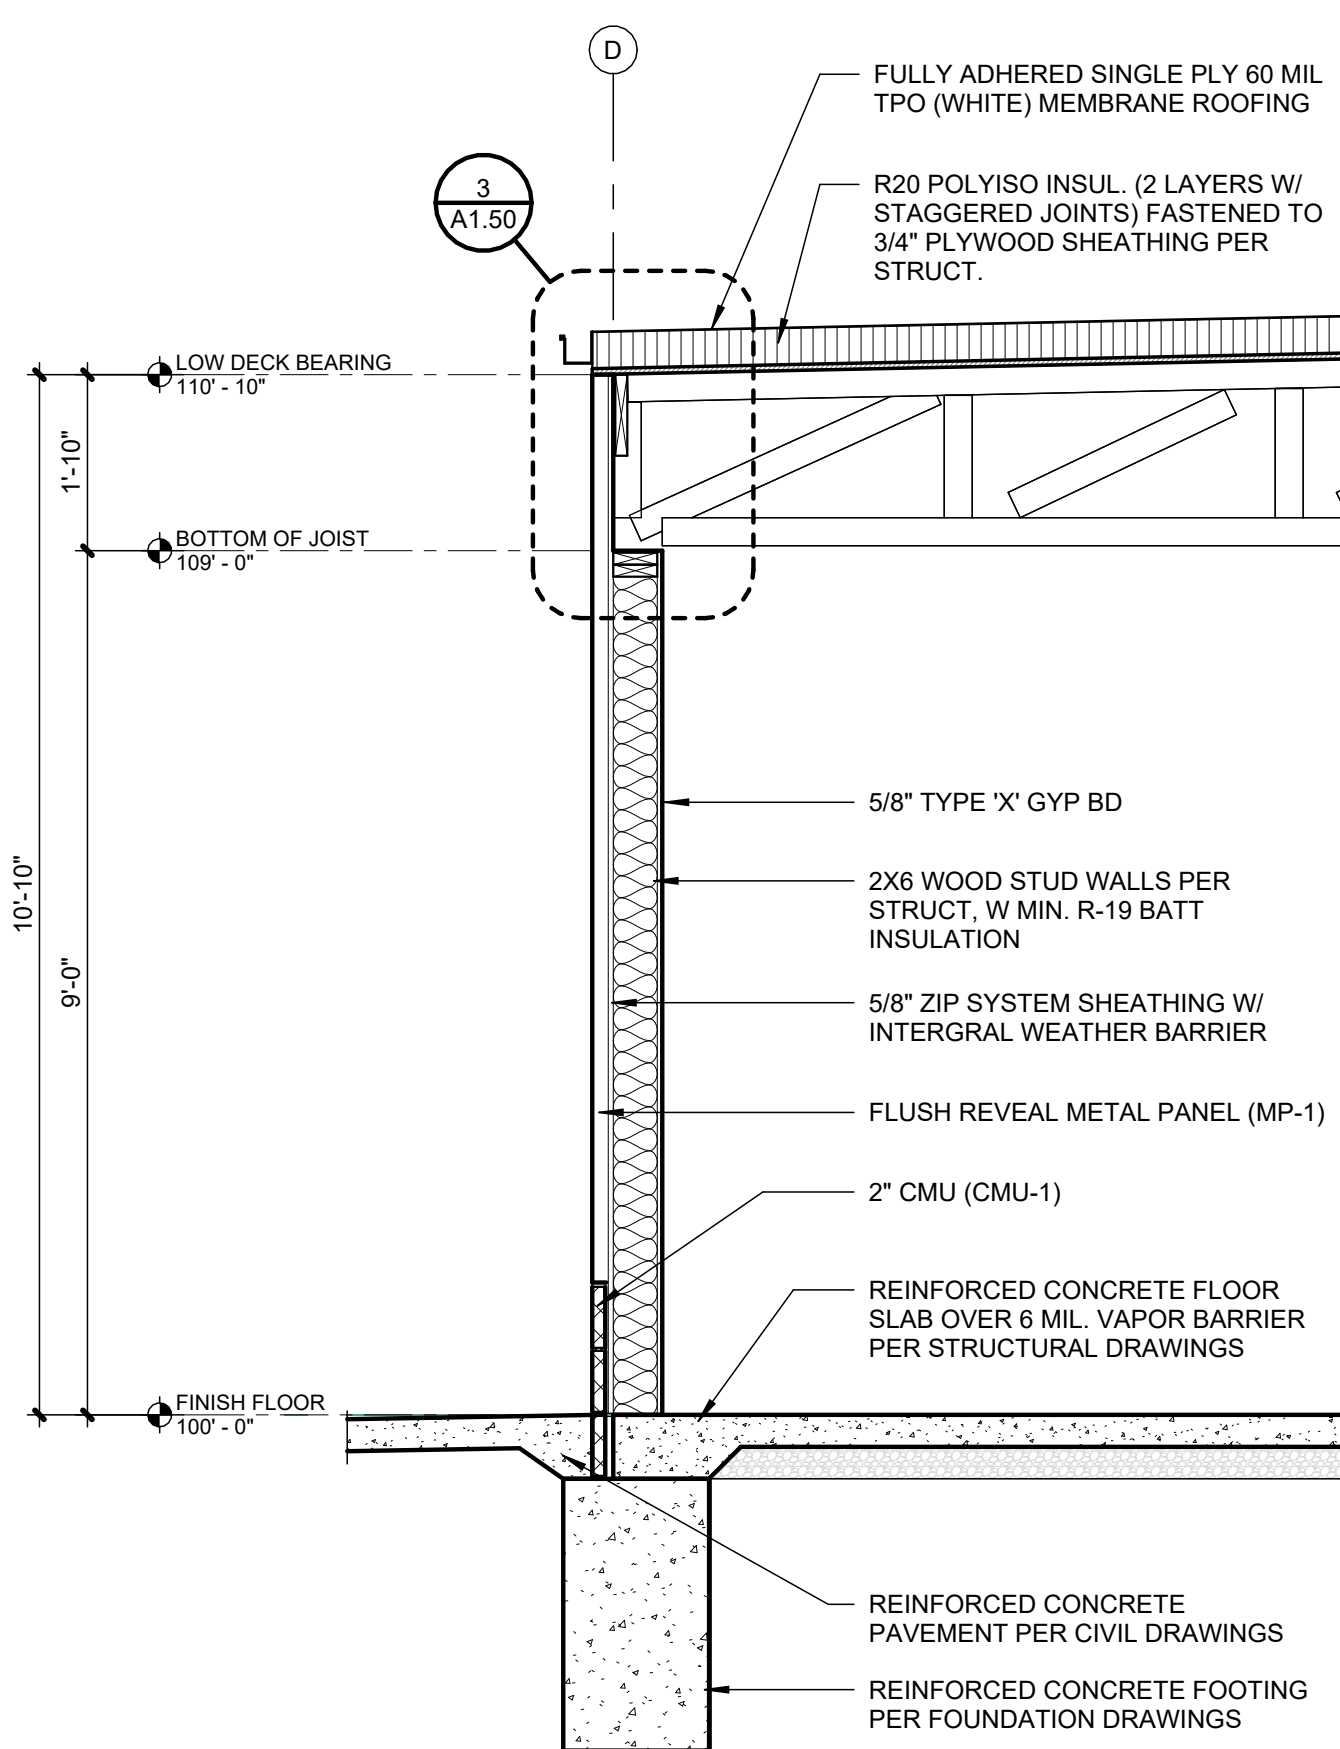


3	Section 3
---	-----------

A3.00	SCALE : 1/2" = 1'-0"
--------------	----------------------

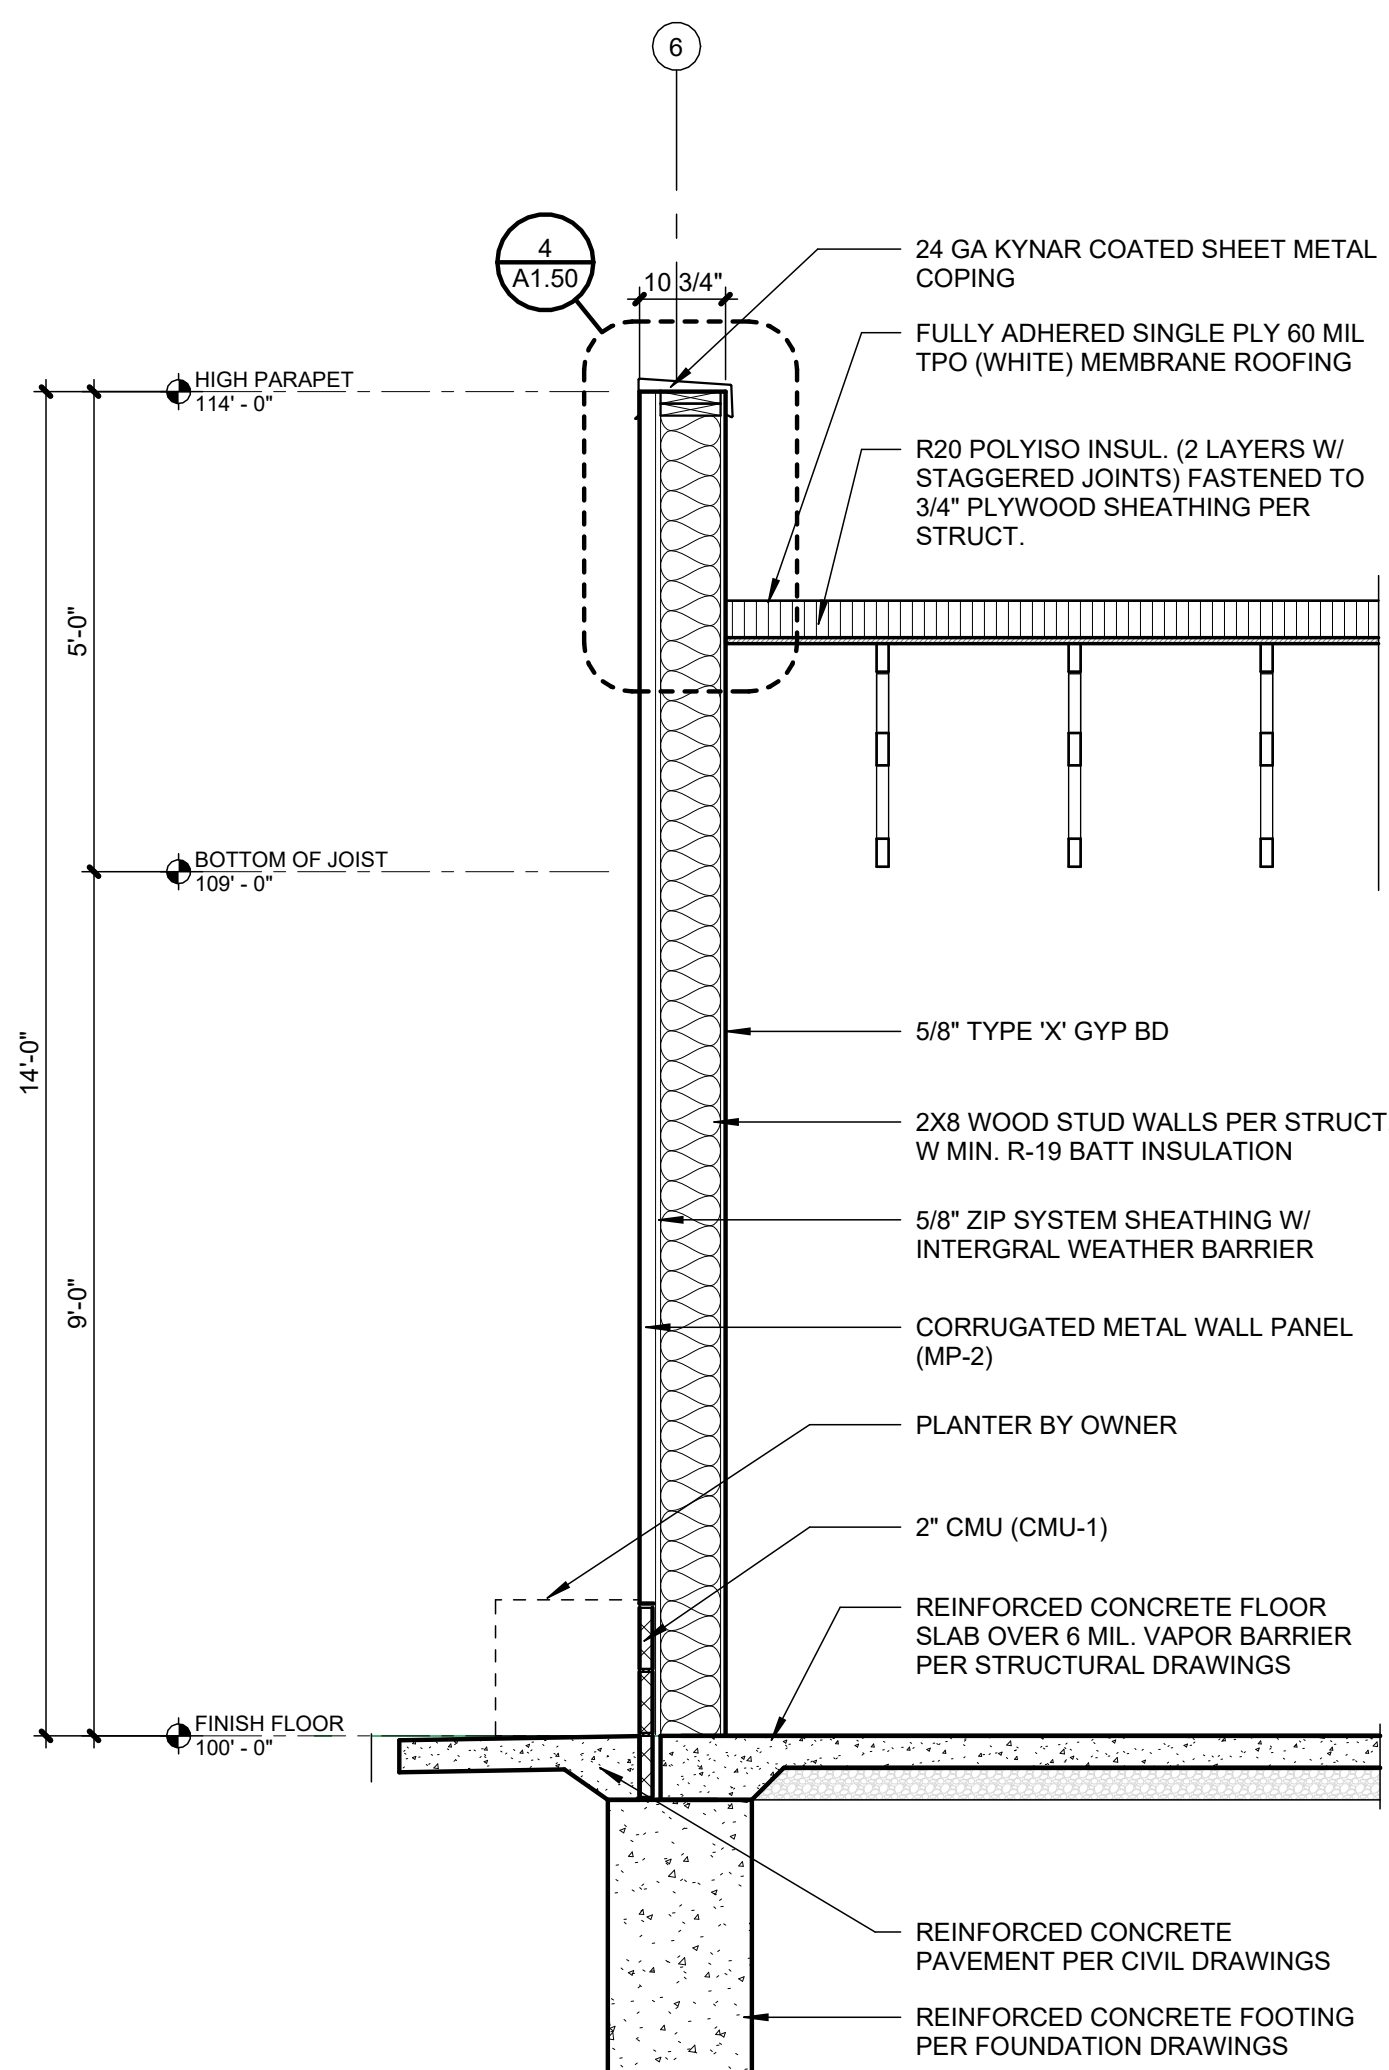

2	WALL SECTION
---	--------------

A3.00	SCALE : 1/2" = 1'-0"
--------------	----------------------

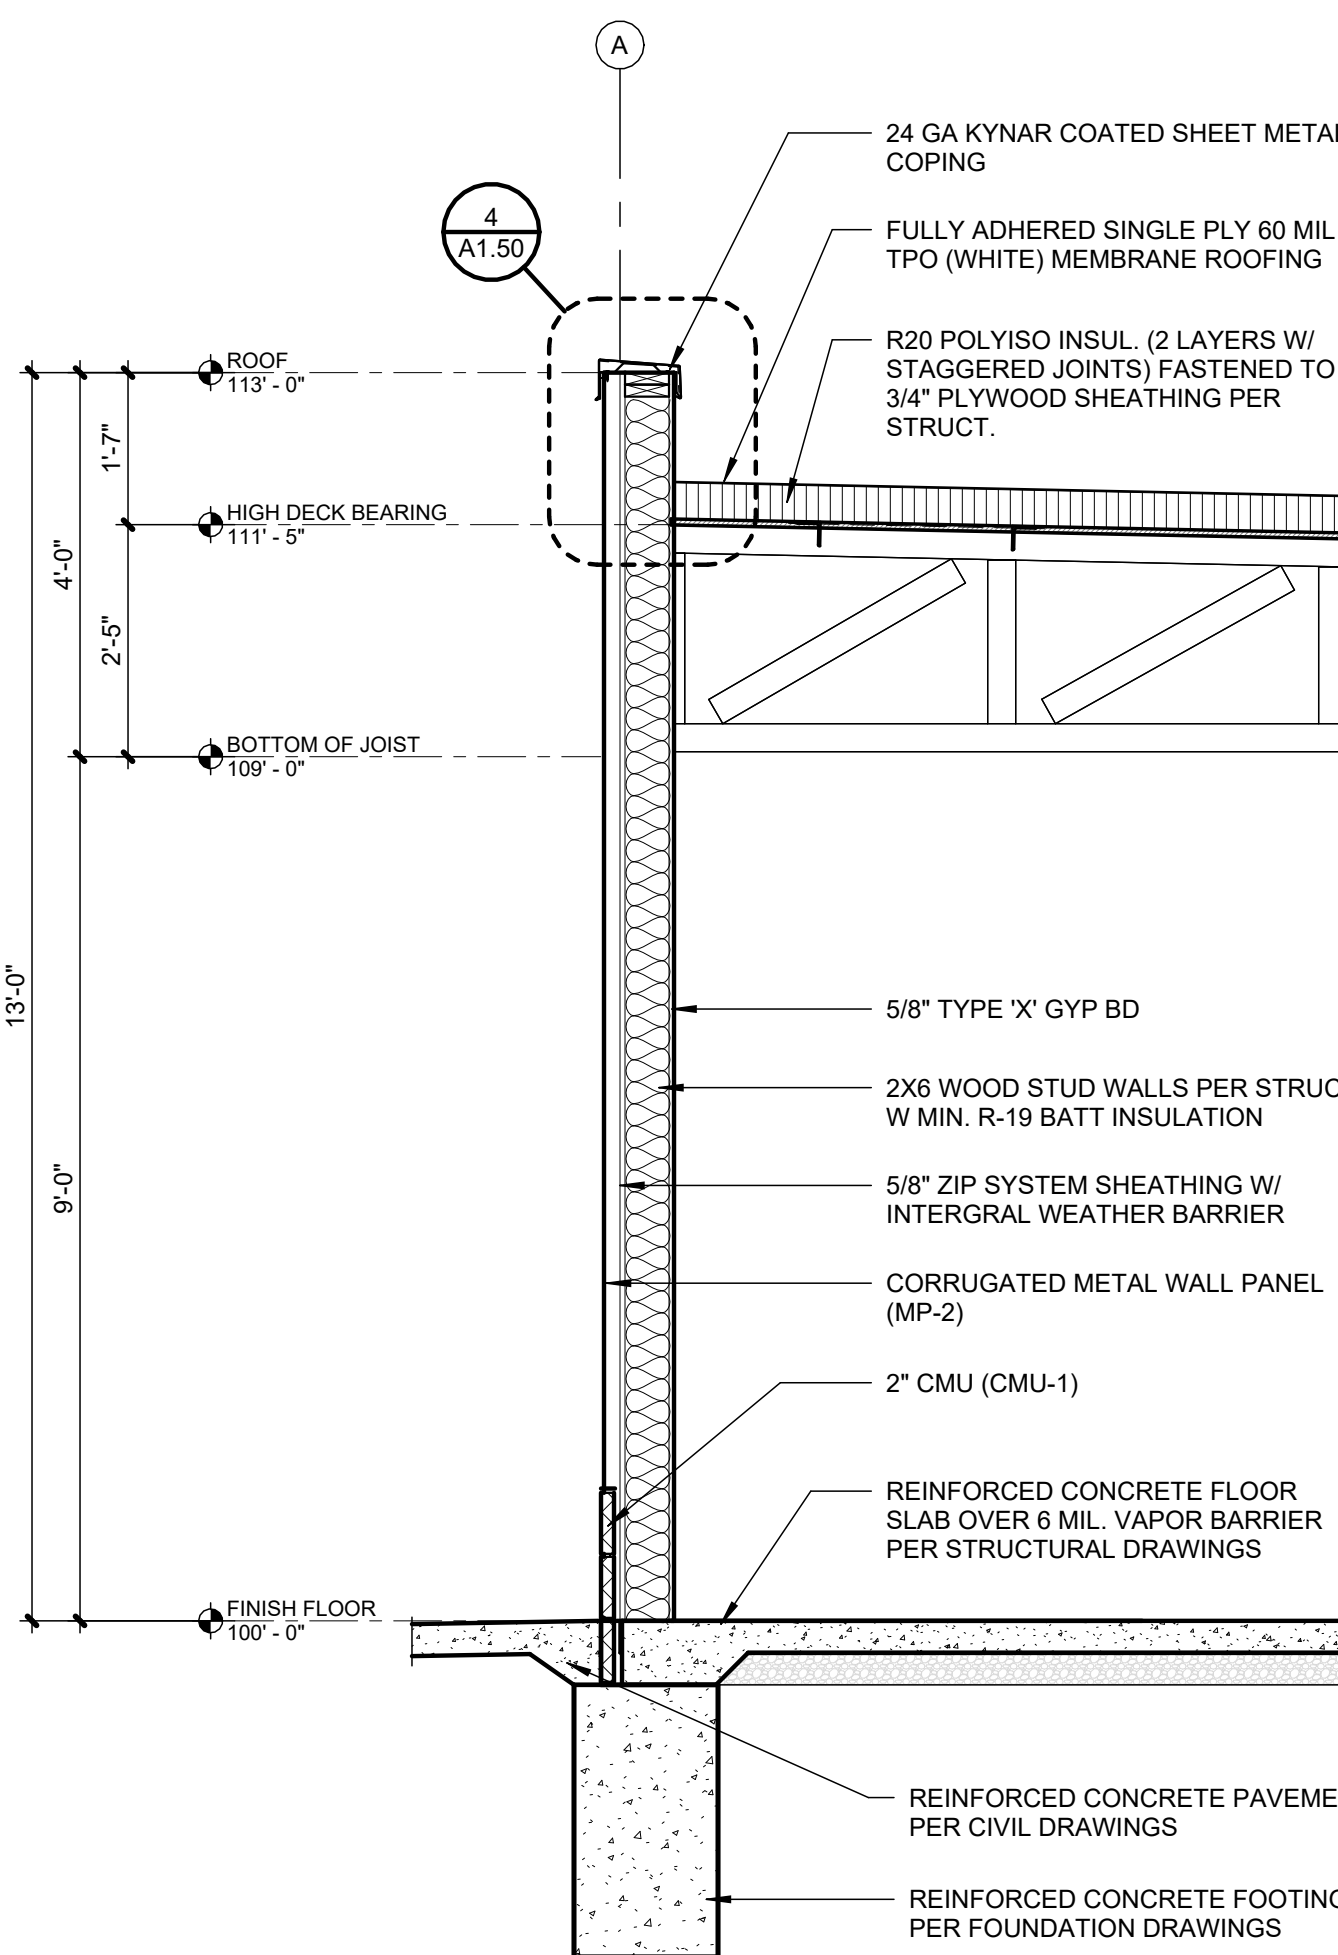

1	WALL SECTION
---	--------------

A3.00	SCALE : 1/2" = 1'-0"
--------------	----------------------

1401 NW River Rd
Lee's Summit, MO 64081

1401 NW River Rd
Lee's Summit, MO 64081

1401 NW River Rd
Lee's Summit, MO 64081

Project No.: 19050.04b


Date: 12.08.2025

Issued For: PERMIT

REVISIONS

[illegible]

REGISTRATION

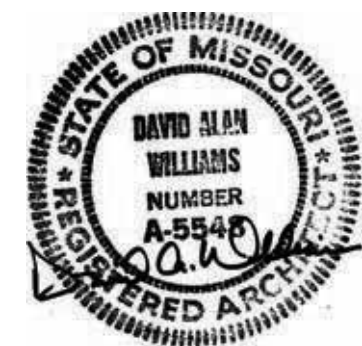

PROJECT TEAM

ARCHITECT FINKLE+WILLIAMS
ARCHITECTURE

STRUCTURAL BSE

PLUMBING PKMR

MECHANICAL CONTRACTOR

ELECTRICAL PKMR

FINKLE + WILLIAMS
ARCHITECTURE

8787 RENNER BLVD., SUITE 100
LENEXA, KANSAS 66219
913.498.1550
www.finklewilliams.com

SHEET TITLE

SHEET NUMBER

A3.50

1401 NW River Rd
Lee's Summit, MO 64081

Project No.: 19050.04b

Date: 12.08.2025

Issued For: PERMIT

REVISIONS

[illegible]

REGISTRATION



PROJECT TEAM

ARCHITECT FINKLE+WILLIAMS
ARCHITECTURE

STRUCTURAL

PLUMBING PKMF

MECHANICAL CONTRACTOR

ELECTRICAL PKMF

FINKLE + WILLIAMS
ARCHITECTURE

913.498.1550
www.finklewilliams.com

SHEET TITLE

DOOR AND FINISH SCHEDULE

SHEET NUMBER

A8.00

KEY	MATERIAL	MFR	PATTERN/STYLE	FINISH/COLOR	SIZE	REMARKS	CONTACT
FLOOR FINISHES							
SC-01	SEALED CONCRETE						
BASE FINISHES							
RB-01	RESILIENT BASE						
SB-01	SCHLUTER BASE	SCHLUTER SYSTEMS	DILEX-AHKA				
WD-01	WOOD BASE						
WALL FINISHES							
EP-01	EPOXY PAINT						
FRP-01	WALL COVERING						
TL-01	TILE						
CEILING FINISHES							
EXP-01	EXPOSED TO STRUCTURE			PAINT BLACK			
MISCELLANEOUS FINISHES							
CG	CORNER GUARD						


1. COORDINATE ALL FINAL FINISH SELECTIONS WITH OWNER PRIOR TO ORDERING MATERIALS.
2. ROOM FINISH SCHEDULE IS FOR GENERAL COORDINATION OF FINISHES. REFERENCE ROOM FINISH PLANS, INTERIOR ELEVATIONS AND REFLECTED CEILING PLANS FOR COORDINATION OF ALL FINAL FINISHES.
3. WHERE MULTIPLE FINISHES ARE INDICATED ON ANY SURFACE REFER TO THE DRAWINGS FOR EXTENT OF EACH FINISH.
4. STOP WALL / CEILING PAINT COLORS AND FINISH MATERIAL CHANGES AT INSIDE CORNERS, UNLESS NOTED OTHERWISE.
5. WHERE NO BASE IS INDICATED (-) CONTINUE WALL FINISH TO FLOOR.
6. ALL EXPOSED DUCTWORK, MECHANICAL GRILLES, ELECTRICAL CONDUIT, PLUMBING SUPPLY, WASTE OR VENTING AND ALL OTHER PIPING SHALL BE PAINTED TO MATCH ADJACENT WALL OR CEILING FINISH, UNLESS NOTED OTHERWISE.
7. TILE INDICATED ON WALLS IS TO BE FULL HEIGHT, UNLESS NOTED OTHERWISE.
8. UNFINISHED EXPOSED TILE EDGES TO RECEIVE STAINLESS STEEL OR ALUMINUM TRIM EQUAL TO SCHLUTER, FINISH: **[TO BE SELECTED BY ARCHITECT FROM STANDARD OPTIONS]**. AT CORNERS, **[QUADEC]** AT TOP EDGES, SCHIENE / JOLLY.
9. PAINT ALL HOLLOW METAL DOORS AND FRAMES W/ 2 COATS OF SEMI-GLOSS, ACRYLIC LATEX PAINT TO MATCH ADJACENT WALL, U.N.O.
10. DOOR FRAME FINISH TRANSITIONS SHALL BE AT THE INSIDE CORNER OF THE STOP ON THE DOOR SIDE.
11. DUAL FINISH DOORS SHALL HAVE MATCHING FRONT FACE AND STRIKE EDGE AND MATCHING BACK FACE AND HINGE EDGE.

ROOM		WALLS						CEILING	REMARKS
NO.	NAME	FLOOR	BASE	N	E	S	W		
100	CONCESSIONS	SC-01	RB-01	FRP-01	FRP-01	FRP-01	FRP-01	EXP-01	
101	BAR AREA	SC-01	RB-01	FRP-01	FRP-01	FRP-01	FRP-01	EXP-01	
102	BACK OF HOUSE	SC-01	RB-01	FRP-01	FRP-01	FRP-01	FRP-01	EXP-01	
103	SHARED SINKS	SC-01	TL-01	TL-01 / EP-01	TL-01 / EP-01	TL-01 / EP-01	TL-01 / EP-01	EXP-01	
104	WOMEN'S RESTROOM	SC-01	TL-01	TL-01 / EP-01	TL-01 / EP-01	TL-01 / EP-01	TL-01 / EP-01	EXP-01	
105	MEN'S RESTROOM	SC-01	TL-01	TL-01 / EP-01	TL-01 / EP-01	TL-01 / EP-01	TL-01 / EP-01	EXP-01	
106	FAMILY RESTROOM	SC-01	TL-01	TL-01 / EP-01	TL-01 / EP-01	TL-01 / EP-01	TL-01 / EP-01	EXP-01	
107	UTILITY ROOM	SC-01	RB-01	FRP-01	FRP-01	FRP-01	FRP-01	EXP-01	


(1) ALL WALL FINISHES TO 9'-0" U.N.O. ON INTERIOR ELEVATIONS

NO.	DOOR				FRAME				DETAILS				HARDWARE	REMARKS
	W.	H.	SIZE		TYPE	MAT.	TYPE	MAT.	RATING	JAMB	HEAD	SILL		
100.A	10'-0"	4'-0"	-	-	O1	AL			-		11/A3.50	10/A3.50		
101.A	10'-0"	4'-0"	-	-	O1	AL			-		11/A3.50	9/A3.50		
102.A	3'-0"	7'-0"	1/4"	1/4"	H1	HM	H1	HM	-	2/A3.50	3/A3.50	1/A3.50		
103.A	6'-0"	7'-0"	1/4"	1/4"	H2	HM	H1	HM	-	2/A3.50	3/A3.50	1/A3.50		
103.B	3'-0"	7'-0"	1/4"	1/4"	H1	HM	H1	HM	-	2/A3.50	3/A3.50	1/A3.50		
106.A	3'-0"	7'-0"	1/4"	1/4"	H1	HM	H1	HM	-	2/A3.50	3/A3.50	1/A3.50		
107.A	3'-0"	7'-0"	1/4"	1/4"	H1	HM	H1	HM	-	2/A3.50	3/A3.50	1/A3.50		

ALL HOLLOW METAL DOORS TO BE FACTORY PRIMED. PAINT TO BE SPRAYED

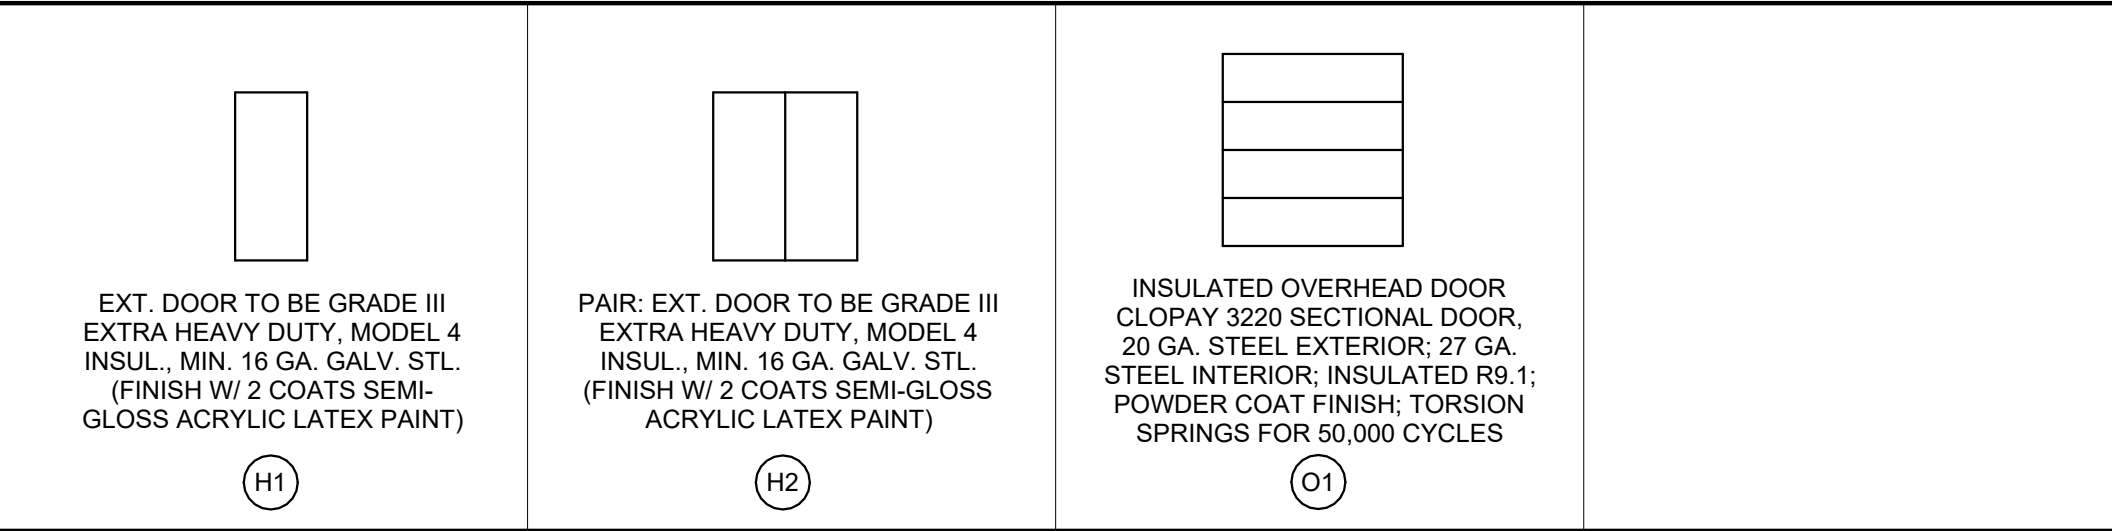

ALL HOLLOW METAL FRAMES TO BE FACTORY PRIMED. PAINT TO BE SPRAYED

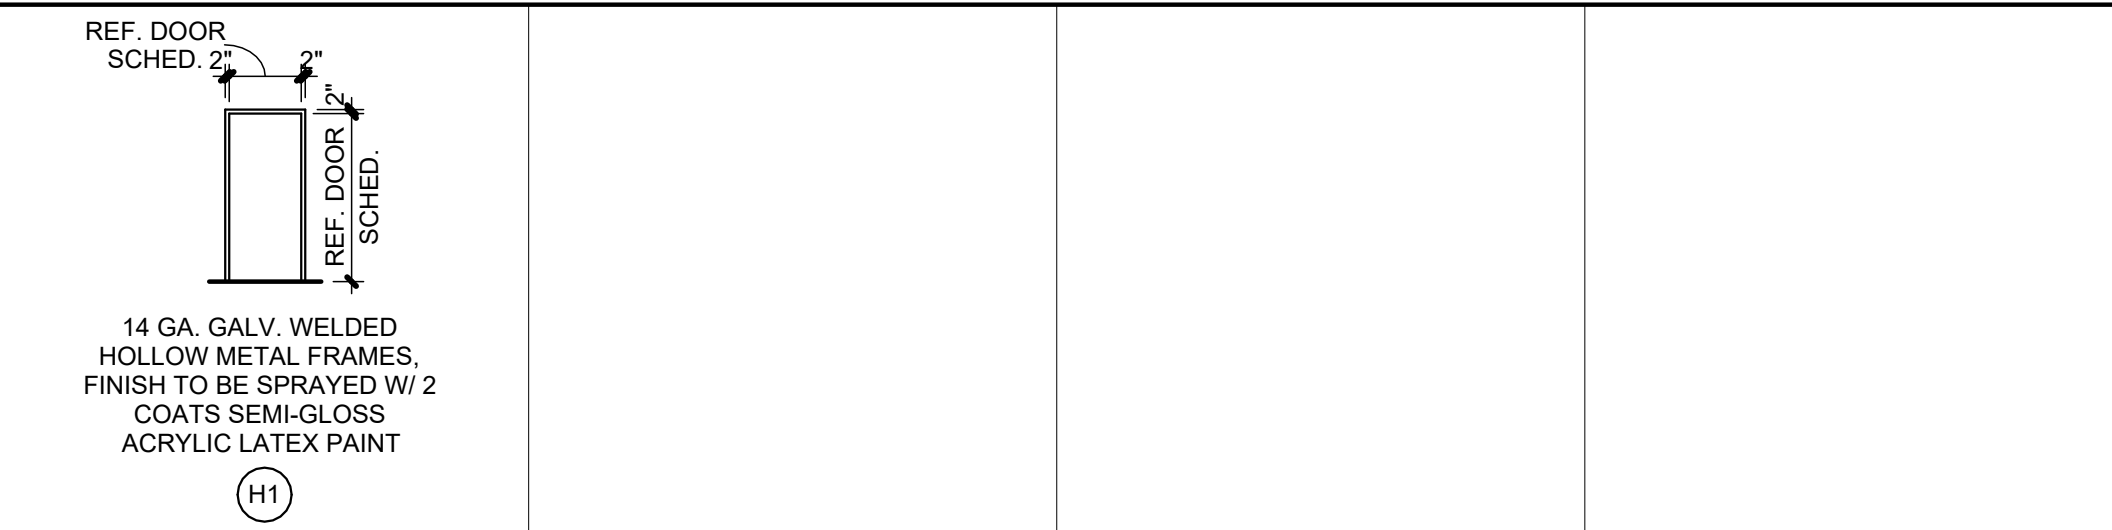

GL	-	GLASS
HM	-	HOLLOW METAL
WD	-	WOOD
STL	-	STEEL
AL	-	ALUMINUM
MFR	-	PER MANUFACTURER
POLY	-	POLYETHYLENE
P	-	POLYCARBONATE

SEE SPECIFICATIONS FOR DETAILED HARDWARE INFORMATION.

GENERAL NOTES:

1. ALL HARDWARE SHALL COMPLY WITH APPLICABLE REQUIREMENTS OF THE AMERICANS WITH DISABILITIES ACT (ADA).
2. ALL DOOR HARDWARE SHALL BE FINISH US260 OR EQUIVALENT.
3. ALL LATCHSETS AND LOCKSETS SHALL BE EQUIPPED WITH LEVER TYPE OPERATING TRIM W/ THE "CLUTCH" FEATURE.
4. ALL CLOSERS SHALL BE LOCATED ON ROOM SIDES OF DOORS.
5. CONTRACTOR'S HARDWARE CONSULTANT SHALL BE RESPONSIBLE FOR DETERMINING APPROPRIATE HARDWARE FUNCTION AND OPTIONS.
6. CONTRACTOR SHALL COORDINATE FINAL KEYING WITH OWNER.

(EL) EXTERIOR LOCKSETS

- SET # EL1** (EXTERIOR SINGLE W/L LOCK)
- * HINGES
 - * LOCKSET
 - * CLOSER
 - * THRESHOLD
 - * WEATHERSTRIP
 - * BOTTOM SWEEP
 - * DRIP CAP
 - * LATCH GUARD
 - * STORM CHAIN
- SET # EL2** (EXTERIOR PAIR W/L LOCK, CLOSERS, & MANUAL FLUSHBOLTS)
- * HINGES
 - * LOCKSET
 - * FLUSHBOLTS
 - * ASTRAGAL
 - * CLOSERS
 - * THRESHOLD
 - * WEATHERSTRIP
 - * BOTTOM SWEEP
 - * DRIP CAP
 - * LATCH GUARD
 - * STORM CHAIN

1401 NW River Rd
Lee's Summit, MO 64081

1401 NW River Rd
Lee's Summit, MO 64081

Project No.: 19050.04b


Date: 12.08.2025

Issued For: PERMIT

REVISIONS

[illegible]

REGISTRATION

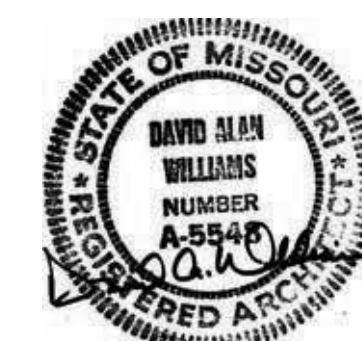

PROJECT TEAM

ARCHITECT FINKLE+WILLIAMS
ARCHITECTURE

STRUCTURAL BSE

PLUMBING PKMR

MECHANICAL CONTRACTOR

ELECTRICAL PKMR

WILLIAMS
ARCHITECTURE

8787 RENNER BLVD., SUITE 100
LENEXA, KANSAS 66219
913.498.1550
www.finklewilliams.com


SHEET TITLE

EQUIPMENT PLAN

SHEET NUMBER

A9.00

EQUIPMENT SCHEDULE					
TAG	QTY	CATEGORY	MANUFACTURER	MODEL	COMMENT
1E	1	KEGERATOR	PERLICK	HP24TO-4	
2E	1	75" TV	TOSHIBA	C350 SERIES	
3E	1	SINGLE DOOR MERCHANDISER	COCA-COLA	MBERA G319 C02	
4E	1	2 DOOR MERCHANDISER	AVANTCO	GC0-49-HC	
5E	3	3 DOOR MERCHANDISER	AVANTCO	GLD-109-HC	
6E	1	FRIDGE	LG	LDCS2803S	
7E	3	STAINLESS STEEL TABLE	LEGACY		
8E	1	AIR FRYER	ACP EXPRESSCHEF	4 MKXP22TLT	
9E	1	HOT DOG ROLLER	AVANTCO	RH300	
10E	1	PRETZEL WARMER	CARNIVAL KING	H2W-18D2	
11E	1	NACHO CHEESE DISPENSER	CARNIVAL KING	CD225	
12E	1	MINI MELT'S FREEZER			
13E	1	SUSHIE MACHINE	BUNN	58000.0015	
14E	1	BIB RACK	MULTIPLY	28"W x 16"D x 37"H	
15E	2	CARBONATOR SHELF	OWNER SPEC.	OWNER SPEC.	
16E	1	SODA GUN	OWNER SPEC.	WBM-10620	
17E	1	DROP IN ICE WELL	OWNER SPEC.	22"W x 15"D x 14.25"H	
21E	1	ICE MACHINE	AVANTCO	KMC-H-530-A	
22E	1	COFFEE MAKER			
23E	1	SNOWMIE MACHINE	SNOWIE	SNOWIE CUBE PRO	

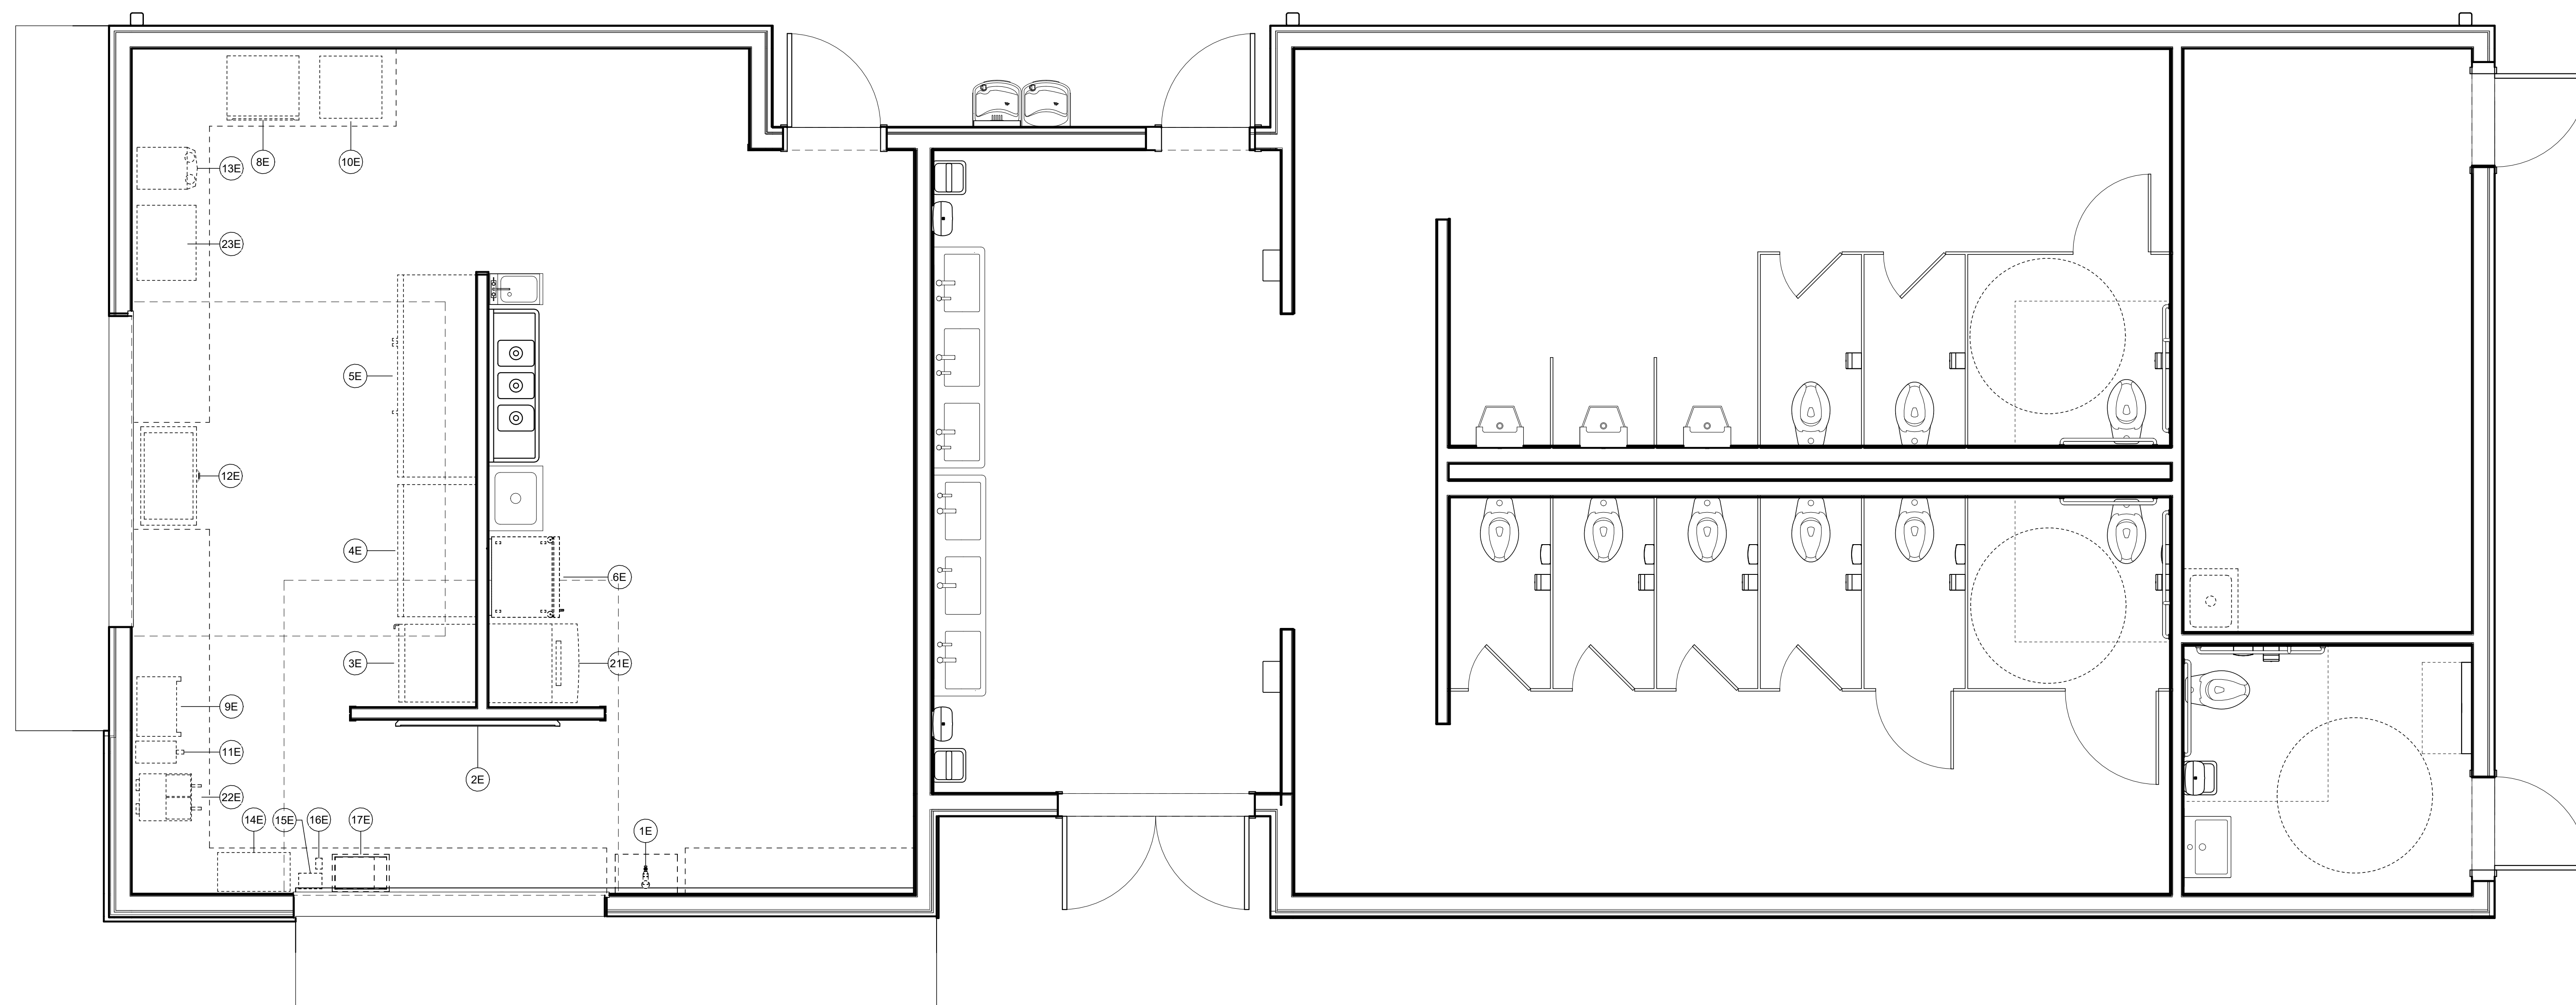

1401 NW River Rd
Lee's Summit, MO 64081

1401 NW River Rd
Lee's Summit, MO 64081

Project No.: 19050.04b

Date: 12.08.2025

Issued For: PERMIT

REVISIONS

[illegible]

REGISTRATION




NOTES:

1.) ISOMETRIC VIEWS ARE SHOWN FOR SCHEMATIC PURPOSES ONLY
ACTUAL CONSTRUCTION TO MATCH CONSTRUCTION DOCUMENTS.
REFERENCE ARCHITECTURAL, MECHANICAL, CIVIL, & STRUCTURAL
DOCUMENTS.

ISOMETRIC | 01

50

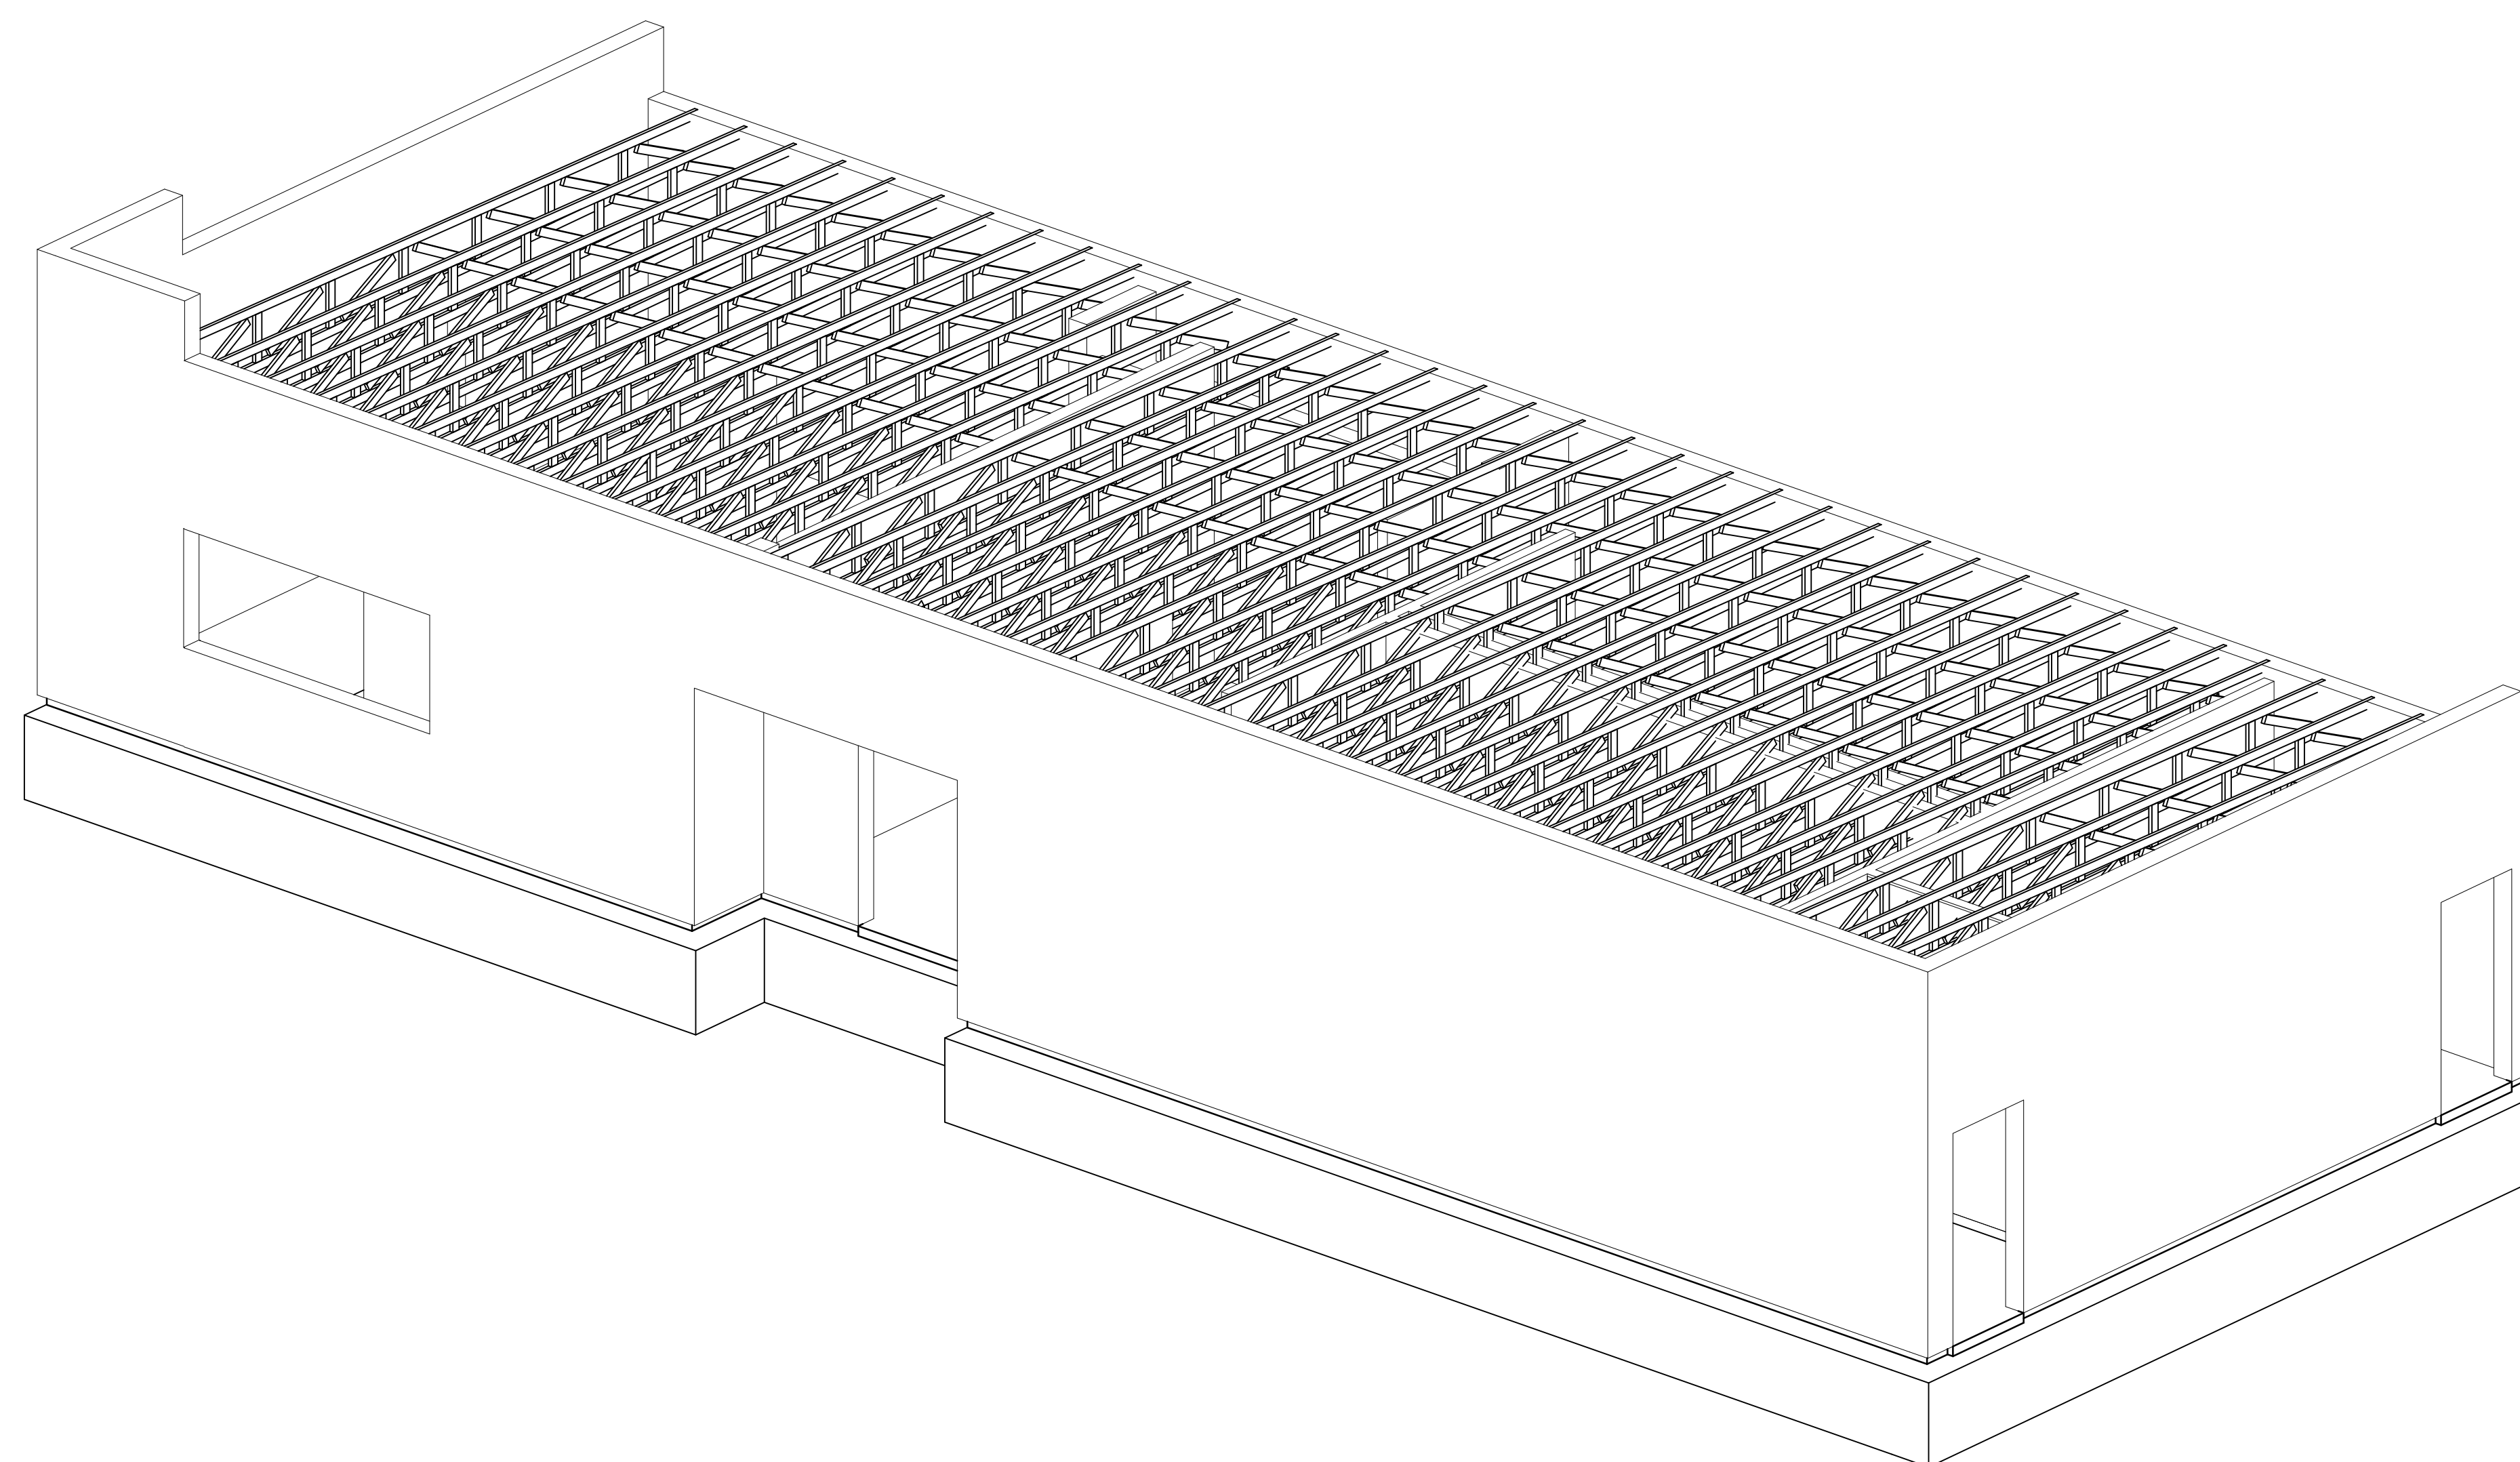

NOTES:

1.) ISOMETRIC VIEWS ARE SHOWN FOR SCHEMATIC PURPOSES ONLY
ACTUAL CONSTRUCTION TO MATCH CONSTRUCTION DOCUMENTS.
REFERENCE ARCHITECTURAL, MECHANICAL, CIVIL, & STRUCTURAL
DOCUMENTS.

ISOMETRIC | 01

50

PROJECT TEAM

ARCHITECT	FINKLE & WILLIAMS ARCHITECTURE
CIVIL	GBA
LANDSCAPE	LAND3 STUDIO
FOUNDATIONS	BSE ENGINEERS
STRUCTURAL	BSE ENGINEERS
PLUMBING	HENDERSON ENGINEERS
MECHANICAL	HENDERSON ENGINEERS
ELECTRICAL	HENDERSON ENGINEERS
FIRE PROTECTION	HENDERSON ENGINEERS
CONTRACTOR	FOGEL-ANDER



11320 West 79th
Lenexa, Kansas 66157
Phone 913.492.7400
www.BSEstructure.com
Project Number 2008-001

SHEET TITLE

ISOMETRIC

SHEET NUMBER

S0.1

2/8/2025 10:33:08 AM | PARAGON STAR RR-CONCESSIONS

2/8/2025 10:33:08 AM | PARAGON STAR RR-CONCESSIONS

NOTES:

1.) BUILDING SECTIONS ARE SHOWN FOR SCHEMATIC PURPOSES ONLY. ACTUAL CONSTRUCTION TO MATCH CONSTRUCTION DOCUMENTS. REFERENCE ARCHITECTURAL, MECHANICAL, CIVIL, & STRUCTURAL DOCUMENTS.

BUILDING SECTION | 02

$$1/2'' = 1'-0''$$

1401 NW River Rd
Lee's Summit, MO 64081

Project No.: 19050.04b

Date: 12.08.2025

Issued For: PERMIT

REVISION

[illegible]

REGISTRATION



PROJECT TEAM

ARCHITECT	FINKLE+WILLIAMS ARCHITECTURE
CIVIL	GBA
LANDSCAPE	LAND3 STUDIO
FOUNDATIONS	BSE ENGINEERS
STRUCTURAL	BSE ENGINEERS
PLUMBING	HENDERSON ENGINEERS
MECHANICAL	HENDERSON ENGINEERS
ELECTRICAL	HENDERSON ENGINEERS
FIRE PROTECTION	HENDERSON ENGINEERS
CONTRACTOR	FOGEL-ANDERSON




11320 West 79th Street
Lenexa, Kansas 66214
Phone 913.492.7400
www.BSEstructural.com
Project Number 25-290

SHEET TITLE

FOUNDATION
PLAN

SHEET NUMBER

S1.1

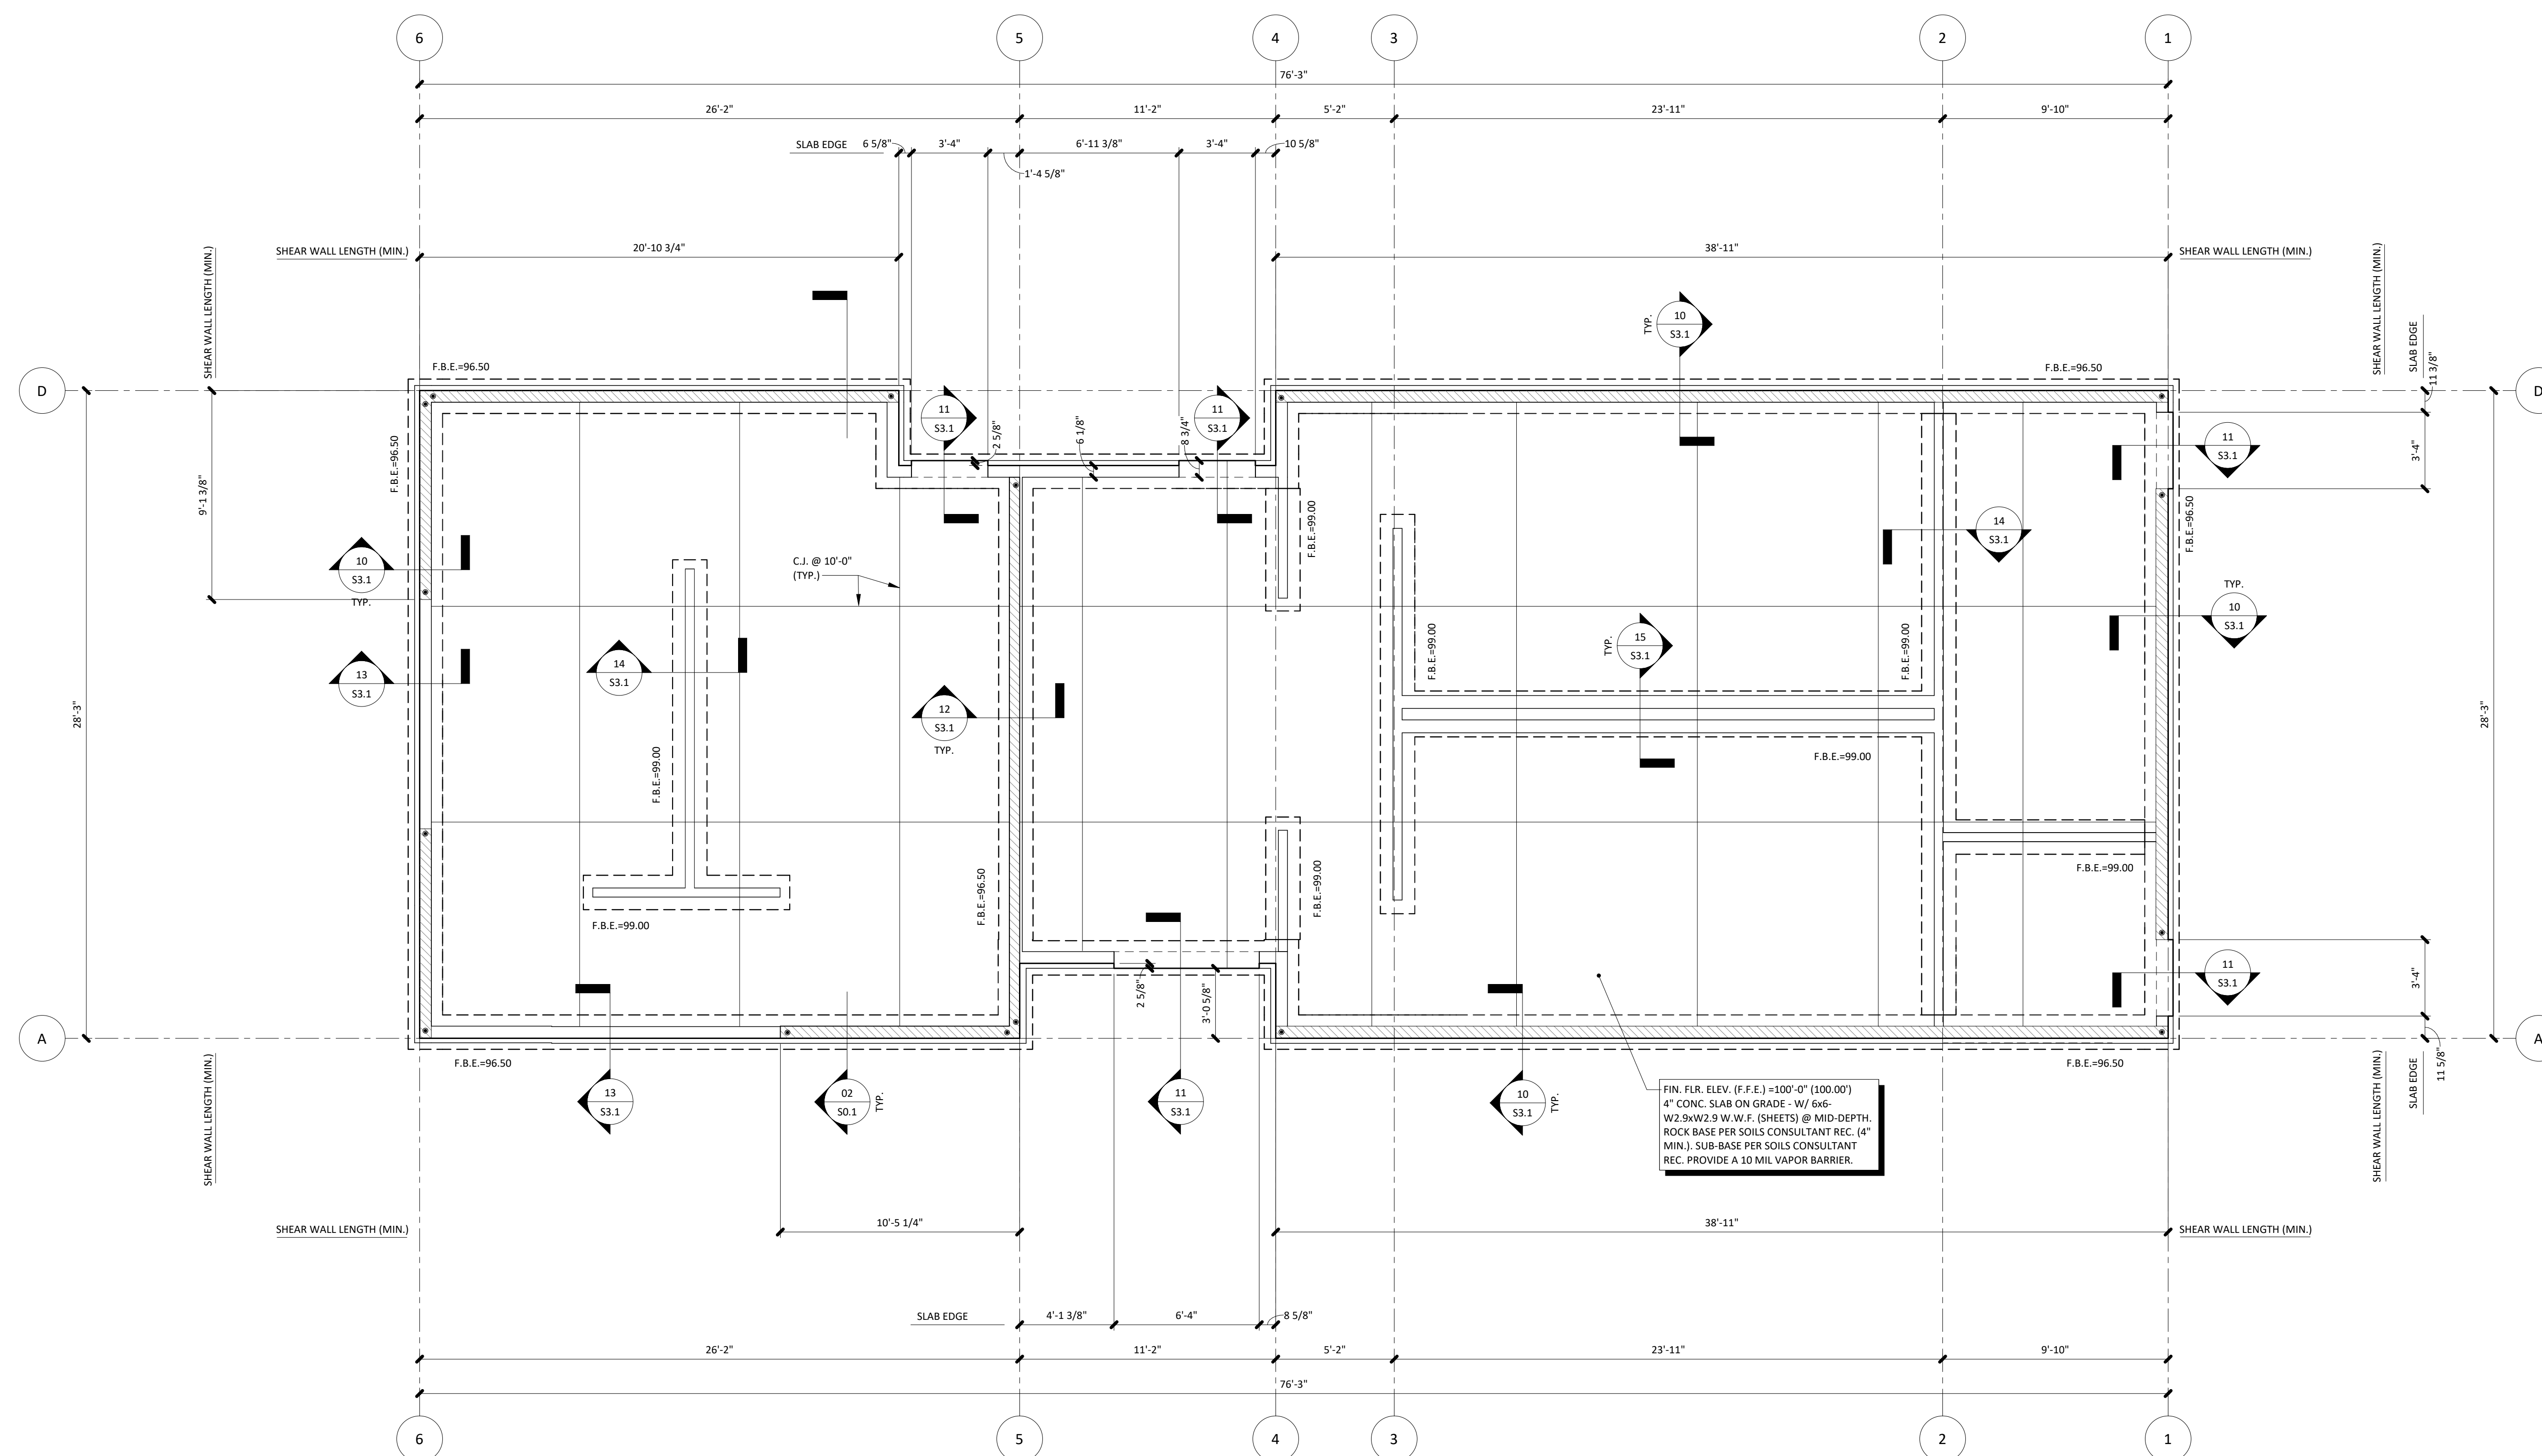

NOTES:

1.) SEE DRAWING S0.0 FOR GENERAL NOTES, SYMBOLS LEGEND, MATERIALS LEGEND, & ABBREVIATION LIST.

2.) REFERENCE DRAWING S3.1 FOR TYPICAL FOUNDATION DETAILS INCLUDING ANCHOR ROD DETAILS, FOOTING STEP DETAILS, CONTROL JOINT & CONSTRUCTION JOINT DETAILS, REINF. LAP LENGTH TABLE, ETC.

3.) SEE DRAWING S0.1 FOR ISOMETRIC VIEW & FULL BUILDING SECTIONS.

4.) REFER TO GEOTECHNICAL REPORT FOR BEHIND WALL DRAINAGE RECOMMENDATIONS. COORD. W/ CIVIL AS REQ'D. REFER TO ARCHITECTURAL DRAWINGS FOR FOUNDATION WATERPROOFING & INSULATION REQUIREMENTS.

5.) * INDICATES HOLD DOWN LOCATION - REFER TO TYP. DETAILS.

FOUNDATION PLAN | 01

$1/4" = 1'-0"$	S1.1
----------------	------



1401 NW River Rd
Lee's Summit, MO 6408


[illegible]

ARCHITECT	FINKLE+WILLIAMSON ARCHITECTURE
CIVIL	GBA
LANDSCAPE	LAND3 STUDIO
FOUNDATIONS	BSE ENGINEERS
STRUCTURAL	BSE ENGINEERS
PLUMBING	HENDERSON ENGINEERS
MECHANICAL	HENDERSON ENGINEERS
ELECTRICAL	HENDERSON ENGINEERS
FIRE PROTECTION	HENDERSON ENGINEERS
CONTRACTOR	FOGEL-ANDERSON

11320 West 79th Street
Lenexa, Kansas 66214
Phone 913.492.7400
www.BSEstructural.com
Project Number 25-290

ROOF FRAMING PLAN

S2.2

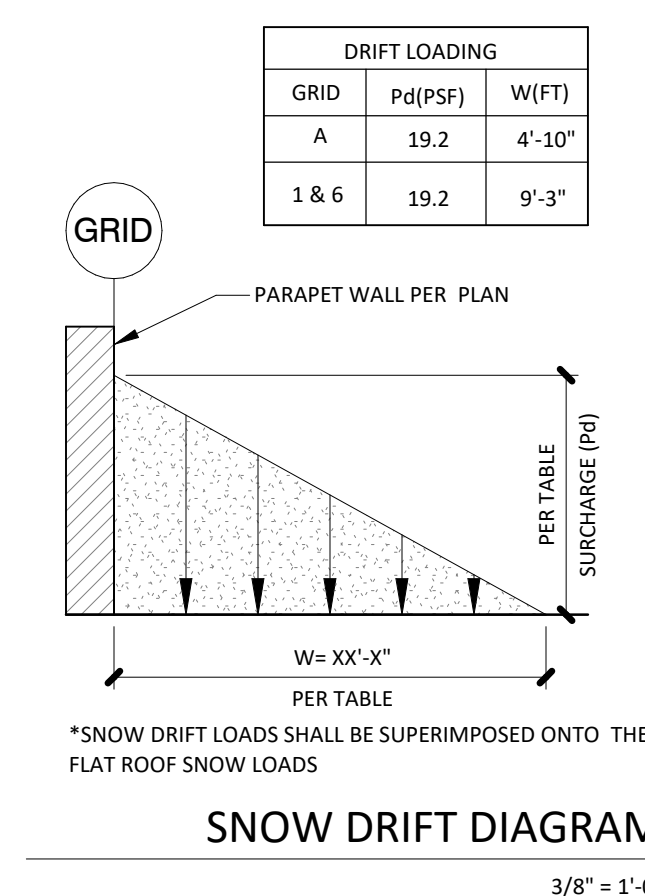

HEADER/BEAM SCHEDULE			
MARK	SIZE	BEARING STUDS	KING STUDS
H1	(3) 2x6 W/ 1/2" PLYWOOD SPACERS	(2) 2x6	(1)2x6
H2	(3) 2x8 W/ 1/2" PLYWOOD SPACERS	(2) 2x6	(1)2x6
H3	(1) 5 1/4" x 9 1/2" 2.0E PSL	(2) 2x6	(1)2x6
H4	(3) 2x10 W/ 1/2" PLYWOOD SPACERS	(2) 2x6	(1)2x6

NOTE:
1.) UPSET HEADERS AS REQ'D. & PROVIDE SIMPSON HANGE
2.) BEARING STUDS REQUIRED AT EACH END OF HEADER PER
HEADER SCHEDULE

NOTES:

- 1.) SEE DRAWING SO.0 FOR GENERAL NOTES, SYMBOLS LEGEND, MATERIALS LEGEND, & ABBREVIATION LIST.
- 2.) REFERENCE DRAWING SA.1 FOR TYPICAL FORMAL DETAILS.
- 3.) SEE DRAWING SO.0 FOR ISOMETRIC VIEW & FULL BUILDING SECTIONS.
- 4.) REFERENCE ARCHITECTURAL DRAWINGS TO VERIFY SIZE & LOCATIONS OF ALL ROOF & WALL OPENINGS.
- 5.)  DENOTES HEADER REFER TO SCHEDULE & TYP. DETAILS.
- 6.)  DENOTES SHEAR WALL SCHEDULE REFER TO SCHEDULE & TYP. DETAILS. SEE FOUNDATION PLAN HOLD DOWN FOR EXTENTS OF SHEAR WALL BOUNDARIES.
- 7.)  INDICATES HOLD DOWN LOCATION - REFER TO TYP. DETAILS. I. HOLD DOWN PRESIDENT. REFER TO PLAN DIMENSIONS FOR SHEAR WALL BOUNDARY LOCATIONS.

2ND FLOOR FRAMING PLAN	01
1/4" = 1'-0"	S2.2


1401 NW River Rd
Lee's Summit, MO 6408

[illegible]

ARCHITECT	FINKE- WILLIAMS ARCHITECTURE
CIVIL	GBA
LANDSCAPE	LAND3 STUDIO
FOUNDATIONS	BSE ENGINEERS
STRUCTURAL	BSE ENGINEERS
PLUMBING	HENDERSON ENGINEERS
MECHANICAL	HENDERSON ENGINEERS
ELECTRICAL	HENDERSON ENGINEERS
FIRE PROTECTION	HENDERSON ENGINEERS
CONTRACTOR	FOGEL-ANDERSON









STANDARD 90° HOOK TABLE | 06
12" = 1'-0" | S3.1

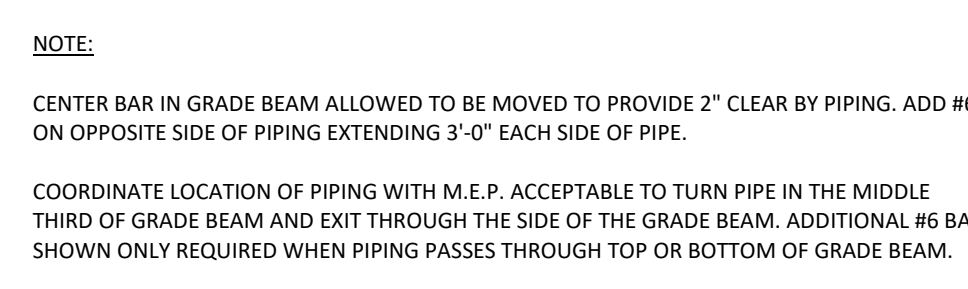

NOTES:

1. TABULATED VALUES ARE BASED ON GRADE 60 REINFORCING BARS AND NORMAL-WEIGHT CONCRETE.
2. TENSION DEVELOPMENT LENGTHS AND TENSION LAP SPACE LENGTHS ARE BASED ON A4318, SECTIONS 12.2.2 AND 12.15, RESPECTIVELY.
3. TABULATED VALUES FOR BEAMS OR COLUMNS ARE BASED ON TRANSVERSE REINFORCEMENT AND CONCRETE COVER MEETING MINIMUM CODE REQUIREMENTS. LENGTHS ARE IN INCHES.
4. CASES 1 AND 2, WHICH DEPEND ON THE TYPE OF STRUCTURAL ELEMENT, CONCRETE COVER, AND THE CENTER-TO-CENTER SPACING OF THE BARS ARE DEFINED AS:
 - BEAMS OR COLUMNS:
 - CASE 1: COVER AT LEAST (1) BAR DIAMETER AND C-C. SPACING AT LEAST (2) BAR DIAMETERS
 - CASE 2: COVER LESS THAN (1) BAR DIAMETER AND C-C. SPACING LESS THAN (2) BAR DIAMETERS
- ALL OTHERS:
 - CASE 1: COVER AT LEAST (1) BAR DIAMETER AND C-C. SPACING AT LEAST (3) BAR DIAMETERS
 - CASE 2: COVER LESS THAN (1) BAR DIAMETER AND C-C. SPACING LESS THAN (3) BAR DIAMETERS
5. LAP CLASS A VALUES ARE THE REQUIRED TENSION DEVELOPMENT LENGTHS, & LAP CLASS LENGTHS ARE MULTIPLES OF TENSION DEVELOPMENT LENGTHS; CLASS A - 1.0M AND CLASS B = 1.3M (A4318, SECTION 12.15.1)
6. LAP CLASS B SHALL BE USED FOR ALL CASES UNLESS APPROVED BY E.O.R
7. TOP BARS ARE HORIZONTAL. BARS WITH MORE THAN 12 INCHES OF CONCRETE CAST BELOW THE BARS.
 - 8. LENGTHS SHOWN ARE FOR UNCOATED BARS. LENGTHS SHOWN SHALL BE MULTIPLIED BY 2 FOR ALL EXPOSED COATED BARS (A4318 SECTION 12.2.4)
9. WHEN BARS OF DIFFERENT SIZES ARE LAP SPICED, THE SPACE LENGTH FOR

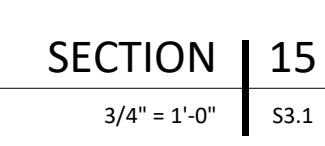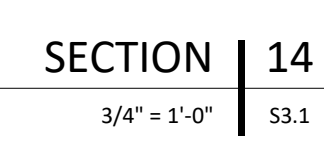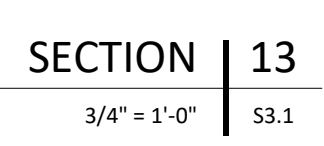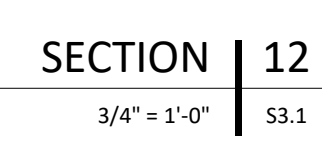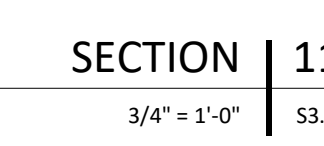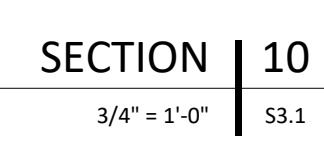

1401 NW River Rd
Lee's Summit, MO 64081

1401 NW River Rd
Lee's Summit, MO 64081

Project No.: 19050.04b

Date: 12.08.202

Issued For: PERMIT

REVISION

REGISTRATION

PROJECT TEAM

ARCHITECT	FINKLE+WILLIAMS ARCHITECTURE
CIVIL	G&A
LANDSCAPE	LAND3 STUDIO
FOUNDATIONS	BSE ENGINEERS
STRUCTURAL	BSE ENGINEERS
PLUMBING	HENDERSON ENGINEERS
MECHANICAL	HENDERSON ENGINEERS
ELECTRICAL	HENDERSON ENGINEERS
FIRE PROTECTION	HENDERSON ENGINEERS
CONTRACTOR	FOGEL-ANDERSON



11320 West 79th Street
Lenexa, Kansas 66214
Phone 913.492.7400
www.BSEstructural.com
Project Number 25-290

SHEET TITLE


TYPICAL FRAMING DETAILS

SHEET NUMBER

S4.1









TYP. FASTENING SCHEDULE	06
3/4" = 1'-0"	\$4.1

 

NOTE:
1.) BORED HOLES & NOTCHES FOR JOIST & STUDS SHALL NOT OCCUR AT THE SAME SECTION OF THE MEMBER.

2.) LARGER BORED HOLES & NOTCHES FOR JOIST & STUDS SHALL NOT BE USED UNLESS APPROVED BY THE E.O.R

      3.) BUILT UP STUD PACKS CONSISTING OF MORE THAN (2) STUDS SHALL NOT BE BORED OR NOTCHED UNLESS APPROVED BY THE E.O.R.



1401 NW River Rd
Lee's Summit, MO 64081

1401 NW River Rd
Lee's Summit, MO 64081

Project No.: 19050.04b


Date: 12.08.2025

Issued For: PERMIT

REVISIONS

[illegible]

REGISTRATION

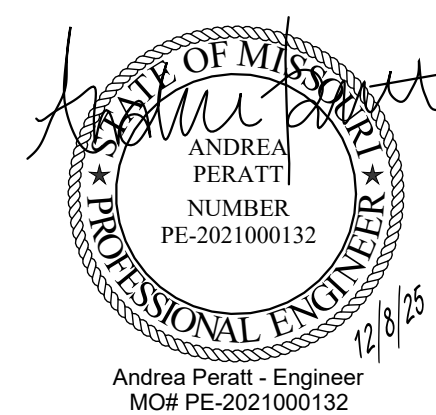

PROJECT TEAM

ARCHITECT	FINKLE+WILLIAMS ARCHITECTURE
CIVIL	CIVIL CONSULTANT
LANDSCAPE	LANDSCAPE
STRUCTURAL	STRUCTURAL
PLUMBING	PLUMBING
MECHANICAL	MECHANICAL
ELECTRICAL	ELECTRICAL
FIRE PROTECTION	FIRE PROTECTION
CONTRACTOR	GC






SHEET TITLE

SHEET NUMBER

P1.01

1. REFER TO GENERAL NOTES ON MEET COVER SHEET FOR ADDITIONAL REQUIREMENTS OF WORK.
2. REFER TO PUMPING VENT/ DRAIN SCHEDULES FOR PUMPING SIZES AND LOCATIONS. CONNECTIONS TO STRUCTURES SHALL NOT BE SHOWN ON PLANS.
3. NO SANITARY OR VENT PIPING BELOW GRADE CAN BE LESS THAN 4".
4. NO DOMESTIC WATER PIPING SHALL BE SMALLER THAN 4" UNLESS NOTED OTHERWISE.
5. ALL VENT PIPING SHALL BE DIAGRAMMATIC. USE APPROPRIATE FITTINGS FOR VENT PIPING BELOW FLOOR OF FINISH.
6. NOT ALL PIPING SHALL BE IDENTIFIED. PROVIDE CLARITY. CONTRACTOR SHALL INSTALL ALL CODE-REQUIRED CLEARANCES (RE: GENERAL NOTES ON COVER SHEET). CONTRACTOR EXACT LOCATIONS OF CLEANSOUTS WITH ACCESS.
7. ALL FLOOR DRAIN TRAP SHALL BE PROTECTED BY ONE OF THE FOLLOWING METHODS: TO BE INSTALLED AT CONTRACTORS DISCRETION AND IN ACCORDANCE WITH ADOPTED CODES, OR TO BE INSTALLED IN ACCORDANCE WITH:
 1. PROVIDE TRAP SEALS LISTED FOR PROPOSED USE.
 2. PROVIDE TRAP PRIMER, 1/2" TRAP PRIMER PIPING TO NEAREST TRAP. PROVIDE VENT PIPING TO NEAREST TRAP. PROVIDE SOFT COPPER SEAMLESS WITH NO JOINTS FROM VALVE TO DRAIN.

- 1 2" DOMESTIC WATER SERVICE AND DRIP BACKLOW PREVENTER. PROVIDE COMPRESSED AIR FITTING AND RISE AT RISER FOR SYSTEM DRAIN DOWN AND WATERING.
- 2 PROVIDE 1/2" DOW TO OWNER PROVIDED COFFEE MAKER. PROVIDE BACKLOW PREVENTER FOR DUAL CHECK VALVE PRIOR TO EQUIPMENT CONNECTION. PIPING SHALL BE EXPOSED AND PROVIDED WITH PVC JACKETING TO PROTECT PIPING.
- 3 PROVIDE 3/4" DOW TO OWNER PROVIDED BOTTLE. PROVIDE BACKLOW PREVENTER PRIOR TO EQUIPMENT CONNECTION. PIPING SHALL BE EXPOSED AND PROVIDED WITH PVC JACKETING TO PROTECT PIPING.
- 4 PROVIDE 3/4" DOW TO OWNER PROVIDED ICE MAKER. PROVIDE BACKLOW PREVENTER PRIOR TO EQUIPMENT CONNECTION.
- 5 PROVIDE DOW AND DWV TO OWNER PROVIDED SINK.
- 6 COORDINATE ALL FINAL CONNECTIONS WITH OWNER. LOCATIONS WITH OWNER PROVIDED EQUIPMENT PRIOR TO INSTALLATION.
- 7 INSTALL DOW TO WF-1 IN WALL MOUNTED FREEZE-RESISTANT VALVE CABINET.

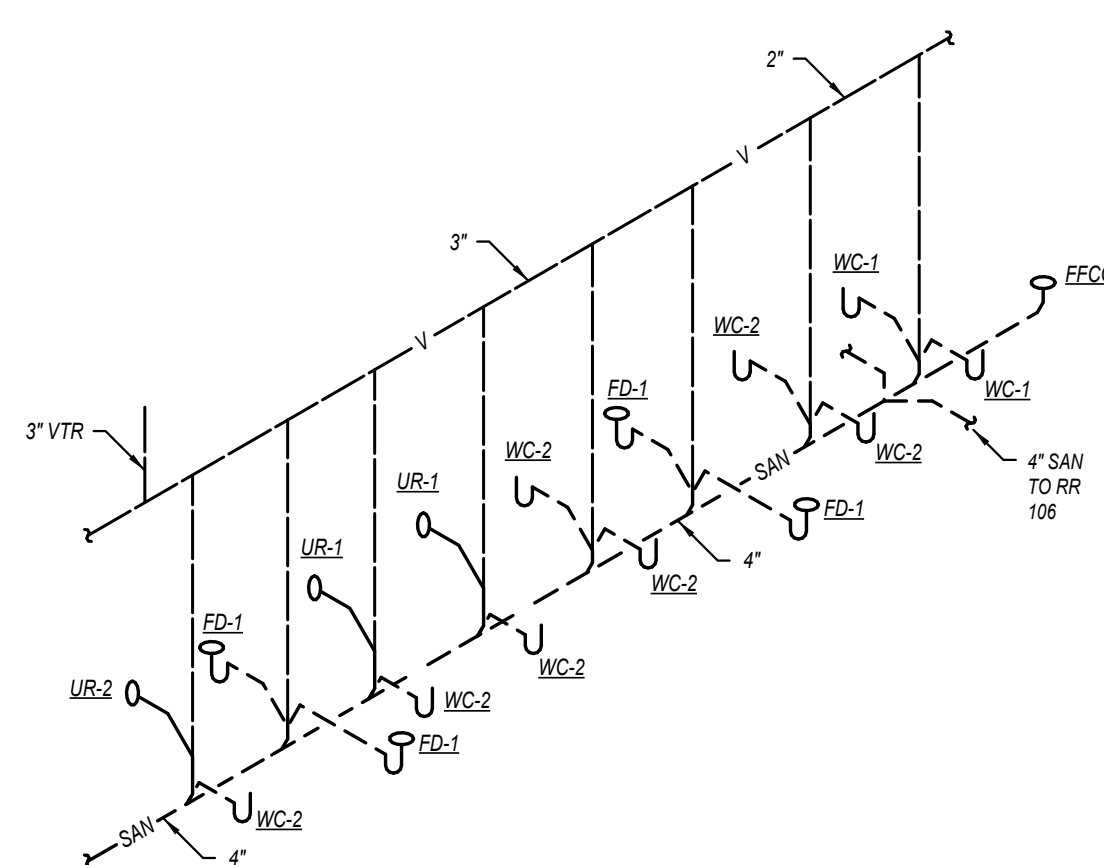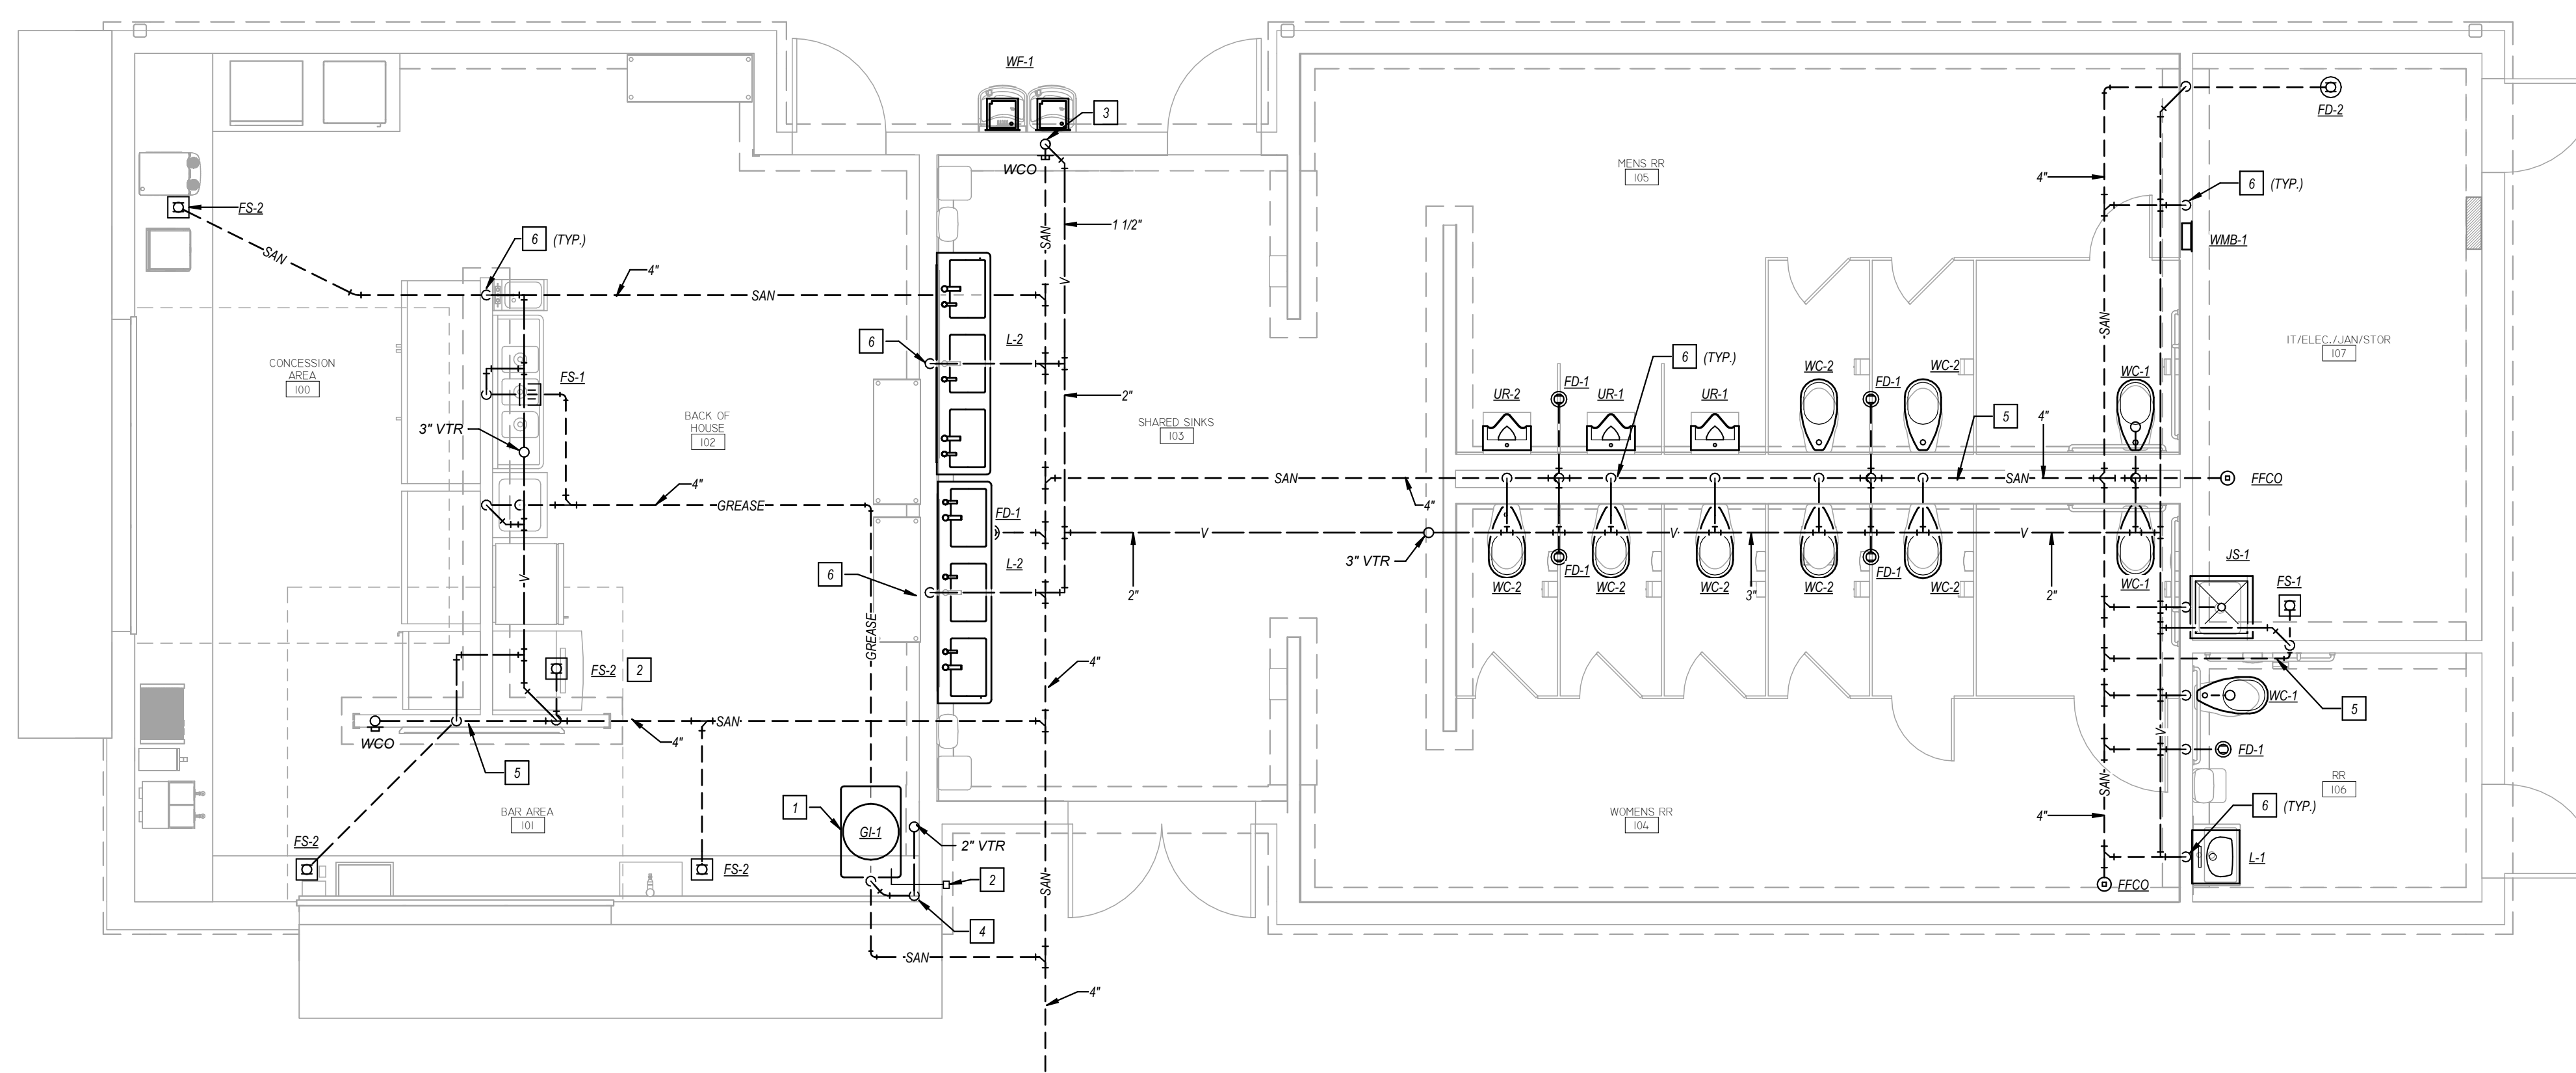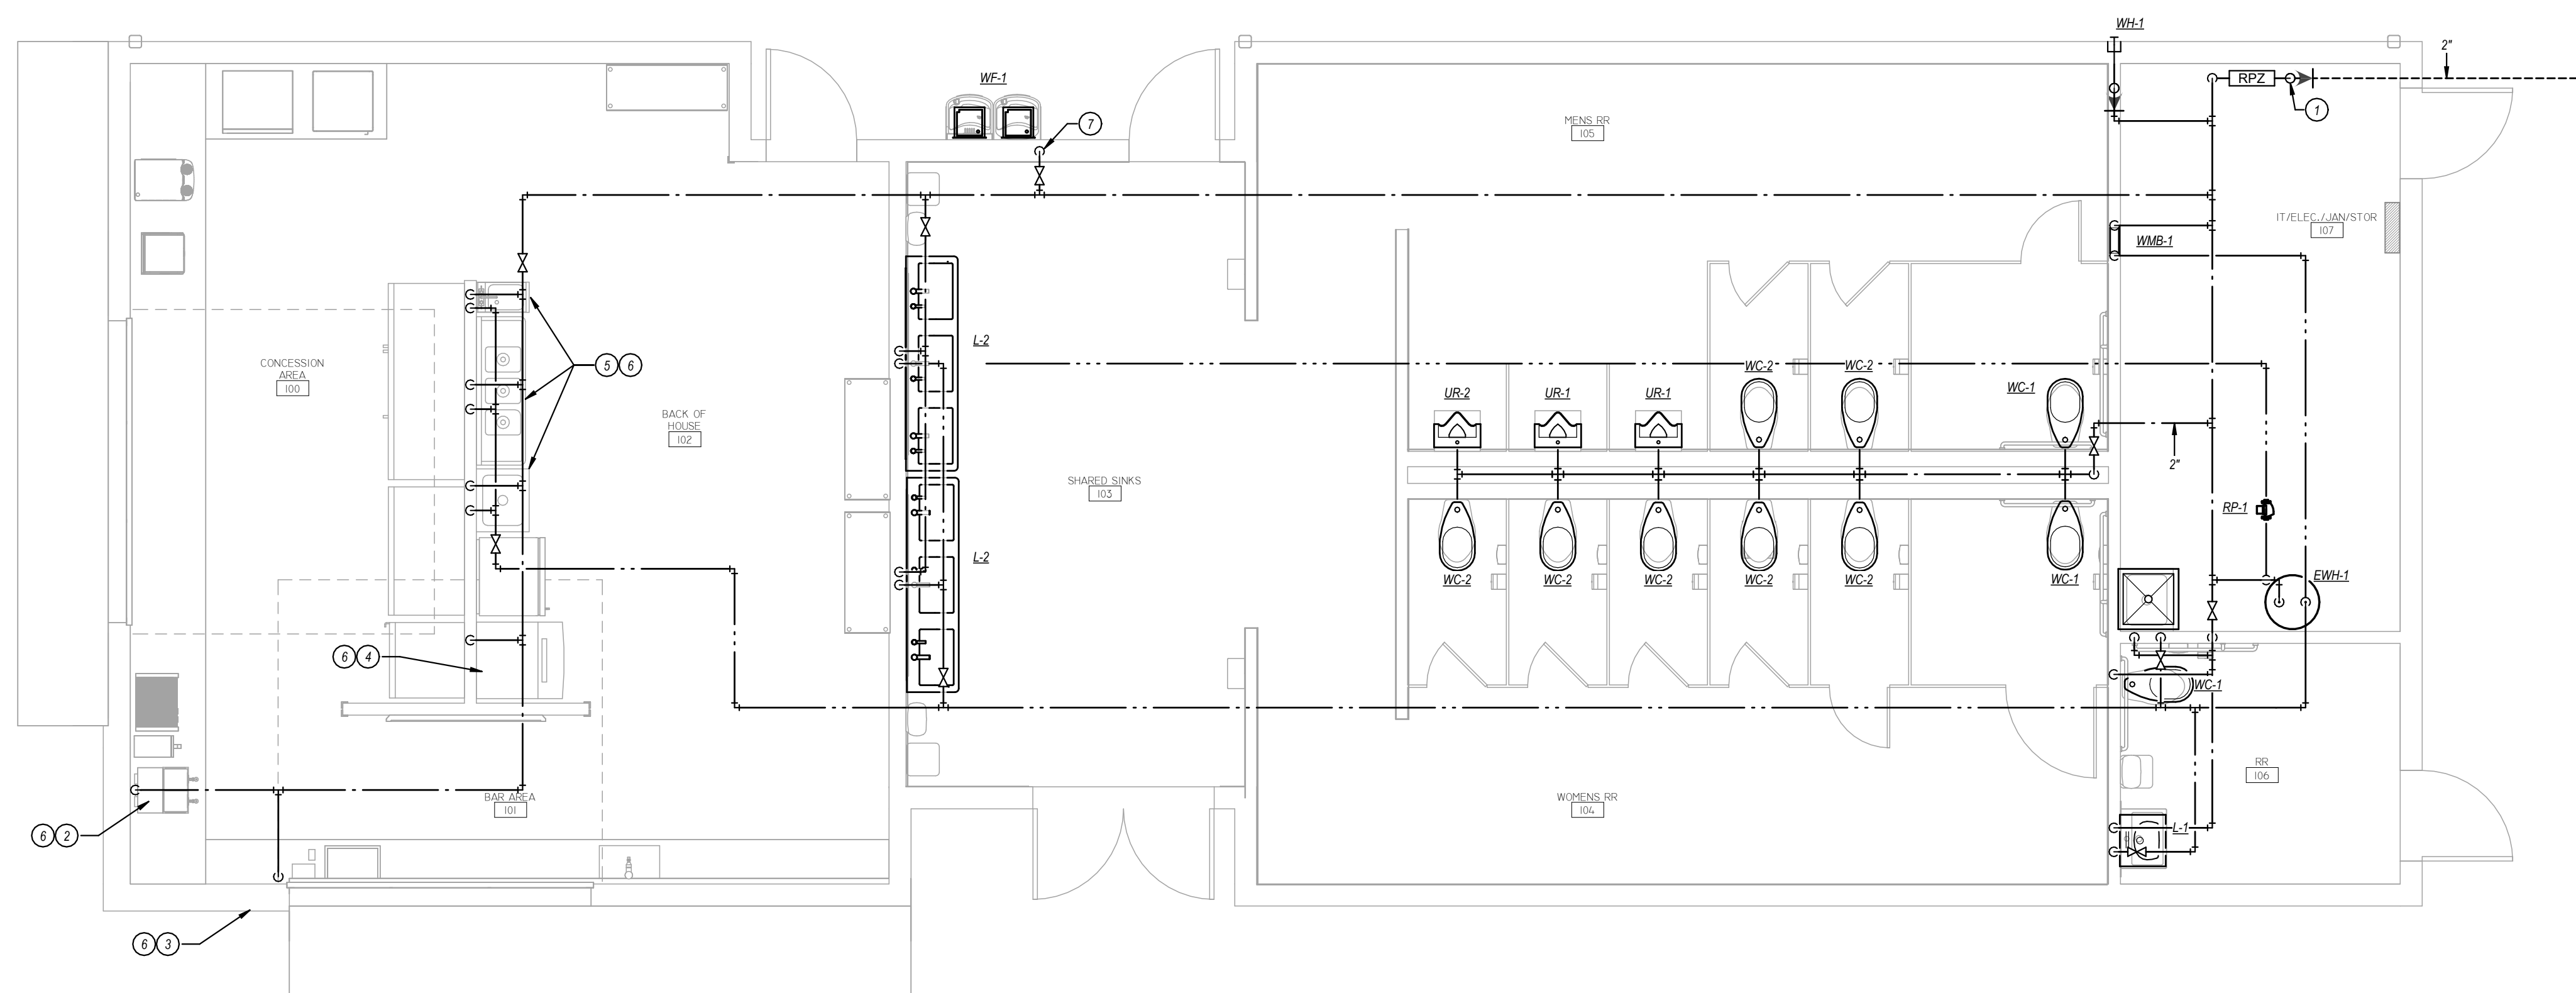

1401 NW River Rd
Lee's Summit, MO 64081

1401 NW River Rd
Lee's Summit, MO 64081

Project No.: 19050.04b


Date: 12.08.2025

Issued For: PERMIT

REVISIONS


[illegible]

REGISTRATION

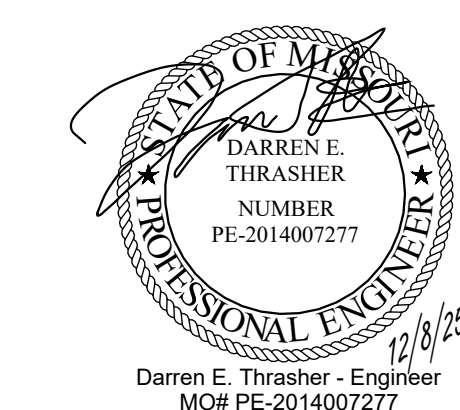

PROJECT TEAM

ARCHITECT	FINKLE+WILLIAMS ARCHITECTURE
CIVIL	CIVIL CONSULTANT
LANDSCAPE	LANDSCAPE
STRUCTURAL	STRUCTURAL
PLUMBING	PLUMBING
MECHANICAL	MECHANICAL
ELECTRICAL	ELECTRICAL
FIRE PROTECTION	FIRE PROTECTION
CONTRACTOR	GC

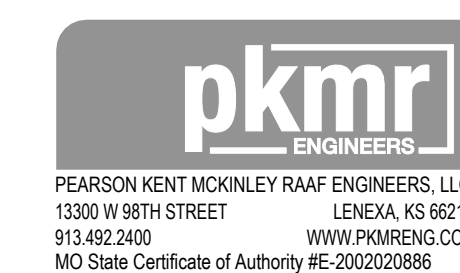

SHEET TITLE

SHEET NUMBER


E1.01

GENERAL LIGHTING NOTES


1. REFER TO GENERAL NOTES ON MEP COVER SHEET FOR ADDITIONAL REQUIREMENTS OF WORK.
2. LIGHT FIXTURES INDICATED AS EMERGENCY FIXTURES ARE TO FUNCTION AS NIGHT LIGHTS UNLESS SPECIFICALLY SHOWN SWITCHED.

THE WIRING AND/OR TIC MARKS SHOWN BELOW ARE NOT SHOWN ON THE PLANS FOR CLARITY. PROVIDE WIRING FROM JUNCTION BOX(ES) TO SWITCHES/CONTROLLERS AND LIGHT FIXTURES AS SHOWN BELOW FOR EACH ROOM/AREA.


LINE VOLTAGE STANDARD WALL SWITCHES

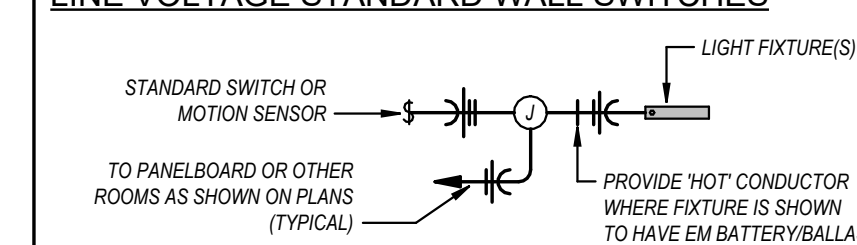


3-WAY WALL SWITCHES

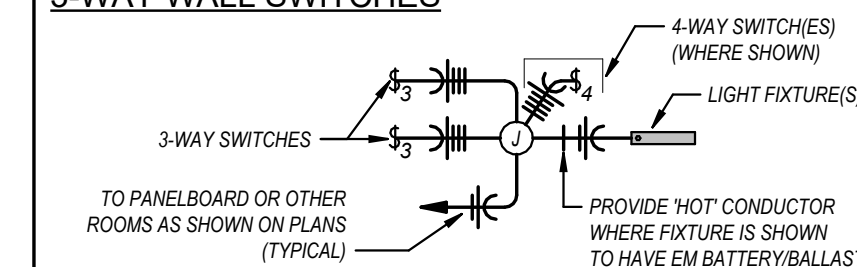

LINE VOLTAGE CEILING SENSORS

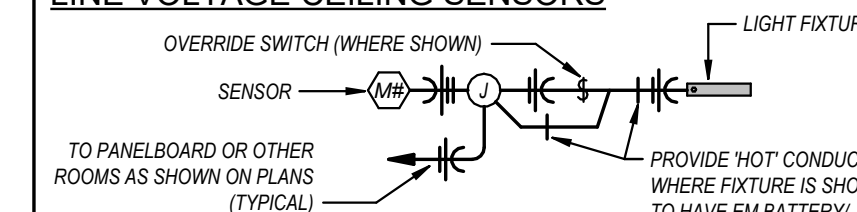



ROOM CONTROLLERS / POWER PACKS

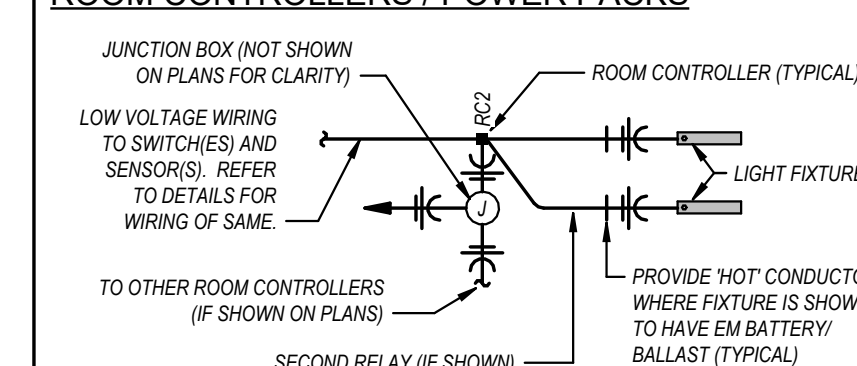

GENERAL COVER NOTES


1. REFER TO GENERAL NOTES ON MEP COVER SHEET FOR ADDITIONAL REQUIREMENTS OF WORK.
2. COORDINATE EXACT NEMA CONFIGURATIONS OF RECEPTACLES SERVING EQUIPMENT WITH EXACT EQUIPMENT BEING FURNISHED.
3. EXACT MECHANICAL EQUIPMENT LOCATIONS MAY NOT BE SHOWN FOR CLARITY. COORDINATE EXACT LOCATIONS OF ALL MECHANICAL EQUIPMENT, DUCT DETECTORS, ETC. WITH MECHANICAL DRAWINGS AND CONTRACTOR.
4. COORDINATE EXACT LOCATIONS OF SMOKE DETECTORS WITH CEILING FAN, HVAC, DIFFUSERS, SPRINKLER HEADS, ETC. PER MEP4 REQUIREMENTS.

- 1 SPECIAL PURPOSE GROUND FAULT CIRCUIT INTERRUPTER FOR 30A/20 208V CIRCUIT. LITTLEFUSE SMOKE BLOCK GFCI OR EQUIV.
- 2 POWER CONNECTION TO HAND WIRE. PROVIDE LOCKABLE BREAKER.
- 3 CONNECTION TO MOUNTING HANG WITH ARCHITECT PIER TO ROUNGIN.
- 3 (2) 18-2 1" CONDUIT.
- 4 (2) 18-2 1" CONDUIT.
- 5 CONNECTION TO EXTERIOR HEAT PUMP. PROVIDE 60A/250V/3P/4W 30 HEAVY DUTY DISCONNECT SWITCH MECHANICAL SYSTEM IS PROVIDED. DESIGN/BID BY THE MECHANICAL CONTRACTOR. PROVIDE 60A/250V/3P/4W 30 HEAVY DUTY DISCONNECT SWITCH MECHANICAL SYSTEM IS PROVIDED. COORDINATE ALL REQUIREMENTS WITH MECHANICAL CONTRACTOR PROVIDER.
- 6 CONNECTION TO HANDLER SINGLE POINT CONNECTION. PROVIDE 100A/250V/1P/4W 1 HEAVY DUTY DISCONNECT SWITCH MECHANICAL SYSTEM IS PROVIDED. DESIGN/BID BY THE MECHANICAL CONTRACTOR. AIR HANDLER REQUIREMENTS AND COORDINATE ALL REQUIREMENTS WITH MECHANICAL CONTRACTOR PROVIDER.
- 7 CONNECTION TO R/C UNIT. PROVIDE 100A/250V/1P/4W 1 HEAVY DUTY DISCONNECT SWITCH MECHANICAL SYSTEM IS PROVIDED. DESIGN/BID BY THE MECHANICAL CONTRACTOR. PROVIDE 100A/250V/1P/4W 1 HEAVY DUTY DISCONNECT SWITCH MECHANICAL SYSTEM IS PROVIDED. COORDINATE ALL REQUIREMENTS WITH MECHANICAL CONTRACTOR PROVIDER.
- 8 CONNECTION TO HANDLER SINGLE POINT CONNECTION. PROVIDE 100A/250V/1P/4W 1 HEAVY DUTY DISCONNECT SWITCH MECHANICAL SYSTEM IS PROVIDED. DESIGN/BID BY THE MECHANICAL CONTRACTOR. PROVIDE 100A/250V/1P/4W 1 HEAVY DUTY DISCONNECT SWITCH MECHANICAL SYSTEM IS PROVIDED. COORDINATE ALL REQUIREMENTS WITH MECHANICAL CONTRACTOR PROVIDER.
- 9 POWER CONNECTION TO PAPER TOLU DISPENSER. PROVIDE LOCKABLE BREAKER. COORDINATE MOUNTING HANG WITH ARCHITECT PIER TO ROUNGIN.

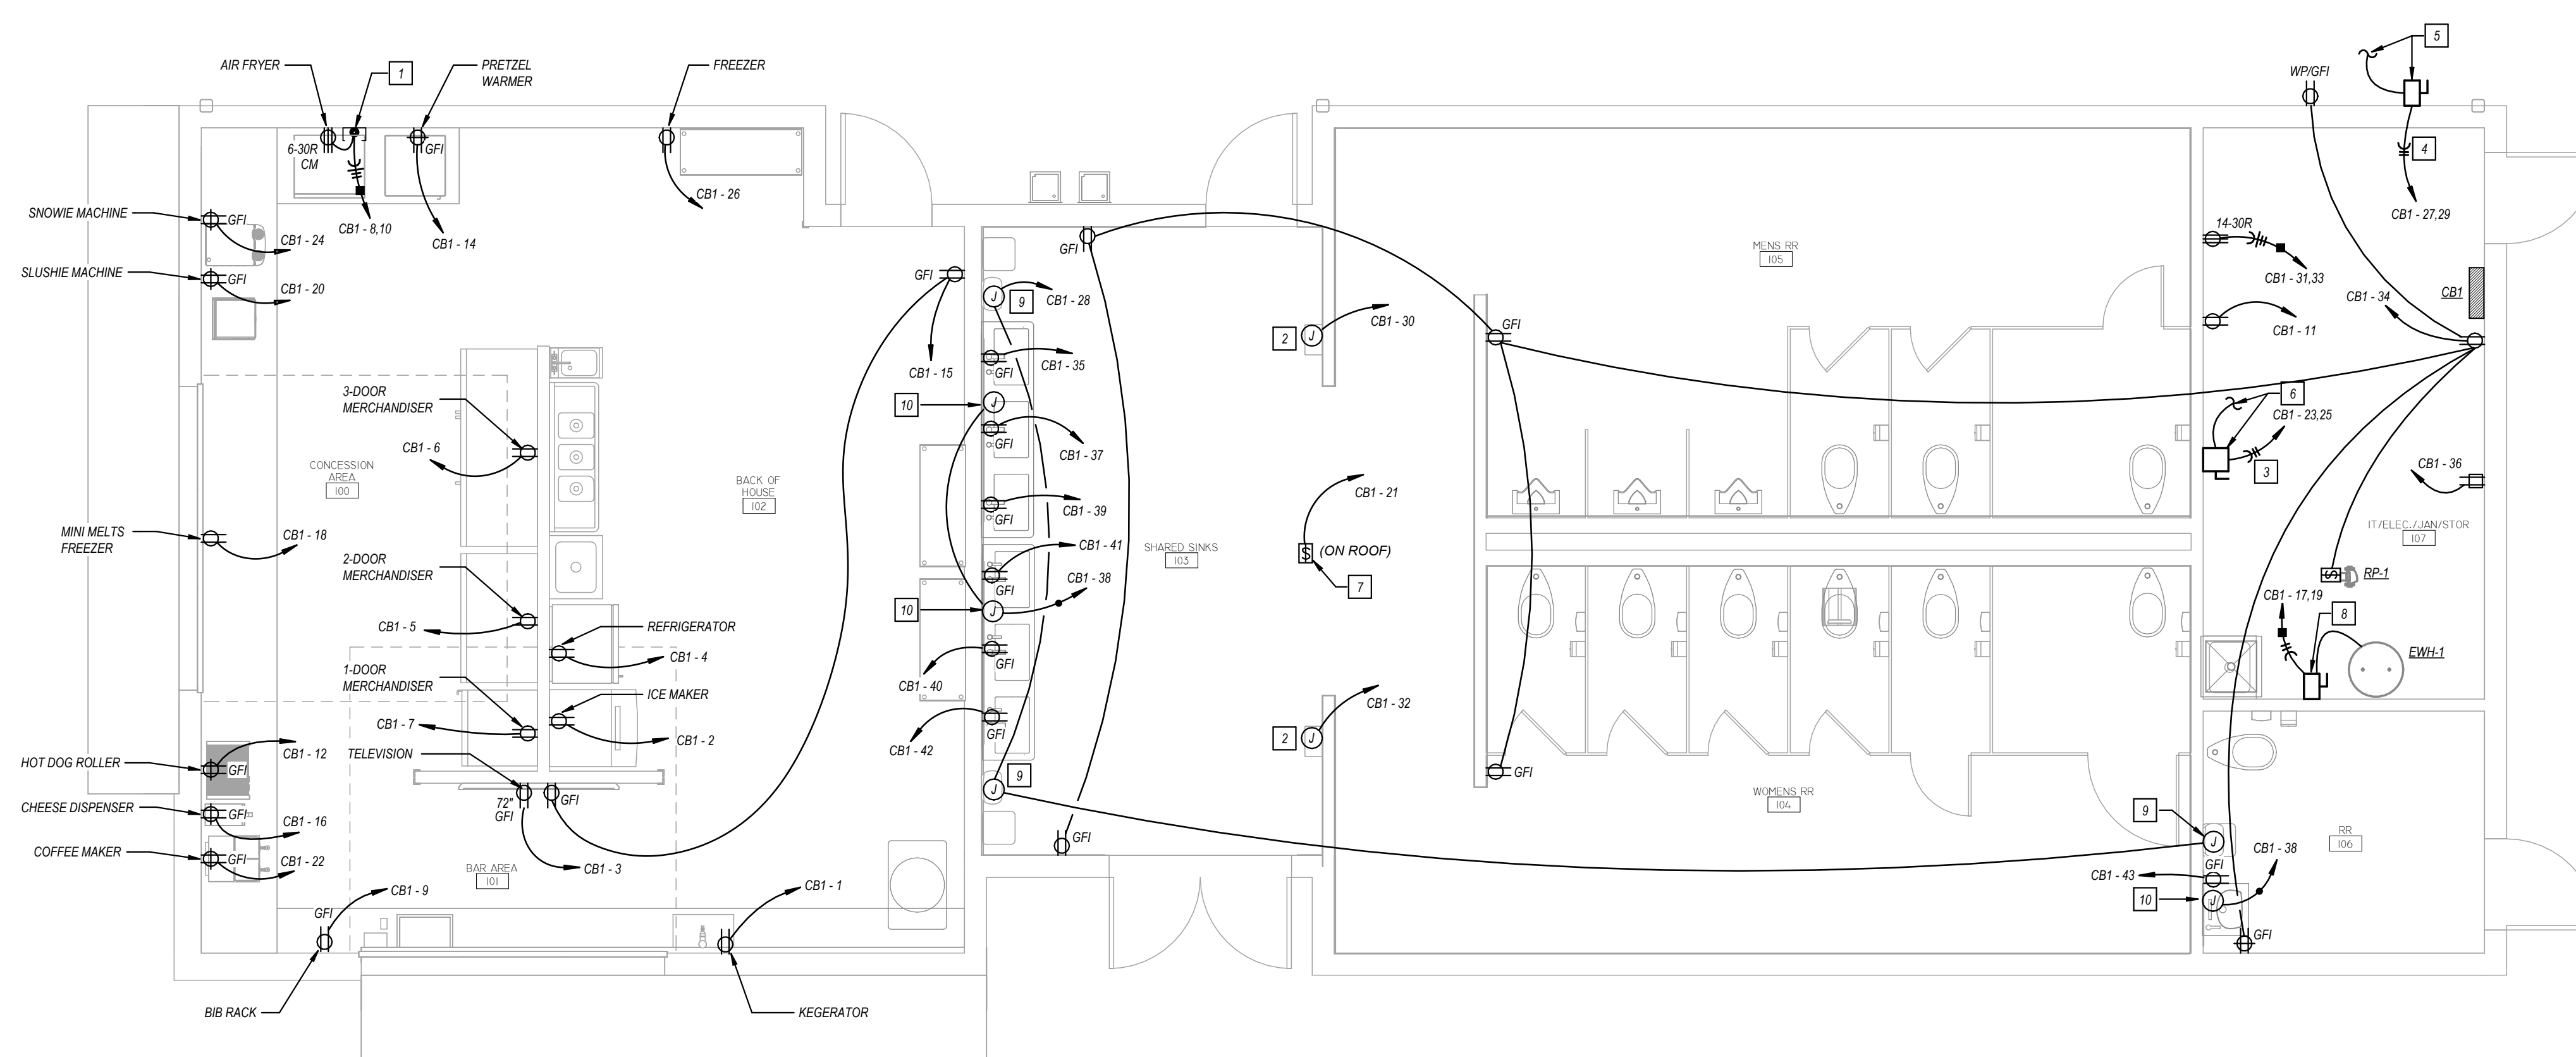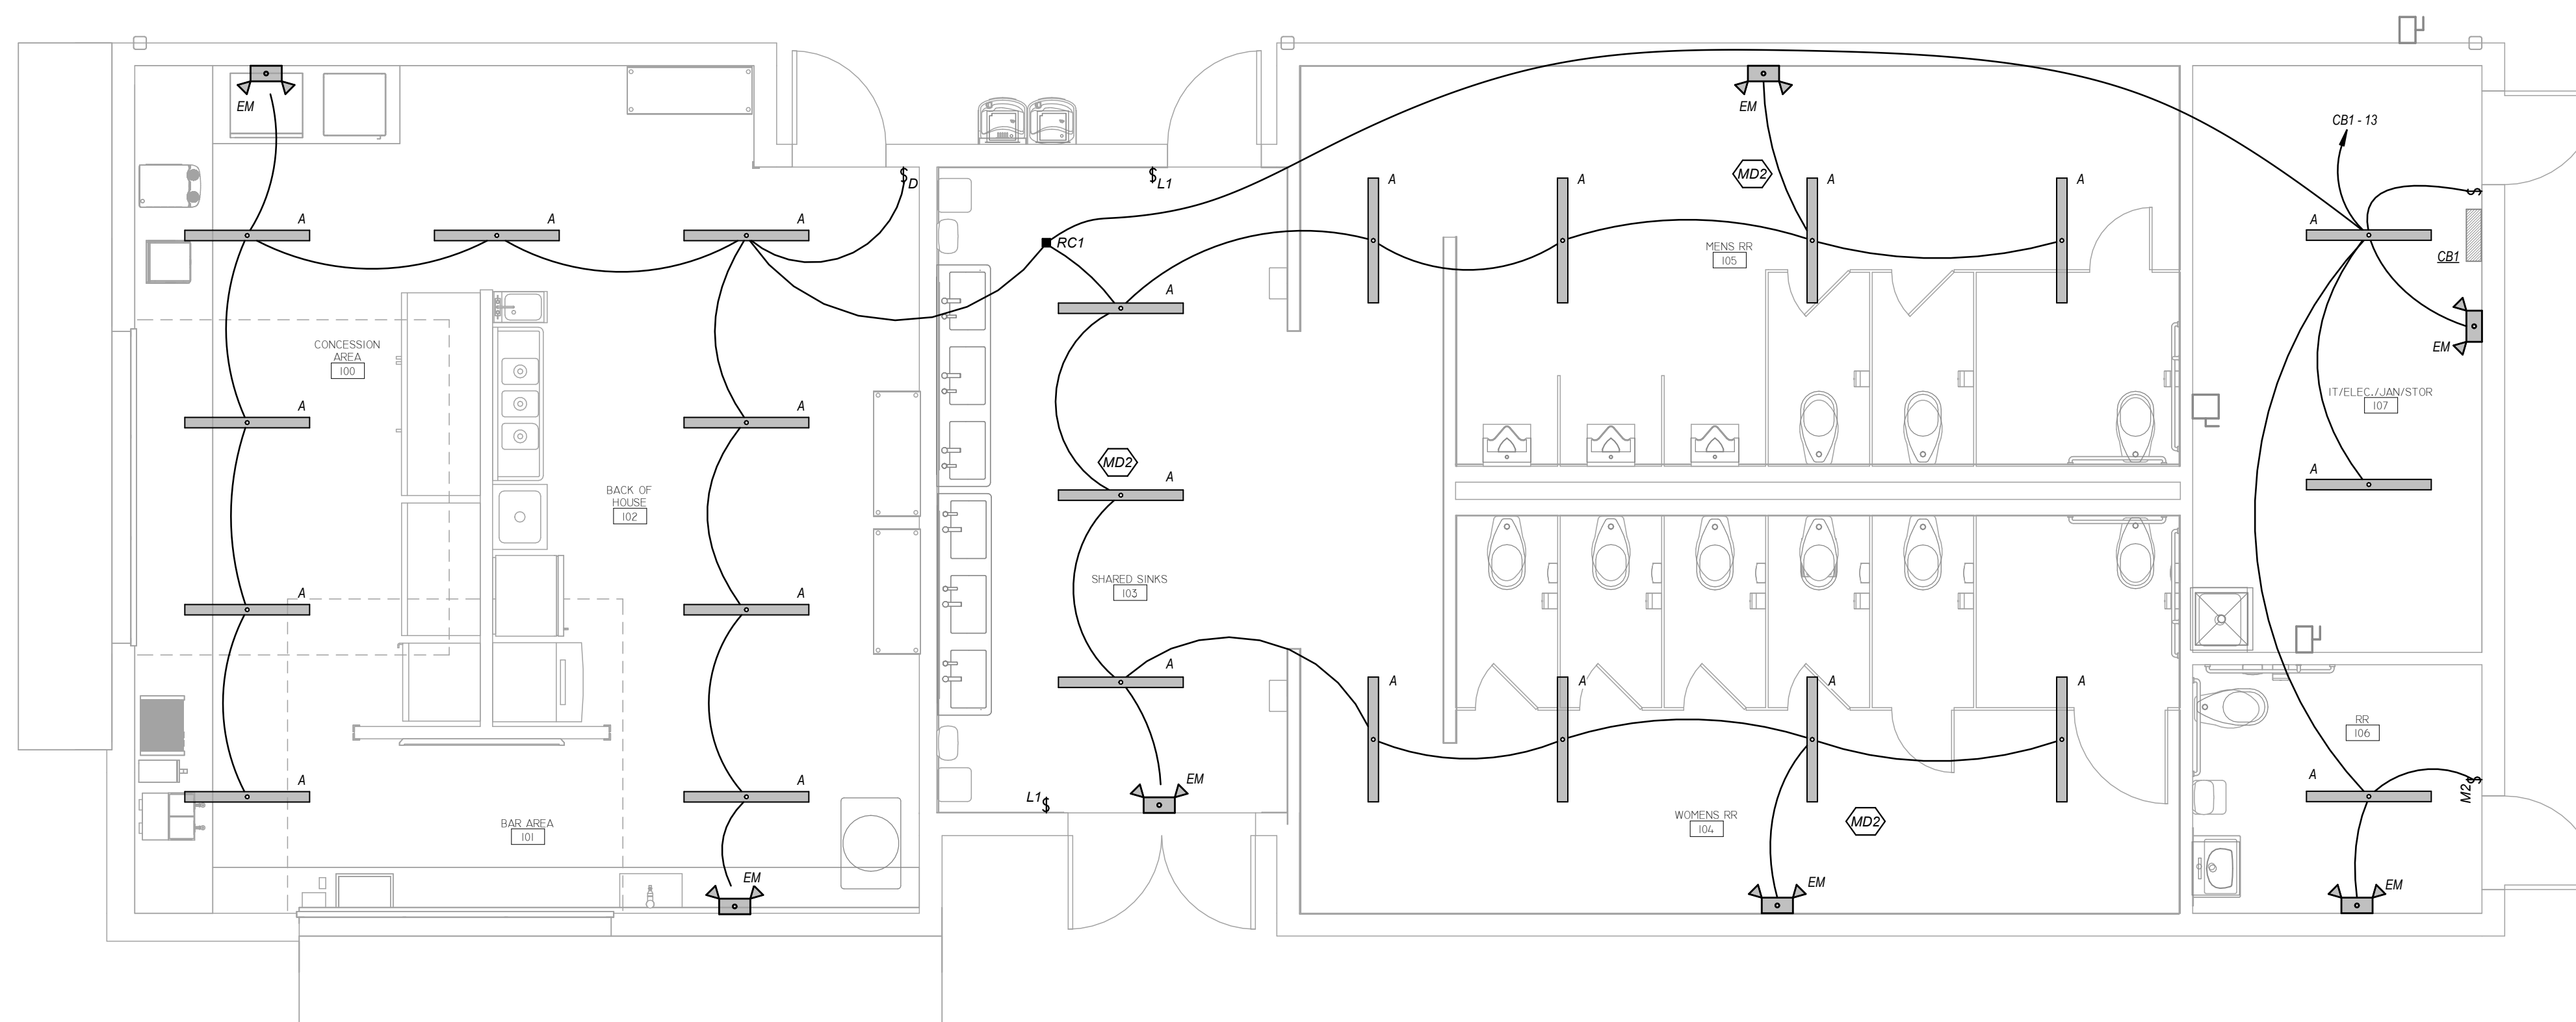

MECHANICAL SPECIFICATIONS

1. GENERAL PROVISIONS:
- 1.1. PROVIDE ALL LABOR, MATERIALS, AND EQUIPMENT NECESSARY FOR THE COMPLETE INSTALLATION OF THE MECHANICAL SYSTEMS OUTLINED.
 - 1.2. OBTAIN ALL PERMITS, FEES, LICENSES, INSPECTIONS, AND CERTIFICATES OF COMPLIANCE OR APPROVAL AS REQUIRED BY THE AUTHORITIES.
 - 1.3. ALL WORK SHALL BE PERFORMED IN ACCORDANCE WITH ALL APPLICABLE LAWS, CODES AND REGULATIONS OF THE GOVERNMENTAL BODIES HAVING JURISDICTION OVER THE SITE.
 - 1.4. ALL TESTING REQUIRED BY AUTHORITIES SHALL BE CONSIDERED PART OF THIS WORK.
 - 1.5. DURING CONSTRUCTION, ALL FIXTURES, EQUIPMENT, PIPE, DUCT, ETC. SHALL BE COVERED, PLUGGED, OR CAPPED AS REQUIRED TO KEEP CLEAN AND UNDAMAGED. ALL DAMAGED ITEMS SHALL BE RESTORED TO ORIGINAL CONDITION OR REPLACED. ALL PROTECTIVE COVERING SHALL BE REMOVED BEFORE FINAL ACCEPTANCE.
 - 1.6. PROVIDE ALL NECESSARY CUTTING AND PATCHING OF WALLS, FLOORS, CEILINGS, AND ROOFS AS NECESSARY. PATCH AROUND ALL OPENINGS SHALL MATCH ADJACENT AREA. COORDINATE ALL ROOFING WORK WITH OWNER OR RESPONSIBLE PARTY, SO THAT THE EXISTING ROOFING WARRANTY WILL BE MAINTAINED.
 - 1.7. CONTRACTOR SHALL GUARANTEE ALL WORK AND MATERIALS AGAINST DEFECTS FOR A PERIOD OF ONE YEAR FROM FINAL ACCEPTANCE.
2. OPERATION AND MAINTENANCE MANUALS:
- 2.1. DURING THE COURSE OF CONSTRUCTION, COLLECT AND COMPILE OPERATING INSTRUCTIONS, WIRING DIAGRAMS, CATALOG CUTS, LUBRICATION AND PREVENTIVE MAINTENANCE INSTRUCTIONS, PARTS LISTS, ETC. FOR ALL EQUIPMENT FURNISHED UNDER THIS CONTRACT.
 - 2.2. ALL LITERATURE AND INSTRUCTIONS SHIPPED WITH THE EQUIPMENT SHALL BE SAVED FOR INCLUSION IN THE OPERATION AND MAINTENANCE MANUALS.
 - 2.3. ALL LITERATURE LISTED ABOVE AND ALL PAPERS LISTING WARRANTIES, ETC. SHALL BE BOUND IN A 3-RING BINDER AND LABELED WITH THE PROJECT NAME, ADDRESS, ARCHITECT, ENGINEER, CONTRACTORS, ETC.
3. MANUFACTURERS:
- 3.1. MANUFACTURERS, MODEL NUMBERS, ETC. INDICATED OR SCHEDULED ON THE DRAWINGS SHALL BE INTERPRETED AS HAVING ESTABLISHED A STANDARD OF QUALITY AND SHALL NOT BE CONSTRUED AS LIMITING COMPETITION. ARTICLES, FIXTURES, ETC. OF EQUAL QUALITY BY MANUFACTURERS SHALL BE ACCEPTABLE, SUBJECT TO STRUCTURAL AND ELECTRICAL CONSTRAINTS OF THE PROJECT DESIGN, UNLESS NOTED OTHERWISE.
4. MOTORS:
- 4.1. PROVIDE THERMAL OVERLOAD PROTECTION FOR EACH MOTOR PROVIDED BY THIS WORK.
5. TESTING, BALANCING, AND CLEANING:
- 5.1. ALL PIPING SHALL BE TESTED FOR LEAKS BEFORE BEING CONCEALED IN WALL CONSTRUCTION OR COVERED WITH INSULATION.
 - 5.2. DUCTWORK AND PIPING SHALL BE BALANCED BY QUALIFIED BALANCING PERSONNEL WHO HAVE PREVIOUS EXPERIENCE WITH BALANCING PROCEDURES.
6. PIPING:
- 6.1. CONDENSATE DRAINS & INDIRECT WASTE (ABOVEGROUND):
 - 6.1.1. DWV, WROUGHT COPPER, ANSI B-16.29 (INSIDE BUILDING).
 - 6.1.2. POLYVINYLCHLORIDE (PVC) DWV PIPE, SCHEDULE 40, SOLVENT JOINT (EXTERIOR OF BUILDING).
 - 6.2. REFRIGERANT:
 - 6.2.1. ASTM B 280, TYPE ACR, HARD-DRAWN STRAIGHT LENGTHS, AND SOFT-ANNEALED COILS, SEAMLESS COPPER TUBING.
 - 6.2.2. WROUGHT COPPER, ANSI B16.22, STREAMLINED PATTERN, FITTINGS, BRAZED JOINTS, AWS A 5.8, CLASSIFICATION BAG-1 (SILVER).
 - 6.2.3. TUBING SHALL BE FACTORY CLEANED, READY FOR INSTALLATION, AND HAVE ENDS CAPPED TO PROTECT CLEANLINESS OF PIPE INTERIORS PRIOR TO SHIPPING.
 - 6.2.4. SIZE AND INSTALLATION OF PIPE SHALL BE IN ACCORDANCE WITH MANUFACTURER'S RECOMMENDATIONS.
 - 6.3. ALL PIPE HANGERS AND SUPPORTS SHALL BE STANDARD PRODUCTS OF GRINNELL, FEE AND MASON, OR ELCEN. HANGER SPACING SHALL BE IN ACCORDANCE WITH MSS-SP-69.
 - 6.4. SLEEVES:
 - 6.4.1. PROVIDE, SET, AND PROPERLY LOCATE PIPE SLEEVES AS REQUIRED FOR THIS WORK. ALL SLEEVES SHALL BE OF SUFFICIENT SIZE TO PERMIT PIPE MOVEMENT DUE TO EXPANSION AND CONTRACTION AND TO ACCOMMODATE PIPE INSULATION.
 - 6.4.2. INTERIOR PARTITIONS: 18 GAGE GALVANIZED STEEL, PACK BETWEEN PIPE AND SLEEVE WITH FIRE SAFING AND CAULK AT EACH END WITH FIRE RESISTANT SEALANT.
 - 6.4.3. ROOF: PROSET OR EQUAL, MANUFACTURED PVC SCHEDULE 40 PIPE SLEEVE WITH WATERPROOF SEAL. COORDINATE WITH ROOFING CONTRACTOR AND FLASH AS REQUIRED TO MAINTAIN ROOF WARRANTY.
 - 6.4.4. PLUMBING VENTS: FLASH ROOF VENT INTO ROOFING SYSTEM AS REQUIRED BY THE ROOFING CONTRACTOR TO MAINTAIN EXISTING ROOF WARRANTY.
 - 6.5. PROVIDE CHROME PLATED ESCUTCHEONS ON ALL PIPE ENTERING FINISHED AREAS.
7. INSULATION AND DUCT LINING:
- 7.1. ALL INSULATIONS AND ACCESSORIES SHALL HAVE A FIRE HAZARD CLASSIFICATION WITH A MAXIMUM FLAME SPREAD RATING OF 25, A MAXIMUM FUEL CONTRIBUTION RATING OF 50, AND A MAXIMUM SMOKE DEVELOPED RATING OF 50, IN ACCORDANCE WITH NFPA.
 - 7.2. PIPE INSULATION:
 - 7.2.1. THE PIPING INSULATION USED SHALL HAVE A THERMAL CONDUCTIVITY OF 0.27 Btu per in/h"sqft°F OR LESS.
 - 7.2.2. FIBERGLASS INSULATION WITH FACTORY APPLIED VAPOR BARRIER, ASJ JACKET, FACTORY APPLIED PRESSURE SEALING LONGITUDE LAP JOINT, NO STAPLES, ZESTON PREMOLDED PVC FITTING COVERS. INSTALLATION SHALL BE IN ACCORDANCE WITH MANUFACTURER'S RECOMMENDATIONS.
 - 7.2.3. FLEXIBLE CLOSED CELL ELASTOMERIC THERMAL INSULATION, UNSLIT OR PRESLIT WITH PRESSURE SENSITIVE ADHESIVE SYSTEM FOR CLOSURE AND VAPOR SEALING, EQUAL TO ARMSTRONG AP ARMAFLEX OR ARMAFLEX 2000.
 - 7.2.4. FOR NON CIRCULATING SYSTEMS, THE FIRST 8 FEET OF INLET AND OUTLET PIPING BETWEEN THE TANK AND THE HEAT TRAP (INCLUDING THE HEAT TRAP) MUST BE INSULATED.
 - 7.2.5. INSULATION SCHEDULE:
 - 7.2.5.1. REFRIGERANT SUCTION: 1" FOR PIPING UP TO 1 1/2", & 1-1/2" FOR PIPING 1-1/2" AND LARGER
 - 7.2.5.2. CONDENSATE DRAINS INSIDE BUILDING: 1/2"
 - 7.3. DUCTWORK: ACOUSTICAL INSULATION:
 - 7.3.1. DUCT LINING: 2 LB/CF, THICKNESS AS SCHEDULED, AIR STREAM SIDE COATED, INSTALL PER SMACNA STANDARDS.
 - 7.3.1.1. DUCT LINING SCHEDULE:
 - 7.3.1.1.1. RETURN AIR DUCT: 1/2" THROUGHOUT THE FIRST 10 FEET OF DUCT.
 - 7.3.1.1.2. DUCTWORK: THERMAL INSULATION
 - 7.3.1.1.3. DUCT COVERING: 3/4 LB/CF, FIBERGLASS BLANKET WITH FACTORY APPLIED VAPOR BARRIER AND FACING, THICKNESS AS SCHEDULED. INSTALLATION IN ACCORDANCE WITH MANUFACTURER'S RECOMMENDATIONS.
 - 7.3.2.1. DUCT COVERING SCHEDULE: MINIMUM R-6:
 - 7.3.2.1.1. ROUND SUPPLY DUCT 2"
 - 7.3.2.1.2. RETURN AIR DUCT 2"
 - 7.3.2.1.3. OUTDOOR AIR DUCT 2"
 - 7.3.2.2. DUCT LINING: 2 LB/CF, THICKNESS AS SCHEDULED, AIR STREAM SIDE COATED, INSTALL PER SMACNA STANDARDS.
 - 7.3.2.2.1. DUCT LINING SCHEDULE: MINIMUM R-6:
 - 7.3.2.2.1.1. ROUND SUPPLY DUCT 1-1/2"
 - 7.3.2.2.1.2. RETURN AIR DUCT 1-1/2"
8. DUCTWORK:
- 8.1. ALL DUCTWORK, UNLESS OTHERWISE INDICATED, SHALL BE FABRICATED FROM GALVANIZED SHEET STEEL COMPLYING WITH ASTM A 57, LOCKFORMING QUALITY, WITH G 60 ZINC COATING IN ACCORDANCE WITH ASTM A 525; AND MILL PHOSPHATING FOR EXPOSED LOCATIONS.
 - 8.2. DUCTWORK: METAL GAUGES, REINFORCING, ETC. SHALL BE CONSTRUCTED IN ACCORDANCE WITH SMACNA "HVAC DUCT CONSTRUCTION STANDARDS," LATEST EDITION FOR A 2 INCH WATER GAUGE STATIC PRESSURE.
 - 8.3. ALL FITTINGS SHALL BE CONSTRUCTED IN ACCORDANCE WITH SMACNA "HVAC DUCT CONSTRUCTION STANDARDS," LATEST EDITION.
 - 8.4. SEAL ALL CONCEALED DUCTWORK JOINTS WITH NON-HARDENING, NON-MIGRATING MASTIC SEALANT, AS RECOMMENDED FOR SEALING SEAMS AND JOINTS IN DUCTWORK. OIL-BASE CAULKING AND GLAZING COMPOUNDS SHALL NOT BE ACCEPTABLE. DUCTS SHALL BE SEALED TO THE CLASS LEVEL LISTED BELOW:
 - 8.4.1. 1) UNCONDITIONED SPACES:
 - 8.4.1.1. SUPPLY ≤ 2" W.C. - CLASS B
 - 8.4.1.2. SUPPLY > 2" W.C. - CLASS A
 - 8.4.1.3. EXHAUST - CLASS C
 - 8.4.1.4. RETURN - CLASS B
 - 8.4.2. CONDITIONED SPACES (PLENUM):
 - 8.4.2.1. SUPPLY ≤ 2" W.C. - CLASS C
 - 8.4.2.1. SUPPLY > 2" W.C. - CLASS B
 - 8.4.2.2. EXHAUST - CLASS B
 - 8.4.2.3. RETURN - CLASS C
9. FLEXIBLE DUCT:
- 9.1. ATO #888 (R-6), OR EQUAL.
 - 9.2. FACTORY APPLIED INSULATION AND VAPOR BARRIER, 1-1/2" THICK.
 - 9.3. MAXIMUM LENGTH OF 6'-0".
10. EXHAUST FANS:
- 10.1. CENTRIFUGAL TYPE FAN WITH CHARACTERISTICS AND CAPACITY AS SCHEDULED, ELECTRICALLY POWERED, SUITABLE FOR MOUNTING ON ROOF CURB, DIRECT OR BELT DRIVEN, HEAVY GAUGE SPUN-ALUMINUM WEATHERPROOF HOUSINGS OF THE HOODED DOME OR UPLAIST TYPE. PROVIDE PERMANENT SPLUT-CAPACITOR TYPE MOTOR FOR DIRECT DRIVEN FANS, AND CAPACITOR-START, INDUCTION-RUN TYPE MOTOR FOR BELT DRIVEN FANS.
11. AIR HANDLING UNIT AND HEAT PUMP CONDENSING UNIT:
- 11.1. AIR HANDLING UNIT SHALL BE FACTORY ASSEMBLED, PRE-WIRED UNIT CONSISTING OF SHEETMETAL CASING, FILTER, SUPPLY FAN, ELECTRIC RESISTANCE HEATER, AND CONTROLS. CAPACITY SHALL BE AS SCHEDULED.
 - 11.1.1. THE UNIT SHALL BE EQUIPPED WITH THE MANUFACTURER'S STANDARD CONTROLS INCLUDING 24 VOLT CONTROL TRANSFORMER, HIGH TEMPERATURE LIMIT SWITCH, AND FAN TIMED DELAY RELAY.
 - 11.1.2. RETURN AIR INLET ON UNIT SHALL BE PROVIDED WITH A 1" THROWAWAY TYPE FILTER AND SLIDE IN FRAME, MOUNTED ON THE UNIT.
 - 11.1.3. FAN SHALL BE A DIRECT DRIVE MULTI-SPEED BLOWER, RESILIENTLY MOUNTED IN THE CASING. MOTOR SHALL BE PROVIDED WITH AUTOMATIC THERMAL OVERLOAD PROTECTION.
 - 11.1.4. REFRIGERANT COIL: ALUMINUM FINS BONDED TO SEAMLESS COPPER TUBE BY MEANS OF MECHANICAL EXPANSION. AN EQUALIZING TYPE VERTICAL DISTRIBUTOR SHALL ENSURE EACH COIL CIRCUIT RECEIVES THE SAME AMOUNT OF REFRIGERANT.
 - 11.1.5. ELECTRIC HEAT: ELECTRIC HEATER SHALL BE INSTALLED INTERNAL TO THE AIR HANDLING UNIT. HEATING ELEMENTS SHALL BE CONSTRUCTED OF HEAVY DUTY NICKEL CHROMIUM. EACH HEATER SHALL HAVE AUTOMATICALLY RESET HIGH LIMIT CONTROL OPERATING THROUGH HEATING ELEMENT CONTACTORS. EACH HEATER SHALL BE INDIVIDUALLY FUSED AND SHALL COMPLY WITH ALL NEC REQUIREMENTS. HEATERS SHALL BE UL LISTED.
 - 11.2. HEAT PUMP CONDENSING UNIT SHALL BE FACTORY-ASSEMBLED AND TESTED AIR-COOLED CONDENSING UNIT, CONSISTING OF COMPRESSOR, CONDENSER COIL, FAN, MOTOR, REVERSING VALVE, SOLID-STATE DEFROST CONTROL UTILIZING THERMISTERS, REFRIGERANT RESERVOIR, OPERATING CONTROLS, ETC. CAPACITY AND ELECTRICAL CHARACTERISTICS SHALL BE AS SCHEDULED.
 - 11.2.1. HERMETICALLY SEALED COMPRESSOR WITH BUILT-IN OVERLOADS AND VIBRATION ISOLATION. COMPRESSOR MOTOR, SHALL HAVE THERMAL AND CURRENT SENSITIVE OVERLOAD DEVICES, INTERNAL HIGH-PRESSURE PROTECTION, HIGH AND LOW PRESSURE CUTOUT SWITCHES, START CAPACITOR AND RELAY, 2-POLE CONTACTOR, CRANKCASE HEATER, AND TEMPERATURE ACTUATED SWITCH AND TIMER TO PREVENT COMPRESSOR RAPID CYCLE.
 - 11.2.2. COIL SHALL BE COPPER TUBING WITH ALUMINUM FINS, COMPLETE WITH LIQUID ACCUMULATOR AND LIQUID SUBCOOLER. EXTEND REFRIGERANT PIPING WITH BRASS SERVICE VALVES, FITTINGS, AND GAGE PORTS TO EXTERIOR OF CASING.
 - 11.2.3. ALUMINUM PROPELLER FAN SHALL BE DIRECT DRIVEN, WITH PERMANENTLY LUBRICATED FAN MOTOR HAVING THERMAL OVERLOAD PROTECTION.
 - 11.2.4. PROVIDE REVERSING VALVE, SUCTION LINE ACCUMULATOR, DISCHARGE MUFFLER, FLOW CONTROL CHECK VALVE, AND SOLID-STATE DEFROST CONTROL UTILIZING THERMISTERS.
12. CONTROL WIRING:
- 12.1. ELECTRICAL WIRING AND WIRING CONNECTIONS REQUIRED FOR THE INSTALLATION OF THE TEMPERATURE CONTROL SYSTEM, SHALL BE PROVIDED BY THIS CONTRACTOR, UNLESS SPECIFICALLY SHOWN ON THE ELECTRICAL DRAWINGS OR SPECIFICATIONS.
 - 12.2. INSTALL CONTROL WIRING, WITHOUT SPLICES BETWEEN TERMINAL POINTS, COLOR CODED. INSTALL IN NEAT WORKMANLIKE MANNER, SECURELY FASTENED. INSTALL IN ACCORDANCE WITH NATIONAL ELECTRICAL CODE AND THE ELECTRICAL SPECIFICATIONS.
 - 12.2.1. INSTALL CIRCUITS OVER 250 VOLT WITH COLOR CODED NUMBER 12 WIRE.
 - 12.2.2. INSTALL CIRCUITS UNDER 250 VOLT WITH COLOR CODED NUMBER 18 WIRE WITH 0.031 INCH HIGH TEMPERATURE 105°F PLASTIC INSULATION ON EACH CONDUCTOR AND PLASTIC SHEATH OVER ALL.
 - 12.2.3. INSTALL ELECTRONIC CIRCUITS WITH COLOR CODED NUMBER 22 WIRE WITH 0.023 INCH POLYETHYLENE INSULATION ON EACH CONDUCTOR WITH PLASTIC JACKETED COPPER SHIELD OVER ALL.
 - 12.2.4. INSTALL LOW VOLTAGE CIRCUITS, LOCATED IN CONCRETE SLABS AND MASONRY WALLS, OR EXPOSED IN OCCUPIED AREAS, IN ELECTRIC CONDUIT.
 - 12.2.5. ALL WIRING IN AREAS USED AS AIR PLENUMS SHALL BE IN ELECTRIC CONDUIT EXCEPT THAT LOW VOLTAGE WIRING MAY BE TEFLON COATED, ALUMINUM SHEATHED CABLE OR OTHER WIRE SPECIFICALLY APPROVED FOR INSTALLATION IN AIR PLENUMS, WHERE ACCEPTABLE BY LOCAL CODES.
 - 12.2.6. ALL WIRING IN AREAS NOT USED FOR AIR MOVEMENT SHALL BE IN ELECTRIC METALLIC TUBING EXCEPT LOW VOLTAGE WIRING MAY BE IN APPROVED SIGNAL CABLE WHERE ACCEPTED BY LOCAL CODES.

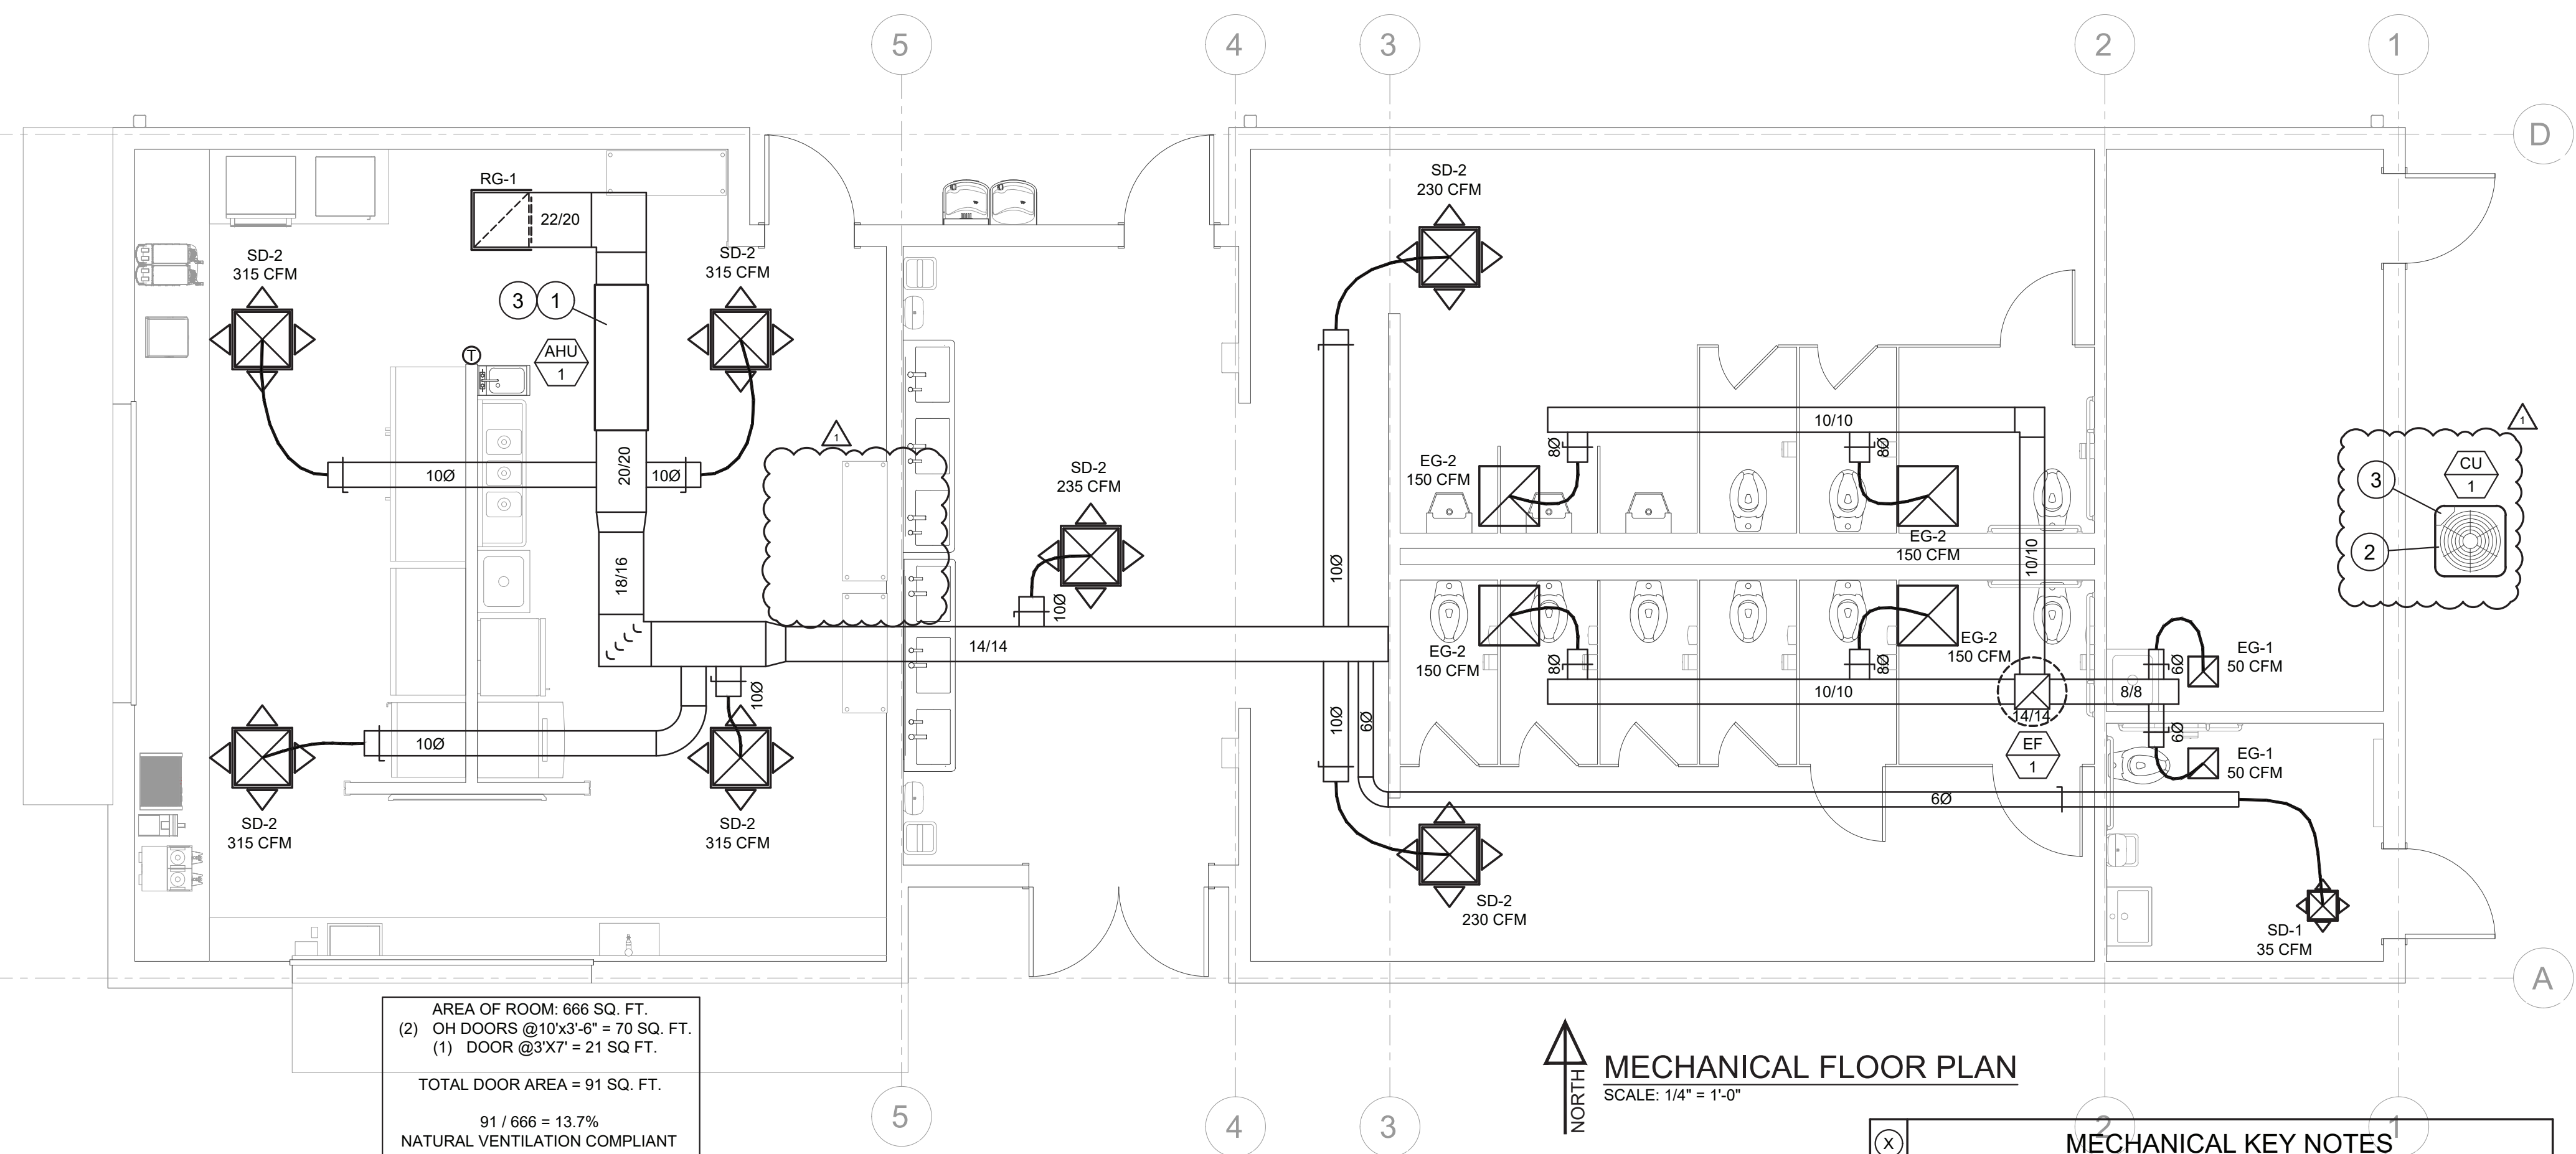

AIR HANDLER SCHEDULE														
MARK	MANUFACTURER	MODEL	TONS	MINIMUM OUTDOOR AIR (CFM)	BLOWER DATA			HEATING DATA (ELEC)			ELECTRICAL DATA			ACCESSORIES AND INSTALLATION NOTES
					CFM	E.S.P.	HP	KW INPUT	STAGES	BTU/H OUTPUT	VOLTAGE	MCA	MOCP	
	LENNOX	CBK47UHET060	5	0	1990	0.6	1	4.0 (@240V)	1	10,250	208 / 1Ø	28	30	1,2,3,4,5
1. AIR HANDLER AND CONDENSING UNIT SHALL BE OF THE SAME MANUFACTURER. 2. 1" THICK DISPOSABLE FILTER. 3. EXTERNAL STATIC PRESSURE INCLUDES PRESSURE DROP THROUGH ALL COMPONENTS EXTERNAL TO AIR HANDLER. 4. 7-DAY PROGRAMMABLE (HEAT/COOL/AUTO) COMMERCIAL THERMOSTAT. 5. ALL UNIT BREAKER SIZES SHALL BE COORDINATED WITH ELECTRICAL CONTRACTOR.														

HEAT PUMP CONDENSING UNIT SCHEDULE									
MARK	MANUFACTURER	MODEL	EVAP. COIL MODEL	TONS	EFFICIENCY RATING (SEER)	COOLING DATA			ACCESSORIES AND INSTALLATION NOTES
						TOTAL BTU/H	AMBIENT	EVAP. EAT	
CU 1	LENNOX	ML14KP1-060	CBK47UHET060	5	14.0	60,000	95°F	80°F/67°F	1,2,3,4,5,6
1. TIME DELAY ON COMPRESSOR RE-START. COMPRESSOR LOCK-OUT WITH AMBIENT BELOW 5°F. 2. INDOOR COIL WITH THERMAL EXPANSION VALVE (TXV). 3. CRANKCASE HEATER. 4. CONCRETE OR PRE-MANUFACTURED POLYOLEFIN PAD. 5. HAIL GUARDS. 6. ALL UNIT BREAKER SIZES SHALL BE COORDINATED WITH ELECTRICAL CONTRACTOR.									

GRILL, REGISTER, & DIFFUSER SCHEDULE						
MARK	MANUFACTURER	MODEL	FACE SIZE (INCHES)	NECK SIZE (INCHES)	FINISH	NOTES
SD-1	TITUS	TMS/3	12x12	6Ø	WHITE	-
SD-2	TITUS	TMS/3	24x24	10Ø	WHITE	-
RG-1	TITUS	PAR/3	24x24	22x22	WHITE	-
EG-1	TITUS	PAR-AA/3	12x12	6Ø	WHITE	-
EG-2	TITUS	PAR-AA/3	24x24	8Ø	WHITE	-

EXHAUST FAN SCHEDULE								
MARK	MANUFACTURER	MODEL	AIRFLOW (CFM)	E.S.P. (" W.C.)	RPM (MAX)	ELECTRICAL DATA		
						VOLTAGE	WATTS	HP
EF 1	SOLER & PALAU	SDB-12	700	0.50	1200	120 / 1Ø	-	1/4
1. BACKDRAFT DAMPER. 2. BIRD SCREEN. 3. 14" TALL PRE-SLOPED ROOF CURB								

MECHANICAL SYMBOLS AND LEGEND		
ABBR.	SYMBOL	DESCRIPTION
CD		CEILING DIFFUSER (SUPPLY AIR)
RG		RETURN GRILLE
EF		EXHAUST GRILLE
		THERMOSTAT (48" AFF)
		DUCTWORK (NEW)
18/12		SIZE OF RECTANGULAR DUCTWORK (WIDTH/HEIGHT, INCHES)
14Ø		SIZE OF ROUND DUCTWORK (DIAMETER, INCHES)
		FLEX DUCTWORK
SA		SUPPLY AIR (POSITIVE PRESSURE)
RA		RETURN AIR (NEGATIVE PRESSURE)
EA		EXHAUST AIR (POSITIVE OR NEGATIVE PRESSURE)
MBD		MANUAL BALANCING DAMPER
		MECHANICAL EQUIPMENT (AS SCHEDULED)
M.C.		MECHANICAL CONTRACTOR

MECHANICAL KEY NOTES	
1	SUPPORT UNIT FROM STRUCTURE AS REQUIRED BY MANUFACTURER. PROVIDE VIBRATION ISOLATION AT SUPPORT POINTS. PROVIDE WATERPROOF DRAIN PAN UNDER UNIT WITH CONTACT TO DE-ENERGIZE UNIT WITH PRESENCE OF WATER IN DRAIN PAN.
2	SET UNIT ON CONCRETE OR PRE-MANUFACTURER POLYEFIN PAD.
3	CONNECT REFRIGERANT PIPING TO CONDENSING UNIT & COIL AS REQUIRED. PROVIDE REFRIGERANT PIPING FOR CONDENSING UNIT AS REQUIRED BY MANUFACTURER. INSTALL PIPING AS RECOMMENDED BY MANUFACTURER.

MECHANICAL GENERAL NOTES	
1	COORDINATE WITH ALL PROJECT CONTRACTORS AND VERIFY EXISTING CONDITIONS FOR PROPER INSTALLATION OF SYSTEMS AS INTENDED.
2	INSTALL SYSTEMS AS REQUIRED TO PROVIDE MANUFACTURER-RECOMMENDED CLEARANCES.
3	FLEXIBLE CONNECTIONS SHALL BE PROVIDED BETWEEN DUCTWORK AND MOTORIZED EQUIPMENT.
4	NO PIPE OR DUCT SHALL BE ROUTED OVER THE TOP OF ELECTRICAL PANELS.
5	ALL MATERIALS EXPOSED WITHIN PLENUMS SHALL BE NONCOMBUSTIBLE OR SHALL HAVE A MAXIMUM FLAME SPREAD INDEX OF 25 AND A MAXIMUM SMOKE-DEVELOPED INDEX OF 50, WHEN TESTED IN ACCORDANCE WITH ASTM E 84.
6	ALL ROOFING WORK SHALL BE PERFORMED BY LANDLORD'S ROOFING CONTRACTOR (AT THIS CONTRACTOR'S EXPENSE) TO MAINTAIN EXISTING ROOF WARRANTY. VERIFY APPROVED ROOFING CONTRACTOR WITH LANDLORD PRIOR TO PERFORMING WORK.

MISSOURI PE COA #2016025677

Engineering, LLC

1624 N Glen Ellyn

Independence, MO 64056

816-516-9540

CONCESSIONS AND RESTROOMS

1421 NW RIVER RD.

LEE'S SUMMIT, MO

STAMP 2-9-2026




REVISION DATE:

1 HP RELOCATE 02.09.2026

ISSUE DATE:

02 FEBRUARY 2026

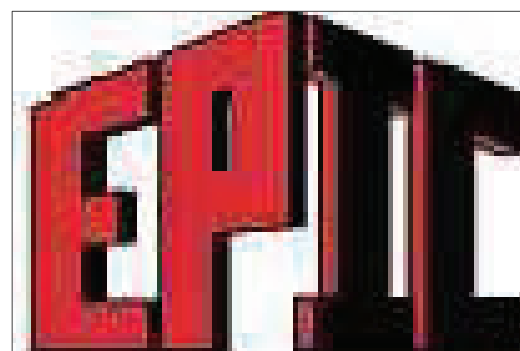

CONCRETE CONSTRUCTION
12600 E. 98TH ST.
KANSAS CITY, MO 64138

This drawing has been prepared by the Engineer, or under his supervision. This drawings is provided as an instrument of service by the Designer/Engineer and is intended for the use on this project only. Pursuant to the Architectural Works Copyright Protection Act of 1990, all drawings, specifications, ideas and designs, including the overall form, arrangement and composition of spaces and elements appearing herein, constitute the original, copyrighted work of the Designer/Engineer. Any reproduction, use, or disclosure of information contained herein without prior written consent of the Engineer is strictly prohibited. © 2026 CG Engineering, LLC.

M-1