




1 Floor Plan
scale: 1/8"=1'-0"

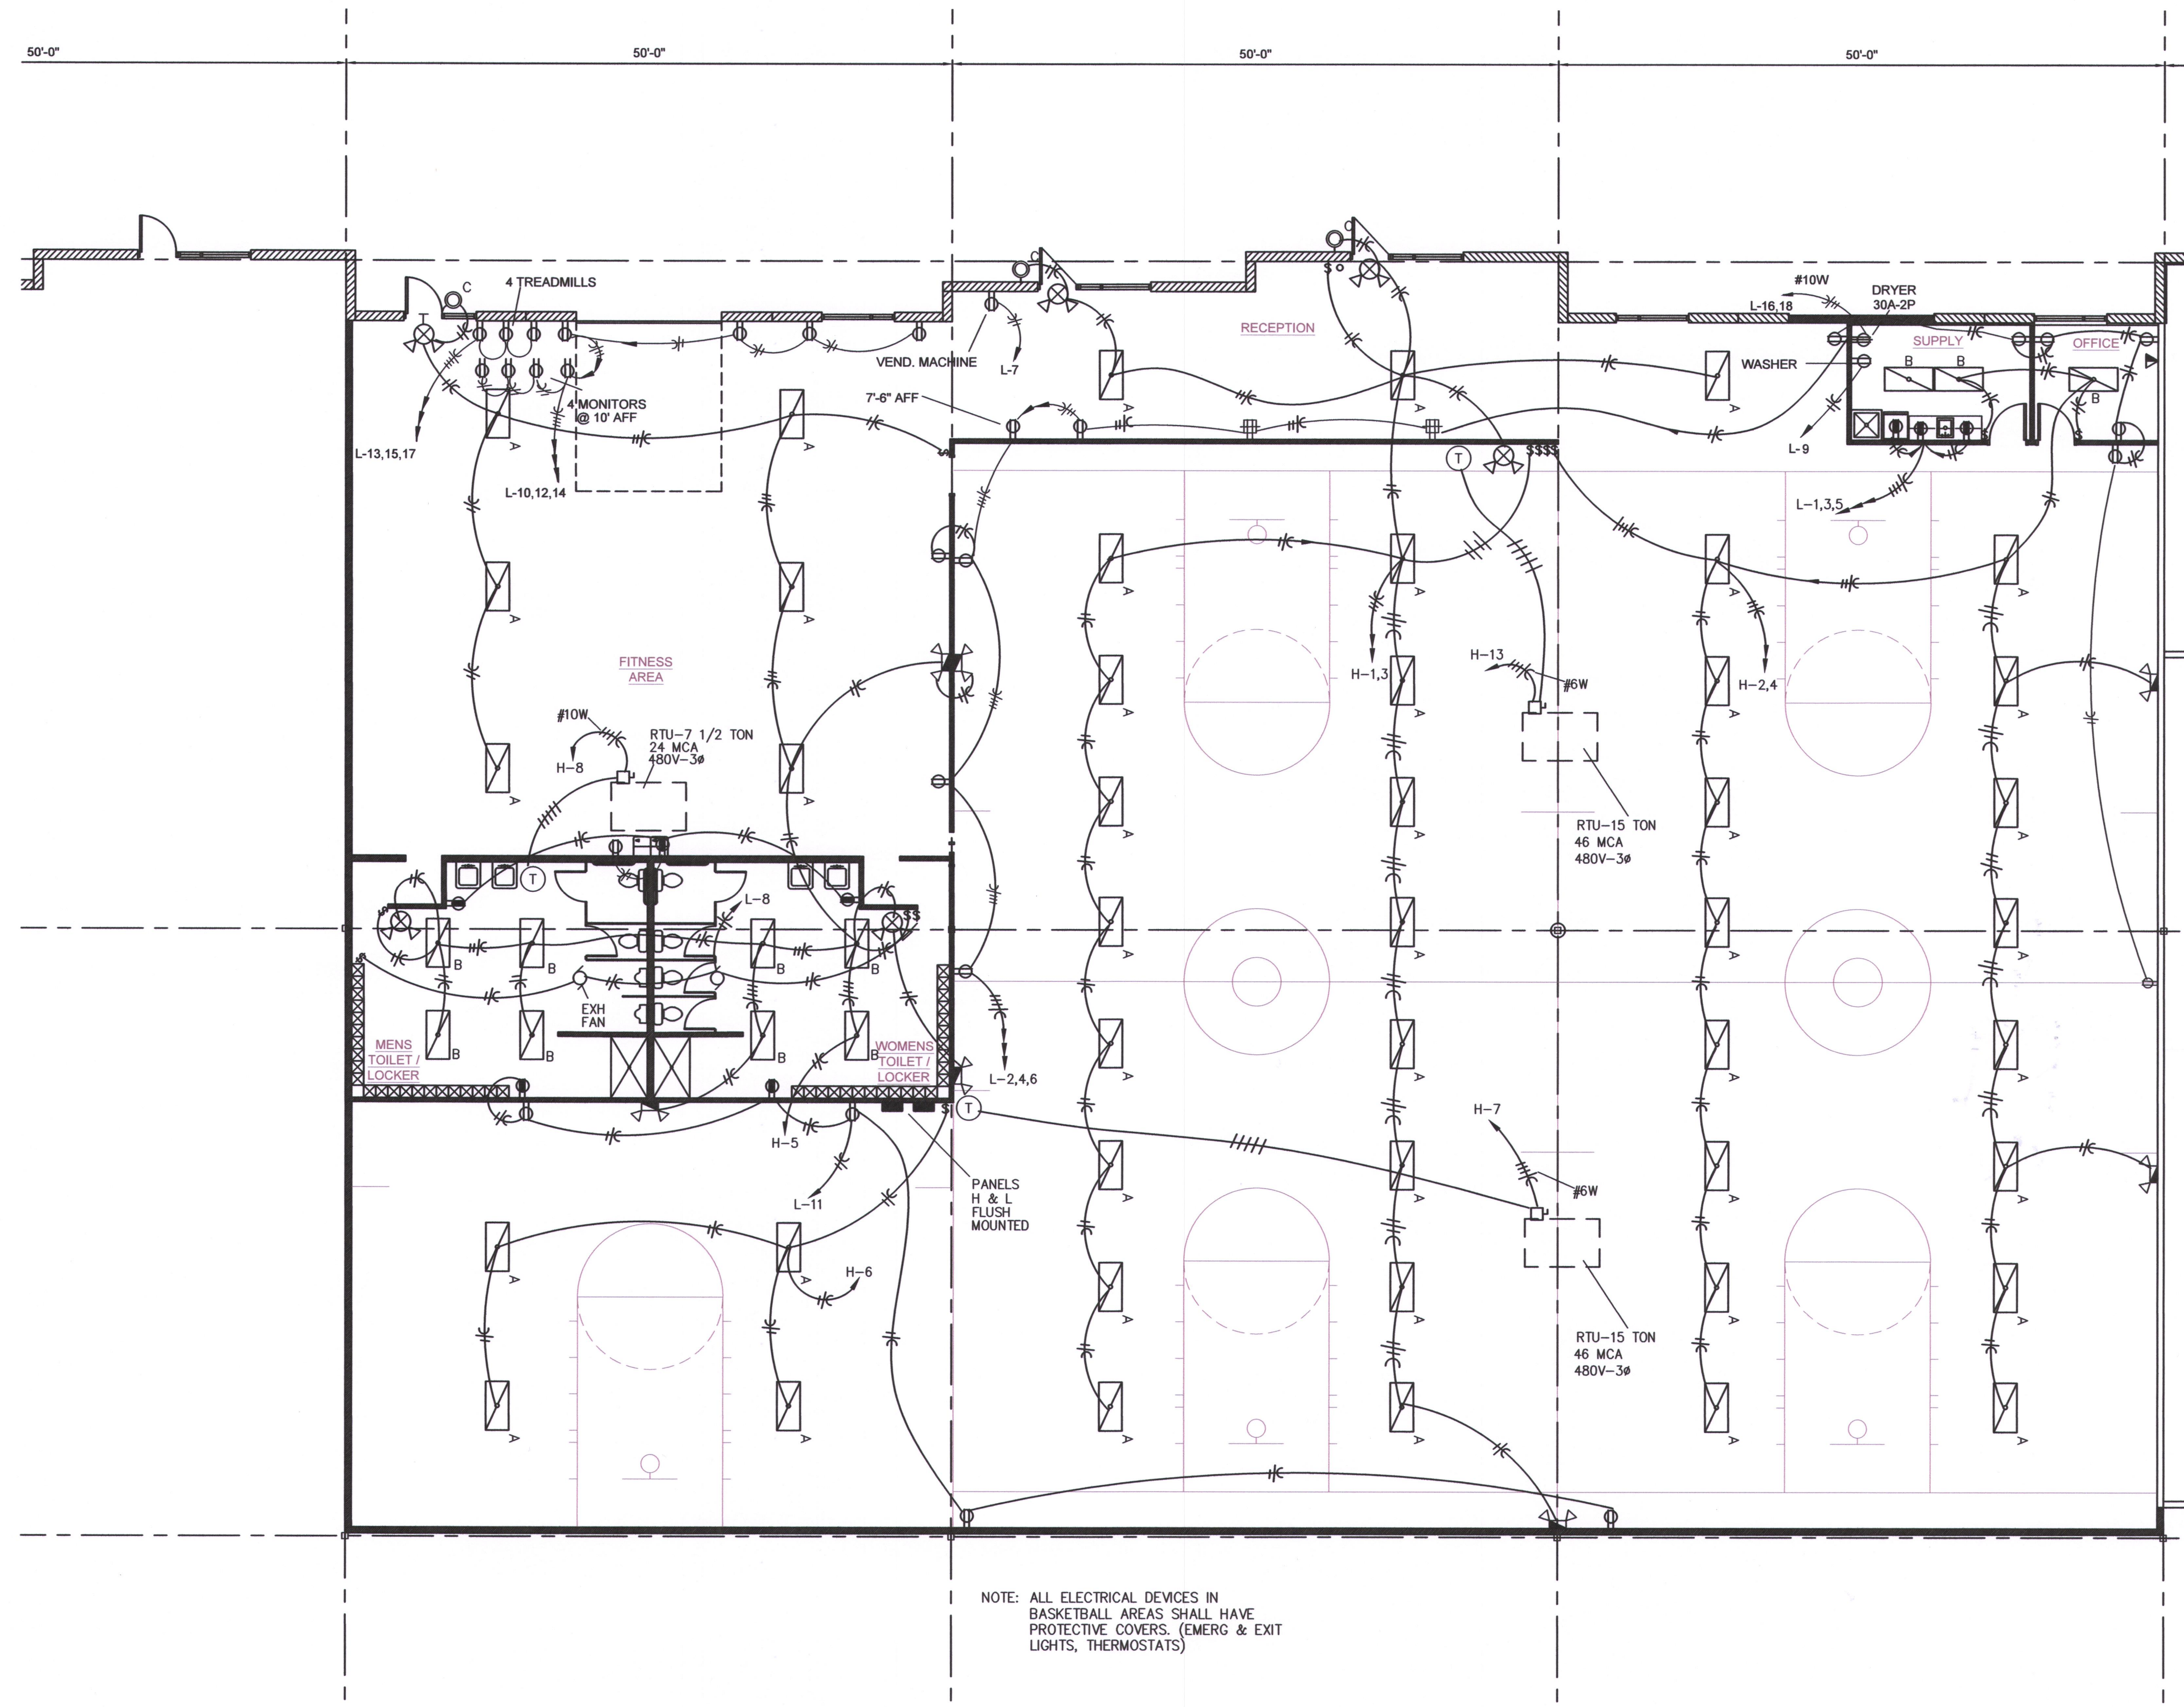

CASBURN CONSULTANTS
Professional Engineering
Mechanical * Electrical * Plumbing
128 SW HILLCREST LANE, LEES SUMMIT, MO 64063
C: (816) 726-6531
E-mail: jwcasburn@att.net

TENANT
INFILL
FOR

PICKUP
USA
FITNESS

AT

2724 NE
McBAINE DRIVE
LEE'S SUMMIT
MISSOURI

DATE: 4/20/2020


REVISIONS:

- △
- △
- △
- △
- △



ARCHITECTURAL
SERVICES
Robert J. Shirk Jr. - Principal / Project Mgr.

3009 ELMIRA CT.
INDEPENDENCE,
MISSOURI 64057
(816) 797-7115

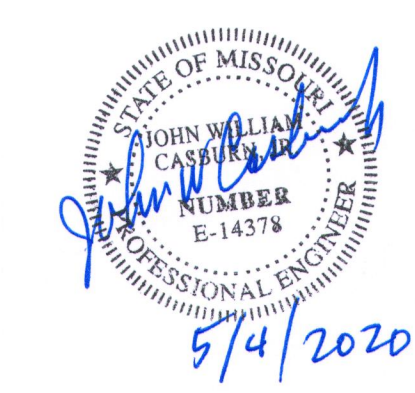

SHEET NO.

E101