



GENERAL REQUIREMENTS

- 1. ALL WORK SHALL BE DONE IN ACCORDANCE WITH LOCAL BUILDING, MECHANICAL, PLUMBING CODES NATIONAL ELECTRICAL CODE, NATIONAL FIRE PROTECTION CODE, EPA REGULATIONS, AND OCCUPATIONAL SAFETY AND HEALTH ACT. UNIFORM MECHANICAL, PLUMBING & FIRE CODES.
- 2. CONTRACTOR SHALL INCLUDE ALL LABOR, MATERIAL, AND EQUIPMENT TO PROVIDE COMPLETE AND FUNCTIONING INSTALLATIONS, AND ALL MATERIAL AND EQUIPMENT SHALL BE NEW UNLESS OTHERWISE SPECIFIED.
- 3. CONTRACTOR SHALL PROTECT ALL EXISTING WORK TO REMAIN, AND SHALL REPAIR ANY DAMAGED INCIDENTAL TO PERFORMANCE OF NEW WORK.
- 4. INTERFERENCE WITH OWNERS OPERATIONS OR INTERRUPTION OF SERVICES SHALL BE FULLY COORDINATED WITH OTHERS.
- 5. ACCEPTANCE OF WORK SHALL BE SUBJECT TO OWNER'S REPRESENTATIVE APPROVAL OF WORK IN PLACE AS WELL AS SHOP DRAWINGS AND SAMPLES OF MATERIALS AND EQUIPMENT WHICH SHALL BE CHECKED BY CONTRACTOR BEFORE SUBMITTAL.
- 6. ALL PERMITS AND LICENSES THAT ARE REQUIRED BY GOVERNING AUTHORITIES FOR THE PERFORMANCE OF MECHANICAL WORK SHALL BE PROCURED AND PAID FOR BY THE CONTRACTOR.


PLUMBING FIXTURE SCHEDULE

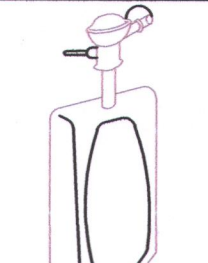


URINAL - AMERICAN STANDARD #6400.014 VITREOUS CHINA WATER SAVER (1.5 GALLONS PER FLUSH) URINAL WITH INTEGRAL SPREADER FLOOR MOUNTED WISCON ROYAL 186 FLUSH VALVE, STRAINER TOP SPUD. 1/2" CW, 2" WASTE, 1-1/2" VENT.

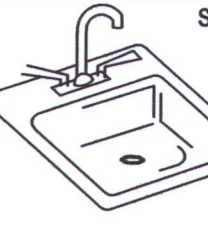


SINK - DAYTON D-12522 STAINLESS STEEL SELF RIMMING, SINK WITH HOLES - 3 HOLES FOR LK-232-S-BH-3 H ARC SINGLE LEVER FAUCET WITH 5" WRIST BLADES. INCLUDE FLEXIBLE SUPPLIES WITH WHEEL HANDLE STOPS AND 1-1/2" P-TRAP AND CUP STRAINER. 1/2" H & CW, 1-1/2" WASTE, 1-1/2" VENT.

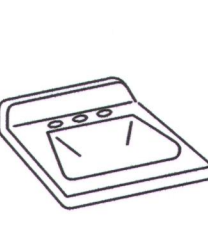

BATHMASTER - BF7404-00 WITH TROP 20 X 18 WALL HUNG, 4" CENTER SET FAUCET, INCLUDE STRAINER, OR EQUAL FAUCET: DELTA 2567 - LPH H22, A22 CHROME, OR EQUAL

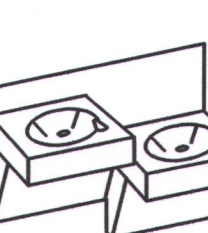


DRINKING FOUNTAIN - HALSEY TAYLOR H-LD BARRIER FREE COOLER, STEEL CABINET, MOSS GRAY COLOR. SHALL DELIVER 6.7 GPH OF 50°F WATER AT 90°F AMBIENT. 120V, 10; 1/5 HP. COMPRESSOR: 4.5 FLA, 350 WATTS. PROVIDE REFRIGERATION UNIT AND MOUNTING HINGE (ALL LEAD FREE PIPING) 1/2" CW, 1-1/2" WASTE, 1-1/4" VENT. HANDICAPPED MOUNTING HEIGHT 35" A.F.F. TO RIM + 28" CLEARANCE BENEATH.




WC

WATER CLOSET - GERBER, AQUA SAVER 21-702 ROUND VITREOUS CHINA, ELONGATED FLOOR OUTLET, SIPHON JET ACTION, TANK TYPE TOILET WITH WHITE, SOLID PLASTIC - KOHLER #KA716 OPEN FRONT SEAT LESS COVER. PROVIDE FLEXIBLE SUPPLY PIPE WITH WHEEL HANDLE STOP. 1/2", 4" WASTE, 2" VENT.

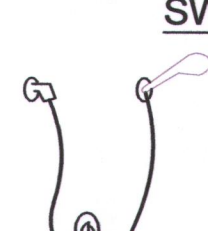


SWR

SHOWER SHALL BE A AKER MAX #141339 PROVIDE WITH DRAIN, MIXING VALVE, FAUCETS, AND "P" TRAP. SHOWER HANDLE, MOEN # TL181, TEMP LIMITOR. VALVE MEON # 62370. SHOWER FLOOR DRAIN - JONES #3D37P BLOT DOWN FLOOR DRAIN AND SHOWER DRAIN., 3" WASTE. PROVIDE WITH SEAT, GRAB BARS. SHALL BE ADA ACCESSIBLE

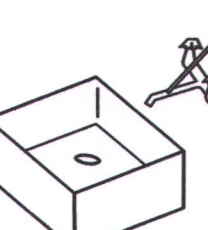


JANITOR SINK - WILLIAMS MODEL MTB-24"24" FLOOR MOUNTED BASIN WITH AMERICAN STANDARD 8341.075 FAUCET WITH VACUUM BREAKER. INCLUDE VINYL BUMPER FOR EXPOSED SIDE & PROVIDE P-TRAP FOR DRAIN. 1/2" H & CW, 3" WASTE, 2" VENT.

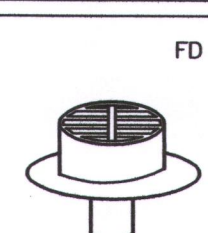


FD

FLOOR DRAIN - JOSAM 32000 CAST IRON, ROUND 7" NIKOLY MEDIUM DUTY LOOSE SET ANTI-TILTING GRATE. SIZE TO SUIT PIPE SIZE AS SHOWN ON DWGS. OR EQUAL.

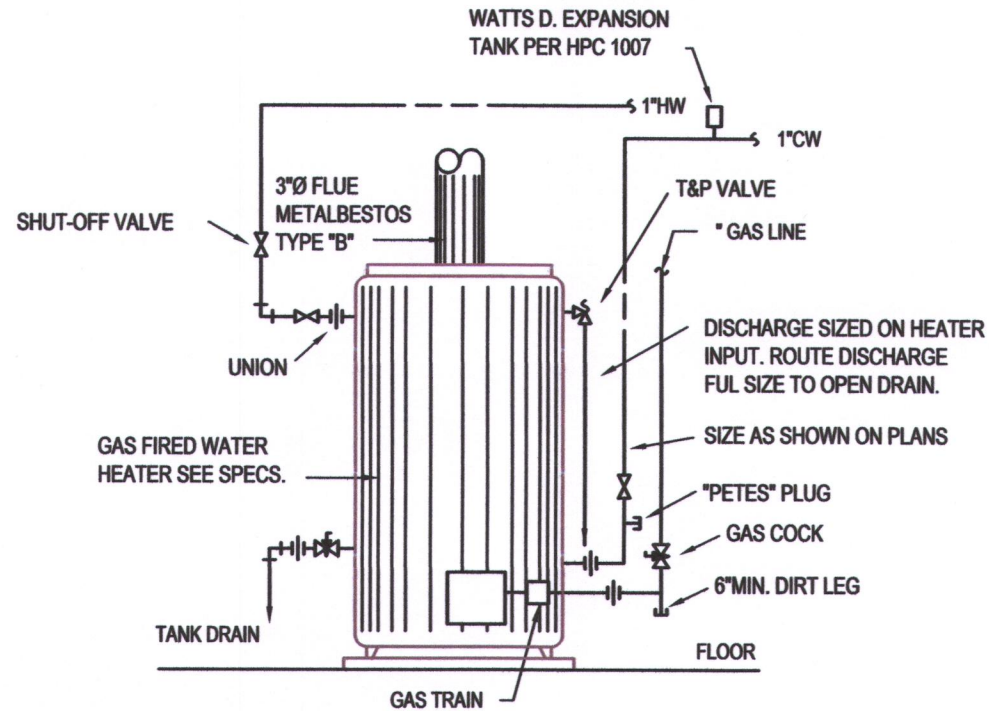

GAS WATER HEATER DETAIL
NO SCALE APPROX. 1000 LBS OPERATING WEIGHT

WATER HEATER A: STATE #PR6 50 NOVET, 50 GALLON, NATURAL GAS-FIRED HEATER REQUIRING 50 CFH NATURAL GAS FOR 27 GPH RECOVER @ 90 RISE. HEATER TO BE FITTED WITH T&P VALVE WITH AGA RATING OF MIN. 10% ABOVE BTU INPUT OF HEATER. VALVES SET FOR 150 PSI @ 210 WATER. THERMO-BOND PROTECTIVE COATED THERMOSTAT TUBE OF LENGTH REQ'D. FOR INSERTION INTO HOTTEST WATER IN TANK. INSTALL VALVE DIRECTLY TO HEATER WITHOUT ELBOWS AND/OR COUPLINGS. EXTEND FULL-SIZE COPPER DRAIN LINE FROM VALVE TO WITHIN 6" OF FLOOR DRAIN. VENT PIPING SHALL BE 4"

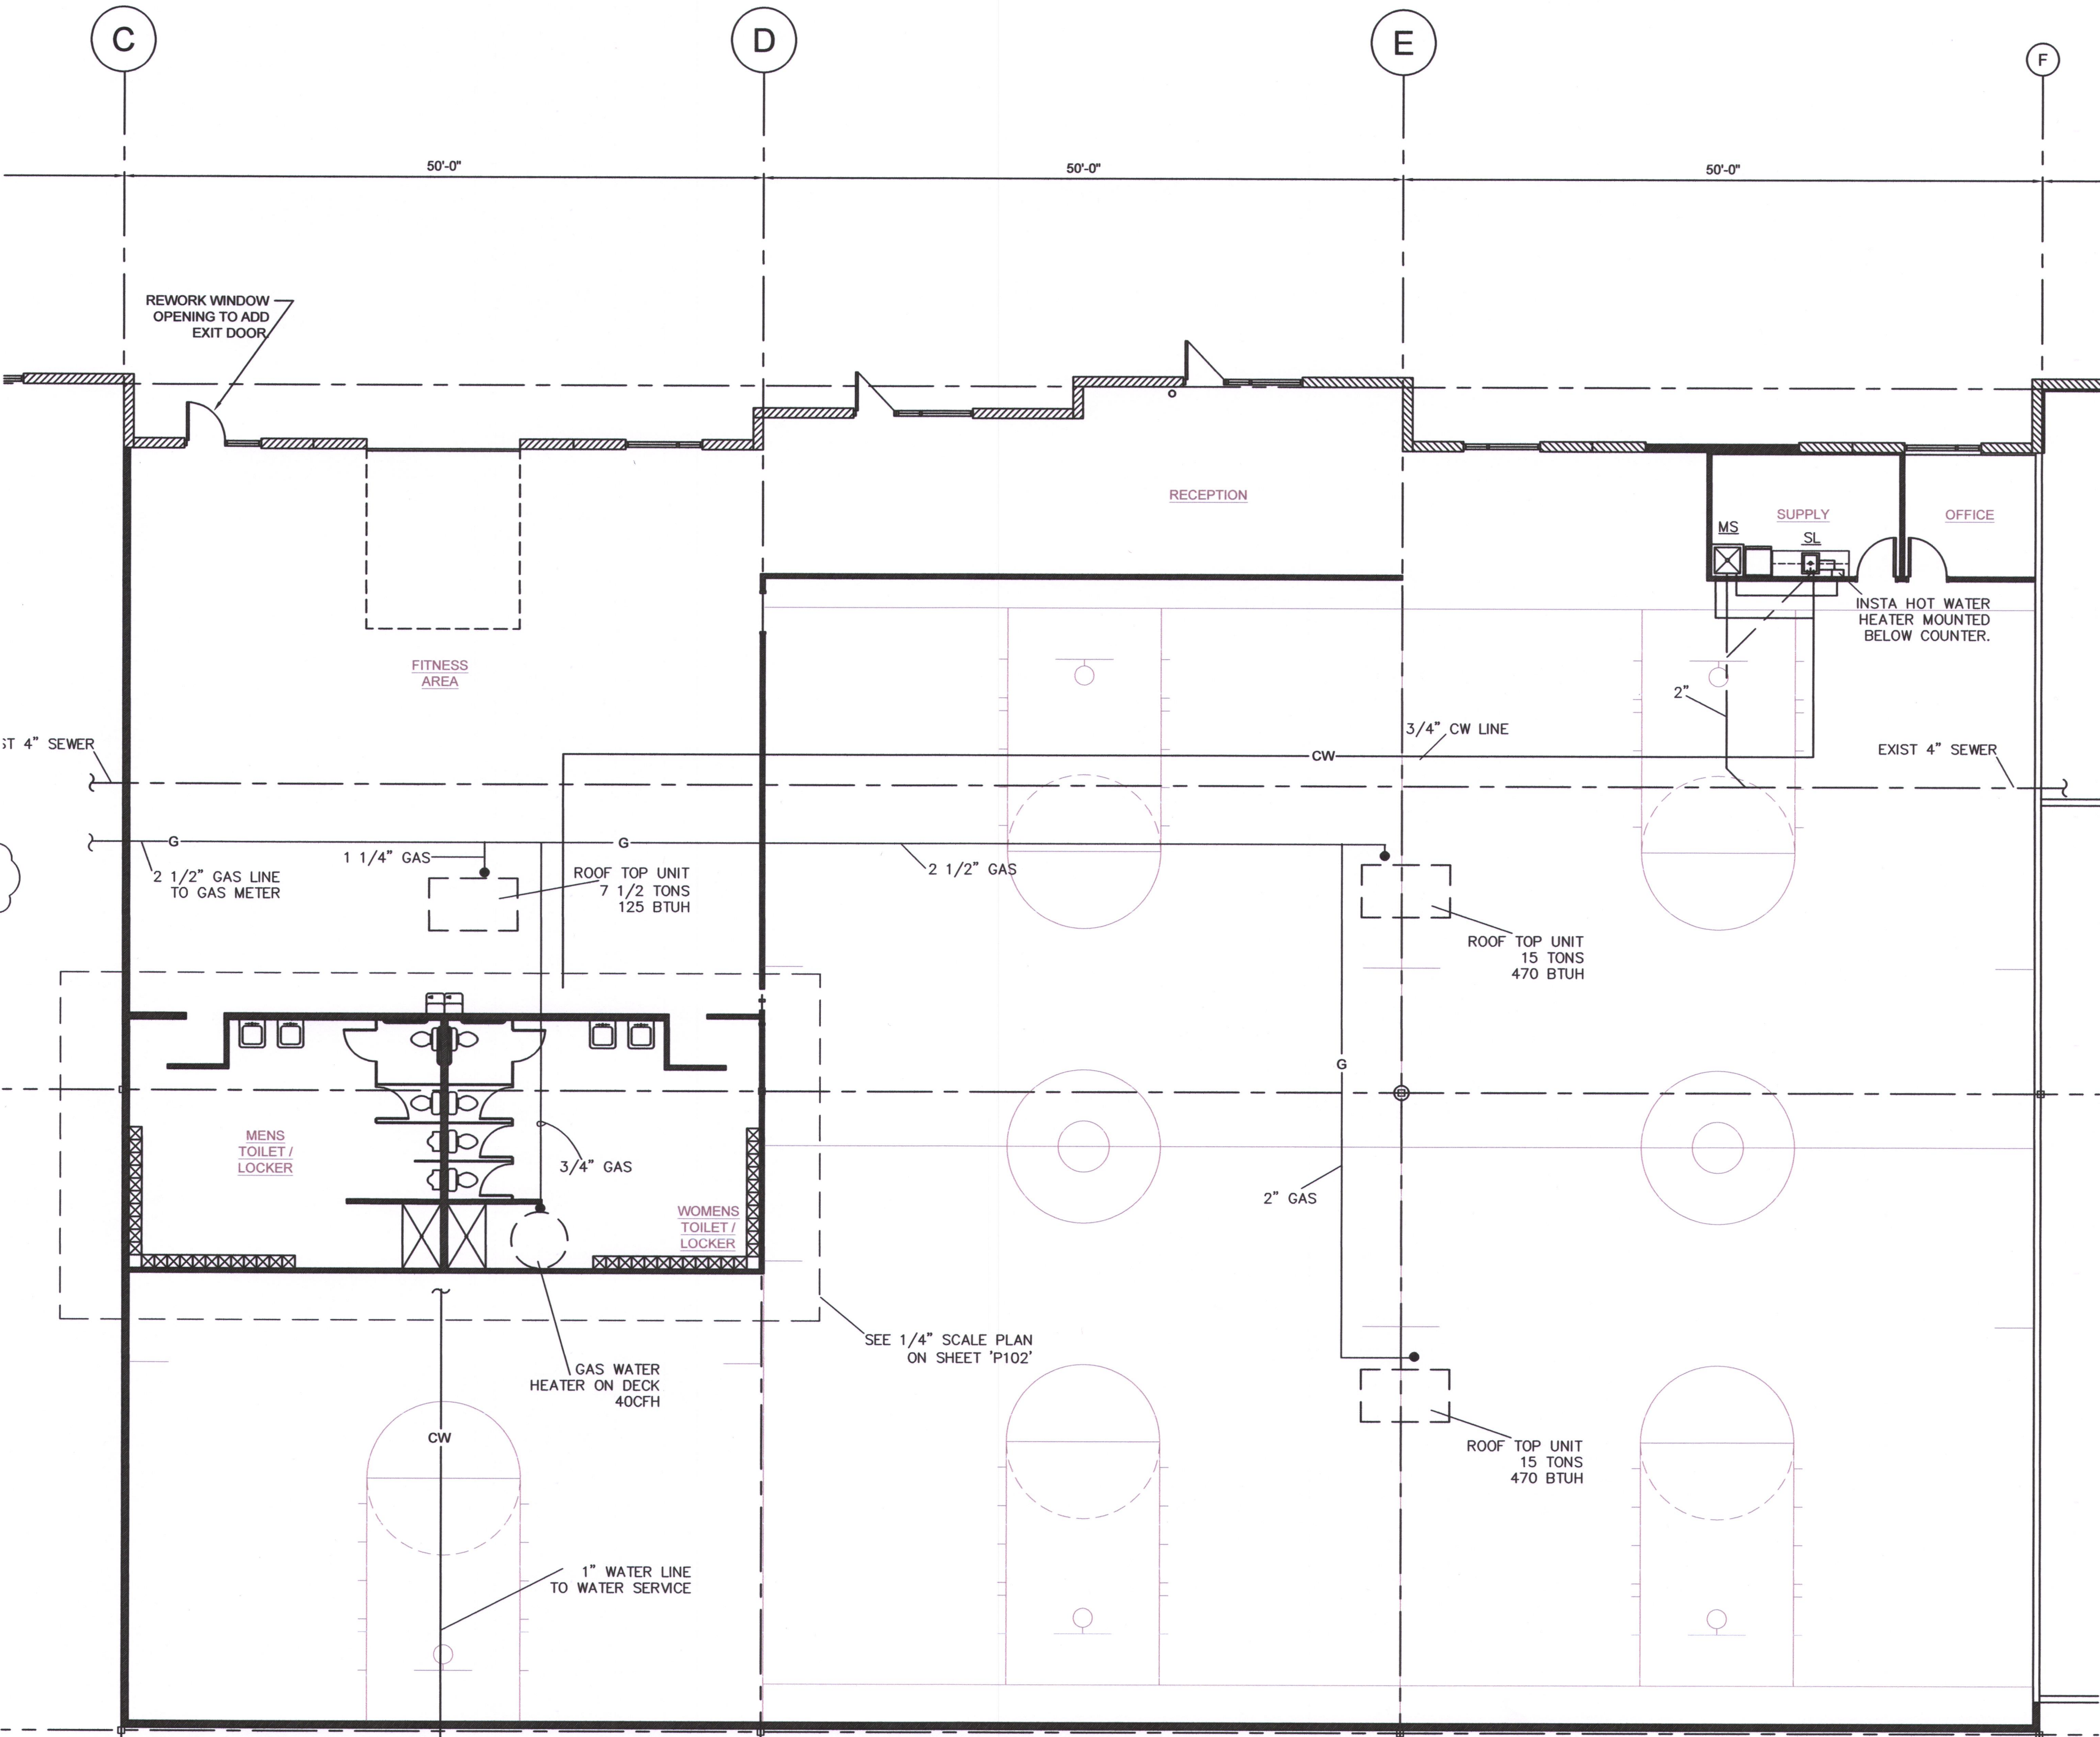

1 Floor Plan
scale: 1/8"=1'-0"



CASBURN CONSULTANTS
Professional Engineering
Mechanical * Electrical * Plumbing
128 SW HILLCREST LANE, LEES SUMMIT, MO 64063
C: (816) 728-6531
E-mail: jwcasburn@att.net

TENANT
INFILL
FOR

PICKUP
USA
FITNESS

AT
2724 NE
McBAINE DRIVE
LEE'S SUMMIT
MISSOURI


DATE: 4/20/2020

REVISIONS:

- △ REV SHOWER
5/17/2020
- △
- △
- △
- △

SBC
ARCHITECTURAL
SERVICES
Robert J. Shirk Jr. - Principal / Project Mgr.

3009 ELMIRA CT.
INDEPENDENCE,
MISSOURI 64057
(816) 797-7115

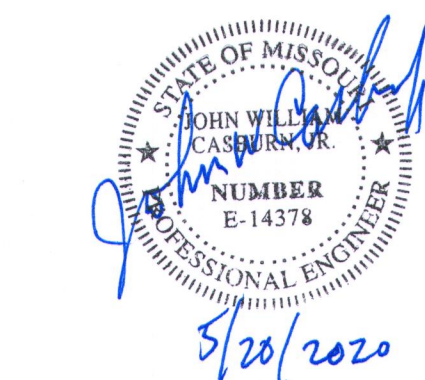

SHEET NO.

P101