

GENERAL NOTES

This plan was designed and drafted BY Advanced Designs Inc. to meet average conditions and codes in the State of Nebraska at the time it was designed. This plan was also designed for Seismic Site Class D. Because codes and requirements can change and may vary from jurisdiction to jurisdiction, cannot warrant compliance with any specific code or regulation. Consult your local building official to determine the suitability of these plans for your specific site and application. This plan can be adapted to your local building codes and requirements, however, it is the responsibility of the purchaser and/or builder of this plan to see that the structure is built in strict compliance with all governing municipal codes (city, county, state and federal). The purchaser and/or builder of this plan releases the designer from any claims or lawsuits that may arise during the construction of this structure or anytime thereafter.

* If the contractor or sub-contractor, in the course of their work finds any discrepancies between the plan and the physical conditions of the site or structure, or any errors in the plans or specifications, it shall be their responsibility to immediately inform ADI, who will promptly verify and if necessary correct the working drawings. Any work done after such discovery will be done at the contractor's expense.

DESIGN LOADS:

Floor: 40 psf, live 15 psf, dead
Roof: 30 psf, live 10 psf, dead
Ceiling: 10 psf, live 5 psf, dead

Soil bearing Capacity - 1500 psf.

Live loads, dead loads, wind loads, snow loads, lateral loads, seismic zoning and any specialty loading conditions will need to be confirmed before construction and adjustments to plans made accordingly. See your local building officials for verification of your specific load data, zoning restrictions and site conditions.

CONCRETE AND FOUNDATIONS:

- All foundation walls and slabs on grade shall be 3000 PSI (28-day compressive strength concrete), unless noted otherwise.
- All interior slabs on grade shall bear on 4" compacted granular fill with 6 mil. polyethylene vapor barrier underneath.
- Provide proper expansion and control joints as per local requirements.
- All 36" x 36" x 18" concrete pade to have (3) #5 rods each way.
- All 48" x 48" x 24" concrete pade to have (4) #5 rods each way.
- Foundation walls are not to be backfilled until properly braced.
- Verify depth of frost footings with your local codes.
- Provide termite protection as required by HUD minimum property standards.
- Foundation bolts must be anchored to sill plate with 5/8" bolts embedded 15" in concrete walls.

STEEL:

- All structural steel for beams and plates shall comply with ASTM specification A-36.
- All structural steel for steel columns shall comply with ASTM specification A-53 Grade B or A-501.
- All reinforcing steel for concrete shall comply with ASTM specification A-615 Grade 60.
- Provide steel shims in all beam pockets.
- Steel columns are to be 3" I.D. (inside diameter) unless noted otherwise.

FRAMING MEMBERS:

- Unless noted otherwise, all framing lumber shall have the following characteristics:
F_b = 1,000 psi F_v = 15 psi E = 1,400,000 psi
- Contractor to confirm the size, spacing and stress characteristics of all framing and structural members to meet your local code requirements.
- Hole sizes and locations in Glulam or Laminated Veneered Lumber (L.V.L.) members are to be confirmed by a professional engineer.
- Any structural or framing members not indicated on the plan are to be sized by contractor.
- Double floor joists under all partition walls, unless noted otherwise.
- All subflooring is assumed to be 3/4" thick, glued & nailed.
- All exterior walls are dimensioned to outside of 1/2" sheathing.
- Calculated dimensions take precedence over scaled dimensions.
- All angled walls on floor plans are at 45 degree angle, unless otherwise noted.
- Laterally unsupported walls 12'-0" high or higher shall be 2x6 and balloon framed unless otherwise noted.
- Unless noted otherwise, above all openings that are:
(1) Load bearing and less than or equal to 3 ft. use 4x6,
(2) Load bearing and more than 3 ft. use (2) 2x12 with 1/2" Plywood between.
(3) Non-load bearing and less than or equal to 6 ft. use 4x6,
(4) Non-load bearing and more than 6 ft. use (2) 2x12 with 1/2" Plywood between.
(5) All exterior openings use (2) 2x12 with 1/2" Plywood between.
- All trusses to be engineered by truss manufacturer according to the loading indicated on this plan.
- All exterior corners shall be braced in each direction with let-in diagonal bracing or plywood.
- Place (1) row of 1" x 3" cross-bridging on all spans over 8'-0" and (2) rows of 1" x 3" cross-bridging on all spans over 16'-0".
- Collar ties are to be spaced 4'-0" o.c.
- All purlins and kickers are to be 2x6's, unless noted otherwise.
- Any hip or valley rafters over a 28'-0" span are to be Laminated Veneer Lumber (L.V.L.).

MISC. NOTES:

- Prefabricated fireplaces and flues are to be U.L. approved and installed as per manufacturer's specifications.
- All materials, supplies and equipment to be installed as per manufacturer's specifications and per local codes and requirements.
- Provide proper insulation for all plumbing.
- 1/2" water-resistant drywall around showers, tubs and whirlpools.
- 1/2" drywall on interior walls and ceilings.
- 5/8" type "X" fire code drywall on garage walls and ceilings.
- When no brand is specified Windows are called out by glass size only.
- Windows, if not noted, are assumed to be casements.
- Header heights are labeled to bottom of arched transoms.
- Confirm window openings for your local egress requirements and minimum light and ventilation requirements.
- Headroom at stairs shall have a minimum clearance of 6'-8" high.
- Provide proper handrails at stairs per local codes.
- The mechanical and electrical layouts are suggested only. Consult your mechanical and electrical contractors for exact specifications, locations and sizes.
- Jog flue to rear of ridge as necessary.
- Provide proper wiring for all electrical appliances, mechanical equipment and whirlpools per manufacturer's specifications.
- Air conditioner locations may vary depending on restrictive covenants and codes.

KH Construction

CONNECT WITH
ADVANCED HOUSE PLANS



advancedhouseplans



NEW PLANS AND EXCLUSIVE
DEALS

advancedhouseplans.com/subscribe

advancedhouseplans

PLAN OF THE WEEK

advanced
houseplans

PRELIM
FINAL
11/2/18
REVISION

KH Construction
4030 SW Benzinger
Lot 14A



IF THIS IS NOT RED
DO NOT COPY

advancedhouseplans

ADVANCED DESIGNS INC. IS A PROFESSIONAL RESIDENTIAL DESIGN FIRM
LOCATED IN NAPA, NE. BECAUSE THE CONDITIONS VARY ADVANCED DESIGNS
CANNOT BE RESPONSIBLE FOR ANY ERRORS OR OMISSIONS THAT MAY OCCUR
DURING CONSTRUCTION FROM THESE PLANS. THESE PLANS SHOULD NOT BE
CONSIDERED A SUBSTITUTE FOR A PROFESSIONAL ENGINEER'S DESIGN.
ADVANCED DESIGNS INC. IS NOT A PROFESSIONAL ENGINEER. IT IS THE
PURCHASER'S RESPONSIBILITY TO OBTAIN ALL NECESSARY PERMITS AND
COMPLY WITH ALL LOCAL, STATE AND FEDERAL REQUIREMENTS PRIOR TO
CONSTRUCTION. ADVANCED DESIGNS INC. IS NOT RESPONSIBLE FOR ANY
DAMAGE OR LOSS THAT MAY OCCUR DURING OR AFTER THE BUILDING PROCESS.

© 2020


29690

SHEET
1
OF
9

20% SCALE # 24"X36"




Approval of this plan is at the developers risk pending approval of #PL2020-171-PRELIMINARY DEVELOPMENT PLAN-Napa Valley subdivision revised residential elevations. Should the #PL2020-171 not be approved the proposed elevations will not be in compliance with the previously approved PDP. Should this occur the proposed elevations will need to be revised.

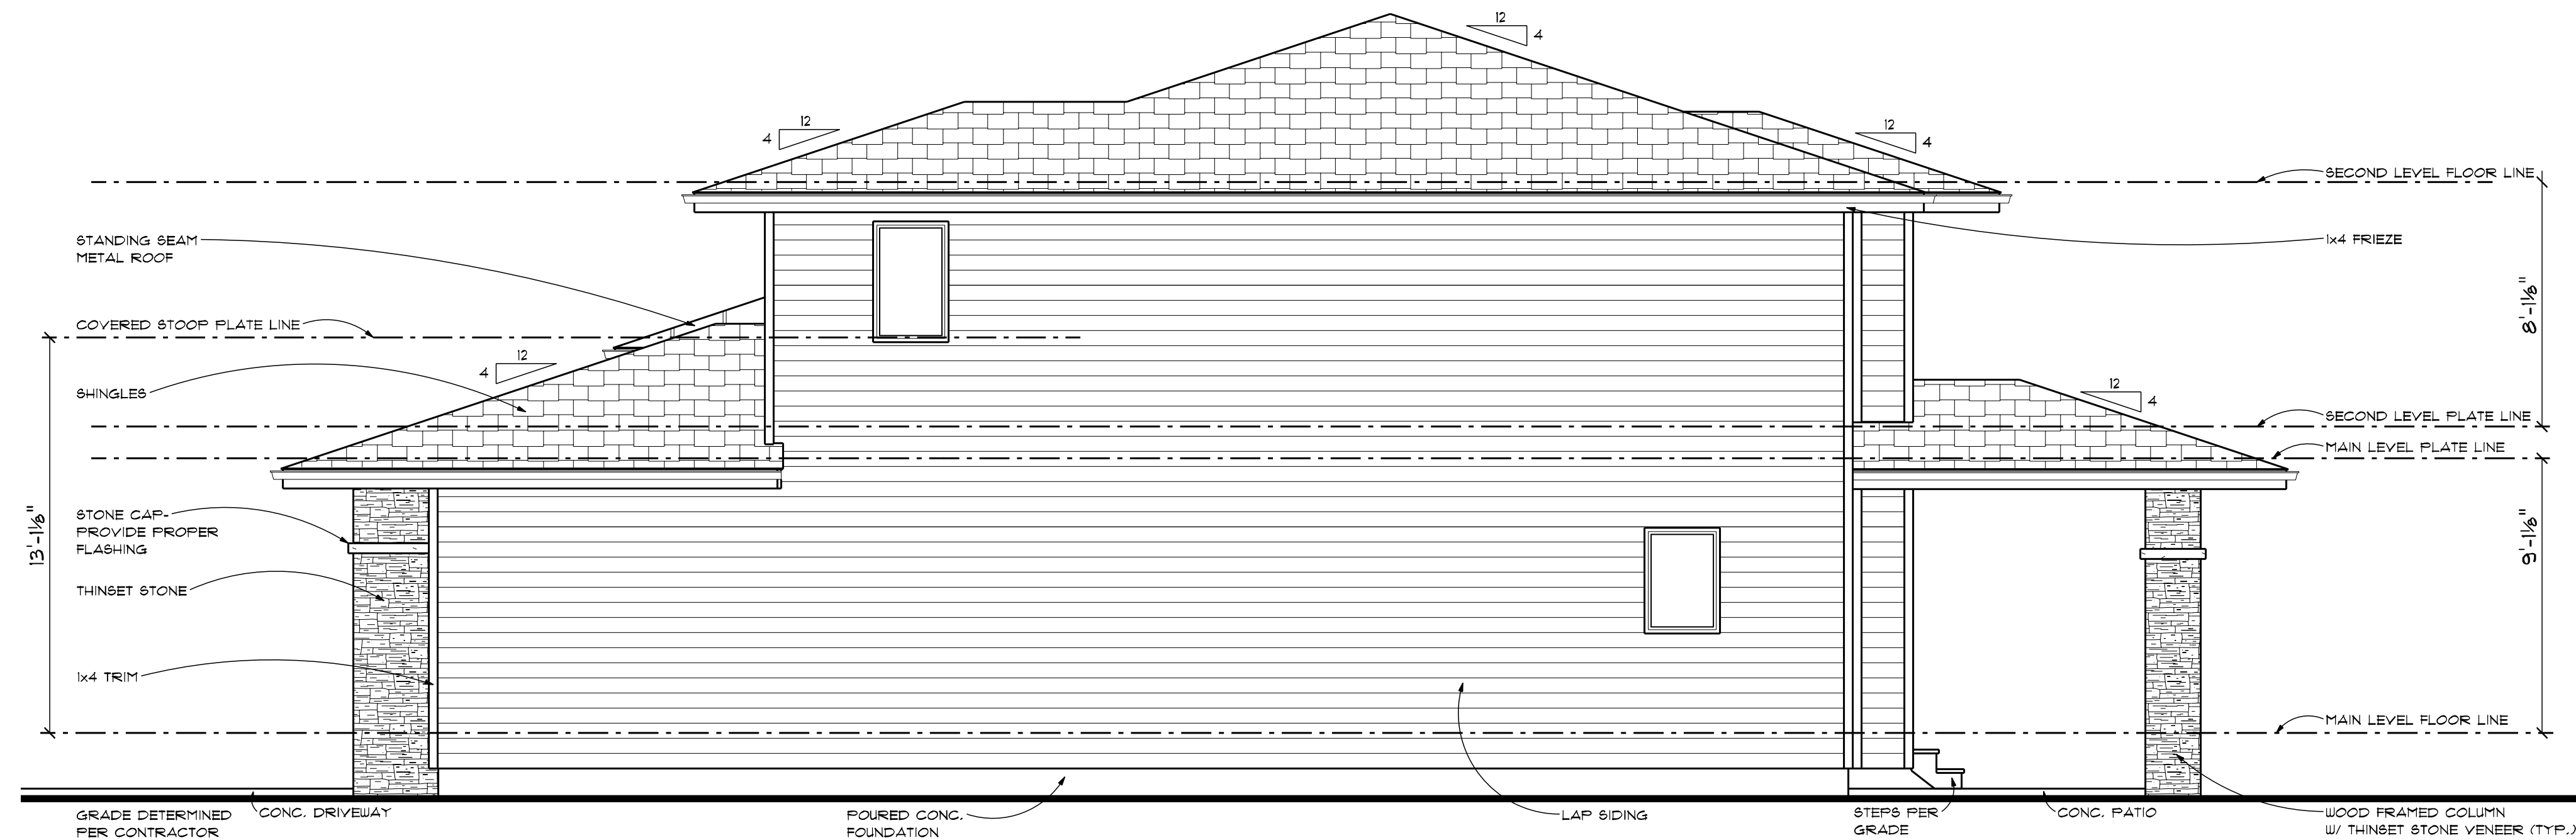


RIGHT ELEVATION

SCALE: 1/4" = 1'-0"

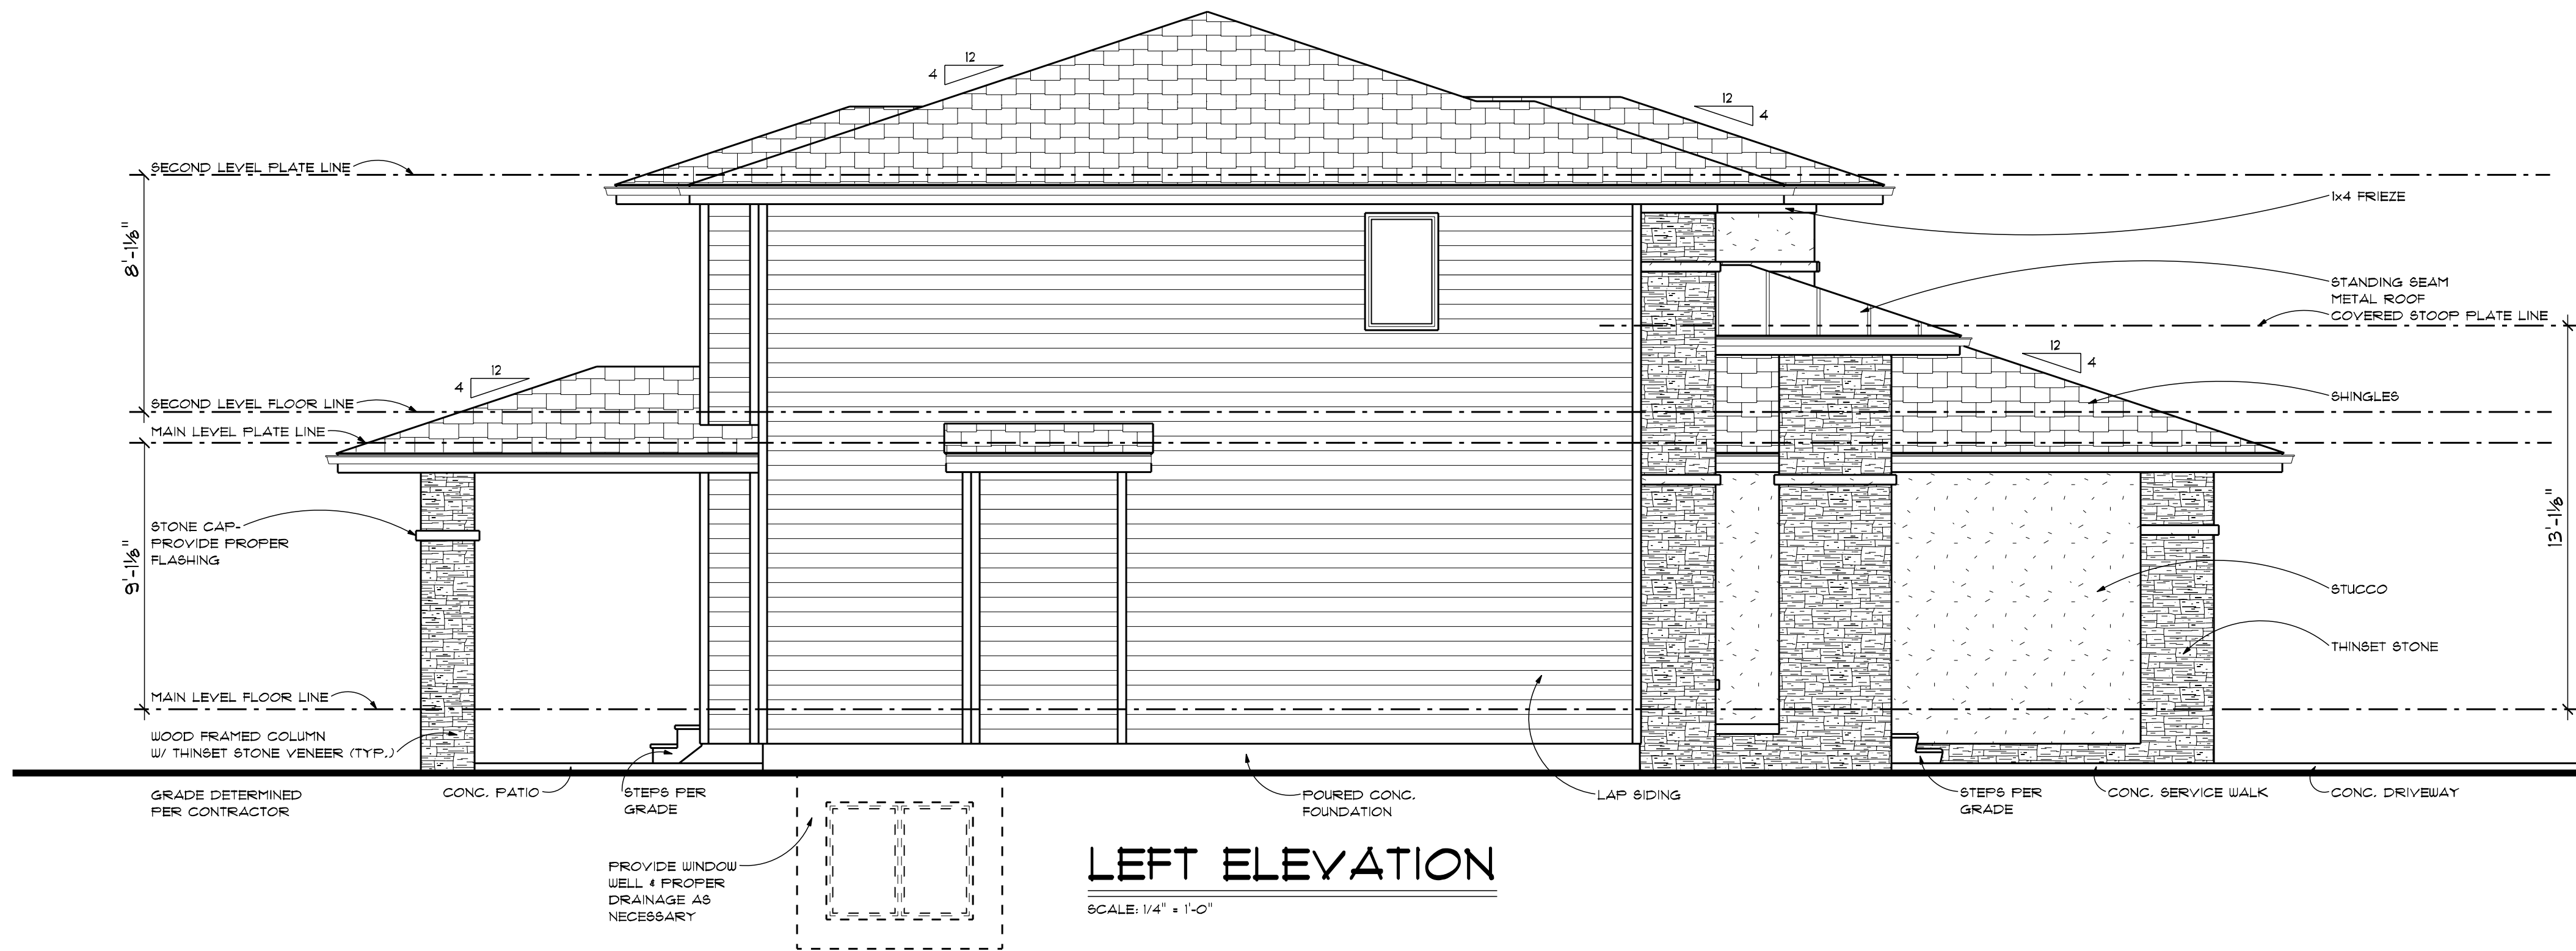

LEFT ELEVATION

SCALE: 1/4" = 1'-0"

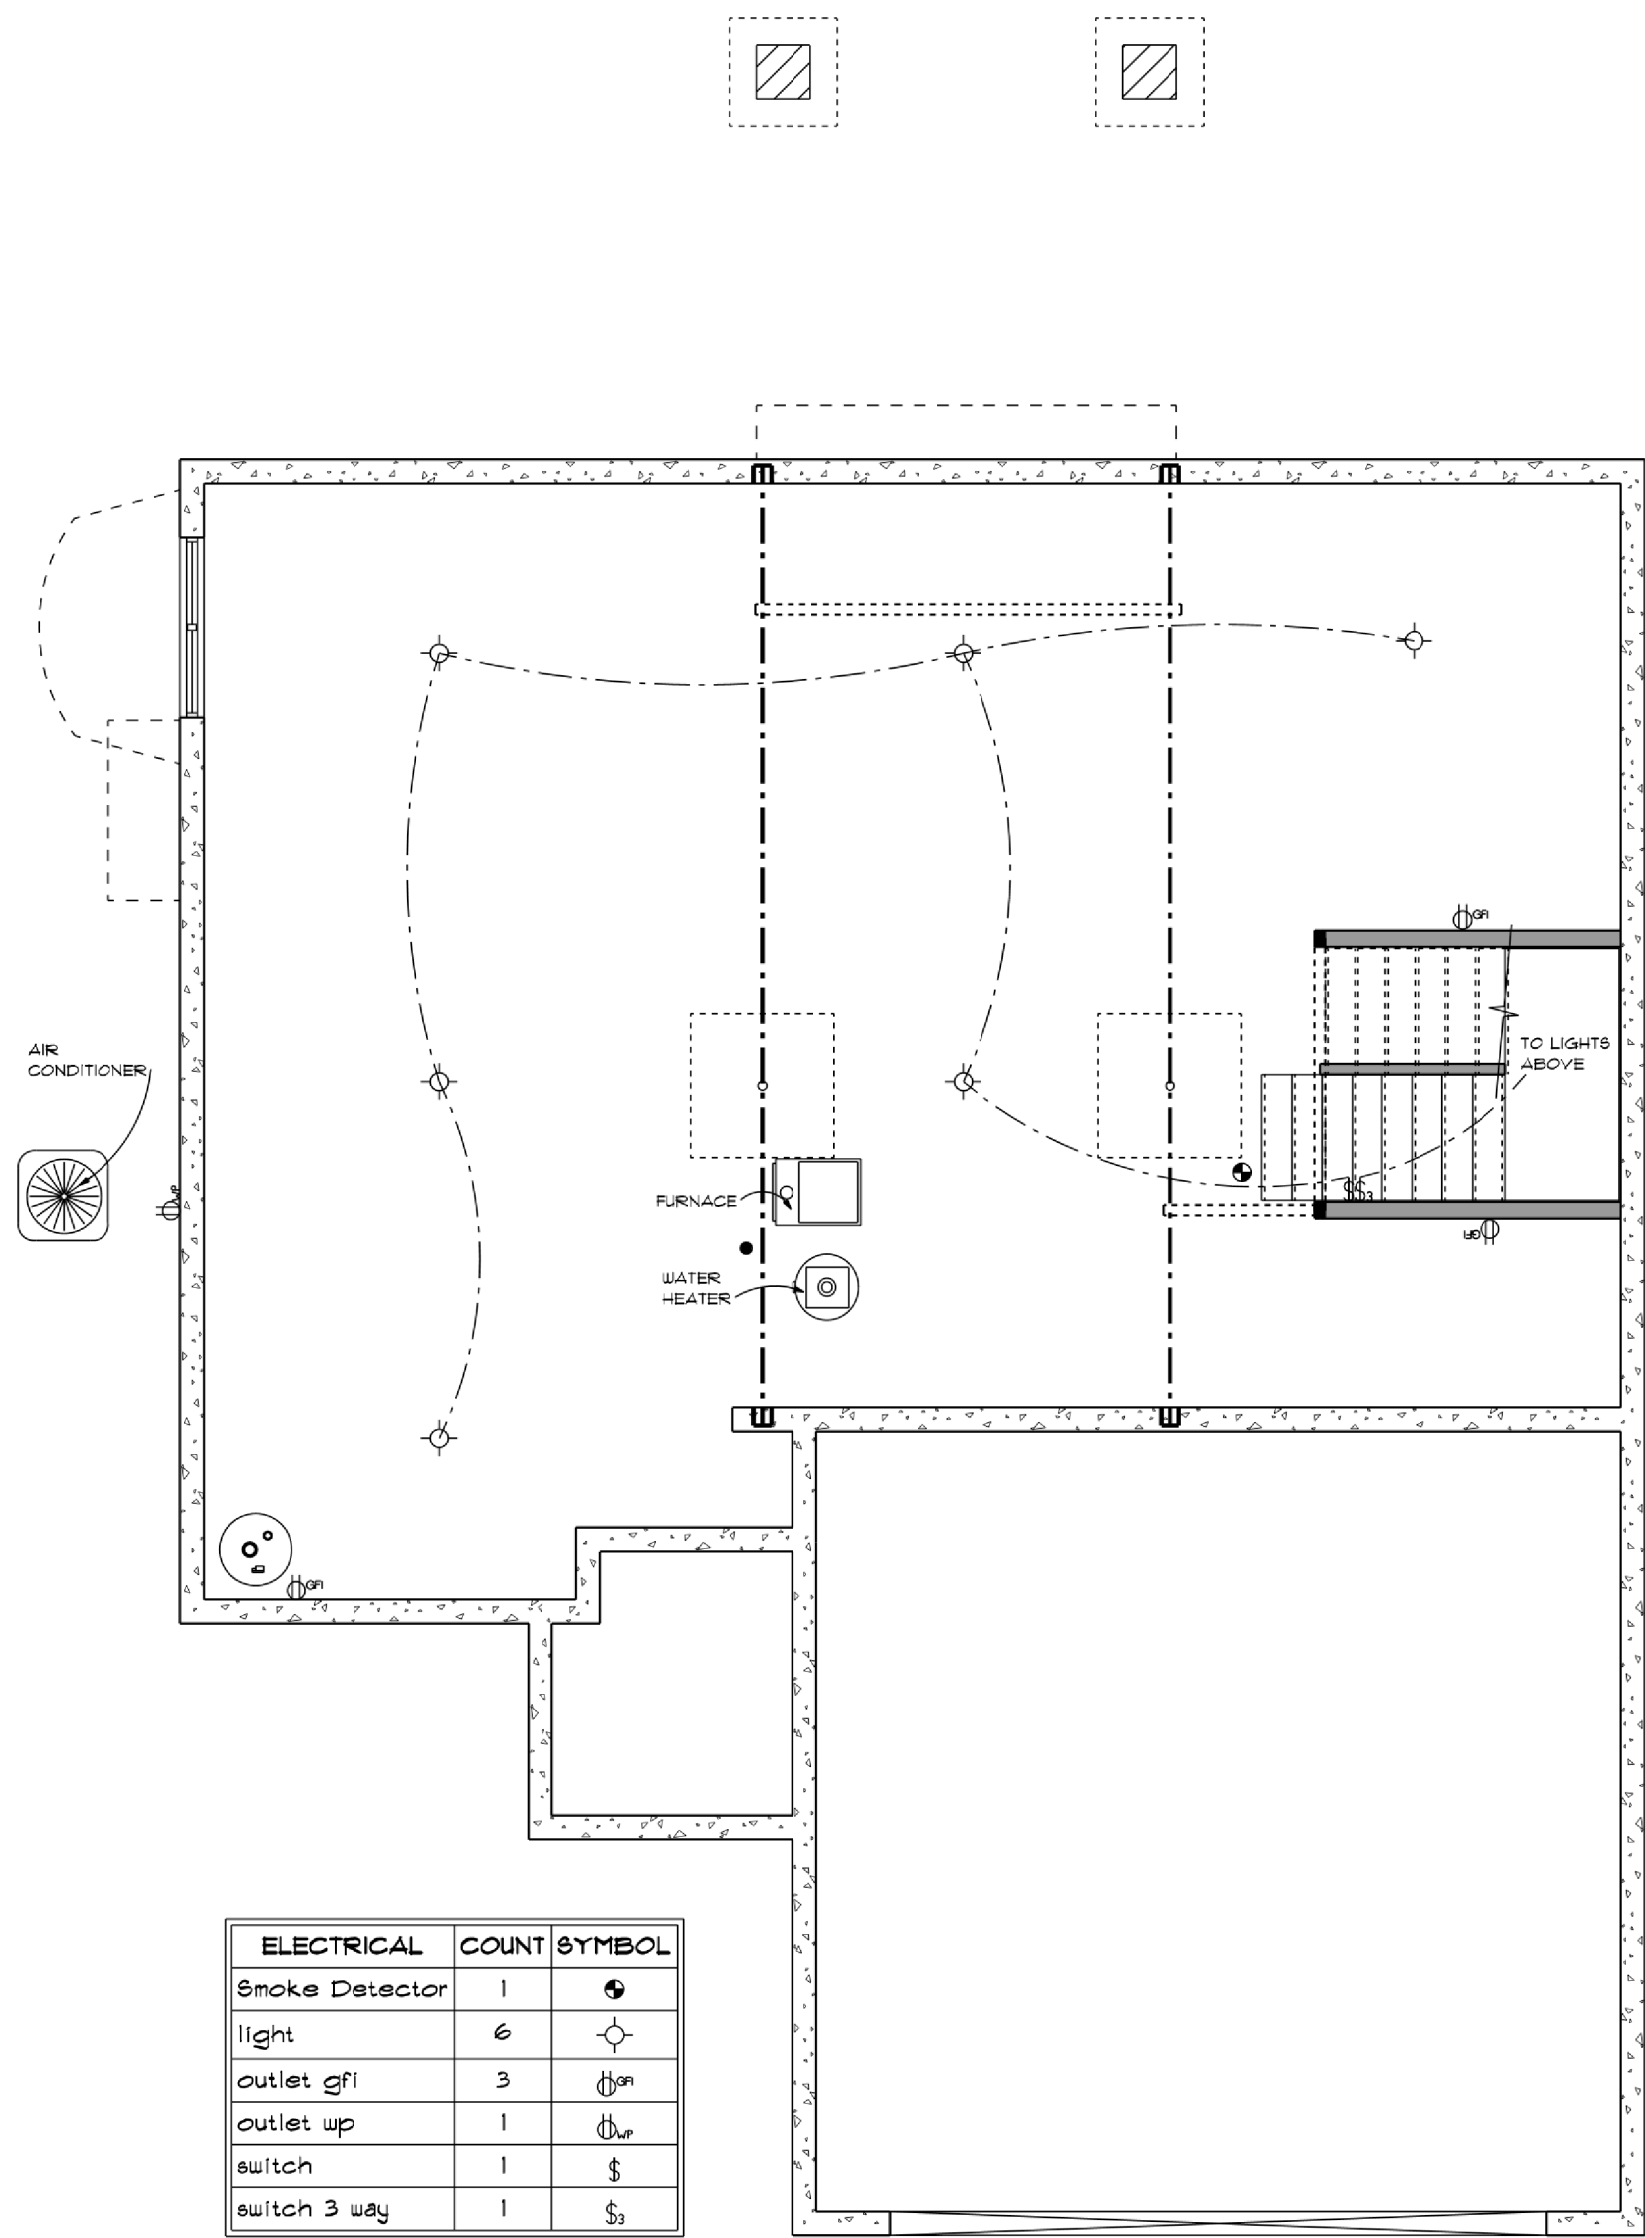


ELECTRICAL	COUNT	SYMBOL
Smoke Detector	1	⬤
light	6	⬢
outlet gfi	3	⬢
outlet wp	1	⬢
switch	1	⬢
switch 3 way	1	⬢

FOUNDATION ELECTRICAL PLAN

SCALE: 3/16"=1'-0"

OPENING SCHEDULE				
OPENING ID	TYPE	PRODUCT CODE	SIZE	COUNT
1	WINDOW	60X48 CASSEMENT 2	5'-0" x 4'-0"	1

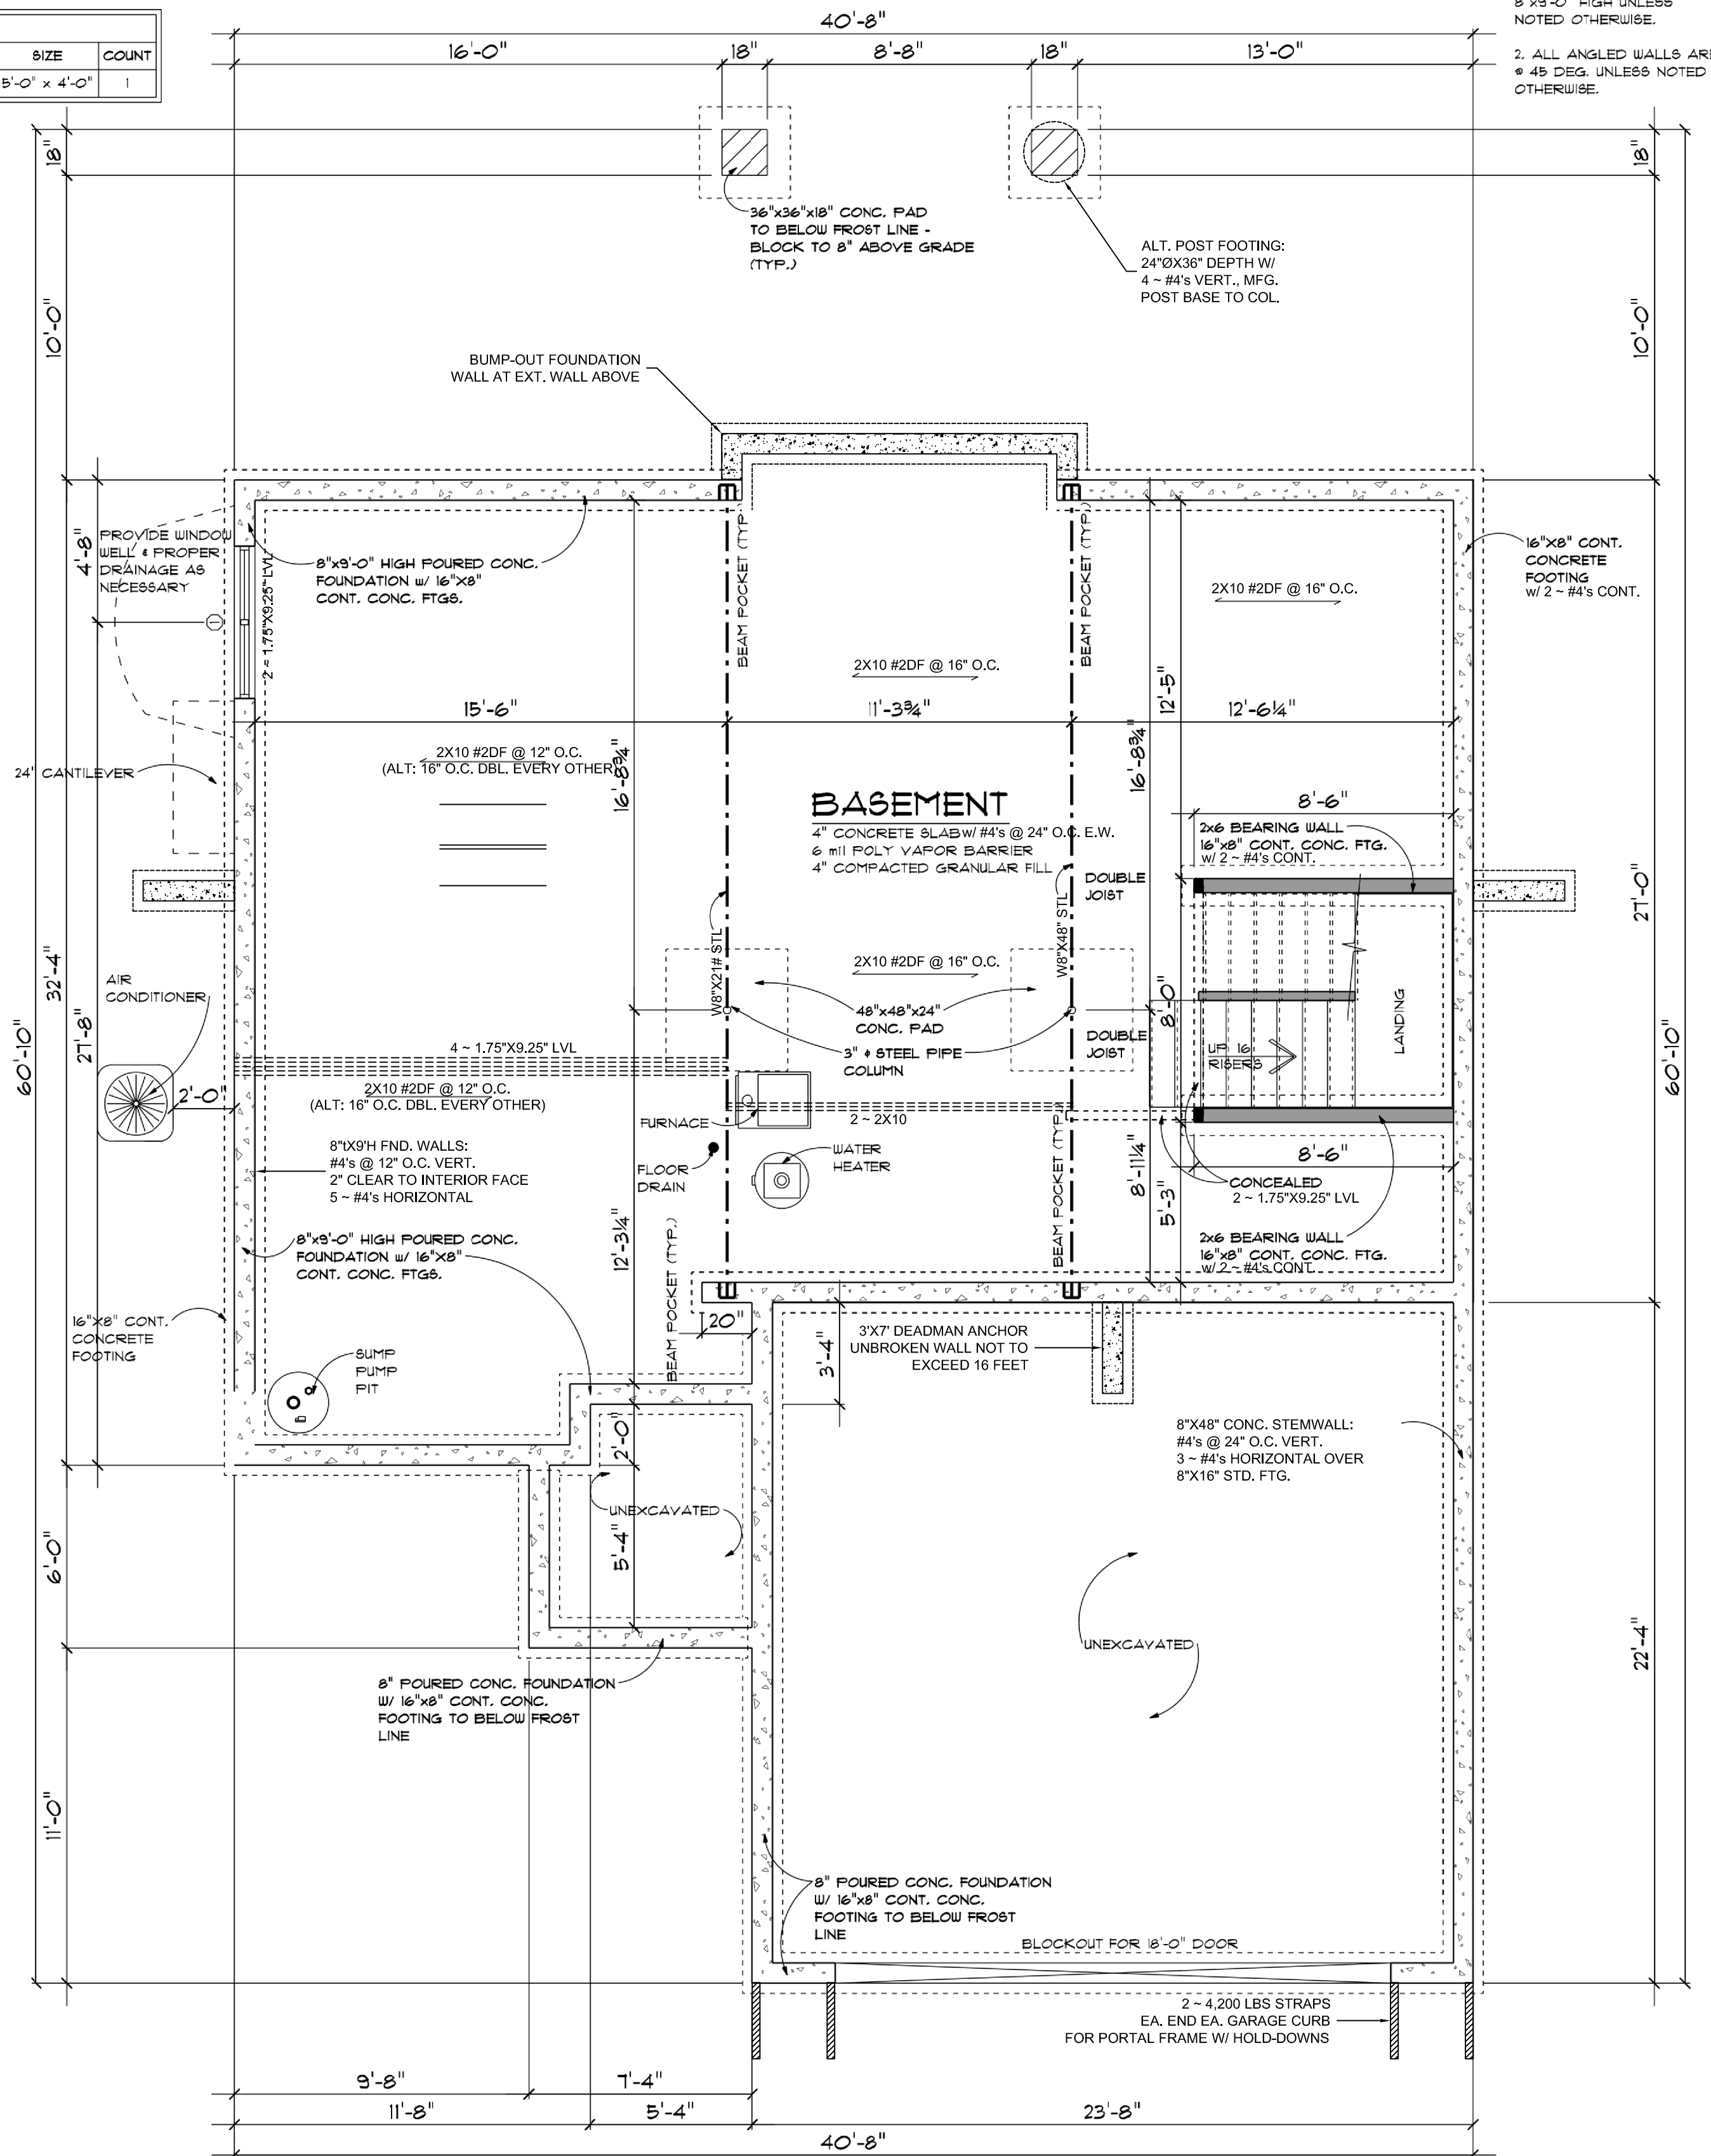

FOUNDATION PLAN

SCALE: 1/4"=1'-0"

STRUCTURAL MEMBER REVIEW AND CERTIFICATION:



RE ENGINEERING, P.C.
CIVIL ENGINEERING CONSULTANTS
1805 WATERS ROAD, HARRISONVILLE, MISSOURI 64701

PH: (816) 380-5150 FAX: (816) 884-3250 EMAIL: MAIL@REENGINEERING.COM
MO. CERTIFICATE OF AUTHORITY #3005002187

AARON D. OBERMILLER, P.E.
REGISTERED PROFESSIONAL ENGINEER

CERTIFICATION IS PROVIDED HEREON FOR STRUCTURAL ITEMS NOT OTHERWISE ADDRESSED IN THE REQUIREMENTS OF THE 2018 INTERNATIONAL RESIDENTIAL CODE. ALL CONSTRUCTION, MATERIALS, FASTENING NOT SPECIFICALLY DENOTED SHALL COMPLY WITH THE REQUIREMENTS OF THE 2018 IRC AND THEREIN REFERENCED STANDARDS. ANY REQUIRED CLARIFICATIONS OR MODIFICATIONS TO STRUCTURAL ITEMS SHALL BE APPROVED BY THE ENGINEER OF RECORD OR OTHER LICENSED PROFESSIONAL CAPABLE OF CERTIFYING COMPLIANCE WITH THE MINIMUM STANDARDS OF THE APPLICABLE CODE.

SCALE: 3/16"=1'-0"

[illegible]

SCALE: 1/4" = 1'-0"

STRUCTURAL MEMBER REVIEW AND CERTIFICATION:



THIS CERTIFICATION IS PROVIDED HEREON FOR STRUCTURAL ITEMS NOT OTHERWISE ADDRESSED IN THE REQUIREMENTS OF THE 2018 INTERNATIONAL RESIDENTIAL CODE. ALL CONSTRUCTION, MATERIALS, FASTENING NOT SPECIFICALLY DENOTED SHALL COMPLY WITH THE REQUIREMENTS OF THE 2018 IRC AND THEREIN REFERENCED STANDARDS. ANY REQUIRED CLARIFICATIONS OR MODIFICATIONS TO STRUCTURAL ITEMS SHALL BE APPROVED BY THE ENGINEER OF RECORD OR OTHER LICENSED PROFESSIONAL CAPABLE OF CERTIFYING COMPLIANCE WITH THE MINIMUM STANDARDS OF THE APPLICABLE CODE.

CIVIL ENGINEERING CONSULTANTS

1805 WATERS ROAD, HARRISONVILLE, MISSOURI 64701

PH: (816) 380 - 5150 FAX: (816) 884 - 3250 EMAIL: MAIL@REOENGINEERING.COM

MO. CERTIFICATE OF AUTHORITY #3005002187

PRELIM

FINAL

REVISIO

KH Construction
4030 SW Benzinger
Lot 14A



advancedhouseplans

ADVANCED DESIGNING INC. IS A PROFESSIONAL, RESIDENTIAL DESIGN FIRM LOCATED IN OHAMA, NE. BECAUSE SITE CONDITIONS, ADVANCED DESIGNING CANNOT WARRANT THE SUITABILITY OF THESE PLANS FOR USE ON YOUR SPECIFIC SITE. CONSTRUCTION FROM THESE PLANS SHOULD NOT BE UNDERTAKEN WITHOUT THE ASSISTANCE OF A CONSTRUCTION PROFESSIONAL, HOMEOWNER/CONTRACTOR MUST OBTAIN ALL NECESSARY PERMITS AND FOLLOW ALL APPLICABLE STRUCTURAL CODE REQUIREMENTS PRIOR TO CONSTRUCTION. ANY RELEASE OF LIABILITY FROM ANY LAISSEZ PASSE THAT MAY OCCUR DURING OR AFTER THE BUILDING PROCESS.

© 2020

29690

SHEET

—

5
OF
8

The purchaser of these plans is given the limited license to reproduce these plans for construction purposes only and further distribution is illegal. Do not scale prints - see dimensions.
www.AdvancedHousePlans.com 402-445-0489

SCALE: 3/16"=1'-0"


2. ALL ANGLED WALLS ARE @ 45 DEG. UNLESS NOTED OTHERWISE

3. ALL EXTERIOR WALLS ARE 4" (3 1/2" STUD/1/2" SHEATHING) & ALL INTERIOR WALLS ARE 3 1/2" UNLESS NOTED OTHERWISE

SECOND LEVEL 1040 sq. ft.


MAIN FLOOR BUILDING LINE

SCALE: 1/4"=1'-0"

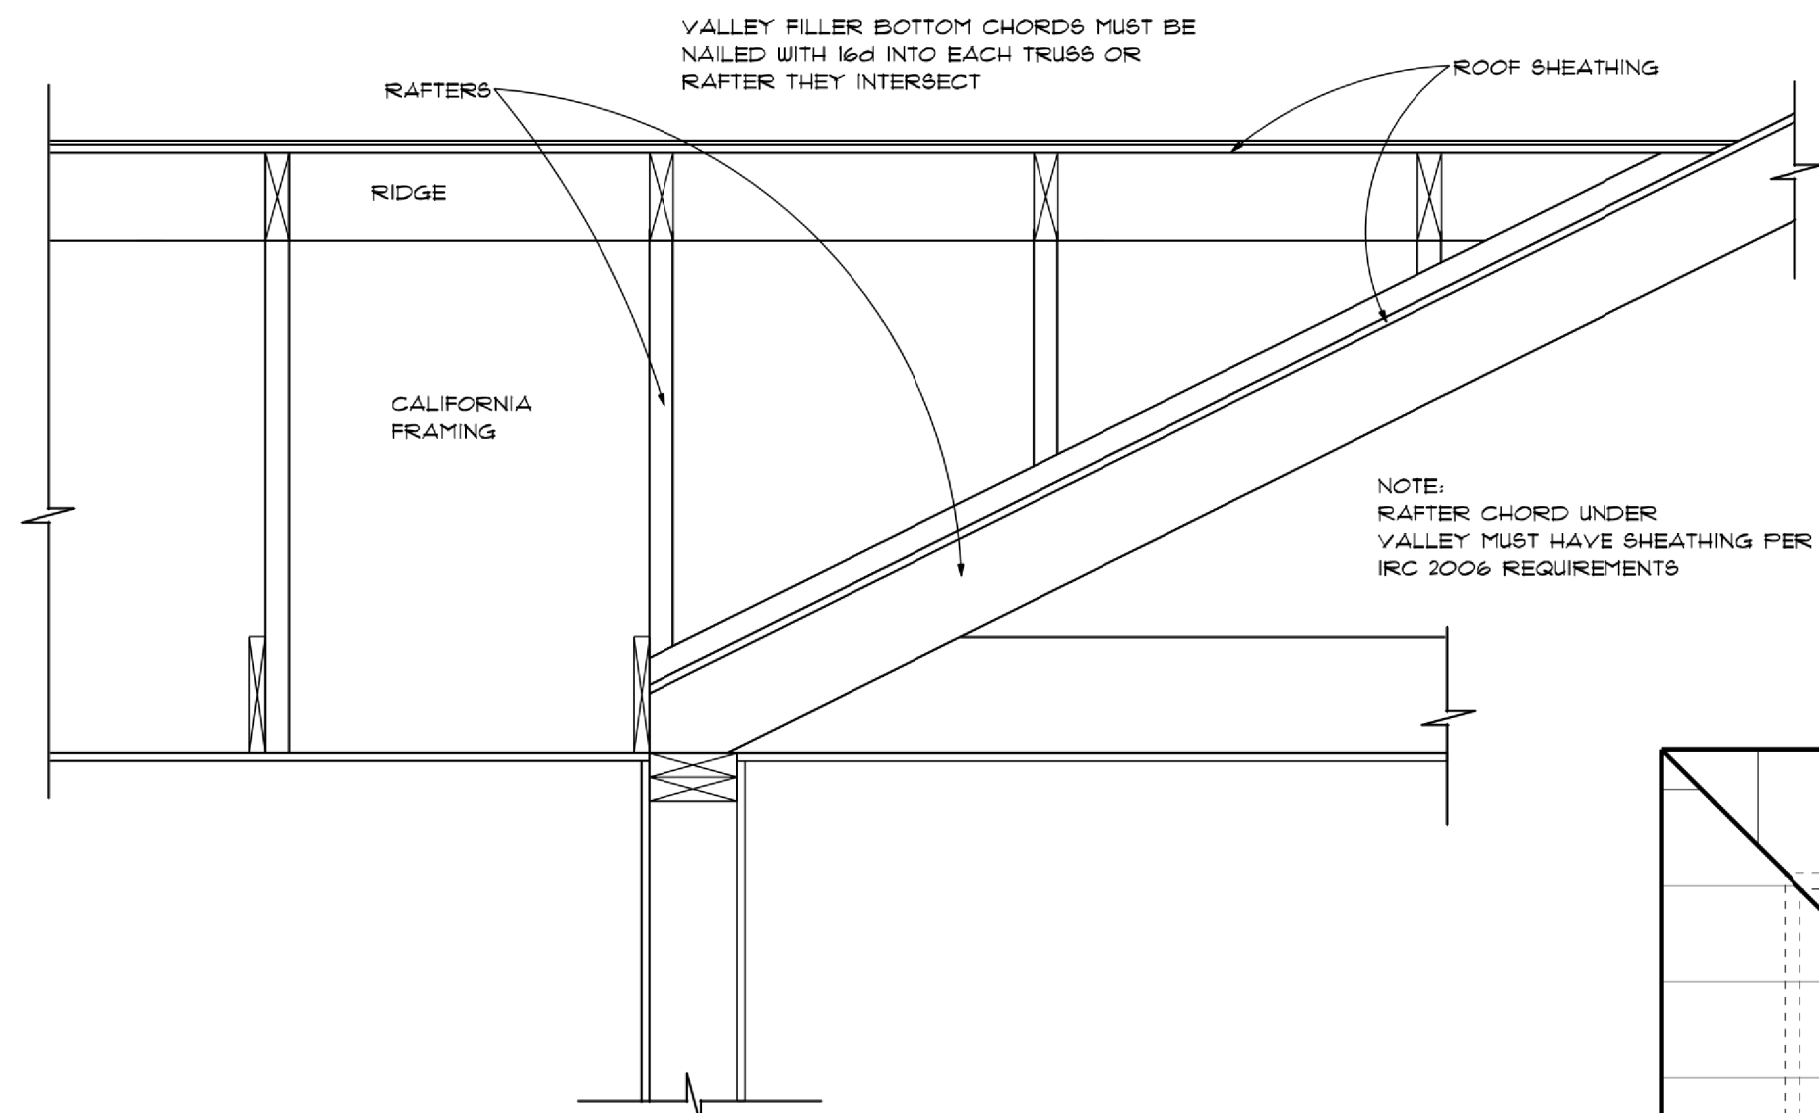


ROOF OVERFRAMING

SCALE: 1/4"=0"

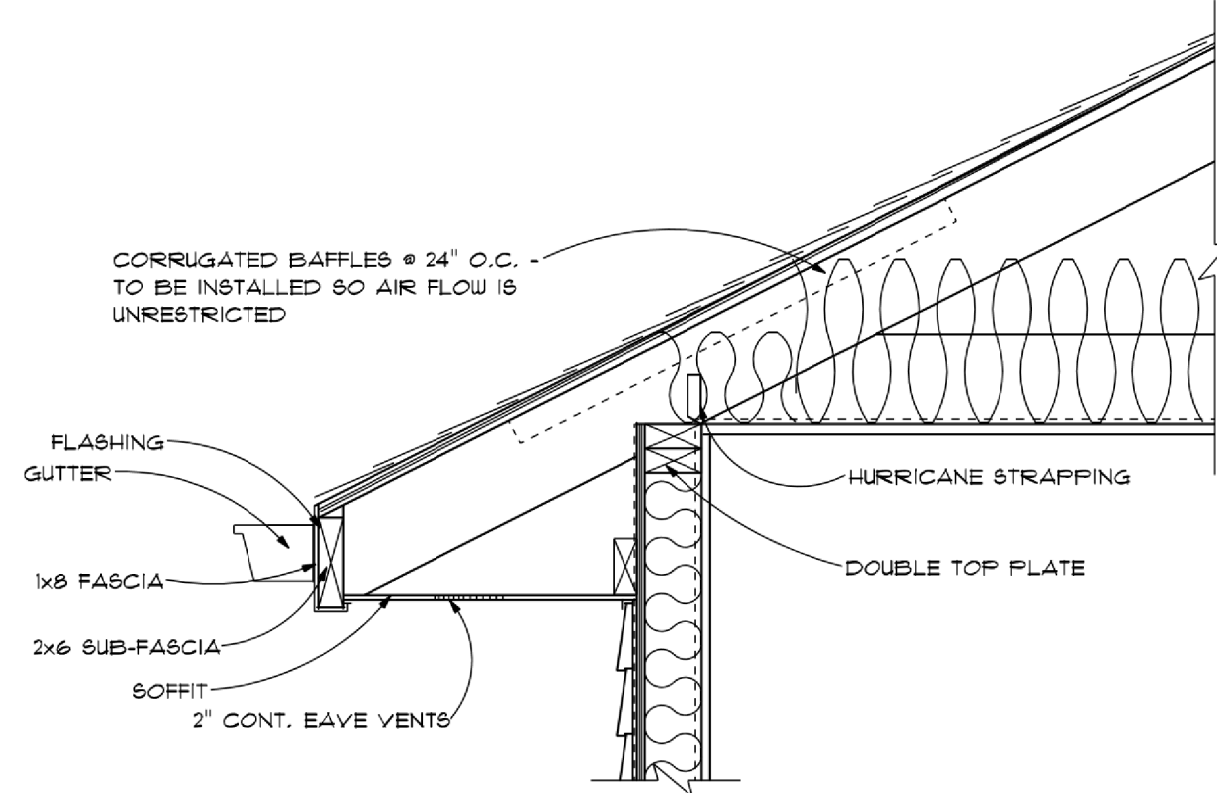


EAVE VENT

SCALE: 1/4"=0"

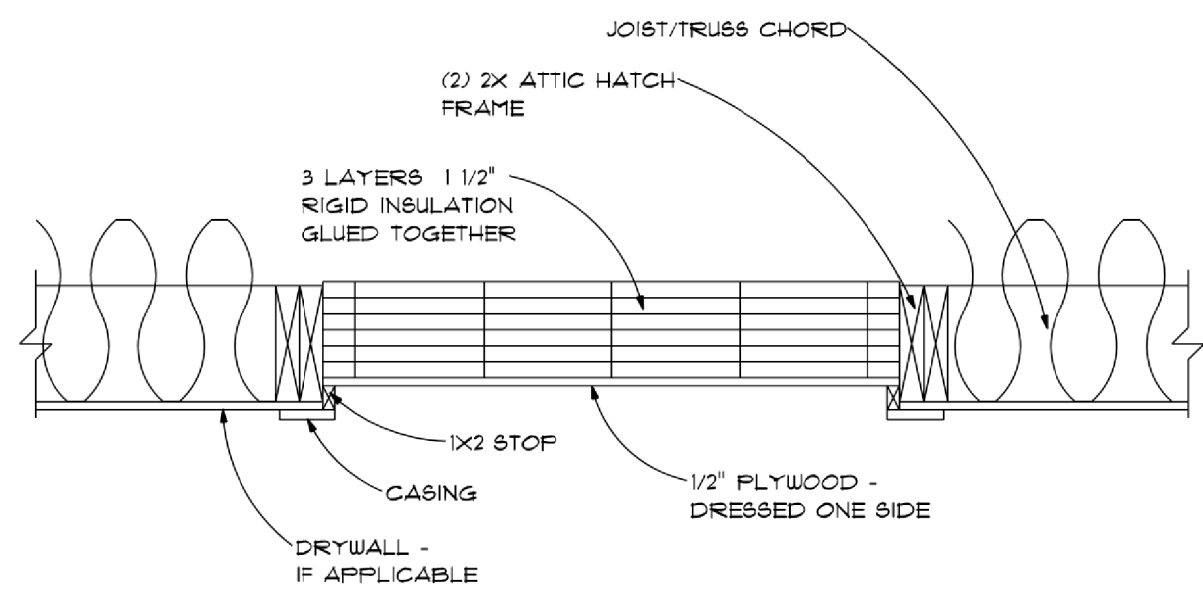


ATTIC HATCH

SCALE: 1/4"=0"

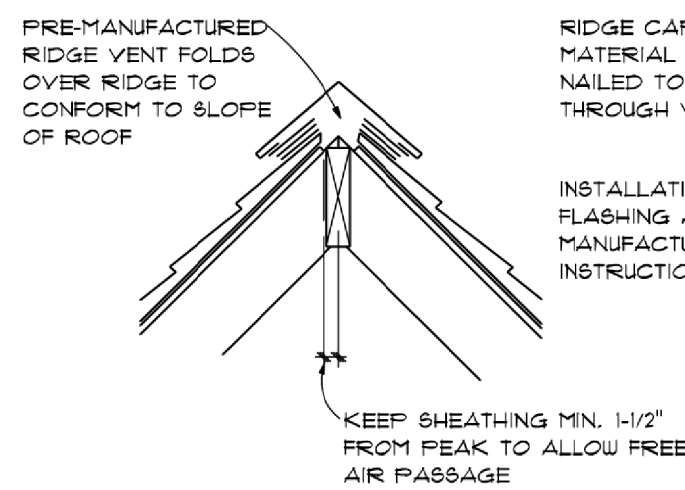

RIDGE VENT

SCALE: 1/4"=0"

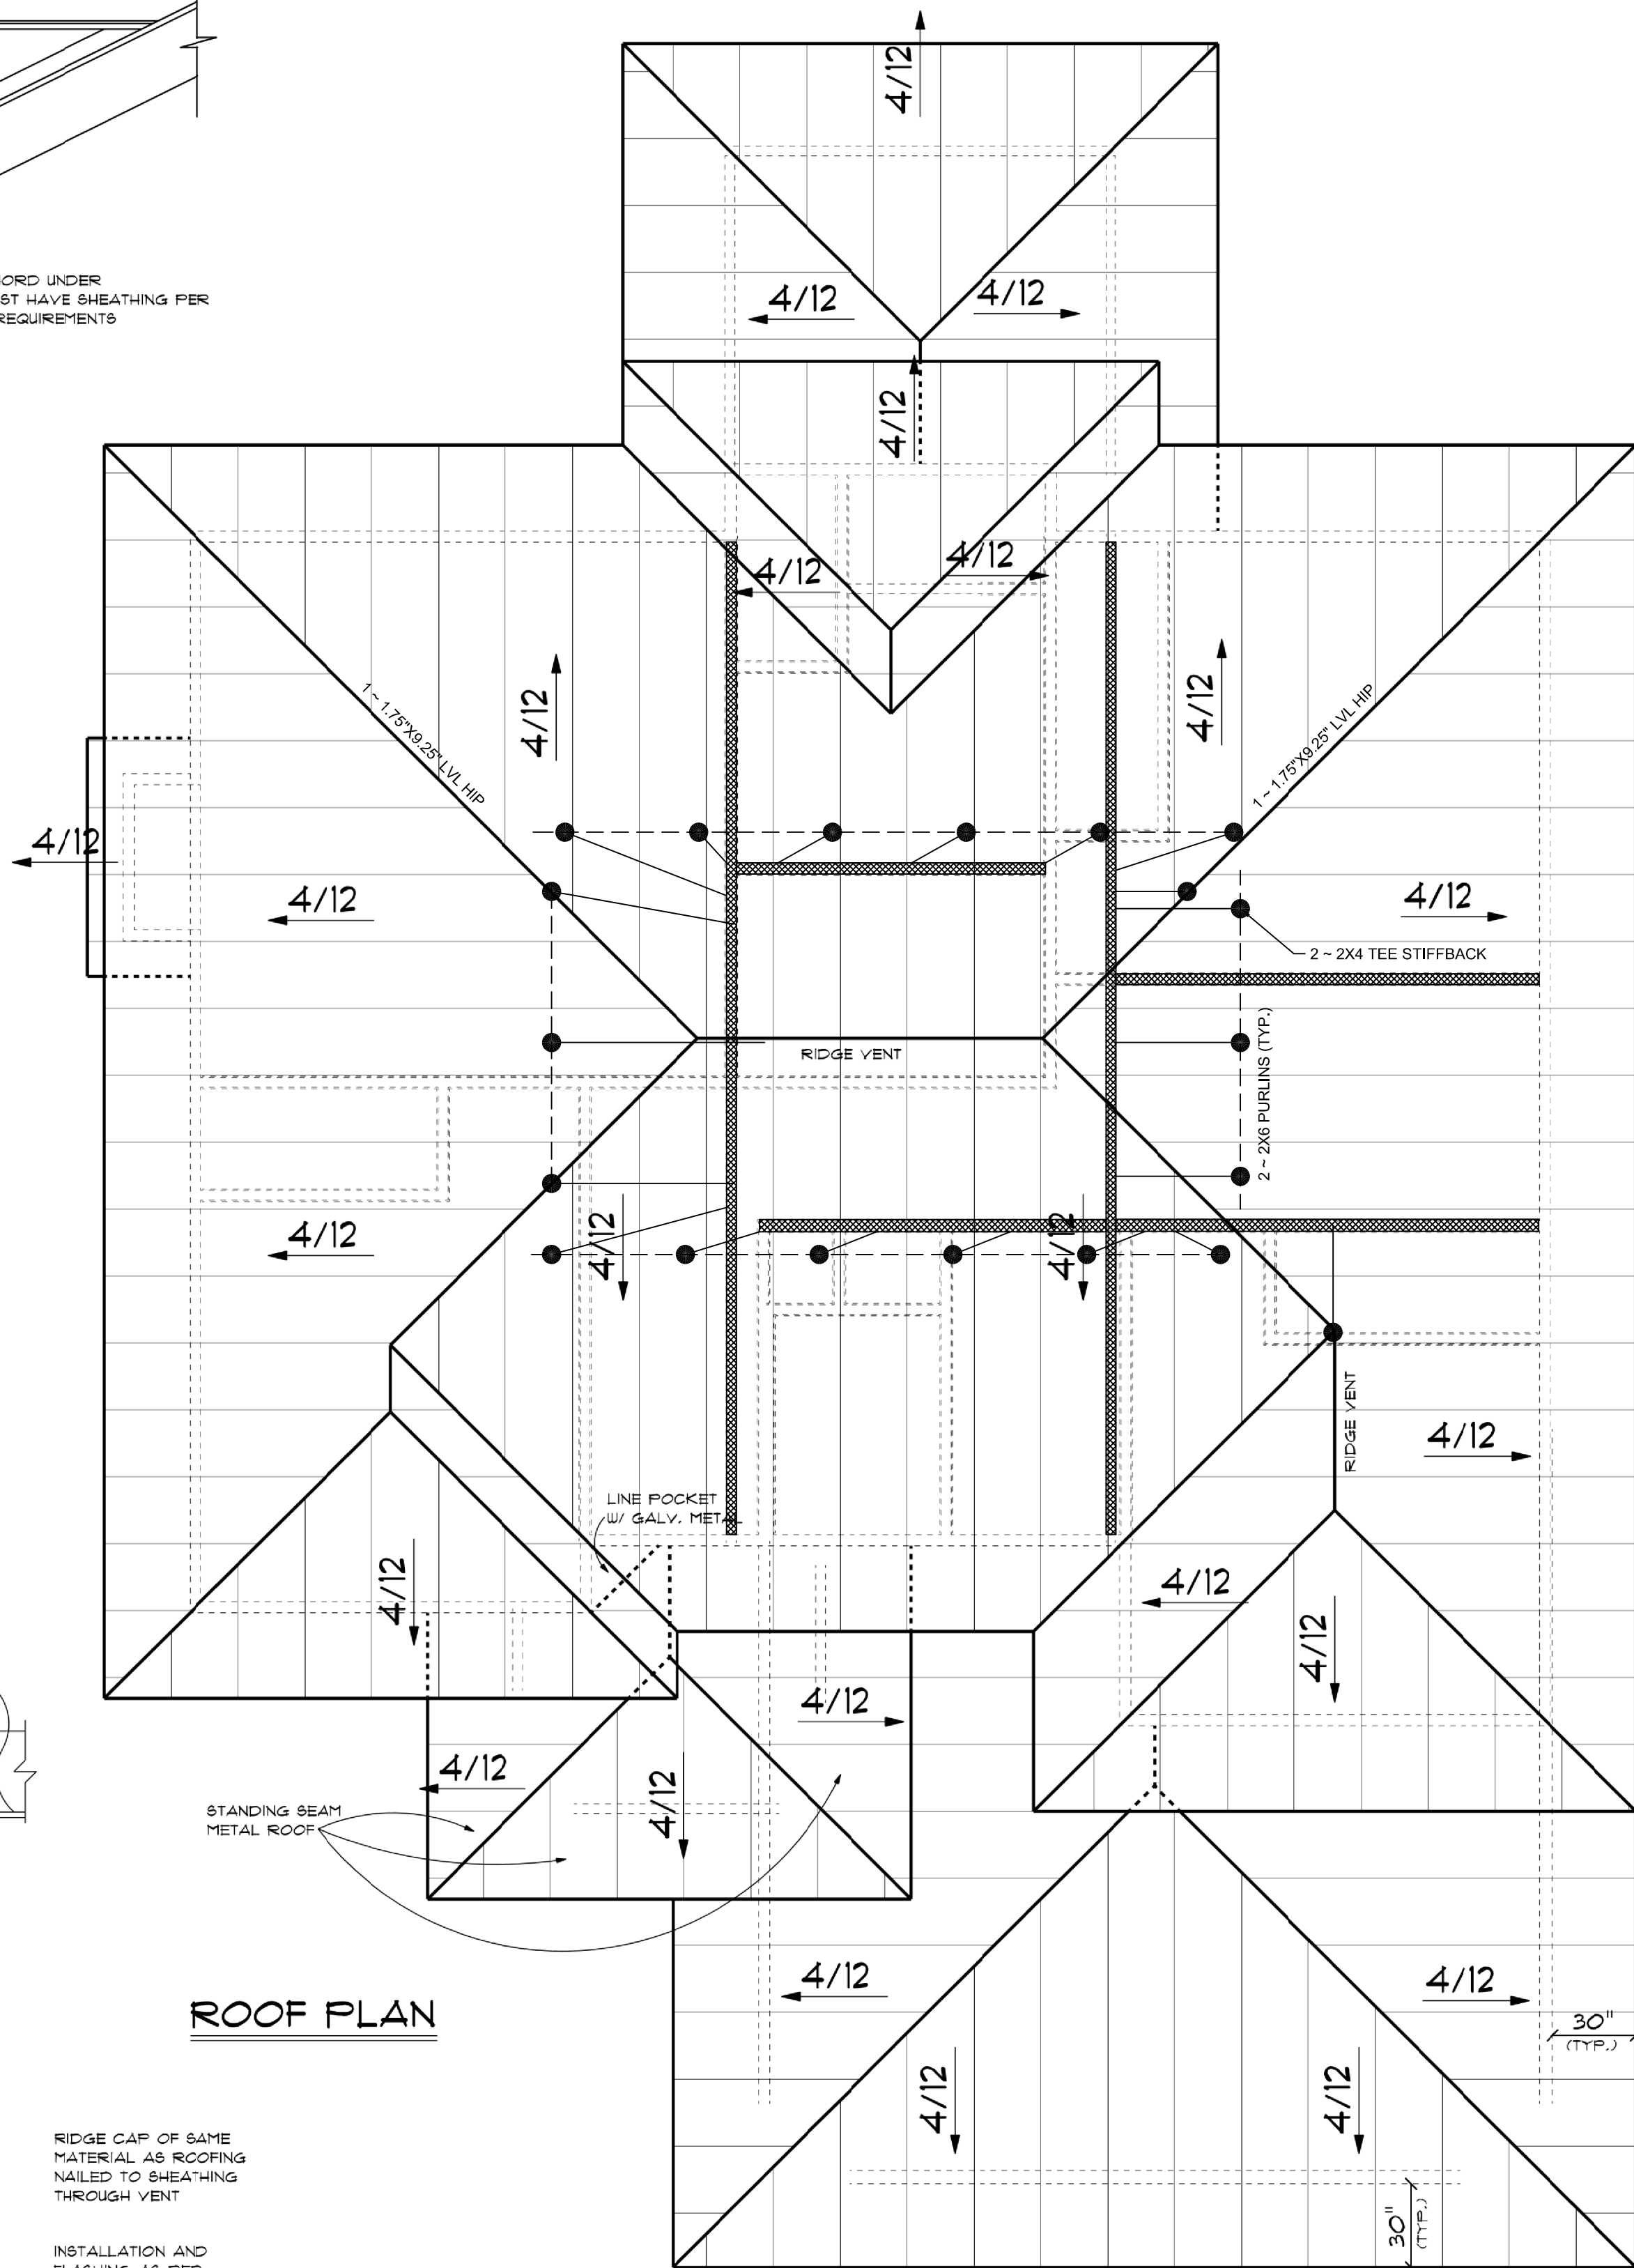

ROOF PLAN

- GENERAL ROOF NOTES:
- HIP RIDGE FOR ROOF:
 - 2X8 FOR UNBRACED LENGTH UP TO 9'-0"
 - 2X10 FOR UNBRACED LENGTH UP TO 10'-0"
 - 2X12 FOR UNBRACED LENGTH UP TO 11'-0"
 - GREATER SPANS REQUIRE ENGINEER DESIGN
 - ALL RAFTERS 2X6 #2DF OR AS NOTED
 - ALL RIDGE MEMBERS TO BE LARGER THAN VERT. FACE-CUT OF RAFTER
 - COLLAR TIES THROUGHOUT AT 48" O.C.
 - ROOF LOADING: 20PSF LL / 10 PSF DL
 - HEEL JOINT CONNECTIONS PER 802.3.1 OR 4-16d MIN.
 - PER 802.11.1 ROOF ASSEMBLIES SHALL HAVE UPLIFT RESISTANCE IN ACCORDANCE WITH SECTION R802.11.1 AND R802.11.2. TIES, TIEDOWNS, ANCHORS OR SCREWS MANUFACTURED SPECIFICALLY TO RESIST UPLIFT, AS INDICATED IN THE MANUFACTURER'S LISTINGS, LITERATURE, OR SPECIFICATIONS. MINIMUM 48 INCHES ON CENTER, IS REQUIRED.

STRUCTURAL MEMBER REVIEW AND CERTIFICATION:






AARON D. OBERMILLER, P.E.
MO-2008019580 / 01-25-20

RE ENGINEERING, P.C.
CIVIL ENGINEERING CONSULTANTS

1805 WATERS ROAD, HARRISONVILLE, MISSOURI 64701
PH: (816) 380 - 5150 FAX: (816) 884 - 3250 EMAIL: MAIL@REENGINEERING.COM
MO. CERTIFICATE OF AUTHORITY #3008002167

CERTIFICATION IS PROVIDED HEREON FOR STRUCTURAL ITEMS NOT OTHERWISE ADDRESSED IN THE REQUIREMENTS OF THE 2018 INTERNATIONAL RESIDENTIAL CODE. ALL CONSTRUCTION MATERIALS, FASTENING NOT SPECIFICALLY DENOTED SHALL COMPLY WITH THE REQUIREMENTS OF THE 2018 IRC AND THEREIN REFERENCED STANDARDS. ANY REQUIRED CLARIFICATIONS OR MODIFICATIONS TO STRUCTURAL ITEMS SHALL BE APPROVED BY THE ENGINEER OF RECORD OR OTHER LICENSED PROFESSIONAL CAPABLE OF CERTIFYING COMPLIANCE WITH THE MINIMUM STANDARDS OF THE APPLICABLE CODE.

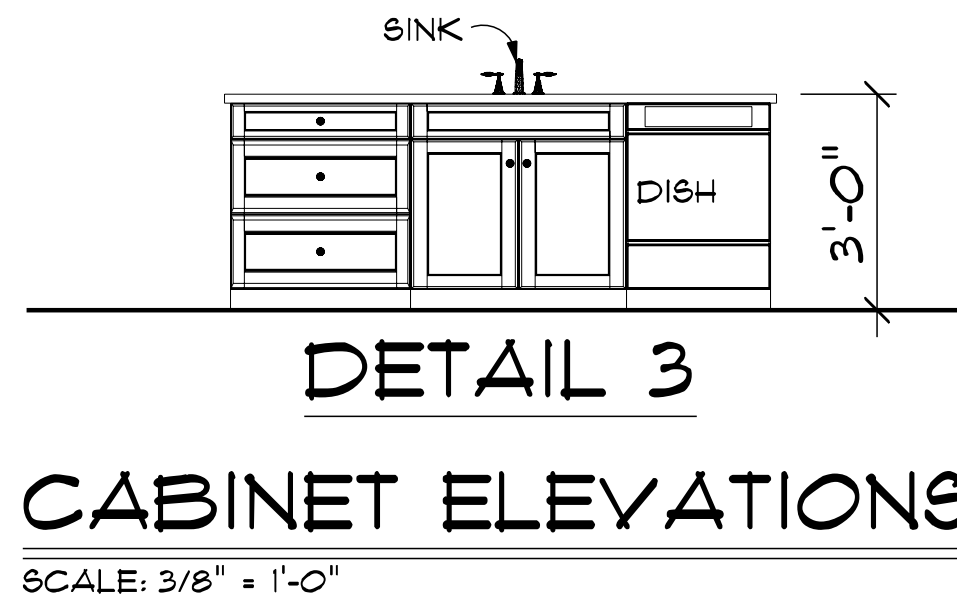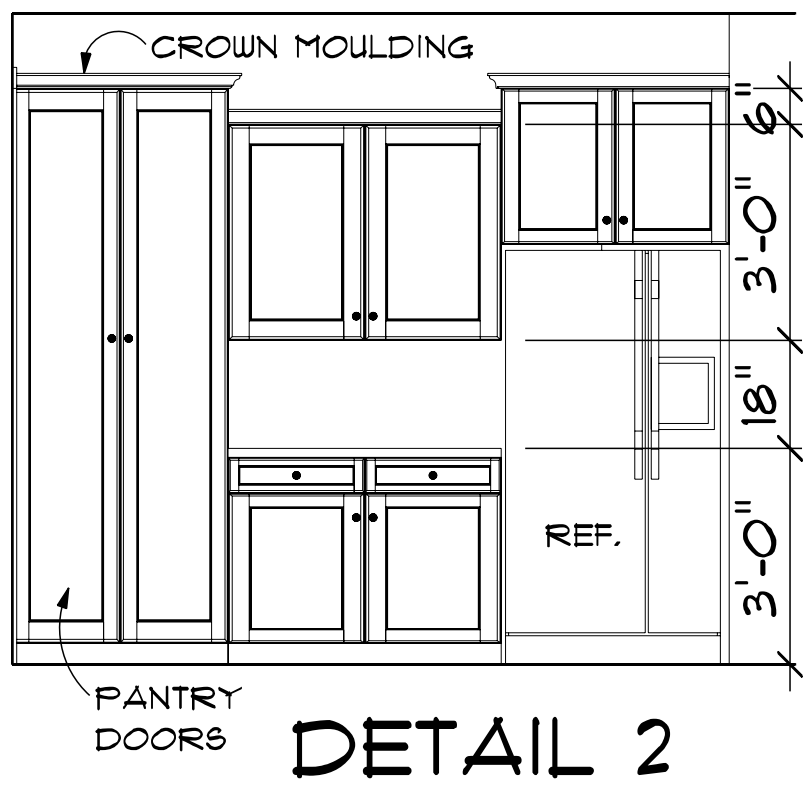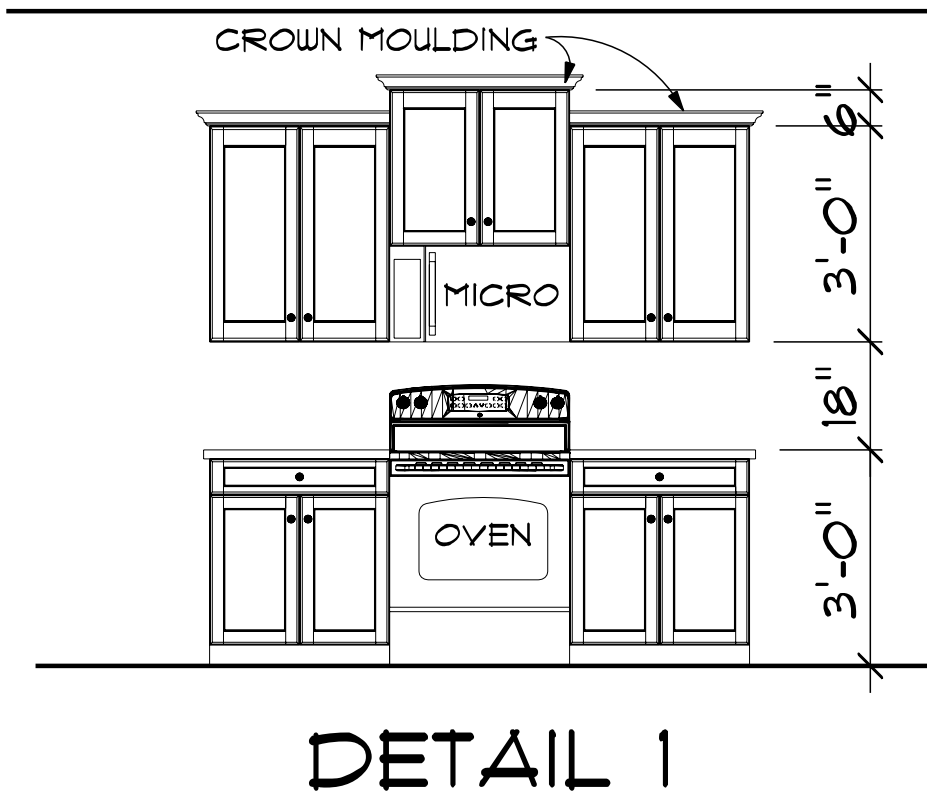


DETAIL 1

DETAIL 2

DETAIL 3


CABINET ELEVATIONS

SCALE: 3/8" = 1'-0"

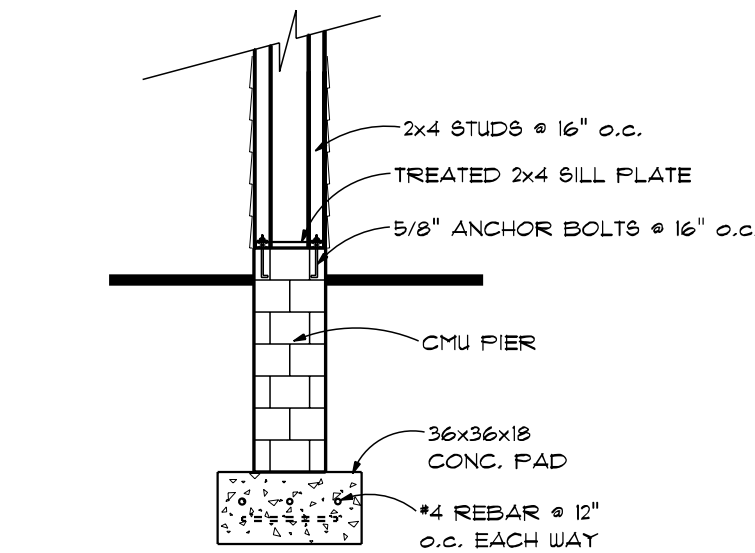


WOOD FRAMED COLUMN FOOTING DETAIL

SCALE: 1/4" = 1'-0"

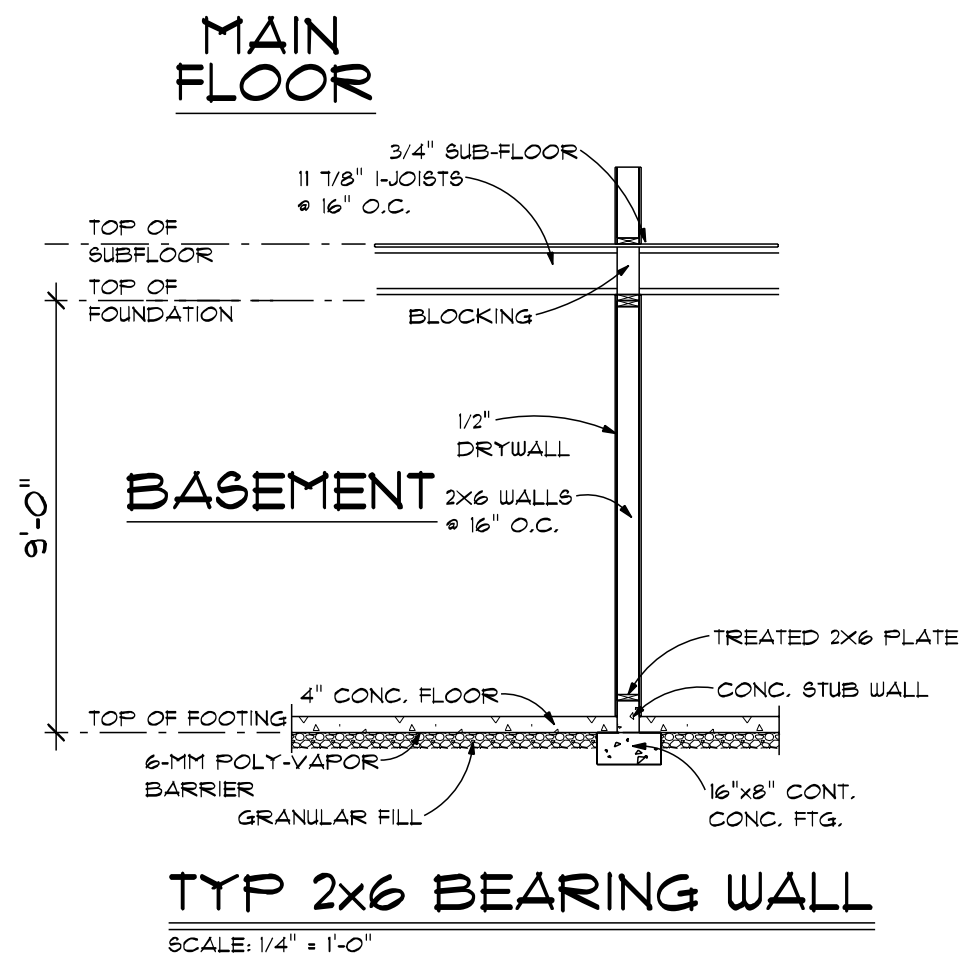


TYP 2x6 BEARING WALL

SCALE: 1/4" = 1'-0"

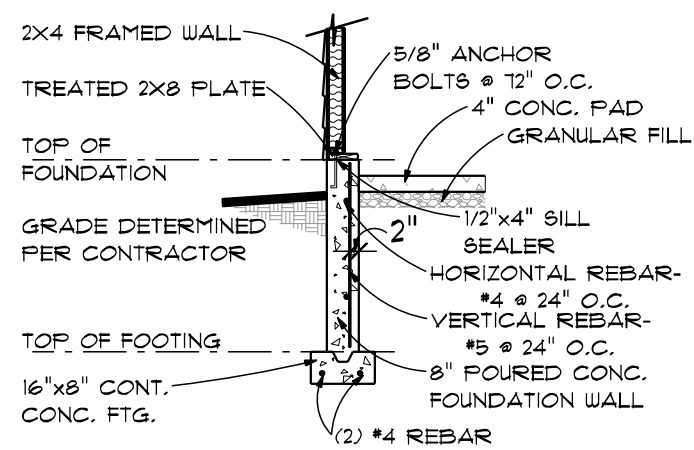


TYP. GARAGE WALL

SCALE: 1/4" = 1'-0"

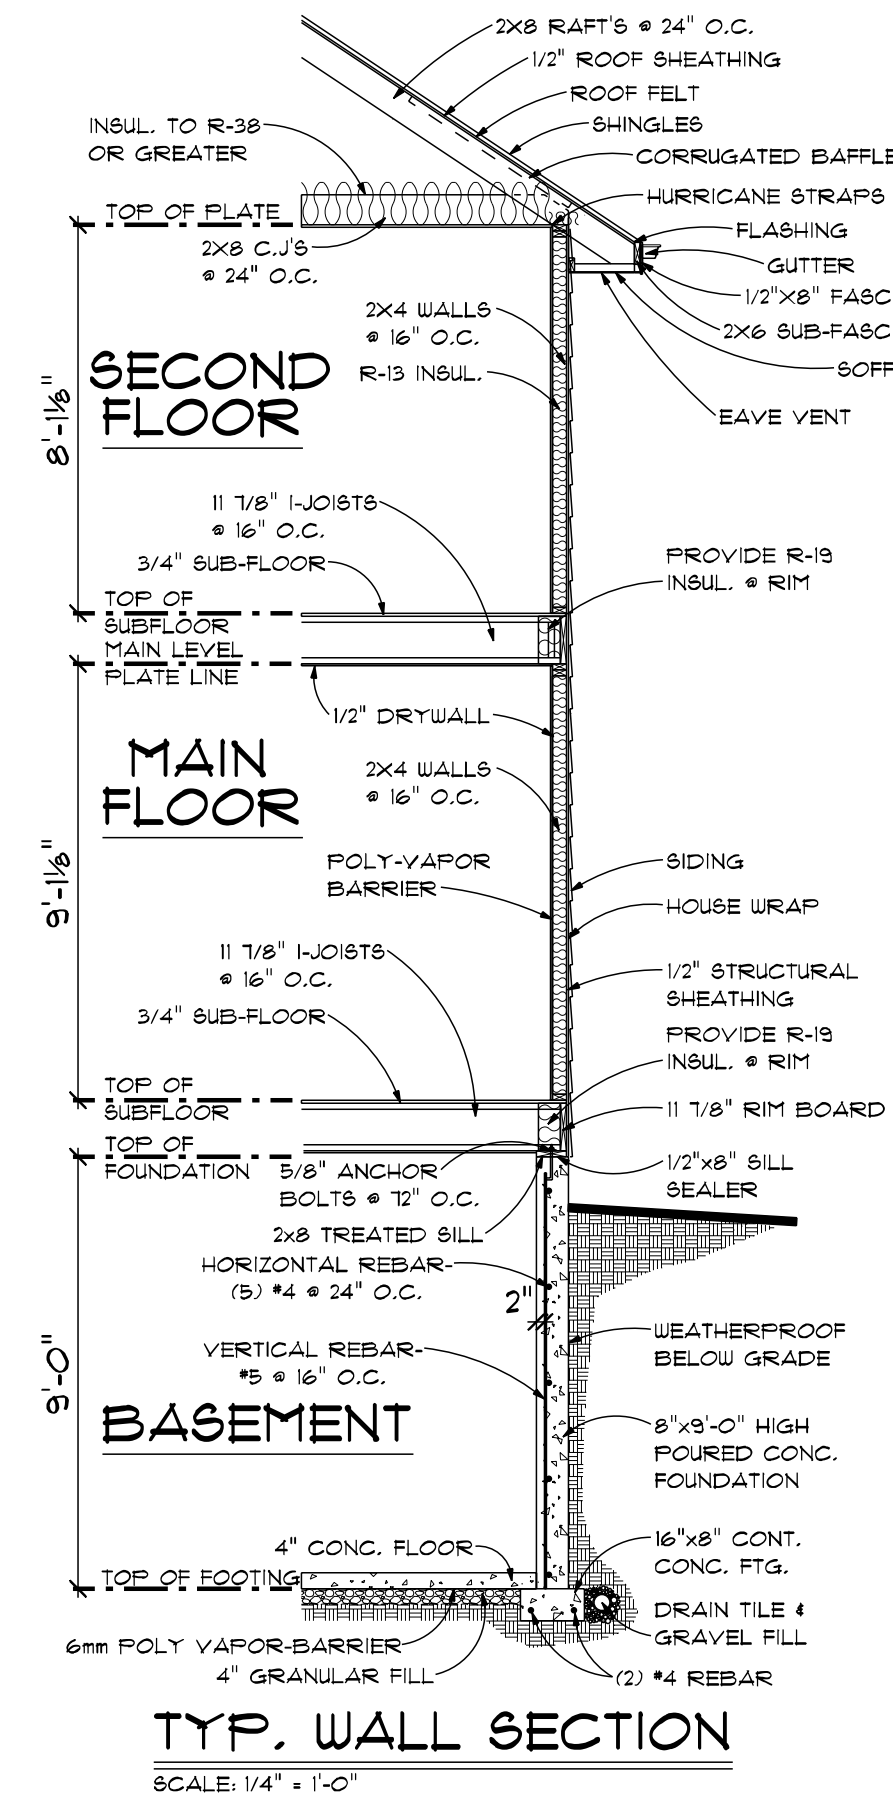

TYP. WALL SECTION

SCALE: 1/4" = 1'-0"

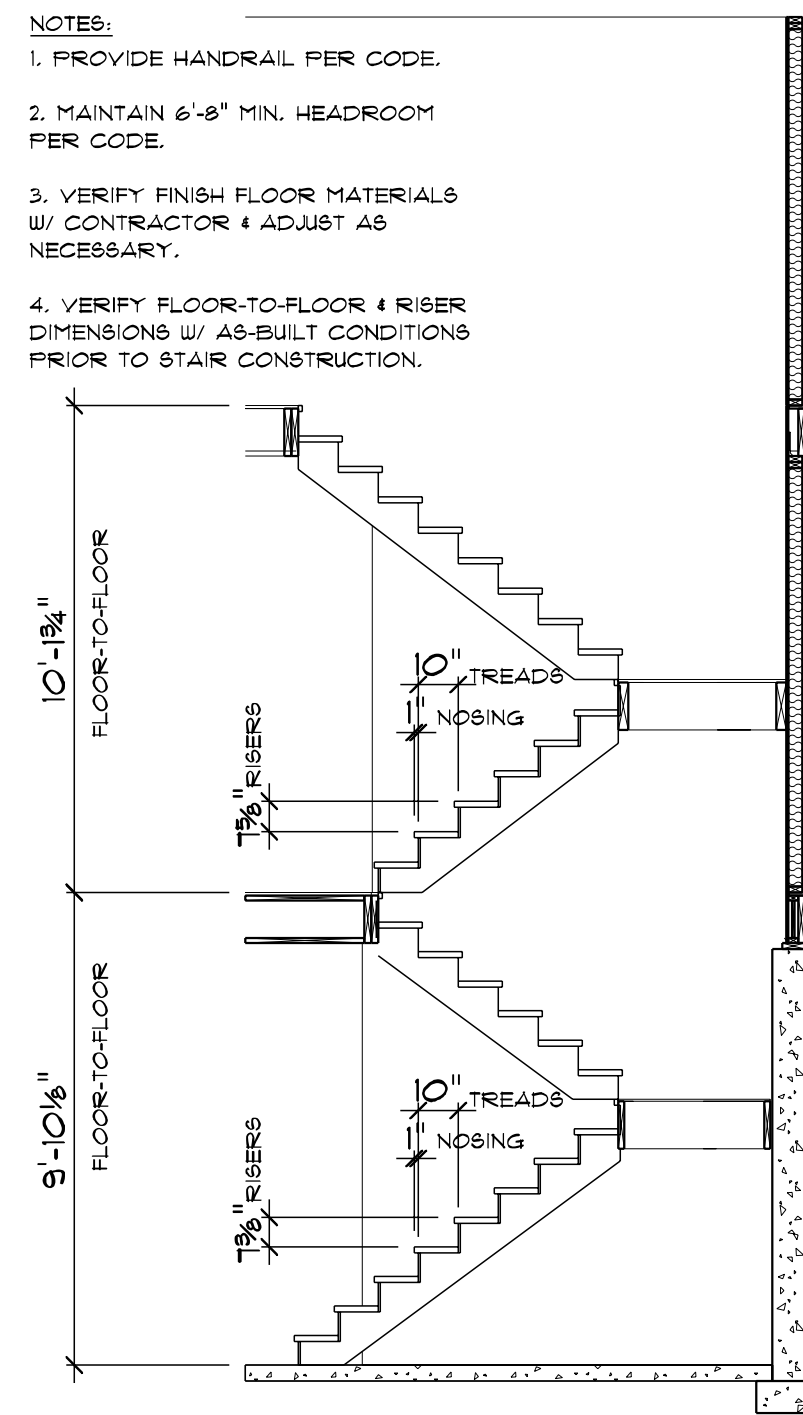

STAIR SECTION

SCALE: 1/4" = 1'-0"

- NOTES:
1. PROVIDE HANDRAIL PER CODE.
 2. MAINTAIN 6'-8" MIN. HEADROOM PER CODE.
 3. VERIFY FINISH FLOOR MATERIALS W/ CONTRACTOR & ADJUST AS NECESSARY.
 4. VERIFY FLOOR-TO-FLOOR & RISER DIMENSIONS W/ AS-BUILT CONDITIONS PRIOR TO STAIR CONSTRUCTION.