


MONTICELLO 4th PLAT
WATER CONSTRUCTION PLANS
LOTS 109- TRACTS
SECTION 4, TOWNSHIP 48 NORTH, RANGE 31 WEST
LEE'S SUMMIT, JACKSON COUNTY, MISSOURI

- WATER:
1 ~ THE CONTRACTOR SHALL COORDINATE WITH THE PUBLIC WORKS INSPECTOR PRIOR TO ANY CONNECTIONS TO THE PUBLIC WATER SUPPLY.
- 2 ~ FIRE HYDRANTS SHALL BE OPTIC YELLOW WATEROUS "PACER" MODEL NO. WB-67-250 WITH NON-RISING STEM OR CITY ENGINEER APPROVED EQUAL. HYDRANTS SHALL HAVE A 5 1/4" VALVE WITH A 4 1/2" PUMPER NOZZLE AND 2 - 2 1/2" HOSE NOZZLES (LEFT HAND OPENING).
- 3 ~ GATE VALVES SHALL BE MUELLER NO. 2360 Series HUB END "O" RING SEAL NON-RISING STEM. VALVES 12" OR LARGER SHALL BE BUTTERFLY VALVES MANUFACTURED BY THE HENRY PRATT COMPANY OR CITY ENGINEER APPROVED EQUAL. LEFT HAND OPENING. MINIMUM 200# TESTING AWWA.
- 4 ~ ALL WATER MAINS SHALL BE CONSTRUCTED WITH A MINIMUM COVER OF 42 INCHES. STREET GRADING SHALL BE COMPLETED PRIOR TO BEGINNING CONSTRUCTION OF WATER MAINS.
- 5 ~ ALL BENDS, TEES AND FIRE HYDRANTS SHALL BE INSTALLED WITH SUITABLE CONCRETE THRUST BLOCKS POURED IN PLACE AGAINST UNDISTURBED EARTH AND PER CITY OF LEES SUMMIT AND APWA STANDARDS.
- 6 ~ THE MINIMUM SEPARATION BETWEEN THE PROPOSED WATER MAIN AND SANITARY OR STORM SEWERS IS AS FOLLOWS:
A ~ SANITARY SEWERS: HORIZONTAL = 10 FEET - VERTICAL = 18 INCHES
B ~ STORM SEWERS: HORIZONTAL = 10 FEET - VERTICAL = 18 INCHES
THESE SEPARATIONS SHALL PREVAIL OVER ANY DATA SHOWN IN THESE PLANS AND THE CONTRACTOR SHALL INSTALL BENDS OR OTHER FITTINGS AS NECESSARY TO ACHIEVE THE REQUIRED SEPARATIONS.
- 7 ~ ALL CONSTRUCTION SHALL FOLLOW THE CITY OF LEE'S SUMMIT DESIGN AND CONSTRUCTION MANUAL AS ADOPTED BY ORDINANCE 5813
- 8 ~ Areas where proposed pipe is at or above existing grade, embankment shall be placed and compacted prior to installing the pipe. Embankment shall be placed to finished grade, prior to trenching for pipe installation. For pipes deeper than 4 feet from finished grade, trenching may take place when the embankment is at least 4 feet above the proposed top of pipe elevation.

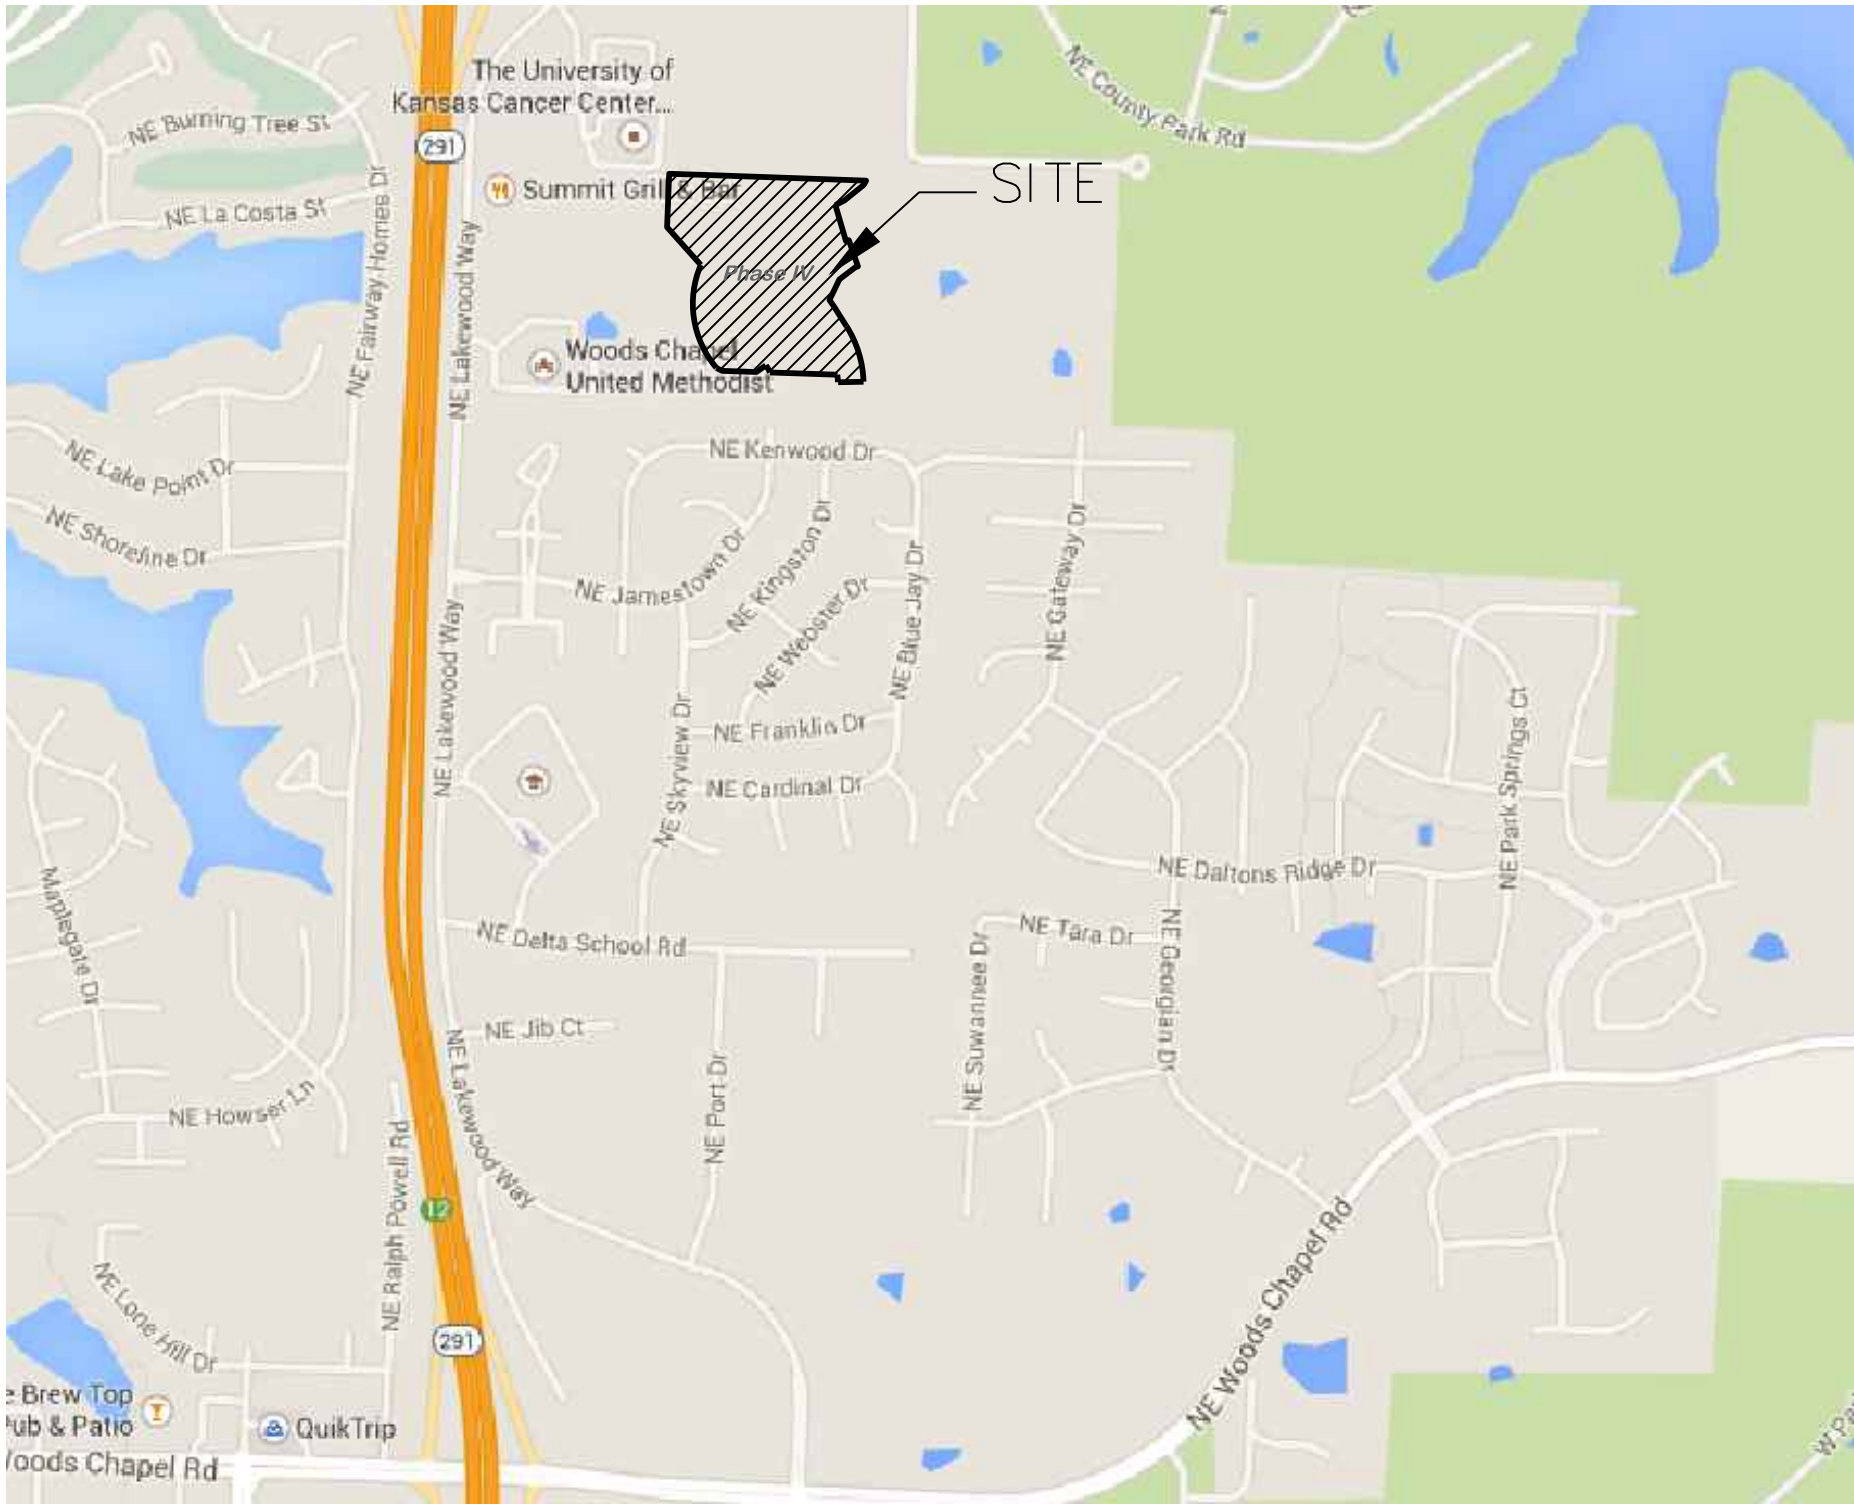

SITE LOCATION MAP

- INDEX OF SHEETS:
- C.500 ~ COVER SHEET
 - C.501 ~ WATER LINE GENERAL LAYOUT
 - C.502 ~ WATER LINE PLAN & PROFILE
 - C.503 ~ WATER LINE PLAN & PROFILE
 - C.504 ~ DETAIL SHEET

Summary of Quantities:

ITEM AND DESCRIPTION	UNIT	ESTIMATED QUANTITY
FIRE HYDRANT ASSEMBLY	UNIT	4.00
8" WATER LINE	FT	2,510.56
8" GATE VALVE/ VALVE BOX & COVER	UNIT	4.00
CONNECT TO EXISTING	UNIT	3.00
TEMP. TO PERM. FIRE HYDRANT CONVERSION	UNIT	2.00
THRUST BLOCK	UNIT	30.00
TEES, BENDS	LS	28.00

UTILITY COMPANIES:

THE FOLLOWING LIST OF UTILITY COMPANIES IS PROVIDED FOR INFORMATION ONLY. WE DO NOT OFFER ANY GUARANTEE OR WARRANTY THAT THIS LIST IS COMPLETE OR ACCURATE. THE CONTRACTOR SHALL BE RESPONSIBLE FOR CONTACTING ALL UTILITY COMPANIES THAT MAY BE AFFECTED BY THE PROPOSED CONSTRUCTION AND VERIFYING THE ACTUAL LOCATION OF EACH UTILITY LINE. THE CONTRACTOR SHALL NOTIFY ENGINEERING SOLUTIONS AT 816.623.9888 OF ANY CONFLICT WITH PROPOSED IMPROVEMENTS.

EVERGY ~ 298-1196
MISSOURI GAS ENERGY ~ 756-5261
SOUTHWESTERN BELL TELEPHONE ~ 761-5011
COMCAST CABLE ~ 795-1100
WILLIAMS PIPELINE ~ 422-6300
CITY OF LEE'S SUMMIT PUBLIC WORKS ~ 969-1800
CITY OF LEE'S SUMMIT DEVELOPMENT ENGINEERING INSPECTION AT 816.969.1200
CITY OF LEE'S SUMMIT WATER UTILITIES ~ 969-1900
MISSOURI ONE CALL (DIG RITE) ~ 1-800-344-7483

- LEGEND:
- B/L ~ BUILDING SET-BACK
 - C/A ~ COMMON AREA
 - D/E ~ DRAINAGE EASEMENT
 - FND. ~ FOUND
 - L/E ~ LANDSCAPE EASEMENT
 - L.N.A. ~ LIMITS OF NO ACCESS
 - R/W ~ RIGHT OF WAY
 - SAN ~ SANITARY SEWER LINE
 - S/W ~ SIDEWALK
 - U/E ~ UTILITY EASEMENT
 - W ~ WATER LINE
 - ST ~ STORM SEWER LINE

ENGINEER'S CERTIFICATION:

I HEREBY CERTIFY THAT THIS PROJECT HAS BEEN DESIGNED AND THESE PLANS PREPARED IN ACCORDANCE WITH THE CURRENT DESIGN CRITERIA OF THE CITY OF LEE'S SUMMIT, MISSOURI AND THE STATE OF MISSOURI. I FURTHER CERTIFY THAT THESE PLANS WERE DESIGNED IN ACCORDANCE TO AASHTO STANDARDS.

CITY OF LEE'S SUMMIT, MISSOURI

APPROVED: DATE:


BY: CITY ENGINEER

"AS-BUILT"

900.10
Indicates data replaced with "As-Built" information. All other data is as designed and has not been field verified.


Monticello 4th Plat
Lee's Summit, Jackson County, Missouri

Water Main Cover Sheet
Construction Plans for:
Monticello 4th Plat
Lee's Summit, Jackson County, Missouri

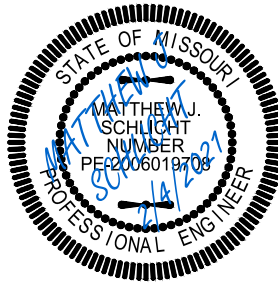

Matthew J. Schlicht
MO PE 2006019708
KS PE 19071
OK PE 25526

REVISIONS
2/4/2021 As-Built

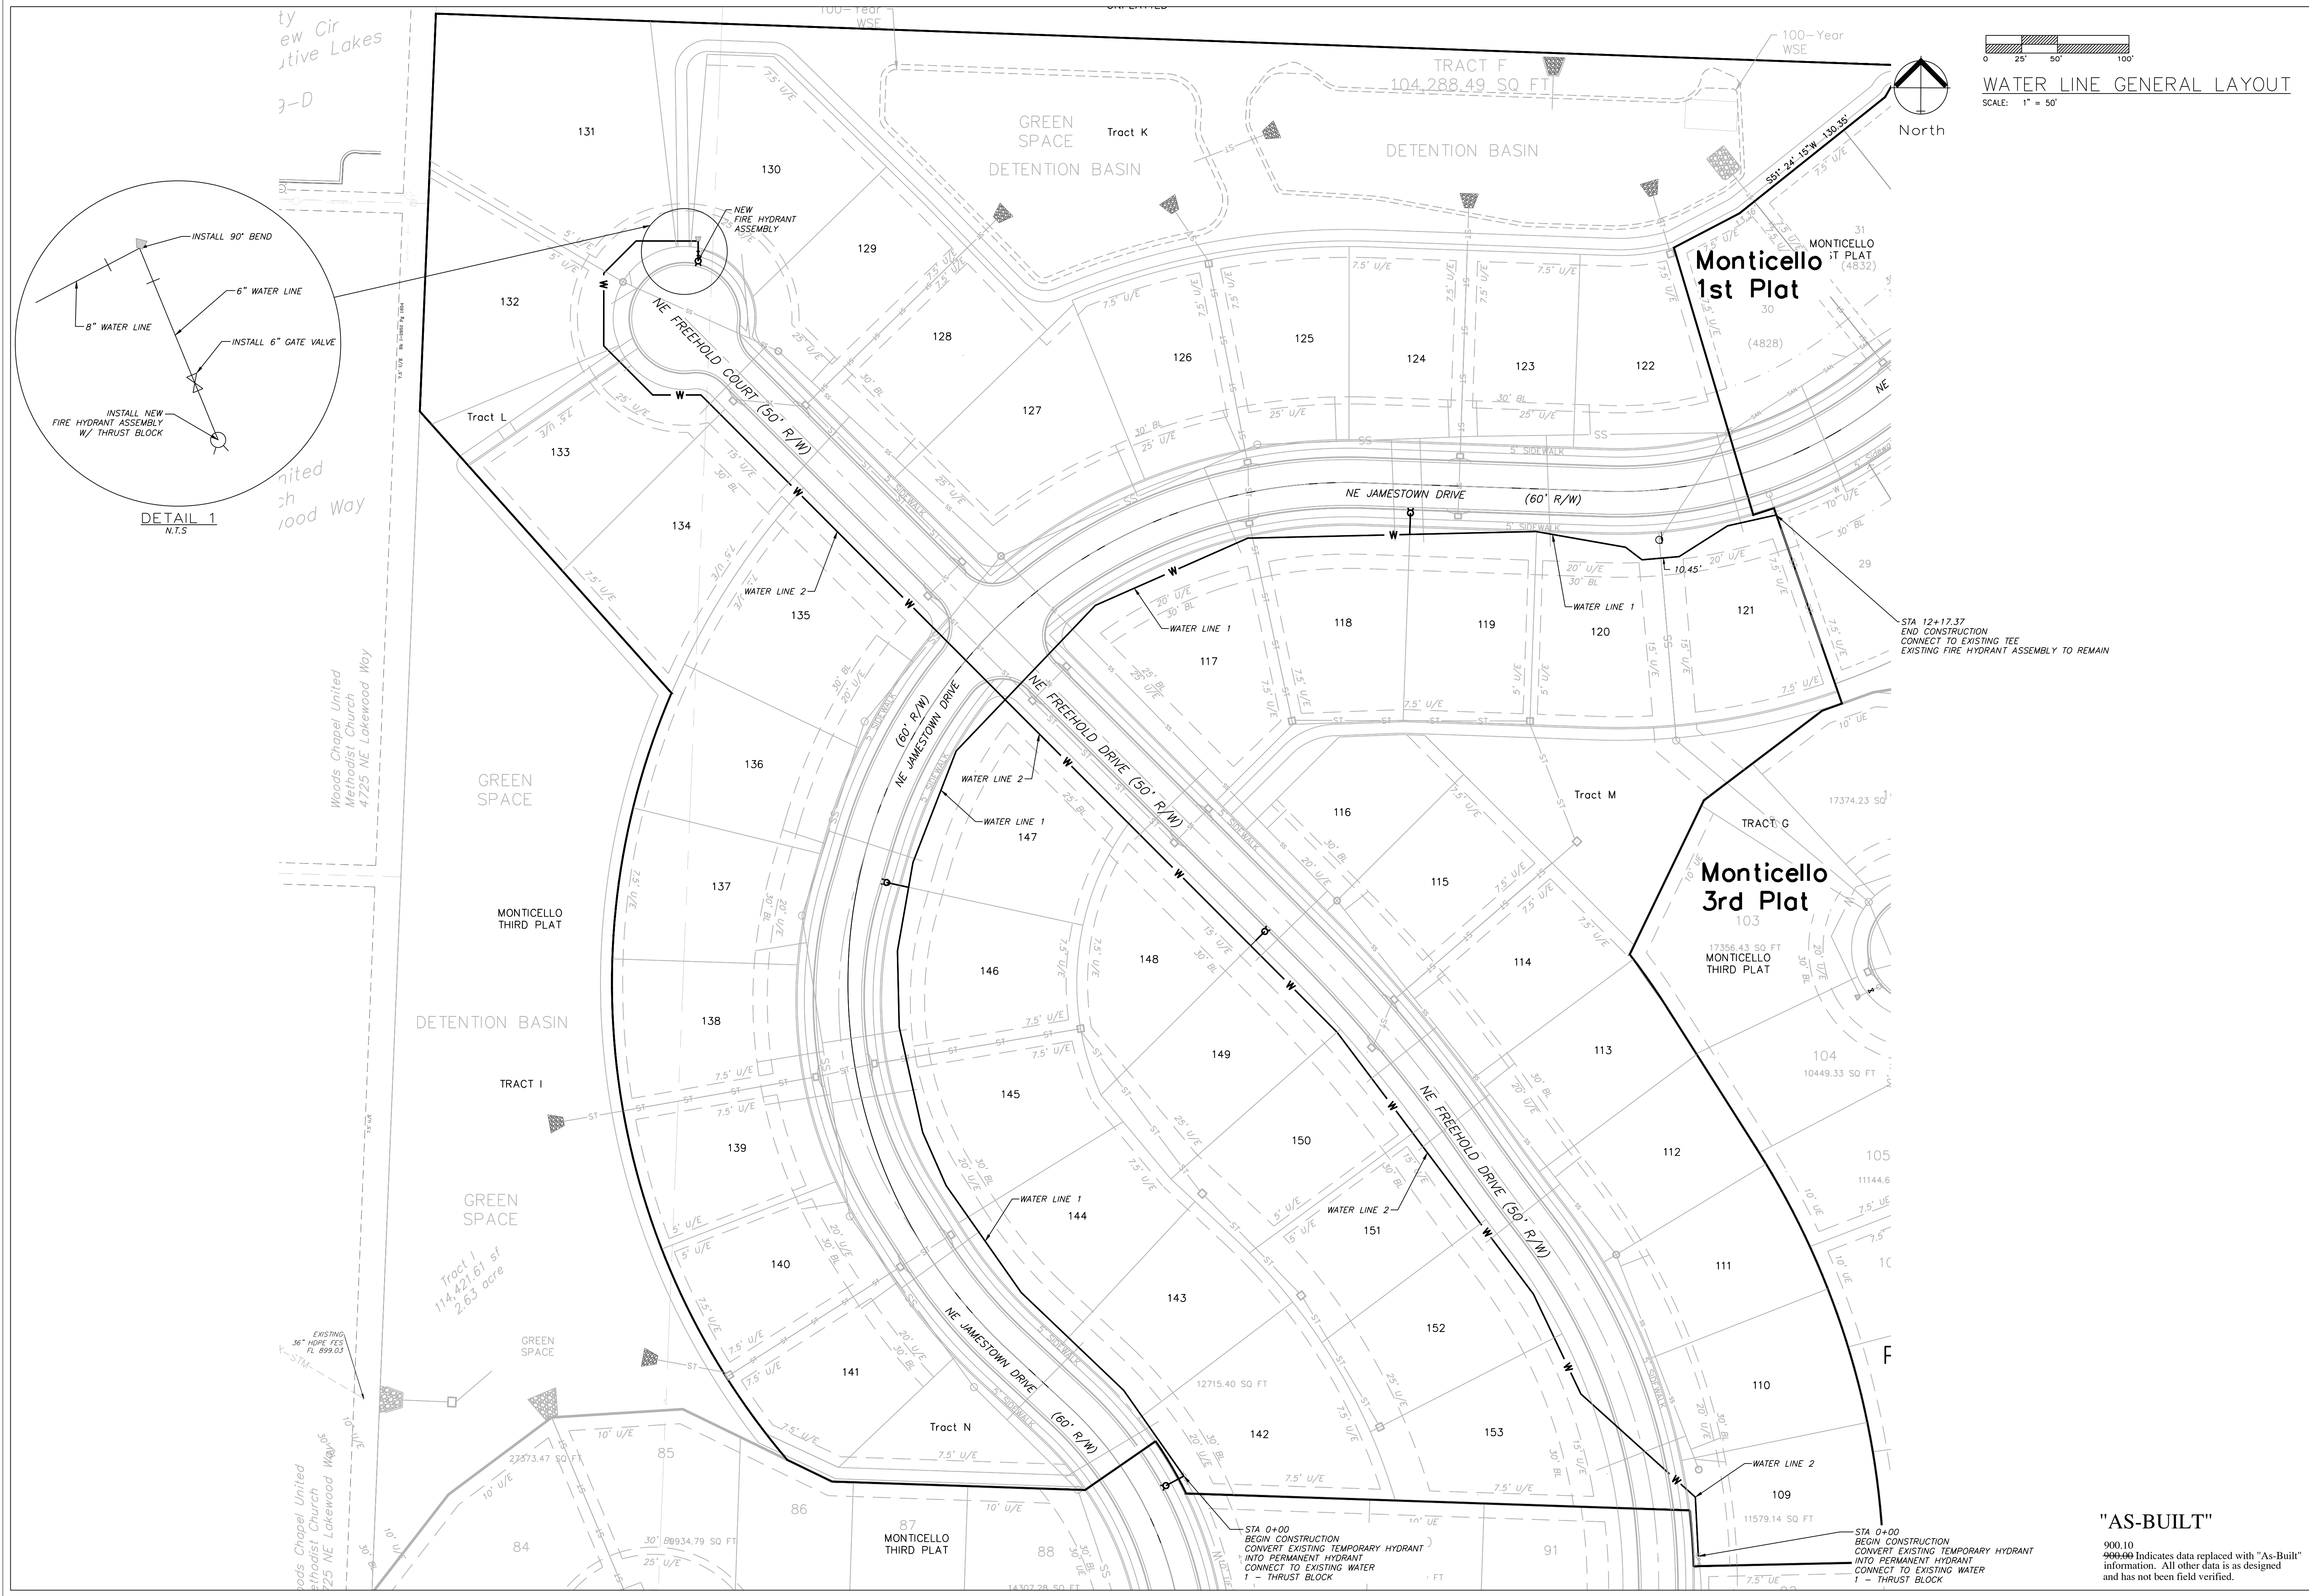

ENGINEERING SOLUTIONS

ENGINEERING & SURVEYING

Professional Registration

Missouri
Engineering 2005002188-D
Surveying 2005000519-D

Kansas
Engineering E-1695
Surveying LS-218

Oklahoma
Engineering 6254

Nebraska
Engineering CA2821

Water Line General Layout
Construction Plans for:
Monticello 4th Plat
Lee's Summit, Jackson County, Missouri

Project:
Monticello

Issue Date:
April 10, 2020

Water Line General Layout
Construction Plans for:
Monticello 4th Plat
Lee's Summit, Jackson County, Missouri

Matthew J. Schlicht
MO PE 2006019708
KS PE 19071
OK PE 25226

 

REVISIONS

2/4/2021 As-Built

"AS-BUILT"


900.10
~~900.00~~ Indicates data replaced with "As-Built" information. All other data is as designed and has not been field verified.

C.501

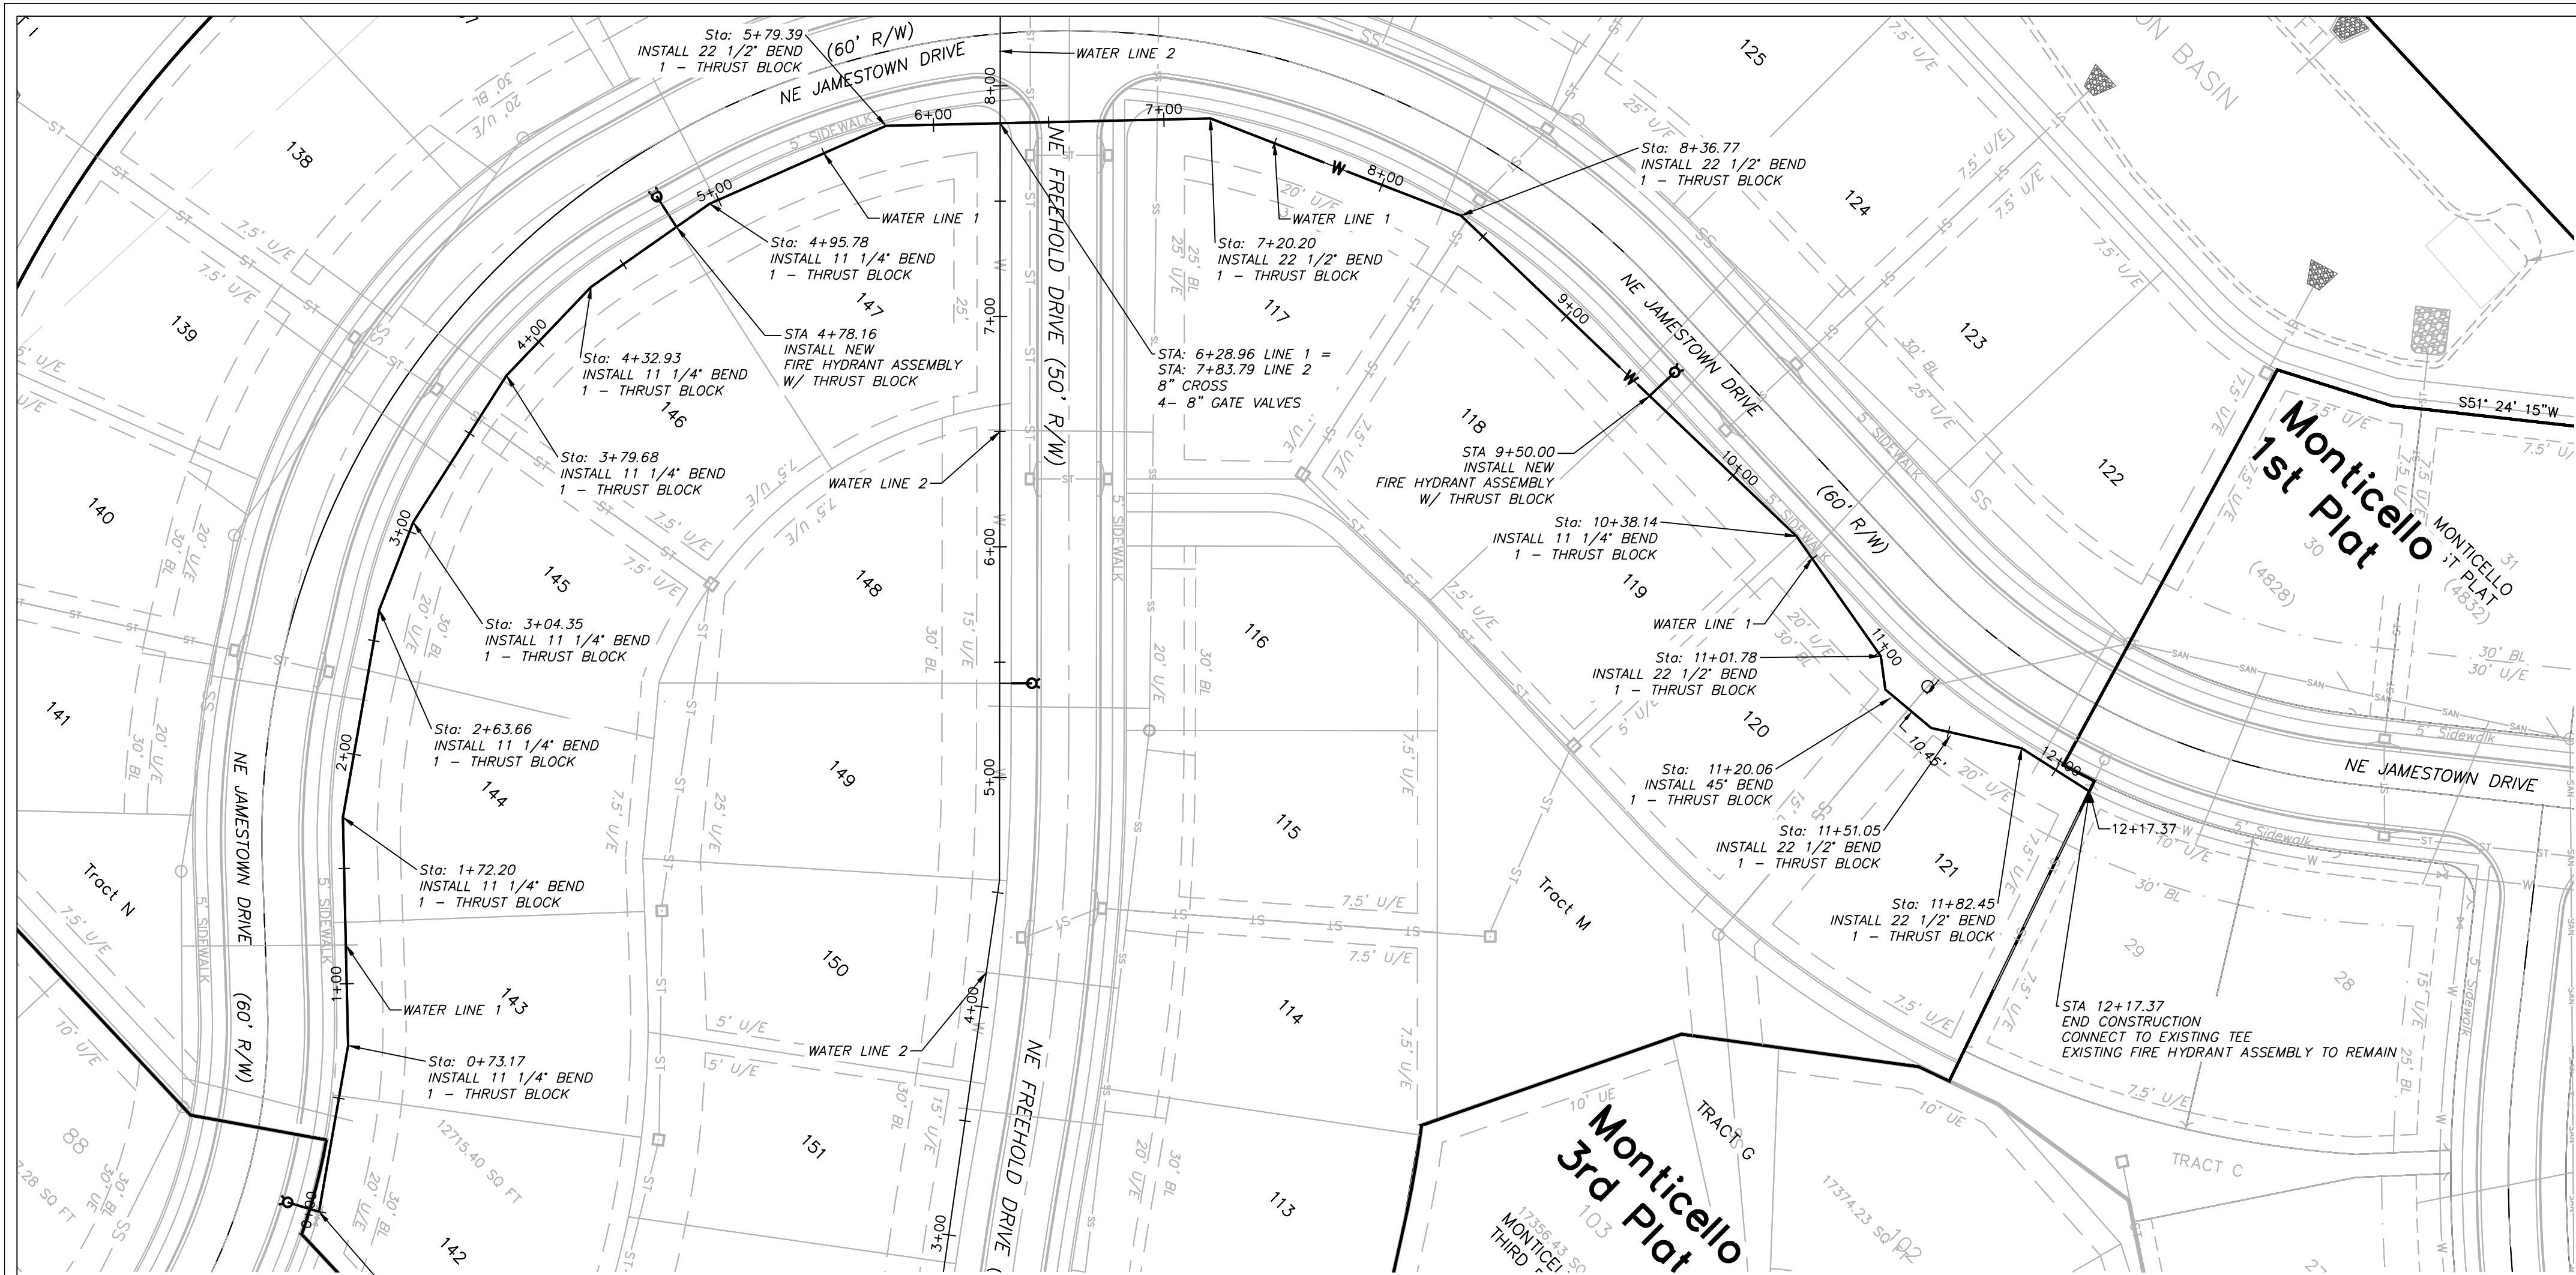


WATER PLAN & PROFILE
SCALE: 1" = 50'

WATER LINE 1

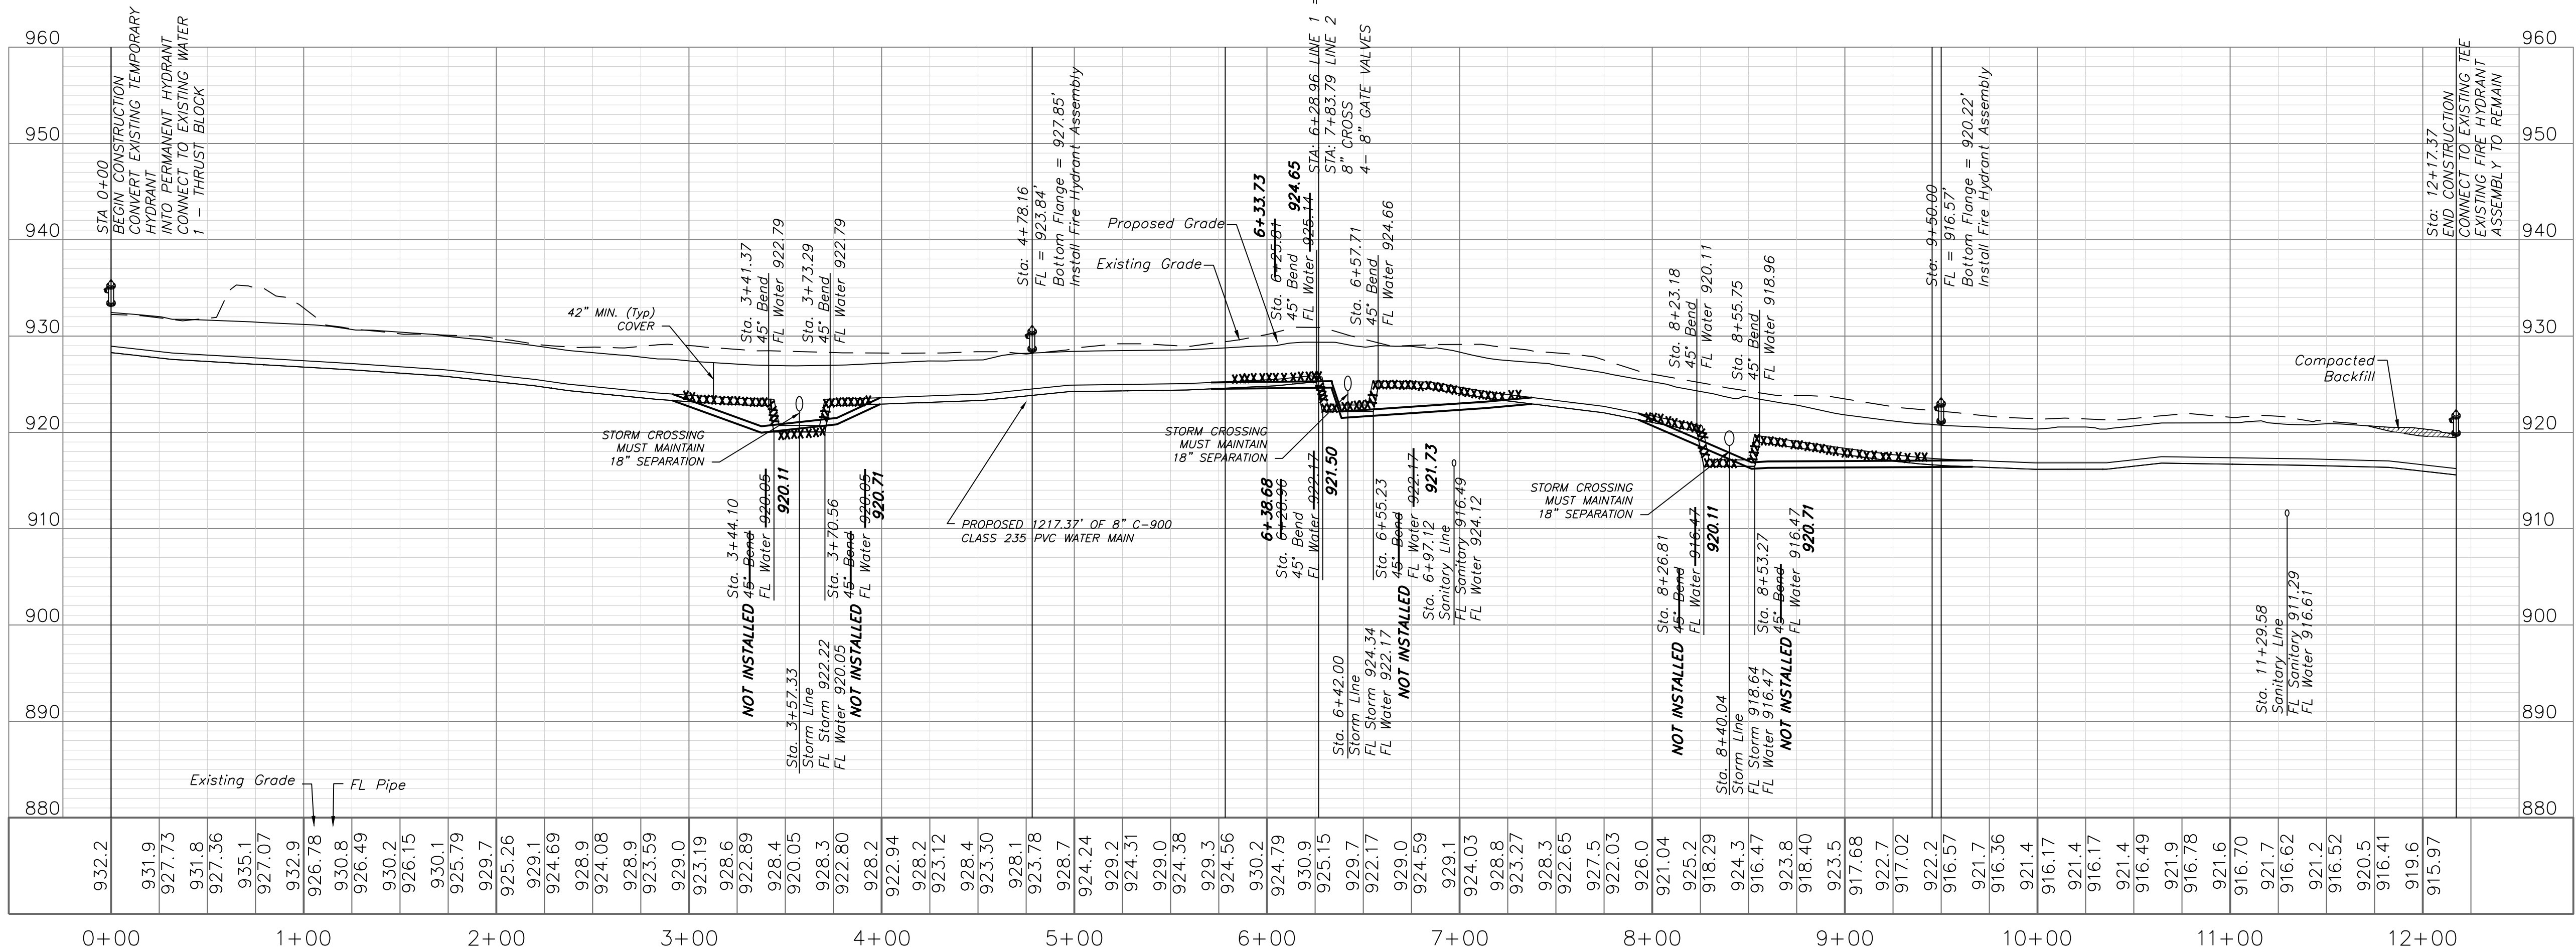


NOTE:
WATER MAINS SHALL NOT EXCEED
7 FEET IN DEPTH AS MEASURED
TO THE TOP OF THE PIPE.

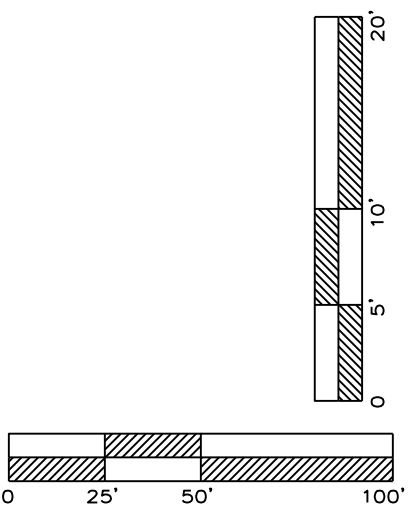

"AS-BUILT"

900.10
900.00 Indicates data replaced with "As-Built"
information. All other data is as designed
and has not been field verified.

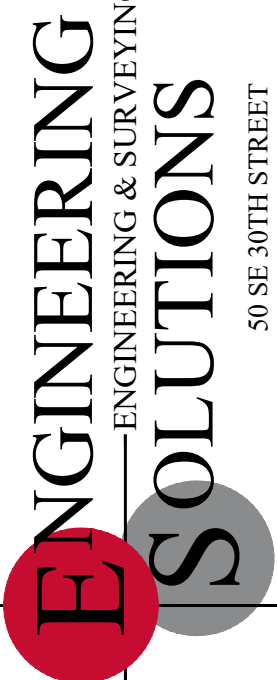


Professional Registration
Missouri
Engineering 200502198-D
Surveying 200500519-D
Kansas
Engineering E-1695
Surveying LS-218
Oklahoma
Engineering 6254
Nebraska
Engineering CA2821

Monticello 4th Plat
Lee's Summit, Jackson County, Missouri


Project:
Monticello
Issue Date:
April 10, 2020

Water Line Plan and Profile
Construction Plans for:
Monticello 4th Plat
Lee's Summit, Jackson County, Missouri

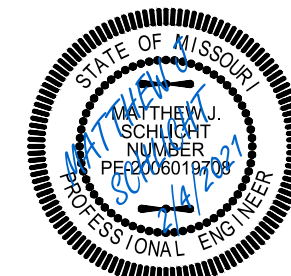


Matthew J. Schlicht
MO PE 2006019708
KS PE 19071
OK PE 25528


REVISIONS
2/4/2021 As-Built

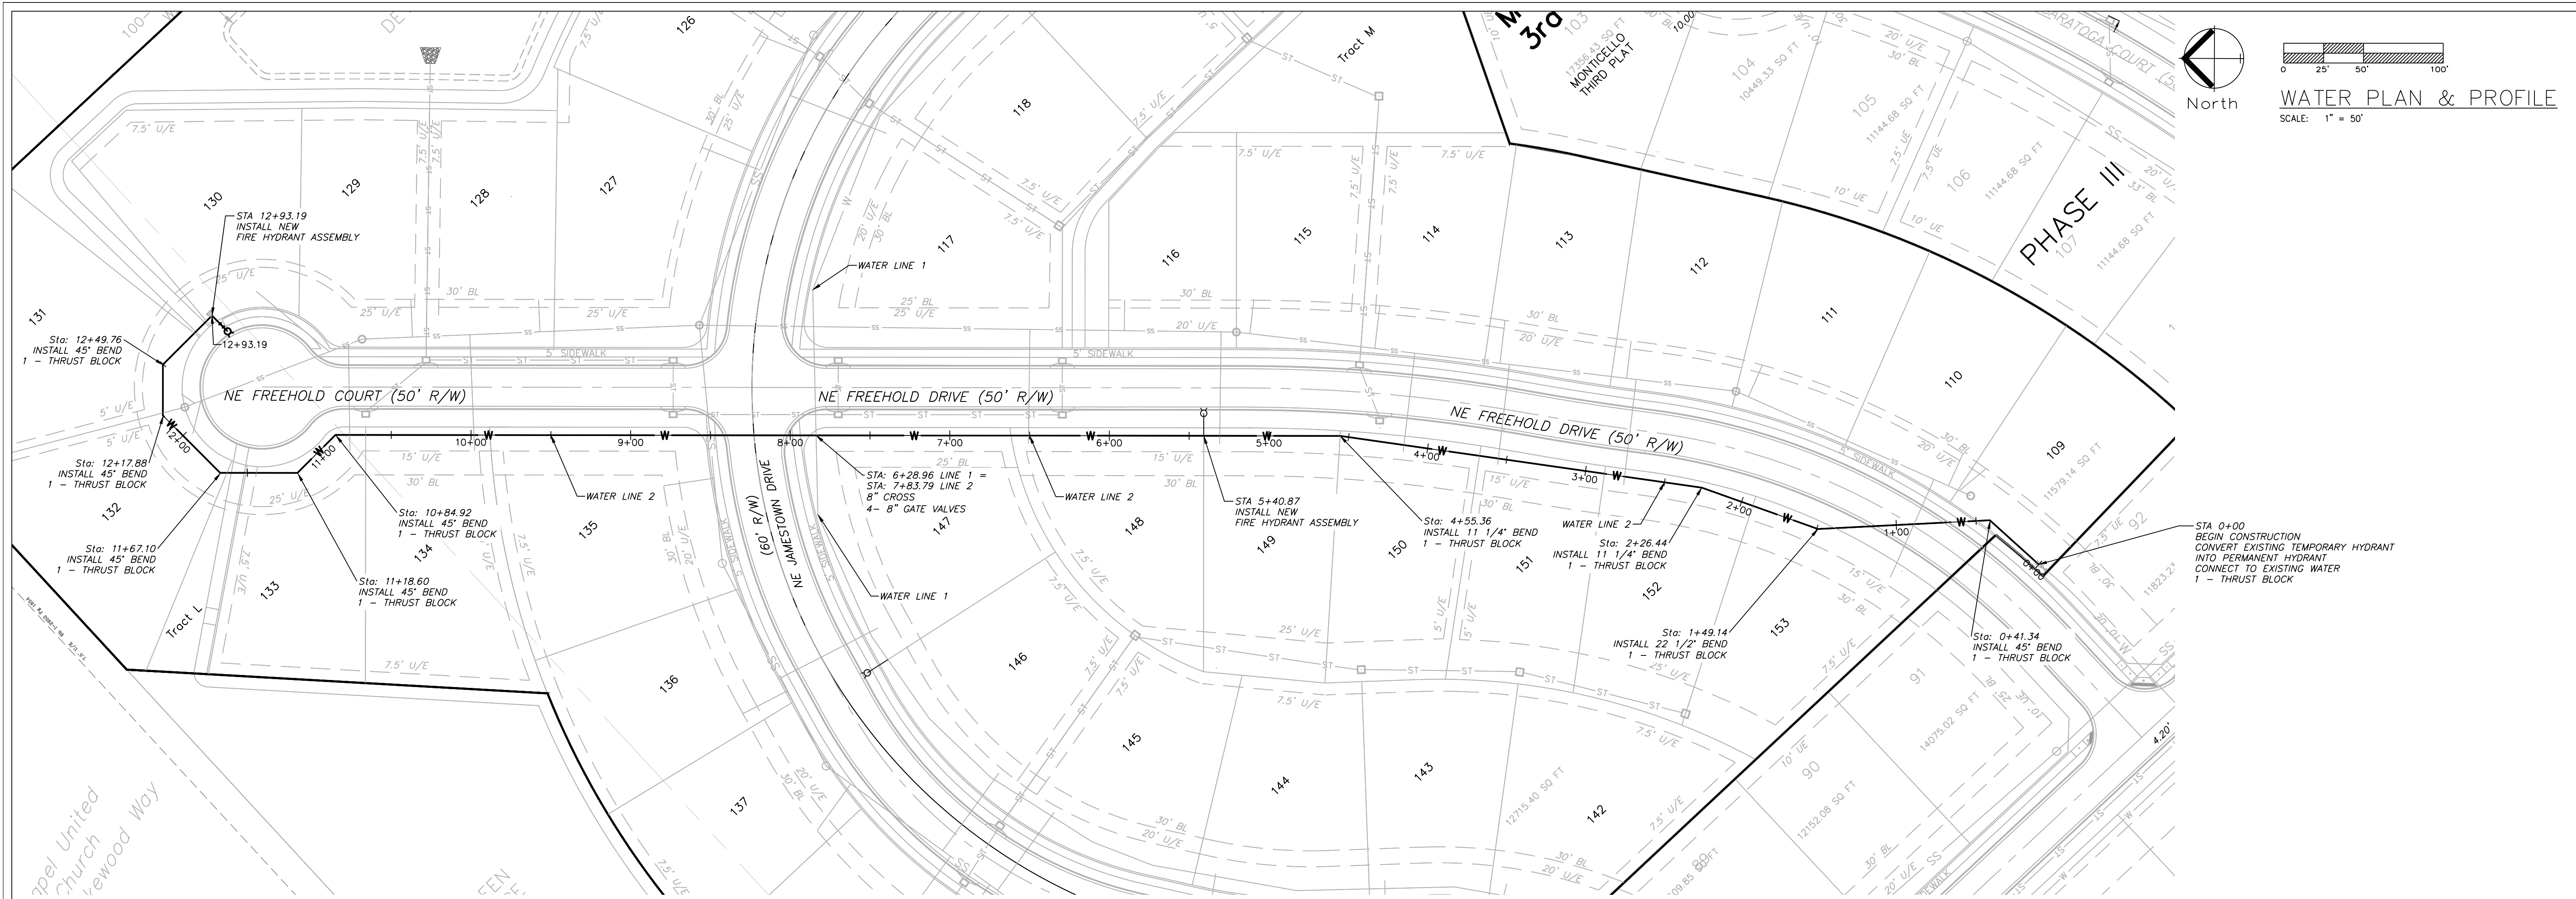

WATER LINE 2

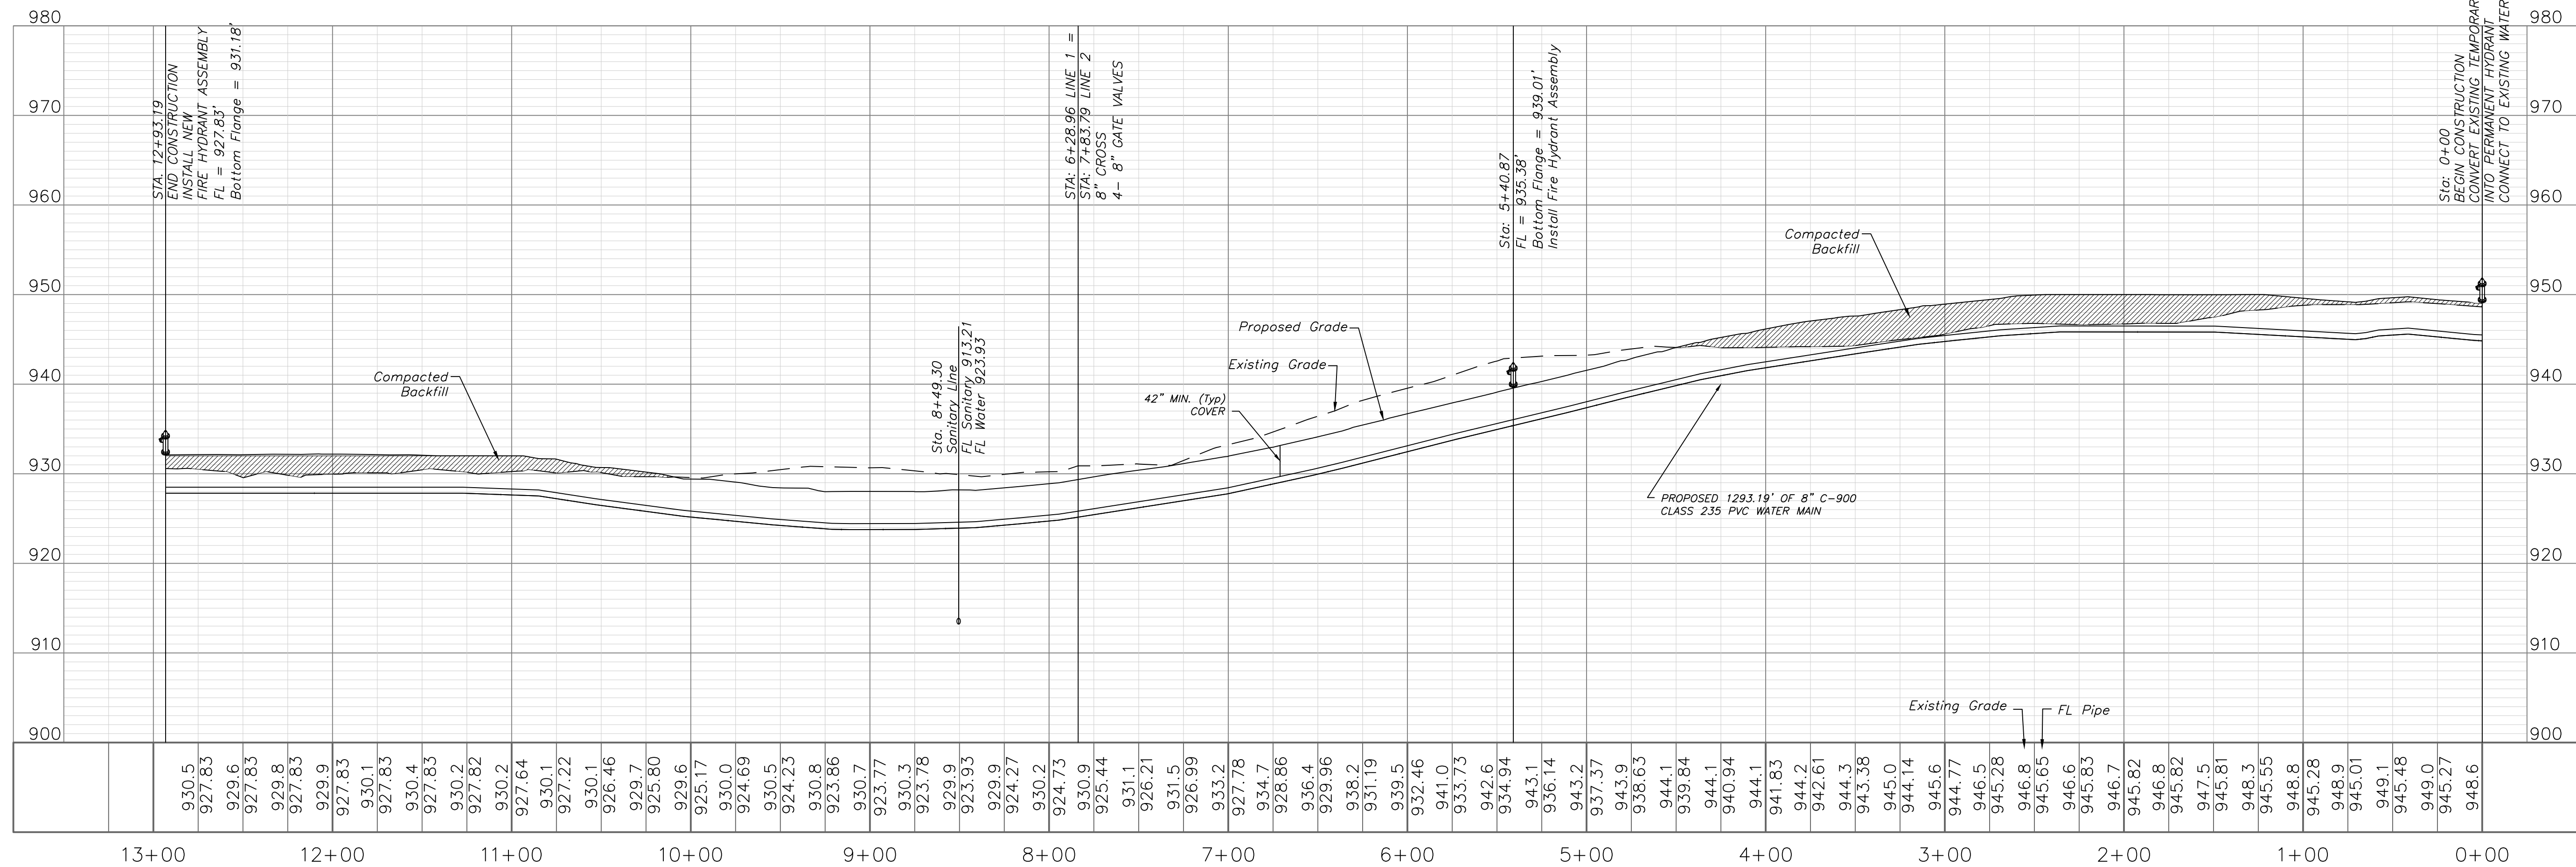

NOTE:
WATER MAINS SHALL NOT EXCEED 7 FEET IN DEPTH AS MEASURED TO THE TOP OF THE PIPE.
COMPACTED FILL SHALL BE PLACED TO A MINIMUM 18" ABOVE THE TOP OF THE PIPE PRIOR TO INSTALLATION.

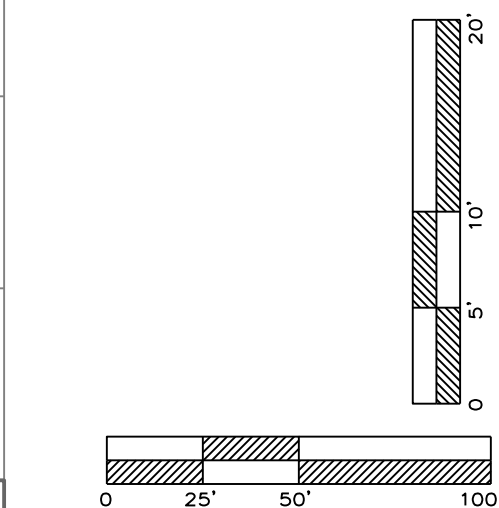

"AS-BUILT"
900.10
900.00 Indicates data replaced with "As-Built" information. All other data is as designed and has not been field verified.

ENGINEERING SOLUTIONS
ENGINEERING & SURVEYING
50 SE 30TH STREET
LEES SUMMIT, MO 64082
P: (816) 623-9888 F: (816) 623-9849







Professional Registration
Missouri
Engineering 2005002188-D
Surveying 200500518-D
Kansas
Engineering E-1695
Surveying LS-218
Oklahoma
Engineering 6254
Nebraska
Engineering CA2821

Project: Monticello
Issue Date: April 10, 2020

Water Line Plan and Profile
Construction Plans for:
Monticello 4th Plat
Lee's Summit, Jackson County, Missouri

Matthew J. Schlicht
MO PE 2006019708
KS PE 19071
OK PE 25528
REVISIONS
2/4/2021 As-Built

C.503

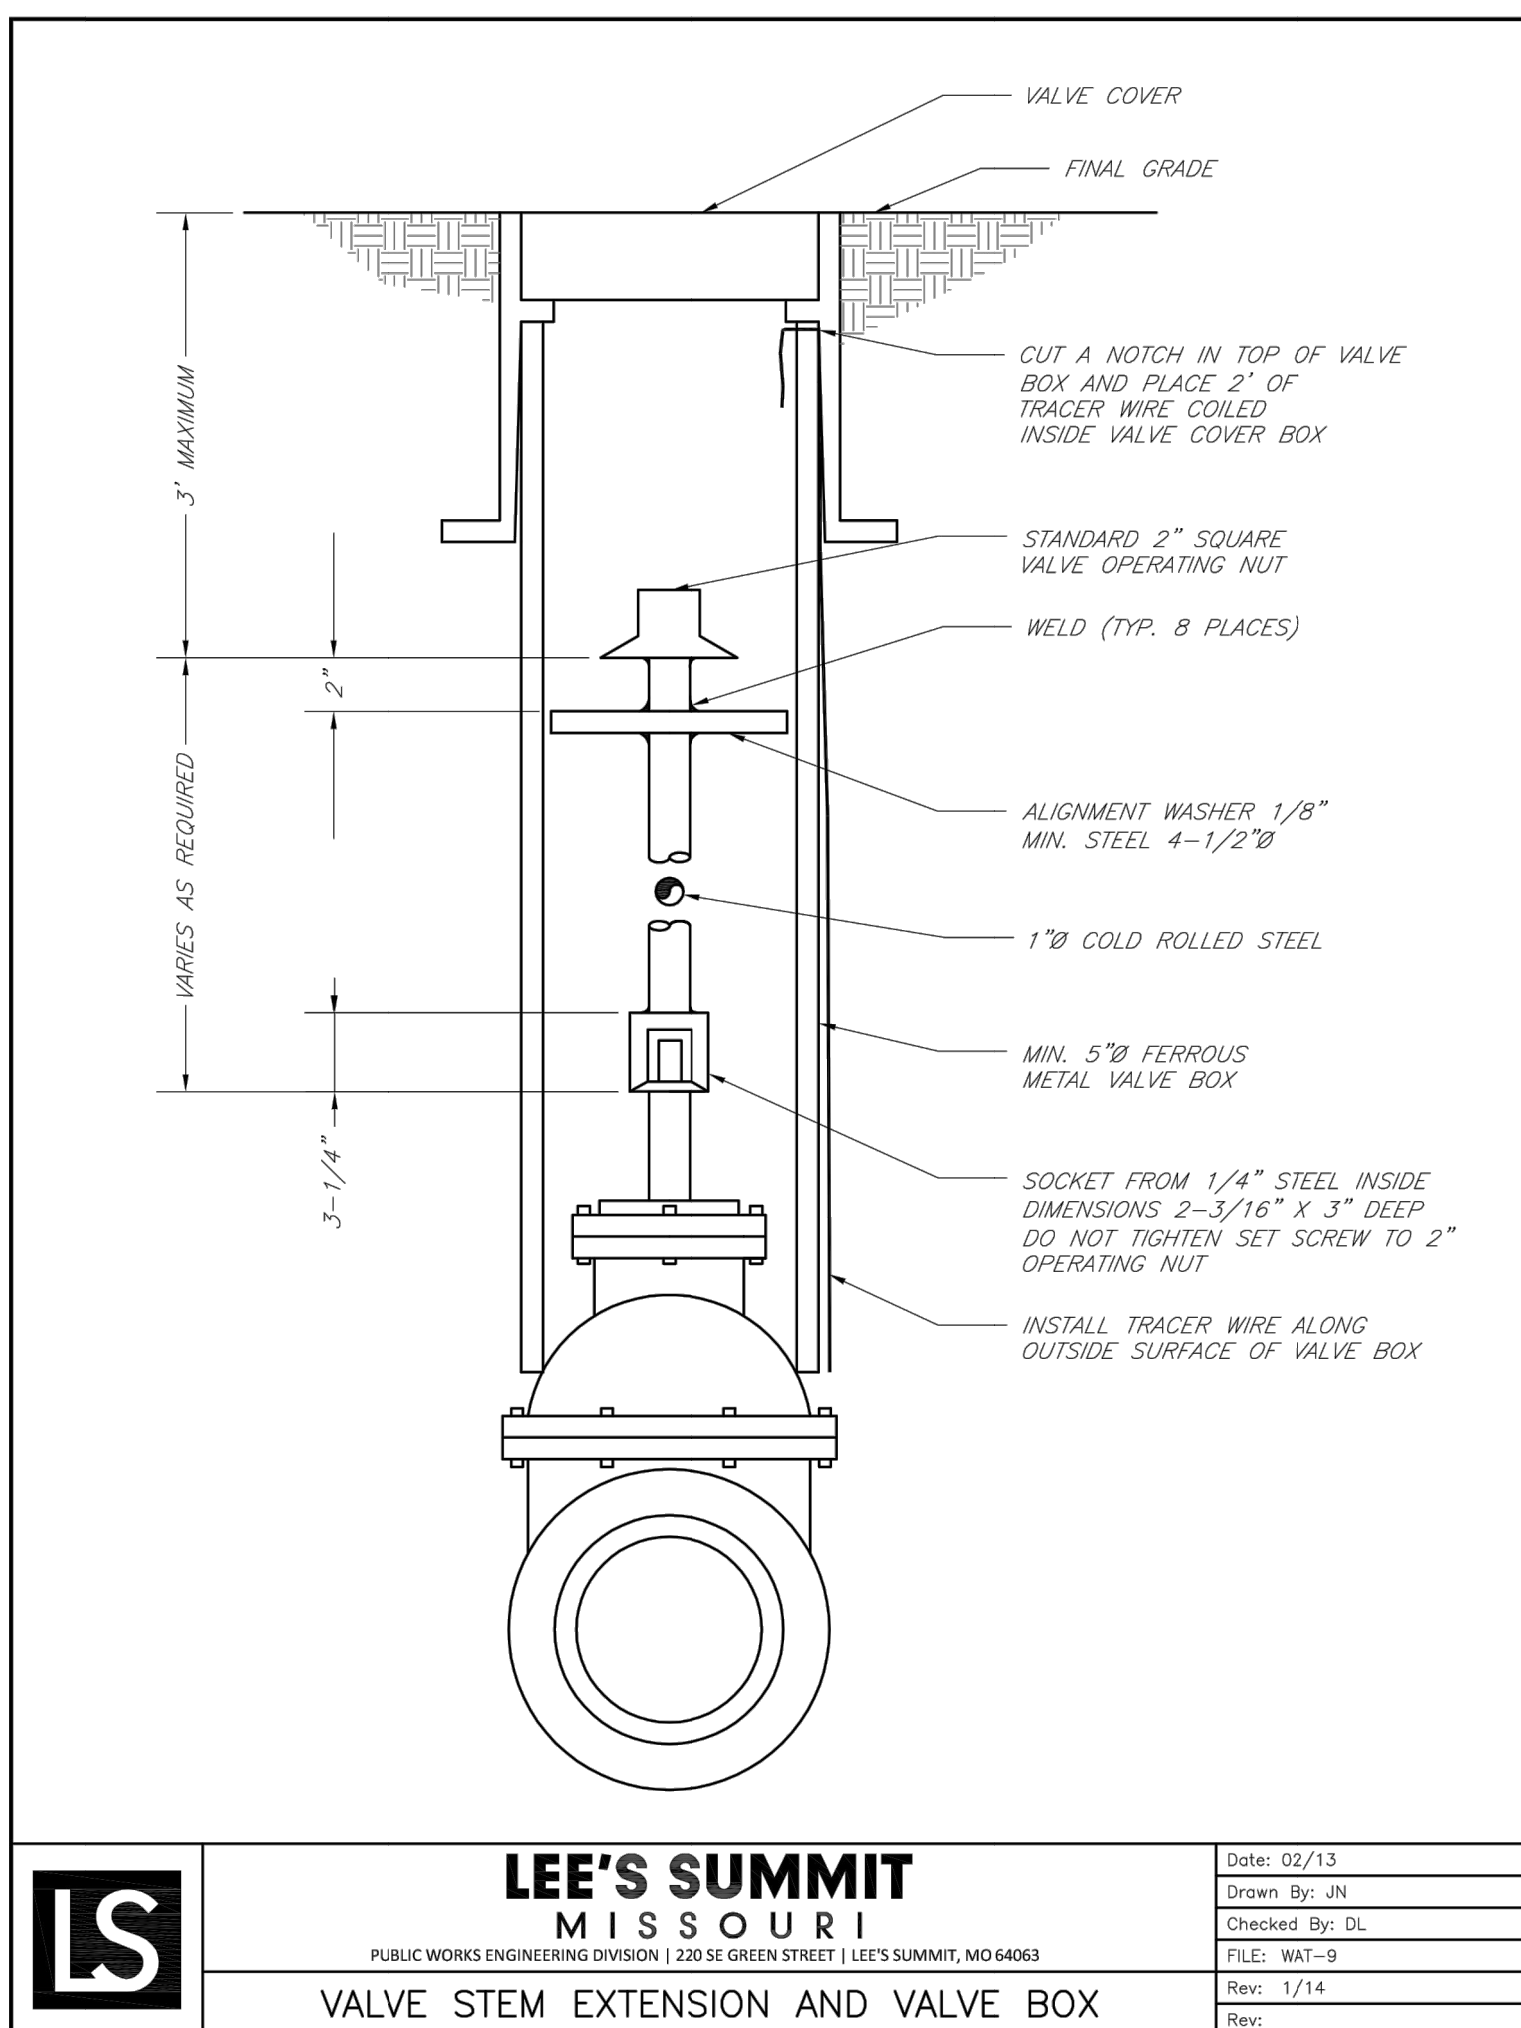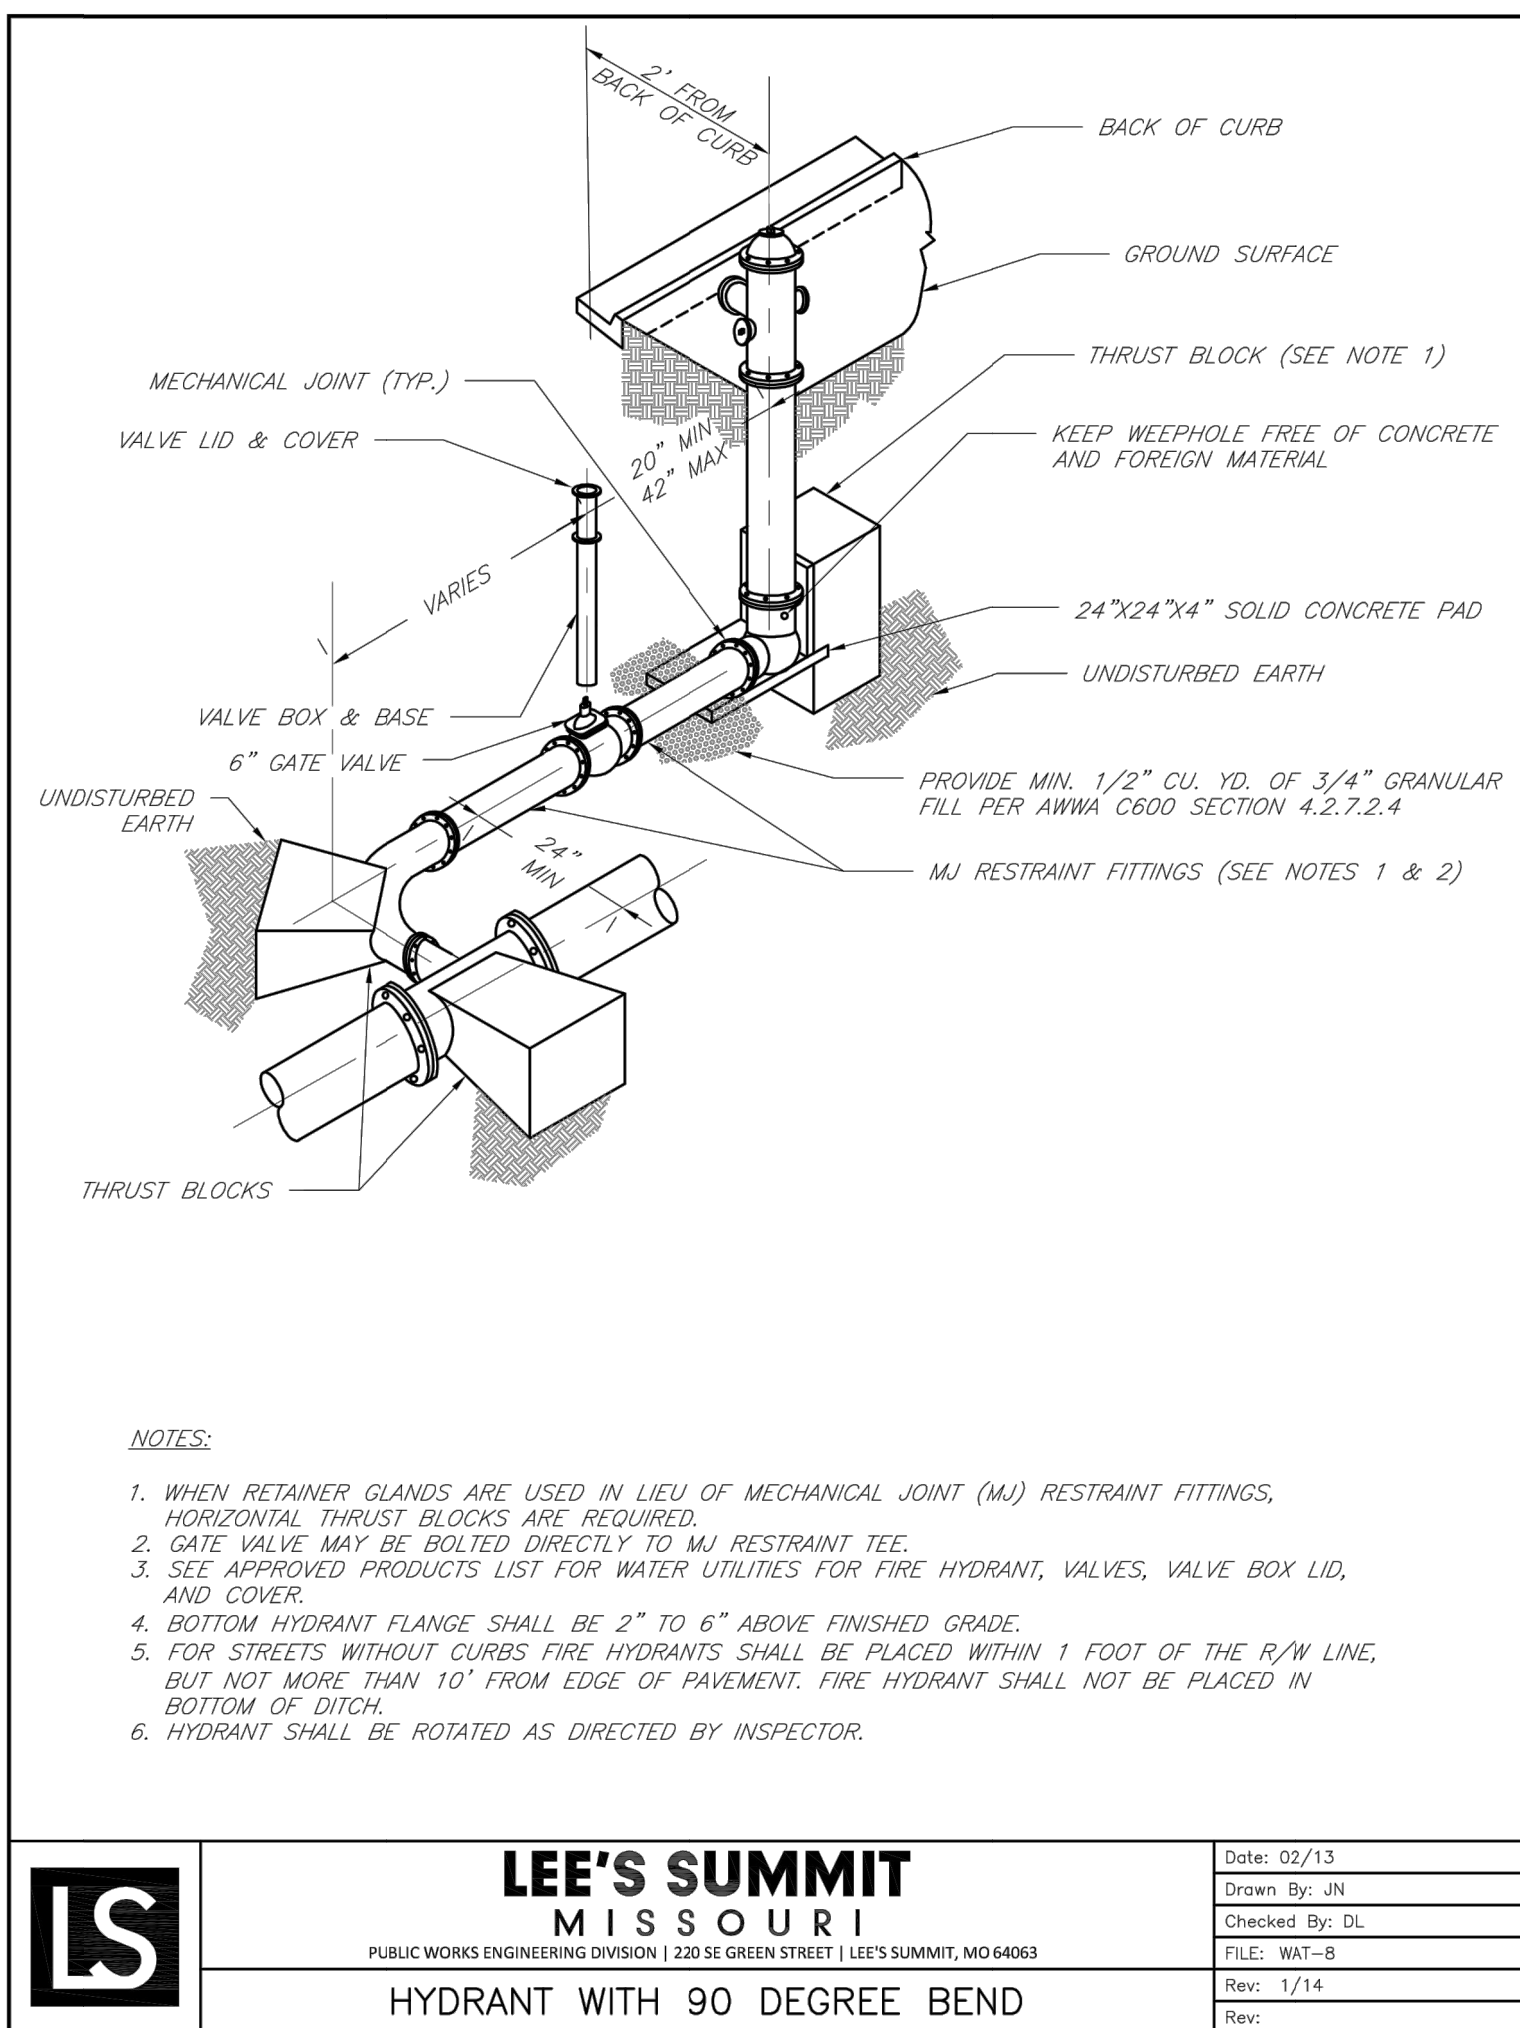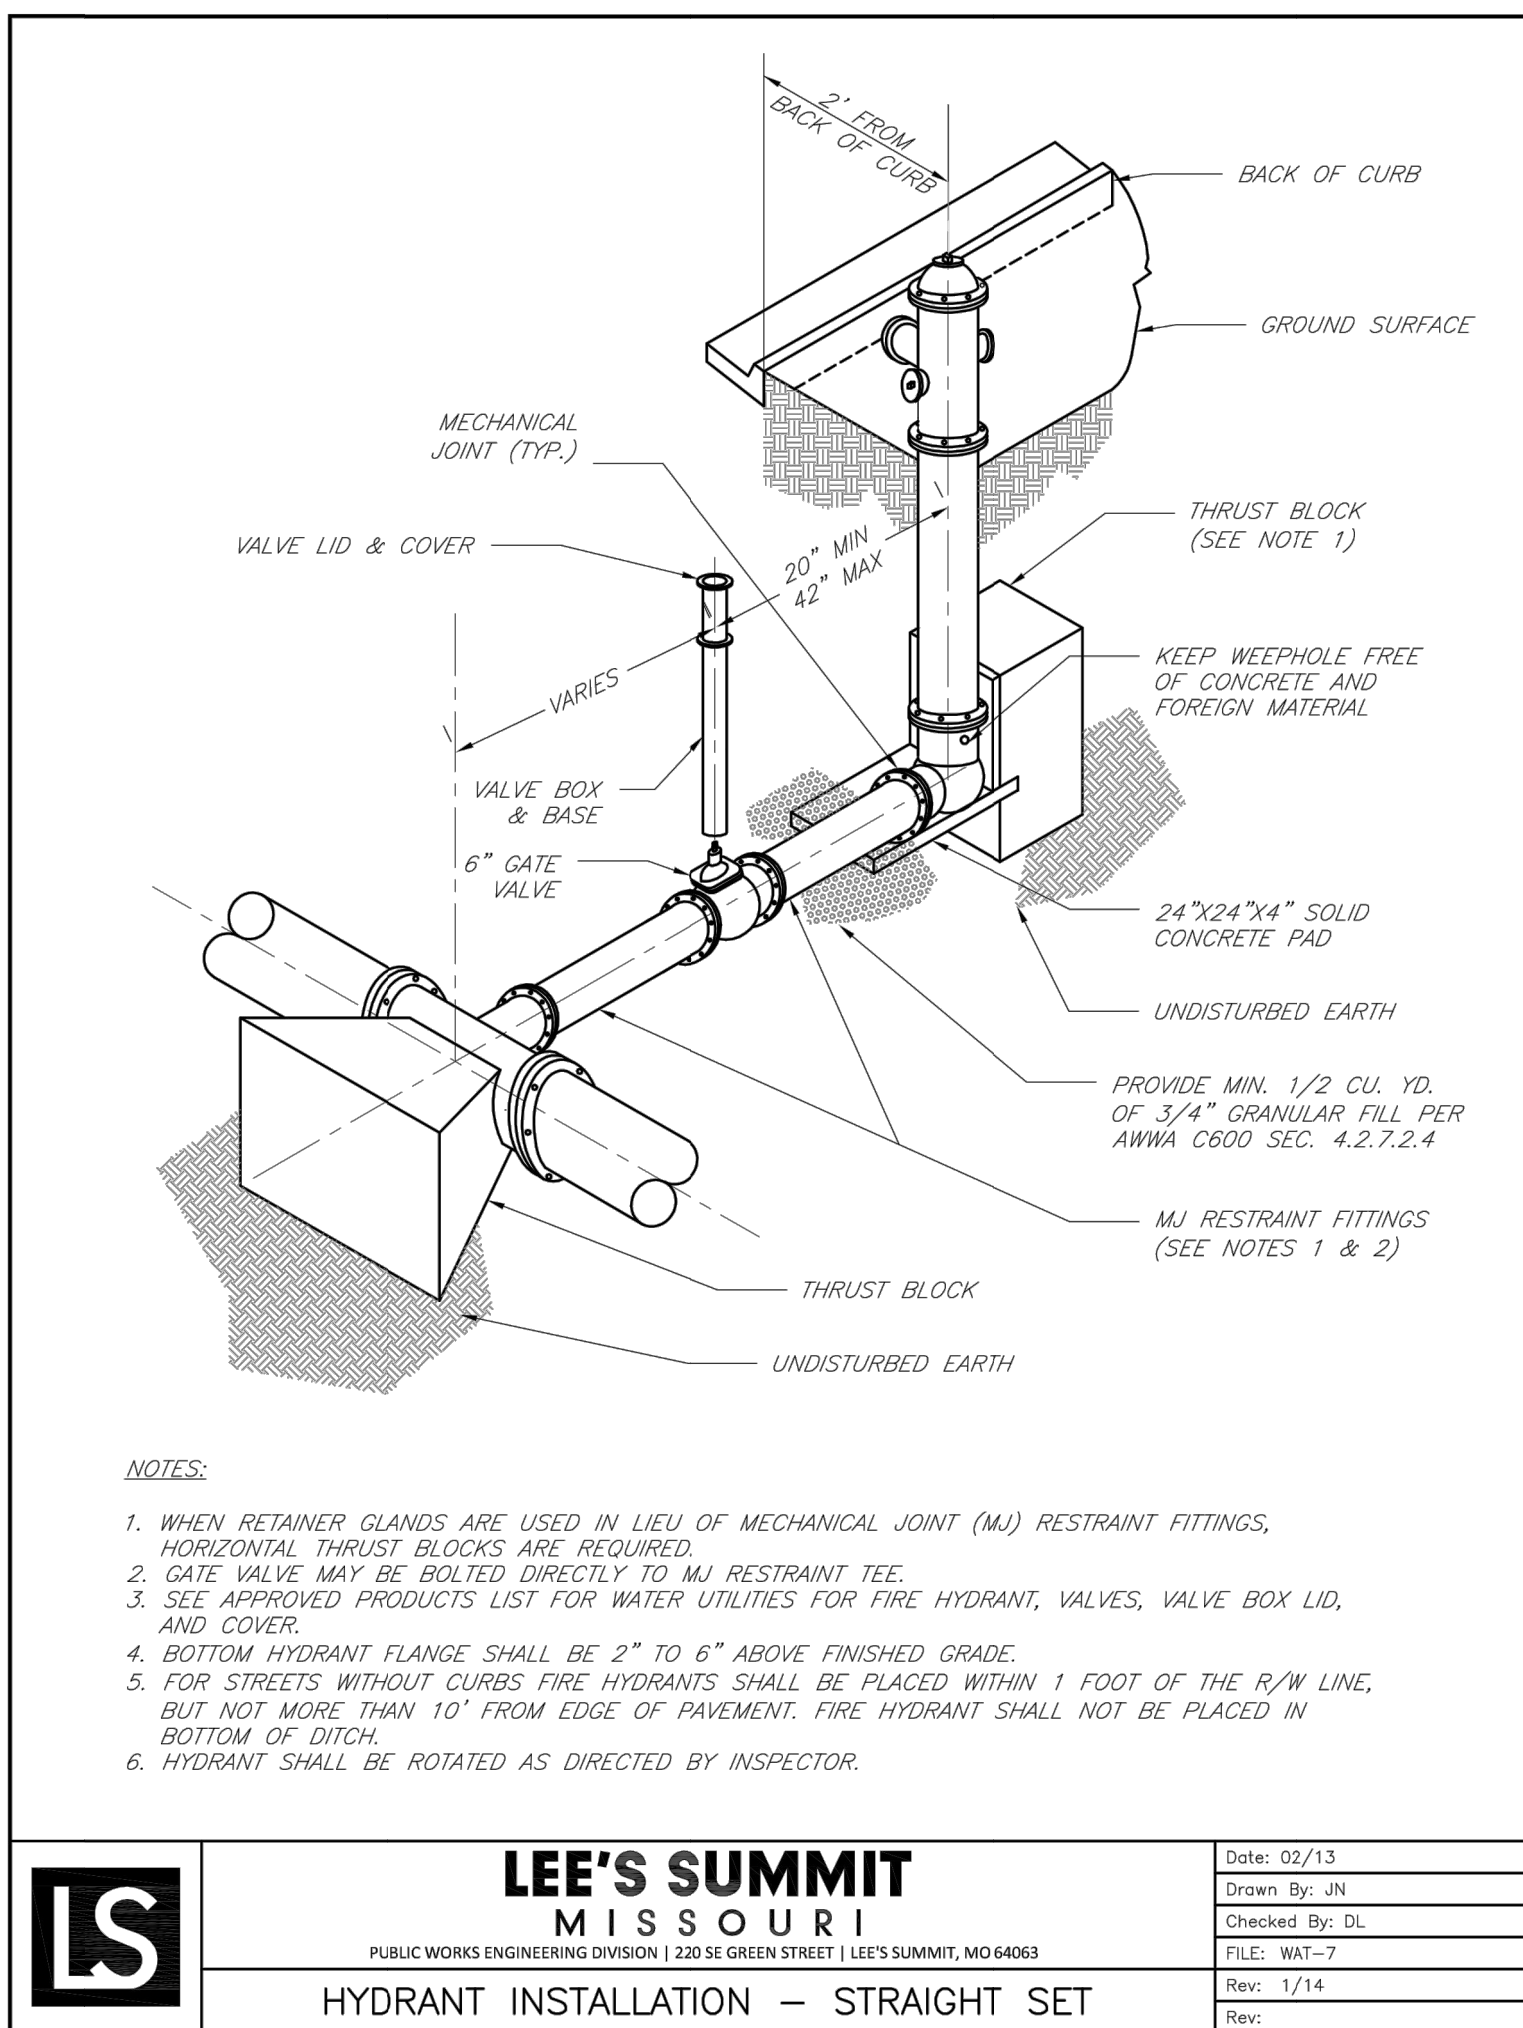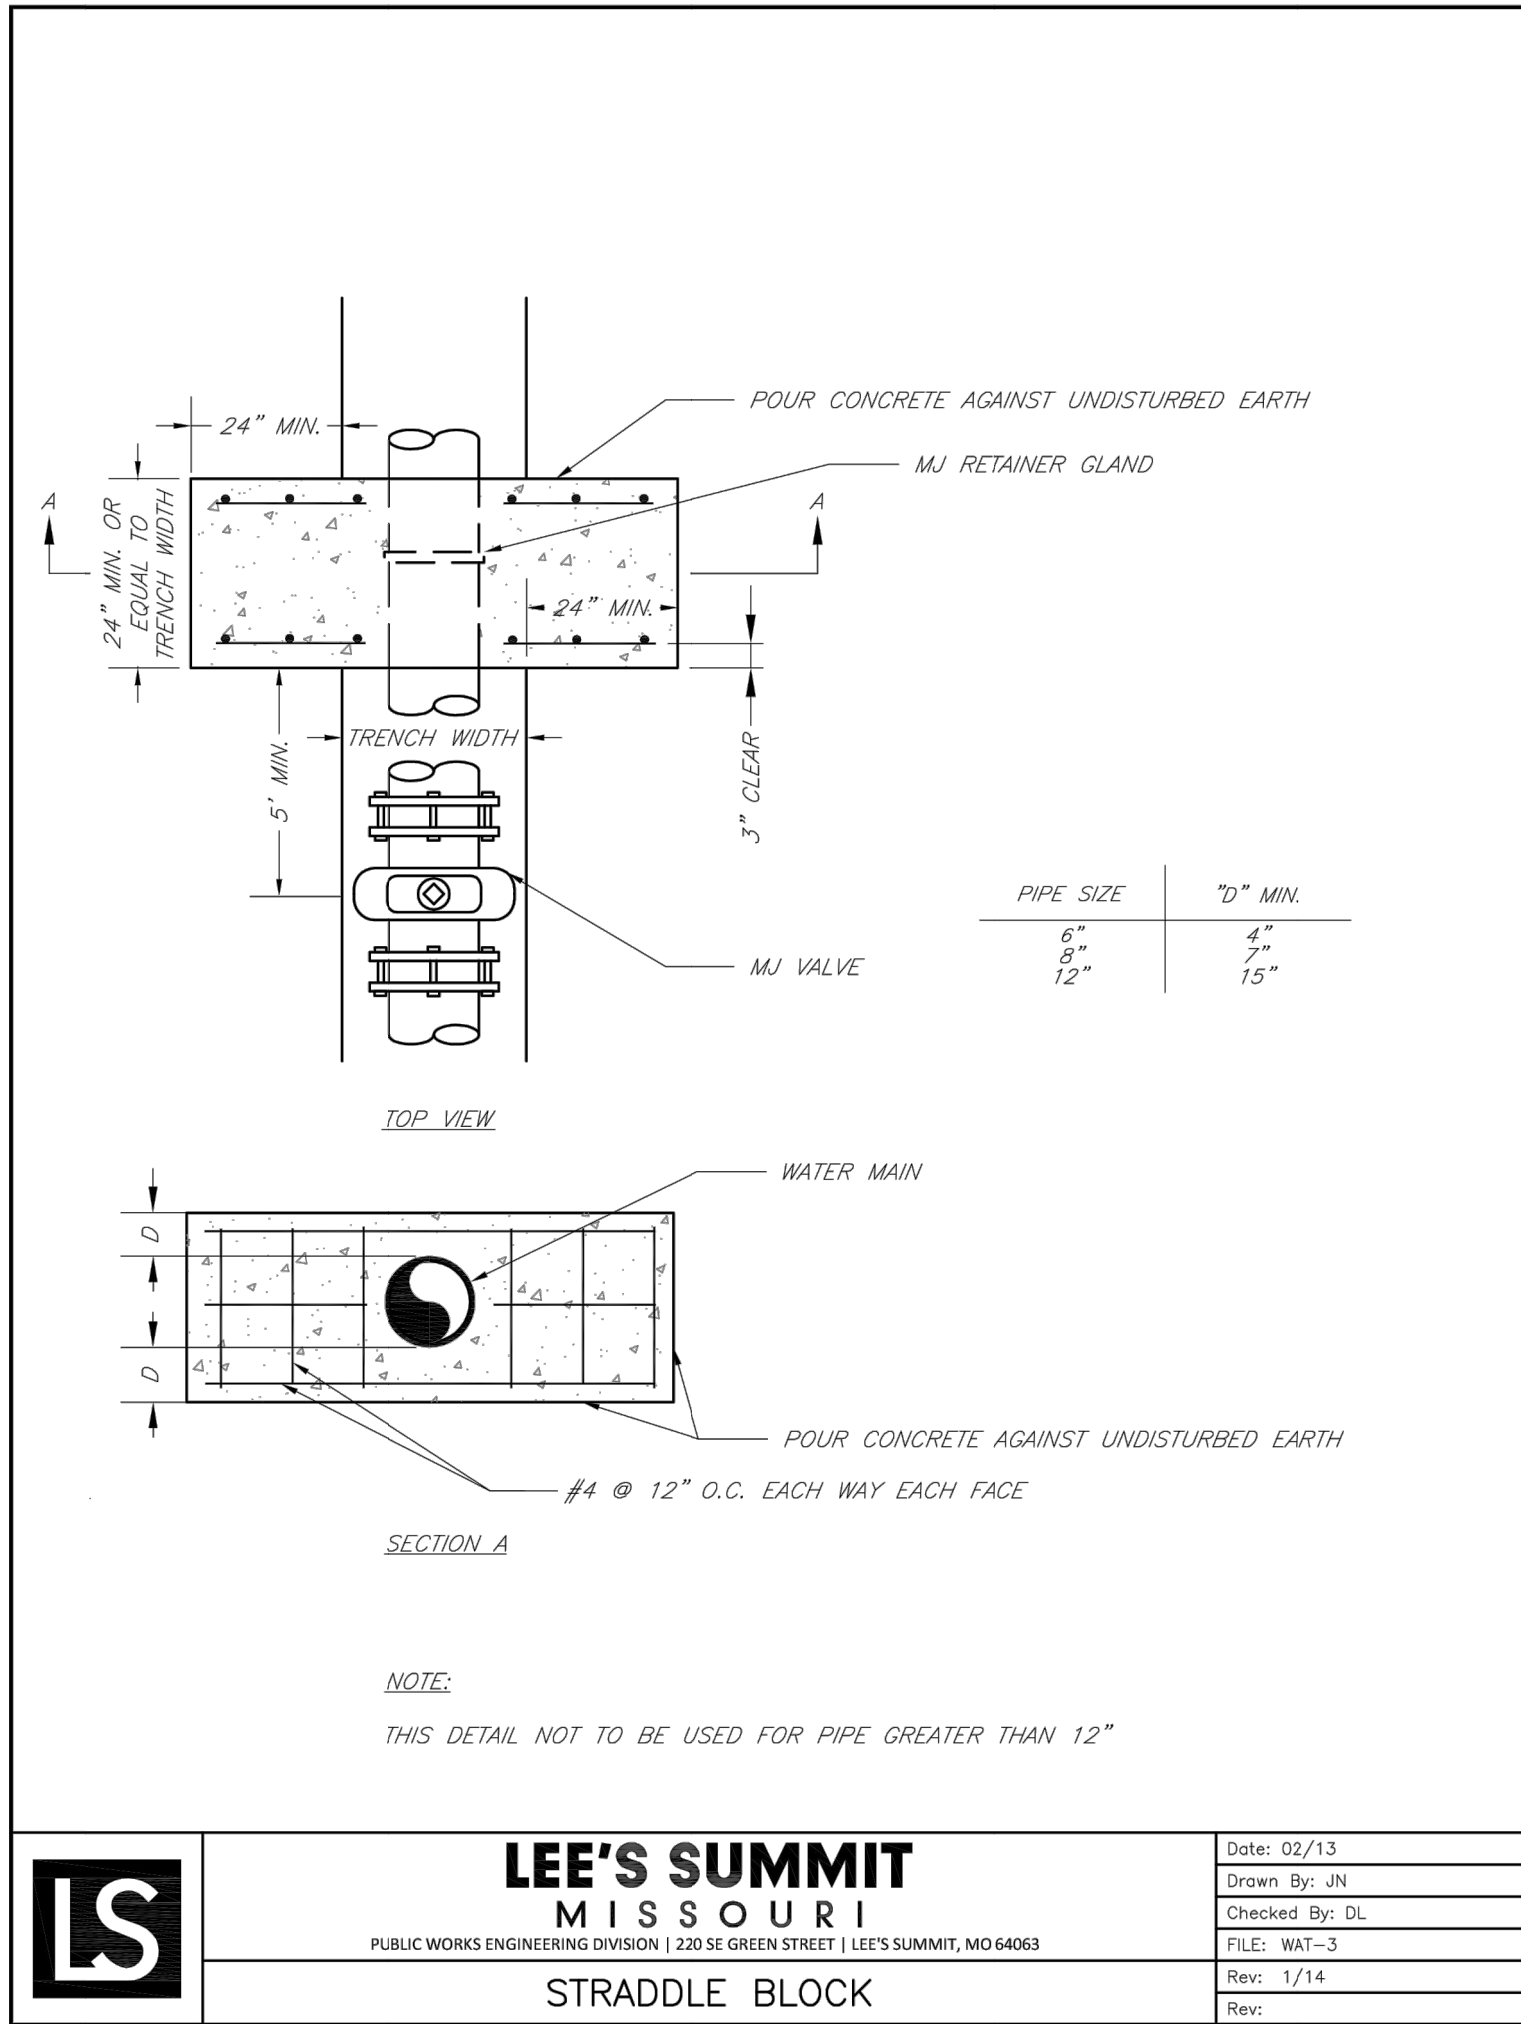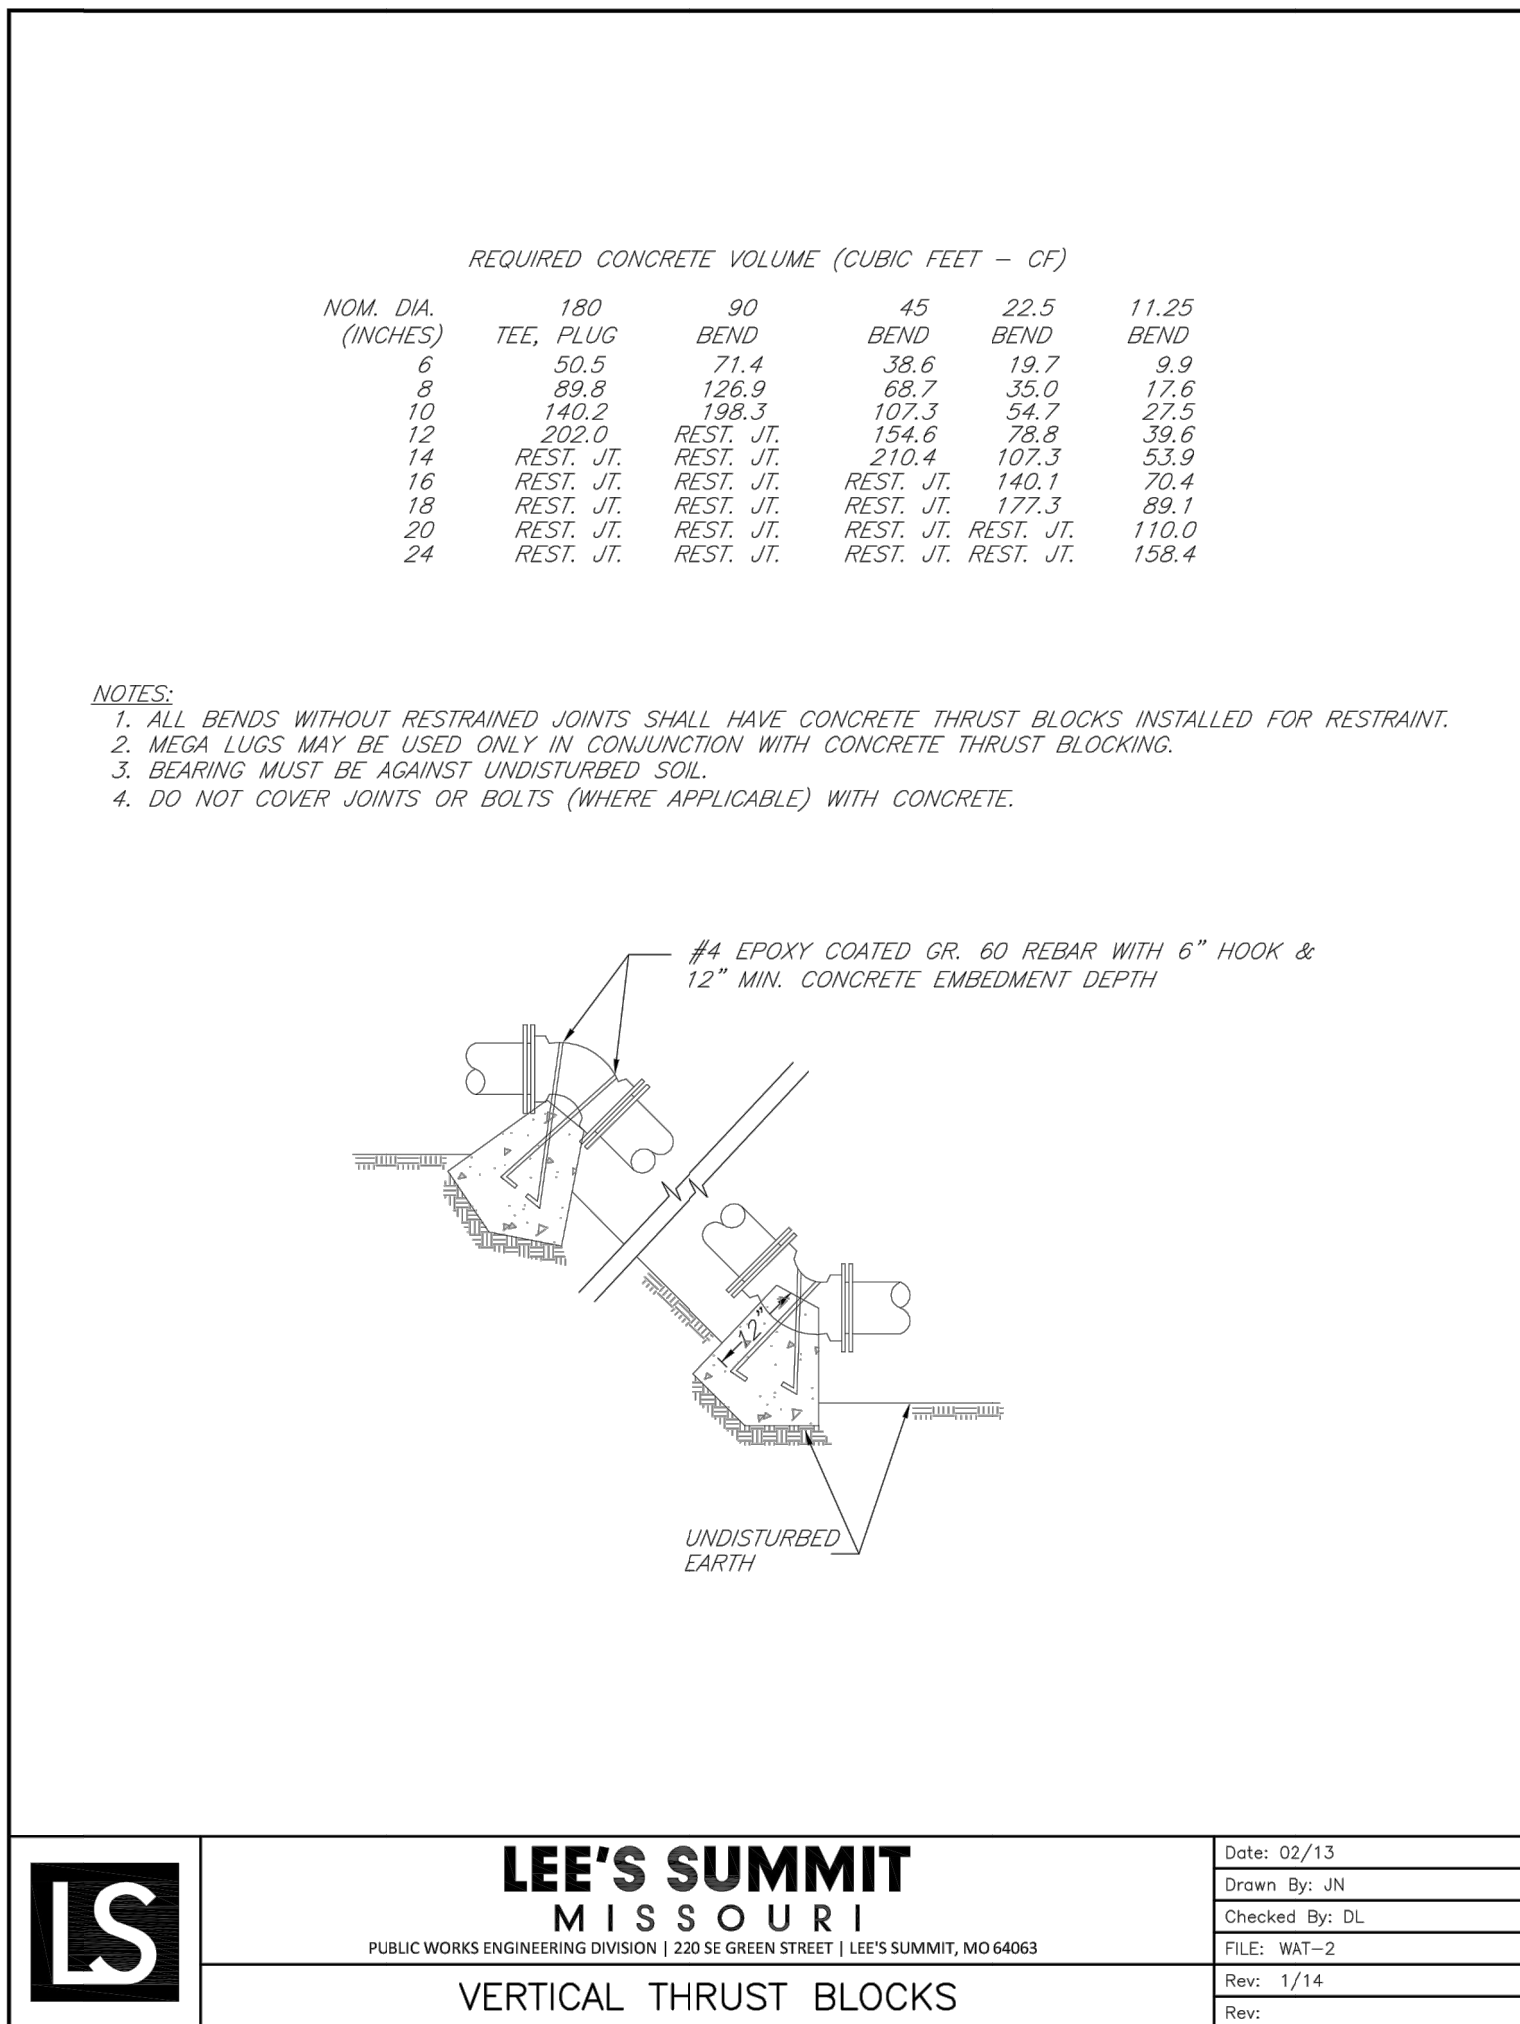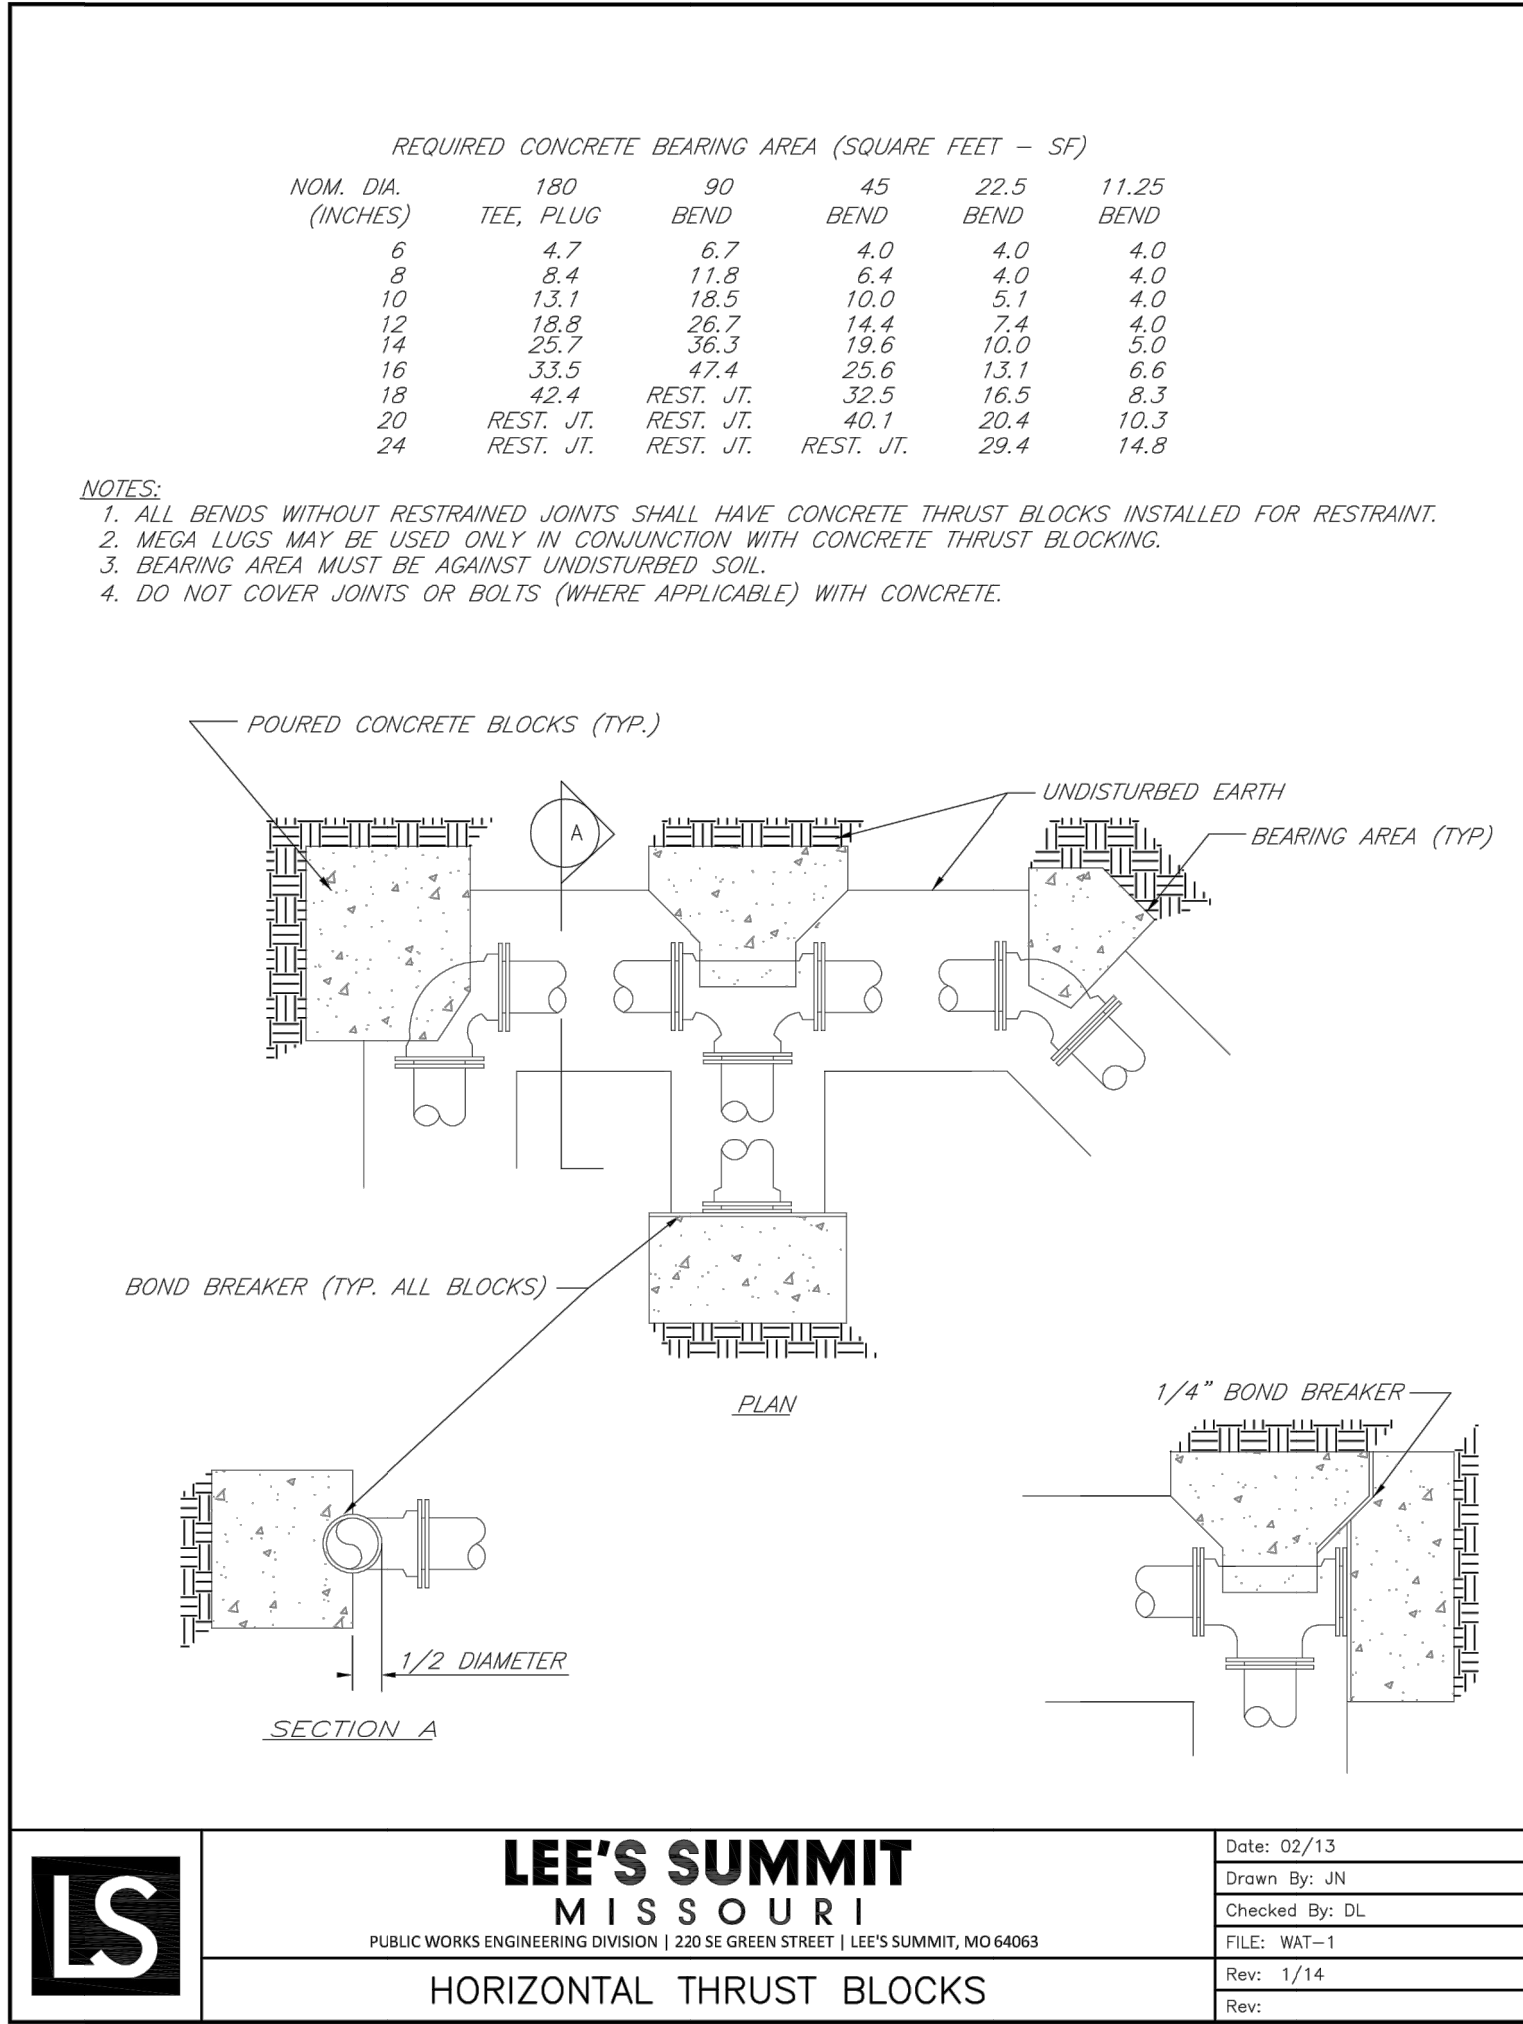

"AS-BUILT"

900.10
~~900.00~~ Indicates data replaced with "As-Built" information. All other data is as designed and has not been field verified.

Project: Monticello
Sheet Date: April 10, 2020

Matthew J. Schlicht
MO PE 2006019708
KS PE 19071
OK PE 25226

REVISIONS

2/4/2021 As-Built

C. 504

Professional Registration

Missouri
Engineering 2005002188-D
Surveying 2005000519-D

Kansas
Engineering E-1695
Surveying LS-218

Oklahoma
Engineering 6254

Nebraska
Engineering CA2821

Lee's Summit, Jackson County, Missouri

