

A-LIST

ORIGINAL DESIGN

400 SW Nichols St
Lee's Summit, MO 64063

Revision

May 11, 2021




Excel Light & Signs
1100 McApline Ave
Kansas City, KS 66105
dustan@excelkc.com

Phone: 913.492.4000
Fax: 913.800.8199
www.ExcelKC.com




STOREFRONT ELEVATION

SCALE: 3/16"=1'-0"

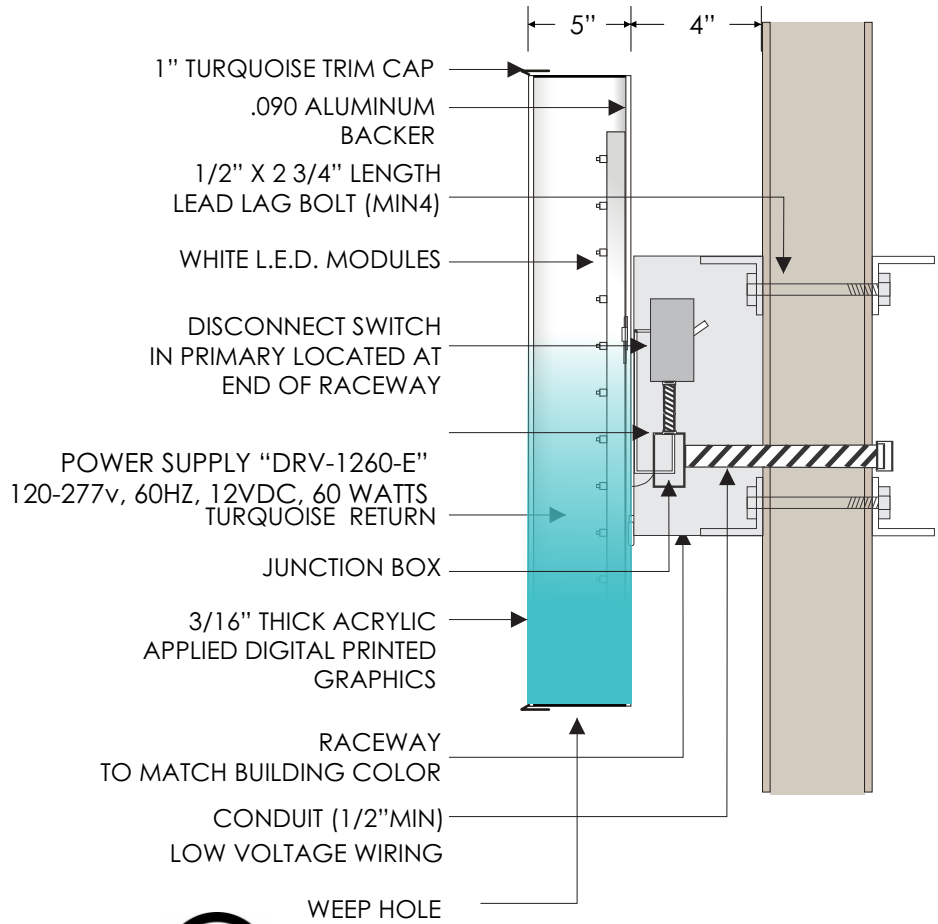

CHANNEL LETTERS
ATTACHED TO RACWAY
CONNECT TO EXISTING 20A CIRCUIT

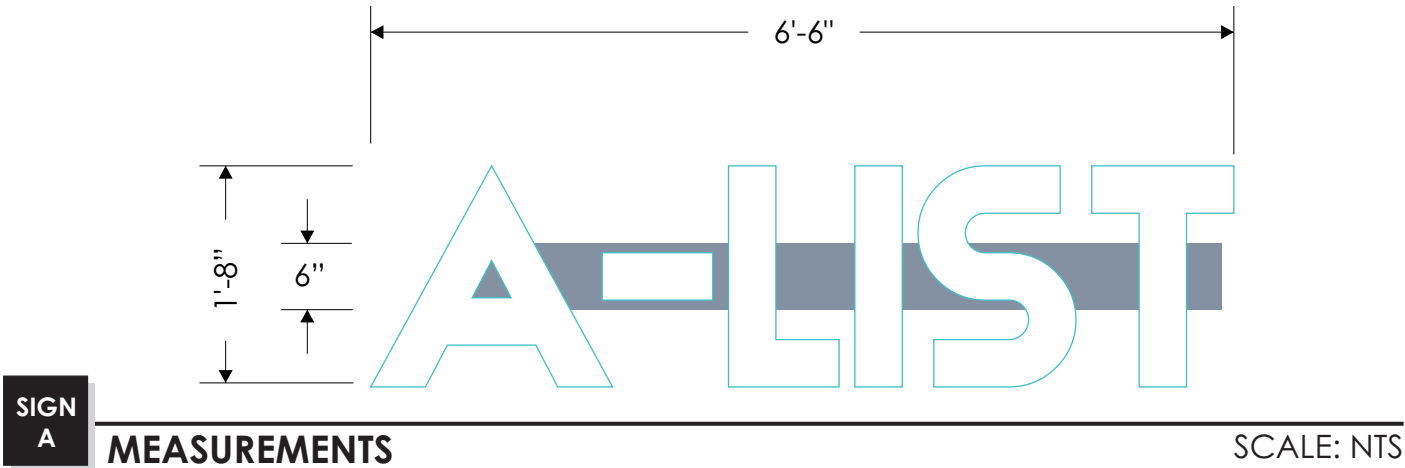

excel

LIGHTING & SIGNS

1100 McALPINE AVE KANSAS CITY, KS 66105
Ph: 913.492.4000 Fax: 913.800.8199
excelkc.com

CLIENT:
The A List
ADDRESS:

TICKET NO.:	DRAWING NO.:	DATE:
246965	20-029	5.6.21
PROJECT MANAGER:	DESIGNER:	
DUSTAN FANKHAUSER	DF	
ELECTRONIC FILE NAME:		
REVIEWED BY:	DATE:	

DATE:	REVISIONS:

CLIENT SIGNATURE & APPROVAL DATE:

excel

LIGHTING & SIGNS

THIS DESIGN IS THE SOLE PROPERTY OF EXCEL LIGHTING AND CAN NOT BE USED IN WHOLE OR PART WITHOUT WRITTEN CONSENT