


CHANNEL LETTERS

SCALE: NTS



STOREFRONT ELEVATION


SCALE: 3/16"=1'-0"

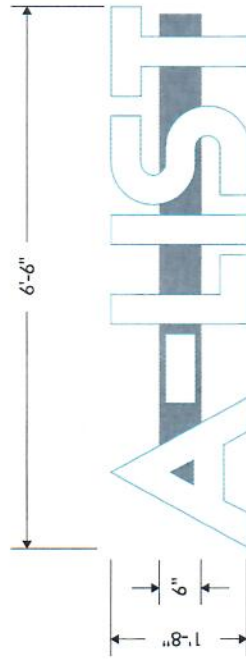

SIGN A

MEASUREMENTS

SCALE: NTS

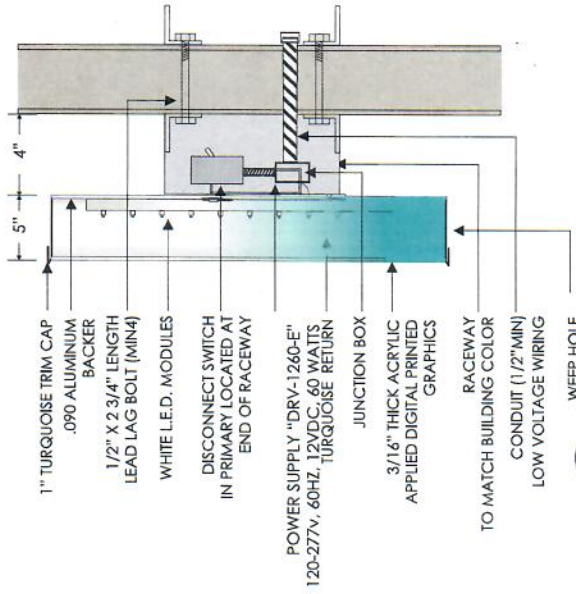

CHANNEL LETTERS
ATTACHED TO RACEWAY
CONNECT TO EXISTING 20A CIRCUIT

excel
LIGHTING & SIGNS
1100 McALPINE AVE KANSAS CITY, KS 66105
Ph: 913.492.4000 Fax: 913.800.8199
excelkc.com

CLIENT: The A List
ADDRESS:

TICKET NO.: 246555
PROJECT MANAGER: DUSTAN FANKHAUSER
ELECTRONIC FILE NAME:
REVIEWED BY:

DRAWING NO.: 20-029
DESIGNER: DF
DATE: 5.6.21

DATE: REVISIONS:

CLIENT SIGNATURE & APPROVAL DATE:

excel
LIGHTING & SIGNS

THIS DESIGN IS THE SOLE PROPERTY OF EXCEL LIGHTING AND CAN NOT BE USED IN WHOLE OR PART WITHOUT WRITTEN CONSENT