




DATE _____ REVISIONS _____

Power Life
940 NW Pryor Rd
Lee's Summit, MO 64081



Aegis Fire Protection, LLC
Corporate: 11936 W. 119th St. #262 Overland Park, KS 66213
Phone: 913-823-0343 Fax: 913-322-4475
Email: info@aegisfirepro.com



JOB NO.		JOB NAME:	
Power Life		Tenant Finish	
FIRE ALARM PLAN			
AHJ:	CITY & OWNER		
SCALE:	1/8"=1'-0"		
DESIGNED BY:	RMS		
CHECKED BY:	GT		
DATE:	5-25-21		
SHEET NO.		F1 1 OF 1	

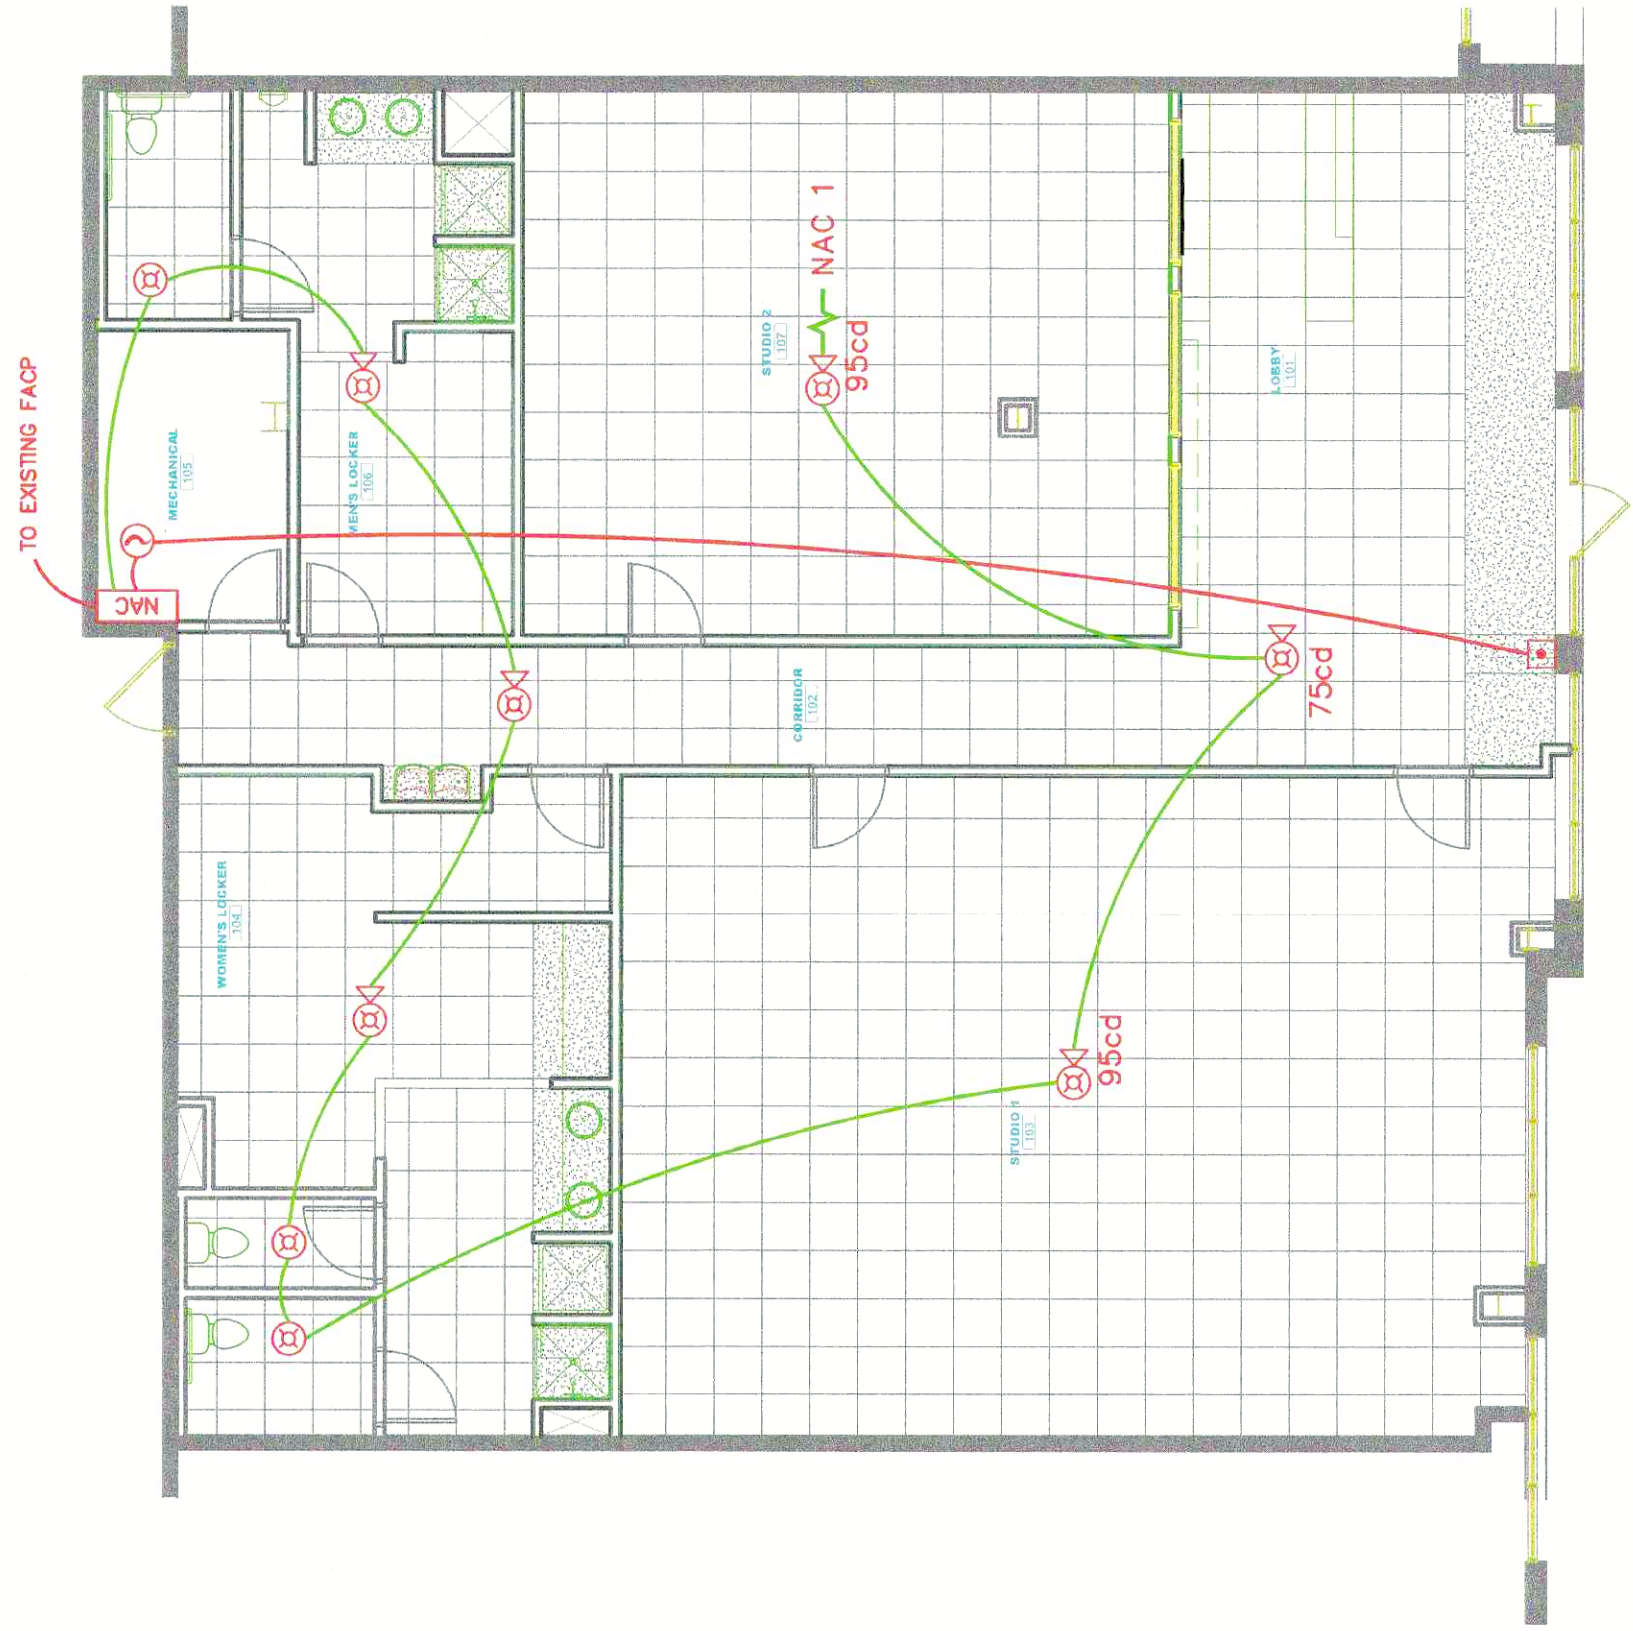

1 FIRE ALARM PLAN
1/8" = 1'0"

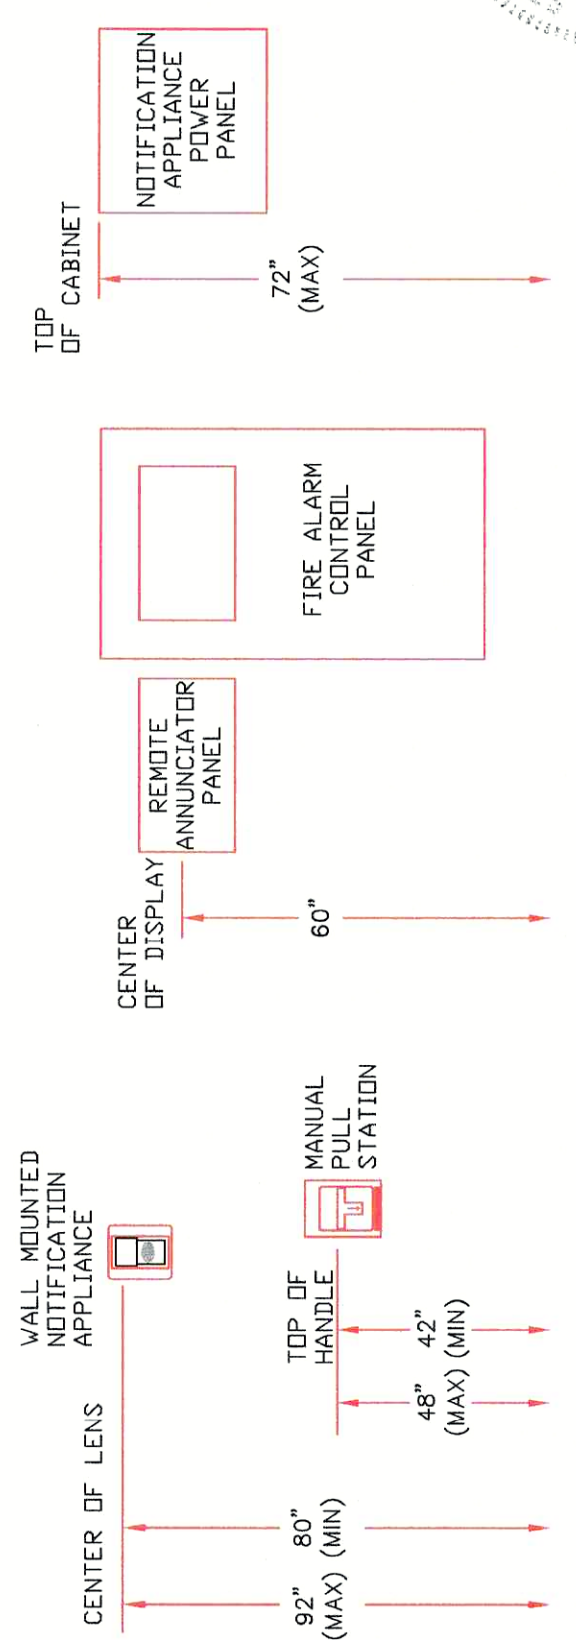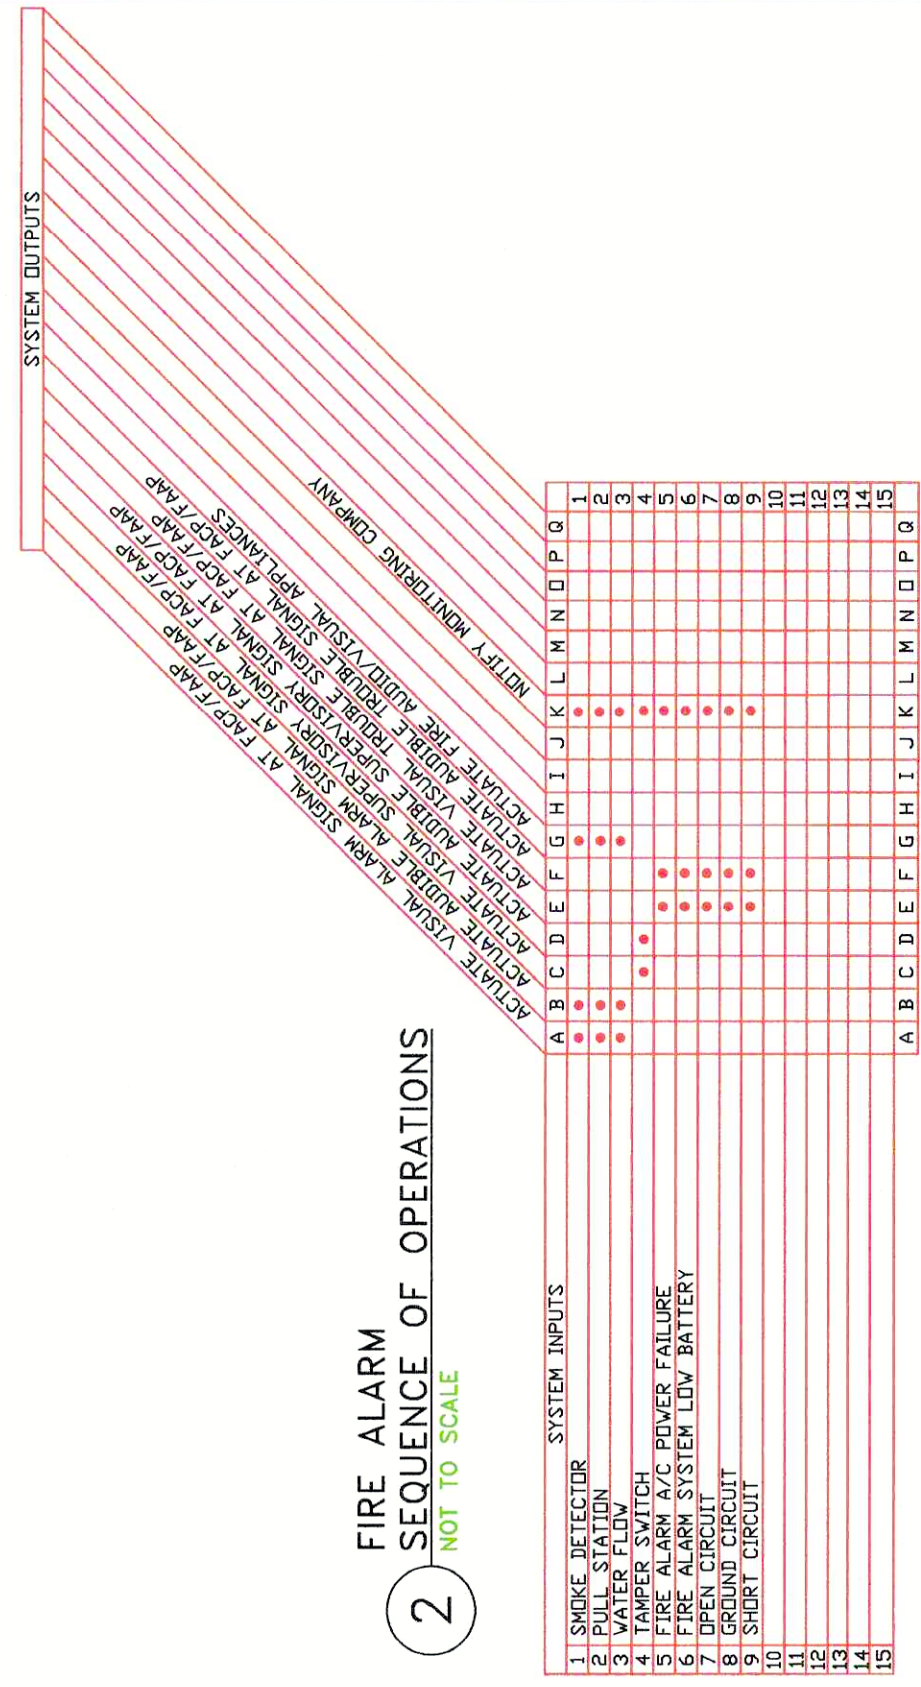

3 WALL MOUNTED EQUIPMENT FIRE ALARM INSTALLATION HEIGHTS/DETAILS

[illegible]

WIRING LEGEND

- 18-2 FPLP WIRE (DATA)
- 14-2 FPLP WIRE (A/V)

GENERAL NOTES

1. ALL STROBES HAVE A 15 CANDELLA RATING UNLESS NOTED OTHERWISE
2. CONNECT DATA WIRE TO EXISTING FIRE ALARM SYSTEM