

	DATE	REVISIONS

Club Pilates
940 NW Pryor Rd
Lee's Summit, MO 64081


Aegis Fire Protection, LLC
Corporate: 11936 W. 119th St. #262 Overland Park, KS 66213
Phone: 913-825-0343 Fax: 913-322-4475
Email: info@aegisfirepro.com




JOB NO.	CITY & OWNER
JOB NAME	SCALE: $1/8"=1'-0"$
Club Pilates	DESIGNED BY: RMS
Tenant Finish	CHECKED BY: CT
	DATE: 6-10-21
	SHEET NO.
	F A I
	1 OF 1



1 FIRE ALARM PLAN
1/8" = 1'0"

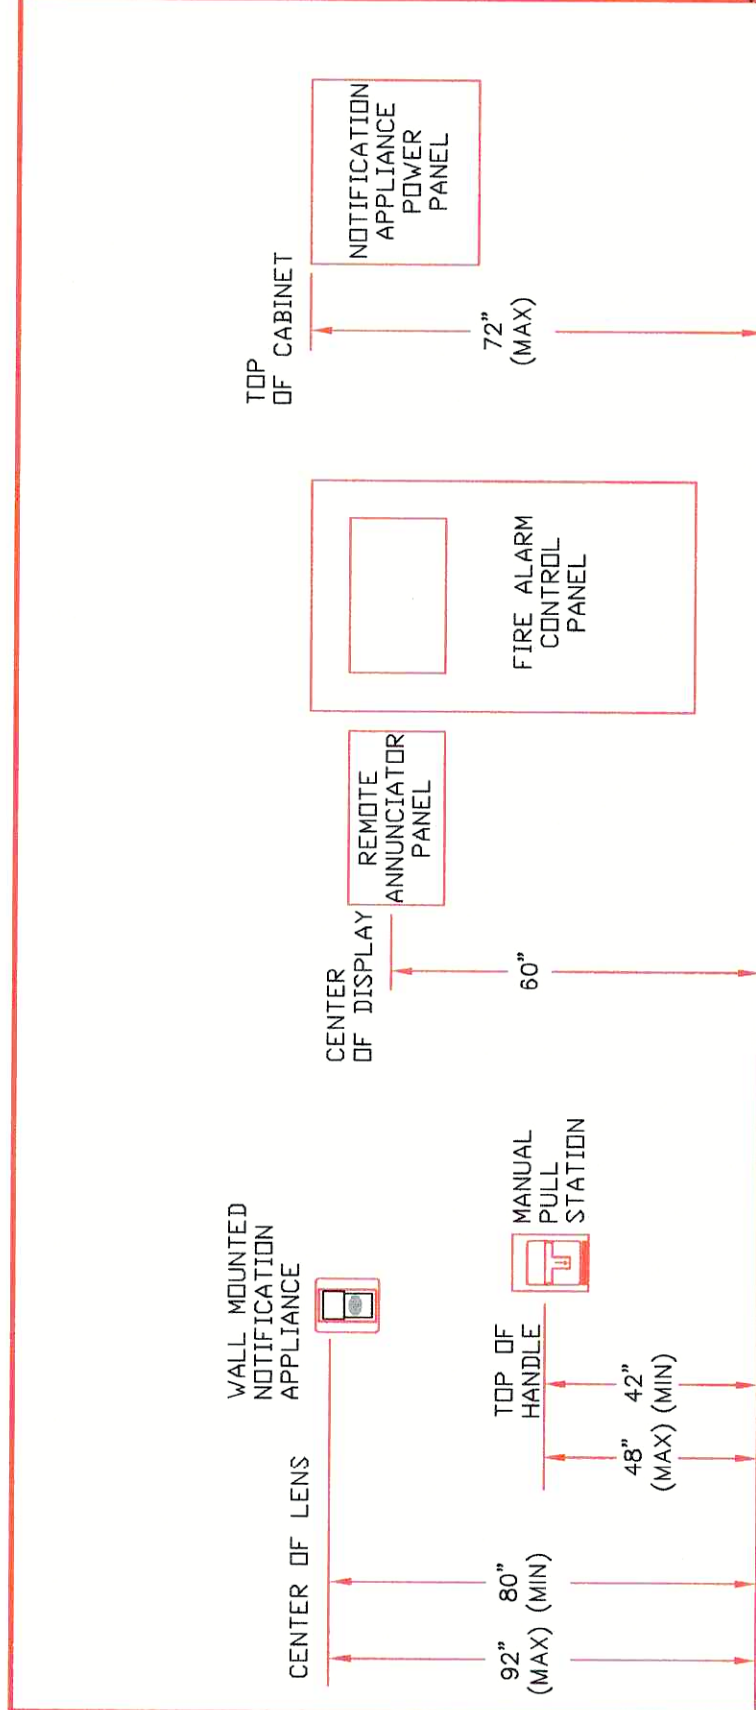

3 WALL MOUNTED EQUIPMENT
FIRE ALARM INSTALLATION HEIGHTS/DETAILS
NOT TO SCALE

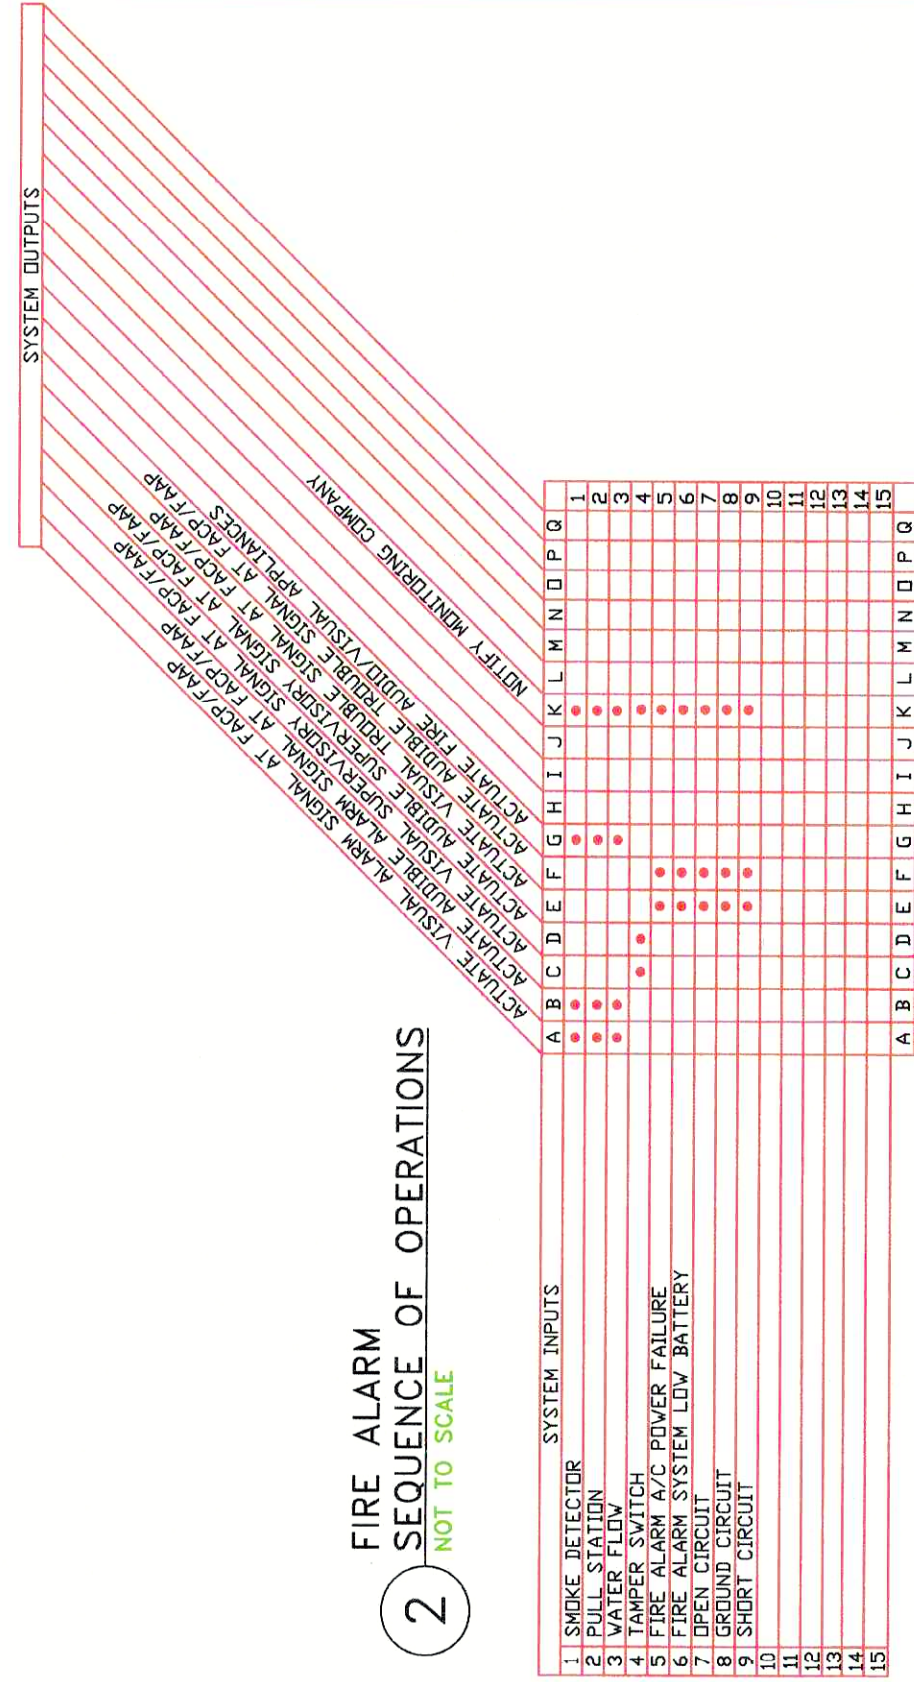

WIRING LEGEND

- 18-2 FPLP WIRE (DATA)
- 14-2 FPLP WIRE (A/V)

GENERAL NOTES

1. ALL STROBES HAVE A 15 CANDELLA RATING UNLESS NOTED OTHERWISE
2. CONNECT DATA WIRE TO EXISTING FIRE ALARM SYSTEM

FIRE ALARM LEGEND		
SYMBOL	DESCRIPTION	MOUNTING
NAC	N.A.C. POWER EXTENDER	WALL
②	AREA SMOKE DETECTOR	CEIL./WALL
⬢	FIRE ALARM MANUAL STATION	WALL
Ⓚ	COMB. F.A. HORN & VISUAL SIGNAL	CEILING
Ⓢ	F.A. VISUAL SIGNAL	CEILING
↘	END OF LINE RESISTOR	