
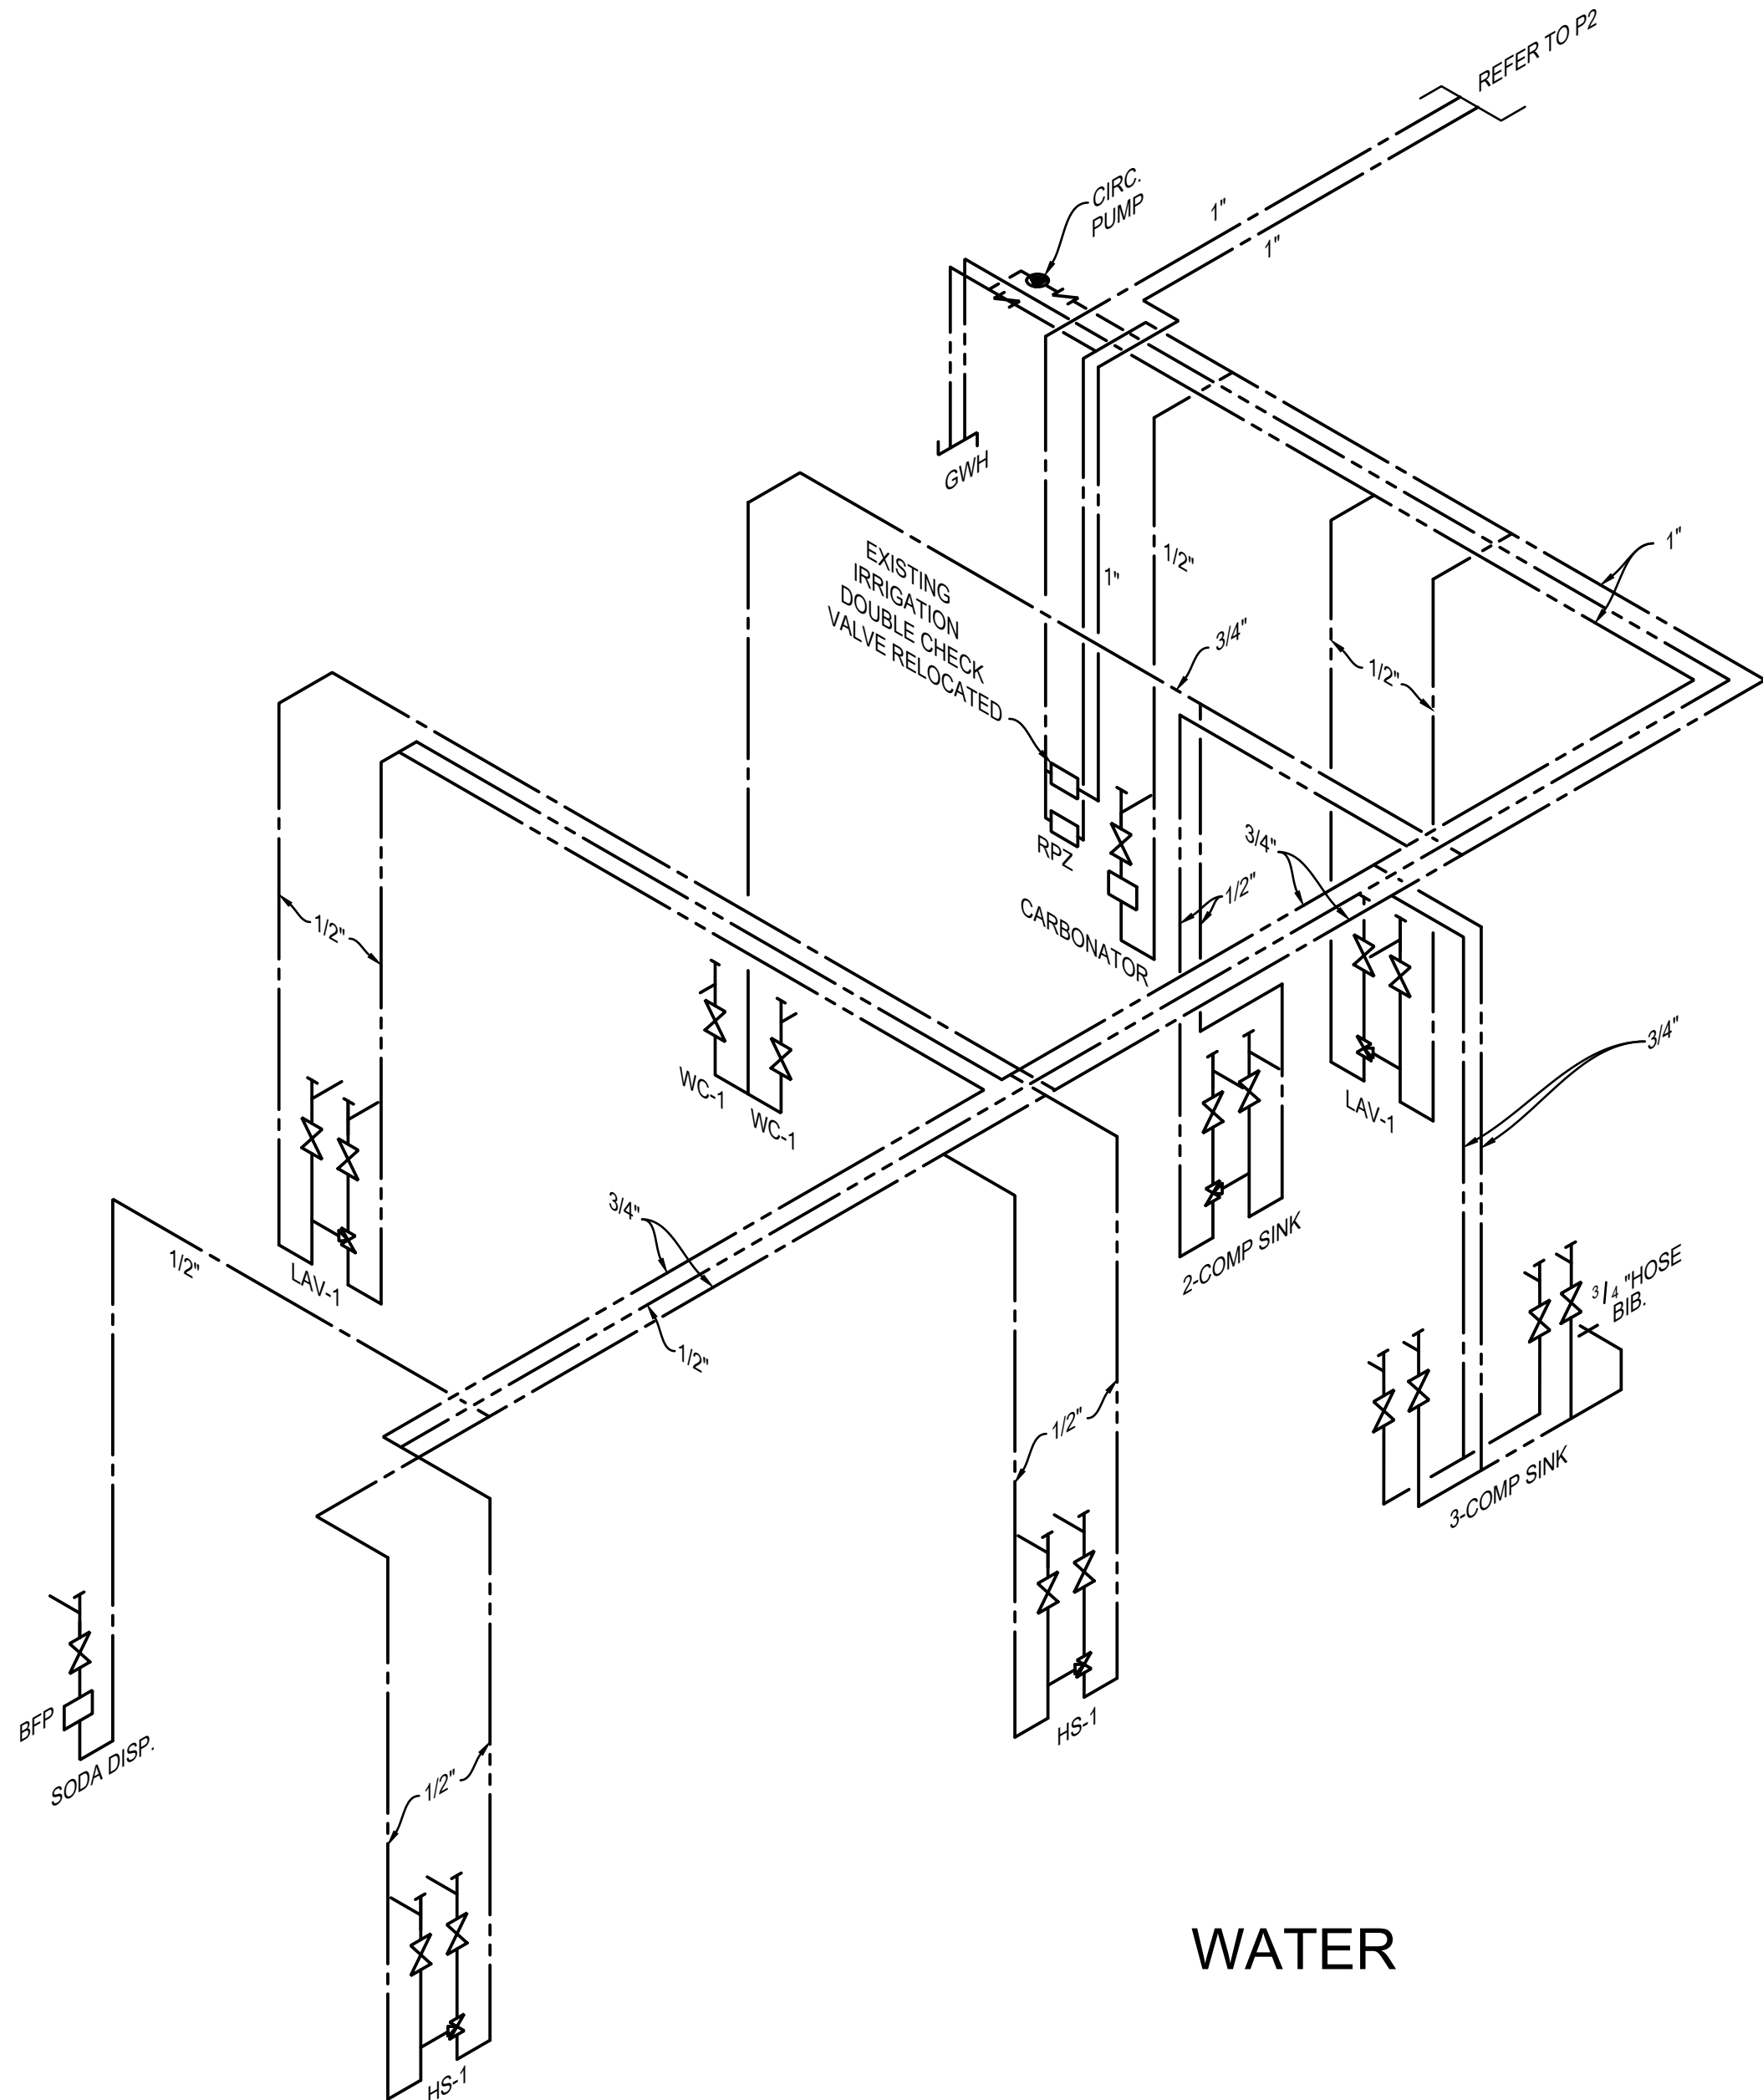


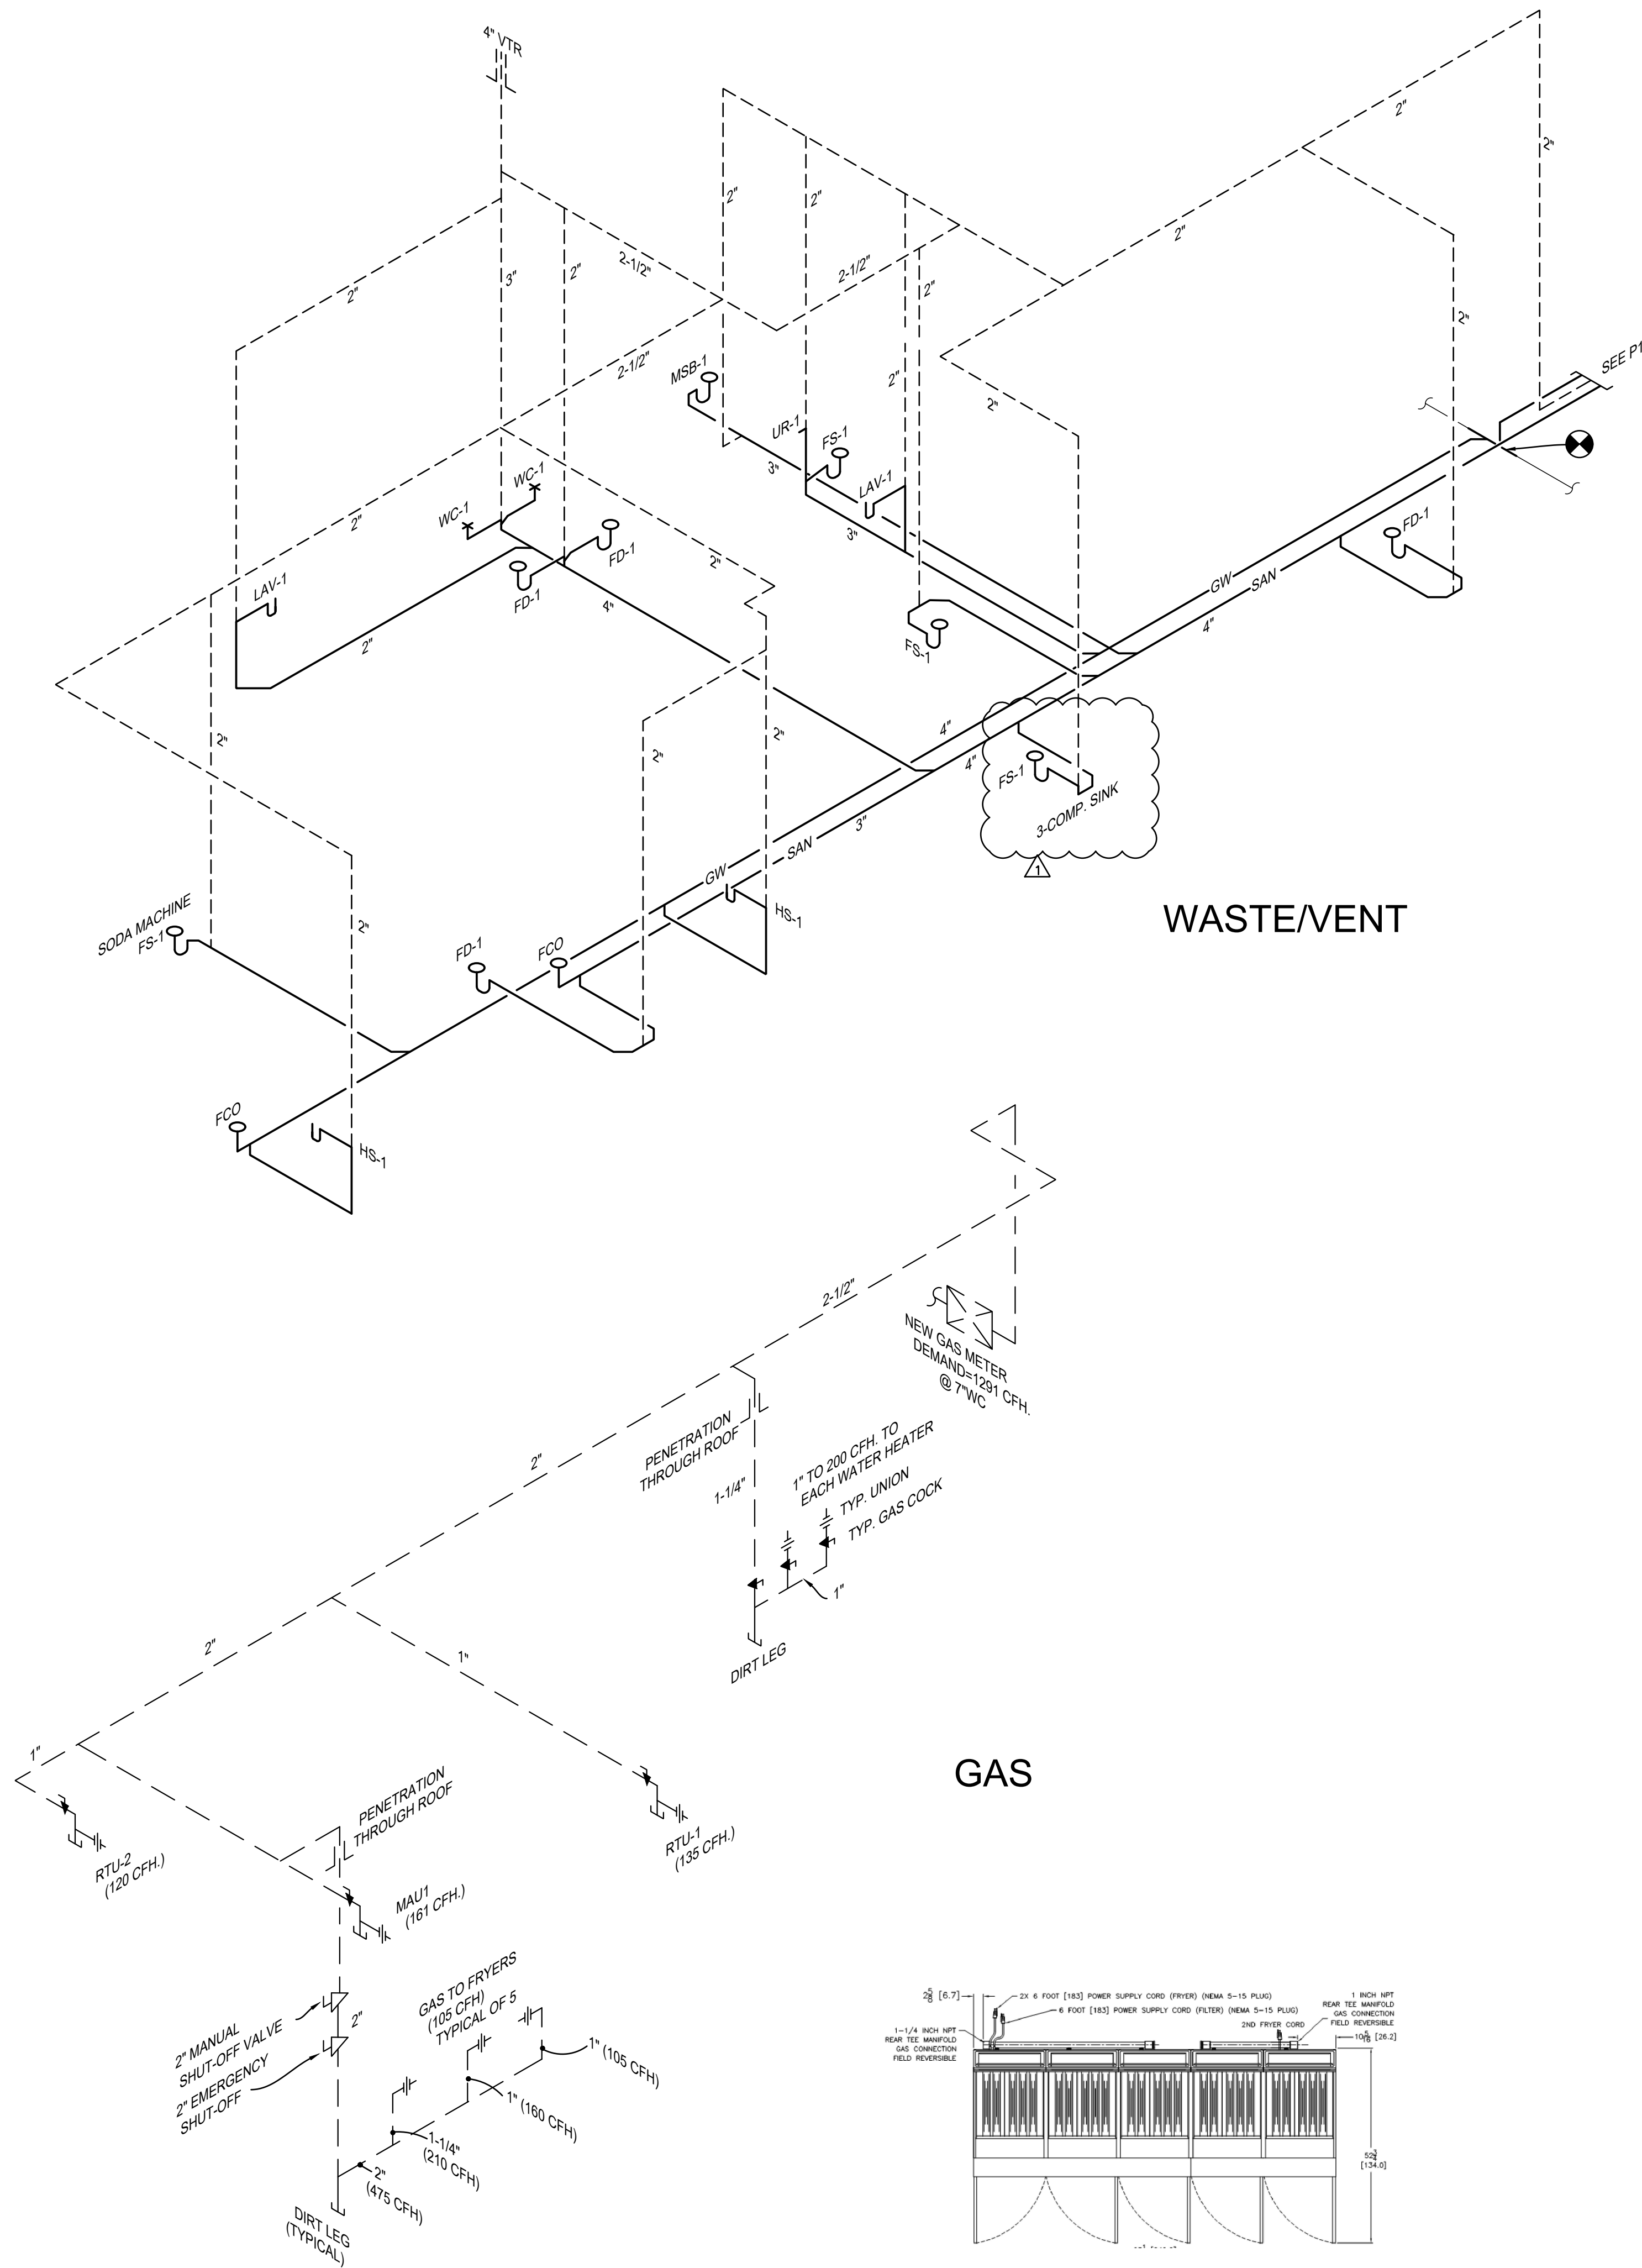

PLUMBING RISER DIAGRAMS
SCALE: NONE

CONSULTANT:

CASE

Engineering Inc.

796 Menz Court
St. Louis, MO 63026
T 636.549.1600
F 636.549.1730

CERTIFICATE OF AUTHORITY NO. 001498

CLIENT:

5501 LBJ FREEWAY, 5TH FLOOR
DALLAS, TX 75240
TELEPHONE: (972) 686-6500
FAX: (972) 686-650

DISCLAIMER:

THESE DRAWINGS, IDEAS, SPECIFICATIONS AND DESIGNS ARE EXCLUSIVE PROPERTY OF WINGSTOP RESTAURANTS, INC. NO PART OF THESE DRAWINGS MAY BE COPIED, REPRODUCED, OR OTHER STRUCTURES BUILT FROM SUCH WITHOUT THE WRITTEN CONSENT OF WINGSTOP RESTAURANTS, INC.

COPYRIGHT © 2021
WINGSTOP RESTAURANTS, INC.
ALL RIGHTS RESERVED

PROJECT INFORMATION:

WING-STOP

STORE NUMBER: GL#Y715
HALLBUSTER SHOPS
1041 N.E. SAM WALTON LANE
LEE'S SUMMIT, MO 64086

SEAL:

STATE OF MISSOURI

DARRELL R. CASE

NUMBER
PE-23303

PROFESSIONAL ENGINEER

7/8/21
DATE

PROJECT NO.: 2021-0158

DRAWN BY: JJV

CHECKED BY: DRC

ISSUE: DATE:

FOR PERMIT & BID 06-10-21

REVISION: DATE:

BLDG. COMMENTS 07-08-21

PROJECT LOCATION:
LEE'S SUMMIT, MO

SHEET NUMBER:
P3