


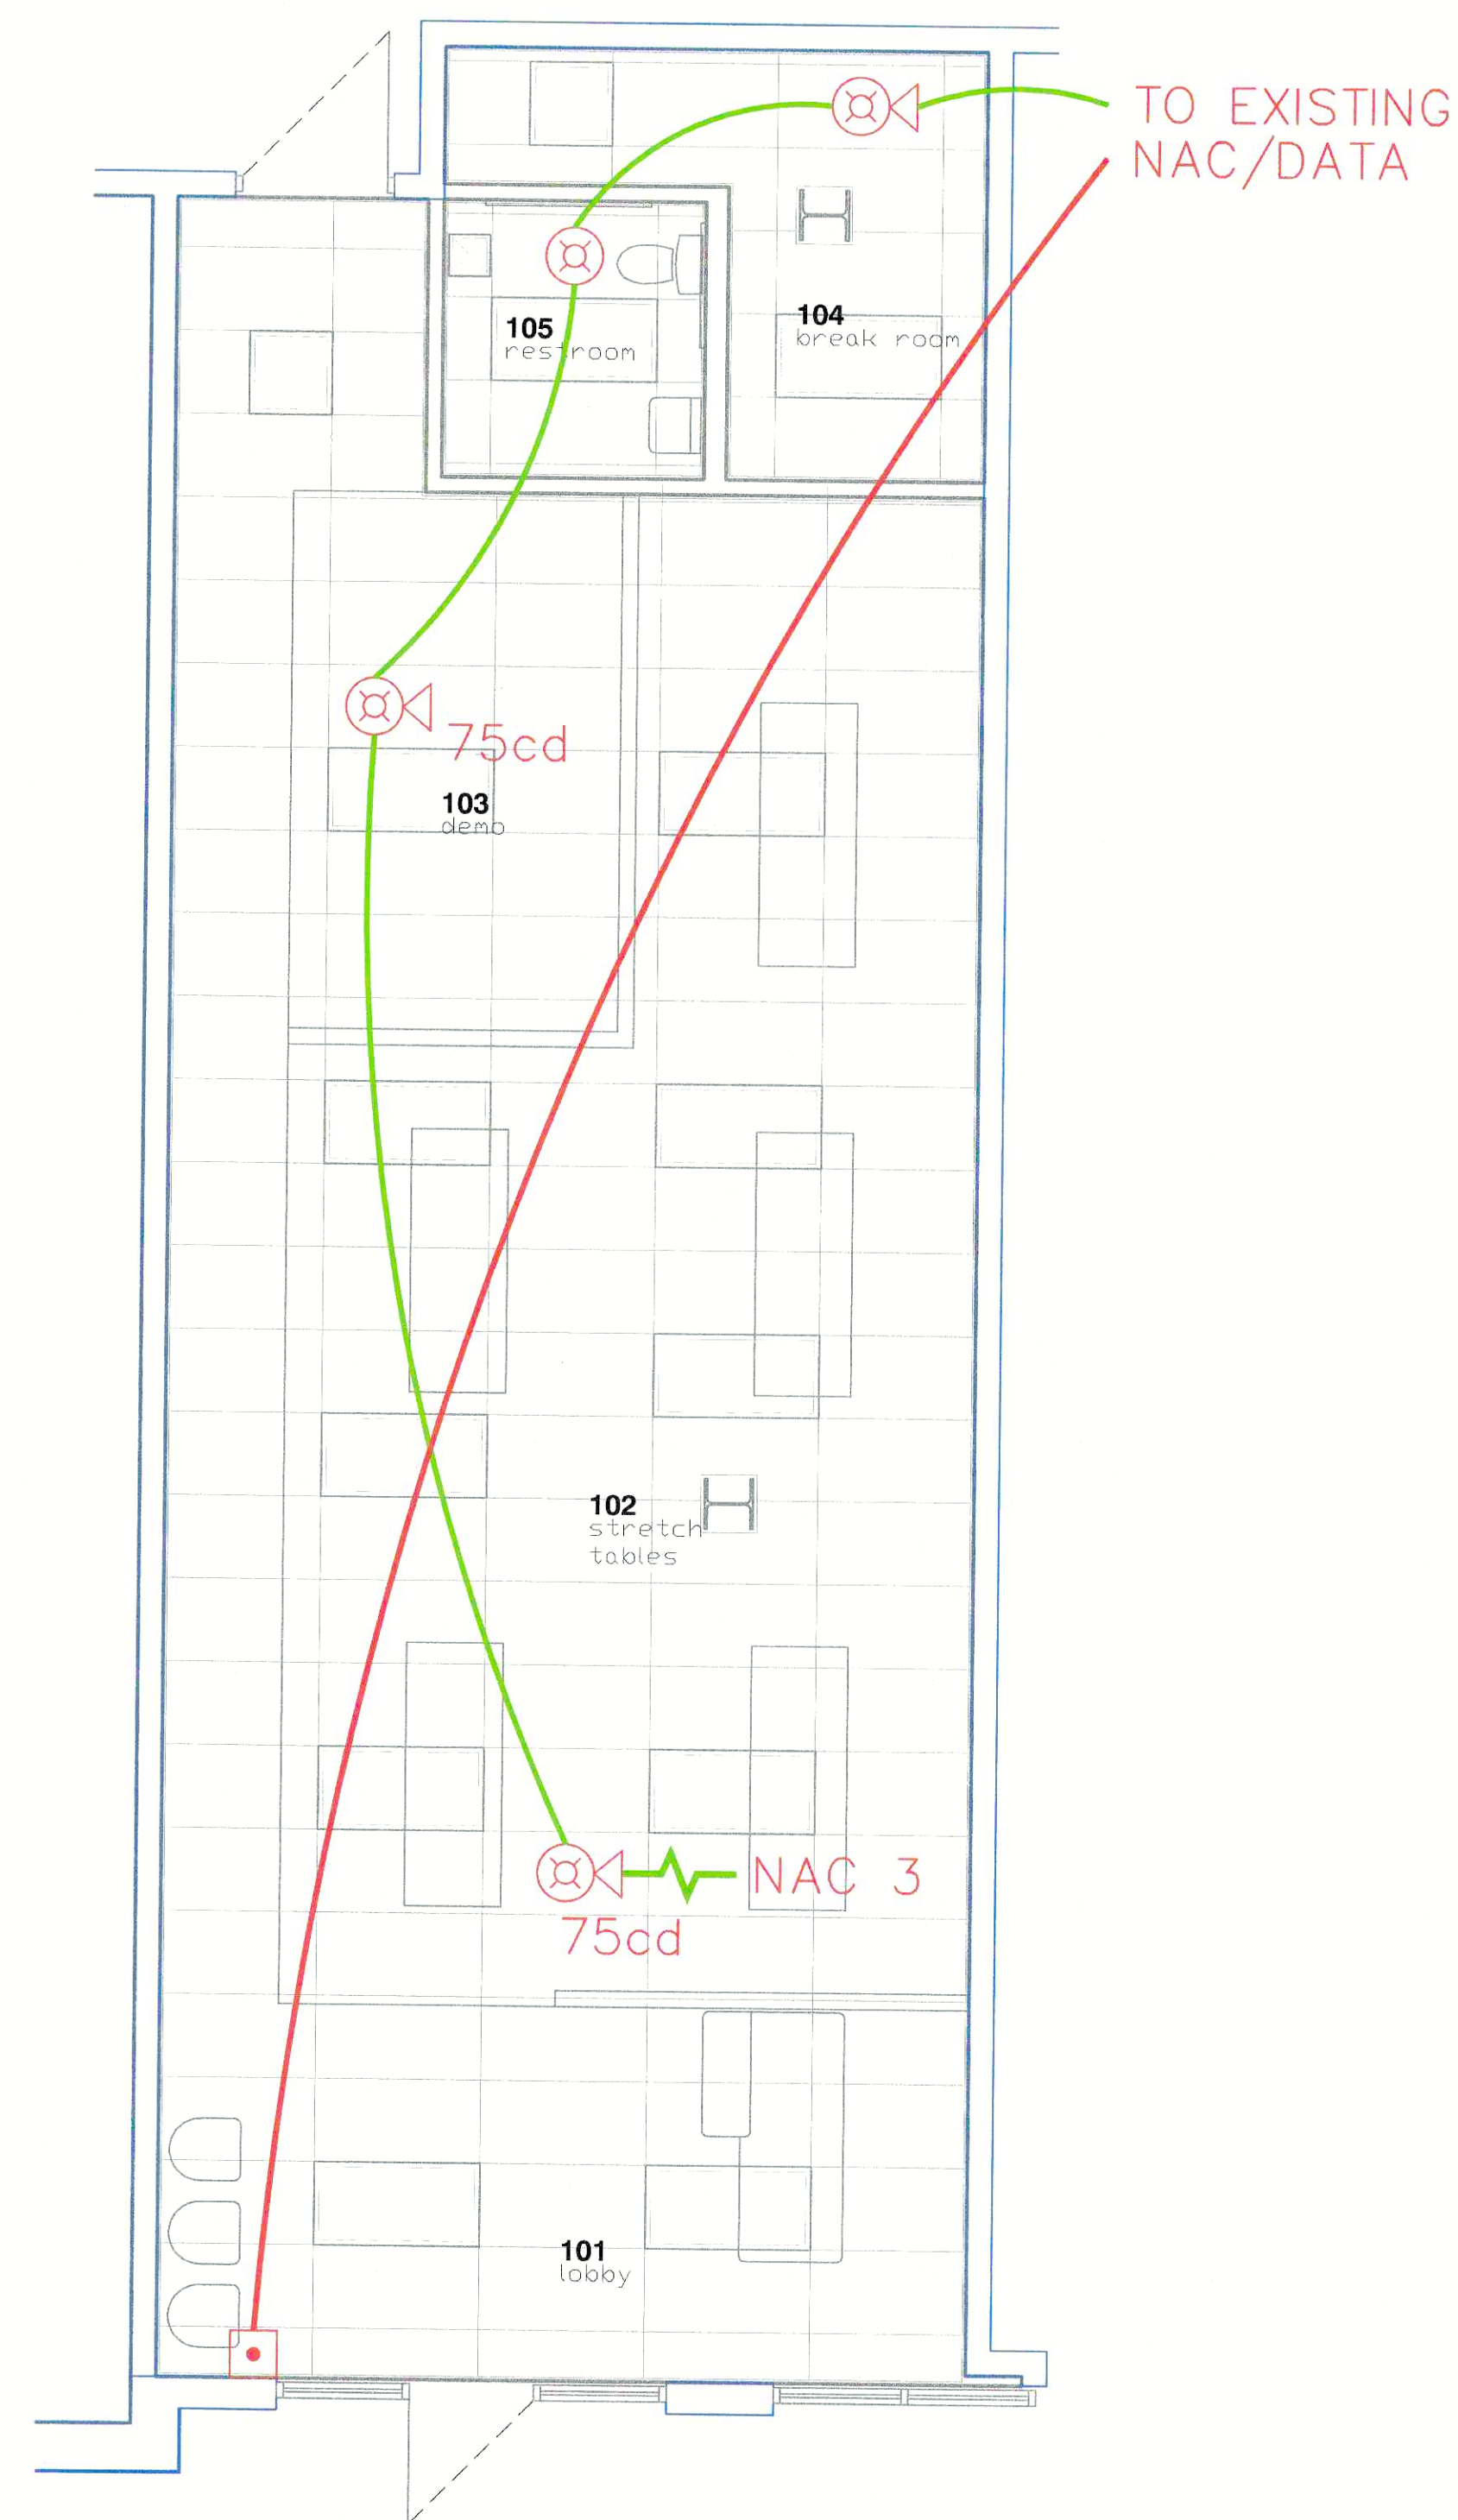

1 FIRE ALARM PLAN
1/4" = 1'0"

[illegible]

WIRING LEGEND

 18-2 FPLP WIRE (DATA)

 14-2 FPLP WIRE (A/V)

GENERAL NOTES

1. ALL STROBES HAVE A 15 CANDELLA RATING UNLESS NOTED OTHERWISE
2. CONNECT DATA WIRE TO EXISTING FIRE ALARM SYSTEM


FIRE ALARM SEQUENCE OF OPERATIONS
NOT TO SCALE

SYSTEM INPUTS

- 1. SMOKE DETECTOR
- 2. PULL STATION
- 3. WATER FLOW
- 4. TAMPER SWITCH
- 5. FIRE ALARM A/C POWER FAILURE
- 6. FIRE ALARM SYSTEM LOW BATTERY
- 7. OPEN CIRCUIT
- 8. GROUND CIRCUIT
- 9. SHORT CIRCUIT

SYSTEM OUTPUTS

- 1. ACTIVATE ZONE 1-400 VDC SIGNAL AT FIREPUMP
- 2. ACTIVATE WIRE FIRE ALARM SIGNAL AT FIREPUMP
- 3. ACTIVATE WIRE FIRE ALARM SIGNAL AT FIREPUMP
- 4. ACTIVATE WIRE FIRE ALARM SIGNAL AT FIREPUMP
- 5. ACTIVATE WIRE FIRE ALARM SIGNAL AT FIREPUMP
- 6. ACTIVATE WIRE FIRE ALARM SIGNAL AT FIREPUMP
- 7. ACTIVATE WIRE FIRE ALARM SIGNAL AT FIREPUMP
- 8. ACTIVATE WIRE FIRE ALARM SIGNAL AT FIREPUMP
- 9. ACTIVATE WIRE FIRE ALARM SIGNAL AT FIREPUMP

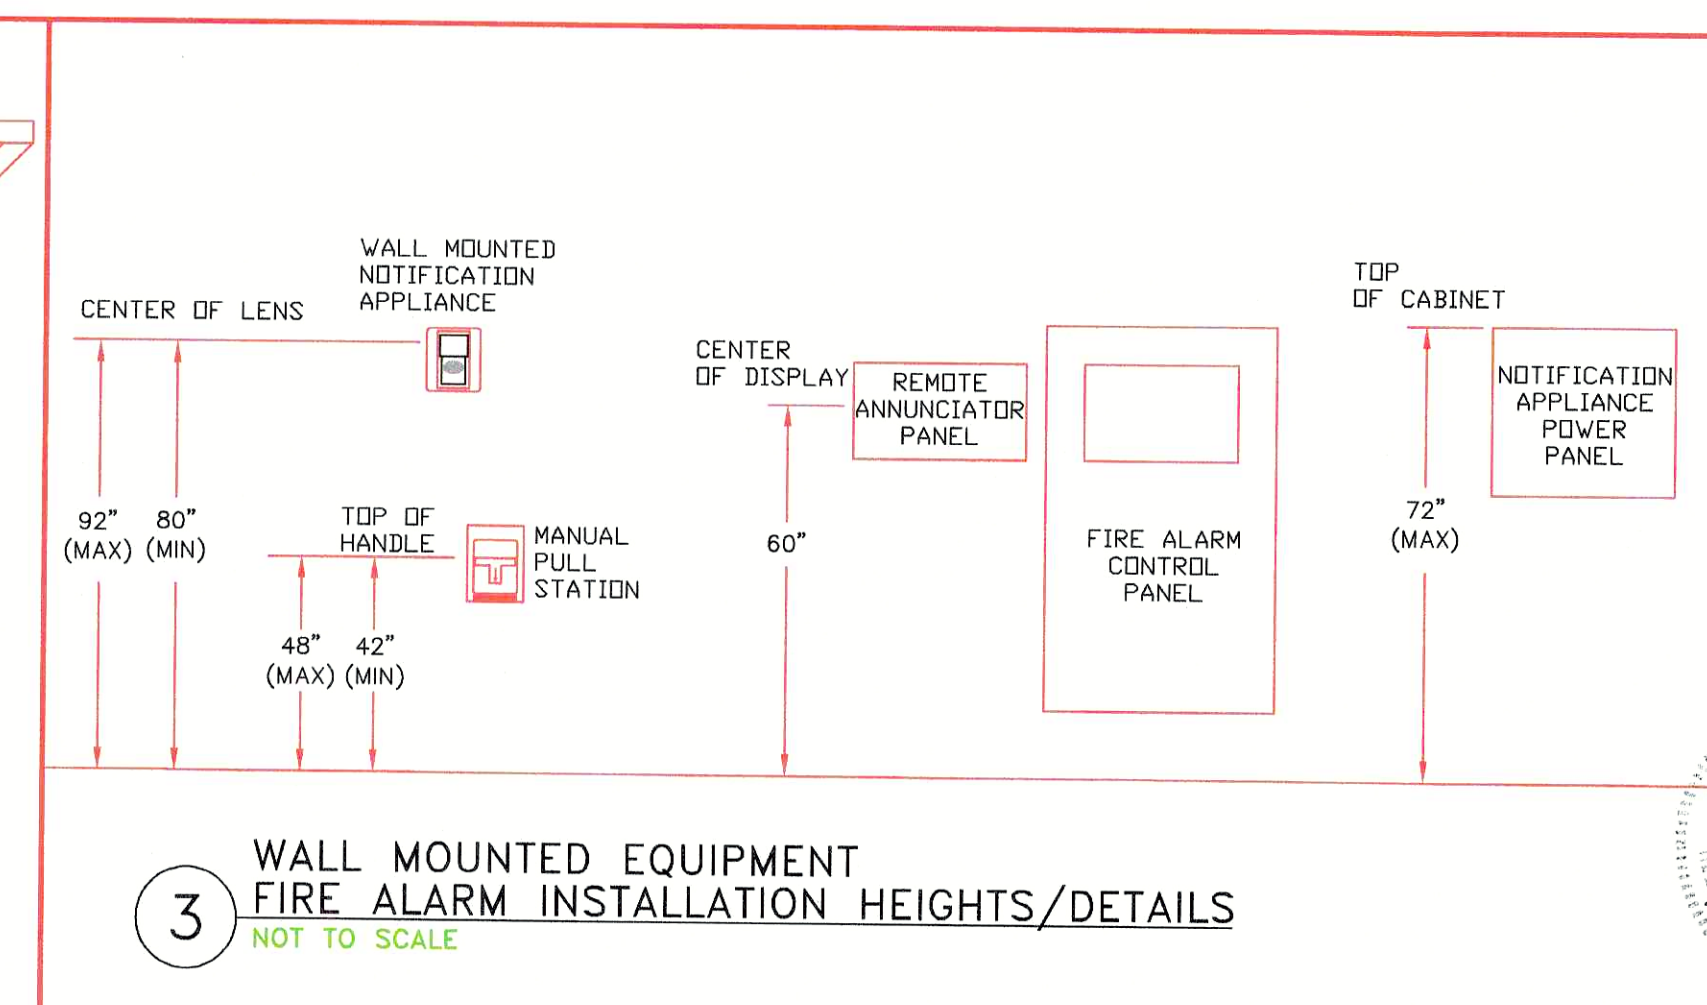This is a blank sheet of white paper with rounded corners. It features horizontal blue lines spaced evenly down its length. A single vertical red line runs down the right side, creating a margin. The entire page is enclosed within a thin red rectangular border.

Stretchzone
940 NW Pryor Rd
Lee's Summit, MO 64081

Aegis Fire Protection, LLC
Corporate: 11936 W. 119th St. #262 Overland Park, KS 66213
Phone: 913-825-0343 Fax: 913-322-4475
Email: info@aegisfirepro.com



NO.	15315
NAME:	Stretchzone Nanant Finish
E ALARM PLAN	
CITY & OWNER	
DATE:	1/4"=1'-0"
DRAWN BY:	RMS
CHECKED BY:	GT
6-10-21	
ST NO.	
FA1	
1 of 1	