



DATE	REVISIONS

Massageluxe
940 NW Pryor Road
Lee's Summit, MO 64081



Aegis Fire Protection, LLC
Corporate: 11936 W. 119th St. #262 Overland Park, KS 66213
Phone: 913-825-0343 Fax: 913-332-4475
Email: info@aegisfirepro.com



15348
JOB NO. 15348
JOB NAME: Messageluxe
Tenant Finish
FIRE ALARM PLAN
SCALE: 1/4"=1'-0"
CITY & OWNER:
DESIGNED BY: RMS
CHECKED BY: GT
DATE: 8-23-21
SHEET NO. 1
OF 1



1 FIRE ALARM PLAN
1/4" = 1'0"

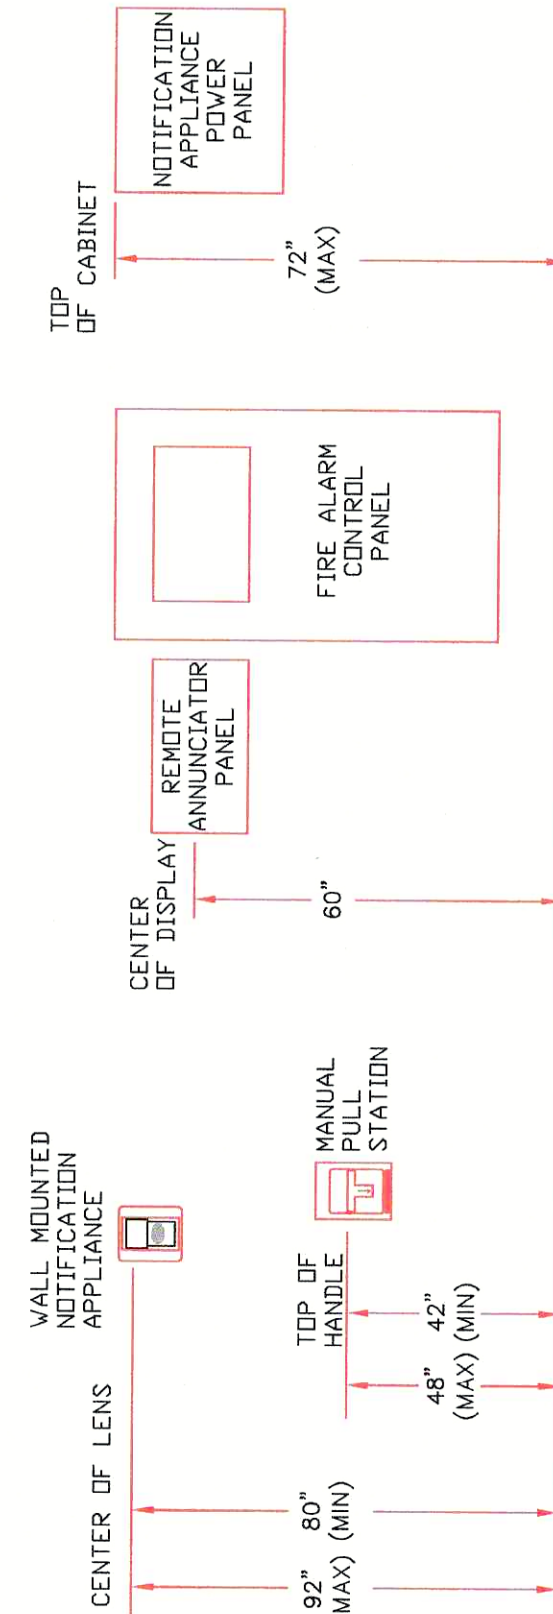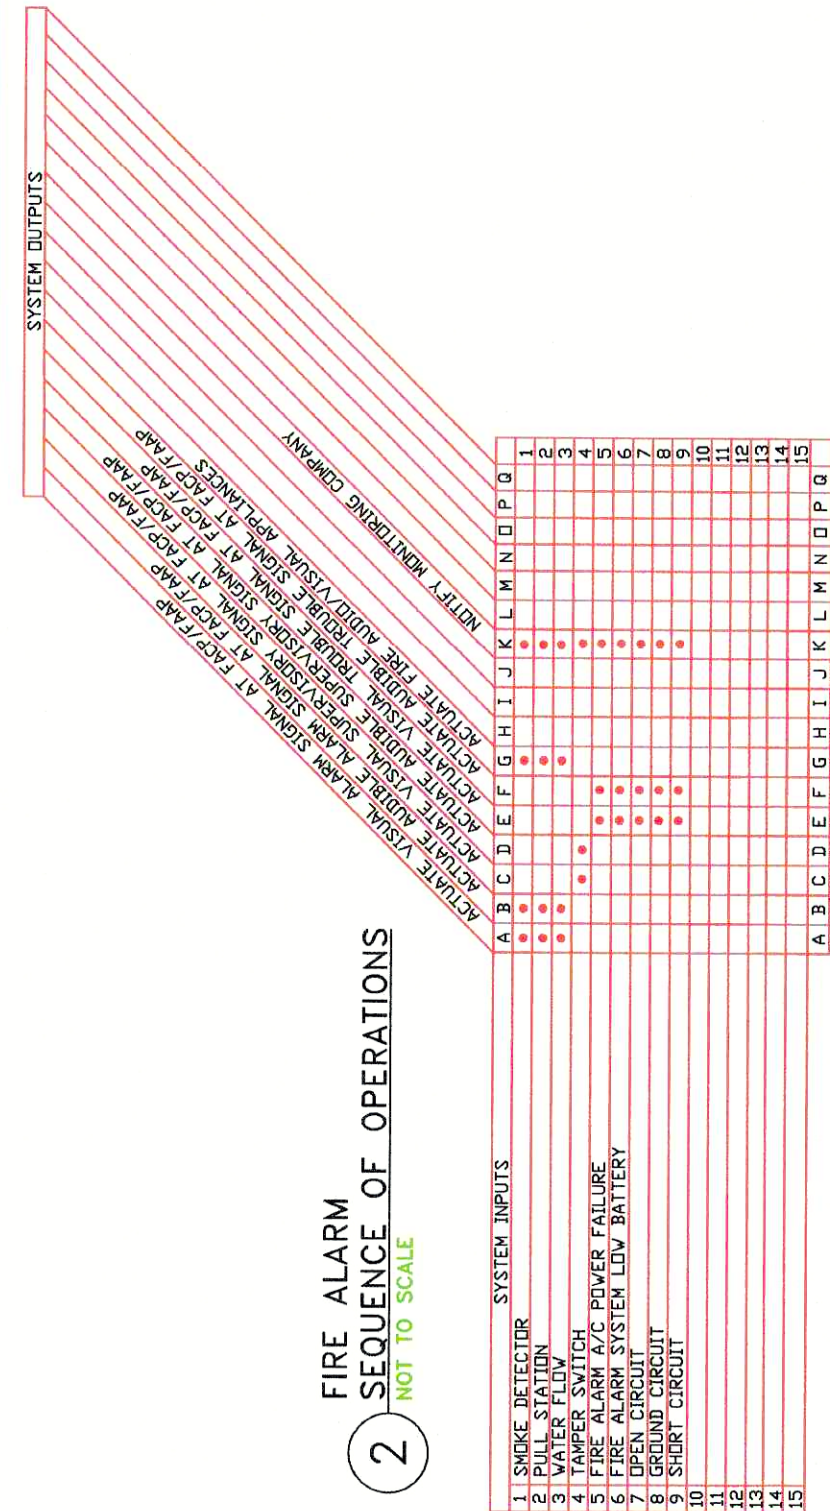

3 WALL MOUNTED EQUIPMENT
FIRE ALARM INSTALLATION HEIGHTS/DETAILS
NOT TO SCALE

FIRE ALARM LEGEND	
SYMBOL	DESCRIPTION
[LINE]	N.A.C. POWER EXTENDER
(7)	AREA SMOKE DETECTOR
[•]	FIRE ALARM MANUAL STATION
(B)(X)	COMB. F.A. HORN & VISUAL SIGNAL
(E)	F.A. VISUAL SIGNAL
- - -	END OF LINE RESISTOR

WIRING LEGEND	
	18-2 FPLP WIRE (DATA)
	14-2 FPLP WIRE (A/V)
GENERAL NOTES	
1. ALL STROBES HAVE A 15 CANDELLA RATING UNLESS NOTED OTHERWISE	
2. CONNECT DATA WIRE TO EXISTING FIRE ALARM SYSTEM	