


GENERAL NOTES:

1. ALL DEVICES, EQUIPMENT, FIXTURES, ETC. MUST BE GROUNDED BY USE OF A PROPERLY SIZED GROUNDING CONDUCTOR. MECHANICAL/ELECTRICAL BONDS OF THE METALLIC RACEWAY SYSTEM SHALL ALSO BE MAINTAINED.
2. BRANCH CIRCUIT WIRE SIZES (AND CONDUITS) SHALL BE INCREASED FROM THOSE INDICATED ON THE PLANS TO PREVENT EXCESSIVE VOLTAGE DROP. BRANCH CIRCUITS SHALL BE INSTALLED WITH WIRES OF SUFFICIENT SIZE SO THAT VOLTAGE DROP BETWEEN THE PANEL AND THE LOADS DOES NOT EXCEED A LIMIT OF 3%.
3. CIRCUITS MAY BE COMBINED IN CONDUIT PROVIDED WIRE IS PROPERLY DERATED AND CONDUIT SIZED PER CODE. UNDER NO CIRCUMSTANCES SHALL MORE THAN NINE (9) CURRENT CARRYING CONDUCTORS BE RUN IN A SINGLE CONDUIT.
4. ALL CONDUITS SHALL CONTAIN A GROUND WIRE SIZED PER NEC TABLE #250-122. WHERE CIRCUIT CONDUCTORS ARE INCREASED IN SIZE FOR VOLTAGE DROP, THE GROUND WIRE SIZE SHALL BE INCREASED PROPORTIONATELY (ACCORDING TO CIRCULAR MIL AREA) FROM THE SIZE REQUIRED BY NEC TABLE #250-122.
5. EXPOSED CONDUITS, WHERE PERMITTED, SHALL BE RUN PARALLEL TO OR AT RIGHT ANGLES TO BUILDING STRUCTURAL MEMBERS.
6. ALL DEVICE COVER PLATES SHALL BE WHITE UNLESS NOTED OTHERWISE.

X KEYED NOTE SCHEDULE

1. (4) CATS PULLED TO EACH SIDE OF CASH WRAP, TOTAL OF (8) TO THE FRONT. COORDINATE ELECTRICAL/COMMUNICATION DROPS FOR CASHWRAP FIXTURING WITH OWNER'S REPRESENTATIVE PRIOR TO ROUGH-IN.
2. PROVIDE NEMA 5/15P RECEPTACLE FOR FREEZER MOUNTED AT 60" AFF.
3. COORDINATE RECEPTACLE REQUIREMENTS FOR DRYER WITH OWNER'S REPRESENTATIVE PRIOR TO ROUGH-IN.
4. MOUNT RECEPTACLE FOR SHOW WINDOWS WITHIN 18" OF THE TOP OF THE WINDOW.
5. VERIFY RECEPTACLE LOCATION WITH OWNER PRIOR TO ROUGH-IN.
6. PHONE BOARD SHALL BE AT LEAST 4 FEET X 4 FEET, 24 PORT PATCH PANEL TO BE MOUNTED ON THE PHONE BOARD AND PROVIDED BY LOW VOLTAGE SUBCONTRACTOR. 66 BLOCK OR VOIP MODEM TO BE MOUNTED ON THE PHONE BOARD AND PROVIDED BY INTERNET SERVICE PROVIDER. COORDINATE ALL REQUIREMENTS WITH OWNER'S REPRESENTATIVE PRIOR TO ROUGH-IN.
7. COORDINATE ELECTRICAL/COMMUNICATION DROPS FOR OFFICE FIXTURING WITH OWNER'S REPRESENTATIVE PRIOR TO ROUGH-IN.
8. PROVIDE (2) BUTTONS AT CASHWRAPS TO ACTIVATE BELL IN STOCKROOM. COORDINATE WITH OWNER REPRESENTATIVE FOR LOCATIONS OF BUTTONS.
9. PROVIDED JUNCTION BOX, CONDUIT AND WIRE FOR SIGNAGE. COORDINATE WITH PET PEOPLE AND SIGN VENDOR.
10. REFER TO EQUIPMENT CONNECTION SCHEDULE THIS SHEET.
11. COORDINATE EXACT LOCATION AND MOUNTING HEIGHT WITH PLUMBING CONTRACTOR PRIOR TO ROUGH-IN.
12. GENERAL PURPOSE RECEPTACLE. REFER TO OPEN WALL PLAN A4.0 FOR EXACT LOCATIONS OF RECEPTACLES.
13. PROVIDE 3/4" CONDUIT WITH PULL STRING FROM BACKROOM TO THE CASHWRAP FOR TENANT BURGLAR ALARM. CONFIRM LOCATIONS WITH TENANT REPRESENTATIVE PRIOR TO ROUGH-IN.
14. MOUNT REMOTE TEMPERATURE SENSOR AT 54" ABOVE FINISHED FLOOR. COORDINATE MOUNTING LOCATION OF TEMPERATURE SENSOR WITH TENANT AND ARCHITECT PRIOR TO ROUGH-IN.
15. POWER AND DATA TO BE STUBBED UP UNDER BASE AND MOUNTED ON SIDEWALL OF CABINETRY. COORDINATE WITH OWNER REPRESENTATIVE FOR EXACT LOCATIONS.
16. 2" CONDUIT WITH PULLWIRE FOR TELEPHONE STUBBED INTO TENANT SPACE IN SHELL. EXTEND CONDUIT AND PROVIDE PHONE CABLE. COORDINATE ALL REQUIREMENTS WITH LOCAL PHONE COMPANY.
17. PROVIDE RECEPTACLES IN OFFICE PER ELEVATION 2/E2.1.
18. PROVIDE RECEPTACLE FOR DRYER VENT BOOSTER FAN. COORDINATE LOCATION WITH MECHANICAL CONTRACTOR PRIOR TO ROUGH-IN.

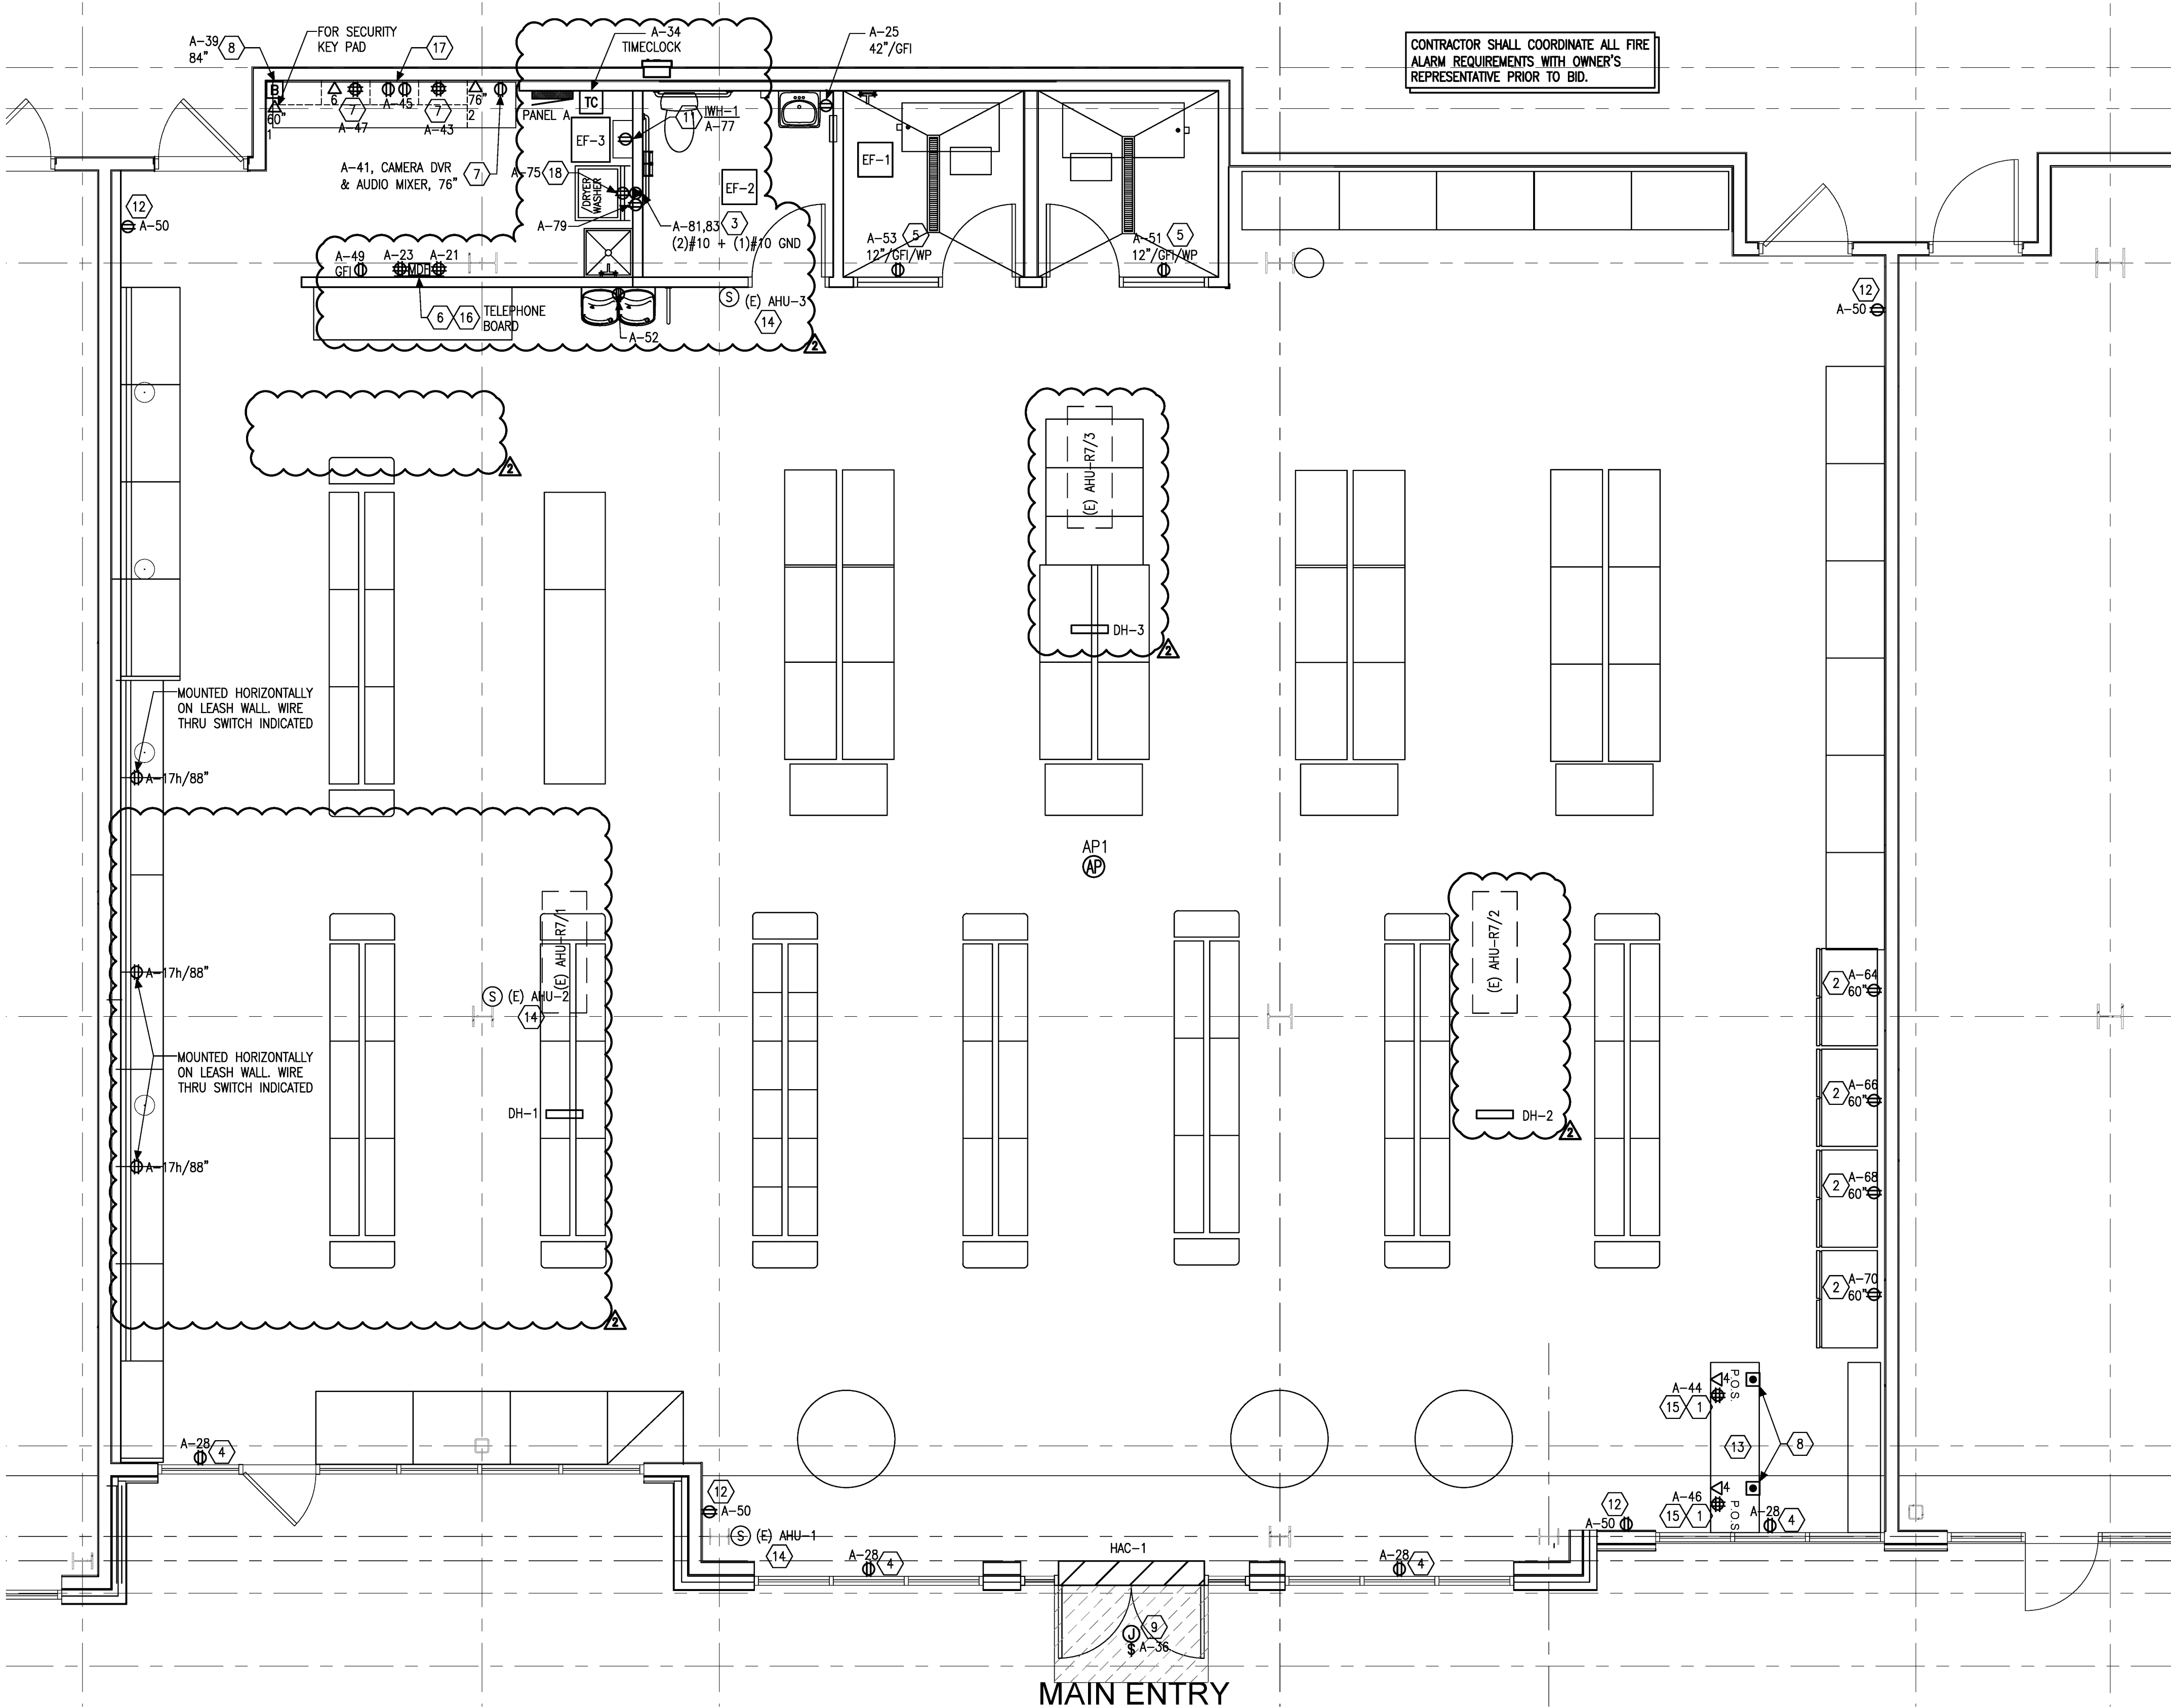

CONTRACTOR SHALL COORDINATE ALL FIRE ALARM REQUIREMENTS WITH OWNER'S REPRESENTATIVE PRIOR TO BID.


Design and construction documents are instruments of service and are given in confidence and remain the property of Onyx Creative. The use of this design and these construction documents for purposes other than the specific project named herein is strictly prohibited without expressed written consent of Onyx Creative.

PetPeople
SUMMIT AT WEST PRYOR
940 NW PRYOR RD, UNIT J
LEE'S SUMMIT (KANSAS CITY), MO

Project No: 18804
Drawn By: TWK
Date: 07/19/2021
Issue: Etk/ Permit
07/24/2021 Revision: 1
08/27/2021 Revision: 2

E2.0

FLOOR PLAN

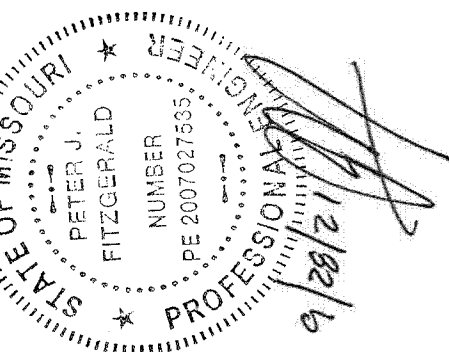

onyx creative
25001 Emery Road, Suite 400
Cleveland, Ohio 44128
216.223.3200 onyxcreative.com

1 | FLOOR PLAN
1/4" = 1'-0"

