


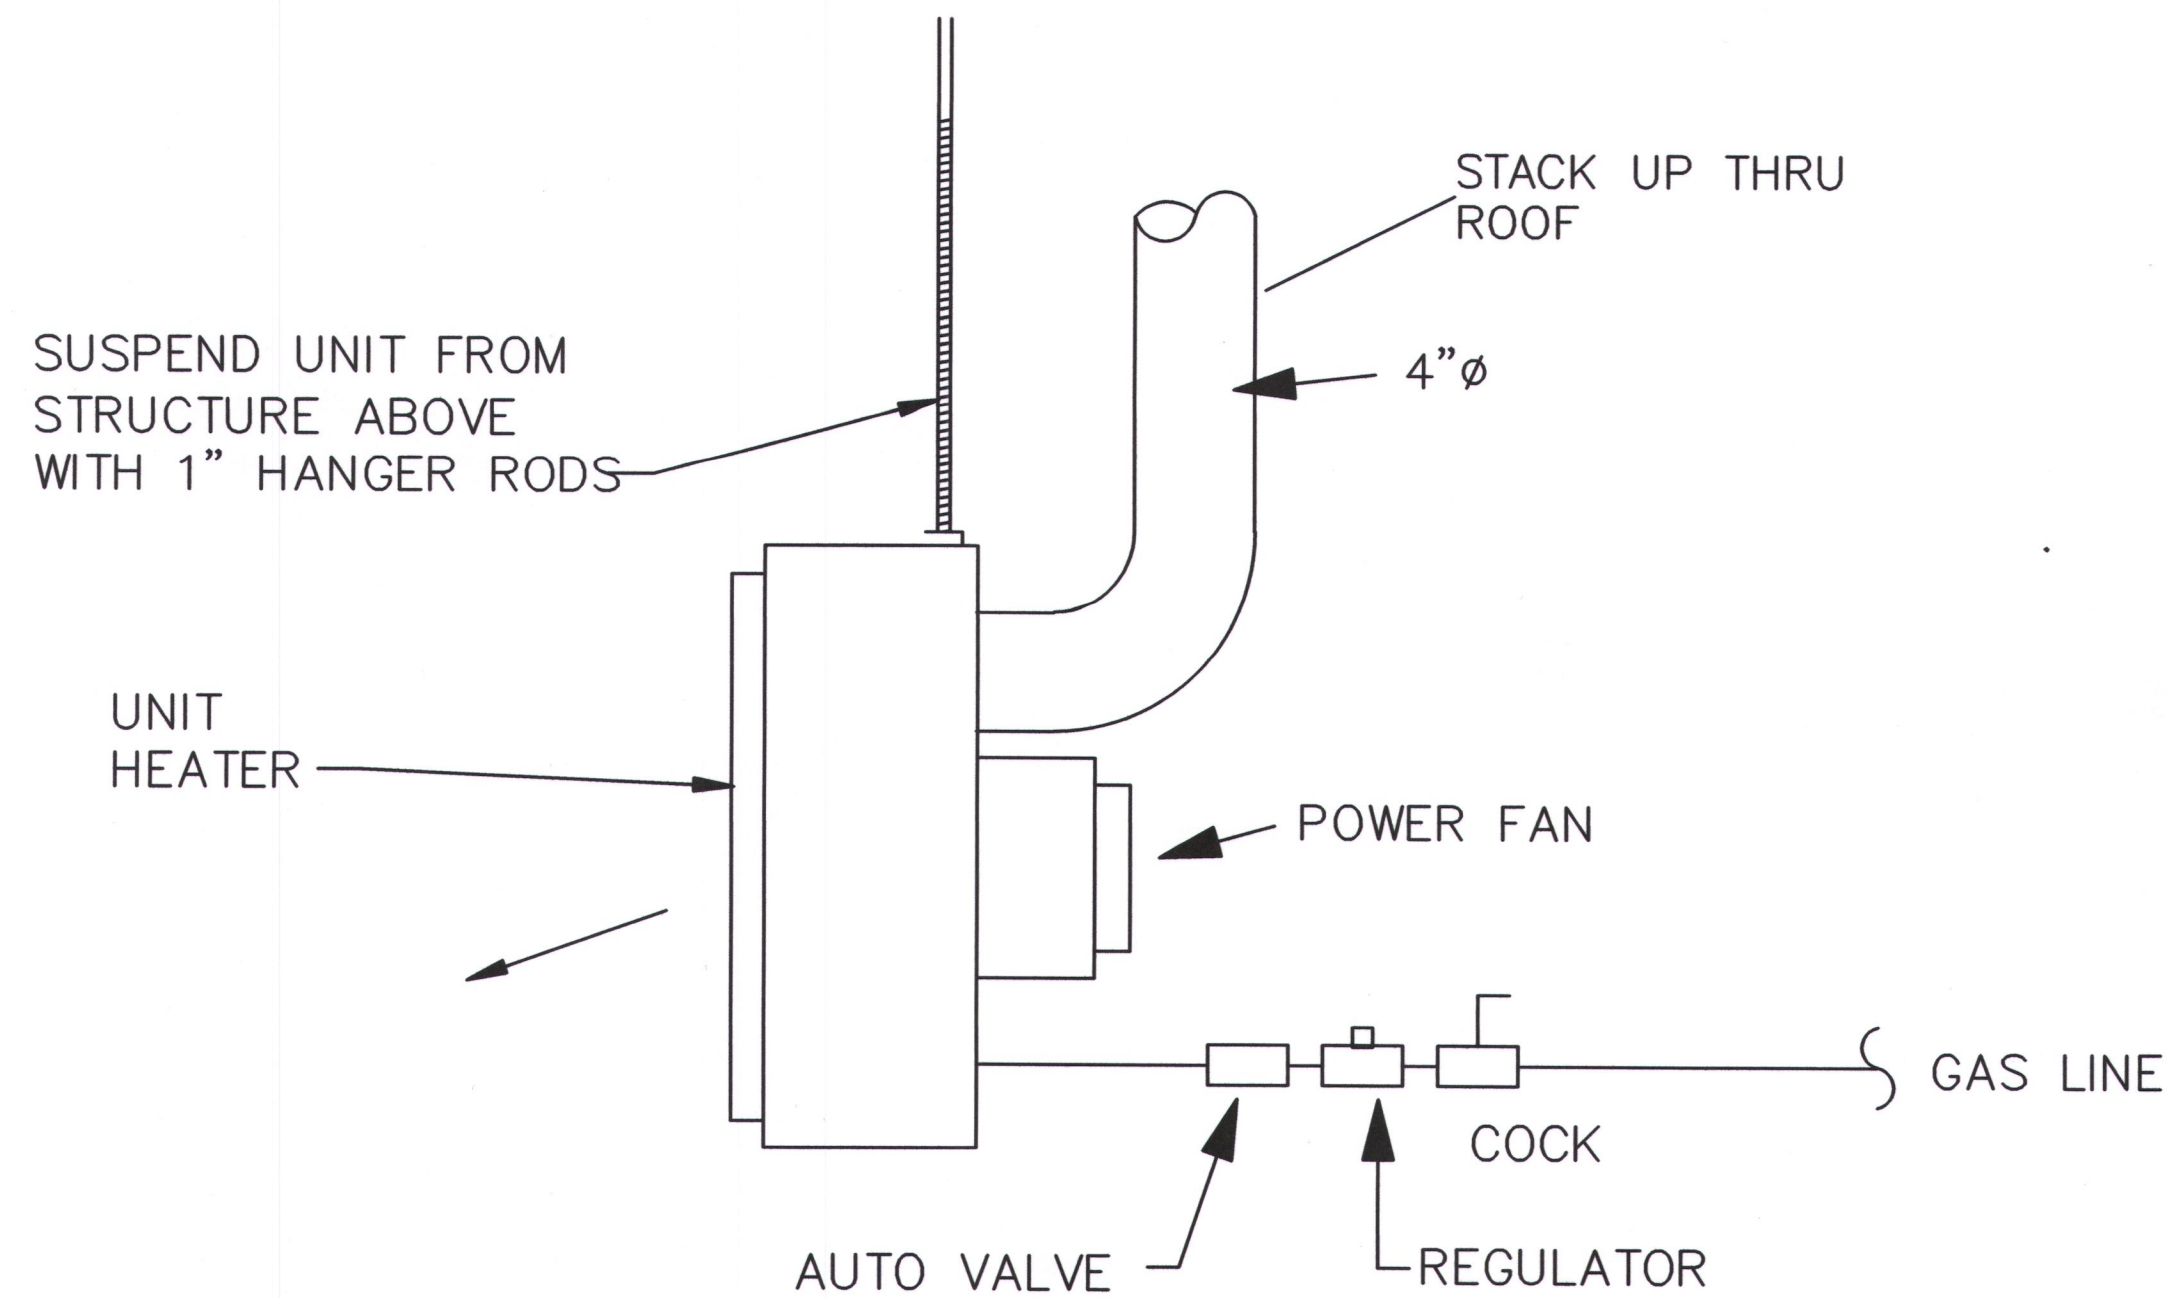


UNIT HEATER DETAIL

NO SCALE
UNIT HEATER SHALL BE 200,000 CFH

PANEL L MOUNTING SURFACE BUS 100A MAIN 100 A CB TYPE BOLT-IN						
LOCATION WAREHOUSE			VOLT 120/208V 3 Ø 4 WIRE			
CKT. NO.	DESCRIPTION	BKR.	CKT. V.A.	BKR.	DESCRIPTION	CKT. NO.
1	LIGHTING	20	600	1000	20	UNIT HEATER
3	RECEPTS	20	1000	1000	20	UNIT HEATER
5	RECEPTS	20	1000	1000	20	UNIT HEATER
7	WATER HEATER	20	800	1000	20	UNIT HEATER
9	FURNACE	20	1000	1000	20	UNIT HEATER
11	COND UNIT	25	3300	-	20	SPARE
13		-	-	-	20	SPARE
15	SPARE	20	-	-	20	SPARE
17	SPARE	20	-	-	20	SPARE
19	SPARE	20	-	-	20	SPARE
21	SPARE	20	-	-	20	SPARE
23	SPARE	20	-	-	20	SPARE
25	SPACE	-	-	-	-	SPACE
27	SPACE	-	-	-	-	SPACE
29	SPACE	-	-	-	-	SPACE
			4,900	TOTAL VOLT AMPS 14 AMPS		

PANEL <u>H</u> MOUNTING <u>SURFACE</u> BUS <u>100A</u> MAIN <u>MLO</u> TYPE <u>BOLT-IN</u>									
LOCATION _____			WAREHOUSE _____		VOLT <u>277/480V</u> <u>3</u> Ø <u>4</u> WIRE _____				
CKT. NO.	DESCRIPTION	BKR.	CKT. V.A.		CKT. V.A.	BKR.	DESCRIPTION	CKT. NO.	
1	LIGHTING	20	1500		4,900	60/3	PANEL-L	2	
3	LIGHTING	20	1500		.	.	.	.	4
5	SPARE	20	.		.	.	.	.	6
7	SPARE	20	.		.	20	SPARE	.	8
9	SPARE	20	.		.	20	SPARE	.	10
11	SPARE	20	.		.	20	SPARE	.	12
13	SPARE	20	.		.	20	SPARE	.	14
15	SPARE	20	.		.	20	SPARE	.	16
17	SPARE	20	.	.	20	SPARE	.	18	
19	SPARE	20	.	.	20	SPARE	.	20	
21	SPARE	20	.	.	20	SPARE	.	22	
23	SPARE	20	.	.	20	SPARE	.	24	
25	SPACE	.	.	.	.	SPACE	.	26	
27	SPACE	.	.	.	.	SPACE	.	28	
29	SPACE	.	.	.	.	SPACE	.	30	
	.	.	19,400	.	TOTAL VOLT AMPS			54 AMPS	

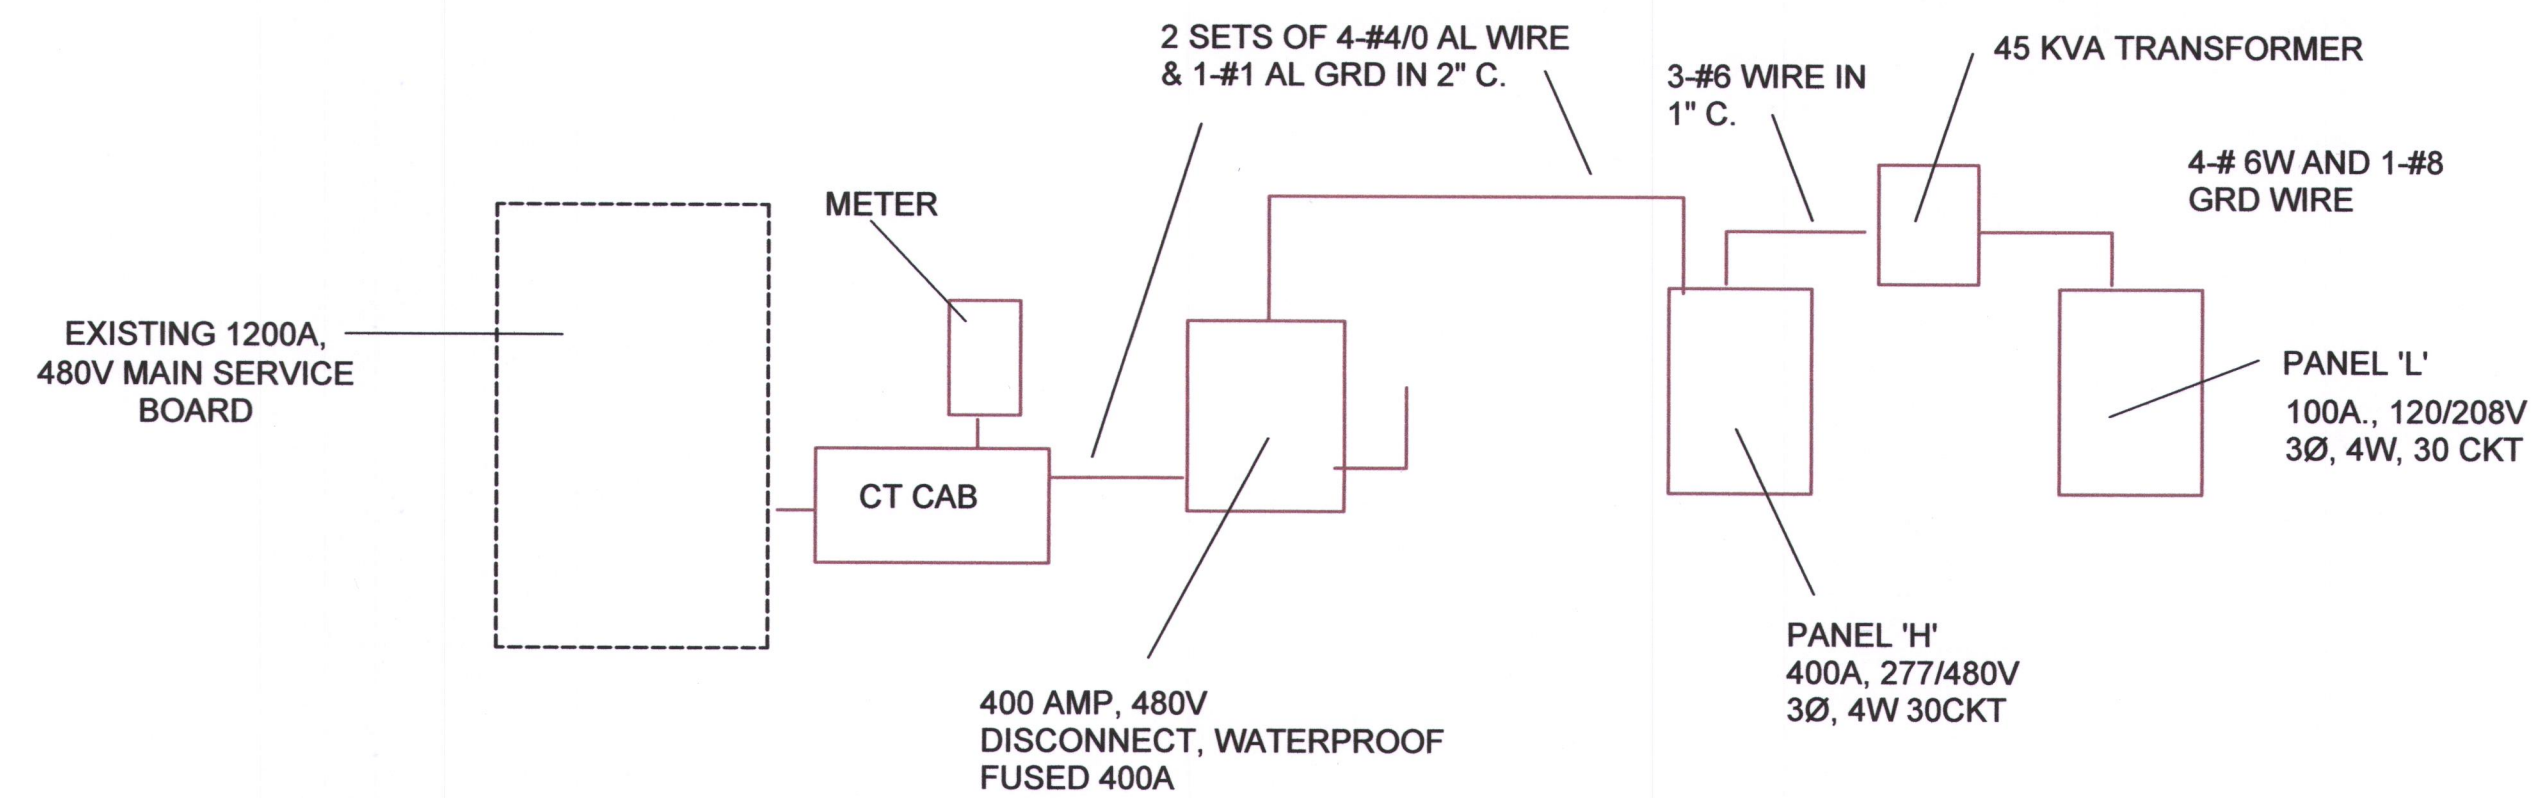

ELECTRICAL RISER DIAGRAM

TENANT
INFILL
FOR

JOHNSON
LOGISTICS
LLC

AT
2736 NE
McBAINE DRIVE
LEE'S SUMMIT
MISSOURI

DATE: 9/21/2020

REVISIONS:

- Δ
- Δ
- Δ
- Δ
- Δ

SBC
ARCHITECTURAL
SERVICES
Robert J. Shirk Jr. - Principal / Project Mgr.

3009 ELMIRA CT.
INDEPENDENCE,
MISSOURI 64057
(816) 797-7115

STATE OF MISSOURI
JERRY WILSON
REGISTERED
NUMBER
E-14378
PROFESSIONAL ENGINEER
9/30/2021

SHEET NO.

E102