

PETLAND AT SUMMIT ORCHARDS

FIRE ALARM DRAWINGS

PROJECT

PETLAND AT SUMMIT ORCHARDS
464 NW CHIPMAN ROAD
LEE’S SUMMIT, MO 64063

GENERAL CONTRACTOR

CAMM CONSTRUCTION
5614 RAYTOWN ROAD
RAYTOWN, MO 64133

FIRE ALARM CONTRACTOR

FIRE & SECURITY SOLUTIONS GROUP, INC.
11240 STRANG LINE ROAD
LENEXA, KS 66215
PH (913) 789–7160
FX (913) 789–7169



11240 STRANG LINE ROAD
LENEXA, KS 66215



SALES: 913–789–7160 EXT.100
SERVICE: 913–789–7160 EXT.102
FAX: 913–789–7169
EMAIL: info@fssgkc.com
WEBSITE: www.fssgkc.com

| DRAWING INDEX | |
|---------------|--------------------------------------------------------------------------------------|
| SHEET # | SHEET TITLE |
| FA–COVER | COVER SHEET |
| FA–101 | FIRE ALARM FLOOR PLAN, RISER DIAGRAM, CALCS., SEQ. OF OPER., MTG. HTS. DTL. |

BC PROJECT #: 21848
MISSOURI PE COA #2009003629
This drawing has been prepared by the Engineer, or under his supervision. This drawing is provided as an instrument of service by the Designer/Engineer and is intended for use on the project only. Pursuant to the Architectural Works Copyright Protection Act of 1990, all drawings, specifications, plans and designs, including the overall form, arrangement and composition of spaces and elements appearing herein, constitute the original, copyrighted work of the Designer/Engineer. Any reproduction, use, or disclosure of information contained herein without prior written consent of the Engineer is strictly prohibited. © 2021 BC Engineers, Inc.



| | |
|-----------|--------------------------------------------------------------------------------------|
| CUSTOMER: | PROJECT: PETLAND AT SUMMIT ORCHARDS 464 CHIPMAN ROAD LEE'S SUMMIT, MO 64063 |
|-----------|--------------------------------------------------------------------------------------|

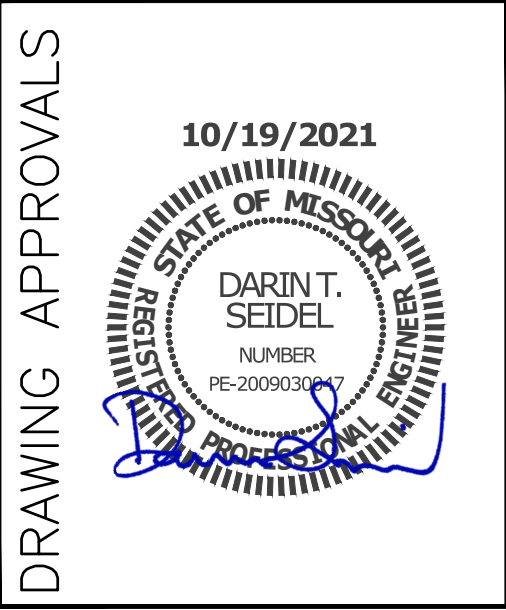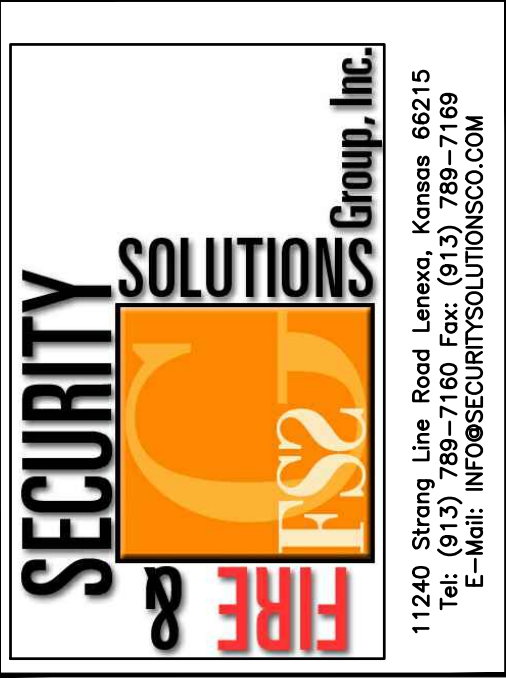

| | | | | | |
|---------------------------|-----------|------------|--|--|-------|
| PROJECT NO. | REVISIONS | | | | NOTE: |
| | | | | | |
| | | | | | |
| | | | | | |
| | | | | | |
| SCALE: AS NOTED | | | | | |
| DRAWN BY: | AP | 10/15/2021 | | | |
| ENGINEER: | | | | | |
| CHECK BY: | CF | 10/15/2021 | | | |
| DATE: 10/15/2021 | | | | | |
| CAD FILE: | | | | | |
| DRAWING TITLE: | | | | | |
| FIRE ALARM COVER SHEET | | | | | |

| |
|-------------------------------|
| DRAWING SHEET NO. FA-COVER |
|-------------------------------|