


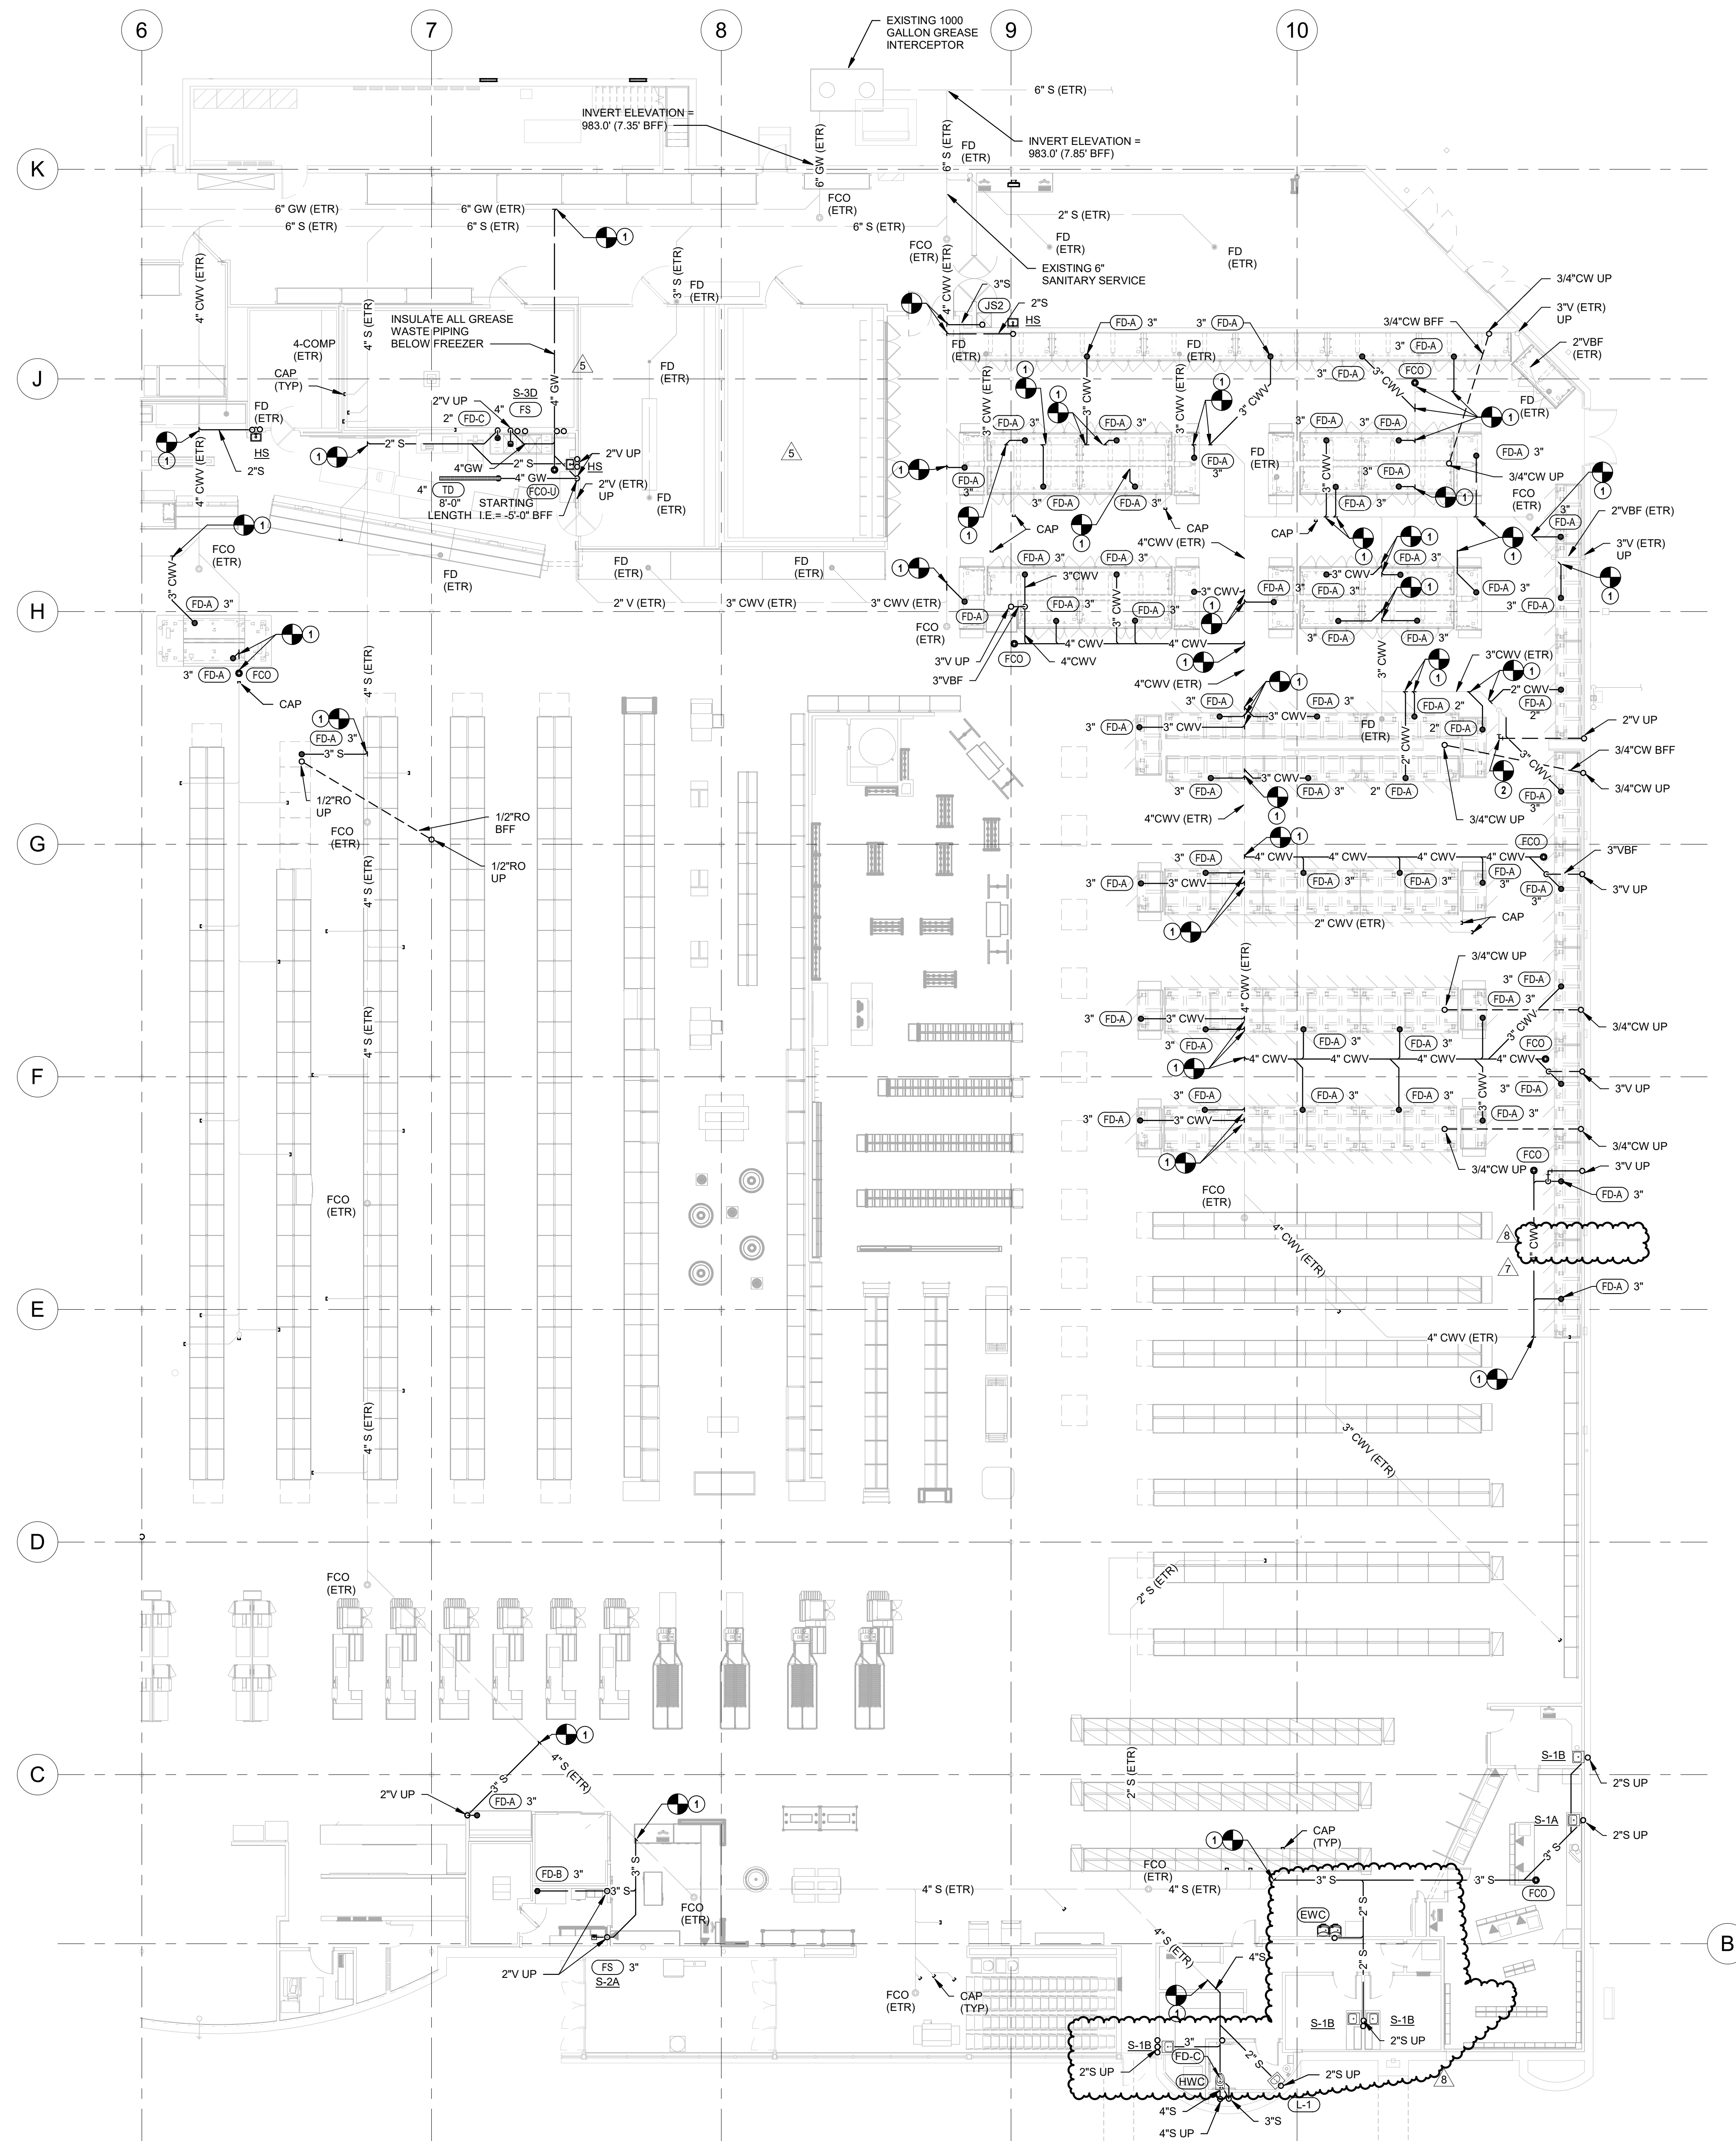

1 UNDERFLOOR PLUMBING PLAN - B
3/32" = 1'-0"

PLUMBING GENERAL NOTES


1. FURNISH AND INSTALL PLUMBING SYSTEMS IN ACCORDANCE WITH LOCAL AND STATE PLUMBING CODES.
2. ALL FLOOR DRAINS, FLOOR SINKS, AND TRENCH DRAINS OUTLETS AND BRANCH SANITARY ARE 3" UNLESS NOTED OTHERWISE.
3. ALL FLOOR CLEANOUTS ARE TO BE ACCESSIBLE AND NOT BENEATH MILLWORK, CASEWORK, SHELVES OR OTHER OBSTRUCTIONS. CLEANOUTS SHALL BE THE SAME SIZE AS PIPING BEING SERVED AND AT THE TRANSITION OF PIPE SIZE.
4. COORDINATE UNDERFLOOR PIPING ROUTING WITH REFRIGERATION AND ELECTRICAL CONTRACTORS.

PLUMBING PLAN NOTES


1. CONNECT NEW SANITARY/GREASE WASTE PIPING INTO EXISTING PIPING. FIELD VERIFY EXACT LOCATION, SIZE AND INVERT PRIOR TO START OF WORK.
2. CONNECT NEW VENT PIPING TO EXISTING VENT PIPING AS FIELD CONDITIONS REQUIRE. FIELD VERIFY EXACT SIZE AND LOCATION PRIOR TO START OF WORK.

REVISION		DATE BY
5	ASI #5	03/19/21
7	ASI #7	04/16/21
8	ASI #8	05/20/21

HENDERSON
ENGINEERS
8345 LENEXA DRIVE, SUITE 300
LENEXA, KS 66214
TEL 913.742.5000 FAX 913.742.5001
WWW.HENDERSONENGINEERS.COM
1950003081
MO. CORPORATE NO. E-5560
EXPIRES 12/31/2021

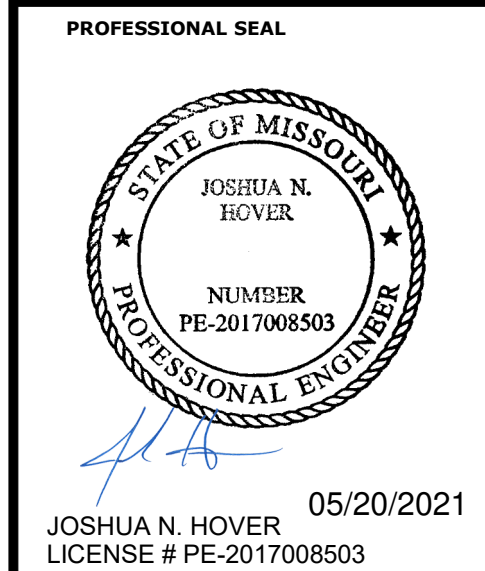


LOCATION
LEE'S SUMMIT, MO #2
310 SW WARD RD
HY-VEE INC.
5820 WESTTOWN PARKWAY
WEST DES MOINES, IOWA 50266
TEL (515) 267-2800
FAX (515) 267-2335
Hy-Vee
EMPLOYEE OWNED

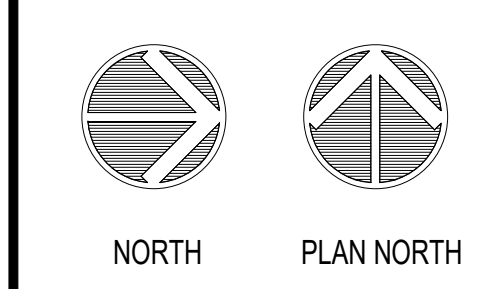

UNDERFLOOR
PLUMBING PLAN -
B

PROJECT MANAGER SL	CHECKED BY HEI
DRAWN BY: HEI	DATE 10/19/2020
SCALE AS NOTED	JOB NUMBER 62830547
SHEET:	

P1.0B

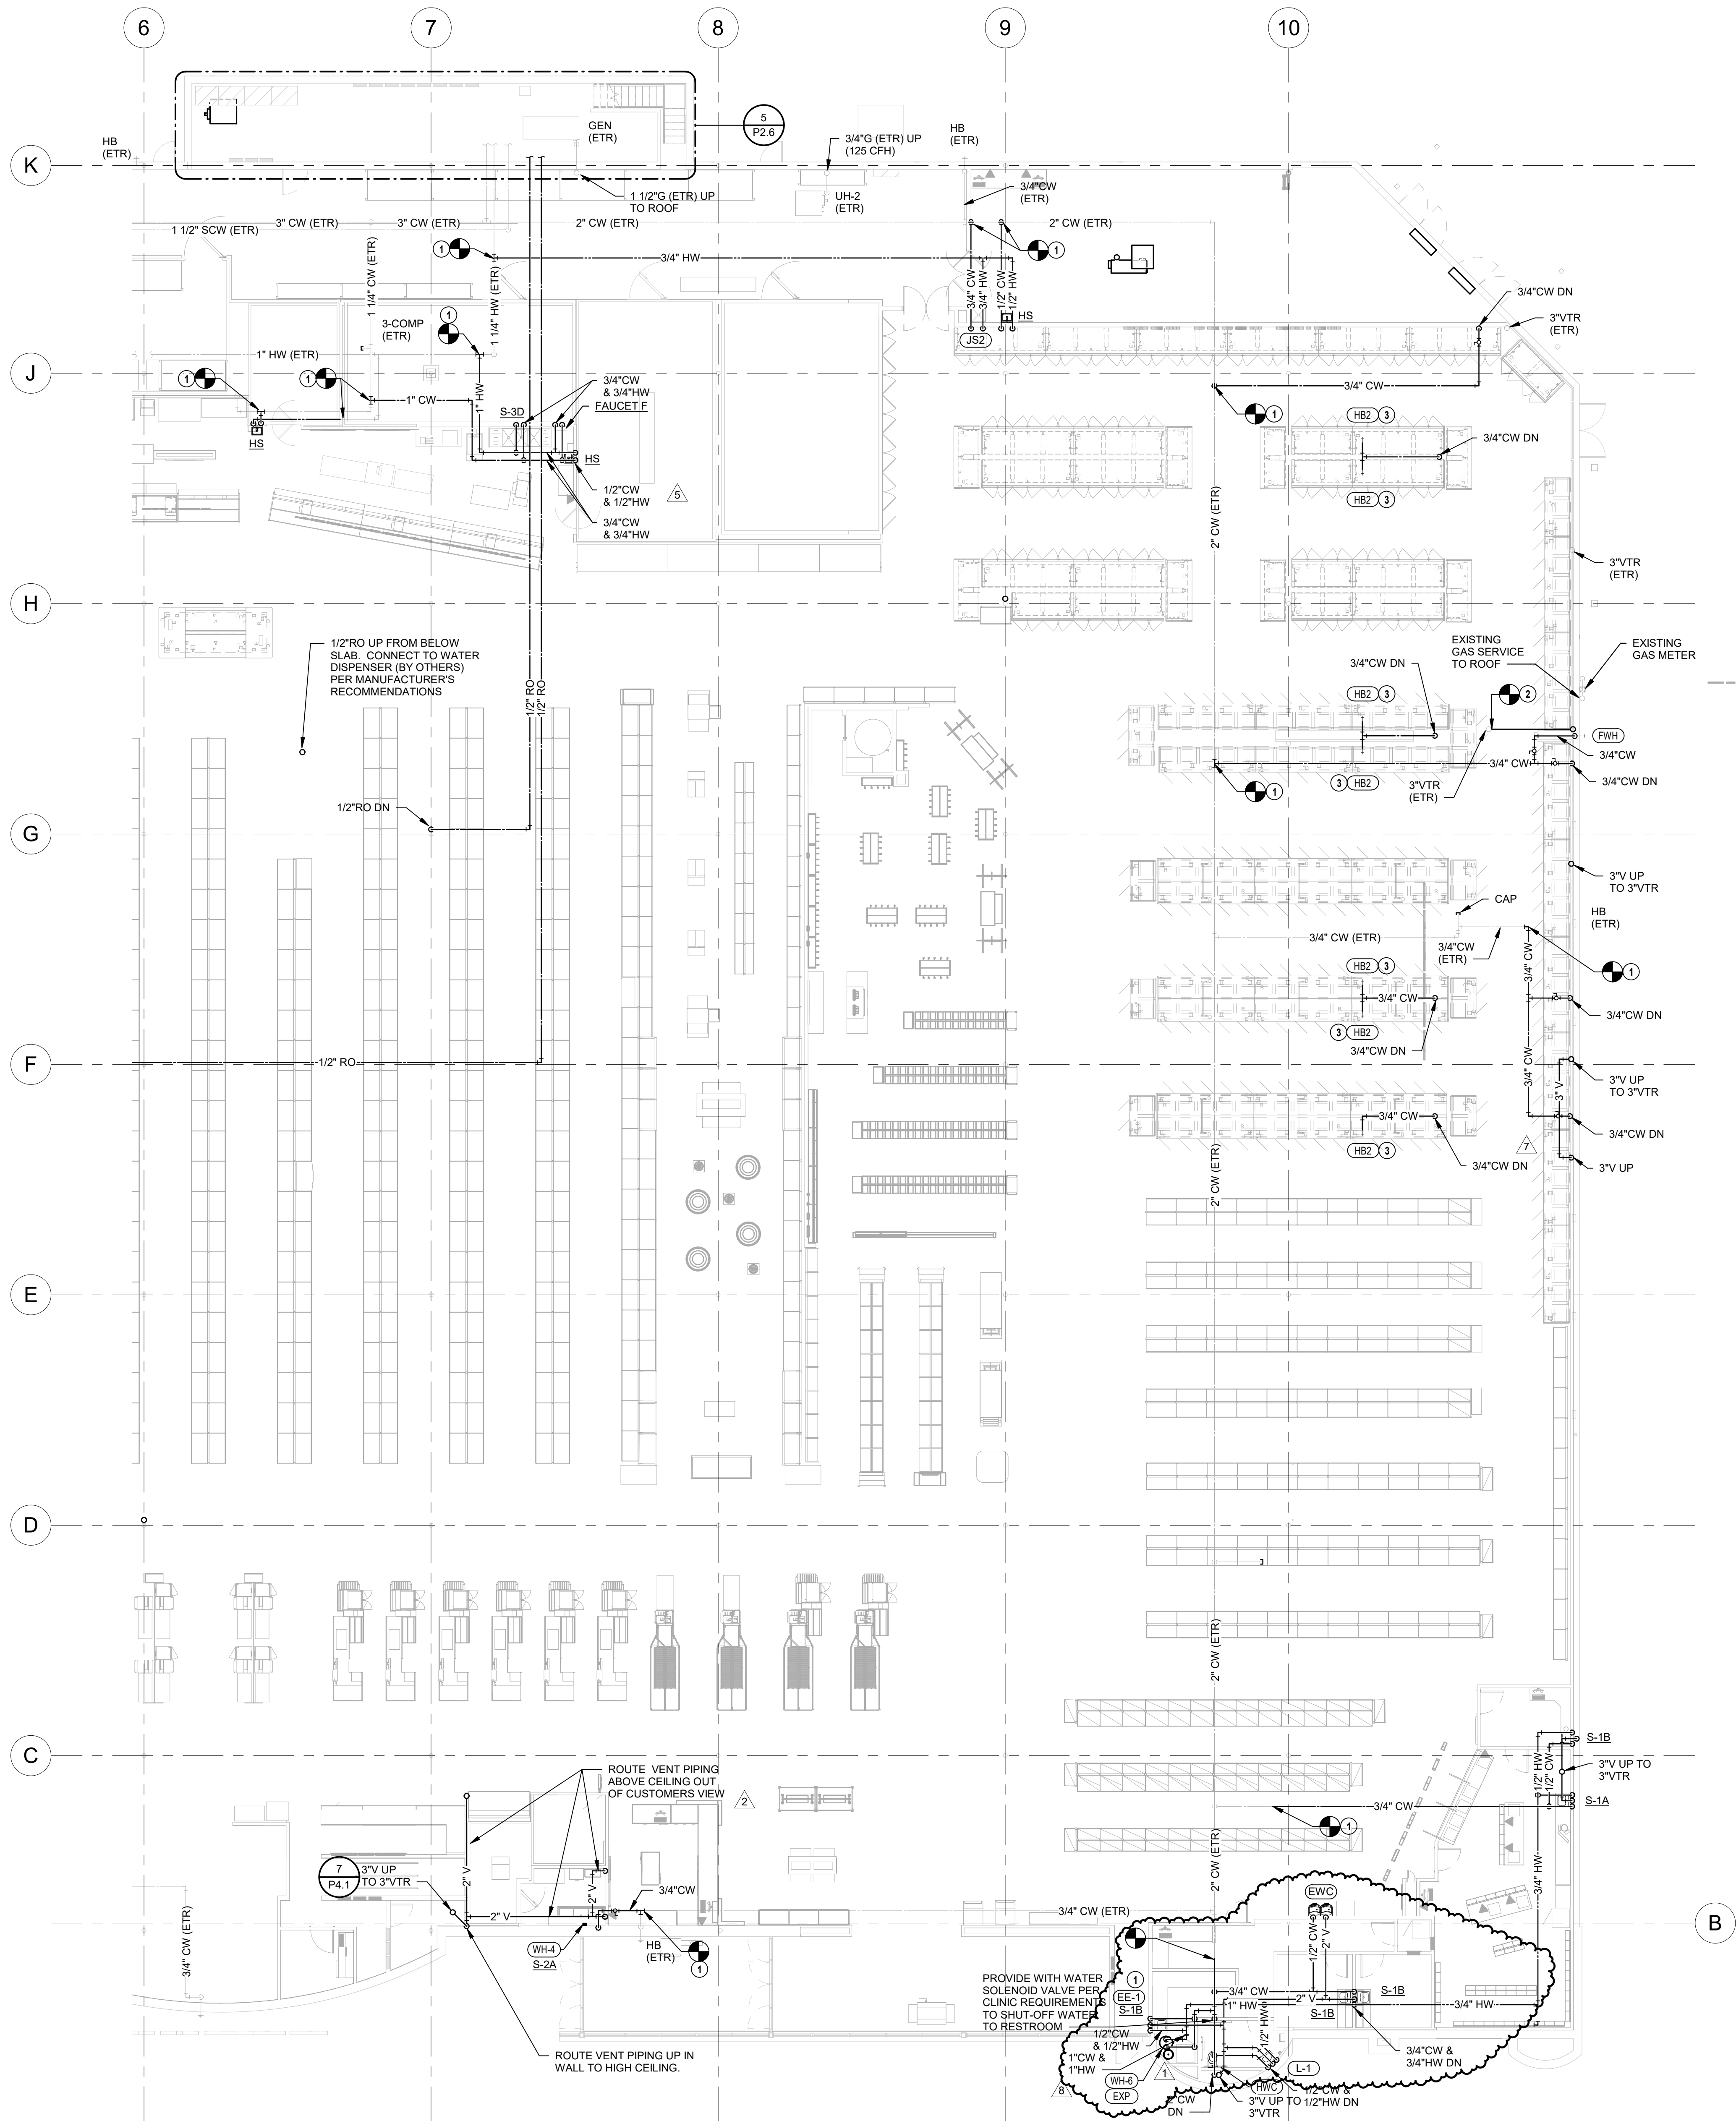

1 PLUMBING FLOOR PLAN - B
3/32" = 1'-0"

PLUMBING GENERAL NOTES

- FURNISH AND INSTALL PLUMBING SYSTEMS IN ACCORDANCE WITH LOCAL AND STATE PLUMBING CODES.
- ALL FLOOR DRAINS, FLOOR SINKS, AND TRENCH DRAINS OUTLETS AND BRANCH SANITARY ARE 3" UNLESS NOTED OTHERWISE.
- ALL FLOOR CLEANOUTS ARE TO BE ACCESSIBLE AND NOT BENEATH MILLWORK, CASEWORK, SHELVES OR OTHER OBSTRUCTIONS. CLEANOUTS SHALL BE THE SAME SIZE AS PIPING BEING SERVED AND AT THE TRANSITION OF PIPE SIZE.
- COORDINATE UNDERFLOOR PIPING ROUTING WITH REFRIGERATION AND ELECTRICAL CONTRACTORS.
- ROUTE BRANCH PIPING 12" ABOVE THE ACCESSIBLE CEILING.

PLUMBING PLAN NOTES

- CONNECT NEW DOMESTIC WATER PIPING TO EXISTING PIPING. FIELD VERIFY EXACT LOCATION AND SIZE PRIOR TO START OF WORK.
- CONNECT NEW VENT PIPING INTO EXISTING VTR. FIELD VERIFY EXACT LOCATION AND SIZE PRIOR TO START OF WORK.
- ROUTE CW PIPING ON TOP OF CASE. INSTALL AND SECURELY FASTEN HB2 IN CENTER OF CASE ARRANGEMENT.

REVISION		DATE BY
1	AS:RT	11/13/20
2	AS:RT	01/07/21
3	AS:RT	03/19/21
4	AS:RT	04/19/21
5	AS:RT	06/02/21

HENDERSON
ENGINEERS
8345 LENEXA DRIVE, SUITE 300
LENEXA, KS 66214
TEL 913.742.5000 FAX 913.742.5001
WWW.HENDERSONENGINEERS.COM


1950003081
MO. CORPORATE NO. E-5560
EXPIRES 12/31/2021

PROFESSIONAL SEAL
JOSHUA N. HOVER
PE-2017008503
05/20/2021
LICENSE # PE-2017008503

LOCATION
LEE'S SUMMIT, MO #2
310 SW WARD RD

HY-VEE INC.
5820 WESTOWN PARKWAY
WEST DES MOINES, IOWA 50326
TEL: (515) 267-2800
FAX: (515) 267-2335

Hy-Vee
EMPLOYEE OWNED

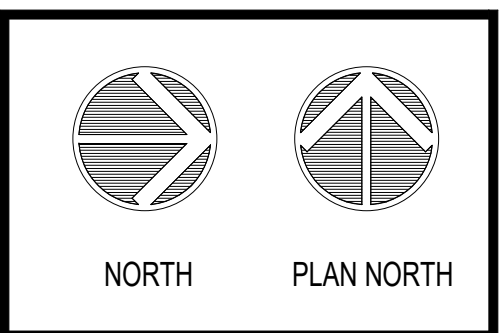

PLUMBING FLOOR
PLAN - B

PROJECT MANAGER SL	CHECKED BY HEI
DRAWN BY: HEI	DATE: 10/19/2020
SCALE: AS NOTED	JOB NUMBER: 62830547
SHEET:	

P2.0B