 
 
 
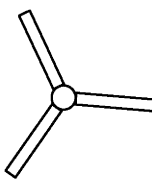
 
 
 



CEILING LEGEND

	PENDANT LIGHT
	4' STRIP LIGHT
	8' STRIP LIGHT
	4' ENCLOSED STRIP LIGHT (DOG WASH)
	4' TRACK WITH 3 HEADS
	CEILING FAN
	SUSPENSION CEILING SYSTEM
	EXHAUST FAN
	RETURN AIR GRILLE. REFER TO MECHANICAL DRAWINGS
	SUPPLY AIR DIFFUSER. REFER TO MECHANICAL DRAWINGS


NOTE:
REFER TO LIGHT FIXTURE SCHEDULE ON SHEET E1.0
FOR COMPLETE FIXTURE DESCRIPTIONS.

CEILING NOTES

1. PAINT ALL GYPSUM BOARD CEILINGS, EXPOSED DECK STRUCTURE, CONDUIT, PIPING, DUCTWORK AND SOFFITS P-2, UNLESS OTHERWISE NOTED; FACE OF RETURNS TO MATCH THE UNDERSIDE. NO COLOR TO CHANGE AT AN OUTSIDE CORNER.
2. PAINT ALL DIFFUSER AND OTHER EXPOSED MECHANICAL COMPONENTS TO MATCH CEILING IN WHICH THEY OCCUR.
3. REFER TO INTERIOR ELEVATIONS FOR ADDITIONAL INFORMATION ABOUT PENDANTS AND OTHER DECORATIVE LIGHTING.
4. OUTLETS, SWITCHES AND DEVICES TO MATCH THE MATERIAL IN WHICH THEY OCCUR.
5. ALL CEILING TILES TO BE CENTERED IN ROOM, CENTER LIGHT FIXTURES IN ROOMS WITH ACOUSTIC TILE UNLESS NOTED OTHERWISE.
6. SEE MEP DRAWINGS FOR ADDITIONAL CEILING INFORMATION.
7. ALIGN GYP. BD. SOFFIT AT STOREFRONT WITH HEADER.
8. COORDINATE FINAL CASHWRAP PENDANT LIGHTING WITH TENANT.

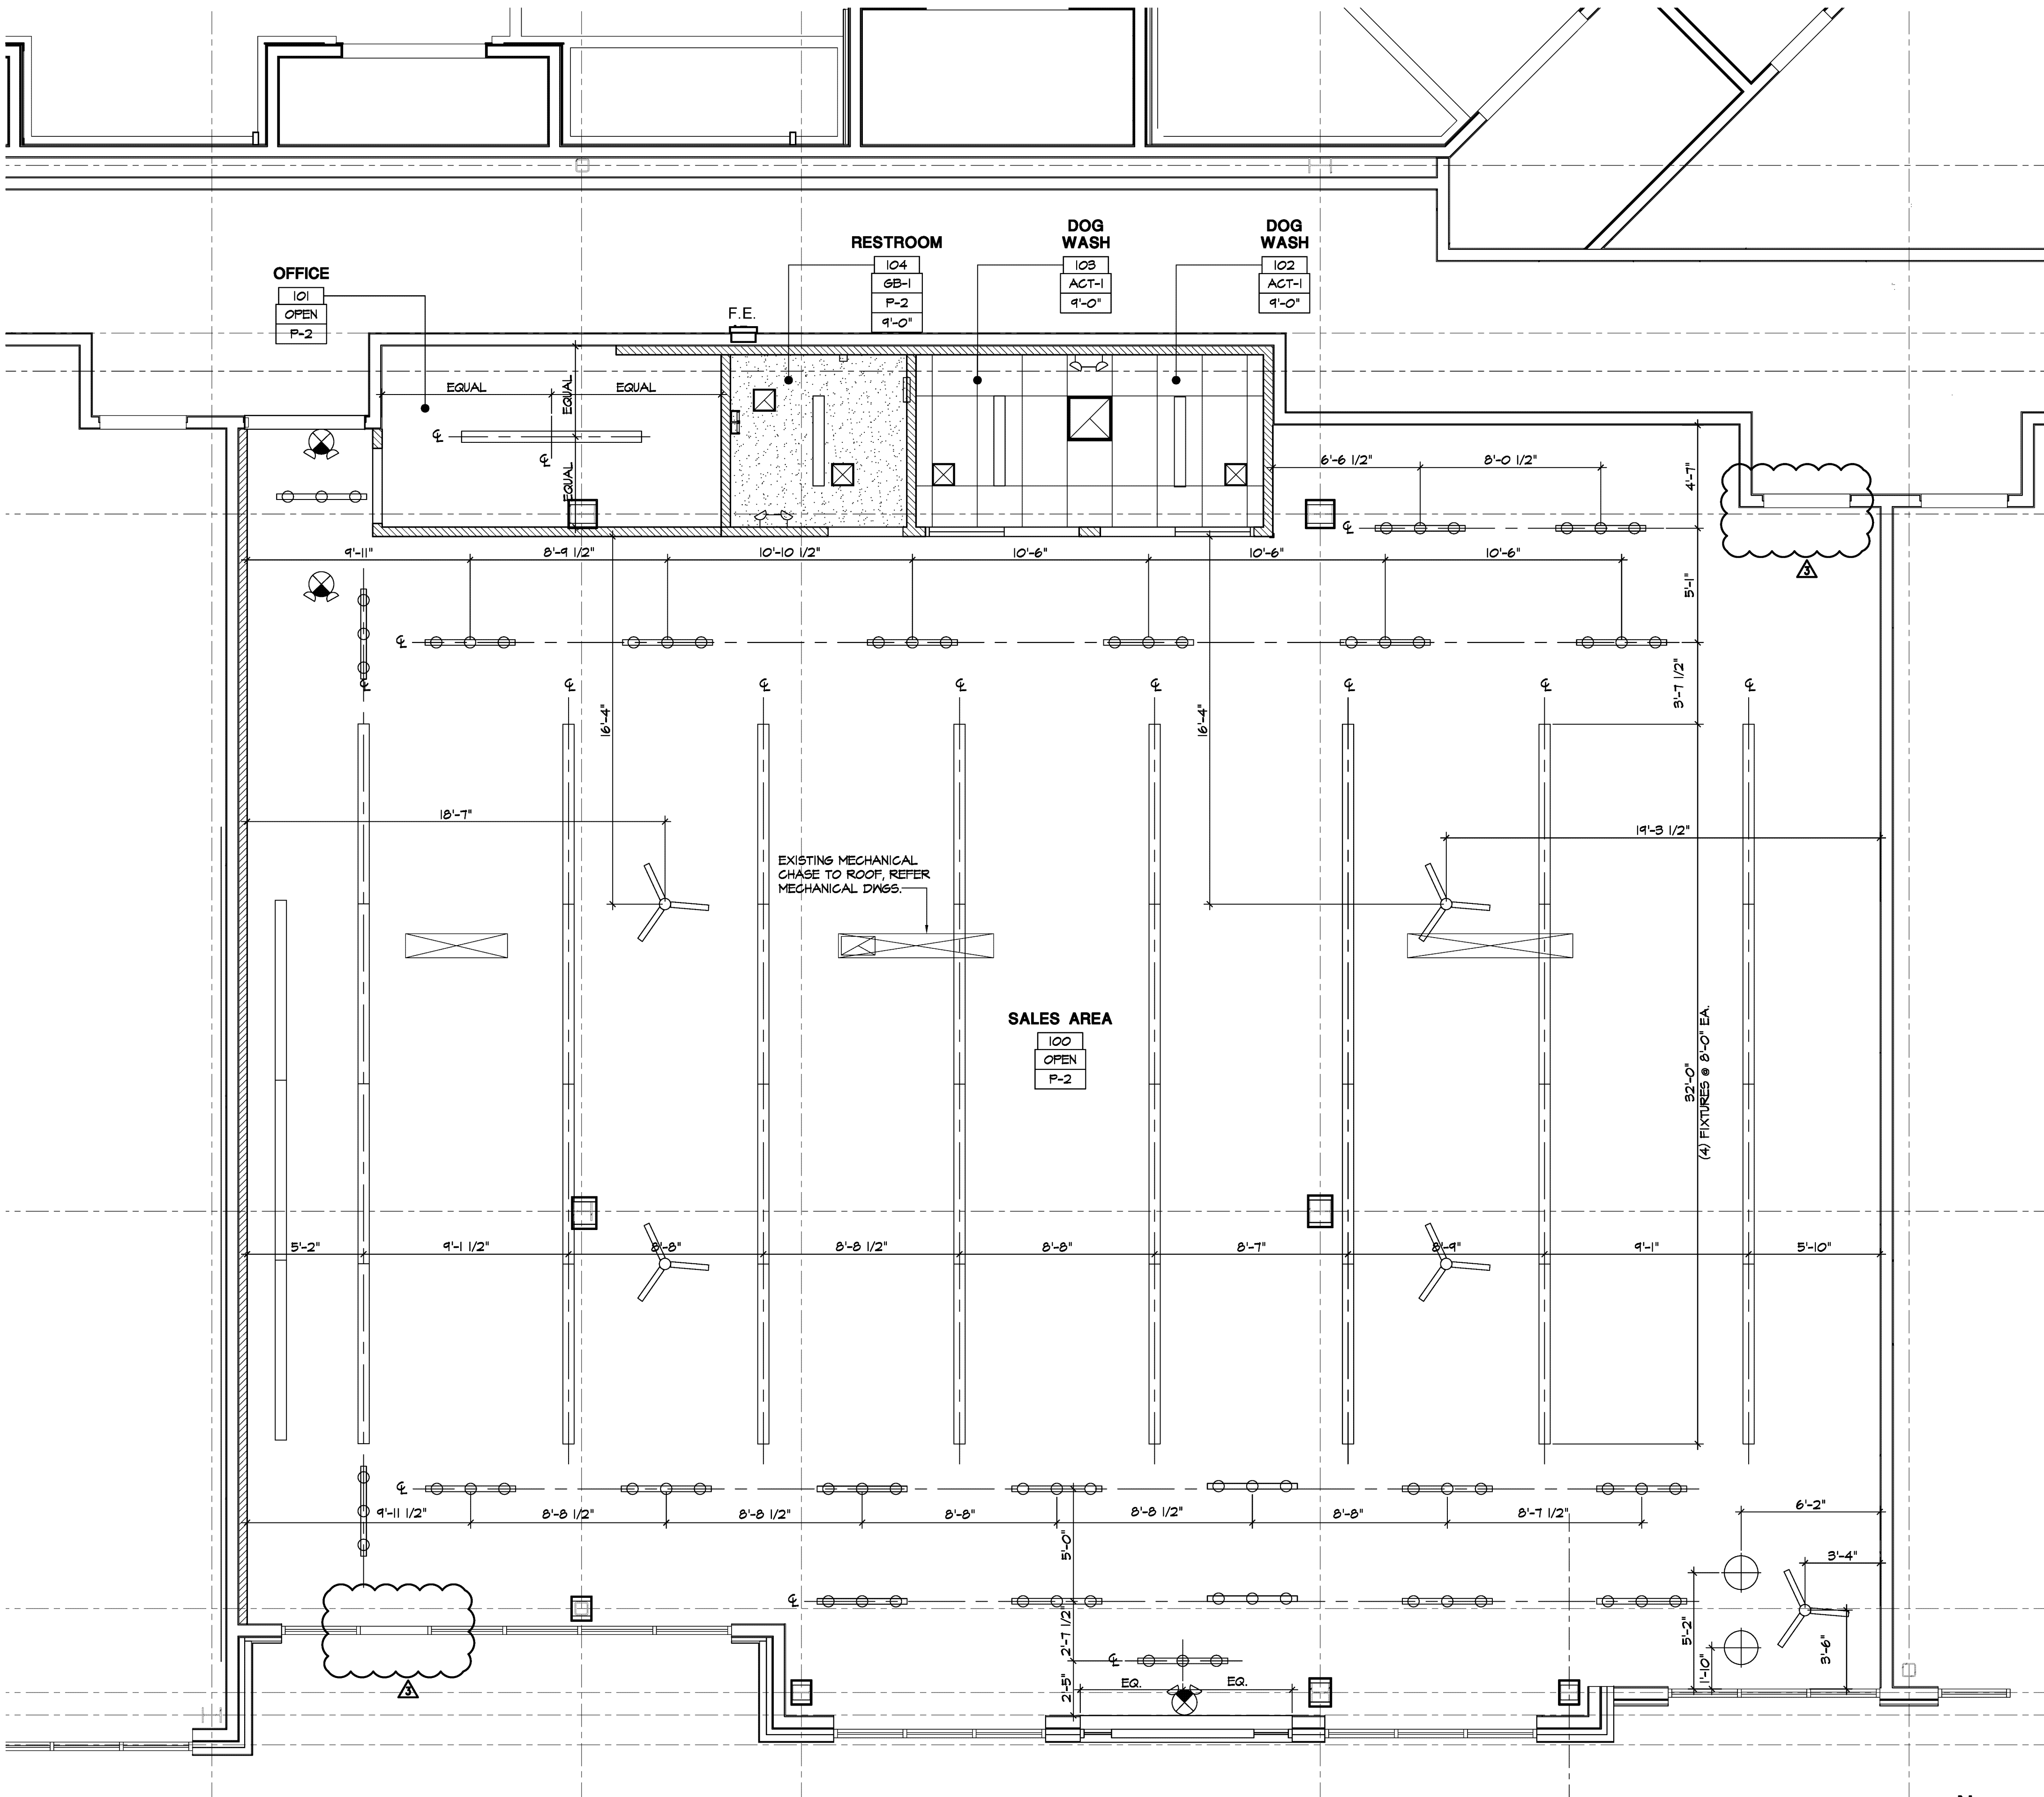


1 REFLECTED CEILING PLAN
1/4" = 1'-0"

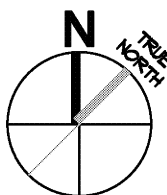

\\XREF-KansasCity_MO.dwg
\\XREF-KansasCity_MO.dwg
\\XREF-KansasCity_MO.dwg
Drawn By: [Name]
Date: [Date]

onyx creative
25001 Emery Road, Suite 400
Cleveland, Ohio 44128
216.233.3200 onyxcreative.com

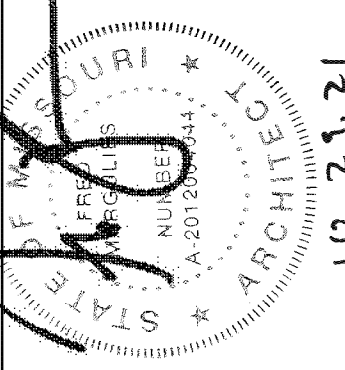

Design and construction documents are instruments of service and shall remain the property of Onyx Creative. The use of this design and these construction documents for purposes other than the specific project named herein is strictly prohibited without expressed written consent of Onyx Creative.

PetPeople
SUMMIT AT WEST PRYOR
940 NW PRYOR RD, UNIT J
LEES SUMMIT (KANSAS CITY), MO

Project No.: 18804
Drawn By: XXX
Date: 07/10/2021
Issue: Etk/ Permit
10/22/2021 Revision: 3

A3.0
REFLECTED CEILING PLAN