



DATE	REVISIONS

Pet People
940 NW Pryor Road
Lee's Summit, MO 64081

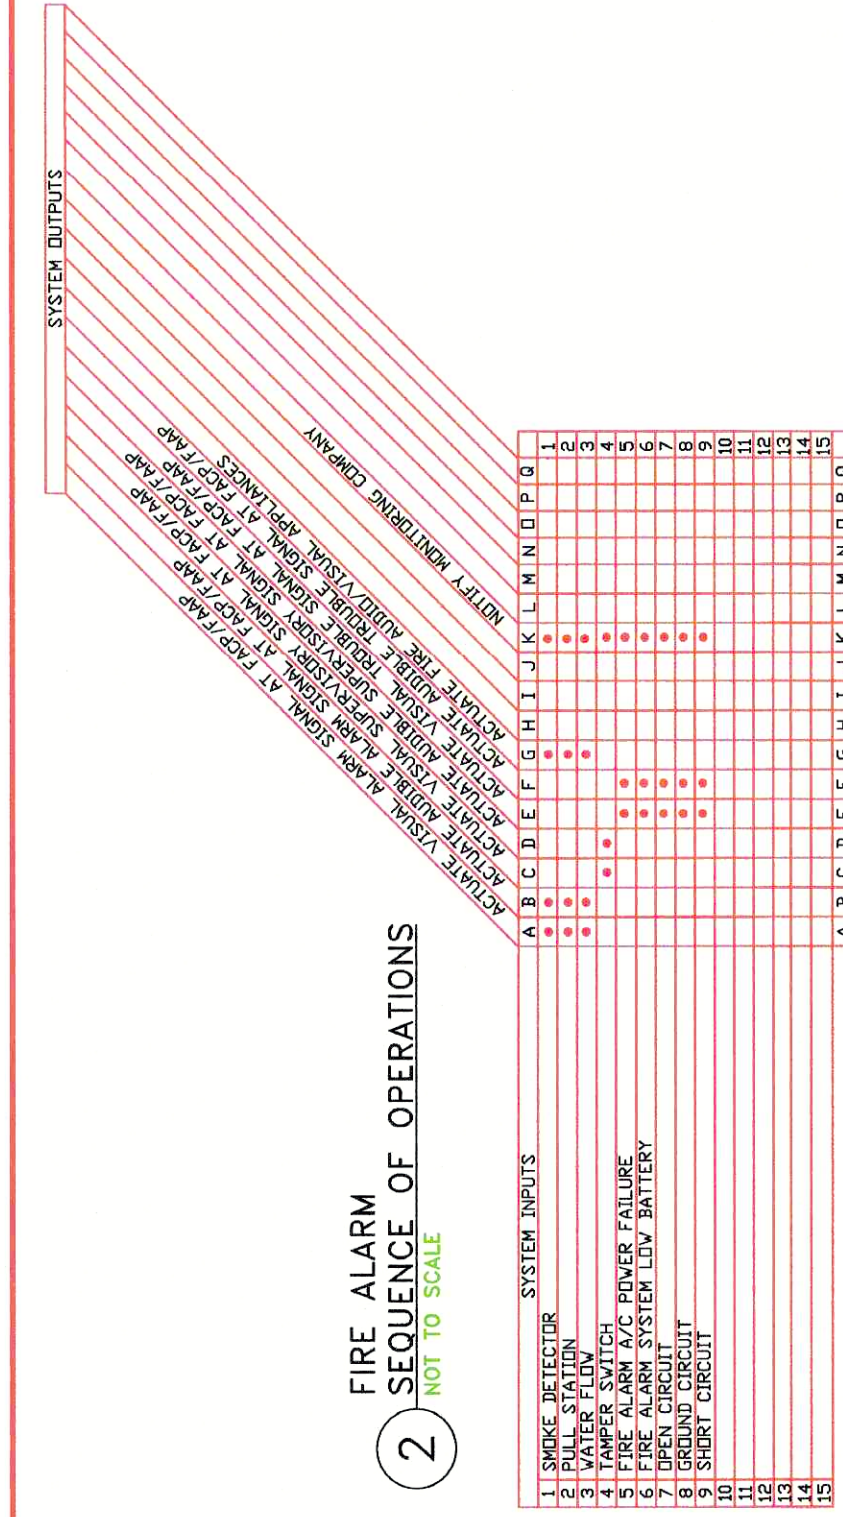
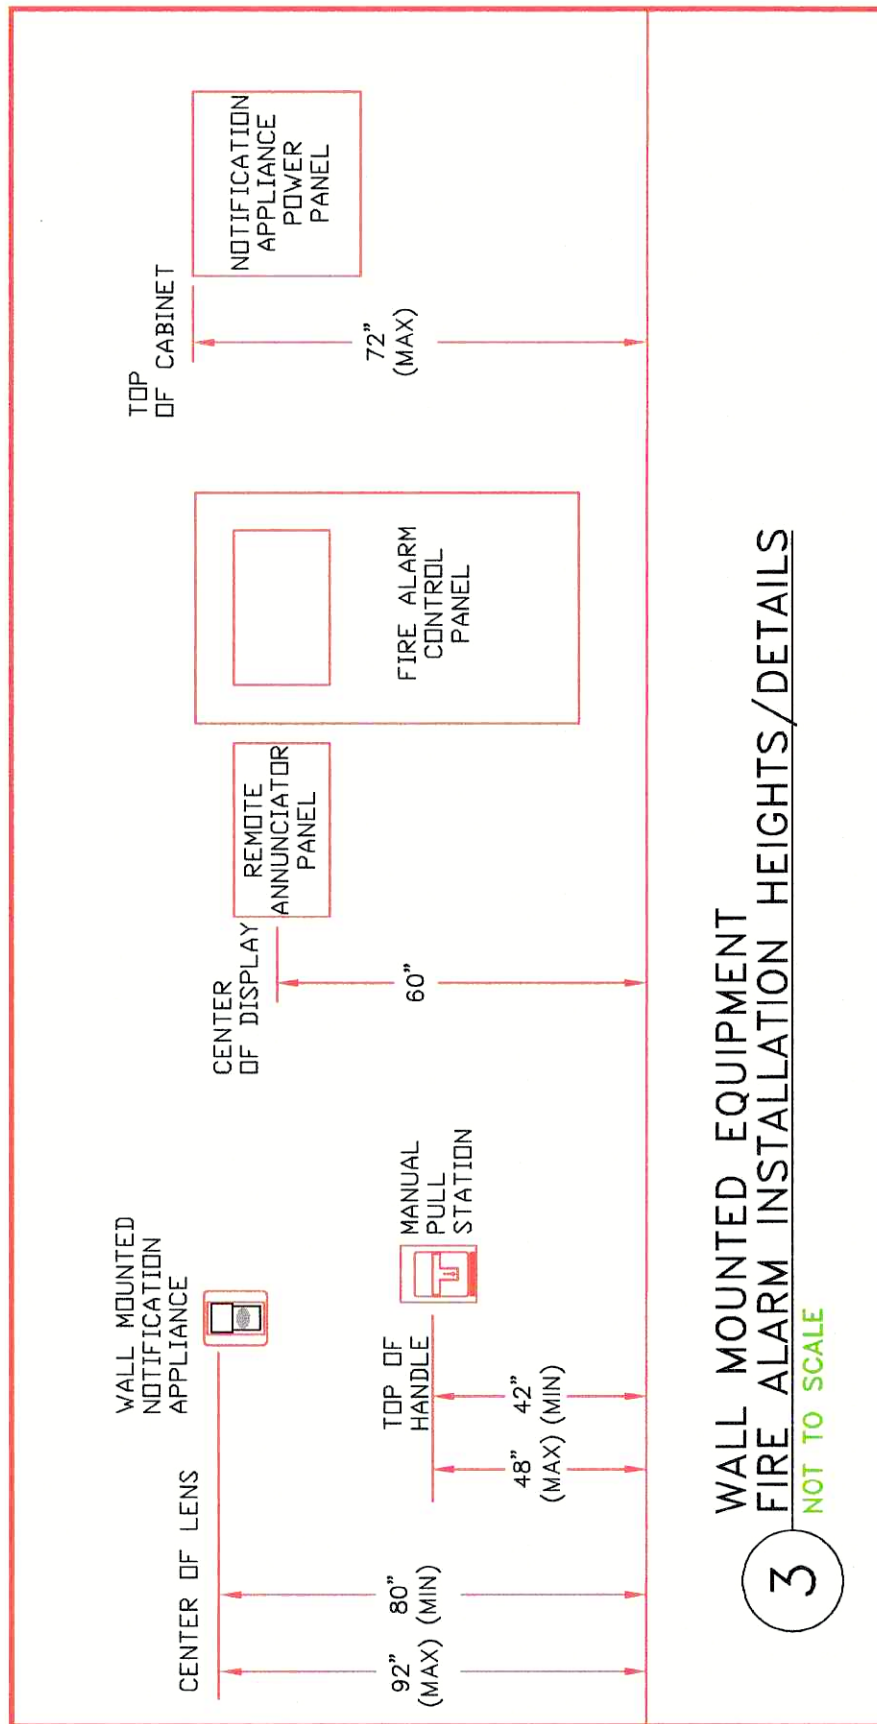
Aegis Fire Protection, LLC
Corporate: 913-825-1196 W. 119th St. #262 Overland Park, KS 66213
Phone: 913-825-0343 Fax: 913-322-4475
Email: info@aegisfirepro.com



JOB NO.	15668
JOB NAME	PetPeople Tenant Finish
FIRE ALARM PLAN	
AHF:	CITY & OWNER
SCALE:	1/4"=1'-0"
DESIGNED BY:	RWS
CHECKED BY:	GT
DATE:	11-10-21
SHEET NO.	
FA1	
1 OF 1	



1 FIRE ALARM PLAN
1/4" = 1'0"

[illegible]