


FIRE ALARM LEGEND	
SYMBOL	DESCRIPTION
	N.A.C. POWER EXTENDER
	AREA SMOKE DETECTOR
	FIRE ALARM MANUAL STATION
	COMB. F.A. HORN & VISUAL SIGNAL
	F.A. VISUAL SIGNAL
	END OF LINE RESISTOR

WIRING LEGEND	
	18-2 FPLP WIRE (DATA)
	14-2 FPLP WIRE (A/V)

**GENERAL NOTES**


- ALL STROBES HAVE A 15 CANDELLA RATING UNLESS NOTED OTHERWISE
- CONNECT DATA WIRE TO EXISTING FIRE ALARM SYSTEM

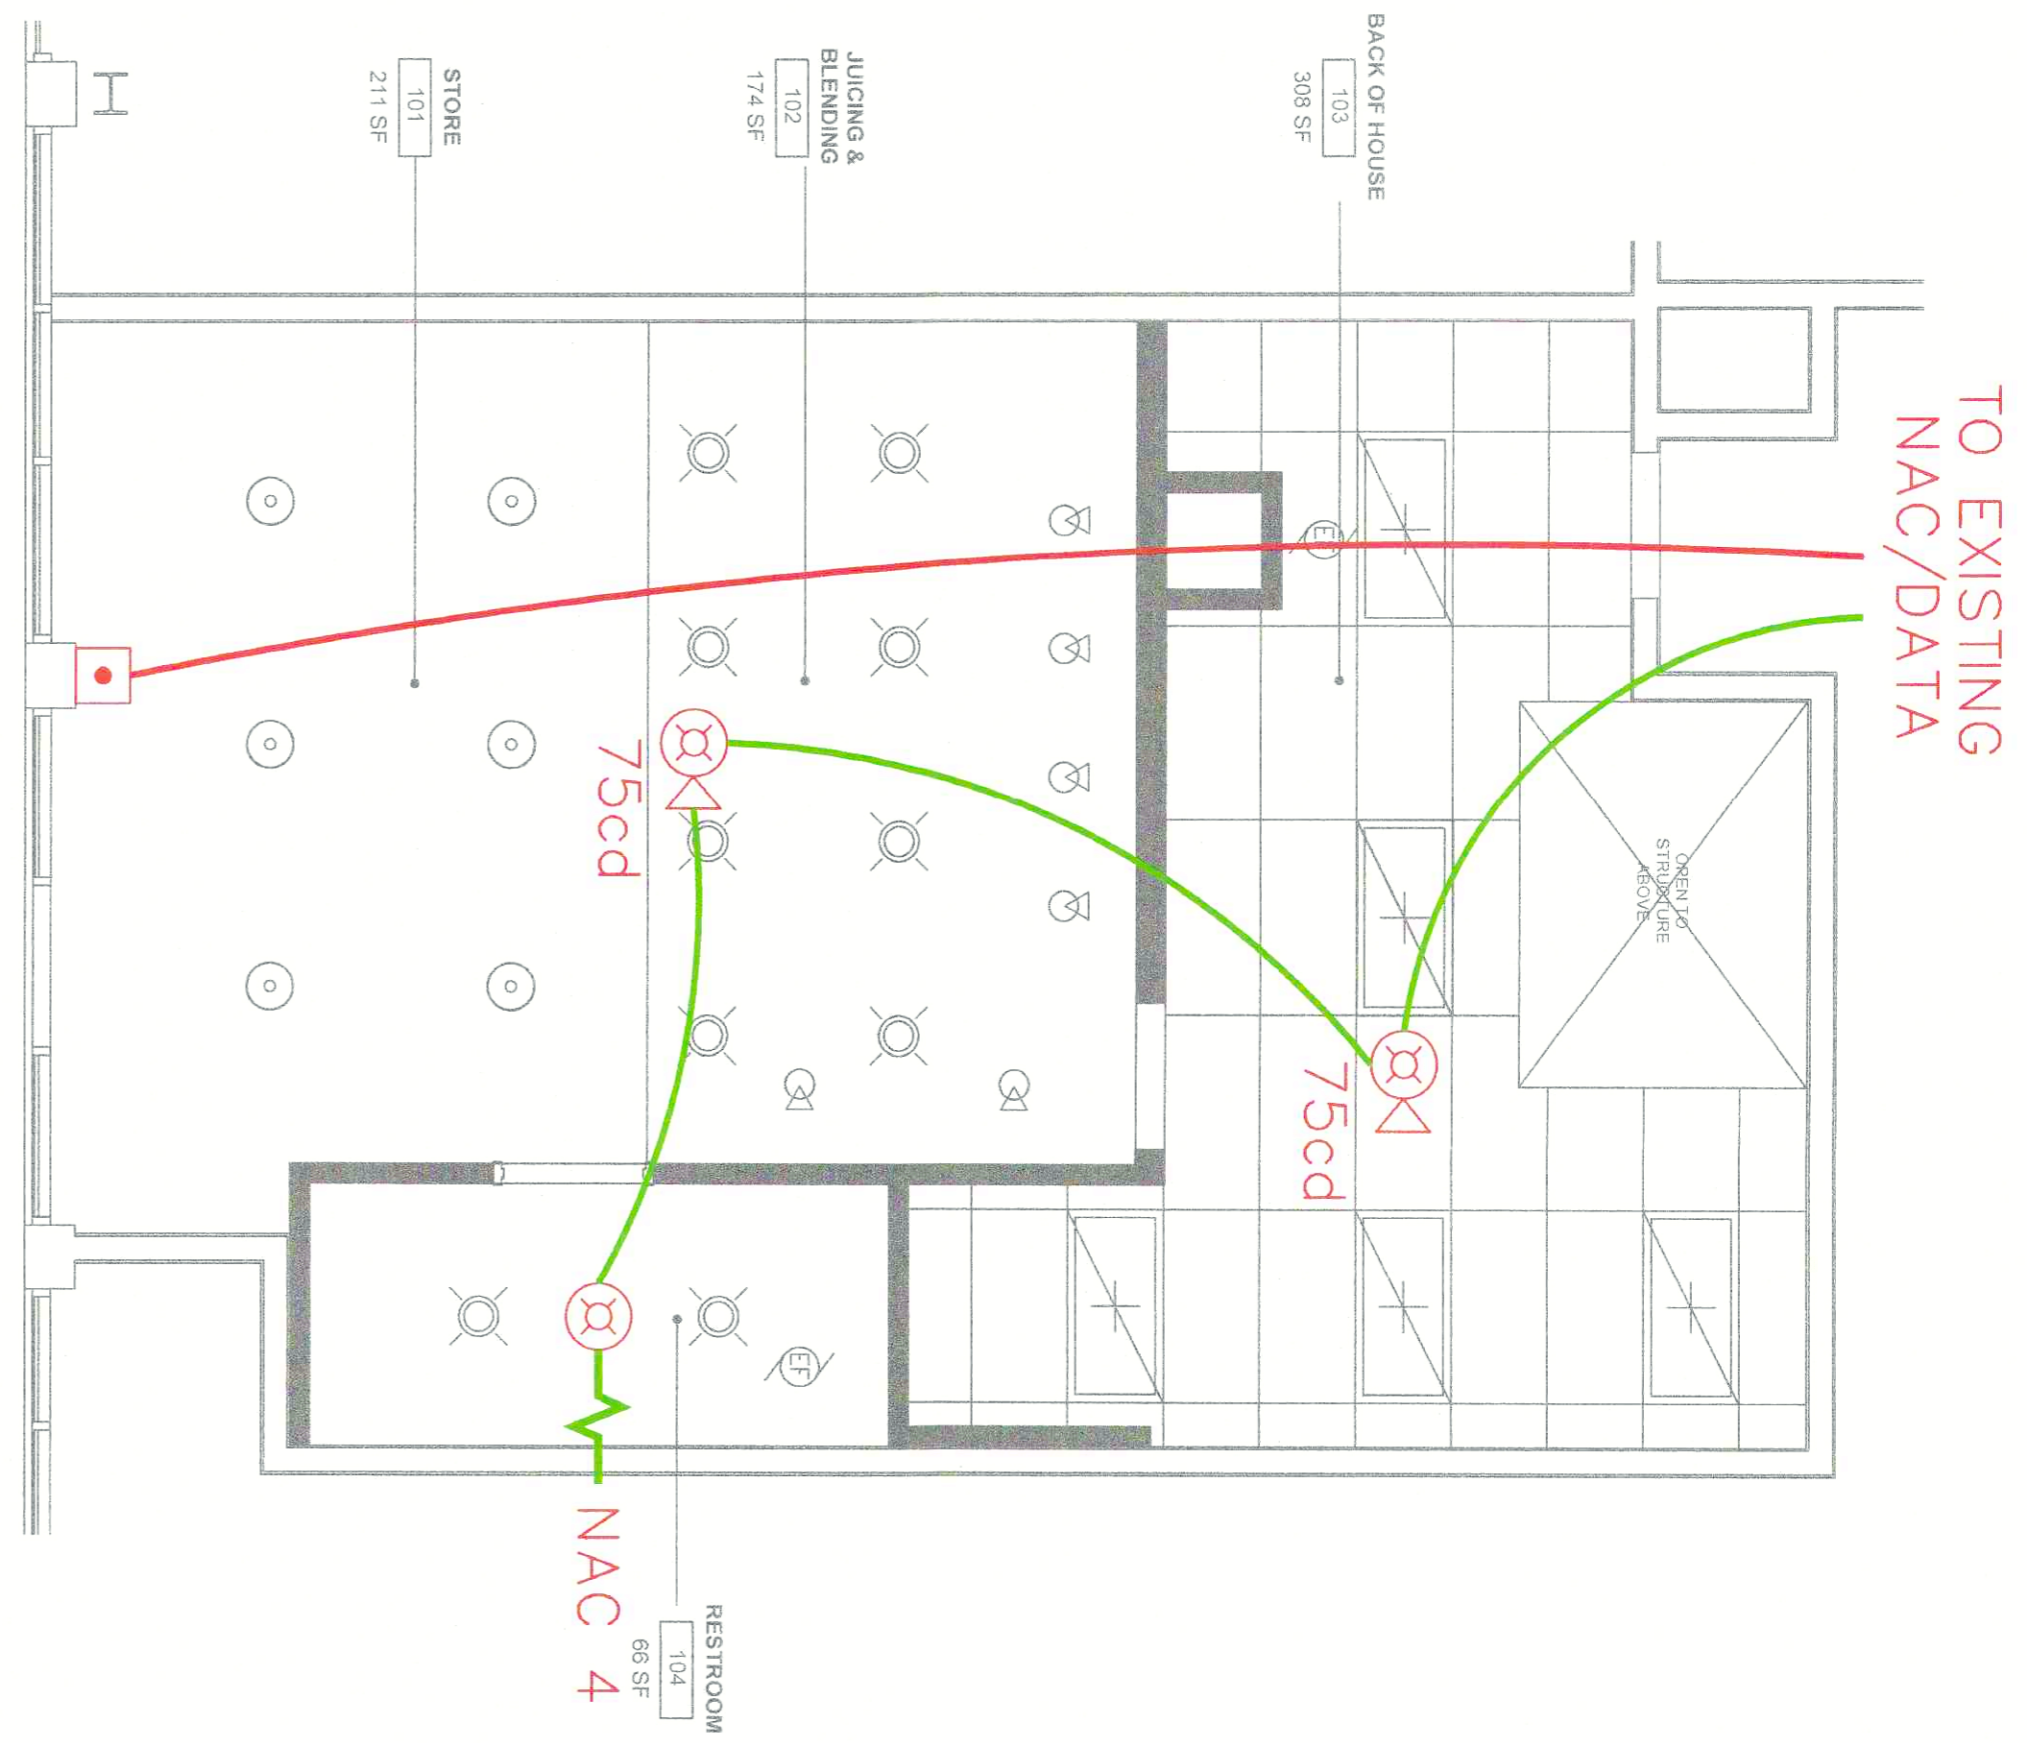

1 FIRE ALARM PLAN  
1/4" = 10'

2 FIRE ALARM SEQUENCE OF OPERATIONS  
NOT TO SCALE

SYSTEM SIGNALS	A	B	C	D	E	F	G	H	I	J	K	L	M	N	O	P	Q	R	S	T	U	V	W	X	Y	Z
SMOKE DETECTOR	.	.	.	.	.	.	.	.	.	.	.	.	.	.	.	.	.	.	.	.	.	.	.	.	.	.
AREA SMOKE DETECTOR	.	.	.	.	.	.	.	.	.	.	.	.	.	.	.	.	.	.	.	.	.	.	.	.	.	.
FIRE ALARM MANUAL STATION	.	.	.	.	.	.	.	.	.	.	.	.	.	.	.	.	.	.	.	.	.	.	.	.	.	.
COMB. F.A. HORN & VISUAL SIGNAL	.	.	.	.	.	.	.	.	.	.	.	.	.	.	.	.	.	.	.	.	.	.	.	.	.	.
F.A. VISUAL SIGNAL	.	.	.	.	.	.	.	.	.	.	.	.	.	.	.	.	.	.	.	.	.	.	.	.	.	.
END OF LINE RESISTOR	.	.	.	.	.	.	.	.	.	.	.	.	.	.	.	.	.	.	.	.	.	.	.	.	.	.

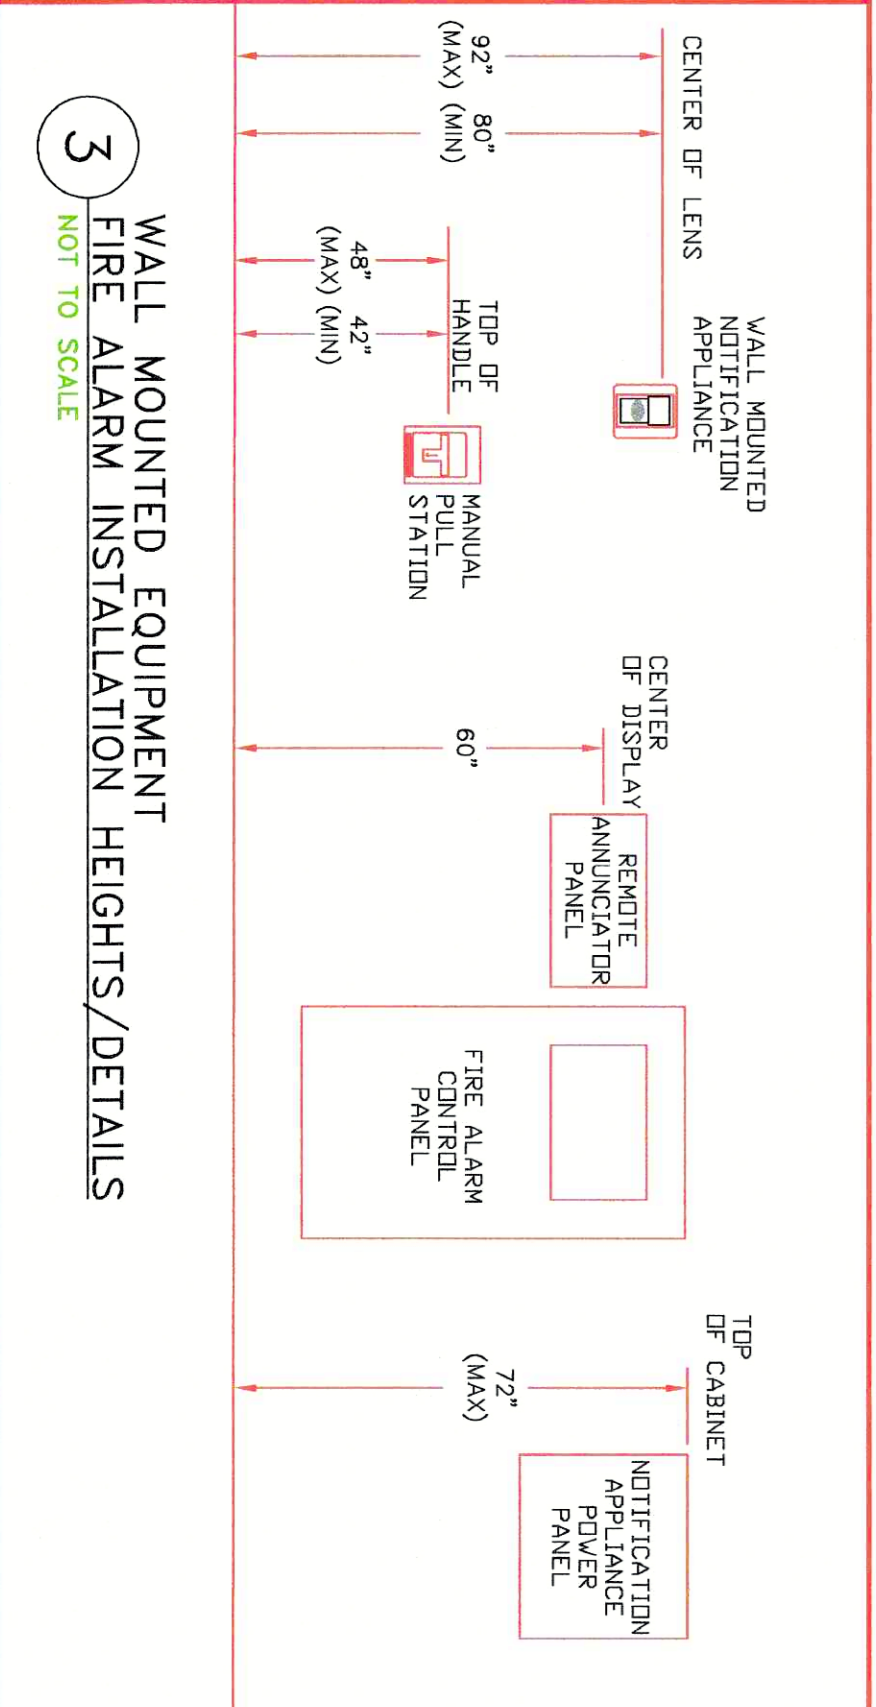

JOB NO. 15805  
JOB NAME: Nektar Juice Bar Tenant Finish  
FIRE ALARM PLAN  
DATE: 12-9-21  
SCALE: 1/4" = 10'  
DESIGNED BY: RNS  
CHECKED BY: GT  
SHEET NO. 1 OF 1



**Aegis Fire Protection, LLC**  
Corporate: 11936 W. 119th St. #262 Overland Park, KS 66213  
Phone: 913-825-0343 Fax: 913-322-4475  
Email: info@agisfirepro.com

**Nektar Juice Bar**  
940 NW Pryor Road  
Lee's Summit, MO 64081

DATE	REVISIONS

