




DATE	REVISIONS

Roots Restaurant
940 NW Pryor Road
Lee's Summit, MO 64081

Aegis Fire Protection, LLC
Corporate: 1196 W. 119th St. #262 Overland Park, KS 66213
Phone: 913-825-0343 Fax: 913-322-4475
Email: info@agfsfirepro.com



JOB NO.	15822
JOB NAME	Roots Restaurant Tenant Finish
FIRE ALARM PLAN	
DATE	12-15-21
SHEET NO.	FA1 1 of 1
SCALE	1/4" = 1'-0"
DESIGNED BY	RMS
CHECKED BY	GT
DATE	12-15-21
QTY & OWNER	

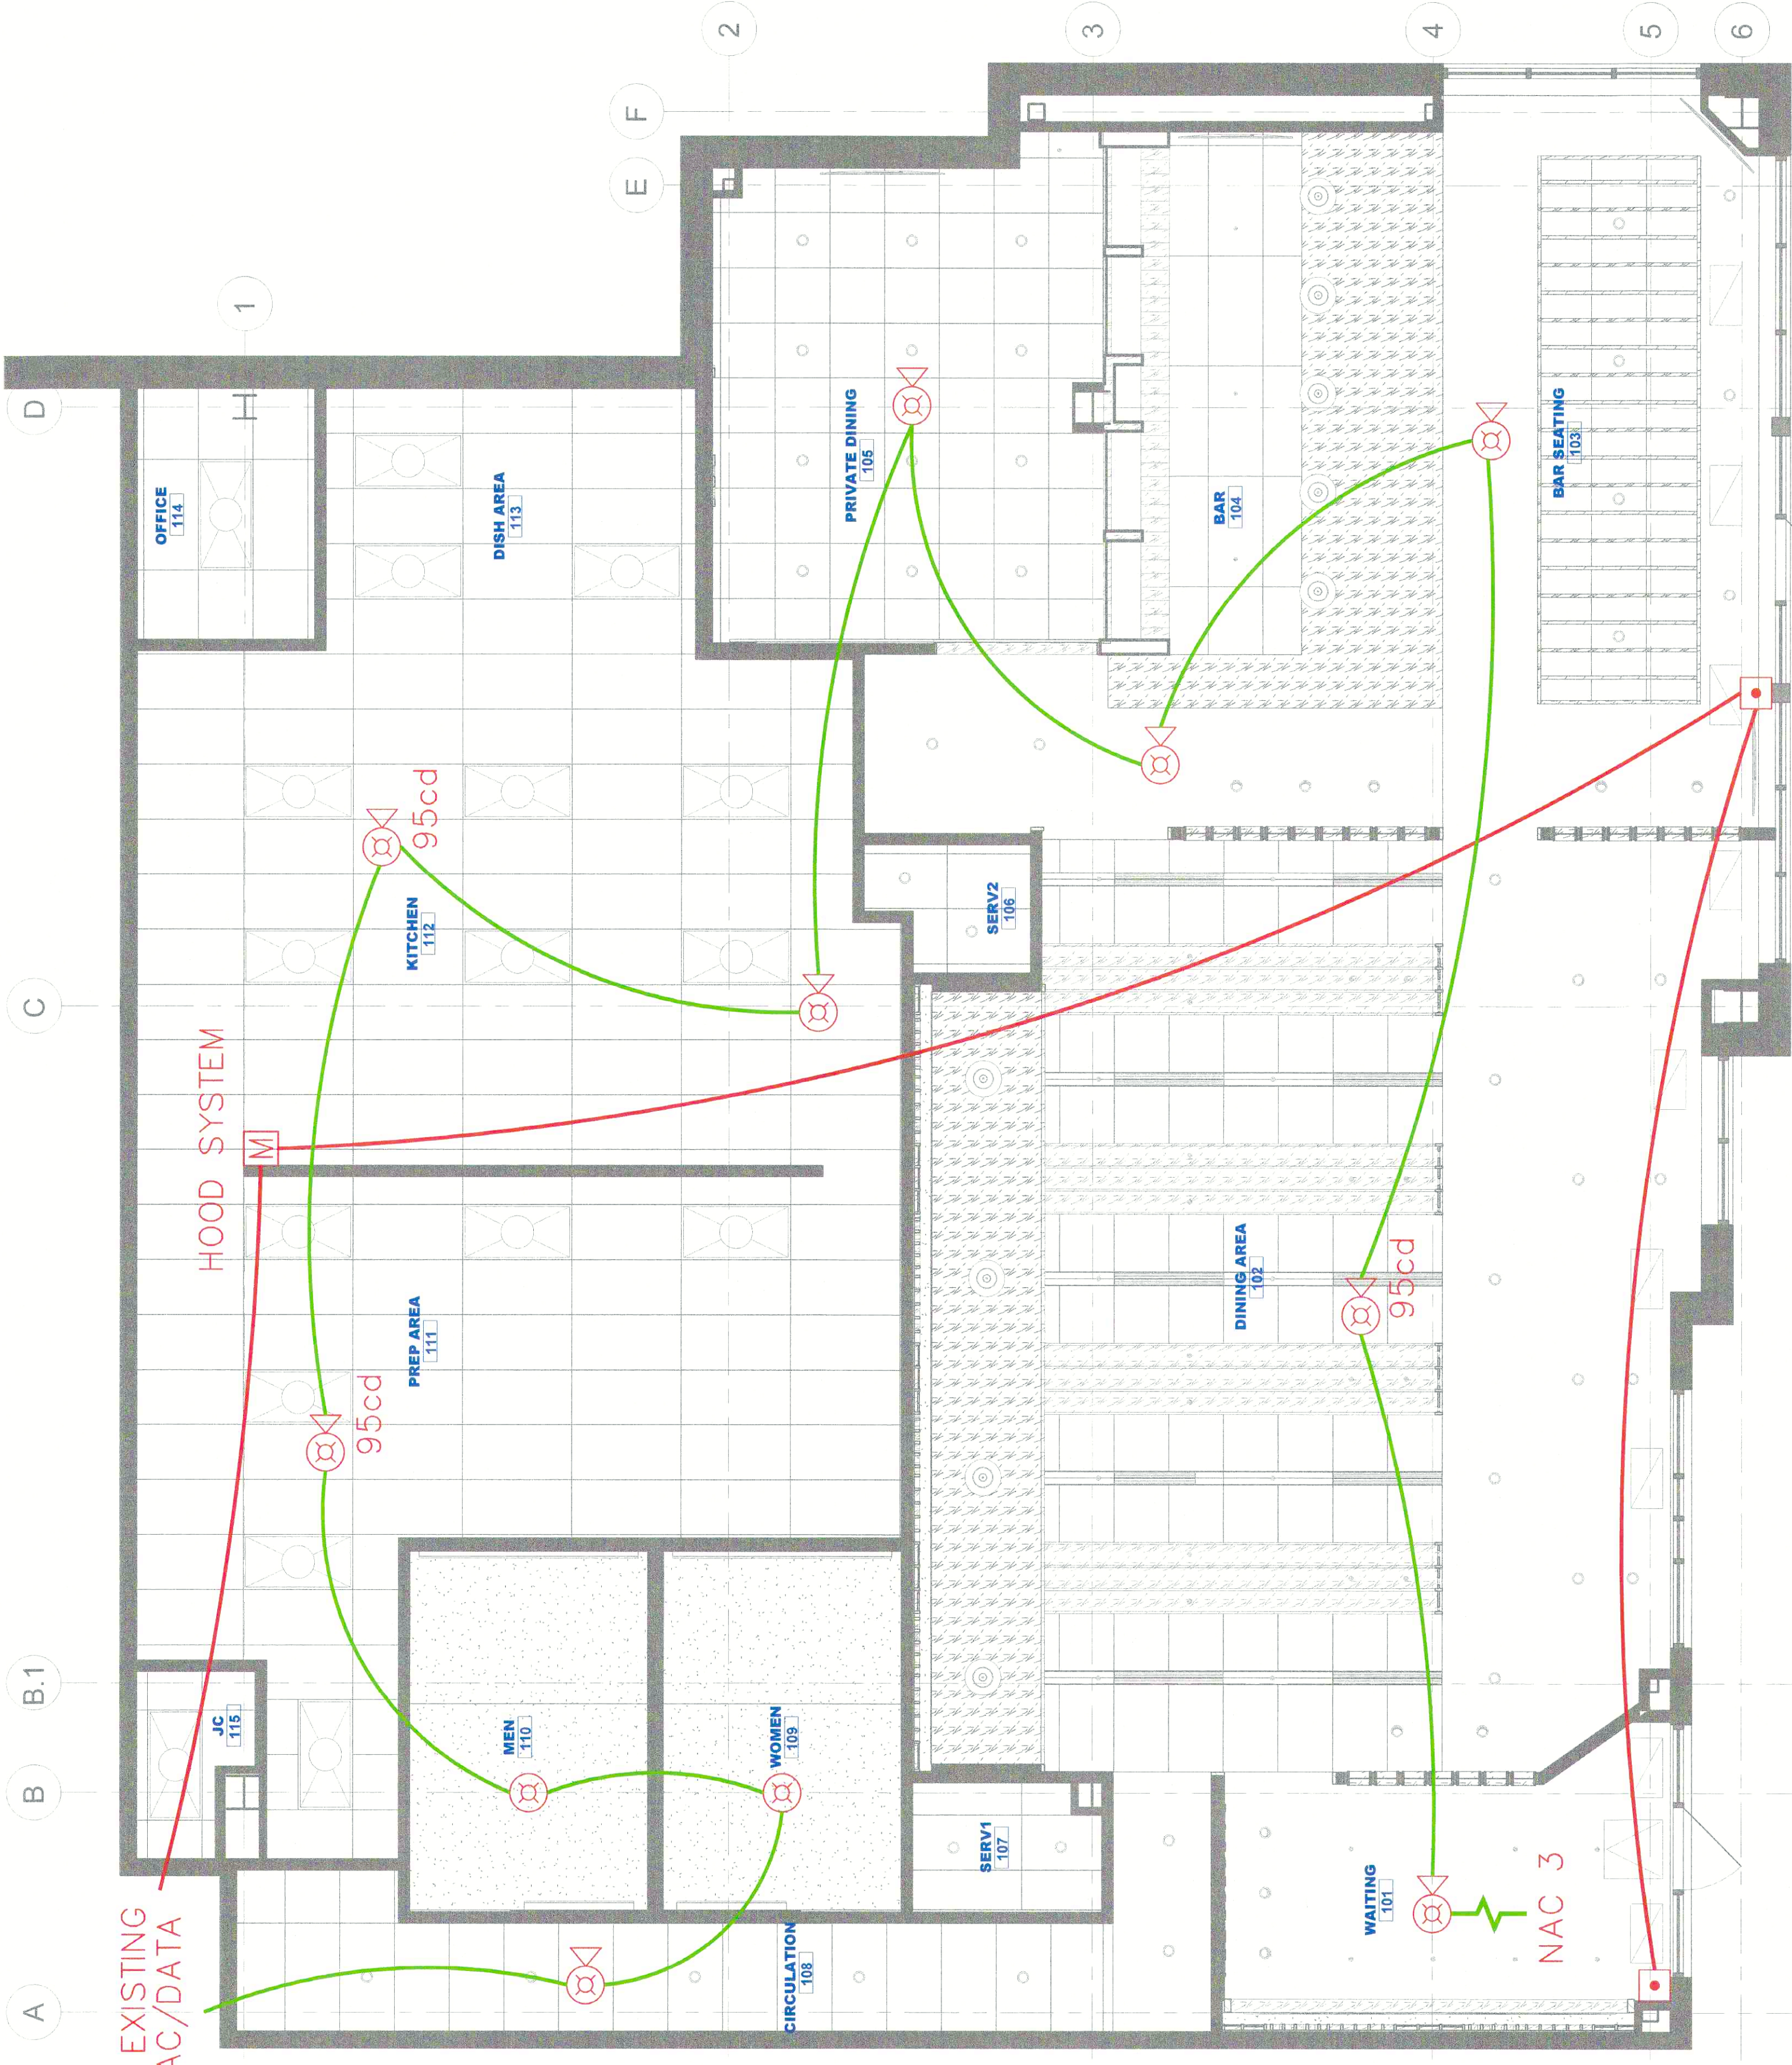

1 FIRE ALARM PLAN
1/4" = 1'-0"

SYSTEM INPUTS		SYSTEM OUTPUTS																										
1	SMoke DETECTOR	A	B	C	D	E	F	G	H	I	J	K	L	M	N	O	P	Q	R	S	T	U	V	W	X	Y	Z	
2	WATER FLOW																											
3	FIRE ALARM F.A. POWER FAILURE																											
4	FIRE ALARM F.A. POWER FAILURE																											
5	OPEN CIRCUIT																											
6	SHORT CIRCUIT																											

2 FIRE ALARM
SEQUENCE OF OPERATIONS
NOT TO SCALE

FIRE ALARM LEGEND		WIRING LEGEND	
SYMBOL	DESCRIPTION	MOUNTING	
NAC	N.A.C. POWER EXTENDER	WALL	
1	AREA SMOKE DETECTOR	CEIL./WALL	
2	FIRE ALARM MANUAL STATION	WALL	
3	COMB. F.A. HORN & VISUAL SIGNAL	CEILING	
4	F.A. VISUAL SIGNAL	CEILING	
5	MONITOR MODULE		
6	END OF LINE RESISTOR		
GENERAL NOTES		FIRE ALARM INSTALLATION HEIGHTS/DETAILS	
1. ALL STROBES HAVE A 15 CANDELLA RATING UNLESS NOTED OTHERWISE		3 NOT TO SCALE	
2. CONNECT DATA WIRE TO EXISTING FIRE ALARM SYSTEM			

