

The Signature at West Pryor Lee's Summit, MO

PROJECT INFORMATION

STATE: Missouri
COUNTY: Jackson
CITY: Lee's Summit
TYPE: Inground pool, non-diving
SCOPE: Single body pool
CONSTRUCTION METHOD: Concrete
SANITATION: Intellichem with acid and chlorine injection
COVER: YES - Winter Safety Cover
HEATED: NO

PROJECT TEAM

MIDWEST CUSTOM POOLS

GLEN WESTERVELT, PRESIDENT
785.766.1111
GLEN@MIDWESTCUSTOMPOOLS.COM

ERIK MILLER, PROJECT MANAGER
785.304.0171
ERIK@MIDWESTCUSTOMPOOLS.COM

GENERAL NOTES

- > ANY CHANGES IN CONSTRUCTION PLANS OR EQUIPMENT MUST BE APPROVED BY THE GOVERNING HEALTH DEPARTMENT. CHANGES MAY REQUIRE ADDITIONAL PLAN CHECK FEES AND RE-SUBMITTAL.
- > POOL PLAN APPROVAL DOES NOT AUTHORIZE THE VIOLATION OF ANY LAW, ORDINANCE, OR REGULATION AND FINAL APPROVAL IS SUBJECT TO FIELD INSPECTION.
- > ALL EQUIPMENT SHALL BE INSTALLED PER MANUFACTURER'S INSTRUCTIONS.
- > ALL EQUIPMENT AND MATERIALS NOT SHOWN OR SPECIFIED ON THESE PLANS, BUT REQUIRED TO COMPLETE THIS PROJECT, SHALL BE SUPPLIED BY THE POOL CONTRACTOR AS PART OF THIS CONTRACT WORK.

LOCATION MAP



POOL DATA

PERIMETER: 183 - FT
SURFACE AREA: 1667 - SQFT
APPROXIMATE VOLUME: 27,715 - GALLONS
MINIMUM TURN OVER: 6 - HOURS
MINIMUM FLOW RATE: 76.98 - GPM
MAXIMUM FLOW OF PUMP: 120 - GPM
MINIMUM DEPTH OF POOL AT SUN-LEDGE: 0' - 6"
MAXIMUM DEPTH OF POOL AT DRAIN: 4' - 0"

CODE COMPLIANCE

- > ANSI POOL AND SPA STANDARD TO PREVENT SUCTION ENTRAPMENT
- > VIRGINIA GRAEME BAKER SAFETY ACT
- > JACKSON COUNTY ENVIRONMENTAL SANITARY CODE ISPSC 2018
- > JACKSON COUNTY CODE OF REGULATIONS FOR BUILDINGS AND CONSTRUCTION.

SHEET INDEX

P0.00	COVER SHEET
P1.00	SITE PLAN
P2.00	EQUIPMENT SCHEDULE
P3.00	FLOW CALCULATIONS
P4.00	LAYOUT - PLAN VIEW
P4.01	LAYOUT - POOL DIMENSIONS
P4.02	SECTIONS
P5.00	EQUIPMENT LAYOUT - PLAN VIEW
P5.01	EQUIPMENT LAYOUT - DIMENSIONS
P6.00	PLUMBING PLAN - SUCTION
P6.01	PLUMBING PLAN - RETURN
P7.00	ELECTRICAL PLAN
P8.00	BONDING PLAN
P9.00	DETAILS

MIDWEST CUSTOM POOLS
600 Lincoln Street
Lawrence, KS 66044
P: 785.843.9119
F: 785.843.6524
MidwestCustomPools.com



The Signature at West Pryor
2100 & 2150 NW LOWENSTEIN DR.
LEE'S SUMMIT, MO 64081


Plan Date:

01.2022

Drawn By: EM

SHEET NO.


P0.00

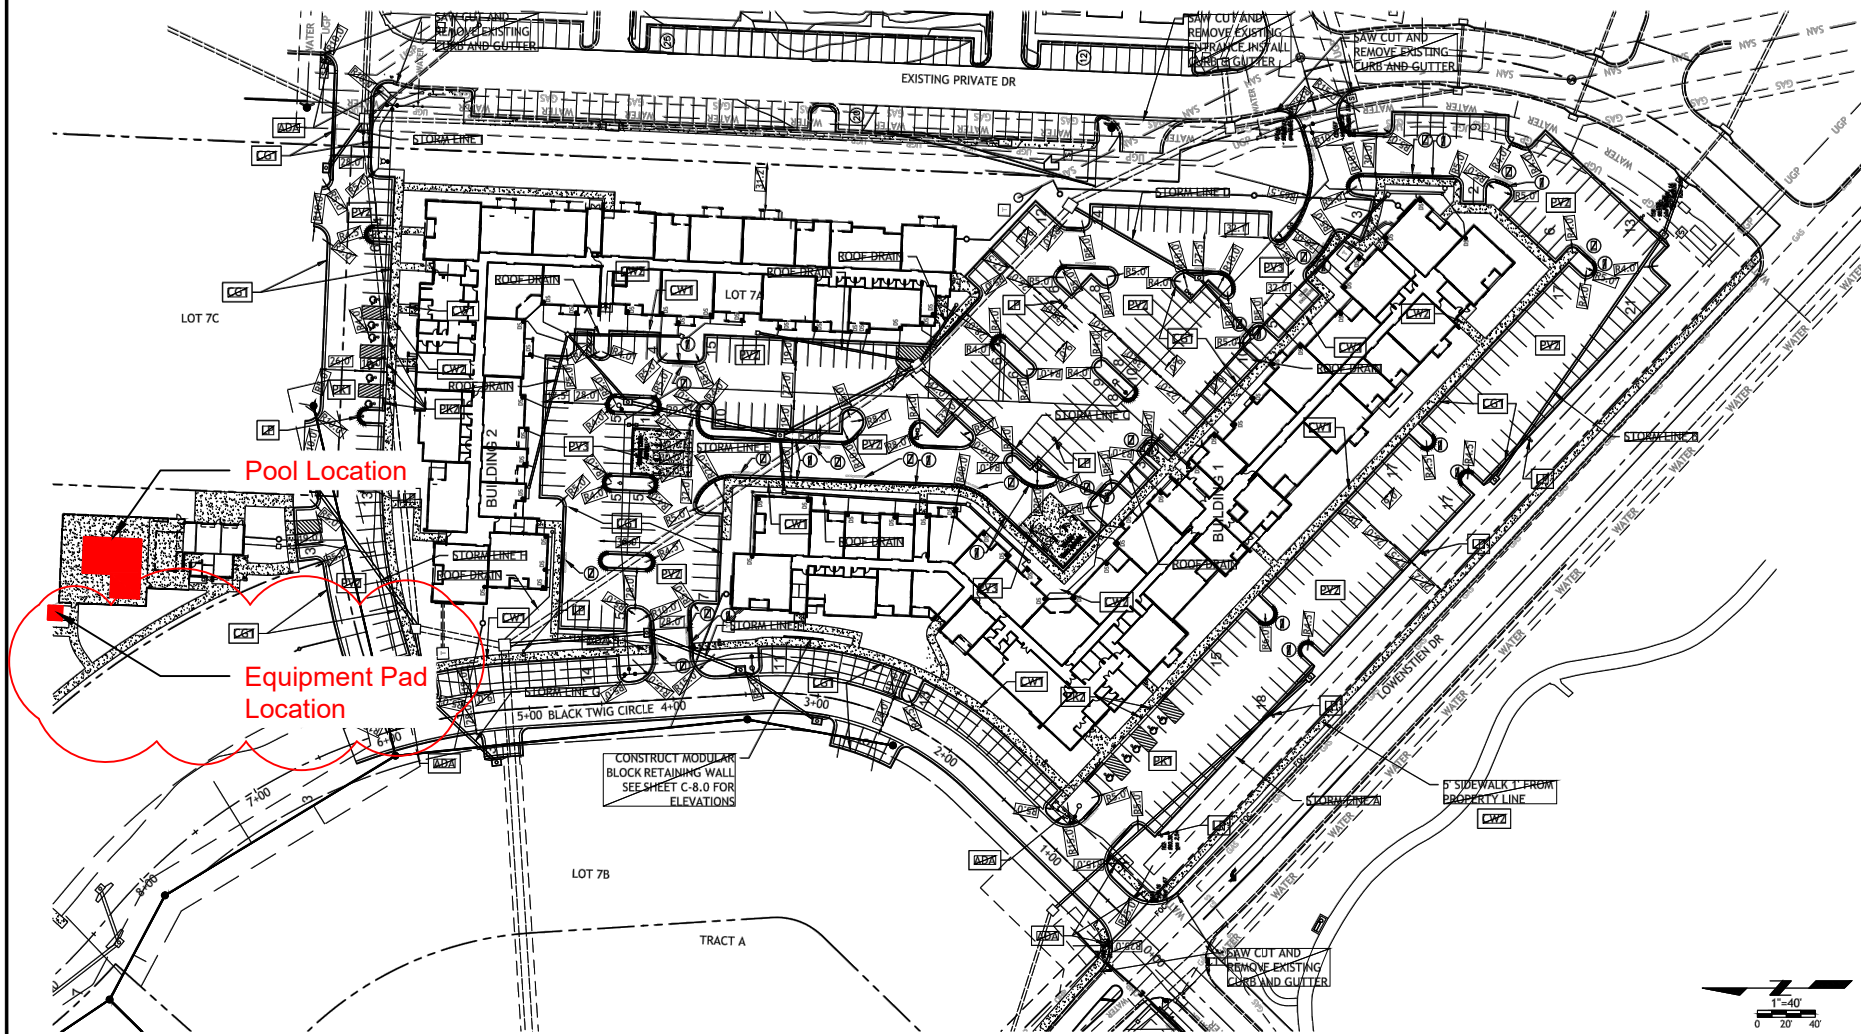

Pool Location

Equipment Pad Location

 CONSTRUCT MODULAR
BLOCK RETAINING WALL
SEE SHEET C-8.0 FOR
ELEVATIONS



MIDWEST CUSTOM POOLS
600 Lincoln Street
Lawrence, KS 66044
P: 785.843.9119
F: 785.843.6524
MidwestCustomPools.com



The Signature at West Pryor
2100 & 2150 NW LOWENSTEIN DR.
LEE'S SUMMIT, MO 64081

Plan Date:

01.2022

Drawn By: EM

SHEET NO.

P1.00

A Site Plan

Scale: N.T.S.

MIDWEST CUSTOM POOLS
600 Lincoln Street
Lawrence, KS 66044
P: 785.843.9119
F: 785.843.6524
MidwestCustomPools.com



The Signature at West Pryor
2100 & 2150 NW LOWENSTEIN DR.
LEE'S SUMMIT, MO 64081

Plan Date:

01.2022

Drawn By: EM

SHEET NO.

P2.00

Equipment						
Equipment Name	Manufacturer Part#	Warehouse Part#	Qty	Power Requirements	Hookup Responsibility	Notes
2"-2.5" FloVis Flow Gauge	FV-C	EMO-56-1000	1	N/A	MCP	
Hayward Skimmer	SP1082	HAY-25-1641	5	N/A	MCP	
Intellichem	522578	PAC-45-0596	1	110V 5A	MCP - Plumbing Electrician - Hookup	
2"-2.5" 3-Way Diverter Valve	263028	PAC-56-4102	5	N/A	MCP	
36" Sand Filter - TR140C	140316	PAC-05-708	1	N/A	MCP	
2"S Hiflow sand/quad DE SM Multiport Valve	261050	PAC-06-245	1	N/A	MCP	
3 HP Intelliflo VSP	011056	PUR-10-1662	1	230 V 20 amp breaker must be Siemens GFI breaker	MCP - Plumbing Electrician - High Voltage	Will not work on 208 VAC
Black Plastic 5-Hole J-Box	PJB4175	INT-57-110	3	N/A	MCP	
300W Transformer	PX300	INT-30-745	1	300W 120 VAC 3 A Max	MCP - Low Voltage Electrician - High Voltage	
Globrite Led Lights	602055	AMP-30-7002	9	15W 12V	MCP	
Spectrum Aquatics ADA Chair Lift w/ Battery Power	153121	SPM-42-8516	1	110 VAC (Charger Only)	MCP	
Levelor - Autofill	25514-000-000	SPG-56-5000	1	N/A	MCP	Back-flow Preventor By Others
Buck Boost Transformer	PH488489	MT-BBT	1	208V Primary - 240V Secondary, 23.4 Amps, 50/60Hz	To be provided and installed by Electrician	Install to increase voltage from 208 to 240

A Equipment schedule

A Flow Calculations

Flow Calculations Signature at West Pryor		
Pump(s)	1	Pentair Intelliflow
Pool Capacity GALLONS	27,715	
Required Turn Over (6 hours or 4 times per day)	4	
Required Gallons Per 24 Hours	110,860	
Required Gallons Per Hour	4619.167	
Required Gallons Per Minute	76.98611	
Required Per Pump	76.98611	
Filter(s)	1	Pentair TR140-C
Filter Sq Ft (Each)	7.06	
Filter rate per Gallon	10.90	
Filter rate at max pump (sq ft per Gallon)	17.00	
Max Pump Flow GPM	120	From Pump Chart (see Submittals)
Max Velocity Suction Required	6 FPS	From Jackson County Code
Max Velocity at Max Pump Flow Feet Per Second (Suction)	5.45	https://www.engineeringtoolbox.com/pipe-velocity-d_1096.html
Max Velocity Return Required	8 FPS	From Jackson County Code
Max Velocity at Max (Return)	7.84	
Minimum Pipe Size Suction	3"	
Minimum Pipe Size Return	2.5"	
Minimum Pipe Size Suction (after first tee on suction)	2"	
Minimum Pipe Size Return (after first tee on return)	2"	
Max Flow Requirements for Main Drain - Gallons Per Minute	120	
Max Flow Requirements for Main Drain Specified		
Floor Gallons Per Minute	308	
Wall Gallons Per Minute	212	
Main Drain Specified	25506-320-000	32" Unblockable main drain. 2.5" outside connections



MIDWEST CUSTOM POOLS
 600 Lincoln Street
 Lawrence, KS 66044
 P: 785.843.9119
 F: 785.843.6524
MidwestCustomPools.com

The Signature at West Pryor
 2100 & 2150 NW LOWENSTEIN DR.
 LEE'S SUMMIT, MO 64081


Plan Date:

01.2022

Drawn By: EM

SHEET NO.

P3.00

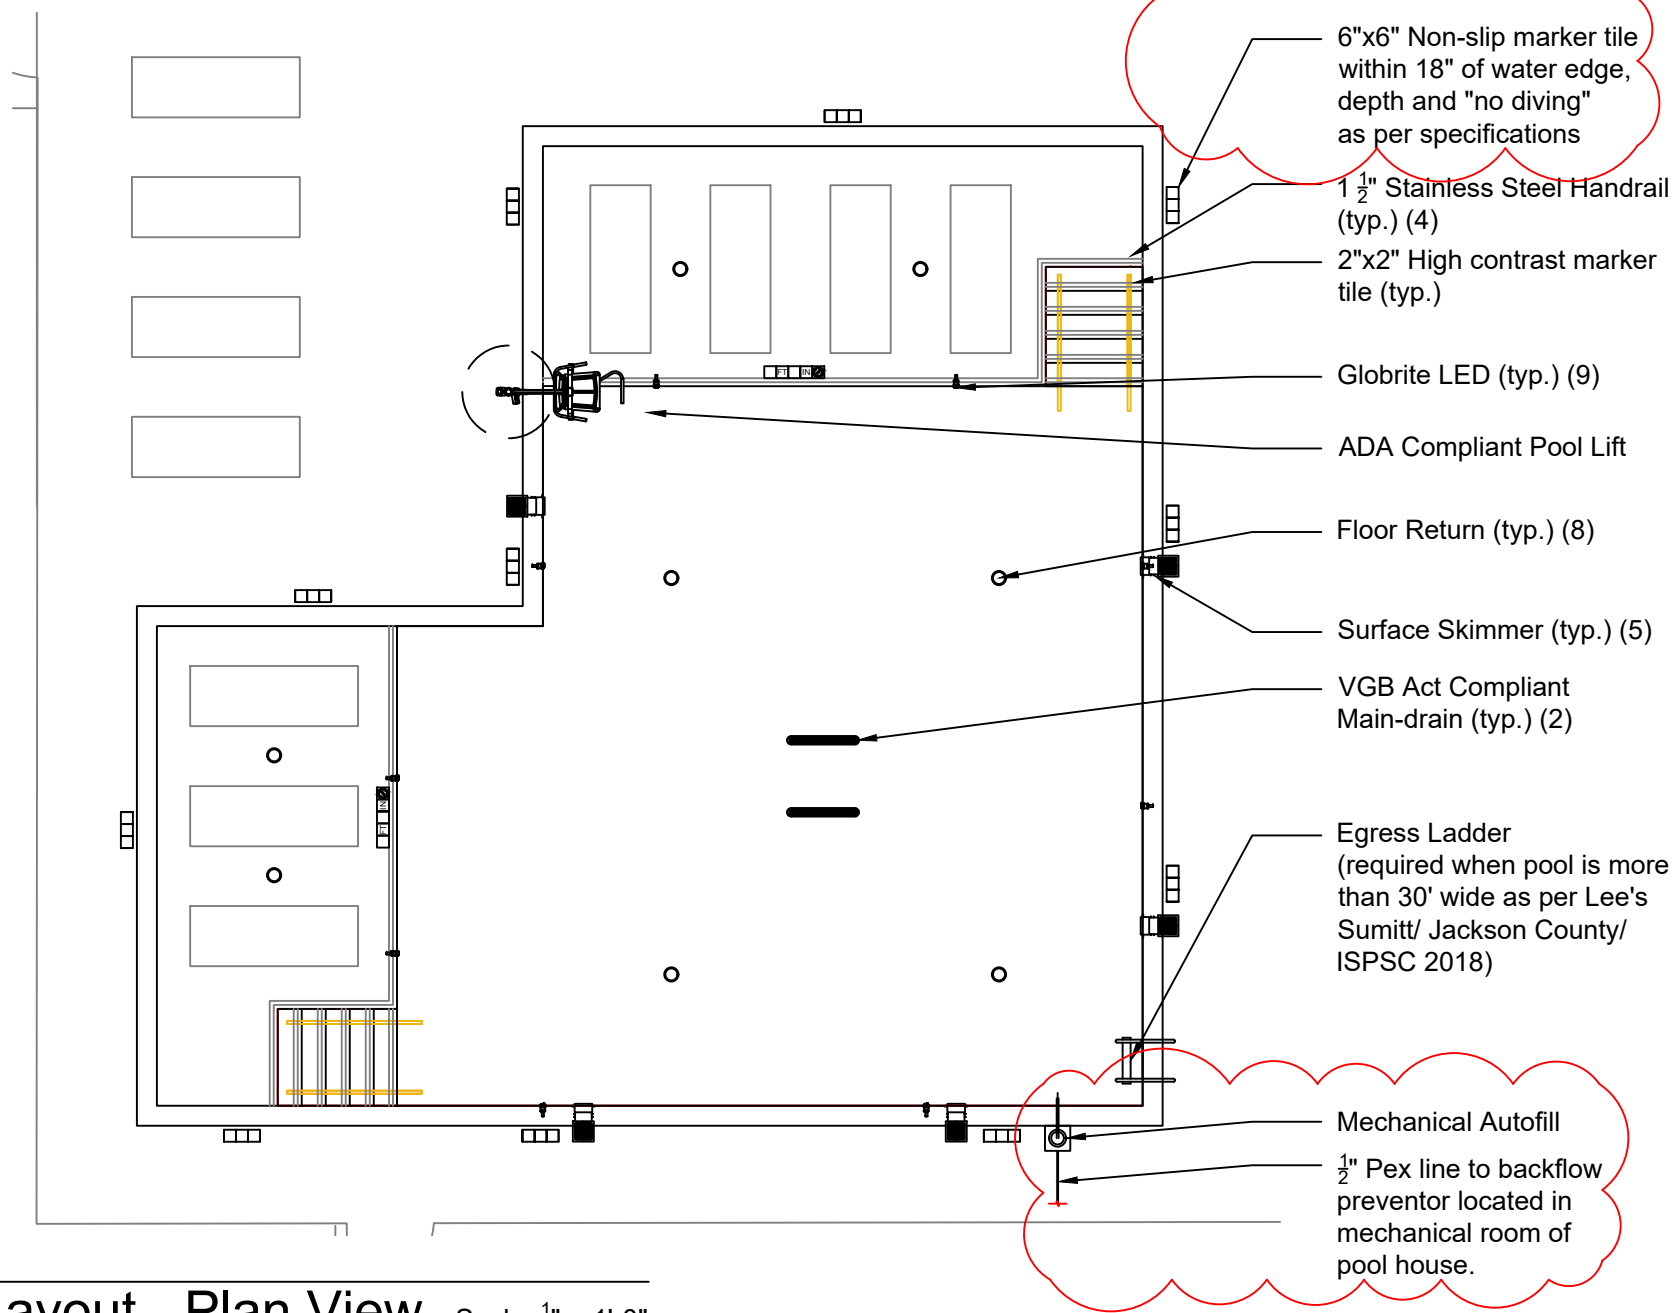

MIDWEST CUSTOM POOLS
600 Lincoln Street
Lawrence, KS 66044
P: 785.843.9119
F: 785.843.6524
MidwestCustomPools.com



The Signature at West Pryor
2100 & 2150 NW LOWENSTEIN DR.
LEE'S SUMMIT, MO 64081

Plan Date:


01.2022

Drawn By: EM

SHEET NO.


P4.00

A Pool Layout - Plan View Scale: 1/8" = 1'-0"

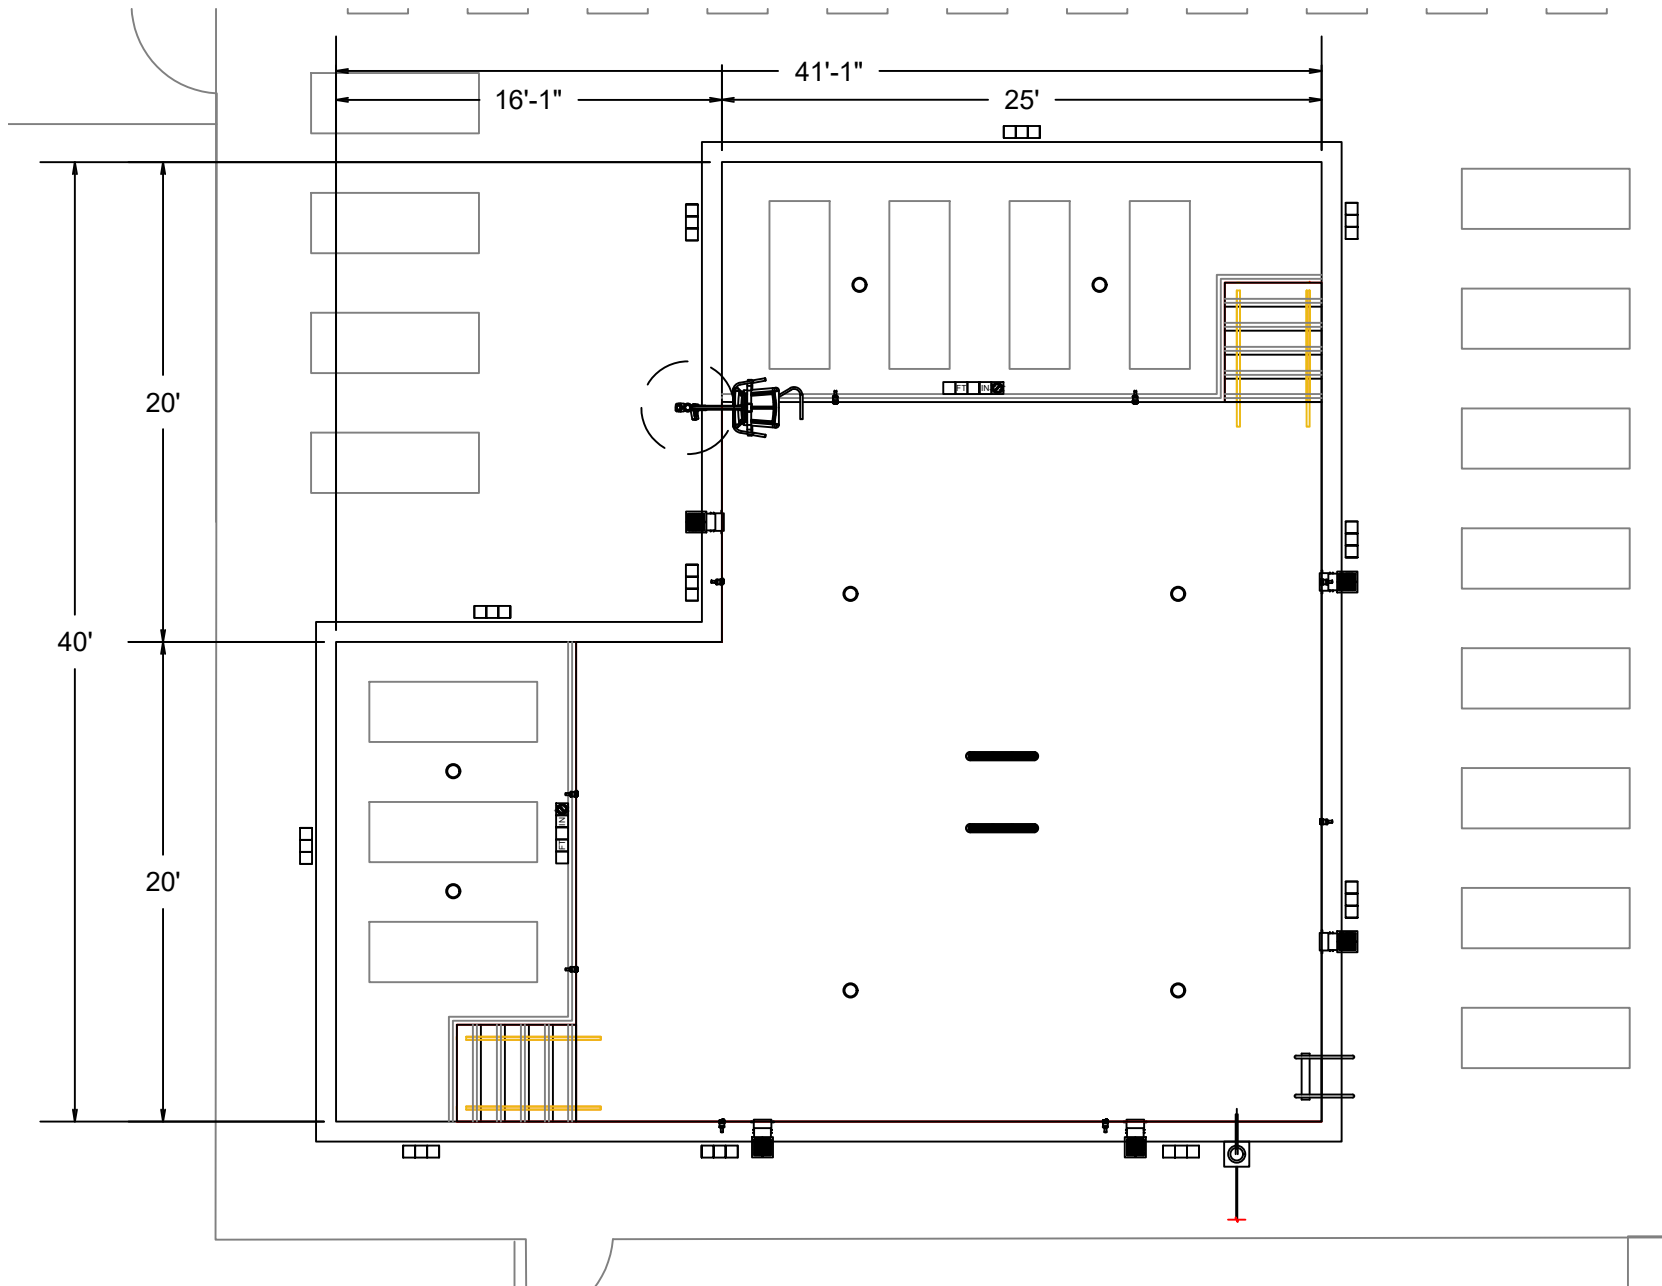

A Pool Layout - Plan View Scale: $\frac{1}{8}" = 1'-0"$

Midwest Custom Pools 600 Lincoln Street Lawrence, KS 66044 P: 785.843.9119 F: 785.843.6524 MidwestCustomPools.com	
Midwest CUSTOM POOLS	
The Signature at West Pryor 2100 & 2150 NW LOWENSTEIN DR. LEE'S SUMMIT, MO 64081	
Plan Date: 01.2022	
Drawn By: EM	
SHEET NO. P4.01	

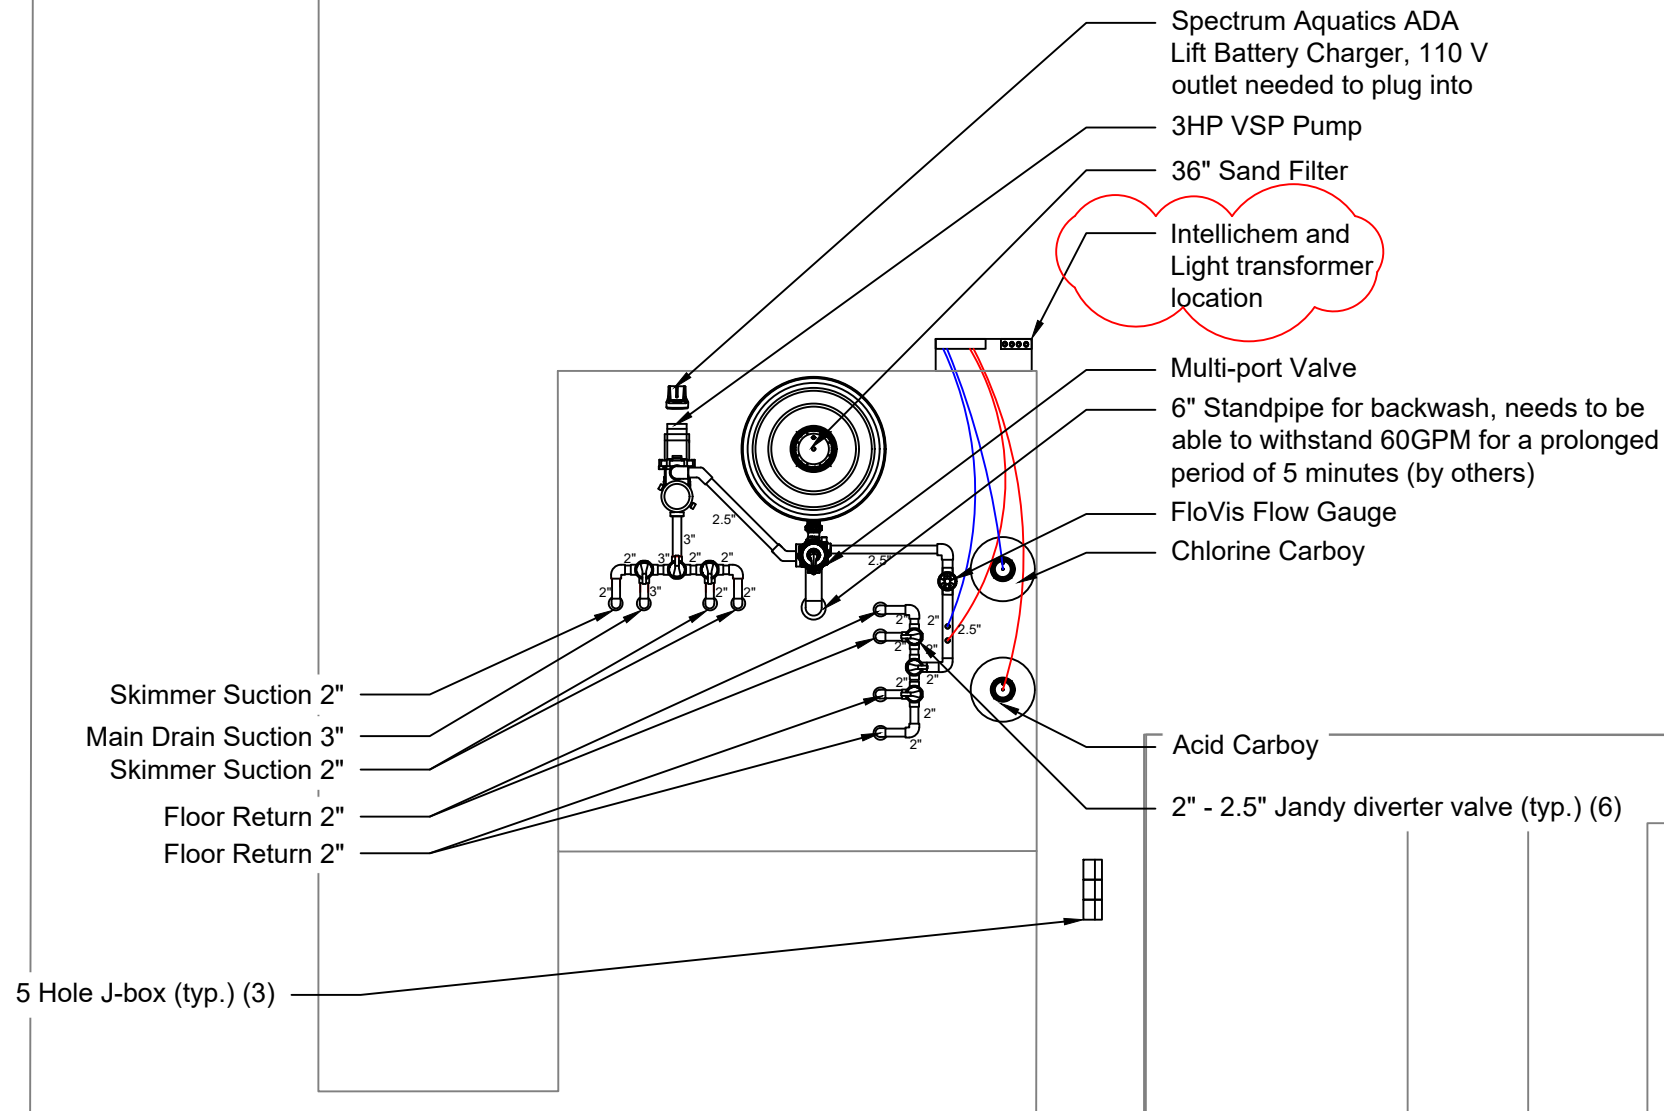

A Pool Layout - Equipment Pad Scale: $\frac{1}{4}" = 1'-0"$

MIDWEST CUSTOM POOLS
600 Lincoln Street
Lawrence, KS 66044
P: 785.843.9119
F: 785.843.6524
MidwestCustomPools.com



The Signature at West Pryor
2100 & 2150 NW LOWENSTEIN DR.
LEE'S SUMMIT, MO 64081


Plan Date:

01.2022

Drawn By: EM

SHEET NO.


P5.00

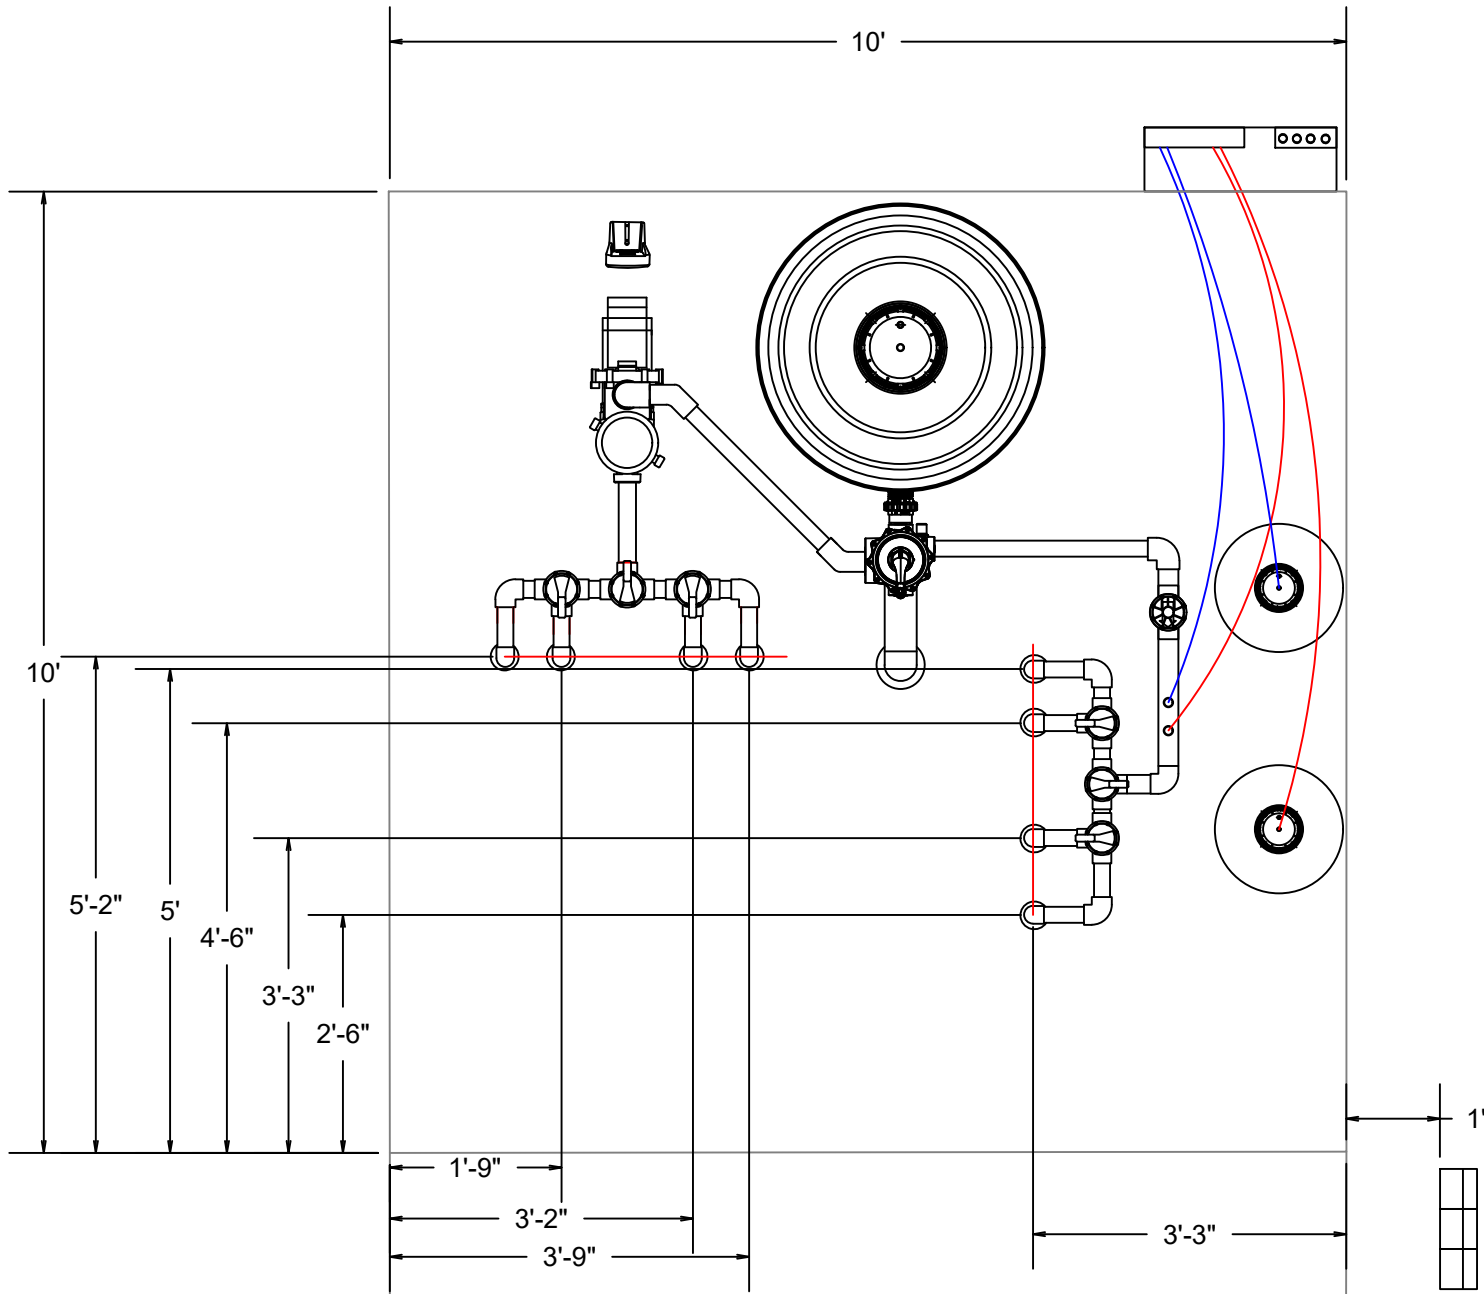

A Pool Layout - Equipment Pad Dimensions


Scale: $\frac{1}{4}" = 1'-0"$

MIDWEST CUSTOM POOLS 600 Lincoln Street Lawrence, KS 66044 P: 785.843.9119 F: 785.843.6524 MidwestCustomPools.com		The Signature at West Pryor 2100 & 2150 NW LOWENSTEIN DR. LEE'S SUMMIT, MO 64081	Plan Date: 01.2022 Drawn By: EM SHEET NO. P5.01
--	---	---	---

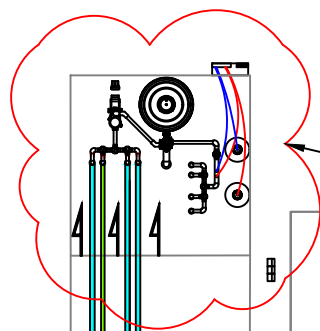


Moved location as per civil PC3.0

- Flow Direction
- 3" Suction SCH 40 PVC
- 2.5" Suction SCH 40 PVC
- 2" Suction SCH 40 PVC

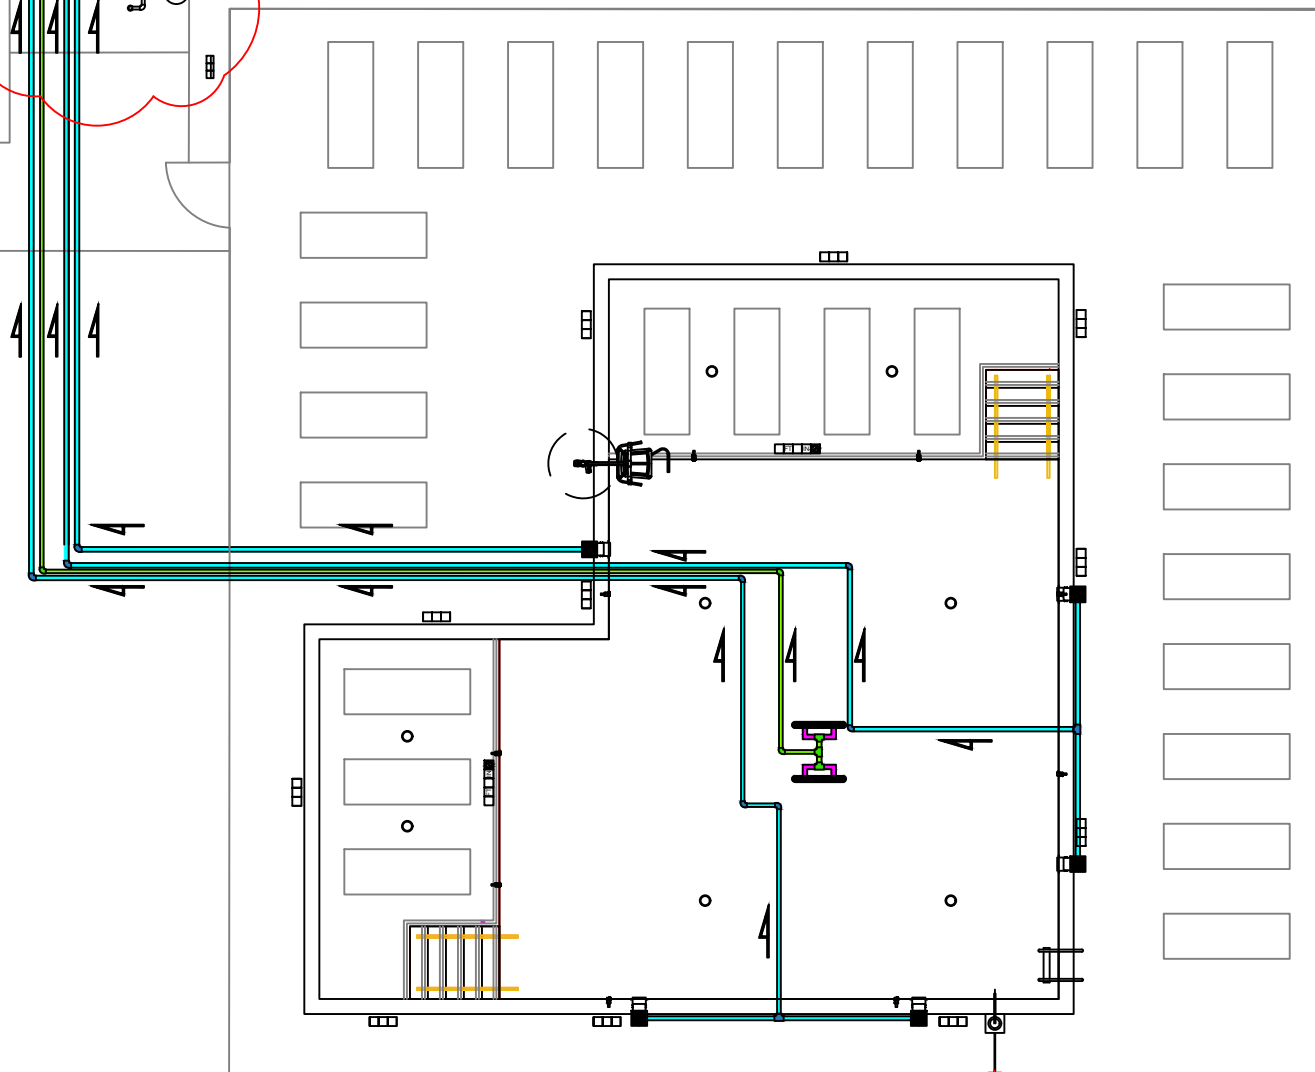


A Plumbing plan - Suction Scale: $\frac{3}{32}" = 1'-0"$

	
Midwest Custom Pools 600 Lincoln Street Lawrence, KS 66044 P: 785.843.9119 F: 785.843.6524 MidwestCustomPools.com	
The Signature at West Pryor 2100 & 2150 NW LOWENSTEIN DR. LEE'S SUMMIT, MO 64081	
Plan Date:	01.2022
Drawn By:	EM
SHEET NO.	
P6.00	

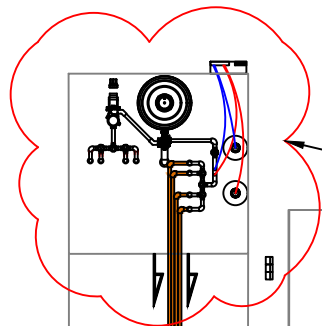


Moved location as per civil PC3.0

 Flow Direction
 2" Return SCH 40 PVC

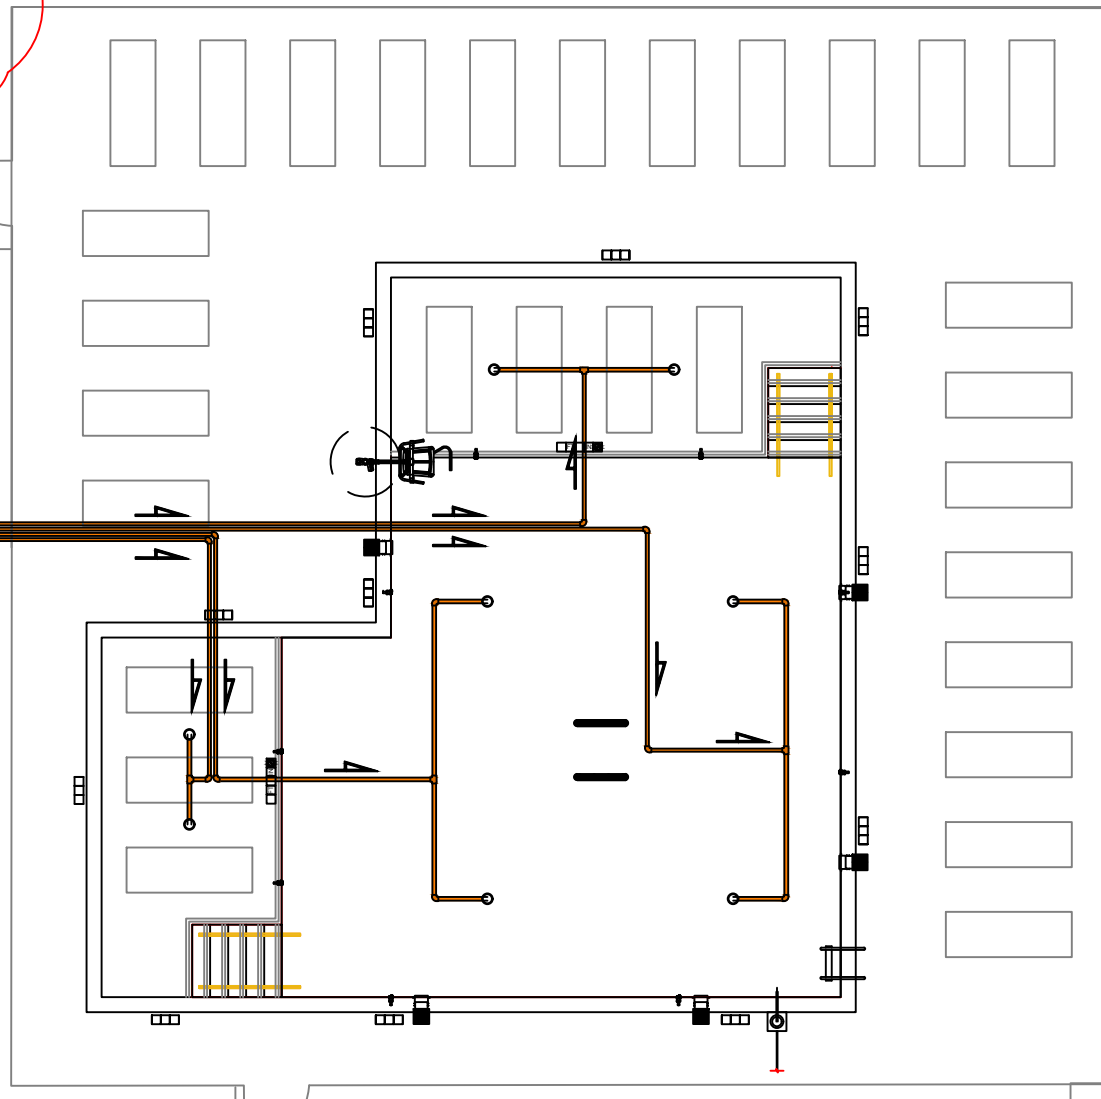


A Plumbing plan - Return Scale: $\frac{3}{32}" = 1'-0"$

MIDWEST CUSTOM POOLS 600 Lincoln Street Lawrence, KS 66044 P: 785.843.9119 F: 785.843.6524 MidwestCustomPools.com	 Midwest CUSTOM POOLS	The Signature at West Pryor 2100 & 2150 NW LOWENSTEIN DR. LEE'S SUMMIT, MO 64081	Plan Date:	01.2022	Drawn By: EM	SHEET NO.	P6.01
---	--	---	-------------------	----------------	---------------------	------------------	---------------------

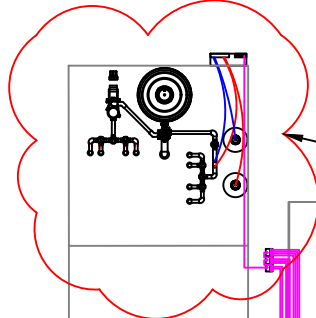

Moved location as per civil PC3.0


1" SCH 40 PVC Conduit

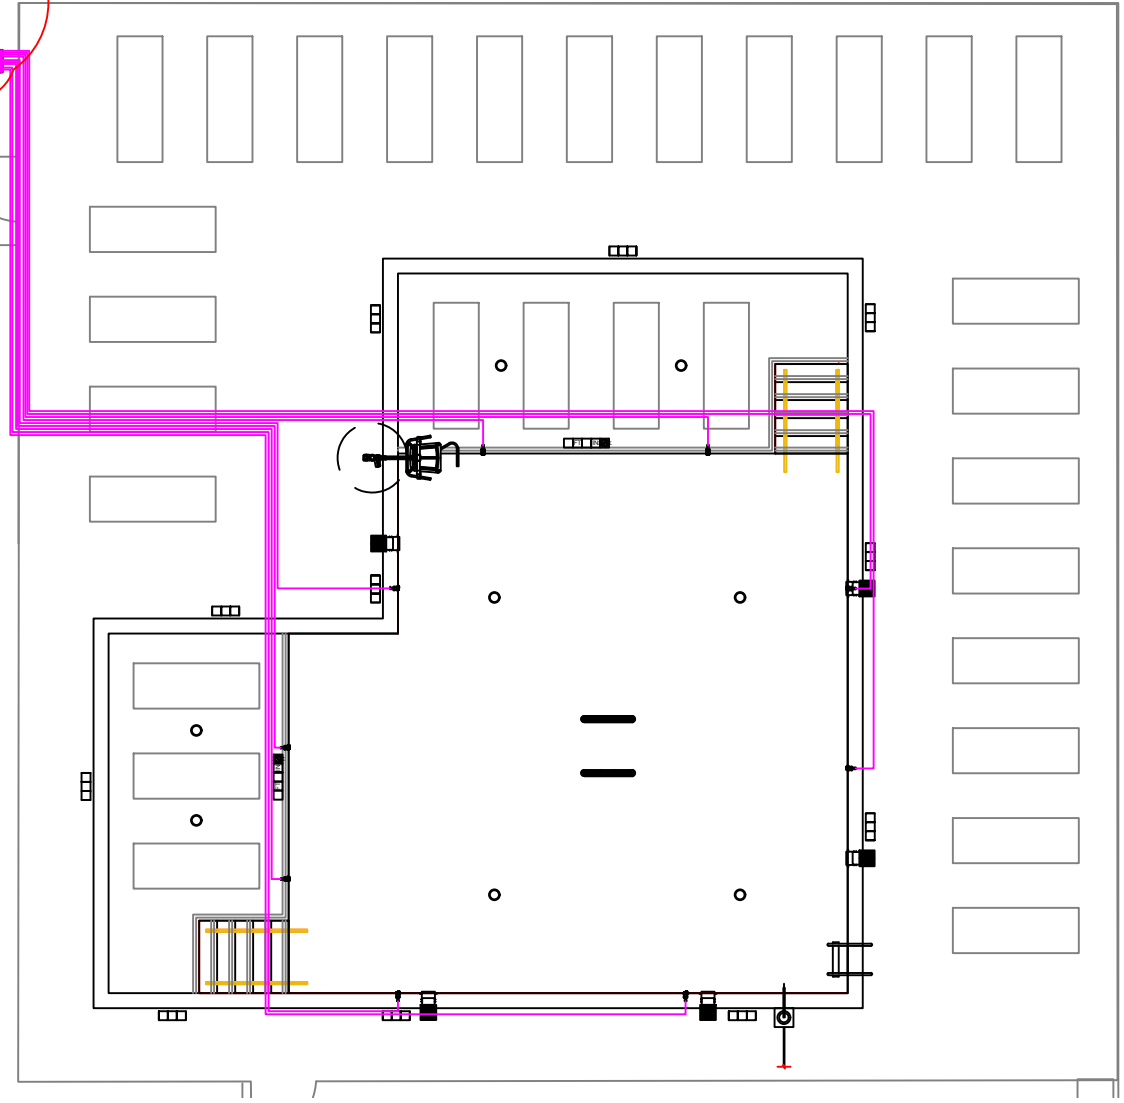

A Electrical Plan


Scale: $\frac{3}{32}" = 1'-0"$

	
MIDWEST CUSTOM POOLS 600 Lincoln Street Lawrence, KS 66044 P: 785.843.9119 F: 785.843.6524 MidwestCustomPools.com	
The Signature at West Pryor 2100 & 2150 NW LOWENSTEIN DR. LEE'S SUMMIT, MO 64081	
Plan Date: 01.2022	
Drawn By: EM	
SHEET NO. P7.00	

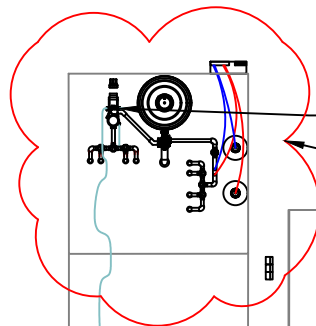

Equipment to be bonded.
 Moved location as per civil PC3.0


— #8 AWG Copper Bonding Wire

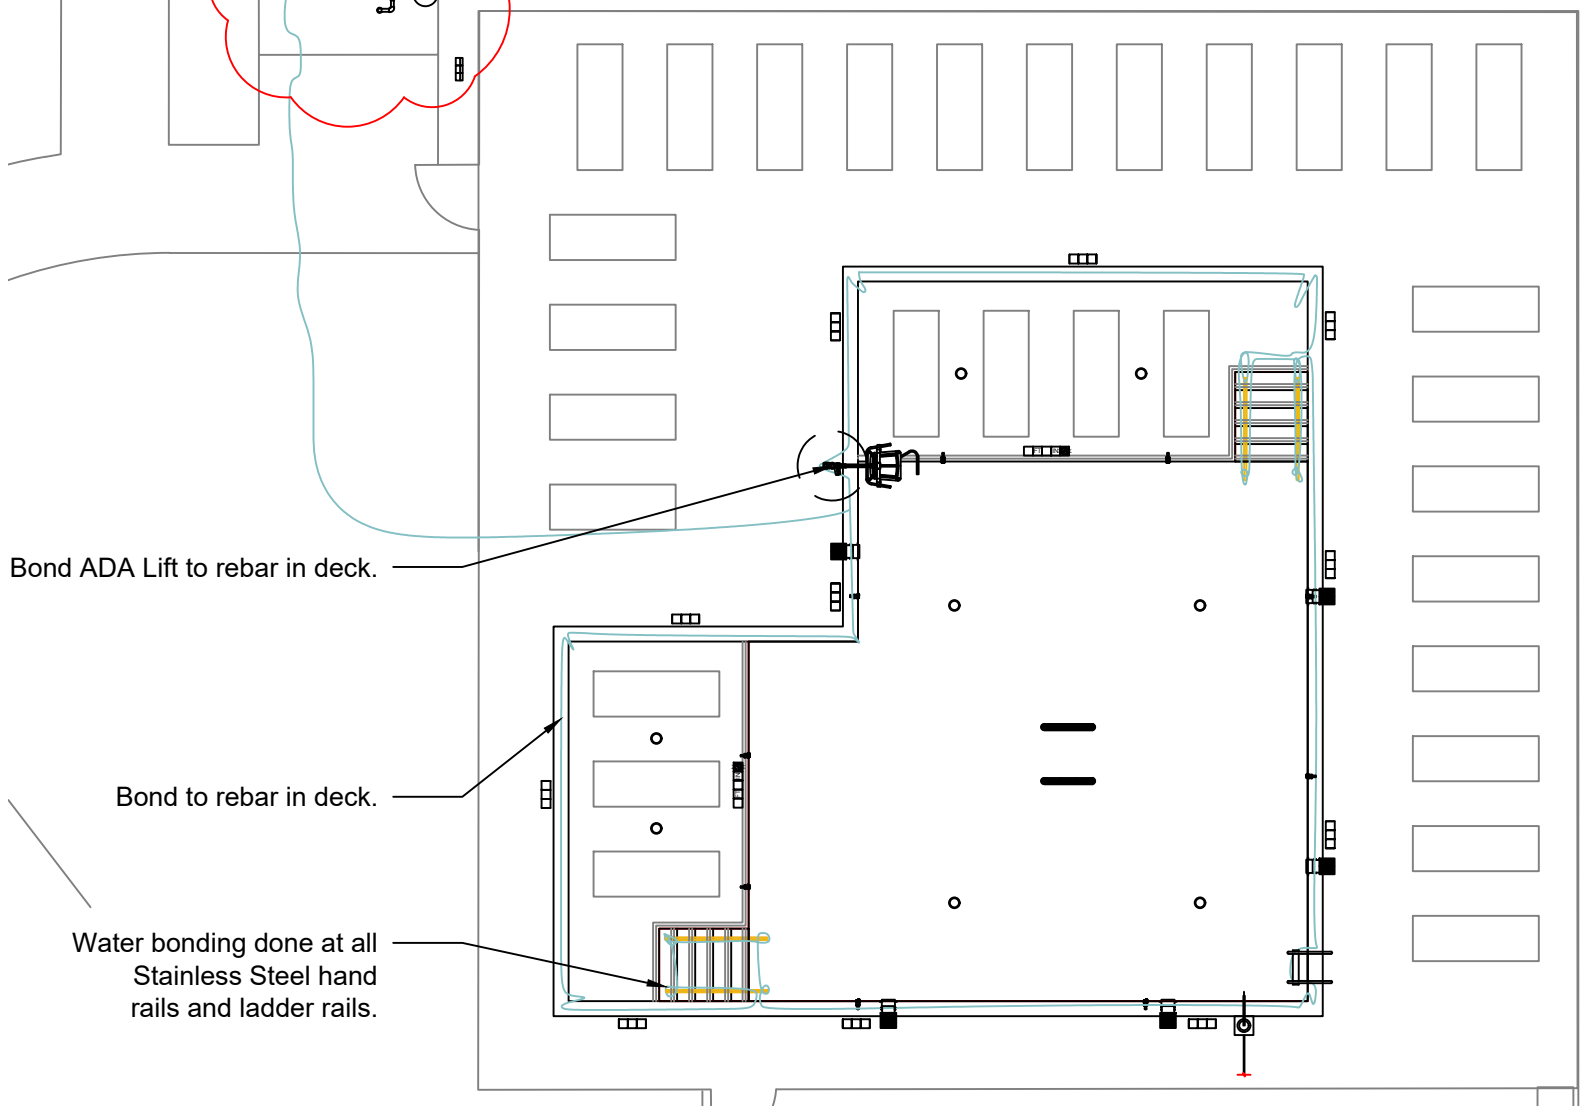


A Bonding plan

Scale: $\frac{3}{32}" = 1'-0"$


MIDWEST CUSTOM POOLS 600 Lincoln Street Lawrence, KS 66044 P: 785.843.9119 F: 785.843.6524 MidwestCustomPools.com		The Signature at West Pryor 2100 & 2150 NW LOWENSTEIN DR. LEE'S SUMMIT, MO 64081	Plan Date:	01.2022	Drawn By: EM	SHEET NO.	P8.00
---	---	---	-------------------	----------------	---------------------	------------------	--------------

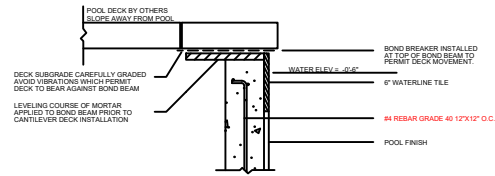


TYPICAL TOP OF WALL AND PRECAST/TRAVERTINE COPING DETAIL | 01
NO SCALE

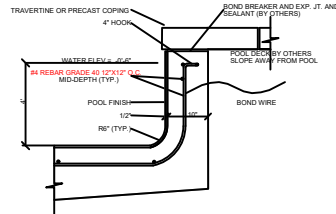


TYPICAL POOL WALL SECTION | 02
NO SCALE

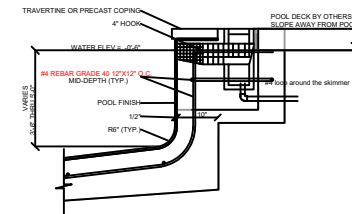


TYPICAL POOL SKIMMER SECTION | 03
NO SCALE

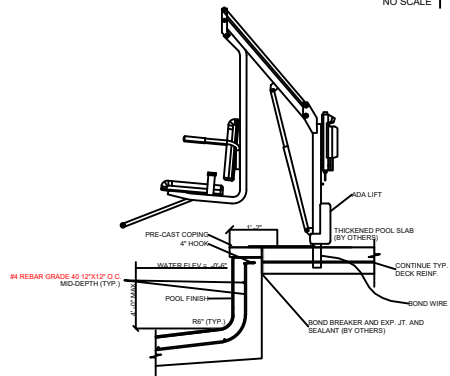


POOL ADA LIFT SECTION | 04
NO SCALE

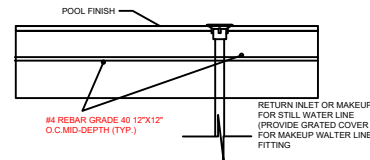


POOL FLOOR RETURN INLET SECTION | 05
NO SCALE

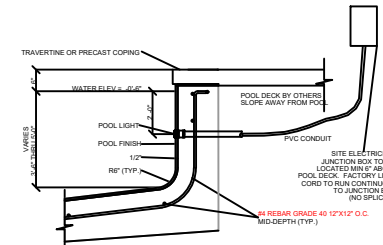


POOL LIGHT SECTION | 06
NO SCALE

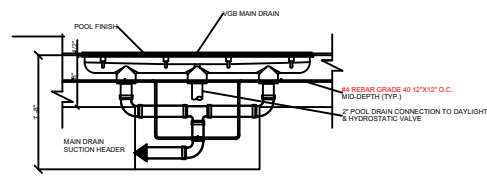

POOL MAIN DRAIN SECTION | 07
NO SCALE

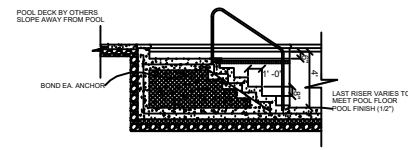

POOL STAIR DETAIL | 08
NO SCALE

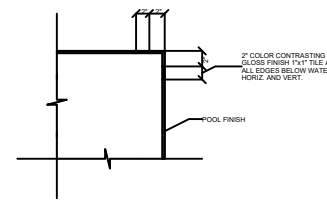

STAIR TREAD AND UNDER WATER EDGE DETAIL | 09
NO SCALE



MIDWEST CUSTOM POOLS
 600 Lincoln Street
 Lawrence, KS 66044
 P: 785.843.9119
 F: 785.843.6524
 MidwestCustomPools.com

The Signature at West Pryor
 2100 & 2150 NW LOWENSTEIN DR.
 LEE'S SUMMIT, MO 64081

Plan Date:

01.2022

Drawn By: EM

SHEET NO.

P9.00