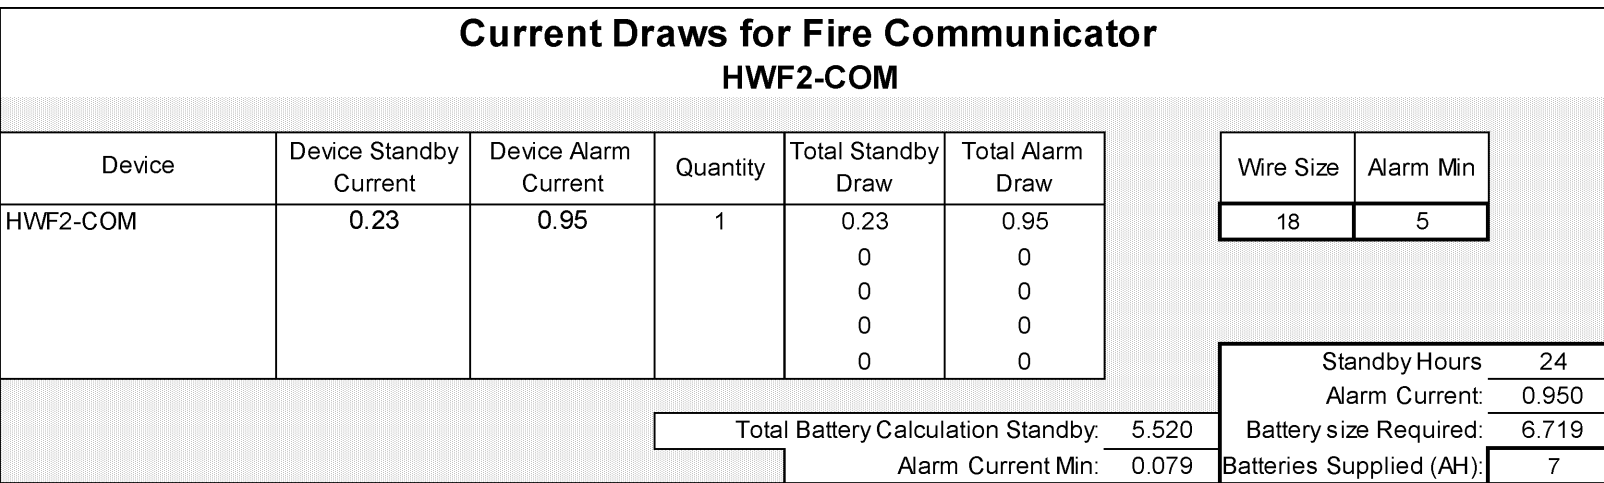
 
 


		
PLAN TYPE: FIRE ALARM SYSTEM DEVICE LOCATIONS		
BC ENGINEERS INCORPORATED 5720 Rieder Shawnee, Ks. 66203 (913)262-1772		
ARCHWAY SYSTEMS 17020 E. 40 Hwy, Ste 1 Independence, MO 64055 Office: (816) 709-3358		
Kansas City CCTV & Security 6415 Universal Ave Kansas City, MO 64120 855-452-2288		
Caliber Collision 710 SE Blue Parkway Lees Summit, MO 64063		
4/14/2022  NO. _____ REVISION _____ DATE _____ 1. Cost Change. 04/19/2022 JES		
DATE: 03/04/2022 LAYOUT BY: DANIEL HEBBLETHWAITE, ET NCOT #107102		
SCALE: 1/8" = 1'-0" FA-1 of FA-1		