


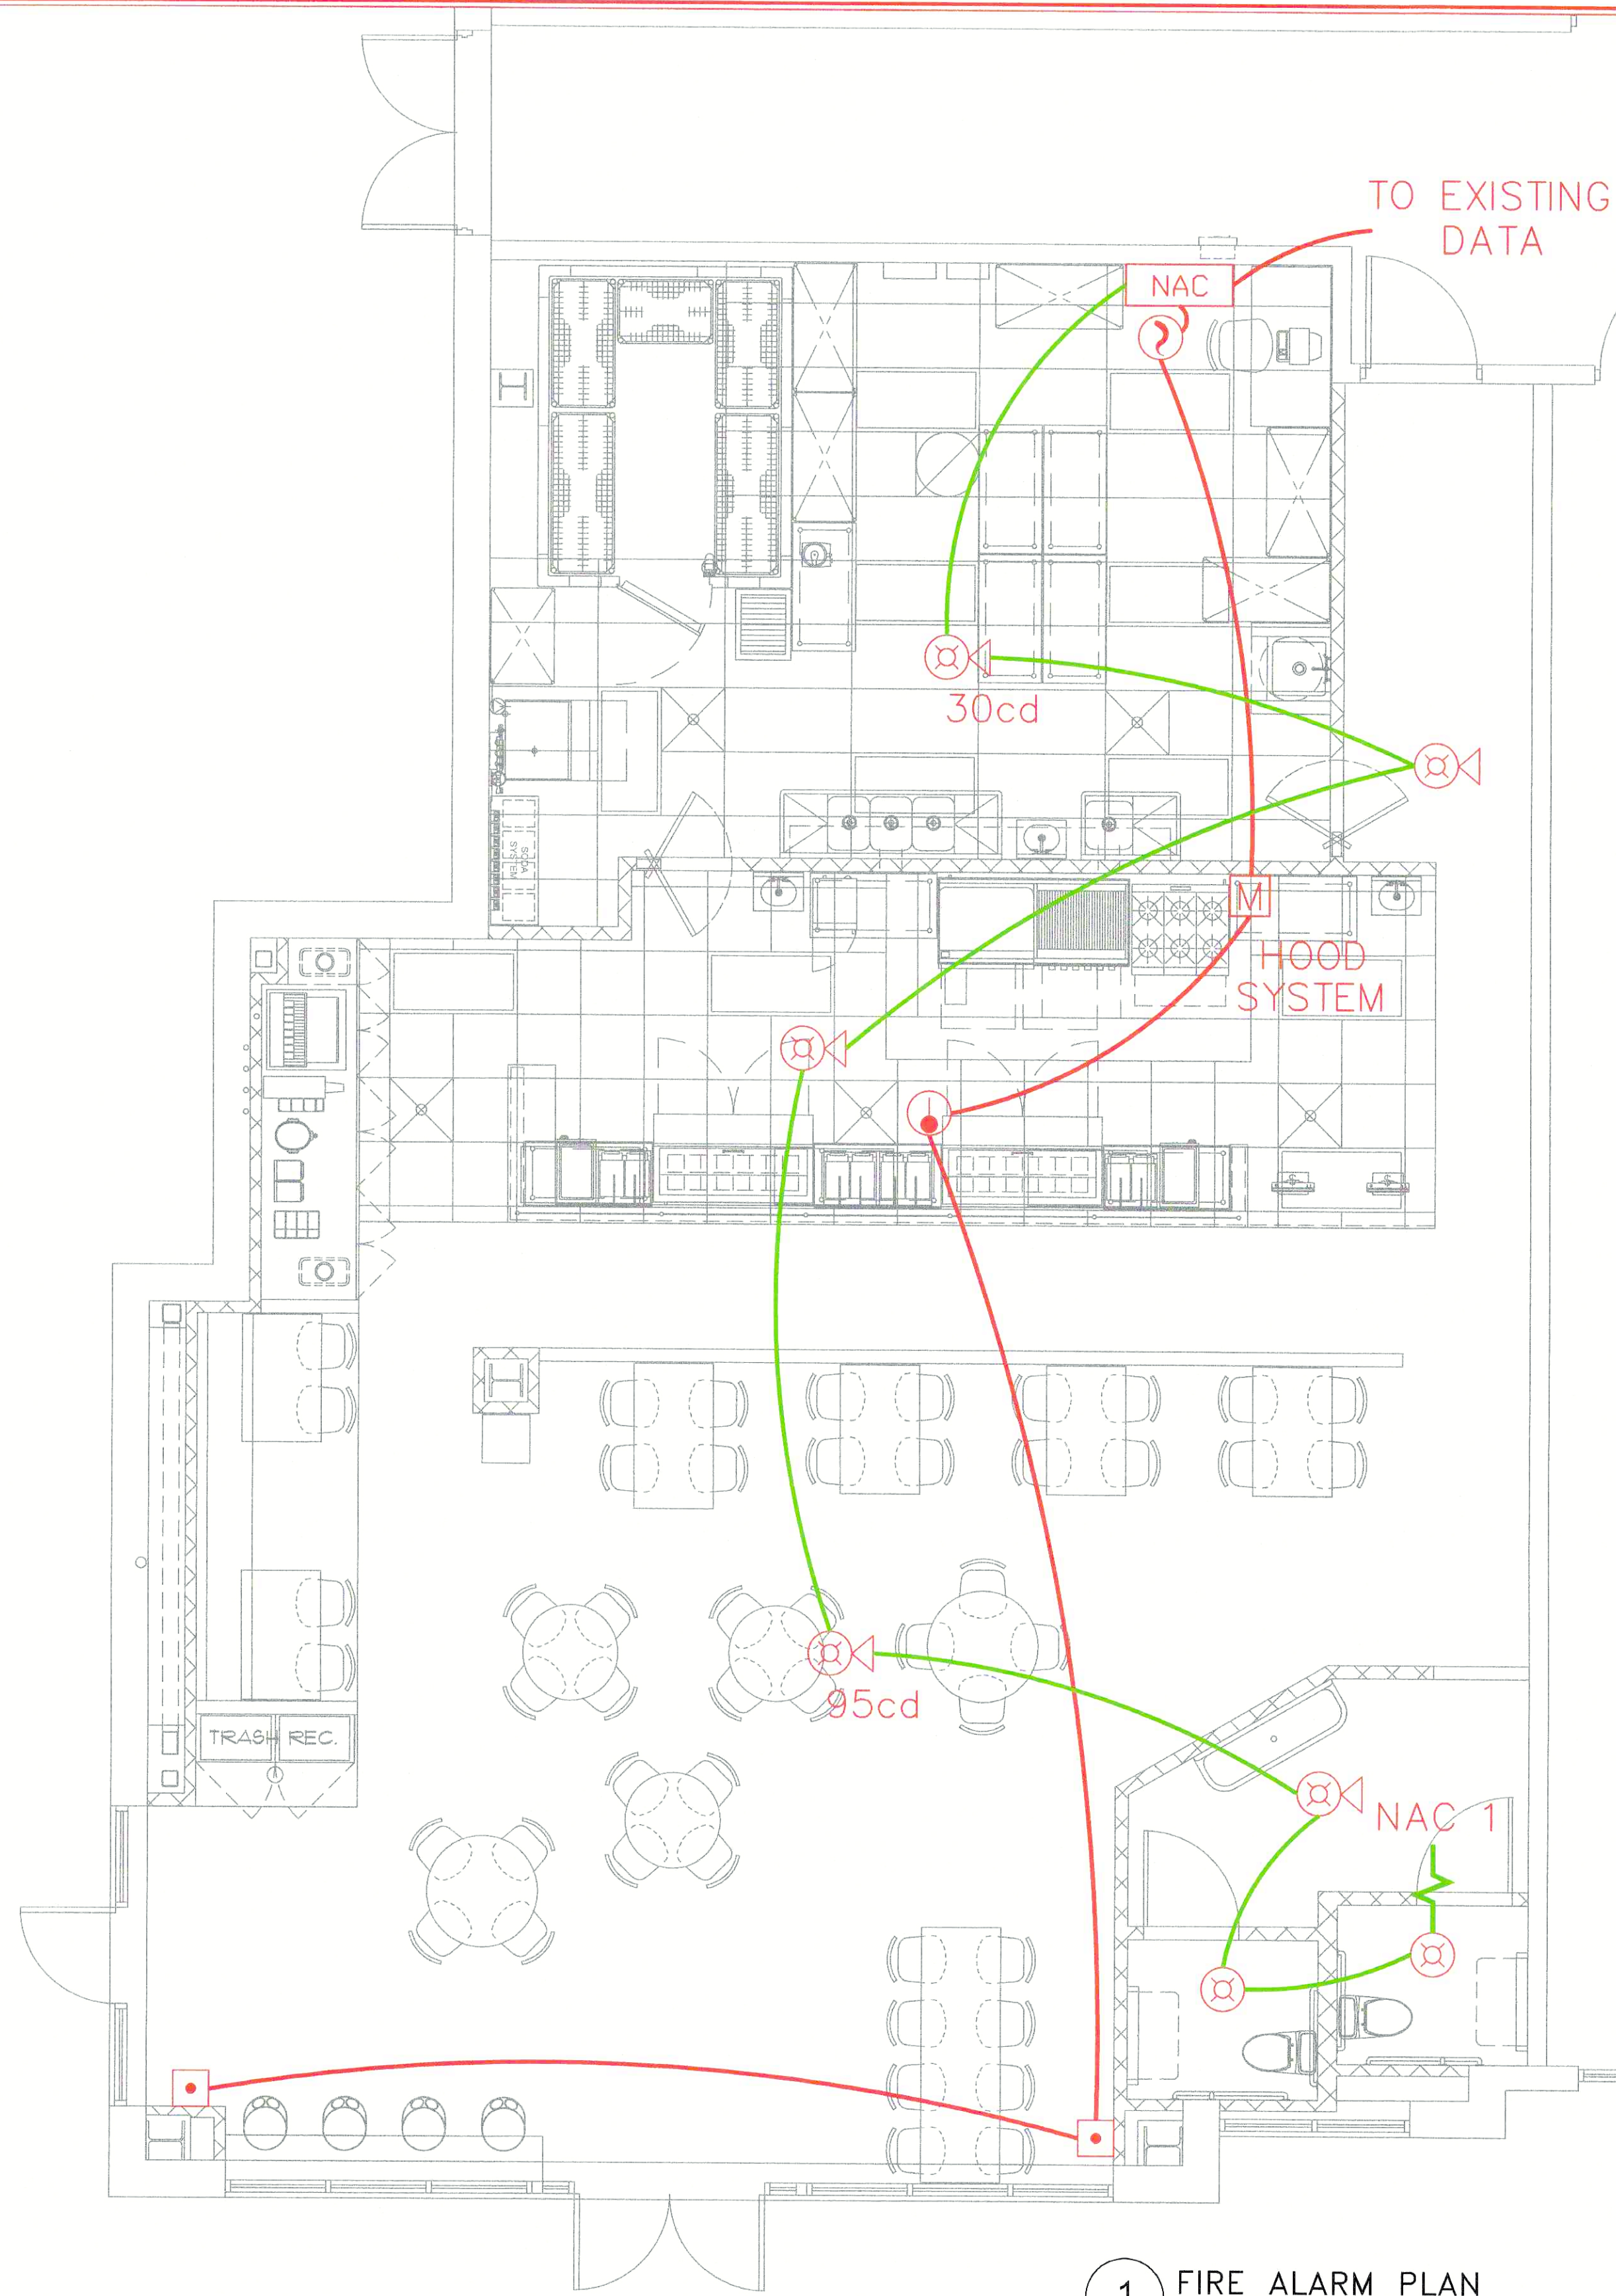


1 FIRE ALARM PLAN
1/4" = 1'0"

FIRE ALARM LEGEND		
SYMBOL	DESCRIPTION	MOUNTING
NAC	N.A.C. POWER EXTENDER	WALL
?	AREA SMOKE DETECTOR	CEIL./WALL
⬆	AREA HEAT DETECTOR	CEIL./WALL
■	FIRE ALARM MANUAL STATION	WALL
Ⓜ	MONITOR MODULE	
Ⓢ	COMB. F.A. HORN & VISUAL SIGNAL	CEILING
Ⓣ	F.A. VISUAL SIGNAL	CEILING
— —	END OF LINE RESISTOR	

WIRING LEGEND	
	18-2 FPLP WIRE (DATA)
	14-2 FPLP WIRE (A/V)
GENERAL NOTES	
1. ALL STROBES HAVE A 15 CANDELLA RATING UNLESS NOTED OTHERWISE.	
2. CONNECT DATA WIRE TO EXISTING ADDRESSABLE FIRE ALARM DEVICE.	

2 FIRE ALARM SEQUENCE OF OPERATIONS
NOT TO SCALE

SYSTEM INPUTS															
1	SMOKE DETECTOR	+	+	+	+	+	+	+	+	+	+	+	+	+	+
2	HEAT DETECTOR	+	+	+	+	+	+	+	+	+	+	+	+	+	+
3	PULL STATION	+	+	+	+	+	+	+	+	+	+	+	+	+	+
4	WATER FLOW	+	+	+	+	+	+	+	+	+	+	+	+	+	+
5	TAMPER SWITCH	+	+	+	+	+	+	+	+	+	+	+	+	+	+
6	FIRE ALARM A/C POWER FAILURE	+	+	+	+	+	+	+	+	+	+	+	+	+	+
7	FIRE ALARM SYSTEM LOW BATTERY	+	+	+	+	+	+	+	+	+	+	+	+	+	+
8	OPEN CIRCUIT	+	+	+	+	+	+	+	+	+	+	+	+	+	+
9	CLOSED CIRCUIT	+	+	+	+	+	+	+	+	+	+	+	+	+	+
10	SHUNT CIRCUIT	+	+	+	+	+	+	+	+	+	+	+	+	+	+
11															
12															
13															
14															
15															

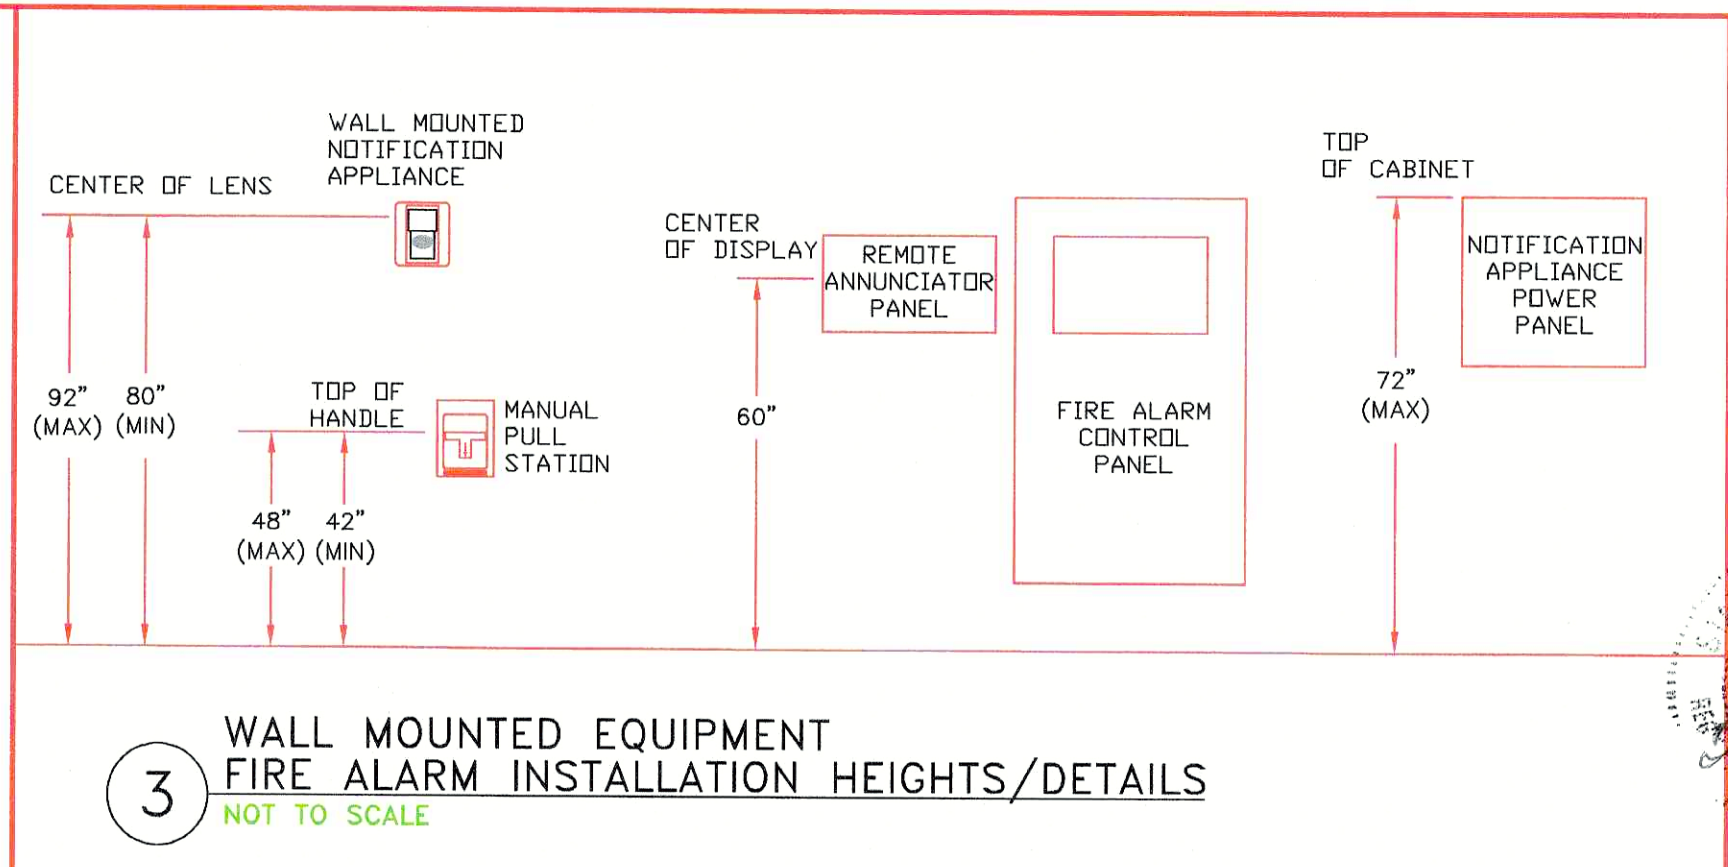


3 WALL MOUNTED EQUIPMENT FIRE ALARM INSTALLATION HEIGHTS/DETAILS
NOT TO SCALE



DATE	REVISIONS

Twisted Fresh
940 NW Pryor Road
Lee's Summit, MO 64081

Aegis Fire Protection, LLC
Corporate: 11936 W. 119th St. #262 Overland Park, KS 66213
Phone: 913-322-4475
Email: info@aegisfirepro.com

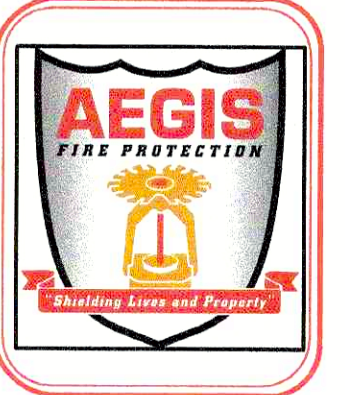

JOB NO. 17157
JOB NAME: Twisted Fresh Tenant Finish
FIRE ALARM PLAN
AHL: CITY & OWNER
SCALE: 1/4"=1'-0"
DESIGNED BY: RMS
CHECKED BY: GT
DATE: 7-14-22
SHEET NO. FA1
1 OF 1