




1 FLUSH GRADE CLEANOUT DETAIL
NOT TO SCALE

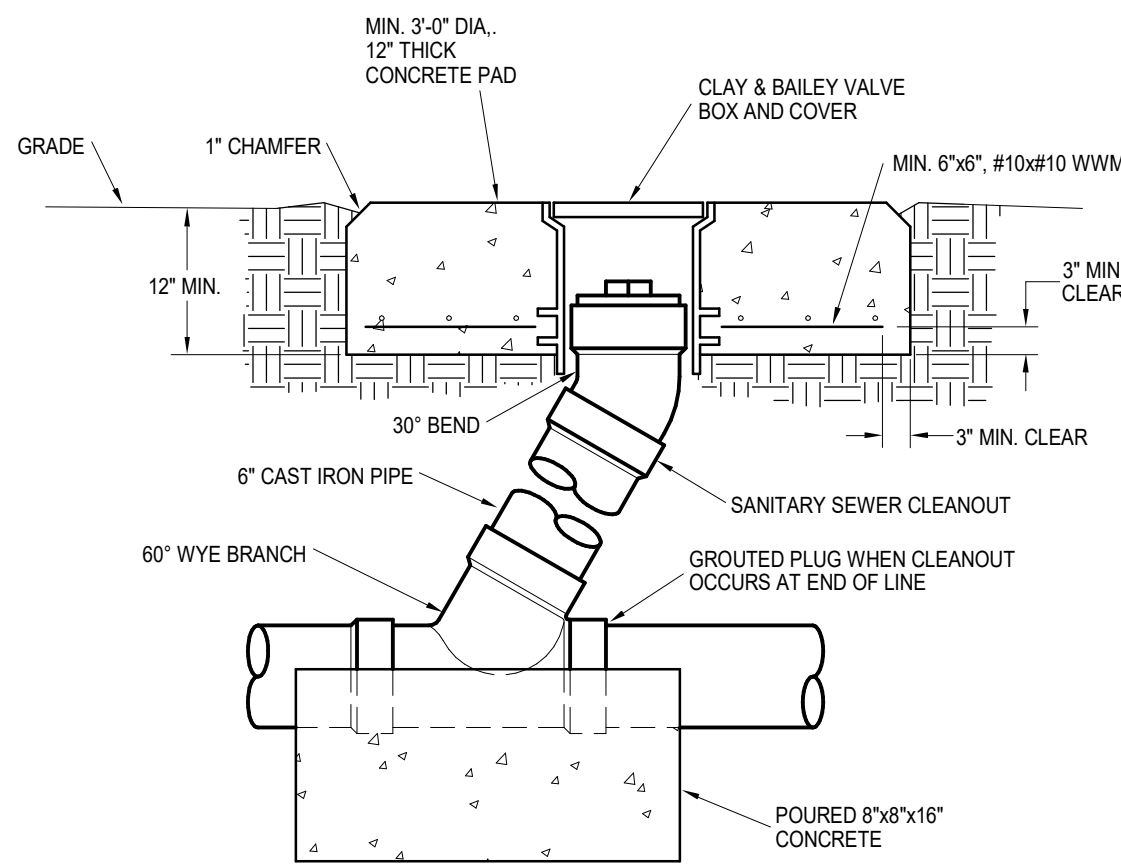


2 PARKING GARAGE FAN CONTROL DETAIL
NOT TO SCALE

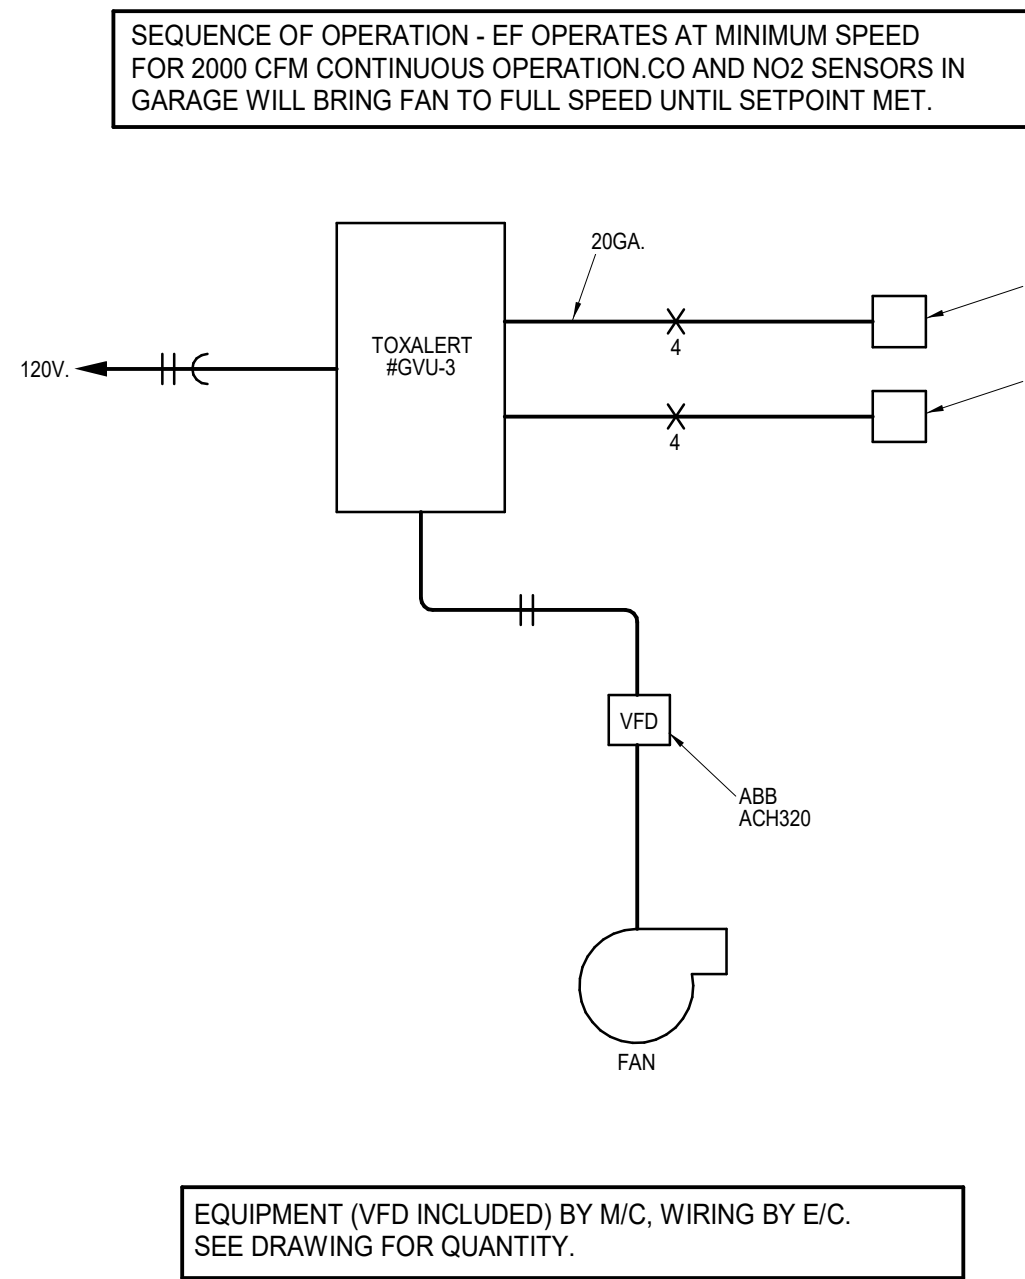


3 APARTMENT AHU/WATER HEATER
NOT TO SCALE

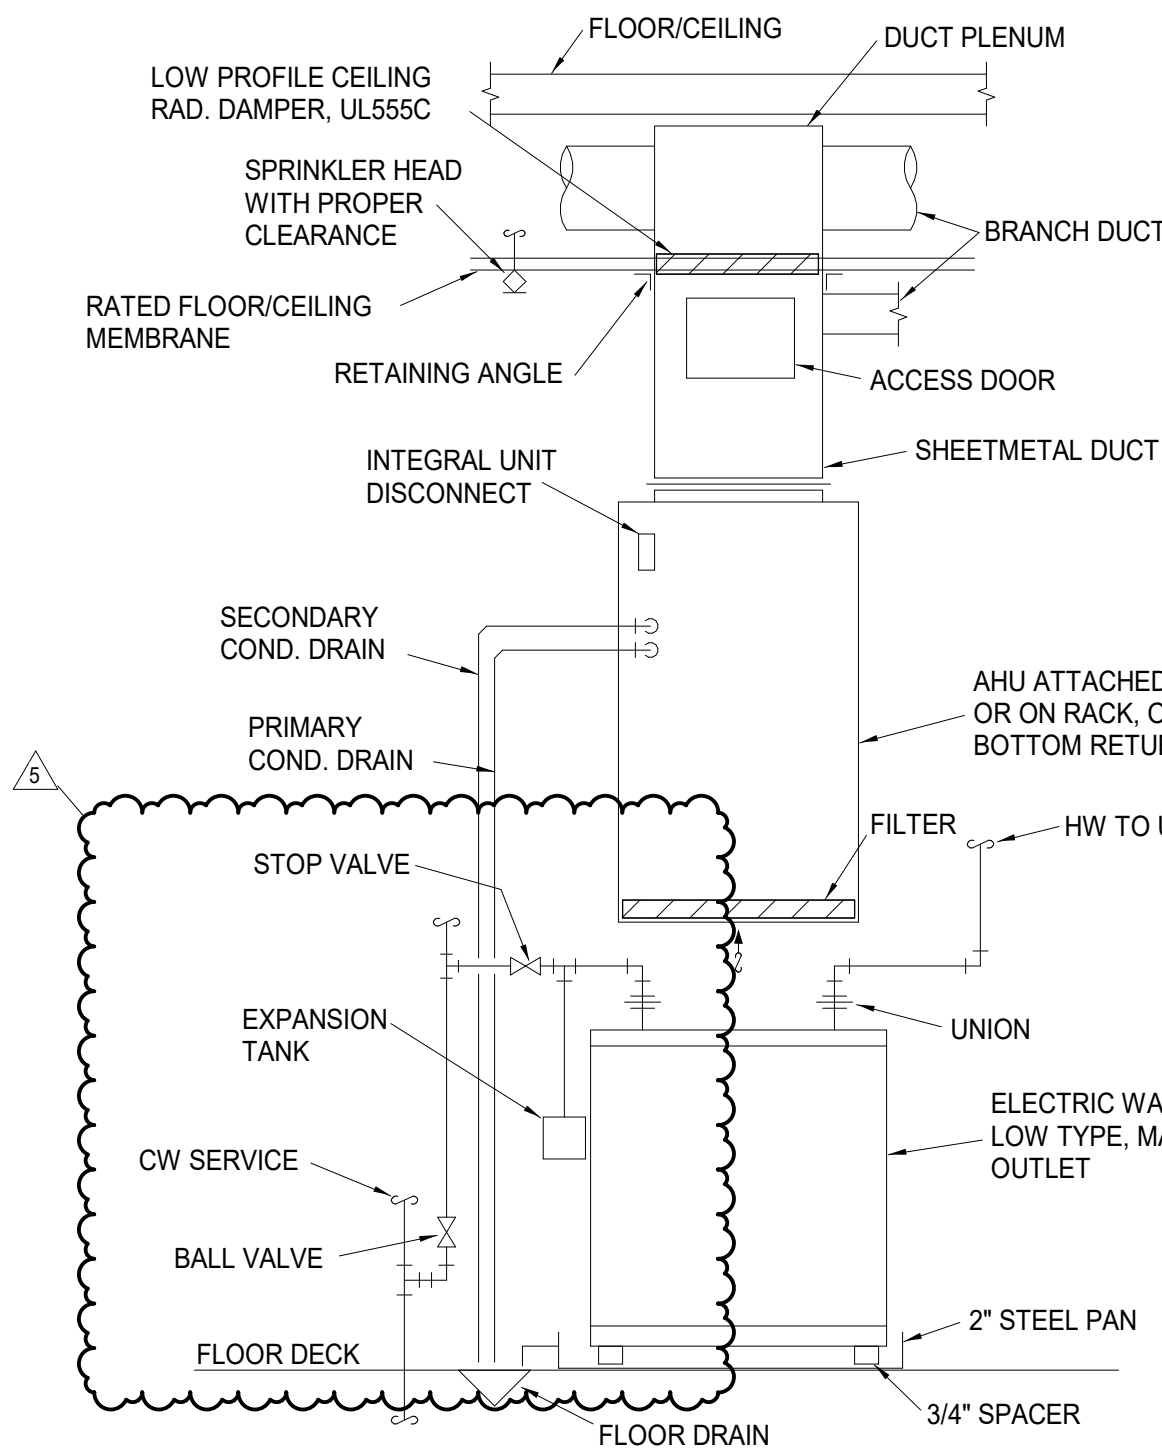


5 FIRE/SMOKE DAMPER DETAIL
NOT TO SCALE

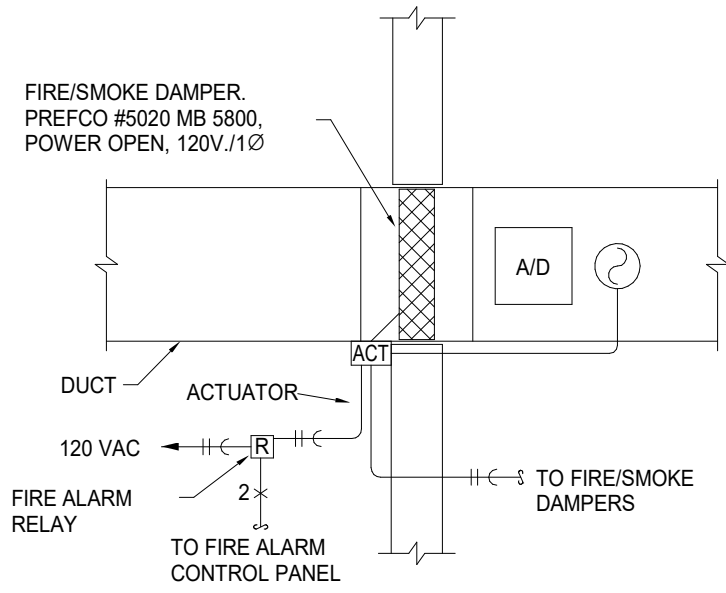



6 ROOF DRAIN DETAIL
NOT TO SCALE

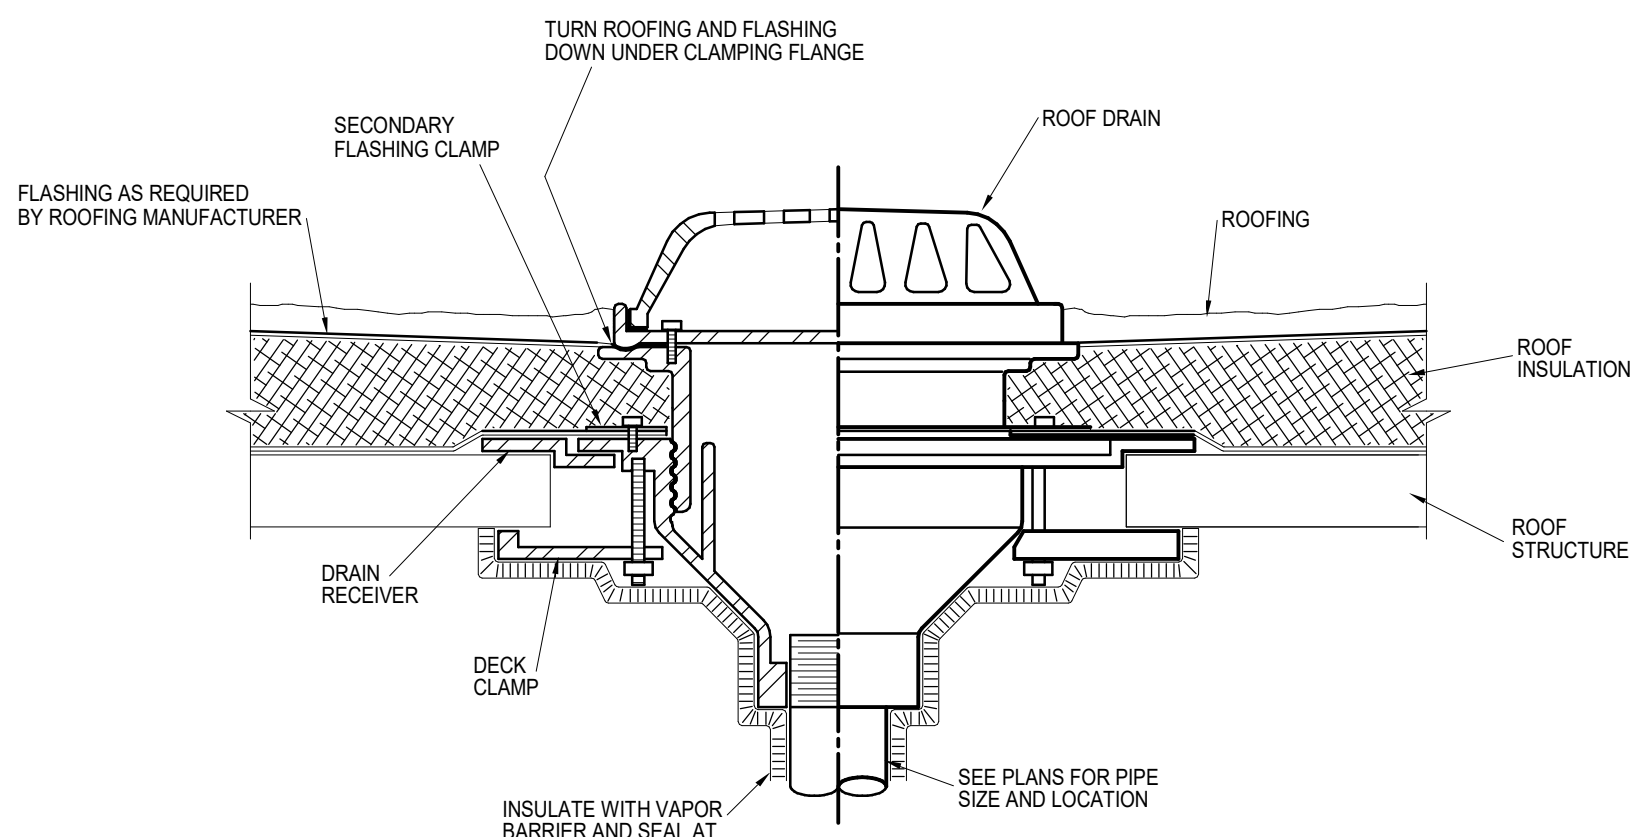


7 CORRIDOR AHU DETAIL
NO SCALE

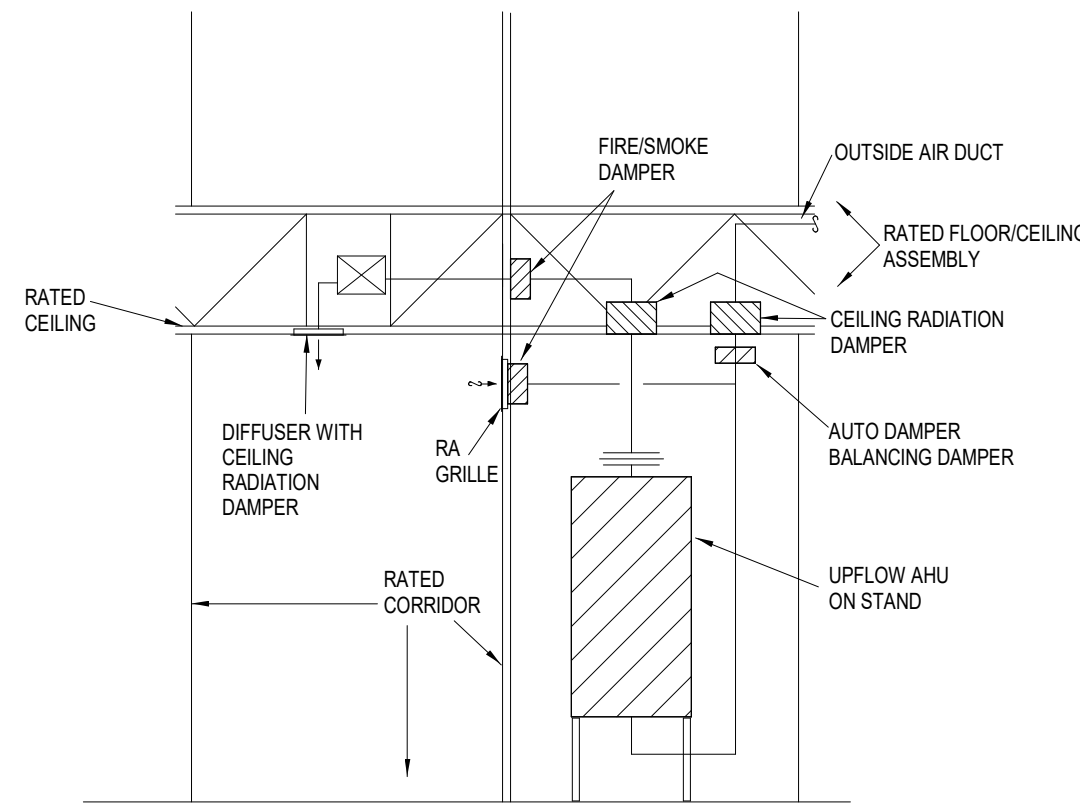


4 SAND/OIL SEPERATOR DETAIL
NOT TO SCALE

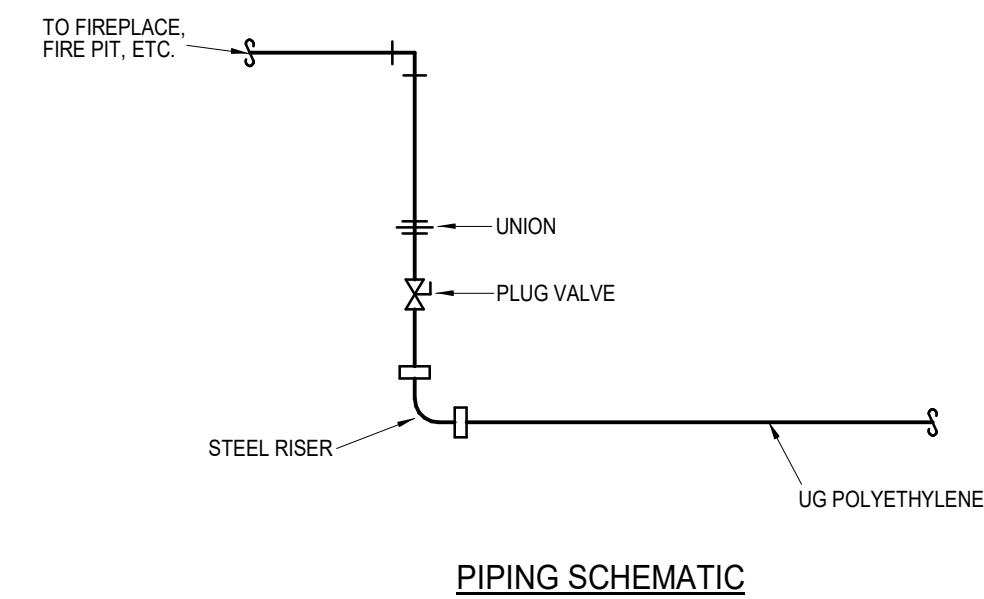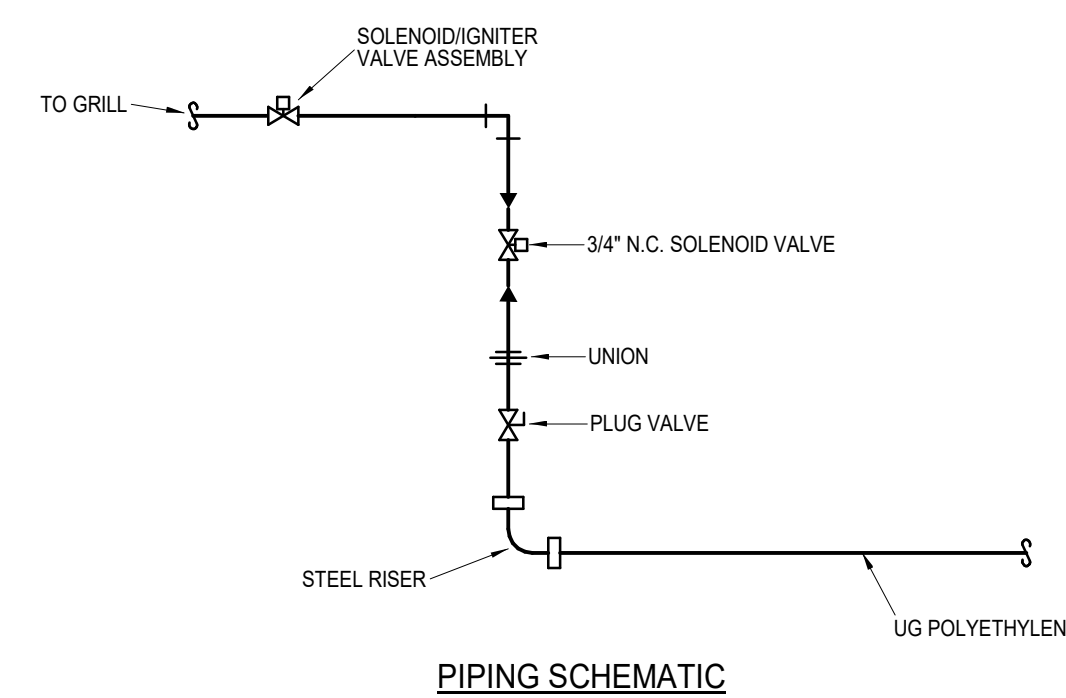


8 OUTSIDE AIR DAMPER CONTROL SCHEMATIC
NOT TO SCALE

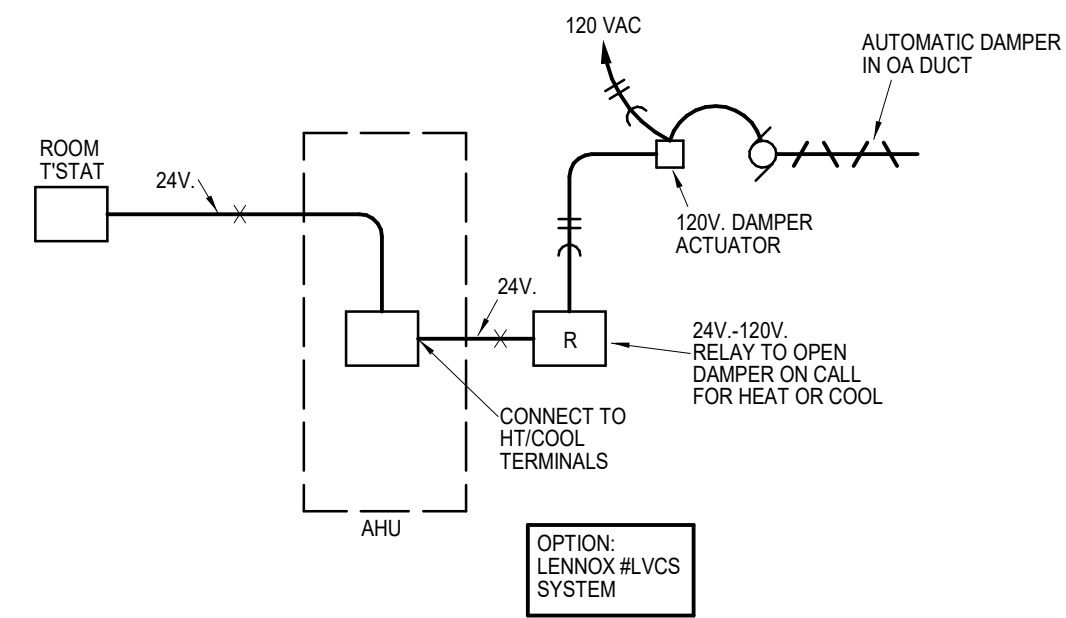



9 ELEVATOR SUMP PUMP DETAIL
NOT TO SCALE

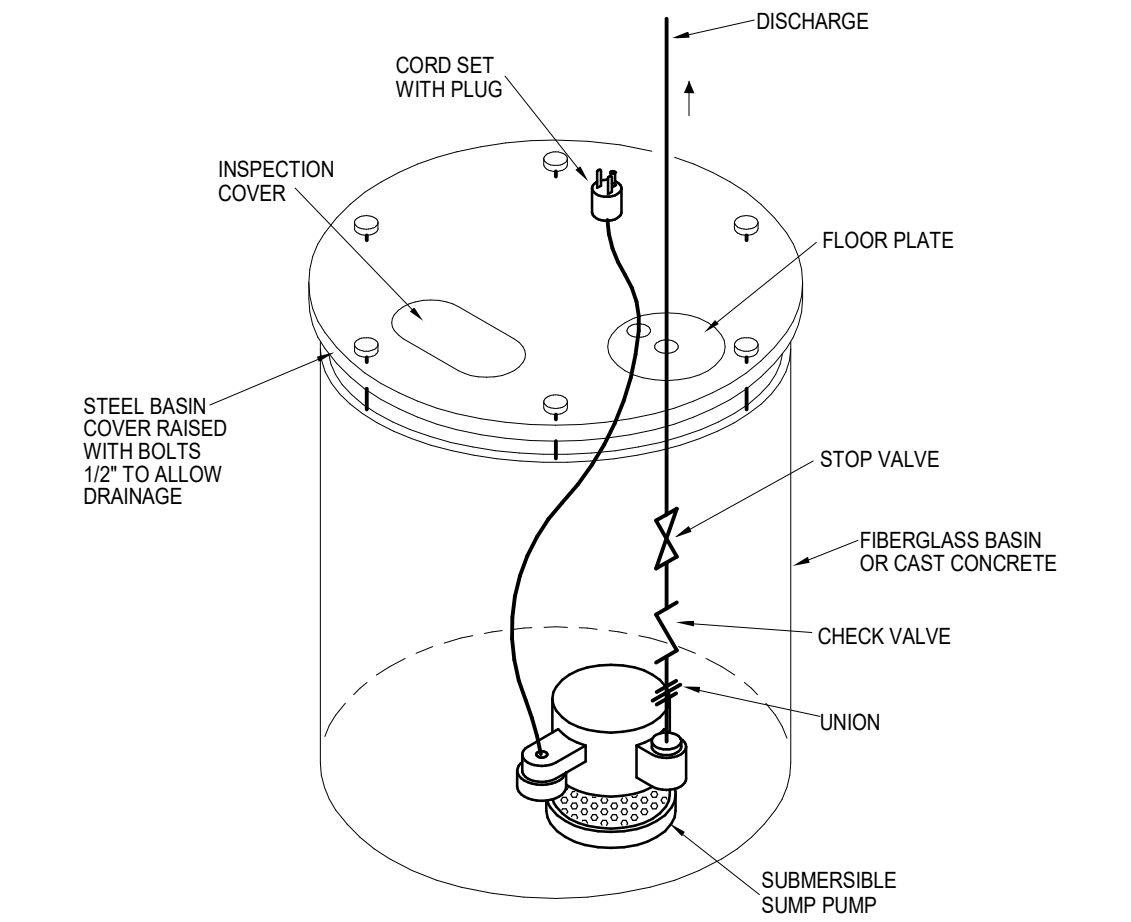


10 ROOF HYDRANT
NOT TO SCALE

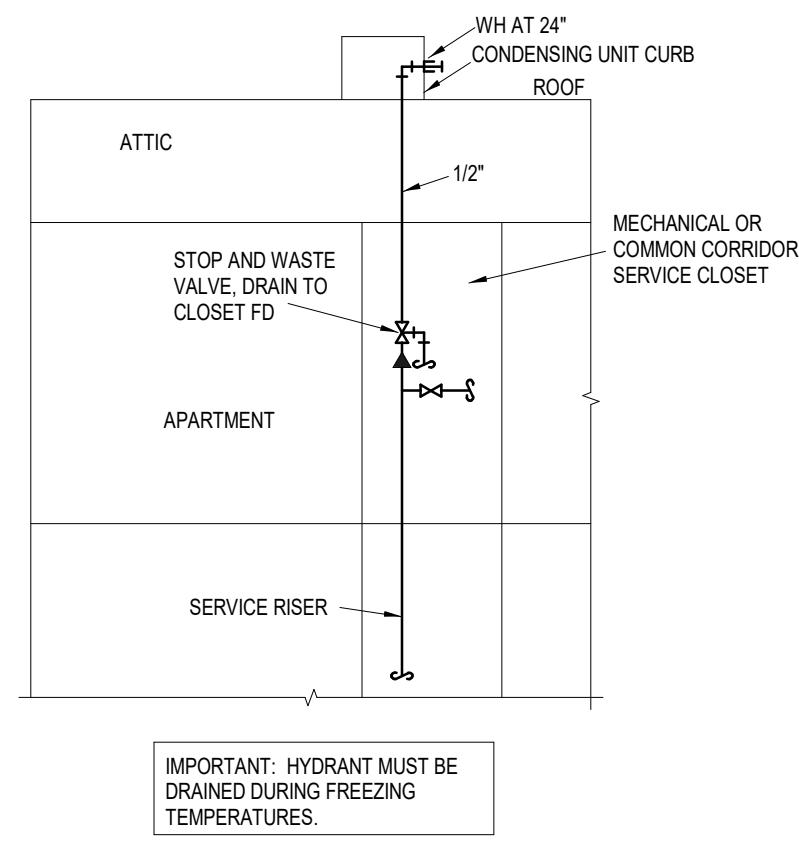


11 GAS GRILL/FIRE PIT DETAIL
NOT TO SCALE

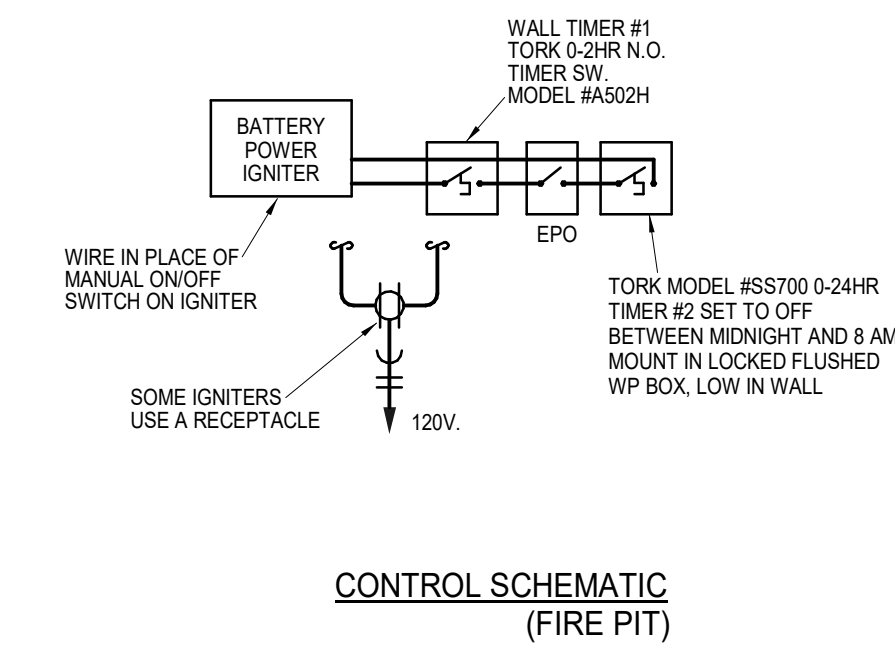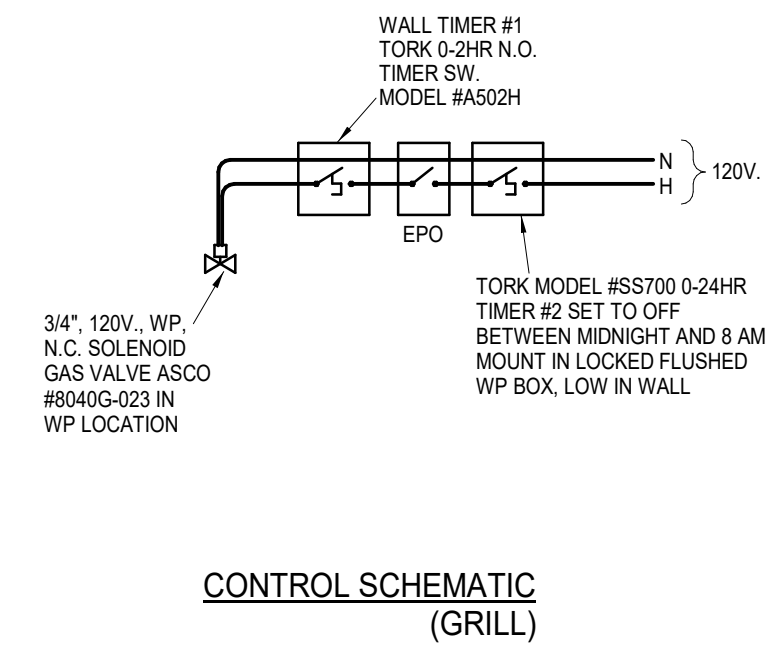


12 ISLAND VENT DETAIL
NOT TO SCALE

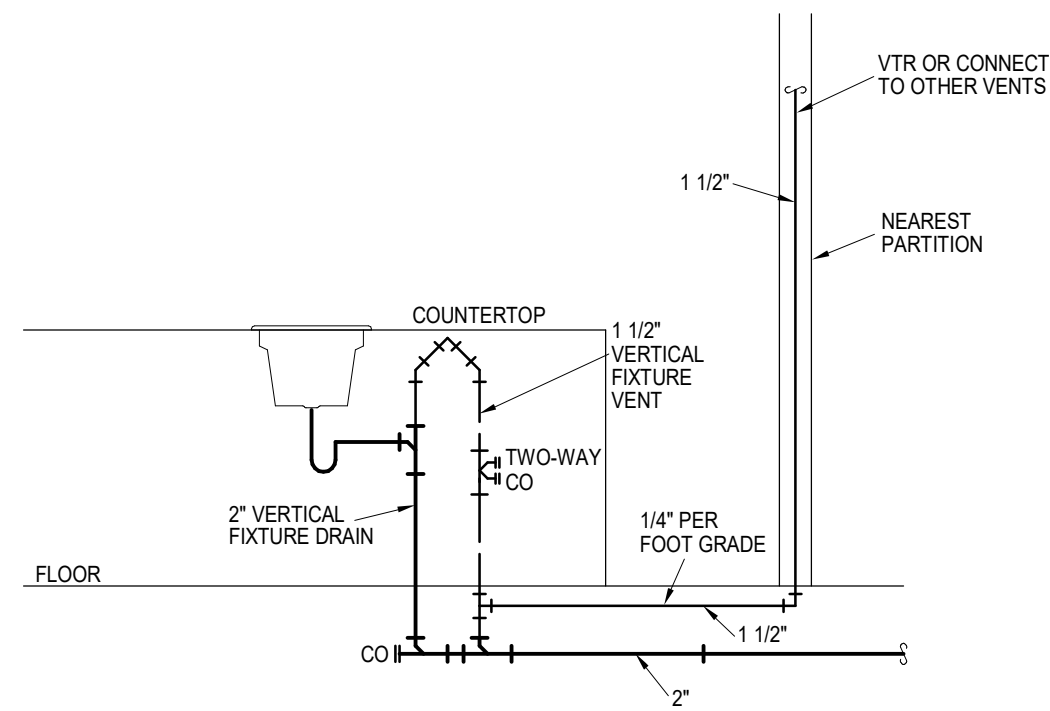


13 ROOF MOUNTED CONDENSING UNIT DETAIL
NOT TO SCALE

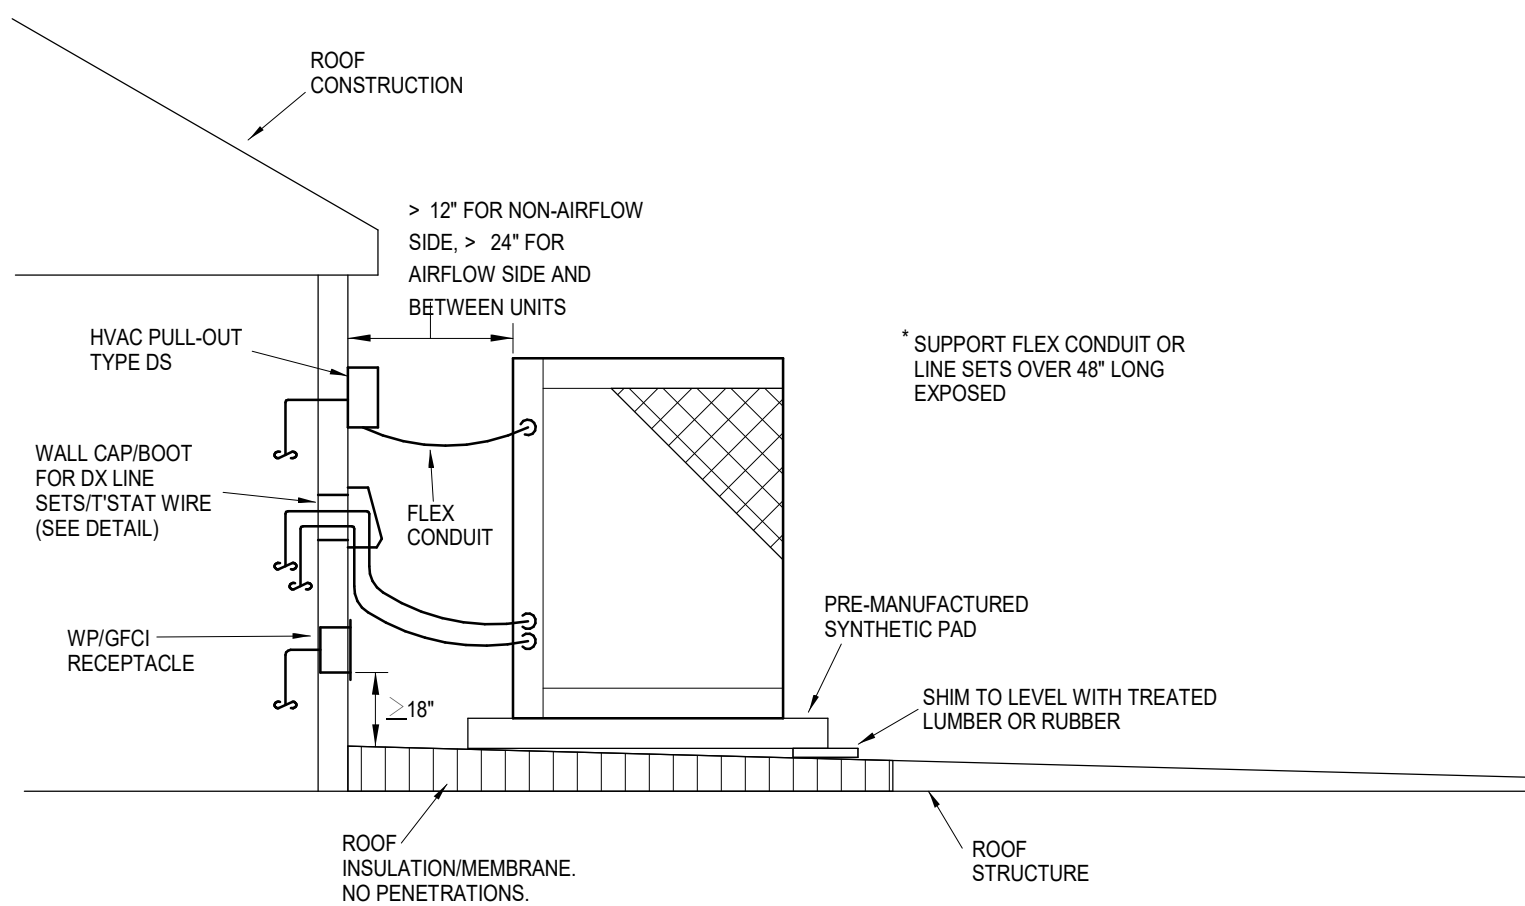

14 DOMESTIC WATER RISER
NO SCALE

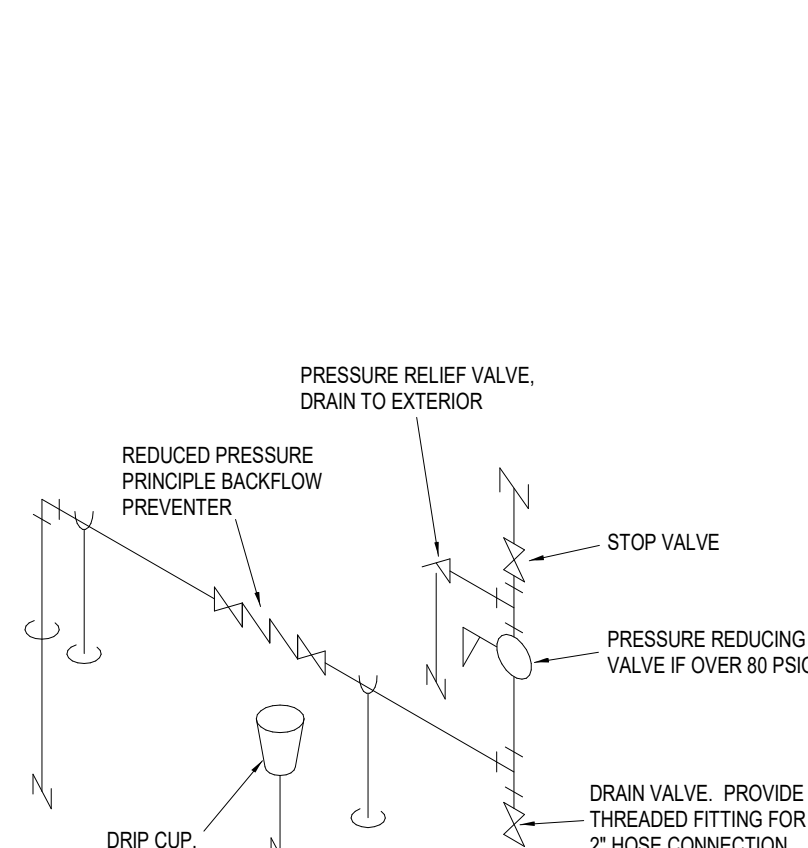

15 FIRE SUPPRESSION ENTRANCE RISER
NO SCALE

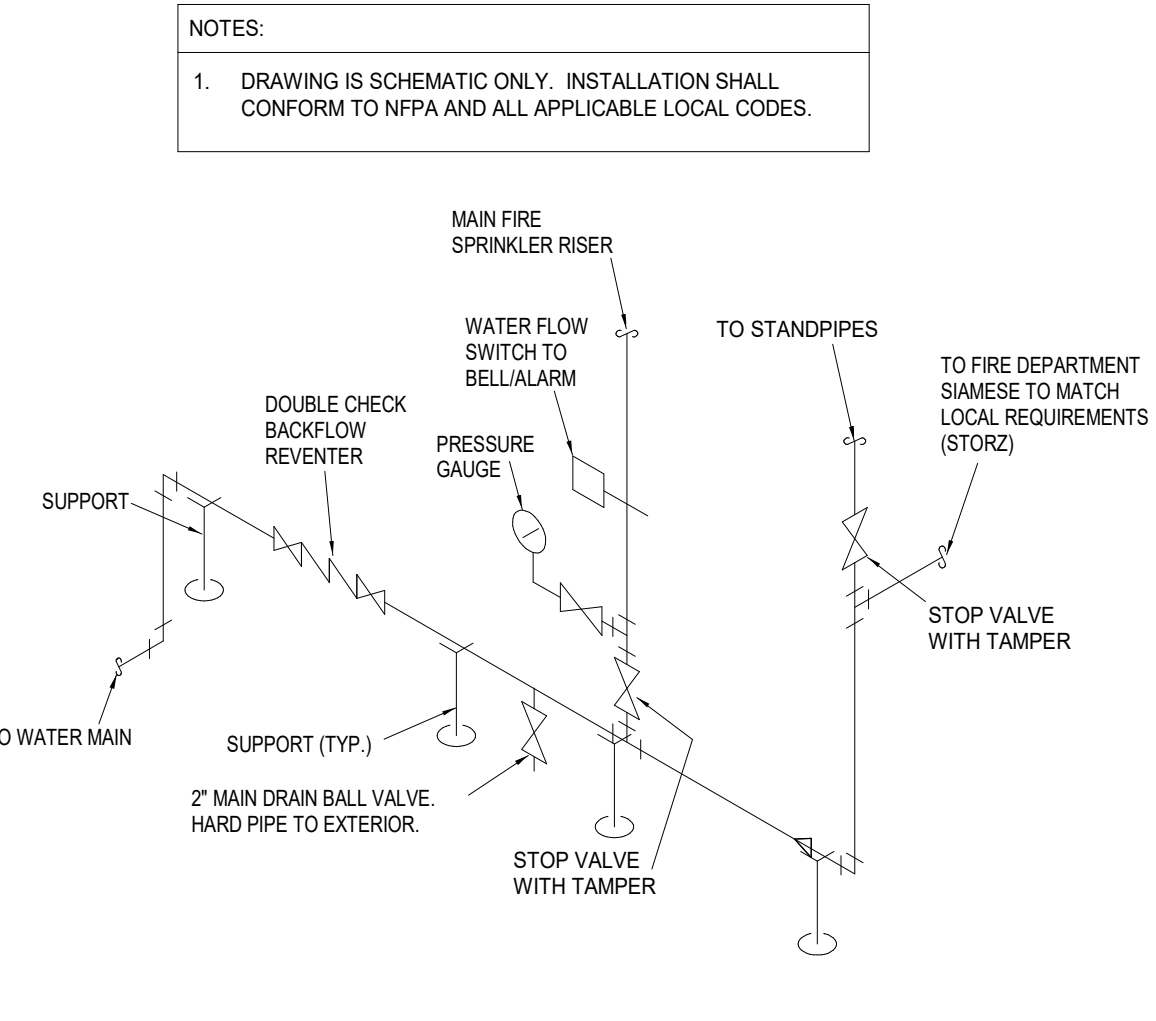

PARAGON STAR
NORTH VILLAGE

3200 NW PARAGON PKWY
LEE'S SUMMIT, MO 64081

Project No.: 18017.19050.07,19050.08
Date: 06.28.22
Issued For: FOR CONSTRUCTION

REVISIONS

No.	Date	Description
2	07.11.22	ADDENDUM 1
4	9.28.22	ASI 1
5	11.01.22	ASI 2

REGISTRATION



PROJECT TEAM

ARCHITECT	FINKLE-WILLIAMS ARCHITECTURE
CIVIL	GBA ENGINEERS
LANDSCAPE	LAND 3
STRUCTURAL	BOB D. CAMPBELL
PLUMBING	LATIMER SOMMERS
MECHANICAL	LATIMER SOMMERS
ELECTRICAL	LATIMER SOMMERS
FIRE PROTECTION	LATIMER SOMMERS
CONTRACTOR	BRINKMANN CONSTRUCTORS



SHEET TITLE

MECHANICAL
DETAILS/SCHEDULES

SHEET NUMBER

MP2.01