

**Deer Brook Plaza  
Smith & Boucher Project No. 2218000**

**January 16, 2023**

**To Documents Titled:**  
1121 & 1151 NE Rice Road  
Lee's Summit, MO 64086-6788  
Permit Set  
June 10, 2022

**Architect-of-Record:**  
Icon Architecture + Fabrication  
506 Grand Boulevard  
Kansas City, MO 64106






The Contract Documents for the above referenced project and the Work covered thereby are modified as described herein.

## **DRAWINGS**

1. E3.11
  - a. Revised one-line diagram to reflect what is being installed.

END OF MEP ITEMS FOR REVISION NO. 3

PROJECT NAME: Deer Brook Retail Renovations  
AUTOCAD FILE LOCATION: X:\22\22180\Drawings\06-2218000\_E3.11.dwg  
LAST CORRECTION BY: Blee  
PLOTED BY: Bob  
DATE: Monday, January 16, 2023 9:40:52 AM  
TIME: Monday, January 16, 2023 9:52:41 AM

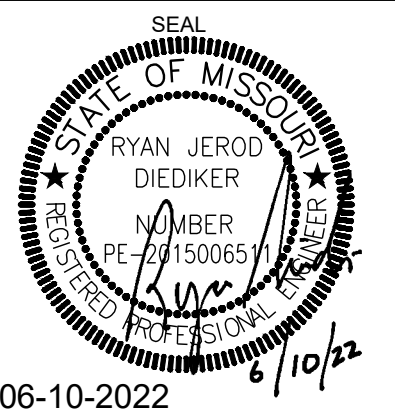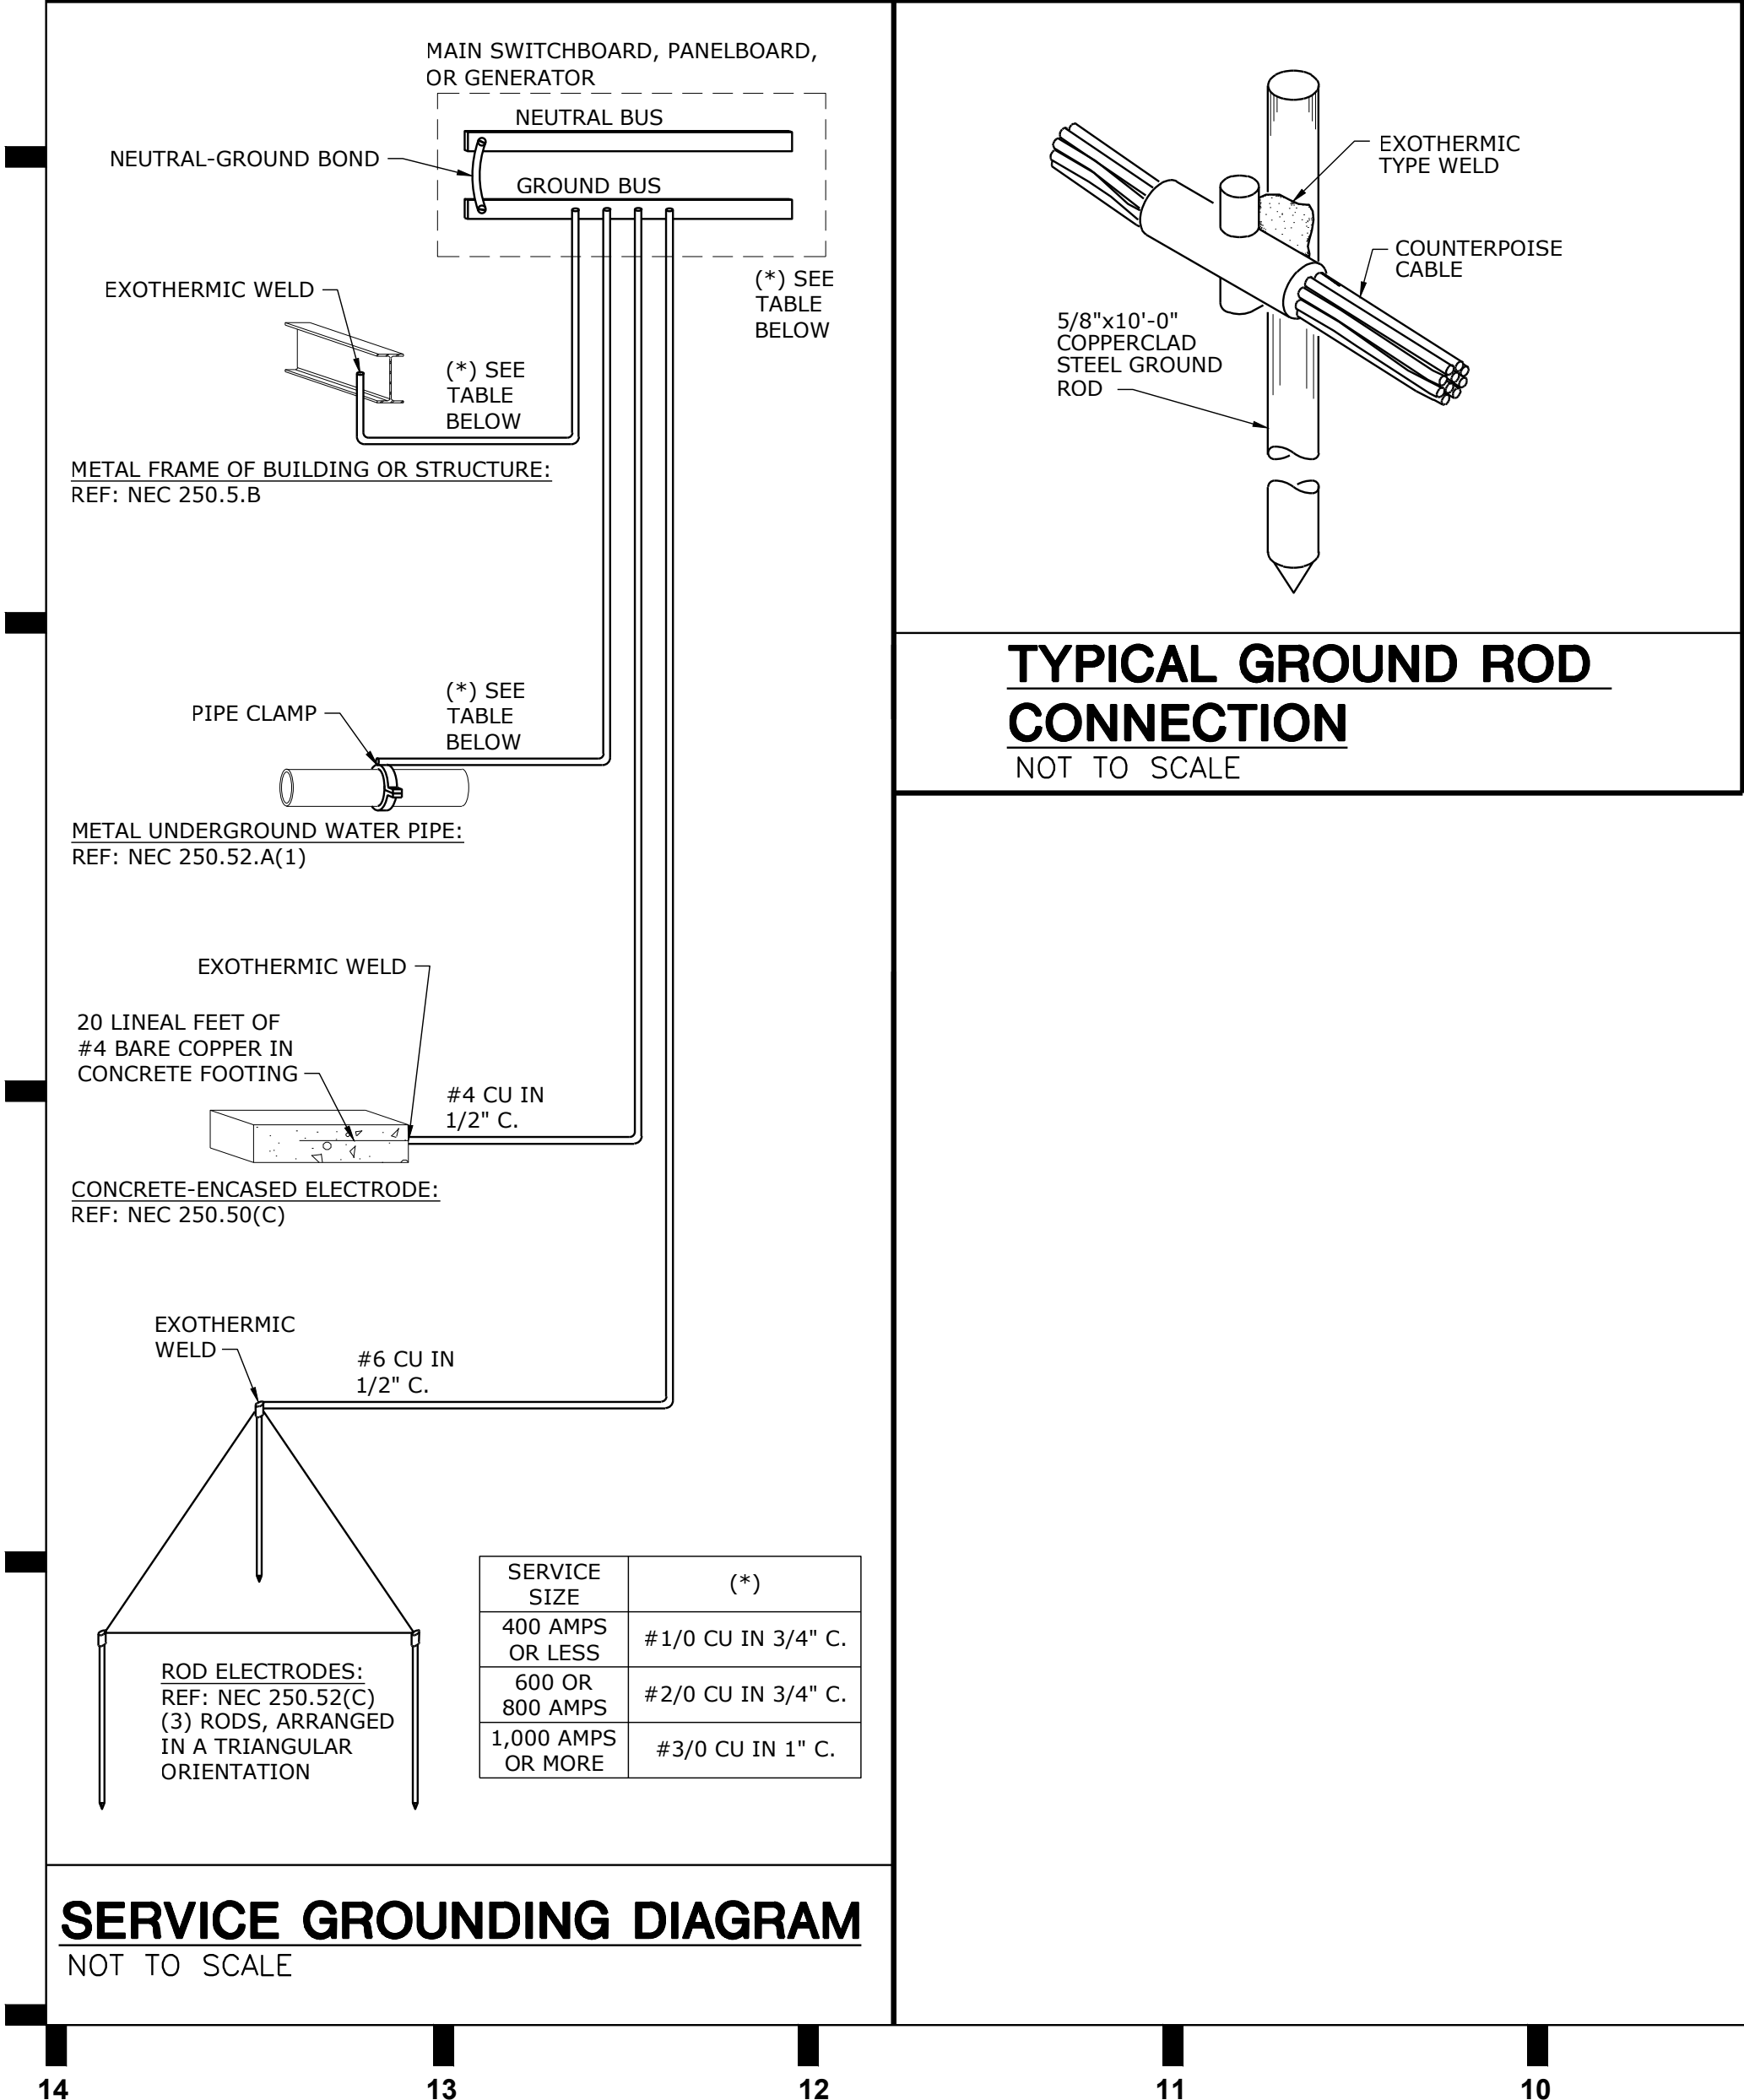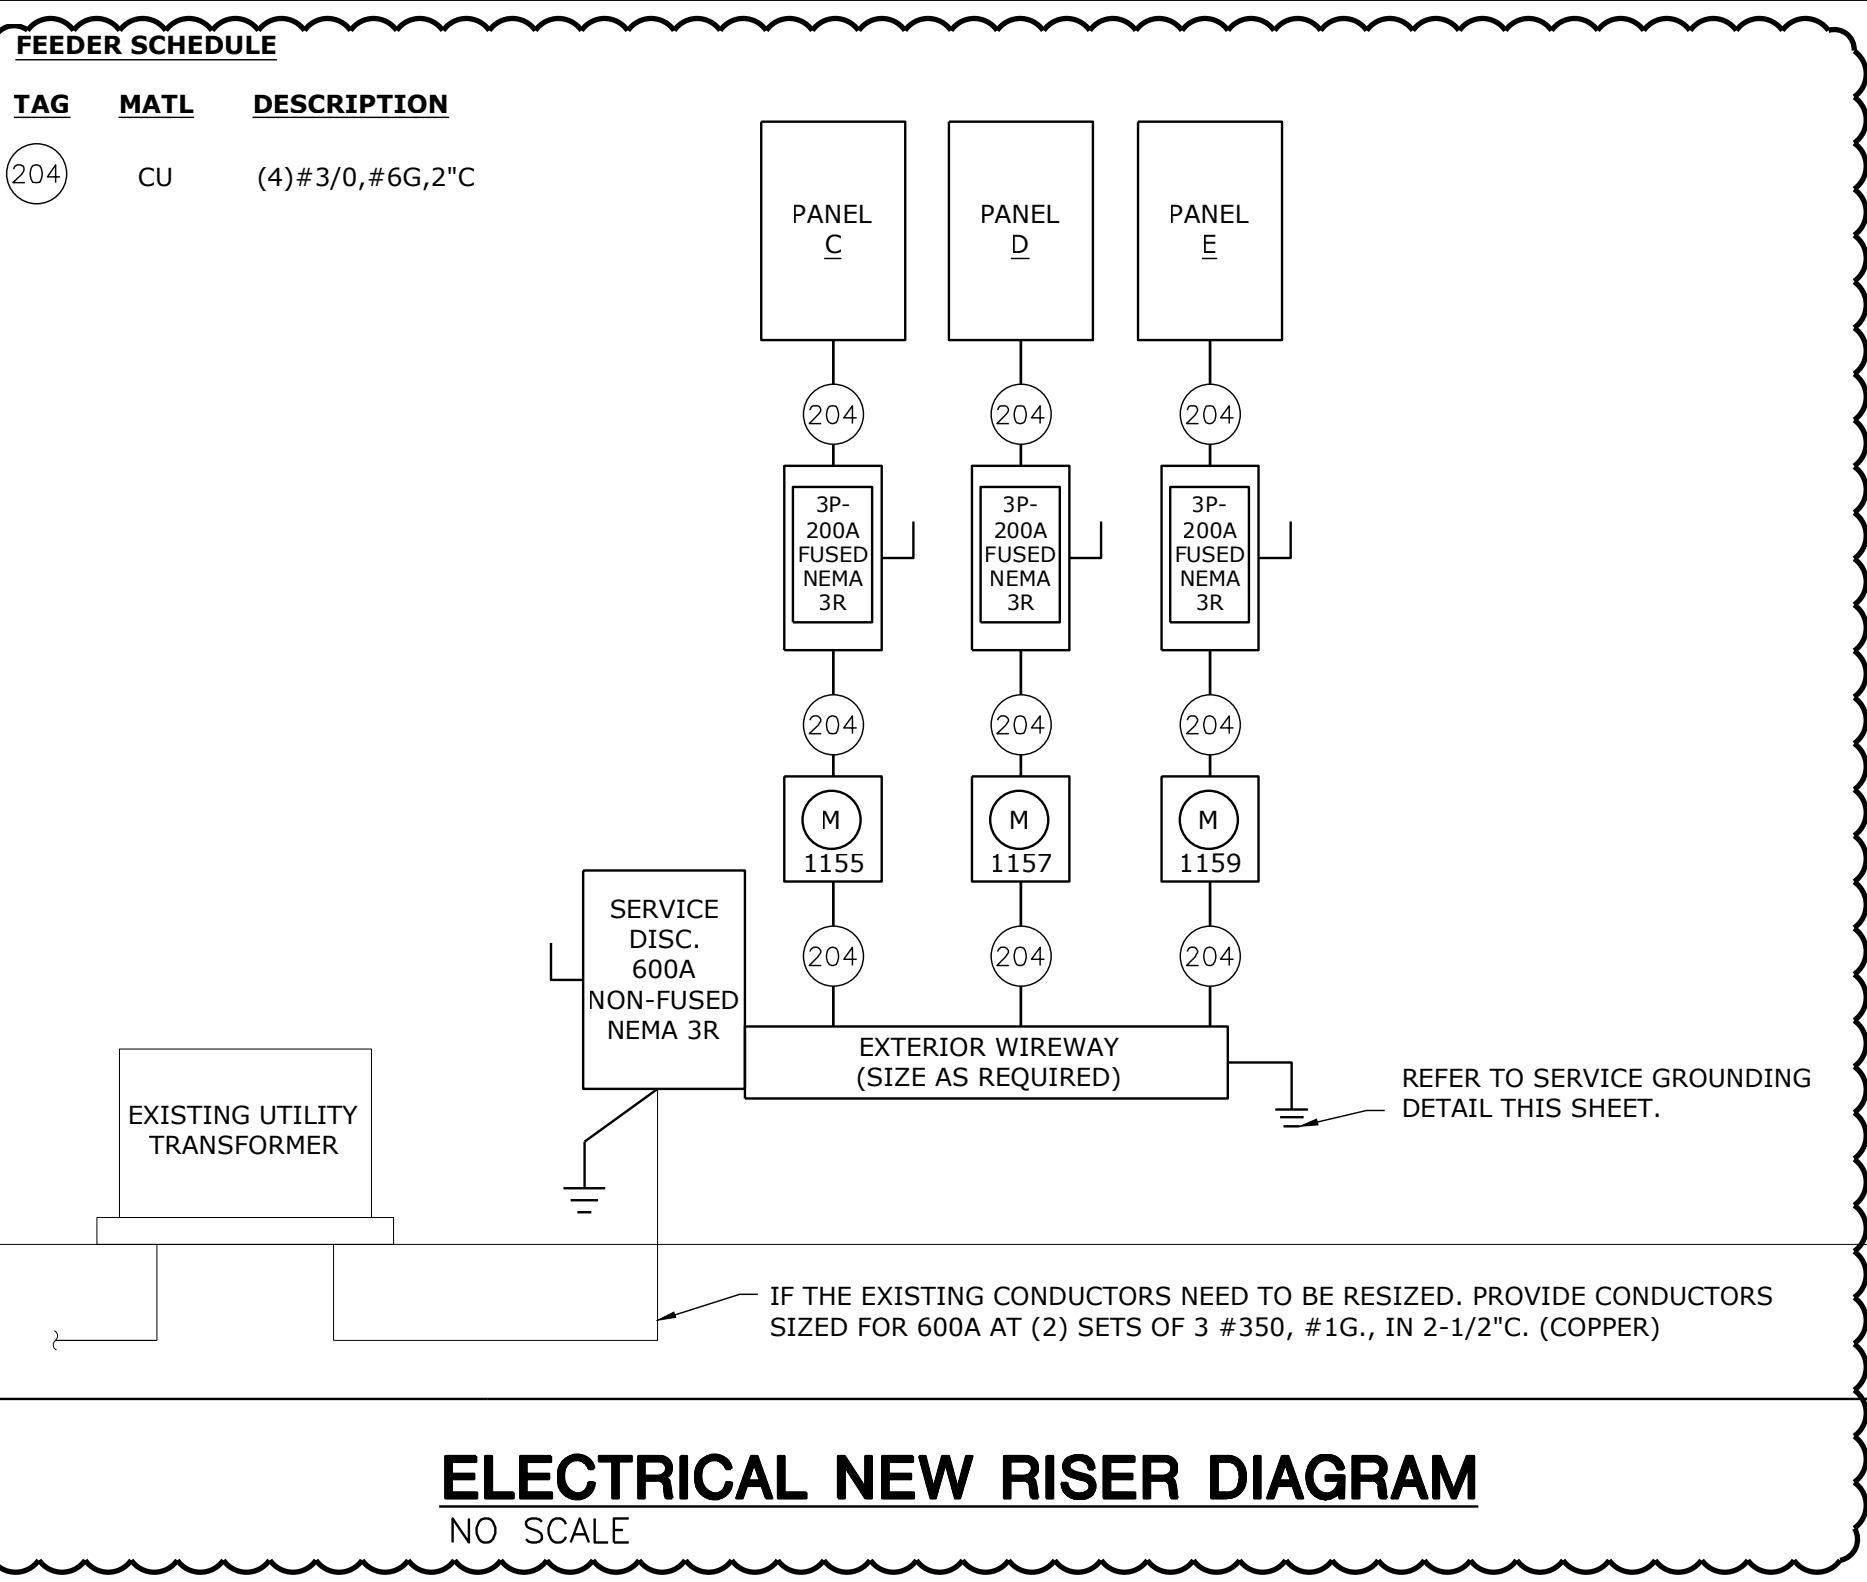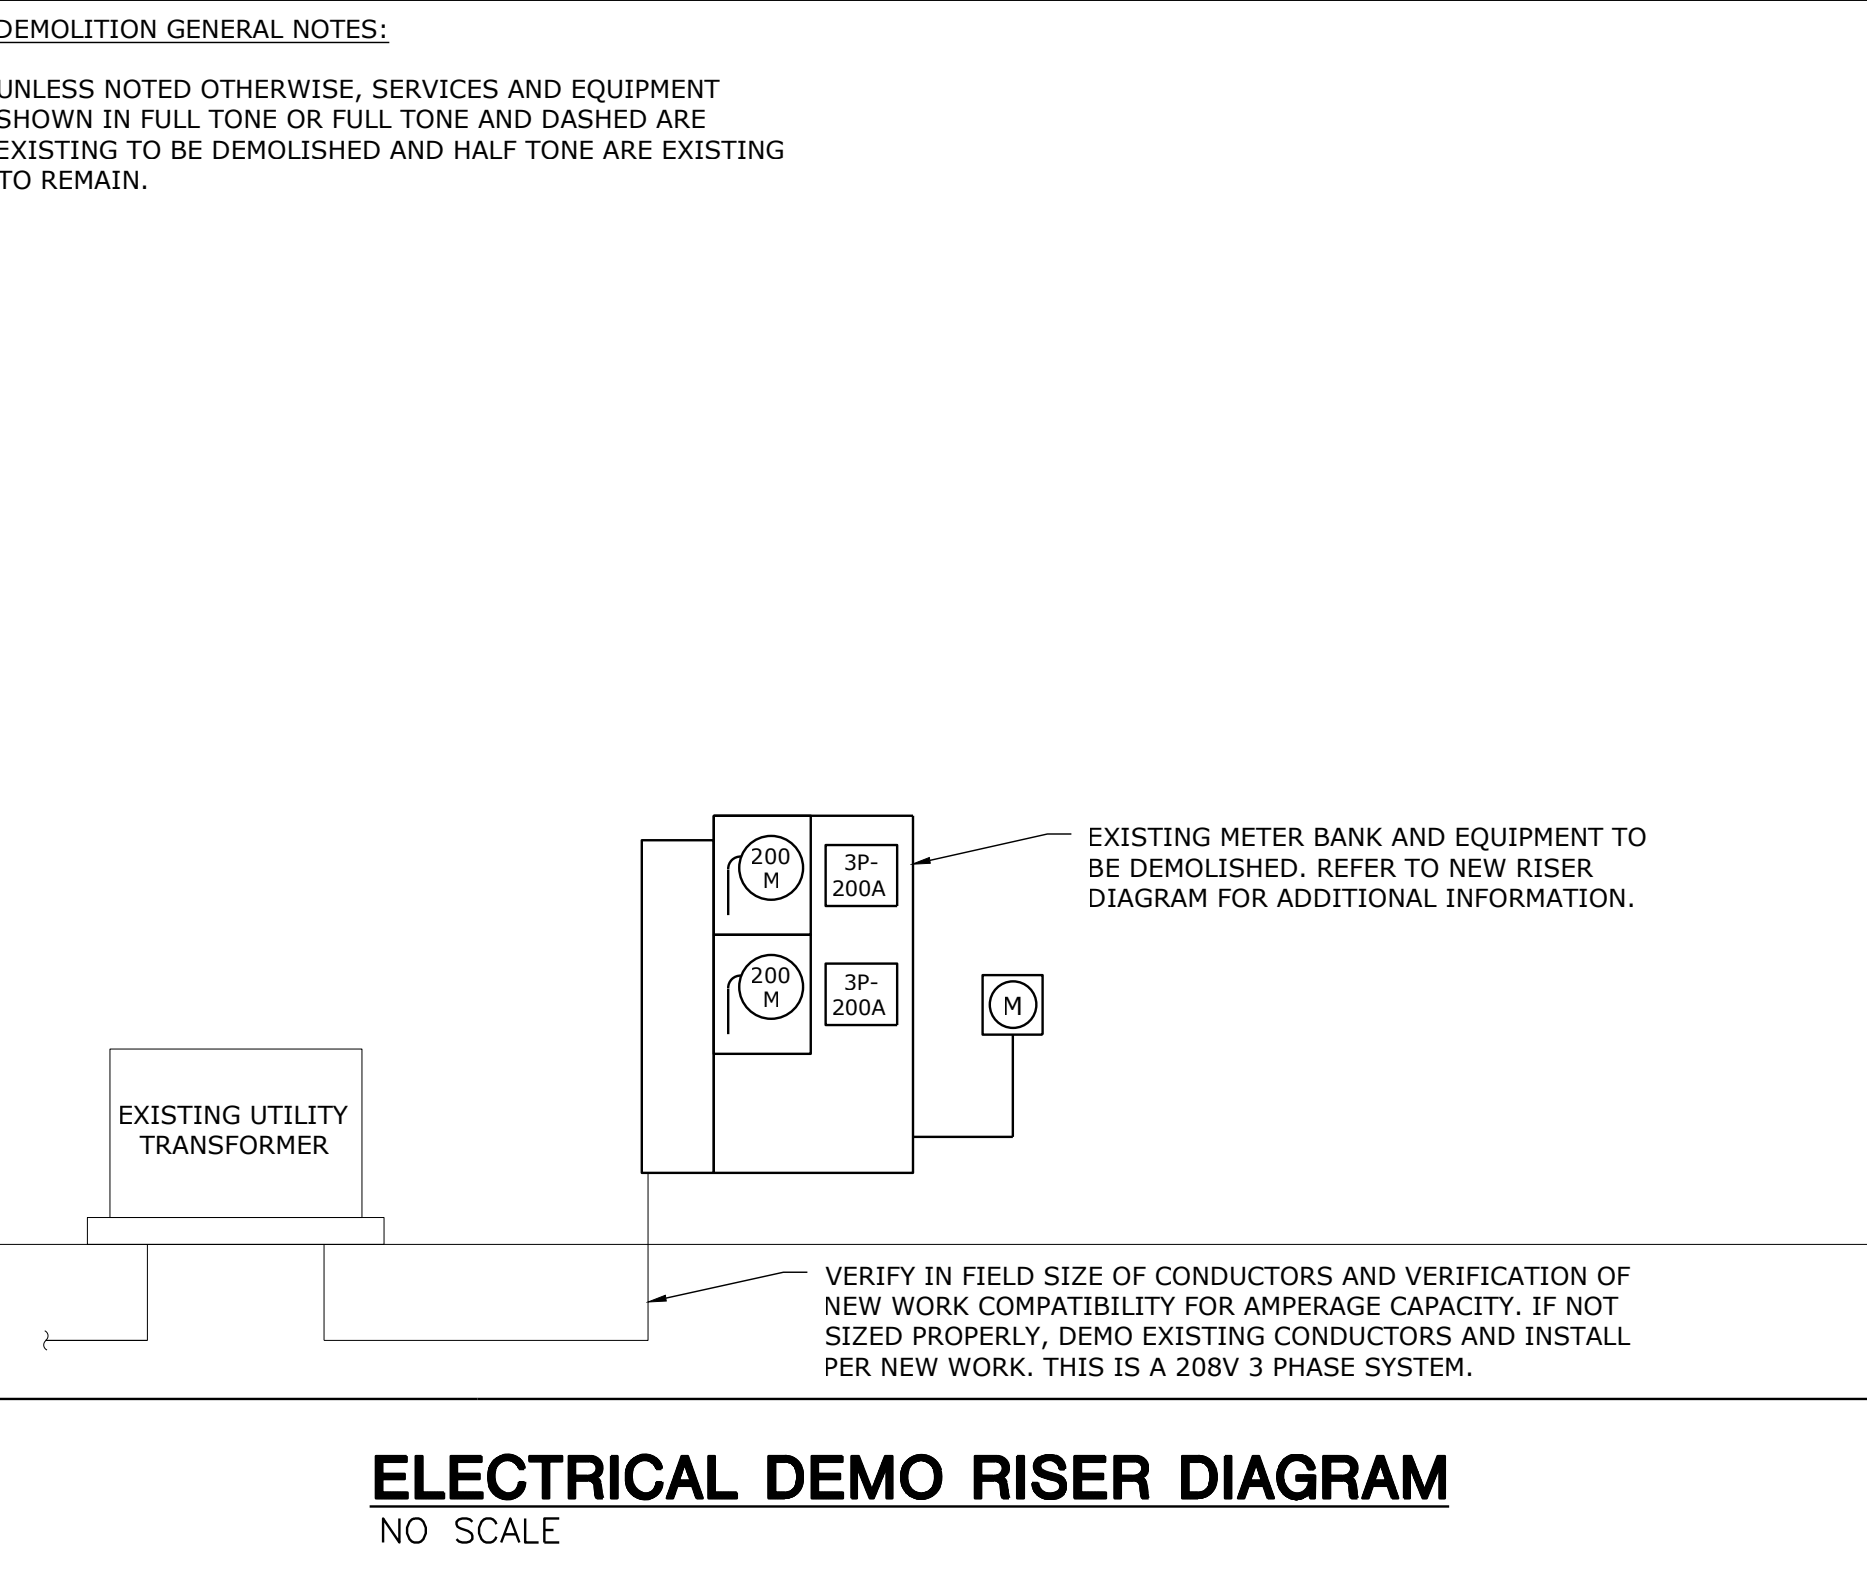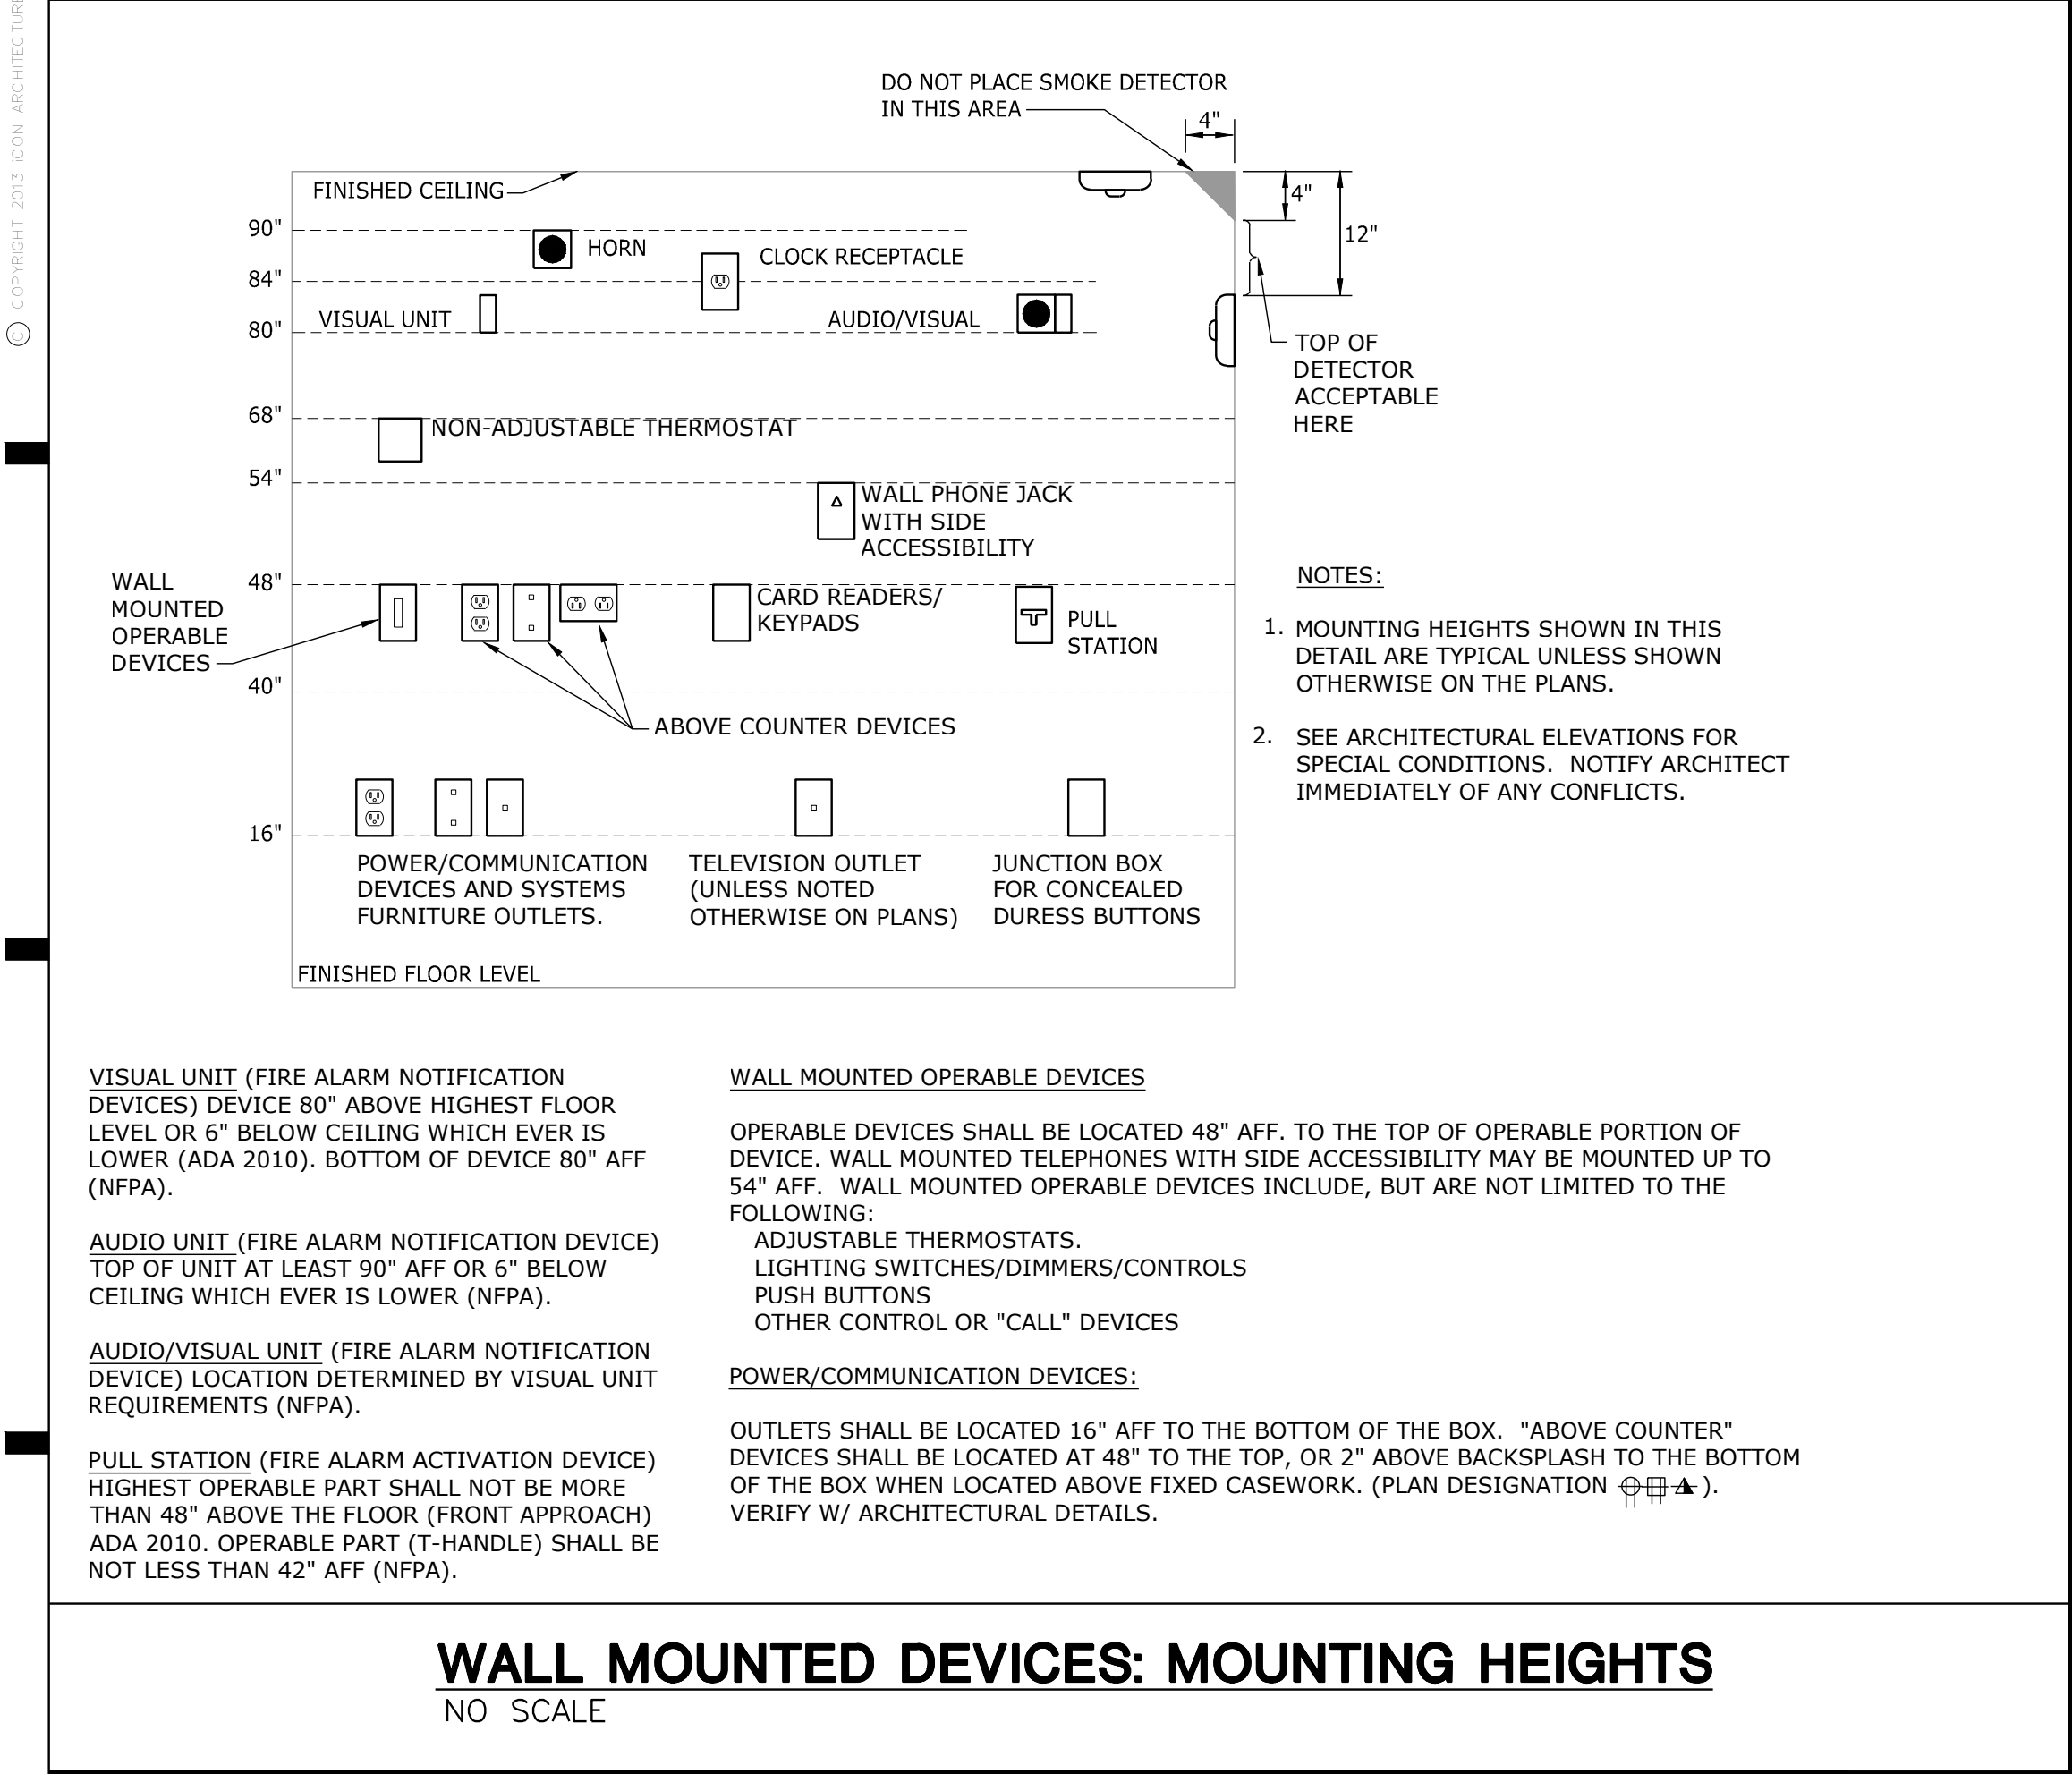

PERMIT SET

DEER BROOK PLAZA  
1121 & 1151 NE RICE ROAD  
LEE'S SUMMIT, MO 64086-6788



506 Grand Boulevard  
Kansas City, MO 64106  
p:816.221.0250 f:816.221.0251

REVISIONS  
3  
ASI No. 1  
ELECTRICAL  
REVISION 1-16-23

ISSUE DATE  
06-10-22

PROJECT NUMBER  
2022-000

SHEET NUMBER

E3.11

Electrical - Schedules & Details

