




4 PLUMBING WATER RISER
NOT TO SCALE

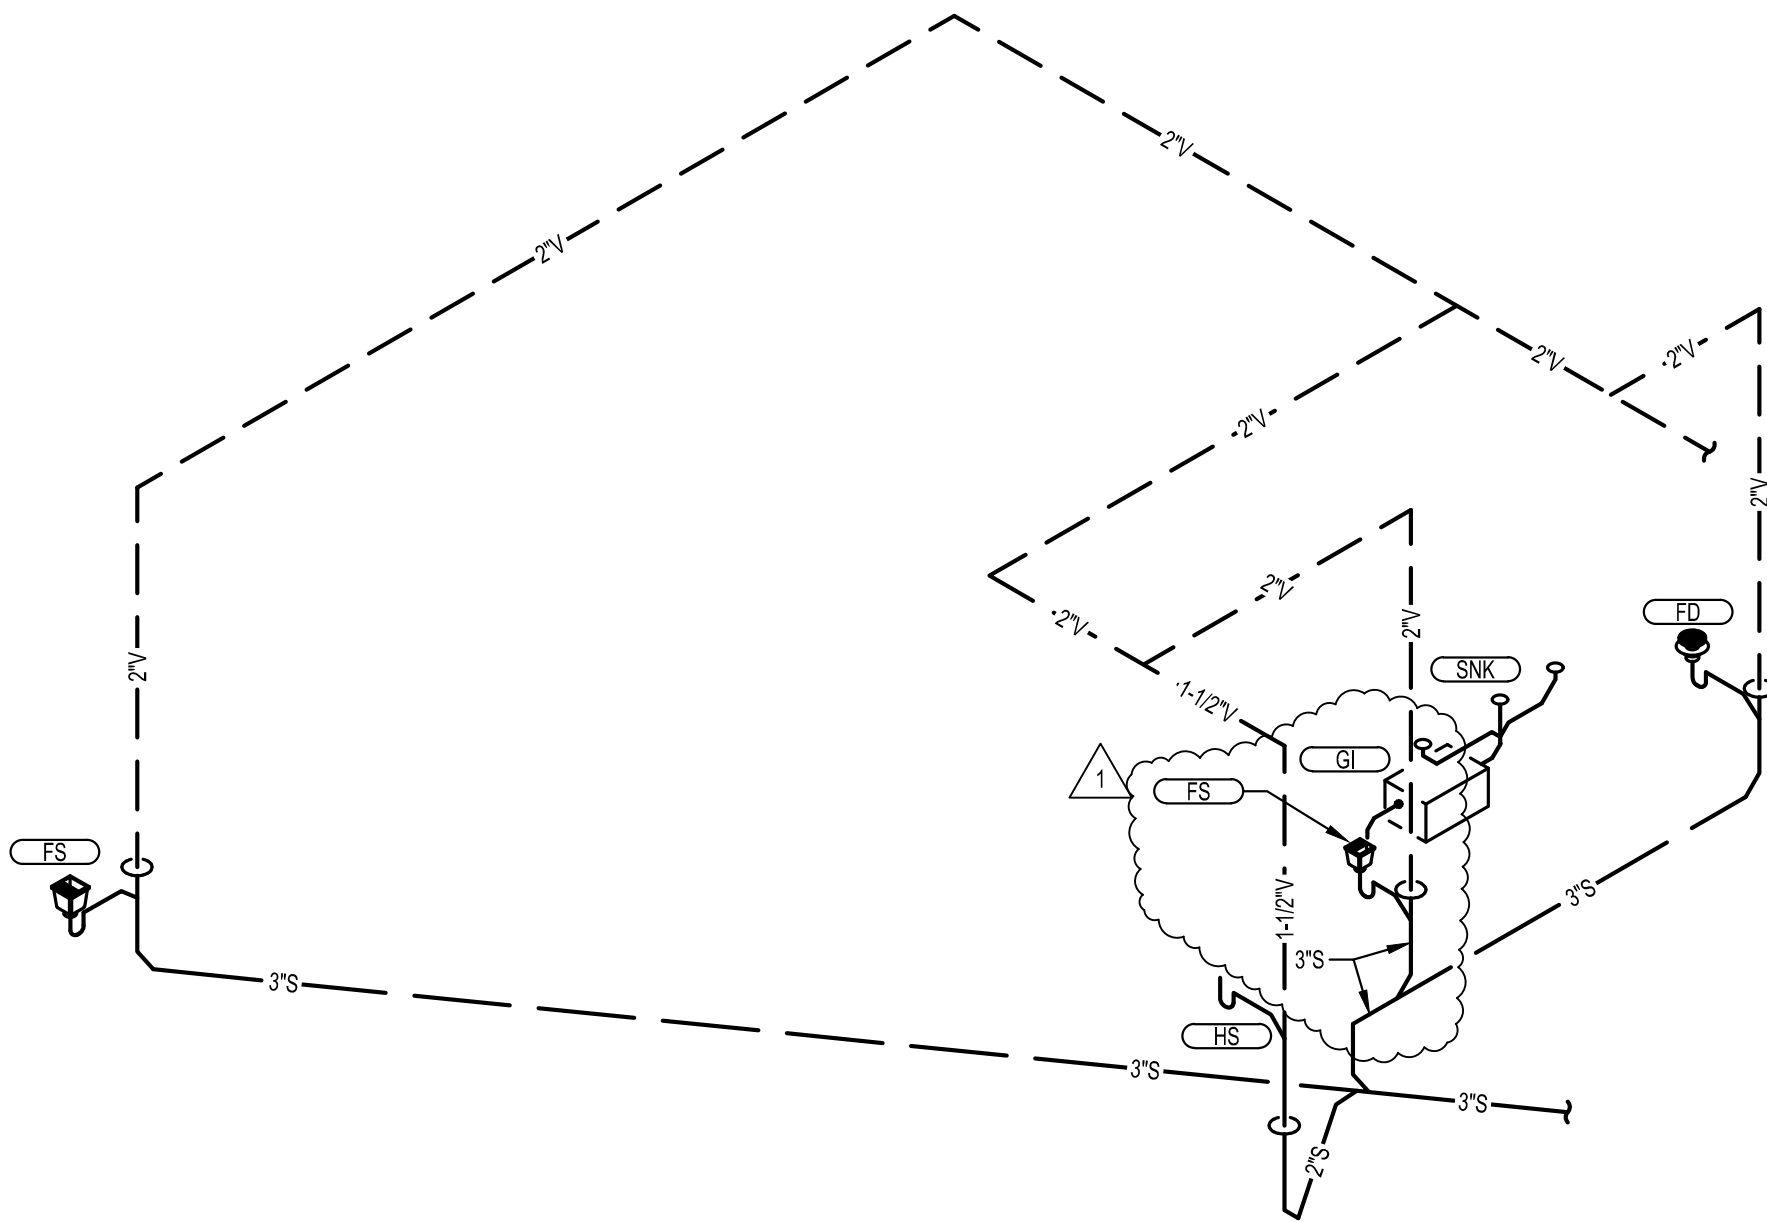

3 PLUMBING WASTE AND VENT RISER
NOT TO SCALE

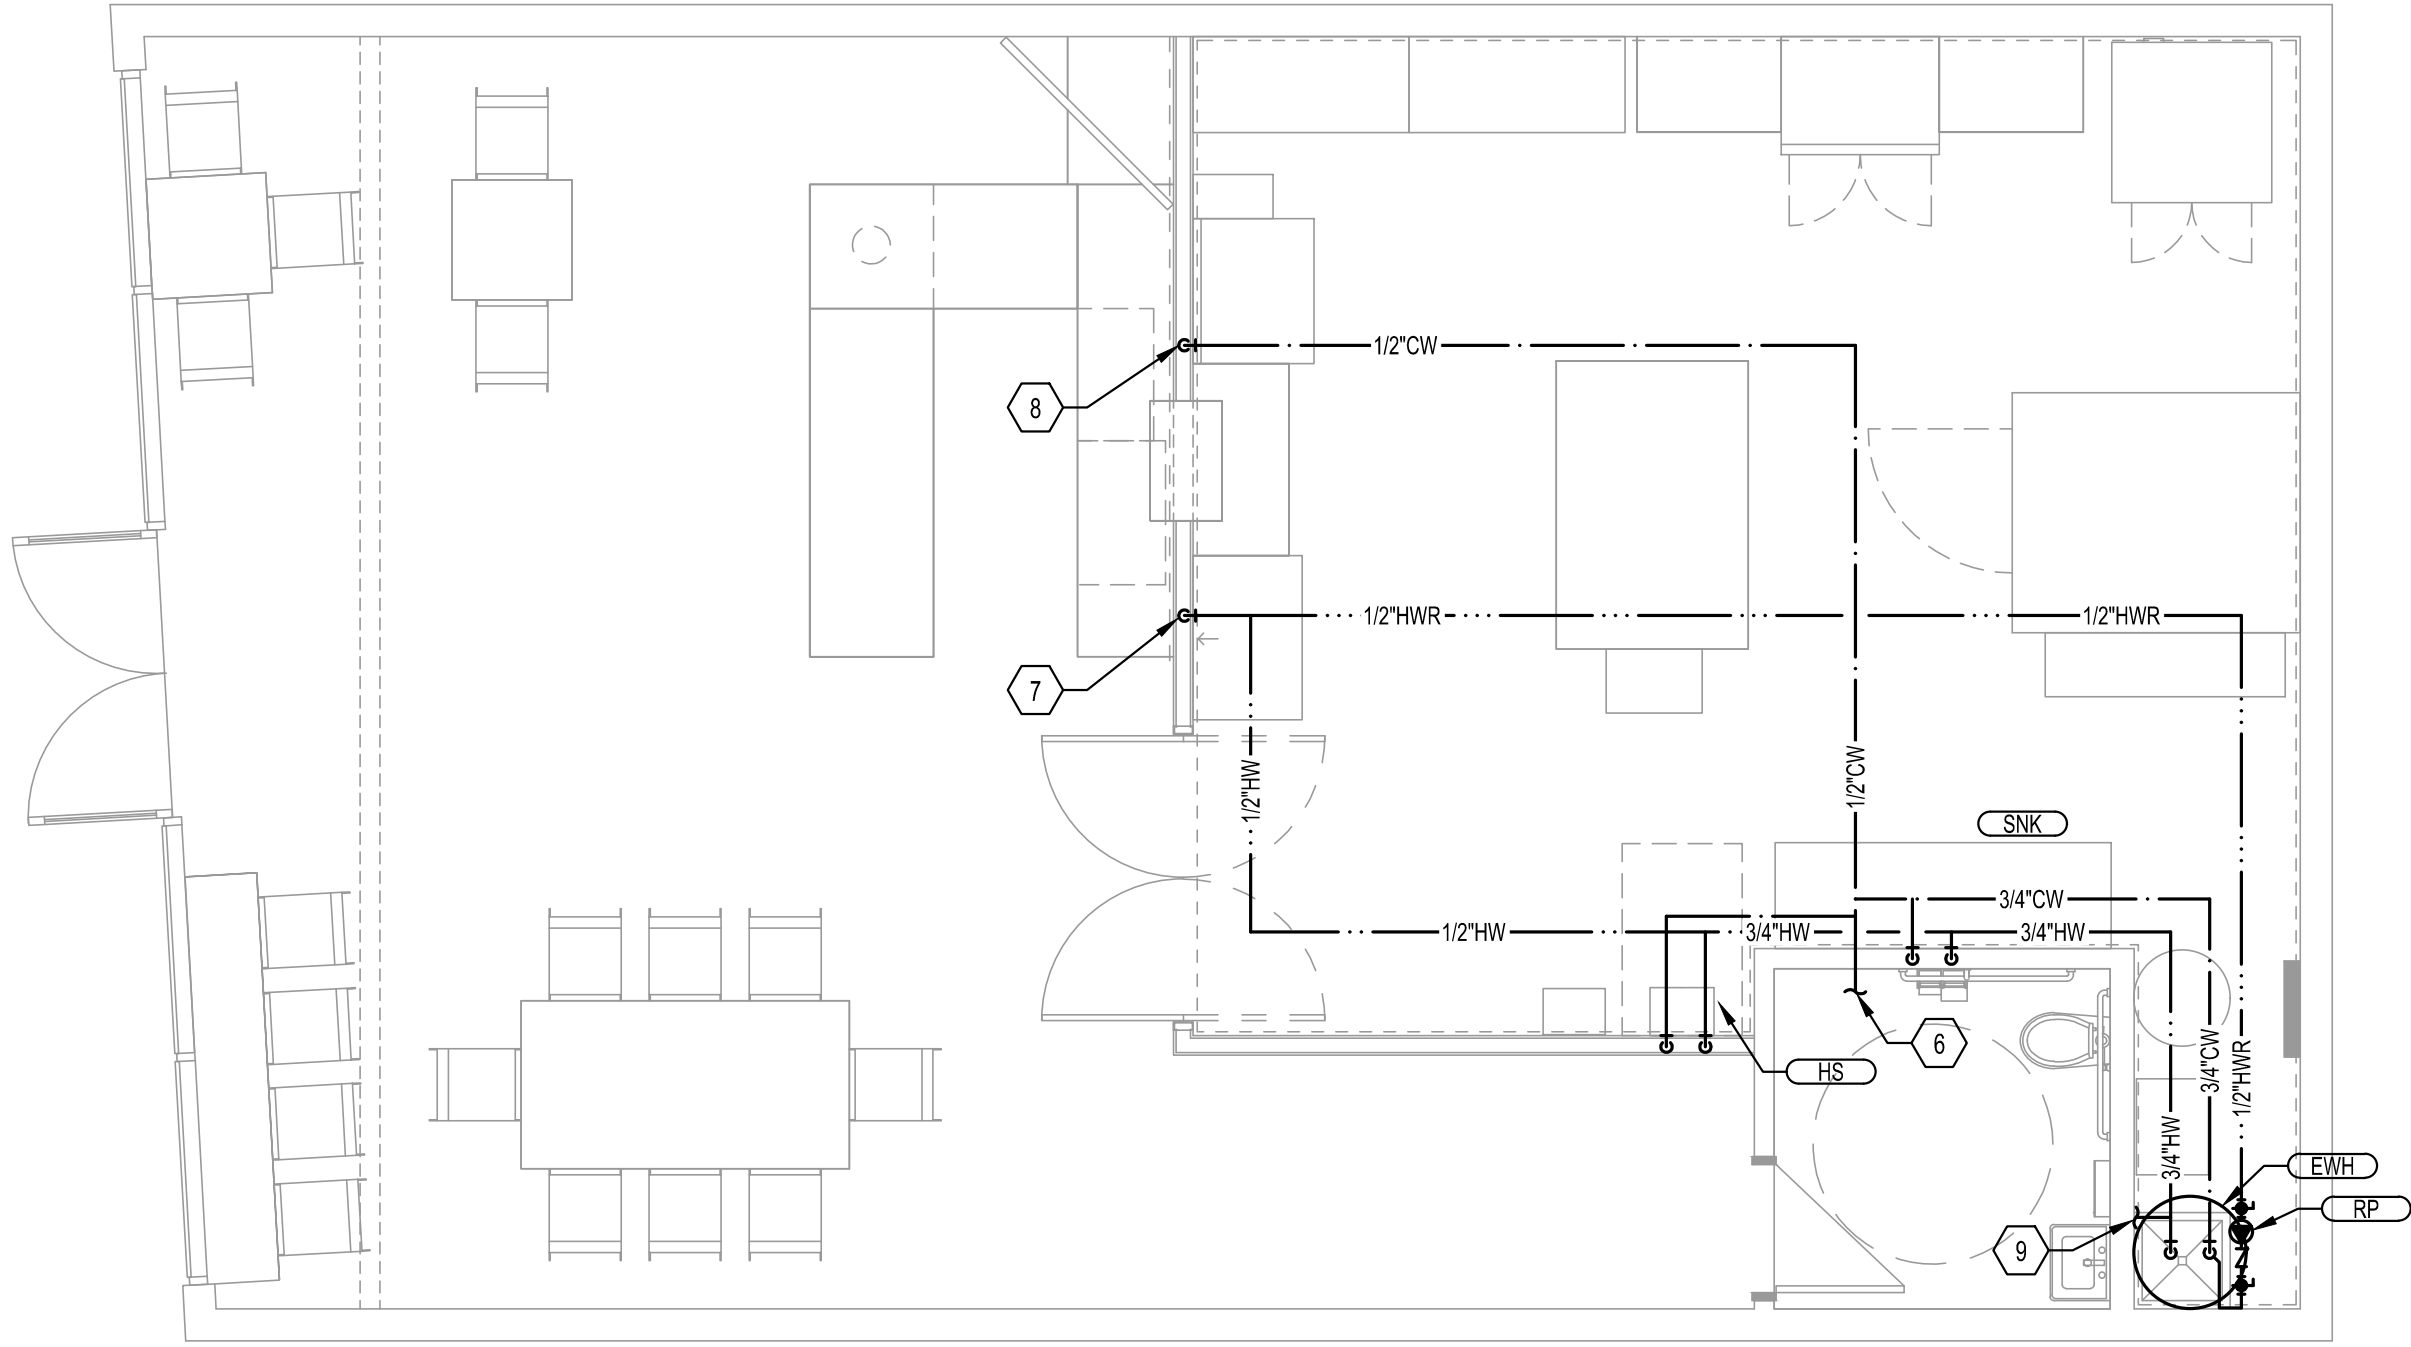

2 PLUMBING WATER PLAN
SCALE: 1/4" = 1'-0"

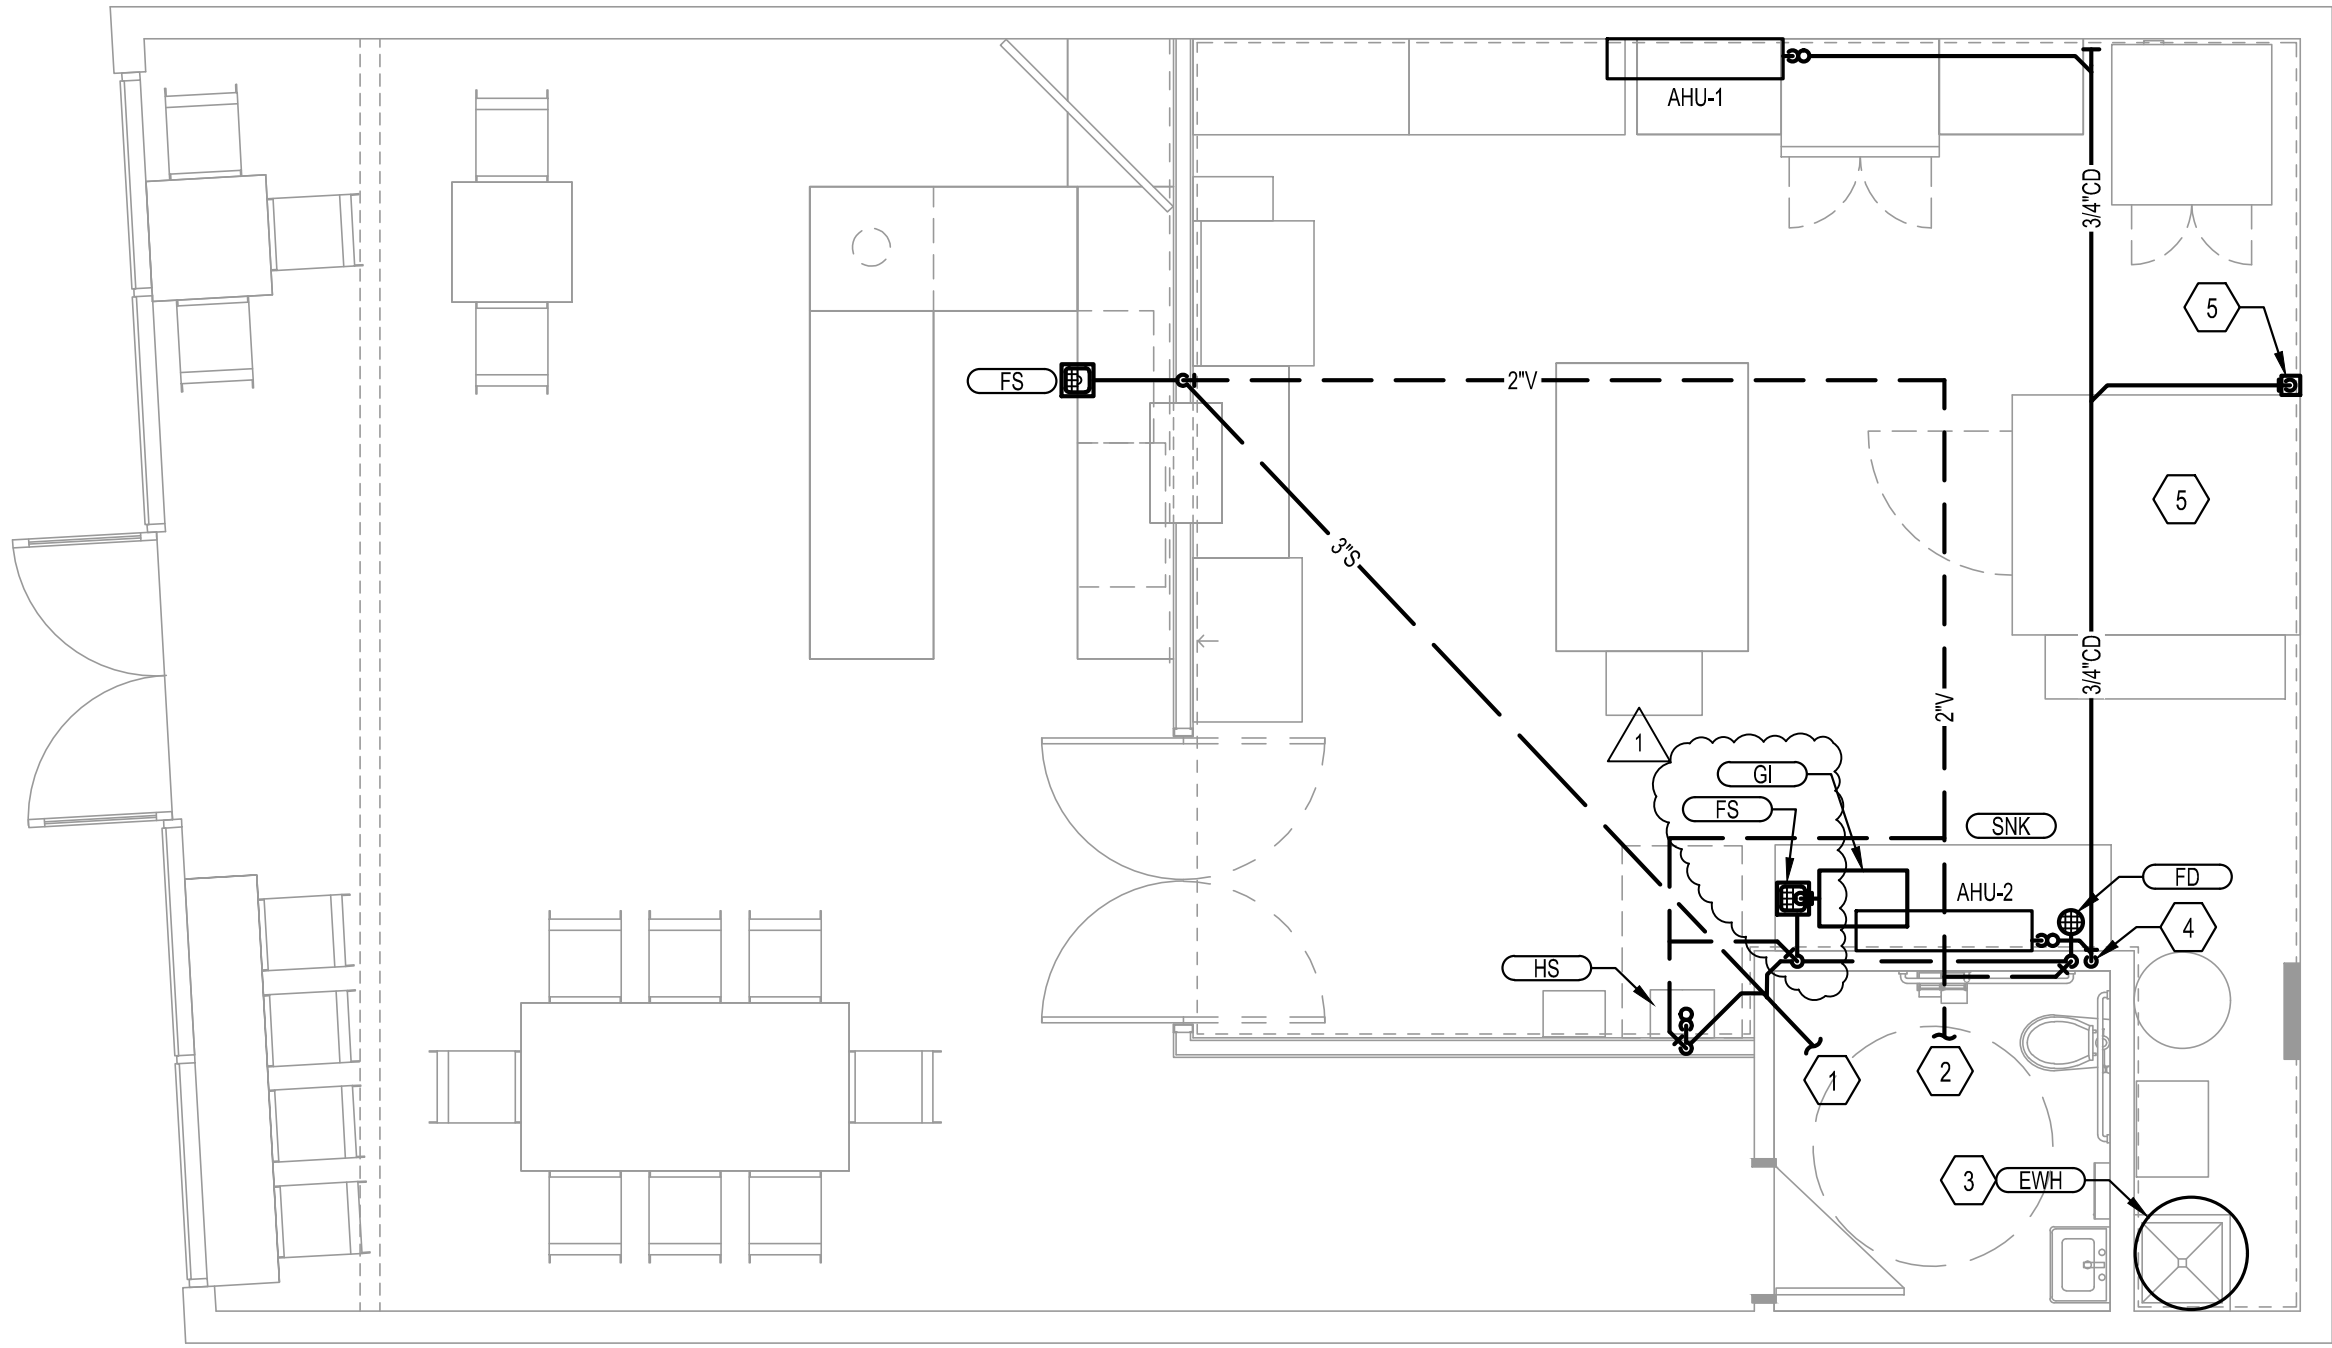

1 PLUMBING WASTE AND VENT PLAN
SCALE: 1/4" = 1'-0"

GENERAL NOTES

(NOT ALL NOTES APPLY)

1. REFERENCE SHEET P101 FOR GENERAL NOTES, SYMBOLS, AND ABBREVIATIONS.
2. ALL SHUT-OFF OR BALANCING VALVES TO PLUMBING ROUTED IN PIPE CHASES SHALL BE ACCESSIBLE FROM CEILING AREA OR ACCESS DOORS PROVIDED IN WALL.
3. ALL EXPOSED PIPES PENETRATING FINISHED WALLS SHALL BE EQUIPPED WITH WALL ESCUTCHEONS.
4. PROVIDE FINAL CONNECTIONS FOR ALL EQUIPMENT SPECIFIED IN PLUMBING FIXTURES AND EQUIPMENT SCHEDULES ON THESE CONSTRUCTION DOCUMENTS IN ACCORDANCE WITH MANUFACTURERS INSTRUCTIONS. PROVIDE ALL REQUIRED SHUT-OFFS, BACKFLOW PREVENTERS, PRESSURE REGULATORS, AND CONDENSATE DRAINS INDICATED ON PLUMBING SCHEDULES AND AS REQUIRED BY LOCAL CODES FOR COMPLETE EQUIPMENT INSTALLATION. CONSULT EQUIPMENT SUPPLIER OR OWNER FOR ADDITIONAL FINAL CONNECTION REQUIREMENTS NOT SHOWN ON THESE DRAWINGS.

KEYED NOTES: ○

1. CONNECT NEW 3" SANITARY LINE INTO EXISTING SANITARY SERVING EXISTING TO REMAIN RESTROOM AREA. FIELD VERIFY EXACT CONNECTION POINT, LINE SIZE, MATERIAL, AND AVAILABLE INVERT.
2. CONNECT NEW 2" V INTO EXISTING VENT LINE SERVING EXISTING TO REMAIN RESTROOM AREA. FIELD VERIFY EXACT CONNECTION POINT, LINE SIZE, AND MATERIAL.
3. WATER HEATER MOUNTED HIGH ON PLATFORM. ROUTE T&P DRAIN LINE AND DRAIN PAN DRAIN LINE TO MOP SINK.
4. ROUTE CONDENSATE DRAIN LINE DOWN IN WALL, TURN PIPING OUT OF WALL LOW AND TERMINATE OVER FLOOR DRAIN WITH AIR GAP PER CODE.
5. ROUTE CONDENSATE DRAIN LINE FROM COOLER TO LITTLE GIANT VCMA-15 SERIES CONDENSATE PUMP OR EQUAL.
6. CONNECT NEW 1" CW INTO EXISTING COLD WATER LINE SERVING EXISTING TO REMAIN RESTROOM AREA. FIELD VERIFY EXACT CONNECTION POINT, LINE SIZE, AND MATERIAL.
7. 1/2" HW DOWN IN WALL, TURN PIPING OUT OF WALL AND CONNECT TO HOT WATER DISPENSER WITH SHUTOFF AND FLEXIBLE LINE.
8. 1/2" CW DOWN IN WALL, TURN PIPING OUT OF WALL AND CONNECT TO UNDER COUNTER ICE MACHINE WITH SHUTOFF AND FLEXIBLE LINE.
9. REMOVE EXISTING WATER HEATER AND CONNECT NEW 3/4" HW INTO EXISTING HOT WATER LINES SERVING EXISTING MOP SINK AND LAVATORY. FIELD VERIFY EXACT CONNECTION POINTS, LINE SIZES, AND MATERIAL.




307B SW Market St., Lee's Summit, Missouri 64083 | 816.249.2270 | www.collinswebb.com

Pura Vida - Summit Fair
910R NW Blue Pkwy
Lee's Summit, MO 64086

COPYRIGHT © BY
COLLINS WEBB
ARCHITECTURE, LLC

REVISION DATES:

1 CITY COMMENTS 05/30/2023

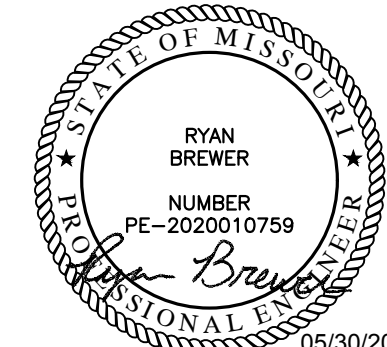

PROFESSIONAL SEAL

P201

ISSUE DATE: 16 MAY 2023
COLLINS WEBB #: 22102

PLUMBING PLANS

CONSTRUCTION DOCUMENTS