




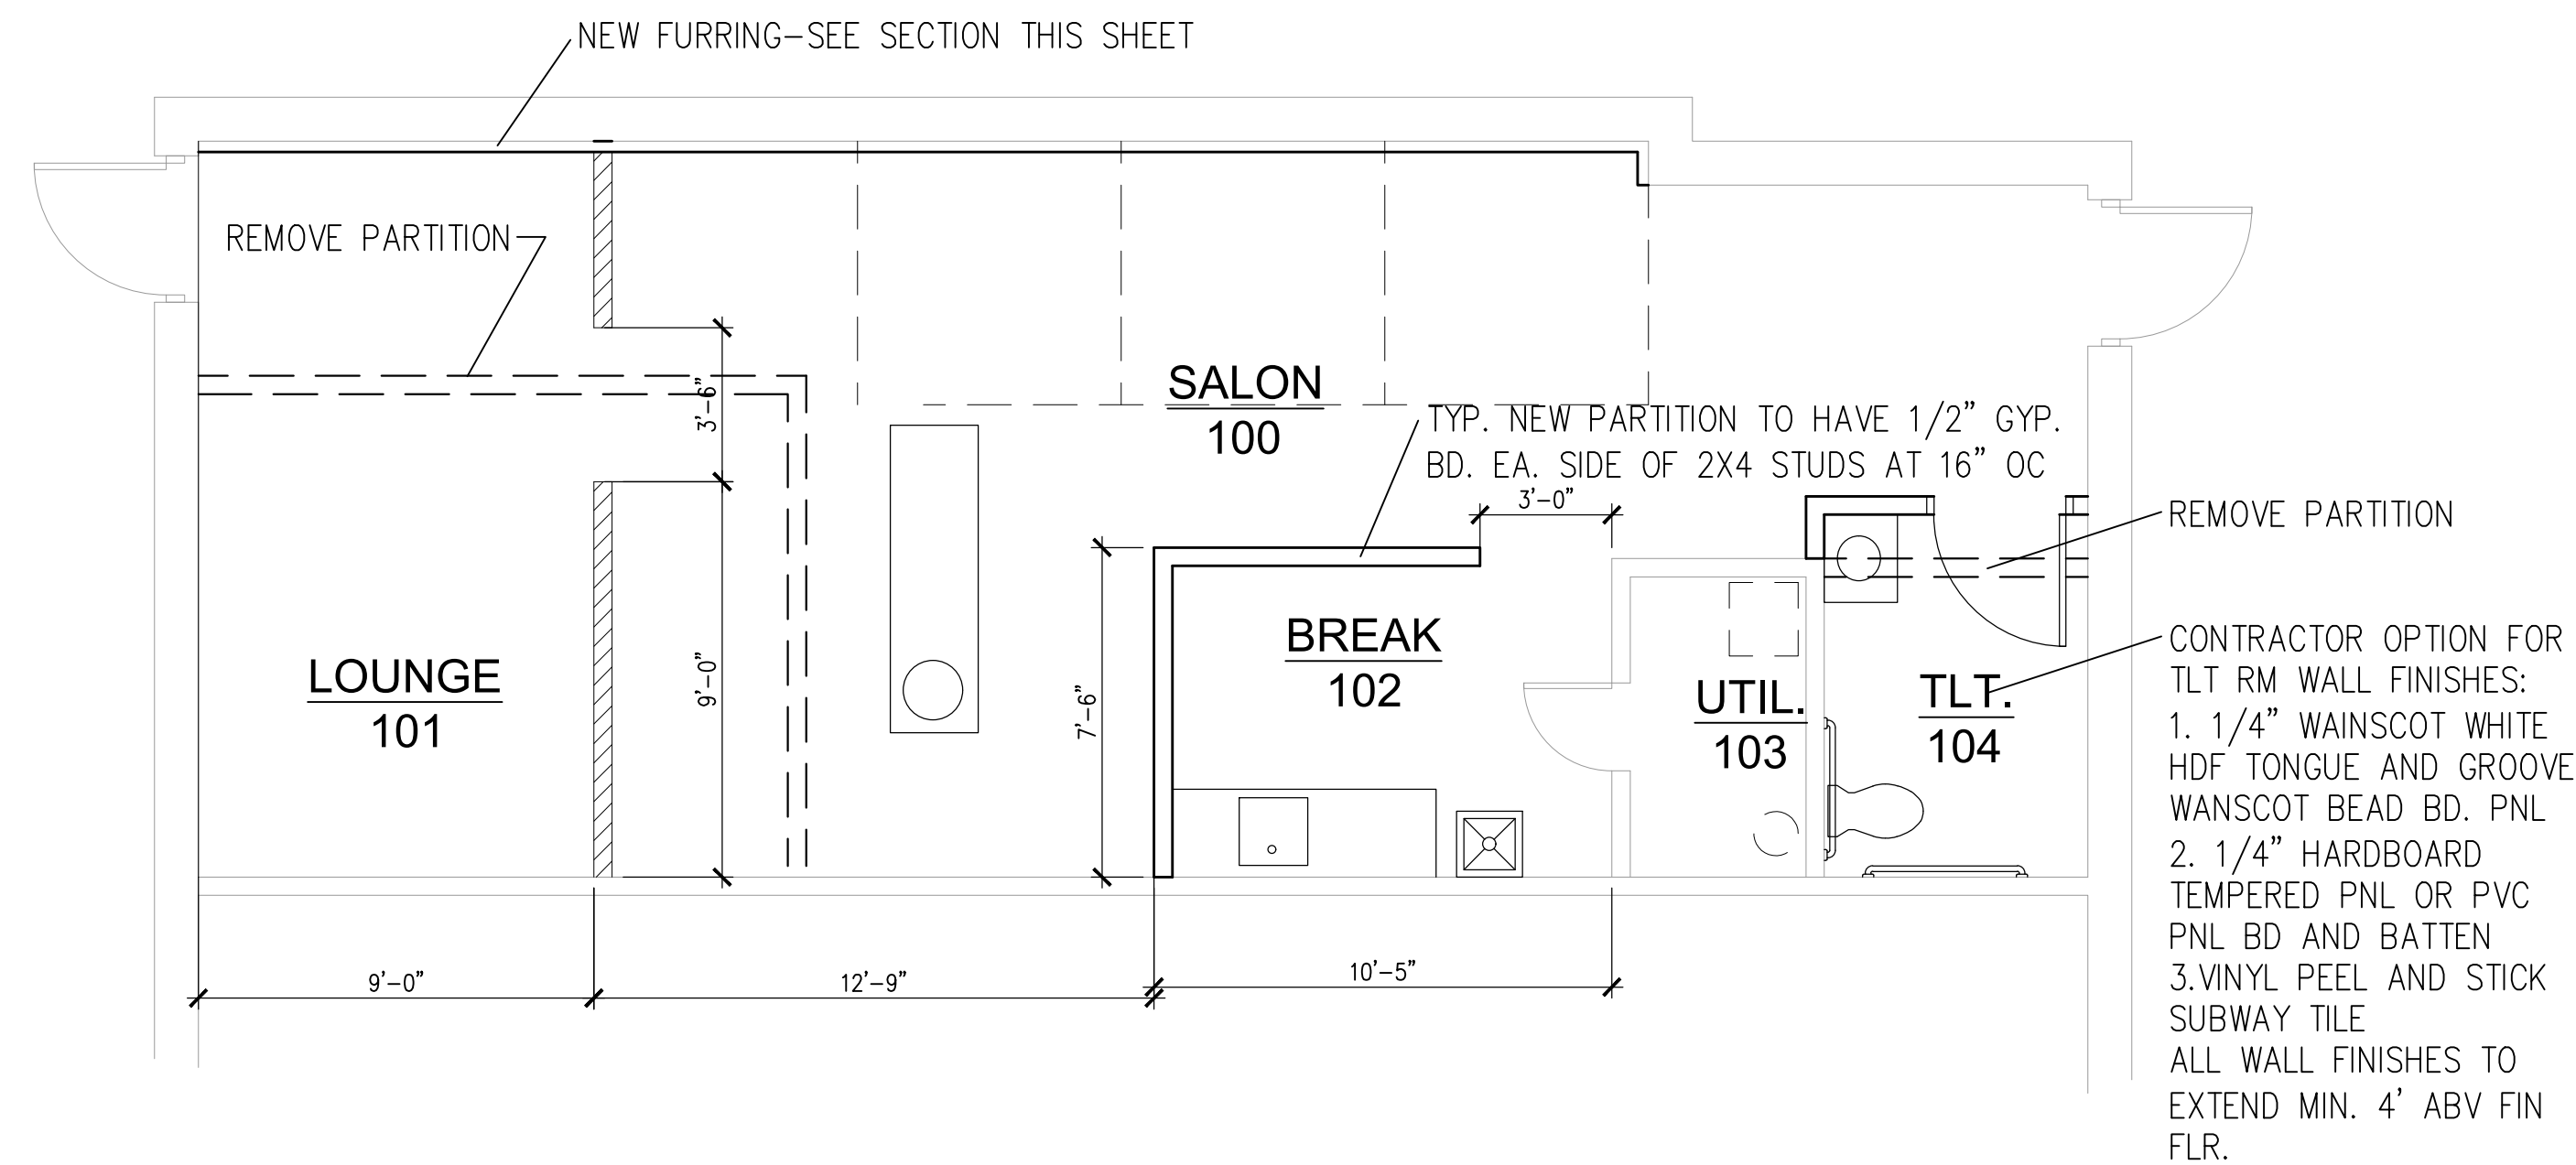


FLOOR PLAN
 SCALE: 1/4" = 1'-0"

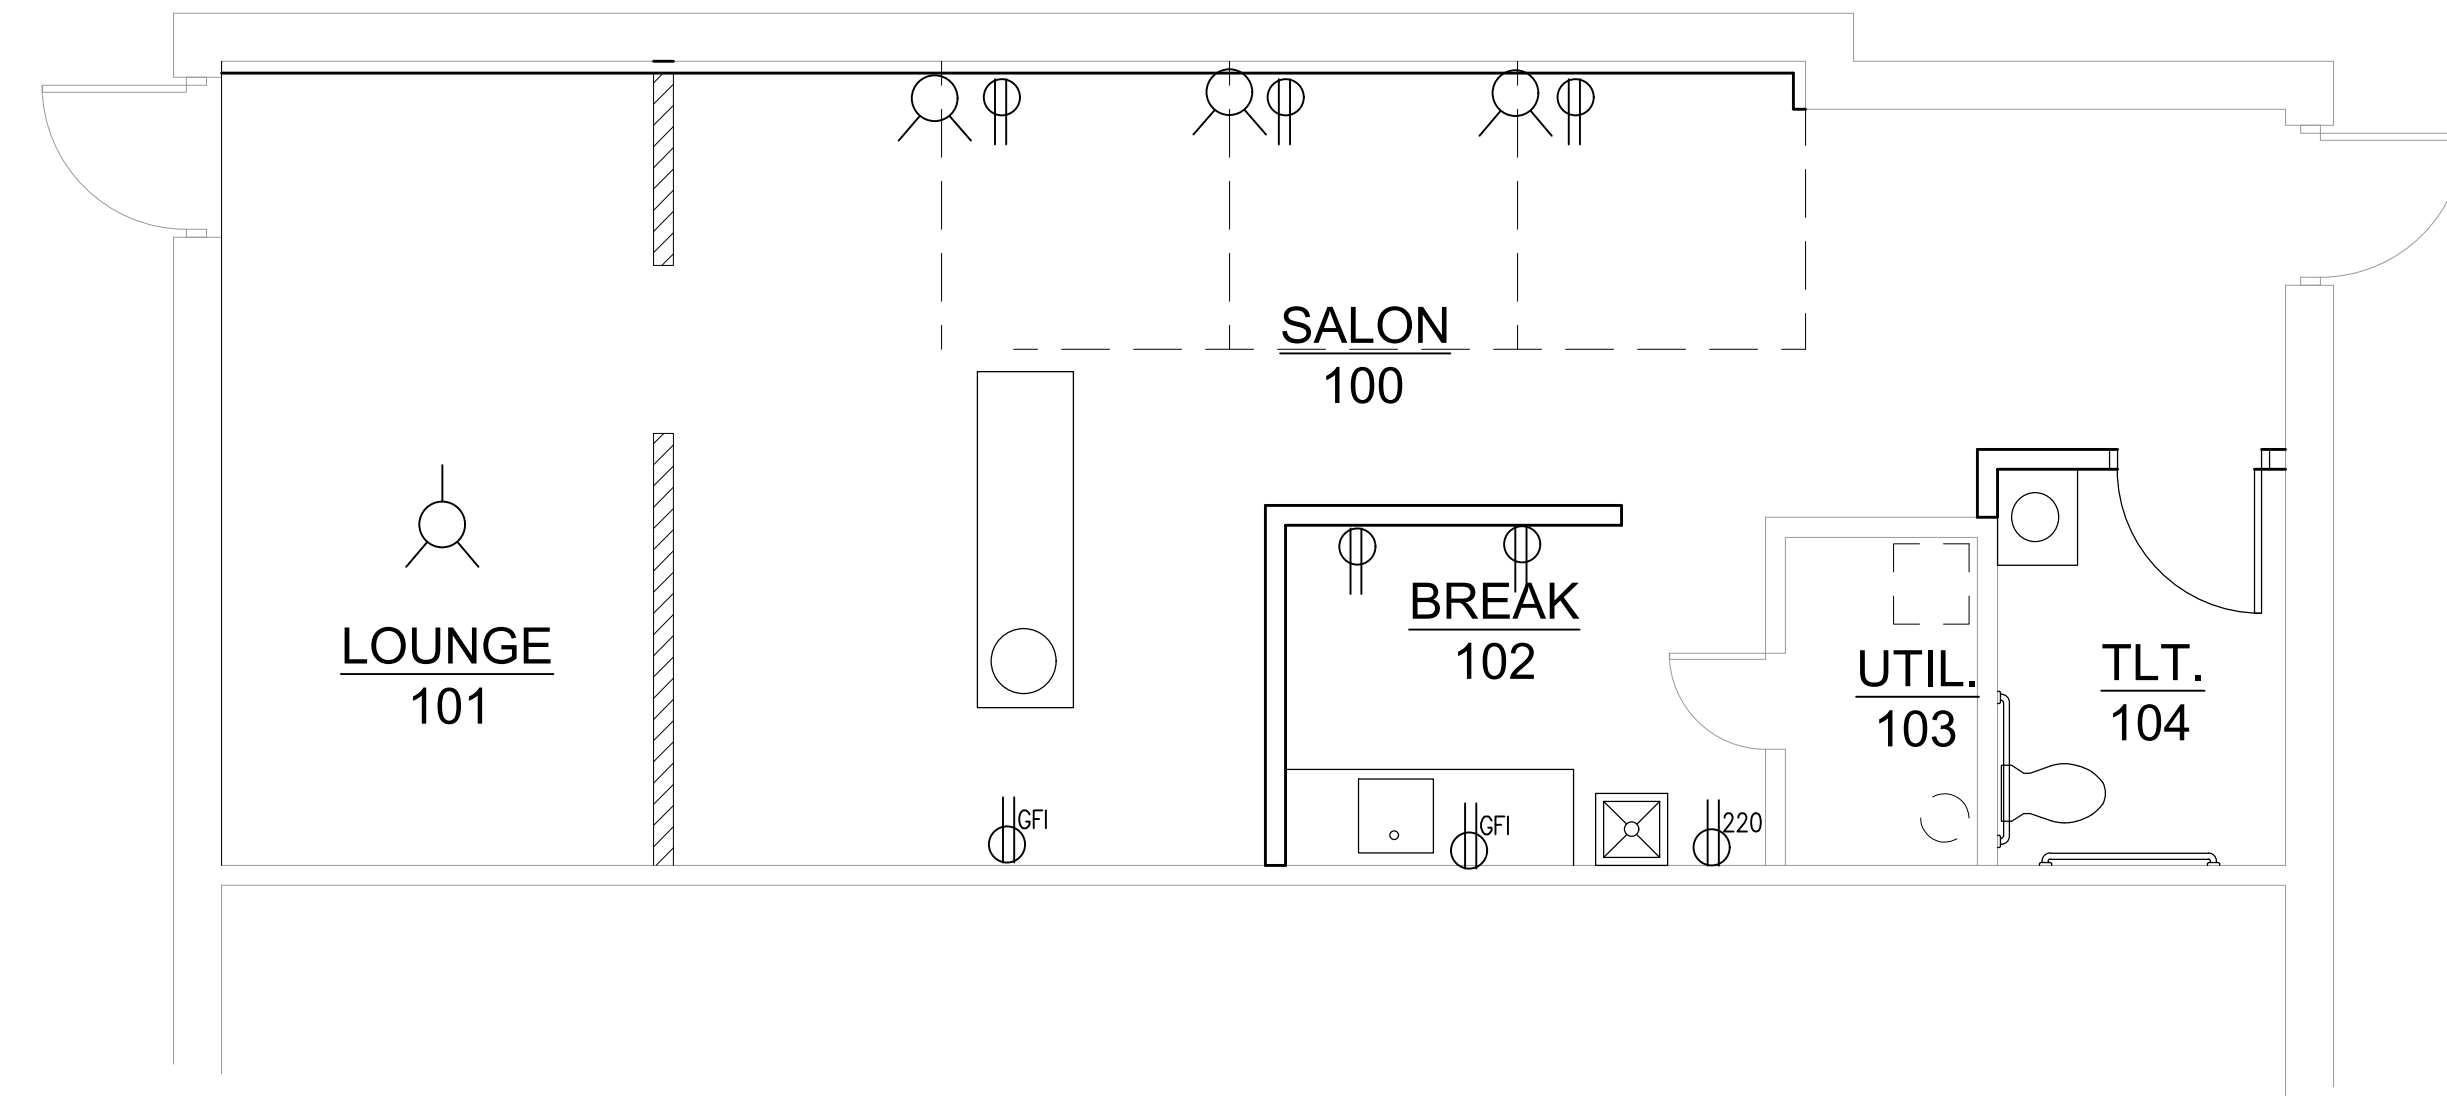

ELEC. PLAN
 SCALE: 1/4" = 1'-0"

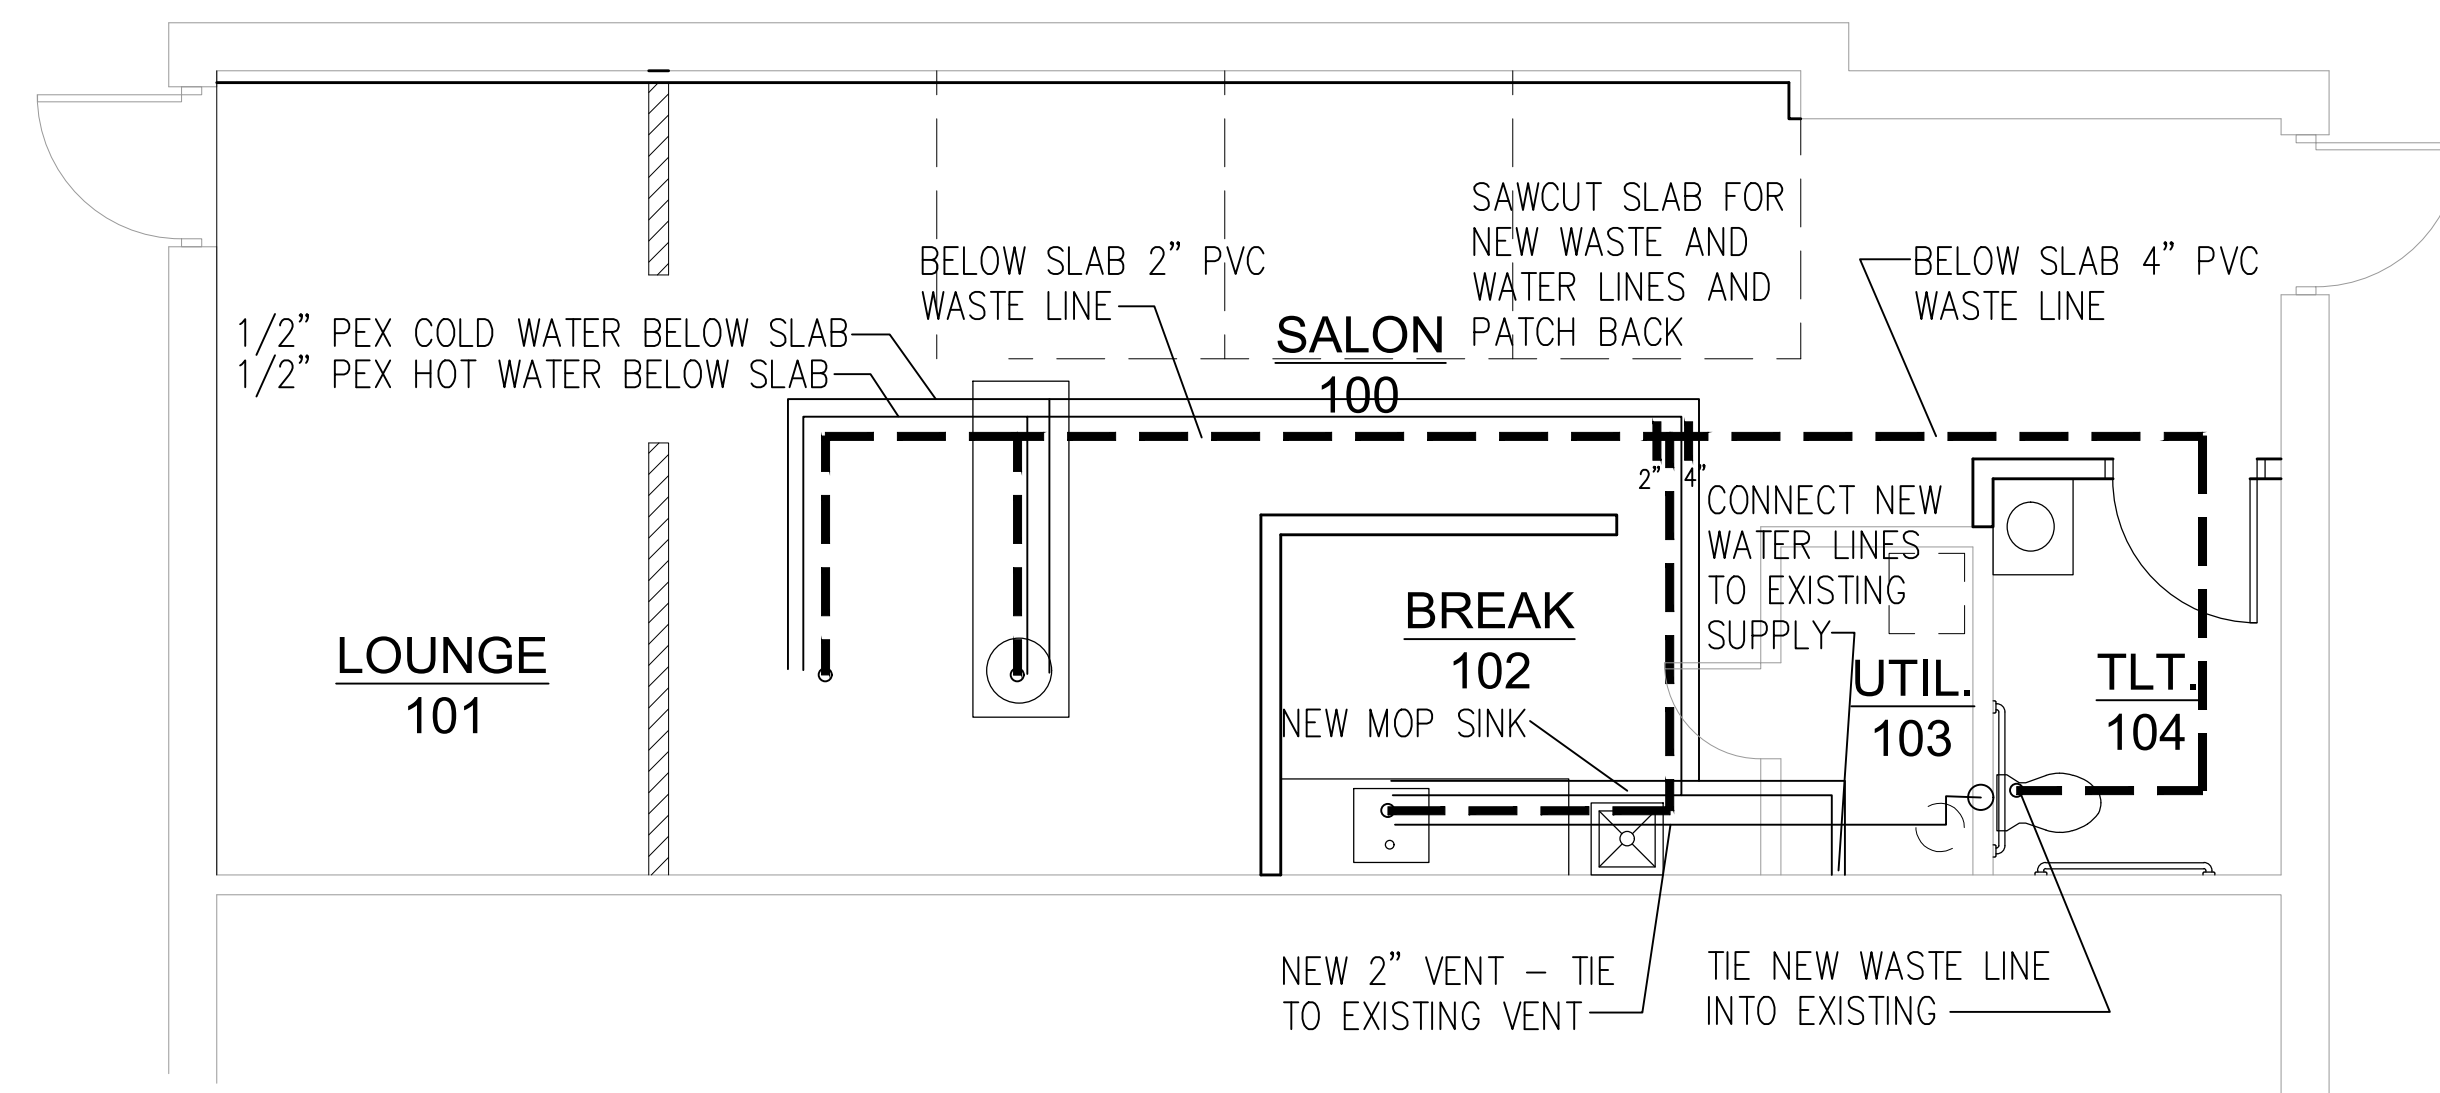

PLUMBING PLAN
 SCALE: 1/4" = 1'-0"

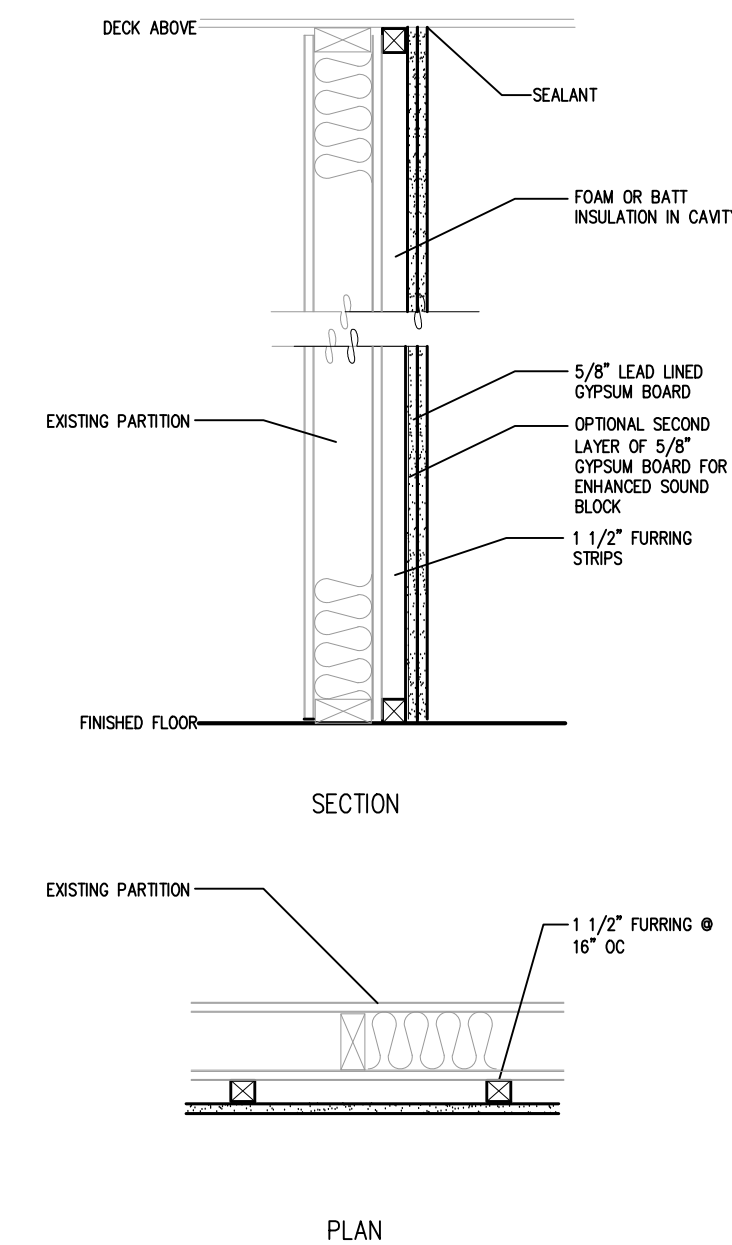

FURRING SECTION
 SCALE: 1" = 1'-0"

LEGEND	
	EXISTING TO BE REMOVED
	NEW PARTITION
	EXISTING PARTITION TO REMAIN
	NEW SCREEN WALL
	NEW DOOR
	WALL SCONCE LIGHT FIXTURE
	ELECTRICAL OUTLET
	OVERHEAD LIGHT FIXTURE
	WASTE LINE
	WATER LINE

TENANT REMODELING
HAIR BY SHELSEA
618 SW 3RD STREET, LEE'S SUMMIT MO

DATE: 7/18/23

SHEET 1 OF 1