


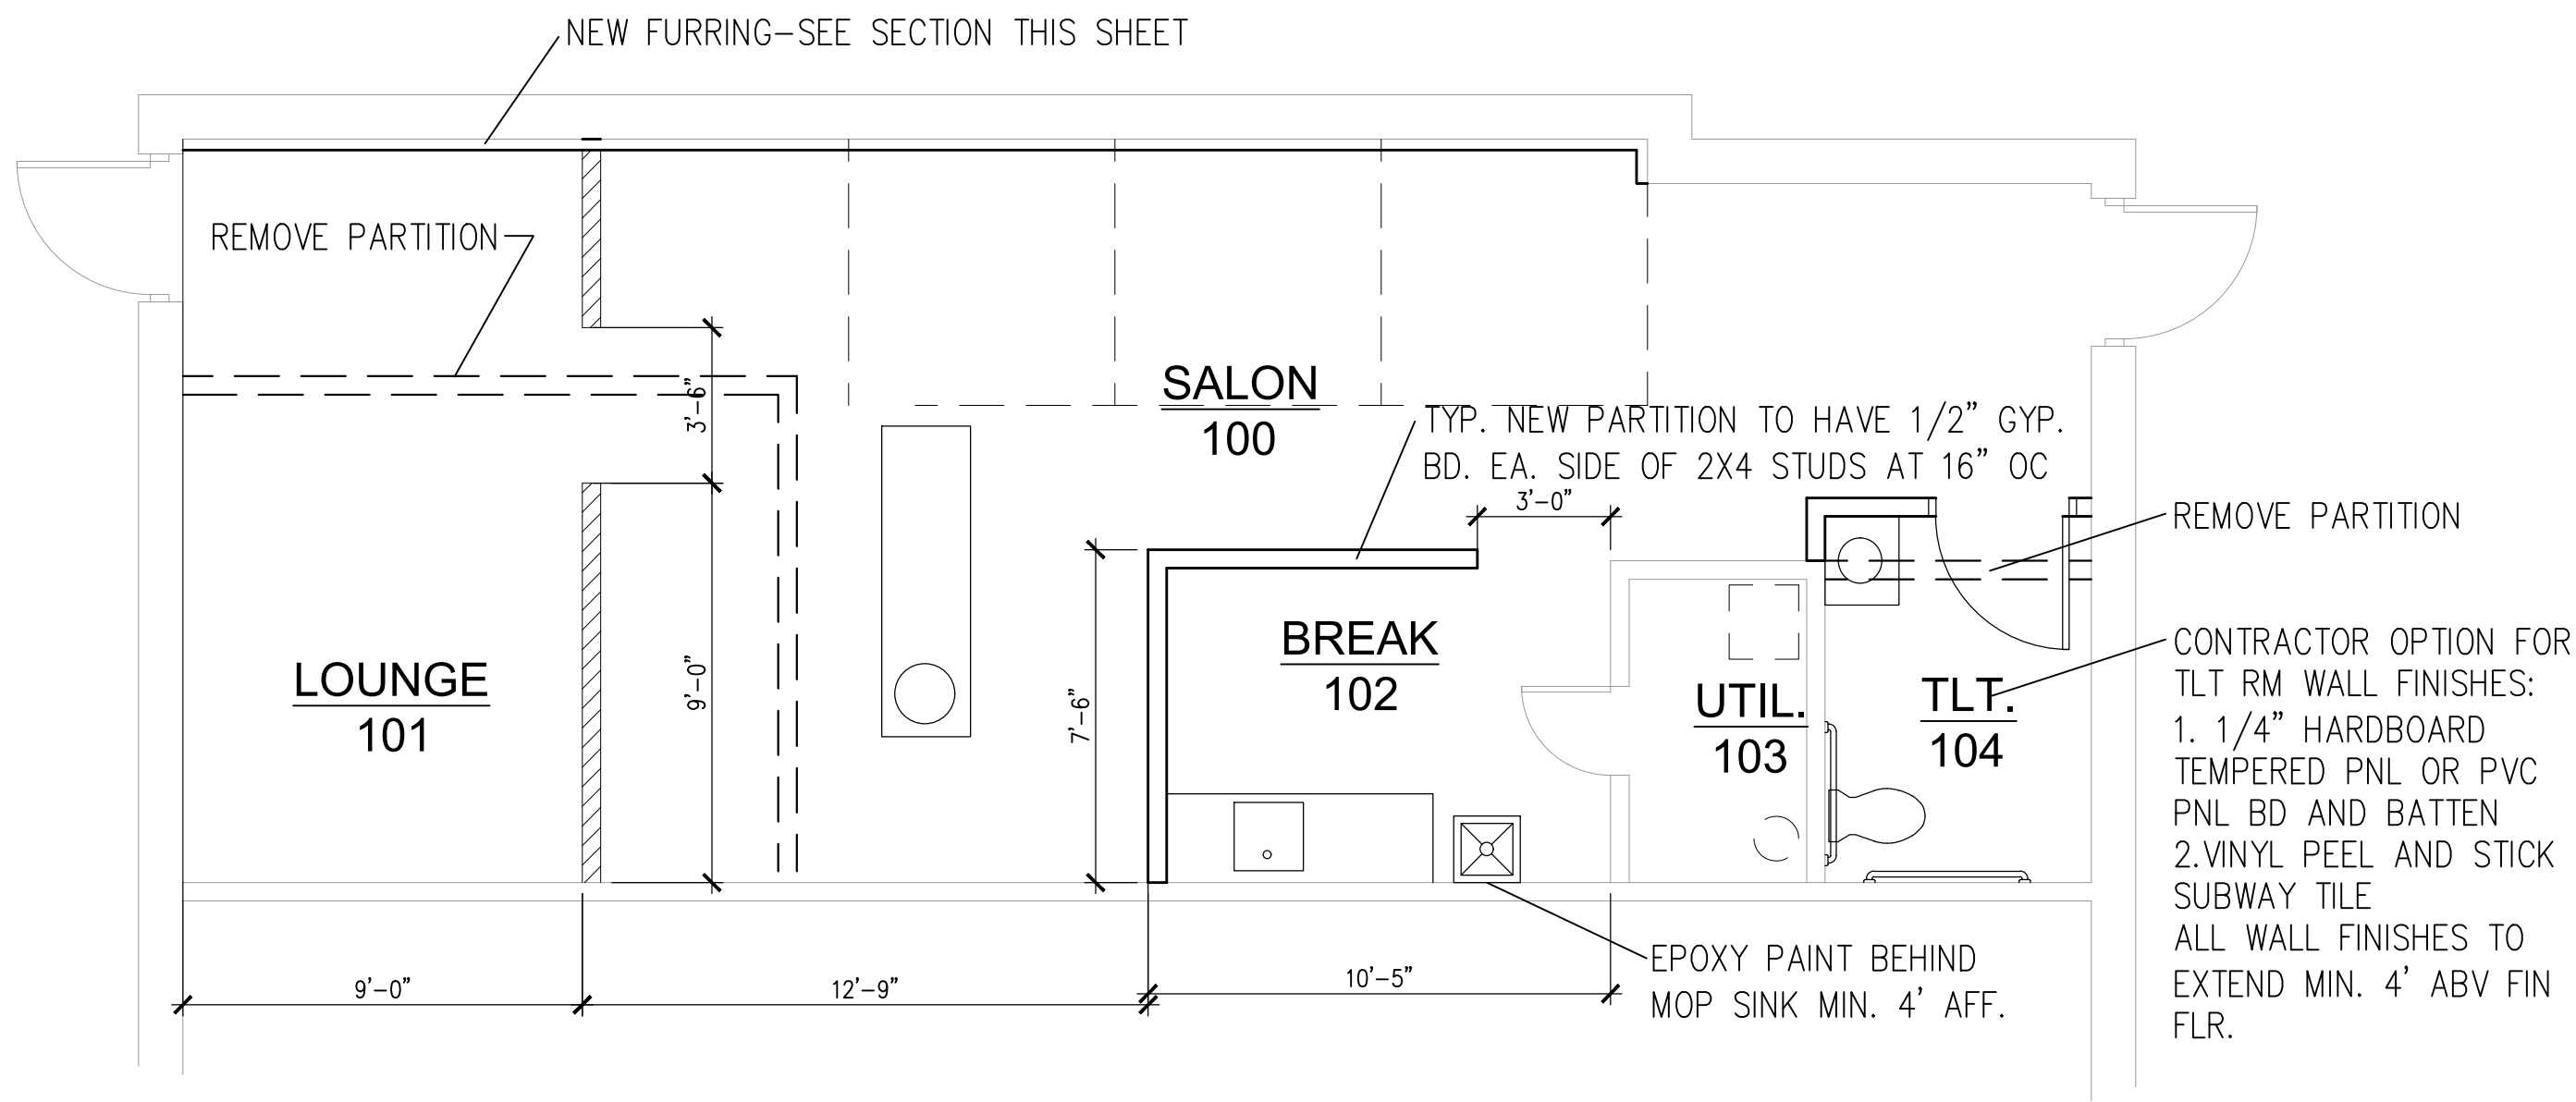
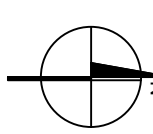


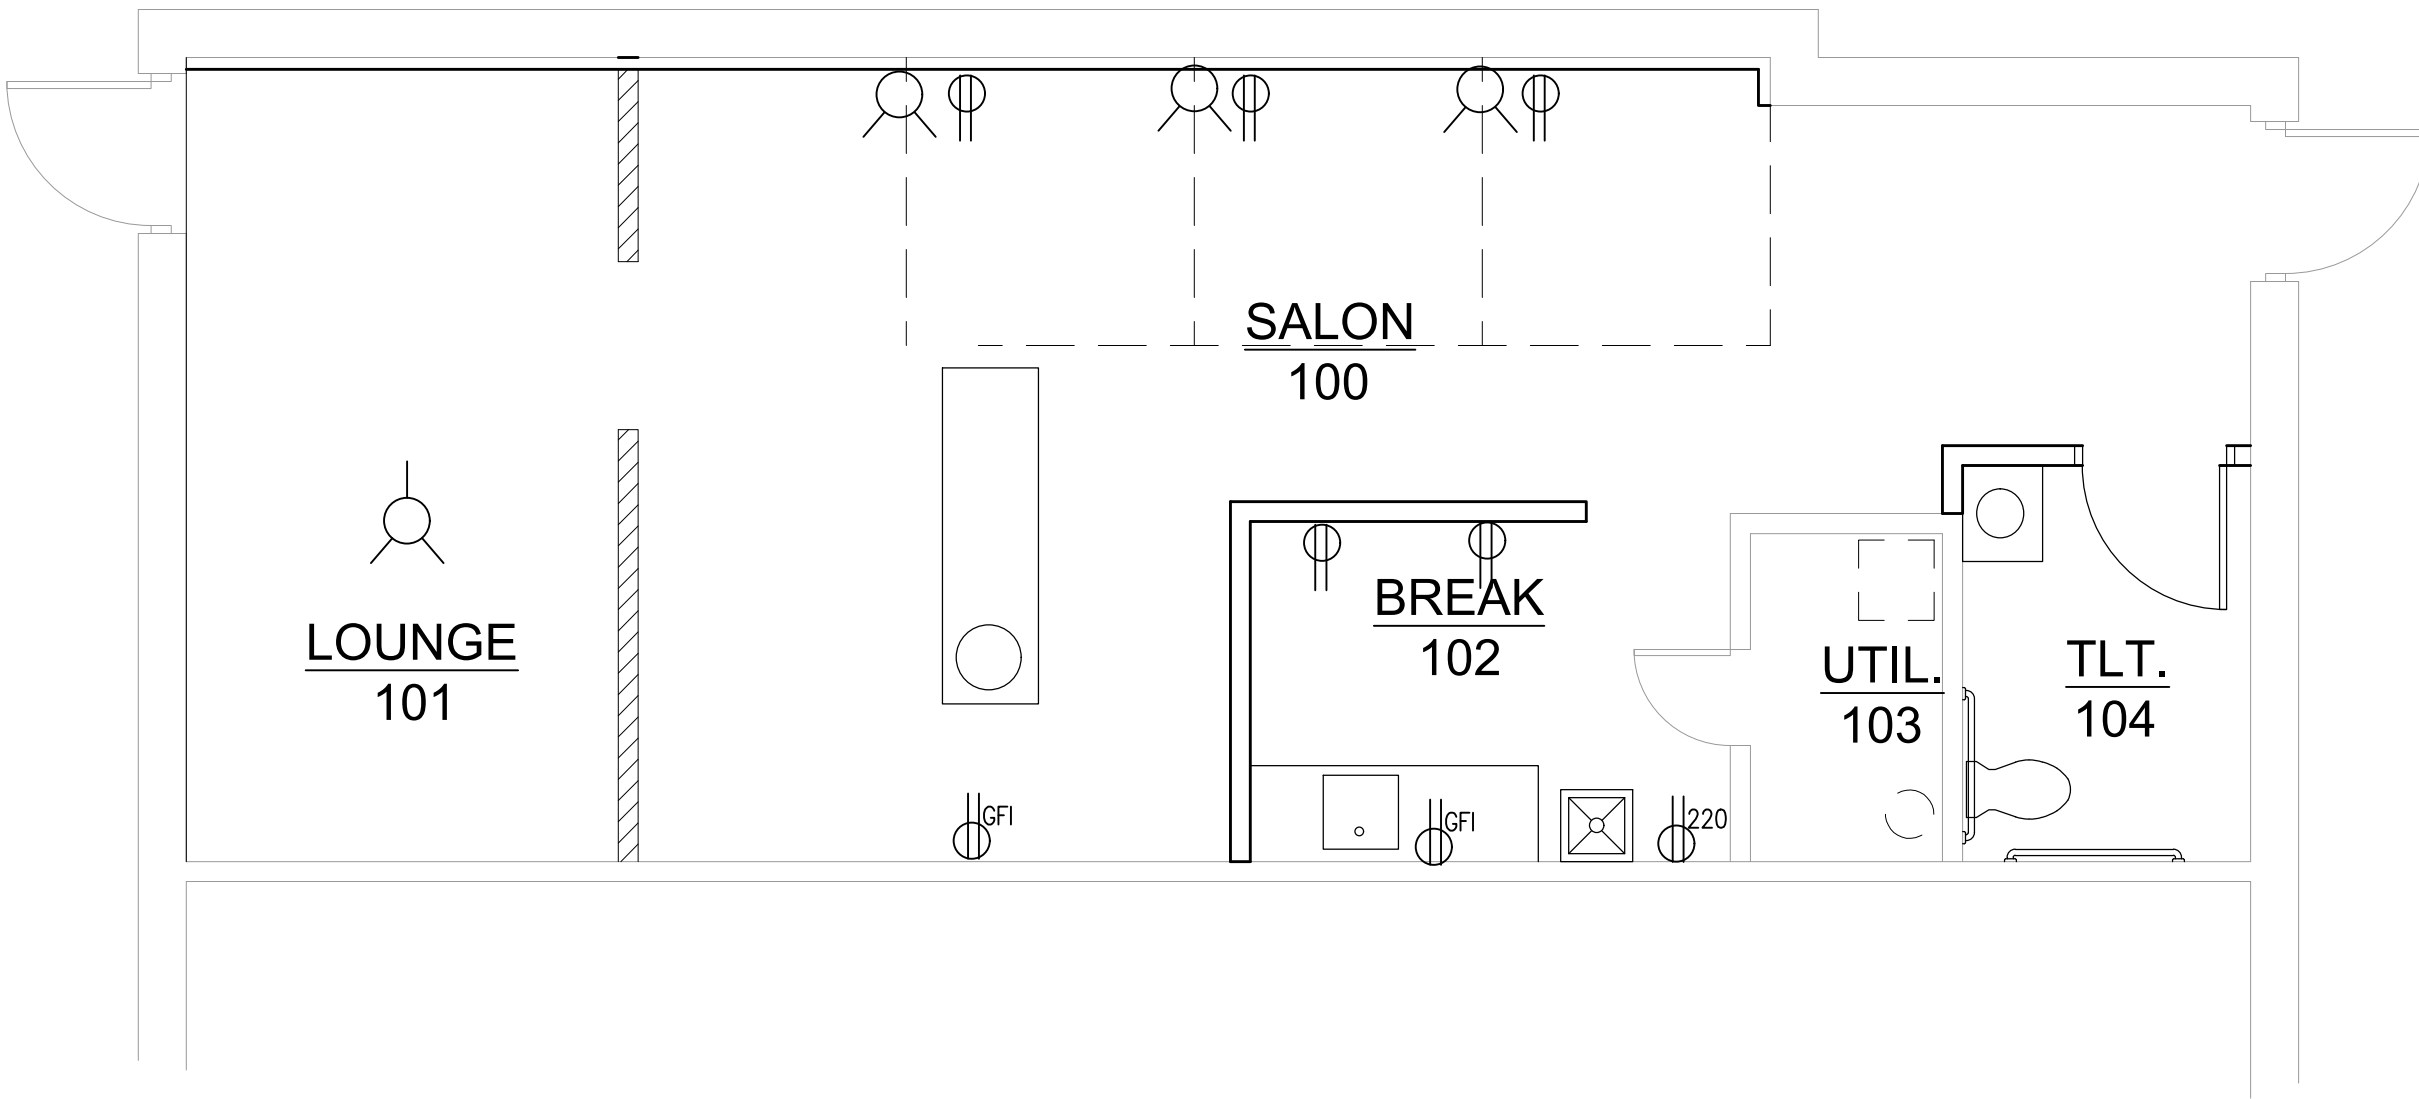



 **FLOOR PLAN**
SCALE: 1/4" = 1'-0"

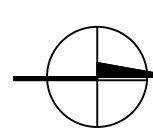

 **ELEC. PLAN**
SCALE: 1/4" = 1'-0"

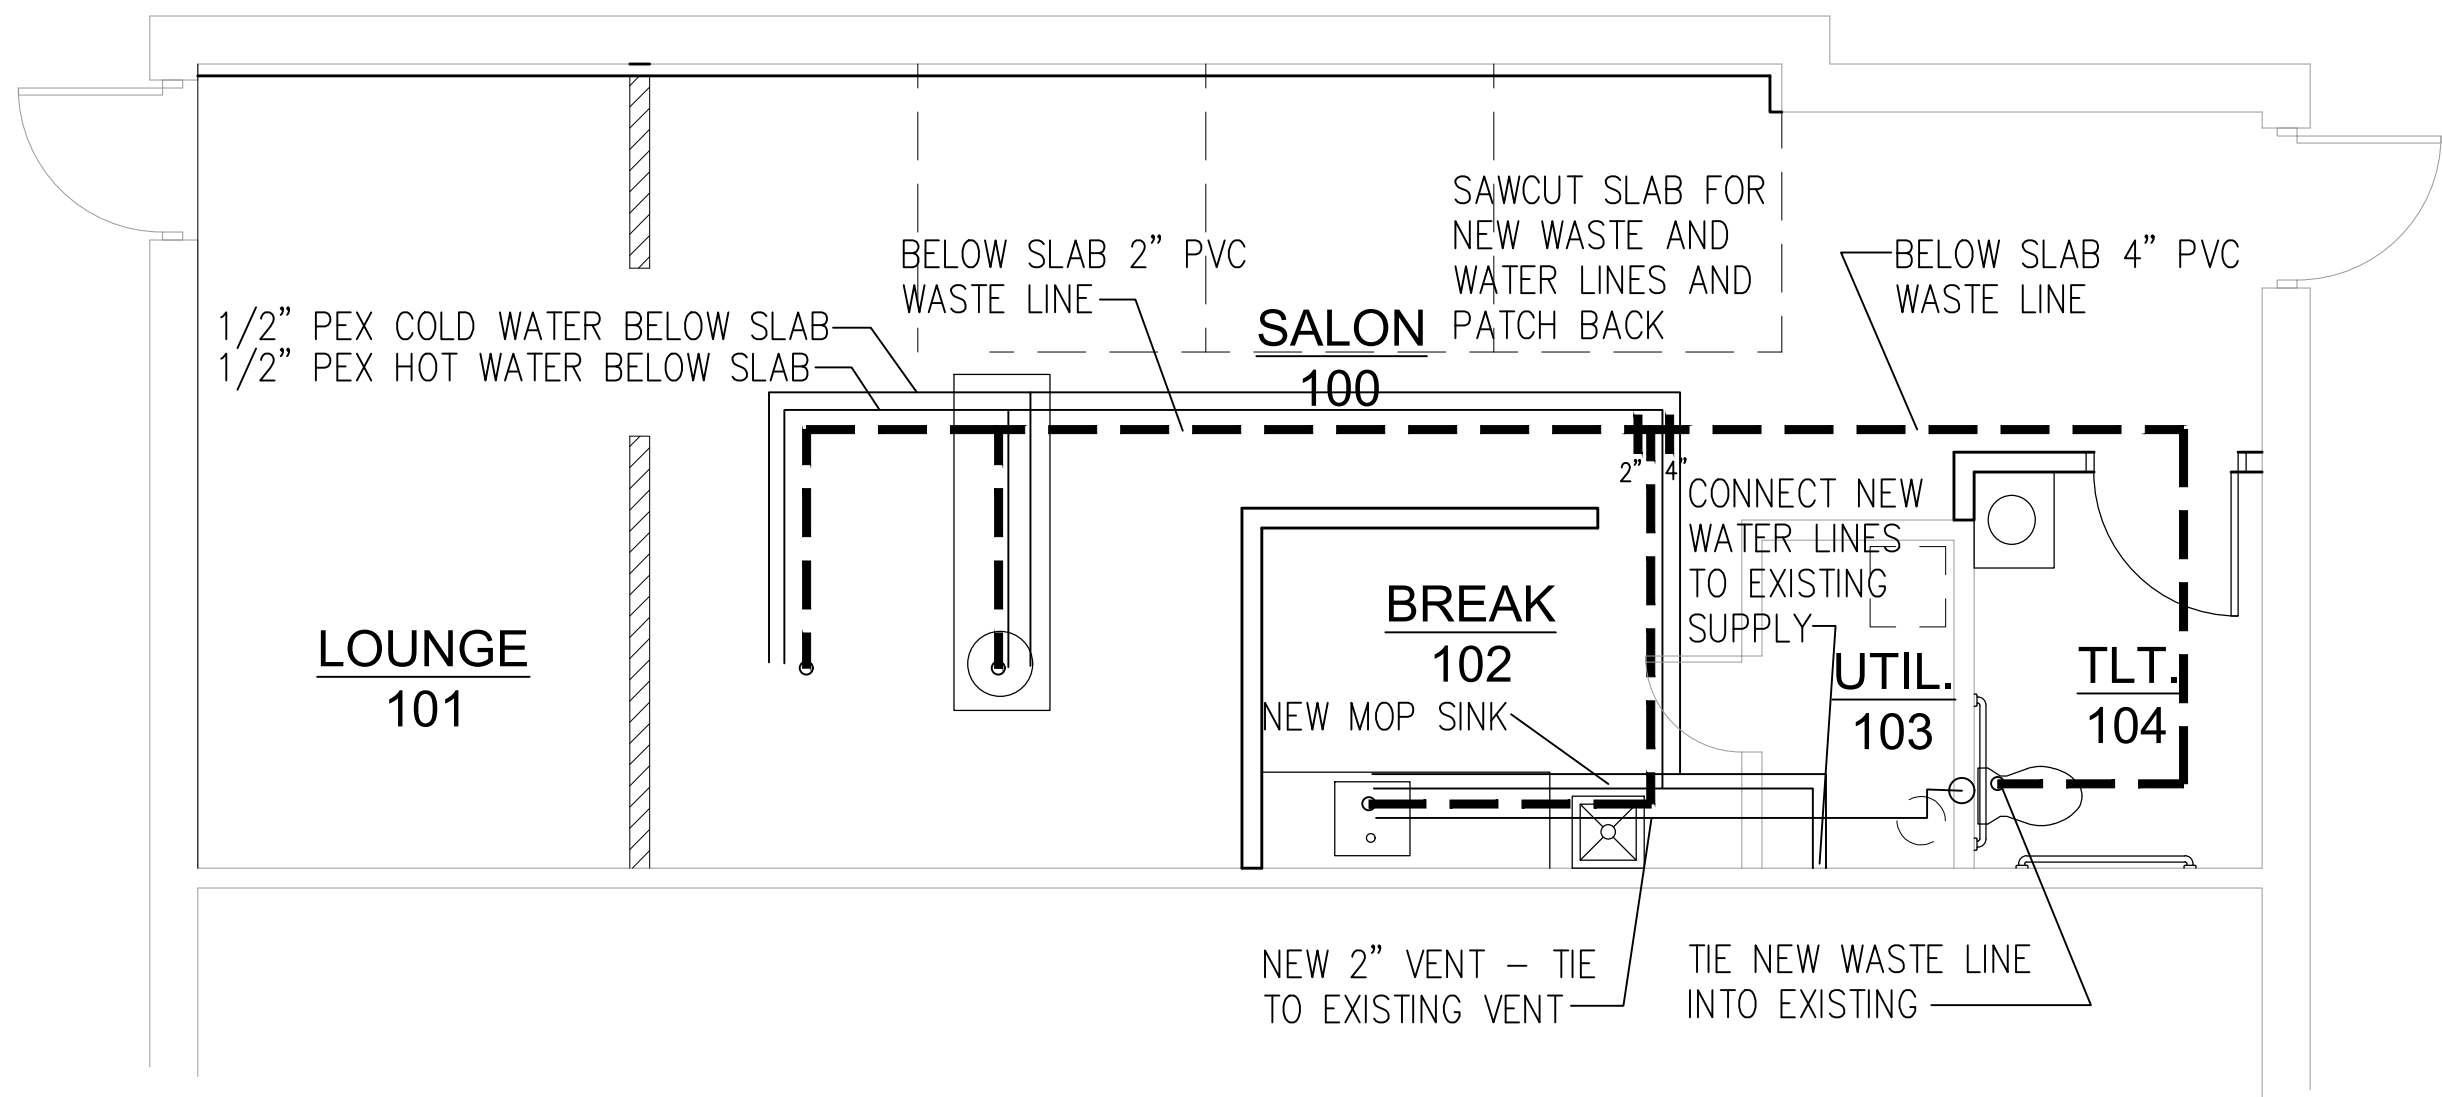

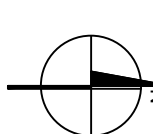 **PLUMBING PLAN**
SCALE: 1/4" = 1'-0"

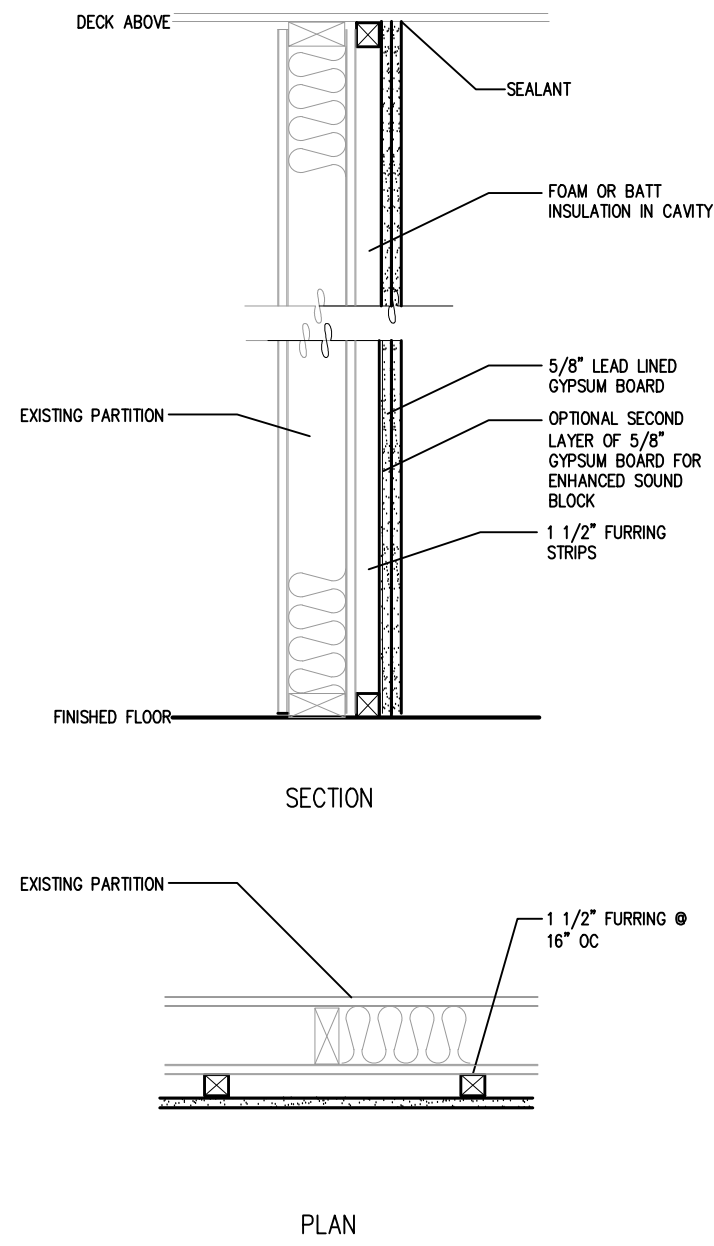

FURRING SECTION
SCALE: 1" = 1'-0"

LEGEND

- == EXISTING TO BE REMOVED
- === NEW PARTITION
- EXISTING PARTITION TO REMAIN
- /// NEW SCREEN WALL
- NEW DOOR
- WALL SCONCE LIGHT FIXTURE
- ELECTRICAL OUTLET
- OVERHEAD LIGHT FIXTURE
- WASTE LINE
- WATER LINE

TENANT REMODELING
HAIR BY SHELSEA
618 SW 3RD STREET, LEE'S SUMMIT MO

DATE: 7/25/23

SHEET 1 OF 1