




FIRE ALARM SYMBOL LEGEND	
 -FIRE ALARM CONTROL PANEL	 -HEAT DETECTOR
 -NAC PANEL	 -WATER FLOW MONITOR MODULE
 -CEILING MOUNT HORN-STROBE	 -TAMPER MONITOR MODULE
 -CEILING MOUNT STROBE	 - RETURN DUCT DETECTOR
 -PHOTO ELECTRIC SMOKE DETECTOR.	 -RELAY
 -PULL-STATION	 -END OF LINE RESISTOR
 -Remote Annunciator	 - MONITOR MODULE

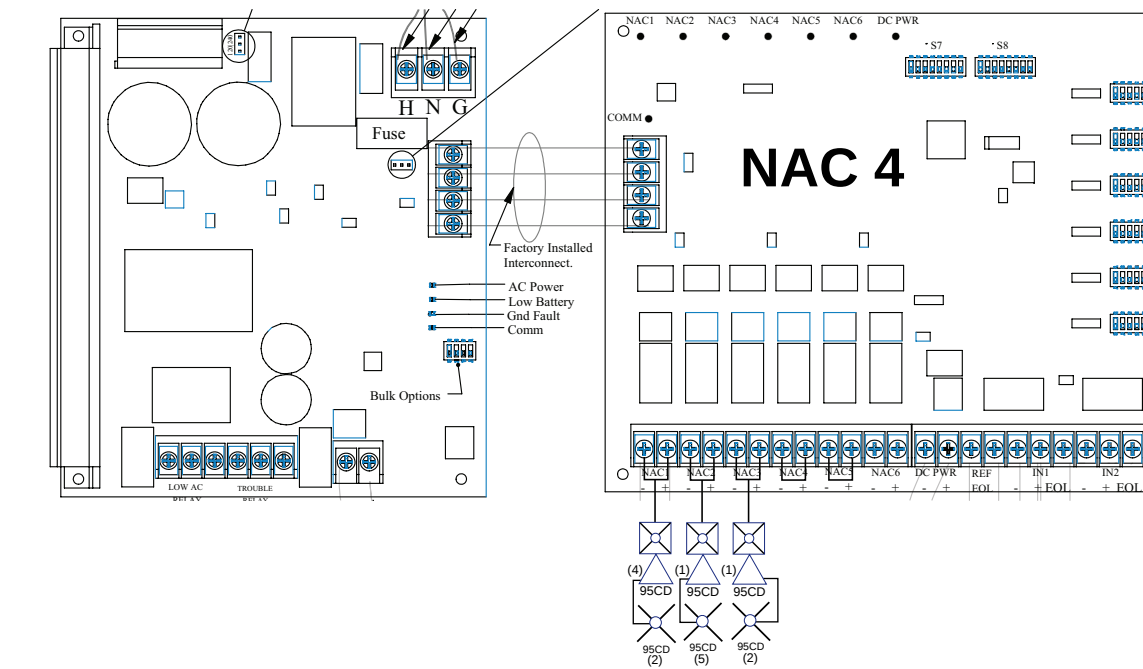




P:816-918-9917
E:tanastasio@apsinstallations.com
Spring Hill, Ks




CURRAN
ARCHITECTURE

5719 LAWTON LOOP E. DR. #212
INDIANAPOLIS, IN 46216
O :: 317 . 288 . 0681
F :: 317 . 288 . 0753

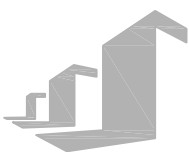

SCANNELL
PROPERTIES

CERTIFICATION

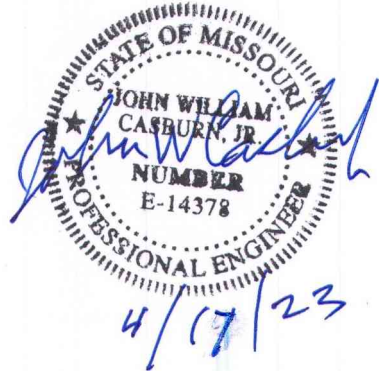

THIS DRAWING AND THE IDEAS, DESIGNS AND CONCEPTS CONTAINED HEREIN ARE THE EXCLUSIVE INTELLECTUAL PROPERTY OF CURRAN ARCHITECTURE AND ARE NOT TO BE USED OR REPRODUCED, WHOLE OR IN PART, WITHOUT THE WRITTEN CONSENT OF CURRAN ARCHITECTURE.
© COPYRIGHT 2021, CURRAN ARCHITECTURE

PROJECT INFORMATION


LEE'S SUMMIT LOGISTICS
BUILDING A LOT I

NW CORNER OF
NE TUDOR RD & MAIN ST
LEE'S SUMMIT, MO 64086

ISSUE DATES

PERMIT SET	02.18.22
CITY COMMENTS	10.17.22

210300

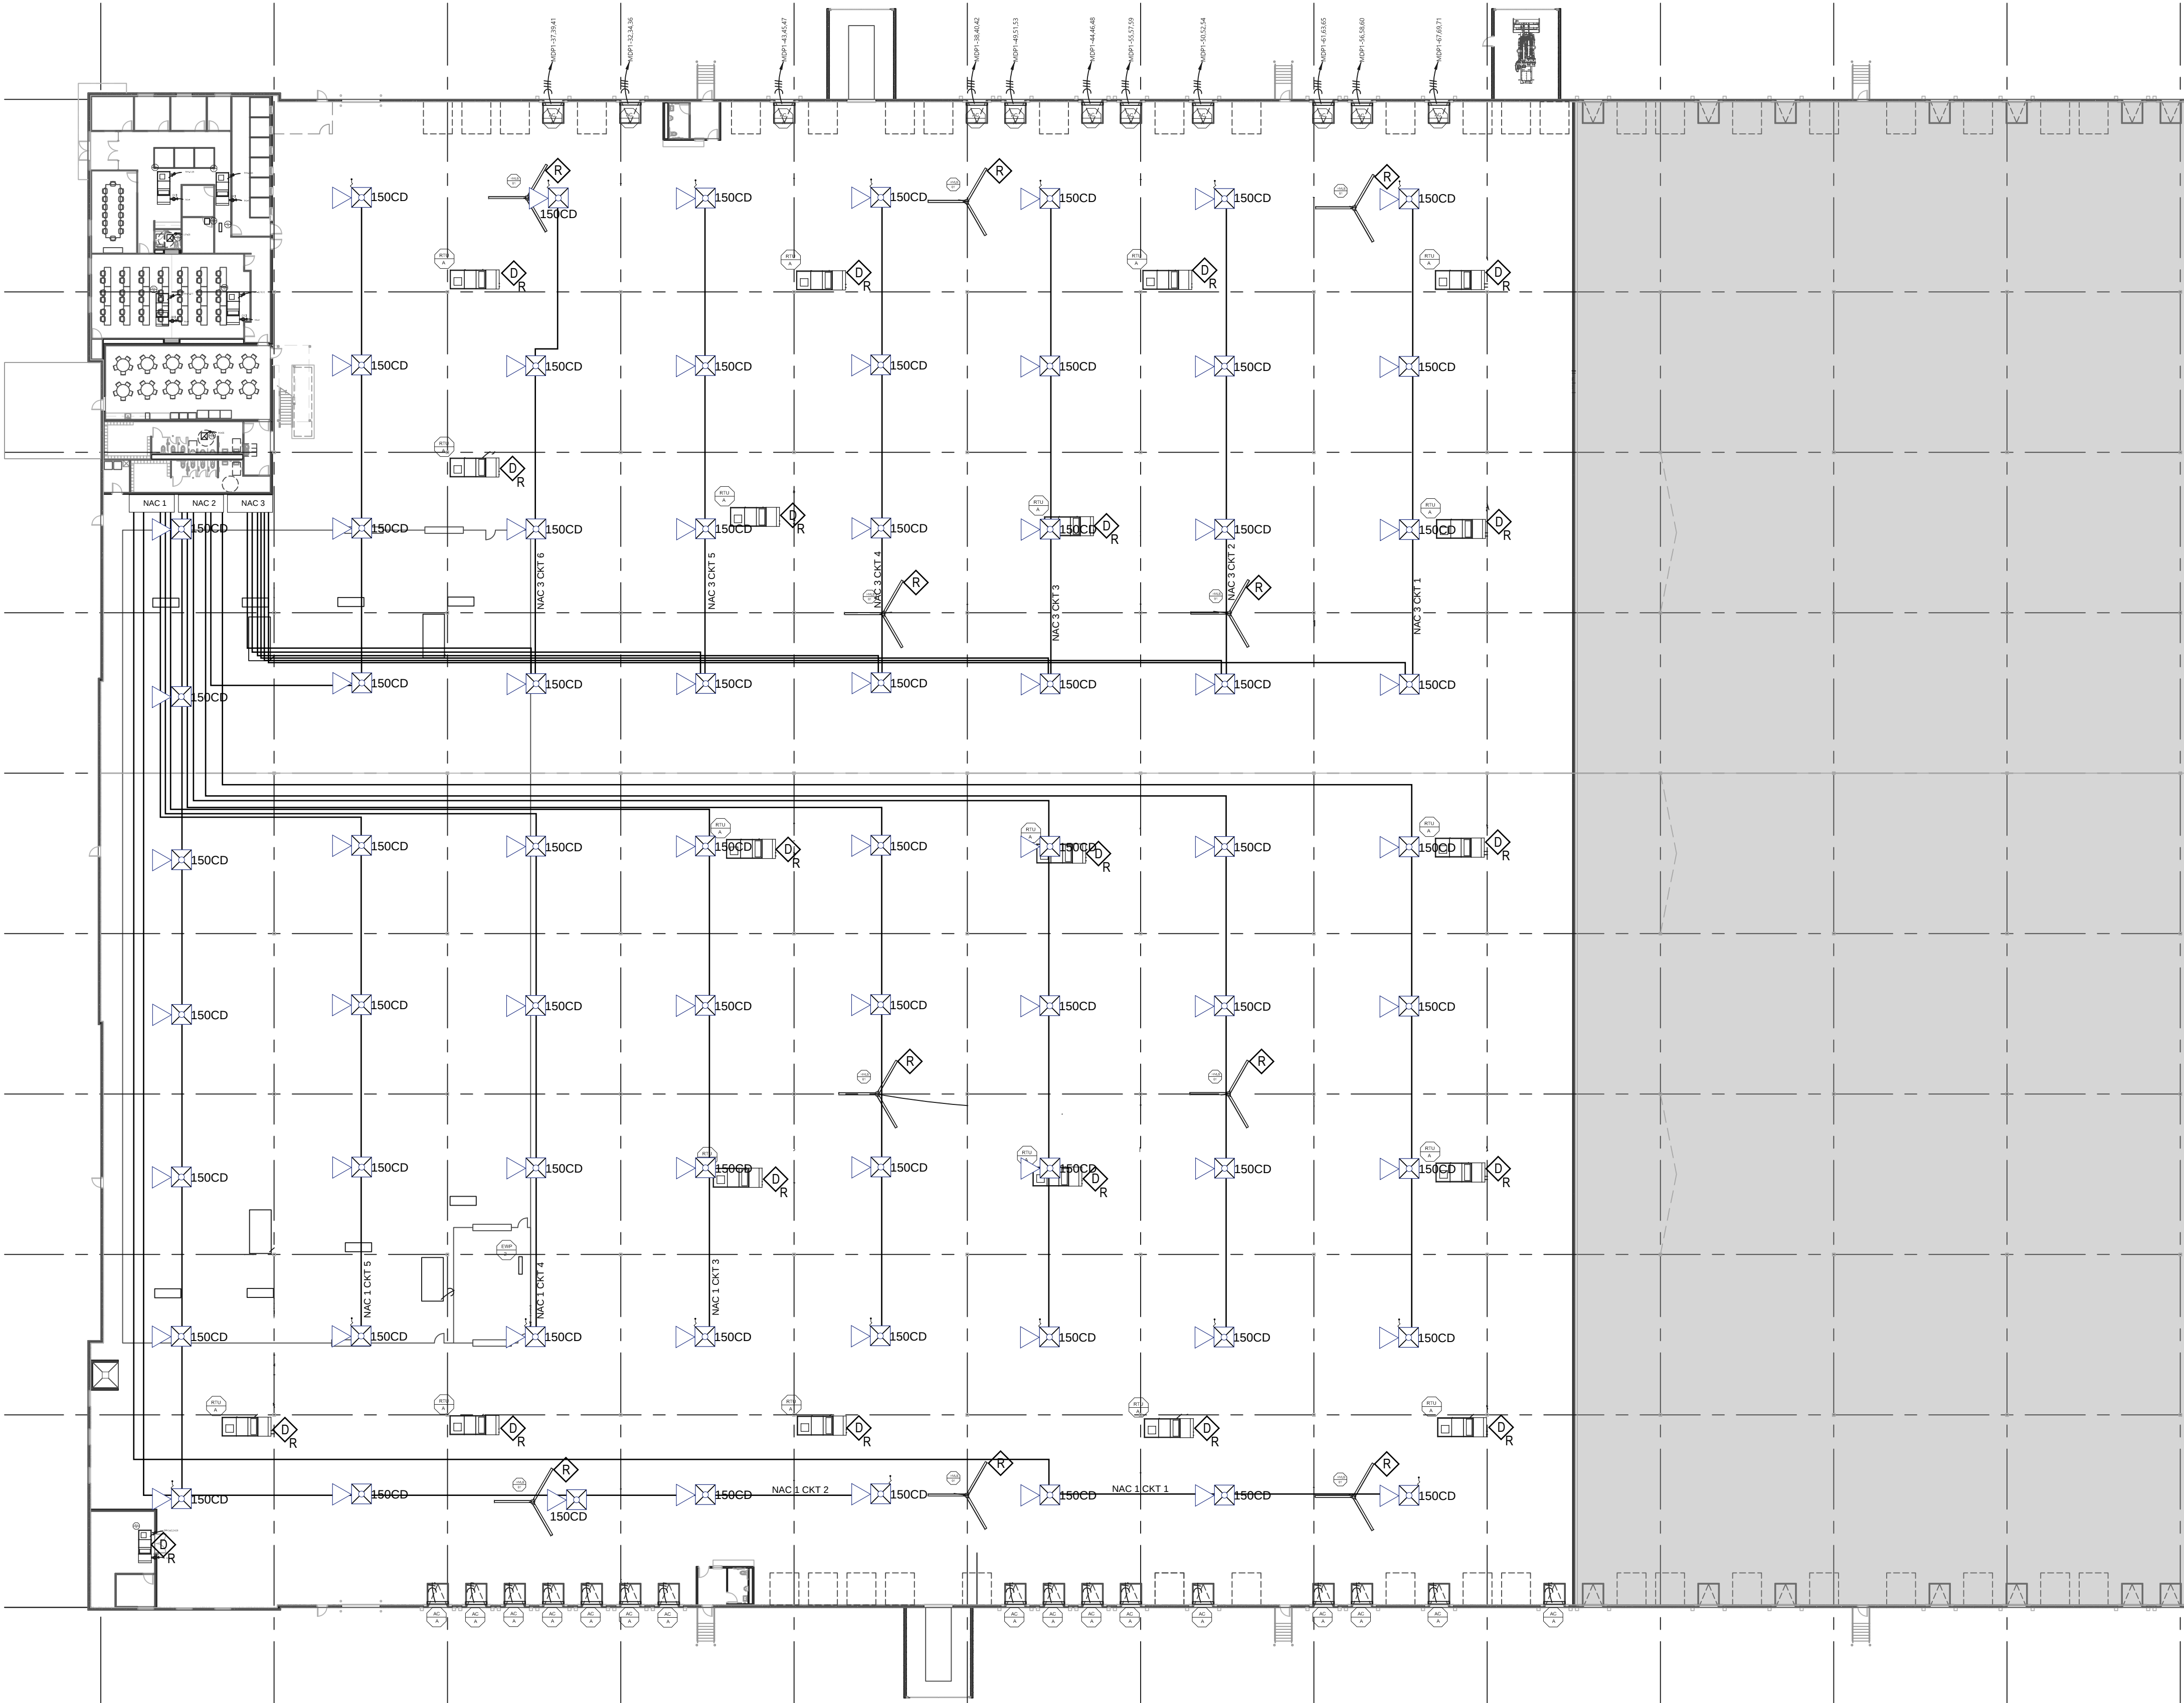

1 WAREHOUSE FIRE ALARM LAYOUT
scale: 1"=30'



FA.01