



10.13.2023

a bathroom remodel for
Lee's Summit Subaru
2101 NE Independence Ave. Lee's Summit, MO 64064

copyright:

The following documents are the sole property of davidson architecture & engineering, llc for the specific purpose of construction of said building. These documents are considered confidential and subject to davidson architecture & engineering llc's copyright protection. Neither receipt nor possession transfers any rights to reproduce these documents or any part thereof. Any re-use of these documents without the express written permission of davidson architecture & engineering, llc is strictly prohibited and shall confer no liability to davidson architecture & engineering, llc.

disclaimer:

These documents are accurate to the best of davidson architecture & engineering, llc's professional knowledge. In the event a discrepancy in the documents is encountered, it is the responsibility of that party to notify davidson architecture & engineering in a timely manner, for corrections and/or explanation of the documents.

project description:

Interior bathroom remodel to increase size of bathrooms at existing car dealership.

Project Address: 2101 NE Independence Ave
Lee's Summit, Missouri 64064

Building Inspection Department: Development Services
220 SE Green
Lee's Summit, MO 64063
Phone: (816) 969-1200

code synopsis:

Adopted Code:
The enclosed documents are reviewed utilizing the currently adopted code for the city of Lee's Summit, Missouri

- 2018 International Building Code
- 2018 International Existing Building Code
- 2018 International Plumbing Code
- 2018 International Mechanical Code
- 2018 International Fuel Gas Code
- 2017 National Electrical Code
- 2018 International Energy Conservation Code
- 2018 International Swimming Pool and Spa Code
- 2018 International Property Maintenance Code
- 2018 International Fire Code
- 2009 Accessible and Usable Buildings and Facilities ICC/ANSI A117.1

Construction Type: II-B (Unprotected, non-combustible)

Automatic Sprinkler System: Yes

Occupancy Classification and Use: S-1 / B

Fire-Resistance Rating Requirements for Building Elements per Table 601

Primary Structural Frame:	0	:
Bearing Walls:		
Exterior	0	
Interior	0	
Nonbearing Walls & Partitions:		
Exterior	0	
Interior	0	
Floor Construction	0	
Roof Construction	0	

sheet index:

coversheet

Architectural

A1.1 Architectural Plans

Plumbing

P0.0 Plumbing Specifications
P1.0 Plumbing Floor Plans
P2.0 Plumbing Riser Plans

Electrical

E1.1 Electrical Notes
E2.1 Electrical Power Plan
E3.1 Electrical Specifications
E3.2 Electrical Specifications

client:

McCall Witt
General Manager,
Lee's Summit Subaru
2101 NE Independence Ave.
Lee's Summit, Missouri 64064

owner:

Bob Balderston
Lee's Summit Subaru
2101 NE Independence Ave.
Lee's Summit, Missouri 64064

architect:

Justin D. Bridges , AIA, LEED AP
Davidson Architecture & Engineering
4301 Indian Creek Parkway
Overland Park, Kansas 66207
p: 913.451.9390 f: 913.451.9391


MEP Engineer:

BC Engineers
5720 Reeder
Shawnee, KS 66203
p: 913.262.1772

KASA Electric LLC
1206 NW Valley Ridge Rd.
Grain Valley, MO 64029
p: 816.228.4886

Partition legend

- [P1]** interior partition (insulated):
3 5/8" metal studs at 16" o.c. with 5/8" gypsum board on both sides to underside of structure with 3 1/2" unfaced batt insulation (R-11). Utilize dens-armour plus at interior side of all bathroom walls. Stud gauge per supplier. Provide slip track at head of wall to accommodate roof / floor movement.
- [P3]** interior partition, furred (insulated):
3 5/8" metal studs at 16" o.c. with 5/8" gypsum board on one side to structure above with 3 1/2" unfaced batt insulation (R-11). Stud gauge per supplier.
- [P4]** interior partition, furred (non-insulated):
3 5/8" metal studs at 16" o.c. with 5/8" gypsum board on one side to 6" above ceiling. Stud gauge per supplier.
- [P5]** insulated double stud plumbing partition:
double 3-5/8" metal studs @ 16" o.c. (stagger studs in opposite wall) with 5/8" DensArmor Plus on each side for a total assembly width per plan to underside of structure above. Install 3 1/2" unfaced sound attenuation insulation in both walls. Stud gauge per supplier.
- * Wet Wall Note: Utilize DensArmor Plus in all plumbing wet walls and all walls adjacent to plumbing walls or where anticipated to be in contact with moisture.
- * Wall Height Note: Utilize 3-5/8" metal studs at 16" o.c. to an un-braced height of 13'-8", at heights to 26'-0" use 6" (20 ga.) studs at 16" o.c. - adjust stud size and spacing for allowable I/240 deflection for 5 psf wind load. Verify stud gauge with supplier.

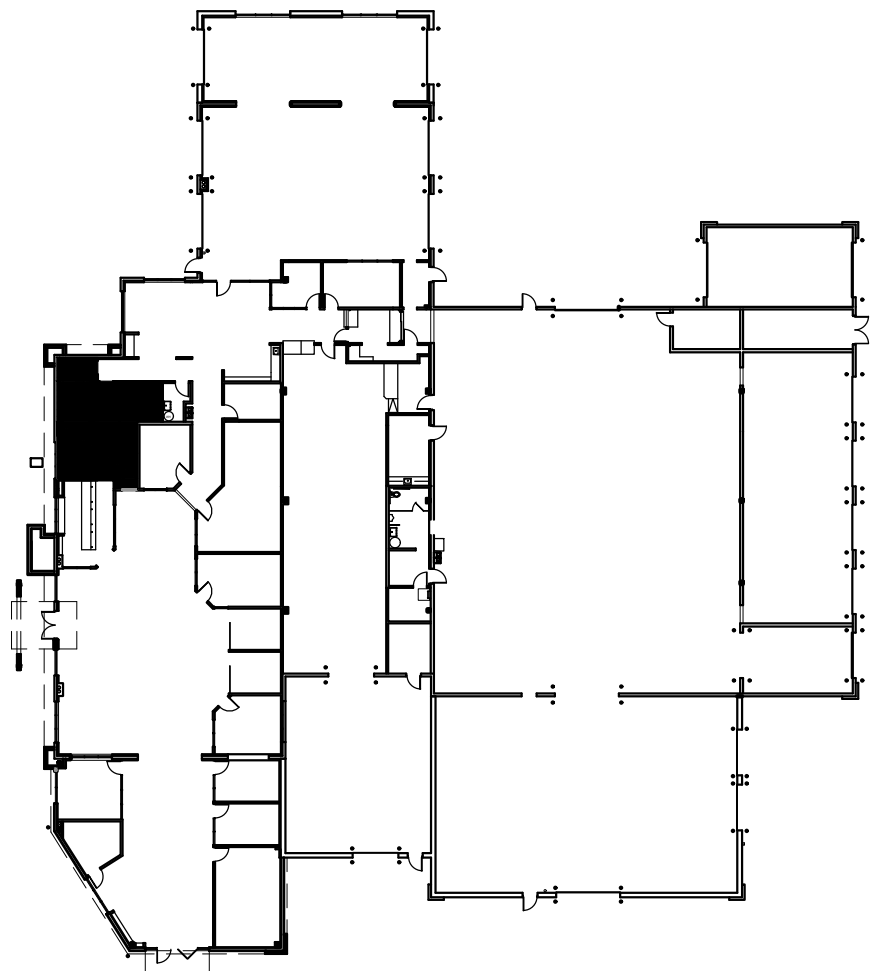

7 Building Key Plan

scale: NTS



Keyed Construction Notes:

Walls & Doors

- 1.1 Infill wall with similar construction; mud, tape and coat to smooth; paint wall from inside corner to outside corner full height to match existing paint color.
- 1.2 Fur out wall over existing window, window shall be prepared to be enclosed.

General Finish Notes

GENERAL NOTES:

- a. Each material specified for application on the entire project shall be from the same dye lot.
- b. All surfaces shall be cleaned and conditioned to receive new finish as required by product manufacturer.
- c. Surfaces shall be smooth, free from depressions, protrusions, pits, slumps, streaks, flashing, and variation in texture.
- d. All gyp. bd. shall receive a level 4 finish unless noted otherwise.
- e. Combustible interior finish products shall be provided per the requirement of the International Building Code section 803.4.
- f. Finishes shall be bid as specified or as approved equal only.
- g. Refer to floor plans for floor finish locations.
- h. Contractor shall be responsible for leveling of floor slabs to receive specified finishes.
- i. Contractor shall perform moisture testing as required by flooring / flooring adhesive manufacturer and perform moisture mitigation as necessary to ensure a warrantable installation.
- j. All patterned flooring shall be centered in both directions and generated from center of room outward toward partitions, unless otherwise noted.
- k. Furnish and install crack isolation membrane below all porcelain & ceramic tile.
- l. All floor finish changes shall occur under centerline of door in closed position.
- m. All walls to receive 1 coat primer & 2 coats paint in finish indicated on legend.
- n. All wall mounted mechanical slots or grilles to be painted to match the wall on which they occur.
- o. Align floor & all grout joints.
- p. Provide tile transitions at all restroom walls to floors, on outside bottom corners, and inside corners.

Material Finish Legend

CEILINGS

ACT-1 Acoustical Ceiling Tile: TBD; ; Suspension System: TBD, Color: White

WALLS, PAINT

1. P-1 General Interior Paint : Match existing, Product: Match existing, Color: "TBD"
2. P-2 Door Frame & HM Door Paint: TBD, Product: TBD, Color: "TBD"

FLOORING & BASE

3. CT-1 Ceramic Tile: Louisville Tile, Color: Slay Grey, Size: 18"x18"
4. CT-2 Ceramic Tile (Restroom Walls): Daltile, Color: TBD, Finish: TBD, Installation: Vertical
5. CTB-1 Ceramic Tile Base: TBD, Color: TBD Size: TBD
6. GR-1 Grout: TBD, Color: TBD
7. GR-2 Grout: TBD, Color: TBD
8. TS-5 Transition (Restroom Tile): TBD, Finish: TBD, installation: Wall to floor transition
9. TS-7 Transition (Restroom Tile): TBD, Finish: TBD, Installation: Vertical at outside tile base corners

CASEWORK & DOORS

10. PL-1 (Restroom Partitions): TBD


Reflected Ceiling Notes/Legend:

1. Refer to general notes and specifications for more information.
2. Refer to engineering drawings for electrical fixtures, specifications and details.
3. Refer to engineering drawings for emergency fixture location and specification.
4. Ducted supply/return/exhaust design build by contractor

- ☒ Exhaust
- ☒ Ducted Supply ☐ Ducted Return


Item	Manufacturer	Product Designation	Color	Description
Clothes Hook w/ bumper	TBD	TBD	TBD	Contractor furnished, contractor installed
18" Grab Bar	TBD	TBD	Stainless steel	1 3/4" diameter steel grab bar with peened gripping surface
36" Grab Bar	TBD	TBD	Stainless steel	1 3/4" diameter steel grab bar with peened gripping surface
42" Grab Bar	TBD	TBD	Stainless steel	1 3/4" diameter steel grab bar with peened gripping surface
Mirror	TBD	TBD	N/A	Contractor furnished, contractor installed
Paper Towel	TBD	TBD	TBD	Automatic roll paper towel dispenser w/ electronic sensor; high impact resin housing, tenant furnished, contractor installed
Sanitary Napkin Disposal	TBD	TBD	TBD	Contractor furnished, contractor installed
Soap Dispenser	Sloan	3346089 (ESD-2000-CP)	Polished Chrome	Contractor furnished, contractor installed
Toilet Compartment	TBD	TBD	TBD	Floor mounted, overhead braced, contractor furnished, contractor installed
Toilet Tissue Dispenser	TBD	TBD	TBD	Surface mounted double roll toilet paper dispenser; no controlled delivery. Contractor furnished, contractor installed
Faucet	Sloan	3335060	Polished Chrome	Contractor furnished, contractor installed

Contractor Note: Not all accessories list on the schedule will be utilized on the project; refer to toilet plans for notations and quantities.

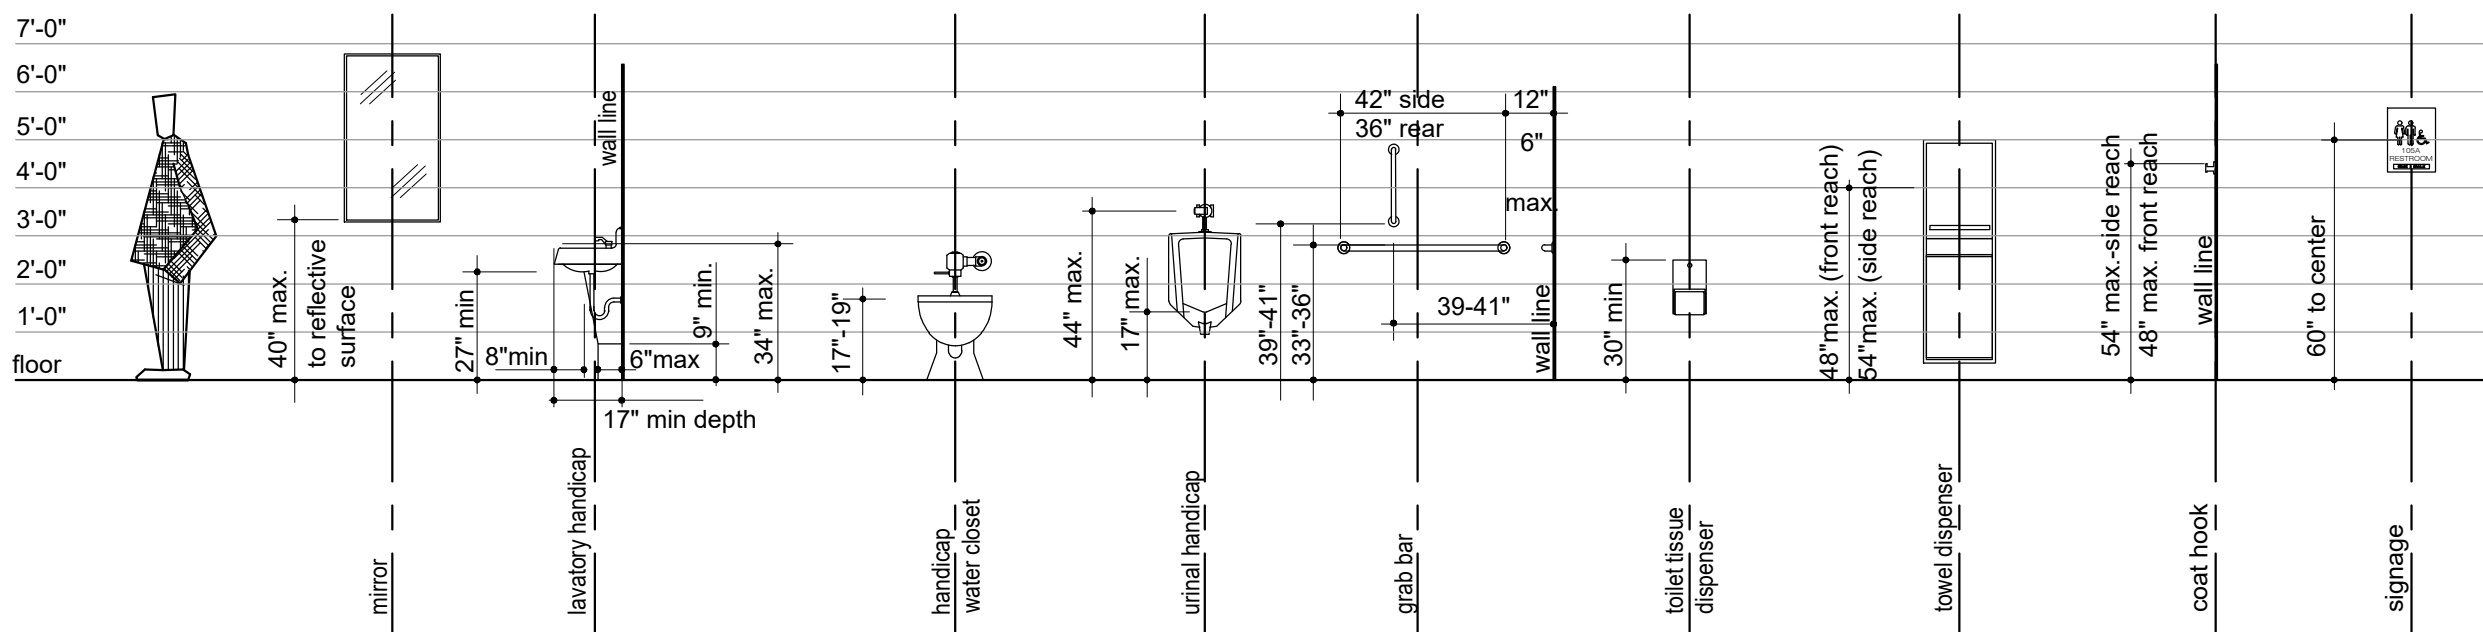


8 ADA Mounting Height Chart

scale: 1/4" = 1'-0"

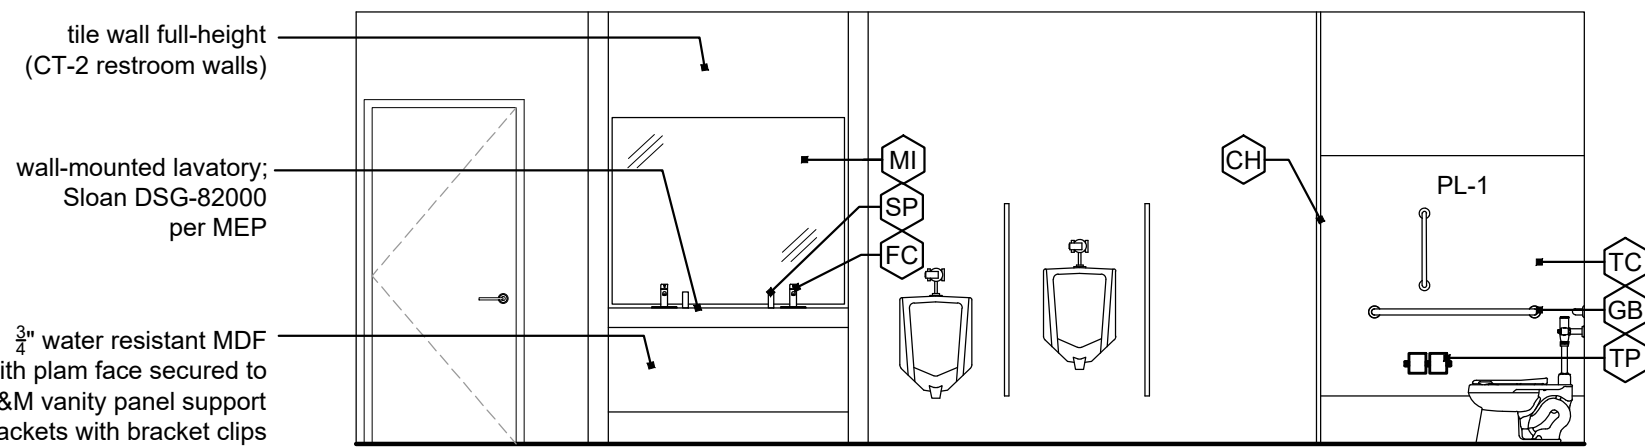


6 Men's Restroom Elevation

scale: 1/4" = 1'-0"

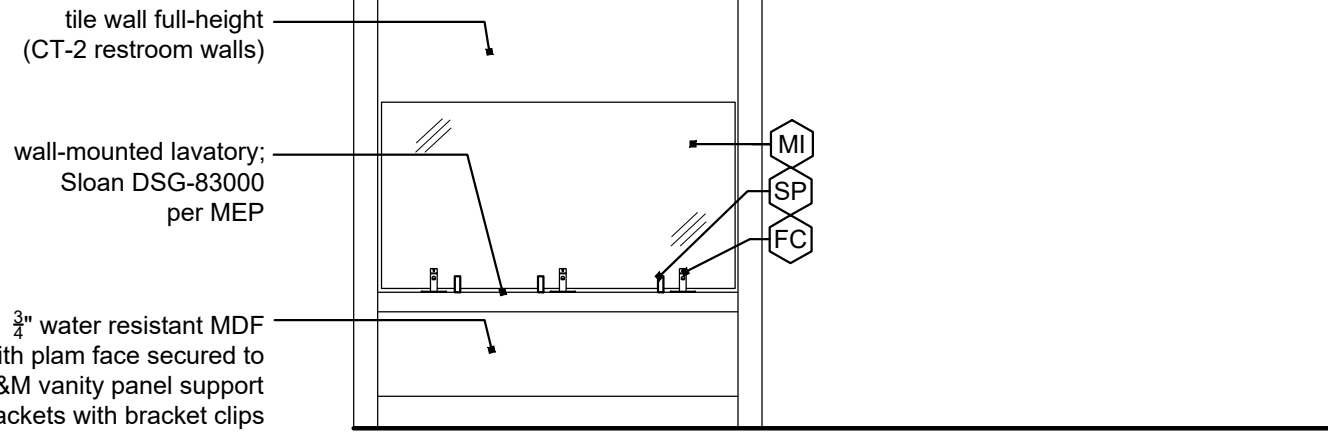


5 Women's Restroom Elevation 1

scale: 1/4" = 1'-0"

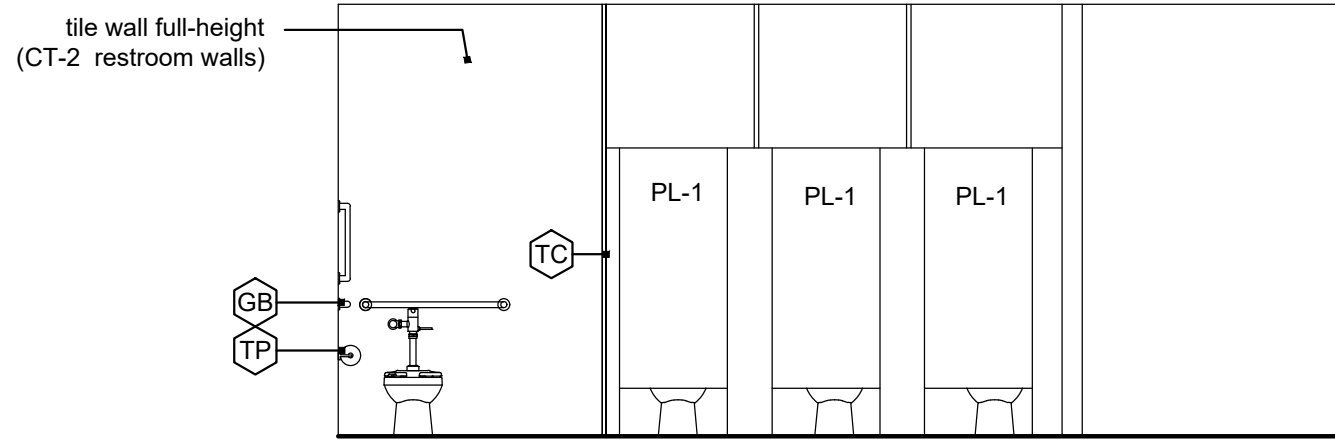


4 Women's Restroom Elevation 2

scale: 1/4" = 1'-0"

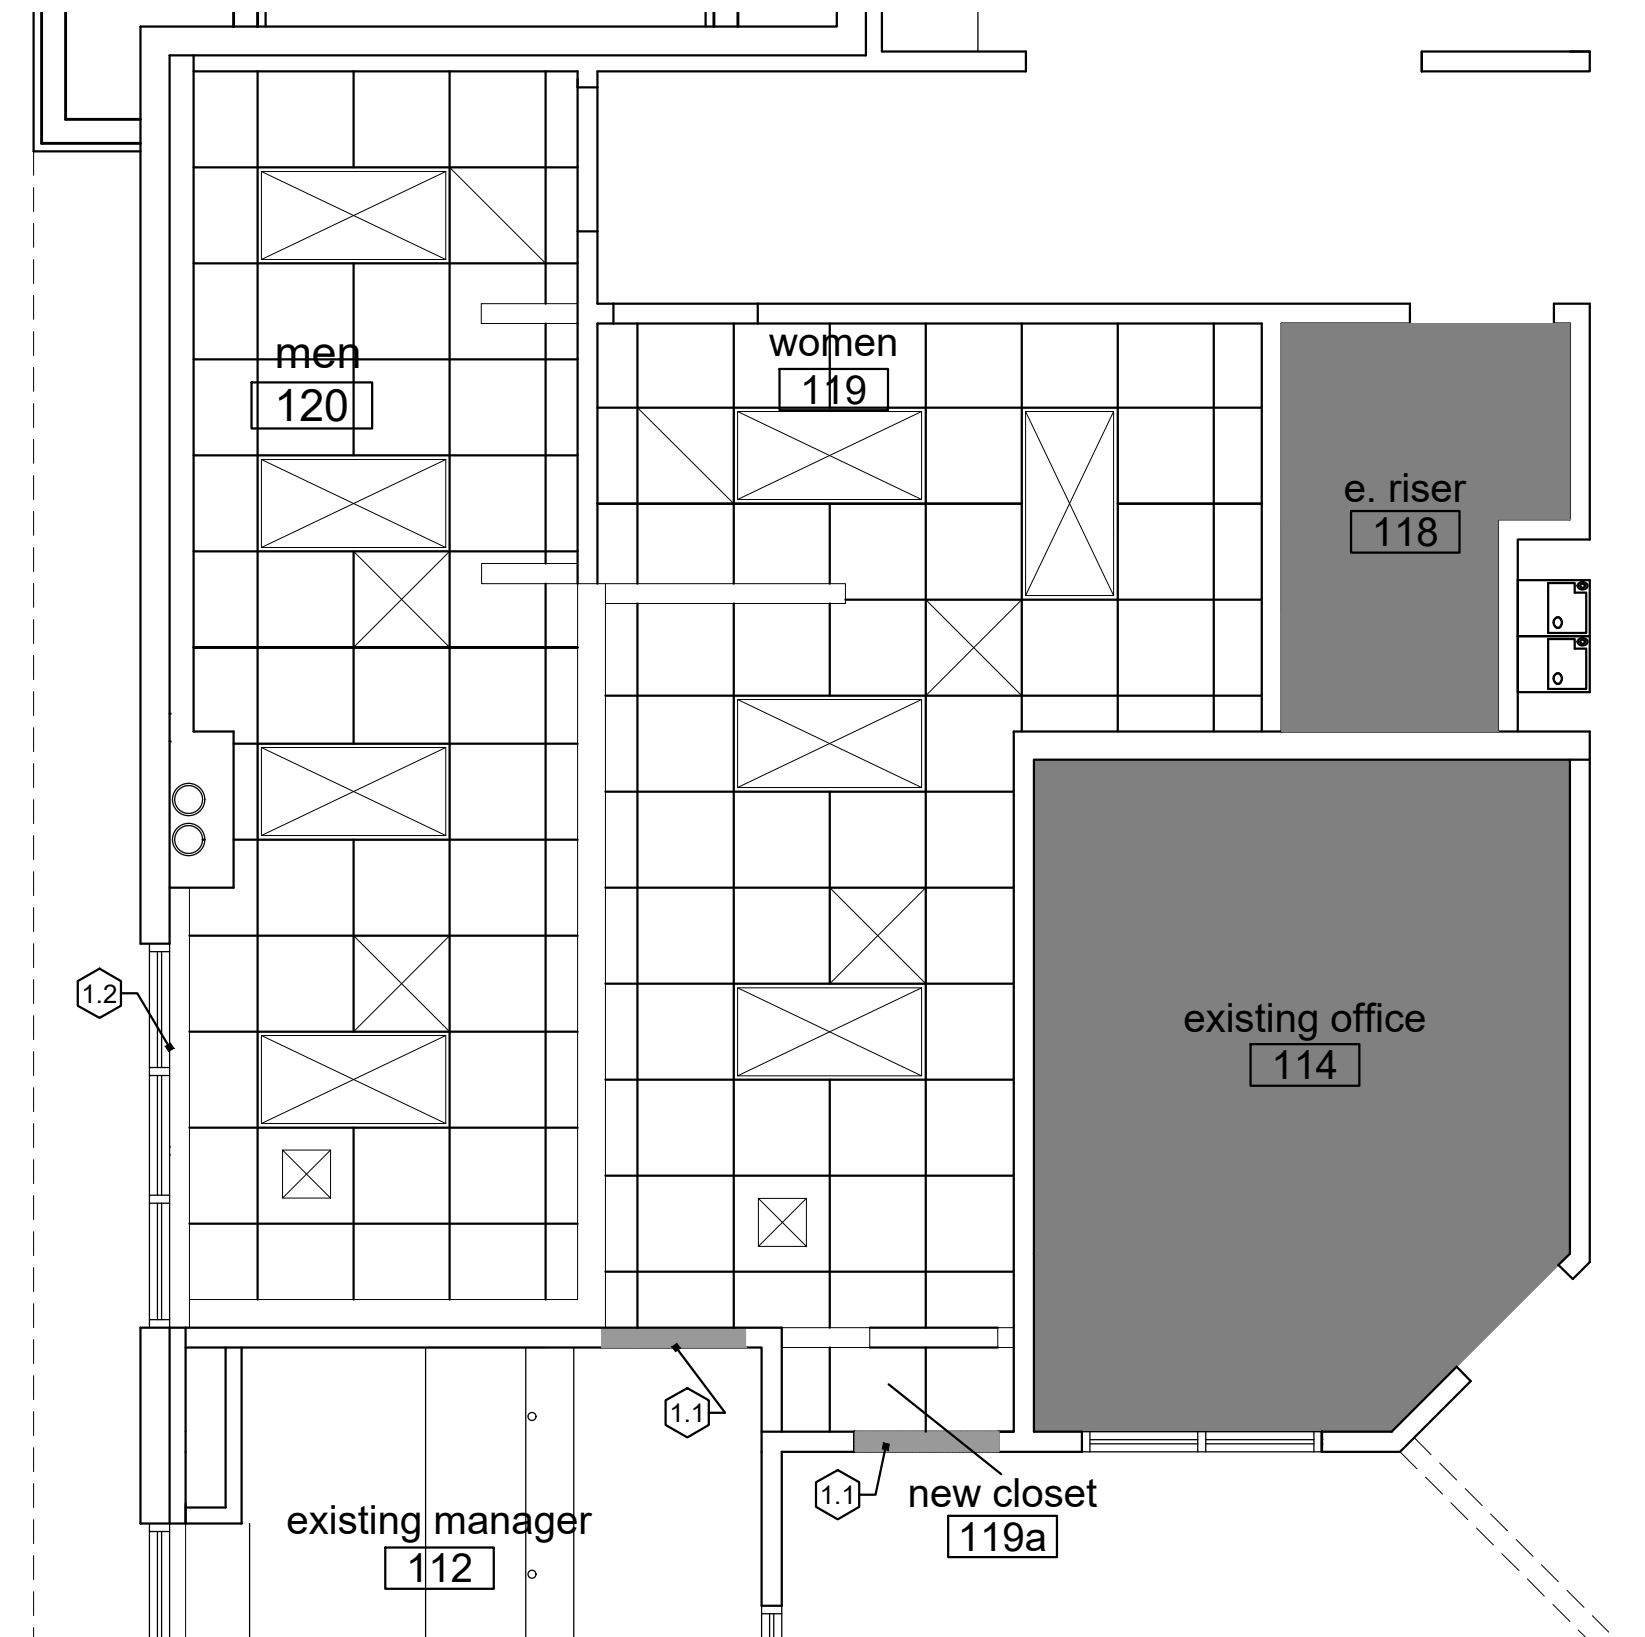


3 Reflected Ceiling Plan

scale: 1/4" = 1'-0"

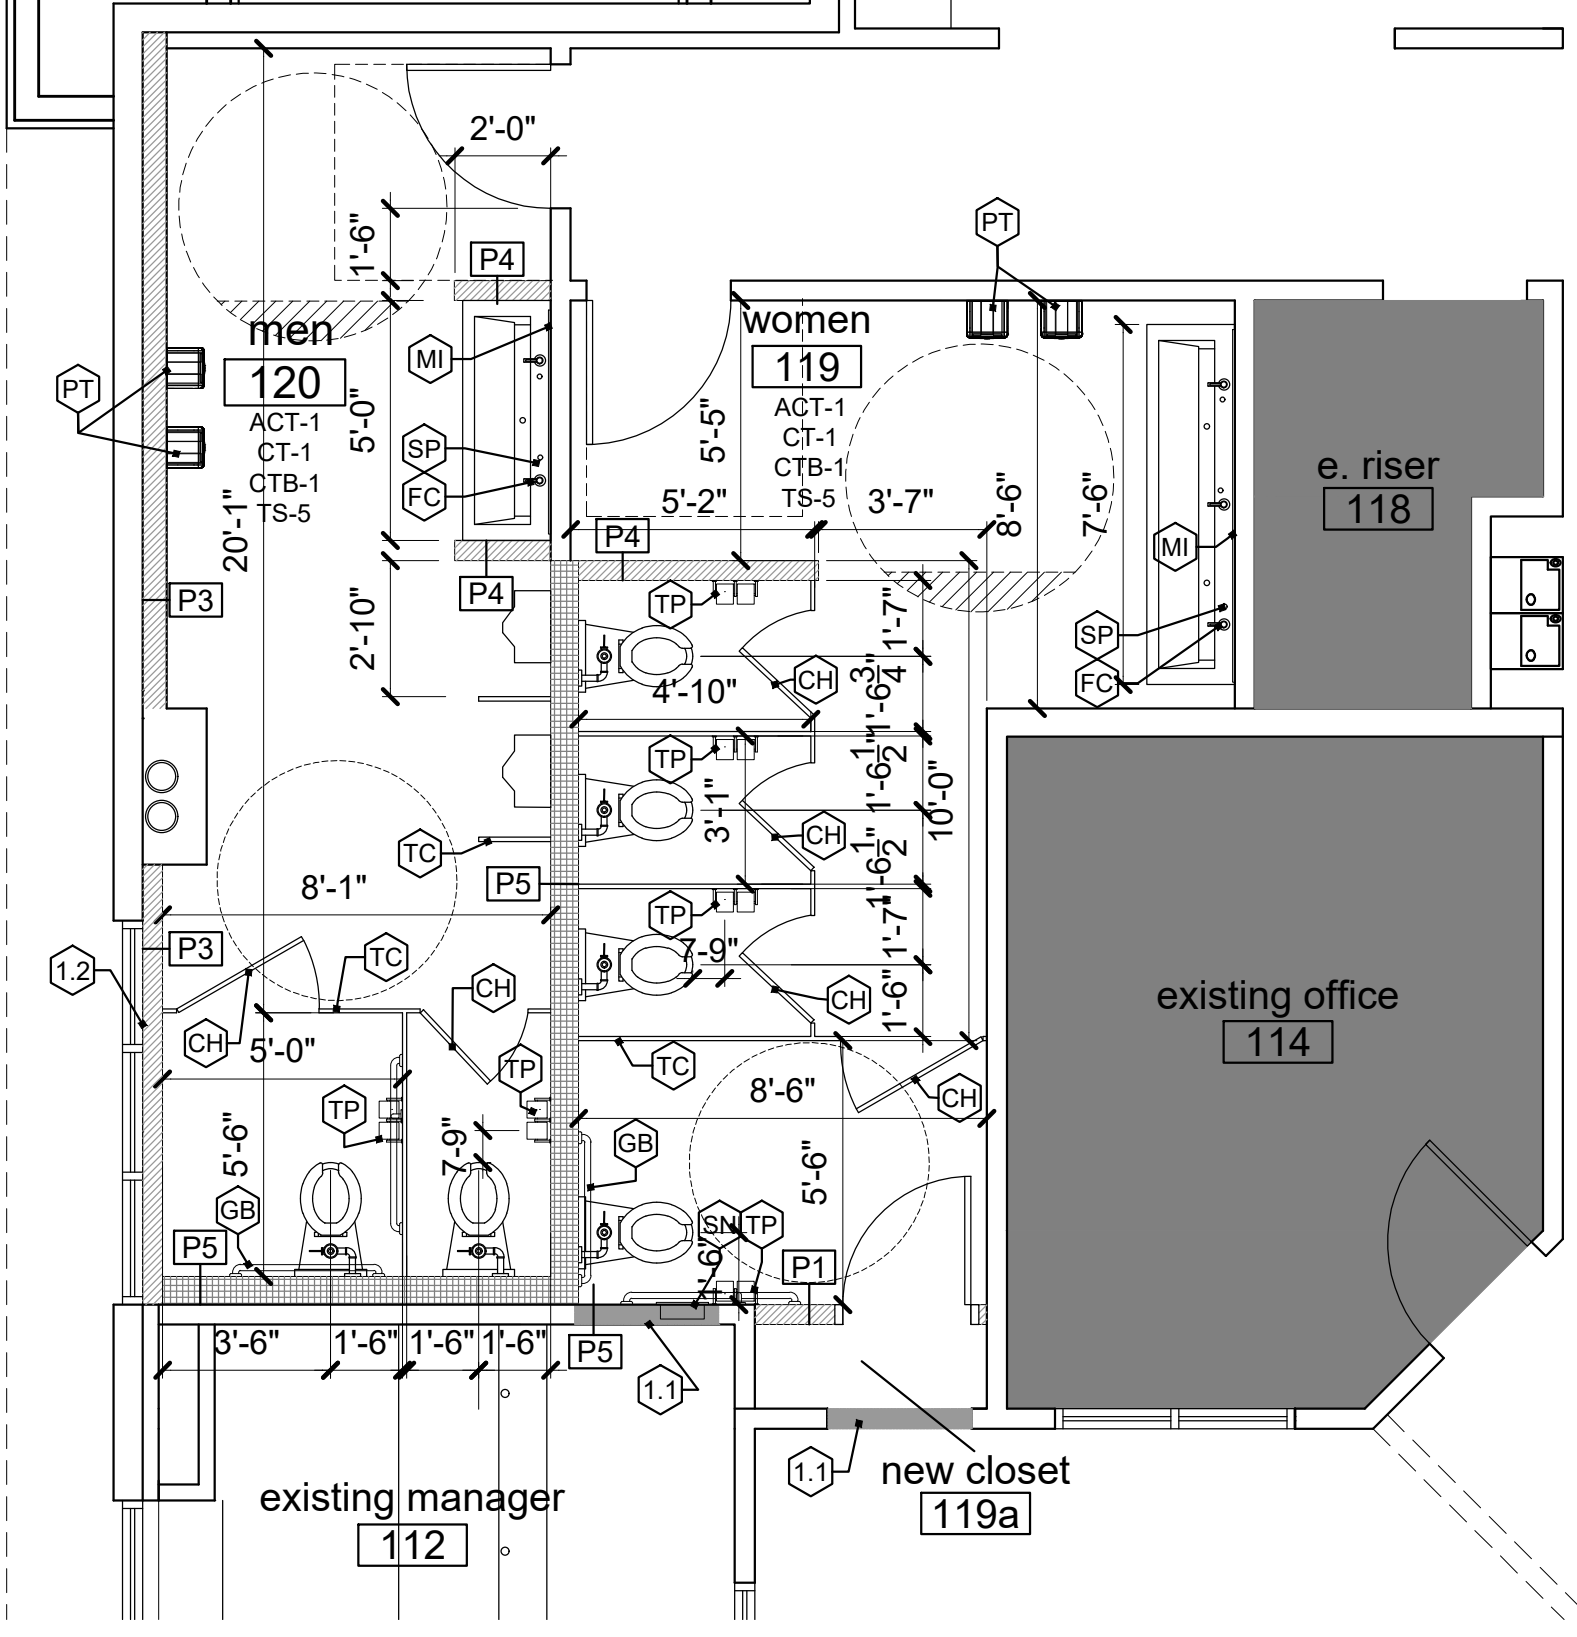

2 Floor Plan

scale: 1/4" = 1'-0"

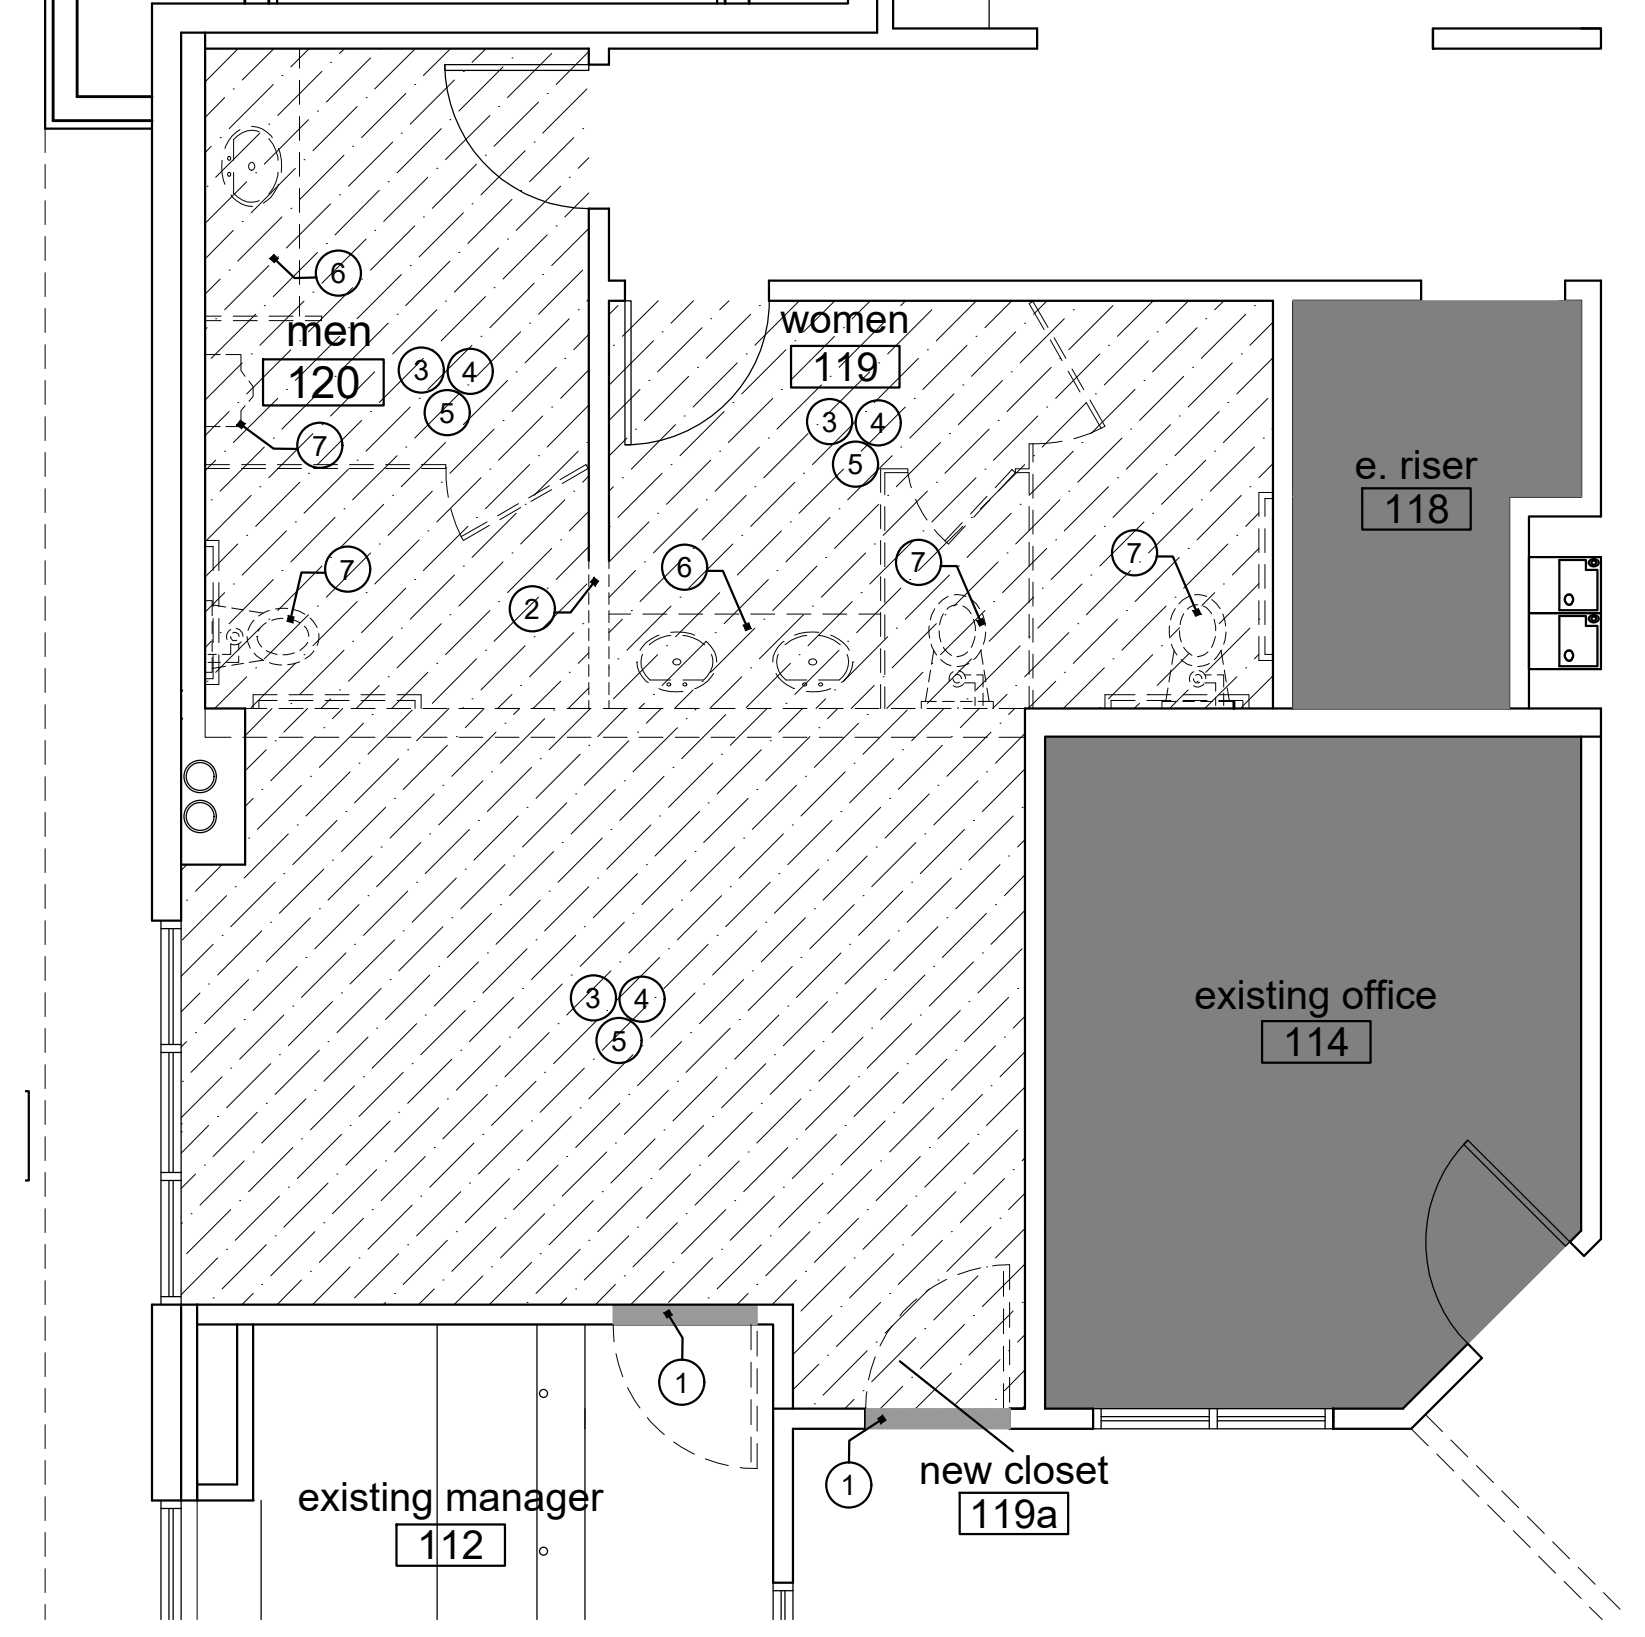

1 Demo Plan

scale: 1/4" = 1'-0"



Keyed demolition notes

1. Remove existing door and frame, infill opening. Match existing wall construction/assembly.
2. Remove portion of existing stud & gypsum board wall in its entirety including wall base & accessories. Cap and/ or reconfigure electrical, plumbing, etc. per MEP
3. Remove existing floor finish in its entirety and prep for new flooring. Floor to be smooth and free from bumps, ready for new flooring installation.
4. Remove existing wall base and and prepare wall for new specified wall base.
5. Remove existing acoustic ceiling tile and grid in its entirety as required for new specific ceiling.
6. Remove existing sink, reconfigure plumbing as required & patch floor and wall as required.
7. Remove existing toilet/urinal, reconfigure plumbing as required and patch floor and wall as required.

Demolition Legend	
	existing wall to remain
	existing wall to be demolished
	existing door to remain
	existing door to be demolished
	existing floor to be demolished

a bathroom remodel for

Lee's Summit Subaru

2101 NE Independence Ave.

Lee's Summit, Missouri 64064

date
10.13.23
drawn by
DAE
checked by
DAE
revisions

sheet number

A1.1

drawing type
permit
project number
23144

9/26/2023



a building addition for
Lee's Summit Subaru
2101 NE Independence Ave.
Lee's Summit, Missouri 64064

date
09.21.2023
drawn by
JS
checked by
EK
revisions



sheet number

P0.0

drawing type
Permit

project number
23144

PLUMBING SPECIFICATIONS

1. GENERAL PROVISIONS:
- A. PROVIDE ALL LABOR, MATERIALS, EQUIPMENT, NECESSARY FOR THE COMPLETE INSTALLATION OF THE PLUMBING SYSTEMS OUTLINED.
- B. OBTAIN ALL PERMITS, FEES, LICENSES, INSPECTIONS, AND CERTIFICATES OF COMPLIANCE OR APPROVAL AS REQUIRED BY THE AUTHORITIES.
- C. ALL WORK SHALL BE PERFORMED IN ACCORDANCE WITH ALL APPLICABLE LAWS, CODES AND REGULATIONS OF THE GOVERNMENTAL BODIES HAVING JURISDICTION OVER THE SITE.
- D. ALL TESTING REQUIRED BY AUTHORITIES SHALL BE CONSIDERED PART OF THIS WORK.
- E. DURING CONSTRUCTION, ALL FIXTURES, EQUIPMENT, PIPE, DUCT, ETC. SHALL BE COVERED, PLUGGED OR CAPPED AS REQUIRED TO KEEP CLEAN AND UNDAMAGED. ALL DAMAGED ITEMS SHALL BE RESTORED TO ORIGINAL CONDITION OR REPLACED. ALL PROTECTIVE COVERING SHALL BE REMOVED BEFORE FINAL ACCEPTANCE.
- F. PROVIDE ALL NECESSARY CUTTING AND PATCHING OF WALLS, FLOORS, CEILINGS, AND ROOFS AS NECESSARY. PATCH AROUND ALL OPENINGS SHALL MATCH ADJACENT AREA. COORDINATE ALL ROOFING WORK WITH OWNER OR RESPONSIBLE PARTY, SO THAT THE EXISTING ROOFING WARRANTY WILL BE MAINTAINED.
- G. CONTRACTOR SHALL GUARANTEE ALL WORK AND MATERIALS AGAINST DEFECTS FOR A PERIOD OF ONE YEAR FROM FINAL ACCEPTANCE.
2. OPERATION AND MAINTENANCE MANUALS:
- A. DURING THE COURSE OF CONSTRUCTION, COLLECT AND COMPILE OPERATING INSTRUCTIONS, WIRING DIAGRAMS, CATALOG CUTS, LUBRICATION AND PREVENTIVE MAINTENANCE INSTRUCTIONS, PARTS LISTS, ETC. FOR ALL EQUIPMENT FURNISHED UNDER THIS CONTRACT.
- B. ALL LITERATURE AND INSTRUCTIONS SHIPPED WITH THE EQUIPMENT SHALL BE SAVED FOR INCLUSION IN THE OPERATION AND MAINTENANCE MANUALS.
- C. ALL LITERATURE LISTED ABOVE AND ALL PAPERS LISTING WARRANTIES, ETC. SHALL BE BOUND IN A 3-RING BINDER AND LABELED WITH THE PROJECT NAME, ADDRESS, ARCHITECT, ENGINEER, CONTRACTORS, ETC.
3. MANUFACTURERS:
- A. MANUFACTURERS, MODEL NUMBERS, ETC. INDICATED OR SCHEDULED ON THE DRAWINGS SHALL BE INTERPRETED AS HAVING ESTABLISHED A STANDARD OF QUALITY AND SHALL NOT BE CONSTRUED AS LIMITING COMPETITION. ARTICLES, FIXTURES, ETC. OF EQUAL QUALITY BY MANUFACTURERS SHALL BE ACCEPTABLE, SUBJECT TO STRUCTURAL AND ELECTRICAL CONSTRAINTS OF THE PROJECT DESIGN, UNLESS NOTED OTHERWISE.
4. TESTING, BALANCING, AND CLEANING:
- A. ALL PIPING SHALL BE TESTED FOR LEAKS BEFORE BEING CONCEALED IN WALL CONSTRUCTION OR COVERED WITH INSULATION.
- B. SEWER AND VENT PIPING SHALL BE HYDROSTATICALLY TESTED WITH NO LESS THAN 10 FEET OF HEAD FOR A PERIOD OF NOT LESS THAN 15 MINUTES, PER THE LOCAL PLUMBING CODE, WITH NO LEAKS.
- C. DOMESTIC WATER PIPING SHALL BE HYDROSTATICALLY TESTED AT A PRESSURE OF NOT LESS THAN 1-1/2 TIMES THE OPERATING PRESSURE, BUT NOT LESS THAN 60 PSI, FOR A PERIOD OF NOT LESS THAN 2 HOURS, WITH NO LEAKS.
- D. BEFORE DOMESTIC WATER PIPING IS PLACED IN SERVICE, ALL DOMESTIC WATER DISTRIBUTION SYSTEMS, INCLUDING THOSE FOR COLD WATER AND HOT WATER SYSTEMS, SHALL BE FLUSHED, STERILIZED AND CHLORINATED IN ACCORDANCE WITH HEALTH DEPARTMENT REGULATIONS. THE SYSTEMS SHALL BE THOROUGHLY FLUSHED OF ALL DIRT AND FOREIGN MATTER, THEN FILLED WITH WATER TREATED WITH 50 PPM OF CHLORINE. DURING THE FILLING PROCESS, VALVES AND FAUCETS SHALL BE OPENED SEVERAL TIMES TO ASSURE TREATMENT OF THE ENTIRE SYSTEM. THE TREATED WATER SHALL BE LEFT IN THE SYSTEM FOR 24 HOURS AFTER WHICH TIME THE SYSTEM SHALL BE FLUSHED; IF THE RESIDUAL CHLORINE IS NOT LESS THAN 10 PPM, THE FLUSHING SHALL BE REPEATED. AFTER STERILIZATION, SAMPLES OF WATER IN THE SYSTEM SHALL BE APPROVED BY THE BOARD OF HEALTH.
5. PLUMBING:
- A. PROVIDE AN APPROVED WATER HAMMER ARRESTOR FOR EACH PLUMBING FIXTURE SUPPLY AS REQUIRED BY FIXTURE MANUFACTURER.
- B. ALL EXPOSED WASTE PIPE SHALL BE CHROME PLATED BRASS PIPE, NO FERROUS PIPE.
- C. PROVIDE CLEANOUTS AT EACH CHANGE OF DIRECTION AND AT 100 FOOT INTERVALS IN STRAIGHT RUNS.
- D. PROVIDE ACCESS PANELS FOR ALL CONCEALED VALVES AND TRAPS.
- E. CLEANOUTS:
- 1) VINYL TILE FLOOR: JR SMITH #4140, OR EQUAL.
- 2) QUARRY TILE FLOOR: JR SMITH #4200, OR EQUAL.
- 3) CARPETED FLOOR: JR SMITH #4020-1, OR EQUAL.
- 4) UNFINISHED FLOOR: JR SMITH #4020, OR EQUAL.
- 5) WALL: JR SMITH #4420, OR EQUAL, 24" ABOVE THE FLOOR.
- 6) WAREHOUSE FLOORS/FORK TRUCK AREAS: JR SMITH #4100, OR EQUAL, WITH HEAVY DUTY CAST IRON BODY AND ROUND ADJUSTABLE SCORRIATED EXTRA HEAVY DUTY NICKEL BRONZE TOP.
- 7) GRADE: JR SMITH #4280, OR EQUAL, WITH HEAVY DUTY CAST IRON BODY AND COVER.
- F. PROVIDE DIELECTRIC UNIONS WITH APPROPRIATE END CONNECTIONS TO MATCH THE PIPE SYSTEM IN WHICH INSTALLED (SCREWED, SOLDERED, OR FLANGED). PROVIDE DIELECTRIC UNIONS ON ALL PIPING CONNECTIONS TO HOT WATER HEATERS AND EXPANSION TANKS.
- G. ALL SEWER PIPING LOCATED INSIDE THE BUILDING SHALL BE INSTALLED WITH THE FOLLOWING SLOPES.
- 1) INSTALL 2-1/2" AND SMALLER PIPE AT 1/4" PER FOOT FALL.
- 2) INSTALL 3" AND LARGER PIPE AT 1/8" PER FOOT FALL.
- 3) INSTALL ALL GREASE WASTE PIPING AT 1/4" PER FOOT FALL.
6. PIPING:
- A. DOMESTIC COLD AND HOT WATER (ABOVEGROUND).
- 1) TYPE L HARD DRAWN COPPER TUBING, ASTM B-88.
- a) KROHST COPPER SOLDERED FITTINGS, ASTM B16 ALLOY C12200, ANSI B16.22, MSS SP-104.
- b) MECHANICAL PRESS COPPER FITTINGS FOR USE IN PLUMBING OR MECHANICAL APPLICATIONS, ASME B16.22, ASME B16.51, OR ASME B16.10. MECHANICAL PRESS COPPER FITTINGS SHALL CONFORM TO API604 PS-117 OR ASME B16.51.
- 2) PEX, HIGH-DENSITY CROSS-LINKED POLYETHYLENE TUBING SHALL BE MANUFACTURED TO THE REQUIREMENTS OF ASTM F876 AND MEET THE STANDARD GRADE HYDROSTATIC PRESSURE RATINGS FROM PLASTIC PIPE INSTITUTE IN ACCORDANCE WITH TR-4/03 (MUST BE INSTALLED PER THE MANUFACTURERS REQUIREMENTS FOR PLENUM USE).
- a) PEX-A AND PEX-B MEETINGS: ANSI/NSF61 AND ANSI/NSF312 STANDARDS FOR POTABLE WATER SAFETY AND LEAD-FREE STANDARDS AND MUST BE MARKED WITH "PPH-S", "NSF-61-S" OR OTHER NSF-APPROVED MARKING, ASTM F2022 FOR USE WITH CHLORINATED WATER. (MUST BE INSTALLED PER THE MANUFACTURERS REQUIREMENTS FOR PLENUM USE).
- b) PEX MECHANICAL, CRIMP/INSERT OR EXPANSION FITTINGS INSTALLED IN ACCORDANCE WITH MANUFACTURERS INSTRUCTIONS. PIPE SIZES GIVEN ON THE DRAWINGS ARE NOMINAL. COPPER PIPE SHALL BE INSTALLED INCREASE PEX PIPING SIZE TO EQUAL OR EXCEED COPPER PIPE INSIDE DIAMETER FOR SUPPLY MAINS. (MUST BE INSTALLED PER THE MANUFACTURERS REQUIREMENTS FOR PLENUM USE).
- 3) VALVES
- a) TO BE INSTALLED ON THE FIXTURE SUPPLY TO EACH PLUMBING FIXTURE.
- b) TO BE INSTALLED ON THE WATER SUPPLY SIDE TO EACH AFFIANCE OR MECHANICAL EQUIPMENT.
- c) TYPE:
1. GATE VALVE: JOMAR T/S-3010 OR EQUAL, LEAD-FREE NSF 61, ANSI B1.20.1.
2. GLOBE VALVE: JOMAR T60 OR EQUAL.
3. BALL VALVE: JOMAR JPO100P OR EQUAL, COMPACT LEAD FREE BRASS BALL VALVE, UL842, CSA 3371-12 & 3371-42, FM, CALIFORNIA CODE AB1183, NSF61 ANNEX 5 APPROVED.
4. BALL VALVE: JOMAR T-100NE OR EQUAL, UL842, FM, CSA, NSF 61-8, MSS SP-110.
- B. LEAD CONTENT OF WATER SUPPLY PIPE AND FITTINGS:
- 1) PIPE AND PIPE FITTINGS, INCLUDING VALVES AND FAUCETS, UTILIZED IN THE WATER SUPPLY SYSTEM SHALL NOT HAVE MORE THAN 0% LEAD CONTENT.
- 2) PIPE, PIPE FITTINGS, JOINTS, VALVES, FAUCETS, AND FIXTURE FITINGS UTILIZED TO SUPPLY WATER FOR DRINKING OR COOKING PURPOSES SHALL COMPLY WITH NSF 372 AND SHALL HAVE A WEIGHTED AVERAGE LEAD CONTENT OF 0.25% OR LESS.
- C. SEWER AND VENTS (UNDERGROUND, INTERIOR TO THE BUILDING).
- 1) ABS PIPE AND FITTINGS: ABS PIPE AND FITTINGS SHALL COMPLY WITH NSF 14, "PLASTICS PIPING SYSTEMS COMPONENTS AND RELATED MATERIALS," FOR PLASTIC PIPING COMPONENTS, INCLUDE MARKING WITH "NSF-DWV" FOR PLASTIC DRAIN, WASTE, AND VENT PIPING AND "NSF-SEWER" FOR PLASTIC SEWER PIPING. SOLID-WALL ABS PIPE: ASTM D 2661, SCHEDULE 40. ABS SOCKET FITTINGS: ASTM D 2661, MADE TO ASTM D 3311, DRAIN, WASTE, AND VENT PATTERNS: SOLVENT CEMENT: ASTM D 2225.
- 2) PVC PIPE AND FITTINGS: PVC PIPE AND FITTINGS SHALL COMPLY WITH NSF 14, "PLASTICS PIPING SYSTEMS COMPONENTS AND RELATED MATERIALS," FOR PLASTIC PIPING COMPONENTS, INCLUDE MARKING WITH "NSF-DWV" FOR PLASTIC DRAIN, WASTE, AND VENT PIPING AND "NSF-SEWER" FOR PLASTIC SEWER PIPING. SOLID-WALL PVC PIPE: ASTM D 2665, DRAIN, WASTE, AND VENT PVC SOCKET FITTINGS: ASTM D 2665, MADE TO ASTM D 3311, DRAIN, WASTE, AND VENT PATTERNS AND TO FIT SCHEDULE 40 PIPE. ADHESIVE PRIMER: ASTM F 656. SOLVENT CEMENT: ASTM D 2564.
- 3) HUBLESS CAST IRON SOIL PIPE AND FITTINGS: HUBLESS CAST IRON PIPE AND FITTINGS SHALL BE MANUFACTURED FROM GRAY CAST IRON AND SHALL CONFORM TO ASTM A 880 AND CIPPI STANDARD 301. HUBLESS COUPLINGS SHALL CONFORM TO CIPPI STANDARD 310 AND BE CERTIFIED BY NSF® INTERNATIONAL.
- 4) HUB AND SPIGOT CAST IRON SOIL PIPE AND FITTINGS: HUB AND SPIGOT CAST IRON PIPE AND FITTINGS SHALL BE MANUFACTURED FROM GRAY CAST IRON AND SHALL CONFORM TO ASTM A 74.
- D. SANITARY SEWER AND VENTS (ABOVE GROUND, INTERIOR TO THE BUILDING).
- 1) ABS PIPE AND FITTINGS: ABS PIPE AND FITTINGS SHALL COMPLY WITH NSF 14, "PLASTICS PIPING SYSTEMS COMPONENTS AND RELATED MATERIALS," FOR PLASTIC PIPING COMPONENTS, INCLUDE MARKING WITH "NSF-DWV" FOR PLASTIC DRAIN, WASTE, AND VENT PIPING AND "NSF-SEWER" FOR PLASTIC SEWER PIPING. SOLID-WALL ABS PIPE: ASTM D 2661, SCHEDULE 40. CELLULAR-CORE ABS PIPE: ASTM F 620, SCHEDULE 40. ABS SOCKET FITTINGS: ASTM D 2661, MADE TO ASTM D 3311, DRAIN, WASTE, AND VENT PATTERNS: SOLVENT CEMENT: ASTM D 2225. (NOT FOR USE IN A RETURN AIR PLENUM).
- 2) PVC PIPE AND FITTINGS: PVC PIPE AND FITTINGS SHALL COMPLY WITH NSF 14, "PLASTICS PIPING SYSTEMS COMPONENTS AND RELATED MATERIALS," FOR PLASTIC PIPING COMPONENTS, INCLUDE MARKING WITH "NSF-DWV" FOR PLASTIC DRAIN, WASTE, AND VENT PIPING AND "NSF-SEWER" FOR PLASTIC SEWER PIPING. SOLID-WALL PVC PIPE: ASTM D 2665, DRAIN, CELLULAR-CORE PVC PIPE: ASTM F 641, SCHEDULE 40. WASTE, AND VENT PVC SOCKET FITTINGS: ASTM D 2665, MADE TO ASTM D 3311, DRAIN, WASTE, AND VENT PATTERNS AND TO FIT SCHEDULE 40 PIPE. ADHESIVE PRIMER: ASTM F 656. SOLVENT CEMENT: ASTM D 2564.
- 3) HUBLESS CAST IRON SOIL PIPE AND FITTINGS: HUBLESS CAST IRON PIPE AND FITTINGS SHALL BE MANUFACTURED FROM GRAY CAST IRON AND SHALL CONFORM TO ASTM A 880 AND CIPPI STANDARD 301. HUBLESS COUPLINGS SHALL CONFORM TO CIPPI STANDARD 310 AND BE CERTIFIED BY NSF® INTERNATIONAL.
- 4) HUB AND SPIGOT CAST IRON SOIL PIPE AND FITTINGS: HUB AND SPIGOT CAST IRON PIPE AND FITTINGS SHALL BE MANUFACTURED FROM GRAY CAST IRON AND SHALL CONFORM TO ASTM A 74.

PLUMBING SPECIFICATIONS (CONTINUED)

- E. ALL PIPE HANGERS AND SUPPORTS SHALL BE STANDARD PRODUCTS OF GRINNELL, FEE AND MASON, OR ELGEN. HANGER SPACING SHALL BE IN ACCORDANCE WITH MSS-SP-64.
- F. SLEEVES
- 1) PROVIDE, SET, AND PROPERLY LOCATE PIPE SLEEVES AS REQUIRED FOR THIS WORK. ALL SLEEVES SHALL BE OF SUFFICIENT SIZE TO PERMIT PIPE MOVEMENT DUE TO EXPANSION AND CONTRACTION AND TO ACCOMMODATE PIPE INSULATION.
- 2) INTERIOR PARTITIONS: 16 GAUGE GALVANIZED STEEL. PACK BETWEEN PIPE AND SLEEVE WITH FIRE SAFING AND CAULK AT EACH END WITH FIRE RESISTANT SEALANT.
- 3) ROOF: PROSET OR EQUAL, MANUFACTURED PVC SCHEDULE 40 PIPE SLEEVE WITH WATERPROOF SEAL. COORDINATE WITH ROOFING CONTRACTOR AND FLASH AS REQUIRED TO MAINTAIN ROOF WARRANTY.
- 4) PROTECTION AGAINST CONTACT: METALLIC PIPING, EXCEPT FOR CAST IRON, DUCTILE IRON AND GALVANIZED STEEL, SHALL NOT BE PLACED IN DIRECT CONTACT WITH STEEL FRAMING MEMBERS, CONCRETE, OR OTHER WALLS AND FLOORS OR OTHER MASONRY. METALLIC PIPING SHALL NOT BE PLACED IN DIRECT CONTACT WITH CORROSIVE SOIL. SHEATHING USED TO PREVENT DIRECT CONTACT SHALL HAVE A THICKNESS OF GREATER THAN .003; AND THE SHEATHING SHALL BE MADE OF PLASTIC. ANY PIPE THAT PASSES THROUGH A FOUNDATION WALL OR FOOTING SHALL BE PROVIDED WITH A RELIEVING ARCH, OR A PIPE SLEEVE SHALL BE BUILT INTO THE FOUNDATION WALL. THE SLEEVE SHALL BE TWO SIZES GREATER THAN THE PIPE PASSING THROUGH THE WALL OR FOOTING.
- 5) PLUMBING VENTS: FLASH ROOF VENT INTO ROOFING SYSTEM AS REQUIRED BY THE ROOFING CONTRACTOR TO MAINTAIN EXISTING ROOF WARRANTY. ALL PLUMBING VENT TERMINALS SHALL TERMINATE A MINIMUM OF 12" ABOVE ROOF OR EQUAL TO HEIGHT OF PARAPET, WHICHEVER IS GREATER.
6. PROVIDE CHROME PLATED ESCUTCHEONS ON ALL PIPE ENTERING FINISHED AREAS.
7. INSULATION:
- A. ALL INSULATIONS AND ACCESSORIES SHALL HAVE A FIRE HAZARD CLASSIFICATION WITH A FLAME SPREAD RATING OF NOT OVER 25, A FUEL CONTRIBUTION RATING OF NOT OVER 50, AND A SMOKE DEVELOPED RATING OF NOT OVER 50, IN ACCORDANCE WITH NFPA.
- B. PIPE INSULATION - ABOVE GRADE:
- 1) THE PIPING INSULATION USED SHALL HAVE A THERMAL CONDUCTIVITY OF 0.21 BTU PER IN./H/1"SQ/1"FT OR LESS.
- 2) FIBERGLASS INSULATION WITH FACTORY APPLIED VAPOR BARRIER, ASJ JACKET, FACTORY APPLIED PRESSURE SEALING LONGITUDE LAP JOINT, NO STAPLES, ZESTON PREMOULDED PVC FITTING COVERS. INSTALLATION SHALL BE IN ACCORDANCE WITH MANUFACTURERS RECOMMENDATIONS.
- 3) FLEXIBLE CLOSED CELL ELASTOMERIC THERMAL INSULATION, UNSUIT OR PRESUIT WITH PRESSURE SENSITIVE ADHESIVE SYSTEM FOR CLOSURE AND VAPOR SEALING, EQUAL TO ARMSTRONGS AP ARMAFLEX OR ARMAFLEX 2000.
- 4) FOR NON CIRCULATING SYSTEMS, THE FIRST 6 FEET OF INLET AND OUTLET PIPINGS BETWEEN THE TANK AND THE HEAT TRAP (INCLUDING THE HEAT TRAP) MUST BE INSULATED.
- 5) FOR CIRCULATING SYSTEMS, ALL HOT WATER PIPING IN THE GRILLATION LOOP MUST BE INSULATED AS SPECIFIED BELOW.
- 6) INSULATION SCHEDULE:
- a) DOMESTIC COLD WATER 1/2"
- b) DOMESTIC HOT WATER 1" FOR PIPING UP TO 1-1/4", 1 1-1/2" FOR PIPING 1-1/2" AND LARGER
- C. EQUIPMENT INSULATION:
- 1) FLEXIBLE FIBERGLASS GLASS FIBER INSULATION, ASTM C 553, TYPE 1, CLASS B-4, SEMI-RIGID BOARD, WITH FACTORY LAMINATED KRAFT ALUMINUM FOIL (ALL SERVICE JACKET), VAPOR BARRIER, JOINTS/CORNING PIPE AND TANK INSULATION.
- D. REMODELING WORK:
- A. DEMOLITION: DISCONNECT, DEMOLISH, AND REMOVE ABANDONED MECHANICAL MATERIALS AND EQUIPMENT INDICATED TO BE REMOVED AND NOT INDICATED TO BE SALVAGED OR REMAIN.
- B. EQUIPMENT TO BE SALVAGED:
- 1) DISCONNECT AND REMOVE EXISTING MECHANICAL EQUIPMENT INDICATED TO BE REMOVED AND SALVAGED. DELIVER EQUIPMENT TO THE LOCATION DESIGNATED BY THE OWNER FOR STORAGE.
- 2) ALL MATERIALS AND EQUIPMENT DESIGNATED TO BE REUSED OR RELOCATED SHALL BE CAREFULLY REMOVED, AND STORED UNTIL NEEDED FOR REMODELING WORK. ALL ITEMS SHALL BE RESTORED TO "LIKE NEW" CONDITION WITH RUST OR CORROSION REMOVED, SURFACE PAINT TOUCHED UP OR REPAINTED AS REQUIRED TO MATCH NEW CONSTRUCTION, AND THOROUGHLY CLEANED AND INSPECTED. ANY ITEMS WHICH BECOME DAMAGED BEYOND REPAIR AS A RESULT OF CONSTRUCTION OR DEMOLITION ACTIVITY SHALL BE REPLACED WITH NEW MATERIAL EQUIVALENT IN EVERY RESPECT.
- C. DISPOSAL AND CLEANUP: REMOVE FROM THE SITE AND LEGALLY DISPOSE OF DEMOLISHED MATERIALS AND EQUIPMENT NOT INDICATED TO BE SALVAGED.
- D. PROTECT ADJACENT MATERIALS INDICATED TO REMAIN. INSTALL AND MAINTAIN DUST AND NOISE BARRIERS TO KEEP DIRT, DUST, AND NOISE FROM BEING TRANSMITTED TO ADJACENT AREAS. REMOVE PROTECTION AND BARRIERS AFTER REMODELING OPERATIONS ARE COMPLETE.
- E. LOCATE, IDENTIFY, AND PROTECT MECHANICAL SERVICES PASSING THROUGH REMODELING AREA AND SERVING OTHER AREAS OUTSIDE THE REMODELING LIMITS. MAINTAIN SERVICES TO AREAS OUTSIDE REMODELING LIMITS. WHERE MECHANICAL SERVICES ARE LOCATED IN A WALL, ETC. TO BE DEMOLISHED, REROUTE PIPING TO NEW OR EXISTING CONSTRUCTION TO MAINTAIN CONTINUITY OF THE SYSTEM. WHEN SERVICES MUST BE INTERRUPTED, INSTALL TEMPORARY SERVICES FOR AFFECTED AREAS.
- F. REMOVE ALL PIPING TO BE DEMOLISHED BACK TO PIPE MAIN OR EDGE OF PROJECT AREA, AND CAP PIPE.
- G. PIPING AND DUCTS EMBEDDED IN FLOORS, WALLS, AND CEILINGS MAY REMAIN IF SUCH MATERIALS DO NOT INTERFERE WITH NEW INSTALLATIONS. PIPING AND DUCTS TO REMAIN SHALL BE APPROVED BY THE ARCHITECT. REMOVE MATERIALS ABOVE ACCESSIBLE CEILINGS, DRAIN AND CAP PIPING AND DUCTS ALLOWED TO REMAIN ABOVE CEILING OR BELOW FLOOR, CONCEALED FROM VIEW, EXCEPT AS OTHERWISE NOTED. PATCH FLOOR TO MATCH EXISTING.
- H. PIPE AND DUCT SHALL BE CONCEALED WITH NEW OR EXISTING CONSTRUCTION WHENEVER POSSIBLE, UNLESS INDICATED OTHERWISE.

MISSOURI PE COA #2009003629

This drawing has been prepared by the Engineer, or under his supervision. This drawing is provided as an instrument of service by the Design/Engineer and is intended for use on the project only. Pursuant to the Architectural Works Copyright Protection Act of 1990, all drawings, specifications, ideas and designs, including the overall form, arrangement and conceptual design of elements appearing herein, constitute the original, copyrighted work of the Design/Engineer. Any reproduction, use, or disclosure of information contained herein without prior written consent of the Engineer is strictly prohibited. © 2023 BC Engineers, Inc.

Taylor Mechanical, Inc.
P.O. Box 2064
Lee's Summit, MO 64063

BC ENGINEERS
INCORPORATED

5720 Reeder Shawnee, Ks. 66203 (913)262-1772



4301 Indian Creek Parkway
Overland Park, KS 66207
phone: 813.451.8360
www.davidsonae.com

9/26/2023



PLUMBING PLAN NOTES:

- 1 CONNECT 4" WASTE TO EXISTING 4" SANITARY SEWER AS REQUIRED. VERIFY EXACT LOCATION AND ELEVATION PRIOR TO INSTALLATION OF ANY PIPING.
- 2 CONNECT 2" CW TO EXISTING 2" DOMESTIC CW AS REQUIRED. VERIFY EXACT LOCATION PRIOR TO INSTALLATION OF ANY PIPING.
- 3 CONNECT 3/4" HW TO EXISTING 3/4" DOMESTIC HW AS REQUIRED. VERIFY EXACT LOCATION PRIOR TO INSTALLATION OF ANY PIPING.
- 4 CONNECT 3" VENT TO EXISTING VENT AS REQUIRED. VERIFY EXACT LOCATION PRIOR TO INSTALLATION OF ANY PIPING.
- 5 CONNECT HOT WATER RECIRC. PIPING BACK TO WATER HEATER AS REQUIRED. REFER TO RISER DIAGRAM FOR DETAILS.
- 6 EXISTING TO REMAIN.

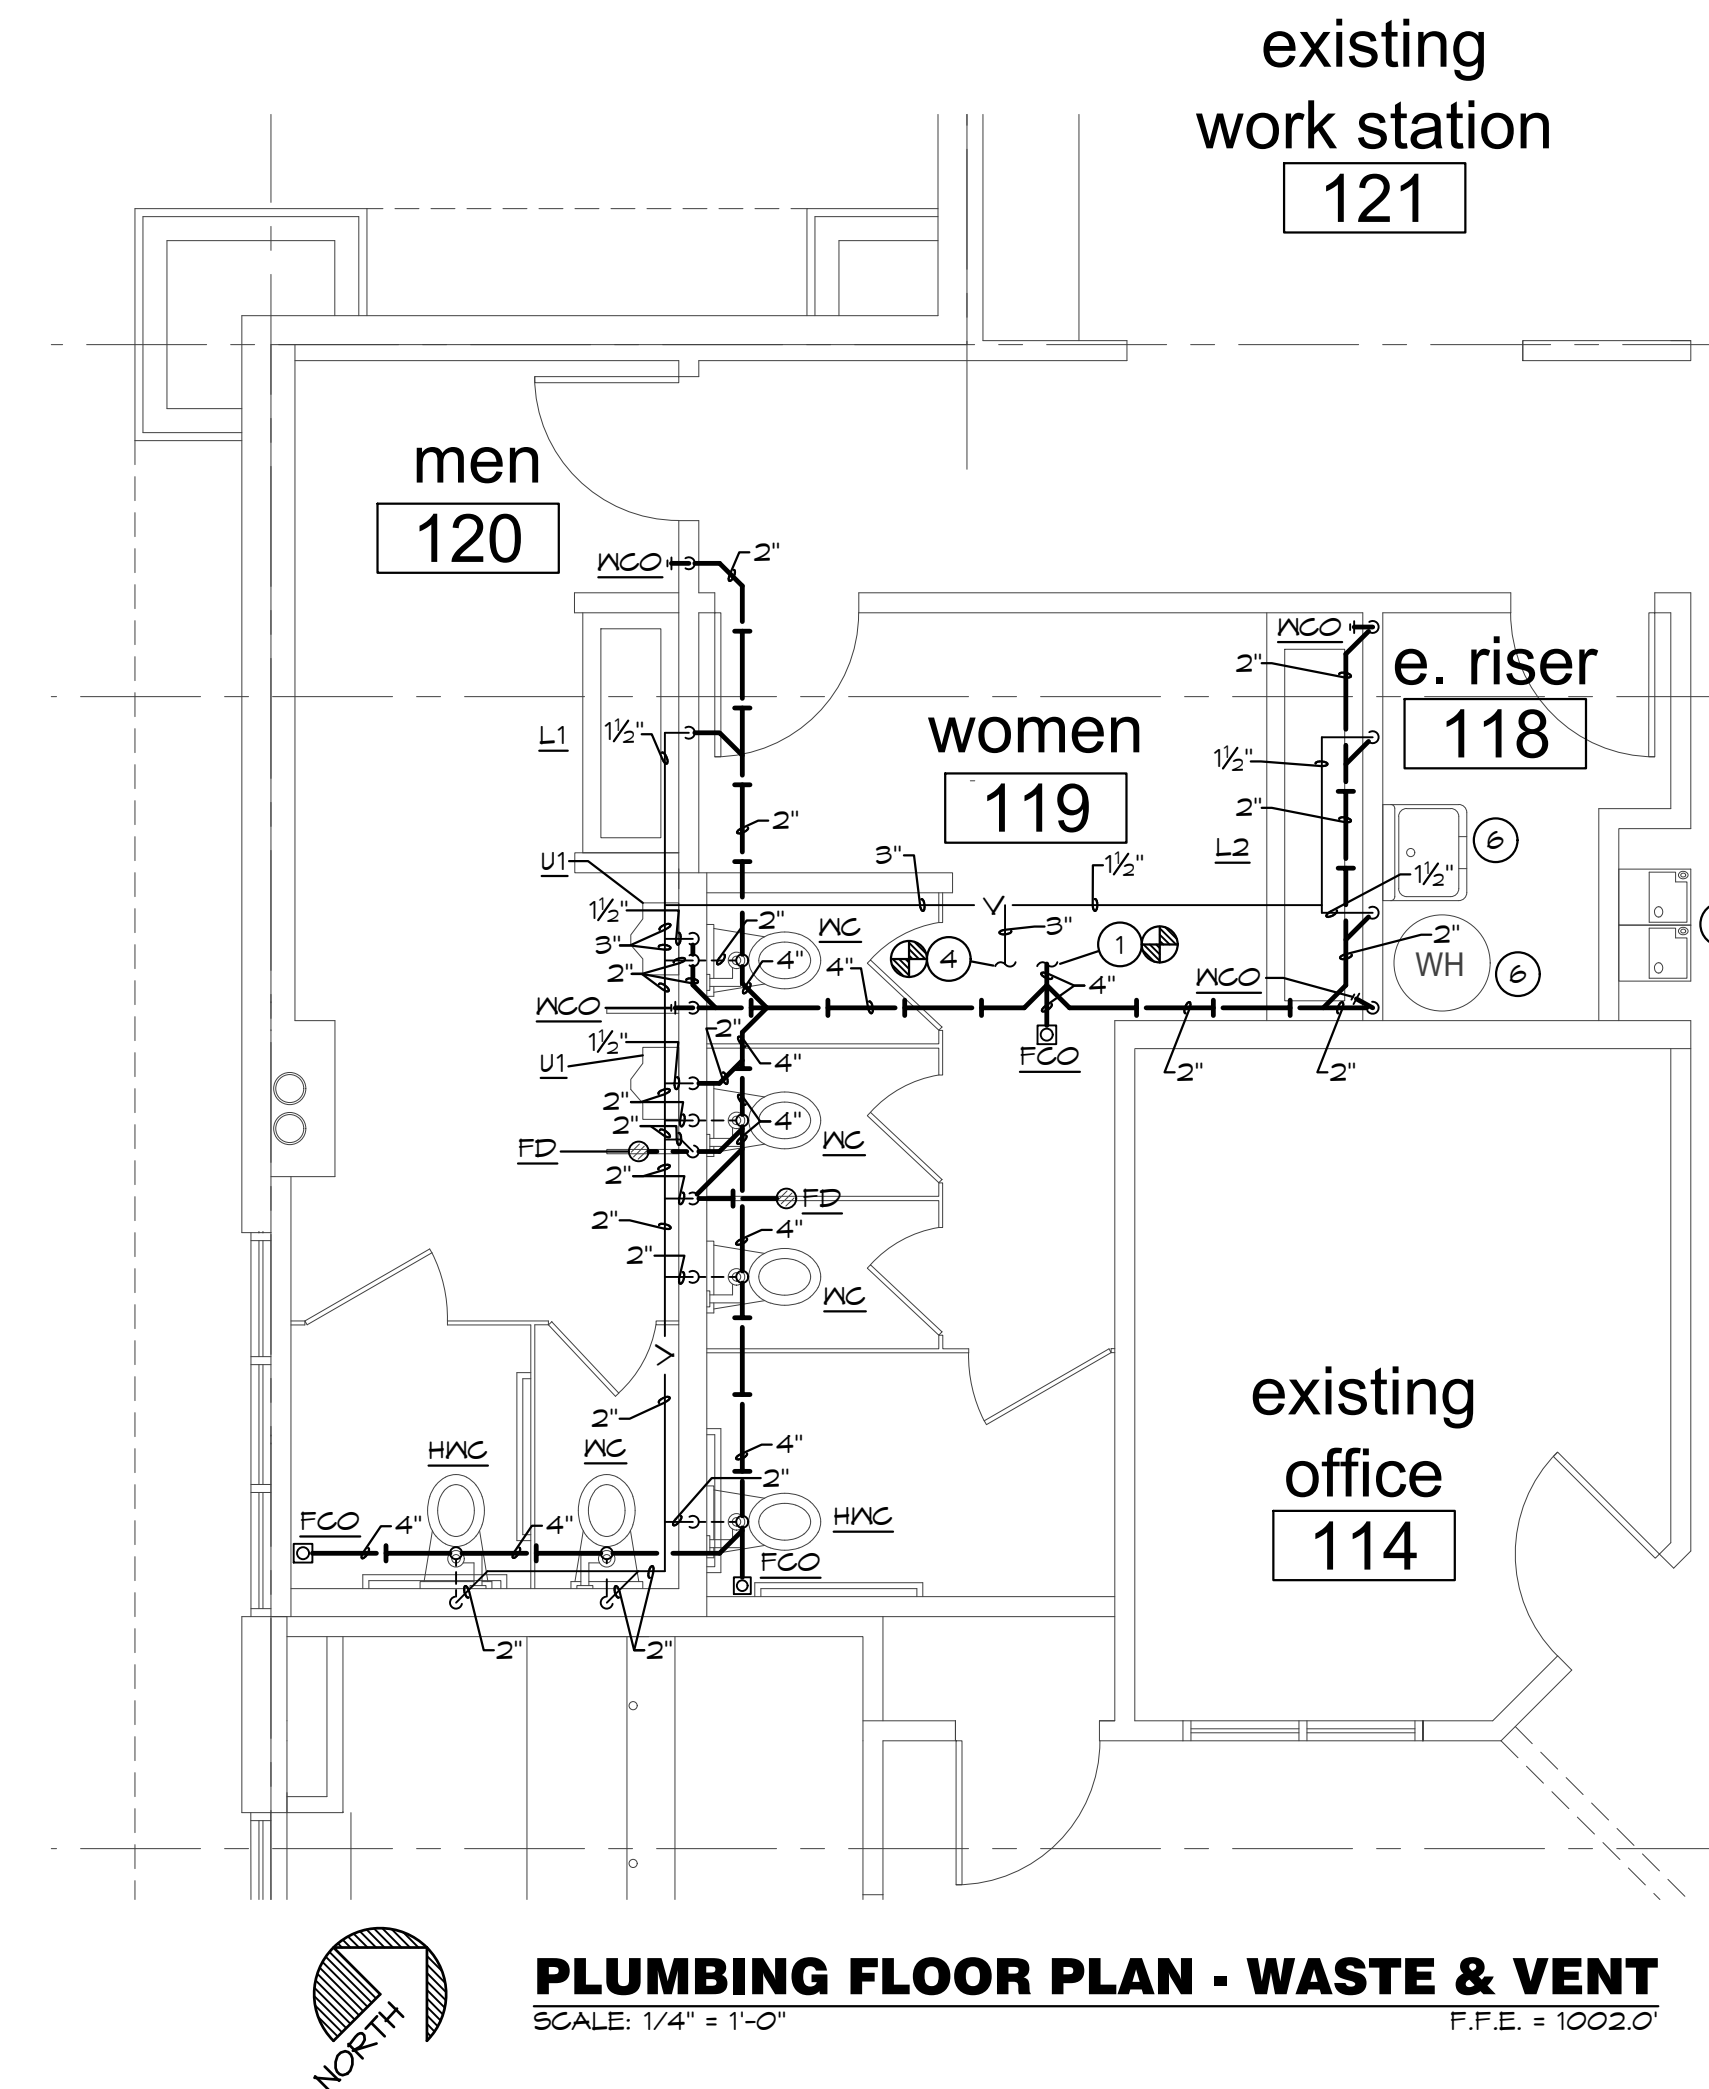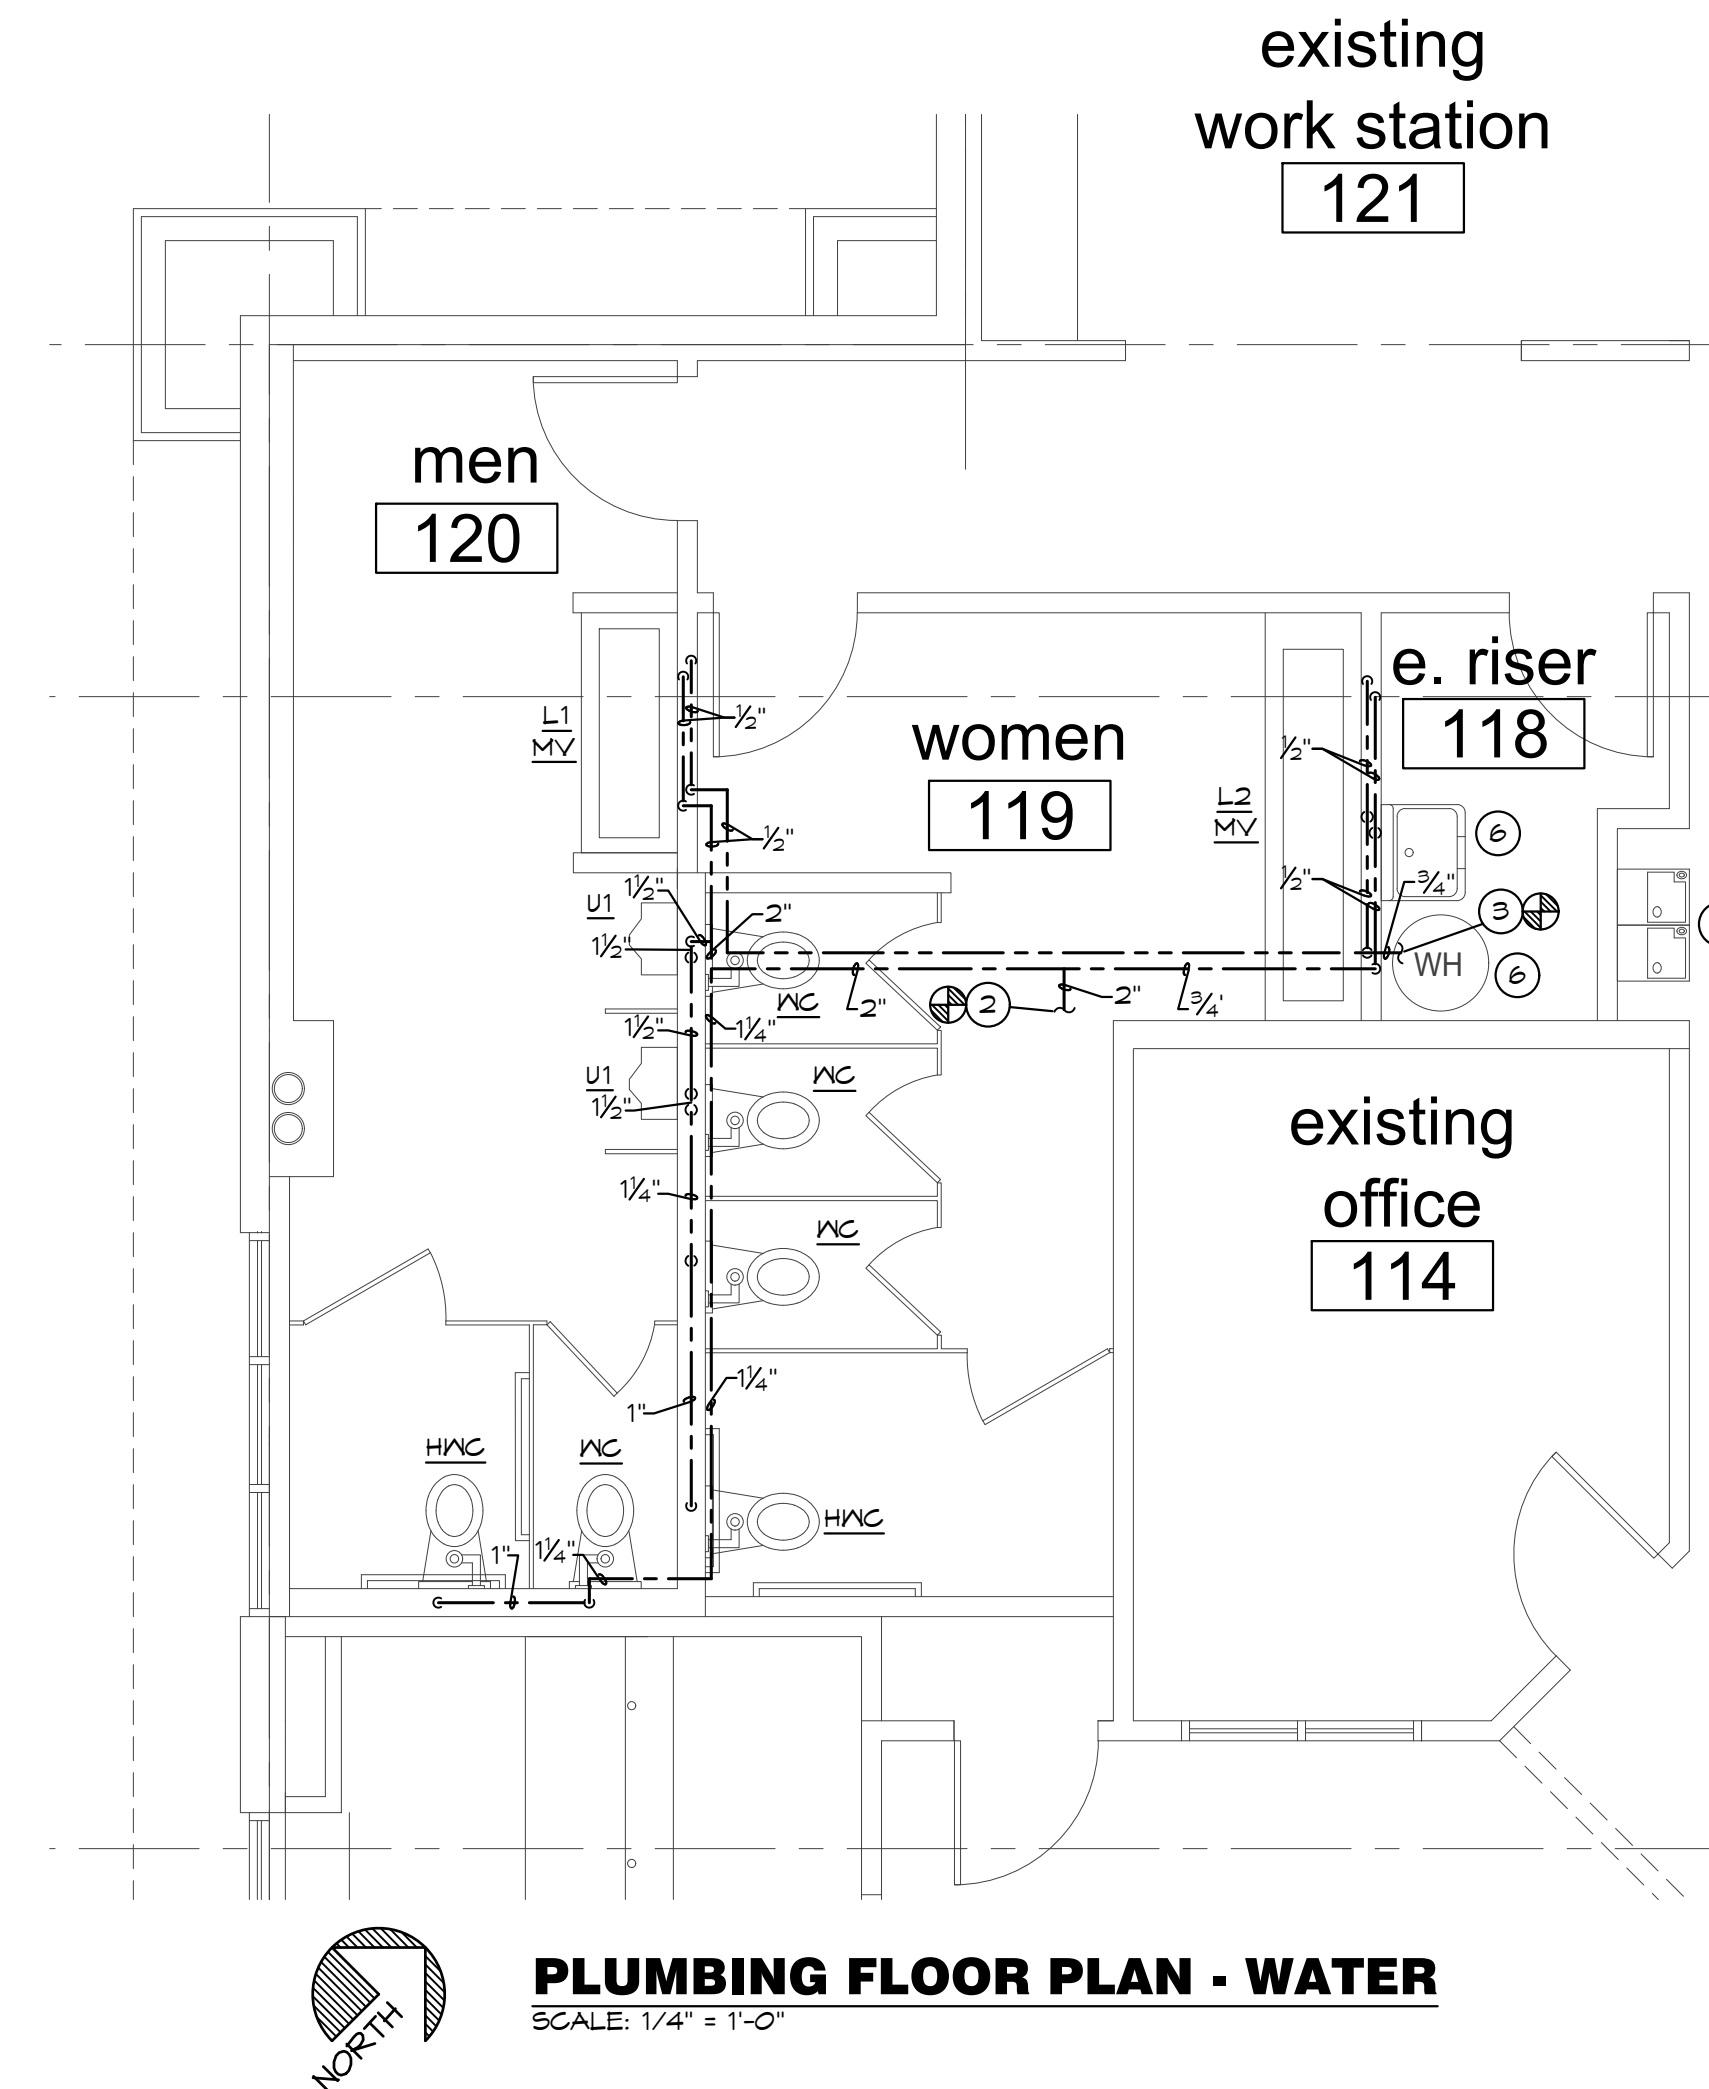

a building addition for
Lee's Summit Subaru
2101 NE Independence Ave.
Lee's Summit, Missouri 64064

date 09.21.2023
drawn by JS
checked by EK
revisions



MISSOURI PE COA #2009003629
This drawing has been prepared by the Engineer, or under his supervision. This drawing is provided as an instrument of service by the Designer/Engineer and is intended for use on the project only. Pursuant to the Architectural Works Copyright Protection Act of 1990, all drawings, specifications, ideas and designs, including the overall form, arrangement and composition of space and elements appearing herein, constitute the original, copyrighted work of the Designer/Engineer. Any reproduction, use, or disclosure of information contained herein without prior written consent of the Engineer is strictly prohibited. © 2023 BC Engineers, Inc.

Taylor Mechanical, Inc.
P.O. Box 2064
Lee's Summit, MO 64063

BC ENGINEERS
INCORPORATED

5720 Reeder Shawnee, Ks. 66203 (913)262-1772

sheet number

P1.0

drawing type
Permit

project number
23144



4301 Indian Creek Parkway
Overland Park, KS 66207
phone: 813.451.8360
www.davidsonae.com

PLUMBING SYMBOLS

	SOIL AND WASTE PIPING BELOW FLOOR/GRADE
	SOIL AND WASTE PIPING ABOVE FLOOR/GRADE
	SANITARY VENT PIPING ABOVE GRADE
	SANITARY VENT PIPING BELOW GRADE
	DOMESTIC COLD WATER PIPING
	DOMESTIC HOT WATER PIPING
	PIPING TURNING DOWN
	PIPING TURNING UP
	TEE TOP CONNECTION
	UNION
	BACKFLOW PREVENTER
	FLOOR DRAIN
	FLOOR CLEAN OUT
	WALL CLEAN OUT
	VALVE
	CONNECT TO EXISTING
	INVERT ELEVATION OF PIPE
	MATCH MARKS ON PLUMBING RISER DIAGRAM

PLUMBING FIXTURE SCHEDULE (OR EQUAL):

HWC	WATER CLOSET (HANDICAPPED); AMERICAN STANDARD, #3043.001 "MADERA ADA", VITREOUS CHINA, FLOOR MOUNTED, FLOOR OUTLET, 16-1/2" HIGH ELONGATED BOWL, SIPHON-JET ACTION, SLOAN G2 SENSOR, #8111-1.28 FLUSH VALVE, 1.28 GAL/FLUSH, BATTERY POWERED, BEMIS #105555G OPEN FRONT ELONGATED SEAT WITH CHECK HINGE. HANDLE ON WIDE SIDE OF FIXTURE.
WC	WATER CLOSET; AMERICAN STANDARD, #2234.001 "MADERA", VITREOUS CHINA, FLOOR MOUNTED, FLOOR OUTLET, ELONGATED BOWL, SIPHON-JET ACTION, SLOAN G2 SENSOR, #8111-1.28 FLUSH VALVE, 1.28 GAL/FLUSH, BATTERY POWERED, BEMIS #105555G OPEN FRONT ELONGATED SEAT WITH CHECK HINGE.
U1	URINAL, WALL HUNG; AMERICAN STANDARD, #6590.001 "WASHBROOK", VITREOUS CHINA, 1.0 GPM WASH OUT ACTION, WALL HUNG URINAL WITH 3/4" TOP SPUD, SLOAN SENSOR #8186-1.0 FLUSH VALVE, 1.0 GAL/FLUSH, BATTERY POWERED, FLOOR MOUNTED FIXTURE SUPPORT. SET RIM HEIGHT PER ARCHITECTURAL DRAWINGS.
L1	HANDICAP LAVATORY, WALL HUNG; SLOAN, #D56-82000, "DESIGNER SERIES", 60"X 22"X5", CORIAN OR CORTZ, (2) SLOAN #EAF250-CP-FCTS "OPTIMA" SENSOR BATTERY POWERED FAUCET #T123.018 OFFSET GRID ELBOW DRAIN AND 1-1/4" TAILPIECE, CHROME PLATED CAST BRASS P-TRAP WITH CLEANOUT (MOUNTED PARALLEL WITH WALL), CHROME PLATED ANGLE STOPS AND RISERS, AND CONCEALED ARM FLOOR MOUNTED FIXTURE SUPPORT. INSULATE EXPOSED DRAIN, WATER SUPPLIES, AND VALVES WITH PROWRAP SEAMLESS MOLDED CLOSED CELL VINYL INSULATION.
L2	HANDICAP LAVATORY, WALL HUNG; SLOAN, #D56-83000, "DESIGNER SERIES", 90"X 22"X5", CORIAN OR CORTZ, (3) SLOAN #EAF250-CP-FCTS "OPTIMA" SENSOR BATTERY POWERED FAUCET (2)#T123.018 OFFSET GRID ELBOW DRAIN AND 1-1/4" TAILPIECE, (2)CHROME PLATED CAST BRASS P-TRAP WITH CLEANOUT (MOUNTED PARALLEL WITH WALL), (2)CHROME PLATED ANGLE STOPS AND RISERS, AND CONCEALED ARM FLOOR MOUNTED FIXTURE SUPPORT. INSULATE EXPOSED DRAINS, WATER SUPPLIES, AND VALVES WITH PROWRAP SEAMLESS MOLDED CLOSED CELL VINYL INSULATION.
MV	MIXING VALVE; POWERS, #LFE480 THERMOSTATIC CONTROLLED MIXING VALVE, LEAD FREE BRONZE BODY, LOCKED TEMPERATURE ADJUSTMENT CAP (VANDAL RESISTANT), SOLID MAX HYDRAULIC PRINCIPLE THERMOSTAT, INTEGRAL FILTER WASHERS AND CHECK VALVES ON HOT AND COLD INLETS. (SET TO 105°F) ASSE #1070.
FD	FLOOR DRAIN; JR SMITH, #2005-A, CAST IRON FLOOR DRAIN WITH ADJUSTABLE TOP, 6" NIKALLOY STRAINER. PROVIDE WITH #2642 QUAD CLOSE TRAP SEAL DEVICE.
FCO/MCO	VINYL TILE FLOOR: JR SMITH #4140, OR EQUAL. QUARRY TILE FLOOR: JR SMITH #4200, OR EQUAL. CARPETED FLOOR: JR SMITH #4020-Y, OR EQUAL. UNFINISHED FLOOR: JR SMITH #4020, OR EQUAL. WALL: JR SMITH #44T2, OR EQUAL, 24" ABOVE THE FLOOR.

PLUMBING GENERAL NOTES:

- INSTALL ALL PIPE, ETC. AS HIGH AS POSSIBLE.
- COORDINATE ALL WORK WITH OTHER TRADES AND EXISTING CONDITIONS AS REQUIRED TO PROPERLY INSTALL ALL SYSTEMS AS INTENDED, WITHIN THE CONFINES OF THE SPACES AVAILABLE, AND WITHOUT INTERFERENCES.
- REFER TO ARCHITECTURAL DRAWINGS FOR EXACT LOCATIONS AND MOUNTING HEIGHTS OF FIXTURES.
- REFER TO ARCHITECTURAL & STRUCTURAL DRAWINGS FOR REQUIREMENTS FOR SUPPORTING PIPING, EQUIPMENT, ETC. FROM THE STRUCTURE. PROVIDE ADDITIONAL STEEL AS REQUIRED TO PROPERLY SUPPORT SYSTEMS FROM THE STRUCTURE.
- SAWCUT EXISTING FLOOR AS REQUIRED FOR INSTALLATION OF UNDERFLOOR PIPING. PATCH FLOOR TO MATCH EXISTING.
- NO PIPING SHALL BE ROUTED OVER THE TOP OF ELECTRICAL PANELS.
- ALL MATERIALS WITHIN PLENUMS SHALL BE NONCOMBUSTIBLE OR SHALL HAVE A FLAME SPREAD INDEX OF NOT MORE THAN 25 AND A SMOKE-DEVELOPED INDEX OF NOT MORE THAN 50 WHEN TESTED IN ACCORDANCE WITH ASTM E 84.
- CONTRACTOR TO TEST WATER PRESSURE ON SITE AND PROVIDE PRESSURE REDUCING VALVE ON WATER SERVICE IF PRESSURE IS OVER 80 PSI.

PIPE HANGER SCHEDULE

PIPE MATERIAL	MAXIMUM HANGER SPACING	HANGER ROD DIAMETER
ABS (All sizes)	4'	3/8"
PVC (All Sizes)	4'	3/8"
CPVC, 1 inch and smaller	3'	1/2"
CPVC, 1-1/4 inches and larger	4'	1/2"
Cast Iron (All Sizes)	5'	5/8"
Cast Iron (All Sizes) with 10 Foot length of pipe	10'	5/8"
Copper Tube, 1-1/4 inches and smaller	6'	1/2"
Copper Tube, 1-1/2 inches and larger	10'	1/2"
Steel, 3 inches and smaller	12'	1/2"
Steel, 4 inches and larger	12'	5/8"
Pex, 1" and below without support channel	32"	3/8"
Pex, 1-1/4" and above without support channel	48"	3/8"
Pex 3/4" and below with support channel	6'	3/8"
Pex 1" and above with support channel	8'	3/8"

MISSOURI PE COA #2009003629

This drawing has been prepared by the Engineer, or under his supervision. This drawing is provided as an instrument of service by the Design/Engineer and is intended for use on the project only. Pursuant to the Architectural Works Copyright Protection Act of 1990, all drawings, specifications, ideas and designs, including the overall form, arrangement and composition of spaces and elements appearing herein, constitute the original, copyrighted work of the Design/Engineer. Any reproduction, use, or disclosure of information contained herein without prior written consent of the Engineer is strictly prohibited. © 2023 DE Engineers, Inc.

BC ENGINEERS INCORPORATED

5720 Reeder Shawnee, Ks. 66203 (913)262-1772

Taylor Mechanical, Inc.
P.O. Box 2064
Lee's Summit, MO 64063

a building addition for

Lee's Summit Subaru

2101 NE Independence Ave.

Lee's Summit, Missouri 64064

date 09.21.2023
drawn by JS
checked by EK
revisions




sheet number


P2.0

drawing type Permit

project number 23144

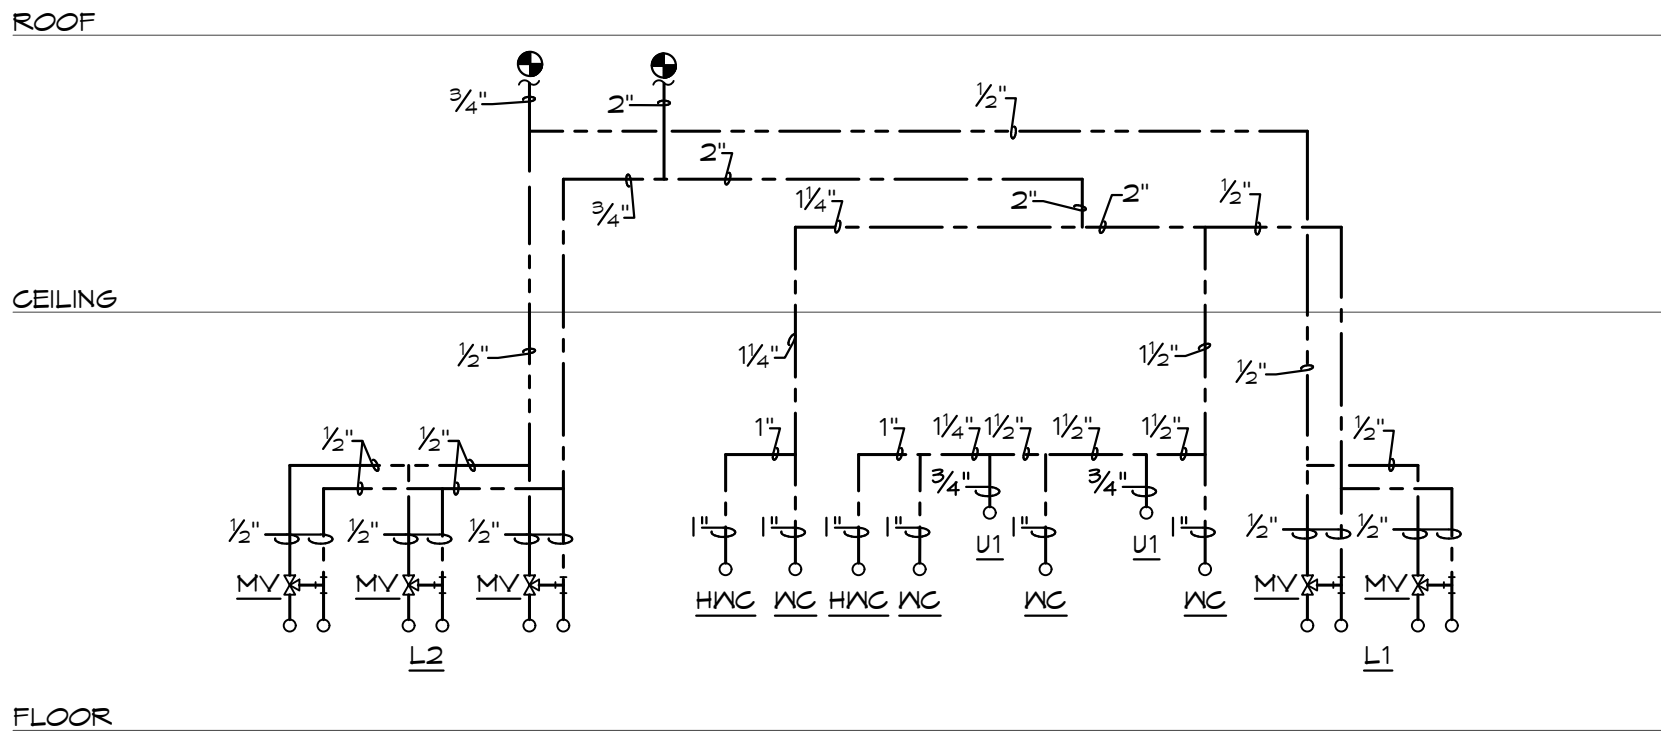

HOT & COLD WATER

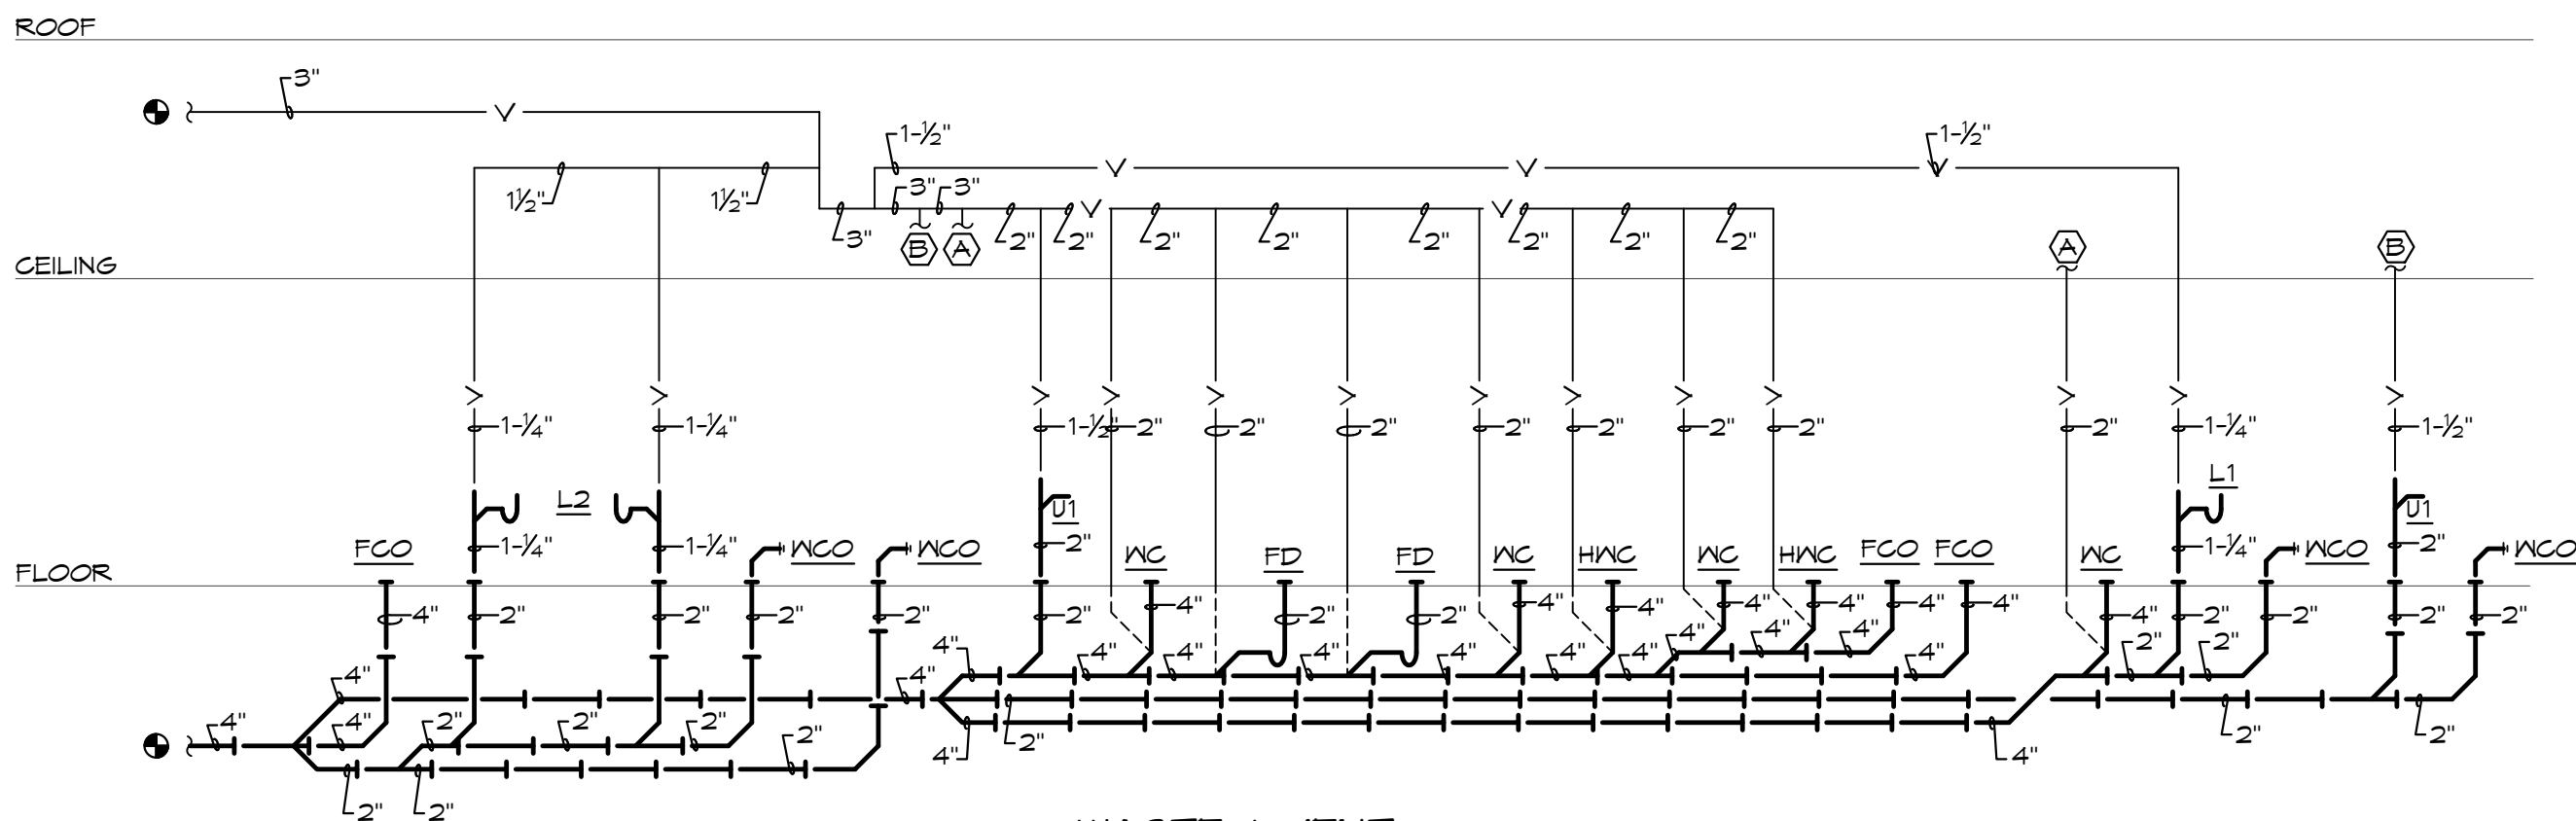

WASTE & VENT

PLUMBING RISER DIAGRAMS

SCALE: NONE

PEX PIPING REQUIREMENTS

PIPE SIZES GIVEN ON THE DRAWINGS ARE NOMINAL COPPER PIPE SIZE. IF PEX PIPING IS USED, INCREASE PEX PIPING ONE SIZE ABOVE LISTED SIZES AS REQUIRED TO EQUAL OR EXCEED COPPER PIPE INSIDE DIAMETER.

PLUMBING FIXTURE BRANCH PIPING SCHEDULE

FIXTURE	WASTE	VENT	C/W	H/W
WATER CLOSET (FLUSH VALVE)	4"	2"	1"	--
URINAL	2"	1-1/2"	3/4"	--
LAVATORY	1-1/4"	1-1/4"	1/2"	1/2"
FLOOR DRAIN	2"	2"	--	--


NOTE: INDIVIDUAL VENTS FOR FIXTURES ON PLANS AND RISER DIAGRAM HAVE BEEN INCREASED WHERE HORIZONTAL VENT LENGTH IS IN EXCESS OF THE MAXIMUM DISTANCE INDICATED BY THE CODE.

RETAIL FIRE PROTECTION NOTES:

- THE EXISTING SPACE IS PROTECTED WITH AN EXISTING WET PIPE SPRINKLER SYSTEM. RELOCATE AND PROVIDE ADDITIONAL SPRINKLER HEADS AND PIPING AS REQUIRED FOR THE NEW CONSTRUCTION. SPRINKLER HEADS IN FINISHED CEILINGS SHALL BE SEMI-RECESSED PENDENT TYPE (VERIFY FINISH). SPRINKLER HEADS IN ROOMS WITHOUT CEILINGS SHALL BE UPRIGHT BRASS TYPE HEADS.
- SPRINKLER WORK SHALL BE PERFORMED BY A LICENSED SPRINKLER CONTRACTOR PRE-APPROVED BY THE OWNER/LANDLORD.
- REFER TO THE ARCHITECTURAL DRAWINGS FOR NEW WALL CONSTRUCTION.
- SPRINKLER PIPING SHALL MATCH EXISTING AND COMPLY WITH NFPA 13.
- SPRINKLER SYSTEM (SHOP DRAWINGS) SHALL BE APPROVED BY THE LOCAL FIRE AUTHORITY AND OWNER'S/LANDLORD'S INSURANCE CARRIER PRIOR TO START OF WORK.
- TENANT DEMISING WALLS ARE BEING MODIFIED. REZONE SPRINKLER SYSTEM AS NECESSARY SO TENANT(S) SHALL HAVE SINGLE ZONE FOR TENANT SPACE(S).



4301 Indian Creek Parkway
Overland Park, KS 66207
phone: 813.421.9360
fax: 813.421.9391
www.davidsonae.com

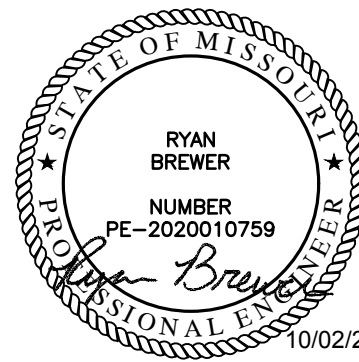

a building addition for
Lee's Summit Subaru
2101 NE Independence Ave.
Lee's Summit, Missouri 64064

date

drawn by

checked by

revisions



sheet number

E3.2

drawing type
preliminary

project number
23144

WIRING OF MECHANICAL EQUIPMENT
PROVIDE ALL RACEWAYS AND POWER WIRING FOR ALL DIVISION 15 EQUIPMENT
REQUIRING ELECTRICAL CONNECTIONS, INCLUDING, BUT NOT LIMITED TO, PUMPS,
WATER HEATERS, AND HVAC EQUIPMENT, AND ALL LINE-VOLTAGE CONTROL AND
INTERLOCK WIRING NOT PROVIDED UNDER DIVISION 15. CONNECT PER
MANUFACTURER'S WIRING DIAGRAMS. COORDINATE WITH DIVISION 15 FOR
DISCONNECTS FURNISHED WITH EQUIPMENT, AND PROVIDE ALL DISCONNECT
SWITCHES AS REQUIRED. AFTER INSTALLING WIRING, VERIFY THAT EACH MOTOR
LOAD HAS THE CORRECT PHASE ROTATION.

VERIFY THE ACTUAL "MAXIMUM OVERCURRENT PROTECTION" DEVICE RATINGS
AND "MINIMUM CIRCUIT AMPACITY" CONDUCTOR SIZING FOR MECHANICAL
EQUIPMENT FROM THE EQUIPMENT NAMEPLATE. BASE ELECTRICAL
INSTALLATIONS ON ACTUAL REQUIRED AMPERAGES, WHICH MAY VARY
SOMEWHAT FROM THE CONDUCTOR AND EQUIPMENT SIZES SHOWN ON THE
DRAWINGS; HOWEVER, IN NO CASE, REDUCE THE SIZE OF CONDUCTORS
INDICATED ON THE DRAWINGS WITHOUT AUTHORIZATION FROM THE ENGINEER.
PROVIDE PROPERLY SIZED ELECTRICAL WIRING AND EQUIPMENT WITHOUT EXTRA
COST TO THE OWNER. NOTIFY THE ENGINEER OF ALL CHANGES REQUIRED IN THE
ELECTRICAL INSTALLATION DUE TO EQUIPMENT VARIANCES SO THAT THE
EFFECTS ON FEEDERS, BRANCH CIRCUITS, PANELBOARDS, FUSES AND CIRCUIT
BREAKERS CAN BE CHECKED PRIOR TO PURCHASING AND INSTALLATION. BE
RESPONSIBLE FOR COORDINATING WITH DIVISION 15 TO VERIFY THE ACTUAL
AMPACITIES AND CORRECT SIZES OF ALL CONDUCTORS AND OVERCURRENT
PROTECTIVE DEVICES FOR ALL EQUIPMENT, AND CORRECT OVERLOAD HEATERS
FOR ALL MOTORS, WHEN STARTERS ARE PROVIDED UNDER DIVISION 16.

PROVIDE ALL RACEWAYS, POWER WIRING, AND LINE-VOLTAGE CONTROL AND
INTERLOCK WIRING NOT PROVIDED UNDER DIVISION 15, FOR ALL THERMOSTATS,
TEMPERATURE CONTROL DEVICES, AND CONTROLS, INCLUDING, BUT NOT LIMITED
TO, NIGHT-STATS, WATER HEATER INTERLOCKS, TIME SWITCHES AND OVERRIDE
TIMERS. SEE MECHANICAL DRAWINGS FOR LOCATIONS AND TEMPERATURE
CONTROL DIAGRAM. LOW-VOLTAGE CONDUCTORS FOR THERMOSTATS AND
TEMPERATURE CONTROL SYSTEMS MAY BE RUN EXPOSED ABOVE FINISHED
ACCESSIBLE CEILINGS, IF APPROVED AND LISTED FOR THIS PURPOSE, BUT SHALL
BE INSTALLED IN CONDUIT WITHIN WALLS AND WHERE EXPOSED IN THE WORK
AREAS.

EXECUTION

METHOD OF PROCEDURE
ERECT EQUIPMENT PARTS AT SUCH TIME AND IN SUCH MANNER AS TO MINIMIZE
INTERFERENCES AND DELAYS IN THE EXECUTION OF THE WORK CARE SHALL BE
USED IN THE ERECTION AND INSTALLATION OF ALL EQUIPMENT AND MATERIALS
TO AVOID MARRING SURFACES OF THE WORK. DAMAGES SHALL BE REPAIRED AT
NO ADDITIONAL COST TO THE OWNER.

EQUIPMENT REQUIRING ELECTRICAL SERVICE SHALL NOT BE ENERGIZED OR
PLACED IN SERVICE UNTIL ALL INTERESTED PARTIES HAVE BEEN DULY NOTIFIED
AND ARE PRESENT OR HAVE WAIVED THEIR RIGHT TO BE PRESENT. WHERE
EQUIPMENT TO BE PLACED IN SERVICE INVOLVES SERVICE OR CONNECTION
FROM ANOTHER CONTRACTOR OR THE OWNER, NOTIFY THE OWNER IN WRITING
WHEN THE EQUIPMENT WILL BE READY. THE OWNER SHALL BE NOTIFIED AS FAR
IN ADVANCE AS POSSIBLE, OF THE DATE THE VARIOUS ITEMS OF EQUIPMENT WILL
BE COMPLETE.

THE WORK OF THIS TRADE INCLUDES ROUGH-IN FOR AND FINAL CONNECTION AND
REQUIRED TO ALL MISCELLANEOUS EQUIPMENT FURNISHED BY OTHERS, OR
UNDER OTHER DIVISIONS OF THE WORK. THIS SHALL INCLUDE POWER AND
CONTROL WIRING, WIRING DEVICES AND COVER PLATES FOR BUILT-IN
EQUIPMENT ARE INCLUDED IN THE WORK OF THIS DIVISION. SAFETY
DISCONNECTS AND OTHER MISCELLANEOUS PROTECTIVE DEVICES REQUIRED BY
N.E.C. ARE INCLUDED IN THE WORK OF THIS DIVISION. DO ALL ROUGHING-IN AND
FINAL CONNECTIONS FROM APPROVED SHOP DRAWINGS ONLY.

COMPLIANCE WITH THE DRAWING AND ANY NOTES THEREON IS REQUIRED.
PROVIDE OPENINGS THROUGH WALLS, PARTITIONS, FLOORS, AND ROOFS AS
REQUIRED FOR ELECTRICAL WORK.

PROVIDE SLEEVES FOR ELECTRICAL WORK PASSING THROUGH WALLS,
PARTITIONS, ROOFS, AND FLOORS. SLEEVES SHALL EXTEND THROUGH FLOORS,
WALLS AND PARTITIONS AND SHALL BE CUT FLUSH WITH EACH SURFACE UNLESS
OTHERWISE SPECIFIED. FIRE WALL AND/OR FLOOR INTEGRITY SHALL BE
RESTORED AFTER PENETRATION. SLEEVES IN CONCRETE AND MASONRY WALLS,
CONCRETE FLOORS AND ROOFS SHALL BE FABRICATED FROM STANDARD
GALVANIZED STEEL PIPE WITH ENDS FINISHED SMOOTH, BURR FREE, WITHOUT
SHARP EDGES. SLEEVES IN WALLS, ROOFS, AND FLOORS OF OTHER
CONSTRUCTION AND THROUGH SUSPENDED CEILINGS SHALL BE FABRICATED
FROM 22 U.S. GAUGE GALVANIZED STEEL. FLOOR SLEEVES SHALL EXTEND THREE
INCHES ABOVE FINISHED FLOOR UNLESS OTHERWISE NOTED. SPACE BETWEEN
FLOOR SLEEVES AND PASSING CONDUIT SHALL BE FILLED WITH DUCT SEAL
PACKING AND CAULKED WITH WATERPROOF COMPOUND AS APPROVED. WHERE
CONDUITS PASS THROUGH WATERPROOFED FLOORS OR WALLS, SLEEVES SHALL
BE FABRICATED SUCH THAT WATERPROOFING CAN BE FLASHED ONTO AND
AROUND THE SLEEVE.

RACEWAYS
ALL POWER AND LIGHTING CIRCUITS SHALL BE RUN IN METALLIC RACEWAYS
EXCEPT WHERE SPECIFICALLY NOTED OTHERWISE. THESE RACEWAYS SHALL BE
RUN CONCEALED IN ALL FINISHED AREAS, AND WHERE RUN EXPOSED SHALL BE
SQUARE TO THE BUILDING AND HELD TIGHT TO THE BUILDING CONSTRUCTION.
LOW VOLTAGE, TELEPHONE, INTERCOM, MUSIC, ALARM AND SECURITY WIRING
RUN ABOVE ACCESSIBLE CEILINGS SHALL BE RUN USING INSULATED, PLENUM
RATED CABLE. PROVIDE LOW VOLTAGE CABLE IN CONDUIT IF REQUIRED BY LOCAL
A.H.J. VERIFY ALL REQUIREMENTS PRIOR TO INSTALLATION. METALLIC CONDUIT
FOR THESE SYSTEMS SHALL BE PROVIDED ONLY WHERE RUN INSIDE WALLS. THE
DRAWINGS INDICATE THE REQUIRED SIZE OF ALL RACEWAYS (EXCEPT AS
HEREINAFTER SPECIFIED), THE POINTS OF TERMINATION AND THE SUGGESTED
ROUTING. HOWEVER, THE INSTALLER IS RESPONSIBLE FOR PROPER
COORDINATION WITH BUILDING STRUCTURE AND THE WORK OF OTHER TRADES.
FURNISH ALL REQUIRED BENDS, ELBOWS, FITTINGS, JUNCTION AND PULL BOXES,
WHETHER OR NOT SPECIFICALLY SHOWN ON DRAWINGS, THAT MAY BE REQUIRED
TO SATISFY CODES AND THE STANDARDS OF GOOD PRACTICE. WHERE CONDUITS
FOR BOTH BRANCH AND FEEDER CIRCUITS ARE RUN CONCEALED, THEY MAY BE
RUN OUT OF SQUARE TO THE BUILDING PROVIDING THE SHORTEST POSSIBLE RUN
IS UTILIZED. RACEWAY SIZES ARE BASED ON THE USE OF COPPER CONDUCTORS
AND N.E.C. FILL.

CONDUIT SHALL BE CONSTRUED AS ELECTRICAL RACEWAYS AND SHALL
CONFORM TO THE FOLLOWING: CONCEALED IN SUSPENDED CEILINGS AND
INTERIOR PARTITIONS - EMT WITH SET SCREW TYPE FITTINGS. UNDERGROUND
OR BELOW INTERIOR SLABS - GRS. (NOTE: PVC CONDUIT IS PERMITTED OUTSIDE
FOR PARKING AREA LIGHTING, SIGNS, ETC. ELBOWS SHALL BE GRS). EXPOSED ON
BUILDING EXTERIOR - GRS.

CONDUIT BENDS SHALL BE MADE TO THE LARGEST POSSIBLE RADIUS FOR EASE IN
PULLING CONDUCTORS AND TO PROVIDE A NEATLY INSTALLED APPEARANCE.
EQUIPMENT AND CONDITIONS PERMITTING, POWER CONDUIT BENDS SHALL
CONFORM TO THE FOLLOWING: 1-1/2 IN. - 18 IN. RADIUS; 2 IN. - 24 IN. RADIUS; 1-2
IN. - 24 IN. RADIUS; 3 IN. - 36 IN. RADIUS.

GRS CONDUIT SHALL BE CUT WITH POWER OR HACKSAW AND CLEANLY REAMED

TO REMOVE ALL "BURRS" AND ALL FIELD CUT THREADS SHALL BE PAINTED WITH
WHITE LEAD BEFORE COUPLINGS ARE APPLIED.

EMPTY CONDUIT SYSTEMS INSTALLED FOR COMMUNICATION SYSTEMS, PUBLIC
TELEPHONES, OWNER ITEMS AND OTHER SYSTEMS AS INDICATED ON DRAWINGS
SHALL BE INSTALLED COMPLETE WITH NYLON PULL WIRES PROPERLY TAGGED AT
BOTH ENDS FOR IDENTIFICATION.

WHERE BUILDING VENTILATION CONDITIONS ARE SUCH THAT AIR MAY FLOW
CONTINUOUSLY IN CONDUITS, CAUSING CONDENSATION AND THE COLLECTION OF
MOISTURE, THE CONDUITS SHALL BE SEALED AT EACH END WITH A PLIABLE X
DUCT SEALING COMPOUND. ALSO SEAL ALL CONDUITS ENTERING AND LEAVING
REFRIGERATED EQUIPMENT AND PROVIDE EXPANSION JOINTS PER N.E.C.

ALL CONNECTIONS TO MOTORS, SOLENOID VALVES, PRESSURE SWITCHES, LIMIT
SWITCHES, AND SIMILAR APPARATUS SHALL BE FLEXIBLE CONDUIT WHERE
PERMITTED. WHERE EQUIPMENT IS INSTALLED OUTDOORS OR EXPOSED TO
MOISTURE, USE LIQUIDTIGHT FLEXIBLE CONDUIT WITH WATERTIGHT FITTINGS.

EQUIPMENT LEVELING, HANGERS AND SUPPORTS
SET EACH PIECE INSTALLED UNDER THIS DIVISION TRUE AND LEVEL.
ADEQUATELY SUPPORT ALL RACEWAYS FROM THE STRUCTURE USING SCREW
CLAMPS TO SECURE TO SAME. ARRANGE SUPPORTS TO PREVENT MOISTURE
COLLECTION AND ALLOW ENTRANCE TO BOXES WITHOUT BENDS. INSTALL
MULTIPLE CONDUITS USING CHANNEL TRAPEZE SUPPORTS TIGHT TO STRUCTURE
ABOVE. USE APPROVED SPACERS TO INSULATE FROM CONTACT WITH BUILDING.
SIZE CLAMPS, INSERTS, CHANNELS AND ALL OTHER MEMBERS TO SUPPORT A
LOAD EQUAL TO 200% OF THE COMBINED WEIGHT OF ALL SUPPORTED MATERIAL
PLUS THE WEIGHT OF A MAN.

WHERE SEVERAL RACEWAYS ARE SUPPORTED ON A COMMON TRAPEZE HANGER,
SUPPORTS SHALL BE SPACED TO ACCOMMODATE THE SMALLEST SIZE RACEWAY
INVOLVED. SPACE HANGERS AS FOLLOWS:
RIGID CONDUIT: 1/2 AND 3/4 IN. SIZE; 6'-0" ON CENTERS; 1 AND 1-1/4 IN. SIZE; 9'-0"
ON CENTERS
ELECTRIC METALLIC TUBING:
1/2 AND 3/4 IN. SIZE; 5'-0" ON CENTERS; 1 AND 1-1/4 IN. SIZE; 6'-0" ON CENTERS.

SECURELY ATTACH HANGERS AND SUPPORTS TO CONSTRUCTION BY METHODS
RECOMMENDED IN THE "NECA STANDARDS OF INSTALLATION" MANUAL
COORDINATION WITH MECHANICAL TRADES: THE INTENT OF THE ABOVE CEILING
SUPPORTS IS TO COMBINE AS MANY PIPES, CONDUITS, ETC., AS IS POSSIBLE
WITHIN SAFE STRUCTURAL LIMITS, ON EACH HORIZONTAL SECTION OF A TRAPEZE
HANGER. PRIOR TO SELECTING THE HORIZONTAL MEMBER, ALL TRADES,
MECHANICAL AND ELECTRICAL, SHALL COORDINATE ACTUAL NUMBER OF PIPES,
CONDUITS, ETC., SUCH THAT FINAL SELECTION RESULTS IN A NEATLY GROUPED,
DISCIPLINED AND ACCESSIBLE INSTALLATION.

WIRING INSTALLATION
EXCEPT FOR SUCH ITEMS AS ARE NORMALLY WIRED AT THEIR POINT OF
MANUFACTURE AND SO DELIVERED - AND UNLESS SPECIFICALLY NOTED TO THE
CONTRARY HEREIN - THE ELECTRICAL TRADE SHALL DO ALL ELECTRICAL WIRING
OF EVERY CHARACTER. IT IS THE INTENT OF THESE SPECIFICATIONS AND
DRAWINGS THAT ALL SYSTEMS AND EQUIPMENT SHALL BE PROVIDED WITH ALL
NECESSARY UTILITY CONNECTIONS, COMPLETED TO ALLOW SAFE AND PROPER
OPERATION OF SAID SYSTEMS, WHEN IT IS NECESSARY FOR TRADES
PERFORMING WORK COVERED BY THIS DIVISION TO MAKE FINAL CONNECTIONS
TO ITEMS OF EQUIPMENT BEING FURNISHED BY OTHERS, OR BY OTHER TRADES
UNDER OTHER DIVISIONS, ALL SUCH WORK SHALL BE PERFORMED IN
ACCORDANCE WITH THE REQUIREMENTS OF THIS DIVISION AND ALL MATERIALS
USED SHALL BE AS SPECIFIED HEREIN.

MINIMUM WIRE SIZE FOR BRANCH CIRCUITS SHALL BE #12 AWG, EXCEPT THAT
HOMERUNS LONGER THAN 100 FT. LENGTH FROM THE PANEL TO THE CIRCUITS
ELECTRICAL LOAD CENTER SHALL BE #10 AWG MINIMUM. WHERE RUNS EXCEED
150', CONTRACTOR MUST ENSURE WIRE SIZE BEING UTILIZED DOES NOT CREATE
A VOLTAGE DROP GREATER THAN 3%. REQUEST PROPER WIRE SIZE PRIOR TO
INSTALLATION IF A 3% VOLTAGE DROP MAY OCCUR FOR ANY BRANCH CIRCUIT.
WHERE MORE THAN THREE CURRENT CARRYING CONDUCTORS ARE ENCLOSED IN
THE SAME RACEWAY, CONDUCTORS ARE TO BE DERATED PER N.E.C. AND WIRE
SIZE INCREASED AS REQUIRED. WHERE THE INCREASED CONDUCTOR SIZE
REQUIRES, INCREASE THE RACEWAY SIZE AS WELL. FOR CONTROL WIRING, USE
#14 AWG MINIMUM. FOR FIXTURE WIRING, AS PERMITTED BY N.E.C., USE #18 AWG
MINIMUM. FOR SIGNAL AND COMMUNICATIONS SYSTEMS USE WIRE SIZE AS
SPECIFICALLY REQUIRED BY THE SYSTEM SUPPLIER.

MAKE CONNECTIONS TO TERMINALS USING PRESSURE TYPE CONNECTORS.
SOLDERED JOINTS ARE PROHIBITED. ALL JOINTS IN CONDUCTORS SHALL BE
MADE AT AN ACCESSIBLE LOCATION WITHIN A BOX BY TWISTING THE BARE
CONDUCTOR ENDS TOGETHER AND APPLYING A WIRE CONNECTOR IN ALL SIZES
UP TO THE MAXIMUM CAPACITY OF THE CONNECTOR. JOINTS SHALL BE TAPED
WITH AN APPROVED ELECTRICAL TAPE. SPLICES FOR CONDUCTORS LARGER
THAN #10 AWG SHALL BE MADE WITH AN APPROVED COMPRESSION (SQUEEZE)
CONNECTOR INSULATED WITH NOT LESS THAN TWO LAYERS OF ELECTRICAL FILL
TAPE TO 1.5 TIMES THE THICKNESS OF INSULATION, FOLLOWED BY TWO
(MINIMUM) LAYERS OF HALF-LAPPED ELECTRICAL TAPE FOR MECHANICAL
PROTECTION. LOCATE ALL SPLICES IN BOXES OR FITTINGS OF PROPER SIZE PER
N.E.C.

IDENTIFY ALL WIRES AND CABLES WITH BRADY ADHESIVE WIRE MARKERS AT
EACH BOX, PANEL, AND OUTLET. IDENTIFICATION SHALL, AS A MINIMUM, INDICATE
THE PANEL AND CIRCUIT SUPPLYING THE OUTLET. AT THE PANEL END, THE LOAD
SERVED AND ITS LOCATION SHALL BE INDICATED. PROVIDE A MINIMUM OF 8 IN.
SLACK WIRE AT EACH OUTLET FOR MAKING CONNECTION TO THE DEVICE OR TO
PROVIDE FOR A FUTURE DEVICE IN THE BOX.

BOXES
EACH BOX SHALL BE OF PROPER SIZE TO ACCOMMODATE THE DEVICE AND
FUNCTION FOR WHICH IT IS SHOWN. BOXES FOR WALL DEVICES SHALL BE
FURNISHED COMPLETE WITH PLASTER RING OR TILE RING ACCORDING TO WALL
CONSTRUCTION WHERE REQUIRED. BOXES FOR INSTALLATION IN MASONRY
WALLS SHALL BE SPECIAL SQUARE CORNER MASONRY TYPE. BOXES FOR
MOUNTING OF LIGHTING FIXTURES SHALL BE FOUR INCH OCTAGON, EQUIPPED
WITH 3/8 IN. "NO-BOLT" FIXTURE STUD. BOXES FOR FLOOR OUTLETS SHALL BE
CONCRETE PROOF STEEL BOXES WITH ADJUSTABLE TOPS AND DEVICES AS
HEREINAFTER NOTED OR SHOWN. ALL BOXES SHALL BE FURNISHED COMPLETE
WITH PROPER COVER AND/OR DEVICE PLATE AND DEVICE. UNLESS OTHERWISE
NOTED, PLACE OUTLET BOXES AT THE FOLLOWING HEIGHTS (BOX CENTER TO
FINISH FLOOR): WALL SWITCHES 48" AND CONVENIENCE OUTLETS 18" UNLESS
NOTED OTHERWISE ON DRAWINGS.

TELEPHONE, ALARM, AND SIGNAL SYSTEM OUTLET BOXES SHALL BE STANDARD
OUTLET BOX TYPE WHERE ONLY ONE CONDUIT ENTERS SAME. UNLESS
OTHERWISE SPECIFIED OR INDICATED ON DRAWINGS, WHERE TWO OR MORE
CONDUITS ENTER, BOX SHALL BE 4-11/16 IN. SQUARE MINIMUM WITH SUITABLE
ADAPTER RING.

LOCATE ALL OUTLETS AS INDICATED ON DRAWINGS, HOWEVER, AT INSTALLATION
INSPECT ARCHITECTURAL DRAWINGS AND LOCATE LOCAL SWITCHES ON THE
STRIKE SIDE OF THE DOOR.

SYSTEM GROUNDING

EQUIPMENT, RACEWAY SYSTEMS, WIRING SYSTEM NEUTRALS, RECEPTACLES AND
POWER OUTLETS, MOTORS AND MOTORIZED EQUIPMENT, SHALL BE GROUNDED IN
ACCORDANCE WITH N.E.C. ARTICLE 250.

GROUND RECEPTACLES AND POWER OUTLETS TO THE CONDUIT SYSTEM WITH A
GREEN GROUNDING CONDUCTOR SIZE IN ACCORDANCE WITH N.E.C. AND
CONNECTED BETWEEN THE DEVICE GROUNDING SCREW AND THE OUTLET BOX.
CONNECTION TO THE BOX MAY BE A "G" CLIP OR BY A 10/24 SCREW THREADED
INTO A HOLE IN THE BACK OF THE BOX AND USED FOR NO OTHER PURPOSE.
EQUIPMENT CONNECTED TO THE ELECTRICAL SYSTEM SHALL BE GROUNDED
WITHIN INSULATED GREEN GROUNDING CONDUCTOR SIZED IN ACCORDANCE WITH
N.E.C. AND INSTALLED WITHIN THE RACEWAY. CONDUCTOR SHALL BE
CONTINUOUS BETWEEN A GROUNDING SCREW IN THE EQUIPMENT JUNCTION BOX
AND A GROUND ATTACHMENT IN THE NEAREST OUTLET BOX IN THE
METALLIC CONDUIT SYSTEM. THIS REQUIREMENT INCLUDES ALL FLEXIBLE
CONDUIT.

GENERALLY FOR TELEPHONE AND SUPPLEMENTAL COMMUNICATION SYSTEMS NO
6 AWG CONDUCTOR TO EACH PROTECTOR CABINET, OTHER CABINET, OR DEVICE
INSTALLATION SHALL BE CONSIDERED SUFFICIENT, FROM THE SERVICE GROUND
(UNLESS INDICATED OTHERWISE).

GROUNDING MATERIAL:
GROUND-RODS - 1/2" DIA., 10' LONG, COPPERWELD
GROUND CONDUCTOR - SIZE AS PER N.E.C. REQUIREMENTS, SOFT DRAWN OR
SOFT ANNEALED, COPPER WIRE.
JOINTS AND CONNECTIONS - MOLDED FUSION WELDING PROCESS USING PROPER
MOLD AND THE NUMBER, SIZE AND TYPE CARTRIDGE FOR THE JOINT OR
CONNECTION, WATERPIPE CONNECTION, SILICON BRONZE APPROVED
MECHANICAL CONNECTOR DESIGNED FOR THE PIPE AND CABLE TO BE BONDED.

PANELBOARD INSTALLATION:
MOUNT PANELBOARDS WITH CENTERLINE AT 5 FT.-6IN. ABOVE FINISH FLOOR,
EXCEPT THAT THE HIGHEST BREAKER HANDLE SHALL BE BELOW 6 FT.-5 IN. ABOVE
FINISH FLOOR, ARRANGE BREAKERS SO THAT THE BREAKER RATING IS VISIBLE
WITH THE PANEL FRONT IN PLACE.

PANEL DIRECTORIES, AS A MINIMUM, SHALL BE TYPEWRITTEN AND INDICATE
BREAKER POSITION NUMBER AND EQUIPMENT SERVED. THE PANEL
IDENTIFICATION SHALL BE LOCATED ON THE PANEL TRIM AND SHALL CONSIST OF
A BLACK LAMINATED PHENOLIC LABEL, SCREW MOUNTED, WITH THE PANEL
IDENTIFICATION MATCHING PANEL IDENTIFICATION ON DRAWINGS. LABEL ALL
CONDUCTORS WITH ADHESIVE WRAP LABELS WITHIN 2 IN. OF THE CONDUCTOR
TERMINATION PRIOR TO INSTALLATION OF TRIM.

LIGHTING FIXTURE INSTALLATION
PROVIDE A LIGHTING FIXTURE FOR EACH AND EVERY OUTLET IN ACCORDANCE
WITH TYPE DESIGNATION AND FIXTURE SCHEDULE ON THE DRAWINGS. VERIFY
THE ARCHITECTURAL FINISHES AND CEILING CONSTRUCTION AND - REGARDLESS
OF THE CATALOG NUMBER PREFIXES AND SUFFIXES SHOWN - PROVIDE FIXTURES
WITH THE PROPER TRIM, FRAMES, SUPPORTS, AND HANGER AND OTHER
MISCELLANEOUS APPURTENANCES TO PROPERLY COORDINATE WITH SAID
FINISHES. REINFORCE CEILING CONSTRUCTION AS REQUIRED TO PROPERLY
SUPPORT THE WEIGHT OF FIXTURES INSTALLED THEREON.

IMMEDIATELY PRIOR TO FINAL INSPECTION, THOROUGHLY CLEAN ALL FIXTURES
INSIDE AND OUT, INCLUDING PLASTICS AND GLASSWARE. ADJUST TRIM TO FIT
ADJACENT SURFACES. REPLACE BROKEN OR DAMAGED PARTS. INSTALL NEW
LAMPS. ELECTRICALLY AND MECHANICALLY TEST THE SYSTEM FOR PROPER
OPERATION.

THE CONTRACTOR IS RESPONSIBLE FOR OBTAINING APPROVAL FROM LOCAL
CODE AUTHORITIES AND MAKING ANY REVISIONS DIRECTED BY THEM ON
EMERGENCY AND EXIT LIGHTING.

CLEANING
THOROUGHLY CLEAN ALL FIXTURES, SWITCHES, OTHER DEVICES, PANELBOARDS,
AND EQUIPMENT PROVIDED OR CONNECTED IN THIS CONTRACT. ALL SURFACES
SHALL BE PROPERLY POLISHED AND SHALL BE FREE OF PAINT AND ALL OTHER
DIRT OR DEBRIS. TOUCHUP OR COMPLETELY REFINISH ALL EQUIPMENT
FURNISHED WITH FACTORY FINISHES THAT IS DAMAGED DURING DELIVERY OR
CONSTRUCTION. PROPERLY PROTECT THE FRONTS OF ALL PANELBOARDS,
SWITCHBOARDS AND SIMILAR EQUIPMENT TO PREVENT MARRING AND OTHER
DEFACTING.

AT ALL TIMES, KEEP THE PREMISES FREE FROM ACCUMULATIONS OF WASTE
MATERIALS OR RUBBISH CAUSED BY THE WORK OF THE TRADESMEN DOING
ELECTRICAL WORK. AT COMPLETION OF THE WORK, REMOVE ALL RUBBISH,
TOOLS, EQUIPMENT, AND SURPLUS MATERIALS. BROOM CLEAN ALL ASSIGNED
SPACES PRIOR TO LEAVING THE PREMISES.


TESTING AND LOAD BALANCING

TEST ALL CIRCUITS TO ASSURE THEM TO BE FREE OF GROUNDS AND SHORTS,
LIGHT AND TEST EACH LAMP. PROVE AND TEST THE AVAILABLE VOLTAGE ON THE
LOAD SIDE OF EACH DISCONNECT. VERIFY PROPER OPERATION OF THE
DISCONNECT. VERIFY THE PHASE SEQUENCE, VOLTAGE, AND ROTATION AT EACH
MOTOR IN THE PRESENCE OF THE INSTALLER. RUN EACH MOTOR WITH ITS
CONTROL AS NEARLY AS POSSIBLE UNDER OPERATING CONDITIONS FOR A
SUFFICIENT LENGTH OVER TIME TO DEMONSTRATE CORRECT ALIGNMENT, WIRING
CAPACITY, SPEED, AND OVERALL SATISFACTORY OPERATION. CHECK THAT THE
PROPER OVERLOAD HEATERS HAVE BEEN INSTALLED BY READING THE MOTOR
NAMEPLATE. ADJUST THE SIZE OF THE OVERLOAD HEATER AS REQUIRED TO
MATCH THE MOTOR NAMEPLATE. OPERATE ALL MAIN AND FEEDER SWITCHES AND
BREAKERS.

THE VARIOUS BRANCH CIRCUITS SERVED FROM THE LIGHTING PANELBOARDS
VARY IN LOADING. CAREFULLY BALANCE THE ACTUAL OPERATING LOAD ON EACH
PANELBOARD WHEN ALL LOAD IS TURNED ON AND THE SYSTEM IS OPERATING AT
100% DEMAND, THE UNBALANCE SHALL NOT EXCEED 10%. DURING FINAL
INSPECTION, FURNISH THE TEST INSTRUMENTS AND QUALIFIED PERSONNEL TO
PERFORM COMPLETE TESTING. COSTS OF ALL TESTING, INCLUDING THE INCIDENT
COSTS FOR RETESTING OCCASIONED BY DEFECTS AND FAILURES OF THE
EQUIPMENT TO MEET THE SPECIFICATIONS, SHALL BE BORNE BY THE
CONTRACTOR.

FURNISH AT THE COMPLETION OF THE PROJECT A FINAL INSPECTION
CERTIFICATE FROM THE LOCAL INSPECTING AUTHORITY.

END OF SECTION 16000

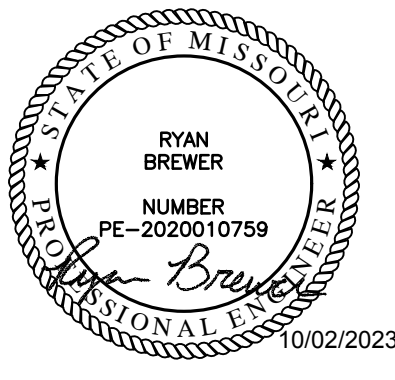

10/02/2023

a building addition for
Lee's Summit Subaru
2101 NE Independence Ave.
Lee's Summit, Missouri 64064

date

drawn by

checked by

revisions



sheet number

E3.1

drawing type

preliminary

project number

23144

16000 - ELECTRICAL

GENERAL

DESCRIPTION

DIVISION 16 OF THE SPECIFICATIONS COVERS ALL ELECTRICAL WORK FOR THE PROJECT. WORK SHALL INCLUDE LABOR, MATERIAL AND ACCESSORIES NECESSARY TO ACCOMPLISH THE WORK AS SPECIFIED AND SHOWN ON THE DRAWINGS, INCLUDING CONNECTION AND CHECKOUTS OF EQUIPMENT FURNISHED BY OTHERS (OTHER TRADES, THE OWNER AND OTHER CONTRACTORS), AND TO ALL EQUIPMENT ITEMS AND AS INDICATED ON DRAWINGS OR AS REQUIRED.

THE ARCHITECTURAL SPECIFICATIONS AND DRAWINGS INCLUDING THE GENERAL CONDITIONS, INCLUDING ALL SUPPLEMENTS ISSUED THERETO, INSTRUCTIONS TO BIDDERS, AND OTHERS PERTINENT DOCUMENTS ISSUED BY THE ARCHITECT ARE A PART OF THESE SPECIFICATIONS AND ELECTRICAL DRAWINGS. THIS TRADE SHALL CONSULT THEM FOR INSTRUCTIONS WHICH APPLY. DRAWINGS INDICATE THE GENERAL ARRANGEMENT OF THE ELECTRICAL LAYOUT AND WORK INCLUDED. ELECTRICIAN SHALL FOLLOW DRAWINGS IN LAYOUT THE ELECTRICAL WORK AND CONSULT THE DRAWINGS AND LAYOUTS OF OTHER TRADES TO VERIFY LOCATION AND SPACES IN WHICH WORK WILL BE INSTALLED.

CODES, PERMITS, INSPECTION AND COMMISSIONING

INSTALLATION SHALL COMPLY WITH ALL LAWS APPLYING TO ELECTRICAL WORK IN EFFECT, INCLUDING THE REQUIREMENTS OF THE NATIONAL ELECTRICAL CODE (N.E.C.), THE NATIONAL ELECTRICAL SAFETY CODE, ALL LOCAL GOVERNING CODES AND ORDINANCES, WITH THE REGULATIONS OF THE SERVING ELECTRICAL UTILITY COMPANY. PROVIDE ALL REQUIRED PERMITS AND INCLUDE THE COST OF SAME IN THE COST OF THE PROJECT. OBTAIN AND PAY FOR (WITHOUT ADDITIONAL EXPENSE TO THE OWNER) ALL REQUIRED INSPECTIONS AND REVIEWS. PROVIDE FOR AND PAY ALL EXPENSES (WITHOUT ADDITIONAL EXPENSE TO THE OWNER) ASSOCIATED WITH LIGHTING AND LIGHTING CONTROLS COMMISSIONING. ALL COMMISSIONING DOCUMENTATION SHALL BE CERTIFIED AND GIVEN TO OWNER AND DESIGN PROFESSIONAL.

QUALITY ASSURANCE

THE FOLLOWING INDUSTRY STANDARDS AS APPLICABLE TO ELECTRICAL WORK SHALL APPLY TO THE WORK OF THIS DIVISION EXCEPT THAT, WHERE THE REQUIREMENTS OF THESE SPECIFICATIONS ARE MORE THAN THE LISTED STANDARD, THESE SPECIFICATIONS SHALL TAKE PRECEDENCE.

UL - UNDERWRITERS' LABORATORIES

NEMA - NATIONAL ELECTRICAL MANUFACTURERS' ASSOCIATION
NECA - NATIONAL ELECTRICAL CONTRACTORS' ASSOCIATION
ANSI - AMERICAN NATIONAL STANDARDS INSTITUTE
ASTM - AMERICAN SOCIETY OF TESTING MATERIALS.

ALL MATERIALS SHALL BE NEW, UL LISTED AND LABELED WHERE LABELED MATERIALS ARE AVAILABLE. UNDAMAGED AND FREE OF DEFECTS AT TIME OF INSTALLATION. MATERIALS OR EQUIPMENT DAMAGED IN SHIPMENT OR OTHERWISE DAMAGED PRIOR TO OR DURING INSTALLATION SHALL NOT BE REPAIRED AT THE JOB SITE, BUT SHALL BE REPLACED WITH NEW MATERIALS. WHEN THE MANUFACTURER'S NAME APPEARS IN THESE SPECIFICATIONS AND DRAWINGS, IT SHALL BE CONSTRUED THAT THE MANUFACTURER HAS TO MEET THE FULL REQUIREMENTS OF THE SPECIFICATIONS AND DRAWINGS.

SUBMITTALS

SUBMIT SHOP DRAWINGS AND PRODUCT DATA FOR EQUIPMENT TO THE ARCHITECT FOR ENGINEER'S REVIEW ELECTRONICALLY OR HARD COPIES. INCLUDE SUFFICIENT INFORMATION TO INDICATE COMPLETE COMPLIANCE WITH SPECIFICATIONS. PROVIDE SUBMITTALS AS EARLY AS REQUIRED TO SUPPORT THE PROJECT SCHEDULE. ALLOW ONE WEEK FOR ENGINEER REVIEW TIME. THE ENGINEER'S SUBMITTAL REVIEWS WILL NOT RELIEVE THE CONTRACTOR FROM RESPONSIBILITY FOR ERRORS IN DIMENSIONS, DETAILS, SIZE OF MEMBERS, OR QUANTITIES; OR FOR OMITTING COMPONENTS OR FITTINGS; OR FOR NOT COORDINATING ITEMS WITH ACTUAL BUILDING CONDITIONS AND/OR OTHER TRADES.

OWNER RECORDS

ACCUMULATE DURING THE PROGRESS OF THE JOB, THE FOLLOWING DATA IN DUPLICATE, AND PREPARE IN A NEAT BROCHURE OR PACKET FOLDER TO BE TURNED OVER TO THE OWNER AT SUBSTANTIAL COMPLETION: RECORD DRAWINGS PER ABOVE.

ALL WARRANTIES, GUARANTEES, AND MANUFACTURER'S DIRECTION ON EQUIPMENT & MATERIAL FURNISHED.

COMPLETE PLAIN ENGLISH STEP-BY-STEP OPERATING INSTRUCTIONS FOR THE ELECTRICAL SYSTEM. ONE COPY OF THESE INSTRUCTIONS SHALL BE FRAMED AND POSTED AS DIRECTED ON THE PREMISES.

CERTIFIED LIGHTING AND LIGHTING CONTROLS COMMISSIONING AS REQUIRED BY CURRENTLY ADOPTED ENERGY CODE REQUIREMENTS.

MANUFACTURERS' NAMES AND CATALOG NUMBERS

IN SOME INSTANCES, SPECIFIC REFERENCES HAVE BEEN MADE TO ONE OR MORE MANUFACTURER'S NAME AND MODEL OR CATALOG NUMBERS. USE OF NAMES AND CATALOG NUMBERS DOES NOT INDICATE THAT THE EQUIPMENT SPECIFIED IS NECESSARILY AN "OFF THE SHELF" ITEM. VARIANCES MAY BE DUE TO REQUIREMENT OF DESIRED FINISH, MATERIAL, OR OTHER MODIFICATION.

IN THE CASE OF PANELBOARDS, SAFETY SWITCHES AND OTHER EQUIPMENT REQUIRING WIRE AND CABLE TERMINATIONS, ASCERTAIN THAT LUG SIZES AND WIRING GUTTERS OR WIRING SPACE ALLOWED IS PROPER FOR THE WIRES AND CABLES CONTAINED THEREIN.

WHEN APPROVAL IS GIVEN FOR THE USE OF EQUIPMENT DIFFERING FROM THAT SHOWN ON DRAWINGS IN REGARD TO FOUNDATIONS, SPACE FOR PIPING, DUCTWORK, WIRING, INSULATION, ETC. CHANGES REQUIRED TO ACCOMPLISH SUCH DIFFERENCES SHALL BE ACCOMPLISHED AT NO COST TO THE OWNER.

PROTECTION OF EQUIPMENT

ELECTRICAL EQUIPMENT SHALL BE PROTECTED FROM THE WEATHER, IN PARTICULAR, DRIPPING OR SPLASHING WATER, AT ALL TIMES DURING SHIPMENT, STORAGE AND CONSTRUCTION. MANUFACTURER'S RECOMMENDATIONS WITH REGARD TO STORAGE, PROTECTION, AND HANDLING SHALL BE FOLLOWED.

SHOULD ANY APPARATUS BE SUBJECTED TO POSSIBLE INJURY DUE TO WATER, IT SHALL BE THOROUGHLY DRIED AND PUT THROUGH A DIELECTRIC TEST, AT THE EXPENSE OF THE CONTRACTOR, TO ASCERTAIN THE SUITABILITY OF THE APPARATUS OR IT SHALL BE REPLACED WITHOUT ADDITIONAL COST TO THE OWNER.

DAMAGED OR DEFECTIVE EQUIPMENT. INSPECT ALL ELECTRICAL EQUIPMENT AND MATERIALS PRIOR TO INSTALLATION. INSTALLATION OR PLACEMENT INTO SERVICE OF DAMAGED MATERIALS WITHOUT THE PRIOR WRITTEN CONSENT OF THE OWNER IS PROHIBITED. REPLACE OR REPAIR TO NEW CONDITION, AS CERTIFIED BY THE MANUFACTURER, AND TEST DAMAGED EQUIPMENT IN COMPLIANCE WITH INDUSTRY STANDARDS AT NO ADDITIONAL COST TO THE OWNER. EQUIPMENT REQUIRED FOR THE TESTING SHALL BE PROVIDED BY THE CONTRACTOR.

WORKING CLEARANCE

THE SIZE OF ELECTRICAL EQUIPMENT SHOWN ON THE DRAWINGS IS BASED ON DIMENSIONS OF A PARTICULAR MANUFACTURER, (GENERALLY THE FIRST NAMED), WHILE OTHER MANUFACTURERS MAY BE ACCEPTABLE, IT IS THE RESPONSIBILITY OF THE TRADE TO DETERMINE IF THE EQUIPMENT PROPOSED WILL FIT IN THE ALLOCATED SPACE.

INSTALL ALL EQUIPMENT IN A MANNER TO PERMIT ACCESS TO ALL SURFACES. MAINTAIN PROPER CLEARANCE TO MEET ALL SAFETY AND OPERATING CODES, PARTICULARLY N.E.C. INCLUDE ALL REQUIREMENTS DICTATED BY OPERATION, CONTROL, ADJUSTMENT, MAINTENANCE AND POSSIBLE REPLACEMENT OF EQUIPMENT IN DETERMINING CLEARANCE.

SHOULD THERE BE APPARENT VIOLATIONS OF N.E.C. CLEARANCE, NOTIFY THE ARCHITECT-ENGINEER BEFORE PROCEEDING WITH CONNECTION OR PLACEMENT OF EQUIPMENT.

COORDINATION

INSTALLATION STUDIES ARE REQUIRED TO COORDINATE THE ELECTRICAL WORK WITH THE WORK OF OTHER TRADES. PREPARE COORDINATION DRAWINGS AT ACCURATE SCALE WHERE SEVERAL ELEMENTS OF ELECTRICAL OR COMBINED MECHANICAL/STRUCTURAL/ELECTRICAL WORK MUST BE SEQUENCED AND POSITIONED WITH PRECISION IN ORDER TO FIT INTO THE AVAILABLE SPACE.

SHOW THE ACTUAL PHYSICAL DIMENSIONS REQUIRED FOR PROPER INTEGRATION OF EQUIPMENT WITH BUILDING SYSTEMS.

PROVIDE APPROVED SHOP DRAWINGS TO ALL REQUIRED DISCIPLINES AND VERIFY FINAL ELECTRICAL CHARACTERISTICS BEFORE ROUGHING POWER FEEDS TO ANY EQUIPMENT. WHEN ELECTRICAL DATA ON APPROVED SHOP DRAWINGS DIFFERS FROM CONTEMPLATED DESIGN, MAKE NECESSARY ADJUSTMENTS TO THE WIRING, DISCONNECTS, AND BRANCH-CIRCUIT PROTECTION FOR THE EQUIPMENT ACTUALLY INSTALLED AT NO ADDITIONAL COST TO THE OWNER.

DAMAGE FROM INTERFERENCE CAUSED BY INADEQUATE COORDINATION SHALL BE RECTIFIED AT NO ADDITIONAL COST TO THE OWNER.

WORKMANSHIP

ALL WORK SHALL BE EXECUTED IN A WORKMANLIKE MANNER AND SHALL PRESENT A NEAT MECHANICAL APPEARANCE WHEN COMPLETED.

ANY MATERIAL ITEMS OR WORK NOT SHOWN ON THE DRAWINGS, BUT MENTIONED IN THESE SPECIFICATIONS OR VISA-VERSA, OR ANY ACCESSORIES NECESSARY TO MAKE THE WORK COMPLETE IN ALL RESPECTS AND READY FOR OPERATION SHALL BE PROVIDED WITHOUT ADDITIONAL COST TO THE OWNER.

THIS TRADE SHALL DO OR HAVE DONE BY COMPETENT TRADESMEN ALL CUTTING AND PATCHING NECESSARY FOR THE INSTALLATION OF THIS WORK. NO CUTTING IN CONSTRUCTIVE PARTS OF THE BUILDING LIKELY TO IMPAIR ITS STRENGTH SHALL BE DONE WITHOUT THE ARCHITECT-ENGINEER'S WRITTEN APPROVAL.

EXCAVATION AND BACKFILL

EXCAVATION, TRENCHING AND BACKFILLING ARE SPECIFIED IN SECTION EXCAVATION. TRENCHING AND BACKFILLING FOR UTILITIES. CONDUIT IS TO BE INSTALLED AS SPECIFIED FOR PIPELINES. CONDUIT INSTALLED BENEATH FLOOR SLAB SHALL BE A MINIMUM OF 6" BELOW SLAB. BACKFILL OVER CONDUIT SHALL BE COMPACTED AS FOR SLAB BEDDING MATERIAL. REFER TO STRUCTURAL DRAWINGS FOR DETAILS OF CONDUIT (PIPE) PENETRATION OF EXTERIOR FOOTINGS. COMPLETE INSTALLATION SHALL CONFORM TO N.E.C.

PENETRATIONS

COORDINATE SLEEVE SELECTION AND APPLICATION WITH SELECTION AND APPLICATION OF FIRE-STOPPING SPECIFIED IN ARCHITECTURAL SPECIFICATIONS.

ROOFS: COORDINATE ALL ROOF PENETRATIONS WITH ENGINEER, OWNER, AND AS APPLICABLE, THE ROOFING CONTRACTOR PROVIDING A ROOF WARRANTY. KEEP ALL RACEWAY PENETRATIONS WITHIN MECHANICAL EQUIPMENT CURBS WHEREVER POSSIBLE. COORDINATE WITH DIVISION 15. FLASH AND COUNTERFLASH ALL OPENINGS THROUGH ROOF, AND/OR PROVIDE PRE-FABRICATED MOLDED SEALS COMPATIBLE WITH THE ROOF CONSTRUCTION INSTALLED, OR AS REQUIRED BY THE ENGINEER, OWNER, OR ROOFING CONTRACTOR. ALL ROOF PENETRATIONS SHALL BE LEAKTIGHT AT THE TERMINATION OF THE WORK AND SHALL NOT VOID ANY NEW OR EXISTING ROOF WARRANTIES.

WALLS AND FLOORS - SLEEVES FOR RACEWAYS AND CABLES: STEEL PIPE SLEEVES: ASTM A 53A 53M, TYPE E, GRADE B, SCHEDULE 40, GALVANIZED STEEL, PLAIN ENDS AND DRIP RINGS.

CAST IRON PIPE SLEEVES: CAST OR FABRICATED "WALL PIPE", EQUIVALENT TO DUCTILE-IRON PRESSURE PIPE, WITH PLAIN ENDS AND INTEGRAL SATERSTOP, UNLESS OTHERWISE INDICATED.

FIRESTOPPING: FIRE RESISTANT THROUGH PENETRAION SEALANTS - TWO PART, FOAMED-IN-PLACE, SILICONE SEALANT FORMULATED FOR USE IN THROUGH-PENETRATION FIRE-STOPPING AND CABLES, RACEWAYS, AND CABLE TRAY PENETRATIONS THROUGH FIRE-RATED WALLS AND FLOORS. SEALANTS AND ACCESSORIES SHALL HAVE FIRE-RESISTANCE RATINGS INDICATED, AS ESTABLISHED BY TESTING IDENTICAL ASSEMBLIES IN ACCORDANCE WITH ASTM E 814, BY UNDERWRITER'S LABORATORIES, INC., OR OTHER NRTL ACCEPTABLE TO AHJ. ACCEPTABLE MANUFACTURERS - HILTI, INC., 3M CORP, RECTORS SEAL, SPECIFY TECHNOLOGY INC., UNITED STATES GYPSUM COMPANY.

ELECTRICAL SERVICE

SERVICE SHALL BE AS SHOWN ON DRAWINGS.

PROVIDE SECONDARY SERVICE INTO THE BUILDING WITH CONDUIT AND WIRING AS SHOWN ON THE PLANS, INCLUDING, BUT NOT LIMITED TO, UNDERGROUND RACEWAYS AND CABLES AND SECONDARY CONNECTIONS TO UTILITY TRANSFORMERS AS REQUIRED BY SERVING ELECTRICAL UTILITY COMPANY. COORDINATE ALL REQUIREMENTS WITH UTILITY COMPANY PRIOR TO BID.

PROVIDE ALL REQUIRED GROUNDING FOR A COMPLETE SERVICE ENTRANCE GROUNDING SYSTEM. PERMANENTLY AND EFFECTIVELY GROUND AND BOND THE ELECTRICAL INSTALLATION IN A THOROUGH AND EFFICIENT MANNER, AND IN CONFORMANCE (AT A MINIMUM) WITH N.E.C. OR THESE DOCUMENTS, WHERE THEY EXCEED CODE REQUIREMENTS. USE BARE OR INSULATED CONDUCTORS, AS SPECIFIED HEREIN, AND OTHER MATERIALS INDICATED ON THE DRAWINGS.

PROVIDE ALL NECESSARY ENCLOSURES REQUIRED BY THE OWNER FOR THE UTILITY COMPANY METERING. REFER TO DRAWINGS FOR MINIMUM REQUIREMENTS. COORDINATE WITH UTILITY COMPANY PRIOR TO BID FOR ALL REQUIREMENTS.

PRODUCTS

GENERAL

ALL EQUIPMENT OF A PARTICULAR KIND, SUCH AS WIRING DEVICES AND PANELBOARDS AND ALL LIGHTING FIXTURES OF THE SAME TYPE, SHALL BE THE PRODUCT OF THE SAME MANUFACTURER.

PROVIDE ACCESS PANELS FOR ALL EQUIPMENT AND DEVICES REQUIRING SUCH PANELS. SIZE AS REQUIRED FOR PROPER ACCESS AND MAINTENANCE, MINIMUM ACCEPTABLE IS 12 IN BY 12 IN CLEAR OPENING WHERE HAND ACCESS ONLY IS REQUIRED.

PROVIDE LABELS FOR EACH MOTOR CONTROLLER, SAFETY SWITCH, RELAY, PANELBOARD, CONTACTOR, TIMER, CONTROL DEVICE, METER AND CIRCUIT BREAKER. LABELS SHALL BE LAMINATED, PHENOLIC STRIPS 1/16" THICK, AND ENGRAVED TO SHOW BLACK LETTERS ON A WHITE BACKGROUND NOT LESS THAN 1/4" HIGH. SIZE STRIPS TO PROPERLY FIT MANUFACTURER'S BRACKETS AND BE LEGIBLE, WHERE MANUFACTURER'S BRACKETS ARE NOT PROVIDED, MOUNT LABELS WITH PROPER SCREWS, OR AN APHERAD ADHESIVE.

RACEWAYS

CONDUIT, RIGID STEEL: GALVANIZED OR SHERADIZED AND MANUFACTURED IN ACCORDANCE WITH ANSI STANDARD C80.L. FITTINGS SHALL BE PIPE THREADED, MALLEABLE IRON. CONNECTORS SHALL BE INSULATED THROAT TYPE.

CONDUIT, PVC: POLY(VINYLCHLORIDE SCHEDULE 40 PIPE SPECIFICALLY MANUFACTURED AND LABELED (UL STANDARD 651) FOR USE AS ELECTRICAL CONDUIT. FITTINGS SHALL BE EITHER SOCKET WELDED TYPE OR PIPE THREADED WITH INSULATED THROAT.

CONDUIT, FLEXIBLE METALLIC: GALVANIZED, INTERLOCKED SPIRALLY WOUND STEEL STRIP WITH GALVANIZED OR SHERADIZED FITTINGS. LISTED PER UL-L. FITTINGS SHALL BE OF THE SQUEEZE TYPE WITH INSULATED THROATS.

CONDUIT, LIQUIDTIGHT FLEXIBLE METALLIC: GALVANIZED, INTERLOCKED SPIRALLY WOUND STEEL STRIP WITH OVERALL JACKET OF LIQUID TIGHT PVC, UL LISTED, FITTINGS SHALL BE STEEL OR MALLEABLE IRON INSULATED THROAT, WATERTIGHT.

ELECTRIC METALLIC TUBING: GALVANIZED OR SHERADIZED AND MANUFACTURED IN ACCORDANCE WITH ANSI STANDARD C80.3. FITTINGS 1/2 INCH THROUGH 2 INCH TRADE SIZE SHALL BE COMPRESSION TYPE, MANUFACTURED FROM MALLEABLE IRON OR STEEL, AND RAIN AND/OR CONCRETE-TIGHT AS REQUIRED BY INSTALLATION. POT METAL OR DIE CAST TYPE FITTINGS ARE PROHIBITED. CONNECTORS SHALL BE INSULATED THROAT TYPE.

CONDUCTORS AND CABLES

GENERAL: SERVICE LATERALS AND PANELBOARD FEEDERS SHALL BE OF ANNEALED (SOFT) COPPER COMPLYING WITH ICEA 5-95-658/NEMA WC70; SOLID CONDUCTOR FOR NO. 10 AWG AND SMALLER, CONCENTRIC, COMPRESSED STRANDED FOR NO. 8 AWG AND LARGER, ALL FEEDER CONDUCTORS NO 8 AWG AND LARGER, STRANDED, TYPE THWN-2 OR XHHW-2 INSULATION. ALL CONDUCTORS, NO 10 AWG AND SMALLER, USED FOR POWER AND LIGHTING CIRCUITS, SOLID COPPER, TYPE THWN-2 INSULATION (WET OR DAMP LOCATIONS, OR IN CONDUIT BELOW GRADE OR SLAB); TYPE THHN INSULATION (DRY LOCATIONS ONLY ABOVE GRADE), OR DUAL RATED TYPE THHN/THWN-2. ALL BRANCH CIRCUIT WIRING SHALL NOT BE SMALLER THAN NO 12 AWG. IF NO CONDUCTOR SIZE IS INDICATED ON THE DRAWINGS FOR A BRANCH CIRCUIT, PROVIDE CONDUCTORS AND CONDUIT SIZED PER NFPA 70 AND BASED ON THE INDICATED BRANCH CIRCUIT OVERCURRENT PROTECTIVE DEVICE RATING AND NUMBER OF POLES, WHERE NO CIRCUIT SIZE (CONDUCTORS AND OVERCURRENT PROTECTIVE DEVICE) IS INDICATED ON THE DRAWINGS FOR A BRANCH CIRCUIT, PROVIDE THREE NO 12 AWG CONDUCTORS IN 3/4" RACEWAY, AND A 20A SINGLE POLE CIRCUIT BREAKER.

ALL BRANCH CIRCUITS SHALL BE ANNEALED (SOFT) COPPER COMPLYING WITH ICEA 5-95-658/NEMA WC70; SOLID CONDUCTOR FOR NO. 10AWG AND SMALLER; CONCENTRIC, COMPRESSED STRANDED FOR NO. 8 AWG AND LARGER. ALL BRANCH CIRCUIT CONDUCTORS NO 8 AWG AND LARGER; STRANDED, TYPE THWN-2 OR XHHW-2 INSULATION. ALL CONDUCTORS, NO 10 AWG AND SMALLER, USED FOR POWER AND LIGHTING CIRCUITS, SOLID COPPER, TYPE THWN-2 INSULATION (WET OR DAMP LOCATIONS, OR IN CONDUIT BELOW GRADE OR SLAB); TYPE THHN INSULATION (DRY LOCATIONS ONLY ABOVE GRADE), OR DUAL RATED TYPE THHN/THWN-2. ALL BRANCH CIRCUIT WIRING SHALL NOT BE SMALLER THAN NO 12 AWG. IF NO CONDUCTOR SIZE IS INDICATED ON THE DRAWINGS FOR A BRANCH CIRCUIT, PROVIDE CONDUCTORS AND CONDUIT SIZED PER NFPA 70 AND BASED ON THE INDICATED BRANCH CIRCUIT OVERCURRENT PROTECTIVE DEVICE RATING AND NUMBER OF POLES, WHERE NO CIRCUIT SIZE (CONDUCTORS AND OVERCURRENT PROTECTIVE DEVICE) IS INDICATED ON THE DRAWINGS FOR A BRANCH CIRCUIT, PROVIDE THREE NO 12 AWG CONDUCTORS IN 3/4" RACEWAY, AND A 20A SINGLE POLE CIRCUIT BREAKER.

CONDUCTOR INSULATION TYPES; 90-DEGREE C-RATED, TYPE THHN/THWN-2 OR XHHW-2 COMPLYING WITH ICEA 5-95-658/NEMA WC70.

COLORS FOR 208/120V CONDUCTORS

PHASE A: BLACK
PHASE B: RED
PHASE C: BLUE
NEUTRAL: WHITE
EQUIPMENT GROUND: GREEN
ISOLATED GROUND: GREEN WITH YELLOW STRIPE

COLORS FOR 480/277V CONDUCTORS
PHASE A: BROWN
PHASE B: ORANGE
PHASE C: YELLOW
NEUTRAL: WHITE
EQUIPMENT GROUND: GREEN

UNLESS NOTED OTHERWISE, SPECIAL PURPOSE CONDUCTORS AND CABLES, SUCH AS LOW VOLTAGE CONTROL AND SHIELDED INSTRUMENT WIRING, SHALL BE AS RECOMMENDED BY THE SYSTEM EQUIPMENT MANUFACTURER.

CONTROL WIRING; STRANDED COPPER CONDUCTORS, 600V INSULATION, OF THE PROPER TYPE, SIZE AND NUMBER AS REQUIRED TO ACCOMPLISH SPECIFIED FUNCTION. MINIMUM SIZE; NO. 14 AWG UNLESS NOTED OTHERWISE.

MC TYPE CABLE CAN BE USED IF ACCEPTED BY LOCAL AUTHORITY AND GOVERNING CODES FOR WHIPS FROM JUNCTION BOX TO LIGHT FIXTURES ONLY. TYPE MC CABLE; 600V, UNJACKETED; ANSI E119 AND E814, UL STANDARDS 44 OR 83 (AS APPLICABLE), AND 1569, NFPA 70 ARTICLE 330; ALUMINUM OR GALVANIZED STEEL INTERLOCKED ARMOR; THHN- OR XHHW-INSULATED CONDUCTORS; COLOR CODE: ICEA METHOD 1, WITH GREEN INSULATED GROUNDING CONDUCTOR.

PROVIDE A DEDICATED EQUIPMENT-GROUNDING CONDUCTOR, OR BONDING JUMPER, AS APPLICABLE, IN ALL BRANCH CIRCUITS AND FEEDERS, SIZED IN ACCORDANCE WITH NFPA 70, UNLESS INDICATED AS LARGER ON THE DRAWINGS.

PROVIDE A DEDICATED NEUTRAL (WHERE REQUIRED) AND DEDICATED GROUNDING CONDUCTOR FOR EACH BRANCH CIRCUIT.

VOLTAGE DROP IN BRANCH CIRCUITS SHALL NOT EXCEED 2%.

GFCI CIRCUITS: DO NOT USE MULTI-CONDUCTOR CIRCUITS, WITH A SHARED NEUTRAL FOR ANY GFCI CIRCUIT BREAKER OR RECEPTACLE CIRCUIT. BRANCH CIRCUITS FED FROM GFCI CIRCUIT BREAKERS, LIMIT THE ONE-WAY CONDUCTOR LENGTH TO 100 FEET BETWEEN THE PANELBOARD AND THE MOST REMOTE RECEPTACLE OR LOAD ON THE GFCI CIRCUIT.

BOXES

OUTLET BOXES: GALVANIZED PRESSED STEEL WITH GALVANIZED STEEL EXTENSION RINGS OR PLASTER RINGS OR TILE RINGS TO PROVIDE EXPOSED SURFACE FLUSH WITH WALL OR CEILING FINISH. PROVIDE ALL CEILING OUTLET BOXES WITH "NO-BOLT" OR THROUGH AND LOCKNUTTED TYPE FIXTURE STUDS.

JUNCTION AND PULL BOXES: FABRICATE IN ACCORDANCE WITH NEMA AND N.E.C. STANDARDS AND REQUIREMENTS INSOFAR AS MATERIAL, GAUGES, DIMENSIONS, AND FABRICATION METHODS. BOXES SHALL BEAR THE UL LABEL. WHERE BOXES ARE NOT SIZED ON THE DRAWINGS, THEY SHALL BE SIZED IN ACCORDANCE WITH

N.E.C. REQUIREMENTS. FINISH IN STANDARD GRAY ENAMEL, WITH SIDES AND BACK SPOT-WELDED IN POSITION AND THE REMOVABLE SCREW COVER MOUNTED WITH BRASS MACHINE SCREWS.

WIRING DEVICES

SWITCHES: HEAVY DUTY AC, RATED 20 AMPERES, 120/277 VOLTS, SINGLE-POLE, DOUBLE-POLE, THREE-POLE, OR FOUR-WAY AS NOTED ON DRAWINGS OR AS REQUIRED FOR THE SWITCHING ARRANGEMENTS IN EACH SPACE. HUBBELL #HBL122" OR EQUAL. COORDINATE SWITCH COLORS WITH COVERPLATES AS DESCRIBED BELOW UNDER "PLATES".

SWITCHES, SPECIAL PURPOSE: KEY OPERATED, HEAVY-DUTY AC, RATED 20 AMPERES, 120/277 VOLTS, SINGLE OR MULTI-POLE AS NOTED OR AS REQUIRED, HUBBELL #HBL122" OR EQUAL.

RECEPTACLES: THREE WIRE GROUNDING TYPE, 120 VOLT RATED, SPECIFICATION GRADE 20 AMPERES DUPLEX UNLESS NOTED OTHERWISE ON DRAWINGS. HUBBELL #5362 OR EQUAL. COORDINATE RECEPTACLE COLOR WITH COVERPLATE AS DESCRIBED BELOW UNDER "PLATES". SINGLE RECEPTACLE, 20 AMPERE, 120 VOLT, SPECIFICATION GRADE. HUBBELL #5361 OR EQUAL.

DUST AND MOISTURE RESISTANT, MELAMINE BODY, GRAY NYLON FACE BACKED BY FABRIC REINFORCED NEOPRENE GASKET SLIT TO PROVIDE WIPING ACTION ON CAP BLADES. PASS & SEYMOUR #6307 OR APPROVED EQUAL. GROUND FAULT CIRCUIT INTERRUPTER, NYLON FACE CLASS A, NEMA 5-20R, SPECIFICATION GRADE. HUBBELL #9F-5362" OR EQUAL.

CORROSION RESISTANT, SIMILAR AND APPROVED EQUAL TO STANDARD RECEPTACLE, EXCEPT FABRICATED FROM YELLOW MELAMINE PLASTIC WITH YELLOW NYLON FACE AND EXPOSED METAL PARTS FINISHED TO RESIST CORROSION. (NEMA 5-15R - HUBBELL #52CM61).

ISOLATED GROUND, DUPLEX OR SIMPLEX THREE WIRE GROUNDING TYPE, SPECIFICATION GRADE, ORANGE FACE, GROUND CONTACT FULLY ISOLATED FROM STRAP AND EQUIPPED WITH SCREW TERMINAL. HUBBELL #IG-5362" OR EQUAL.

RECEPTACLES, SPECIAL PURPOSE: SPECIAL PURPOSE OUTLETS SHALL BE AS SCHEDULED ON DRAWINGS.

PLATES: PROVIDE PLATES FOR ALL OUTLET BOXES. PLATES SHALL BE OF SUITABLE CONFIGURATION FOR THE NUMBER AND TYPE OF DEVICES SERVED, SHALL BE ONE PIECE, SHALL OVERLAP OUTLET BOX EDGE AND ROOM SURFACES, AND SHALL BE SMOOTH FINISH NYLON TYPE OF SAME MANUFACTURER AS THE WIRING DEVICES. VERIFY DESIRED MATERIALS AND COLORS WITH ARCHITECT PRIOR TO INSTALLATION.

STANDARD INTERIOR: IVORY FINISHED ON LIGHT COLORED WALLS - COORDINATE ALL COLORS WITH ARCHITECT

INTERIOR DAMP LOCATIONS: STAINLESS STEEL.

EXTERIOR LOCATIONS: FOR UNATTENDED WET LOCATIONS, PROVIDE IN-USE NEMA 3R, UL LABELED PLATES MOLDED FROM A CLEAR HIGH IMPACT ULTRAVIOLET STABILIZED POLYCARBONATE MATERIAL FOR EASY VERIFICATION THAT CORDS ARE PLUGGED IN AND THAT THE GFCI IS FUNCTIONING. COVER PLATES SHALL BE BY THE SAME MANUFACTURER AS THE WIRING DEVICES, COMPLYING WITH NFPA 70 406.8 (A) OR (B) REQUIREMENTS FOR ATTENDED OR UNATTENDED USE AS APPLICABLE.

ACCEPTABLE MANUFACTURERS: HUBBELL, PASS & SEYMOUR, LEVITON AND COOPER.

CABINETS AND ENCLOSURES

FURNISH AND INSTALL FLUSH CABINETS AND ENCLOSURES AS SHOWN ON THE PLANS AND AS HEREIN SPECIFIED. UNIT SHALL BE PROVIDED WITH DEAD FRONT SUB PANEL, RECESSED AS REQUIRED, TO HOUSE CONTROLS. DOOR SHALL BE PROVIDED WITH CONCEALED HINGES AND FLUSH KEY OPERATED LOCK. DOOR AND TRIM SHALL BE PRIME PAINTED FOR FIELD PAINTING TO MATCH WALL FINISHES. PROVIDE KNOCK-OUTS, LOUSERS AND IDENTIFICATION ENGRAVING AS REQUIRED TO MEET FIELD CONDITIONS. EXACT BACKBOX SIZE TO BE COORDINATED WITH EQUIPMENT SUPPLIER.

CIRCUIT DISCONNECTS

SAFETY SWITCHES: SAFETY SWITCHES SHALL CONSIST OF A BOX, FRONT COVER, AND CIRCUIT PROTECTOR DEVICE ALL MANUFACTURED AND ASSEMBLED IN ACCORDANCE WITH NEMA STANDARDS

THE BOX SHALL BE FABRICATED FROM CODE GAUGE GALVANIZED SHEET STEEL IN ACCORDANCE WITH U.L. LISTING AND LABEL. THE CIRCUIT PROTECTOR DEVICE SHALL BE HEAVY DUTY, QUICK-MAKE, QUICK-BREAK FUSED OR UNFUSED SWITCH RATED FOR MOTOR CIRCUITS AND/OR SERVICE ENTRANCE DUTY, IF REQUIRED, UNITS SHALL BE FURNISHED FOR SURFACE OR FLUSH MOUNTING WITH EITHER GENERAL PURPOSE OR RAIN/TIGHT ENCLOSURES, AS REQUIRED. FUSED UNITS SHALL BE FURNISHED COMPLETE WITH PROPER FUSES.

PANELBOARDS

SHALL CONSIST OF BOX, INTERIOR, FRONT, AND CIRCUIT PROTECTIVE DEVICES. THE ASSEMBLY SHALL BE U.L. LABELED AND BE LISTED FOR SERVICE. THE ASSEMBLY SHALL BE DESIGNED AND MANUFACTURED IN ACCORDANCE WITH NEMA STANDARD PB-1. THE LATEST UL STANDARD (UL-50) AND SHALL HAVE A TURNED EDGE AROUND THE FRONT FOR RIGIDITY AND FOR CLAMPING ON FRONT. PROVIDE STANDARD KNOCKOUTS ON REMOVABLE BOX ENDS. FABRICATE FROM SHEET STEEL AND FINISH WITH BAKED ON GRAY ENAMEL OVER RUST INHIBITOR. EACH FRONT SHALL HAVE A DOOR MOUNTED ON SEMI-CONCEALED HINGES WITH A CYLINDER LOCK, INDEX CARD CIRCUIT DIRECTORY MOUNTED BEHIND CLEAR PLASTIC AND HELD IN A METAL FRAME, AND CONCEALED TRIM CLAMPS FOR MOUNTING TO THE BOX. ALL LOCKS SHALL BE MASTER KEYED AND ALL PANEL DIRECTORIES SHALL BE TYPEWRITTEN.

ALL INTERIORS SHALL BE COMPLETELY FACTORY ASSEMBLED. THE DESIGN OF THE INTERIOR SHALL PERMIT REMOVAL OF INDIVIDUAL BRANCH CIRCUIT BREAKERS WITHOUT DISTURBING ADJACENT UNITS AND WITHOUT MACHINE DRILLING OR TAPPING. BUS BARS FOR PANELS RATED 600 AMPERES OR MORE SHALL BE TIN PLATED 98% CONDUCTIVITY COPPER OR TIN FINISH ALUMINUM (57% CONDUCTIVITY) OF RECTANGULAR CROSS-SECTION. BUS BAR CONNECTIONS TO BRANCH CIRCUIT BREAKERS SHALL BE THE PHASE SEQUENCE TYPE AND ACCEPT BOLT-ON TYPE BREAKERS ONLY. PANELBOARD BUS STRUCTURE AND MAIN BREAKER OR MAIN LUGS SHALL BE RATED AS SCHEDULED ON DRAWING. SUCH RATINGS SHALL BE ESTABLISHED BASED ON HEAT RISE TESTS IN ACCORDANCE WITH UL STANDARDS. GROUP INCOMING CABLE LUGS AT ONE END FOR SEPARATION FROM LOAD SIDE CABLES. EQUIPMENT NEUTRAL BUSSING WITH A LUG FOR EACH BRANCH BREAKER POSITION. INTERIOR SHALL MOUNT TO BOX WITHOUT TOOLS.

BREAKERS SHALL BE QUICK-MAKE, QUICK-BREAK, BOLT-ON THERMAL-MAGNETIC MOLDED CASE CIRCUIT BREAKERS ONE, TWO OR THREE POLE WITH INTEGRAL CROSSBAR FOR MULTI-POLE UNITS, EQUIPPED WITH AN OVERCENTER, TRIP-FREE, TOGGLE-TYPE OPERATING ACTION AND POSITIVE HANDLE INDICATION OF BREAKER STATUS. CIRCUIT BREAKERS SHALL BE UL LISTED IN ACCORDANCE WITH UL STANDARDS.

EACH PANELBOARD, AS A COMPLETE UNIT, SHALL HAVE A SHORT CIRCUIT RATING EQUAL TO OR GREATER THAN THE INTEGRATED EQUIPMENT RATING SHOWN ON DRAWINGS. THE RATING SHALL BE ESTABLISHED BY TESTING WITH THE OVERCURRENT DEVICES MOUNTED IN THE PANELBOARD. THE SHORT CIRCUIT TESTS ON THE OVERCURRENT DEVICES ON THE STRUCTURE SHALL BE MADE SIMULTANEOUSLY BY CONNECTING THE FAULT TO EACH OVERCURRENT DEVICE WITH THE PANELBOARD CONNECTED TO ITS RATED SUPPLY VOLTAGE.

REFER TO PANELBOARD SCHEDULES FOR FULLY RATED OR SERIES-RATED REQUIREMENTS. SERIES-RATED SYSTEMS ARE NOT ALLOWED UNLESS SPECIFICALLY INDICATED ON PANELBOARD SCHEDULES. WHERE ALLOWED, SERIES-RATED SYSTEMS SHALL BE PROPERLY LABELLED BY NEC REQUIREMENTS.

METHOD OF TESTING SHALL BE PER UL STANDARDS. PANELBOARDS SHALL BE MARKED WITH THEIR MAXIMUM SHORT CIRCUIT CURRENT RATING AT THE SUPPLY VOLTAGE.

APPROVED MANUFACTURERS: SQUARE-D CO. OR EQUAL BY GE, SIEMENS AND/OR EATON.

OVERCURRENT PROTECTIVE DEVICES

FUSES OF THE PROPER SIZE, RATING AND ELECTRICAL CHARACTERISTICS SHALL BE PROVIDED IN EACH FUSIBLE DEVICE. FUSES OF 600 VOLTS AND BELOW SHALL BE UL CLASS RK-1, CURRENT-LIMITING, TIME-DELAY, DUAL-ELEMENT, 200,000 AMPERE RMS SYMMETRICAL INTERRUPTING CAPACITY ON NON-MOTOR CIRCUITS AND UL CLASS RK-5, TIME-DELAY, DUAL-ELEMENT, 200,000 AMPERES RMS SYMMETRICAL INTERRUPTING CAPACITY ON MOTOR CIRCUITS.

APPROVED MANUFACTURERS: BUSSMANN, LITTLE FUSE OR FERRAZ-SHAWMUT (ALL FUSES SHALL BE OF SAME MANUFACTURER TO ENSURE SELECTIVE COORDINATION).

CIRCUIT BREAKERS: CIRCUIT BREAKERS OF THE PROPER SIZE, RATING, AND ELECTRICAL CHARACTERISTICS SHALL BE PROVIDED WHERE CALLED FOR ON DRAWINGS. BREAKERS SHALL BE THERMAL MAGNETIC MOLDED-CASE WITH QUICK-MAKE, QUICK-BREAK, OVER CENTER TOGGLE TYPE MECHANISM AND TRIP-FREE HANDLE MECHANISM. THE BREAKER SHALL BE ENCLOSED IN A SUITABLE NEMA RATED ENCLOSURE. BREAKERS SHALL BE OF SAME MANUFACTURER AS THOSE IN THE PANELBOARDS.

TIMESWITCHES

ELECTRONIC TIME SWITCHES: ELECTRONIC, SOLID STATE PROGRAMMABLE UNITS WITH ALPHANUMERIC DISPLAY, COMPLYING WITH UL917. SPST, 30 AMPERE INDUCTIVE OR RESISTIVE, 240VAC, CONTACT RATING. 2 PROGRAMMABLE ON-OFF SET POINTS ON A 24-HOUR SCHEDULE, ALLOWING DIFFERENT SET POINTS FOR EACH DAY OF THE WEEK. ALLOW CONNECTION OF A PHOTOELECTRIC RELAY AS SUBSTITUTE FOR ON-OFF FUNCTION OF A PROGRAM. ASTRONOMIC TIME ON ALL CHANNELS. BATTERY BACKUP FOR SCHEDULES AND TIME CLOCK.


OUTDOOR PHOTOELECTRIC SWITCHES

SOLID STATE, WITH SPST DRY CONTACT RATED FOR 1800-VA TUNGSTEN OR 1000-VA INDUCTIVE, TO OPERATE CONNECTED RELAY, CONTACTOR COILS OR MICROPROCESSOR INPUT, COMPLYING WITH UL 773A.


TELEPHONE AND DATA SYSTEMS

LIGHTING FIXTURE SCHEDULE							
FIXT. TYPE	DESCRIPTION & MANUFACTURER OPTIONS	LAMPS		FIXT. VOLT UNV	TOTAL WATTS 35W	FINISH	REMARKS/MOUNTING
		NO.	TYPE				
A	2' x 4' Field Selectable LED Troffer	1	LED			Standard	Coord. w/ Architect
	M# LITHONIA #STAKS 2X4 AL06 SVW7						
X3	LED Emergency Light w/ (2) 2-Watt Adjustable LED Heads and Emergency Battery Backup	2	LED	UNV	5W	White	Surface (Wall/Ceiling)
	M# EVENLITE #TCL-4-W DUAL LITE #EV4D-02L						
NOTES: 1. Circuit Emergency Battery Packs and Exit Signs to Local Lighting Circuit Ahead of Any Means of Control for Proper Operation.							

LIGHTING CONTROLS SCHEDULE					
FIXTURE TAG	MANUFACTURER	MODEL #	SETTINGS	DESCRIPTION	NOTES
SC	ACUTY BRANDS: nLIGHT	nPP16 SERIES	REFER TO PLANS FOR CONTROL INTENT	ON/OFF ROOM SWITCH CONTROLLER LINE VOLTAGE - SINGLE RELAY	1,2,4
L3	ACUTY BRANDS: nLIGHT	nPQDM	-	ON/OFF LOW VOLTAGE SWITCH WITH 1-CHANNEL CONTROL	1,6
S4	ACUTY BRANDS: nLIGHT	nCM-10 SERIES	-	CEILING MOUNT OCCUPANCY SENSOR - LARGE MOTION LOW VOLTAGE	3
WIRE	-	-	-	CATS, CAT5e, OR CAT 6. STANDARD OR SOLID. TERMINATED AS RJ45 TIA/EIA-568B	
NOTES: 1. COORDINATE ALL MODEL NUMBERS WITH MANUFACTURER PRIOR TO ORDERING. PROVIDE DEVICES TO MEET CONTROL INTENT INDICATED ON THE DRAWINGS. 2. PROVIDE 6'-0" OF EXCESS CONTROL WIRING, COILED AND TIED, BETWEEN CEILING MOUNTED OCCUPANCY SENSOR AND CORRESPONDING LOAD CONTROLLER. 3. MODIFY LOCATIONS OF CEILING MOUNTED OCCUPANCY SENSORS AS REQUIRED SO THAT NO OCCUPACNY SENSORS IS WITHIN 4'-0" OF AN HVAC SUPPLY DIFFUSER. 4. LOCATE DEVICE ABOVE CEILING OR AT STRUCTURE IN ACCESSIBLE LOCATION. LOCATIONS SHOWN ON DRAWINGS ARE SCHEMATIC. ADD ACCESS PANEL WITHIN CEILING IF NECESSARY. COORDINATE ACCESS PANEL LOCATION AND SPECIFICATION DIRECTLY WITH ARCHITECT. 5. LOCATION SHOWN ON PLAN FOR REFERENCE ONLY. CONTRACTOR MAY RELOCATE BRIDGE PORTS FOR A MORE ECONOMICAL LAYOUT IF DESIRED. 6. PROVIDE DEVICES WITH DEFAULT MANUFACTURE MARKINGS ON BUTTONS. 7. ROUTE RECEPTACLE CIRCUIT INDICATED ON PLAN AS "CONTROLLED RECEPTACLES" THROUGH PLUG LOAD CONTROLLER FOR AUTOMATIC ON/OFF CONTROL VIA OCCUPACNY SENSOR. ONE CONTROLLED CIRCUIT PER PLUG CONTROLLER. 8. DEVICE TO BE INSTALLED IN SINGLE GANG BOX. COORDINATE TIME-OF-DAY SCHEDULES WITH OWNER FOR ZONES TO BE ON TIME-OF-DAY CONTROL. 9. PENDANT MOUNT DEVICE TO 1/2" KNOCKOUT ON JUNCTION BOX AS REQUIRED.					

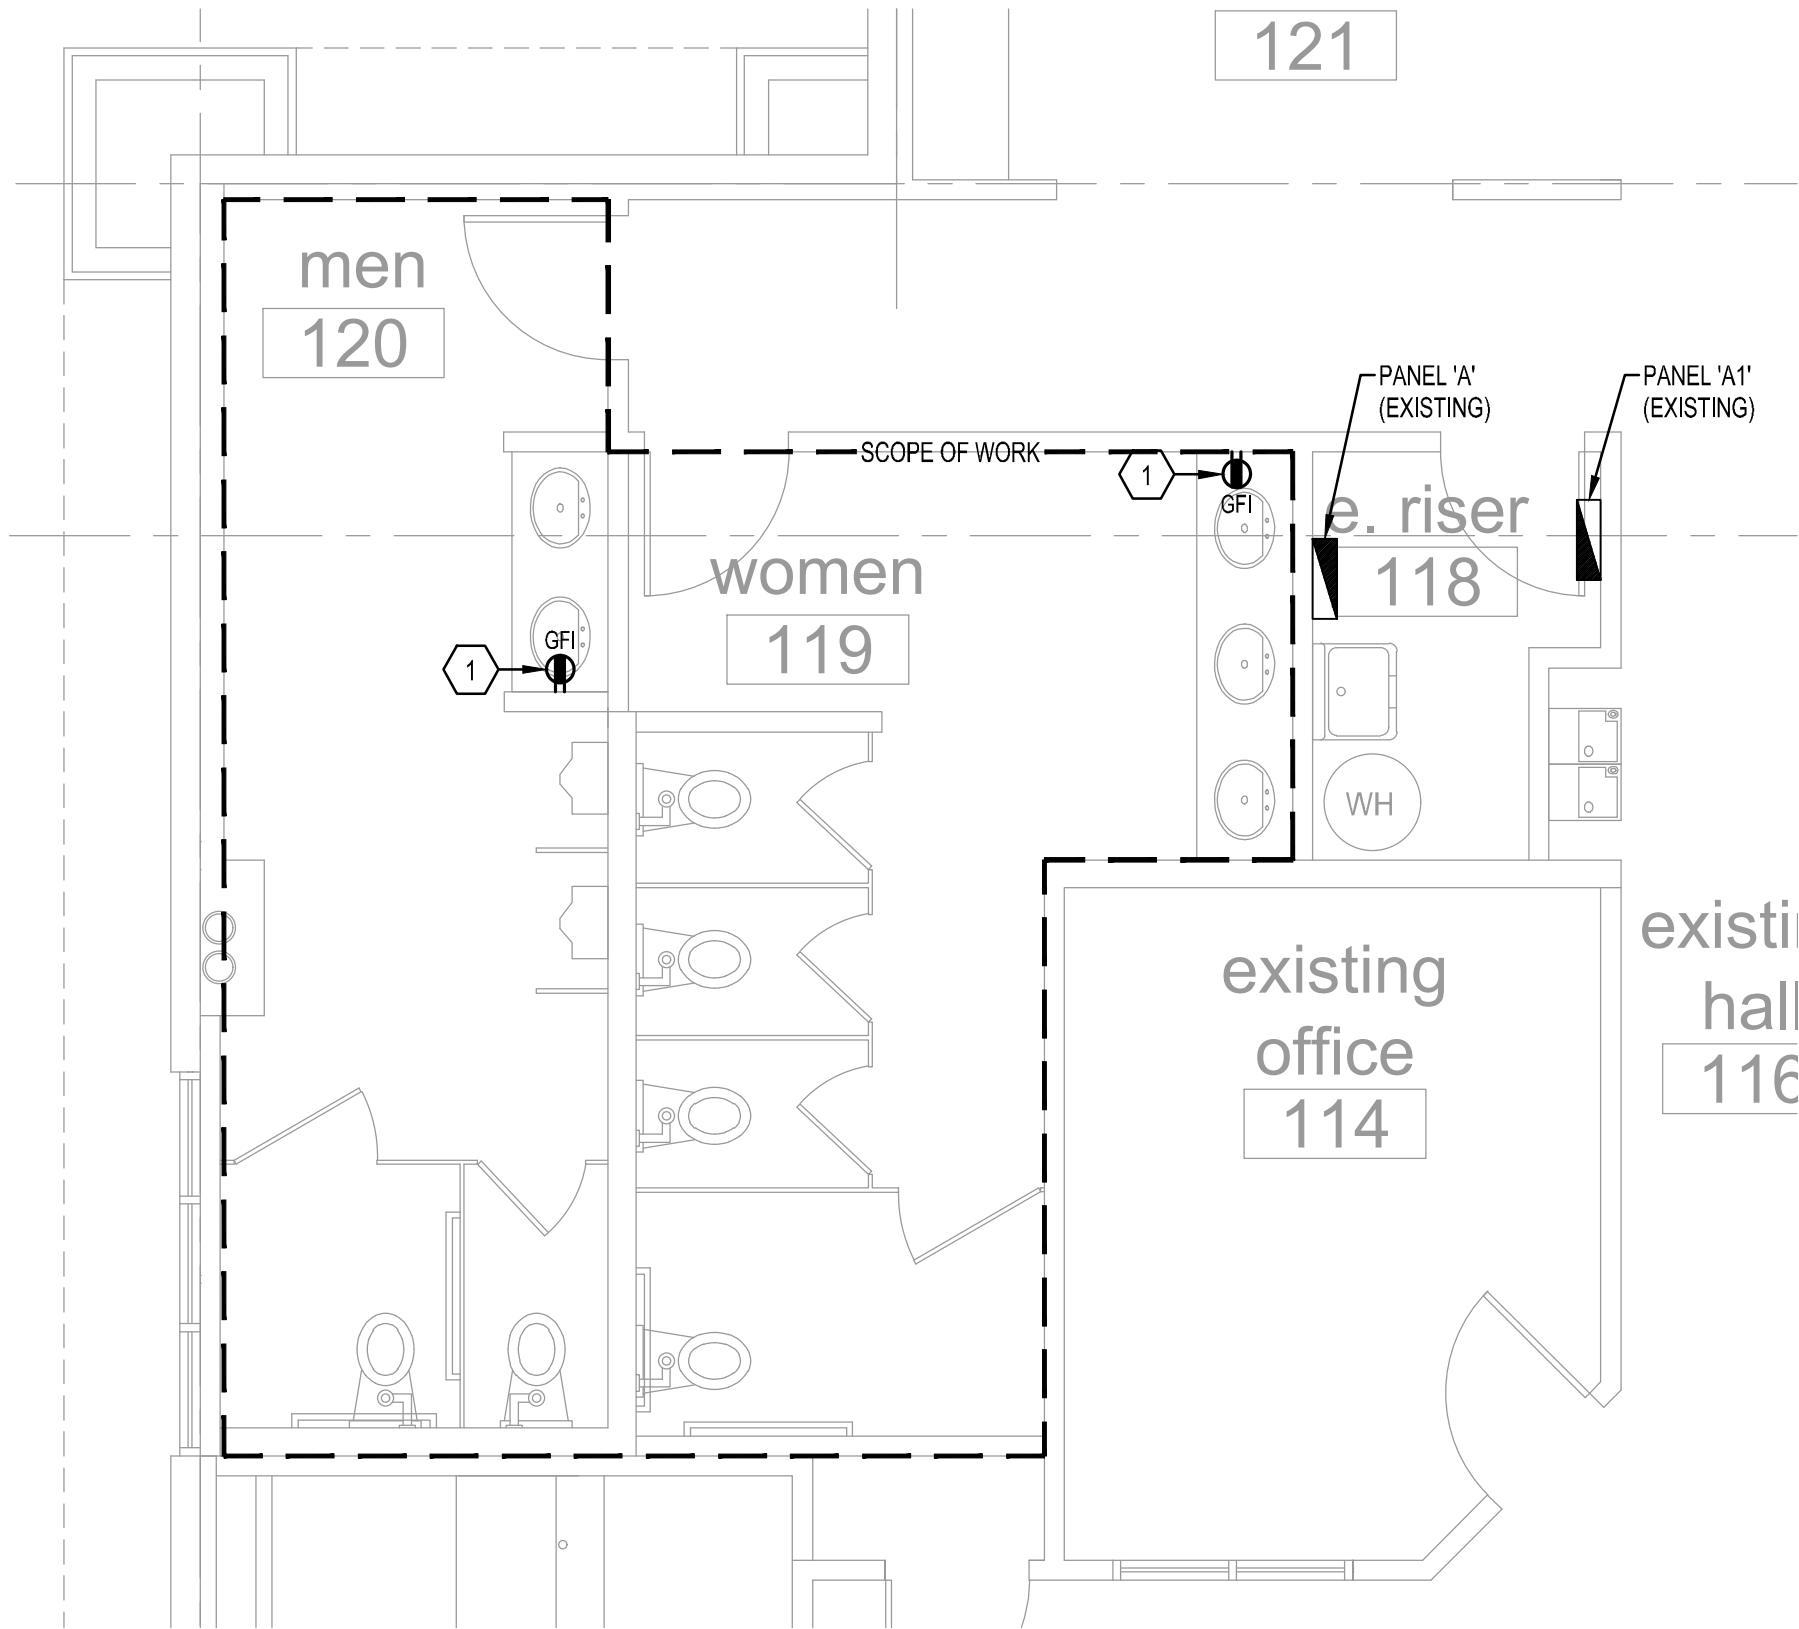

1 POWER PLAN
SCALE: 1/4" = 1'-0"

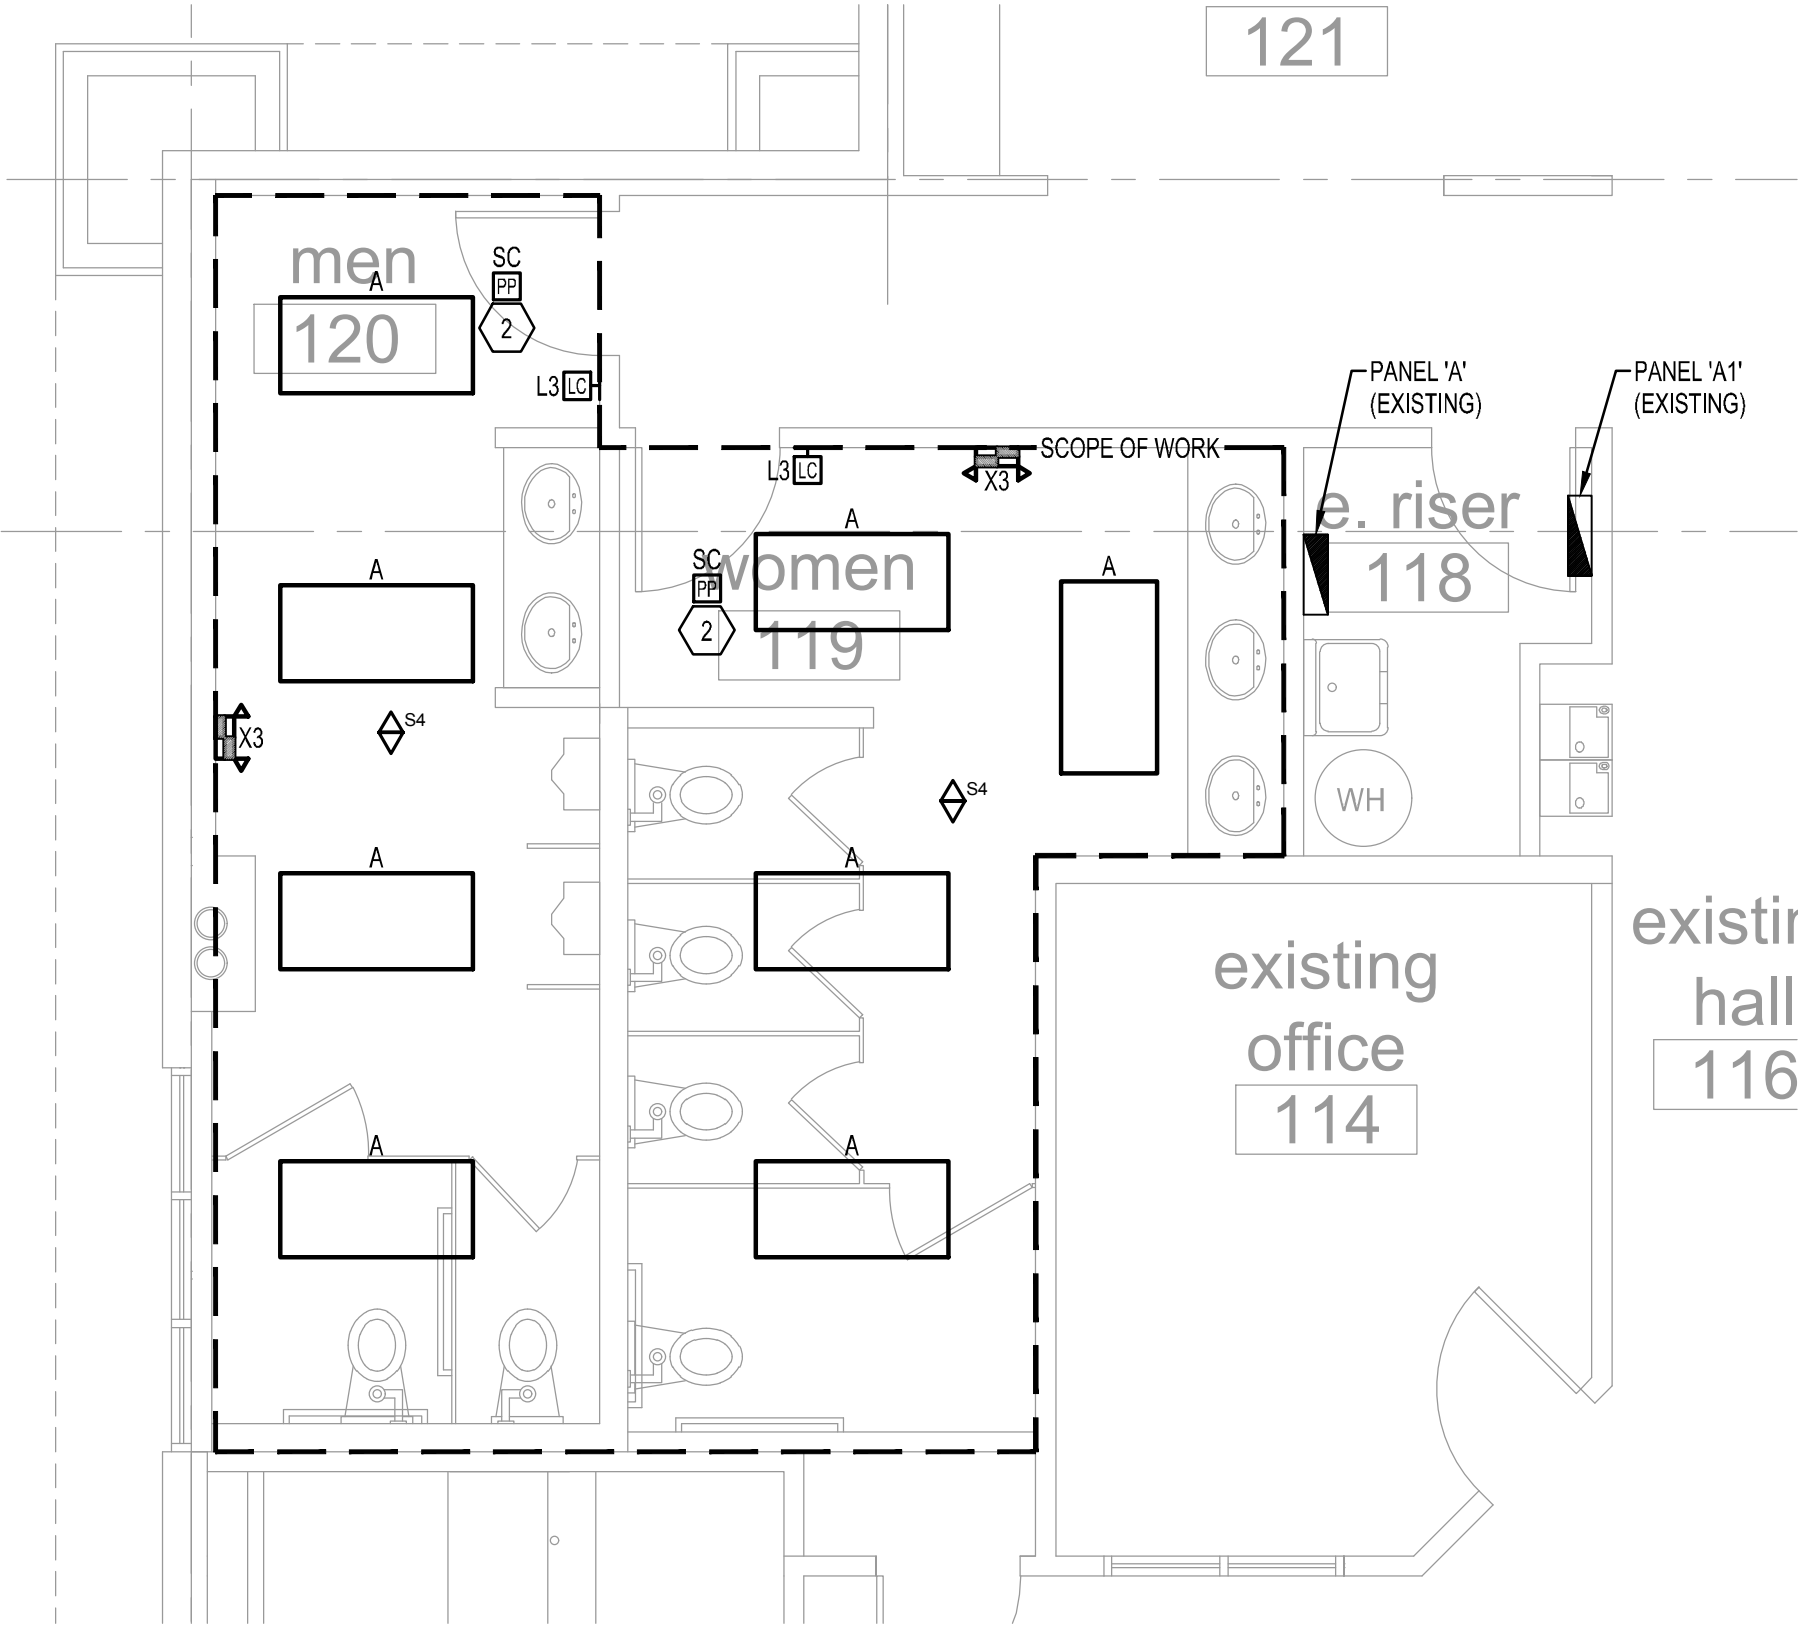

2 LIGHTING PLAN
SCALE: 1/4" = 1'-0"

- GENERAL NOTES
(NOT ALL NOTES APPLY)
- REFERENCE SHEET E1.1 FOR GENERAL NOTES, SYMBOLS, AND ABBREVIATIONS.
 - EXISTING CONDITIONS INDICATED IN THESE DOCUMENTS ARE BASED ON A CURSORY SITE REVIEW AND DO NOT REPRESENT A COMPLETE "AS-BUILT" SET OF DOCUMENTS. IT IS THE CONTRACTORS RESPONSIBILITY TO FULLY INVESTIGATE ALL EXISTING CONDITIONS AND NOTIFY THE ARCHITECT/ENGINEER OF ANY DISCREPANCIES TO THESE DOCUMENTS OR THE DESIGN INTENT.
 - REVIEW EXTENT OF DEMOLITION NOTATED IN THE ARCHITECTURAL DOCUMENTS FOR COMPLETE SCOPE OF WORK TO BE PERFORMED.
 - CIRCUIT NUMBERS SHOWN ARE FOR GENERAL CIRCUITING INTENT ONLY. CONTRACTOR TO FIELD VERIFY EXISTING CONDITIONS AND NOTE ANY DEVIATIONS OR DISCREPANCIES IN THE AS-BUILT DRAWINGS TO BE PROVIDED AT PROJECT COMPLETION.
 - WHERE EXISTING PANEL CIRCUIT DIRECTORIES ARE FOUND TO BE INACCURATE THE CONTRACTOR SHALL CIRCUIT TRACE ALL CIRCUITS WITHIN THE SCOPE OF WORK AND UPDATE ALL PANEL DIRECTORIES DURING AND AT THE COMPLETION OF THE PROJECT.
 - VERIFY ALL EXISTING BRANCH CIRCUITING. CONTRACTOR SHALL WIRE FIXTURES IN ACCORDANCE WITH SWITCHING INDICATED. CONNECTED LOAD ON 277V-20A CIRCUITS SHALL NOT EXCEED 4000W, 120V-20A CIRCUITS SHALL NOT EXCEED 1800W.
 - COORDINATE MOUNTING HEIGHTS AND LOCATIONS FOR ALL DEVICES WITH ARCHITECT AND/OR INTERIOR ELEVATIONS PRIOR TO ROUGH-IN.
 - PROVIDE AND INSTALL 3/4" CONDUIT AND PULL STRINGS FROM TELEPHONE/DATA OUTLETS TO ABOVE ACCESSIBLE CEILING. VERIFY EXACT REQUIREMENTS WITH TELEPHONE EQUIPMENT SUPPLIER AND/OR TENANT.
 - CIRCUIT ALL EXIT SIGNS TO NEAREST EMERGENCY LIGHTING CIRCUIT (OR NEAREST LIGHTING CIRCUIT IF NO GENERATOR).

KEYED NOTES:

- RE-USE EXISTING GFI RECEPTACLE CIRCUIT FROM DEMO'D RESTROOMS TO FEED NEW RECEPTACLES. EXTEND CIRCUITING TO NEW RECEPTACLE LOCATIONS AS REQUIRED.
 - RE-USE EXISTING LIGHTING CIRCUIT FROM DEMO'D RESTROOM TO FEED NEW LIGHT FIXTURES. CONTROL INTENT FOR THIS AREA IS FOR FIXTURES TO BE AUTO ON/AUTO OFF VIA OCCUPANCY SENSOR WITH MANUAL OVERRIDE VIA THE WALL CONTROL STATION. REFER TO GENERAL NOTE 6 (THIS SHEET) FOR ADDITIONAL INFORMATION.

a building addition for

Lee's Summit Subaru

2101 NE Independence Ave.
Lee's Summit, Missouri 64064

date

drawn by

checked by

revisions

sheet number

E2.1

drawing type
preliminary

project number
23144


AC	ALTERNATING CURRENT
AHU	AIR HANDLING UNIT
A. OR AMPS.	AMPERES
AFC	ABOVE FINISH COUNTER
AFCI	ARC FAULT CIRCUIT INTERRUPTER
AFF	ABOVE FINISHED FLOOR
AIC	AMPERES INTERRUPTING CAPACITY
ATS	AUTOMATIC TRANSFER SWITCH
BTC	BRANCH TO CONNECTION POINT AND CONNECT EQUIPMENT
C	CONDUIT (E.C.'S IS EMPTY CONDUIT)
CF	CEILING FAN
CM	COFFEE MAKER
CT	COOKTOP
D	DEDICATED CIRCUIT
DCO	DUPLEX CONVENIENCE OUTLET
DP	DISPOSAL
DW	DISHWASHER
DY	DRYER
EMT	ELECTRICAL METALLIC TUBING
EF	EXHAUST FAN
EW	ELECTRIC WATER COOLER (WATER-COOLED DRINKING FOUNTAIN)
EX	EXISTING
FCU	FAN COIL UNIT
GFI/GFCI	GROUND FAULT CIRCUIT INTERRUPTER
GFIP	GROUND FAULT INTERRUPTER PROTECTED
GRD	GROUND
H	HORIZONTAL MOUNT (RECEPTACLE)
HD	VENTILATION HOOD
HP	HORSEPOWER
HT	HEAT TRACE POWER (PROVIDE W/ 20A1P GFI BREAKER)
HVAC	HEATING, VENTILATING, & AIR CONDITIONING
HZ	HERTZ
IG	ISOLATED GROUND (DUPLEX RECEPTS. -NEMA 5-20RIG)
KCM	THOUSAND CIRCULAR MILLS
KVA	KILOVOLT-AMPERES (1000 VOLT-AMPERES)
KW	KILOWATTS (1000 WATTS)
MLO	MAIN LUGS ONLY
MCB	MAIN CIRCUIT BREAKER
MW	MICROWAVE (COORD MTG HT W/ ARCHITECT)
NIC	NOT IN CONTRACT
NEC	NATIONAL ELECTRICAL CODE
NF	NOT FUSED
OFCI	OWNER FURNISHED CONTRACTOR INSTALLED
PNL	PANEL
PH OR Ø	PHASE
P	POLE
PVC	POLYVINYL CHLORIDE
RF	REFRIGERATOR
RG	RANGE
SPO	SURGE PROTECTIVE DEVICE
T	TAMPERPROOF RECEPTACLE
TTB	TELEPHONE TERMINAL BOARD
TV	TELEVISION RECEPTACLE
UC	UNDERCOUNTER REFRIGERATOR (OR ICE MACHINE)
UL	UNDERWRITERS LABORATORIES
U.N.O.	UNLESS NOTED OTHERWISE
V	VOLTS
VA	VOLT-AMPERES
VD	VENDING MACHINE (24" AFF)
VFD	VARIABLE FREQUENCY DRIVE
W	WATTS
WA	WASHER
WD	WARMING DRAWER
WO	WALL OVEN
WP	WEATHERPROOF
WP/WR	WEATHERPROOF/WEATHER RESISTANT
W/UNT	DISCONNECT IS SUPPLIED WITH THE UNIT

1. COMPLETE INSTALLATION SHALL BE IN ACCORDANCE WITH THE NATIONAL ELECTRICAL CODE, REQUIREMENTS OF THE AHJ AND ALL LOCAL & STATE CODES.
2. DO NOT SCALE FOR THESE DRAWINGS.
3. REFER TO ARCHITECTURAL DRAWINGS AND REFLECTED CEILING PLANS FOR EXACT LOCATIONS OF ALL LIGHTING FIXTURES AND ELECTRICAL DEVICES.
4. ALL EMPTY CONDUITS SHALL BE PROVIDED WITH PULL STRINGS AND BUSHINGS.
5. ALL JUNCTION BOXES SHALL HAVE A COVER.
6. COORDINATE EACH LIGHT FIXTURE INSTALLATION'S W/ ACTUAL CEILING TO BE FURNISHED.
7. ALL BRANCH CIRCUITS WITHOUT A CONDUIT OR CONDUIT IDENTIFICATION SHALL BE ROUTED TO A 20A-1P BREAKER W/ 2412/1255-34°C.
8. ALL BRANCH CIRCUIT CONDUITORS SHALL NOT BE SMALLER THAN #12 AWG AND ALL CONDUIT SHALL NOT BE SMALLER THAN 3/4". UNLESS SPECIFICALLY NOTED OTHERWISE.
9. ALL CIRCUITS (LIGHTING AND POWER) SHALL BE PROVIDED WITH DEDICATED NEUTRALS UNLESS NOTED OTHERWISE. WHERE NEUTRALS ARE INDICATED TO BE SHARED, MULTI-WIRE BRANCH CIRCUITS SHALL BE PROVIDED WITH 2P OR 3P BREAKERS AS REQUIRED PER NEC 210.4.
10. ALL CIRCUITS (LIGHTING AND POWER) SHALL BE PROVIDED WITH AN INSULATED EQUIPMENT GROUND CONDUCTOR SIZED IN ACCORDANCE WITH THE NEC. THE RACEWAY SHALL NOT BE USED ON AN EQUIPMENT GROUND.
11. ALL FIXTURES SHALL BE SUPPORTED FROM EACH CORNER (INDEPENDENT OF THE SUSPENDED CEILING) WITH 12 GAUGE WIRE CONNECTED TO STRUCTURAL SYSTEM OF BUILDING. THE INSTALLATION SHALL MEET OR EXCEED THE SEISMIC REQUIREMENTS OF LOCAL AND NATIONAL CODES.
12. ELECTRICAL DEVICE MOUNTING HEIGHTS: UNO
PANELBOARDS 78" AFF TO TOP OF PANEL
SWITCHES 48" AFF TO CENTER OF SWITCH
RECEPTACLES 18" AFF TO CENTER OF RECEPTACLE
TELEDATA OUTLETS 18" AFF TO CENTER OF RECEPTACLE
13. ELECTRICAL EQUIPMENT (PANELBOARDS, TRANSFORMERS, DISTRIBUTION EQUIPMENT, ETC.) IS SHOWN TO SCALE ON THE FLOOR PLANS.
14. THE ELECTRICAL CONTRACTOR IS RESPONSIBLE FOR PROVIDING EQUIPMENT THAT WILL FIT WITHIN THE SPACES SHOWN ON THE PLANS AND COMPLYING WITH ALL CODE REQUIRED CLEARANCES.
15. ELECTRICAL CONTRACTOR TO LABEL ALL DEVICES (RECEPTACLES, SWITCHES, PANELBOARDS, DISCONNECTS, ETC.) WITH CIRCUIT NUMBER AND PANELBOARD DESIGNATION. RECEPTACLES, SWITCHES AND DISCONNECTS TO HAVE PRE-PRINTED, SELF-ADHESIVE LABEL.
16. PANELBOARDS, DISCONNECT SWITCHES, AND SIMILAR DEVICES TO HAVE ENGRAVED, SELF-ADHESIVE, LAMINATED ACRYLIC LABEL (BLACK W/ WHITE LETTERING).
17. PROVIDE TYPE-WRITTEN PANELBOARD SCHEDULES FOR ALL ELECTRICAL PANELBOARDS.

SYMBOL	DESCRIPTION	MOUNTING	SYMBOL	DESCRIPTION	MOUNTING
	DOWNLIGHT (LETTER INDICATES FIXTURE TYPE) REFER TO LIGHT FIXTURE SCHEDULE	CEILING		SWITCHBOARD OR DISTRIBUTION PANEL REFER TO PANEL SCHEDULES	
	DIRECTIONAL DOWNLIGHT (LETTER INDICATES FIXTURE TYPE) REFER TO LIGHT FIXTURE SCHEDULE	CEILING		DRY-TYPE TRANSFORMER REFER TO PLANS FOR KVA RATING	
	WALL MOUNTED LIGHT FIXTURE (LETTER INDICATES FIXTURE TYPE) REFER TO LIGHT FIXTURE SCHEDULE	WALL		120/208V, 30, 4W PANELBOARD REFER TO PANEL SCHEDULES	
	LINEAR LIGHT FIXTURE (LETTER INDICATES FIXTURE TYPE) REFER TO LIGHT FIXTURE SCHEDULE	CEILING OR SUSPENDED		277/480V, 30, 4W PANELBOARD REFER TO PANEL SCHEDULES	
	2X4 LIGHT FIXTURE (LETTER INDICATES FIXTURE TYPE) REFER TO LIGHT FIXTURE SCHEDULE	CEILING		JUNCTION BOX	WALL OR CEILING
	2X2 LIGHT FIXTURE (LETTER INDICATES FIXTURE TYPE) REFER TO LIGHT FIXTURE SCHEDULE	CEILING		FUSED SAFETY SWITCH (E.G. 30/20'S INDICATES A 30A, 3-POLE SWITCH WITH 20A FUSES)	
	HATCHING ON FIXTURE INDICATES FIXTURE TO HAVE EMERGENCY BACK-UP			NON-FUSED SAFETY SWITCH (E.G. 30/NF'S INDICATES A 30A, 3-POLE SWITCH WITHOUT FUSES)	
	TWO HEAD EMERGENCY LIGHT FIXTURE (LETTER INDICATES FIXTURE TYPE) REFER TO LIGHT FIXTURE SCHEDULE	WALL OR CEILING		MOTOR RATED SWITCH	
	EMERGENCY EXIT SIGN. PROVIDE ARROW(S) AS INDICATED. SHADING INDICATES FACE (LETTER INDICATES FIXTURE TYPE) REFER TO LIGHT FIXTURE SCHEDULE	WALL OR CEILING		MOTOR	
	SINGLE POLE SWITCH 20A (120/277V)	WALL - 48" AFF		NEMA 5-20R SIMPLEX RECEPTACLE	WALL - 18" AFF
	THREE WAY SWITCH 20A (120/277V)	WALL - 48" AFF		NEMA 5-20R DUPLEX RECEPTACLE	WALL - 18" AFF
	FOUR WAY SWITCH 20A (120/277V)	WALL - 48" AFF		NEMA 5-20R DUPLEX RECEPTACLE MOUNTED ABOVE COUNTER	WALL - 6" ABOVE FINISHED COUNTER U.N.O.
	WALL BOX DIMMER SWITCH	WALL - 48" AFF		NEMA 5-20R QUAD-PLEX RECEPTACLE	WALL - 18" AFF
	CEILING OR WALL MOUNTED OCCUPANCY SENSOR (LETTER INDICATES SENSOR TYPE) REFER TO LIGHTING CONTROLS SCHEDULE	WALL OR CEILING		NEMA 5-20R SPLIT RECEPTACLE. TOP OUTLET WIRED HOT. BOTTOM OUTLET SWITCHED.	WALL - 18" AFF
	LOW-VOLTAGE CONTROL STATION (LETTER INDICATES CONTROL STATION TYPE) REFER TO LIGHTING CONTROLS SCHEDULE	WALL - 48" AFF		SPECIAL PURPOSE RECEPTACLE REFER TO PLANS FOR NEMA CONFIGURATION	WALL - 18" AFF OR CEILING
	PHOTOCELL SENSOR (LETTER INDICATES SENSOR TYPE) REFER TO LIGHTING CONTROLS SCHEDULE	FIELD VERIFY		NEMA 5-20R - DUPLEX RECEPTACLE WITH USB PORTS SIMILAR TO HUBBELL #USB20AC5W	WALL - 18" AFF
	POWERPACK (LETTER INDICATES POWERPACK TYPE) REFER TO LIGHTING CONTROLS SCHEDULE	ACCESSIBLE CEILING		NEMA 5-20R DUPLEX RECEPTACLE MOUNTED ON CEILING	CEILING - FLUSH

SYMBOL	DESCRIPTION	MOUNTING		CONNECTION CAPABILITY	
	CARD READER (VERIFY EXACT REQUIREMENTS)			HUBBELL B24 SERIES FLOOR BOX (OR EQUAL) WITH (1) DUPLEX RECEPTACLE AND DATA/COMMUNICATION CONNECTION CAPABILITY	FLOOR - FLUSH
	DATA, TELEPHONE, OR COMBO TELE/DATA OUTLET PROVIDE PULLSTRING IN CONDUIT TO ACCESSIBLE CEILING	WALL - 18" AFF		HUBBELL B24 SERIES FLOOR BOX (OR EQUAL) FOR POWER AND DATA CONNECTIONS TO PRE-WIRED FURNITURE VERIFY EXACT CONNECTION WITH FURNITURE VENDOR	FLOOR - FLUSH
	DATA, TELEPHONE, OR COMBO TELE/DATA OUTLET PROVIDE PULLSTRING IN CONDUIT TO ACCESSIBLE CEILING	FLOOR OR CEILING		HUBBELL S1PT SERIES 4" POKE-THRU (OR EQUAL) WITH (2) DUPLEX RECEPTACLES AND DATA/COMMUNICATION CONNECTION CAPABILITY	FLOOR - FLUSH
	TELEVISION OUTLET	WALL OR CEILING		HUBBELL S1PT7E SERIES 4" POKE-THRU (OR EQUAL) FOR POWER AND DATA CONNECTIONS TO PRE-WIRED FURNITURE VERIFY EXACT CONNECTION WITH FURNITURE VENDOR	FLOOR - FLUSH
	SPEAKER OUTLET	FIELD VERIFY		HUBBELL S1R6 SERIES 6" POKE-THRU (OR EQUAL) WITH (2) DUPLEX RECEPTACLES AND DATA/COMMUNICATION AND AV CONNECTION CAPABILITY	FLOOR - FLUSH
	TELEPHONE TERMINAL BOARD	WALL		CONDUIT IN OR UNDER FLOOR/GRADE	
	SECURITY CAMERA OUTLET	FIELD VERIFY		CONDUCTOR HOME RUN - () HOT, (I) NEUTRAL, (G) EQUIPMENT GROUND, & () ISOLATED GROUND	
	PUSH BUTTON			EQUIPMENT CONNECTION	
				CONDUIT IN CEILING OR WALL	

 4301 Indian Creek Parkway
Overland Park, KS 66207
phone: 913.451.9390
fax: 913.451.9391
www.davidsonae.com



sheet number

project number
23144

23144