


NOTES:

INSTALLATION TO MEET NEC AND POWER COMPANY STANDARDS

**RELEASED FOR
CONSTRUCTION**
As Noted on Plans Review

Development Services Department
Lee's Summit, Missouri
01/26/2024

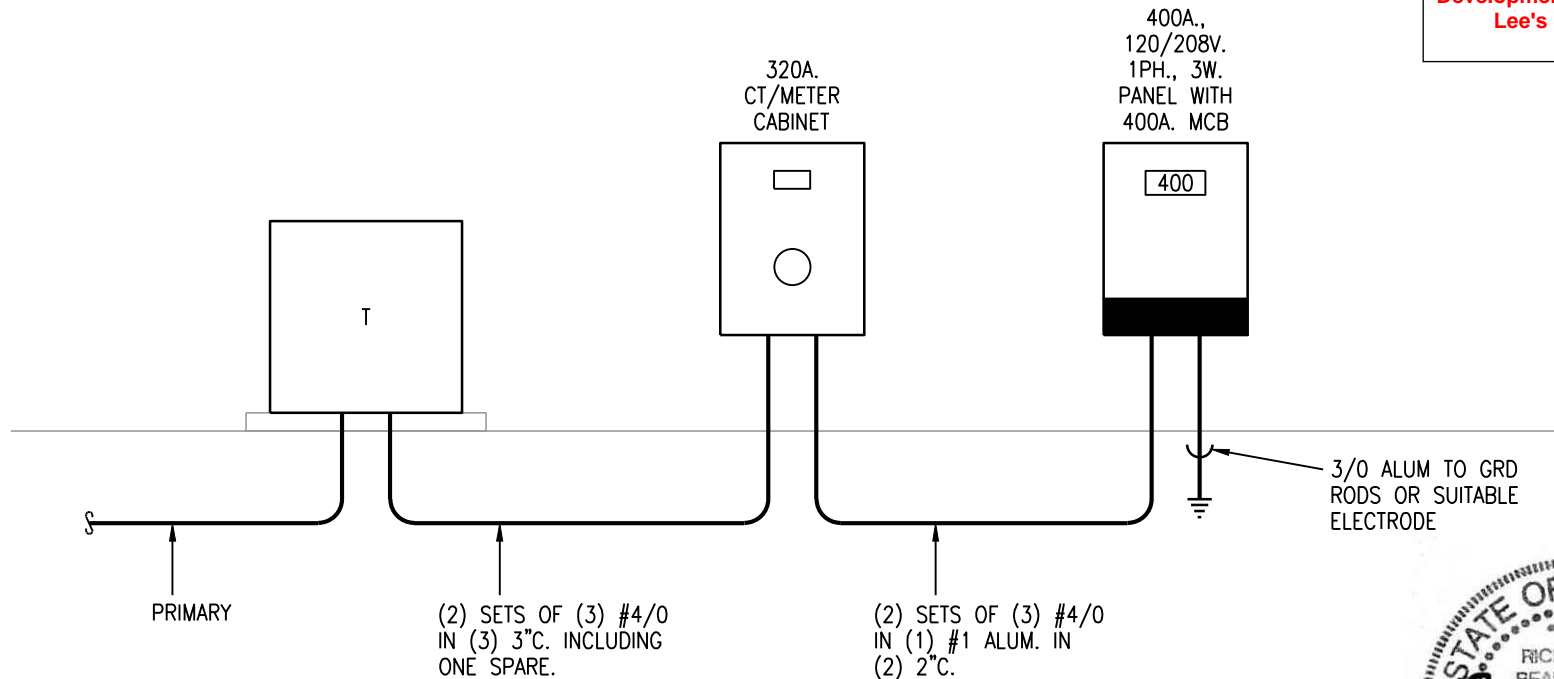

1

TEMPORARY POWER RISER

NO SCALE



01-26-24

**RAINTREE VILLAGE
LEE'S SUMMIT, MO**

LS&A
Latimer Sommers
& Associates, P.A.
CONSULTING ENGINEERS

3639 SW Summerfield Drive, Suite A
Topeka, Kansas 66614-3974

Telephone: (785) 233-3232
FAX: (785) 233-0647
Email: lsapa@lsapa.com

DATE:

1/26/2024

DRAWING NO:
**TEMPORARY
POWER RISER**