

Crash Champions
451 SE Oldham Parkway
Lee's Summit, MO 64081

CODE INFORMATION

Project Type:	new
Building Codes:	IBC-2018 NFPA-72 2016
Number of Stories:	1
Primary Use Group:	B
Sprinkled	100%

RELEASED FOR CONSTRUCTION
As Noted on Plan Review

Lee's Summit Fire Department
Lee's Summit, Missouri
02/06/2024

Fire Alarm System input / output matrix

[illegible]

Sheet Legend

Sheet Legend	
F1	Cover Sheet
F2	Floor Plan
F3	Details and Calculations

J Webb Inc
P O Box 952 Lawrence Kansas 66044
jefwebb@jwebb-k.com (785) 856-FIRE (3473) fax (785) 856-3474 cell (913) 710-2046

Copyright © 2023
BG Consultants, Inc.



Jarrod E. Mann, P.E.
MO #2008014536



Manhattan Lawrence Emporia

M/E/P

BG Consultants, Inc.
1405 Wakarusa Drive
Lawrence, Kansas 66049
ph: 785/749 4474
www.bgcons.com
Missouri State Certificate of Authority # F00856806

CRASH CHAMPIONS

451 SE Oldham Parkway
Lee's Summit, MO 64081

Revision Key

[illegible]

Project Manager:

Jarrold E. Mann, P.E.

Project Number:

23-1054L Phase 23-17


Date of Issue: _____

2023-12-29


Sheet Number:

F-1

Cover Sheet

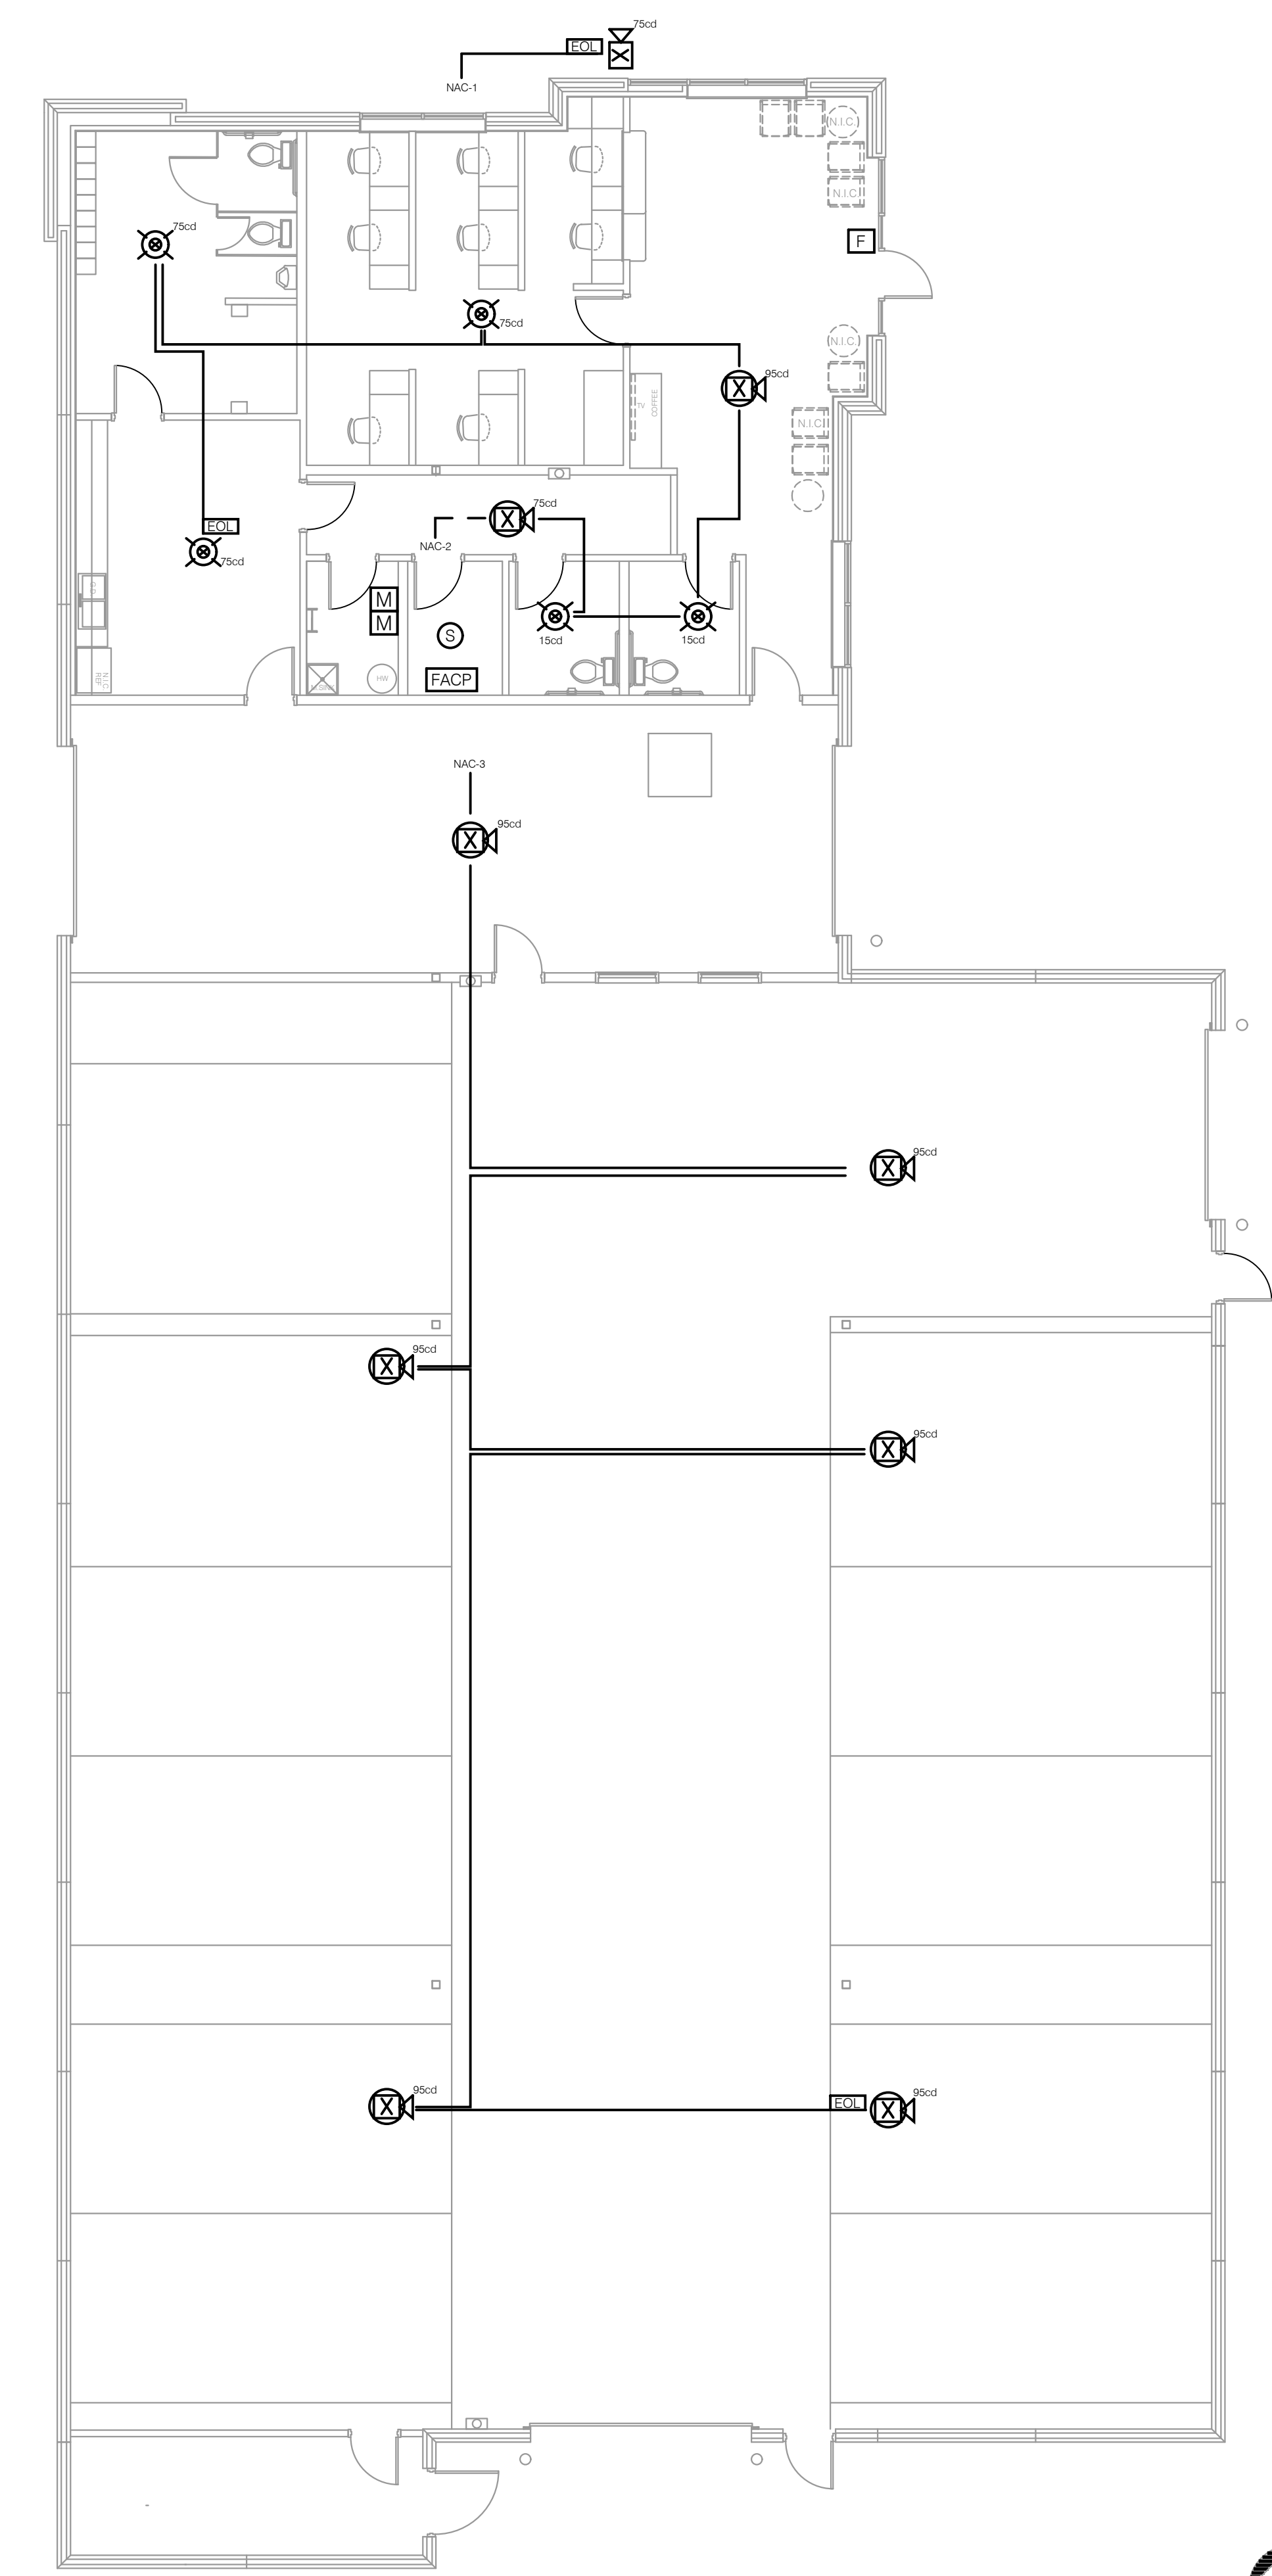

FIRE ALARM PLAN

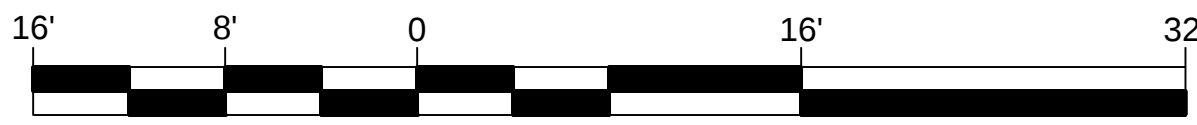

GRAPHIC SCALE
1/8" = 1'-0"



J Webb Inc
P O Box 952 Lawrence Kansas 66044
jeffwebb@jwebb-kc.com (785) 856-3474 fax (785) 856-3474 cell (913) 710-2046

Copyright © 2023
BG Consultants, Inc.



Jarrod E. Mann, P.E.
MO #2008014536



Manhattan Lawrence Emporia

M/E/P
BG Consultants, Inc.
1405 Wakarusa Drive
Lawrence, Kansas 66049
ph: 785/749 4474
www.bgcons.com
Missouri State Certificate of Authority # F00856806

CRASH CHAMPIONS

451 SE Oldham Parkway
Lee's Summit, MO 64081

Revision Key

No.	Date	Revision

Project Manager:
Jarrod E. Mann, P.E.

Project Number:
23-1054L Phase 23-17

Date of Issue:
2023-12-29

Sheet Number:

F-2

Fire Alarm Plan

