




ZOETIS LOGISTICS CENTER

ONE PFIZER
LEE'S SUMMIT, MISSOURI 64018

FIRE ALARM PANEL AND DEVICE REPLACEMENT

- COVER SHEET
- GENERAL INFORMATION SHEET
- FIRE ALARM DEVICE LAYOUT
- ONE-LINE DIAGRAM

- CVR
- FA-01
- FA-02
- FA-03

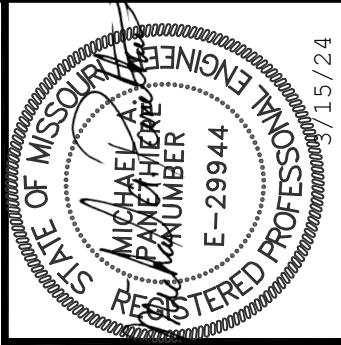

CVR		ZOETIS LOGISTICS CENTER ONE PFIZER LEE'S SUMMIT, MO 64018		CINTAS READY FOR THE WORKDAY® CINTAS FIRE PROTECTION 18533 W 100th Terrace LENEXA, KS 66219		<table><tr><td>PROJECT #</td><td>ISSUE DATE</td><td>DRAWN BY</td><td>CHECKED BY</td></tr><tr><td></td><td>3/15/24</td><td>M P PANETHERE</td><td>M A PANETHERE</td></tr><tr><td>REV</td><td>DATE</td><td></td><td></td></tr><tr><td></td><td></td><td></td><td></td></tr><tr><td colspan="4">REVISION DESCRIPTION</td></tr></table>		PROJECT #	ISSUE DATE	DRAWN BY	CHECKED BY		3/15/24	M P PANETHERE	M A PANETHERE	REV	DATE							REVISION DESCRIPTION			
PROJECT #	ISSUE DATE	DRAWN BY	CHECKED BY																								
	3/15/24	M P PANETHERE	M A PANETHERE																								
REV	DATE																										
REVISION DESCRIPTION																											


ONE PFIZER
LEE'S SUMMIT, MO 64018



LENEA, KS 66219

ISSUE DATE	3/15/24
DRAWN BY	M P PANETHIERE
CHECKED BY	M A PANETHIERE

FLOOR PLAN

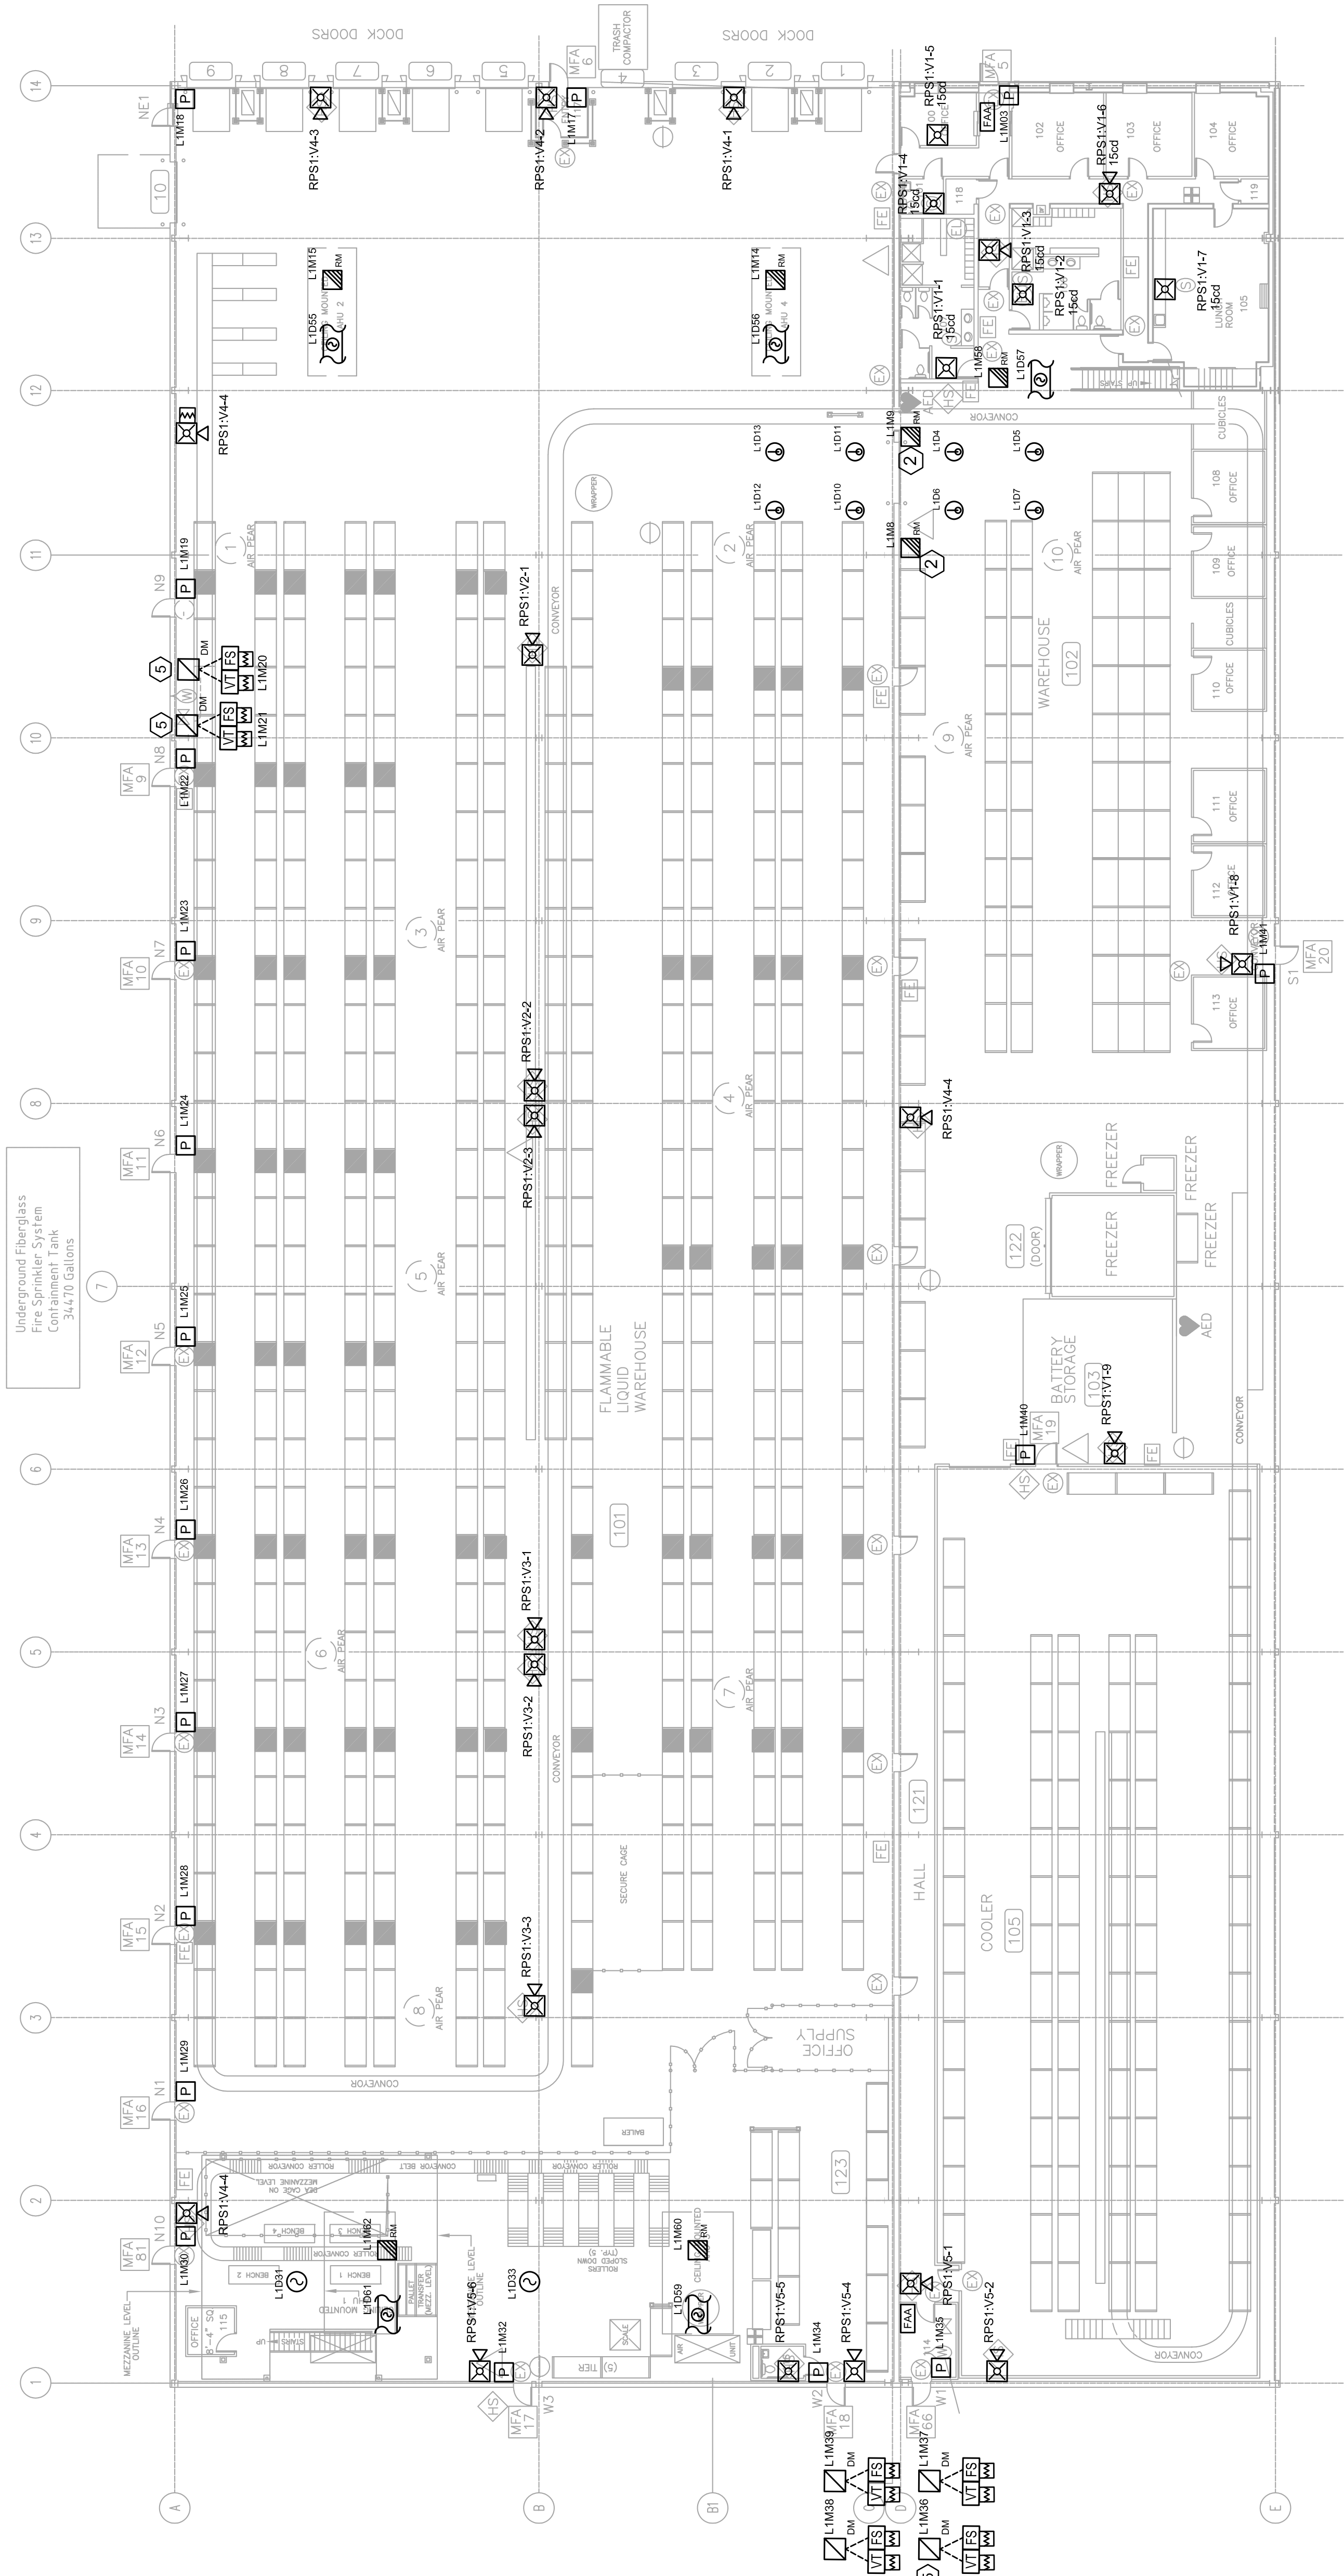




CINTAS FIRE PROTECTION
15533 W 100th Terrace
LENEXA, KS 66219

PROJECT #	ISSUE DATE	CHECKED BY
	3/15/24	M P PANETIERRE
		M A PANETIERRE

REV	DATE	REVISION DESCRIPTION

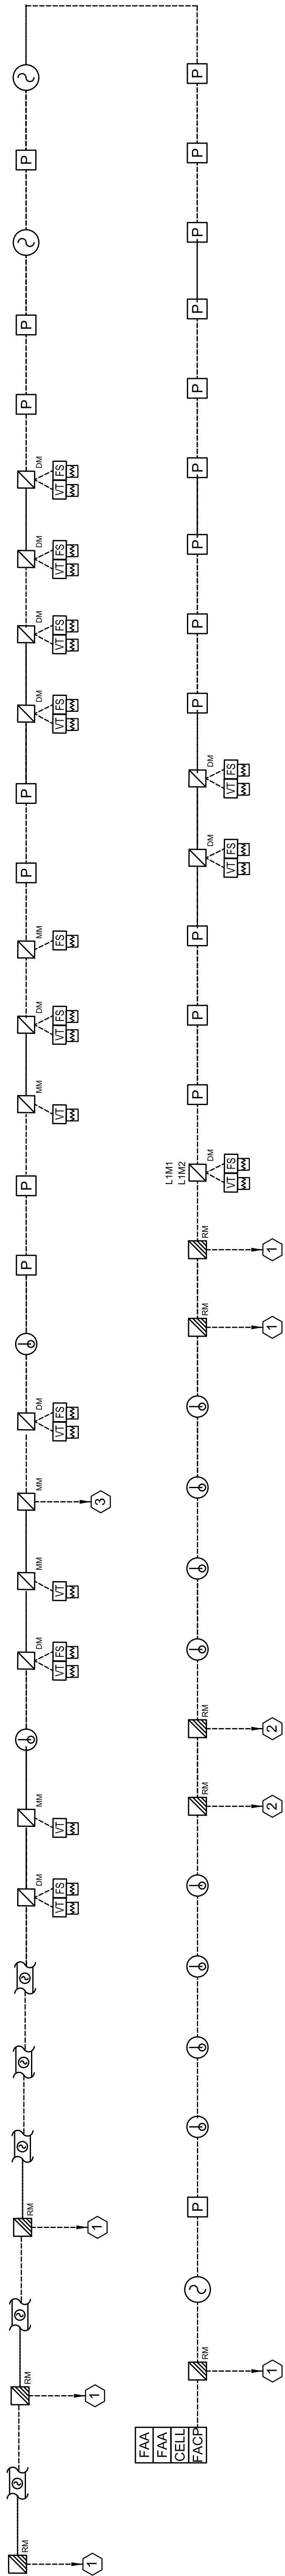

SLC ONE-LINE DIAGRAM
SCALE: NTS