



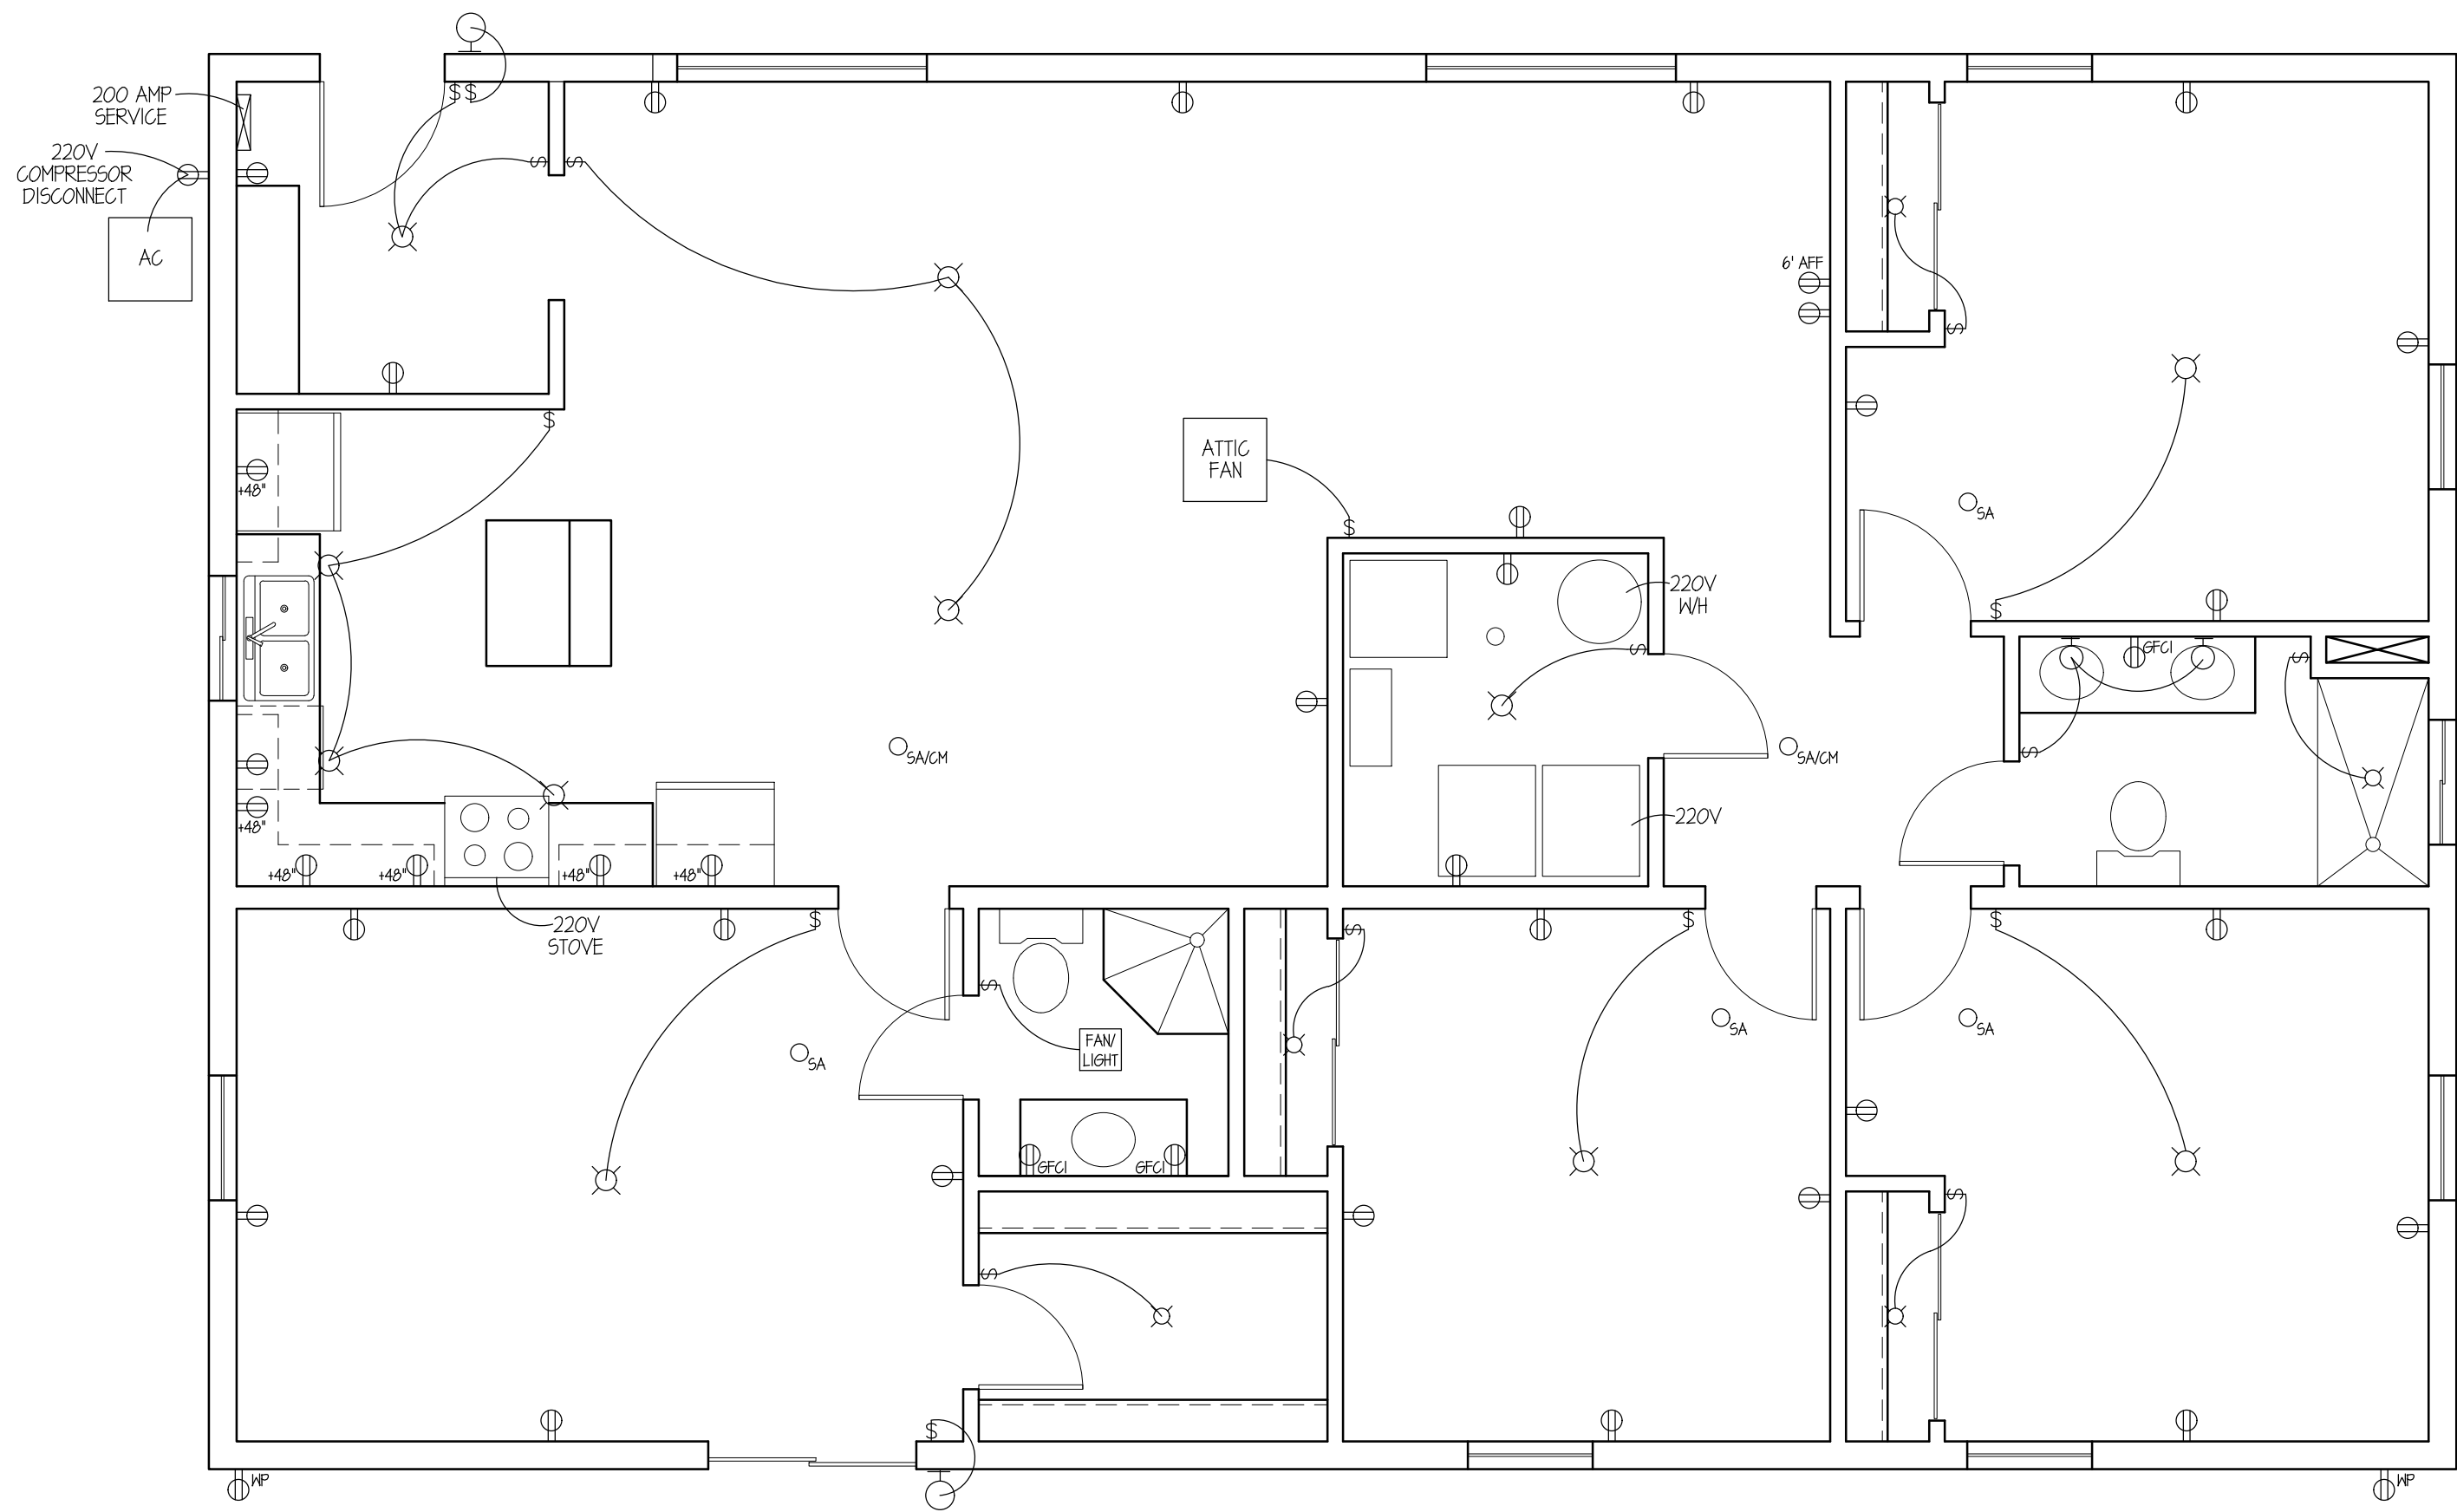


ELECTRICAL PLAN
SCALE: 1/4" = 1'-0"

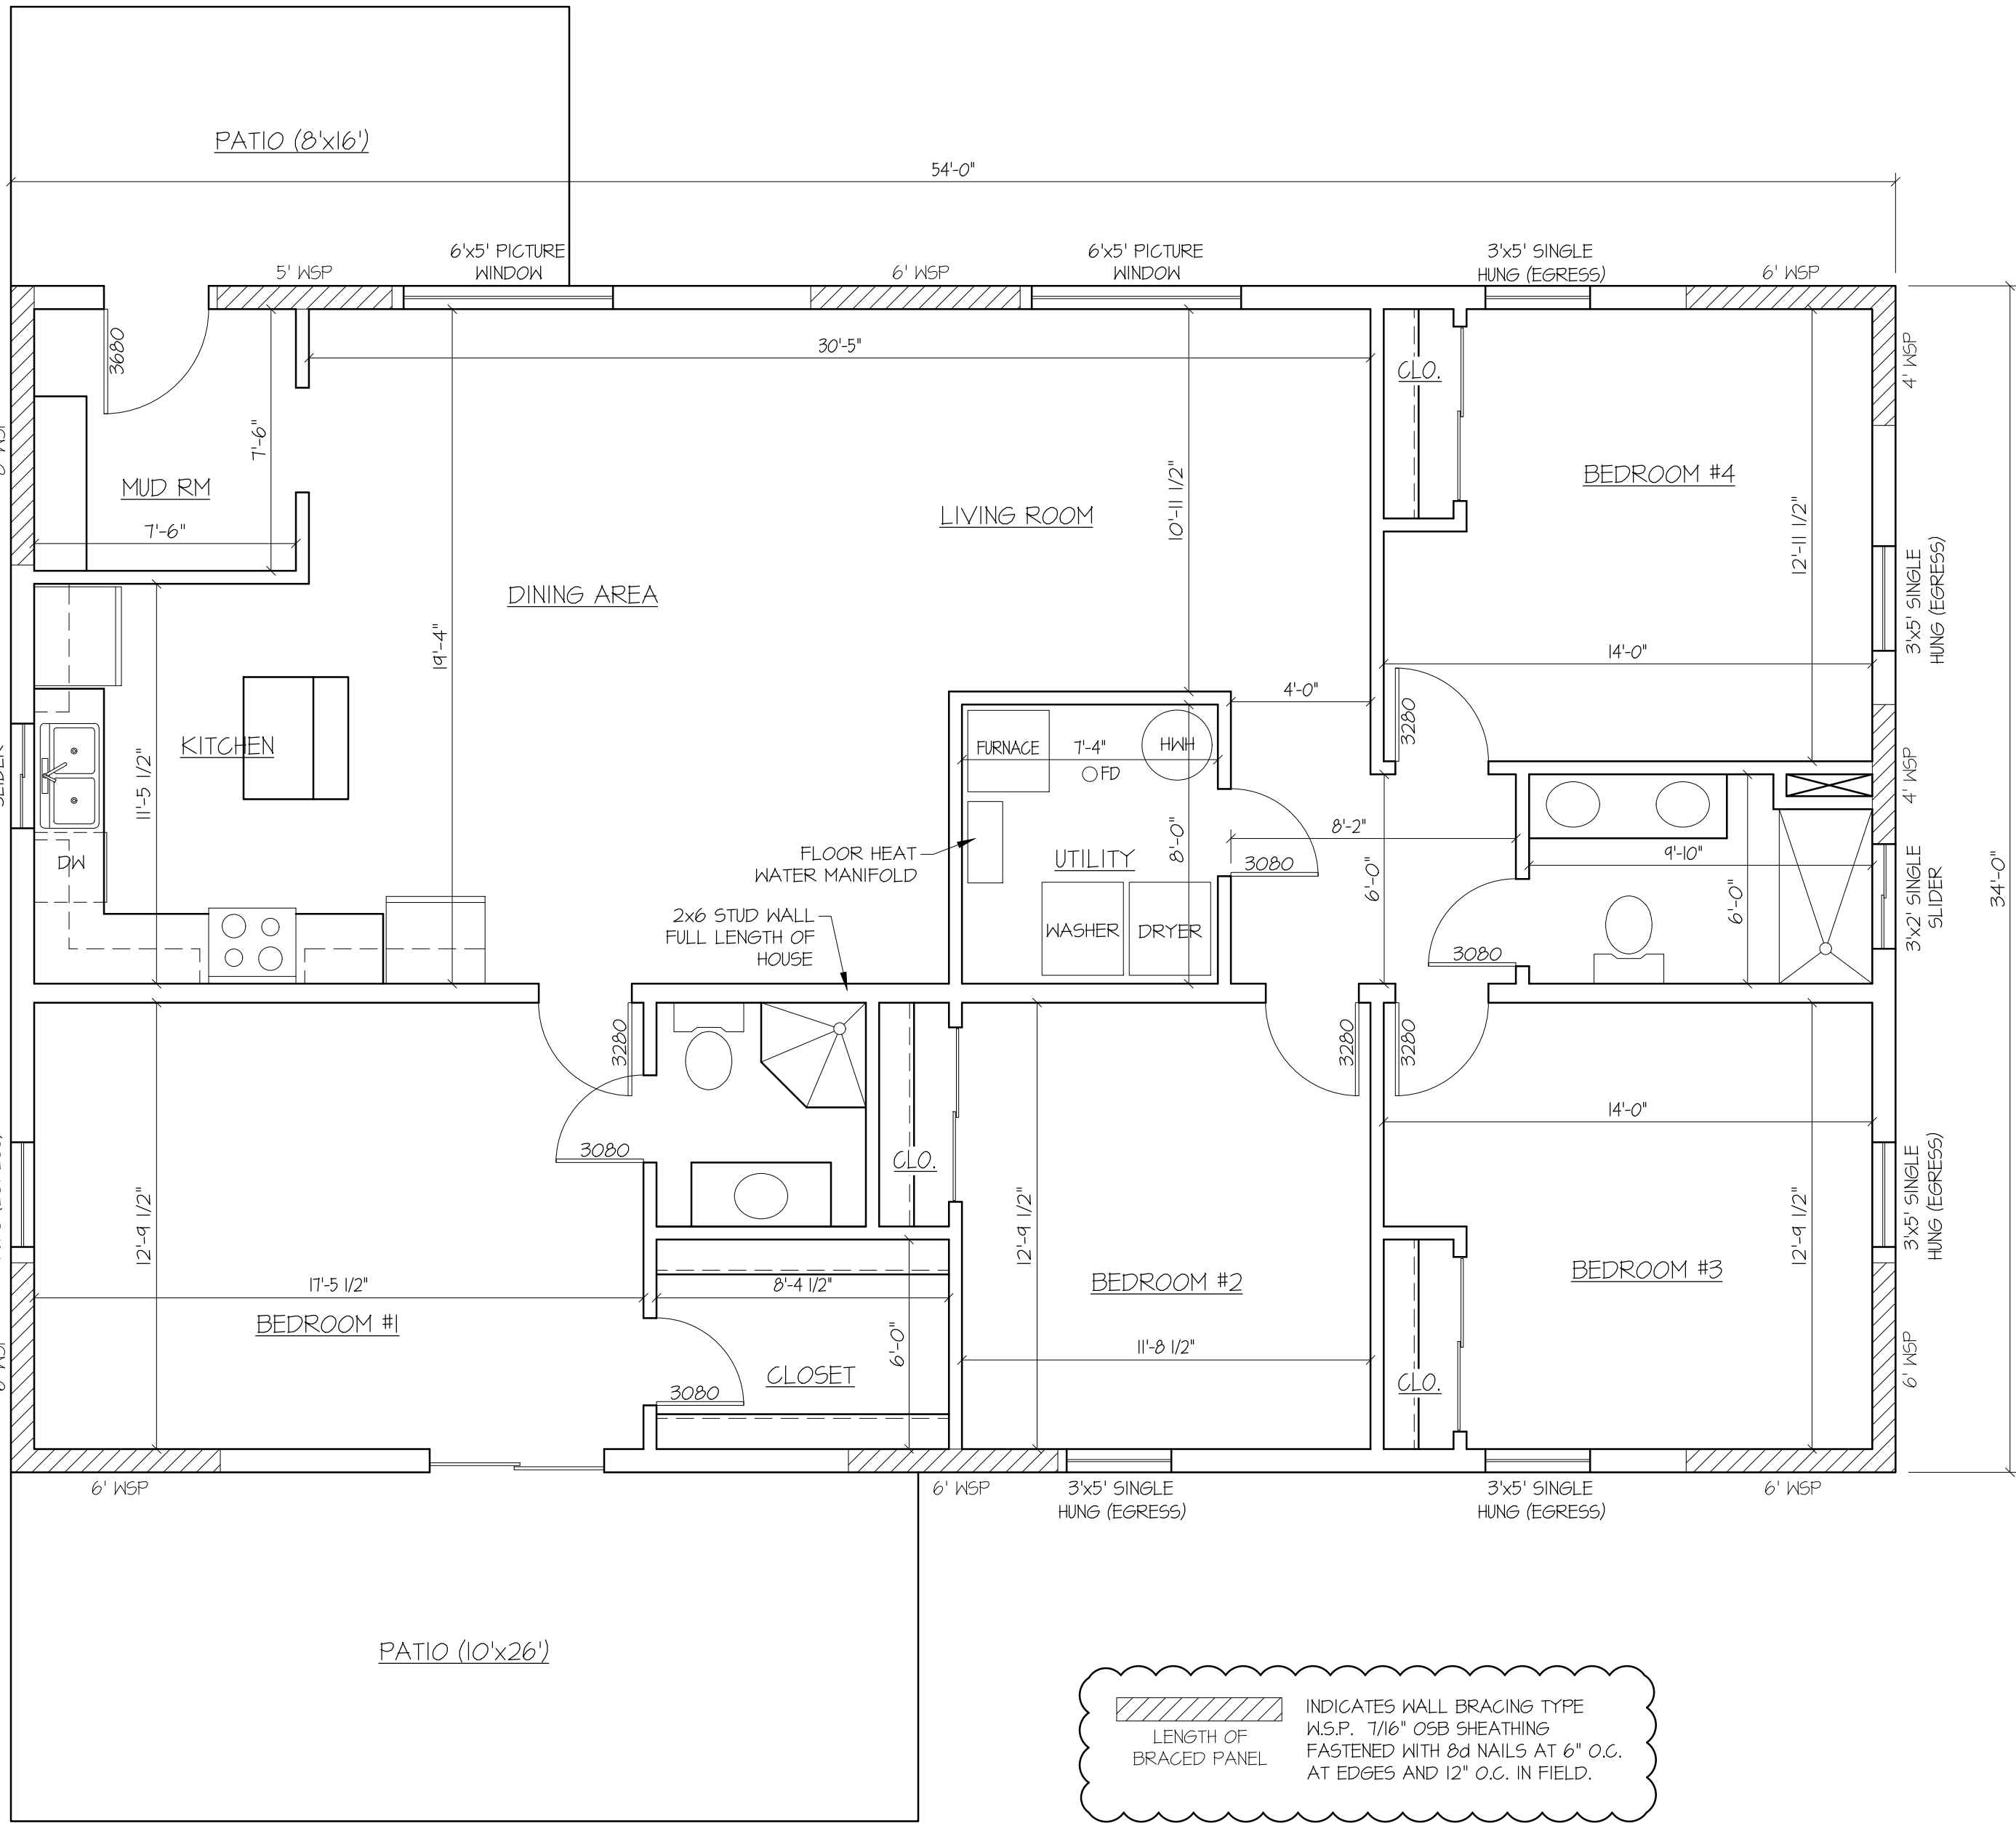

FLOOR PLAN
SCALE: 1/4" = 1'-0"

This drawing has been prepared by the Engineer, or under his supervision. This drawing is provided as an instrument of service by the Designer/Engineer and is intended for use on this project only. Pursuant to the Architectural Works Copyright Protection Act of 1990, all drawings, specifications, notes and designs, including the overall form, arrangement and composition of notes and elements appearing herein constitute the original, copyrighted work of the Designer/Engineer. Any reproduction, use, or disclosure of information contained herein without prior written consent of the Engineer is strictly prohibited. Copyright 2024 Lampen Engineering, Inc.

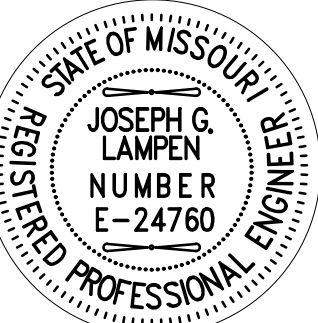

Joseph G. Lampen
4-5-24

RECONSTRUCTION OF RESIDENCE
RISING STAR RANCH
2807 NW CHIPMAN RD.
LEE'S SUMMIT, MO 64081

DESIGN CODE AND LOADS:

- 2018 INTERNATIONAL RESIDENTIAL CODE
- ROOF TRUSS DESIGN LOADS:
TOP CHORD DEAD LOAD = 10 PSF
BOTTOM CHORD DEAD LOAD = 10 PSF
TOP CHORD LIVE LOAD = 20 PSF
BOTTOM CHORD LIVE LOAD = 20 PSF
(WHERE REQUIRED BY CODE)
GROUND SNOW LOAD = 20 PSF
- WIND SPEED = 90 MPH (EXP. B)

GENERAL INFORMATION:

- AREA OF LIVING SPACE = 1,836 S.F.
- MINIMUM INSULATION VALUES
EXTERIOR WALLS - R-13
CEILINGS - R-30
DUCT INSULATION - R-5

- W.S.P. BRACED WALL AREAS
7/16" OSB SHEATHING FASTENED
WITH 8d COMMON NAILS AT
6" O.C. AT EDGES AND 12" O.C.
IN FIELD.

- THIS RESIDENCE IS ALL ELECTRIC. THERE ARE
NO GAS APPLIANCES, FIXTURES OR EXHAUST IN
THIS STRUCTURE.

GENERAL
PLANS SHALL COMPLY WITH THE INTERNATIONAL RESIDENTIAL BUILDING CODE WITH AMENDMENTS AS
ADOPTED BY THE GOVERNING JURISDICTION. IF ANY CHANGES OR DEVIATIONS FROM THE PLANS
ARE MADE DURING CONSTRUCTION, THE CONTRACTOR SHALL NOTIFY THE APPROPRIATE AUTHORITY
AND THE DESIGN PROFESSIONAL OF RECORD, EITHER (OR BOTH) OF WHOM MAY REQUIRE REVISED
DRAWINGS OR CALCULATIONS AT THEIR DISCRETION.

WHERE DISCREPANCIES EXIST BETWEEN THE STANDARD COMMENTS, NOTES FROM THE DESIGN
PROFESSIONAL OR THE CODE, THE MOST RESTRICTIVE SHALL APPLY.

FOUNDATIONS:

- THE FOUNDATION DESIGN SHALL BE BASED ON A MINIMUM SOIL BEARING CAPACITY OF
1500 PSF, UNLESS OTHERWISE INDICATED ON THE PLANS OR IF MODIFIED BY AN ENGINEERING
REPORT BASED ON ACTUAL SITE CONDITIONS.
- FOOTINGS SHALL EXTEND BELOW THE FROST LINE, MINIMUM DEPTH 36 INCHES BELOW GRADE.
- UNLESS OTHERWISE NOTED ON THE PLANS OR IF SITE CONDITIONS REQUIRE OTHERWISE, FOOTINGS
SHALL BE A MINIMUM OF 16 INCHES WIDE AND 8 INCHES DEEP WITH 2-#4 BARS CONTINUOUS.
- CONCRETE FLOOR SLAB SHALL BE A MINIMUM 5 1/2 INCHES THICK OVER A 2" RIGID INSULATION
BOARD OVER ±8 INCH OF 1/2" OR 3/4" CLEAN GRADED ROCK.
- SILL PLATES SHALL BE BOLTED TO THE FOUNDATION W/ A MINIMUM OF 1/2" ANCHOR BOLTS
EMBEDDED AT LEAST 1" INTO THE CMU FOUNDATION WALL AND SPACED NOT MORE THAN 3'-0"
ON CENTER AND WITHIN 12" OF EACH END PIECE.

FRAMING GENERAL:

- ALL LUMBER SIZES ARE FOR DOUGLAS FIR-LARCH UNLESS OTHERWISE NOTED.
- ALL HEADERS TO BE MINIMUM (2) #2-2x10 UNLESS OTHERWISE NOTED.
- ALL HEADERS TO BEAR ON A MINIMUM OF (2) 2x4 STUD POSTS UNLESS OTHERWISE NOTED.
- ALL SILLS AND SLEEPERS SUPPORTED ON CONCRETE OR MASONRY FURRING ATTACHED TO
CONCRETE OR MASONRY SHALL BE DECAY RESISTANT MATERIALS.
- FRAMING OF OPENINGS - HEADERS AND TRIMMERS SHALL BE OF SUFFICIENT GROSS SECTION TO
SUPPORT THE ROOF FRAMING. TRIMMER JOIST SHALL BE DOUBLED WHEN THE HEADER IS
SUPPORTED MORE THAN 3 FEET FROM THE TRIMMER JOIST BEARING. WHEN THE HEADER SPAN
EXCEEDS 4 FEET, THE HEADER AND TRIMMER SHALL BE DOUBLED.
- WATER-RESISTIVE BARRIER SHALL BE PROVIDED OVER ALL EXTERIOR WALLS.

RELEASE FOR CONSTRUCTION
AS NOTED FOR PLAN REVIEW
DEVELOPMENT SERVICES
LEE'S SUMMIT, MISSOURI
04/09/2024

DATE: 3-29-24


REVISIONS		Date
No.	Description	
1	REVISIONS PER PLAN REVIEW COMMENTS	4-5-24

PROJECT # 24-03-011

A100



 
This drawing has been prepared by the Engineer, or under his supervision. This drawing is provided as an instrument of service by the Designer/Engineer and is intended for use on this project only. Pursuant to the Architectural Works Copyright Protection Act of 1990, all drawings, specifications, ideas and designs, including the overall form, arrangement and composition of spaces and elements appearing herein constitute the original, copyrighted work of the Designer/Engineer. Any reproduction, use, or disclosure of information contained herein without prior written consent of the Engineer is strictly prohibited.
Copyright 2024 Lampen Engineering, Inc.



RECONSTRUCTION OF RESIDENCE
 RISING STAR RANCH
 2807 NW CHIPMAN RD.
 LEE'S SUMMIT, MO 64081

[illegible]

 A200



RELEASE FOR CONSTRUCTION
AS NOTED FOR PLAN REVIEW
DEVELOPMENT SERVICES
LEE'S SUMMIT, MISSOURI
04/09/2024

CHAPTER 6 WALL CONSTRUCTION			
TABLE R602.3(1) FASTENING SCHEDULE			
ITEM	DESCRIPTION OF BUILDING ELEMENTS	NUMBER AND TYPE OF FASTENER ^{a, b, c}	SPACING AND LOCATION
Roof			
1	Blocking between ceiling joists or rafters to top plate	4-8d box (2 1/2" x 0.113"); or 3-8d common (2 1/2" x 0.131"); or 3-10d box (3" x 0.128"); or 3-3" x 0.131" nails	Toe nail
2	Ceiling joists to top plate	4-8d box (2 1/2" x 0.113"); or 3-8d common (2 1/2" x 0.131"); or 3-10d box (3" x 0.128"); or 3-3" x 0.131" nails	Per joist, toe nail
3	Ceiling joist not attached to parallel rafter, laps over partitions (see Section R802.5.2 and Table R802.5.2)	4-10d box (3" x 0.128"); or 3-16d common (3 1/2" x 0.162"); or 4-3" x 0.131" nails	Face nail
4	Ceiling joist attached to parallel rafter (heel joint) (see Section R802.5.2 and Table R802.5.2)	Table R802.5.2	Face nail
5	Collar tie to rafter, face nail or 1 1/4" x 20 ga. ridge strap to rafter	4-10d box (3" x 0.128"); or 3-10d common (3" x 0.148"); or 4-3" x 0.131" nails	Face nail each rafter
6	Rafter or roof truss to plate	3-16d box nails (3 1/2" x 0.135"); or 3-10d common nails (3" x 0.148"); or 4-10d box (3" x 0.128"); or 4-3" x 0.131" nails	2 toe nails on one side and 1 toe nail on opposite side of each rafter or truss
7	Roof rafters to ridge, valley or hip rafters or roof rafter to minimum 2" ridge beam	4-16d (3 1/2" x 0.135"); or 3-10d common (3" x 0.148"); or 4-10d box (3" x 0.128"); or 4-3" x 0.131" nails	Toe nail
		3-16d box (3 1/2" x 0.135"); or 2-16d common (3 1/2" x 0.162"); or 3-10d box (3" x 0.128"); or 3-3" x 0.131" nails	End nail
Wall			
8	Stud to stud (not at braced wall panels)	16d common (3 1/2" x 0.162") 10d box (3" x 0.128"); or 3" x 0.131" nails	24" o.c. face nail
9	Stud to stud and abutting studs at intersecting wall corners (at braced wall panels)	16d box (3 1/2" x 0.135"); or 3" x 0.131" nails 16d common (3 1/2" x 0.162")	12" o.c. face nail 16" o.c. face nail
10	Built-up header (2" to 2" header or 1/2" spacer)	16d common (3 1/2" x 0.162") 16d box (3 1/2" x 0.135")	16" o.c. each edge face nail 12" o.c. each edge face nail
11	Continuous header to stud	5-8d box (2 1/2" x 0.113"); or 4-8d common (2 1/2" x 0.131"); or 4-10d box (3" x 0.128")	Toe nail
12	Top plate to top plate	16d common (3 1/2" x 0.162") 10d box (3" x 0.128"); or 3" x 0.131" nails	16" o.c. face nail 12" o.c. face nail
13	Double top plate splice	8-16d common (3 1/2" x 0.162"); or 12-16d box (3 1/2" x 0.135"); or 12-10d box (3" x 0.128"); or 12-3" x 0.131" nails	Face nail on each side of end joint (minimum 24" lap splice length each side of end joint)
14	Bottom plate to joist, rim joist, band joist or blocking (not at braced wall panels)	16d common (3 1/2" x 0.162") 16d box (3 1/2" x 0.135"); or 3" x 0.131" nails	16" o.c. face nail 12" o.c. face nail
15	Bottom plate to joist, rim joist, band joist or blocking (at braced wall panel)	3-16d box (3 1/2" x 0.135"); or 2-16d common (3 1/2" x 0.162"); or 4-3" x 0.131" nails	3 each 16" o.c. face nail 2 each 16" o.c. face nail 4 each 16" o.c. face nail
16	Top or bottom plate to stud	4-8d box (2 1/2" x 0.113"); or 3-16d box (3 1/2" x 0.135"); or 4-8d common (2 1/2" x 0.131"); or 4-10d box(3" x 0.128"); or 4-3" x 0.131" nails	Toe nail
17	Top plate to top plate	3-16d box (3 1/2" x 0.135"); or 2-16d common (3 1/2" x 0.162"); or 3-10d box (3" x 0.128"); or 3-3" x 0.131" nails	End nail
18	Top plates, laps at corners and intersections	3-10d box (3" x 0.128"); or 2-16d common (3 1/2" x 0.162"); or 3-3" x 0.131" nails	Face nail
19	1" brace to each stud and plate	3-8d box (2 1/2" x 0.113"); or 2-8d common (2 1/2" x 0.131"); or 2-10d box (3" x 0.128"); or 2 staples 1 3/4"	Face nail
20	1" x 6" sheathing to each bearing	3-8d box (2 1/2" x 0.113"); or 2-8d common (2 1/2" x 0.131"); or 2-10d box (3" x 0.128"); or 2 staples, 1" crown, 16 ga., 1 3/4" long	Face nail
21	2" x 8" and wider sheathing to each bearing	3-8d box (2 1/2" x 0.113"); or 3-8d common (2 1/2" x 0.131"); or 3-10d box (3" x 0.128"); or 3 staples, 1" crown, 16 ga., 1 3/4" long	Face nail

Floor				
2	1	Joist to sill, top plate or girder	4-8d box (2 1/2" x 0.113"); or 3-8d common (2 1/2" x 0.131"); or 3-10d box (3" x 0.128"); or 3-3" x 0.131" nails	Toe nail
2	2	Rim joist, band joist or blocking to sill or top plate (roof applications also)	8d box (2 1/2" x 0.113") 8d common (2 1/2" x 0.131"); or 10d box (3" x 0.128"); or 3" x 0.131" nails	4" o.c. toe nail 6" o.c. toe nail
2	1*	1" x 6" subfloor or less to each joist	3-8d box (2 1/2" x 0.113"); or 2-8d common (2 1/2" x 0.131"); or 3-10d box (3" x 0.128"); or 2 staples, 1" crown, 16 ga., 1 3/4" long	Face nail
2	4	2" subfloor to joist or girder	3-16d box (3 1/2" x 0.135"); or 2-16d common (3 1/2" x 0.162")	Blind and face nail
2	2	2" planks (plank & beam—floor & 5 roof)	3-16d box (3 1/2" x 0.135"); or 2-16d common (3 1/2" x 0.162")	At each bearing, face nail
2	6	Band or rim joist to joist	3-16d common (3 1/2" x 0.162") 4-10 box (3" x 0.128"), or 4-3" x 0.131" nails; or 4-3" x 14 ga. staples, 7/16" crown	End nail
2	7	Built-up girders and beams, 2-inch lumber layers	20d common (4" x 0.192"); or 10d box (3" x 0.128"); or 3" x 0.131" nails And: 2-20d common (4" x 0.192"); or 3-10d box (3" x 0.128"); or 3-3" x 0.131" nails	Nail each layer as follows: 32" o.c. at top and bottom and staggered. 24" o.c. face nail at top and bottom staggered on opposite sides
2	8	Ledger strip supporting joists or rafters	4-16d box (3 1/2" x 0.135"); or 3-16d common (3 1/2" x 0.162"); or 4-10d box (3" x 0.128"); or 4-3" x 0.131" nails	At each joist or rafter, face nail
2	9	Bridging or blocking to joist	2-10d box (3" x 0.128"), or 2-8d common (2 1/2" x 0.131"); or 2-3" x 0.131" nails	Each end, toe nail
I T E M	DESCRIPTION OF BUILDING ELEMENTS		NUMBER AND OF FASTENER ^{a, b, c}	SPACING OF FASTENERS Edges (inches) ^h Intermediate supports ^{c, e} (inches)
Wood structural panels, subfloor, roof and interior wall sheathing to framing and particleboard wall sheathing to framing [see Table R602.3(3) for wood structural panel exterior wall sheathing to wall framing]				
3	0	3/8" - 1/2"	6d common (2" x 0.113") nail (subfloor, wall) ⁱ 8d common (2 1/2" x 0.131") nail (roof); or RRSR-01 (2 3/8" x 0.113") nail (roof) ^j	6 12 ^f
3	1	19/32" - 1"	8d common (2 1/2" x 0.131"); or RRSR-01; (2 3/8" x 0.113") nail (roof) ^j	6 12 ^f
3	2	1 1/8" - 1 1/4"	10d common (3" x 0.148") nail; or 8d (2 1/2" x 0.131") deformed nail	6 12
Other wall sheathing				
3	3	1/2" structural cellulose fiberboard sheathing	1 1/2" galvanized roofing nail, 7/16" head diameter, or 1 1/4" long 16 ga. staple with 7/16" or 1" crown	3 6
3	4	25/32" structural cellulose fiberboard sheathing	1 3/4" galvanized roofing nail, 7/16" head diameter, or 1 1/2" long 16 ga. staple with 7/16" or 1" crown	3 6
3	5	1/2" gypsum sheathing ^d	1 1/2" galvanized roofing nail; staple galvanized, 1 1/2" long, 1 1/4" screws, Type W or S	7 7
3	6	5/8" gypsum sheathing ^d	1 3/4" galvanized roofing nail; staple galvanized, 1 5/8" long, 1 5/8" screws, Type W or S	7 7
Wood structural panels, combination subfloor underlayment to framing				
3	7	3/4" and less	6d deformed (2" x 0.120") nail; or 8d common (2 1/2" x 0.131") nail	6 12
3	8	7/8" - 1"	8d common (2 1/2" x 0.131") nail; or 8d deformed (2 1/2" x 0.120") nail	6 12
3	9	1 1/8" - 1 1/4"	10d common (3" x 0.148") nail; or 8d deformed (2 1/2" x 0.120") nail	6 12

For SI: 1 inch = 25.4 mm, 1 foot = 304.8 mm, 1 mile per hour = 0.447 m/s; 1 ksi = 6.895 MPa.

- a. Nails are smooth-common box or deformed shanks except where otherwise stated. Nails used for framing and sheathing connections shall have minimum average bending yield strengths as shown: 80 ksi for shank diameter of 0.192 inch (20d common nail), 90 ksi for shank diameters larger than 0.142 inch but not larger than 0.177 inch, and 100 ksi for shank diameters of 0.142 inch or less.
- b. Staples are 16 gage wire and have a minimum 7/16-inch on diameter crown width.
- c. Nails shall be spaced at not more than 6 inches on center at all supports where spans are 48 inches or greater.
- d. Four-foot by 8-foot or 4-foot by 9-foot panels shall be applied vertically.
- e. Spacing of fasteners not included in this table shall be based on Table R602.3(2).
- f. For wood structural panel roof sheathing attached to gable end roof framing and to intermediate supports within 48 inches of roof edges and ridges, nails shall be spaced at 6 inches on center where the ultimate design wind speed is less than 130 mph and shall be spaced 4 inches on center where the ultimate design wind speed is 130 mph or greater but less than 140 mph.
- g. Gypsum sheathing shall conform to ASTM C1396 and shall be installed in accordance with GA 253. Fiberboard sheathing shall conform to ASTM C208.
- h. Spacing of fasteners on roof sheathing panel edges applies to panel edges supported by framing members and required blocking and at floor perimeters only. Spacing of fasteners on roof sheathing panel edges applies to panel edges supported by framing members and required blocking. Blocking of roof or floor sheathing panel edges perpendicular to the framing members need not be provided except as required by other provisions of this code. Floor perimeter shall be supported by framing members or solid blocking.
- i. Where a rafter is fastened to an adjacent parallel ceiling joist in accordance with this schedule, provide two toe nails on one side of the rafter and toe nails from the ceiling joist to top plate in accordance with this schedule. The toe nail on the opposite side of the rafter shall not be required.
- j. RSR5-01 is a Roof Sheathing Ring Shank nail meeting the specifications in ASTM F1667.



This drawing has been prepared by the Engineer, or under his supervision. This drawing is provided as an instrument of service to the Designer/Engineer and is intended for use on this project only. Pursuant to the Architectural Works Copyright Protection Act of 1990, all drawings, specifications, ideas and designs, including the overall form, arrangement and composition of spaces and elements appearing herein constitute the original, copyrighted work of the Designer/Engineer. Any reproduction, use, or disclosure of information contained herein without prior written consent of the Engineer is strictly prohibited.

Copyright 2024 Lampen Engineering, Inc.



RECONSTRUCTION OF RESIDENCE
RISING STAR RANCH
2807 NW CHIPMAN RD.
LEE'S SUMMIT, MO 64081

[illegible]

A300