

VICINITY MAP
SEC 23, TWP 47, RGE 32
SCALE 1"=2000'

PROJECT TEAM & UTILITY CONTACT LIST	
<u>OWNER / DEVELOPER</u> HUNT MIDWEST REAL ESTATE DEVELOPMENT, INC 8300 NE UNDERGROUND DRIVE KANSAS CITY, MO 64161 CONTACT: AARON SCHMIDT PHONE: 816.455.2500 EMAIL: ASCHMIDT@HUNTMIDWEST.COM	<u>UTILITY SERVICE NUMBERS</u> NAME: LEE'S SUMMIT PUBLIC WORKS PHONE: 816-969-1800 NAME: LEE'S SUMMIT WATER UTILITIES PHONE: 816-969-1900
<u>ENGINEER</u> OLSSON 1301 BURLINGTON ST. SUITE 100 NORTH KANSAS CITY, MO 64116 CONTACT: STEPHEN SAYLOR, P.E. PHONE: 816.442.6061 EMAIL: SSAYLOR@OLSSON.COM	NAME: SPIRE PHONE: 314-342-0500 NAME: AT&T PHONE: 800-286-8313 NAME: EVERGY PHONE: 816-471-5275 NAME: SPECTRUM PHONE: 877-772-2253
<u>SURVEYOR</u> OLSSON 1301 BURLINGTON ST. SUITE 100 NORTH KANSAS CITY, MO 64116 CONTACT: JASON ROUDEBUSH PHONE: 816.361.1177 EMAIL: JROUDEBUSH@OLSSON.COM	NAME: GOOGLE FIBER PHONE: 877-454-6959

1



EAGLE CREEK VILLAS FIRST PLAT SANITARY SEWER PLANS

SECTION 23, TOWNSHIP 47 N, RANGE 32 W.
IN LEE'S SUMMIT, JACKSON COUNTY, MISSOURI



PROPERTY DESCRIPTION:

TRACT OF LAND IN THE NORTHEAST QUARTER OF SECTION 23 TOWNSHIP 47 NORTH, RANGE 32 WEST OF THE 5TH PRINCIPAL MERIDIAN IN LEE'S SUMMIT, JACKSON COUNTY, MISSOURI BEING BOUNDED AND DESCRIBED BY OR UNDER THE DIRECT SUPERVISION OF JASON S ROUDEBUSH, P.L.S. 202014092 AS FOLLOWS: COMMENCING AT THE SOUTHEAST CORNER OF SAID NORTHEAST QUARTER; THENCE NORTH 02°46'08" EAST, ON THE EAST LINE OF SAID NORTHEAST QUARTER 1,323.83 FEET TO THE SOUTHEAST CORNER OF THE NORTH HALF OF SAID NORTHEAST QUARTER, ALSO BEING THE NORTHEAST CORNER OF EAGLE CREEK - FIFTH PLAT, A SUBDIVISION OF LAND IN SAID LEE'S SUMMIT RECORDED OCTOBER 9, 2001 AS INSTRUMENT NUMBER 200100082127 IN SAID OFFICE OF RECORDER OF DEEDS, JACKSON COUNTY, MISSOURI; THENCE NORTH 87°41'31" WEST, ON SAID SOUTH LINE AND SAID NORTHEAST QUARTER 1,323.83 FEET TO THE POINT OF BEGINNING OF THE TRACT OF LAND TO BE HEREIN DESCRIBED, THENCE NORTH 87°41'31" WEST ON SAID SOUTH LINE AND SAID NORTH LINE, 675.87 FEET TO THE NORTHWEST CORNER OF SAID EAGLE CREEK - FIFTH PLAT, ALSO BEING THE NORTHWEST CORNER OF EAGLE CREEK - SIXTH PLAT, A SUBDIVISION IN SAID LEE'S SUMMIT RECORDED OCTOBER 9, 2001 AS INSTRUMENT NUMBER 200100082129 IN BOOK 70 AT PAGE 15 IN SAID OFFICE OF RECORDER OF DEEDS, JACKSON COUNTY, MISSOURI; THENCE NORTH 87°41'31" WEST ON SAID SOUTH LINE, ALSO BEING THE NORTH LINE OF SAID EAGLE CREEK - SIXTH PLAT, 704.45 FEET TO THE NORTHWEST CORNER OF SAID EAGLE CREEK - SIXTH PLAT, ALSO BEING THE EASTERLY LINE OF TRACT C OF EAGLE CREEK - SEVENTH PLAT, LOTS 230 THRU 282, INCLUSIVE, AND TRACT C, A SUBDIVISION OF LAND IN SAID LEE'S SUMMIT RECORDED APRIL 25, 2003 AS INSTRUMENT NUMBER 2003000452 IN SAID OFFICE OF RECORDER OF DEEDS, JACKSON COUNTY, MISSOURI; THENCE NORTH 87°41'31" WEST ON SAID SOUTH LINE AND SAID EASTERLY LINE, 61.41 FEET, THENCE LEAVING SAID SOUTH LINE, NORTH 02°46'08" EAST, ON SAID EASTERLY LINE, 197.92 FEET TO THE NORTHEAST CORNER OF SAID TRACT C, ALSO BEING A POINT ON THE EXISTING SOUTHERLY RIGHT-OF-WAY LINE SW EAGLE VIEW DRIVE, AS ESTABLISHED BY SAID EAGLE CREEK - SEVENTH PLAT, LOTS 230 THRU 282, INCLUSIVE, AND TRACT C; THENCE EASTERLY, ON SAID EXISTING SOUTHERLY RIGHT-OF-WAY LINE, ON A CURVE TO THE LEFT HAVING AN INITIAL TANGENT BEARING OF SOUTH 86°54'35" EAST WITH A RADIUS OF 830.00 FEET, A CENTRAL ANGLE OF 29°39'14" AND AN ARC DISTANCE OF 429.57 FEET; THENCE NORTH 63°26'11" EAST, ON SAID EXISTING SOUTHERLY RIGHT-OF-WAY LINE, 285.62 FEET; THENCE EASTERLY, ON SAID EXISTING SOUTHERLY RIGHT-OF-WAY LINE, ON A CURVE TO THE RIGHT BEING TANGENT TO THE LAST DESCRIBED CURVE WITH A RADIUS OF 830.00 FEET, A CENTRAL ANGLE OF 31°00'00" AND AN ARC DISTANCE OF 688.40 FEET; THENCE SOUTH 88°30'22" EAST, ON SAID EXISTING SOUTHERLY RIGHT-OF-WAY LINE, 150.00 FEET; THENCE SOUTHERLY, ON A CURVE TO THE RIGHT BEING TANGENT TO THE LAST DESCRIBED CURVE WITH A RADIUS OF 830.00 FEET, THENCE SOUTH 02°46'08" WEST, 259.61 FEET; THENCE SOUTH 02°31'58" WEST, 50.00 FEET; THENCE WESTERLY ON A CURVE TO THE RIGHT HAVING AN INITIAL TANGENT BEARING OF NORTH 87°41'31" WEST WITH A RADIUS OF 1,025.00 FEET, A CENTRAL ANGLE OF 04°39'21" AND AN ARC DISTANCE OF 83.29 FEET; THENCE SOUTH 02°18'29" WEST, 123.38 FEET TO THE POINT OF BEGINNING, CONTAINING 669.406 SQUARE FEET OR 15.37 ACRES, MORE OR LESS.

BENCHMARK

BENCHMARK NO. 1
CHISELED SQUARE ON THE NORTHWEST CORNER OF 6' X 4' CURB INLET THAT IS ON THE SOUTH SIDE OF SW EAGLEVIEW DRIVE AND WEST OF SW BURNINGWOOD LANE, STRAIGHT SOUTH OF A 6' X 4' CURB INLET.
ELEVATION = 1002.10

SHEET LIST TABLE	
SHEET #	SHEET TITLE
C201	TITLE SHEET
C202	GENERAL NOTES
C203	GENERAL LAYOUT
C204	SANITARY PLAN & PROFILE (LINE 1)
C205	SANITARY PLAN & PROFILE (LINE 1)
C206	SANITARY PLAN & PROFILE (LINE 1)
C207	SANITARY PLAN & PROFILE (LINE 1)
C208	SANITARY PLAN & PROFILE (LINE 2)
C209	SANITARY PLAN & PROFILE (LINE 3)
C210	DESIGN TABLES
C211	DETAIL SHEET
C212	DETAIL SHEET

RELEASED FOR CONSTRUCTION
As Noted on Plan Review

Development Services Department
Lee's Summit, Missouri

05/23/2024

OLSSON HAS BEEN RETAINED TO PROVIDE AS-BUILT DRAWINGS FOR THIS PROJECT.

Step 5

CIVIL ENGINEER

MO#2018021248

5/7/2024

DATE

drawn by: _____					
checked by: _____ CW					
approved by: _____ SS					
QA/QC by: _____ JS					
project no.: _____ JS					
drawing no.: C TLT01 A202467					
date: 02/23/2024					
SHEET C201					
TITLE SHEET SANITARY SEWER PLANS					
EAGLE CREEK VILLAS FIRST PLAT					
LEE'S SUMMIT, MISSOURI					2023
REV. NO.	DATE	REVISIONS DESCRIPTION	BY		
1	02/23/2024	REVISED PER CITY COMMENTS			
2	04/02/2024	REVISED PER CITY COMMENTS			
3	05/07/2024	REVISED PER CITY COMMENTS			
REVISIONS					
					
 Olsson - Civil Engineering Missouri Certificate of Authority #001592 1301 Burlington Street North Kansas City, MO 64116 TEL 816.361.1177 www.olsson.com					

DWG: F:\2020\2001-2500\020-2467-A\40-Design\AutoCAD\Final Plans\Sheets\GNCV\Sanitary\C_TTL01_A202467.dwg
DATE: May 07, 2024 11:04am
USER: ssoyor
XREFS: C_PTBK_A202467

GENERAL NOTES

1.

THE CONTRACTOR SHALL BE RESPONSIBLE FOR ENSURING THAT THE PLANS IN THEIR POSSESSION ARE THE MOST CURRENT VERSION ISSUED, ARE FULLY COORDINATED WITH ALL SUBCONTRACTORS, AND PRESENT ON SITE AT ALL TIMES. CURRENT PLANS PREPARED BY OLSSON MAY BE OBTAINED AT THE DIRECTION OF OLSSON'S CLIENT. DIRECT REQUESTS TO OLSSON MAY REQUIRE ADDITIONAL AUTHORIZATIONS, AGREEMENTS, AND/OR FEES. PLEASE CONTACT THE ENGINEER FOR INFORMATION.
2.

THE CONTRACTOR SHALL BE RESPONSIBLE FOR ANY DEVIATIONS FROM THESE PLANS UNLESS WRITTEN APPROVAL FROM ENGINEER, OWNER, AND DEVELOPER.
3.

ALL WORK AND MATERIALS SHALL BE SUBJECT TO INSPECTION AND APPROVAL BY THE OWNER OR THE OWNER'S REPRESENTATIVE.
4.

ALL ESTIMATES OF QUANTITIES ARE FOR INFORMATIONAL PURPOSES ONLY. THE CONTRACTOR SHALL BE RESPONSIBLE FOR DETERMINING QUANTITIES AND ITEMS OF WORK.
5.

THE CONTRACTOR SHALL BE RESPONSIBLE FOR PROVIDING ALL LABOR, MATERIALS, AND EQUIPMENT REQUIRED TO COMPLETE THE WORK SHOWN IN THE PLANS.
6.

THE CONTRACTOR SHALL BE RESPONSIBLE FOR OBTAINING ALL REQUIRED PERMITS, PAYING ALL FEES, AND FOR OTHERWISE COMPLYING WITH ALL APPLICABLE REGULATIONS GOVERNING THE WORK.
7.

THE CONTRACTOR SHALL NOT ENGAGE IN ACTIVITIES THAT MAY ENCROACH ON WATERS OF THE U.S., INCLUDING WETLANDS, UNTIL ANY NECESSARY PERMITS MAY BE OBTAINED. THE CONTRACTOR SHALL REVIEW AND COMPLY WITH ALL CONDITIONS DESCRIBED IN THE PERMIT.
8.

THE CONTRACTOR SHALL BE SOLELY RESPONSIBLE FOR CONDITIONS OF THE JOB SITE, THE SAFETY OF ALL PERSONS INCLUDING VISITORS AND THE GENERAL PUBLIC, AND PROPERTY DURING PERFORMANCE OF THE WORK. THIS REQUIREMENT WILL APPLY CONTINUOUSLY THROUGHOUT THE PROJECT AND NOT BE LIMITED BY WORKING HOURS. ANY CONSTRUCTION OBSERVATION BY THE ENGINEER OF THE CONTRACTOR'S PERFORMANCE IS NOT INTENDED TO INCLUDE REVIEW OF THE ADEQUACY OF THE CONTRACTOR'S SAFETY MEASURES.
9.

PRIOR TO COMMENCEMENT OF WORK THE CONTRACTOR SHALL NOTIFY AND COORDINATE WITH ALL UTILITY COMPANIES AND OBTAIN ANY RELEVANT INFORMATION. NOTIFY ENGINEER OF ANY DISCREPANCIES.
10.

THE CONTRACTOR IS RESPONSIBLE FOR THE PROTECTION OF ALL BOUNDARY CORNERS AND SECTION CORNERS. ANY BOUNDARY CORNER AND/OR SECTION CORNER DISTURBED OR DAMAGED BY CONSTRUCTION ACTIVITIES SHALL BE RESET BY A LAND SURVEYOR LICENSED IN THE STATE OF MISSOURI, AT THE CONTRACTOR'S EXPENSE.
11.

THE CONTRACTOR IS RESPONSIBLE FOR THE PROTECTION OF ADJACENT PROPERTIES AND SHALL TAKE ALL PRECAUTIONS NECESSARY TO PREVENT DAMAGE DURING CONSTRUCTION. THE CONTRACTOR IS ALSO RESPONSIBLE FOR REPAIRING ANY DAMAGE RESULTING FROM CONSTRUCTION ACTIVITIES.
12.

PRIOR TO MOVING OFF THE JOB THE CONTRACTOR SHALL NOTIFY THE OWNER AND ENGINEER TO PERFORM A FINAL WALK-THROUGH OF THE CONSTRUCTION SITE.

REFERENCES

1.

UNLESS EXPLICITLY DESCRIBED OTHERWISE WITHIN THESE PLANS THE FOLLOWING SHALL APPLY:

A.

ALL CONSTRUCTION, INCLUDING THOSE LISTED BELOW, SHALL CONFORM TO THE LATEST CODES AND ORDINANCES OF LEE'S SUMMIT, MISSOURI.

B.

ALL CONSTRUCTION IN MODOT RIGHT-OF-WAY SHALL CONFORM TO THE LATEST SPECIFICATIONS ADOPTED BY U.S. DEPARTMENT OF TRANSPORTATION AND MODOT.

C.

ALL TRAFFIC CONTROL SIGNAGE SHALL CONFORM WITH THE CURRENT EDITION OF THE MANUAL FOR UNIFORM TRAFFIC CONTROL DEVICES (MUTCD).

D.

ALL UTILITY EXTENSIONS AND CONSTRUCTION SHALL CONFORM TO THE STANDARDS AND SPECIFICATIONS OF THE UTILITY COMPANIES.

E.

ALL EXTERIOR PAVEMENT (PCC, ASPHALT, ETC.) SHALL BE IN CONFORMANCE WITH THE SPECIFICATIONS OF LEE'S SUMMIT, MISSOURI
4.

THE CONTRACTOR IS RESPONSIBLE FOR CONTACTING THE DELIVERY MANAGER AND COORDINATING ANY MAILBOXES THAT MAY BE DISTURBED. FAILURE TO DO SO MAY SUBJECT THE CONTRACTOR TO PROSECUTION BY THE FEDERAL GOVERNMENT.

EXISTING CONDITIONS

1.

THE CONTRACTOR SHALL VISIT THE SITE AND BECOME FAMILIAR WITH THE EXISTING CONDITIONS OF THE PROJECT AREA.
2.

THE CONTRACTOR SHALL BE RESPONSIBLE FOR PERFORMING THEIR OWN INVESTIGATIONS AND MAKING THEIR OWN ASSUMPTIONS REGARDING SITE SURFACE AND SUBSURFACE CONDITIONS. THIS INCLUDES THE LOCATION AND CONSISTENCY OF ANY EXISTING ROCK LAYERS UNDERLYING THE PROJECT SITE. CONTACT THE ENGINEER REGARDING ANY DISCREPANCIES THAT MAY AFFECT THE ABILITY TO CONSTRUCT FROM THESE PLANS AS DESIGNED.
3.

EXISTING CONDITIONS WERE DETERMINED THROUGH A VARIETY OF METHODS THAT MAY INCLUDE SURVEY, AERIAL IMAGERY, AVAILABLE RECORDS, GIS DATA, ETC. SUBSURFACE CONDITIONS ARE APPROXIMATE AND MAY NOT INCLUDE ALL UTILITIES AND OTHER SITE IMPROVEMENTS PRESENT ON SITE. THE CONTRACTOR SHALL MAKE EXPLORATION EXCAVATIONS AND LOCATE EXISTING UNDERGROUND UTILITIES SUFFICIENTLY AHEAD OF CONSTRUCTION TO PERMIT REVISIONS TO PLANS WHEN CONFLICTS AND DISCREPANCIES ARE FOUND.

CONSTRUCTION

1.

THE CONTRACTOR SHALL INSTALL TRAFFIC CONTROL WHILE WORKING IN THE PUBLIC RIGHT-OF-WAY AS SHOWN IN THESE PLANS. IF PLANS ARE NOT PROVIDED, CONTRACTOR SHALL COORDINATE AND PROVIDE CONTROLS TO THE SATISFACTION OF THE RIGHT-OF-WAY OWNER.
2.

THE CONTRACTOR SHALL PROTECT ALL TREES OVER 3" CALIPER FROM DAMAGE. NO TREE SHALL BE REMOVED WITHOUT PERMISSION OF THE OWNER, UNLESS SHOWN OTHERWISE ON THESE PLANS.
3.

THE CONTRACTOR SHALL DISPOSE ALL WASTE MATERIAL RESULTING FROM THE PROJECT OFF-SITE AND IN STRICT CONFORMANCE WITH ALL LOCAL CODES AND ORDINANCES.
4.

ALL MANHOLES, CATCH BASINS, UTILITY VALVES AND METER PITS ARE TO BE ADJUSTED OR REBUILT TO GRADE AS REQUIRED. NOT ALL ADJUSTMENTS ARE INDICATED IN THE PLANS.
5.

THE CONTRACTOR SHALL STREET SWEEP OR OTHERWISE CLEAN ALL ACCESS ROUTES TO THE SITE AT CONCLUSION OF THE PROJECT.

SHOP DRAWINGS

1.

THE CONTRACTOR SHALL SUBMIT SHOP DRAWING A MINIMUM OF 7 DAYS PRIOR TO THE REQUESTED DATE OF APPROVAL. ENGINEER SHALL REVIEW SHOP DRAWINGS OR SAMPLES CONFORMANCE WITH THE DESIGN FOR THIS PROJECT AS DESCRIBED IN THE PLANS. THE CONTRACTOR SHALL BE RESPONSIBLE FOR ERRORS OR OMISSIONS IN SHOP DRAWINGS. THE ENGINEER'S REVIEW SHALL NOT EXTEND TO MEANS OR METHODS OF CONSTRUCTION. CONTRACTOR SHALL BE RESPONSIBLE FOR ANY VARIATION FROM THE REQUIREMENTS OF THE CONTRACT DOCUMENTS UNLESS CONTRACTOR HAS NOTIFIED ENGINEER OF EACH SUCH VARIATION AT THE TIME OF SUBMISSION, AND OBTAINED ENGINEER'S WRITTEN APPROVAL OF EACH SUCH VARIATION. PRIOR TO SUBMITTING EACH SHOP DRAWING OR SAMPLE, CONTRACTOR SHALL HAVE REVIEWED AND VERIFIED:

A.

ALL FIELD MEASUREMENTS, QUANTITIES, DIMENSIONS, SPECIFIED PERFORMANCE CRITERIA, INSTALLATION REQUIREMENTS, MATERIALS, CATALOG NUMBERS AND SIMILAR INFORMATION WITH RESPECT THERETO;

B.

ALL MATERIALS WITH RESPECT TO INTENDED USE, FABRICATION, SHIPPING, HANDLING, STORAGE, ASSEMBLY AND INSTALLATION PERTAINING TO THE PERFORMANCE OF THE WORK;

C.

ALL INFORMATION RELATIVE TO MEANS, METHODS, TECHNIQUES, SEQUENCES AND PROCEDURES OF CONSTRUCTION AND SAFETY PRECAUTIONS AND PROGRAMS INCIDENT THERETO;

D.

CONTRACTOR SHALL ALSO HAVE REVIEWED AND COORDINATED EACH SHOP DRAWING OR SAMPLE WITH OTHER SHOP DRAWINGS AND SAMPLES, AND WITH THE REQUIREMENTS OF THE WORK AND THE CONTRACT DOCUMENTS.

E.

ALL SUBMITTED SHOP DRAWINGS SHALL BEAR A STAMP OR SPECIFIC WRITTEN INDICATION AND SIGNATURE THAT CONTRACTOR HAS FULLY COMPLETED THE ABOVE TASKS.
2.

SHOP DRAWINGS AS DESCRIBED ABOVE ARE REQUIRED FOR, BUT NOT LIMITED TO, THE FOLLOWING:

A.

ALL SANITARY SEWER STRUCTURES TO BE INSTALLED WITH THIS PROJECT.

B.

ANY ITEMS IN THESE PLANS THAT ALLOW FOR AN 'APPROVED EQUAL' ALTERNATIVE.

SANITARY SEWER GENERAL NOTES

1.

PRIOR TO COMMENCEMENT OF WORK THE CONTRACTOR SHALL NOTIFY AND COORDINATE CONSTRUCTION WITH CITY OF LEE'S SUMMIT, MISSOURI.
2.

ALL PIPE LENGTHS ARE CALCULATED LINEARLY FROM CENTER OF STRUCTURE TO CENTER OF STRUCTURE.
3.

ALL STRUCTURE DIMENSIONS ARE TO INSIDE FACE OF STRUCTURE.
4.

COORDINATES ARE PROVIDED AT THE CENTER OF STRUCTURE. ADDITIONAL COORDINATES PROVIDED ARE PER LOCAL CODES AND ORDINANCES OR AS AN AID WHEN ORIENTING THE LID DURING INSTALLATION.
5.

THE CONTRACTOR SHALL EXPOSE EXISTING UTILITIES AT LOCATIONS OF POSSIBLE CONFLICT AND POINTS OF CONNECTION PRIOR TO ANY CONSTRUCTION OF SANITARY SEWER.
6.

SANITARY SEWER TRENCHES SHALL BE CONSTRUCTED SUCH THAT UNDISTURBED EXISTING SOIL OR FILL COMPACTED TO 95% PROCTOR DENSITY IS AT A DEPTH THAT IS 18" ABOVE TOP OF PROPOSED PIPE.
7.

MANHOLE INVERT CHANNELS SHALL BE SMOOTH, CIRCULAR, AND CONFORMING TO ½ THE ADJACENT PIPE SECTION (INVERT TO CENTER). CHANGES IN DIRECTION OF FLOW SHALL BE MADE WITH A SMOOTH CURVE AND MAINTAIN SHAPE THROUGHOUT. CHANGES IN GRADE OF ADJACENT PIPES SHALL BE TRANSITIONED SMOOTHLY AND EVENLY THROUGH THE MANHOLE.
8.

PIPE PENETRATIONS SHALL BE USE GASKETS TO ENSURE WATERTIGHT SEALS.
9.

TRACING TAPE SHALL BE INSTALLED ALONG ALL NON-METALLIC SURFACES OR AS DIRECTED BY LOCAL CODES AND ORDINANCES.
10.

SEWER LINE INSPECTIONS AND TESTING MUST BE SCHEDULED A MINIMUM OF TWO FULL BUSINESS DAYS IN ADVANCE. CONTRACTOR SHALL FURNISH ALL TESTING EQUIPMENT. TESTING SHALL INCLUDE

A.

MANDREL TEST OF ALL GRAVITY SEWERS. IF THE MANDREL TEST FAILS ON ANY SECTION OF PIPE, THAT SECTION SHALL BE UNCOVERED AND REPLACED.

B.

AIR PRESSURE TEST OF ALL GRAVITY SEWERS.

C.

VACUUM TEST OF ALL MANHOLES.
11.

REFER TO SHEET C206 FOR SANITARY DESIGN & SEWER LATERAL INFORMATION.
12.

ALL SERVICE LINE CONNECTIONS SHALL BE MADE WITH AN 8"x4" PVC WYE, 4"PVC 45° BEND, AND THE APPROPRIATE LENGTH OF 4" PVC LATERAL (UNLESS OTHERWISE SHOWN) AND CAP. SEE DETAIL SHEET C207.
13.

MSFE- INDICATES LOWEST FLOOR SERVICEABLE BY PROPOSED SANITARY SEWER.
14.

MAXIMUM DEVIATION FROM LATERAL STATION LOCATIONS AS CALLED OUT SHALL BE 2.0' TO AVOID PIPE JOINT.
15.

SANITARY LATERALS ARE DESIGNED @ 2.00% SLOPE. IF RISER IS INDICATED, IT IS TO BE AT THE SANITARY MAIN, UNLESS OTHERWISE NOTED.
16.

REFER TO CURRENT CITY SPECIFICATIONS FOR MINIMUM PIPE SLOPES.
17.

CONTRACTOR MAY BE REQUIRED TO RECONSTRUCT PIPE AND STRUCTURE IF MINIMUM INVERT DROP OR PIPE SLOPE REQUIREMENTS ARE NOT MET.
18.

SANITARY STRUCTURES SHALL BE PER CURRENT CITY DETAILS. IF CITY DOES NOT HAVE PUBLISHED DETAILS STRUCTURES SHALL BE PER CURRENT APWA SPECIFICATIONS.
19.

GRAVITY SANITARY SEWER AND WATER LINES SHALL BE SEPARATED BY A MINIMUM OF 10' HORIZONTALLY WHEN PARALLEL AND 2' VERTICALLY WHEN CROSSING. WATER LINES SHALL CROSS ABOVE SANITARY SEWERS.

ESTIMATE OF QUANTITIES				
ITEM NO.	DESCRIPTION	UNIT	QUANTITY	AS-BUILT
SANITARY				
	8" SANITARY PVC (SDR-26)	L.F.	2357.37	3
	MANHOLES, STD. 4' DIA.	EA.	11	
	CONNECTION TO EXISTING STRUCTURE	EA.	1	
	TRACER WIRE	L.F.	2357.37	3
	SERVICE WYE	EA.	58	
	4" LATERAL PIPE	L.F.	2308.44	3

SUMMARY OF QUANTITIES AS INDICATED ABOVE AND ANY QUANTITIES AS SHOWN WITHIN THE PLANS HAVE BEEN PROVIDED FOR PERMITTING PURPOSES ONLY AND ARE NOT INTENDED FOR USE IN PREPARATION OF CONTRACT DOCUMENTS. QUANTITIES INTENDED FOR, BUT NOT LIMITED TO, THE PREPARATION OF PROPOSALS AND BID DOCUMENTS SHALL BE INDEPENDENTLY EVALUATED BY THE ESTIMATING PARTY BASED UPON THE CONTENTS OF THESE PLANS.

PLAN LEGEND

_____	R/W	PROPERTY BOUNDARY; R/W LINE
_____		PROPERTY LOT LINE
_____	SS	EXISTING SANITARY LINE
_____	SD	EXISTING STORM LINE
_____	W	EXISTING WATER LINE
_____	SS	PROPOSED SANITARY LINE
-----		PROPOSED SANITARY SERVICE STUB
_____	SD	PROPOSED STORM LINE
_____	W	PROPOSED WATER LINE
⊕		SURVEY CONTROL POINT
⊕		SURVEY BENCHMARK
⎓		ELECTRIC BOX
⊖		ELECTRICAL POLE
⊖		SIGN
⊙		STORM MANHOLE
⊙		STORM INTAKE
⊙		SANITARY MANHOLE
⊙		GAS METER
⊙		GAS MANHOLE
⊙		FIBER BOX

EASEMENT ABBREVIATIONS LIST

A.E.	ACCESS EASEMENT
T.E.	TEMPORARY EASEMENT
U.E.	UTILITY EASEMENT

SANITARY SEWER SERVICE STUBS SHOWN ON THIS SHEET TO SERVE FUTURE BUILDINGS THAT ARE NOT PROPOSED WITH THESE PLANS.

RELEASED FOR CONSTRUCTION
As Noted on Plan Review
Development Services Department
Lee's Summit, Missouri
05/23/2024

olsson

Olsson - Civil Engineering
Missouri Certificate of Authority #001592
1301 Burlington Street
North Kansas City MO 64116
TEL 816.361.1177
www.olsson.com

STATE OF MISSOURI
STEPHEN M. SAYLOR
NUMBER
PE-2018021246
5/7/2024

REVISIONS

REV. NO.	DATE	REVISIONS DESCRIPTION	BY
1	02/23/2024	REVISED PER CITY COMMENTS	
2	04/02/2024	REVISED PER CITY COMMENTS	
3	05/07/2024	REVISED PER CITY COMMENTS	

GENERAL NOTES
SANITARY SEWER PLANS

EAGLE CREEK VILLAS
FIRST PLAT

LEE'S SUMMIT, MISSOURI

2023

drawn by: _____ CW

checked by: _____ SS

approved by: _____ JS

QA/QC by: _____ JS

project no.: A20-2467

drawing no.: C TTL01 A202467



date: 02/23/2024

SHEET

C202

DWG: F:\2020\2001-2500\020-2467-A\40-Design\AutoCAD\Final Plans\Sheets\Sanitary\Sanitary\GEN01_A202467.dwg
DATE: May 07, 2024 11:05am
XREFS: C_PSSWR_A202467 C_PUTIL_A202467 C_FBASE_A202467 C_PBASE_A202467 C_PENDY_A202467 C_PTBLK_A202467
USER: ssoy/or

Structure Table		
STRUCTURE ID	NORTHING	EASTING
50-111	987753.1200	2810757.5740
50-145	987953.0650	2810812.2860
FUT MH 1-9	988210.1077	2812423.7050
MH 1-2	987957.9565	2810925.1621
MH 1-3	987988.3494	2811063.5262
MH 1-4	987884.3497	2811225.1389
MH 1-5	987895.5994	2811555.2621
MH 1-6	987886.8284	2811788.7393
MH 1-7	987851.6460	2812093.9038
MH 1-8	987826.5606	2812405.2040
MH 2-1	988013.3441	2811793.7724
MH 2-2	988225.1174	2811770.4221
MH 3-1	988065.8315	2812106.3650
MH 3-2	988234.7455	2812069.6445

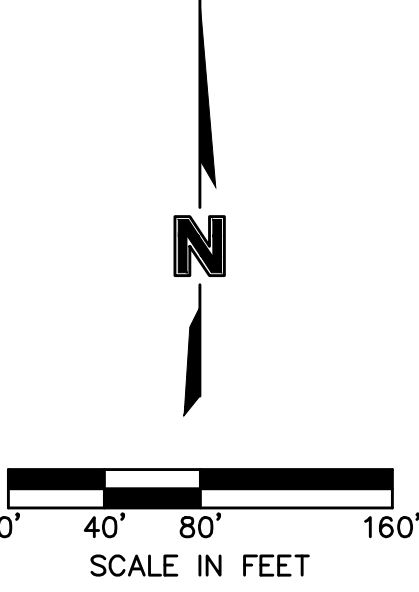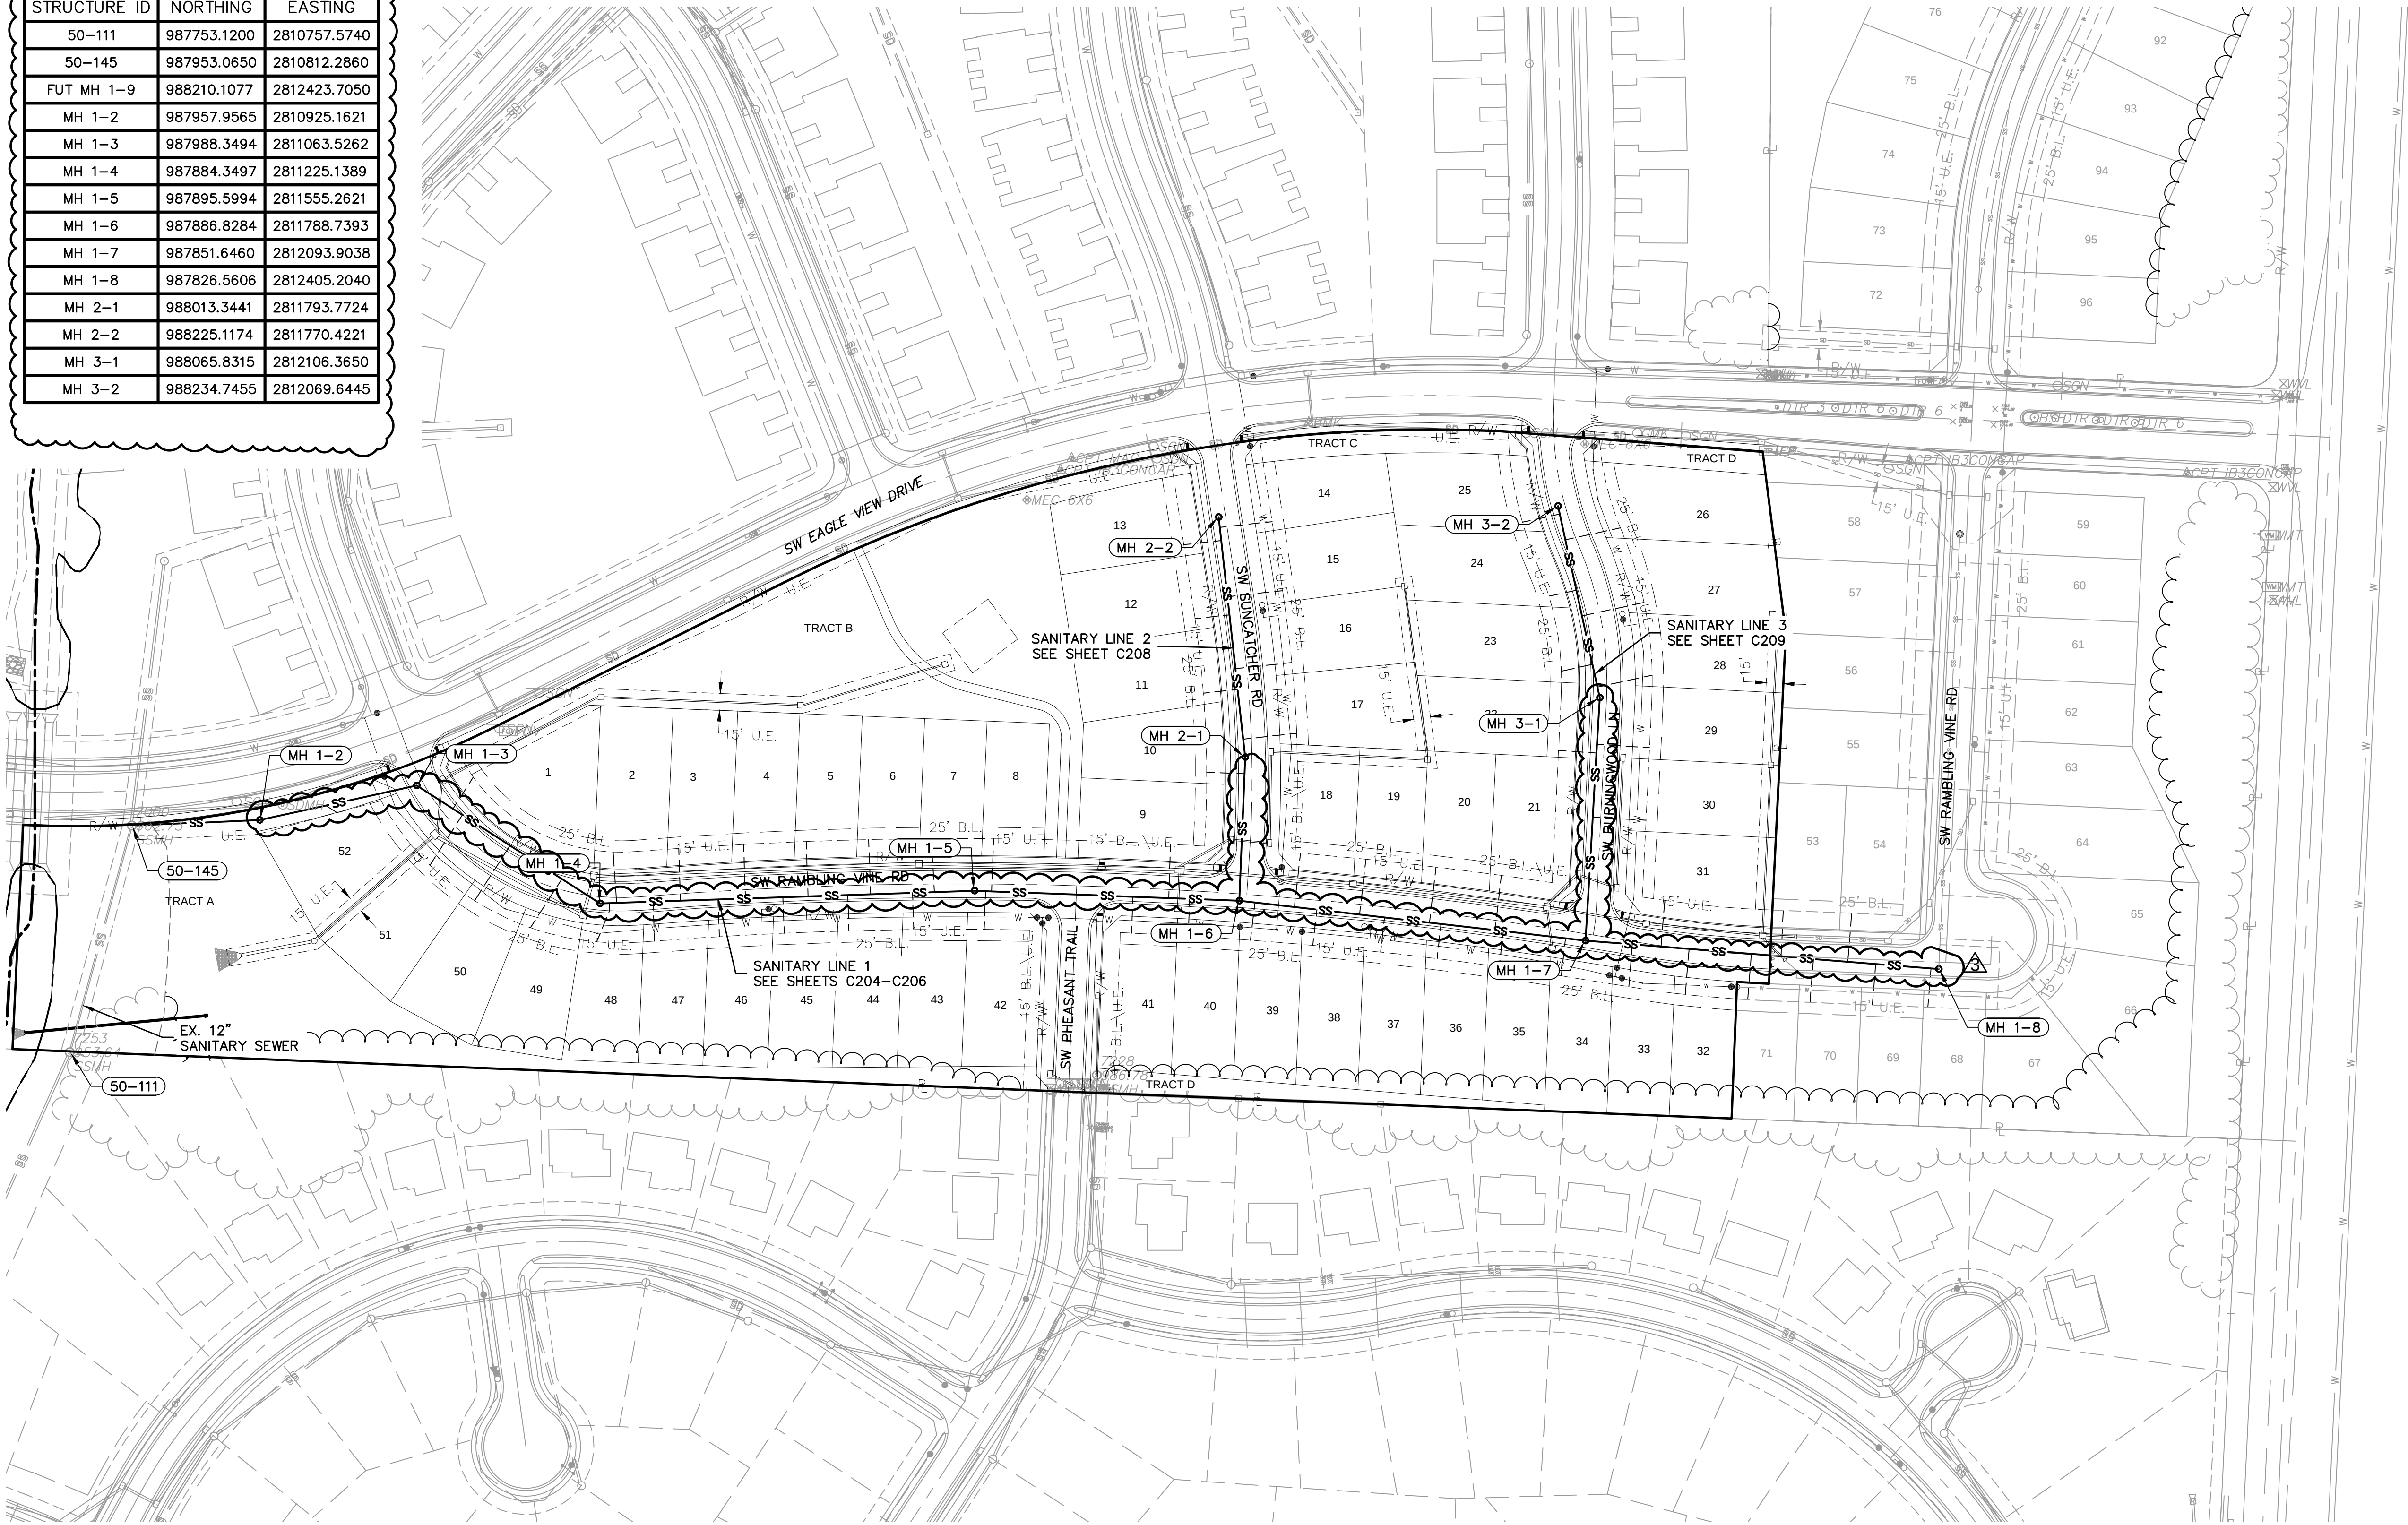

RELEASED FOR CONSTRUCTION
As Noted on Plan Review

Development Services Department
Lee's Summit, Missouri

05/23/2024

olsson

Olsson - Civil Engineering
Missouri Certificate of Authority #001592
1301 Burlington Street
North Kansas City, MO 64116
TEL 816.361.1177
www.olsson.com

STATE OF MISSOURI
STEPHEN M. SAYLOR
NUMBER
PE-2018021248
5/7/2024

PROFESSIONAL ENGINEER

REV.	NO.	DATE	REVISIONS DESCRIPTION	BY
1	02/23/2024	REVISED PER CITY COMMENTS		
2	04/02/2024	REVISED PER CITY COMMENTS		
3	05/07/2024	REVISED PER CITY COMMENTS		

GENERAL LAYOUT
SANITARY SEWER PLANS

EAGLE CREEK VILLAS
FIRST PLAT


LEE'S SUMMIT, MISSOURI

2023

drawn by: CWS
checked by: SS
approved by: JS
QA/QC by: JS
project no.: A20-2467
drawing no.: C_GEN01_A202467
date: 02/23/2024

SHEET
C203

DWG: F:\2020\2001-2500\020-2467-A\40-Design\AutoCAD\Final Plans\Sheets\GNCV\Sanitary\C_SAN01_A202467.dwg
DATE: May 07, 2024 11:07am XREFS: C_PSSWR_A202467 C_PUTIL_A202467 C_SAN01_A202467 C_FBASE_A202467 C_PBASE_A202467 C_PENDY_A202467 C_PTBLK_A202467 USER: ssaylor

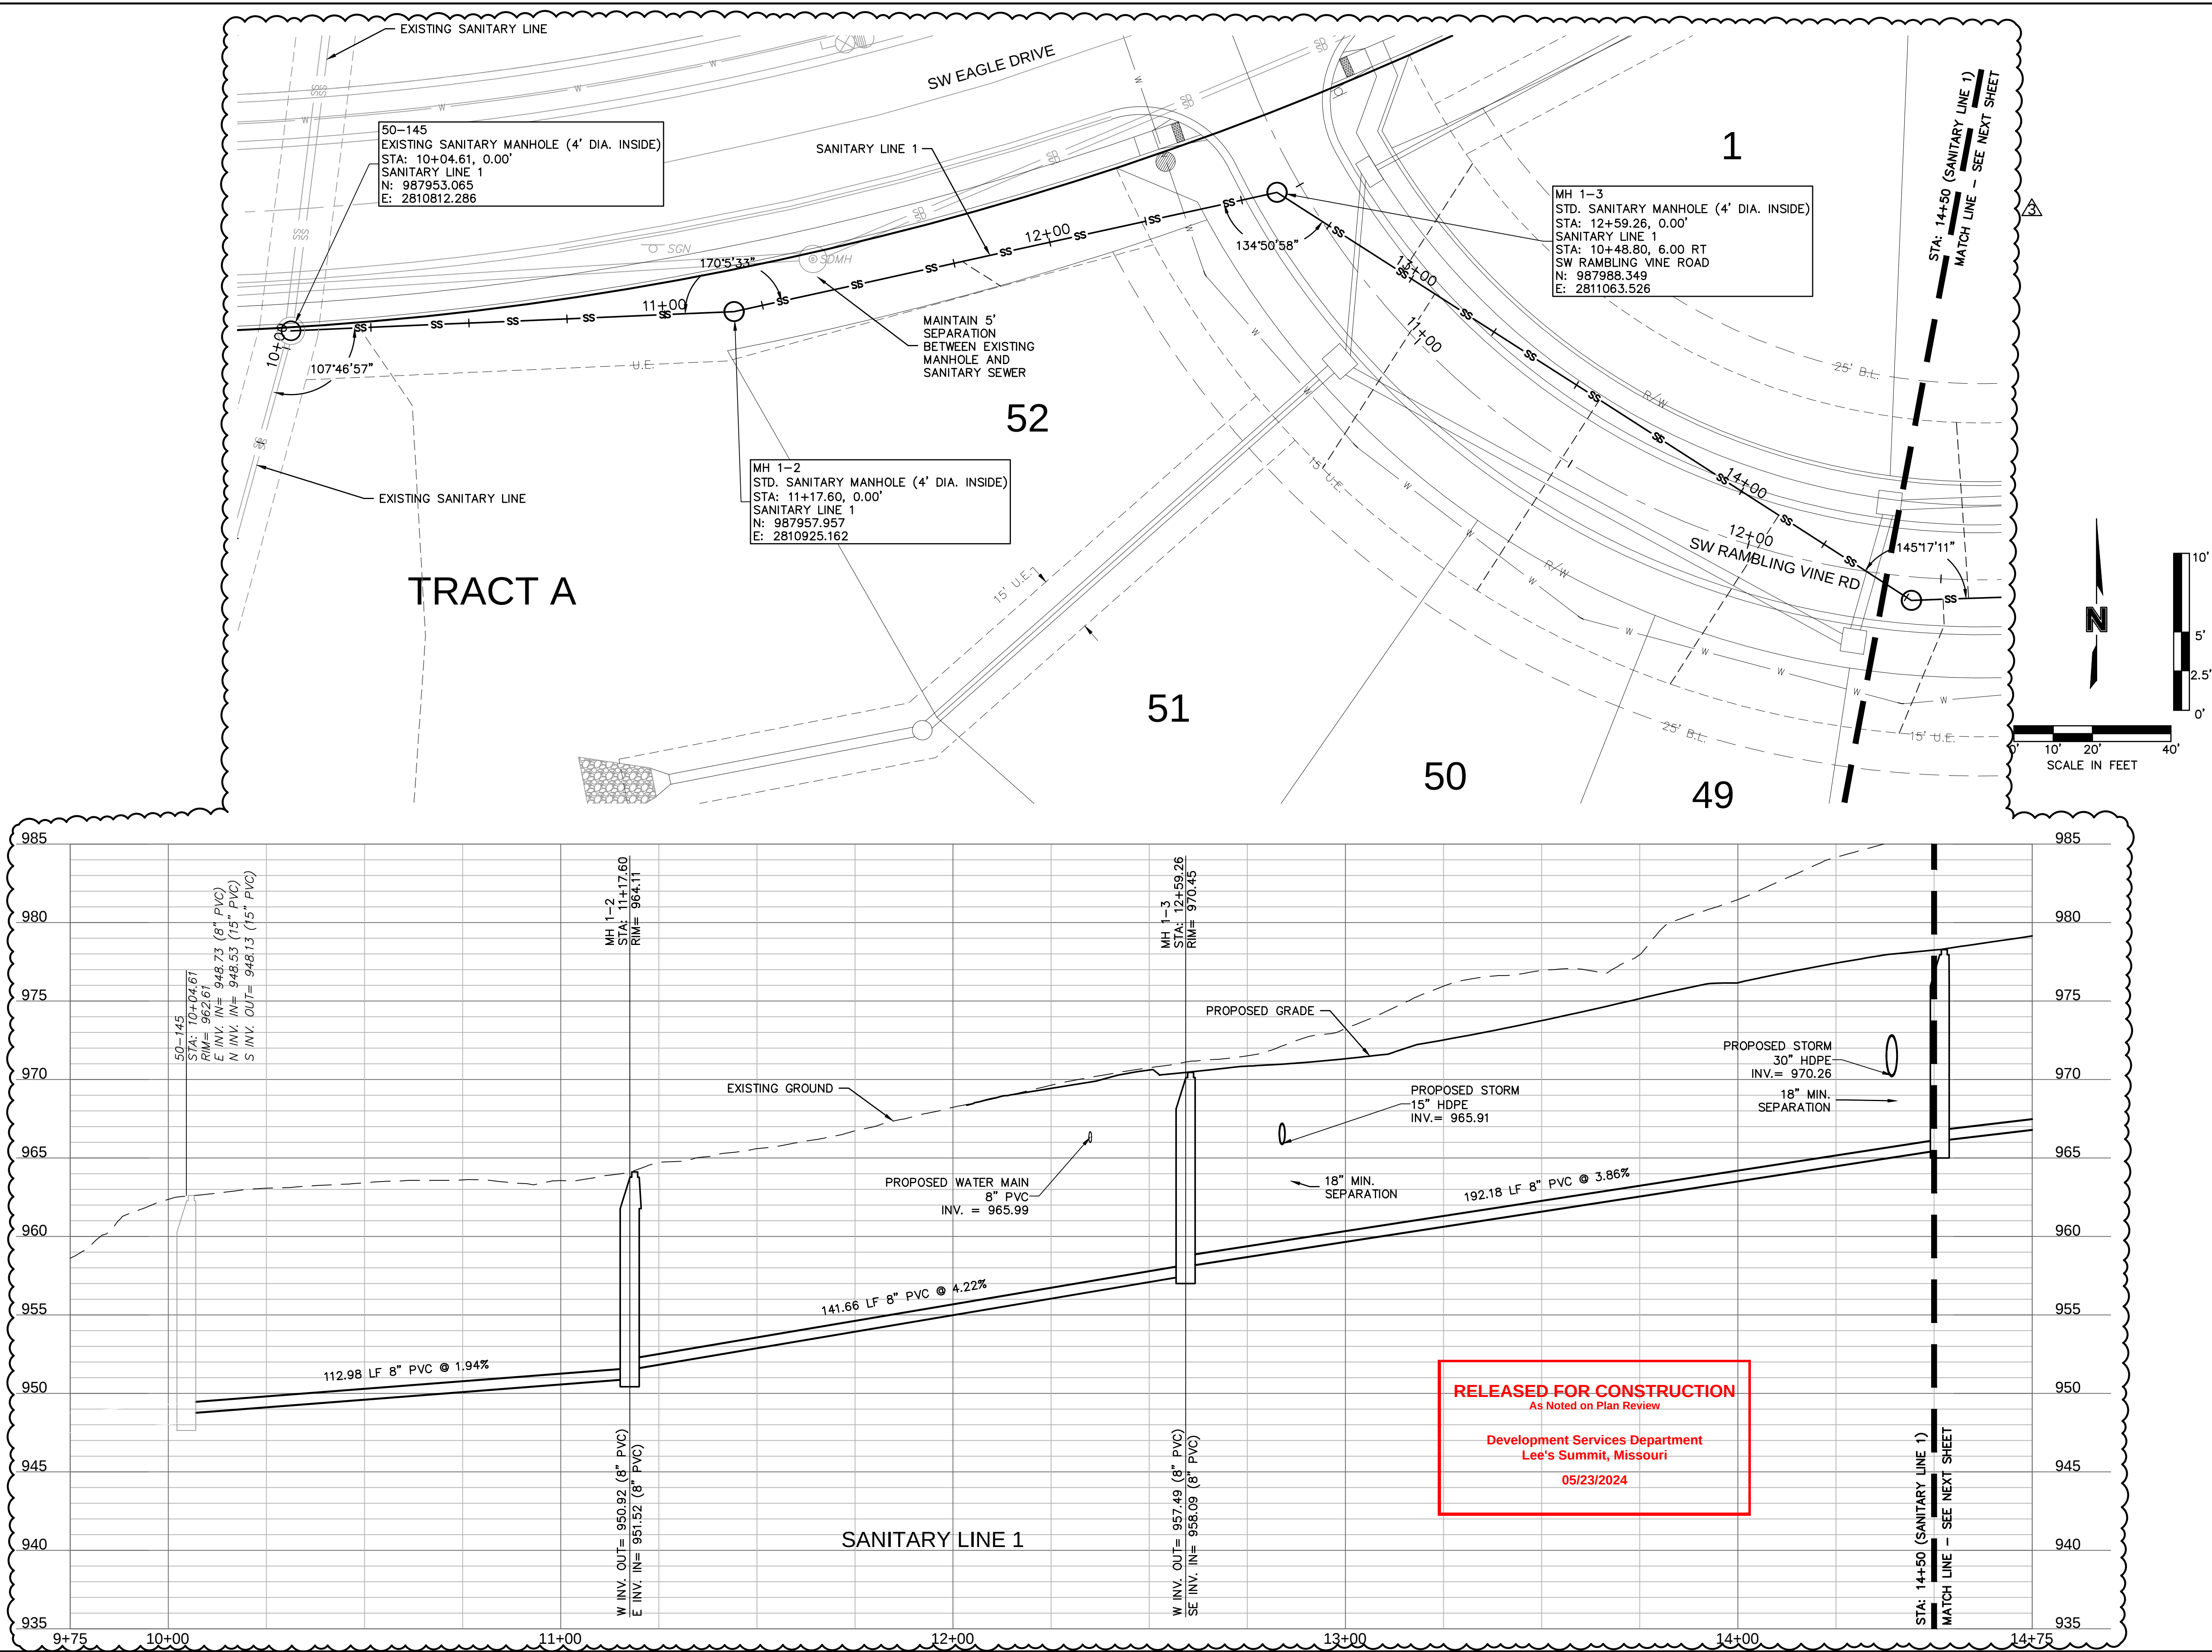

olsson

Olsson - Civil Engineering
Missouri Certificate of Authority #001592
1301 Burlington Street
North Kansas City MO 64116
TEL 816.361.1177
www.olsson.com

STATE OF MISSOURI
STEPHEN M. SAYLOR
NUMBER
PE-2018021248
5/7/2024

REVISIONS


REV. NO.	DATE	REVISIONS DESCRIPTION
1	02/23/2024	REVISED PER CITY COMMENTS
2	04/02/2024	REVISED PER CITY COMMENTS
3	05/07/2024	REVISED PER CITY COMMENTS

SANITARY PLAN & PROFILE (LINE 1)
SANITARY SEWER PLANS
EAGLE CREEK VILLAS
FIRST PLAT
LEE'S SUMMIT, MISSOURI

2023

drawn by: CQ
checked by: SS
approved by: LB
QA/QC by: JS
project no.: A20-2467
drawing no.: C_SAN01_A202467
date: 02/23/2024

SHEET
C204

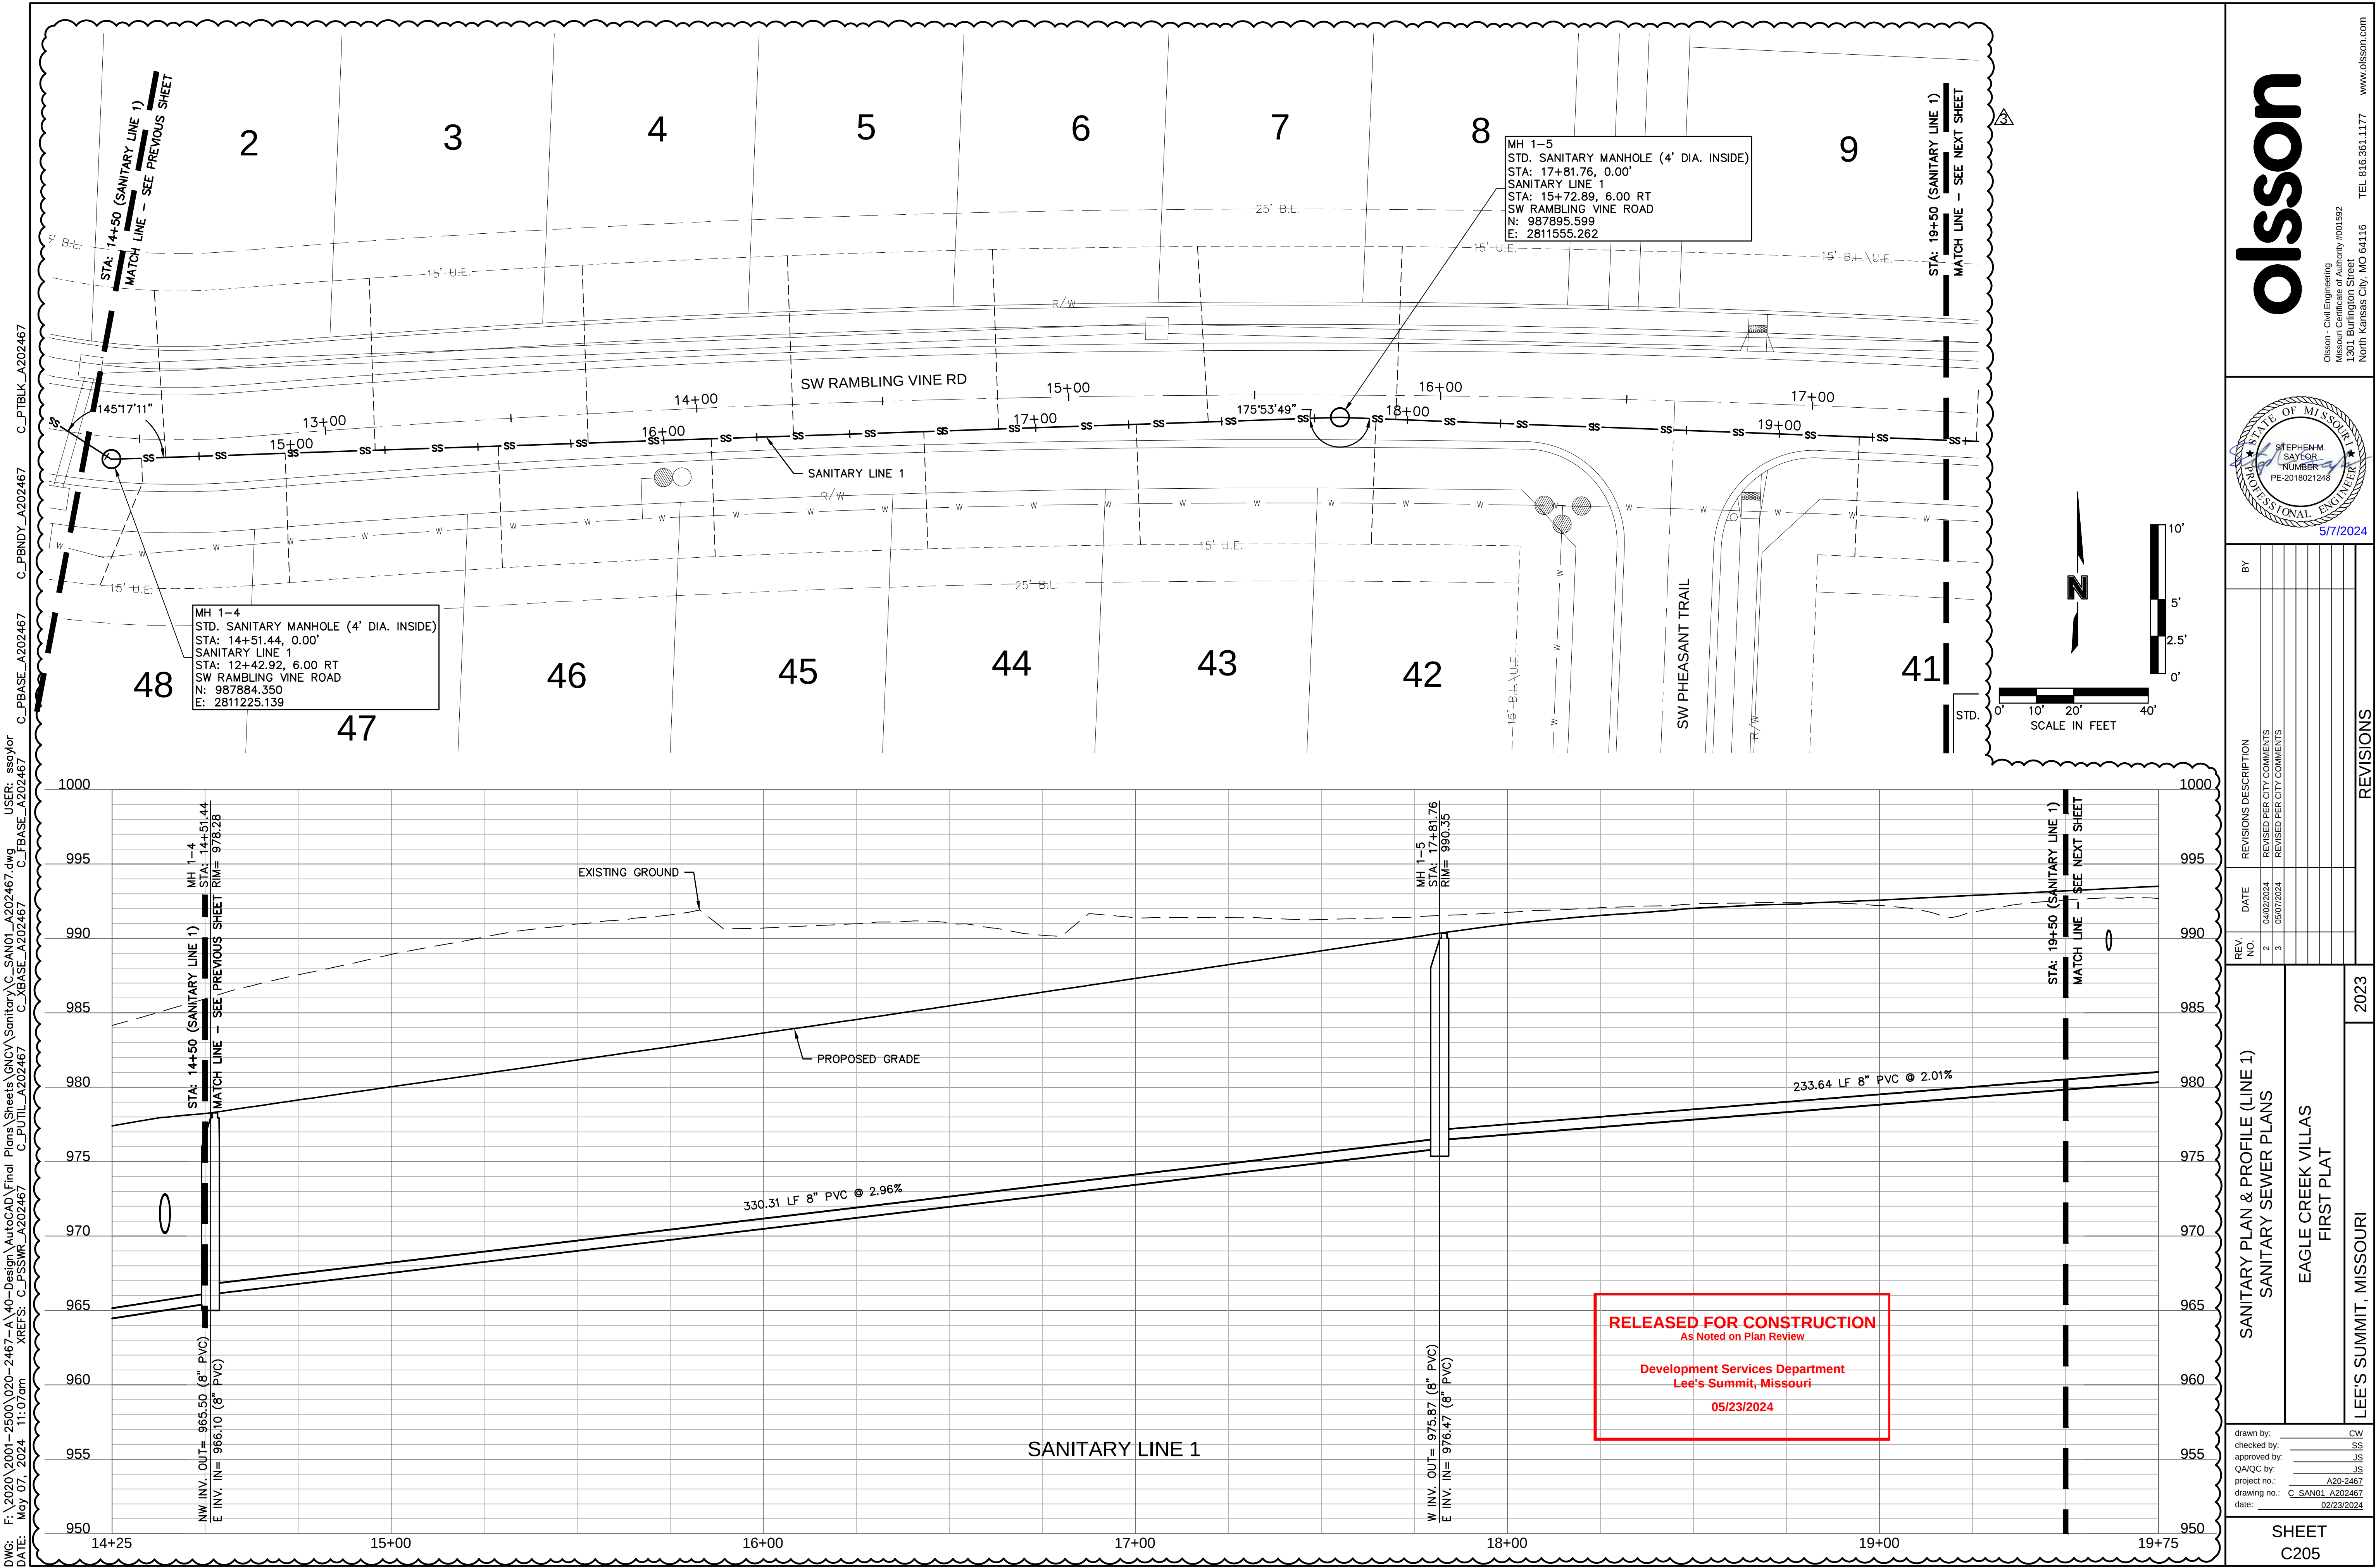

Olsson - Civil Engineering
Missouri Certificate of Authority #001592
1301 Burlington Street
North Kansas City, MO 64116
TEL 816.361.1177
www.olsson.com

REV.	NO.	DATE	REVISIONS DESCRIPTION	BY
2		04/02/2024	REVISED PER CITY COMMENTS	
3		05/07/2024	REVISED PER CITY COMMENTS	

SANITARY PLAN & PROFILE (LINE 1)
SANITARY SEWER PLANS

EAGLE CREEK VILLAS
FIRST PLAT

LEE'S SUMMIT, MISSOURI


2023

drawn by: _____
checked by: _____
approved by: _____
QA/QC by: _____
project no.: A20-2467
drawing no.: C_SAN01_A202467
date: 02/23/2024

CW
SS
JS
JS

SHEET
C205

DWG: F:\2020\2001-2500\020-2467-A\40-Design\AutoCAD\Final Plans\Sheets\GNCV\Sanitary\C_SAN01_A202467.dwg
DATE: May 07, 2024 11:07am XREFS: C_PSSWR_A202467 C_PUTIL_A202467 C_XBASE_A202467 C_PBASE_A202467 C_PENDY_A202467 C_PTBLK_A202467 USER: ssaylor

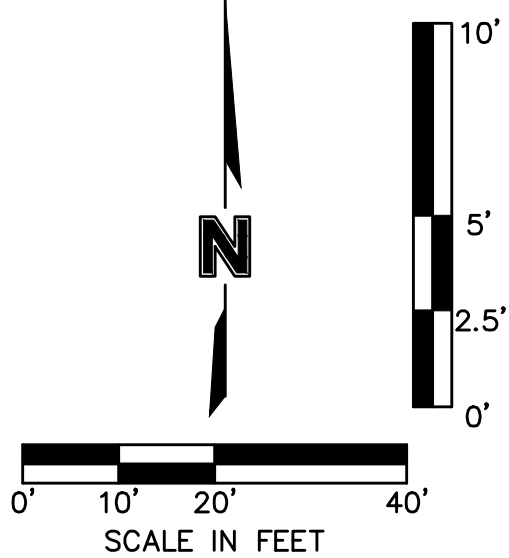

RELEASED FOR CONSTRUCTION
As Noted on Plan Review

Development Services Department
Lee's Summit, Missouri

05/23/2024

Olsson - Civil Engineering
Missouri Certificate of Authority #001592
1301 Burlington Street
North Kansas City, MO 64116
TEL 816.361.1177
www.olsosn.com

REVISIONS	
REV. NO.	DATE
2	04/02/2024
3	05/07/2024

SANITARY PLAN & PROFILE (LINE 1)	
SANITARY SEWER PLANS	
EAGLE CREEK VILLAS FIRST PLAT	
LEE'S SUMMIT, MISSOURI	

SHEET	
C206	

drawn by: _____ CW

checked by: _____ SS


approved by: _____ JS

QA/QC by: _____ JS

project no.: A20-2467

drawing no.: C_SAN01_A202467

date: 02/23/2024

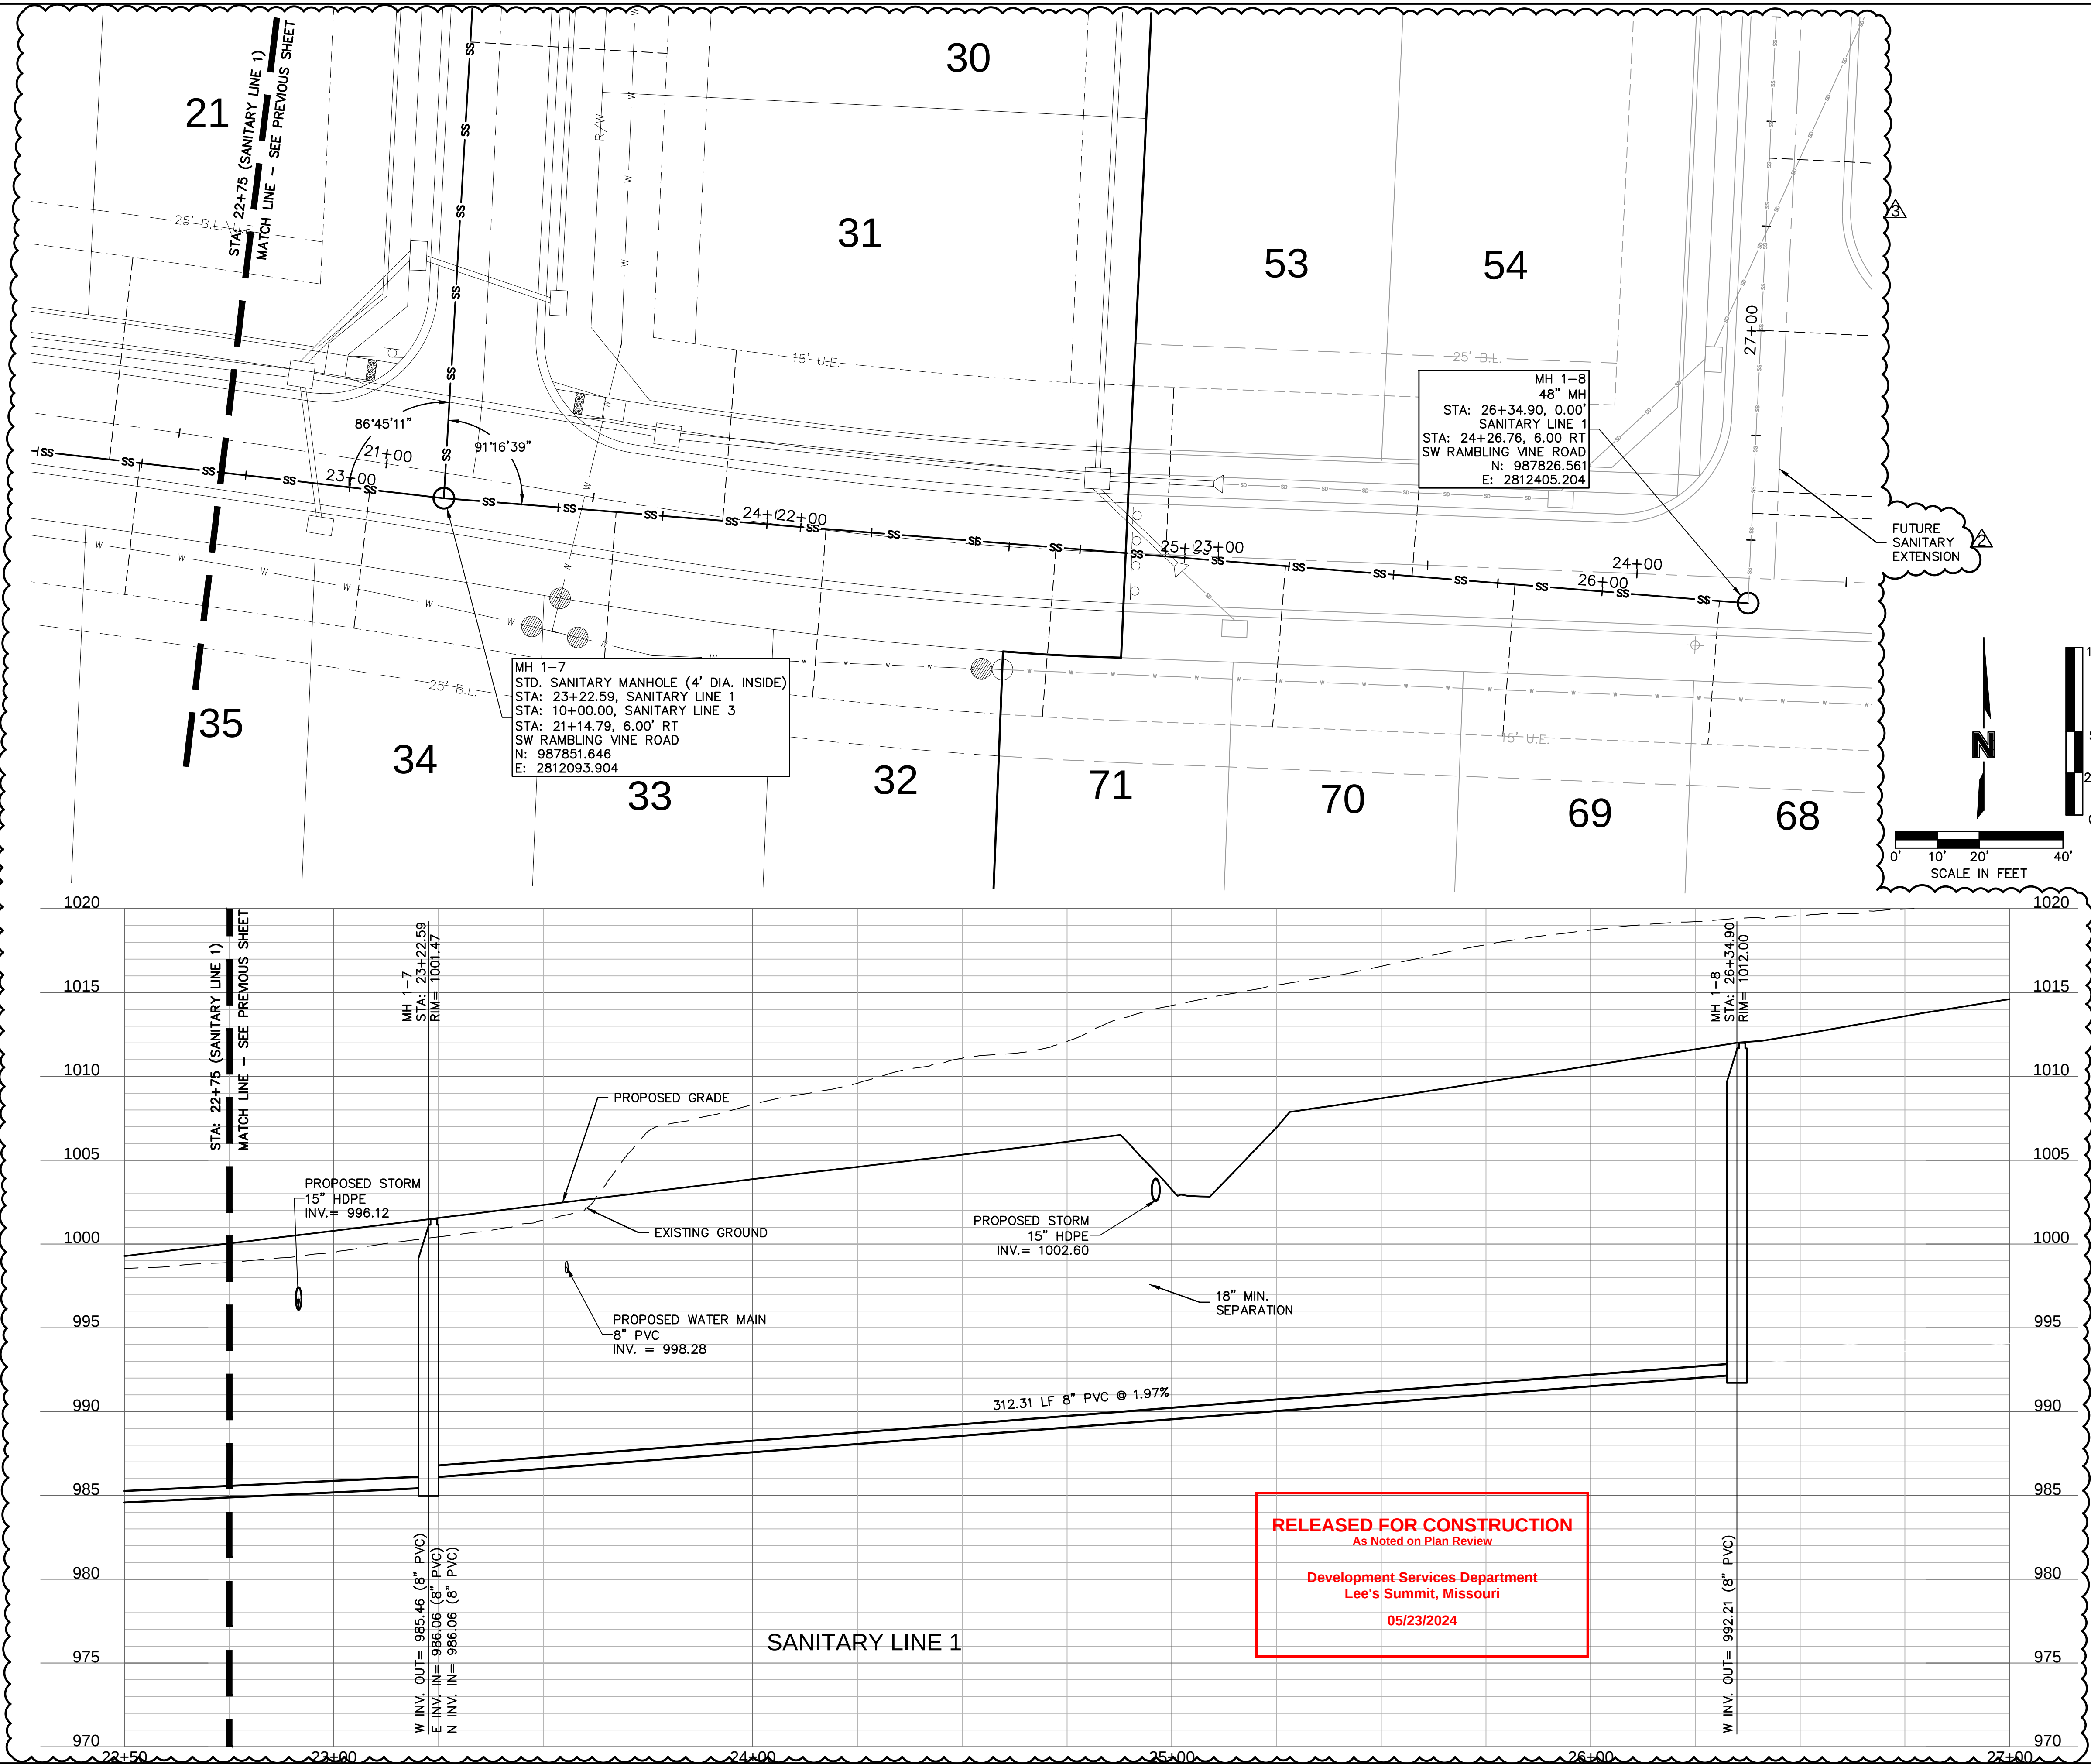

olsson

Olsson - Civil Engineering
Missouri Certificate of Authority #001592
1301 Burlington Street
North Kansas City, MO 64116
TEL 816.361.1177
www.olsson.com

STATE OF MISSOURI
STEPHEN M. Saylor
Professional Engineer
PE-2018021248
5/7/2024

REVISIONS	
REV. NO.	DATE
1	02/23/2024
2	04/02/2024
3	05/07/2024

SANITARY PLAN & PROFILE (LINE 1) SANITARY SEWER PLANS	
EAGLE CREEK VILLAS FIRST PLAT	
LEE'S SUMMIT, MISSOURI	
2023	

drawn by: _____

checked by: _____

approved by: _____

QA/QC by: _____




project no.: A20-2467

drawing no.: C_SAN01_A202467

date: 02/23/2024

SHEET
C207

DWG: F:\2020\2001-2500\020-2467-A\40-Design\AutoCAD\Final Plans\Sheets\GNCV\Sanitary\C_SAN02_A202467.dwg
DATE: May 07, 2024 11:09am XREFS: C_PSSWR_A202467 C_PUTIL_A202467 C_SAN02_A202467 C_XBASE_A202467 C_PBASE_A202467 C_PTBLK_A202467 C_PBNDY_A202467 USER: ssaylor

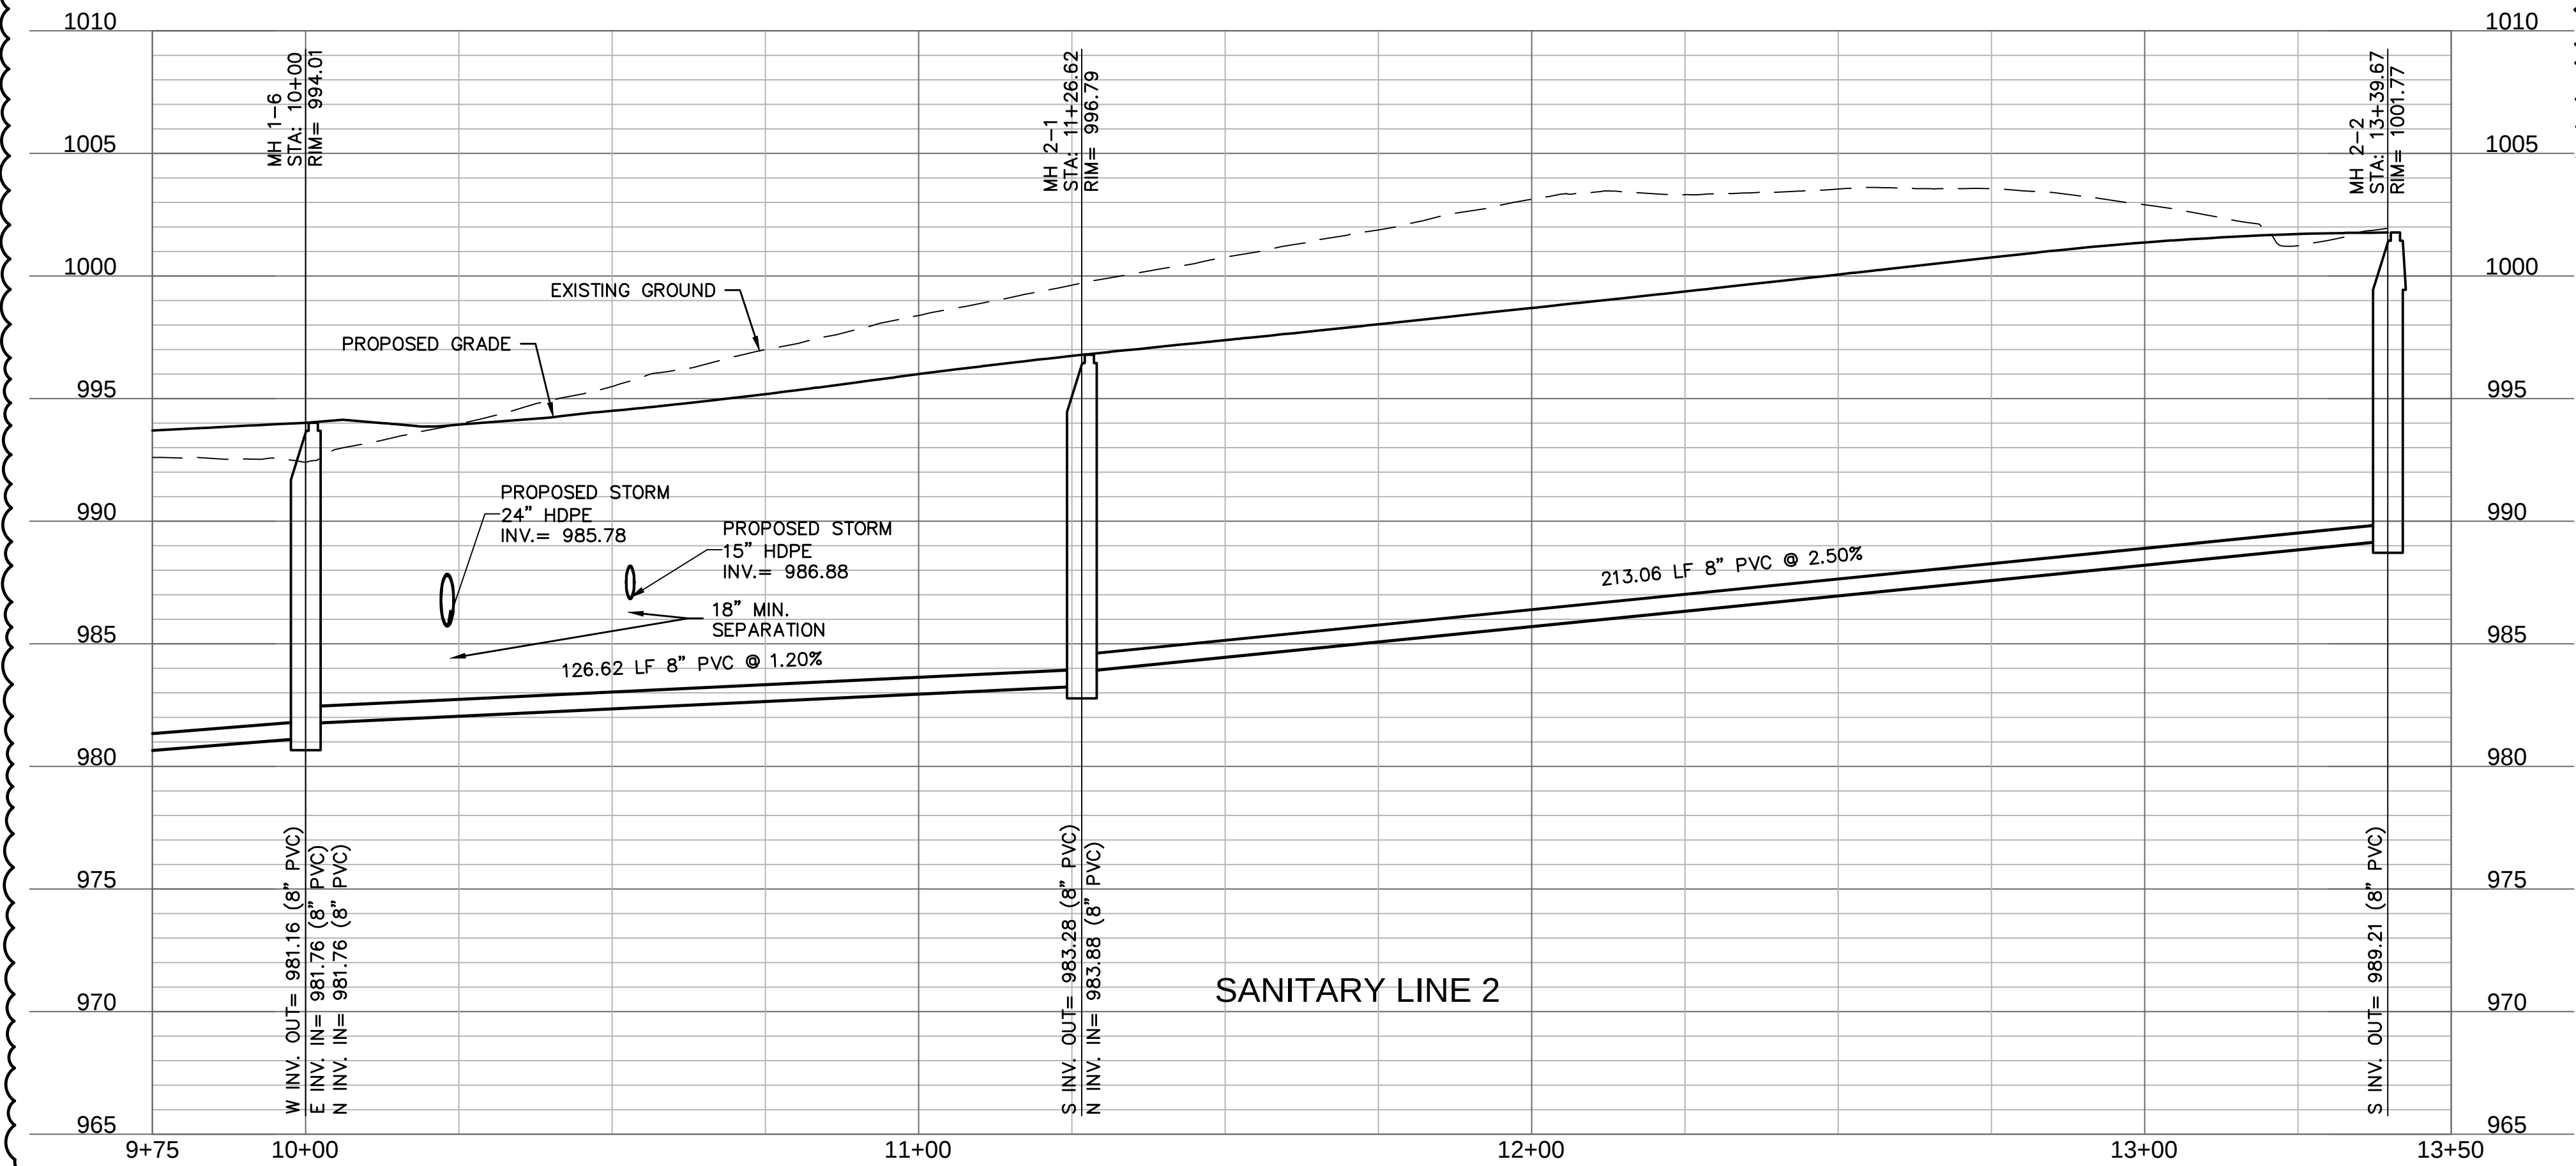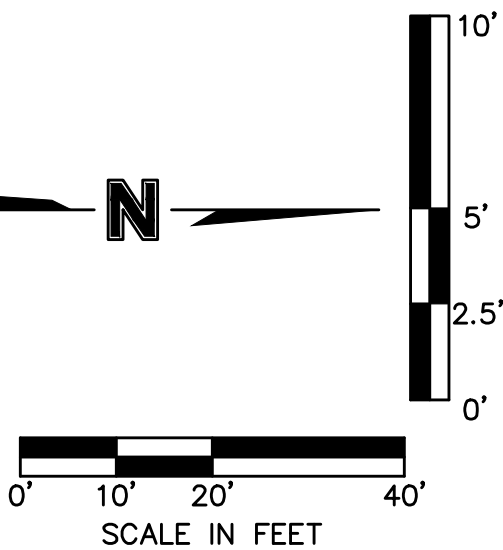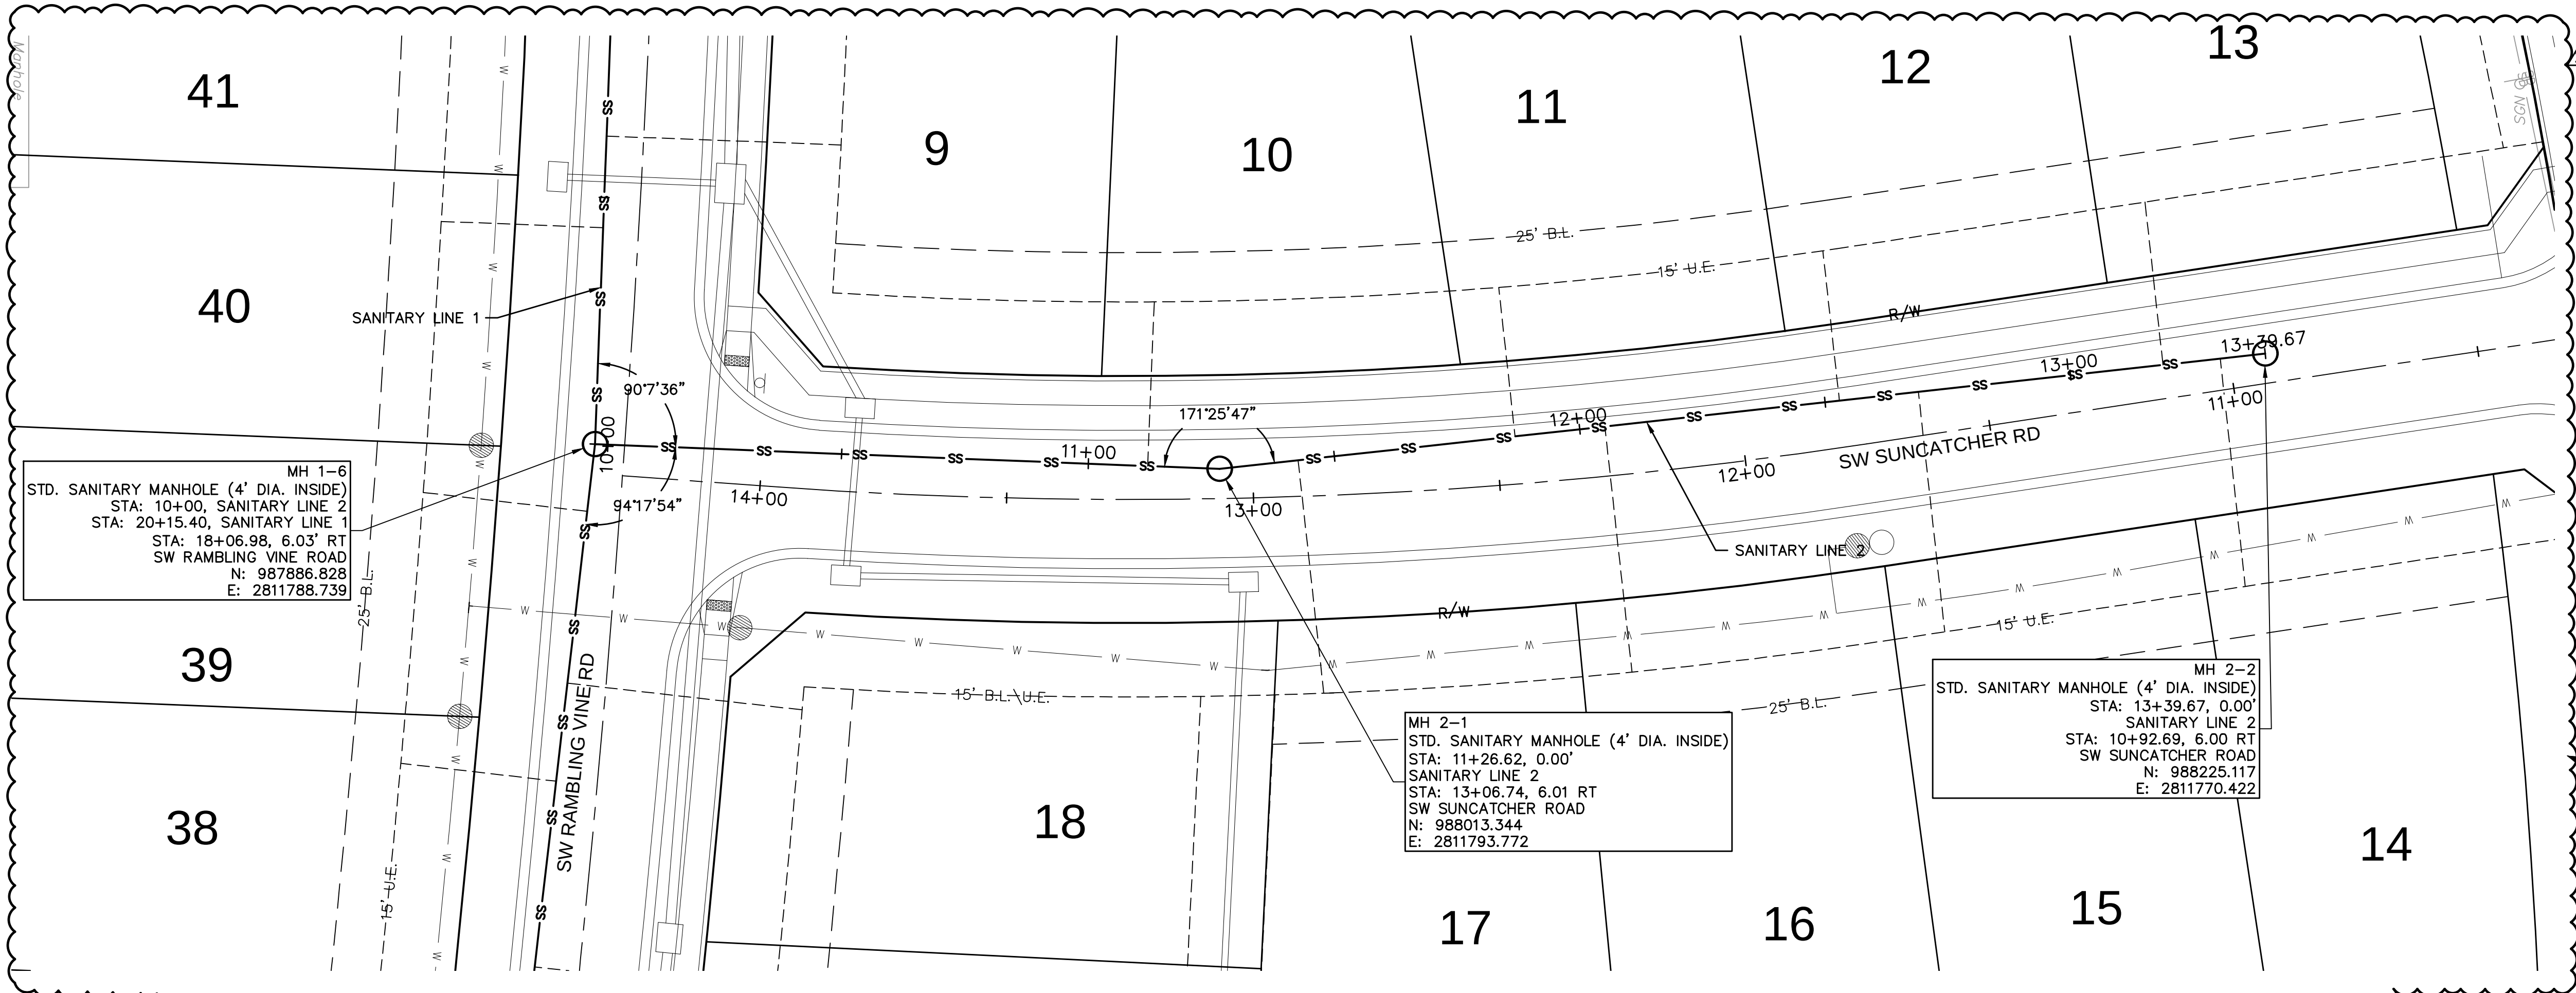

RELEASED FOR CONSTRUCTION
As Noted on Plan Review

Development Services Department
Lee's Summit, Missouri

05/23/2024







Olsson - Civil Engineering
Missouri Certificate of Authority #001592
1301 Burlington Street
North Kansas City, MO 64116
TEL 816.361.1177
www.olsosn.com

REVISIONS	
REV. NO.	DATE
2	04/02/2024
3	05/07/2024

SANITARY PLAN & PROFILE (LINE 2)	
SANITARY SEWER PLANS	
EAGLE CREEK VILLAS FIRST PLAT	
LEE'S SUMMIT, MISSOURI	
2023	

drawn by: _____	CW
checked by: _____	SS
approved by: _____	LS
QA/QC by: _____	JS
project no.: _____	A20-2467
drawing no.: _____	C_SAN02_A202467
date: _____	02/23/2024


SHEET C208

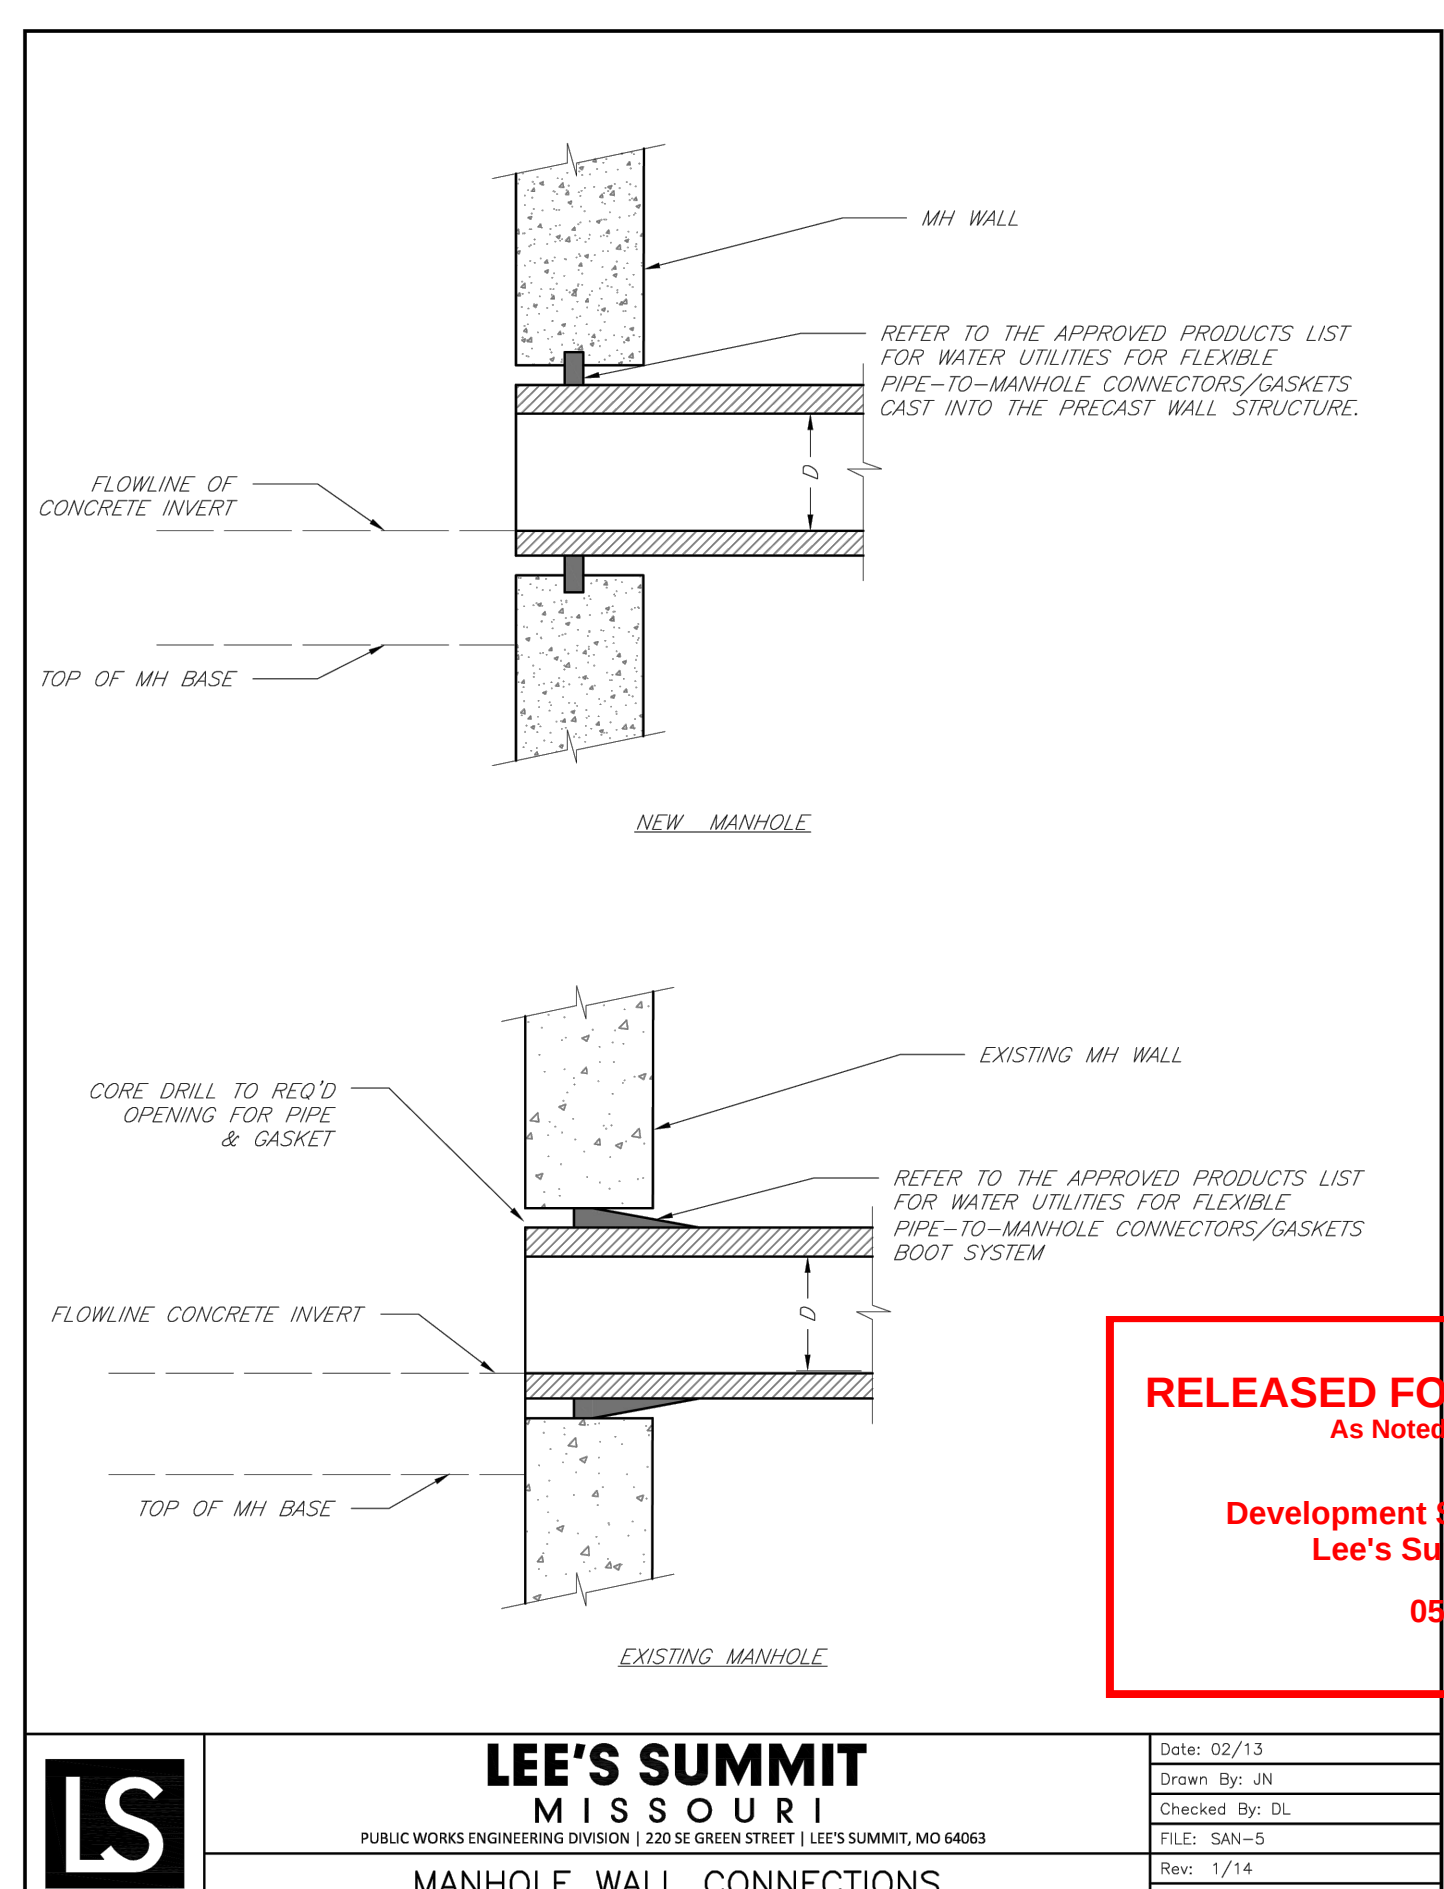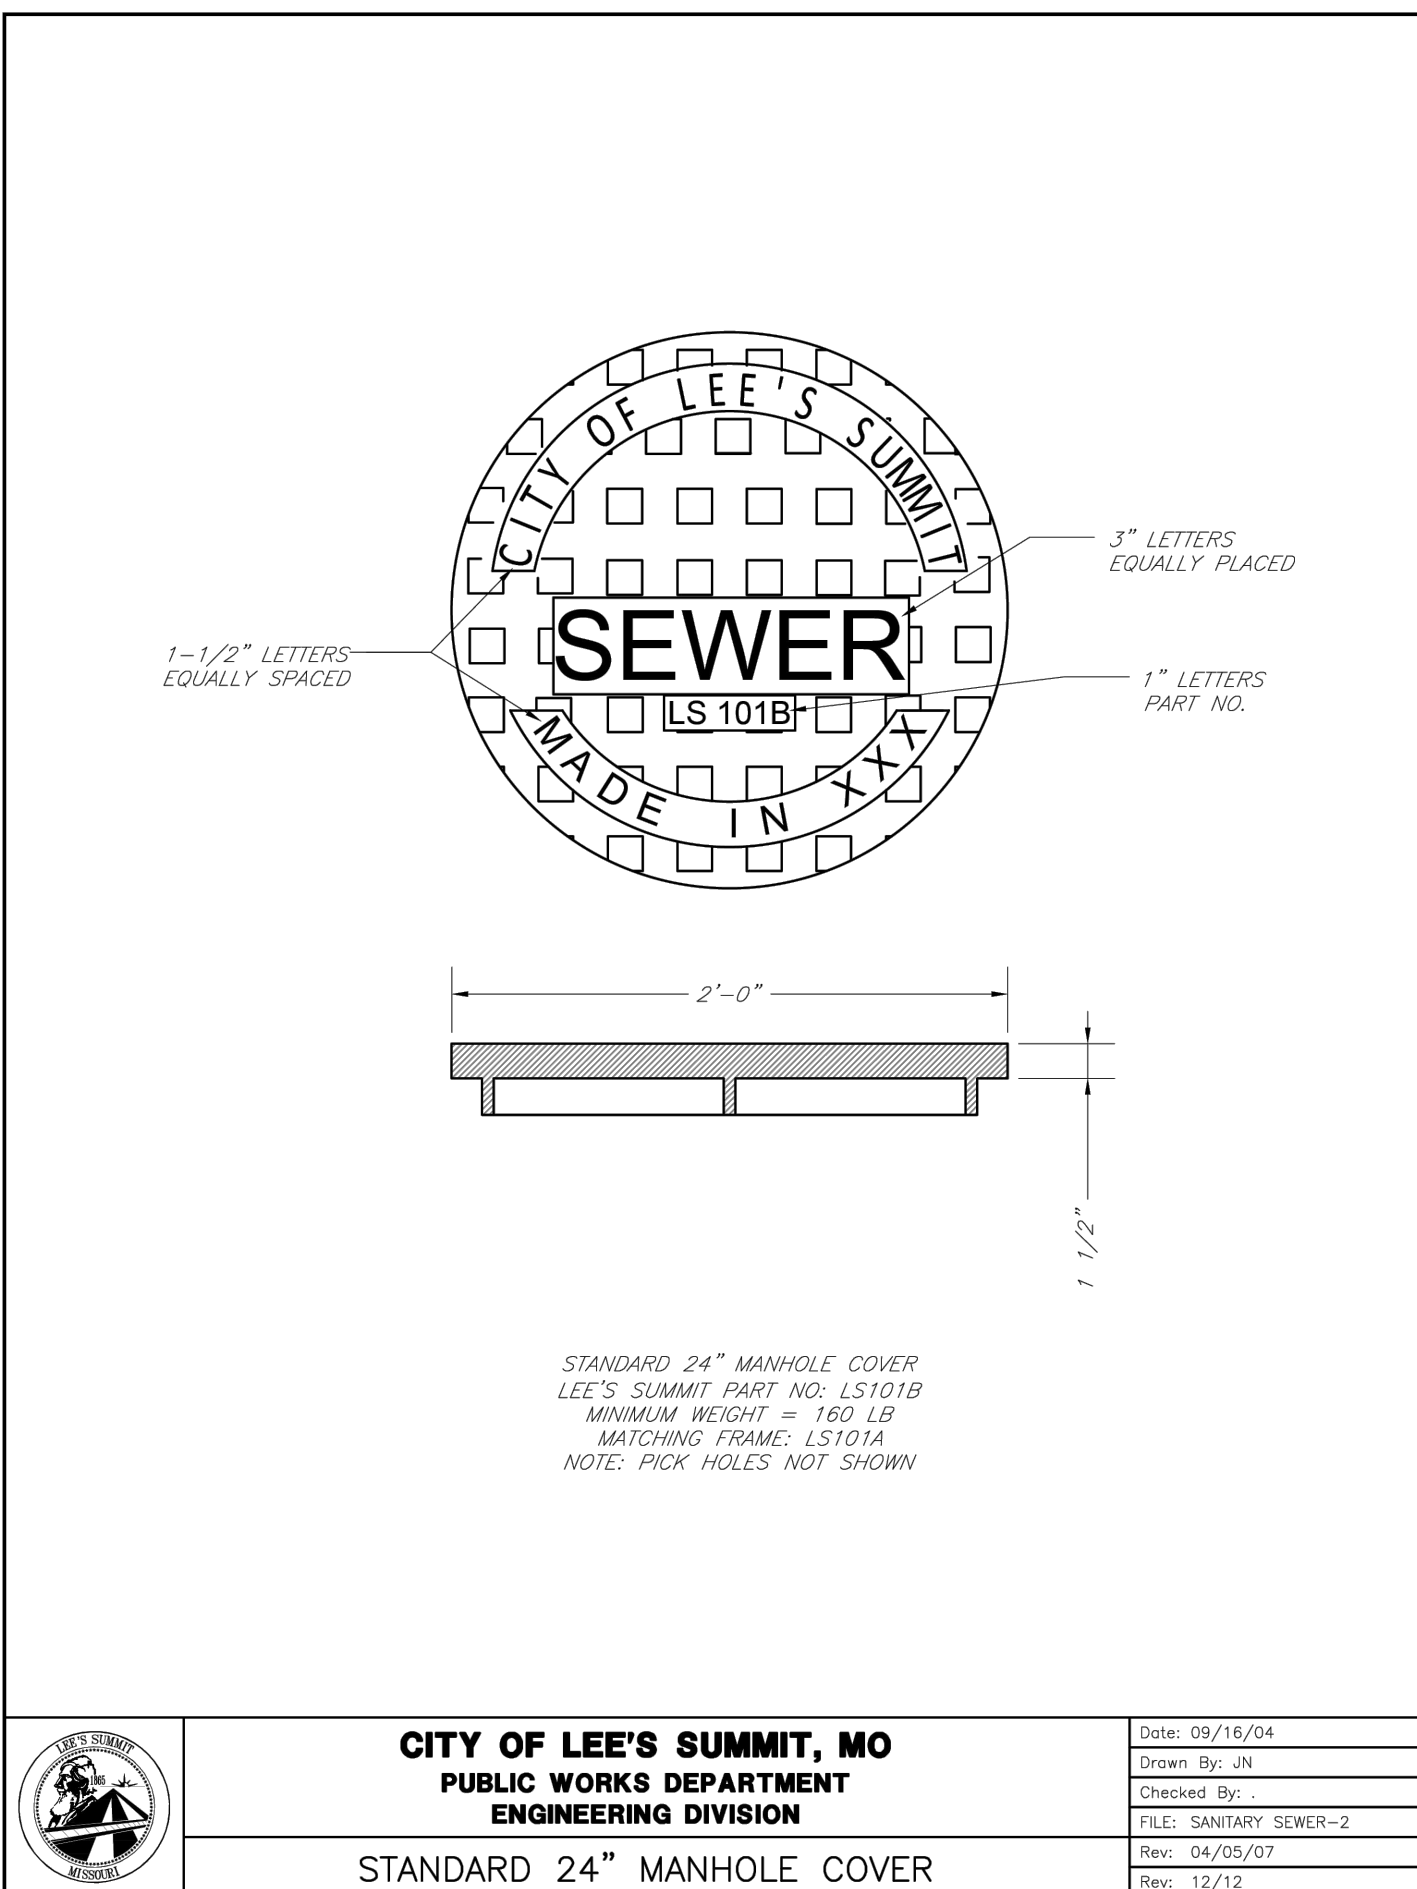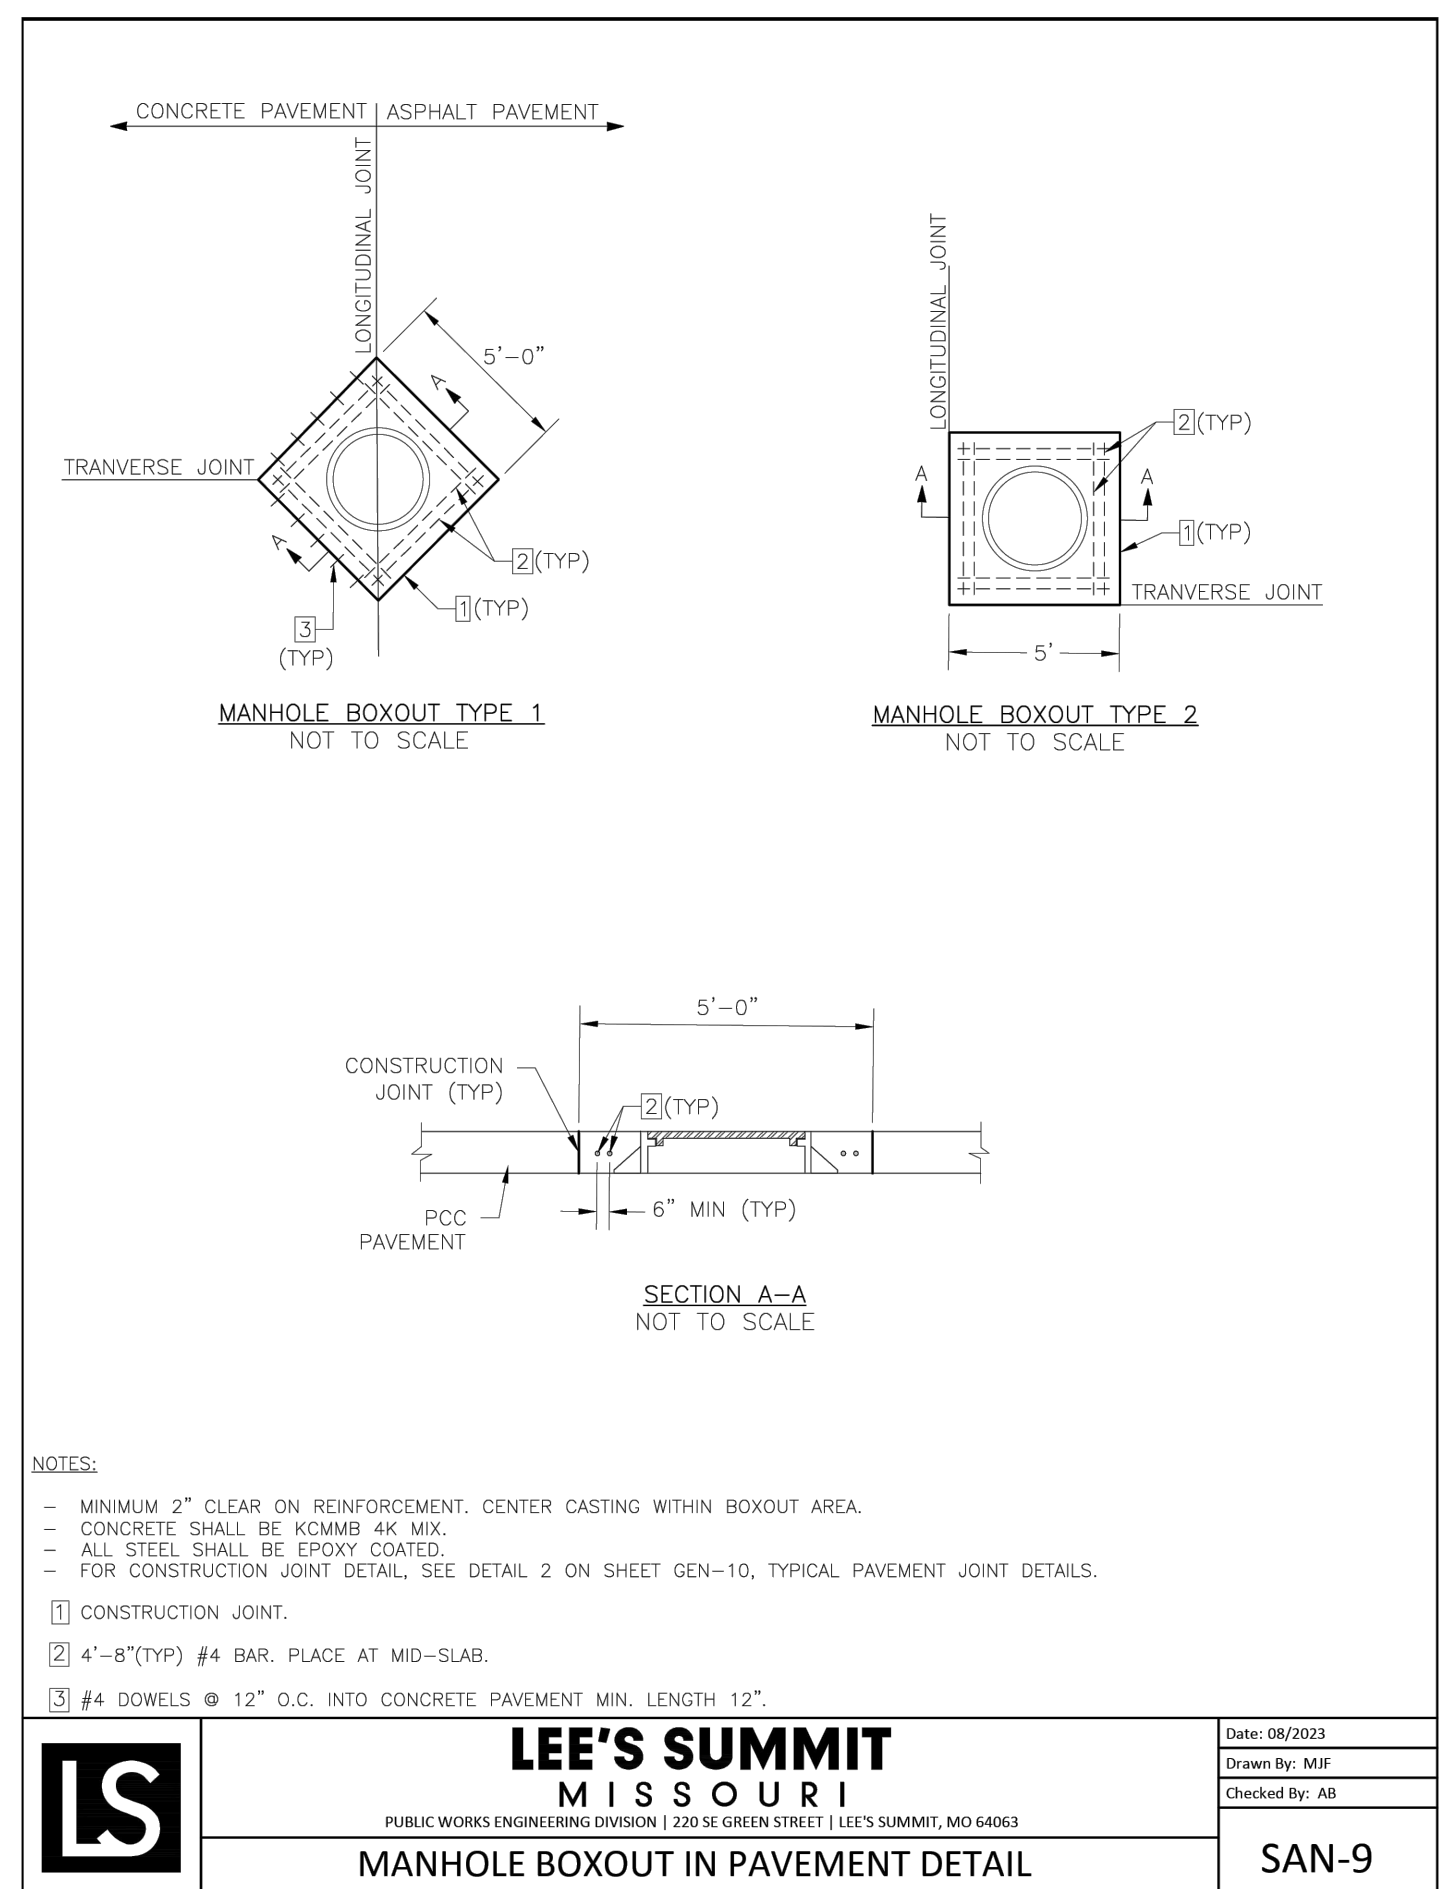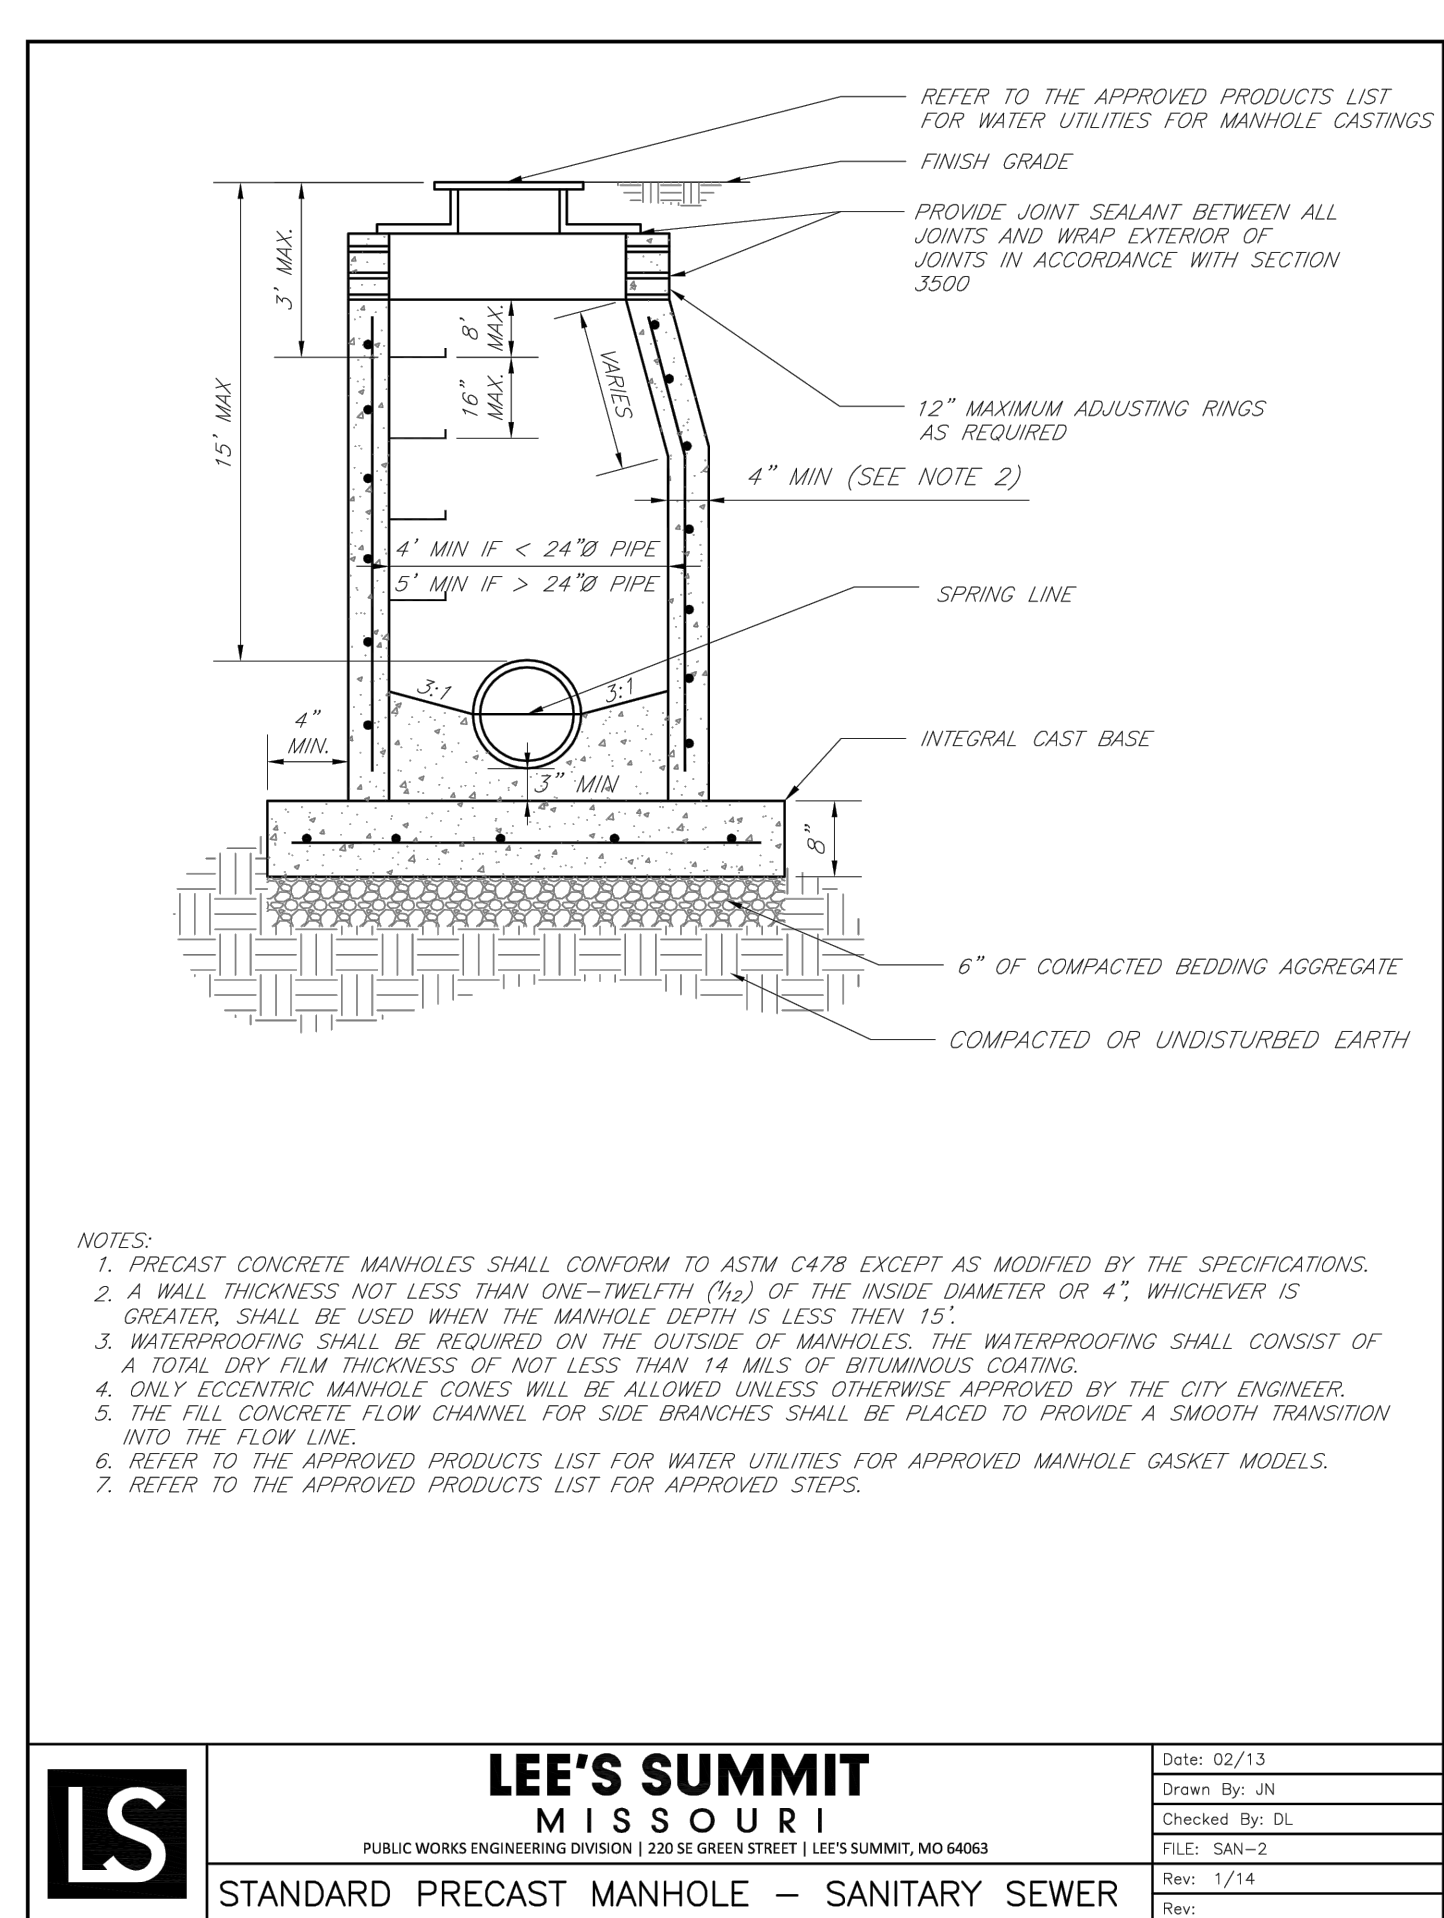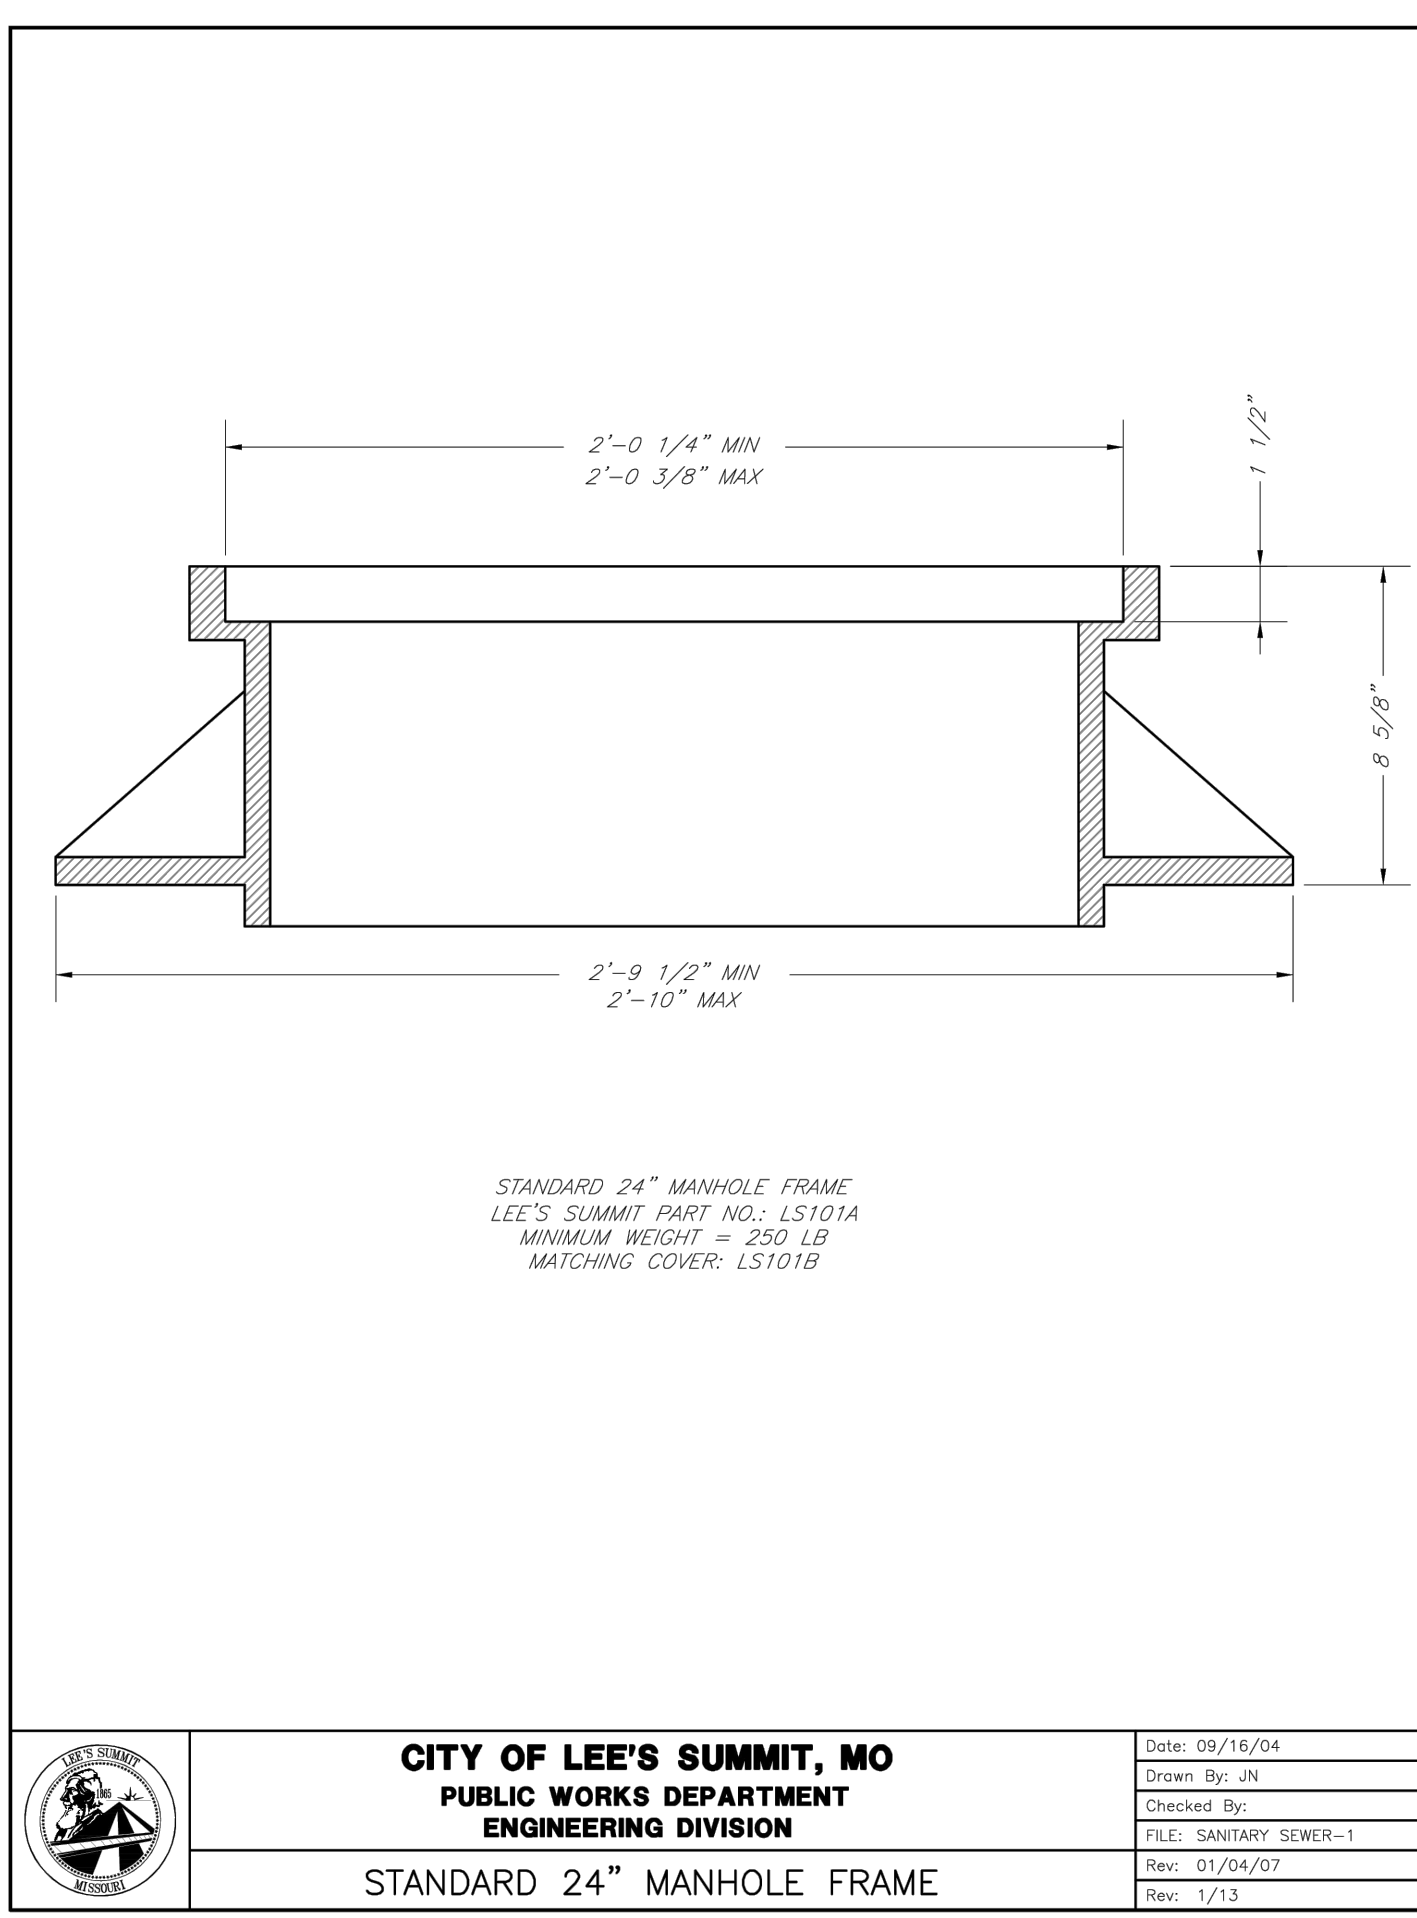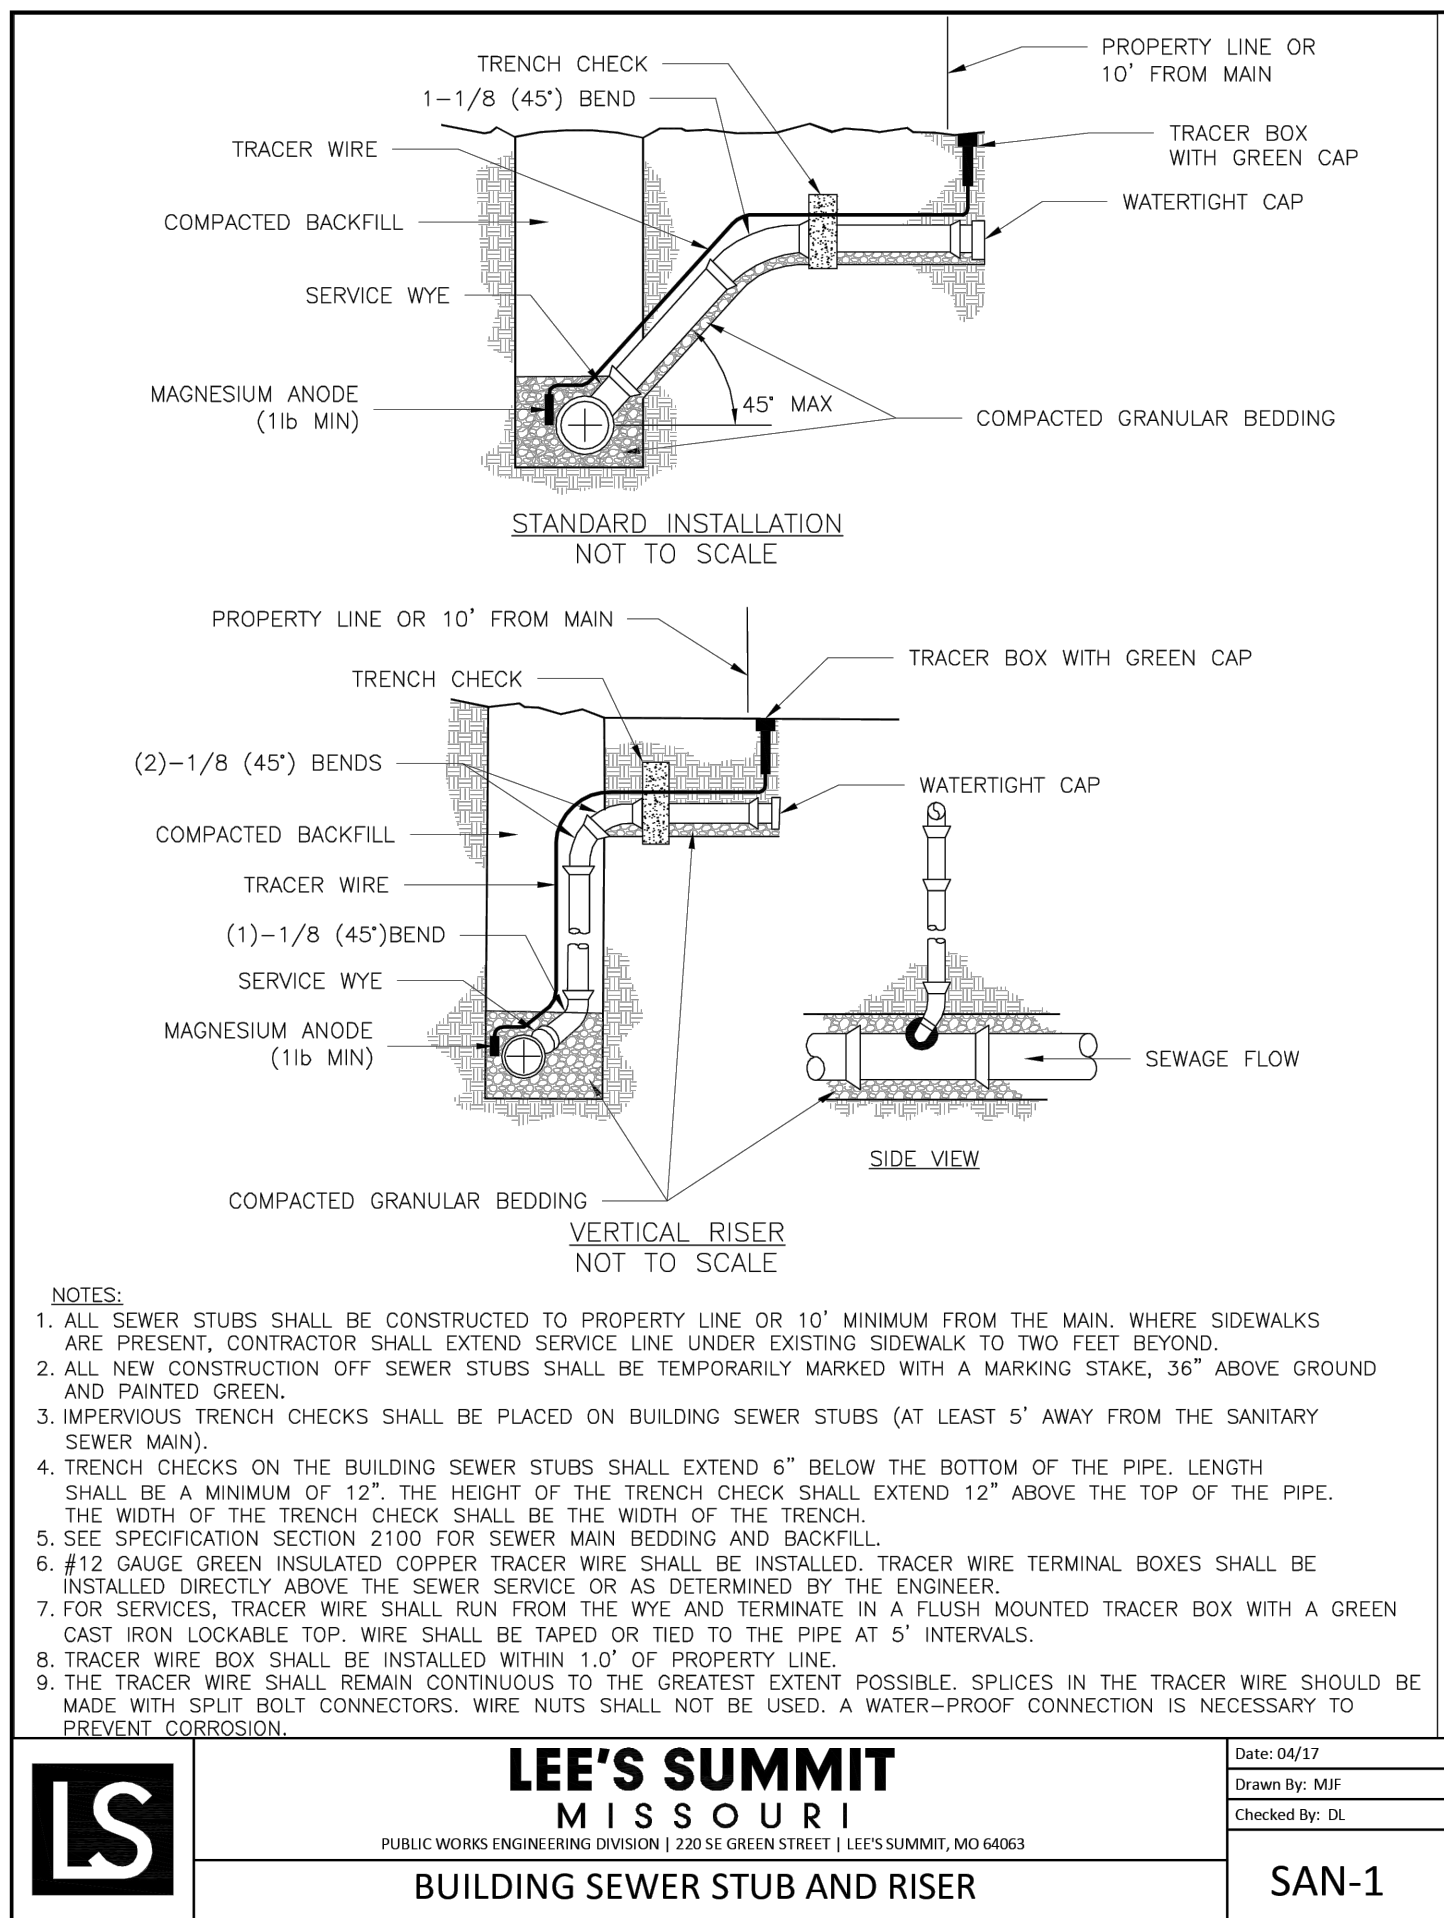

DWG: F:\2020\2001-2500\020-2467-A\40-Design\AutoCAD\Final Plans\Sheets\GNCV\Sanitary\C_DTL01_A202467.dwg
DATE: May 06, 2024 3:22pm XREFS: C:\PTBK_A202467
USER: ssaylor

500\020-2467-A\40-Design\AutoCAD\Final Plans\Sheets\GNCV\Sanitary\C_DTL01_A202467.dwg
3:22pm XREFS: C_PTBK_A202467

USER: ssaylor

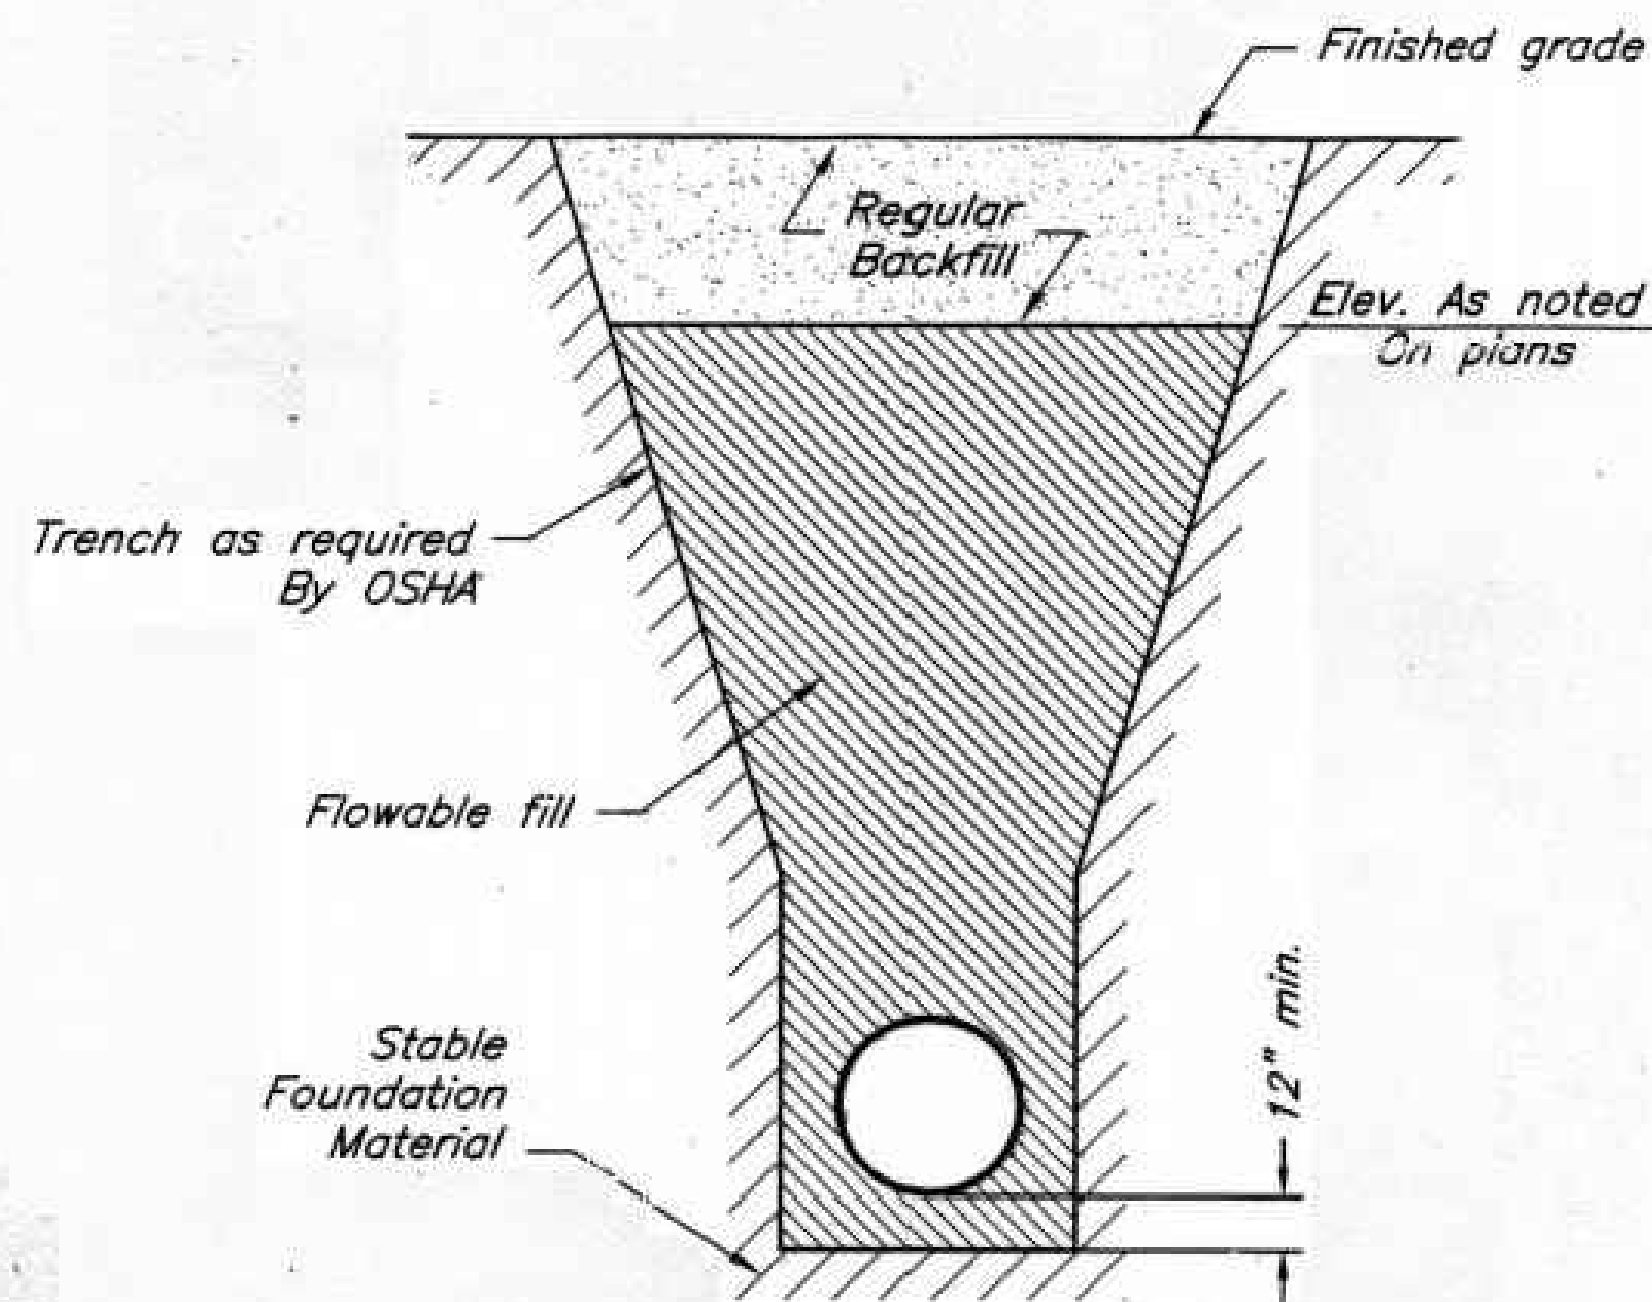

NOTES


1. FLOWABLE FILL SHALL MEET THE REQUIREMENTS OF THE CITY OF LEE'S SUMMIT STANDARD SPECIFICATIONS.
2. REGULAR BACKFILL ABOVE THE TRENCH CHECK SHALL BE FREE OF DEBRIS, ORGANIC MATTER, AND STONES > 6" IN ANY DIMENSION.
3. TOP OF FLOWABLE BACKFILL SHALL BE A MINIMUM OF 2 FEET BELOW FINISHED GRADE.

Subject to revision without notice.

CITY OF LEE'S SUMMIT, MISSOURI

TRENCH CHECK

Date: 09/16/04
Rev:
Rev:
Rev:

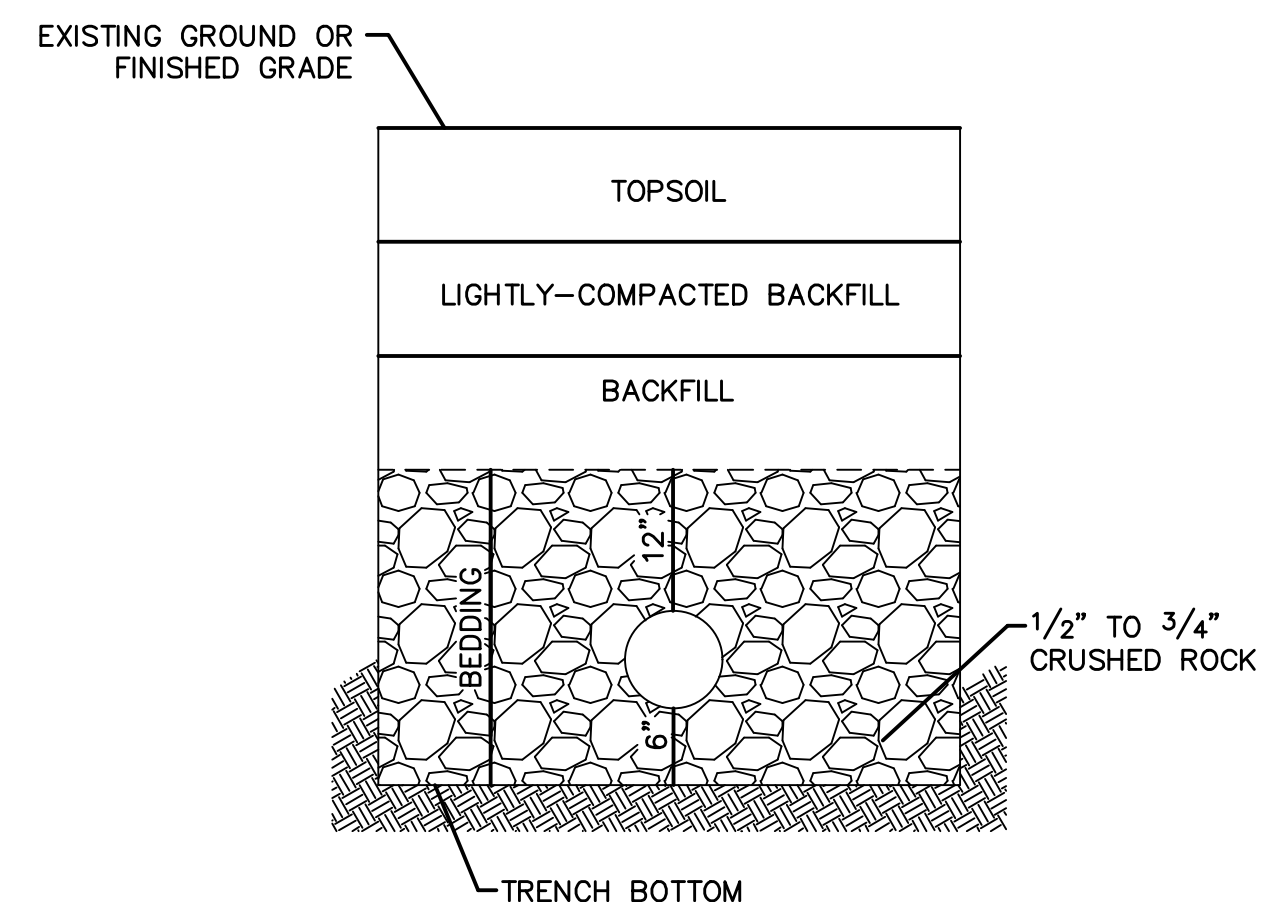

UNDERGROUND PIPE INSTALLATION FOR SANITARY SEWER

NOTES:

1. MINIMUM OF 36 INCHES OF COVER SHALL BE OVER THE TOP OF THE PIPE. THIS MINIMUM OF COVER SHALL BE FROM THE TOP OF PIPE TO THE FINISHED GRADE.
2. BEDDING AGGREGATE MATERIAL SHALL BE PER SECTION 6900 AND 2102 OF THE CITY DESIGN AND CONSTRUCTION MANUAL. BEDDING AGGREGATE SHALL BE PLACED FROM A LEVEL 6 INCHES BELOW THE BOTTOM OF THE PIPE TO A LEVEL 12 INCHES ABOVE THE TOP OF THE PIPE.
3. BACKFILL MATERIAL AND PLACEMENT SHALL BE PER SECTION 6900 AND 2102 OF THE CITY DESIGN AND CONSTRUCTION MANUAL.
4. TRENCHING SHALL BE IN ACCORDANCE WITH CURRENT OSHA REGULATIONS. SLOPES MUST NOT EXTEND BELOW TOP OF BEDDING.
5. MINIMUM AND MAXIMUM TRENCH WIDTHS SHALL BE IN ACCORDANCE WITH PIPE MANUFACTURERS RECOMMENDATION AS APPROVED ON ENGINEERING PLANS.

RELEASED FOR CONSTRUCTION
As Noted on Plan Review

Development Services Department
Lee's Summit, Missouri

05/23/2024

STATE OF MISSOURI
 ★ ★
 STEPHEN M.
 SAYLOR
 NUMBER
 PE-2018021248
 PROFESSIONAL ENGINEER

[illegible]

DETAIL SHEET

SANITARY SEWER PLANS

EAGLE CREEK VILLAS

FIRST PLAT

MISSOURI

drawn by: _____ CV
checked by: _____ SS
approved by: _____ JS
QA/QC by: _____ JS
project no.: _____ A20-246
drawing no.: C DTL01 A20246
date: _____ 02/23/2021

SHEET
C212