


[illegible]

E 192

ITEM NO	QTY	EQUIPMENT DISCRPTION	AMPS	VOLTAGE/ PHASE	WIRE SIZE	HEIGHT (AFF)	NOTES
1	2	S/S WORK TABLE	15.0	120V/1ø	(3) #12, 1/2"C.		
2	1	BULK CO2 TANK	15.0	120V/1ø	(3) #12, 1/2"C.	48"	
3	1	PORTABLE OIL FILTER	15.0	120V/1ø	(3) #12, 1/2"C.	20"	
5	1	BAG-IN-BOX SYSTEM	15.0	120V/1ø	(3) #12, 1/2"C.	60"	
11	3	COOLER/FREEZER LIGHTS AND ACCESSORIES	10.0	120V/1ø	(3) #12, 1/2"C.		2
11A	1	BEER COOLER CONDENSER	16.1	208V/1ø	(3) #10, 3/4"C.		
11B	1	BEER COOLER COIL	15.0	120V/1ø	(3) #12, 1/2"C.		
11C	1	COOLER CONDENSER	19.6	208V/1ø	(3) #10, 3/4"C.		
11D	1	COOLER COIL	15.0	120V/1ø	(3) #12, 1/2"C.		
11E	1	FREEZER CONDENSER	20.6	208V/1ø	(3) #10, 3/4"C.		
11F	1	FREEZER COIL	15.0	208V/1ø	(3) #12, 3/4"C.		
11G	1	DRAIN LINE HEATER	15.0	240V/1ø	(3) #12, 1/2"C.		
18	1	FOOD PROCESSOR	12.0	120V/1ø	(3) #12, 1/2"C.	48"	
19	1	FOOD SLICER	4.8	120V/1ø	(3) #12, 1/2"C.	48"	
22	1	PLANTARY MIXER	15.0	120V/1ø	(3) #12, 1/2"C.	48"	
26	2	EXHAUST HOOD SYSTEM	15.0	120V/1ø	(3) #12, 1/2"C.		
33	1	REFRIGERATED EQUIPMENT STAND	6.0	120V/1ø	(3) #12, 1/2"C.	20"	
35	1	UNDERCOUNTER FREEZER	2.6	120V/1ø	(3) #12, 1/2"C.	20"	
36	1	ICE MAKER	11.0	208V/1ø	(3) #12, 1/2"C.	60"	
36	1	REMOTE CONDENSER	1.0	208V/1ø	(3) #12, 1/2"C.		
37	1	PREP REFRIGERATOR	5.8	120V/1ø	(3) #12, 1/2"C.	20"	
38	1	PREP REFRIGERATOR	6.0	120V/1ø	(3) #12, 1/2"C.	20"	
39	1	HOT FOOD SERVING COUNTER	18.8	208V/1ø	(3) #10, 3/4"C.	20"	
41	1	REFRIGERATED WORKTOP	2.5	120V/1ø	(3) #12, 1/2"C.	20"	
41	1	INDUCTION RANGE	15.0	208V/1ø	(3) #12, 1/2"C.	48"	
43	1	MEGA TOP PREP REFRIGERATOR	5.8	120V/1ø	(3) #12, 1/2"C.	20"	
44	1	HEAT LAMP	18.3	120V/1ø	(3) #10, 1/2"C.	56"	1
45	1	REFRIGERATED WORKTOP	2.5	120V/1ø	(3) #12, 1/2"C.	20"	
46	1	PANINI GRILL	13.3	240V/1ø	(3) #12, 1/2"C.	48"	
48	2	HEAT LAMP	23.3	120V/1ø	(3) #12, 1/2"C.	56"	1
50	1	REFRIGERATED WORKTOP	2.0	120V/1ø	(3) #12, 1/2"C.	20"	
52	1	FOOD PAN WARMER	8.3	120V/1ø	(3) #12, 1/2"C.	48"	
58	1	COMBI GAS OVEN	12.0	120V/1ø	(3) #12, 1/2"C.	48"	
60	1	UNDERCOUNTER REFRIGERATOR	2.5	120V/1ø	(3) #12, 1/2"C.	20"	
64	1	SOAD DISPENSER	2.4	120V/1ø	(3) #12, 1/2"C.	60"	
68	1	DISHWASHER	111.3	208V/3ø	(3) #1/0 & (1) #6 GRD, 2"C.	20"	
80	1	UNDERCOUNTER DISWASHER	15.0	120V/1ø	(3) #12, 1/2"C.	20"	


1. PROVIDE (2) JUNCTION BOXES, ONE FOR HEAT LAMP AND ONE FOR REMOTE CONTROL ENCLOSURE. PROVIDE DISCONNECT SWITCH ABOVE ACCESSIBLE CEILING, UPSTREAM OF REMOTE CONTROL AND HEAT LAMP. SEE KITCHEN EQUIPMENT DRAWINGS FOR EXACT MOUNTING HEIGHT AND MANUFACTURER'S INSTRUCTIONS FOR EXACT WIRING REQUIREMENTS.
2. PROVIDE CONNECTION TO ALL ACCESSORIES (HEAT TAPE, PRESSURE RELIEF PORT, LIGHT/THERMOMETER SWITCH, VAPOR LIGHT, ETC) PER MANUFACTURER'S INSTRUCTIONS.

1. EQUIPMENT ON SCHEDULE FURNISHED BY OTHERS.
2. EQUIPMENT SUBJECT TO CHANGE, FIELD VERIFY EQUIPMENT W/ OWNER AND ARCHITECT.
3. FIELD VERIFY ELECTRICAL REQUIREMENTS FOR ALL EQUIPMENT.
4. ALL EQUIPMENT SHALL BE INSTALLED PER MANUFACTURER'S SPECIFICATIONS.
5. COORDINATE EXACT LOCATION OF EQUIPMENT WITH OWNER.

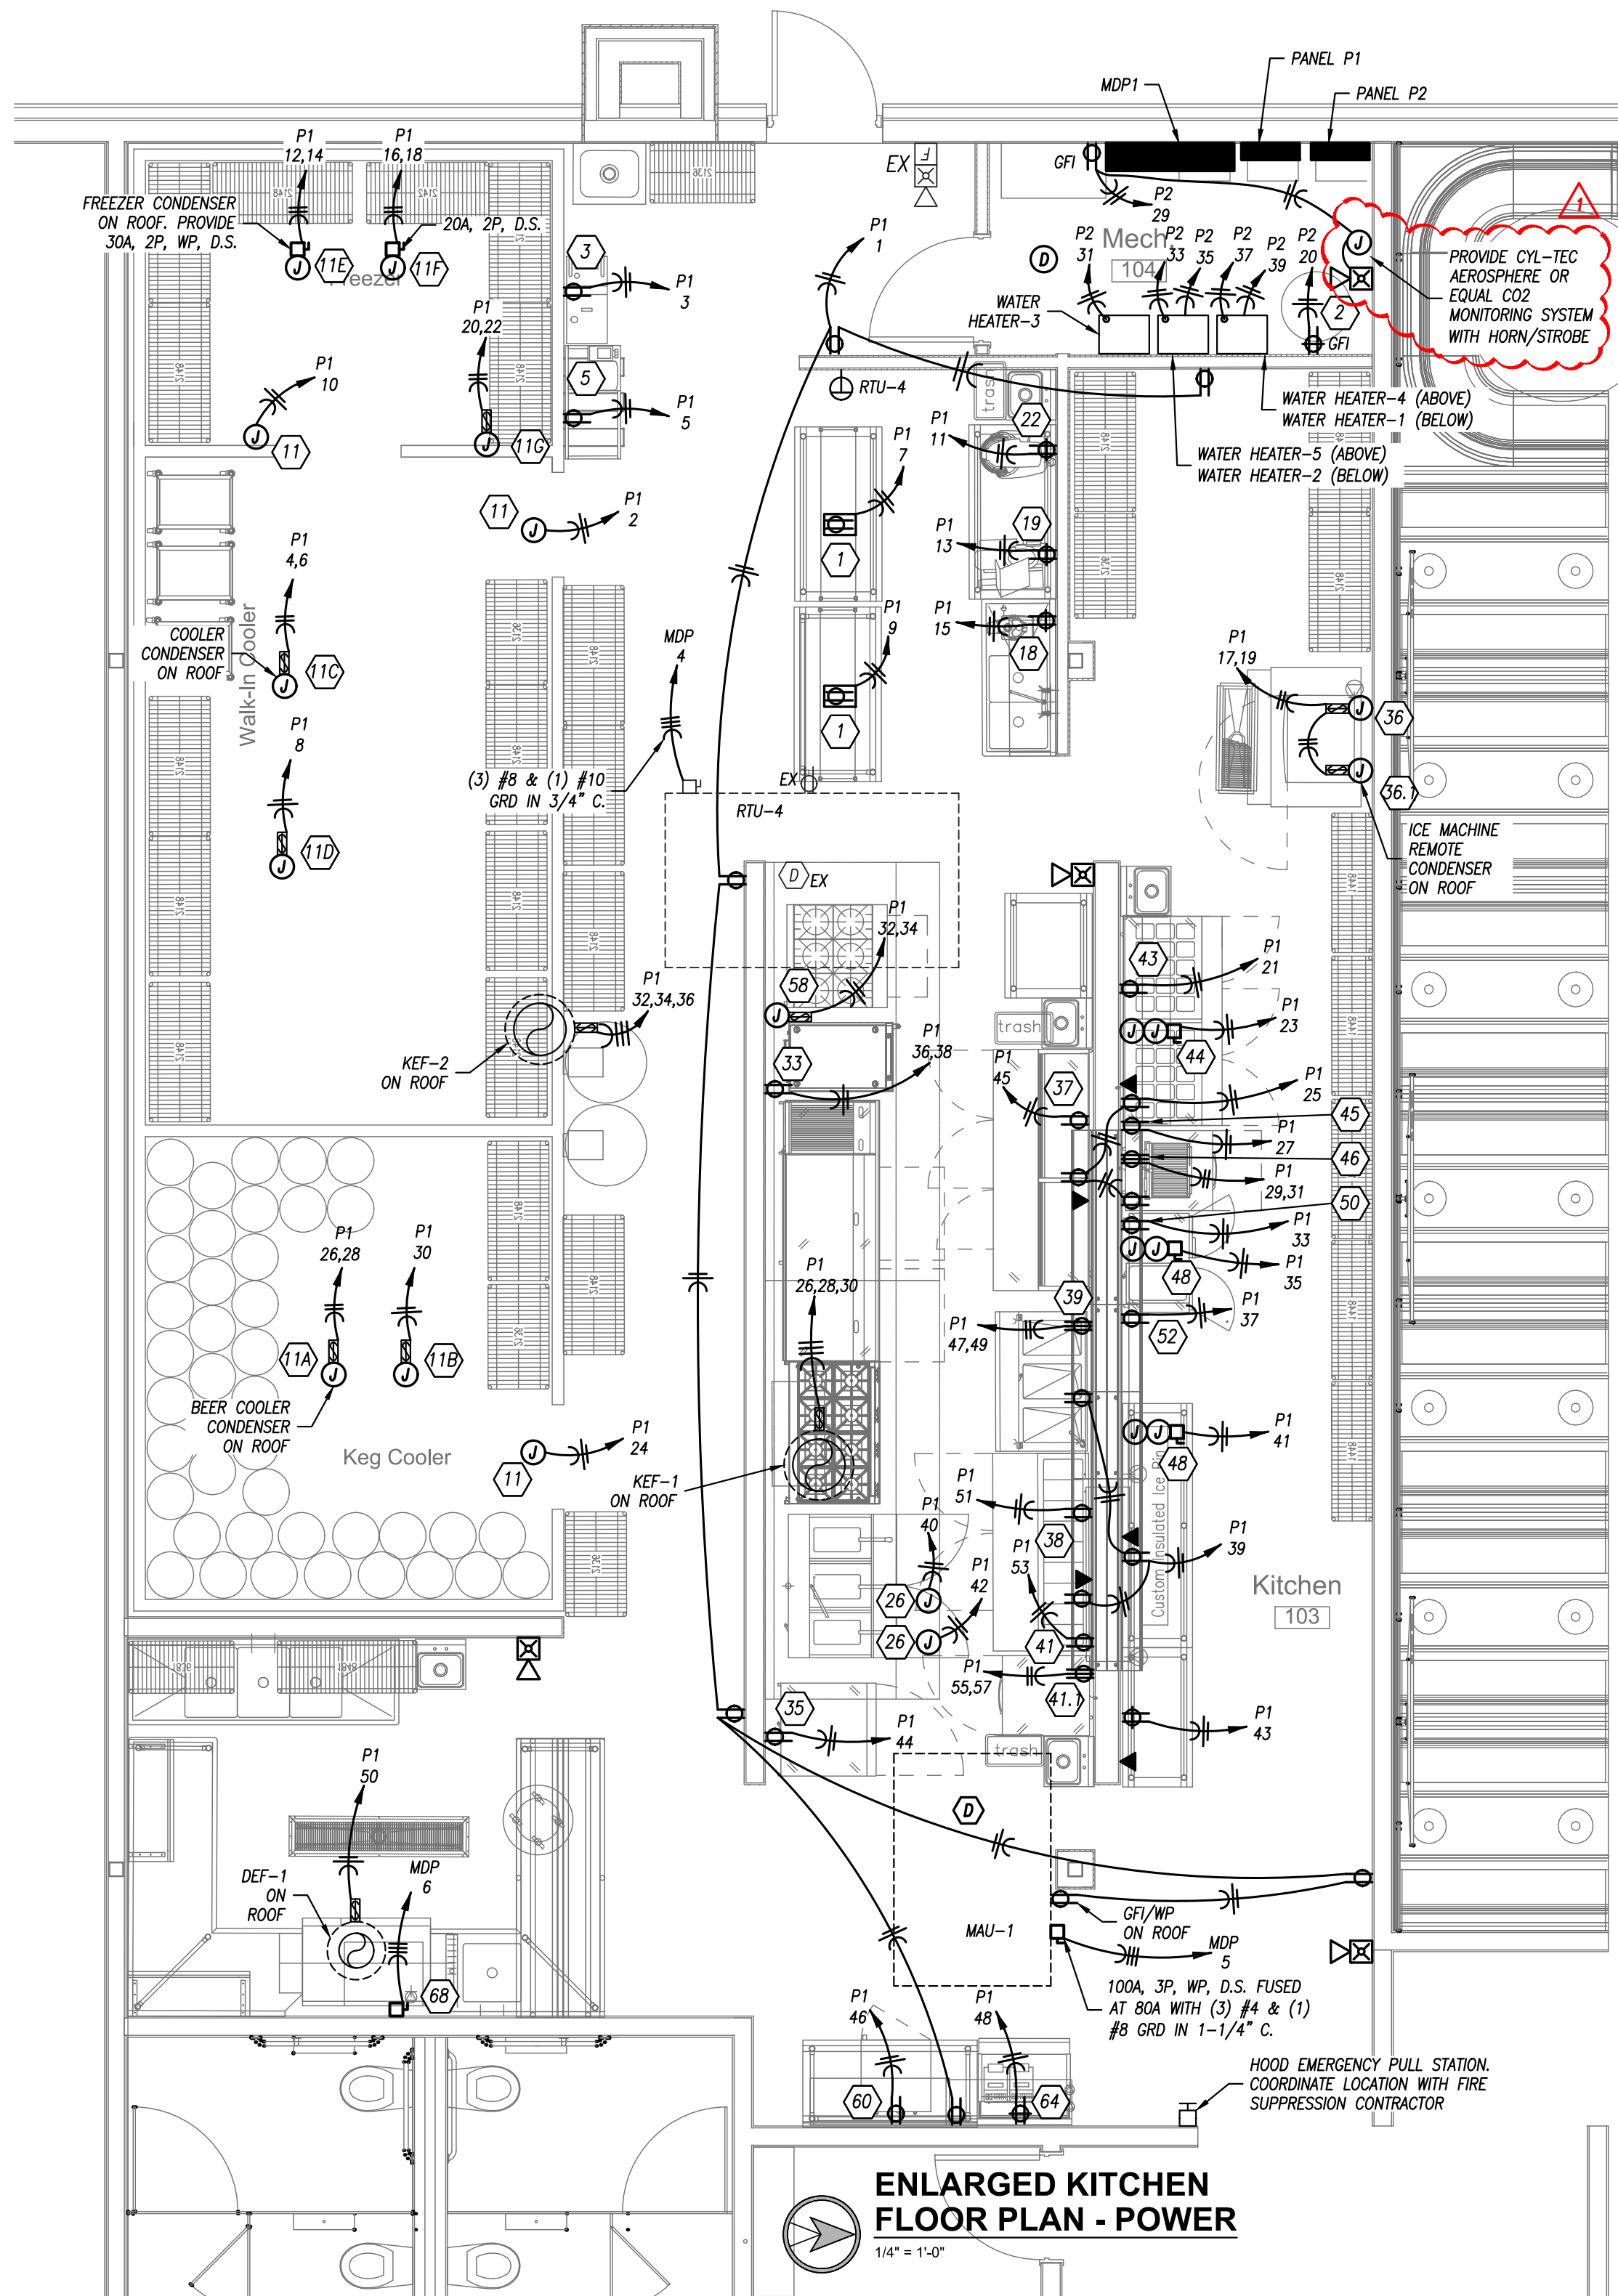




1. SWITCHBANK SHOWN IS DIAGRAMMATIC. CONTRACTOR TO PROVIDE SWITCHES TO MATCH SWITCHING ARRANGEMENT.
2. CONTRACTOR TO SUPPLY SWITCHES AS NEEDED TO ACCOMMODATE THE CORRESPONDING LIGHTING LOAD TYPE AND SIZE.
3. CONTRACTOR SHALL ENSURE THAT EACH SWITCH IS RATED TO SERVE THE CONNECTED LIGHTING LOAD, FOLLOWING ALL APPLICABLE DERATING FACTORS AS OUTLINED BY THE MANUFACTURER.
4. CONTRACTOR SHALL LABEL SWITCHES PER OWNER DIRECTION.
5. VERIFY EXIST ARRANGEMENT AND LOCATION WITH ARCHITECT PRIOR TO ROUGH-IN.

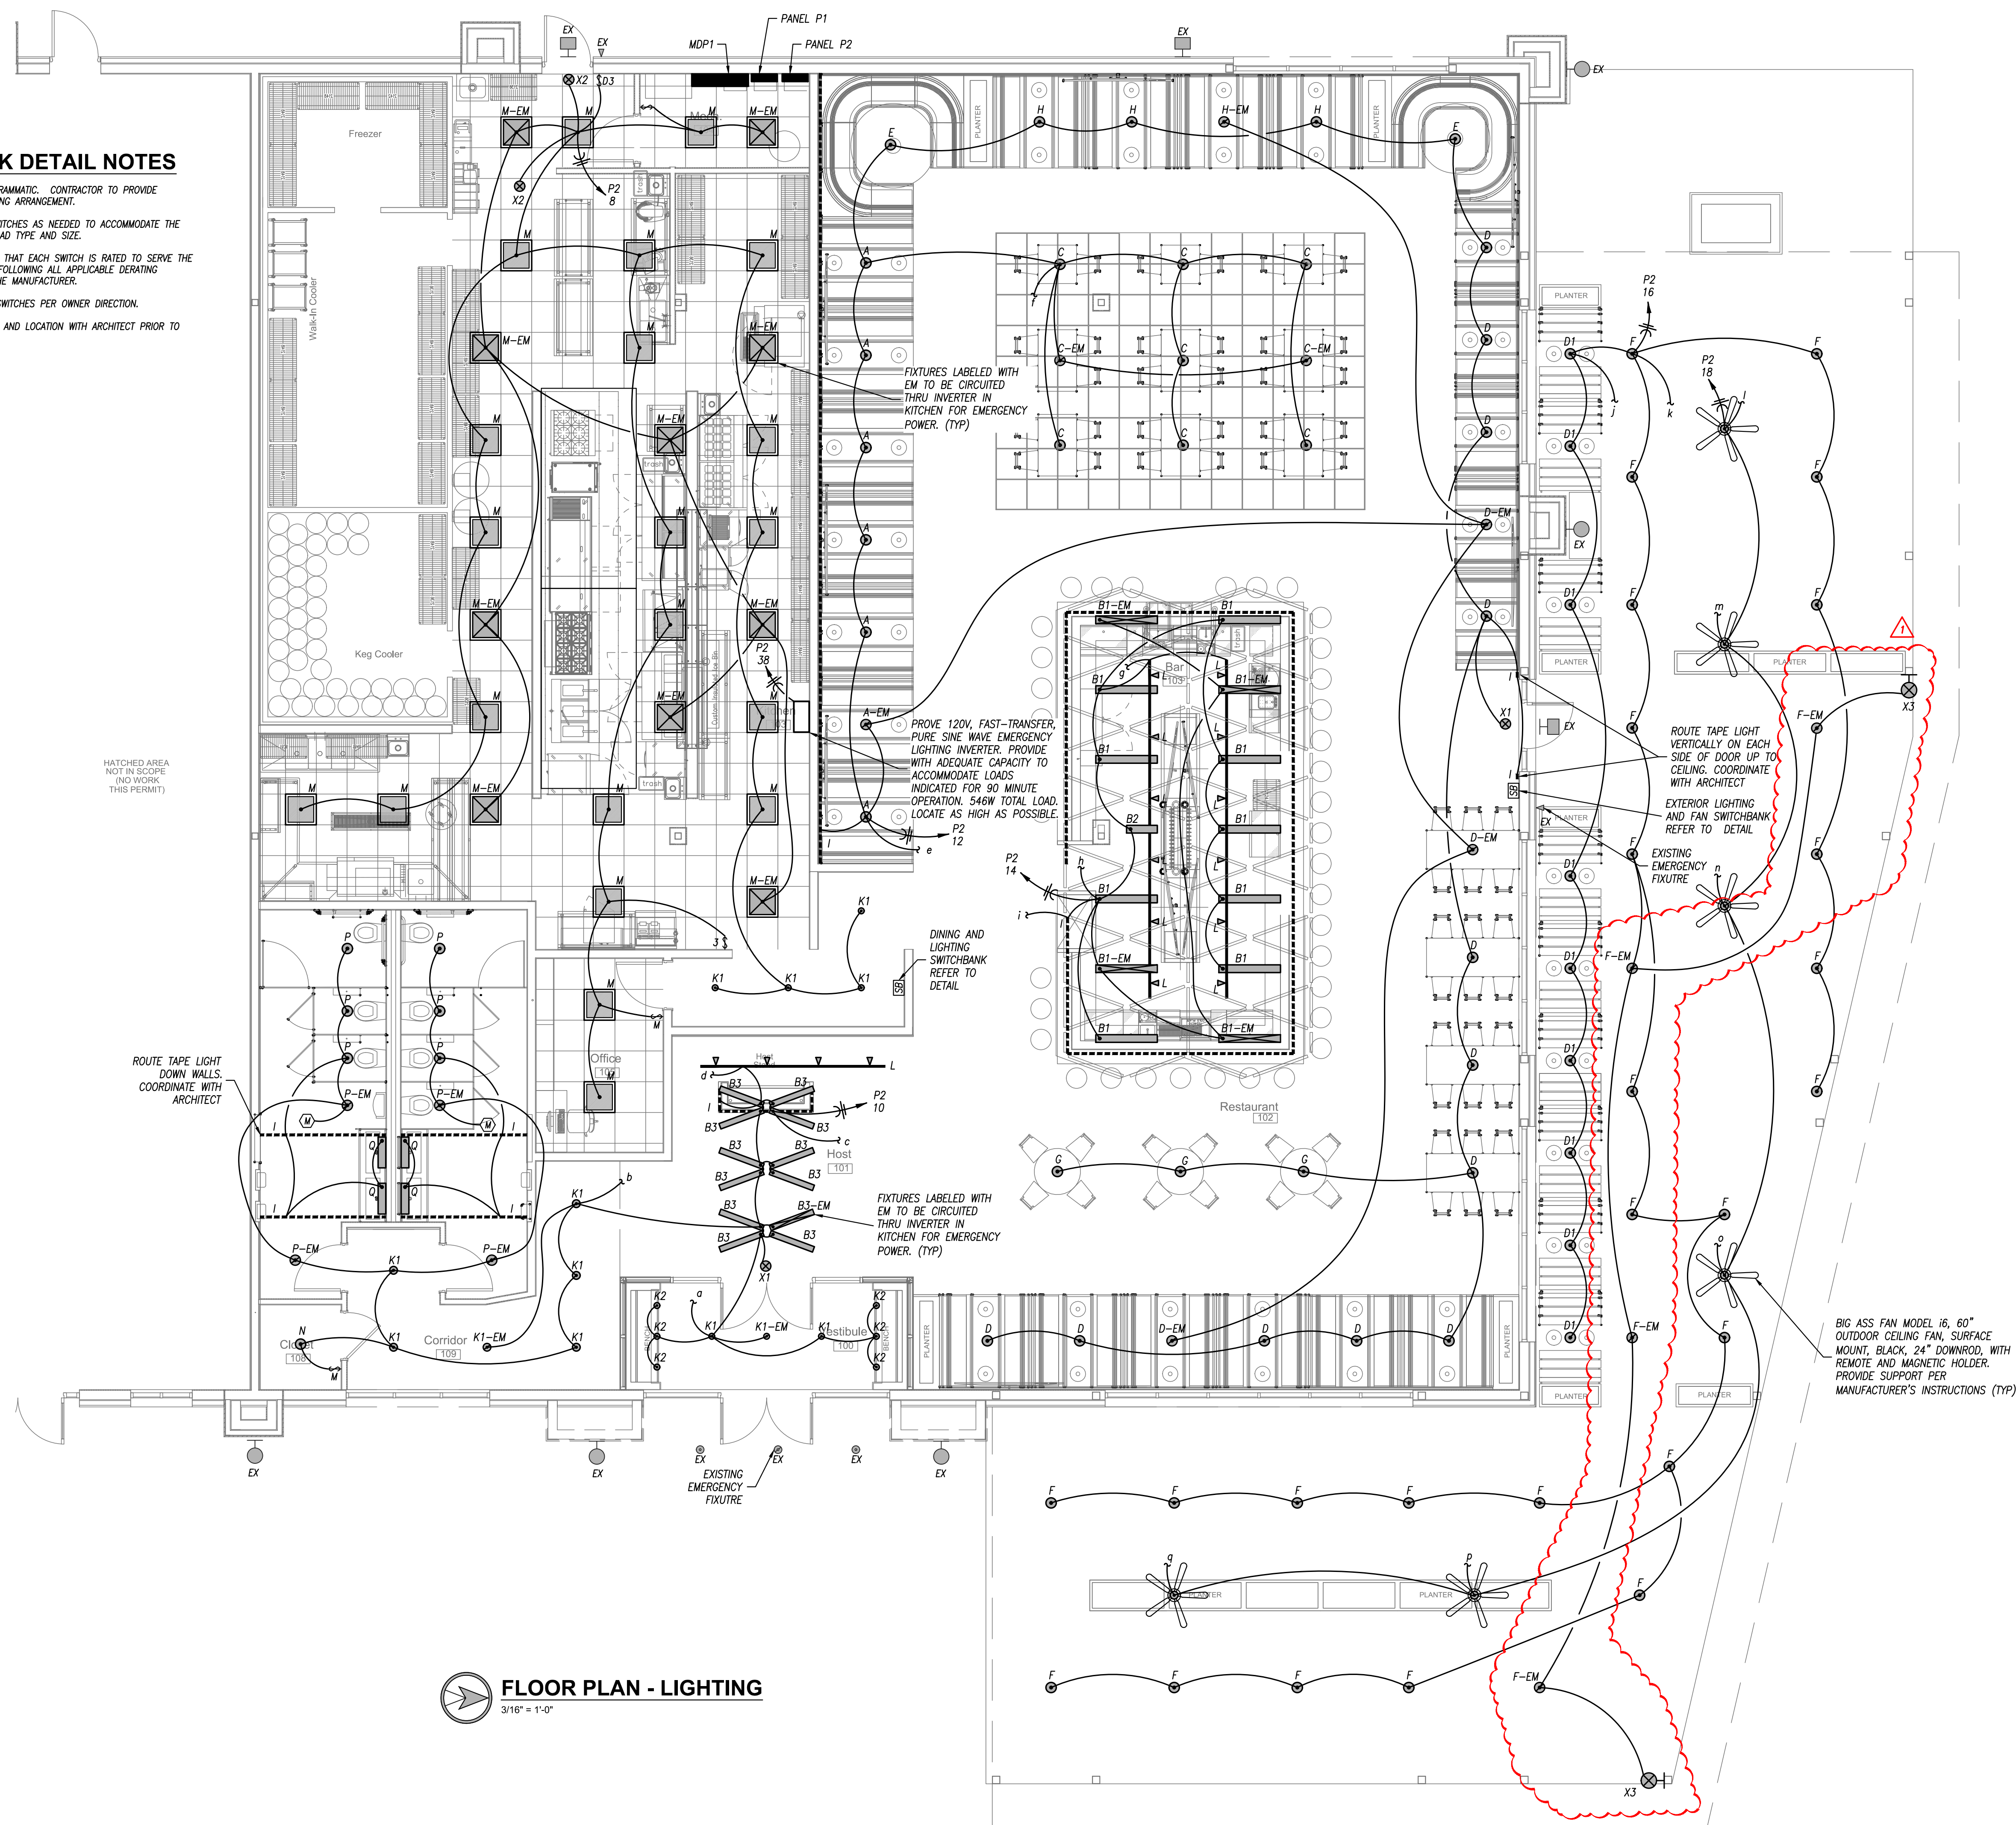

 **FLOOR PLAN - LIGHTING**
3/16" = 1'-0"

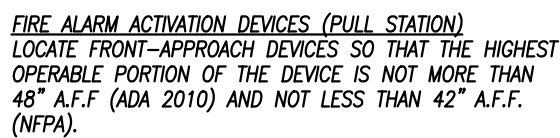

NOT TO SCALE




NOTES LEGEND

1. PROVIDE DIMMABLE LED DRIVER UNIVERSAL VOLTAGE.
2. PROVIDE WITH PHILIPS BW, A19 WARM GLOW LED DIMMABLE BULB.
3. PROVIDE WET LOCATION RATED FIXTURE.
4. PROVIDE COLD LOCATION RATED BALLAST.
5. PROVIDE 1 CIRCUIT SURFACE TRACK -- REFER TO PLANS FOR TRACK LENGTH AND CONFIGURATION. PROVIDE ALL NECESSARY POWER FEEDS AND ACCESSORIES FOR COMPLETE INSTALLATION TRACK AND COMPONENT FINISHES TO MATCH FIXTURE. PROVIDE EACH TRACK RUN WITH 3 AMP CURRENT LIMITER.
6. PROVIDE EMERGENCY BATTERY MINIMUM OF 1000 LUMENS FOR 90 MINUTES



1. REFER TO GENERAL NOTES ON MEP COVER SHEET FOR ADDITIONAL REQUIREMENTS OF WORK.
2. LIGHT FIXTURES INDICATED AS EMERGENCY FIXTURES ARE TO FUNCTION AS NIGHT LIGHTS UNLESS SPECIFICALLY SHOWN SWITCHED.
3. ALL CIRCUITING SHOWN ON THIS PLAN IS DIAGRAMMATIC.
 - 3.1. ALL FIXTURES SHALL BE FED FROM JUNCTION BOXES WITH LIGHTS (L) AND/OR FAN (F). DUSTY-COVERED FIXTURES IS NOT ALLOWED.
 - 3.2. SWITCH BOX LOCATIONS SHALL BE WIRED SO THAT A NEUTRAL WIRE IS AVAILABLE AT THE SWITCH BOX LOCATION, EITHER IN THE BOX OR AVAILABLE TO BE ADDED VIA RACEWAY OR AN ACCESSIBLE WALL CAVITY.
 - 3.3. WIRING METHODS FOR SPECIAL TYPES (Eg/NORMAL, 120/277V, ETC.) SHALL NOT BE IN A SINGLE BOX.
 - 3.4. REFER TO SPECIFICATIONS FOR ADDITIONAL REQUIREMENTS.

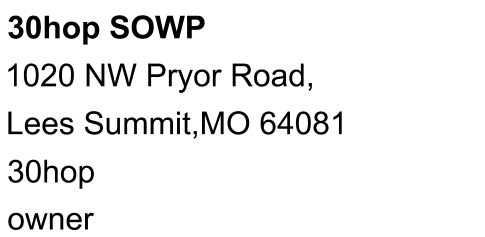

orientation

project number 232882

scale As Noted

date 5/22/2024

sheet title	Electrical Details
-------------	--------------------

sheet title	Electrical Details
-------------	--------------------

sheet number