
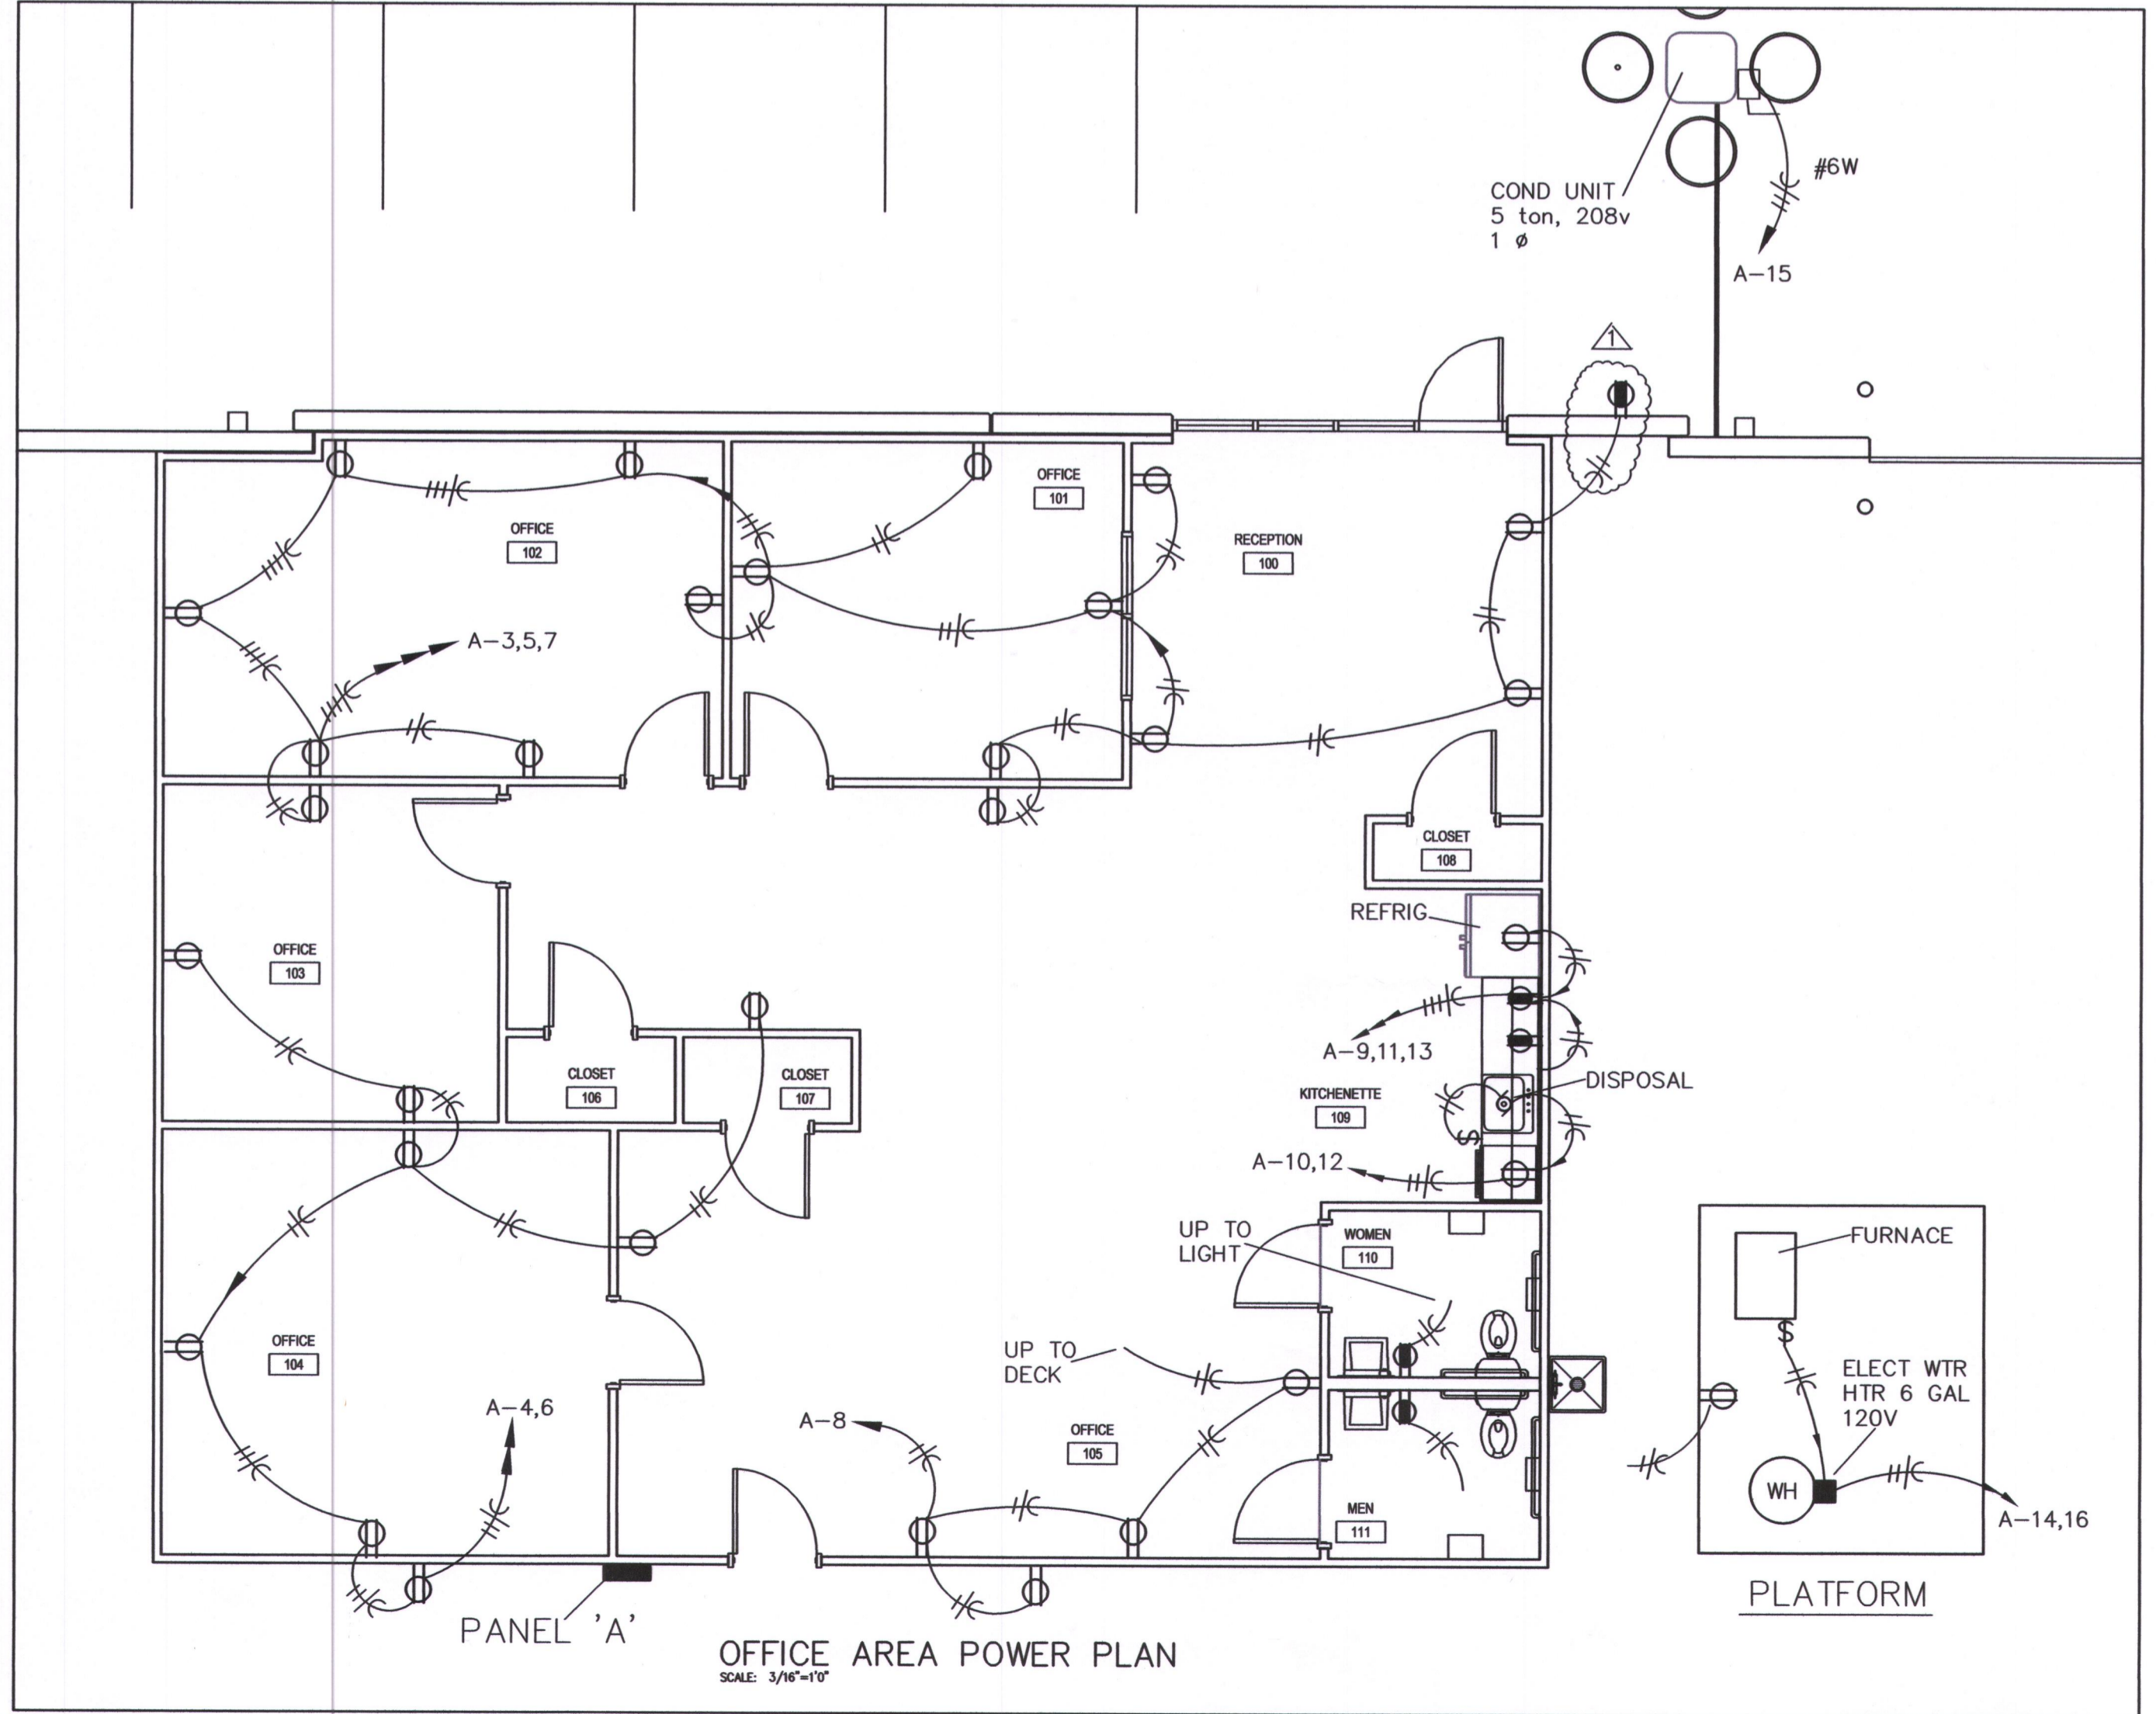


LIGHT FIXTURE SCHEDULE

- A RAB #H17 HIGH BAY LED, 150WATT, 277V, 4000K, WITH CORD PROVIDE WITH HOOK TO HANG FROM ROOF
- B EIKO #SLM2462C5840U 2'X4' LEDSLIM PANEL 6200 LUMENS, 4000K, 50 WATT, 120 V
- C SIMILAR TO TYPE B EXCEPT 2'X2'LED, 120 V
- ⊗ COMBO EXIT/ EMERGENCY LIGHT LITHONIA #LHQM LED RHO
- ◀ EMERGENCY LIGHT LITHONIA #ELM2 LED

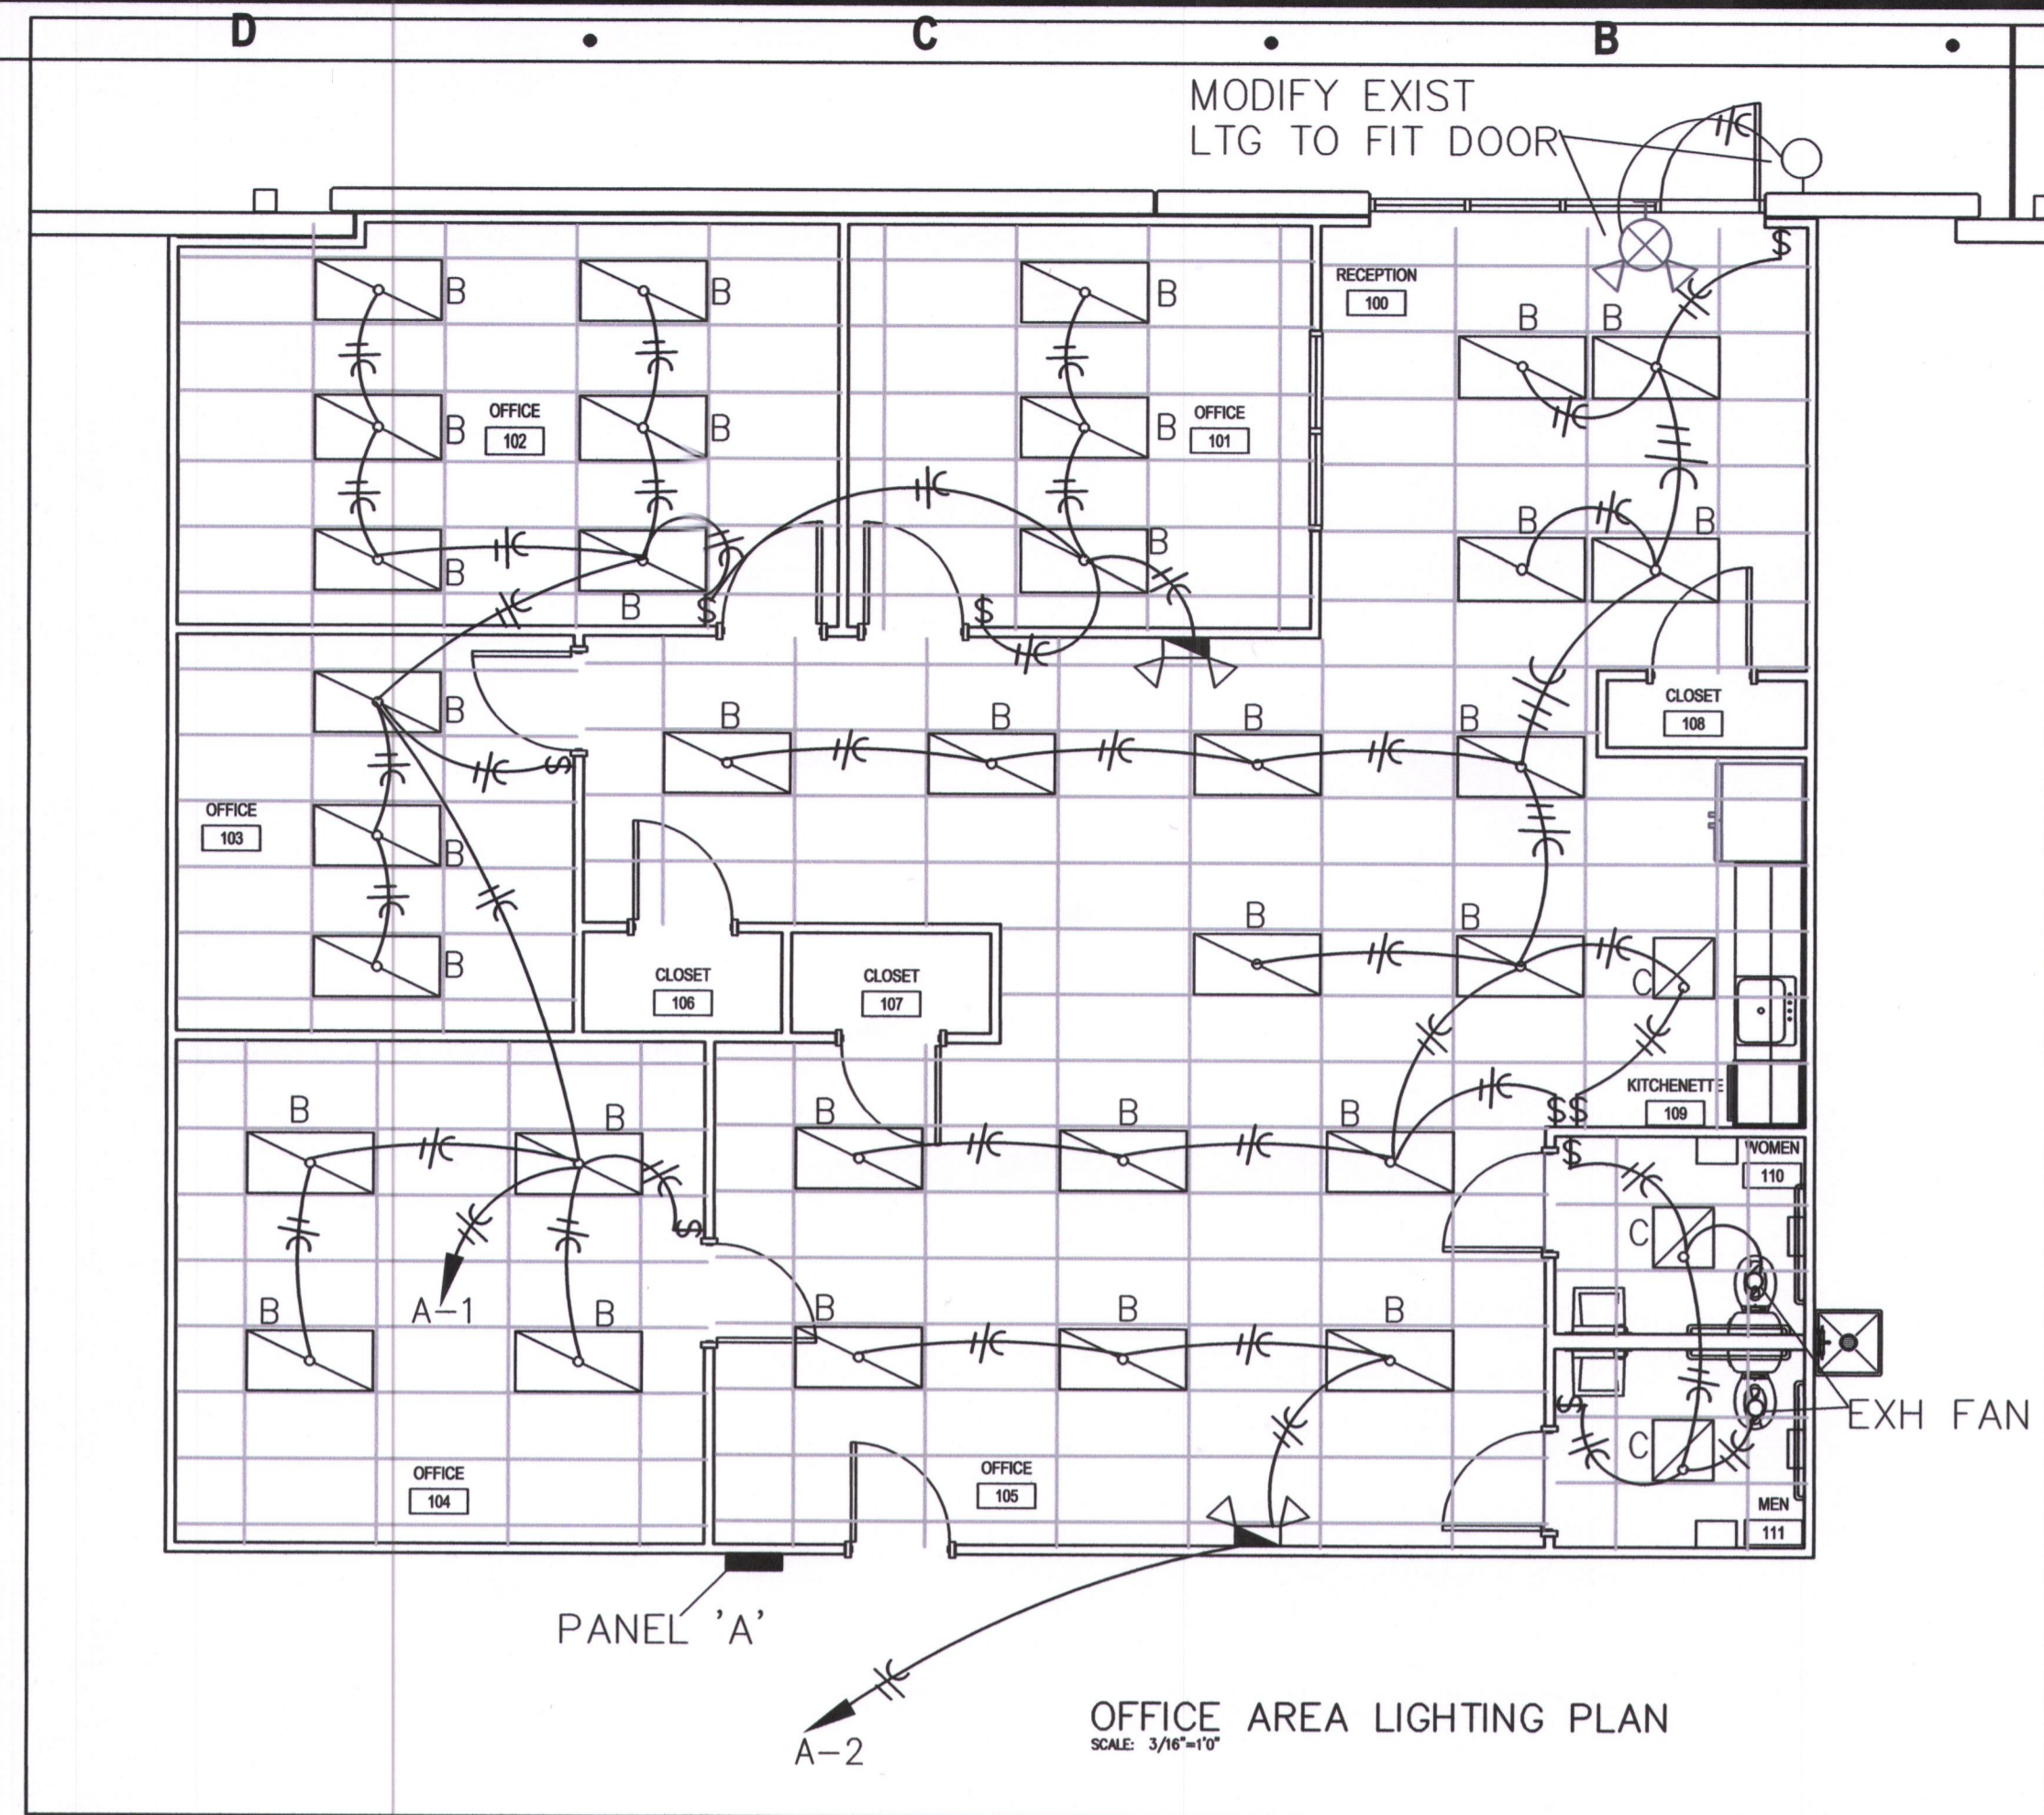


Architect:
MIDWEST ARCHITECTS
1120 NW Eagle Ridge Blvd.
Grain Valley, Missouri 64029
t: (816) 229-8115

Client:
Ward Development
1120 NW Eagle Ridge Blvd.
Grain Valley, Missouri 64029
t: (816) 229-8115

Consultants:
MEP Engineering:
Casburn Consultants
Professional Engineering
128 SW Hillcrest Lane
Lee's Summit, MO 64063
t: (816) 726-6531

Revisions to technical submissions which are not made or approved by the licensee are prohibited.

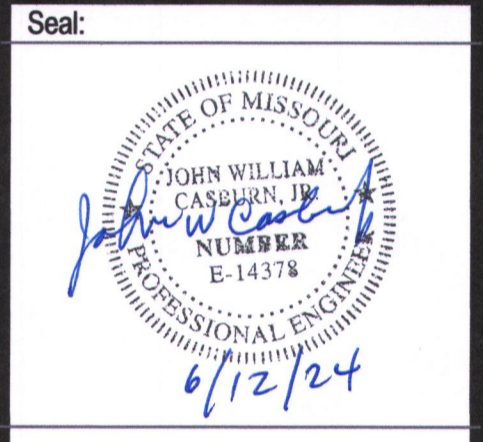

Project Number: 2404
Project Type: TENANT FINISH
Project Name and Address:

JOHNSON STORAGE
2225 NW Town Centre Blvd.
Lee's Summit, Missouri 64064

Issue:	Date:
Permit Submittal	05.29.24
1 added receipt.	06.12.24

Sheet Title:

E-2