


REMARKS:

1. EQUIPMENT ON SCHEDULE FURNISHED BY OTHERS.
2. EQUIPMENT SUBJECT TO CHANGE, FIELD VERIFY EQUIPMENT W/ OWNER AND ARCHITECT.
3. FIELD VERIFY PLUMBING REQUIREMENTS FOR ALL EQUIPMENT.
4. ALL EQUIPMENT SHALL BE INSTALLED PER MANUFACTURER'S SPECIFICATIONS.
5. COORDINATE EXACT LOCATION OF EQUIPMENT WITH OWNER.



REMARKS:


1. EQUIPMENT ON SCHEDULE FURNISHED BY OTHERS.
2. EQUIPMENT SUBJECT TO CHANGE, FIELD VERIFY EQUIPMENT W/ OWNER AND ARCHITECT.
3. FIELD VERIFY PLUMBING REQUIREMENTS FOR ALL EQUIPMENT.
4. ALL EQUIPMENT SHALL BE INSTALLED PER MANUFACTURER'S SPECIFICATIONS.
5. COORDINATE EXACT LOCATION OF EQUIPMENT WITH OWNER.

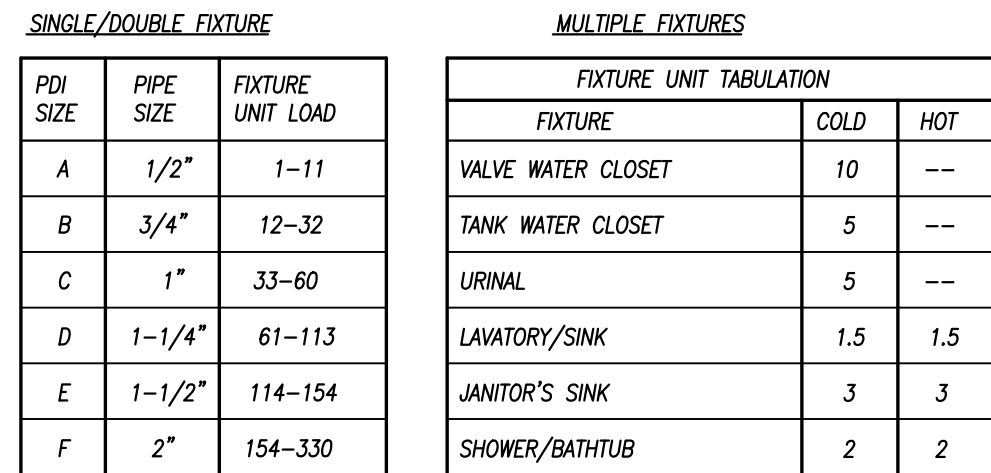


FOR BATTERIES & FIXTURES, PROVIDE WATER HAMMER ARRESTERS BY SIOUX CHIEF, PRECISION PLUMBING PRODUCTS, WAITS OR APPROVED EQUIVALENT WITH PISTON AND O-RING CONSTRUCTION, HAVING PDI #WH-201, ASSE # 1010 AND ANSI # A112.26.1M CERTIFICATION. INSTALL IN HORIZONTAL OR VERTICAL POSITION, BUT NEVER UPSIDE DOWN. INSTALL IN LINE WITH WATER FLOW DIRECTION IF POSSIBLE. SIZE THE UNITS AS SHOWN ON THE DRAWINGS AND/OR PER THE TABLES SHOWN ABOVE. PROVIDE ACCESSIBILITY TO "WHA" WHERE REQUIRED BY LOCAL CODE.

NOT TO SCALE



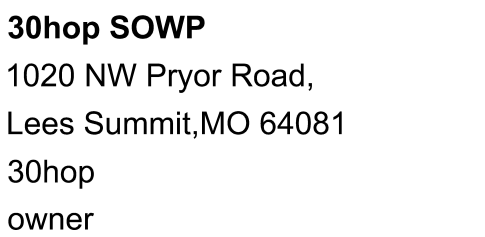

orientation	
project number	232882
scale	As Noted
date	7/23/2024
sheet title	Plumbing Details
sheet number	

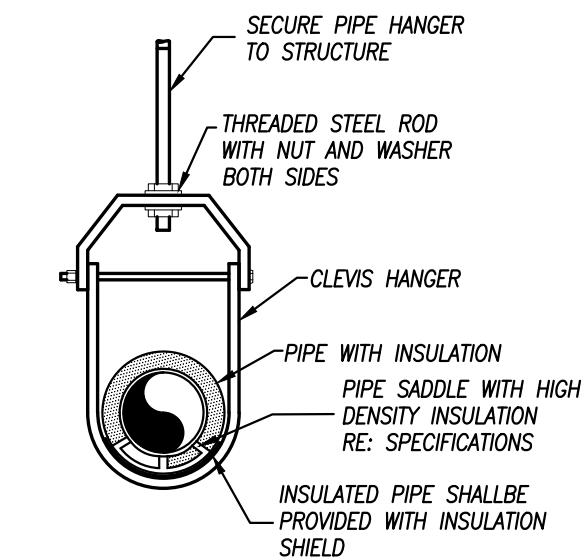


NOT TO SCALE

- ## TANKLESS GAS WATER HEATER DETAIL



 NOT TO SCALE



NOT TO SCALE



WATER HEATER SCHEDULE						
PLAN MARK	MANUFACTURER	MODEL NUMBER	GALLONS	CAPACITY	ELECTRICAL	NOTES
WATER HEATER-1	NAVEN	NPE-240A2	TANKLESS	13,300 BTU/H MIN ~ 199,000 BTU/H MAX	120V, 200W	1,2,3
WATER HEATER-2	NAVEN	NPE-240A2	TANKLESS	13,300 BTU/H MIN ~ 199,000 BTU/H MAX	120V, 200W	1,2,3
WATER HEATER-3	NAVEN	NPE-240A2	TANKLESS	13,300 BTU/H MIN ~ 199,000 BTU/H MAX	120V, 200W	1,2,3
WATER HEATER-4	NAVEN	NPE-240A2	TANKLESS	13,300 BTU/H MIN ~ 199,000 BTU/H MAX	120V, 200W	1,2,3
WATER HEATER-5	NAVEN	NPE-240A2	TANKLESS	13,300 BTU/H MIN ~ 199,000 BTU/H MAX	120V, 200W	1,2,3

- ## EXPANSION TANK SCHEDULE

FLOOR DRAIN SCHEDULE						
PLAN MARK	MANUFACTURER	MODEL NUMBER	SERVICE	TOP/GRAZE SIZE	WASTE SIZE	REMARKS
FD-1	SIOUX CHIEF	842-PB	FLOOR DRAIN	5-1/2"Ø	2"	1,3
FS-1	SIOUX CHIEF	861	FLOOR SINK	12"x12"	2"	2
FT-1	JOHN BOOS	FTFG-1236	TRENCH DRAIN	12"x36"	4"	---

- ## PIPING MATERIAL & INSULATION SCHEDULE

PIPING						FIELD TEST PRESSURE/TIME		ALLOWABLE IN PLENUMS		INSULATION	
SYSTEM	SIZE	TYPE/SCHED	MATERIAL	ACCEPTABLE FITTINGS					TYPE	THICKNESS	
DOMESTIC COLD WATER	1/2"-2-1/2"	L	COPPER	SOLDER, PRO-PRESS		130 PSI - 1/2HR	YES		FIBERGLASS W/ ASJ	1/2"	
DOMESTIC HOT WATER & HW RETURN	1/2"-2-1/2"	L	COPPER	SOLDER, PRO-PRESS		130 PSI - 1/2HR	YES		FIBERGLASS W/ ASJ	1"	
DOM. HOT & COLD BELOW GRADE	1/2"-1-1/4"	K	COPPER	CONTINUOUS TUBING, BRAZED		130 PSI - 1/2HR	YES		ELASTOMERIC	3/4" (HOT ONLY)	
DOMESTIC COLD WATER	3"-6"	L	COPPER	BRAZED, PRO-PRESS		130 PSI - 1/2HR	YES		FIBERGLASS W/ ASJ	1/2"	
DOMESTIC HOT WATER	3"-6"	L	COPPER	BRAZED, PRO-PRESS		130 PSI - 1/2HR	YES		FIBERGLASS W/ ASJ	1-1/2"	
NATURAL GAS - ABOVE GRADE	2-1/2" & Up	SCH. 40	STEEL - SEEMED	WELDED		75 PSI - 1HR	YES	----	----	----	
NATURAL GAS - ABOVE GRADE	1/2"-2"	SCH. 40	STEEL - SEEMLESS	THREADED IRON		75 PSI - 1HR	YES	----	----	----	
NATURAL GAS BELOW GRADE	ALL	SOR-11	POLYETHYLENE	FUSION JOINTS		100 PSI - 1HR	NO	----	----	----	
SOIL & WASTE ABOVE GRADE	1-1/2"-6"	NO HUB / SERVICE WT.	CAST IRON	NO HUB		10 FT - 1/2HR	YES	----	----	----	
SOIL & WASTE ABOVE GRADE	2"-8"	SCH. 40	PVC	SOLVENT JOINED		10 FT - 1/2HR	NO	----	----	----	
SOIL & WASTE BELOW GRADE	2"-8"	SCH. 40	PVC	SOLVENT JOINED		10 FT - 1/2HR	NO	----	----	----	
DRINKING FOUNT. DRAIN	ALL	----	----	----		----	YES	----	ELASTOMERIC	1/2"	
CONDENSATE DRAIN ON ROOF	3/4"-2"	SCH. 40	PVC	SOLVENT JOINED		10 FT - 1/2HR	NO	----	----	----	
CONDENSATE DRAIN INTERIOR	1/2"-2"	L	COPPER	SOLDER, PRO-PRESS		10 FT - 1/2HR	YES		FIBERGLASS W/ ASJ	1/2" (PLENUM ONLY)	
FIRE SERVICE BELOW GRADE	4"-8"	AWWA C151	DUCTILE IRON	AWWA C111, MECH JOINTS		130 PSI - 1/2HR	YES	----	----	----	
DOM. WATER SERVICE BELOW GRADE	4"-8"	AWWA C151	DUCTILE IRON	AWWA C111, MECH JOINTS		130 PSI - 1/2HR	YES	----	----	----	
DOM. WATER SERVICE BELOW GRADE	1"-3"	K	COPPER	CONTINUOUS TUBING, BRAZED		130 PSI - 1/2HR	YES	----	----	----	
DOM. WATER SERVICE BELOW GRADE	1"-3"	DR 9	HDPE	CONTINUOUS TUBING, FUSED		130 PSI - 1/2HR	NO	----	----	----	

- NOTES
1. ALL PIPING AND MATERIALS IN PLENUMS MUST MEET ASTM E84 FLAME/SMOKE RATING OF 25/50
 2. ALL INSULATION THICKNESSES SHALL MEET ASHRAE 90.1 - 2007 REQUIREMENTS AT A MINIMUM.
 3. REFER TO SPECIFICATIONS FOR MORE DETAILED INFORMATION.

30hop SOWP
1020 NW Pryor Road,
Lees Summit,MO 64081
30hop
owner

[illegible]

orientation

project number 232882


scale As Noted

date 7/23/2024

sheet title	Power Plan
-------------	------------

sheet number

sheet number 542

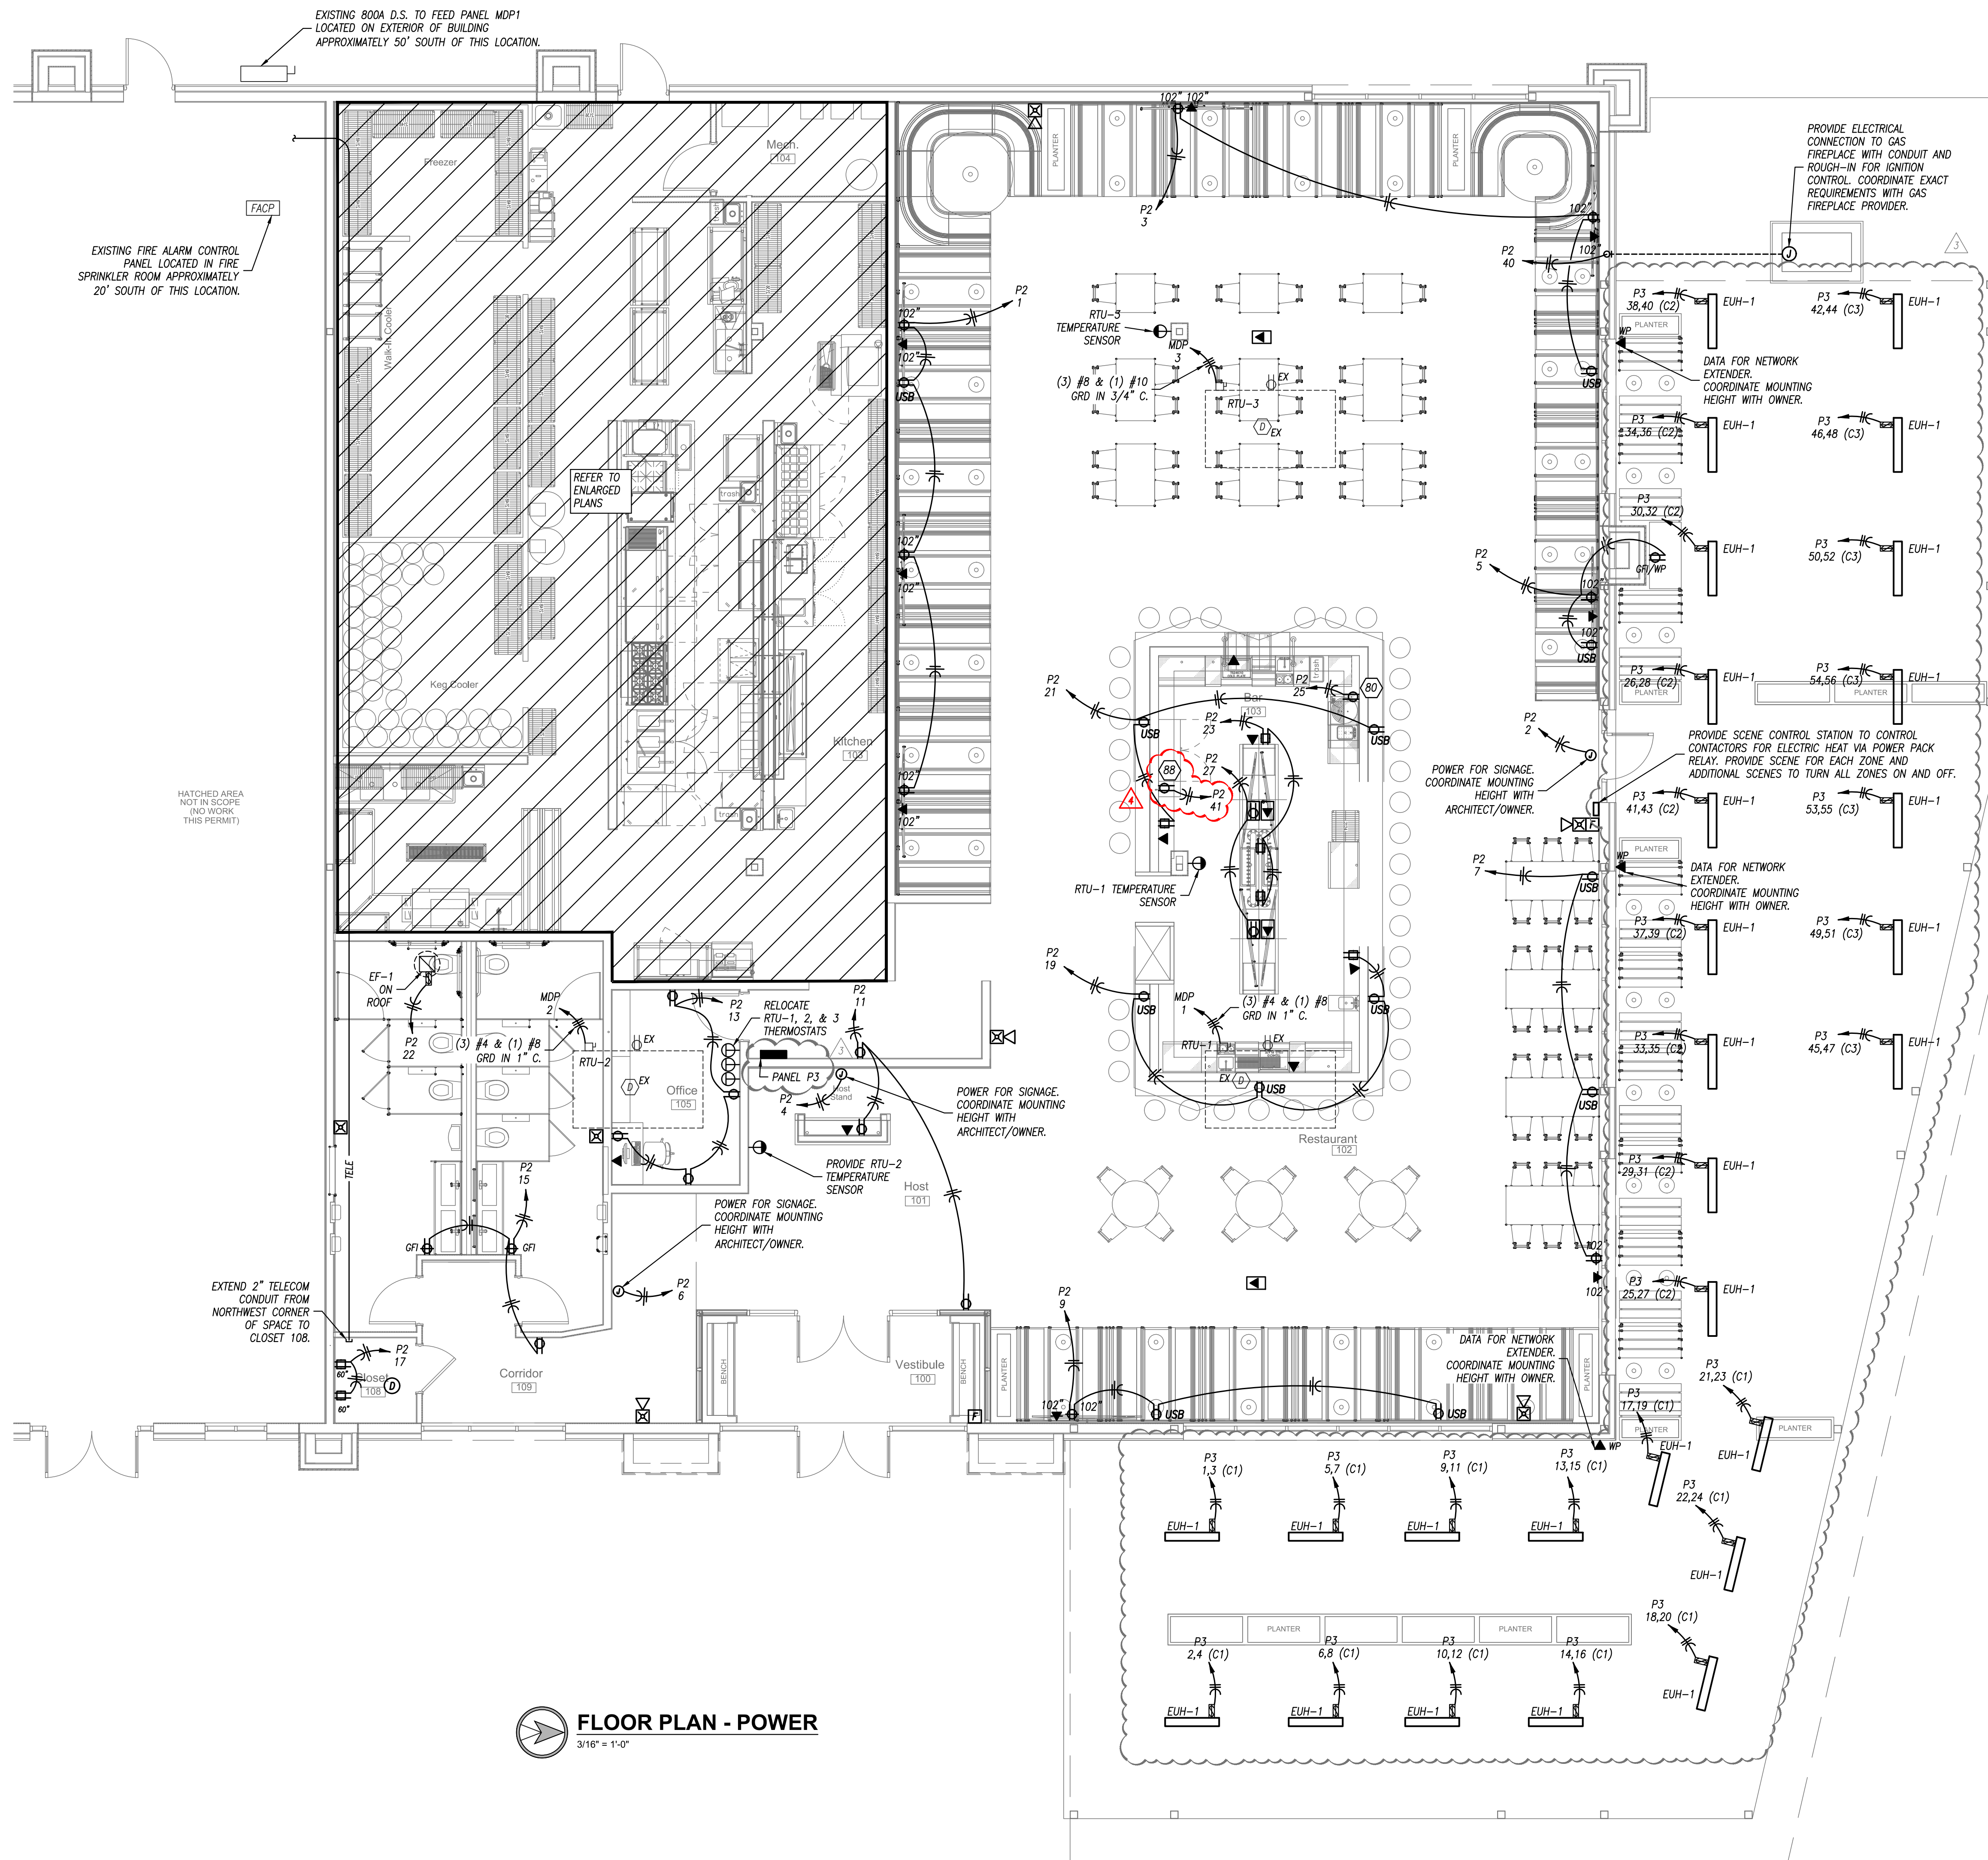


 **FLOOR PLAN - POWER**
3/16" = 1'-0"


orientation	
project number	232882
scale	As Noted
date	7/23/2024
sheet title	Power Plant
sheet number	

ITEM NO	QTY	EQUIPMENT DISCRPTION	AMPS	VOLTAGE/ PHASE	WIRE SIZE	HEIGHT (AFF)	NOTES
2	2	S/S WORK TABLE	15.0	120V/1#	(3) #12, 1/2"C.		
2	1	BULK CO2 TANK	15.0	120V/1#	(3) #12, 1/2"C.	48"	
3	1	PORTABLE OIL FILTER	15.0	120V/1#	(3) #12, 1/2"C.	20"	
5	1	BAG-IN-BOX SYSTEM	15.0	120V/1#	(3) #12, 1/2"C.	60"	
11	3	COOLER/FREEZER LIGHTS AND ACCESSORIES	10.0	120V/1#	(3) #12, 1/2"C.		2
1A	1	BEER COOLER CONDENSER	16.1	208V/1#	(3) #10, 3/4"C.		
11B	1	BEER COOLER COIL	15.0	120V/1#	(3) #12, 1/2"C.		
11C	1	COOLER CONDENSER	22.2	208V/1#	(3) #10, 3/4"C.		
11D	1	COOLER COIL	15.0	120V/1#	(3) #12, 1/2"C.		
11E	1	FREEZER CONDENSER	25.3	208V/1#	(2) #8 & (1) #10 GRD, 3/4"C.		
11F	1	FREEZER COIL	15.0	208V/1#	(3) #12, 3/4"C.		
11G	1	DRAIN LINE HEATER	15.0	240V/1#	(3) #12, 1/2"C.		
18	1	FOOD PROCESSOR	12.0	120V/1#	(3) #12, 1/2"C.	48"	
18	1	IMMERSION HAND MIXER	10.0	120V/1#	(3) #12, 1/2"C.	48"	
19	1	FOOD SLICER	1.4	120V/1#	(3) #12, 1/2"C.	48"	
22	1	NOT USED					
26	2	EXHAUST HOOD SYSTEM	15.0	120V/1#	(3) #12, 1/2"C.		
31	1	REFRIGERATED EQUIPMENT STAND	6.0	120V/1#	(3) #12, 1/2"C.	20"	
33	1	REFRIGERATED EQUIPMENT STAND	6.0	120V/1#	(3) #12, 1/2"C.	20"	
34	1	BATTERY FRYER	12.0	120V/1#	(3) #12, 1/2"C.	20"	
35	1	UNDERCOUNTER FREEZER	1.8	120V/1#	(3) #12, 1/2"C.	20"	
36	1	ICE MAKER	11.0	208V/1#	(3) #12, 1/2"C.	60"	
36	1	REMOTE CONDENSER	1.0	208V/1#	(3) #12, 1/2"C.		
37	1	PREP REFRIGERATOR	5.8	120V/1#	(3) #12, 1/2"C.	20"	
38	1	PREP REFRIGERATOR	6.0	120V/1#	(3) #12, 1/2"C.	20"	
39	1	HOT FOOD SERVING COUNTER	12.5	120V/1#	(3) #12, 1/2"C.	20"	
41	1	REACH IN UNDERCOUNTER FREEZER	1.8	120V/1#	(3) #12, 1/2"C.	20"	
41	1	NOT USED					
43	1	MEGA TOP PREP REFRIGERATOR	2.8	120V/1#	(3) #12, 1/2"C.	20"	
44	1	HEAT LAMP	13.3	120V/1#	(3) #12, 1/2"C.	56"	1
45	1	REFRIGERATED WORKTOP	4.8	120V/1#	(3) #12, 1/2"C.	20"	
46	1	PANNINI GRILL	13.3	240V/1#	(3) #12, 1/2"C.	42"	
46	2	HEAT LAMP	23.3	120V/1#	(3) #12, 1/2"C.	56"	1
50	1	REFRIGERATED WORKTOP	2.0	120V/1#	(3) #12, 1/2"C.	20"	
52	1	FOOD PAN WARMER	8.3	120V/1#	(3) #12, 1/2"C.	48"	
58	1	MULTICOOK OVEN	28.0	208V/3#	(3) #8 & (1) #10 GRD, 1"C.	48"	
60	1	UNDERCOUNTER REFRIGERATOR	2.3	120V/1#	(3) #12, 1/2"C.	20"	
64	1	SOAD DISPENSER	2.4	120V/1#	(3) #12, 1/2"C.	60"	
68	1	DISHWASHER	111.3	208V/3#	(3) #1/0 & (1) #6 GRD, 2"C.	20"	
80	1	UNDERCOUNTER DISHWASHER	3.5	120V/1#	(3) #12, 1/2"C.	20"	
88	1	REFRIGERATED BACK BAR CABINET	7.0	120V/1#	(3) #12, 1/2"C.	20"	

REMARKS:

1. EQUIPMENT ON SCHEDULE FURNISHED BY OTHERS.
2. EQUIPMENT SUBJECT TO CHANGE, FIELD VERIFY EQUIPMENT W/ OWNER AND ARCHITECT.
3. FIELD VERIFY ELECTRICAL REQUIREMENTS FOR ALL EQUIPMENT.
4. ALL EQUIPMENT SHALL BE INSTALLED PER MANUFACTURER'S SPECIFICATIONS.
5. COORDINATE EXACT LOCATION OF EQUIPMENT WITH OWNER.

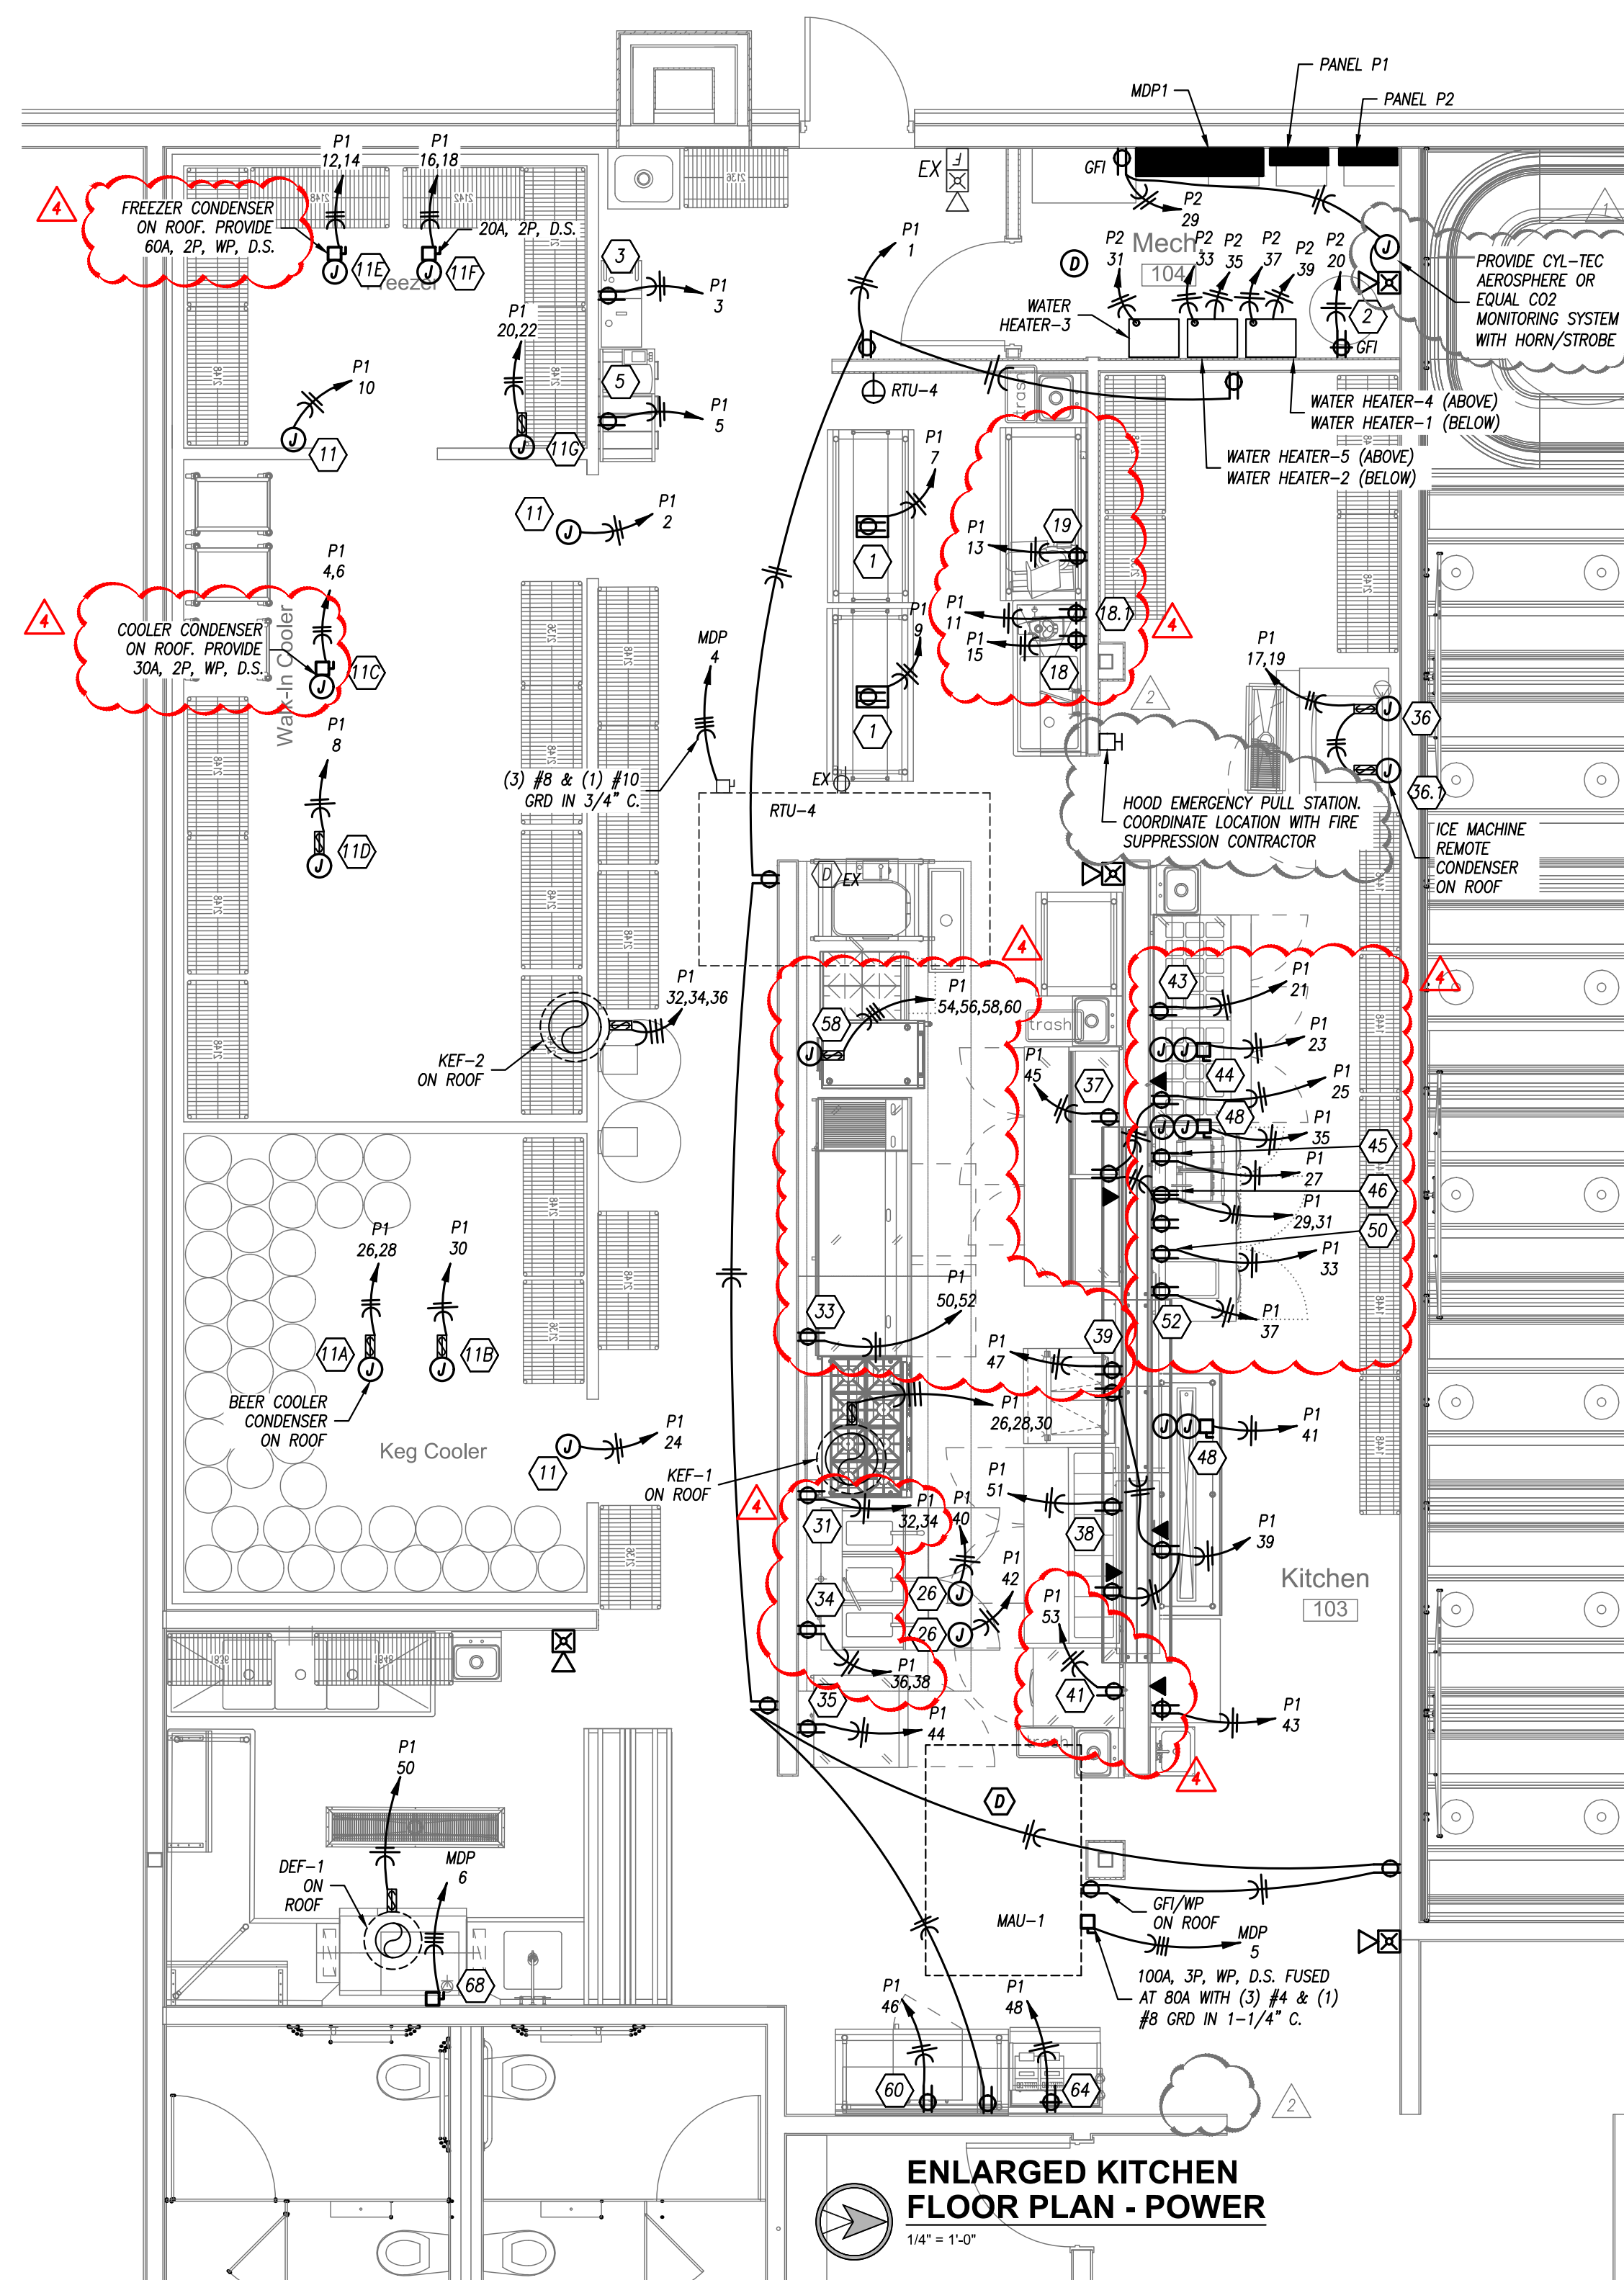

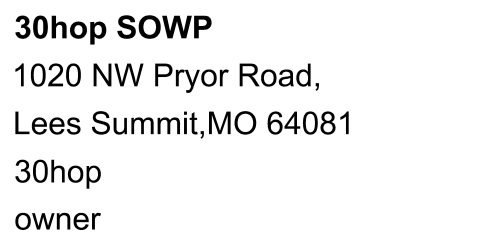

orientation

project number 232882

scale	As Noted
-------	----------

date 7/23/2024

sheet title Panelboard Schedules

sheet number

L502

PANELBOARD SIZING LOAD				CONNECTED PHASE LOADS		
LOAD DESCRIPTION	CONNECTED	DEMAND	CODE MIN. (VA)	PHASE	VA	AMPS
LIGHTS	4,520	1.25	5,650	A	11,640	96.9
RECEPTACLES	11,460	10KVA + 50% REST	10,730	B	8,600	71.6
MOTORS	7,910	<i>*LARGEST % SUM OF REC</i>	8,833	C	10,070	83.9
AIR CONDITIONING	0	1.00	0	TOTALS	30,310	84.1
SPACE HEATING	0	0.00	0			
HEAT PUMP	0	1.00	0			
CONTINUOUS	0	1.25	0			
NON-CONTINUOUS	6,420	1.00	6,420			
MISC. LOADS 1	0	1.00	0			
SIZING LOAD:			31,633			
SIZING LOAD (AMPS):			88			

PANELBOARD SIZING LOAD				CONNECTED PHASE LOADS		
LOAD DESCRIPTION	CONNECTED	DEMAND	CODE MIN. (VA)	PHASE	VA	AMPS
LIGHTS	0	1.25	0	A	22,880	190.5
RECEPTACLES	2,520	10KVA + 50% REST	2,520	B	23,080	192.2
MOTORS	0	<i>* (LARGEST + SUM OF RES)</i>		C	32,440	270.1
AIR CONDITIONING	0	1.00	0	TOTALS	78,400	217.6
SPACE HEATING	0	0.00	0			
HEAT PUMP	0	1.00	0			
CONTINUOUS	0	1.25	0			
NON-CONTINUOUS	36,660	1.00	36,660			
MISC. LOADS 1	0	1.00	0			
SIZING LOAD:			64,673			
SIZING LOAD (AMPS):			180			

PANEL DESIGNATION: P3				CIRCUIT #	MAIN LUG AMPS: 400				SCCR RATING (AIC): 22,000			
MOUNTING: SURFACE					MAIN BREAKER: M.L.O.				VOLTAGE: 208/120			
LOCATION: CORRIDOR					PHASE/WIRE: 3Ø, 4W							
DESCRIPTION		PHASE			C/B		C/B		PHASE		DESCRIPTION	
	A	B	C	TRIP	POLE			A	B	C		
ELECTRIC HEATER	1730			20	2	1	2	2	20	1730	ELECTRIC HEATER	
-		1730		-	-	3	4	-	-	1730	-	
ELECTRIC HEATER			1730	20	2	5	6	2	20		1730	
-	1730			-	-	7	8	-	-	1730	-	
ELECTRIC HEATER		1730		20	2	9	10	2	20		1730	
-			1730	-	-	11	12	-	-		1730	
ELECTRIC HEATER	1730			20	2	13	14	2	20	1730	ELECTRIC HEATER	
-		1730		-	-	15	16	-	-	1730	-	
ELECTRIC HEATER			1730	20	2	17	18	2	20		1730	
-	1730			-	-	19	20	-	-	1730	-	
ELECTRIC HEATER		1730		20	2	21	22	2	20		1730	
-			1730	-	-	23	24	-	-		1730	
ELECTRIC HEATER	1730			20	2	25	26	2	20	1730	ELECTRIC HEATER	
-		1730		-	-	27	28	-	-	1730	-	
ELECTRIC HEATER			1730	20	2	29	30	2	20		1730	
-	1730			-	-	31	32	-	-	1730	-	
ELECTRIC HEATER		1730		20	2	33	34	2	20		1730	
-			1730	-	-	35	36	-	-		1730	
ELECTRIC HEATER	1730			20	2	37	38	2	20	1730	ELECTRIC HEATER	
-		1730		-	-	39	40	-	-	1730	-	
ELECTRIC HEATER			1730	20	2	41	42	2	20		1730	
-	1730			-	-	43	44	-	-	1730	-	
ELECTRIC HEATER		1730		20	2	45	46	2	20		1730	
-			1730	-	-	47	48	-	-		1730	
ELECTRIC HEATER	1730			20	2	49	50	2	20	1730	ELECTRIC HEATER	
-		1730		-	-	51	52	-	-		-	
ELECTRIC HEATER			1730	20	2	53	54	2	20		1730	
-	1730			-	-	55	56	-	-	1730	-	
SPACE		-	-	-	1	57	58	1	-		SPACE	
SPACE			-	-	1	59	60	1	-		SPACE	
TOTALS	17300	15570	15570							17300	15570	TOTALS

PANELBOARD SIZING LOAD			
LOAD DESCRIPTION	CONNECTED	DEMAND	CODE MIN. (VA)
LIGHTS	0	1.25	0
RECEPTACLES	0	10KVA + 50% REST	0
MOTORS	0	<i>* LARGEST * SUM OF REMAINING</i>	0
AIR CONDITIONING	0	0.00	0
SPACE HEATING	96,880	1.00	96,880
HEAT PUMP	0	1.00	0
CONTINUOUS	0	1.25	0
NON-CONTINUOUS	0	1.00	0
MISC. LOADS 1	0	1.00	0
SIZING LOAD:			96,880
SIZING LOAD (AMPS):			269

CONNECTED PHASE LOADS		
PHASE	VA	AMPS
A	34,600	288.1
B	31,140	259.3
C	31,140	259.3
TOTALS	96,880	268.9

REMARKS:
1. EATON POW-R-LINE 2X OR EQUAL