

NICET LEVEL IV CERT. #129883
FIRE PROTECTION ENGINEERING
TECHNOLOGY - FIRE ALARM SYSTEMS



SWC OF KANSAS CITY
3241 NORTH 7TH ST.
KANSAS CITY, KS 66115

[illegible]


WILSHIRE HILLS III
AREA OF RESCUE

ENGINEERED BY:	PROJECT #:
SWC OF ATLANTA	191240913
DRAWN BY:	ET BID ID:
C. TOWNSEND	61628
REVIEWED BY:	PROJECT MANAGER:
K. WELLS	JASON LOAR
REFERENCE DRAWING:	ASBUILT SUBMITTED BY:
2001 POWER PLAN	

NE MANHATTAN DR.
EES SUMMIT, MO 64064

AREA OF RESCUE
FIRST FLOOR PLAN

REFERENCE
NUMBER
AOR2.1
SHEET 2 OF 4

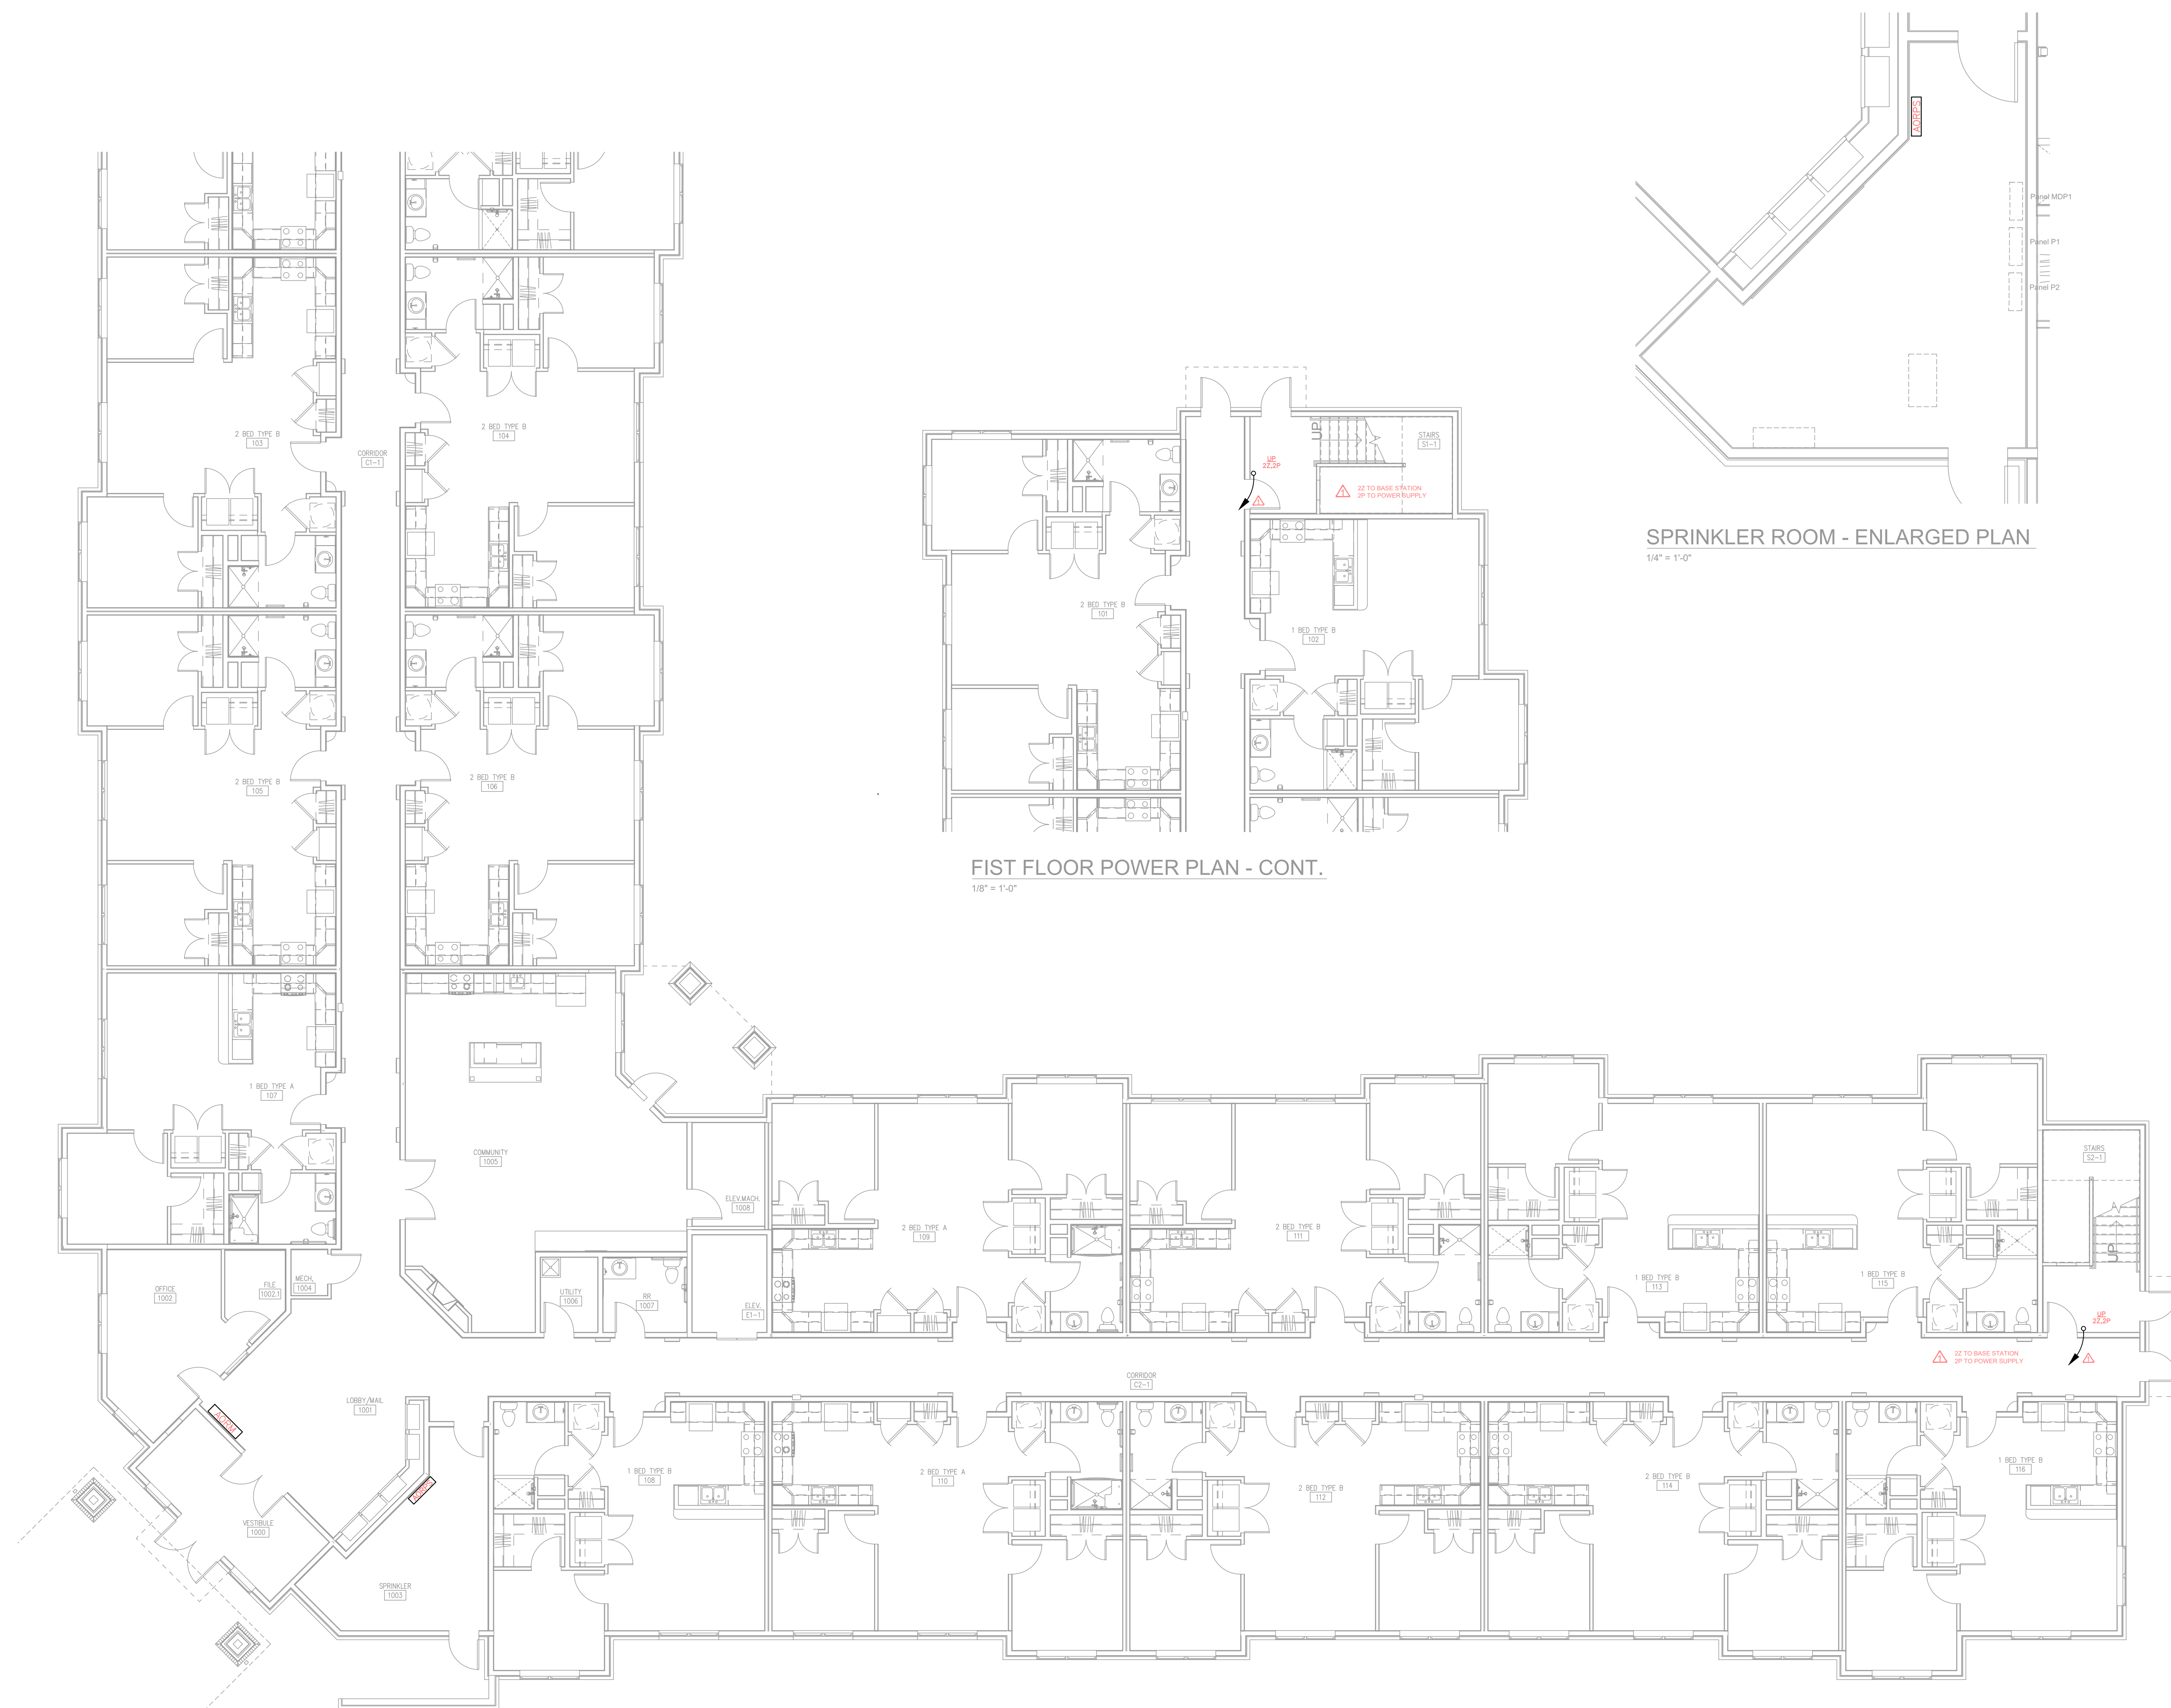

 FIRST FLOOR POWER PLAN
1/8" = 1'-0"

12/6/2024




BC ENGINEERS
INCORPORATED

5720 Reeder Shawnee, Ks. 66203 (913)262-1772

S:\B-Projects\KC88\Wilshire Hills III_FACILITY\191240913 Wilshire Hills AOR Second Floor Drawing.dwg
PRINTED BY: CHUCK TOWNSEND

4
3
2
1

A B C D E

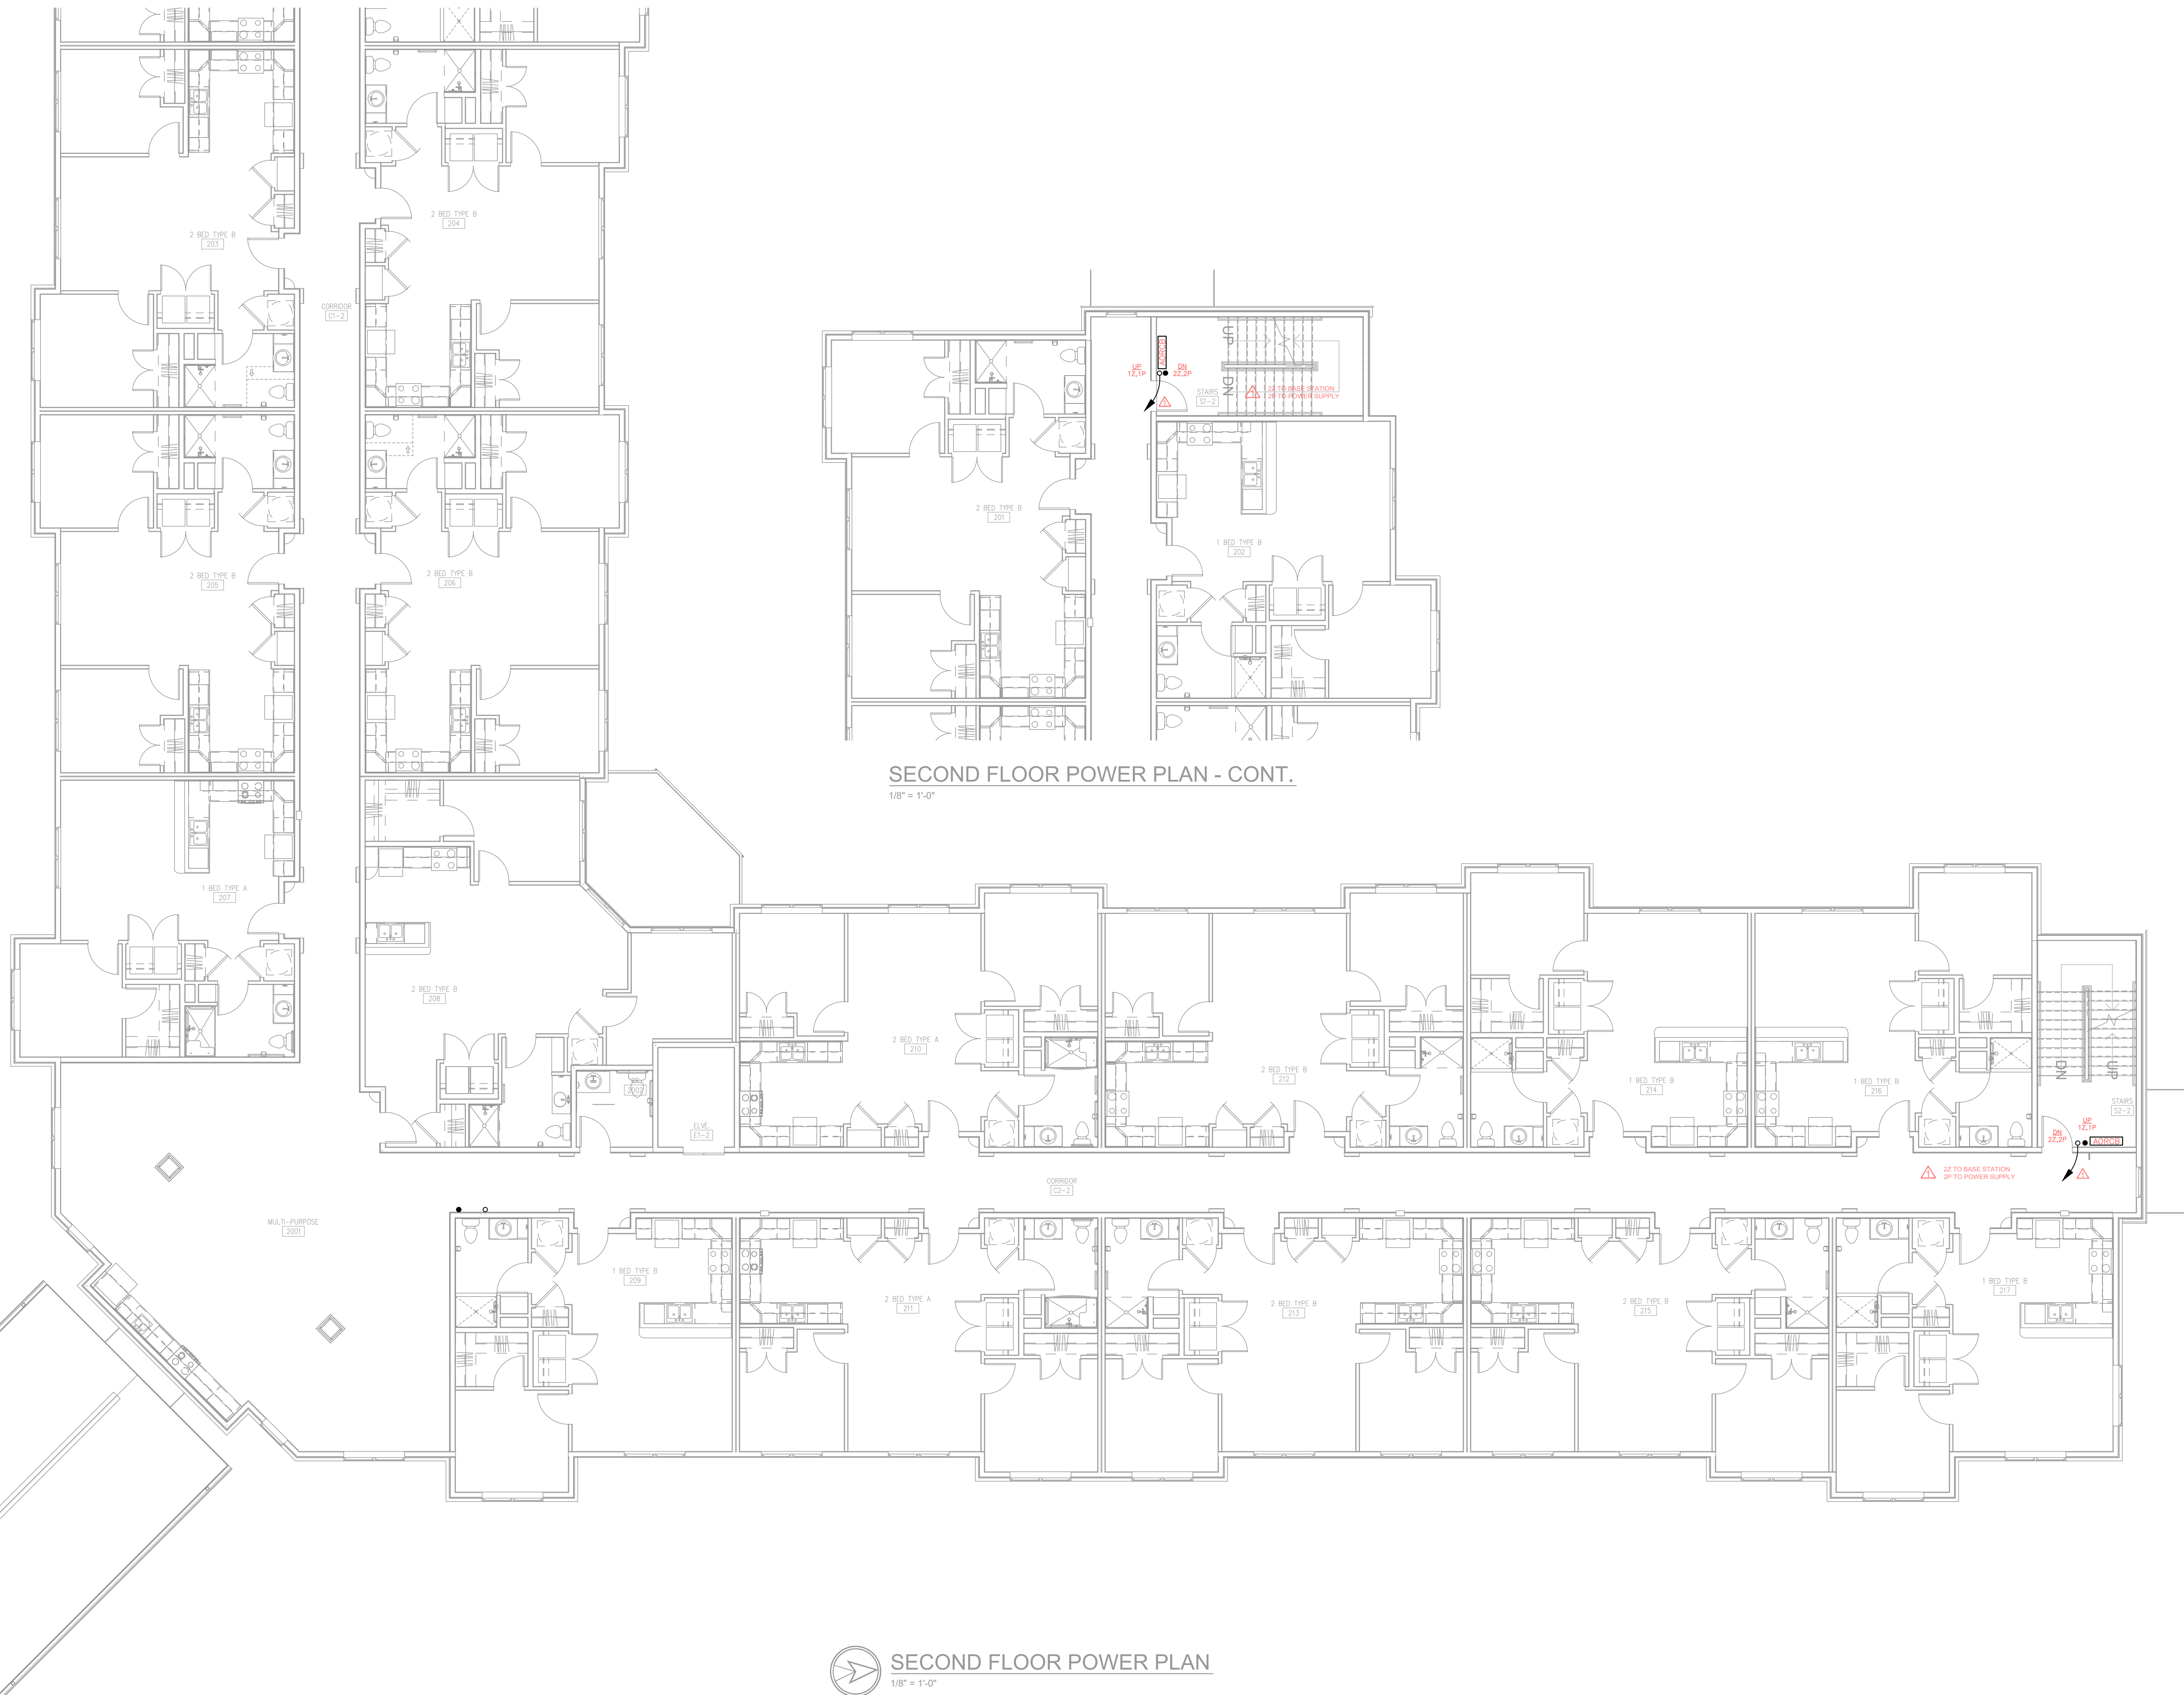

SECOND FLOOR POWER PLAN
1/8" = 1'-0"

Signature: *Charles Townsend*
EXP Date: Charles Townsend
NICET LEVEL IV CERT. #129883
FIRE PROTECTION ENGINEERING
TECHNOLOGY - FIRE ALARM SYSTEMS

12/6/2024
DARIN T. SEIDEL
REGISTERED PROFESSIONAL ENGINEER
STATE OF MISSOURI
NUMBER PE-0009631

BC ENGINEERS INCORPORATED
5720 Reeder Shawnee, Ks. 66203 (913)262-1772

SOUTH WESTERN COMMUNICATIONS
WWW.SWC.NET
SWC OF KANSAS CITY
3241 NORTH 7TH ST.
KANSAS CITY, KS 66115

SYMBOL	REVI	DESCRIPTION	DATE
1			

WILSHIRE HILLS III
AREA OF RESCUE

ENGINEERED BY: PROJECT #:
SVC OF ATLANTA 191240913
DRAWN BY: ET BID ID:
C. TOWNSEND 61628
REVIEWED BY: PROJECT MANAGER
K. WELLS JASON LOAR
REFERENCE DRAWING: JASBUILT SUBMITTED BY:
E202 POWER PLAN ...

NE MANHATTAN DR.
LEES SUMMIT, MO 64064
AREA OF RESCUE
SECOND FLOOR PLAN

REFERENCE NUMBER
AOR2.2
SHEET 3 OF 4


4
3
2
1

S:\B-Projects\KC88\Wilshire Hills III_FACILITY\191240913 Wilshire Hills AOR Third Floor Drawing.dwg
PRINTED BY: CHUCK TOWNSEND



THIRD FLOOR POWER PLAN
1/8" = 1'-0"

Signature: *Charles Townsend*
EXP Date: Charles Townsend
NICET LEVEL IV CERT. #129883
FIRE PROTECTION ENGINEERING
TECHNOLOGY - FIRE ALARM SYSTEMS

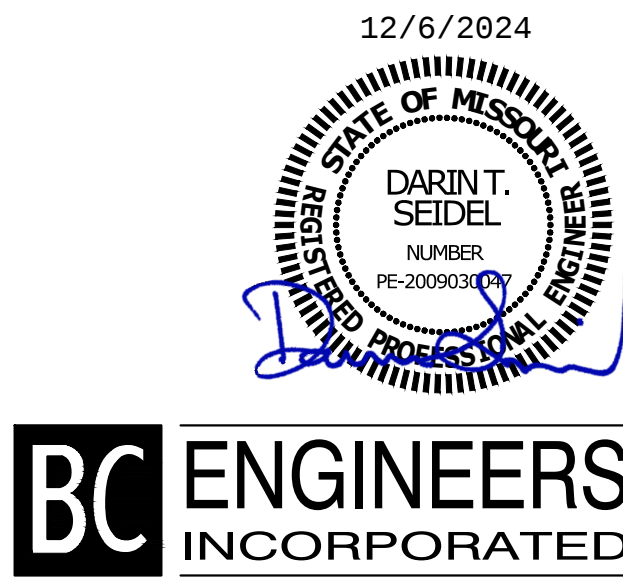

BC ENGINEERS
INCORPORATED
5720 Reeder Shawnee, KS, 66203 (913)262-1772

WILSHIRE HILLS III AREA OF RESCUE

ENGINEERED BY: PROJECT #:
SVC OF ATLANTA 191240913
DRAWN BY: ET BID ID:
C. TOWNSEND 61628
REVIEWED BY: PROJECT MANAGER
K. WELLS JASON LOAR
REFERENCE DRAWING: ASSAULT SUBMITTED BY:
E203 POWER PLAN ...

NE MANHATTAN DR.
LEES SUMMIT, MO 64064
AREA OF RESCUE
THIRD FLOOR PLAN

REFERENCE
NUMBER:
AOR2.3
SHEET 4 OF 4

SOUTH WESTERN COMMUNICATIONS
WWW.SWC.NET
SWC OF KANSAS CITY
3241 NORTH 7TH ST.
KANSAS CITY, KS 66115

SYMBOL	REVI	DESCRIPTION	DATE
1			