


11/20/2024 8:38:31 AM

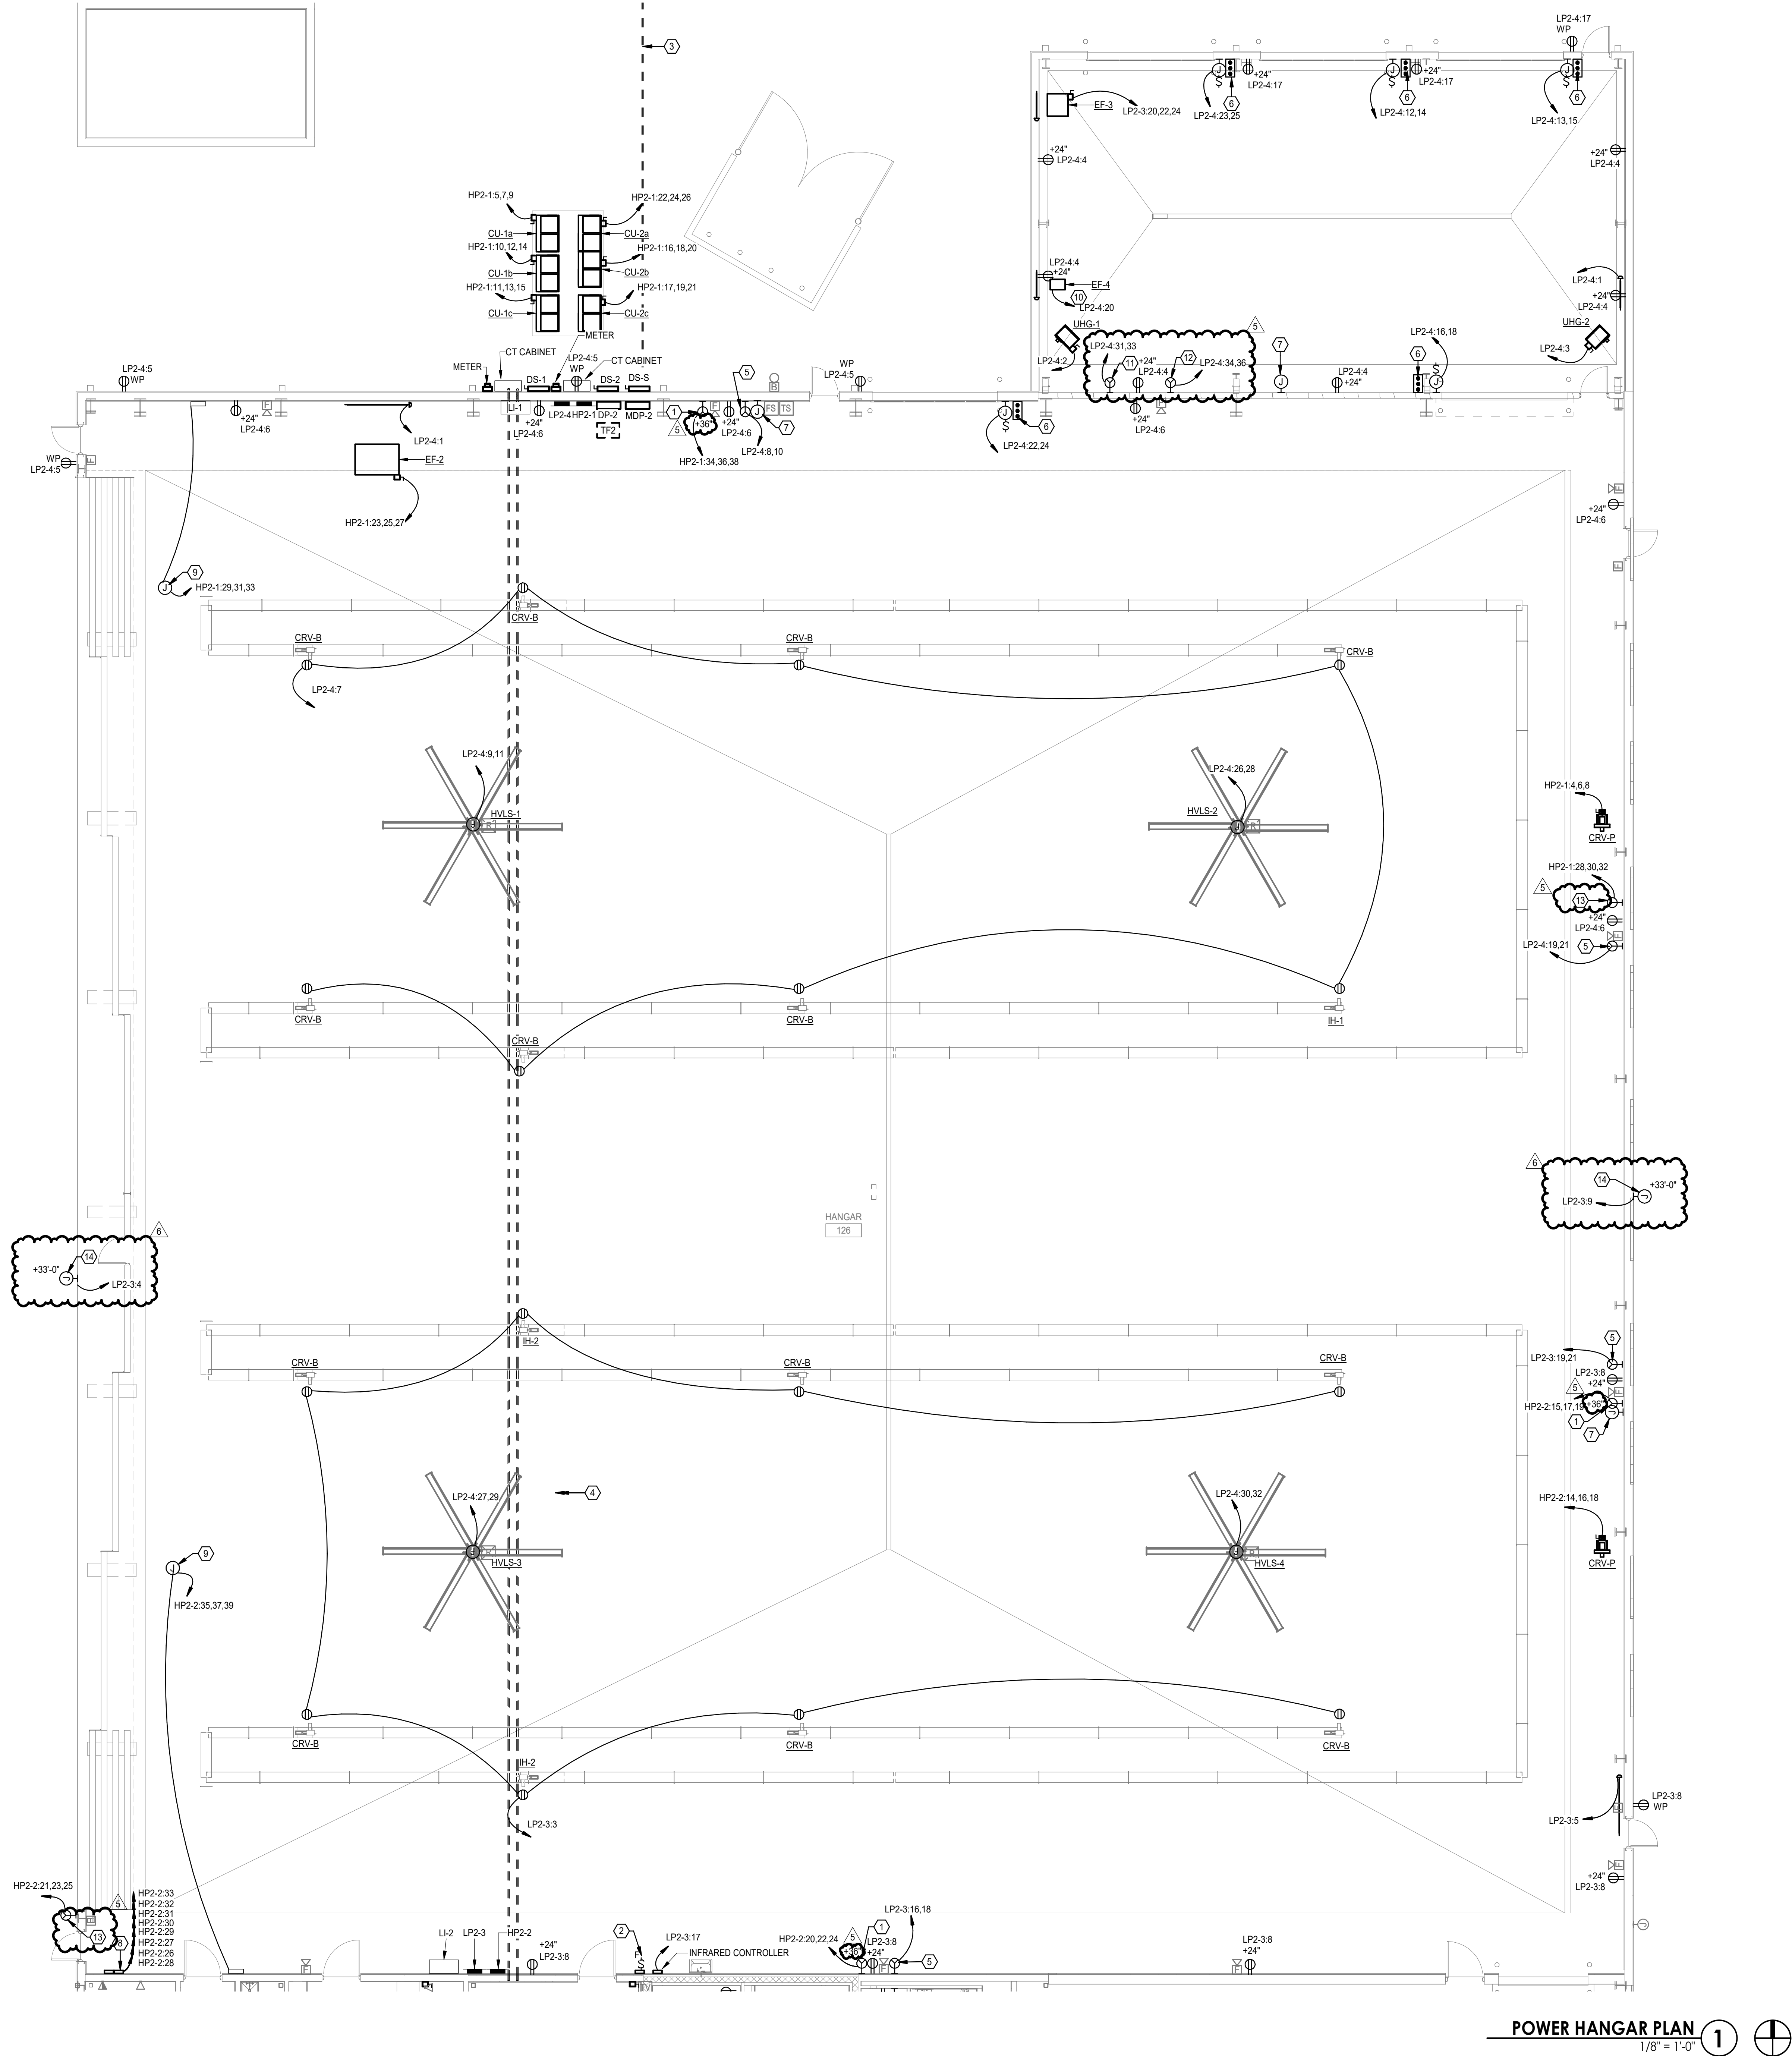

- ### ELECTRICAL KEYNOTES
1. PROVIDE KILLARK RECEPTACLE VR1041ES OR VR1044ES FOR OWNER PROVIDED GROUND POWER UNIT GPU. REFER TO MANUFACTURER MANUAL FOR EXACT REQUIREMENTS. PROVIDE (3) #2 AND (1) #8 GROUND IN 1-1/4" CONDUIT.
 2. ROUTE CIRCUIT FOR CEILING FANS THROUGHOUT CONTROL KEYPAD.
 3. SECONDARY FEEDER ROUTED BELOW GRADE FROM UTILITY TRANSFORMER. REFER TO ONE-LINE DIAGRAM FOR ADDITIONAL INFORMATION.
 4. FEEDER ROUTED BELOW FROM SERVICE ENTRANCE. REFER TO ONE-LINE DIAGRAM FOR ADDITIONAL INFORMATION.
 5. PROVIDE NEMA 6-30R RECEPTACLE FOR OWNER PROVIDED EQUIPMENT. COORDINATE WITH MANUFACTURER FOR EXACT REQUIREMENTS. PROVIDE (2) #10 AND (1) #10 GROUND IN 0.75" CONDUIT. MOUNT RECEPTACLE AT 24" A.F.F.
 6. PROVIDE START/STOP PUSH BUTTON FOR COILING OVERHEAD DOOR PER MANUFACTURER REQUIREMENT.
 7. PROVIDE BACK BOX AND 1-1/4" CONDUIT ROUGH-IN FOR OWNER PROVIDED EQUIPMENT. ROUTE EMPTY CONDUIT WITH PULL STRINGS TO NEAREST 208V PANELBOARD.
 8. PROVIDE CIRCUITS FOR SNOW MELT RELAY PANEL. REFER TO MANUFACTURER FOR ADDITIONAL INFORMATION.
 9. PROVIDE (3) #10 AND (1) #10 GROUND IN 3/4" CONDUIT FOR HANGER DOOR MOTORS. PROVIDE ADDITIONAL POWER CONNECTIONS TO EACH MOTOR LOCATION PER MANUFACTURER REQUIREMENT. ROUTE LOW VOLTAGE CABLES TO CONTROLLER.
 10. ROUTE 120V POWER TO HYDROGEN GAS DETECTOR FOR EXHAUST FAN CONTROL. REFER TO MECHANICAL PLANS AND MANUFACTURER DETAILS FOR ADDITIONAL INFORMATION.
 11. PROVIDE KILLARK RECEPTACLE VR641E3 OR VR644E4 FOR OWNER PROVIDED TUG WELDER. REFER TO MANUFACTURER MANUAL FOR EXACT REQUIREMENTS. PROVIDE (3) #6 AND (1) #10 GROUND IN 1" CONDUIT. MOUNT AT 36" A.F.F.
 12. PROVIDE KILLARK RECEPTACLE VR1041ES OR VR1044ES FOR OWNER PROVIDED TUG WELDER. REFER TO MANUFACTURER MANUAL FOR EXACT REQUIREMENTS. PROVIDE (3) #2 AND (1) #8 GROUND IN 1-1/4" CONDUIT. MOUNT AT 36" A.F.F.
 13. PROVIDE KILLARK RECEPTACLE VR641E3 OR VR644E4 FOR OWNER PROVIDED GROUND POWER UNIT GPU. REFER TO MANUFACTURER MANUAL FOR EXACT REQUIREMENTS. PROVIDE (3) #4 AND (1) #8 GROUND IN 1-1/4" CONDUIT. MOUNT AT 36" A.F.F.
 14. PROVIDE POWER ROUGH-IN FOR SIGN LIGHTING.



1627 MAIN STREET, SUITE 600
KANSAS CITY, MO 64108




1627 MAIN STREET, SUITE 100
KANSAS CITY, MO 64108



1301 BURLINGTON STREET
NORTH KANSAS CITY, MO 64116

LEE'S SUMMIT MUNICIPAL AIRPORT
LEE'S SUMMIT, MISSOURI
EASTSIDE DEVELOPMENT
CITY PROJECT NO. - 47732472

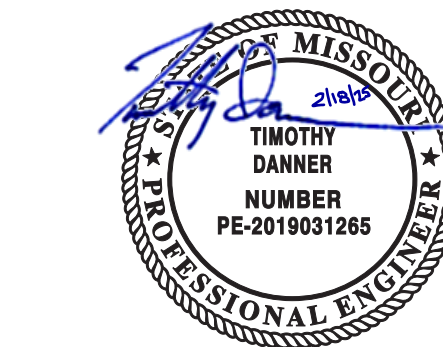

03-29-2024

LEES SUMMIT MUNICIPAL AIRPORT AUTHORITY
LEES SUMMIT, MO

6	11/8/24	PR-07
5	8/7/24	PR-06

MARK DATE DESCRIPTION

PROJECT NO: 022-04268
CAD DWG FILE: Lee's Summit - Hangar 2.rvt
DESIGNED BY: SH
DRAWN BY: OH
CHECKED BY: AF
APPROVED BY: TWO
COPYRIGHT 2023


SHEET TITLE
POWER HANGAR PLAN

E202


SHEET OF

POWER HANGAR PLAN 1
1/8" = 1'-0"

8/21/2024 10:31:05 AM

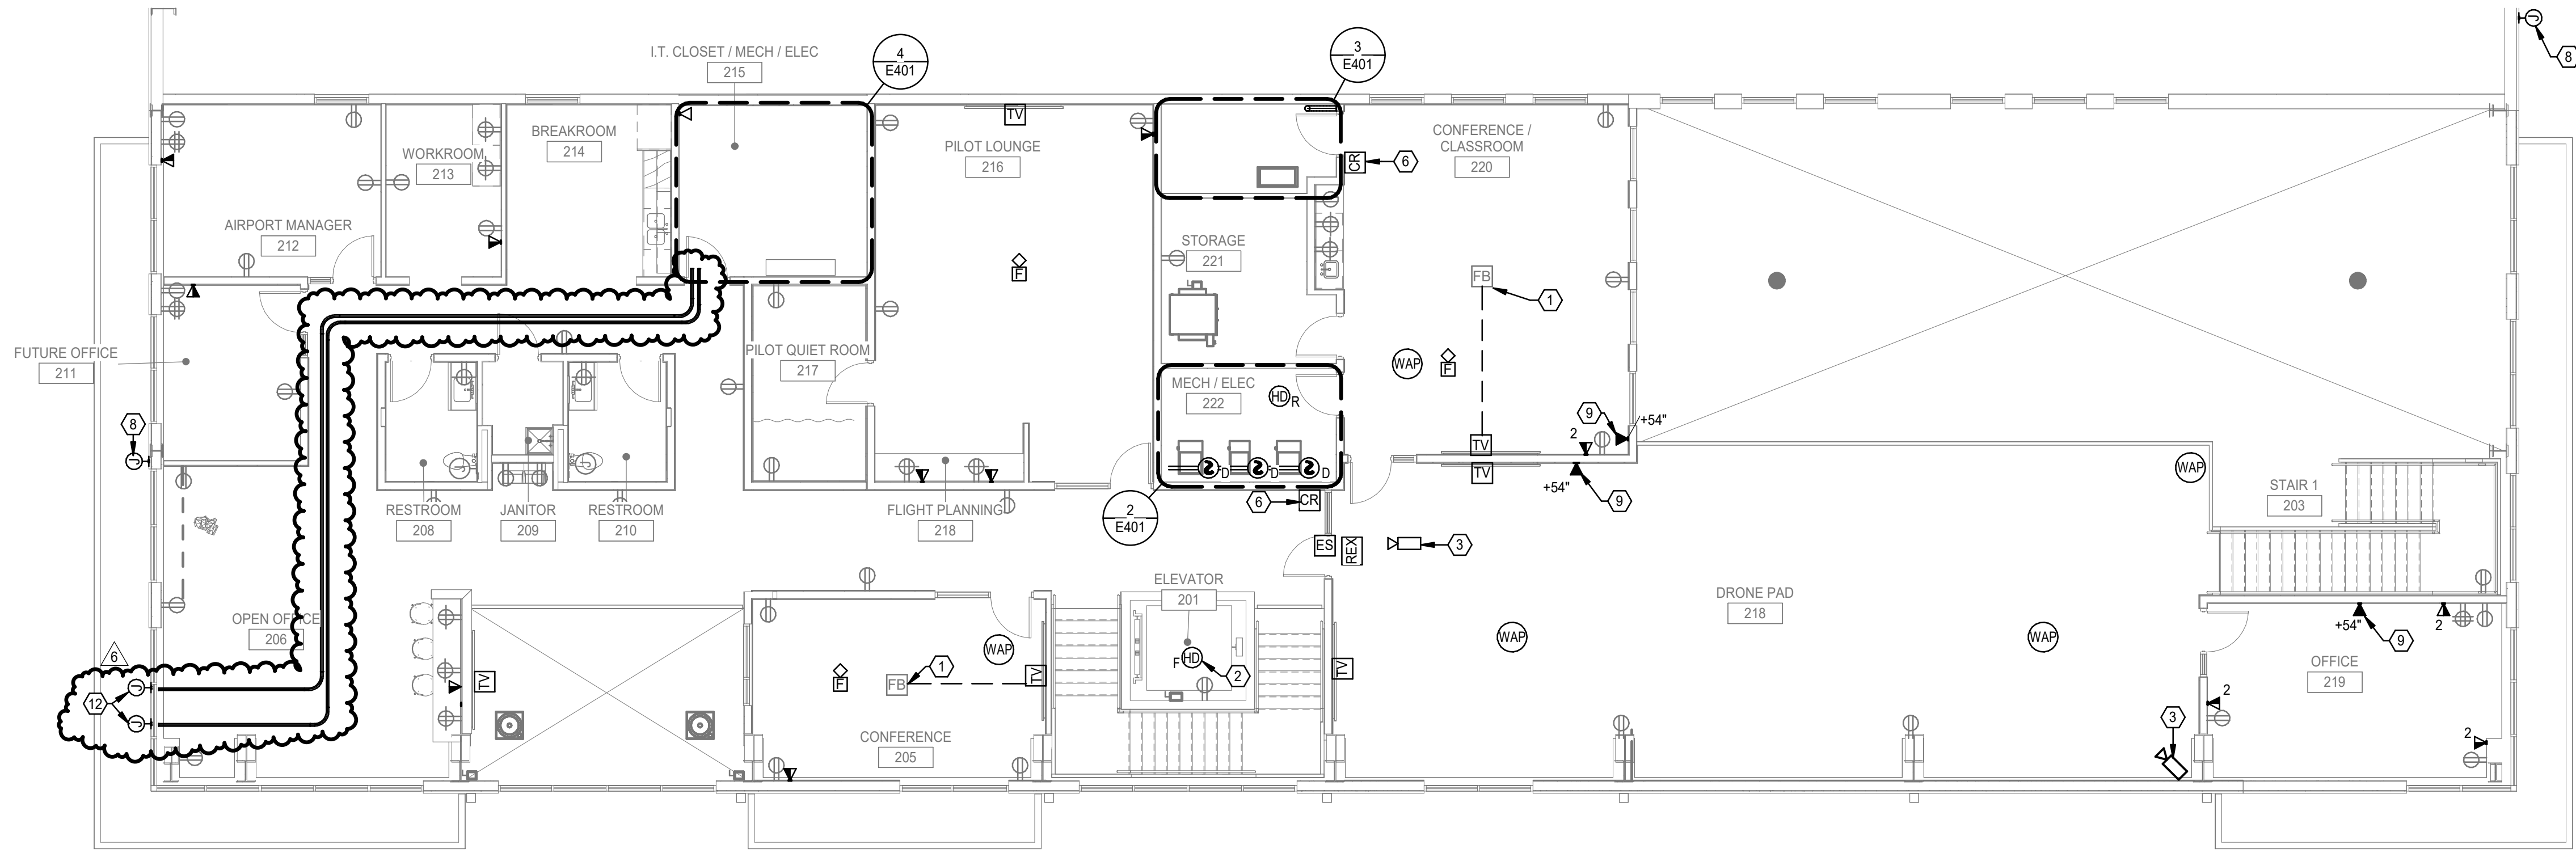

SYSTEMS SECOND FLOOR PLAN 2 1/8" = 1'-0"

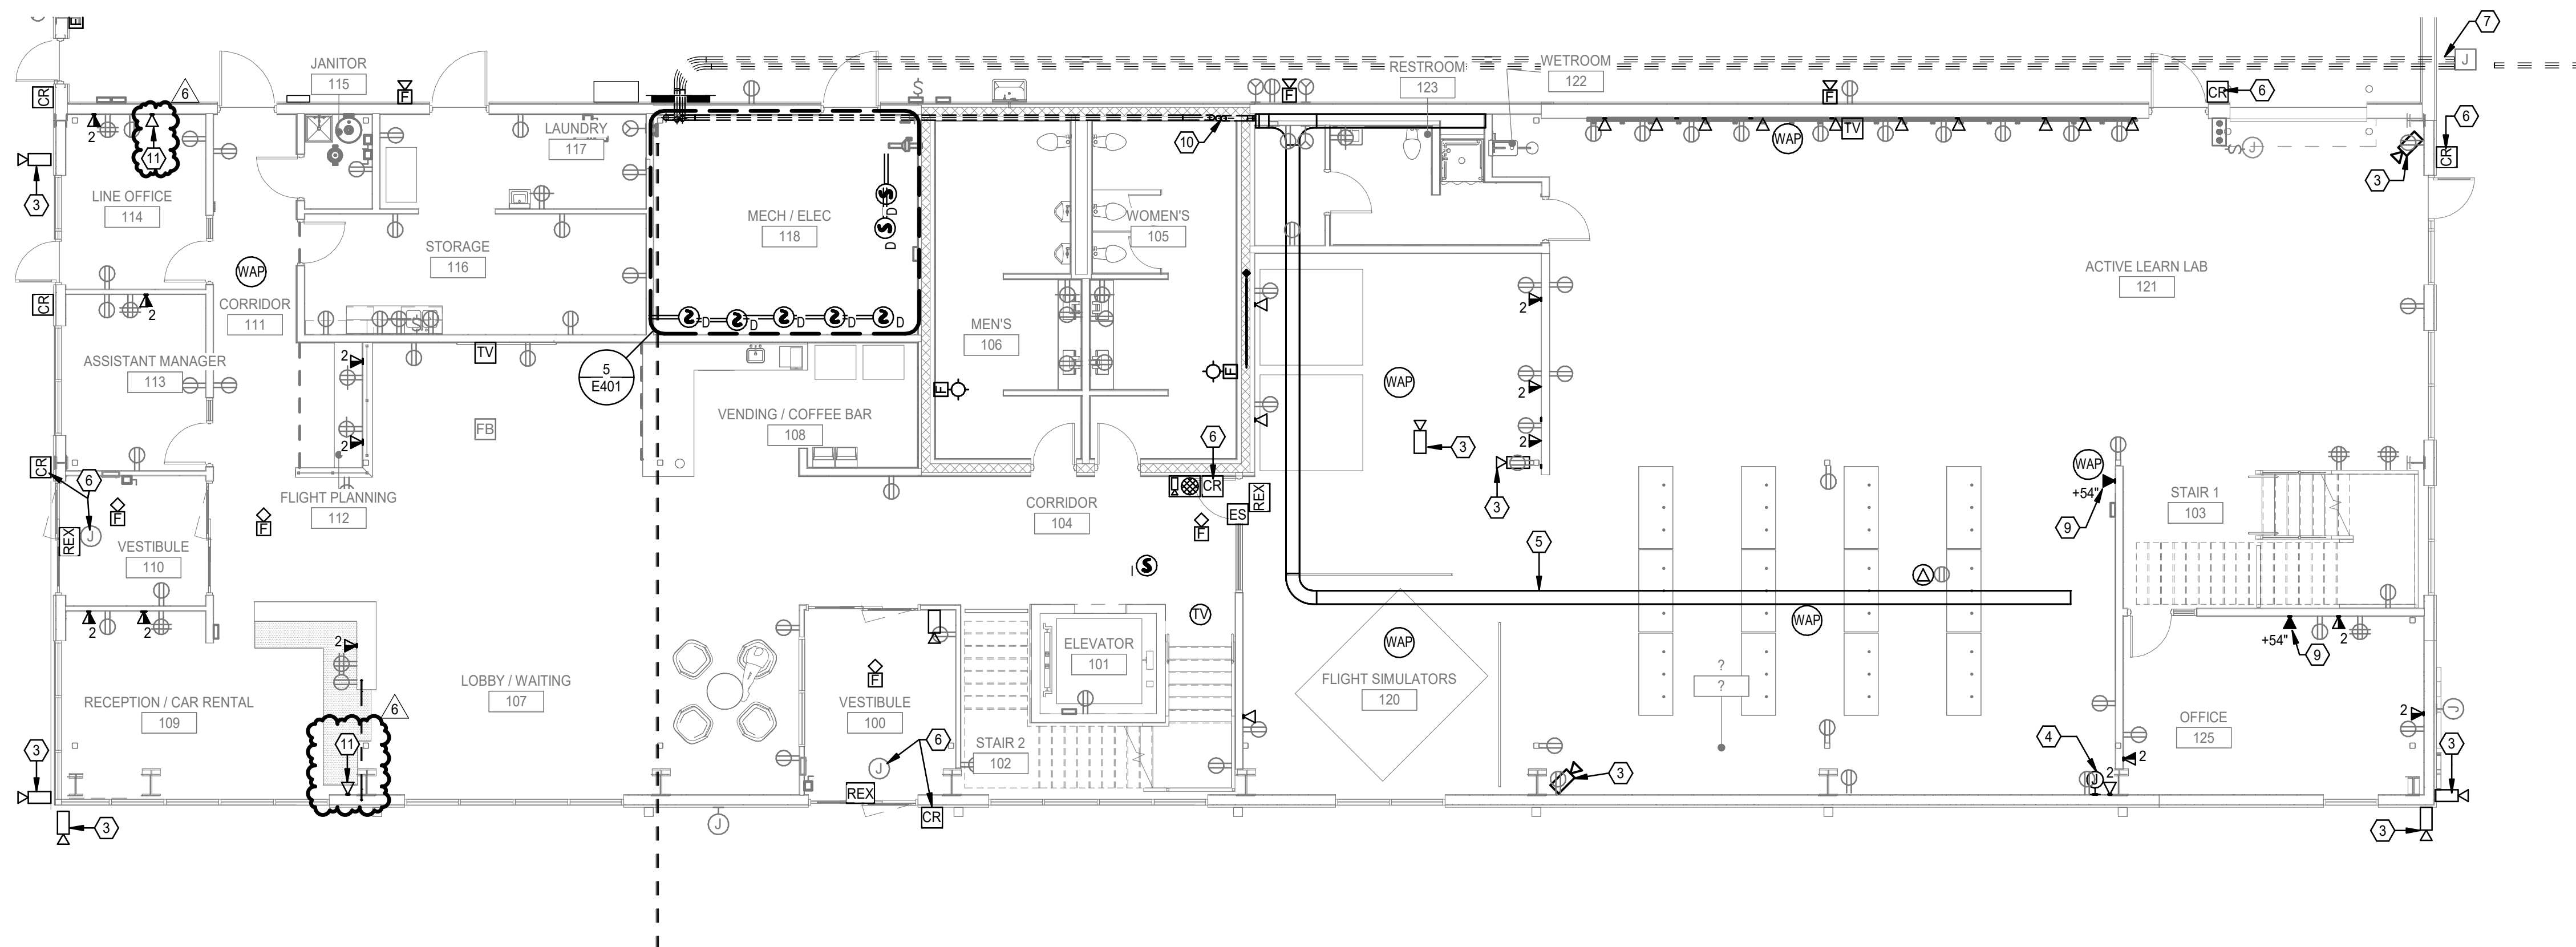

SYSTEMS FIRST FLOOR PLAN 1 1/8" = 1'-0"

GENERAL SHEET NOTES

- WHERE TELEDATA OUTLET SYMBOL IS SHOWN PROVIDE BACK BOX AND CONDUIT ROUGH IN TO ABOVE ACCESSIBLE CEILING. REFER TO COMMUNICATION ROUGH-IN DETAIL FOR ADDITIONAL INFORMATION.
- COORDINATE ALL TELECOMM DATA DEVICE LOCATION AND MOUNTING HEIGHTS WITH OWNER/ARCHITECT PRIOR TO INSTALLATION.
- PROVIDE TRACER WIRE WITH PULL STRINGS.

ELECTRICAL KEYNOTES

- PROVIDE 1-1/4" CONDUIT FROM FLOOR BOX/POKE-THRU TO TV OUTLET LOCATION FOR DATA AND AV CABLING.
- HEAT DETECTOR IN ELEVATOR SHAFT WITHIN 2FT OF SPRINKLER HEAD. REFER TO ELEVATOR INTERLOCK WITH FIRE ALARM DETAIL FOR ADDITIONAL INFORMATION. COORDINATE LOCATION WITH SPRINKLER PROVIDER.
- PROVIDE JUNCTION BOX AND 3/4" CONDUIT ROUGH IN FOR CAMERA. ROUTE CONDUIT BACK TO IT ROOM. COORDINATE EXACT LOCATION AND REQUIREMENTS WITH OWNER AND SECURITY PROVIDER. IN AREAS WITH NO ABOVE CEILING ROUTE CONDUIT HIGH AND TIGHT TO STRUCTURE ABOVE.
- PROVIDE BOX WITH 1-1/4" EMPTY CONDUIT WITH PULL STRINGS TO PROJECTOR OUTLET BOX.
- 2"X12" WIRE MESH CABLE TRAY ABOVE ACCESSIBLE CEILING.
- PROVIDE POWER ROUGH IN FOR CARD READER. REFER TO ACCESS CONTROL DETAIL FOR ADDITIONAL INFORMATION.
- (2)X4" EMPTY CONDUITS ROUTED BELOW GRADE FROM TELECOM JUNCTION BOX AND STUBBED UP IN ELECTRICAL ROOM. CAP CONDUITS WITH PULL STRINGS. COORDINATE EXACT LOCATION OF JUNCTION BOX WITH TELECOM SERVICE PROVIDER. PROVIDE TRACER WIRE WITH PULL STRINGS. ROUTE CONDUITS TO SERVICE PROVIDER DEMARC LOCATION. COORDINATE LOCATION WITH SERVICE PROVIDER.
- MOUNT SINGLE BOX AT 15'-0" A.F.G. WITH 1" CONDUIT WITH CAT 6A ROUTED WITHIN STRUCTURE FOR OWNER SUPPLIED EXTERIOR WIFI BOOSTER EQUAL TO CISCO CATALYST 8166 SERIES WITH BRACKET AND ARM. REFER TO MANUFACTURER FOR MOUNTING REQUIREMENTS. PROVIDE BLOCKING AS REQUIRED. COORDINATE EXACT LOCATION WITH OWNER AND ARCHITECT.
- PROVIDE DOUBLE GANGE BACK BOX WITH 4" LUG SPACING MATCHING PHONE HARDWARE. REFER TO PHONE MANUFACTURER FOR EXACT MOUNTING REQUIREMENTS.
- ROUTE (2)X4" EMPTY CONDUIT TO ABOVE CEILING ON FIRST FLOOR BELOW AND PROVIDE FIRE RATED PENETRATION THRU FIRE WALL. CONDUIT TO
- ROUTE (1)X1" EMPTY CONDUIT WITH PULL STRINGS TO ROOF FOR COAX CABLING TO ANTENNA. PROVIDE COAX OUTLET WHERE SHOWN. COORDINATE EXACT LOCATION AND REQUIREMENTS WITH OWNER.
- MOUNT SINGLE BOX AT +25'-0" A.F.G. WITH 1" CONDUIT ROUTED TO LOCATIONS SHOWN ON FIRST FLOOR FOR OWNER RELOCATED ANTENNA. PROVIDE BLOCKING AS REQUIRED. COORDINATE EXACT LOCATION WITH OWNER. PROVIDE GROUNDING PER NEC.



1627 MAIN STREET, SUITE 600
KANSAS CITY, MO 64108




1627 MAIN STREET, SUITE 100
KANSAS CITY, MO 64108



1301 BURLINGTON STREET
NORTH KANSAS CITY, MO 64116

LEE'S SUMMIT MUNICIPAL AIRPORT
LEE'S SUMMIT, MISSOURI

EASTSIDE DEVELOPMENT
CITY PROJECT NO. - 47732472

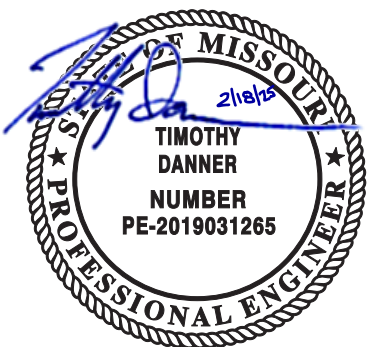

03-29-2024

LEES SUMMIT MUNICIPAL AIRPORT AUTHORITY
LEES SUMMIT, MO

8/23/24 PR-07
MARK DATE DESCRIPTION


PROJECT NO: 022-04268
CAD DWG FILE: Lee's Summit - Hangar 2.rvt
DESIGNED BY: SH
DRAWN BY: OH
CHECKED BY: AF
APPROVED BY: TWO
COPYRIGHT 2023

SHEET TITLE

SYSTEMS FLOOR
PLANS

E301


SHEET OF

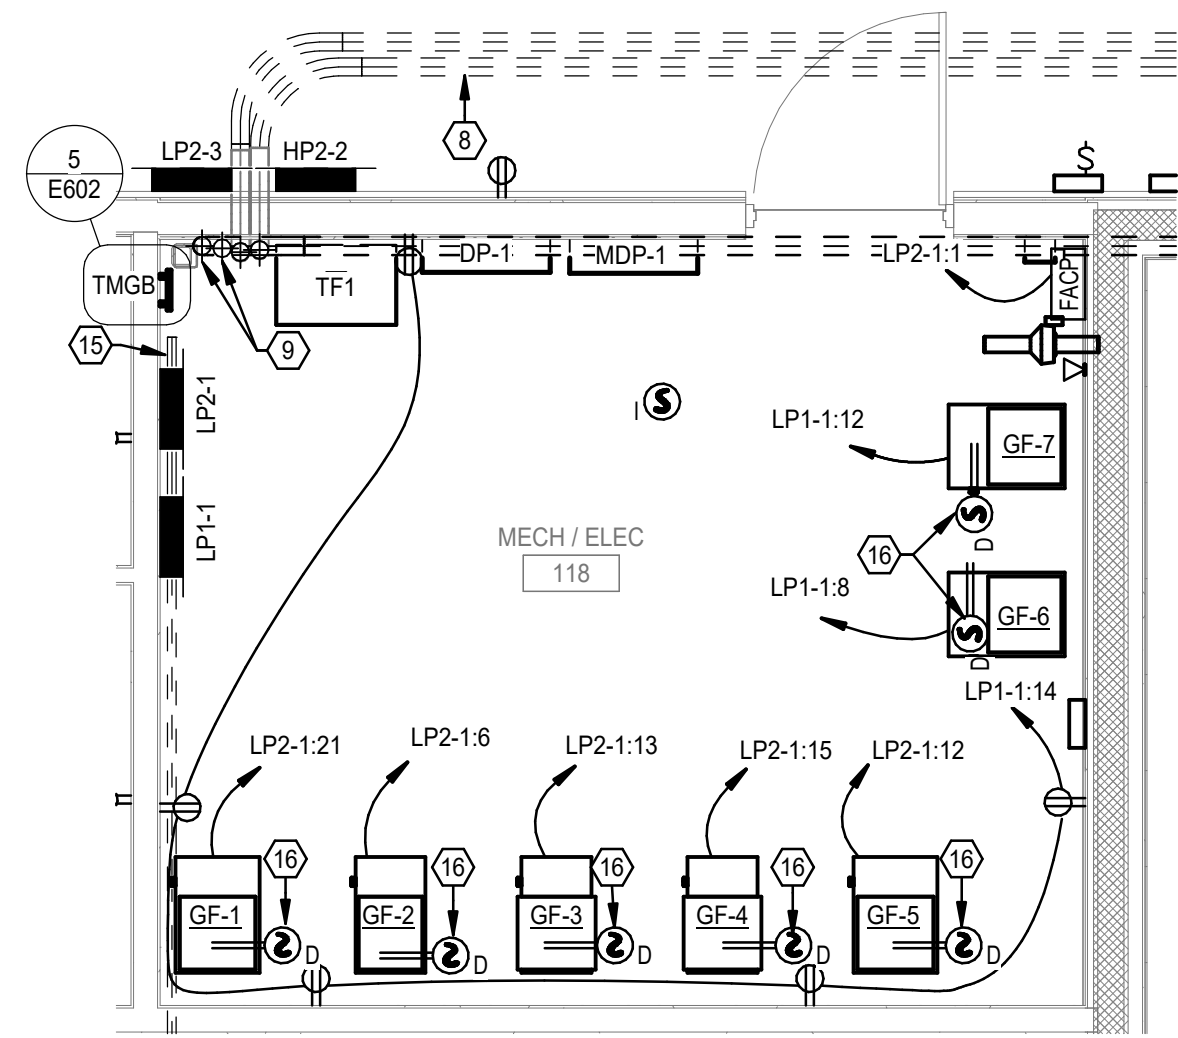

ENLARGED ELECTRICAL ROOM PLAN

1/4" = 1'-0"


5

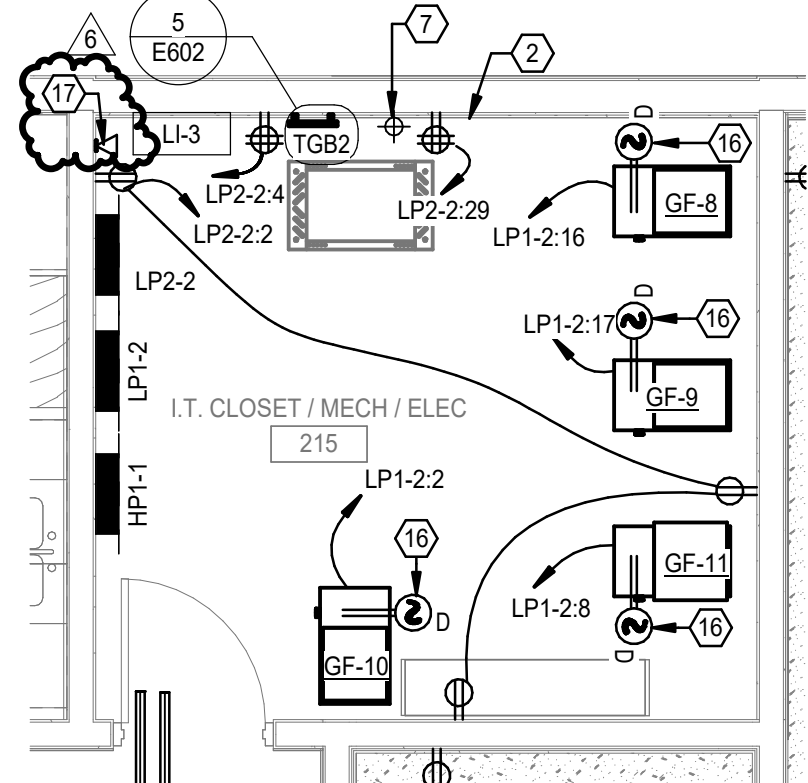

ENLARGED 2ND FLOOR PLAN

1/4" = 1'-0"


4

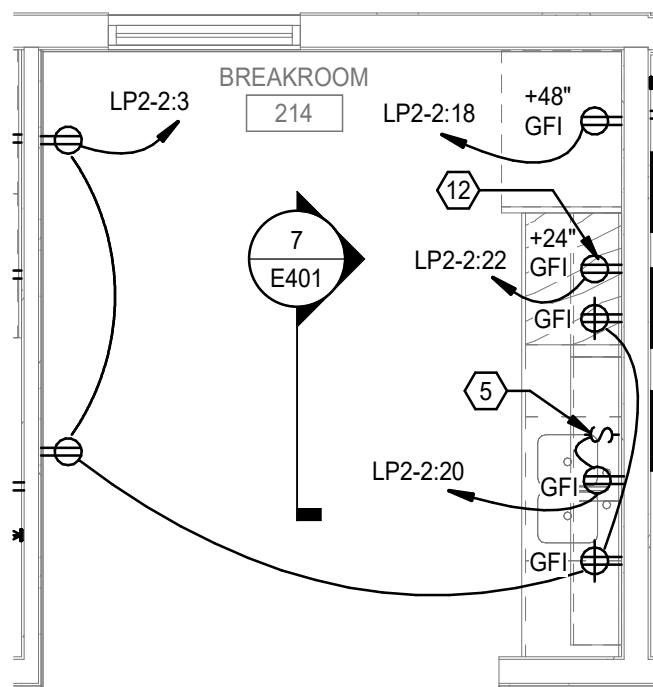

ENLARGED 2ND FLOOR BREAK ROOM

1/4" = 1'-0"


8

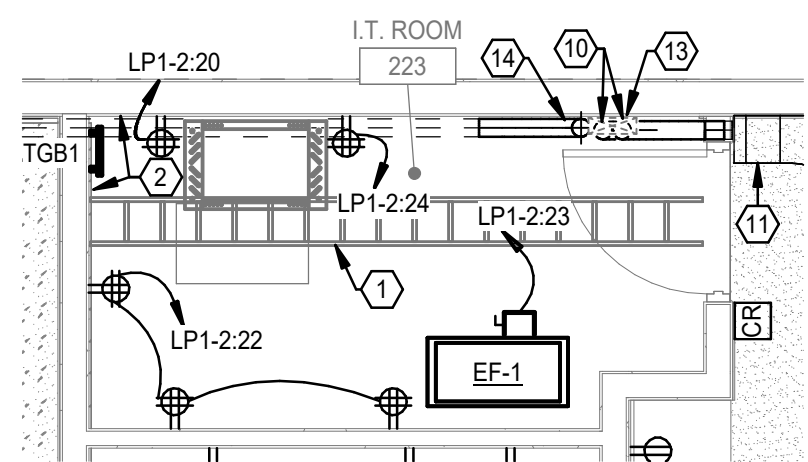

ENLARGED 2ND FLOOR IT ROOM

1/4" = 1'-0"


3

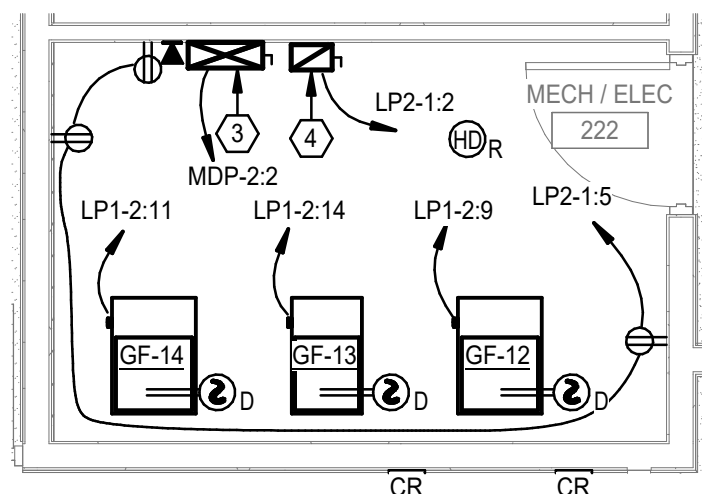

ENLARGED 2ND FLOOR MECH ROOM

1/4" = 1'-0"


2

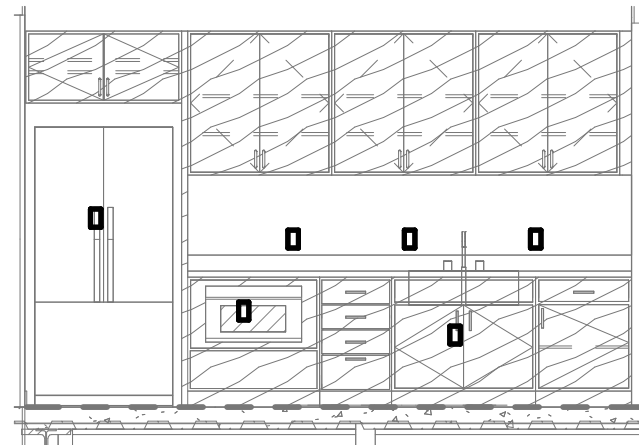

BREAK ROOM SECTION

NOT TO SCALE


7

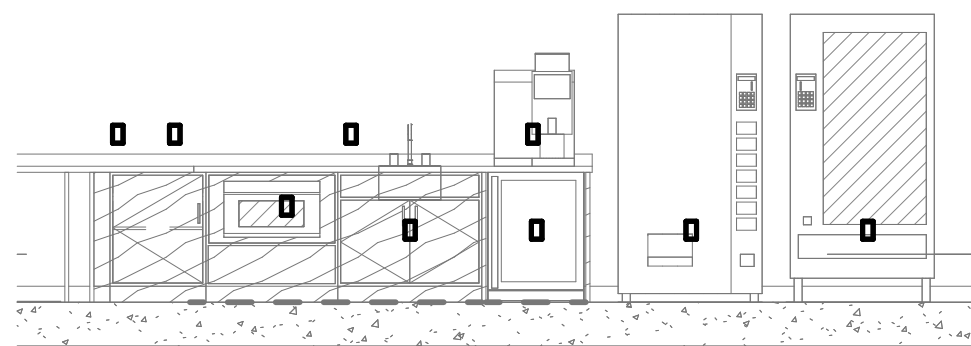

COFFEE BAR SECTION

NOT TO SCALE

6

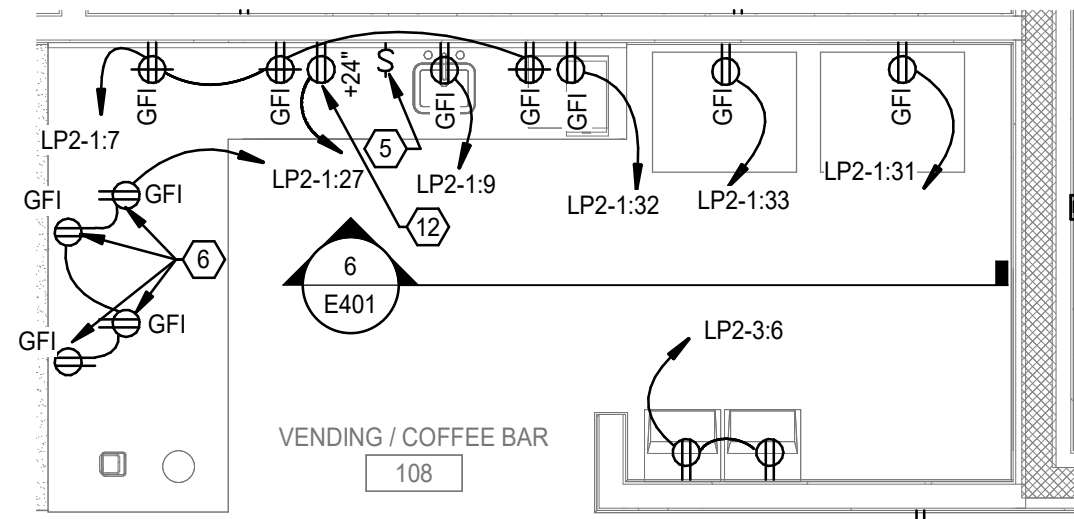

ENLARGED 1ST FLOOR BREAK ROOM

1/4" = 1'-0"

1

ELECTRICAL KEYNOTES

- 1 LADDER CABLE TRAY MOUNTED HIGH TO CEILING AND ON WALL.
- 2 5/8" FIRE RATED PLYWOOD PAINTED TO MATCH WALL. PROVIDE 96" TALL TO FULL WIDTH OF WALL SHEET.
- 3 PROVIDE A FUSED, HEAVY DUTY, LOCKABLE DISCONNECT POWER MODULE EQUAL TO BUSSMANN PS-1T48-R2-G-A WITH CLASS J FUSES. FIRE ALARM SYSTEM INTERFACE, GREEN PILOT LIGHT AND ALL NECESSARY INTERLOCKING CONTACTS. PROVIDE FINAL ELECTRICAL CONNECTION TO ELEVATOR CONTROLLER. COORDINATE EXACT REQUIREMENTS WITH ELEVATOR MANUFACTURER.
- 4 PROVIDE 20A, 120V, SINGLE POLE FUSED DISCONNECT SWITCH FOR ELEVATOR CAB LIGHTS. MOUNT AT +6'-0" A.F.F. PROVIDE FINAL ELECTRICAL CONNECTION TO ELEVATOR CONTROLLER. COORDINATE EXACT REQUIREMENTS WITH ELEVATOR MANUFACTURER. SWITCH SHALL BE CAPABLE OF BEING LOOKED "OFF".
- 5 ROUTE CIRCUIT FOR GARBAGE DISPOSAL OUTLET THROUGH TOGGLE SWITCH.
- 6 COORDINATE RECEPTACLE WITH CASEWORK.
- 7 4" EMPTY CONDUIT STUBBED UP AT 3' A.F.F. AND CAPPED WITH PULL STRINGS. ROUTED FROM FLOOR BELOW.
- 8 (2) 4" EMPTY CONDUITS STUBBED UP AT 3' A.F.F. AND CAPPED WITH PULL STRINGS. ROUTED FROM EXTERIOR BUILDING AND TERMINATED IN GRADE JUNCTION BOX. COORDINATE EXACT LOCATION WITH TELECOMMUNICATION PROVIDER.
- 9 4" EMPTY CONDUIT WITH PULL STRINGS ROUTED TO IT ROOM ON FLOOR ABOVE. PROVIDE FIRE RATED PENETRATION THRU FIRE WALL.
- 10 ROUTE (2) 4" EMPTY CONDUIT TO ABOVE CEILING ON FIRST FLOOR BELOW AND PROVIDE FIRE RATED PENETRATION THRU FIRE WALL. CONDUIT TO STUB OUT WALL TO CABLE TRAY ABOVE CEILING ON FIRST FLOOR.
- 11 WIRE MESH CABLE TRAY ABOVE CEILING ON FIRST FLOOR BELOW. REFER TO FIRST FLOOR SYSTEM PLAN FOR CONTINUATION.
- 12 COORDINATE MICROWAVE RECEPTACLE MOUNTING HEIGHT WITH CASEWORK.
- 13 VERTICAL LADDER TRAY FROM FLOOR TO 96".
- 14 4" EMPTY CONDUIT WITH PULL STRINGS ROUTED FROM ELECTRICAL ROOM ON FIRST FLOOR. PROVIDE FIRE RATED PENETRATION THRU FIRE WALL.
- 15 4" CONDUIT ROUTED BELOW GRADE FROM ELECTRICAL ROOM AND TERMINATED IN JUNCTION BOX FOR FUTURE TERMINAL BUILDING COMMUNICATION CABLE. PROVIDE EMPTY CONDUIT WITH PULL STRINGS.
- 16 PROVIDE DUCT MOUNTED SMOKE DETECTOR IN RETURN AIR DUCT.
- 17 ROUTE (1) 1" EMPTY CONDUIT WITH PULL STRINGS TO ROOF FOR COAX CABLEING TO ANTENNA. PROVIDE COAX OUTLET WHERE SHOWN. COORDINATE EXACT LOCATION AND REQUIREMENTS WITH OWNER.



1627 MAIN STREET, SUITE 600
KANSAS CITY, MO 64108




1627 MAIN STREET, SUITE 100
KANSAS CITY, MO 64108



1301 BURLINGTON STREET
NORTH KANSAS CITY, MO 64116

LEE'S SUMMIT MUNICIPAL AIRPORT
LEE'S SUMMIT, MISSOURI
EASTSIDE DEVELOPMENT
CITY PROJECT NO. - 47732472

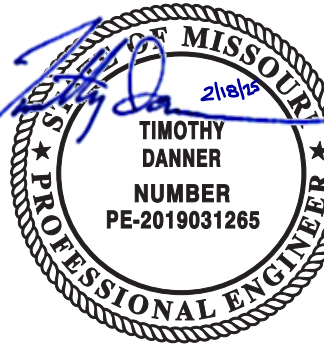

03-29-2024

LEES SUMMIT MUNICIPAL AIRPORT AUTHORITY
LEES SUMMIT, MO

8/23/24 PR-07
MARK DATE DESCRIPTION

PROJECT NO: 022-04268
CAD DWG FILE: Lee's Summit - Hangar 2.rvt
DESIGNED BY: SH
DRAWN BY: OH
CHECKED BY: AF
APPROVED BY: TWO
COPYRIGHT 2023

SHEET TITLE

ENLARGED PLANS

E401

SHEET OF

