

SUMMIT FAIR BLDG D

860 NW BLUE PARKWAY

LEE'S SUMMIT, MO 64086

RELEASED FOR CONSTRUCTION
As Noted on Plan Review

Lee's Summit Fire Department
Lee's Summit, Missouri

04/24/2025

MATRIX -

FIRE ALARM SYSTEM INPUT/OUTPUT MATRIX		SYSTEM OUTPUTS																											
		FACP ANNUNCIATION													NOTIFICATION							REQUIRED FIRE SAFETY CONTROL							
SYSTEM INPUTS		ACTIVATE COMMON FIRE ALARM INDICATOR ACTIVATE FIRE ALARM SIGNAL ACTIVATE COMMON SUPERVISORY SIGNAL ACTIVATE AMBULANCE SUPERVISORY SIGNAL ACTIVATE FIRE ALARM SIGNAL ACTIVATE FIRE																											

APPLICABLE BUILDING CODES:



2018 INTERNATIONAL BUILDING CODE
2018 INTERNATIONAL FIRE CODE
2016 NFPA 72

SCOPE OF WORK:

Adjust Fire Alarm System
for remodel area

Marmic Fire and Safety
4008 E 138th St,
Grandview, MO 64030

Marmic ST job number: #39067912

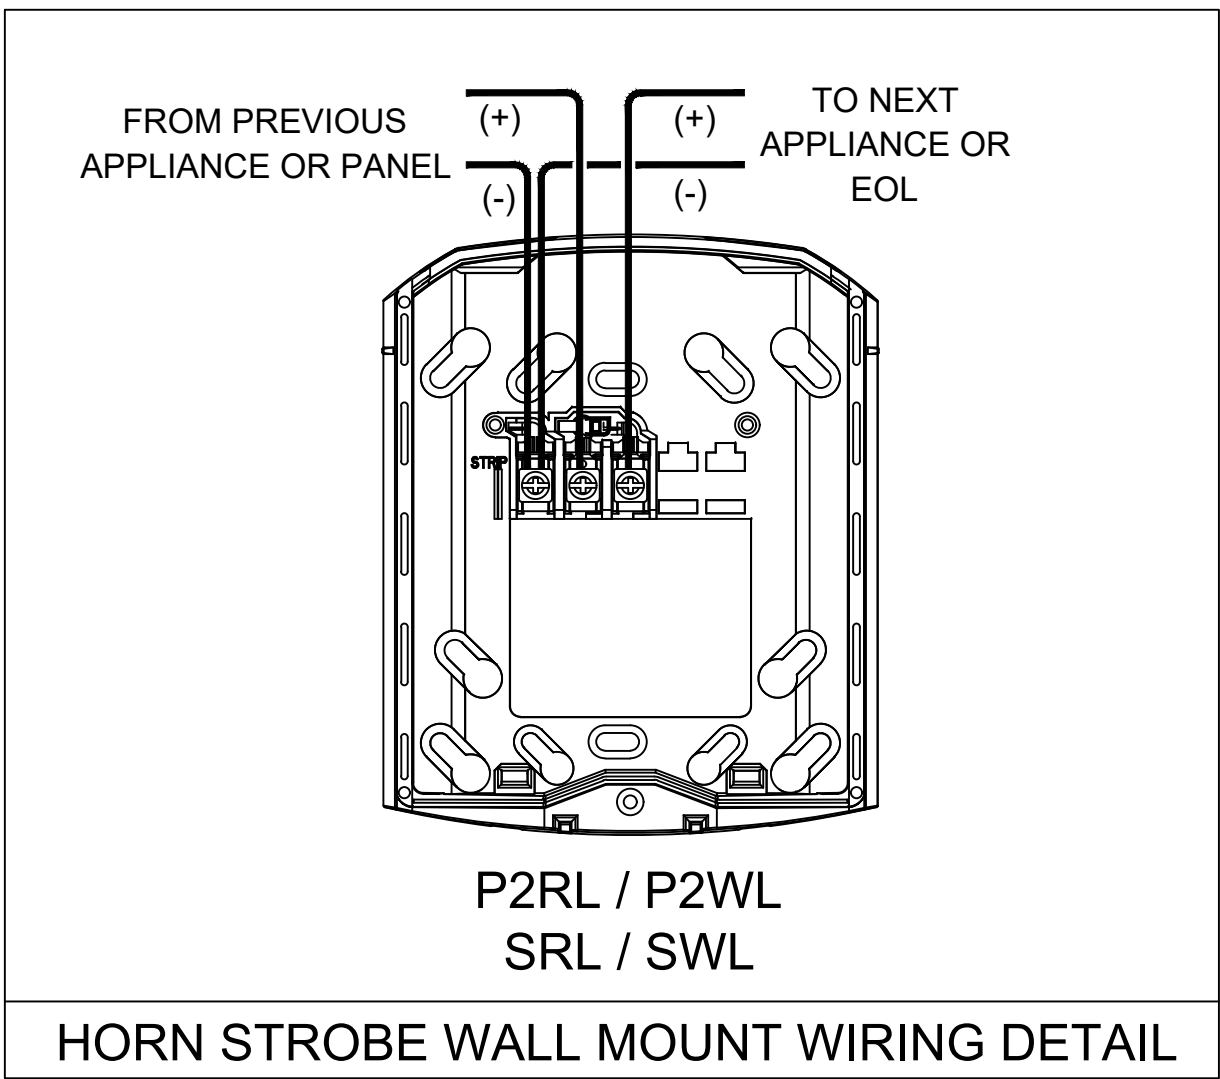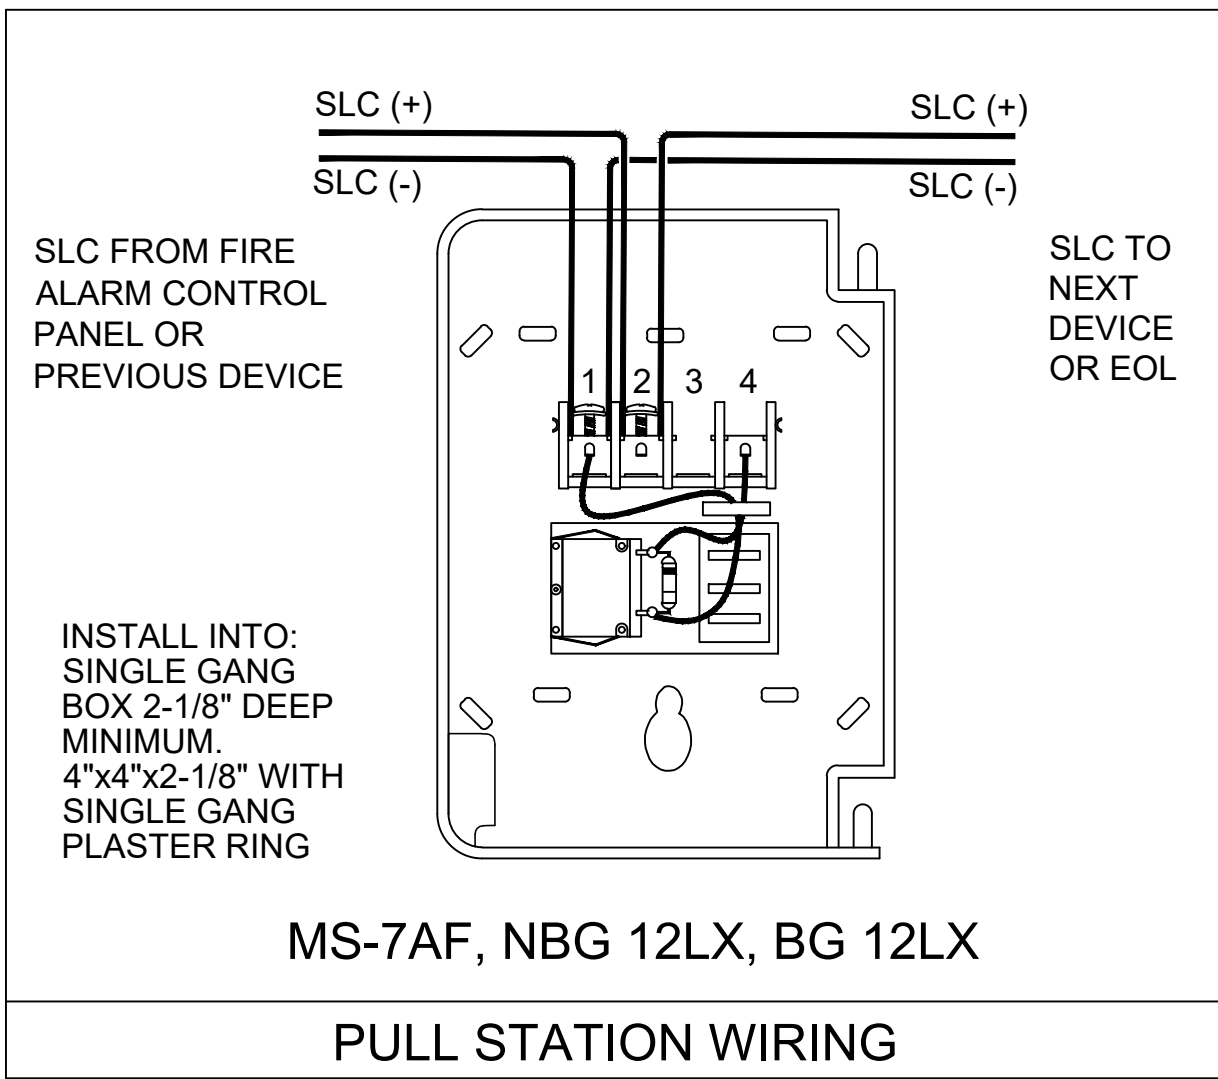

MEP Engineering Group
Certificate of Authority #2016015108
mepengineeringgroup@gmail.com
(816)778-1195



REVISION	DATE
1 Fire Alarm	4/7/2025
2	




Date:	4/7/2025
Scale:	1/8" = 1'0"

Designed by:	Drawn by:	Approved By:
	PHILLIP YOUNG	

MARMIC FIRE & SAFETY 4008 E 138th St, Grandview, MO 64030 913-760-3237

SUMMIT FAIR BLDG D 860 NW BLUE PARKWAY LEE'S SUMMIT, MO 64086

SHEET REFERENCE NUMBER: 1 TOTAL SHEETS 2

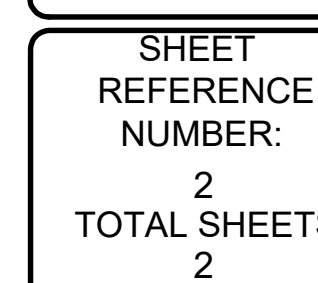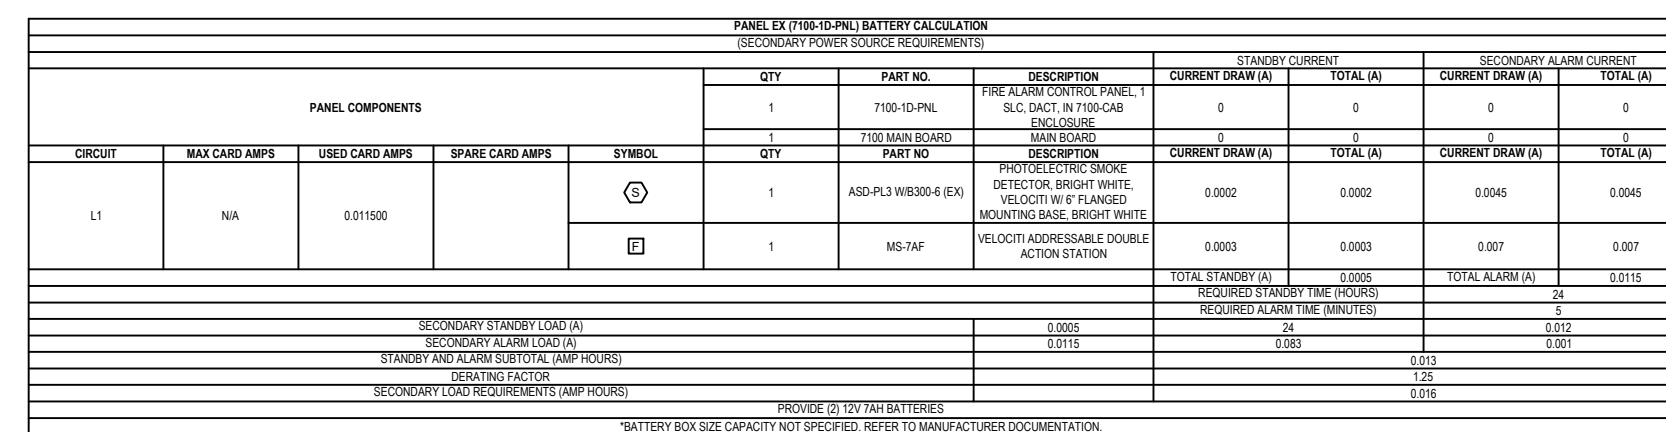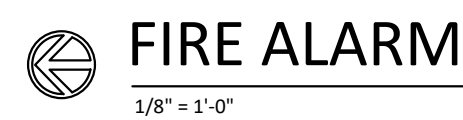

MEP Engineering Group
Certificate of Authority #2016015108
mepengineeringgroup@gmail.com
(816)778-1195

	SHEET REFERENCE NUMBER: 2
	TOTAL SHEET 2