

NEW PHOTOVOLTAIC PITCHED ROOF MOUNTED SYSTEM - 9.450 KW DC/7.980 KW AC

1705 SOUTHWEST 27TH STREET, LEE'S SUMMIT, MO 64082


NEW PV SYSTEM SPECIFICATIONS
SYSTEM SIZE: DC SIZE: 9.450 KW DC-(STC)
AC SIZE: 7.980 KW AC
MODULE: (21) REC450AA PURE-RX
INVERTER: (21) ENPHASE IQ8X-80-M-US

APPLICABLE CODES
ALL WORK SHALL CONFORM TO THE FOLLOWING CODES:
2018 INTERNATIONAL BUILDING CODE
2018 INTERNATIONAL RESIDENTIAL CODE
2018 INTERNATIONAL FIRE CODE
2017 NATIONAL ELECTRICAL CODE
AS ADOPTED BY CITY OF LEE'S SUMMIT


DESIGN CRITERIA
ROOF SURFACE TYPE: ASPHALT/COMPOSITE SHINGLE
ROOF FRAMING: 2X6" RAFTERS @ 16" OC
BUILDING STORY: 2 STORY
GROUND SNOW LOAD: 20 PSF
WIND SPEED: 109 MPH
WIND EXPOSURE: C
RISK CATEGORY: II

PROJECT NOTES
1.1.1 THIS PHOTOVOLTAIC (PV) SYSTEM SHALL COMPLY WITH THE RELEVANT YEAR OF THE NATIONAL ELECTRIC CODE (NEC), ALL MANUFACTURER'S LISTING AND INSTALLATION INSTRUCTIONS, AND THE RELEVANT CODES AS SPECIFIED BY THE AUTHORITY HAVING JURISDICTION'S (AHJ) APPLICABLE CODES.
1.1.2 THE UTILITY INTERCONNECTION APPLICATION MUST BE APPROVED AND THE PV SYSTEM MUST BE INSPECTED PRIOR TO OPERATION
1.1.3 ALL PV SYSTEM COMPONENTS; MODULES, UTILITY-INTERACTIVE INVERTERS, AND SOURCE CIRCUIT COMBINER BOXES ARE IDENTIFIED AND LISTED FOR USE IN PHOTOVOLTAIC SYSTEMS AS REQUIRED BY NEC AND OTHER GOVERNING CODES
1.1.4 ALL SIGNAGE TO BE PLACED IN ACCORDANCE WITH LOCAL BUILDING CODE. IF EXPOSED TO SUNLIGHT, IT SHALL BE UV RESISTANT. ALL PLAQUES AND SIGNAGE WILL BE INSTALLED AS REQUIRED BY THE NEC AND AHJ.

SCOPE OF WORK
1.2.1 CONTRACTOR IS RESPONSIBLE FOR THE DESIGN AND SPECIFICATIONS OF THE GRID-TIED PHOTOVOLTAIC SYSTEM. THE CONTRACTOR WILL BE RESPONSIBLE FOR COLLECTION OF EXISTING ONSITE CONDITIONS TO DESIGN, SPECIFY, AND INSTALL THE PITCHED ROOF-MOUNTED PHOTOVOLTAIC SYSTEM DETAILED IN THIS DOCUMENT

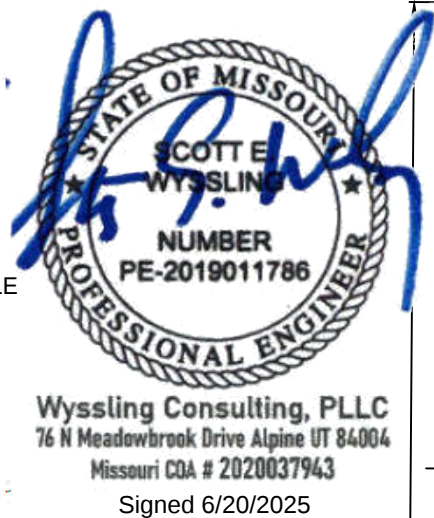

SOUTHWEST 27TH STREET

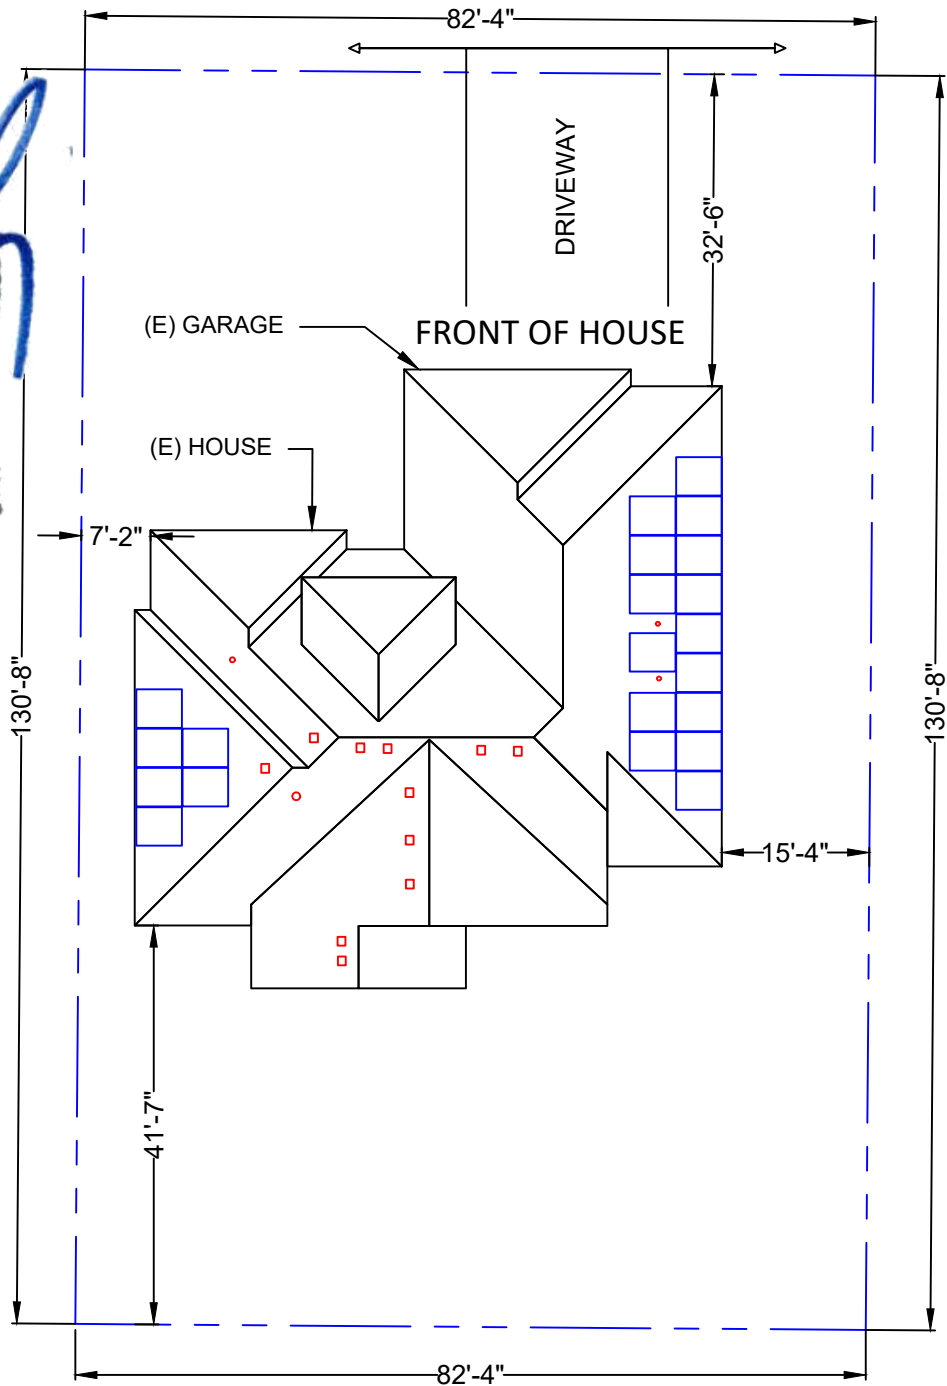


SHEET INDEX

PV-01	COVER PAGE
PV-02	SITE PLAN
PV-03	ATTACHMENT PLAN & DETAILS
PV-04	ELECTRICAL DIAGRAM
PV-05	NOTES
PV-06	WARNING LABELS
PV-07	INSTALLATION RESOURCE
EQUIPMENT DATASHEETS ATTACHED	

LEGEND

	- PROPERTY LINE
	- FENCE LINE

VICINITY MAP

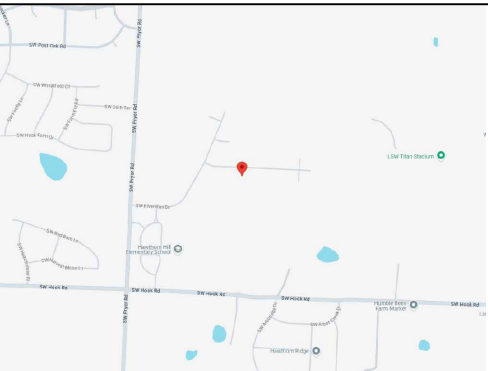

SATELLITE MAP



CONTRACTOR



THE SOLAR GUYS

6114 MO-9
PARKVILLE, MISSOURI 64152

PHONE - 816-708-5556

RELEASE FOR CONSTRUCTION

AS NOTED FOR PLAN REVIEW
DEVELOPMENT SERVICES

LEE'S SUMMIT, MISSOURI

06/26/2025

PROJECT NAME & ADDRESS

BRANDON COLEMAN
1705 SOUTHWEST 27TH STREET,
LEE'S SUMMIT, MO 64082

APN #: 999999
AHJ: CITY OF LEE'S SUMMIT
UTILITY: EVERGY

SYSTEM DETAILS

9.450 KW DC-(STC) / 7.980 KW AC
(21) REC450AA PURE-RX
(21) ENPHASE IQ8X-80-M-US

REVISIONS

REV	DESCRIPTION	DATE

SHEET TITLE

COVER PAGE

DRAWN DATE	6/19/2025
DRAWN BY	JANE

SHEET NUMBER

PV-01




PROPERTY PLAN

SCALE:1" = 20'-0"

- NOTES:**
1. ROOF ACCESS POINT SHALL NOT BE LOCATED IN AREAS THAT REQUIRE THE PLACEMENT OF GROUND LADDERS OVER OPENINGS SUCH AS WINDOWS OR DOORS, AND LOCATED AT STRONG POINTS OF BUILDING CONSTRUCTION IN LOCATIONS WHERE THE ACCESS POINT DOES NOT CONFLICT WITH OVERHEAD OBSTRUCTIONS SUCH AS TREE LIMBS, WIRES OR SIGNS.
 2. STRUCTURES, PATIO COVERS, AND/OR ADDITIONS BUILT WITHOUT PERMITS TO BE RESOLVED BY A SEPARATE PERMIT.

SOUTHWEST 27TH STREET

FRONT OF HOUSE

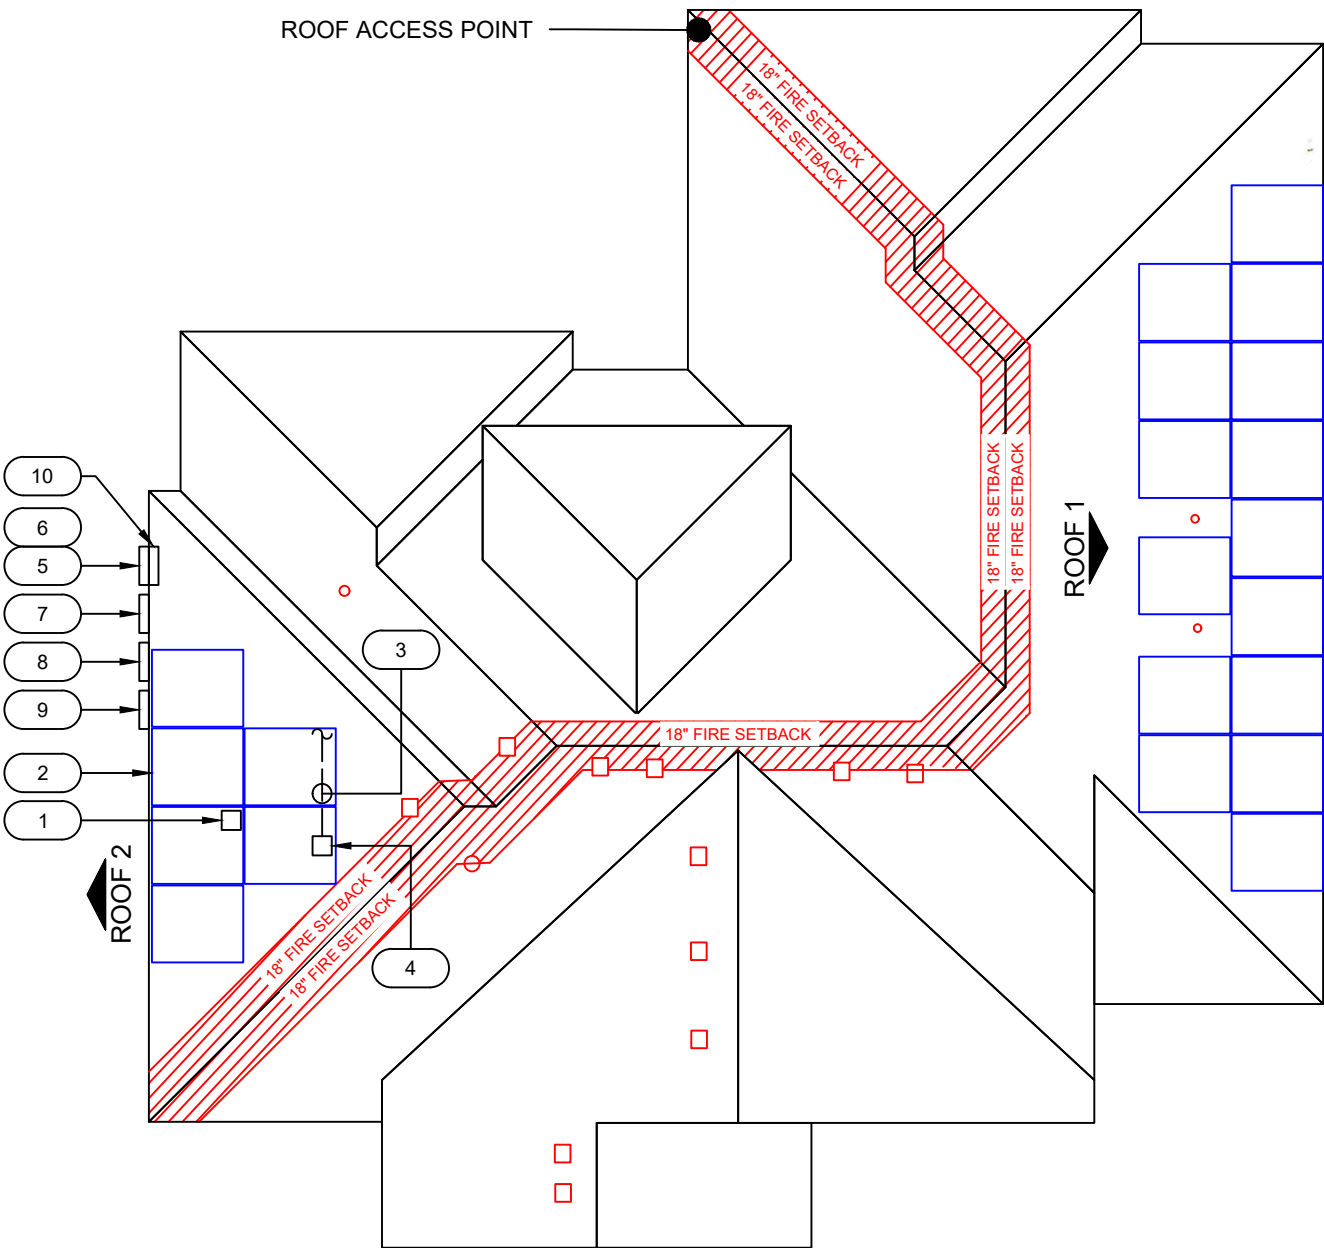

PLAN VIEW TOTAL ROOF AREA: 3661.49 FT²
TOTAL PV ARRAY AREA: 470.65 FT²
TOTAL % OF ROOF COVERED BY PV: 12.85%




Wyssling Consulting, PLLC
76 N Meadowbrook Drive Alpine UT 84004
Missouri COA # 2020037943
Signed 6/20/2025

LEGEND

- 36" 18" FIRE SETBACKS
- = MECHANICAL VENT
○ = FLUE / PLUMBING VENT
- 1 MICROINVERTER (1 PER MODULE)
2 (21) RECSO REC450AA PURE-RX MODULES WITH ENPHASE IQ8X-80-M-US MICROINVERTERS UNDER EACH MODULE
3 JUNCTION BOX; SIZE DETERMINED IN FIELD
4 CONDUIT RUN; SURFACE MOUNTED (ACTUAL CONDUIT RUNS TO BE DETERMINED IN FIELD)
5 UTILITY METER (UNDERGROUND) METER #: 25 121 491
6 MAIN SERVICE DISCONNECT
7 PV PRODUCTION METER
8 AC DISCONNECT
9 (N) ENPHASE IQ COMBINER BOX 5/5C
10 MAIN DISTRIBUTION PANEL

ROOF 1	SLOPE	- 33°
	AZIMUTH	- 92°
	MODULE QTY	- 15
	RAFTERS	- 2X6 @ 16" O.C.
	ASPHALT/COMPOSITE SHINGLE	
ROOF 2	SLOPE	- 33°
	AZIMUTH	- 272°
	MODULE QTY	- 6
	RAFTERS	- 2X6 @ 16" O.C.
	ASPHALT/COMPOSITE SHINGLE	

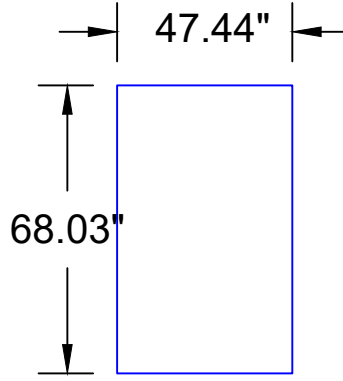

CONTRACTOR



THE SOLAR GUYS
6114 MO-9
PARKVILLE, MISSOURI 64152
PHONE - 816-708-5556

PROJECT NAME & ADDRESS
BRANDON COLEMAN
1705 SOUTHWEST 27TH STREET,
LEE'S SUMMIT, MO 64082

APN #: 999999
AHJ: CITY OF LEE'S SUMMIT
UTILITY: EVERGY

SYSTEM DETAILS
9.450 KW DC-(STC) / 7.980 KW AC
(21) RECSO REC450AA PURE-RX
(21) ENPHASE IQ8X-80-M-US

REVISIONS

REV	DESCRIPTION	DATE

SHEET TITLE
SITE PLAN

DRAWN DATE	6/19/2025
DRAWN BY	JANE

SHEET NUMBER
PV-02
06/26/2025



1
PV-02

SITE PLAN
SCALE: 1" = 10'-0"

DISTRIBUTED LOAD CALCULATIONS	
MODULE	RECSO REC450AA PURE-RX
MODULE WEIGHT	50.04 LBS
MODULE DIMENSIONS (L" x W")	68.03" x 47.44"
TOTAL QTY. OF MODULES	21
TOTAL WEIGHT OF MODULES	1050.8 LBS
TYPE OF RACKING	IRONRIDGE XR-10-168B
TYPE OF ATTACHMENT	IRONRIDGE QM-HUG-01-B1
DISTRIBUTED WEIGHT OF RACKING	0.5 PSF
TOTAL WEIGHT OF ARRAY	1286.2 LBS
AREA OF MODULE	22.4 SQFT.
TOTAL ARRAY AREA	470.7 SQFT.
DISTRIBUTED LOAD	2.7 PSF

- NOTE:**
- CONTRACTOR/INSTALLER TO VERIFY COMPATIBILITY OF ANY BRANDS OR PRODUCTS SUBSTITUTED OR USED AS ALTERNATES WITHIN ANY BRAND-SPECIFIC SYSTEMS. CONTRACTOR SHALL SUPPLY AND PRESENT CERTIFICATES OF COMPATIBILITY TO THE BUILDING OFFICIAL UPON INSPECTION AS NEEDED.
 - REFER TO PV MODULE MANUFACTURER'S INSTALLATION INSTRUCTIONS FOR RAIL SPACING SPECIFICATIONS

LEGEND	
●	- ATTACHMENT POINTS
—	- RAIL
----	- STRUCTURAL MEMBER

CONTRACTOR



THE SOLAR GUYS

6114 MO-9
PARKVILLE, MISSOURI 64152

PHONE - 816-708-5556

PROJECT NAME & ADDRESS
BRANDON COLEMAN
1705 SOUTHWEST 27TH STREET,
LEE'S SUMMIT, MO 64082

APN #: 999999
AHJ: CITY OF LEE'S SUMMIT
UTILITY: EVERGY

SYSTEM DETAILS
9.450 KW DC-(STC) / 7.980 KW AC
(21) RECSO REC450AA PURE-RX
(21) ENPHASE IQ8X-80-M-US

REVISIONS

REV	DESCRIPTION	DATE


SHEET TITLE
ATTACHMENT PLAN
& DETAILS

DRAWN DATE	6/19/2025
DRAWN BY	JANE


SHEET NUMBER

RELEASE FOR CONSTRUCTION
AS NOTED FOR PLAN REVIEW
DEVELOPMENT SERVICES
LEE'S SUMMIT, MISSOURI

06/26/2025

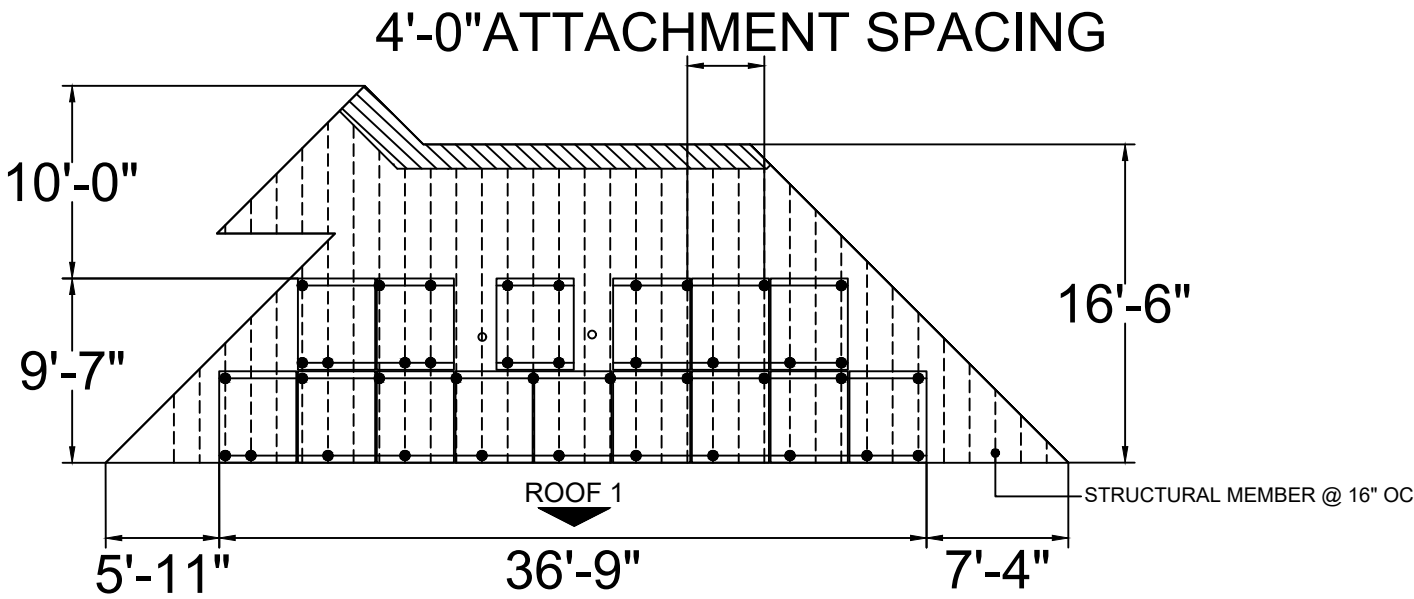


1 ATTACHMENT PLAN
SCALE: NTS

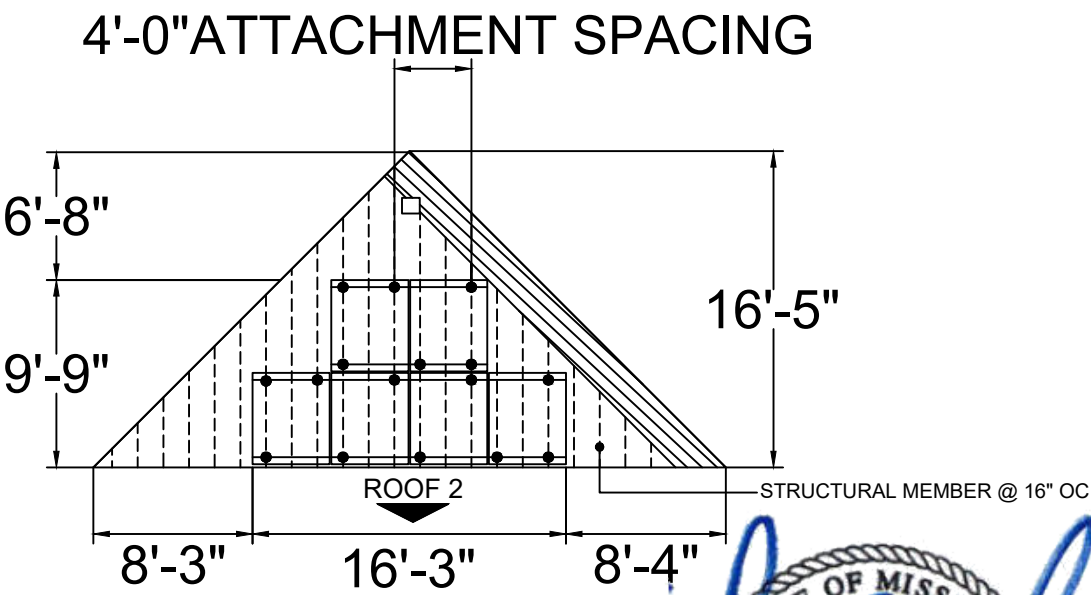


Wyssling Consulting, PLLC
76 N Meadowbrook Drive Alpine UT 84004
Missouri COA # 2020037943
Signed 6/20/2025

NOTE: 6" MAXIMUM DISTANCE FROM ROOF SURFACE TO TOP OF PV MODULES

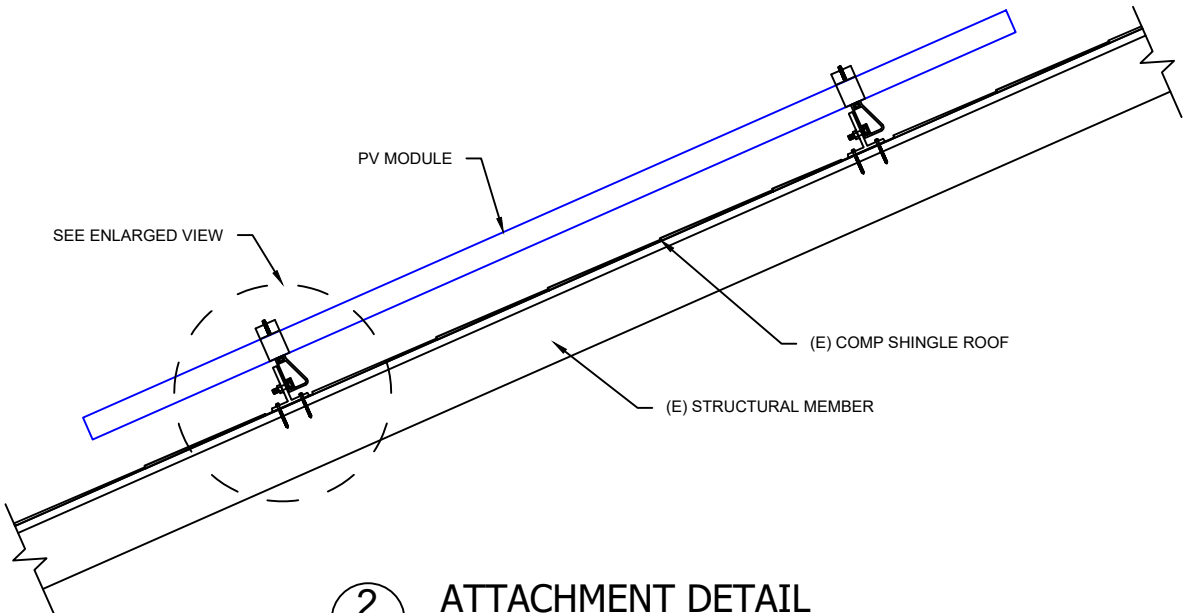

2 ATTACHMENT DETAIL
Scale: NTS

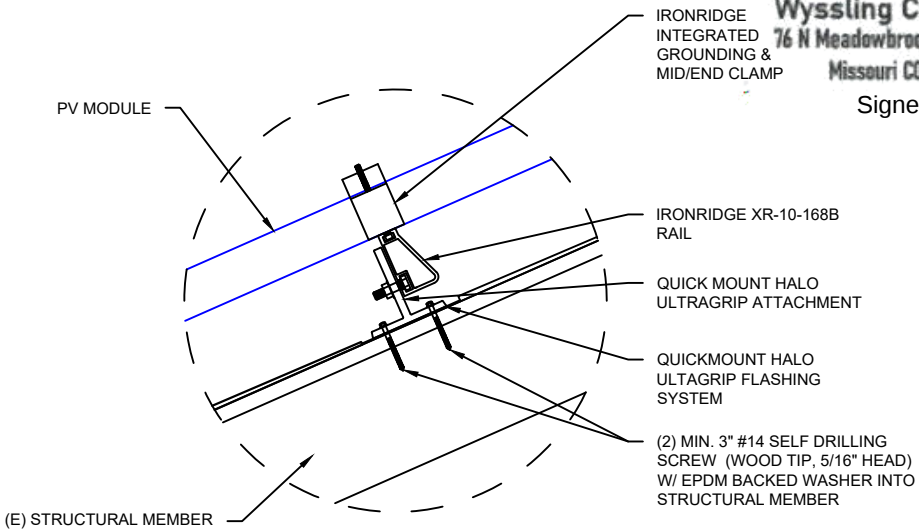

3 ENLARGED VIEW
Scale: NTS

MICROINVERTER SPECIFICATIONS		SOLAR MODULE SPECIFICATIONS	
MANUFACTURER / MODEL #	ENPHASE IQ8X-80-M-US	MANUFACTURER / MODEL #	RECSO REC450AA PURE-RX
INPUT POWER RANGE	320-540W	VMP	54.3 V
MIN/MAX START VOLTAGE	30V/79.5V	IMP	8.29 A
NOMINAL AC VOLTAGE	240V	VOC	65.6 V
MAX CONT. OUTPUT CURRENT	1.58A	ISC	8.81 A
MAX CONT. OUTPUT POWER	380W	TEMP. COEFF. VOC	-0.24 %/°C
MAX MODULES PER STRING	10 (10 MICROINVERTERS)		

AMBIENT TEMPERATURE SPECIFICATIONS	
RECORD LOW TEMP	-20
AMBIENT TEMP (HIGH TEMP 2% AVG.)	35
MINIMUM CONDUIT HEIGHT ABOVE ROOF SURFACE	7/8"

CONTRACTOR




THE SOLAR GUYS

6114 MO-9
PARKVILLE, MISSOURI 64152

PHONE - 816-708-5556

ROMEX CAN BE USED IN LIEU OF CONDUIT FOR INTERIOR BUILDING AND ATTIC RUNS ONLY. DO NOT USE ROMEX IN CONDUIT OR OUTDOOR ENVIRONMENTS.

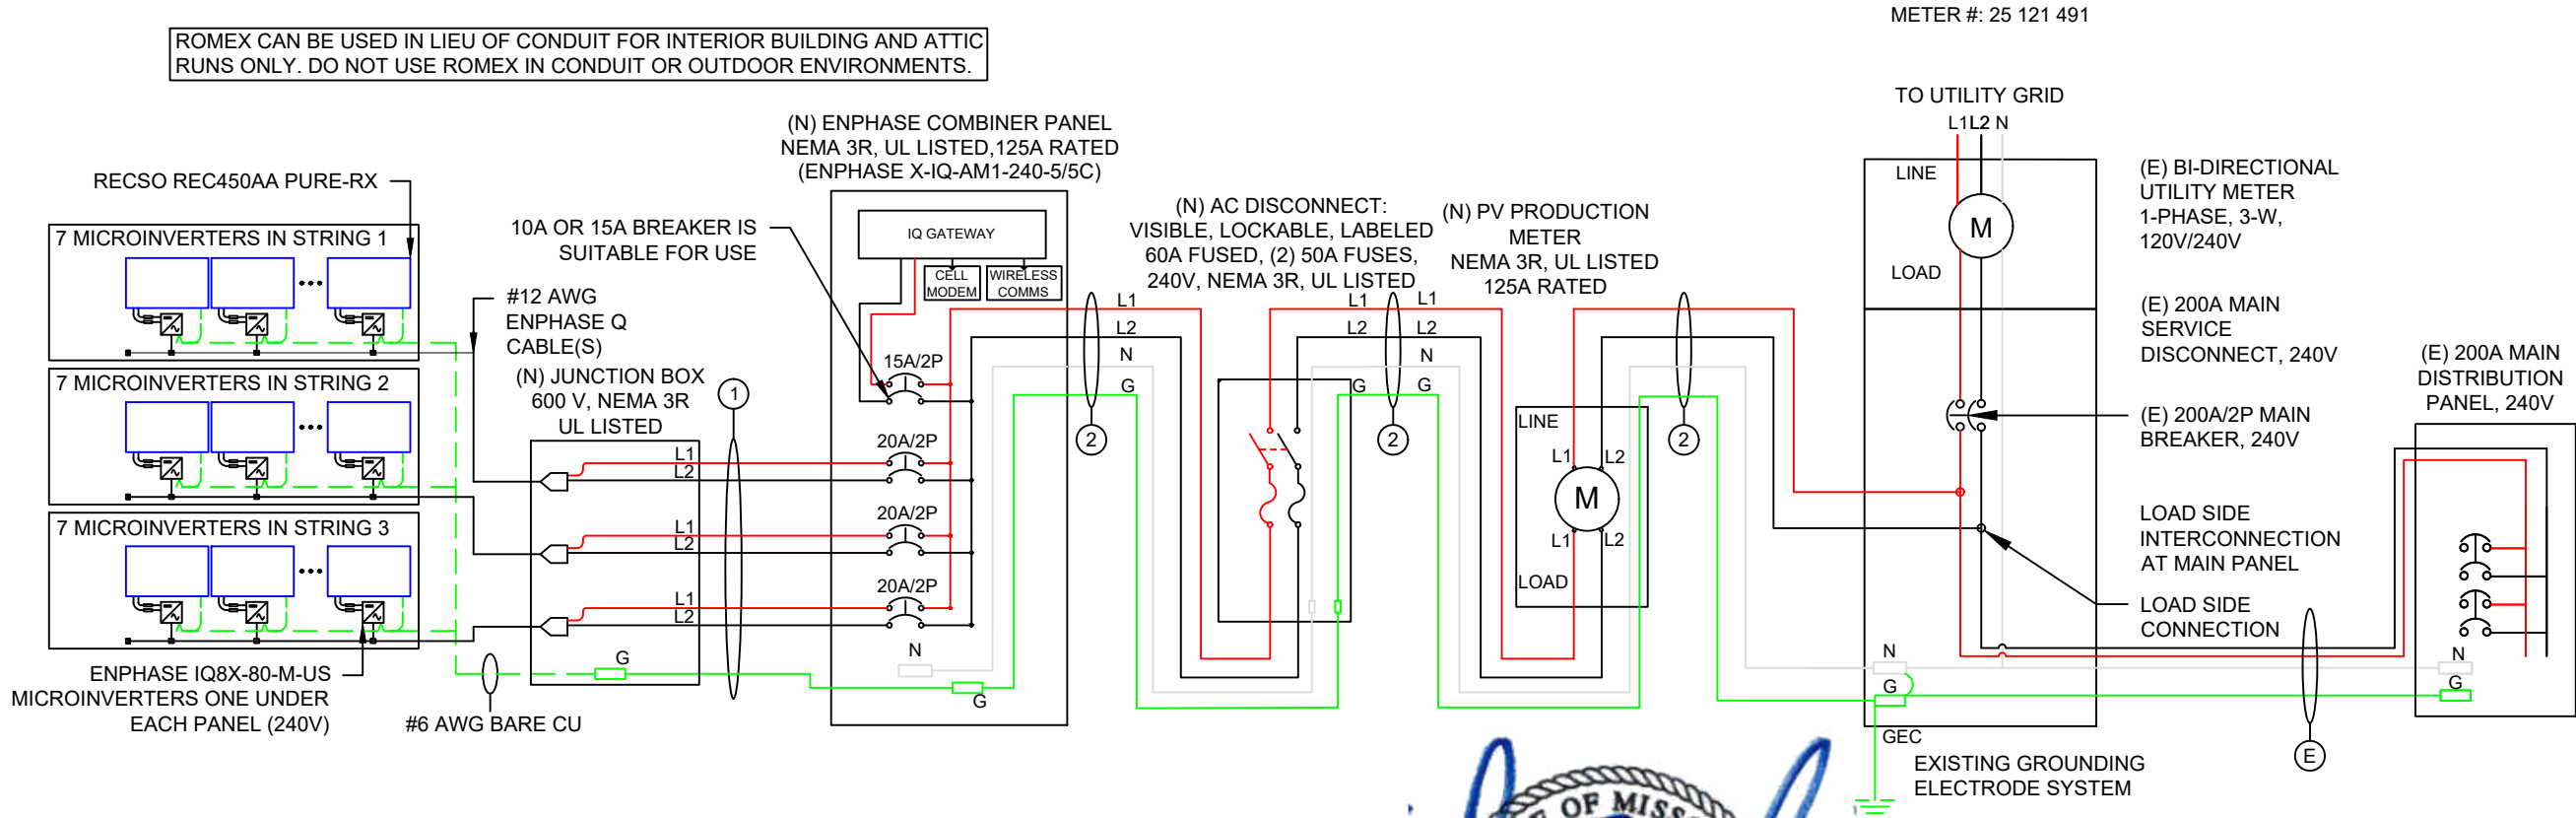

Wyssling Consulting, PLLC
76 N Meadowbrook Drive Alpine UT 84004
Missouri COA # 2020037943
Signed 6/20/2025

PROJECT NAME & ADDRESS
BRANDON COLEMAN
1705 SOUTHWEST 27TH STREET,
LEE'S SUMMIT, MO 64082

APN #: 999999
AHJ: CITY OF LEE'S SUMMIT
UTILITY: EVERGY

SYSTEM DETAILS
9.450 KW DC-(STC) / 7.980 KW AC
(21) RECSO REC450AA PURE-RX
(21) ENPHASE IQ8X-80-M-US

REVISIONS

REV	DESCRIPTION	DATE

SHEET TITLE
ELECTRICAL
DIAGRAM

DRAWN DATE 6/19/2025
DRAWN BY JANE

DESCRIPTION						FORMULA				RESULT		
PV OVERCURRENT PROTECTION NEC 690.9(B)						TOTAL INVERTER OUTPUT CURRENT x 1.25 = 33.2A x 1.25				41.48A (SELECTED OCPD = 50A)		
WIRE ID	EXPECTED WIRE TEMP (°C)	TEMP DERATE (90 °C)	QTY OF CURRENT CARRYING CONDUCTORS	CONDUIT FILL DERATE	MINIMUM CONDUIT SIZE (TBD ON SITE)	WIRE GAUGE & TYPE	CONDUCTOR AMPACITY @ 90°C (A)	CONDUCTOR AMPACITY @ 75°C (A)	REQUIRED CIRCUIT CONDUCTOR AMPACITY (A)	ADJUSTED CONDUCTOR AMPACITY @ 90 °C (A)	NEUTRAL CONDUCTOR SIZE & TYPE	GROUND WIRE SIZE & TYPE
1	35	0.96	6	0.8	3/4" METAL	#10 THWN-2	40	35	13.825	30.72	NONE	#8 THWN-2
2	35	0.96	2	1	3/4" METAL	#6 THWN-2	55	50	50	52.8	#8 THWN-2	#8 THWN-2

SHEET NUMBER
RELEASE FOR CONSTRUCTION
AS NOTED FOR PLAN REVIEW
DEVELOPMENT SERVICES
LEE'S SUMMIT, MISSOURI
PV 01

06/26/2025

GENERAL NOTES

SITE NOTES

- 2.1.1 A LADDER WILL BE IN PLACE FOR INSPECTION IN ACCORDANCE WITH OSHA REGULATIONS.
- 2.1.2 THE PV MODULES ARE CONSIDERED NON-COMBUSTIBLE AND THIS SYSTEM IS A UTILITY INTERACTIVE SYSTEM WITH NO STORAGE BATTERIES.
- 2.1.3 THE SOLAR PV INSTALLATION WILL NOT OBSTRUCT ANY PLUMBING, MECHANICAL, OR BUILDING ROOF VENTS.
- 2.1.4 PROPER ACCESS AND WORKING CLEARANCE AROUND EXISTING AND PROPOSED ELECTRICAL EQUIPMENT WILL BE PROVIDED IN ACCORDANCE WITH SECTION NEC 110
- 2.1.5 ROOF COVERINGS SHALL BE DESIGNED, INSTALLED, AND MAINTAINED IN ACCORDANCE WITH THIS CODE AND THE APPROVED MANUFACTURER'S INSTRUCTIONS SUCH THAT THE ROOF COVERING SERVES TO PROTECT THE BUILDING OR STRUCTURE.

EQUIPMENT LOCATIONS

- 2.2.1 ALL EQUIPMENT SHALL MEET MINIMUM SETBACKS IN ACCORDANCE WITH NEC 110.26.
- 2.2.2 WIRING SYSTEMS INSTALLED IN DIRECT SUNLIGHT MUST BE RATED FOR EXPECTED OPERATING TEMPERATURE AS SPECIFIED BY 2017 NATIONAL ELECTRICAL CODE.
- 2.2.3 JUNCTION AND PULL BOXES PERMITTED INSTALLED UNDER PV MODULES IN ACCORDANCE WITH NEC 690
- 2.2.4 ALL EQUIPMENT SHALL BE INSTALLED ACCESSIBLE TO QUALIFIED PERSONNEL IN ACCORDANCE WITH NEC APPLICABLE CODES.
- 2.2.5 ALL COMPONENTS ARE LISTED FOR THEIR PURPOSE AND RATED FOR OUTDOOR USAGE WHEN APPROPRIATE.

STRUCTURAL NOTES

- 2.3.1 RACKING SYSTEM & PV ARRAY WILL BE INSTALLED IN ACCORDANCE WITH THE CODE-COMPLIANT INSTALLATION MANUAL. TOP CLAMPS REQUIRE A DESIGNATED SPACE BETWEEN MODULES, AND RAILS MUST ALSO EXTEND A MINIMUM DISTANCE BEYOND EITHER EDGE OF THE ARRAY/SUBARRAY, IN ACCORDANCE WITH RAIL MANUFACTURER'S INSTALLATION PRACTICES.
- 2.3.2 JUNCTION BOX WILL BE INSTALLED PER MANUFACTURER'S SPECIFICATIONS. IF ROOF-PENETRATING TYPE, IT SHALL BE FLASHED & SEALED PER LOCAL REQUIREMENTS.
- 2.3.3 ROOFTOP PENETRATIONS FOR PV RACEWAY WILL BE COMPLETED AND SEALED W/ APPROVED CHEMICAL SEALANT PER CODE BY A LICENSED CONTRACTOR.
- 2.3.4 ALL PV RELATED ROOF ATTACHMENTS TO BE SPACED NO GREATER THAN THE SPAN DISTANCE SPECIFIED BY THE RACKING MANUFACTURER OR PROFESSIONAL ENGINEERING GUIDANCE.
- 2.3.5 WHEN POSSIBLE, ALL PV RELATED RACKING ATTACHMENTS WILL BE STAGGERED AMONGST THE ROOF FRAMING MEMBERS.

WIRING & CONDUIT NOTES

- 2.4.1 ALL CONDUIT AND WIRE WILL BE LISTED AND APPROVED FOR THEIR PURPOSE. CONDUIT AND WIRE SPECIFICATIONS ARE BASED ON MINIMUM CODE REQUIREMENTS AND ARE NOT MEANT TO LIMIT UP-SIZING.
- 2.4.2 CONDUCTORS SIZED IN ACCORDANCE WITH THE NEC
- 2.4.3 AC CONDUCTORS TO BE COLORED OR MARKED PER NEC
- 2.4.4 LISTED OR LABELED EQUIPMENT SHALL BE INSTALLED AND USED IN ACCORDANCE WITH ANY INSTRUCTIONS INCLUDED IN THE LISTING OR LABELING PER NEC

GROUNDING NOTES

- 2.5.1 GROUNDING SYSTEM COMPONENTS SHALL BE LISTED FOR THEIR PURPOSE, AND GROUNDING DEVICES EXPOSED TO THE ELEMENTS SHALL BE RATED FOR SUCH USE.
- 2.5.2 PV EQUIPMENT SHALL BE GROUNDED IN ACCORDANCE WITH NEC 690 AND NEC TABLE 250.122.
- 2.5.3 METAL PARTS OF MODULE FRAMES, MODULE RACKING, AND ENCLOSURES CONSIDERED GROUNDED IN ACCORDANCE WITH NEC 250.
- 2.5.4 EQUIPMENT GROUNDING CONDUCTORS SHALL BE SIZED IN ACCORDANCE WITH NEC 690 AND INVERTER MANUFACTURER'S INSTALLATION PRACTICES
- 2.5.5 EACH MODULE WILL BE GROUNDED AS SHOWN IN MANUFACTURER DOCUMENTATION AND APPROVED BY THE AHJ.
- 2.5.6 THE GROUNDING CONNECTION TO A MODULE SHALL BE ARRANGED SUCH THAT THE REMOVAL OF A MODULE DOES NOT INTERRUPT A GROUNDING CONDUCTOR TO ANOTHER MODULE.
- 2.5.7 GROUNDING AND BONDING CONDUCTORS, IF INSULATED, SHALL BE COLORED GREEN OR MARKED GREEN IF #4 AWG OR LARGER PER NEC 250
- 2.5.8 THE GROUNDING ELECTRODE SYSTEM COMPLIES WITH NEC 690 AND NEC 250. IF EXISTING SYSTEM IS INACCESSIBLE, OR INADEQUATE, A GROUNDING ELECTRODE SYSTEM PROVIDED IN ACCORDANCE WITH NEC 250, NEC 690 AND THE AHJ.
- 2.5.9 GROUND-FAULT DETECTION SHALL COMPLY WITH NEC 690 TO REDUCE FIRE HAZARDS

DISCONNECTION AND OVERCURRENT PROTECTION NOTES

- 2.6.1 DISCONNECTING SWITCHES SHALL BE WIRED SUCH THAT WHEN THE SWITCH IS OPENED THE CONDUCTORS REMAINING ENERGIZED ARE CONNECTED TO THE TERMINALS MARKED "LINE SIDE" (TYPICALLY THE UPPER TERMINALS).
- 2.6.2 DISCONNECTS TO BE ACCESSIBLE TO QUALIFIED UTILITY PERSONNEL, BE LOCKABLE, AND BE A VISIBLE-BREAK SWITCH
- 2.6.3 PV SYSTEM CIRCUITS INSTALLED ON OR IN HABITABLE BUILDINGS SHALL INCLUDE A RAPID SHUTDOWN FUNCTION TO REDUCE SHOCK HAZARD FOR EMERGENCY RESPONDERS IN ACCORDANCE WITH 690
- 2.6.4 ALL OCPD RATINGS AND TYPES SPECIFIED ACCORDING TO NEC 690 AND 240.
- 2.6.5 INVERTER ON-GRID BRANCHES SHALL BE CONNECTED TO A SINGLE BREAKER OR GROUPED FUSE DISCONNECT(S) IN ACCORDANCE WITH NEC 110.
- 2.6.6 IF REQUIRED BY THE AHJ, SYSTEM WILL INCLUDE ARC-FAULT CIRCUIT PROTECTION IN ACCORDANCE WITH NEC 690.11 AND UL1699B.

INTERCONNECTION NOTES

- 2.7.1 LOAD SIDE INTERCONNECTION SHALL BE IN ACCORDANCE WITH NEC 705.
- 2.7.2 THE SUM OF THE UTILITY OCPD AND INVERTER CONTINUOUS OUTPUT MAY NOT EXCEED 120 PERCENT OF BUSBAR RATING PER NEC 705.
- 2.7.3 THE SUM OF 125 PERCENT OF THE POWER SOURCE(S) OUTPUT CIRCUIT CURRENT AND THE RATING OF THE OVERCURRENT DEVICE PROTECTING THE BUSBAR SHALL NOT EXCEED 120 PERCENT OF THE AMPACITY OF THE BUSBAR, PV DEDICATED BACKFEED BREAKERS MUST BE LOCATED OPPOSITE END OF THE BUS FROM THE UTILITY SOURCE OCPD IN ACCORDANCE WITH NEC 705.
- 2.7.4 AT MULTIPLE ELECTRIC POWER SOURCES OUTPUT COMBINER PANEL, TOTAL RATING OF ALL OVERCURRENT PROTECTION DEVICES SHALL NOT EXCEED AMPACITY OF BUSBAR. HOWEVER, THE MAIN OVERCURRENT PROTECTION DEVICE MAY BE EXCLUDED IN ACCORDANCE WITH NEC 705.
- 2.7.5 FEEDER TAP INTERCONNECTION (LOAD SIDE) IN ACCORDANCE WITH NEC 705.
- 2.7.6 SUPPLY SIDE TAP INTERCONNECTION IN ACCORDANCE WITH TO NEC 705 WITH SERVICE ENTRANCE CONDUCTORS IN ACCORDANCE WITH NEC 230.
- 2.7.7 BACKFEEDING BREAKER FOR ELECTRIC POWER SOURCES OUTPUT IS EXEMPT FROM ADDITIONAL FASTENING PER NEC 705.



Wyssling Consulting, PLLC
76 N Meadowbrook Drive Alpine UT 84004
Missouri COA # 2020037943
Signed 6/20/2025

CONTRACTOR



THE SOLAR GUYS

6114 MO-9
PARKVILLE, MISSOURI 64152

PHONE - 816-708-5556

PROJECT NAME & ADDRESS
BRANDON COLEMAN
1705 SOUTHWEST 27TH STREET,
LEE'S SUMMIT, MO 64082

APN #: 999999
AHJ: CITY OF LEE'S SUMMIT
UTILITY: EVERGY

SYSTEM DETAILS
9.450 KW DC-(STC) / 7.980 KW AC
(21) RECSO REC450AA PURE-RX
(21) ENPHASE IQ8X-80-M-US

REVISIONS

REV	DESCRIPTION	DATE

SHEET TITLE

NOTES

DRAWN DATE	6/19/2025
DRAWN BY	JANE

SHEET NUMBER
RELEASE FOR CONSTRUCTION
AS NOTED FOR PLAN REVIEW
PV 05
DEVELOPMENT SERVICES
LEE'S SUMMIT, MISSOURI

06/26/2025

⚠️

WARNING

ELECTRICAL SHOCK HAZARD

TERMINALS ON THE LINE AND
LOAD SIDES MAY BE ENERGIZED
IN THE OPEN POSITION

LABEL LOCATION: COMBINER PANEL, AC DISCONNECT,
POINT OF INTERCONNECTION
PER CODE: NEC 690.13(B)

⚠️

WARNING

TURN OFF PHOTOVOLTAIC AC
DISCONNECT PRIOR TO
WORKING INSIDE PANEL

LABEL LOCATION: COMBINER PANEL(S), MAIN SERVICE DISCONNECT
PER CODE: NEC 110.27(C), OSHA 1910.145(f)(7)

WARNING: PHOTOVOLTAIC
POWER SOURCE

LABEL LOCATION: DC CONDUIT/RACEWAY/CABLE TRAY
PER CODE: NEC 690.31(G)(3-4)

PHOTOVOLTAIC SYSTEM AC DISCONNECT

RATED AC OUTPUT CURRENT: 33.18 A
NOMINAL OPERATING AC VOLTAGE: 240 V

LABEL LOCATION: POINT OF INTERCONNECTION
PER CODE: NEC 690.54

PV SYSTEM

DISCONNECT

LABEL LOCATION: AC DISCONNECT
PER CODE: NEC 690.13(B)

DO NOT DISCONNECT
UNDER LOAD

LABEL LOCATION: MAIN SERVICE DISCONNECT
PER CODE: NEC 690.15(C) & NEC 690.33(E)(2)

⚠️

WARNING

DUAL POWER SOURCE
SECOND SOURCE IS PHOTOVOLTAIC SYSTEM

LABEL LOCATION: MAIN SERVICE DISCONNECT
PER CODE: NEC 705.12(B)(3-4), NEC 690.59

⚠️

WARNING

THIS EQUIPMENT FED BY MULTIPLE SOURCES.
TOTAL RATING OF ALL OVERCURRENT DEVICES
EXCLUDING MAIN SUPPLY OVERCURRENT DEVICE
SHALL NOT EXCEED AMPACITY OF BUSBAR.

LABEL LOCATION: POINT OF INTERCONNECTION, COMBINER PANEL
PER CODE: NEC 705.12(B)(2)(3)(c)

⚠️

WARNING

POWER SOURCE OUTPUT
CONNECTION. DO NOT RELOCATE
THIS OVERCURRENT DEVICE.

LABEL LOCATION: MAIN SERVICE DISCONNECT, POINT
OF INTERCONNECTION
PER CODE: 705.12(B)(2)(3)(b)

MAIN PHOTOVOLTAIC
SYSTEM DISCONNECT

LABEL LOCATION: MAIN SERVICE DISCONNECT, UTILITY METER
PER CODE: NEC 690.13(B)

RAPID SHUTDOWN SWITCH
FOR SOLAR PV SYSTEM

LABEL LOCATION: RSD INITIATION DEVICE, AC DISCONNECT
PER CODE: NEC 690.56(C)(3)

SOLAR PV SYSTEM EQUIPPED
WITH RAPID SHUTDOWN

TURN RAPID SHUTDOWN
SWITCH TO THE
"OFF" POSITION TO
SHUT DOWN PV SYSTEM
AND REDUCE
SHOCK HAZARD
IN THE ARRAY

LABEL LOCATION: MAIN SERVICE DISCONNECT
PER CODE: NEC 690.56(C)(1)(a)

⚠️

CAUTION

PHOTOVOLTAIC SYSTEM CIRCUIT IS BACKFED

LABEL LOCATION: MAIN SERVICE DISCONNECT
PER CODE: NEC 690.13(F), NEC 705.12(B)(3-4), NEC 690.59

6114 MO-9, PARKVILLE, MISSOURI 64152

CAUTION:

POWER TO THIS SERVICE IS ALSO
SUPPLIED FROM THE FOLLOWING
SOURCES WITH DISCONNECTS AS
SHOWN

SOLAR INSTALLED BY:

THE SOLAR GUYS
888-SOLAR-72

ADDRESS: 1705 SOUTHWEST 27TH STREET, LEE'S SUMMIT, MO, 64082

MAXIMUM AC OPERATING CURRENT: 33.180000 AMPS

NOMINAL OPERATING AC VOLTAGE: 240 VAC

PLACARD LOCATION: MSP

CONTRACTOR

THE SOLAR GUYS

6114 MO-9
PARKVILLE, MISSOURI 64152

PHONE - 816-708-5556

PROJECT NAME & ADDRESS

BRANDON COLEMAN
1705 SOUTHWEST 27TH STREET,
LEE'S SUMMIT, MO 64082

APN #: 999999
AHJ: CITY OF LEE'S SUMMIT
UTILITY: EVERGY

SYSTEM DETAILS

9.450 KW DC-(STC) / 7.980 KW AC
(21) RECSO REC450AA PURE-RX
(21) ENPHASE IQ8X-80-M-US

REVISIONS

REV	DESCRIPTION	DATE

SHEET TITLE

WARNING LABELS

DRAWN DATE

6/19/2025

DRAWN BY

JANE

SHEET NUMBER

RELEASE FOR CONSTRUCTION
AS NOTED FOR PLAN REVIEW
DEVELOPMENT SERVICES
LEE'S SUMMIT, MISSOURI
PV-06
06/26/2025


	A	B	C	D	E	F
1						
2						
3						
4						
5						
6						
7						
8						
9						
10						

REFERENCE ONLY



Wyssling Consulting, PLLC
76 N Meadowbrook Drive Alpine UT 84004
Missouri COA # 2020037943
Signed 6/20/2025

FRONT OF HOUSE

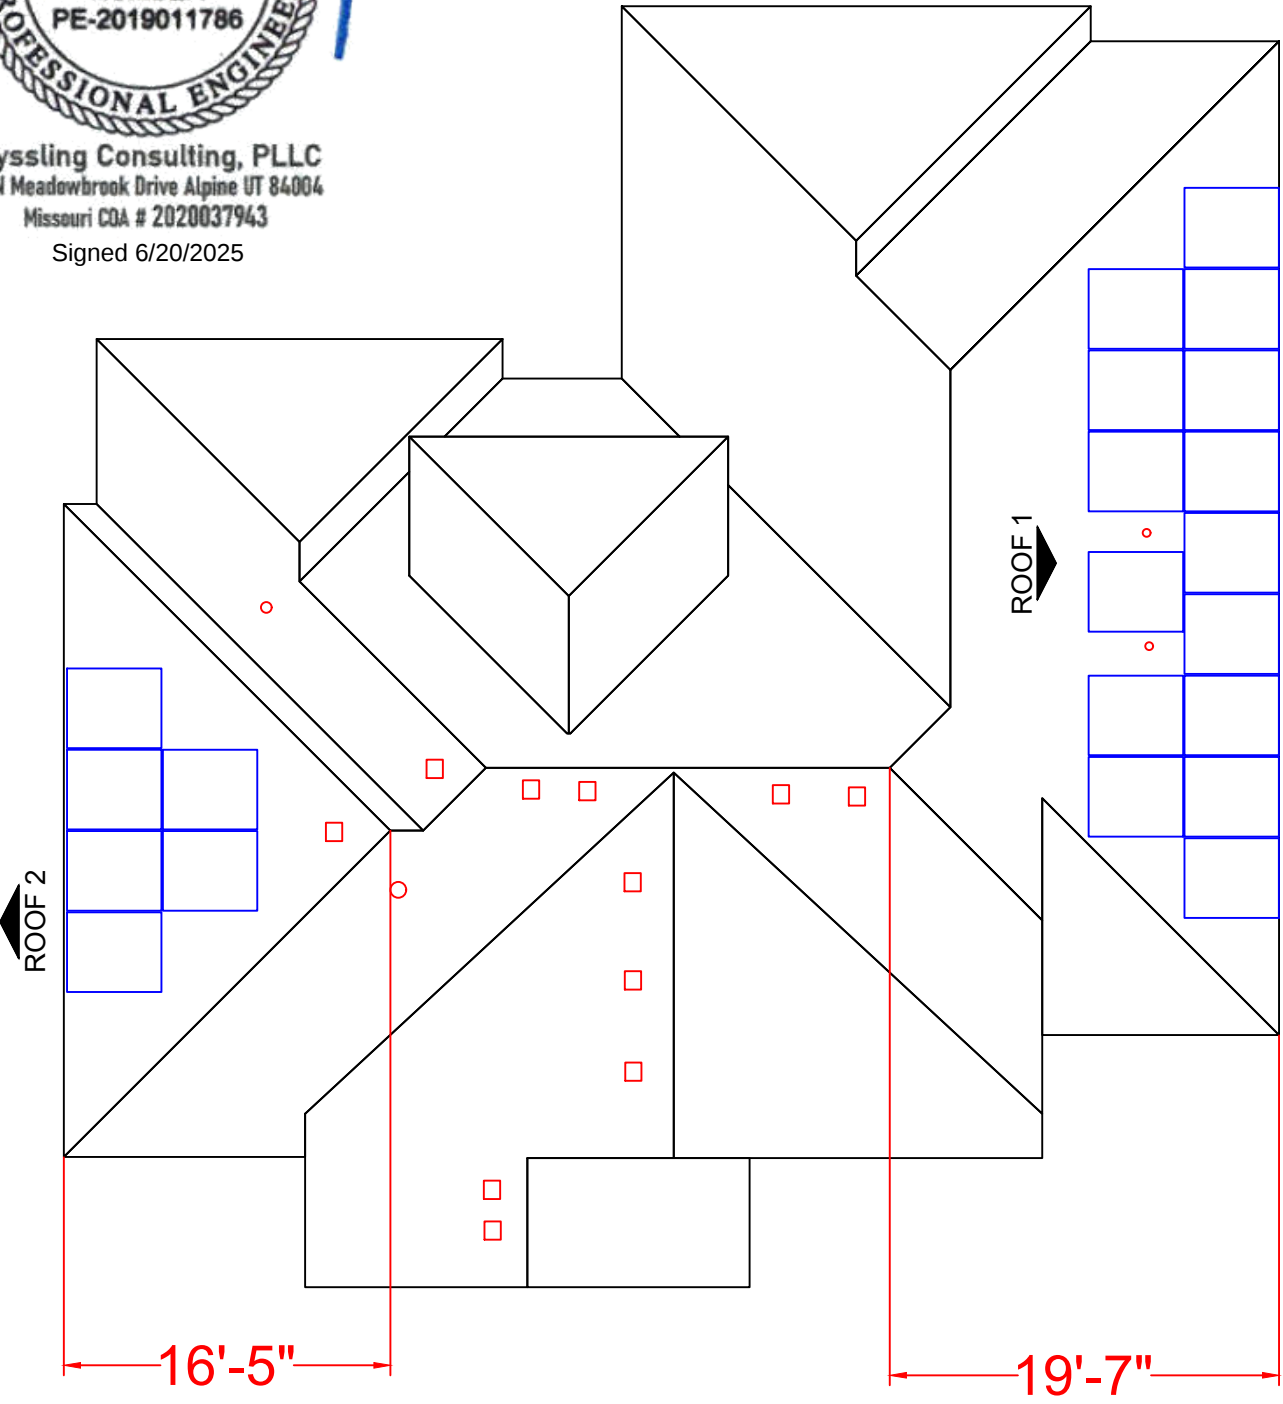

**DIMENSIONS ARE 2D (FLAT)

CONTRACTOR

THE SOLAR GUYS
6114 MO-9
PARKVILLE, MISSOURI 64152
PHONE - 816-708-5556

PROJECT NAME & ADDRESS
BRANDON COLEMAN
1705 SOUTHWEST 27TH STREET,
LEE'S SUMMIT, MO 64082

APN #: 999999
AHJ: CITY OF LEE'S SUMMIT
UTILITY: EVERGY

SYSTEM DETAILS
9.450 KW DC-(STC) / 7.980 KW AC
(21) REC450AA PURE-RX
(21) ENPHASE IQ8X-80-M-US

REVISIONS		
REV	DESCRIPTION	DATE

SHEET TITLE
INSTALLATION
RESOURCE

DRAWN DATE	6/19/2025
DRAWN BY	JANE


SHEET NUMBER
PV-07
06/26/2025

SOLAR'S MOST TRUSTED



REC ALPHA[®] PURE-RX SERIES

DATASHEET

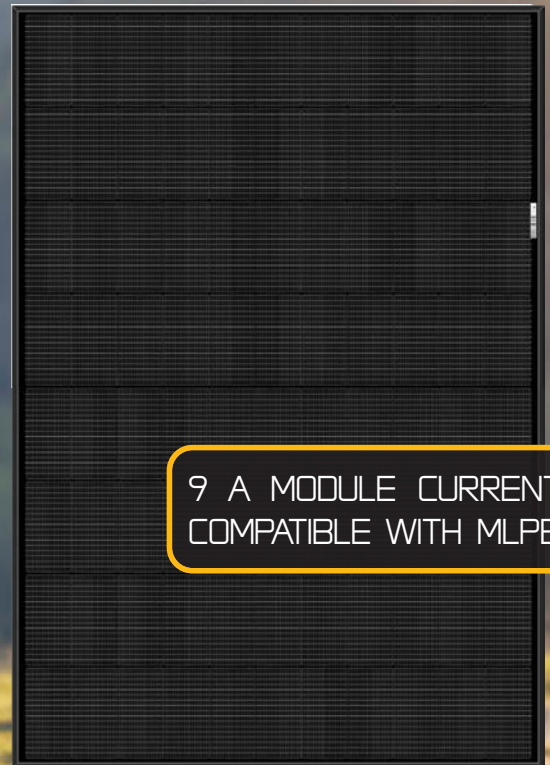

9 A MODULE CURRENT
COMPATIBLE WITH MLPE

450 - 470W
HETEROJUNCTION
TECHNOLOGY

22.6% EFFICIENCY
>92% POWER IN YEAR 25
-0.24%/K TEMPERATURE
COEFFICIENT OF P_{MAX}



RELEASE FOR CONSTRUCTION
AS NOTED FOR PLAN REVIEW
DEVELOPMENT SERVICES
ELIGIBLE
LEE'S SUMMIT, MISSOURI

06/26/2025


REC ALPHA® PURE-RX SERIES

DATASHEET

Measurements in [inches] and mm

GENERAL DATA

Cell Type	88 half-cut bifacial REC heterojunction cells, with gapless technology
Glass	0.13 in solar glass with anti-reflective surface treatment in accordance with EN12150
Backsheet	Highly resistant polymer (Black)
Frame	Anodized aluminum (Black)
Junction Box	4-part, 4 bypass diodes, IP68 rated, in accordance with IEC 62790:2020
Connectors	Stäubli MC4 PV-KBT4/KST4 (12 AWG) in accordance with IEC 62852:2014, IP68 only when connected
Cable	12 AWG solar cable, 66.9 in (1.70 m) + 66.9 in (1.70 m) in accordance with EN50618:2014
Dimensions	68.0 x 47.4 x 1.2 in (22.4 ft²) / 1728 x 1205 x 30 mm (2.08 m²)
Weight	50.0 lb / 22.7 kg
Origin	Made in Singapore

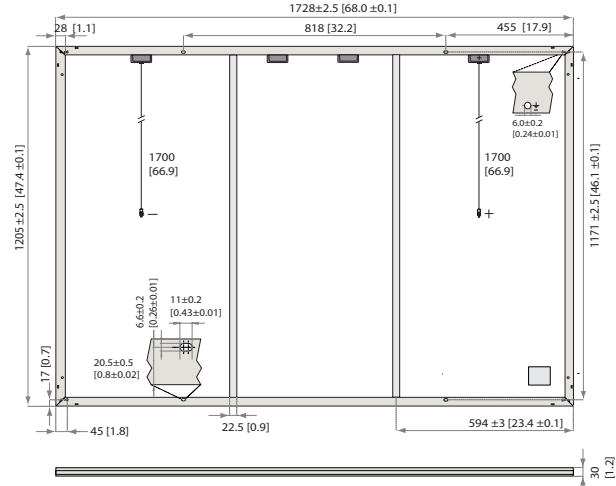

Specifications subject to change without notice.

ELECTRICAL DATA

PRODUCT CODE*: RECXXXAA PURE-RX

Power Output - P _{MAX} (WP)	450	460	470
Watt Class Sorting - (W)	0/+10	0/+10	0/+10
Nominal Power Voltage - V _{MPP} (V)	54.3	54.9	55.4
Nominal Power Current - I _{MPP} (A)	8.29	8.38	8.49
Open Circuit Voltage - V _{OC} (V)	65.6	65.8	65.9
Short Circuit Current - I _{SC} (A)	8.81	8.88	8.95
Power Density (W/ft²)	20.1	20.5	21.0
Panel Efficiency (%)	21.6	22.1	22.6
Power Output - P _{MAX} (W _P)	343	350	358
Nominal Power Voltage - V _{MPP} (V)	51.2	51.7	52.2
Nominal Power Current - I _{MPP} (A)	6.70	6.77	6.86
Open Circuit Voltage - V _{OC} (V)	61.8	62.0	62.1

Values at standard test conditions (STC: air mass AM1.5, irradiance 1000 W/m², temperature 25°C), based on a production spread with a tolerance of P_{MAX}, V_{OC} & I_{SC} ±3% within one watt class. Nominal module operating temperature (NMOT: air mass AM1.5, irradiance 800 W/m², temperature 20°C, windspeed 1 m/s). *Where xxx indicates the nominal power class (P_{MAX}) at STC above.

MODULE RATINGS

Module Operating Temperature [T ₉₈]	158°F (70°C)
Min. Environmental Temperature	-40°F (-40°C)
System Voltage	1000 V
Maximum Test Load (4 Point Mounting, Front)*	+7000 Pa (1.02 lbs/in²)
Maximum Test Load (4 Point Mounting, Rear)*	-4000 Pa (0.58 lbs/in²)
Maximum Test Load (6 Point Mounting, Front)**	+8000 Pa (1.16 lbs/in²)
Maximum Test Load (6 Point Mounting, Rear)**	-6000 Pa (0.87 lbs/in²)
Max Series Fuse Rating	25 A
Max Reverse Current	25 A

Design load = Test load / 1.5 (safety factor)
* 98th percentile operating temperature

* IEC61730/UL61730 certified. Refer to installation manual.

** Internal testing. Refer to installation manual.

TEMPERATURE RATINGS*

Nominal Module Operating Temperature	44 ± 2°C
Temperature coefficient of P _{MAX}	-0.24%/K
Temperature coefficient of V _{OC}	-0.24%/K
Temperature coefficient of I _{SC}	0.04%/K

*The temperature coefficients stated are linear values

DELIVERY INFORMATION

Panels per Pallet	33
Panels per 40 ft GP/high cube container	594 (18 Pallets)
Panels per 53 ft truck	792 (24 Pallets)

CERTIFICATIONS

ISO 14001; ISO9001; IEC45001; IEC62941	
IEC 61215:2021; IEC 61730:2023; UL 61730	
ISO 11925-2	Ignitability (EN 13501-1 Class E)
IEC 62716	Ammonia Resistance
IEC 61701	Salt Mist (SM6)
IEC 61215:2016	Hailstone (35mm)
UL 61730	Fire Type 2




WARRANTY

	Standard	REC ProTrust	
Installed by an REC	No	Yes	Yes
Certified Professional			
System Size	All	<25 kW	25-500 kW
Product Warranty (yrs)	20	25	25
Power Warranty (yrs)	25	25	25
Labor Warranty (yrs)	0	25	10
Power in Year 1	98%	98%	98%
Annual Degradation	0.25%	0.25%	0.25%
Power in Year 25	92%	92%	92%

REC ProTrust Warranty applies only for i) REC panels installed by an REC Certified Solar Professional, and ii) panels have been registered by the installer with REC. Subject to System Size and further conditions. See www.recgroup.com for details.

LOW LIGHT BEHAVIOR

Typical low irradiance performance of module at STC:

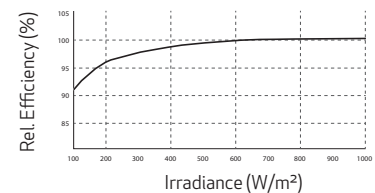

Available from:


Founded in 1996, REC Group is an international pioneering solar energy company dedicated to empowering consumers with clean, affordable solar power. As Solar's Most Trusted, REC is committed to high quality, innovation, and a low carbon footprint in the solar materials and solar panels it manufactures. Headquartered in Norway with operational headquarters in Singapore, REC also has regional hubs in North America, Europe, and Asia-Pacific.

REC Solar PTE. LTD.
20 Tuas South Ave. 14
Singapore 637312
post@recgroup.com
www.recgroup.com

RELEASE FOR CONSTRUCTION
AS NOTED FOR PLAN REVIEW
DEVELOPMENT SERVICES
LEE'S SUMMIT, MISSOURI

06/26/2025

REC-PN-DS-12-06-REV-4.3/B/ULEN12.2024

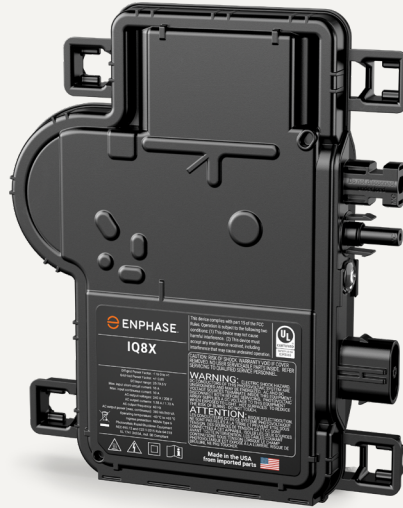

IQ8X Microinverter

Our newest IQ8 Series Microinverters are the industry's first microgrid-forming*, software-defined microinverters with split-phase power conversion capability to convert DC power to AC power efficiently. The brain of the semiconductor-based microinverter is our proprietary application-specific integrated circuit (ASIC), which enables the microinverter to operate in grid-tied or off-grid mode. This chip is built using advanced 55-nm technology with high-speed digital logic and superfast response times to changing loads and grid events, alleviating constraints on battery sizing for home energy systems.


IQ8X Microinverter is the latest addition to this family, designed to support PV modules with high input DC voltage and cell counts, such as 80-half-cut cells, 88-half-cut cells and 96-cells.



Part of the Enphase Energy System, IQ8 Series Microinverters integrate with the IQ Battery, IQ Gateway, and the Enphase App monitoring and analysis software.



IQ8 Series Microinverters redefine reliability standards with more than one million cumulative hours of power-on testing, enabling an industry-leading limited warranty of up to 25 years.

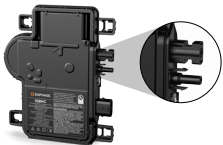

Connect PV modules quickly and easily to the IQ8 Series Microinverters with integrated MC4 connectors.



IQ8 Series Microinverters are UL Listed as PV rapid shutdown equipment and conform with regulations when installed according to the manufacturer's instructions.

*Meets UL 1741 only when installed with IQ System Controller 2 and 3.

Easy to install

- Lightweight and compact with plug-and-play connectors
- Power line communication (PLC) between components
- Faster installation with simple two-wire cabling

High productivity and reliability

- Produces power even when the grid is down*
- More than one million cumulative hours of testing
- Class II double-insulated enclosure
- Optimized for the latest high-powered PV modules

Microgrid-forming

- Complies with the latest advanced grid support
- Remote automatic updates for the latest grid requirements
- Configurable to support a wide range of grid profiles
- Meets CA Rule 21 (UL 1741-SA) and IEEE 1547:2018 (UL 1741-SB)

NOTE:

- IQ8 Series Microinverters cannot be mixed with previous generations of Enphase microinverters (IQ7 Series, IQ6 Series, and so on) in the same system.
- IQ Gateway is required to change the default grid profile at the time of installation to meet local Authority Having Jurisdiction (AHJ) requirements.

IQ8X Microinverter

INPUT DATA (DC)	UNIT	IQ8X-80-M-US
Commonly used module pairings ¹	W	320–540
Module compatibility	—	To meet compatibility, PV modules must be within the following maximum input DC voltage and maximum module I_{sc} . Module compatibility can be checked at https://enphase.com/installers/microinverters/calculator
MPPT voltage range	V	43–60
Operating range	V	25–79.5
Minimum and maximum start voltage	V	30–79.5
Maximum input DC voltage	V	79.5
Maximum continuous operating DC current	A	10
Maximum input DC short-circuit current	A	16
Maximum module I_{sc}	A	13
Overvoltage class DC port	—	II
DC port backfeed current	mA	0
PV array configuration	—	Ungrounded array; no additional DC side protection required; AC side protection requires maximum 20 A per branch circuit

OUTPUT DATA (AC)	UNIT	IQ8X-80-M-US @240 VAC	IQ8X-80-M-US @208 VAC
Peak output power	VA	384	366
Maximum continuous output power	VA	380	360
Nominal grid voltage (L-L)	V	240, split-phase (L-L), 180°	208, single-phase (L-L), 120° ⁴
Minimum and maximum grid voltage ²	V	211–264	183–229
Max. continuous output current	A	1.58	1.73
Nominal frequency	Hz	60	
Extended frequency range	Hz	47–68	
AC short circuit fault current over three cycles	A _{rms}	2.70	
Maximum units per 20 A (L-L) branch circuit ³	—	10	9
Total harmonic distortion	%	<5	
Overvoltage class AC port	—	III	
AC port backfeed current	mA	18	
Power factor setting	—	1.0	
Grid-tied power factor (adjustable)	—	0.85 leading ... 0.85 lagging	
Peak efficiency	%	97.3	97.0
CEC weighted efficiency	%	96.5	96.5
Nighttime power consumption	mW	26	12

MECHANICAL DATA	
Ambient temperature range	–40°C to 65°C (–40°F to 149°F)
Relative humidity range	4% to 100% (condensing)
DC connector type	Stäubli MC4
Dimensions (H × W × D); Weight	212 mm (8.3") × 175 mm (6.9") × 30.2 mm (1.2"); 1.1 kg (2.43 lbs)
Cooling	Natural convection – no fans
Approved for wet locations; Pollution degree	Yes; PD3
Enclosure	Class II double-insulated, corrosion-resistant polymeric enclosure
Environmental category; UV exposure rating	NEMA Type 6; outdoor

COMPLIANCE	
Certifications	CA Rule 21 (UL 1741-SA), UL 62109-1, IEEE 1547:2018 (UL 1741-SB), FCC Part 15 Class B, ICES-0003 Class B, CAN/CSA-C22.2 NO. 107.1-01 This product is UL Listed as PV rapid shutdown equipment and conforms with NEC 2014, NEC 2017, NEC 2020, and NEC 2023 section 690.12 and C22.1-2018 Rule 64-218 rapid shutdown of PV systems for AC and DC conductors when installed according to the manufacturer's instructions.

(1) No enforced DC/AC ratio.

(2) Nominal voltage range can be extended beyond nominal if required by the utility.

(3) Limits may vary. Refer to local requirements to define the number of microinverters per branch in your area.

(4) IQ8X is not certified for use with Enphase Three Phase Network Protection Relay (NPR-3P-208-NA) and therefore designed for single-phase operation only. Check with the local utility requirements if you wish to install single phase inverter across three phases.

IQ8X-MC4-DSH-00185-2.0-EN-US-2023-11-16

RELEASE FOR CONSTRUCTION
AS NOTED FOR PLAN REVIEW
DEVELOPMENT SERVICES
LEE'S SUMMIT, MISSOURI

06/26/2025

Revision history

REVISION	DATE	DESCRIPTION
DSH-00185-2.0	November 2023	Preliminary release - public.
DSH-00185-1.0	October 2023	Preliminary release.



X-IQ-AM1-240-5
X-IQ-AM1-240-5C

IQ Combiner 5/5C

The IQ Combiner 5/5C consolidates interconnection equipment into a single enclosure and streamlines IQ Series Microinverters and IQ Gateway installation by providing a consistent, pre-wired solution for residential applications. IQ Combiner 5/5C uses wired control communication and is compatible with IQ System Controller 3/3G and IQ Battery 5P.

The IQ Combiner 5/5C, along with IQ Series Microinverters, IQ System Controller 3/3G, and IQ Battery 5P provides you with a complete grid-agnostic Enphase Energy System.



IQ Series Microinverters

The high-powered smart grid-ready IQ Series Microinverters (IQ6, IQ7, and IQ8 Series) dramatically simplify the installation process



IQ System Controller 3/3G

Provides microgrid interconnection device (MID) functionality by automatically detecting grid failures and seamlessly transitioning the home energy system from grid power to backup power



IQ Battery 5P

Fully integrated AC battery system. Includes six field-replaceable IQ8D-BAT Microinverters



IQ Load Controller

Helps prioritize essential appliances during a grid outage to optimize energy consumption and prolong battery life

Smart

- Includes IQ Gateway for communication and control
- Includes Enphase Mobile Connect (CELLMODEM-M1-06-SP-05), only with IQ Combiner 5C
- Supports flexible networking: Wi-Fi, Ethernet, or cellular
- Provides production metering (revenue grade) and consumption monitoring

Easy to install

- Mounts to one stud with centered brackets
- Supports bottom, back, and side conduit entry
- Supports up to four 2-pole branch circuits for 240 VAC plug-in breakers (not included)
- 80 A total PV branch circuits

Reliable

- Durable NRTL-certified NEMA type 3R enclosure
- 5-year limited warranty
- Two years labor reimbursement program coverage included for both the IQ Combiner SKUs
- UL1741 listed



5-year
limited
warranty



IQ Combiner 5/5C

MODEL NUMBER	
IQ Combiner 5 (X-IQ-AM1-240-5)	IQ Combiner 5 with IQ Gateway printed circuit board for integrated revenue grade PV production metering (ANSI C12.20 $\pm 0.5\%$), consumption monitoring ($\pm 2.5\%$) and IQ Battery monitoring ($\pm 2.5\%$). Includes a silver solar shield to deflect heat
IQ Combiner 5C (X-IQ-AM1-240-5C)	IQ Combiner 5C with IQ Gateway printed circuit board for integrated revenue grade PV production metering (ANSI C12.20 $\pm 0.5\%$), consumption monitoring ($\pm 2.5\%$) and IQ Battery monitoring ($\pm 2.5\%$). Includes Enphase Mobile Connect cellular modem (CELLMODEM-M1-06-SP-05) ¹ . Includes a silver solar shield to deflect heat
WHAT'S IN THE BOX	
IQ Gateway printed circuit board	IQ Gateway is the platform for total energy management for comprehensive, remote maintenance and management of the Enphase IQ System
Busbar	125A busbar with support for 1 x IQ Gateway breaker and 4 x 20A breaker for installing IQ Series Microinverters and IQ Battery 5P
IQ Gateway breaker	Circuit breaker, 2-pole, 10 A/15 A
Production CT	Prewired revenue-grade solid core CT, accurate up to 0.5%
Consumption CT	Two consumption metering clamp CTs, shipped with the box, accurate up to 2.5%
IQ Battery CT	One battery metering clamp CT, shipped with the box, accurate up to 2.5%
CTRL board	Control board for wired communication with IQ System Controller 3/3G and the IQ Battery 5P
Enphase Mobile Connect (only with IQ Combiner 5C)	4G-based LTE-M1 cellular modem (CELLMODEM-M1-06-SP-05) with a 5-year T-Mobile data plan
Accessories kit	Spare control headers for CTRL board
ACCESSORIES AND REPLACEMENT PARTS (NOT INCLUDED, ORDER SEPARATELY)	
CELLMODEM-M1-06-SP-05	4G-based LTE-M1 cellular modem with a 5-year T-Mobile data plan
CELLMODEM-M1-06-AT-05	4G-based LTE-M1 cellular modem with a 5-year AT&T data plan
Circuit breakers (off-the-shelf)	Supports Eaton BR210, BR215, BR220, BR230, BR240, BR250, and BR260 circuit breakers Supports Eaton BR220B, BR230B, and BR240B circuit breakers compatible with hold-down kit
Circuit breakers (provided by Enphase)	BRK-10A-2-240V, BRK-15A-2-240V, BRK-20A-2P-240V, BRK-15A-2P-240V-B, and BRK-20A-2P-240V-B (More details in "Accessories" section)
XA-SOLARSHIELD-ES	Replacement solar shield for IQ Combiner 5/5C
XA-ENV2-PCBA-5	IQ Gateway replacement printed circuit board (PCB) for Combiner 5/5C
X-IQ-NA-HD-125A	Hold-down kit compatible with Eaton BR-B series circuit breakers (with screws)
ELECTRICAL SPECIFICATIONS	
Rating	80 A
System voltage	120/240 VAC, 60 Hz
Busbar rating	125 A
Fault current rating	10 kAIC
Maximum continuous current rating (input from PV/storage)	64 A
Branch circuits (solar and/or storage)	Up to four 2-pole Eaton BR series distributed generation (DG) breakers only (not included)
Maximum total branch circuit breaker rating (input)	80 A of distributed generation/95 A with IQ Gateway breaker included
IQ Gateway breaker	10 A or 15 A rating GE/Siemens/Eaton included
Production metering CT	200 A solid core pre-installed and wired to IQ Gateway
Consumption monitoring CT (CT-200-CLAMP)	A pair of 200 A clamp-style current transformers is included with the box
IQ Battery metering CT	200 A clamp-style current transformer for IQ Battery metering, included with the box

¹ A plug-and-play industrial-grade cell modem for systems up to 60 microinverters. (Available in the US, Canada, Mexico, Puerto Rico, and the US Virgin Islands, where there is adequate cellular service in the installation area.)

MECHANICAL DATA	
Dimensions (WxHxD)	37.5 cm x 49.5 cm x 16.8 cm (14.75" x 19.5" x 6.63"). Height is 21.06" (53.5 cm) with mounting brackets
Weight	7.5 kg (16.5 lbs)
Ambient temperature range	-40°C to 46°C (-40°F to 115°F)
Cooling	Natural convection, plus heat shield
Enclosure environmental rating	Outdoor, NRTL-certified, NEMA type 3R, polycarbonate construction
Wire sizes	• 20 A to 50 A breaker inputs: 14 to 4 AWG copper conductors • 60 A breaker branch input: 4 to 1/0 AWG copper conductors • Main lug combined output: 10 to 2/0 AWG copper conductors • Neutral and ground: 14 to 1/0 copper conductors • Always follow local code requirements for conductor sizing
Communication (In-premise connectivity)	Built-in CTRL board for wired communication with IQ Battery 5P and IQ System Controller 3/3G. Integrated Power Line Communication for IQ Series Microinverters
Altitude	Up to 2,600 meters (8,530 feet)
COMMUNICATION INTERFACES	
Integrated Wi-Fi	802.11b/g/n (dual band 2.4 GHz/5 GHz), for connecting the Enphase cloud via the internet
Wi-Fi range (recommended)	10 m
Ethernet	Optional, 802.3, Cat5E (or Cat 6) UTP Ethernet cable (not included), for connecting to the Enphase Cloud via the internet
Mobile Connect	CELLMODEM-M1-06-SP-05 or CELLMODEM-M1-06-AT-05 (included with IQ Combiner 5C)
Digital I/O	Digital input/output for grid operator control
USB 2.0	For Mobile Connect
Access point (AP) mode	For connection between the IQ Gateway and a mobile device running the Enphase Installer App
Metering ports	Up to two Consumption CTs, one IQ Battery CT, and one Production CT
Power line communication	90–110 kHz
Web API	Refer to https://developer-v4.enphase.com
Local API	Refer to guide for local API
COMPLIANCE	
IQ Combiner	UL 1741, CAN/CSA C22.2 No. 107.1, Title 47 CFR, Part 15, Class B, ICES 003
IQ Gateway	UL 60601-1/CANCSA 22.2 No. 61010-1, IEEE 1547: 2018 (UL 1741-SB, 3 rd Ed.) IEEE 2030.5/CSIP Compliant Production metering: ANSI C12.20 accuracy class 0.5 (PV production)
COMPATIBILITY	
IQ System Controller 3/3G	SC200D111C240US01, SC200G111C240US01
IQ Battery 5P	IQBATTERY-5P-1P-NA
Microinverter	IQ6, IQ7, and IQ8 Series Microinverters

Accessories



Enphase Mobile Connect

4G-based LTE-M1 cellular modem with a 5-year data plan
(CELLMODEM-M1-06-SP-05 for Sprint and
CELLMODEM-M1-06-AT-05 for AT&T)



Circuit breakers

BRK-10A-2-240V Circuit breaker, 2-pole, 10 A, Eaton BR210
BRK-15A-2-240V Circuit breaker, 2-pole, 15 A, Eaton BR215
BRK-20A-2P-240V Circuit breaker, 2-pole, 20 A, Eaton BR220
BRK-15A-2P-240V-B Circuit breaker, 2-pole, 15 A, Eaton BR215B
with hold-down kit support
BRK-20A-2P-240V-B Circuit breaker, 2-pole, 20 A, Eaton
BR220B with hold-down kit support



CT-200-SOLID

200 A revenue grade solid core Production CT
with <0.5% error rate (replacement SKU)



CT-200-CLAMP

200 A clamp-style consumption and battery
metering CT with <2.5% error rate (replacement
SKU)

Revision history

REVISION	DATE	DESCRIPTION
DSH-00007-1.0	May 2023	Initial release

Enphase Q Cable Accessories

The **Enphase Q Cable™** and accessories are part of the latest generation Enphase IQ System™. These accessories provide simplicity, reliability, and faster installation times.



Enphase Q Cable

- Two-wire, double-insulated Enphase Q Cable is 50% lighter than the previous generation Enphase cable
- New cable numbering and plug and play connectors speed up installation and simplify wire management
- Link connectors eliminate cable waste

Field-Wireable Connectors

- Easily connect Q cables on the roof without complex wiring
- Make connections from any open connector and center feed any section of cable within branch limits
- Available in male and female connector types

Enphase Q Cable Accessories

CONDUCTOR SPECIFICATIONS

Certification	UL3003 (raw cable), UL 9703 (cable assemblies), DG cable
Flame test rating	FT4
Compliance	RoHS, OIL RES I, CE, UV Resistant, combined UL for Canada and United States
Conductor type	THHN/THWN-2 dry/wet
Disconnecting means	The AC and DC bulkhead connectors have been evaluated and approved by UL for use as the load-break disconnect required by NEC 690.

Q CABLE TYPES / ORDERING OPTIONS

Connectorized Models	Size / Max Nominal Voltage	Connector Spacing	PV Module Orientation	Connector Count per Box
Q-12-10-240	12 AWG / 277 VAC	1.3 m (4.2 ft)	Portrait	240
Q-12-17-240	12 AWG / 277 VAC	2.0 m (6.5 ft)	Landscape (60-cell)	240
Q-12-20-200	12 AWG / 277 VAC	2.3 m (7.5 ft)	Landscape (72-cell)	200

ENPHASE Q CABLE ACCESSORIES

Name	Model Number	Description
Raw Q Cable	Q-12-RAW-300	300 meters of 12 AWG cable with no connectors
Field-wireable connector (male)	Q-CONN-10M	Make connections from any open connector
Field-wireable connector (female)	Q-CONN-10F	Make connections from any Q Cable open connector
Cable Clip	Q-CLIP-100	Used to fasten cabling to the racking or to secure looped cabling
Disconnect tool	Q-DISC-10	Disconnect tool for Q Cable connectors, DC connectors, and AC module mount
Q Cable sealing caps (female)	Q-SEAL-10	One needed to cover each unused connector on the cabling
Terminator	Q-TERM-10	Terminator cap for unused cable ends
Enphase EN4 to MC4 adaptor ¹	ECA-EN4-S22	Connect PV module using MC4 connectors to IQ micros with EN4 (TE PV4-S SOLARLOK). 150mm/5.9" to MC4.
Enphase EN4 non-terminated adaptor ¹	ECA-EN4-FW	For field wiring of UL certified DC connectors. EN4 (TE PV4-S SOLARLOK) to non-terminated cable. 150mm/5.9"
Enphase EN4 to MC4 adaptor (long) ¹	ECA-EN4-S22-L	Longer adapter cable for EN4 (TE PV4-S SOLARLOK) to MC4. Use with split cell modules or PV modules with short DC cable. 600mm/23.6"
Replacement DC Adaptor (MC4)	Q-DCC-2	DC adaptor to MC4 (max voltage 100 VDC)
Replacement DC Adaptor (UTX)	Q-DCC-5	DC adaptor to UTX (max voltage 100 VDC)

1. Qualified per UL subject 9703.




TERMINATOR

Terminator cap for unused cable ends, sold in packs of ten (Q-TERM-10)



SEALING CAPS

Sealing caps for unused aggregator and cable connections (Q-BA-CAP-10 and Q-SEAL-10)

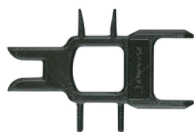

DISCONNECT TOOL

Plan to use at least one per installation, sold in packs of ten (Q-DISC-10)



CABLE CLIP

Used to fasten cabling to the racking or to secure looped cabling, sold in packs of one hundred (Q-CLIP-100)


To learn more about Enphase offerings, visit enphase.com



The Respect Your Roof Deserves

When integrating with a home, solar attachments must be dependable for the lifetime of the rooftop. Due to recent innovations, many asphalt shingles have bonded courses. A mount that protects without the need to pry shingles can really speed things up.

Halo UltraGrip®(HUG®) is here to respect the roof. Its Halo is a cast-aluminum barrier that encases the UltraGrip, our industrial-grade, foam-and-mastic seal. This allows HUG to accelerate the installation process and provide the utmost in waterproofing protection. Give your roof a HUG.®

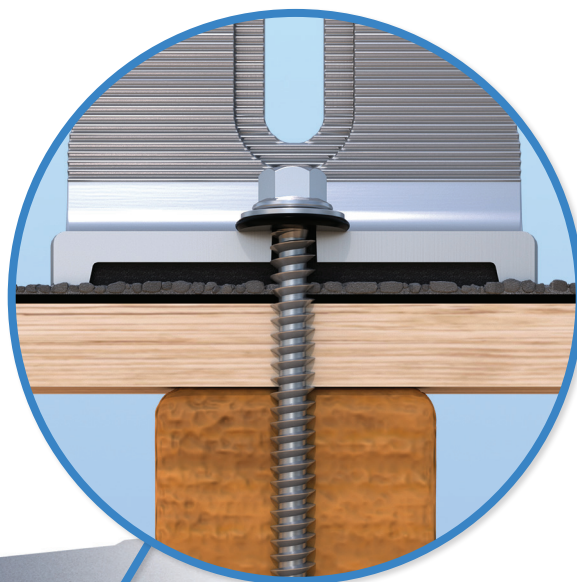

Multi-Tiered Waterproofing

HUG® utilizes a multi-tiered stack of components to provide revolutionary waterproofing protection. The Halo cast-aluminum, raised-perimeter foundation surrounds the UltraGrip base—a foam-backed mastic seal combination that prevents water intrusion by adhering and sealing with the shingle surface.

Halo UltraGrip™ is part of the QuickMount® product line.

UltraGrip® Seal Technology

HUG UltraGrip utilizes a state-of-the-art seal design that uses a unique, foam-and-mastic combination. The foam-backed adhesive provides an entirely new flashing system that conforms and adheres to every nook and cranny of composition shingles, filling gaps and shingle step-downs (up to 1/8" in height).



Rafter Mount



Deck Mount



Rafter & Deck Mounting Options

Mount HUG® to the roof rafters, the roof deck, or both with our custom-engineered RD (rafter-or-deck) Structural Screw. The RD Structural Screw anchors HUG to the roof with an EPDM sealing washer, completing the stack of waterproofing barriers. See backside for more installation information.



Triple Rated & Certified to Respect the Roof™
UL 2703, 441 (27)
TAS 100(A)-95

SEEKING BEFORE CONSTRUCTION
AS NOTED FOR PLAN REVIEW
DEVELOPMENT SERVICES
LEE'S SUMMIT, MISSOURI

06/26/2025

Adaptive, Rafter-Friendly Installation



Hit the rafter? Good to go!

When you find a rafter, you can move on. Only 2 RD Structural Screws are needed.



Miss the rafter? Try it again.


Place another screw to the left or right. If rafter is found, install 3rd and final screw.



Still no luck? Install the rest.

If more than 3 screws miss the rafter, secure six screws to deck mount it.

Trusted Strength & Less Hassle

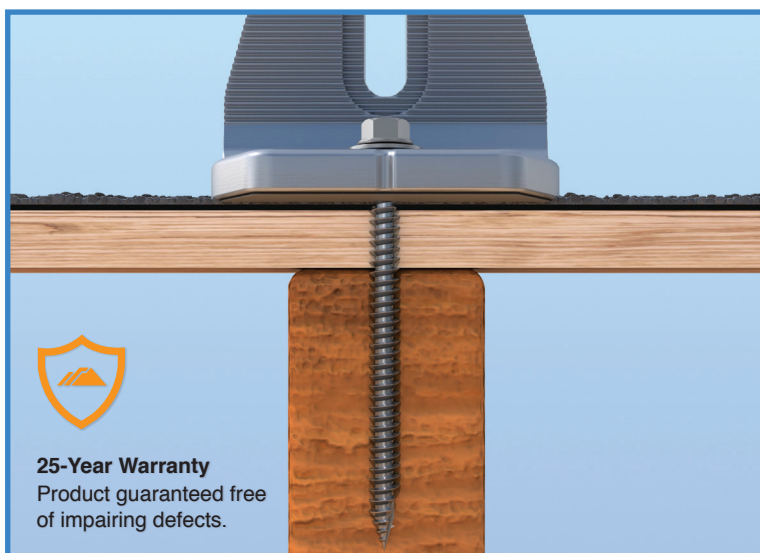

Structural capacities of HUG® were reviewed in many load directions, with racking rail running cross-slope or up-slope in relation to roof pitch.

For further details, see the HUG certification letters for attaching to rafters and decking.

IronRidge designed the HUG, in combination with the RD Structural Screw to streamline installs, which means the following:

- No prying shingles
- No roof nail interference
- No pilot holes necessary
- No sealant (in most cases)
- No butyl shims needed

Attachment Loading



The rafter-mounted HUG has been tested and rated to support 1004 (lbs) of uplift and 368 (lbs) of lateral load.

Structural Design



Parts are designed and certified for compliance with the International Building Code & ASCE/SEI-7.

Water Seal Ratings



HUG passed both the UL 441 Section 27 "Rain Test" and TAS 100(A)-95 "Wind Driven Rain Test" by Intertek.

UL 2703 System




Systems conform to UL 2703 mechanical and bonding requirements. See [Flush Mount Manual](#) for more info.

Solar Is Not Always Sunny

Over their lifetime, solar panels experience countless extreme weather events. Not just the worst storms in years, but the worst storms in 40 years. High winds capable of ripping panels from a roof, and snowfalls weighing enough to buckle a panel frame.

XR Rails® are the structural backbone preventing these results. They resist uplift, protect against buckling and safely and efficiently transfer loads into the building structure. Their superior spanning capability requires fewer roof attachments, reducing the number of roof penetrations and the amount of installation time.

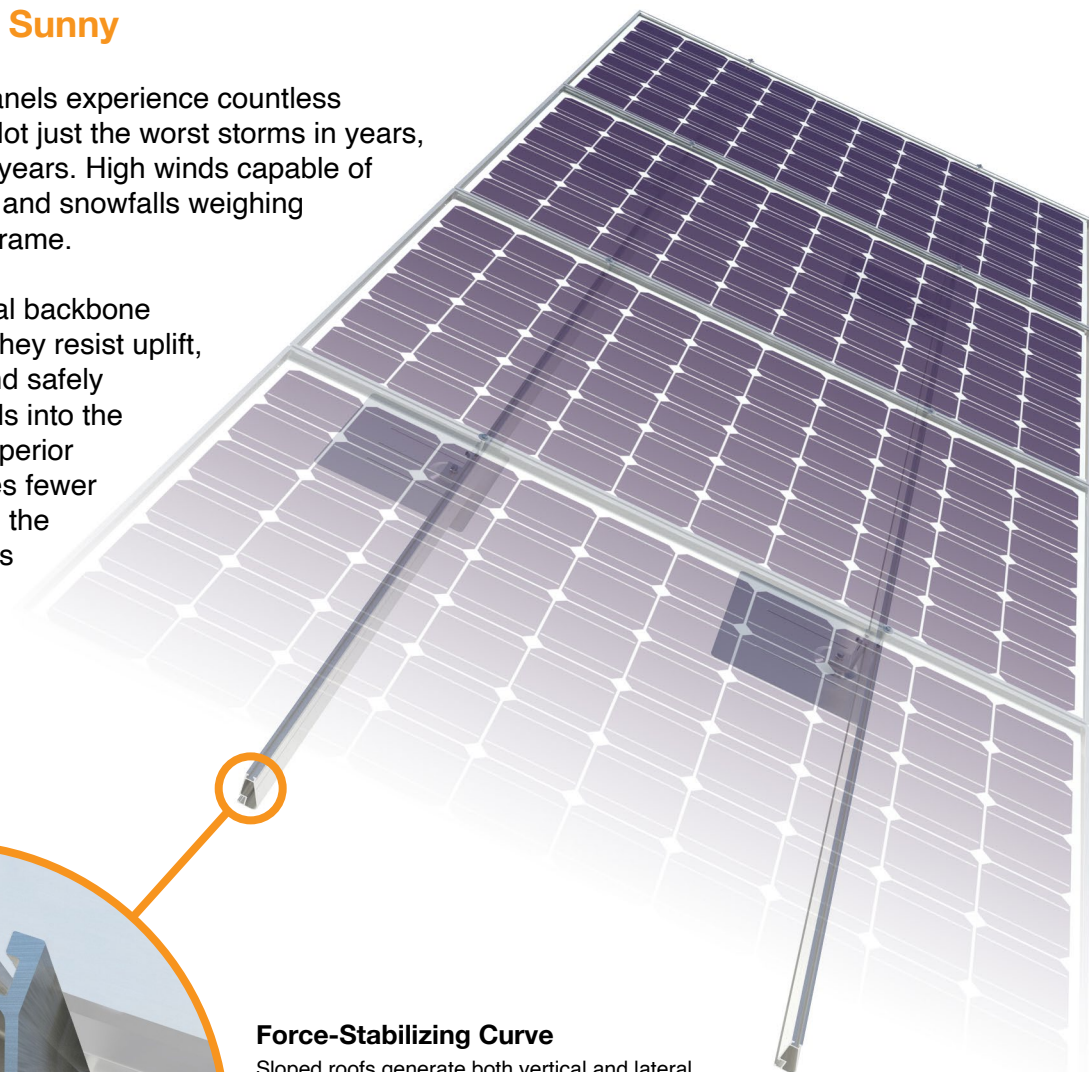

Force-Stabilizing Curve

Sloped roofs generate both vertical and lateral forces on mounting rails which can cause them to bend and twist. The curved shape of XR Rails® is specially designed to increase strength in both directions while resisting the twisting. This unique feature ensures greater security during extreme weather and a longer system lifetime.

Compatible with Flat & Pitched Roofs



XR Rails® are compatible with FlashFoot® and other pitched roof attachments.



IronRidge® offers a range of tilt leg options for flat roof mounting applications.

Corrosion-Resistant Materials

All XR Rails® are made of 6000-series aluminum alloy, then protected with an anodized finish. Anodizing prevents surface and structural corrosion, while also providing a more attractive appearance.



RELEASE FOR CONSTRUCTION
AS NOTED FOR PLAN REVIEW
DEVELOPMENT SERVICES
LEE'S SUMMIT, MISSOURI

06/26/2025

XR Rail® Family

The XR Rail® Family offers the strength of a curved rail in three targeted sizes. Each size supports specific design loads, while minimizing material costs. Depending on your location, there is an XR Rail® to match.



XR10

XR10 is a sleek, low-profile mounting rail, designed for regions with light or no snow. It achieves spans up to 6 feet, while remaining light and economical.


- 6' spanning capability
- Moderate load capability
- Clear & black anodized finish
- Internal splices available



XR100

XR100 is a residential and commercial mounting rail. It supports a range of wind and snow conditions, while also maximizing spans up to 10 feet.

- 10' spanning capability
- Heavy load capability
- Clear & black anodized finish
- Internal splices available

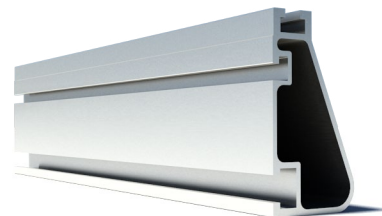

XR1000

XR1000 is a heavyweight among solar mounting rails. It's built to handle extreme climates and spans up to 12 feet for commercial applications.

- 12' spanning capability
- Extreme load capability
- Clear anodized finish
- Internal splices available

Rail Selection

The table below was prepared in compliance with applicable engineering codes and standards.* Values are based on the following criteria: ASCE 7-16, Gable Roof Flush Mount, Roof Zones 1 & 2e, Exposure B, Roof Slope of 8 to 20 degrees and Mean Building Height of 30 ft. Visit IronRidge.com for detailed certification letters.

Load		Rail Span					
Snow (PSF)	Wind (MPH)	4'	5' 4"	6'	8'	10'	12'
None	90	XR10			XR100		XR1000
	120						
	140						
	160						
20	90	XR10			XR100		XR1000
	120						
	140						
	160						
30	90	XR10			XR100		XR1000
	160						
40	90	XR10			XR100		XR1000
	160						
80	160	XR10			XR100		XR1000
120	160	XR10			XR100		XR1000

*Table is meant to be a simplified span chart for conveying general rail capabilities. Use approved certification letters for detailed engineering services.

RELEASE FOR CONSTRUCTION
AS NOTED FOR PLAN REVIEW
DEVELOPMENT SERVICES
LEE'S SUMMIT, MISSOURI

06/26/2025