




TYPICAL WALL PACK DETAIL (B, B1 & B2)
SCALE: NTS

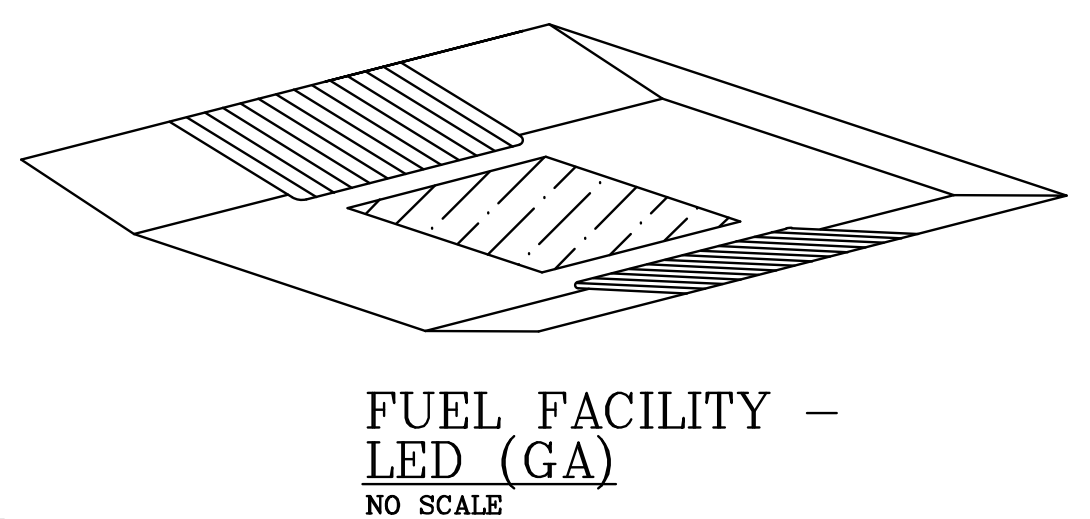

LIGHTING FIXTURE SCHEDULE							
TYPE	MANUFACTURER	NUMBER	LAMPS	MOUNT	WATT	REMARKS	COLOR
P	COOPER	GALN-SA8B-740-U-SWQ-BZ	LED	POLE	325	36"-6" ABOVE FINISHED GRADE. ROUND TAPERED FIBERGLASS/FIBERGLASS POLE	4000K
P1	COOPER	GALN-SA6B-740-U-SL3-HSS	LED	POLE	243	WALMONT (COSTCO-150-10-36.5 POLE). NUMBER OF HEADS SHALL BE PER PLAN. SEE DETAIL SHEET SE-1. FIXTURE SHALL BE POWDER PAINTED.	
P2	COOPER	GALN-SA4B-740-U-SLR-HSS	LED	POLE	164	ELECTRO-STATIC APPLICATION. POLE SHALL HAVE MIN EPA=10 FOR 150 MPH WIND.	
P3	COOPER	GALN-SA4B-740-U-SLL-HSS	LED	POLE	164		

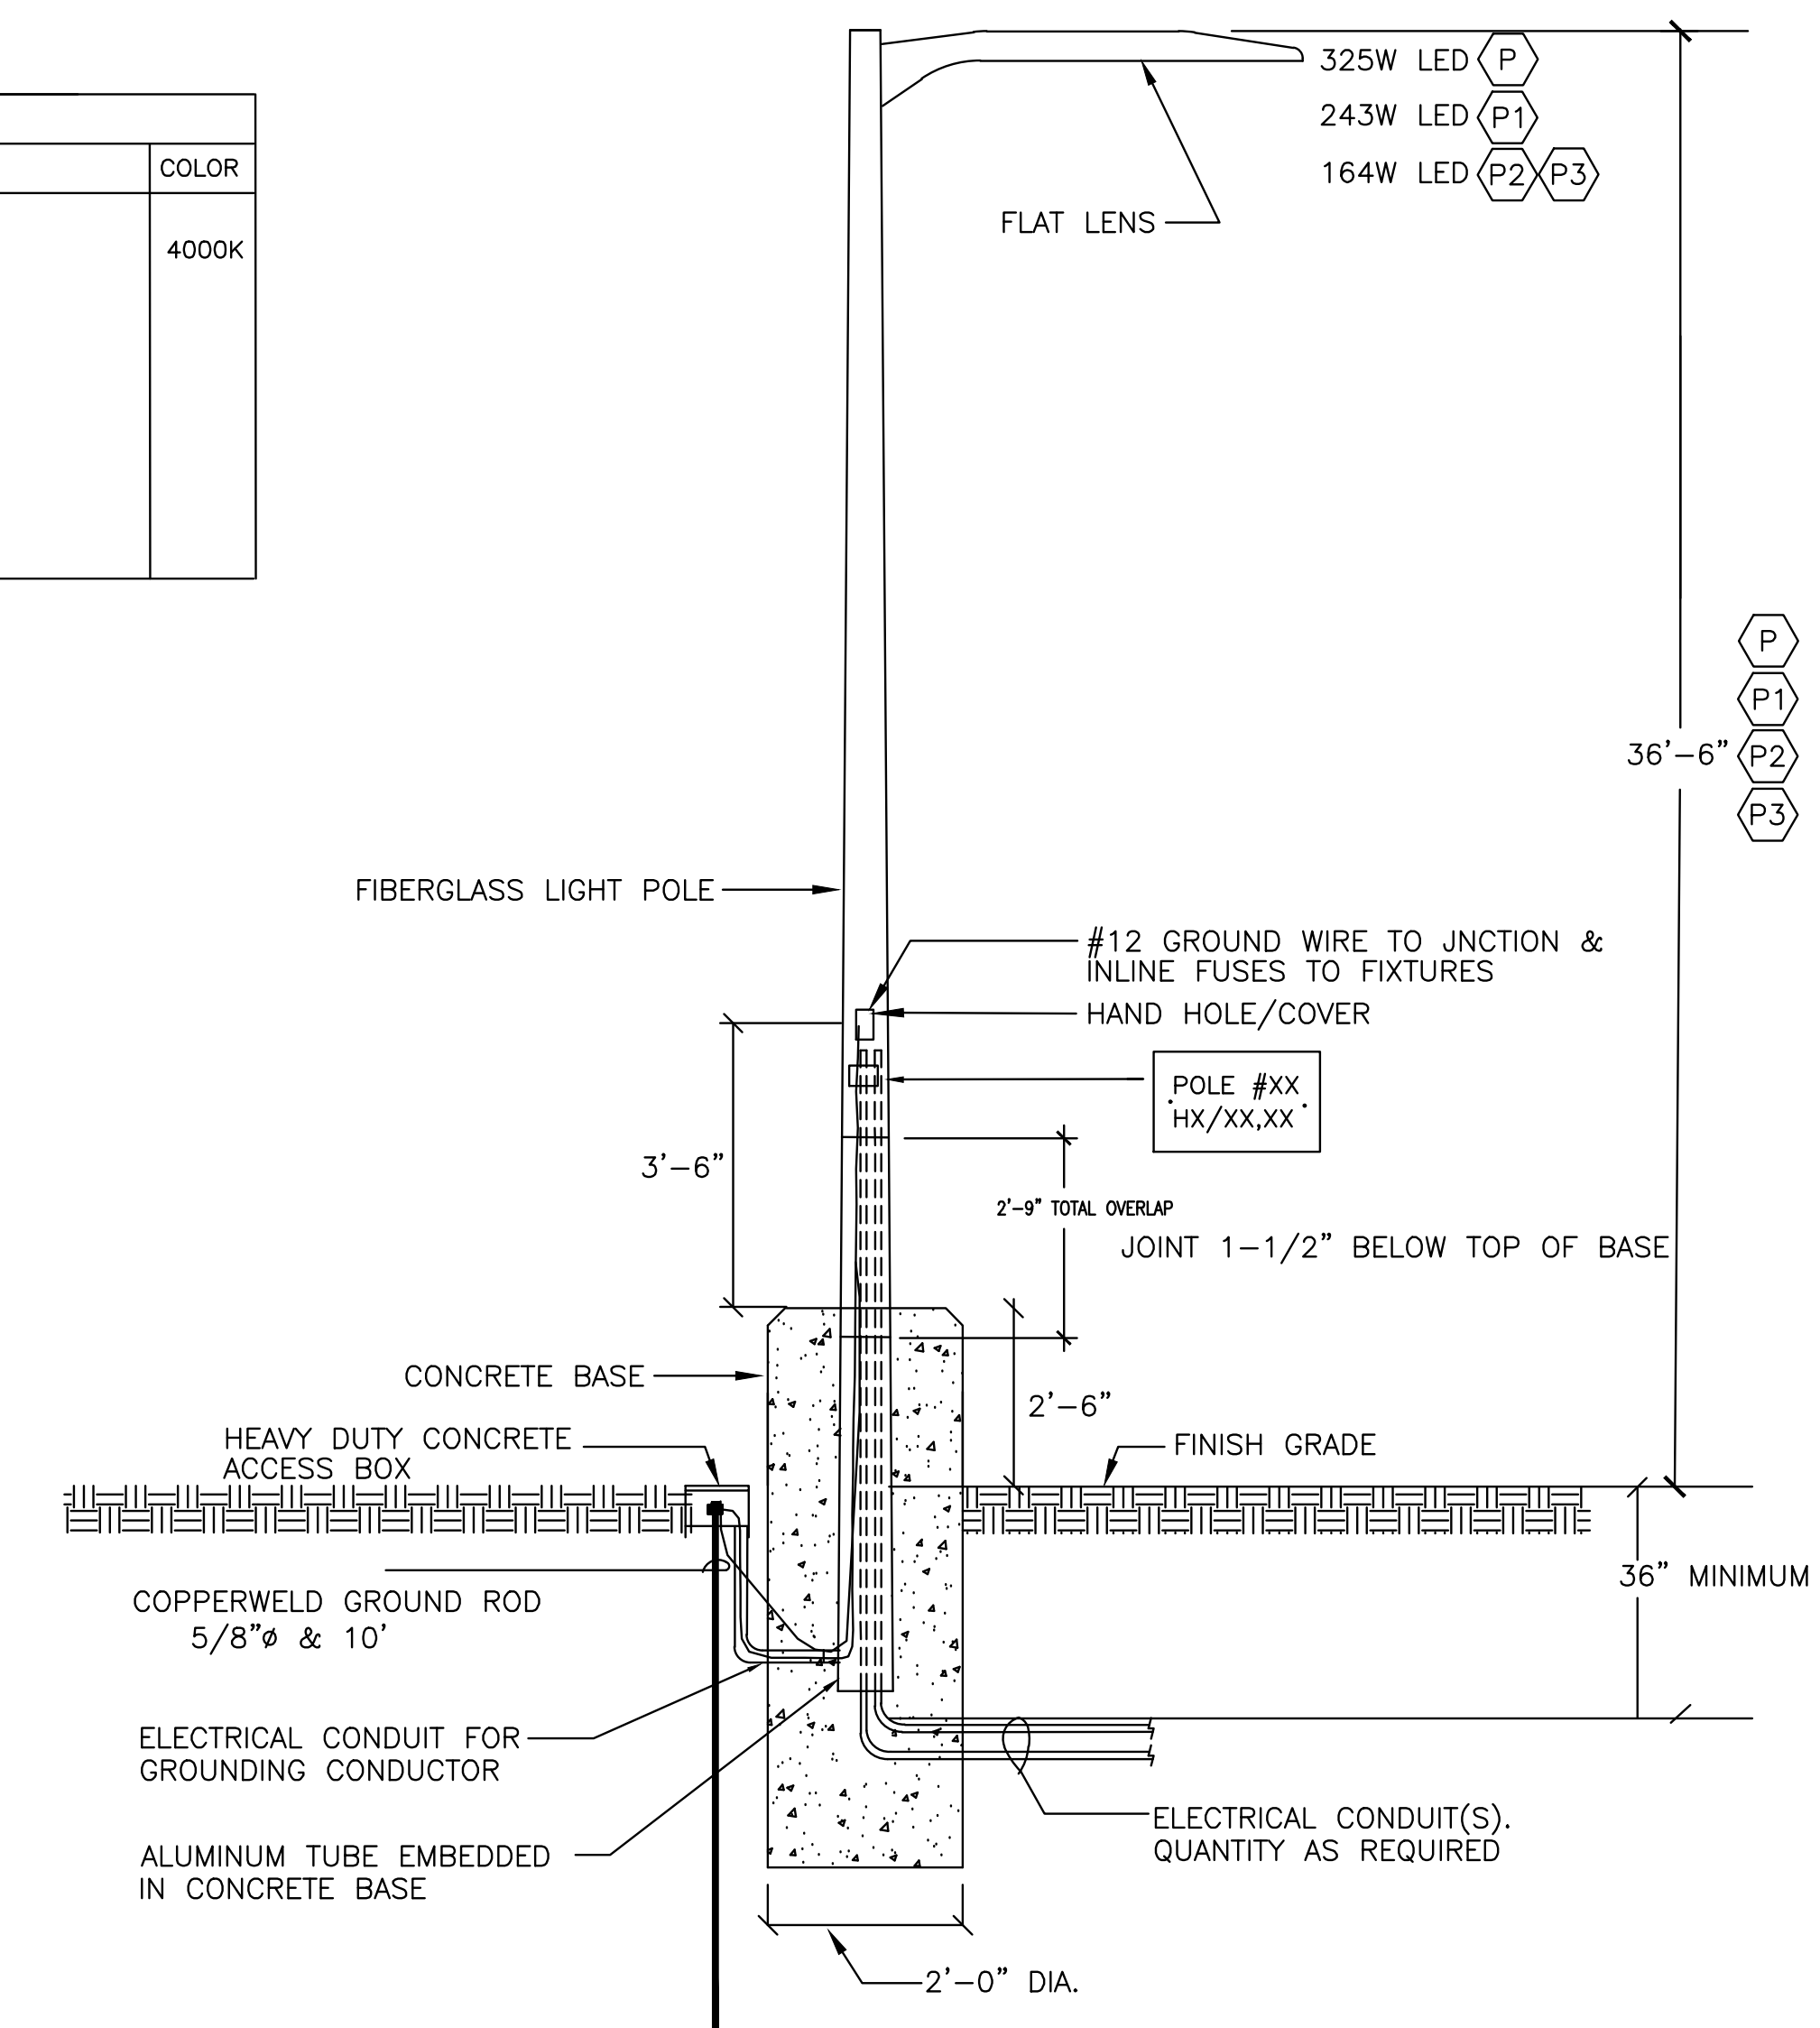


POLE DETAIL
SCALE: NTS

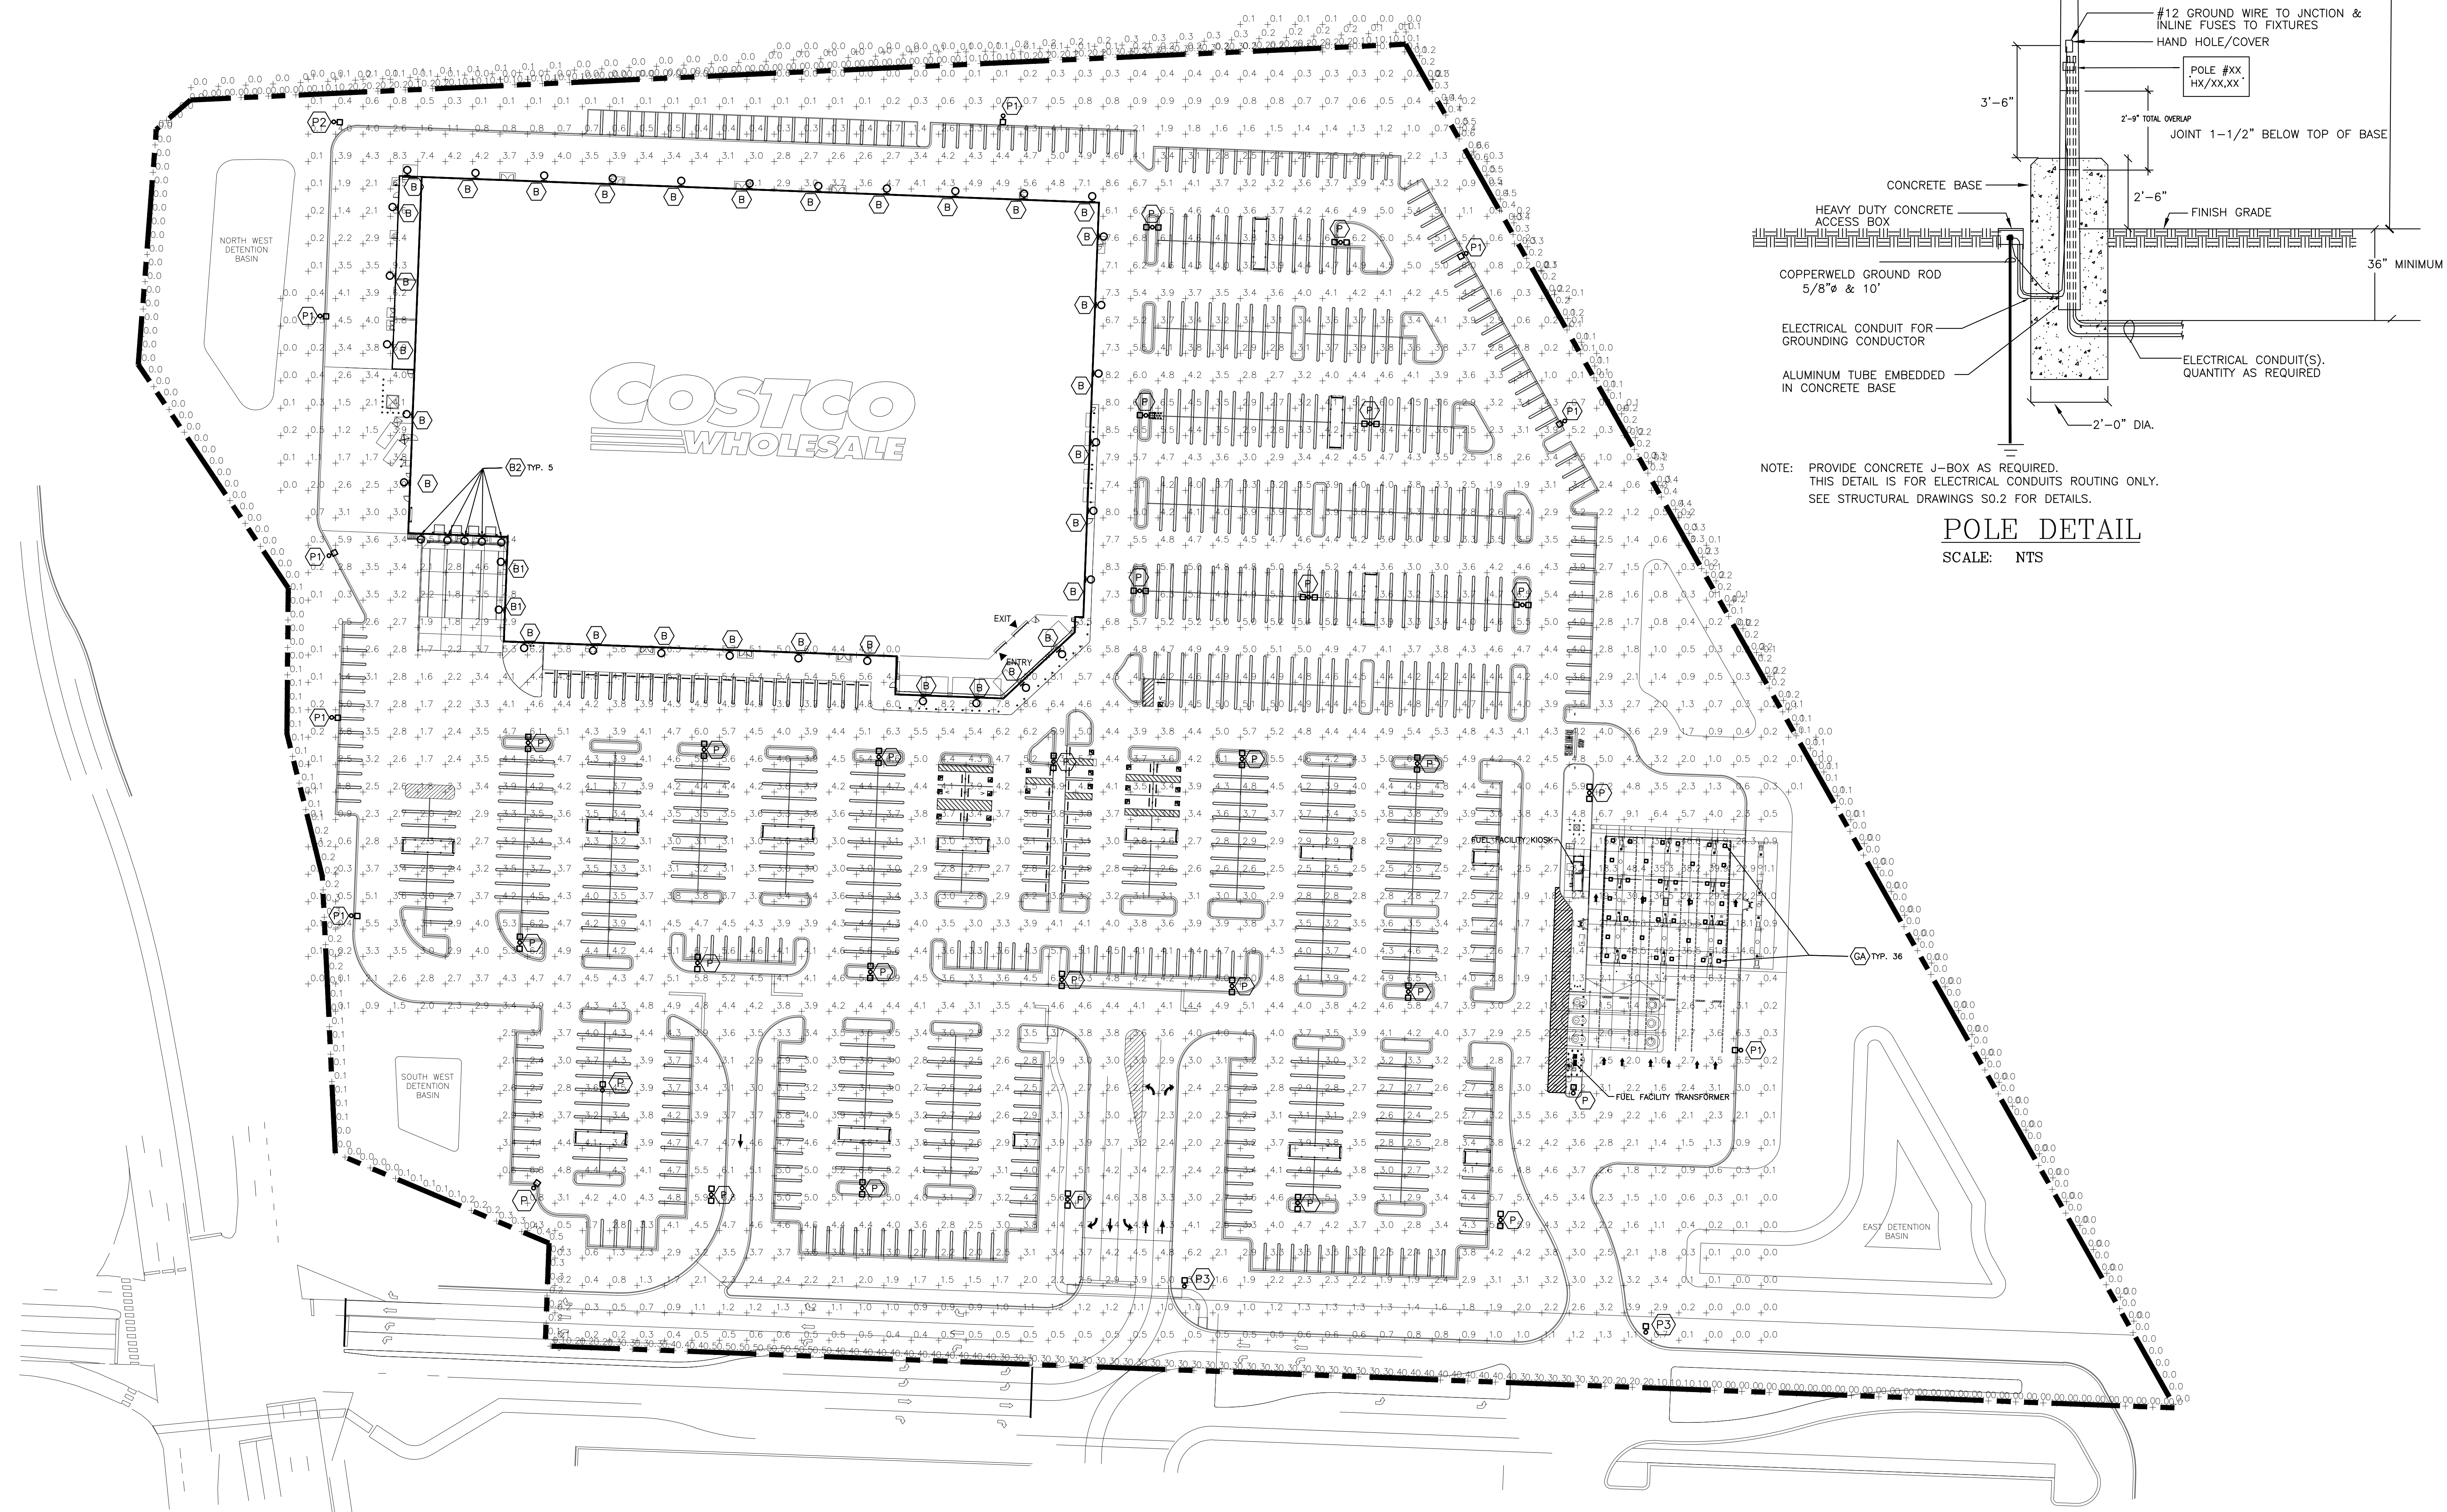

SITE PHOTOMETRIC PLAN
SCALE: 1" = 50'-0"


SITE ELECTRICAL PLAN
 PROJECT NO: 25-346
 NO PART OF THIS DOCUMENT MAY BE USED OR COPIED IN WHOLE OR IN PART WITHOUT THE PRIOR WRITTEN CONSENT OF T.E.I.N.C.
 ARCHITECT REFERENCE NO:
 DD PACKAGE
 T.E., Inc.
 830 N. RIVERSIDE DRIVE
 SUITE #200
 RENTON, WA 98057
 PHONE: 425-970-3763
 FAX: 425-970-3766
 LEE'S SUMMIT, MO
 FOR QA REVIEW, NOT FOR CONSTRUCTION
 REVISION DATE:
 ISSUE DATE: JULY 2025
 DRAWN: MW
 CHECKED: HW

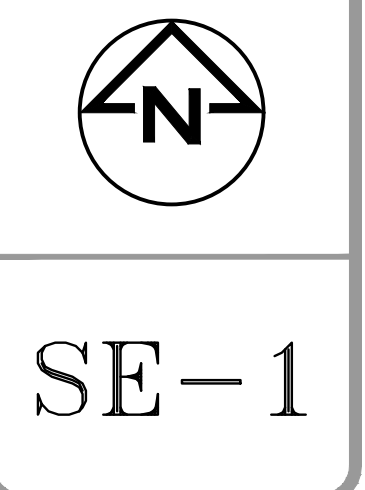

SE-1



DD PACKAGE

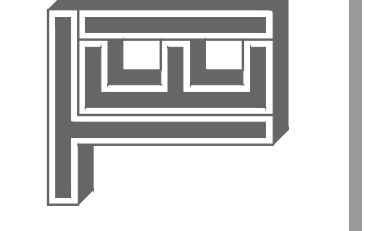

T.E., Inc.
830 N. RIVERSIDE DRIVE
SUITE #200
RENTON, WA 98057
PHONE: 425-970-3763
FAX: 425-970-3766