


VILLAGE AT VIEW HIGH
ON-SITE WATER LINE CONSTRUCTION PLANS
PART OF THE NW 1/4, SECTION 03-T.47-R.32
LEE'S SUMMIT, JACKSON COUNTY, MISSOURI

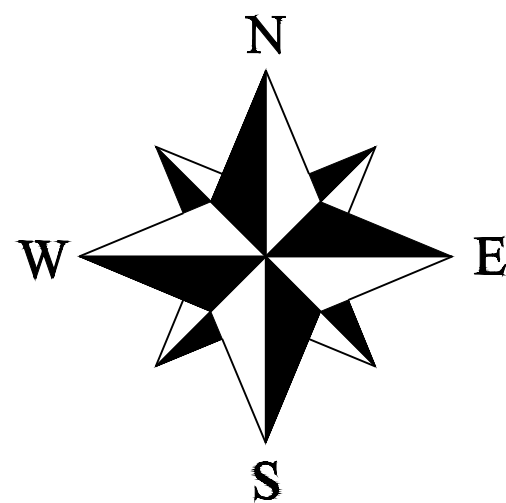

WATER:

1 ~ THE CONTRACTOR SHALL COORDINATE WITH THE PUBLIC WORKS INSPECTOR PRIOR TO ANY CONNECTIONS TO THE PUBLIC WATER SUPPLY.

2 ~ ALL WATER MAINS SHALL COMPLY WITH ANSI/AWWA C150/A21.50 AND C151/A21.51, AND CITY OF LEES SUMMIT STANDARDS.

3 ~ FIRE HYDRANTS SHALL BE OPTIC YELLOW WATEROUS "PACER" MODEL NO. WB-67-250 WITH NON-RISING STEM OR CITY ENGINEER APPROVED EQUAL. HYDRANTS SHALL HAVE A 5 1/4" VALVE WITH A 4 1/2" PUMPER NOZZLE AND 2 - 2 1/2" HOSE NOZZLES (LEFT HAND OPENING).

4 ~ GATE VALVES SHALL BE MUELLER NO. A 2380-5 HUB END "O" RING SEAL NON-RISING STEM. VALVES 12" OR LARGER SHALL BE BUTTERFLY VALVES MANUFACTURED BY THE HENRY PRATT COMPANY OR CITY ENGINEER APPROVED EQUAL. LEFT HAND OPENING. MINIMUM 200# TESTING AWWA.

5 ~ VALVE BOXES SHALL BE CLAY & BAILEY NO. P-108 OR CITY ENGINEER APPROVED EQUAL. ALL VALVE BOXES SHALL BE LOCATED OUT OF EXISTING OR PROPOSED PAVEMENT AREAS.

6 ~ ALL WATER MAINS SHALL BE CONSTRUCTED WITH A MINIMUM COVER OF 42 INCHES. STREET GRADING SHALL BE COMPLETED PRIOR TO BEGINNING CONSTRUCTION OF WATER MAINS.

7 ~ ALL BENDS, TEES AND FIRE HYDRANTS SHALL BE INSTALLED WITH SUITABLE CONCRETE THRUST BLOCKS POURED IN PLACE AGAINST UNDISTURBED EARTH AND PER CITY OF LEES SUMMIT AND APWA STANDARDS.

8 ~ THE MINIMUM SEPARATION BETWEEN THE PROPOSED WATER MAIN AND SANITARY OR STORM SEWERS IS AS FOLLOWS:


A ~ SANITARY SEWERS: HORIZONTAL = 10 FEET - VERTICAL = 18 INCHES

B ~ STORM SEWERS: HORIZONTAL = 5 FEET - VERTICAL = 18 INCHES

THESE SEPARATIONS SHALL PREVAIL OVER ANY DATA SHOWN IN THESE PLANS AND THE CONTRACTOR SHALL INSTALL BENDS OR OTHER FITTINGS AS NECESSARY TO ACHIEVE THE REQUIRED SEPARATIONS.

9 ~ ALL CONSTRUCTION SHALL FOLLOW THE CITY OF LEE'S SUMMIT DESIGN AND CONSTRUCTION MANUAL AS ADOPTED BY ORDINANCE 5813

10 ~ Areas where proposed pipe is above existing grade, embankment shall be placed and compacted prior to installing the pipe. Embankment shall be placed to finished grade, prior to trenching for pipe installation. For pipes deeper than 4 feet from finished grade, trenching may take place when the embankment is at least 4 feet above the proposed top of pipe elevation.

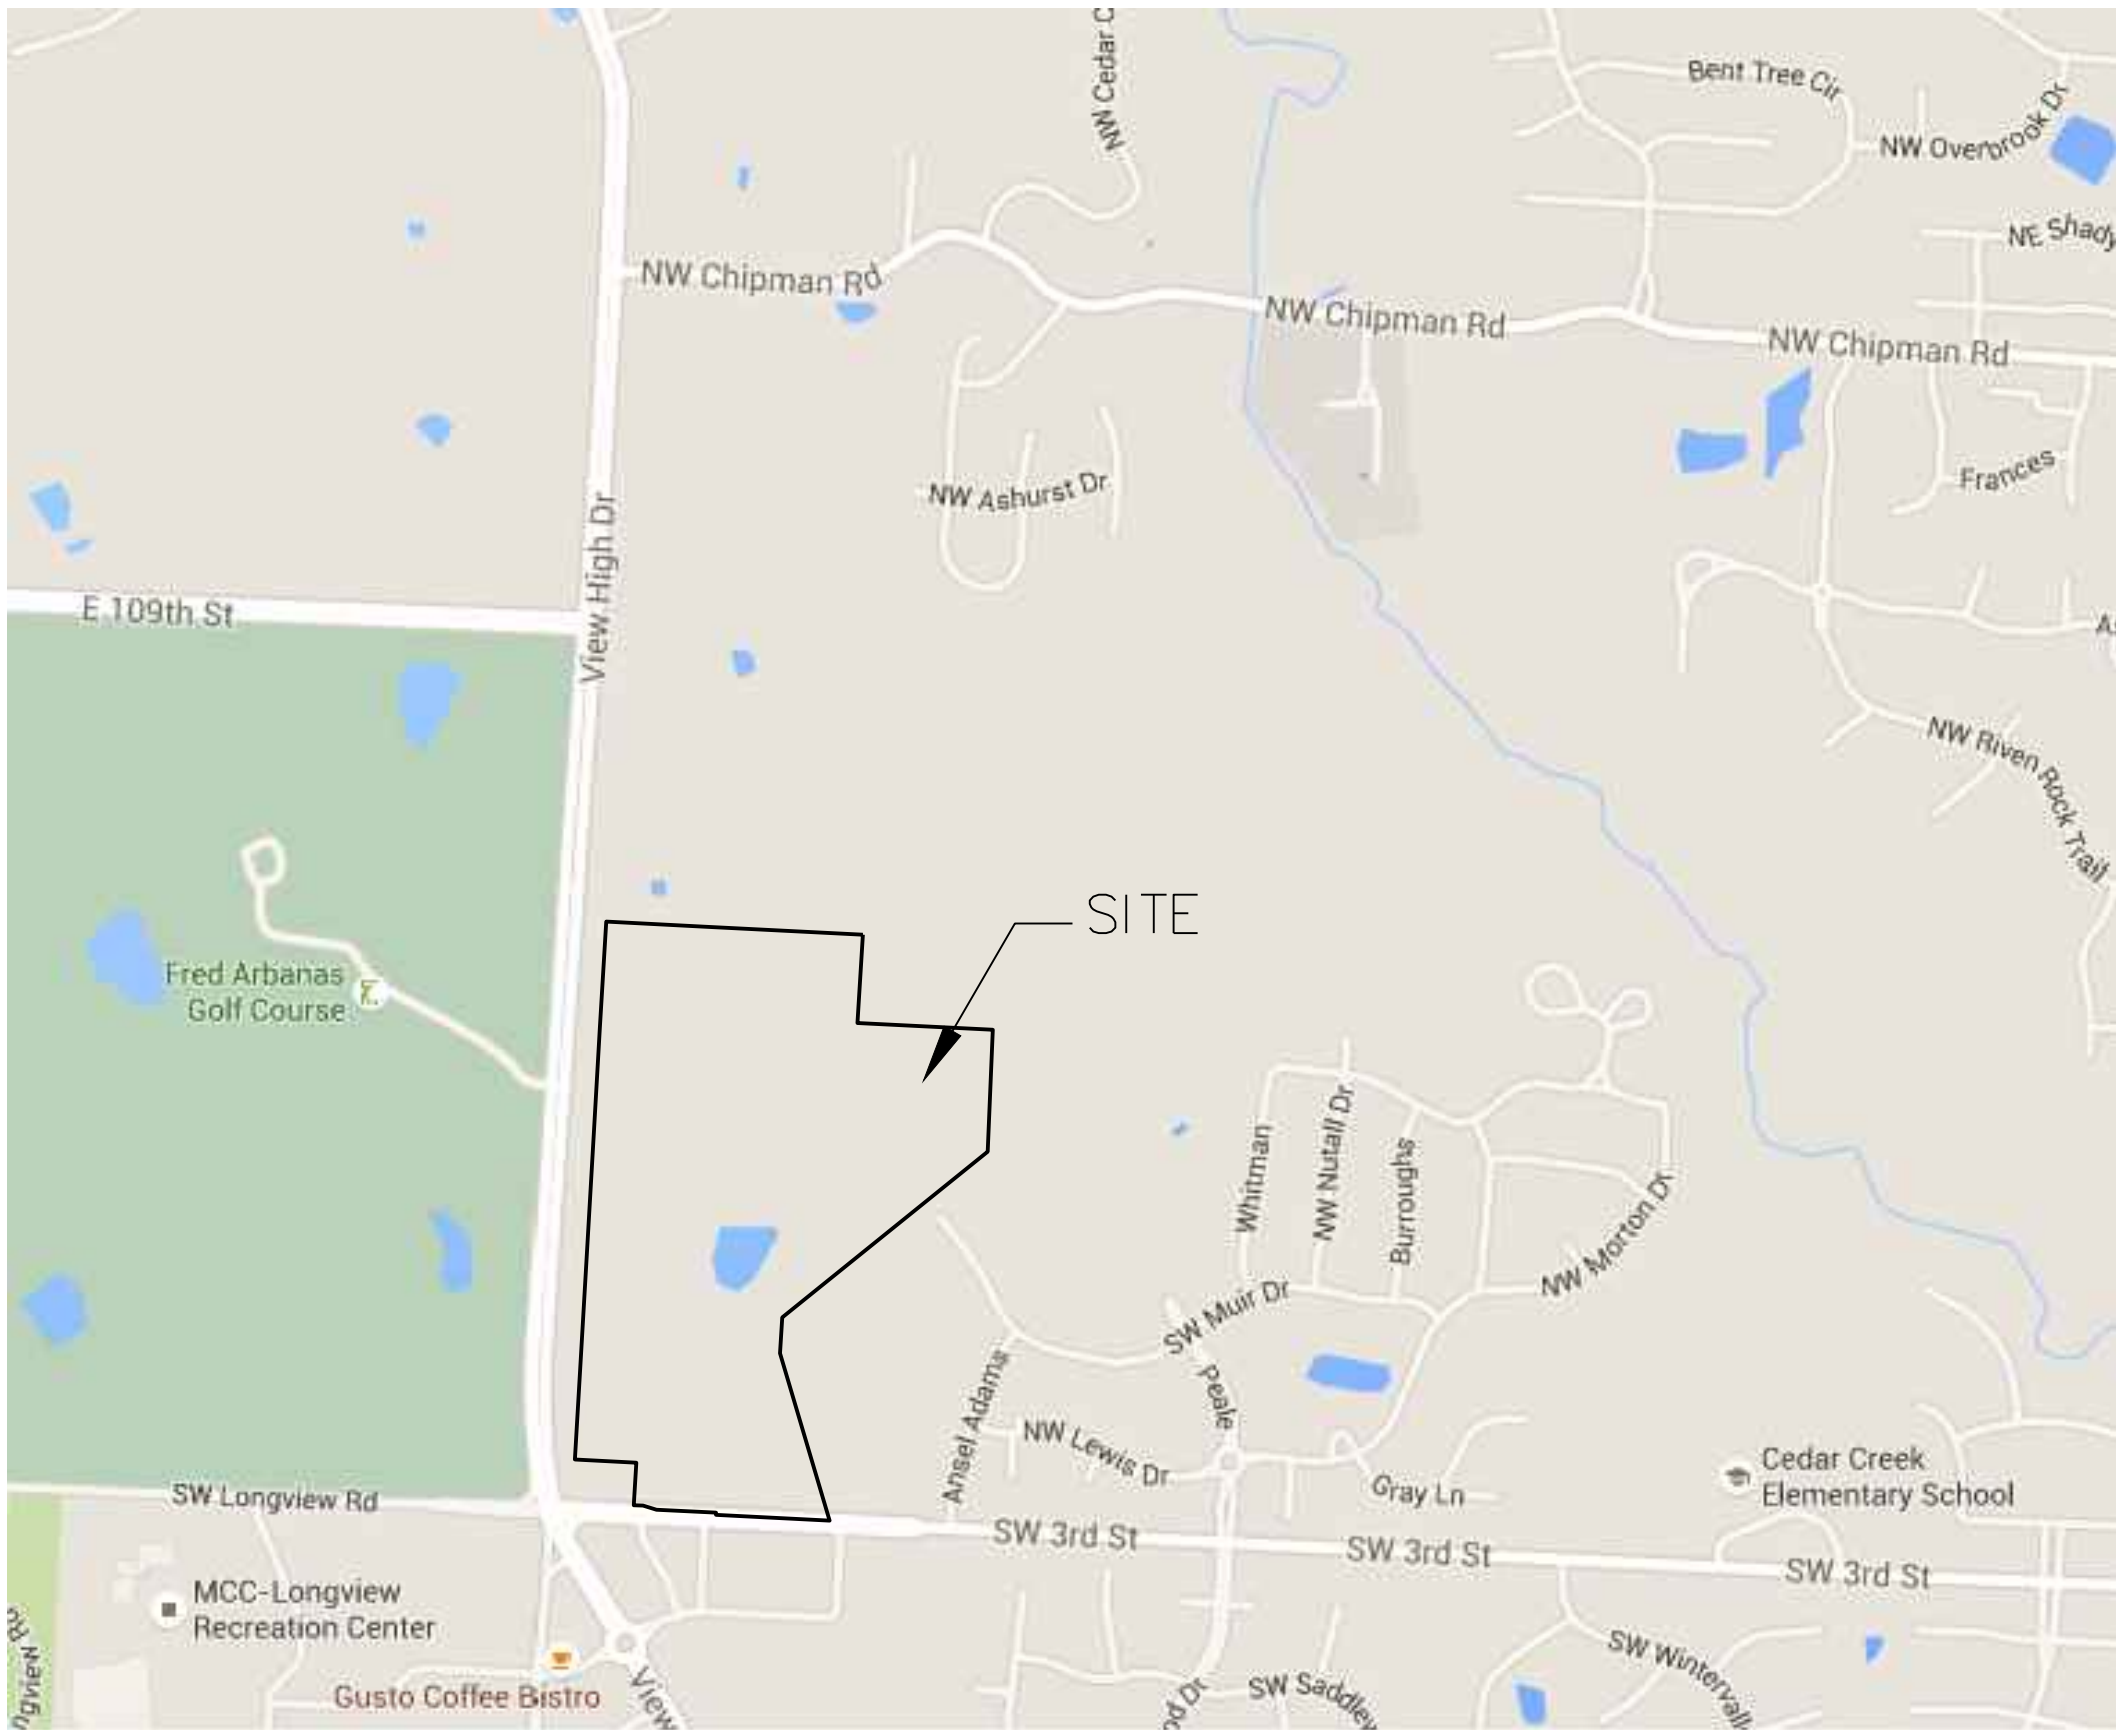

SITE LOCATION MAP

INDEX OF SHEETS:

- C.500 ~ COVER SHEET
- C.501 ~ WATER LINE GENERAL LAYOUT
- C.502 ~ WATER MAIN PLAN & PROFILE
- C.503 ~ WATER MAIN PLAN & PROFILE
- C.504 ~ WATER MAIN PLAN & PROFILE
- C.505 ~ DETAIL SHEET

UTILITY COMPANIES:

THE FOLLOWING LIST OF UTILITY COMPANIES IS PROVIDED FOR INFORMATION ONLY. WE DO NOT OFFER ANY GUARANTEE OR WARRANTY THAT THIS LIST IS COMPLETE OR ACCURATE. THE CONTRACTOR SHALL BE RESPONSIBLE FOR CONTACTING ALL UTILITY COMPANIES THAT MAY BE AFFECTED BY THE PROPOSED CONSTRUCTION AND VERIFYING THE ACTUAL LOCATION OF EACH UTILITY LINE. THE CONTRACTOR SHALL NOTIFY ENGINEERING SOLUTIONS AT 816.623.9888 OF ANY CONFLICT WITH PROPOSED IMPROVEMENTS.

- KCP&L ~ 298-1198
- MISSOURI GAS ENERGY ~ 756-5261
- SOUTHWESTERN BELL TELEPHONE ~ 761-5011
- COMCAST CABLE ~ 795-1100
- WILLIAMS PIPELINE ~ 422-6300
- CITY OF LEE'S SUMMIT PUBLIC WORKS ~ 969-1800
- CITY OF LEE'S SUMMIT PUBLIC WORKS INSPECTIONS ~ 969-1800
- CITY OF LEE'S SUMMIT WATER UTILITIES ~ 969-1900
- MISSOURI ONE CALL (DIG RITE) ~ 1-800-344-7483

LEGEND:

- B/L ~ BUILDING SET-BACK
- C/A ~ COMMON AREA
- D/E ~ DRAINAGE EASEMENT
- FND. ~ FOUND
- L/E ~ LANDSCAPE EASEMENT
- L.N.A. ~ LIMITS OF NO ACCESS
- R/W ~ RIGHT OF WAY
- SAN ~ SANITARY SEWER LINE
- S/W ~ SIDEWALK
- U/E ~ UTILITY EASEMENT
- W ~ WATER LINE
- ST ~ STORM SEWER LINE

ENGINEER'S CERTIFICATION:

I HEREBY CERTIFY THAT THIS PROJECT HAS BEEN DESIGNED AND THESE PLANS PREPARED IN ACCORDANCE WITH THE CURRENT DESIGN CRITERIA OF THE CITY OF LEE'S SUMMIT, MISSOURI AND THE STATE OF MISSOURI. I FURTHER CERTIFY THAT THESE PLANS WERE DESIGNED IN ACCORDANCE TO AASHTO STANDARDS.

CITY OF LEE'S SUMMIT, MISSOURI

APPROVED: DATE: _____


BY: _____
CITY ENGINEER

 

Water Main Cover Sheet
Construction Plans for:
Village at View High
Lee's Summit, Jackson County, Missouri

Project:
View High Project
Issue Date:
July 22, 2016

Matthew J. Schlicht
MO PE 2006019708
KS PE 19071
OK PE 25226


REVISIONS
REV. 9-20-17
REV. 10-11-17

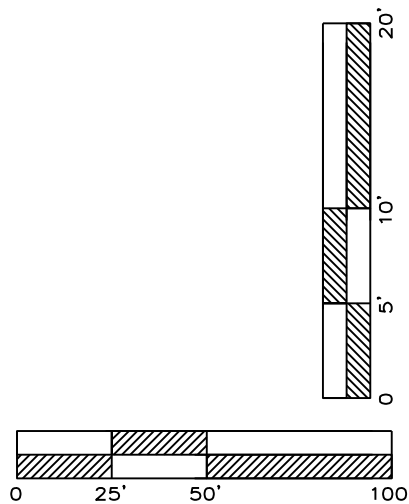

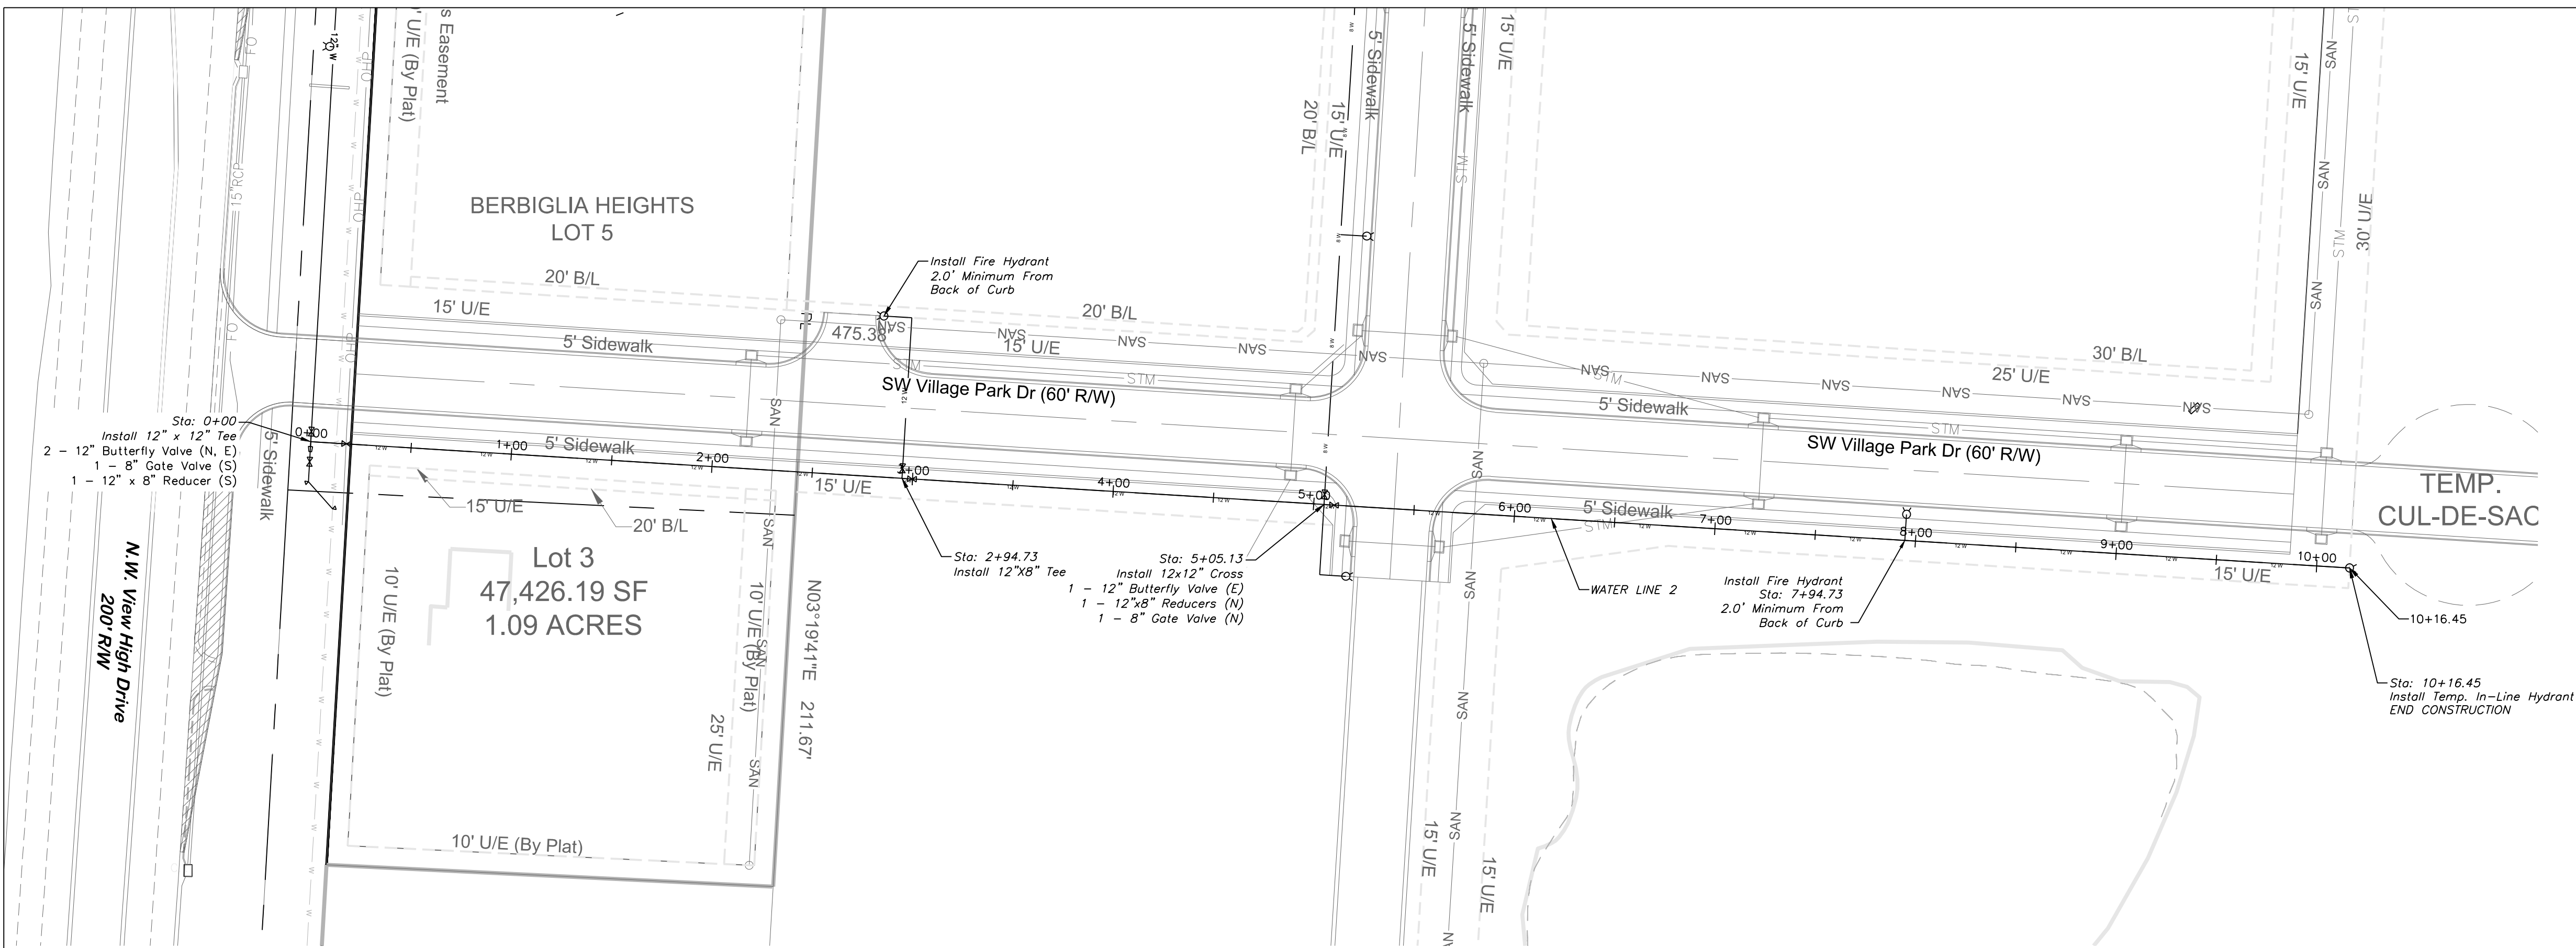


WATER PLAN & PROFILE
SCALE: 1" = 50'

WATER LINE 2

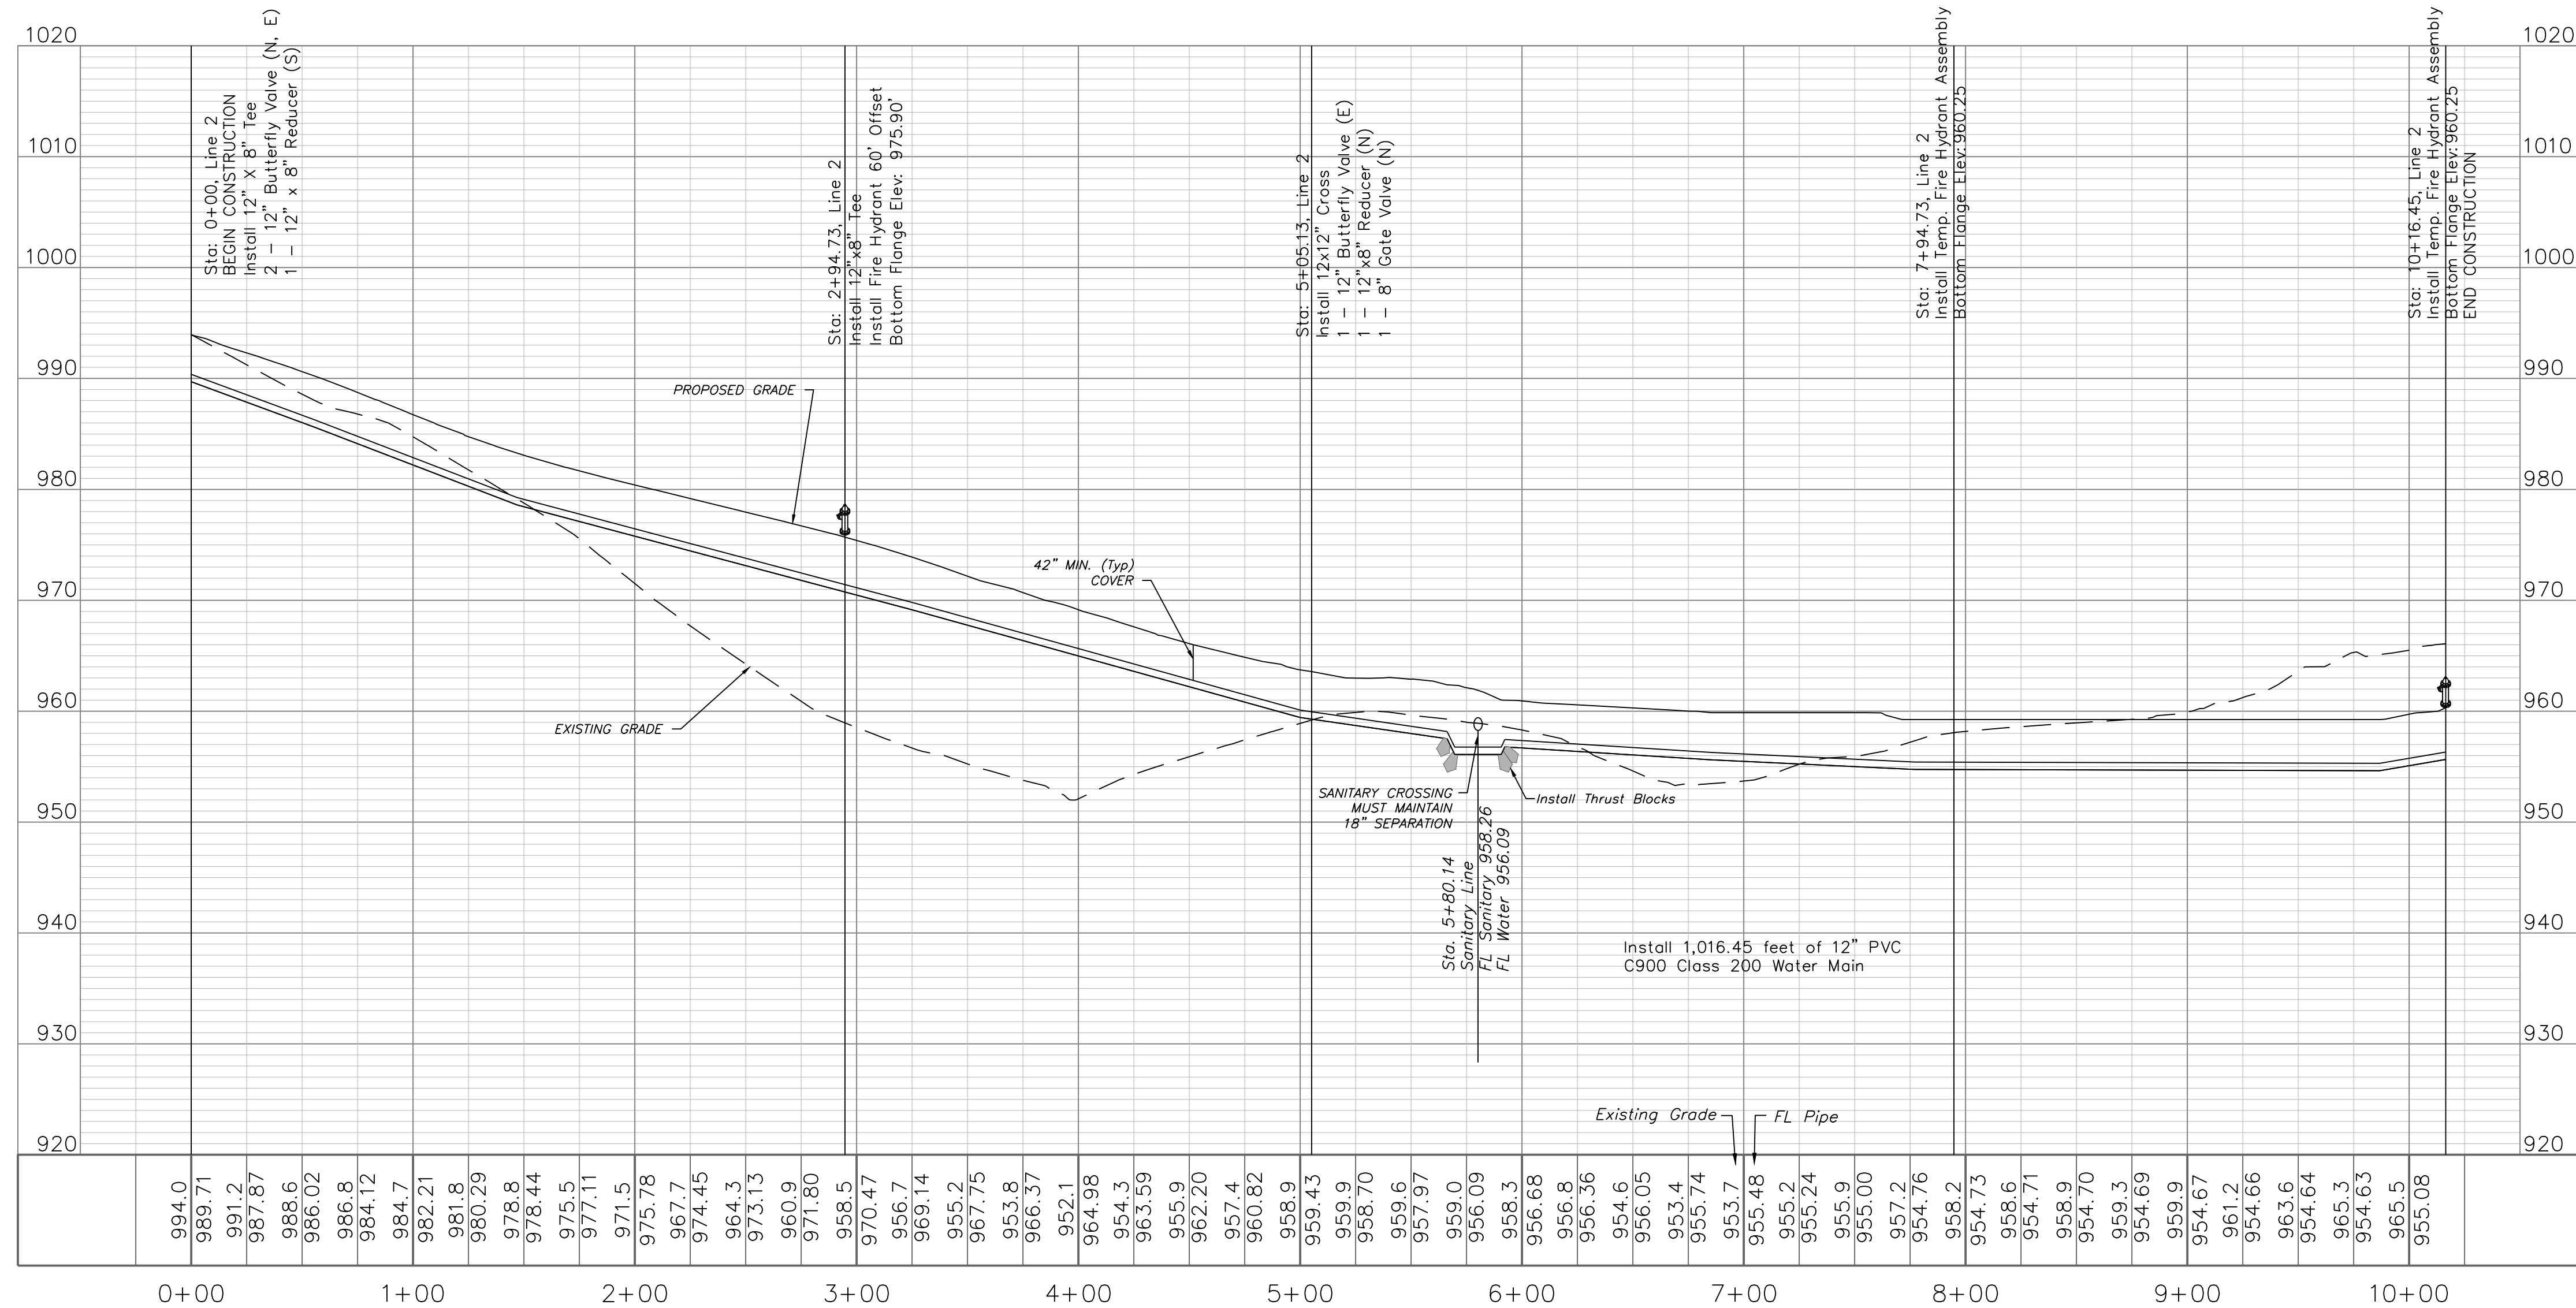

NOTE:
WATER MAINS SHALL NOT EXCEED
7 FEET IN DEPTH AS MEASURED
TO THE TOP OF THE PIPE.

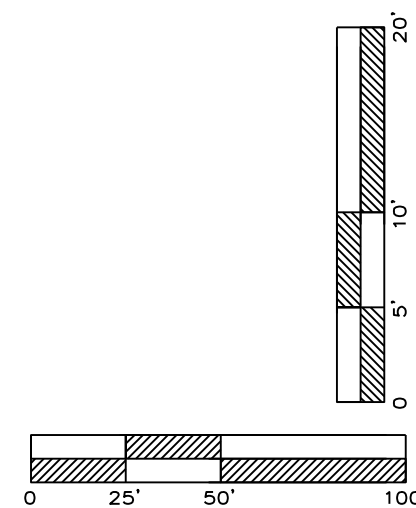

Water Line Plan and Profile
Construction Plans for:
Village at View High
Lee's Summit, Jackson County, Missouri

Village At View High
Lee's Summit, Jackson County, Missouri

Professional Registration
Missouri
Engineering 2005002186-D
Surveying 2005003182-D
Kansas
Engineering E-1895
Surveying LS-218
Oklahoma
Engineering 6254
Nebraska
Engineering CA2821

Matthew J. Schlicht
MO PE 2006019708
KS PE 19071
OK PE 25226

REVISIONS
REV. 9-20-17
REV. 10-11-17

