



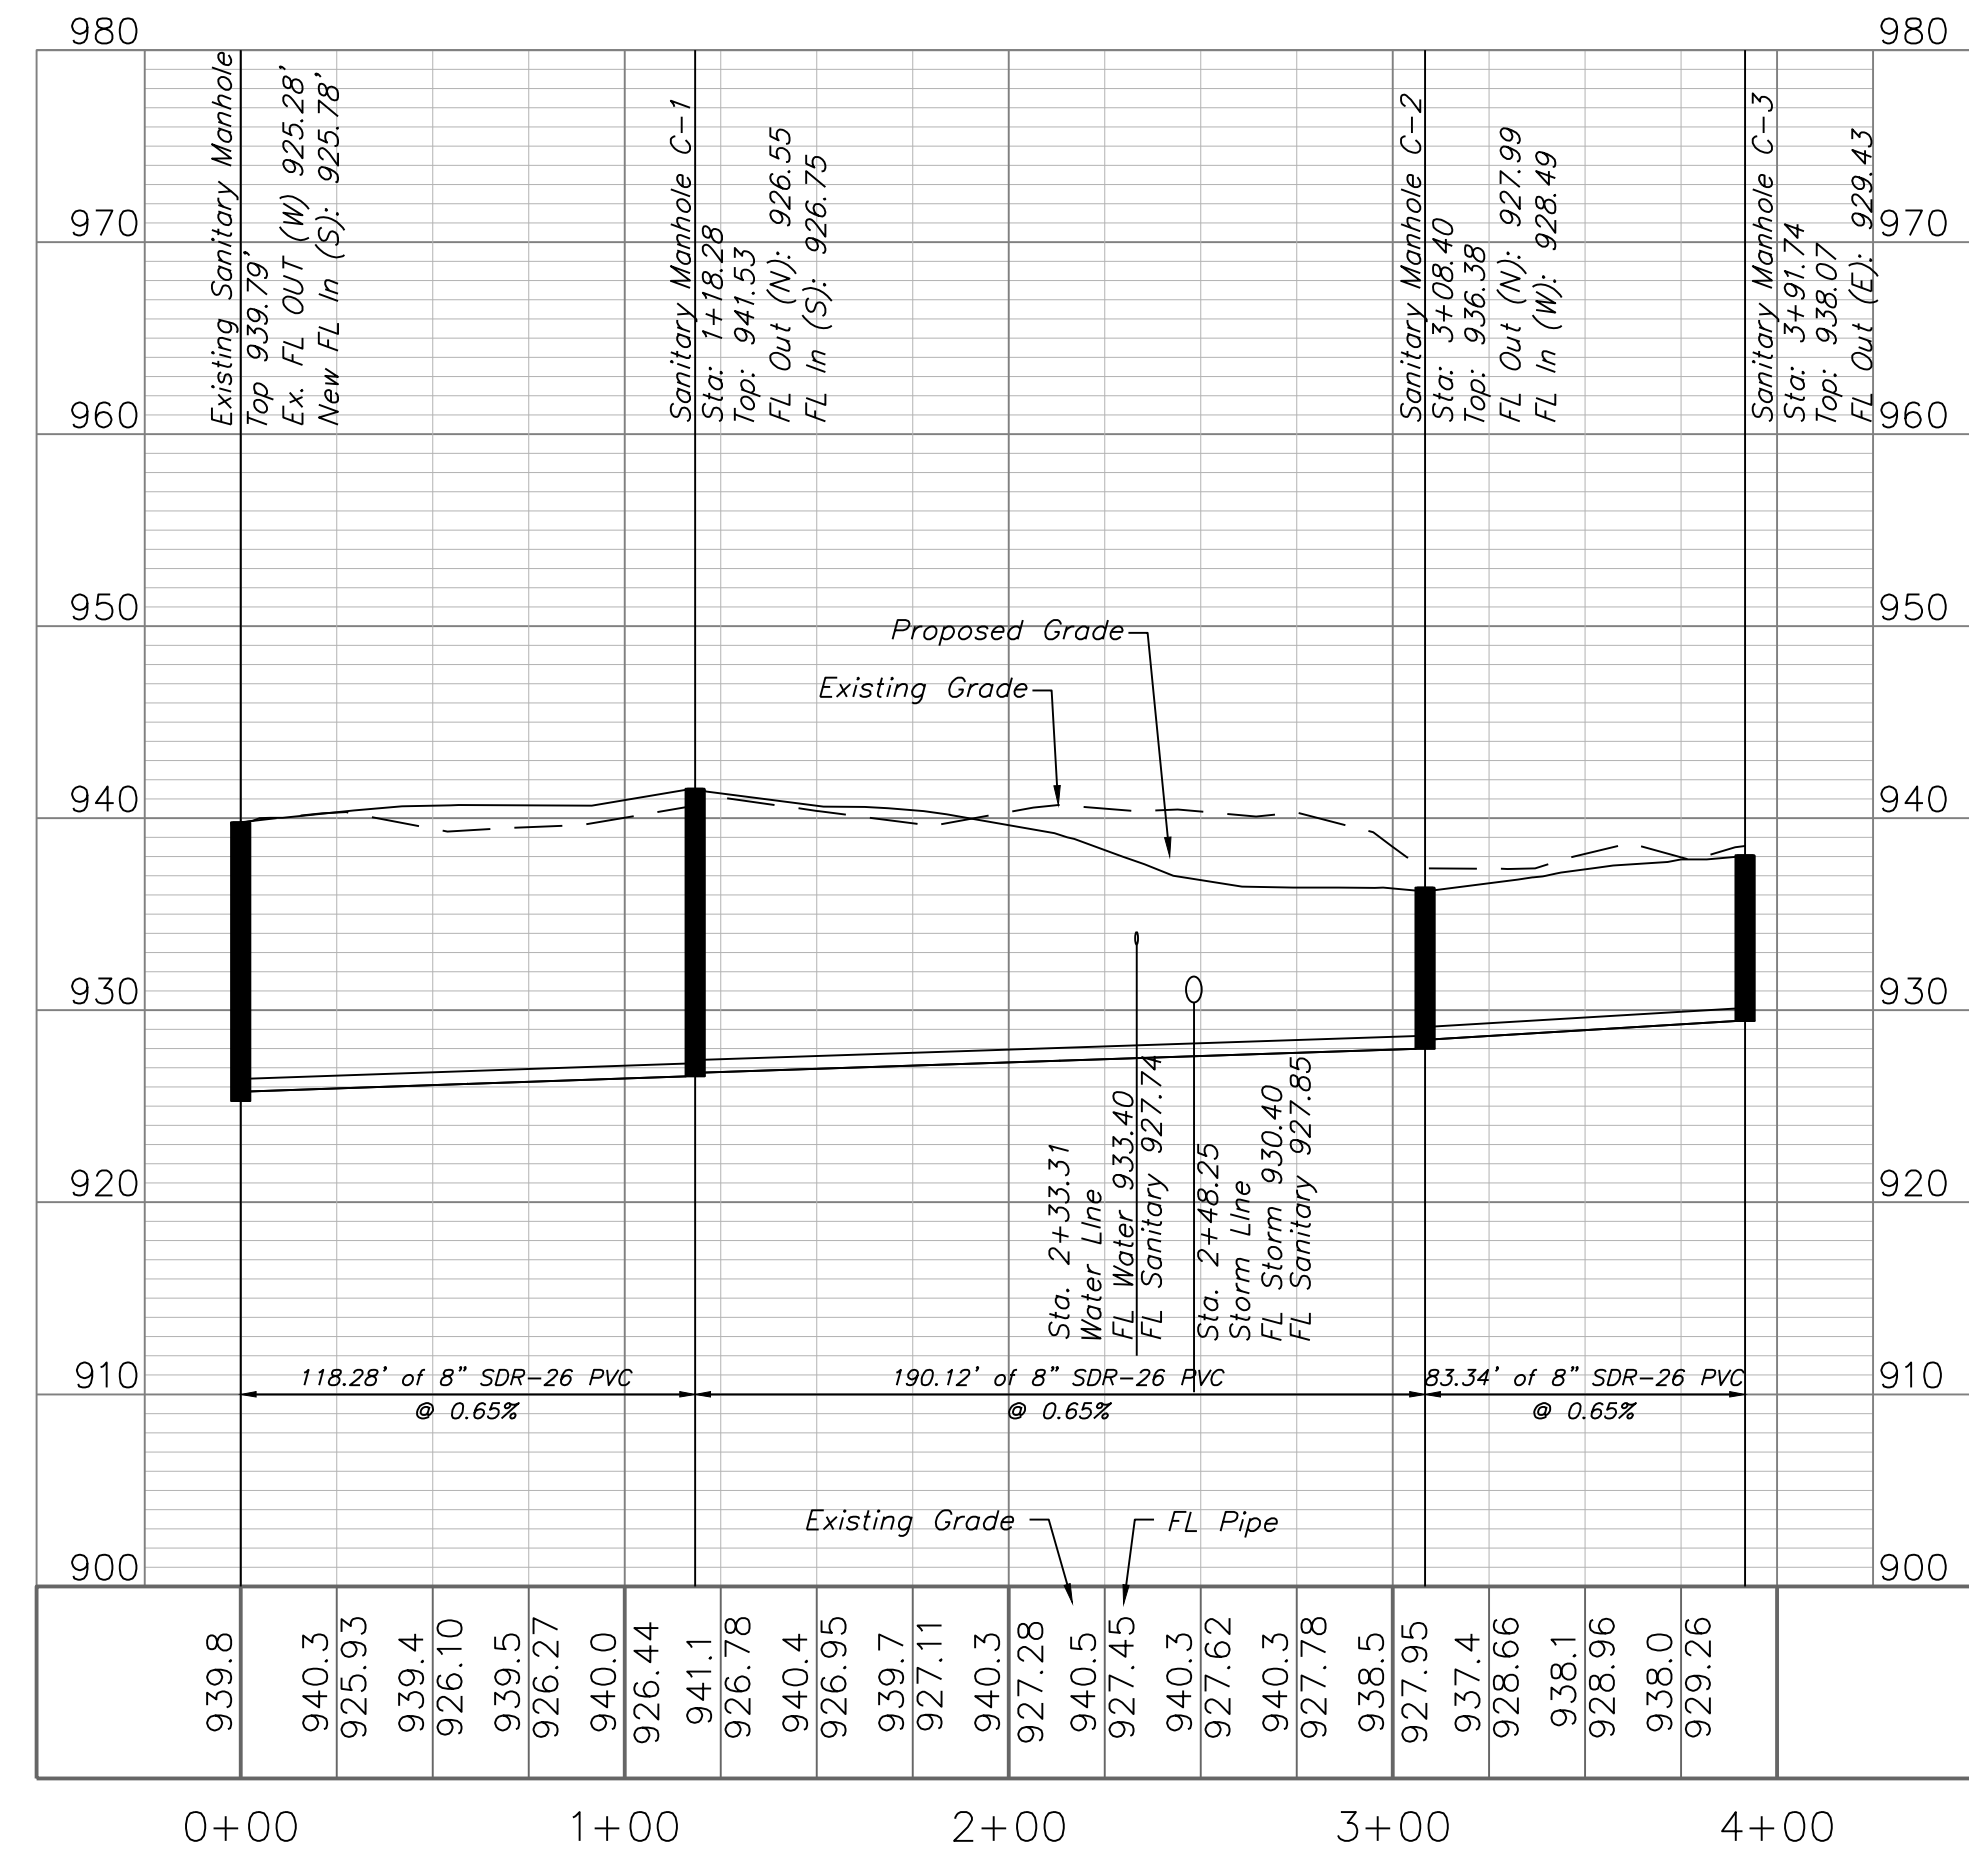

SANITARY LINE C

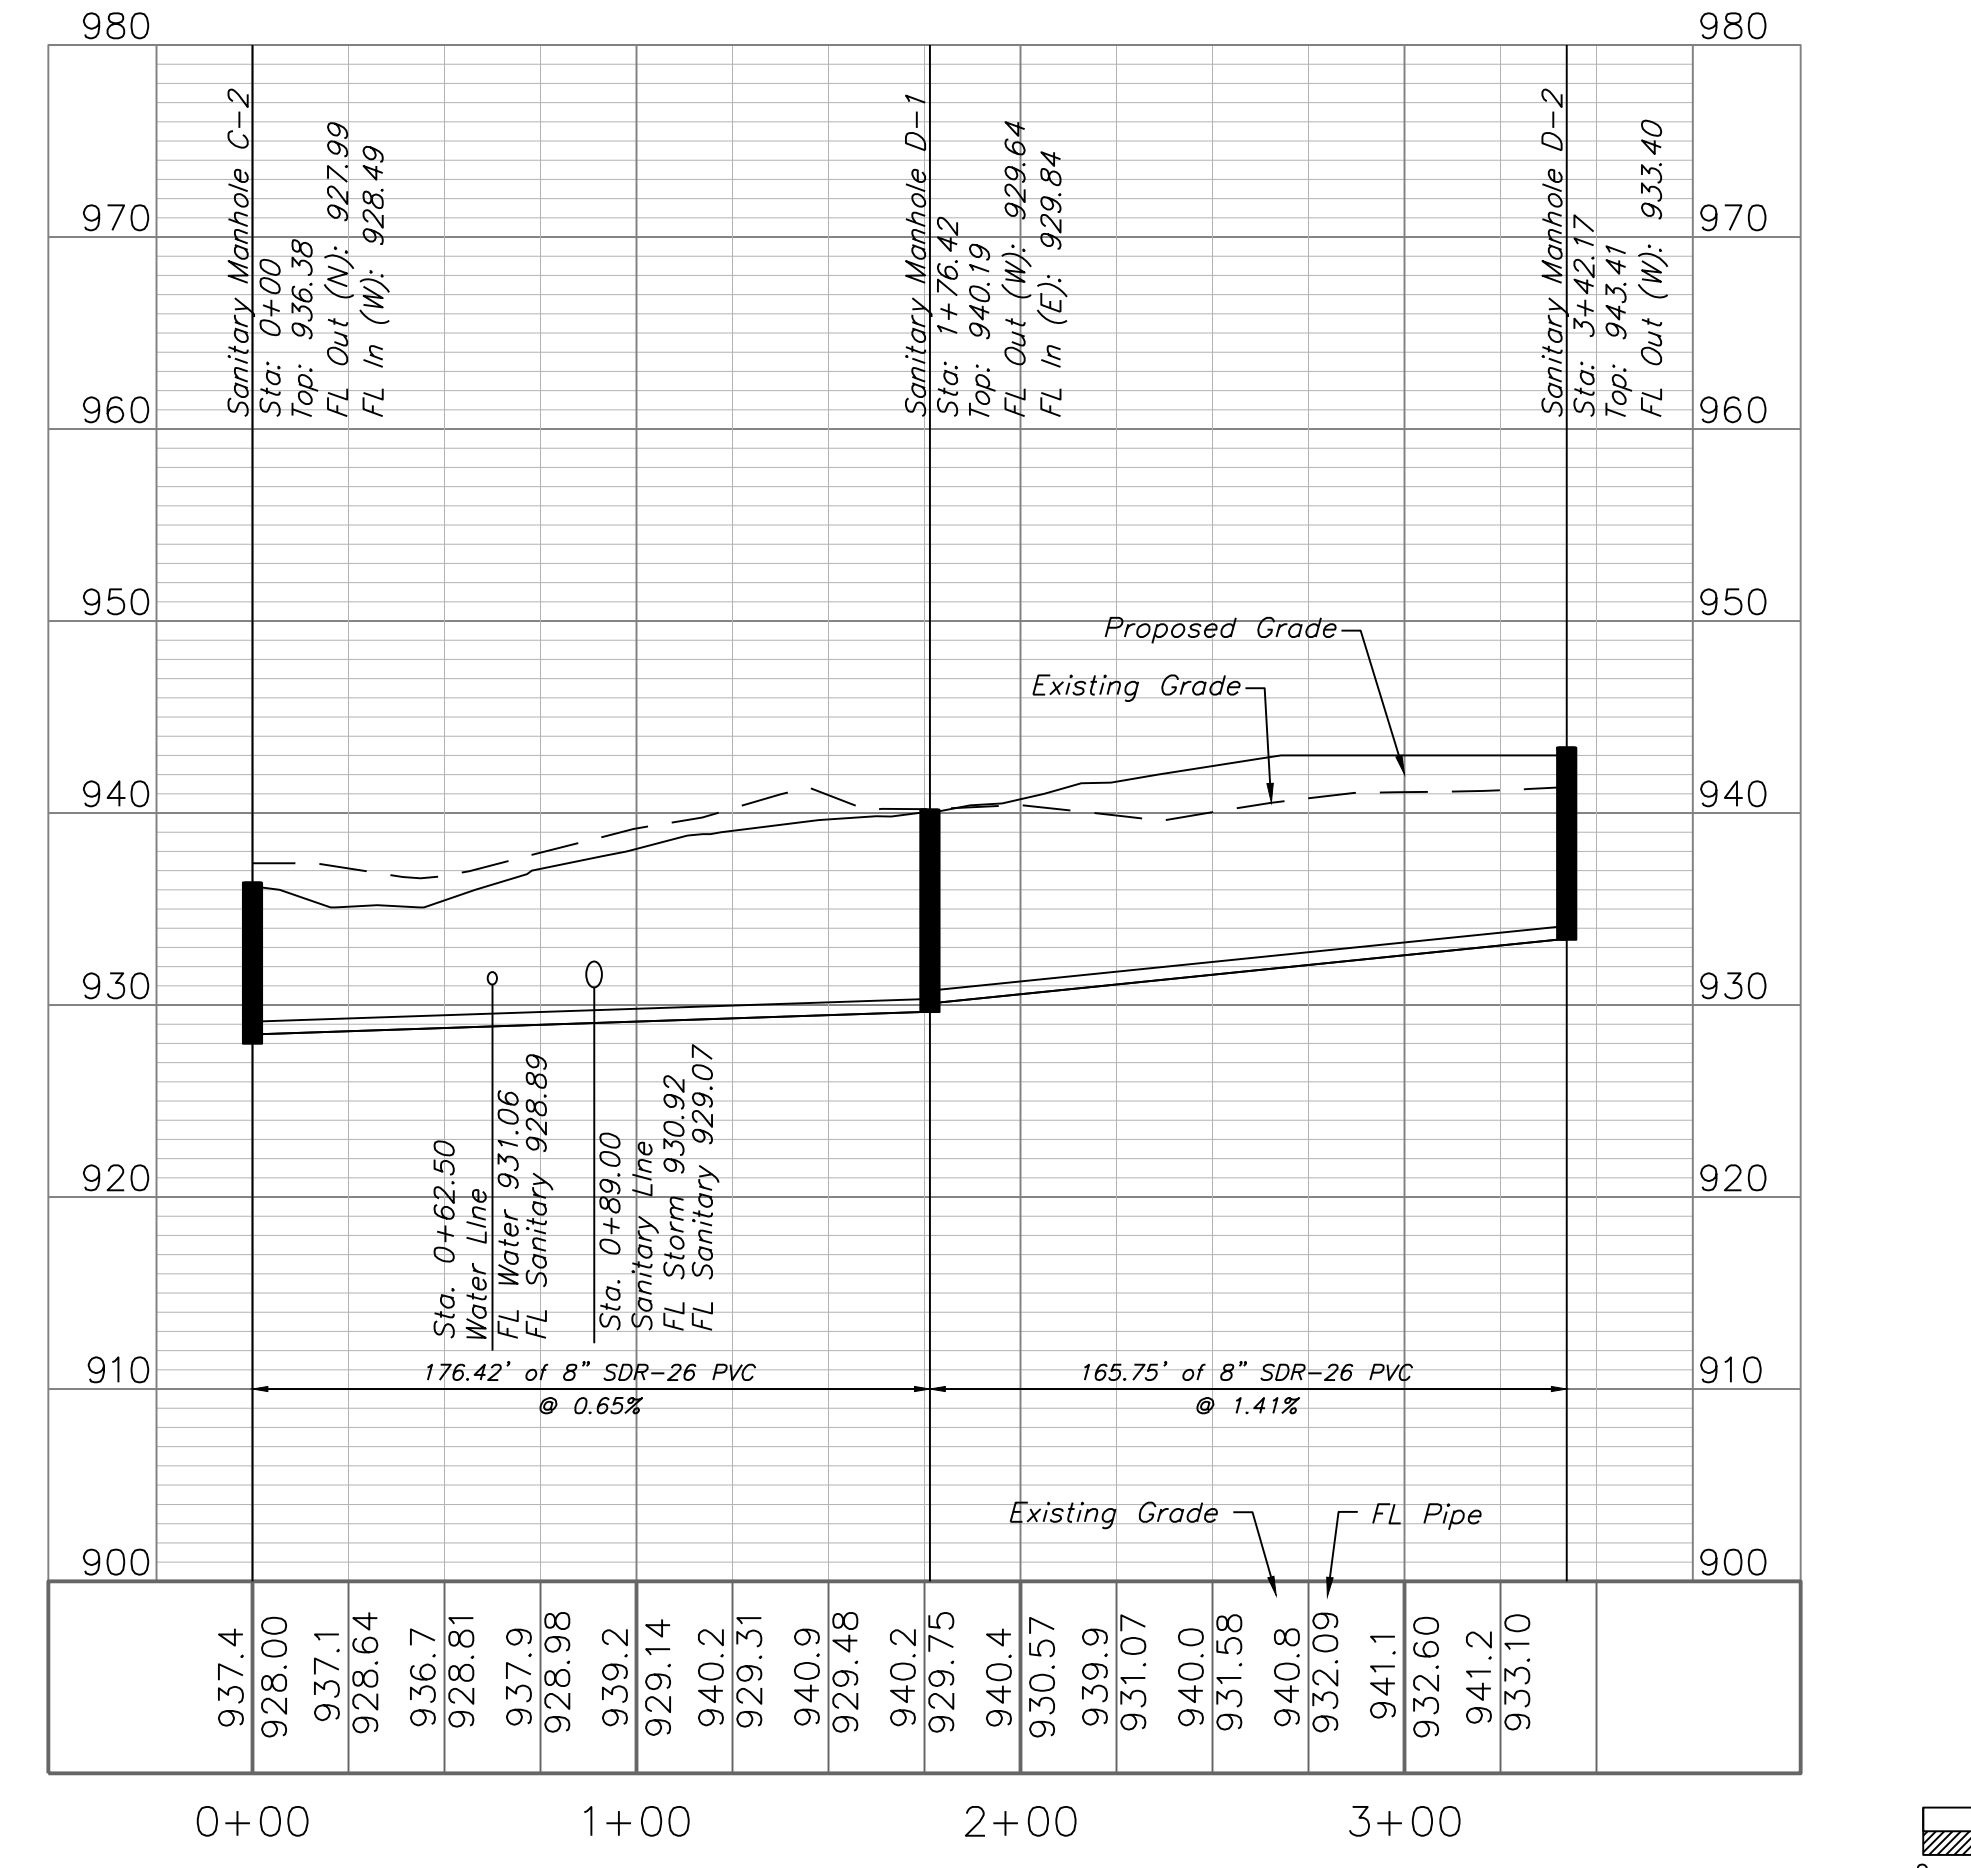

SANITARY LINE D



GENERAL NOTE:
1 - ALL CONSTRUCTION SHALL CONFORM TO THE CITY OF LEE'S SUMMIT DESIGN AND CONSTRUCTION MANUAL AS ADOPTED BY ORDINANCE 5813.
2 - TRENCH CHECKS SHALL BE INSTALL AT ALL SANITARY WYES LOCATION.

SANITARY PLAN & PROFILE
SCALE: 1" = 50'



Professional Registration
Missouri
Engineering 2005002188-D
Surveying 200500019-D
Kansas
Engineering E-1695
Surveying LS-219
Oklahoma
Engineering 6254
Nebraska
Engineering CA2821

Park Ridge - 6th Plat
Lee's Summit, Jackson County, Missouri

Project: PARK RIDGE
6TH
Issue Date:
November 17, 2017

Sanitary Plan and Profile
Construction Plans for:
Park Ridge - 6th Plat
Lee's Summit, Jackson County, Missouri

Matthew J. Schlicht
MO PE 2006019708
KS PE 19071
OK PE 25526

REVISIONS
