



WATER PLAN & PROFILE
SCALE: 1" = 50'

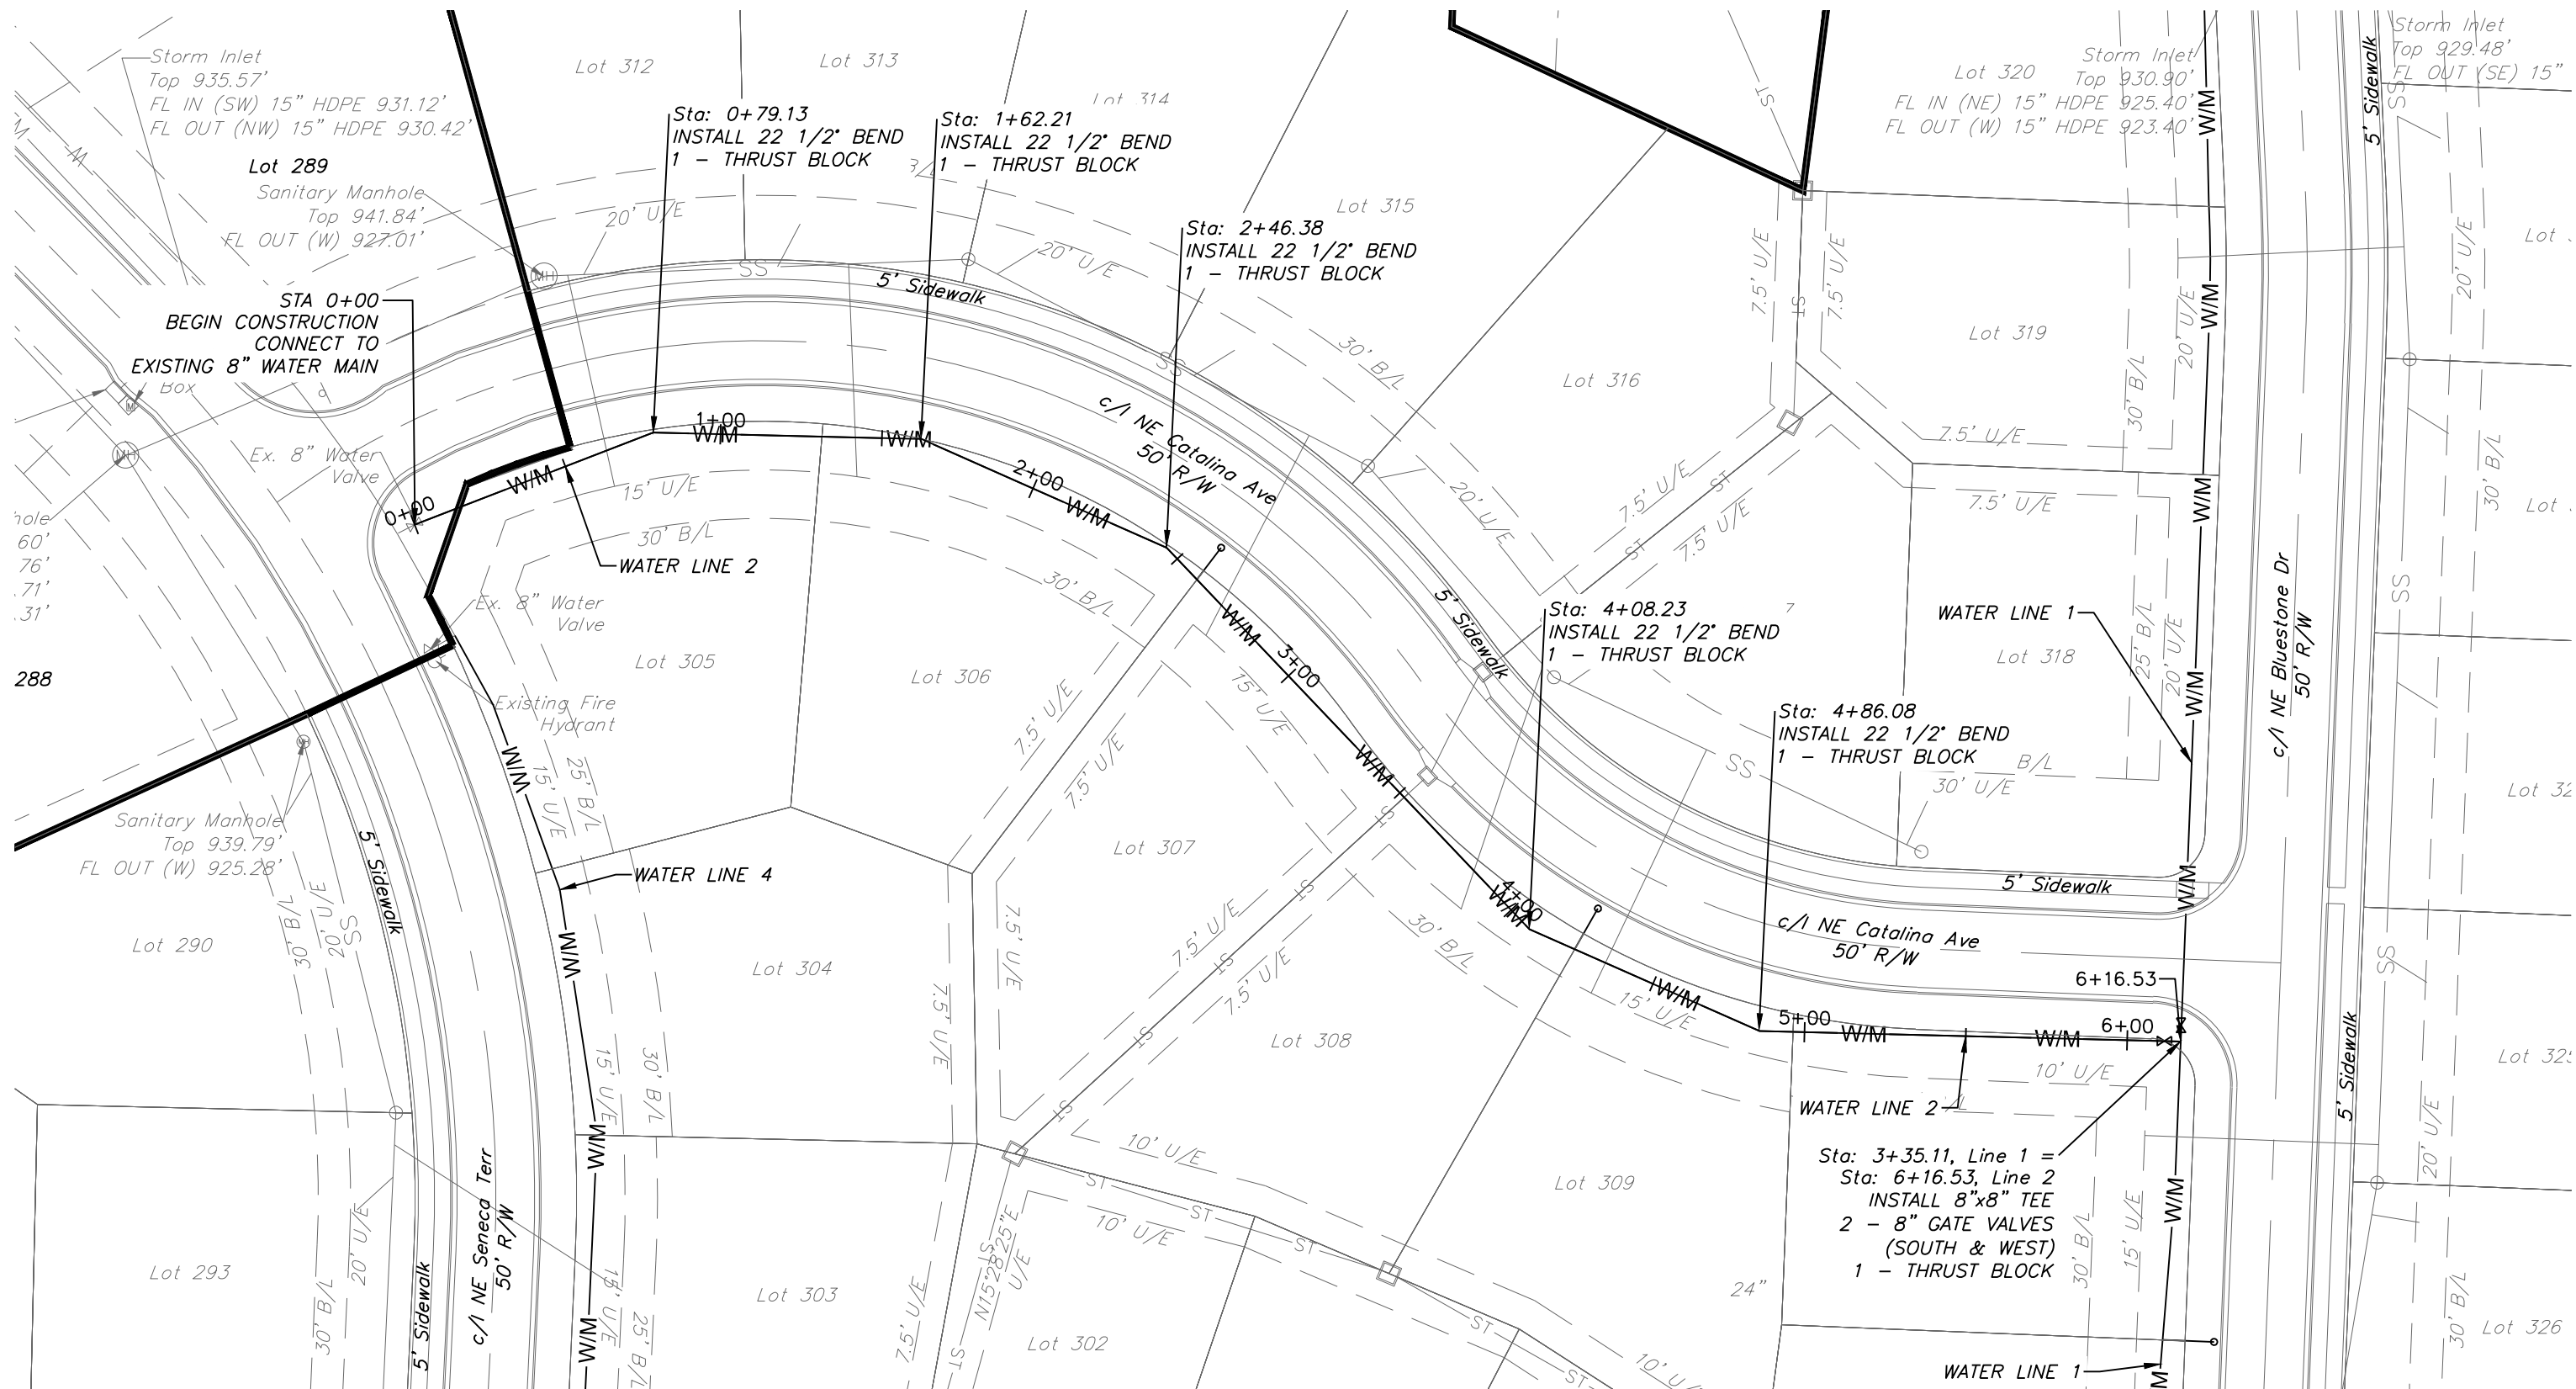

WATER LINE 2

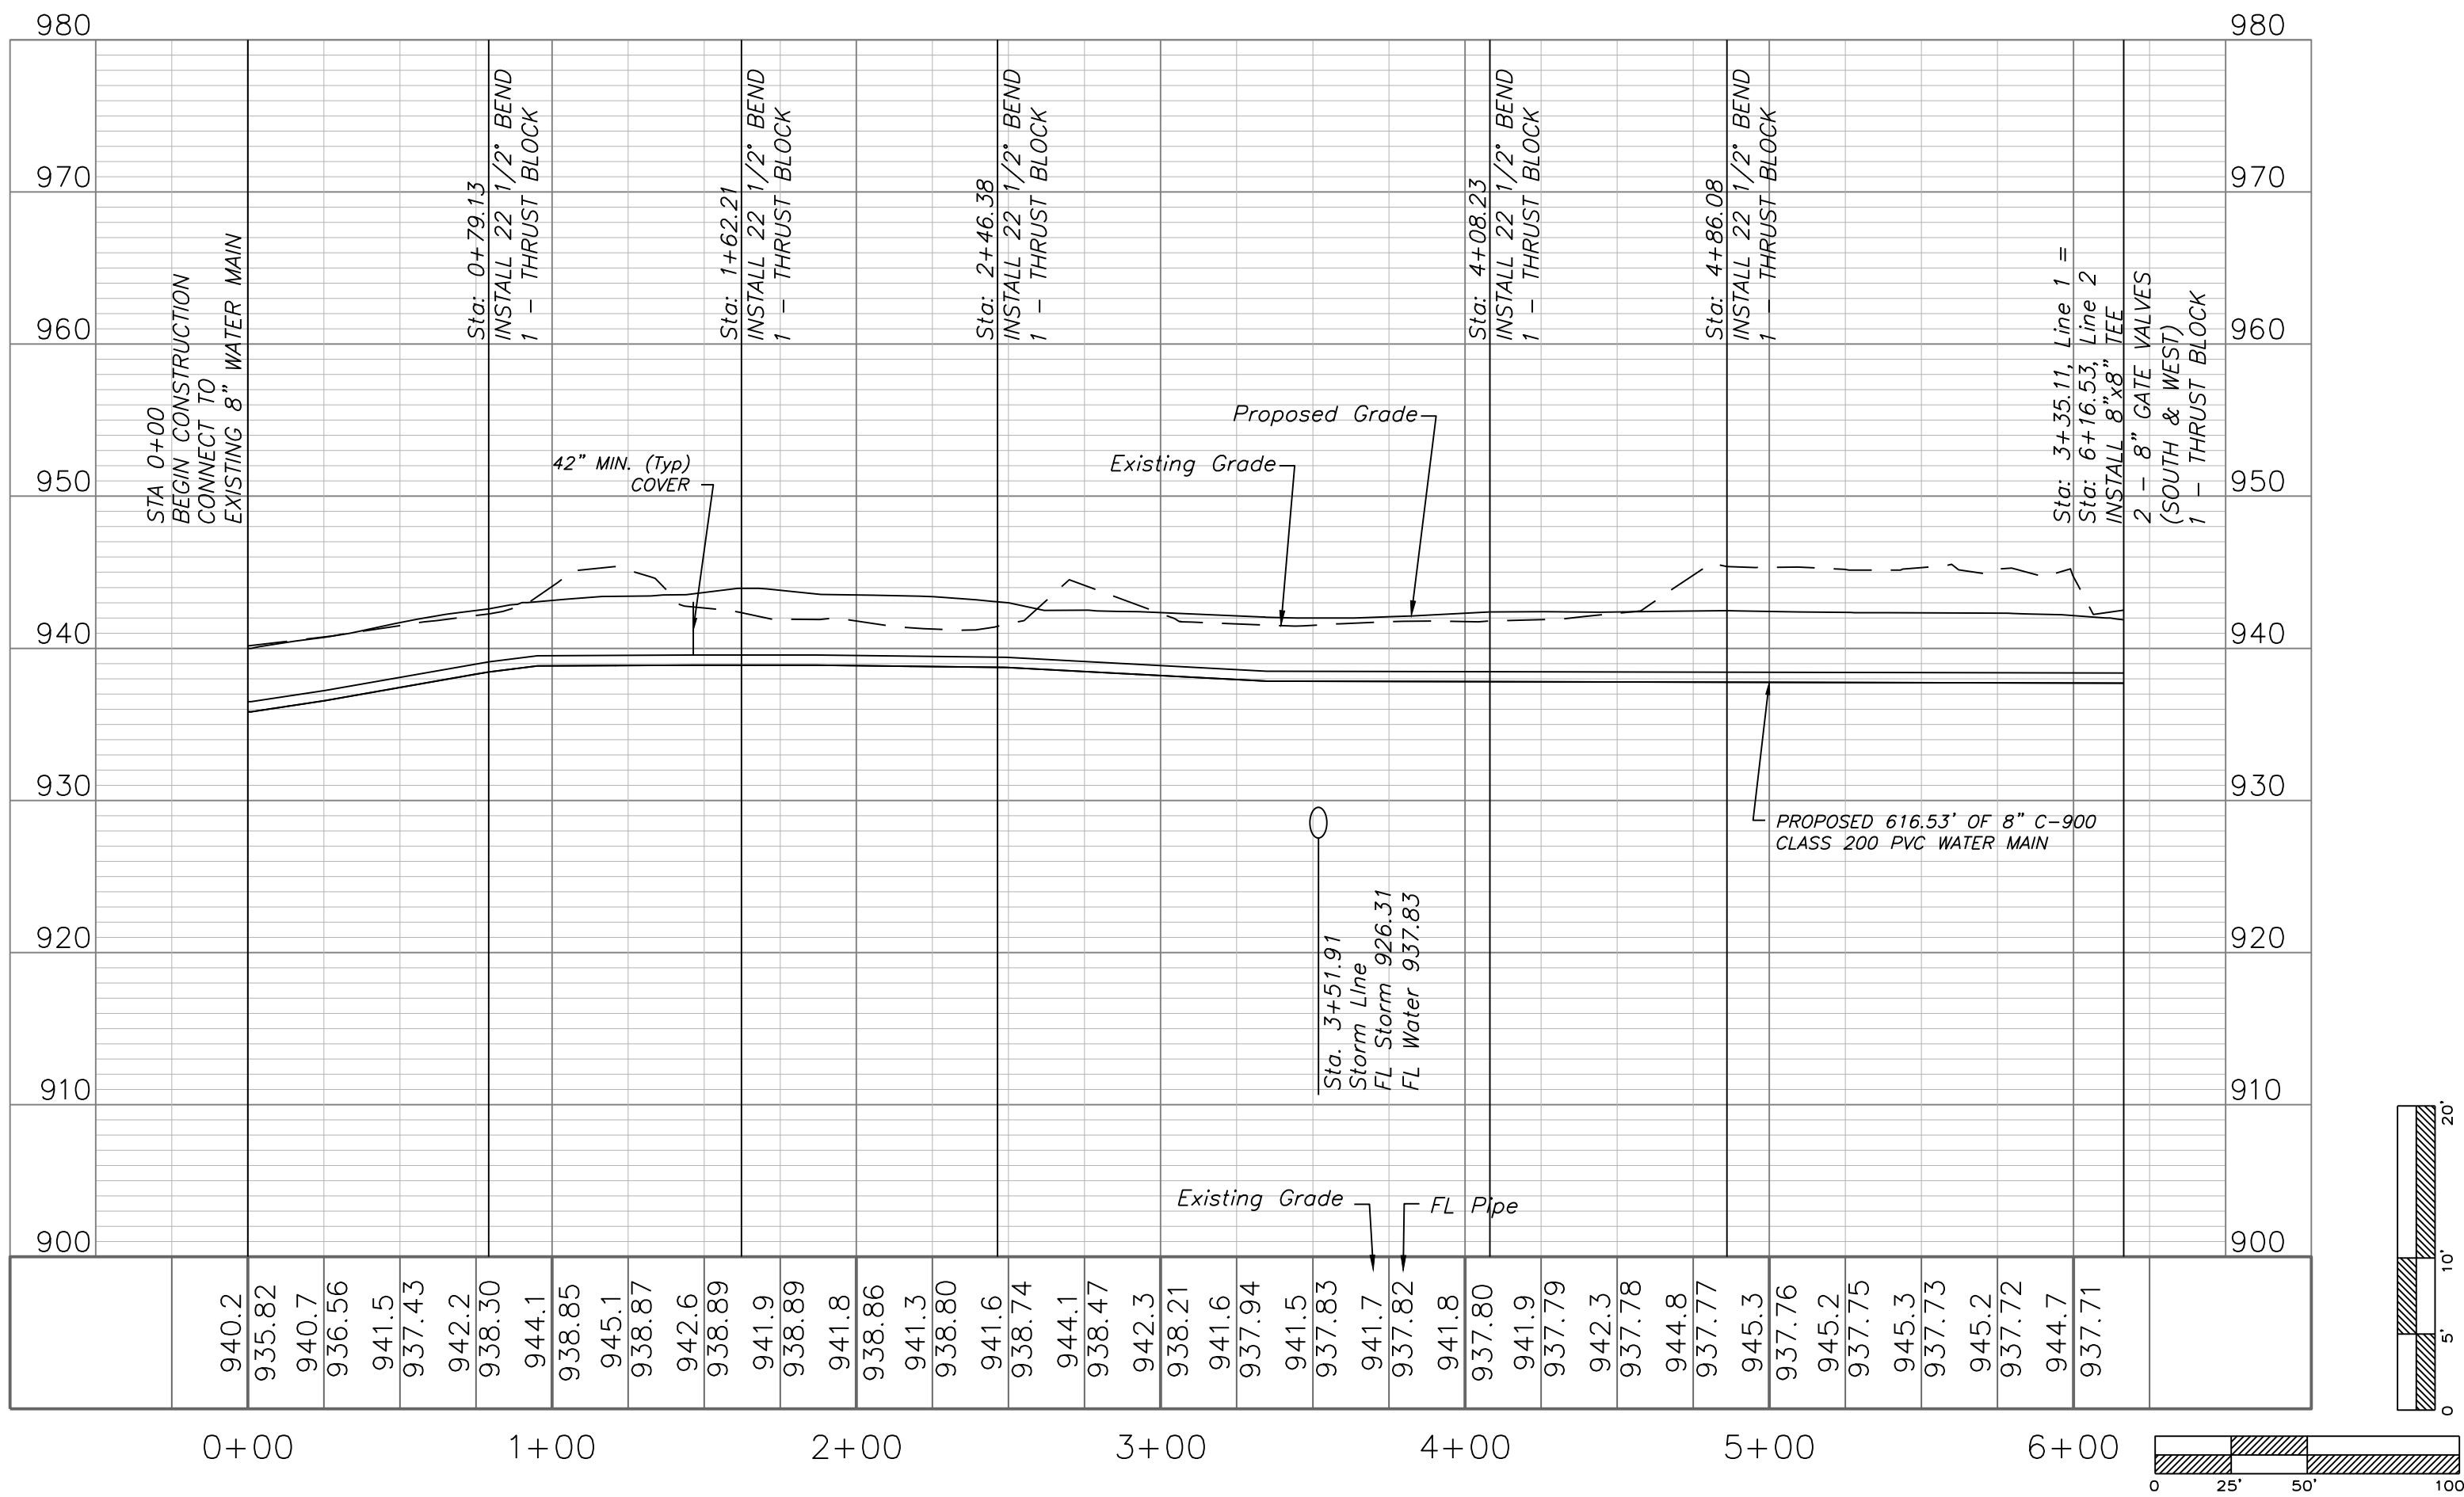

Professional Registration
Missouri
Engineering 2005002188-D
Surveying 200500319-D
Kansas
Engineering E-1895
Surveying LS-218
Oklahoma
Engineering 6254
Nebraska
Engineering CA2821

Park Ridge - 6th Plat
Lee's Summit, Jackson County, Missouri

Project: R1DCE
6TH
Issue Date:
November 17, 2017

Water Main Plan and Profile, Line 2
Construction Plans for:
Park Ridge - 6th Plat
Lee's Summit, Jackson County, Missouri

Matthew J. Schlicht
MO PE 2006019708
KS PE 19071
OK PE 25526

REVISIONS