



SANITARY PLAN & PROFILE

SCALE: 1" = 50'

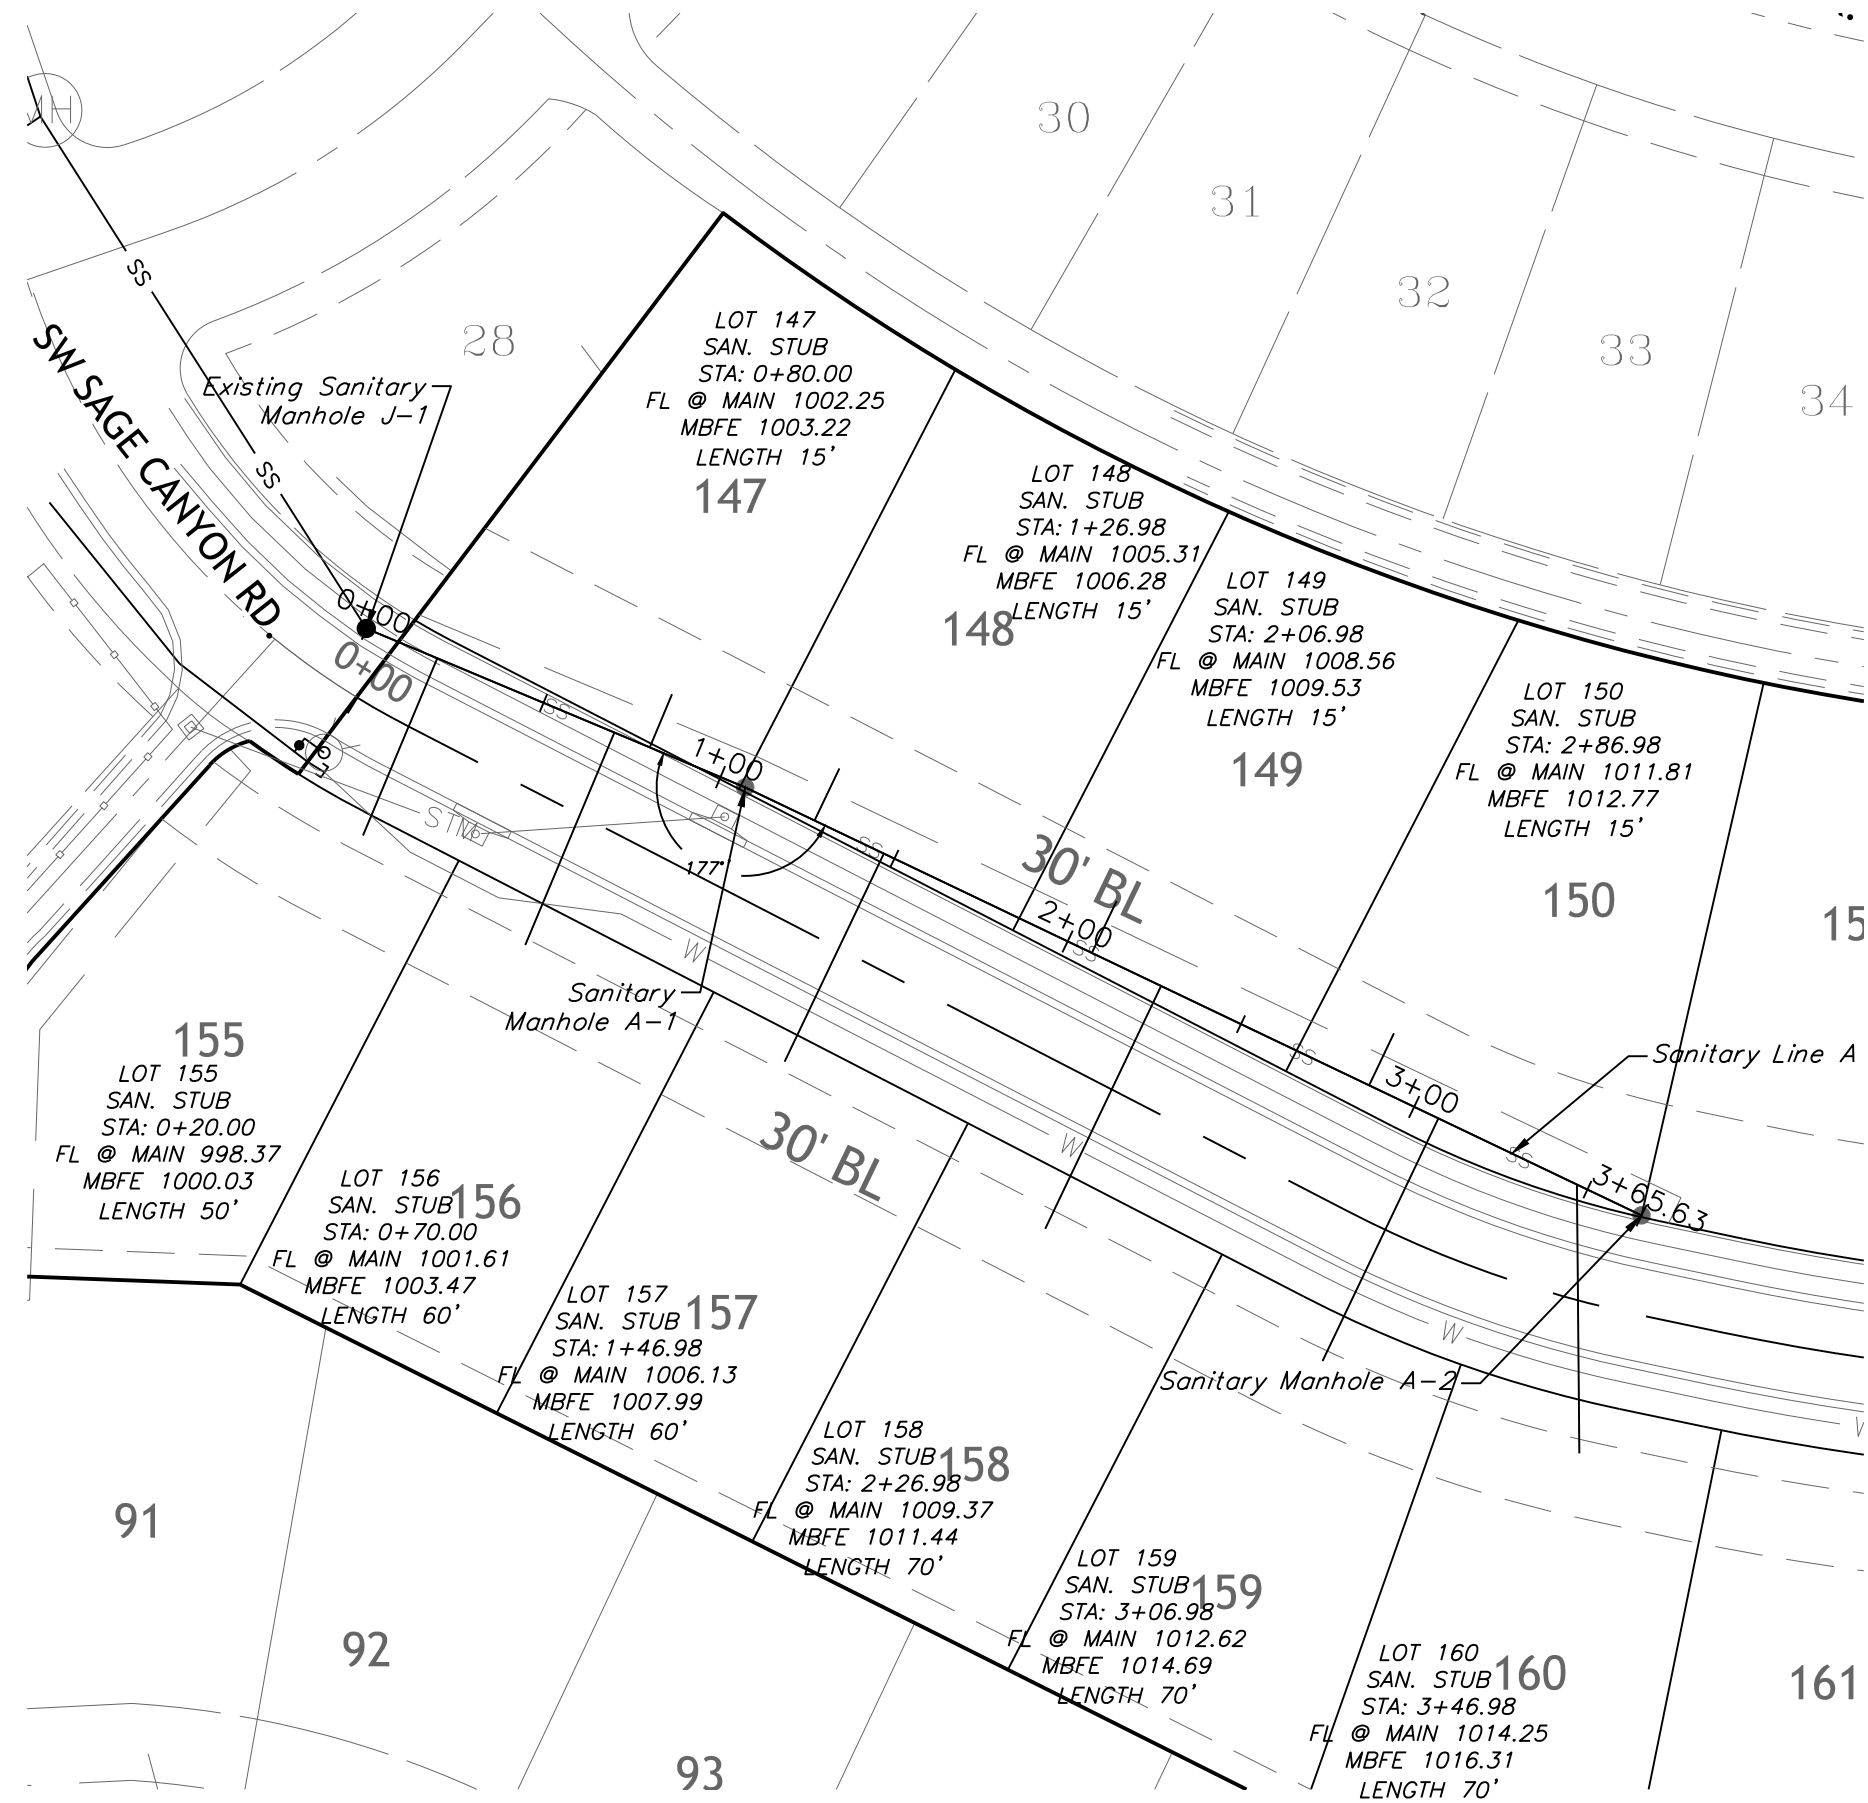

SANITARY LINE A

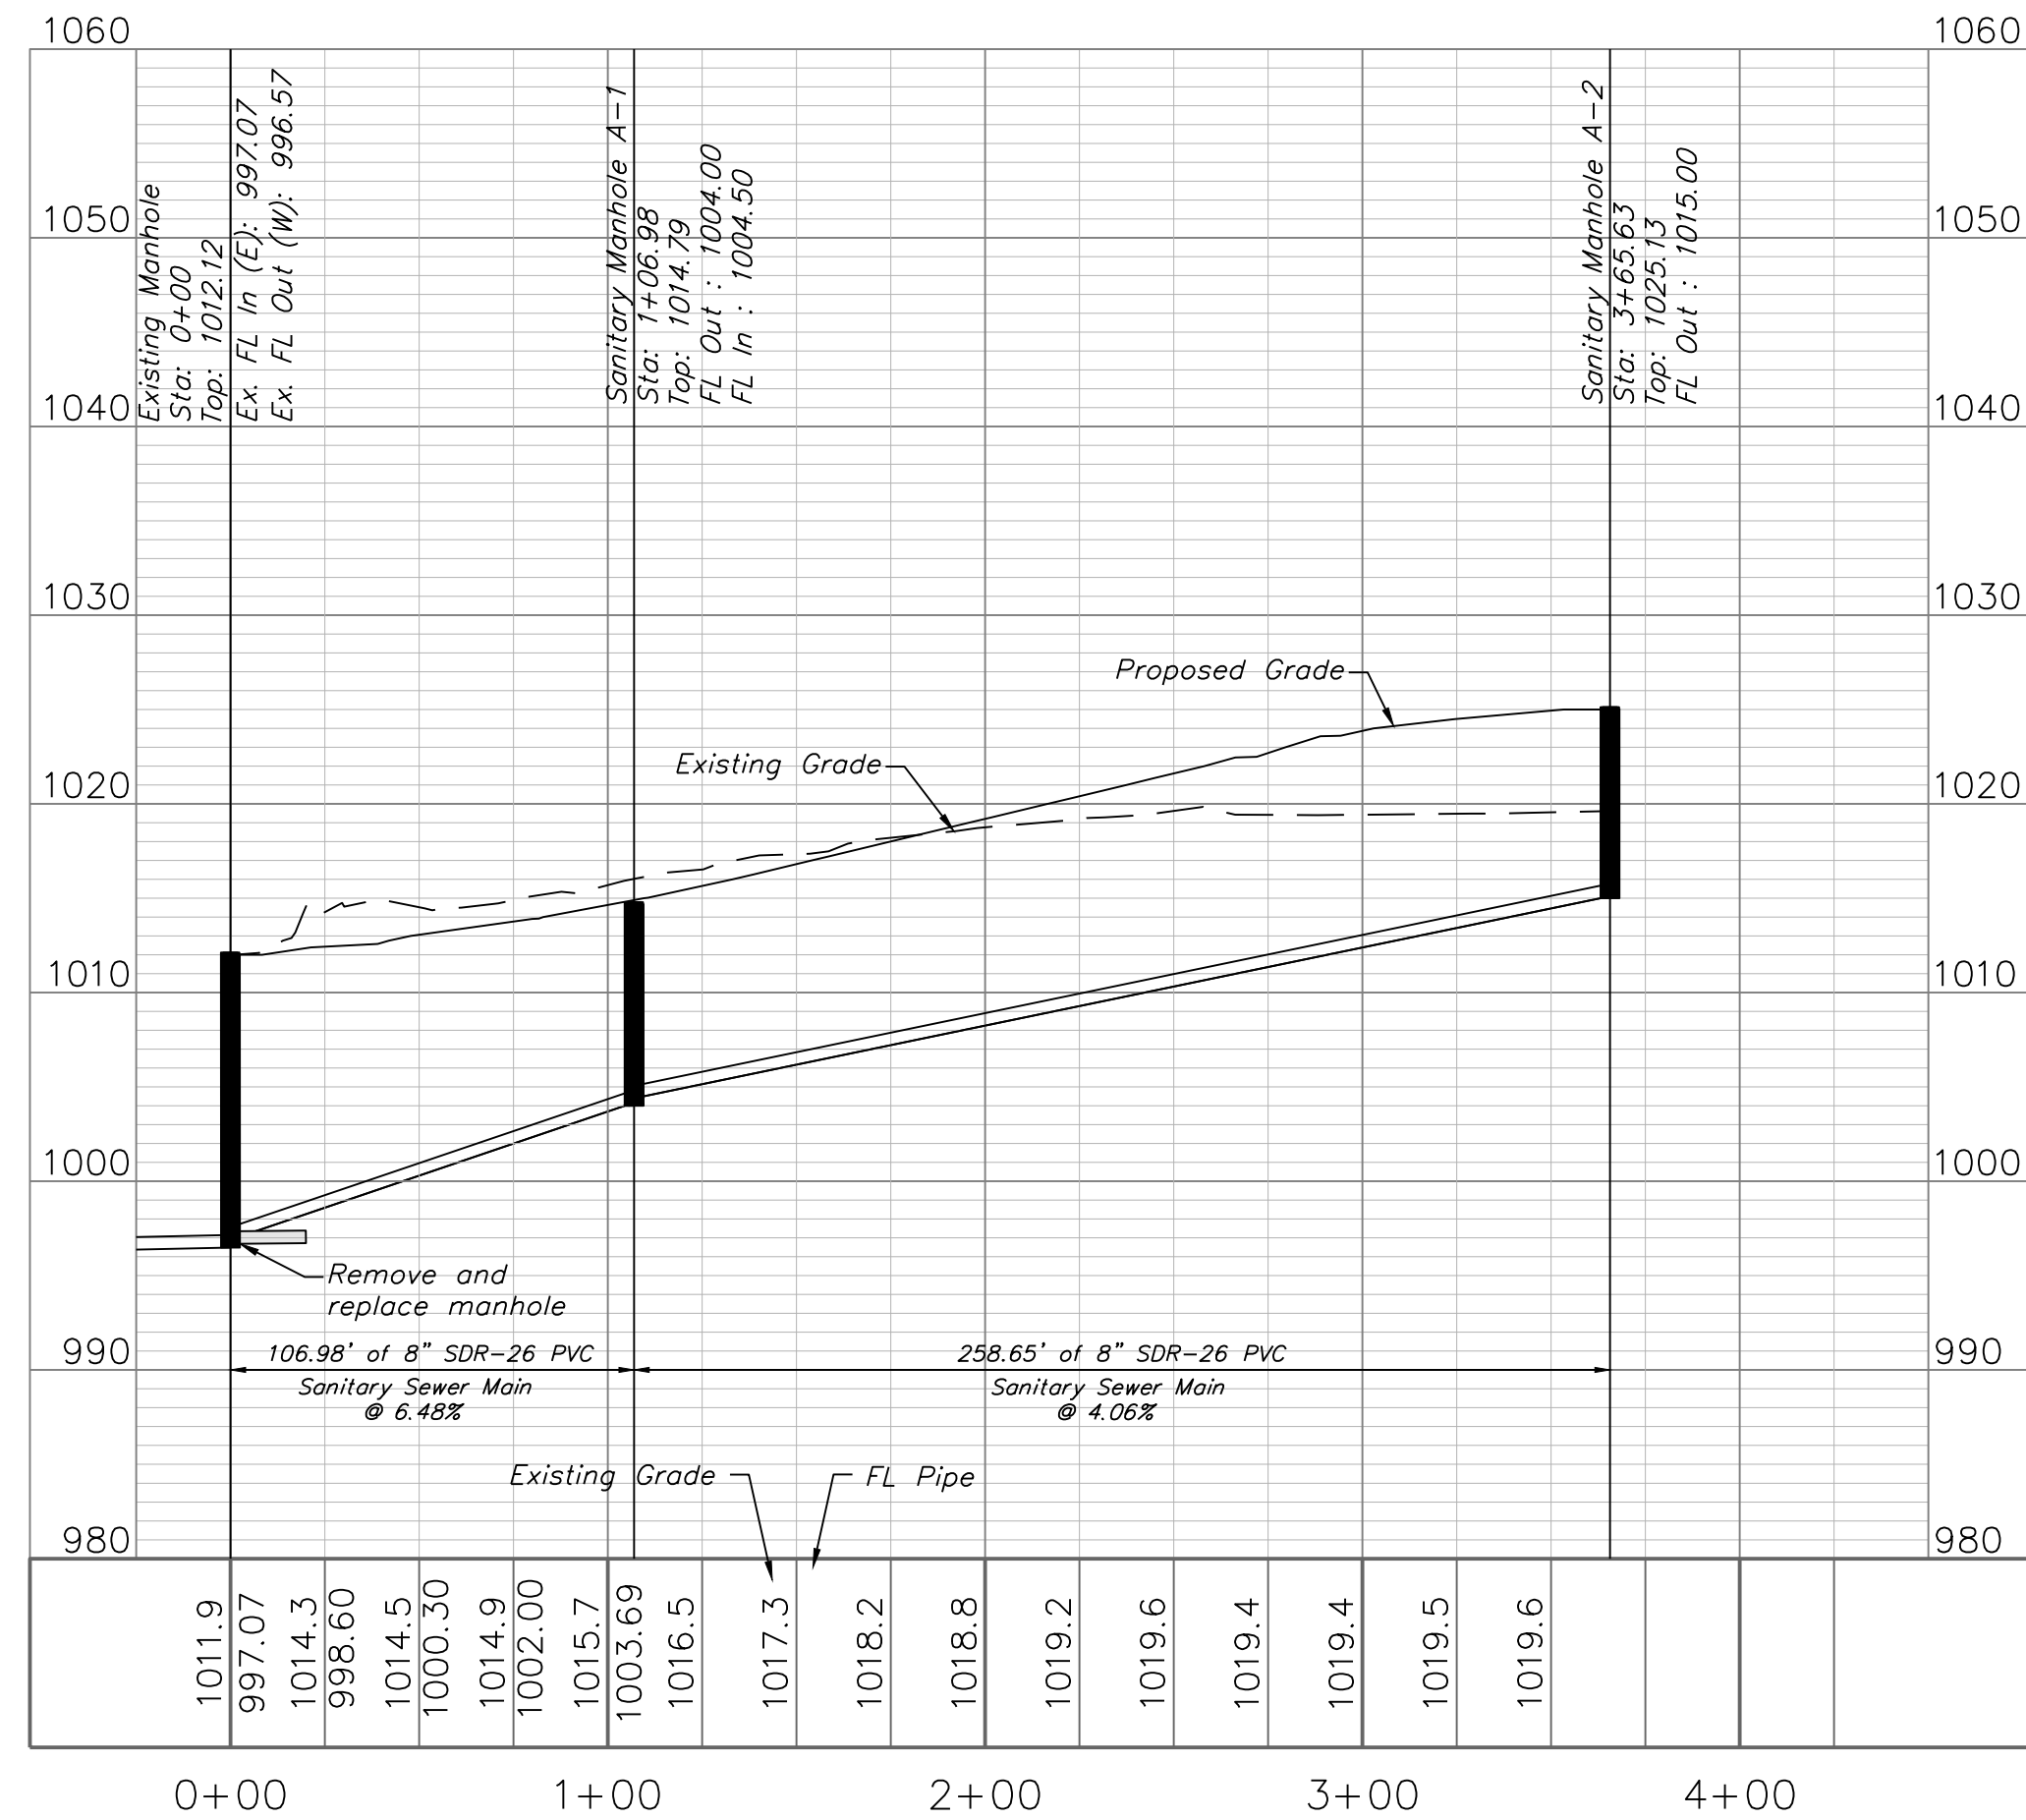


NOTES:

- SEWER MAIN PIPE SHALL BE SDR-26 PVC MINIMUM UNLESS OTHERWISE INDICATED.
- ALL SERVICE STUBS SHALL BE SDR-26 MINIMUM.
- CONTRACTOR SHALL FIELD VERIFY EXACT LENGTHS OF 4" RISERS AND SERVICE LINES.
- TRENCH CHECKS SHALL BE INSTALLED ON ALL SANITARY WYE LOCATIONS.


GENERAL NOTE:

1 - ALL CONSTRUCTION SHALL CONFORM TO THE CITY OF LEE'S SUMMIT DESIGN AND CONSTRUCTION MANUAL AS ADOPTED BY ORDINANCE 5813.


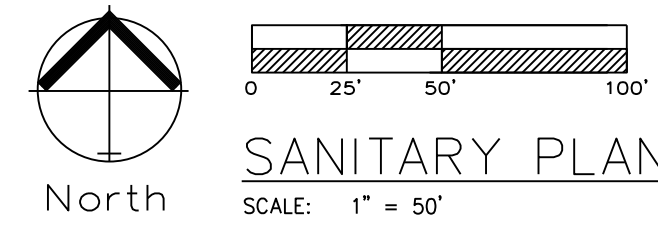


SANITARY PLAN & PROFILE

SCALE: 1" = 50'

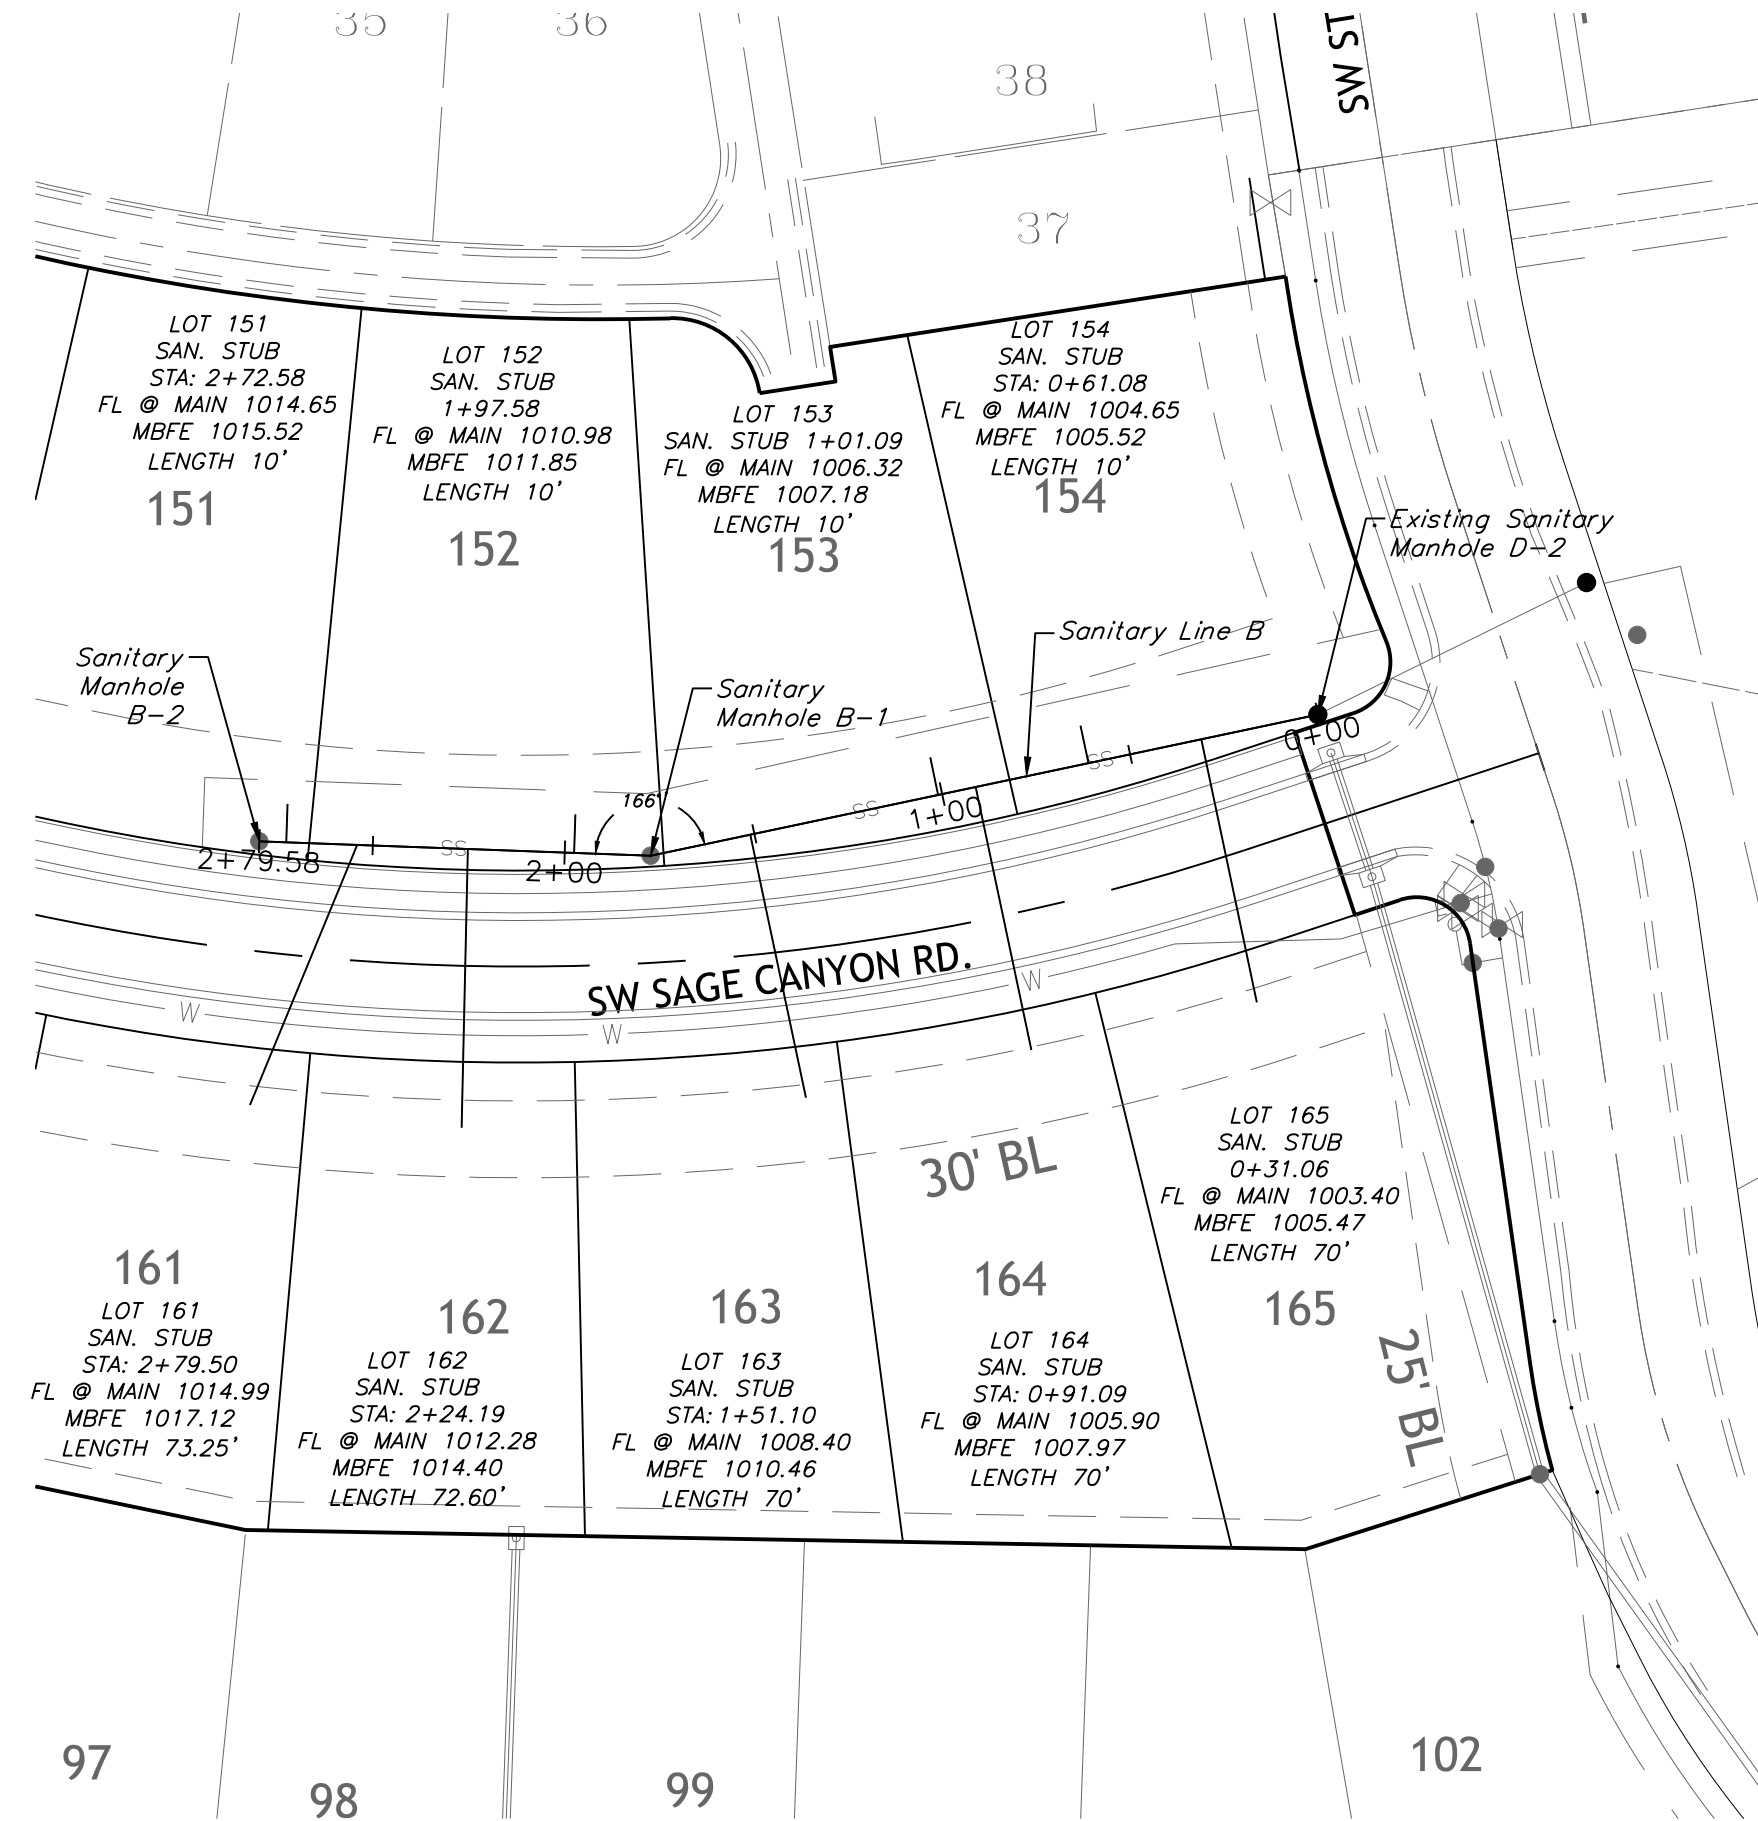

SANITARY LINE B

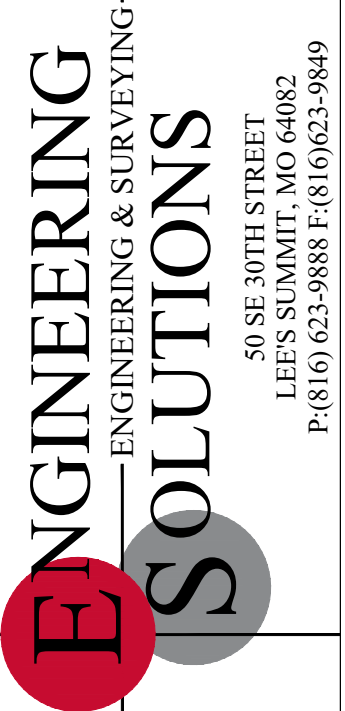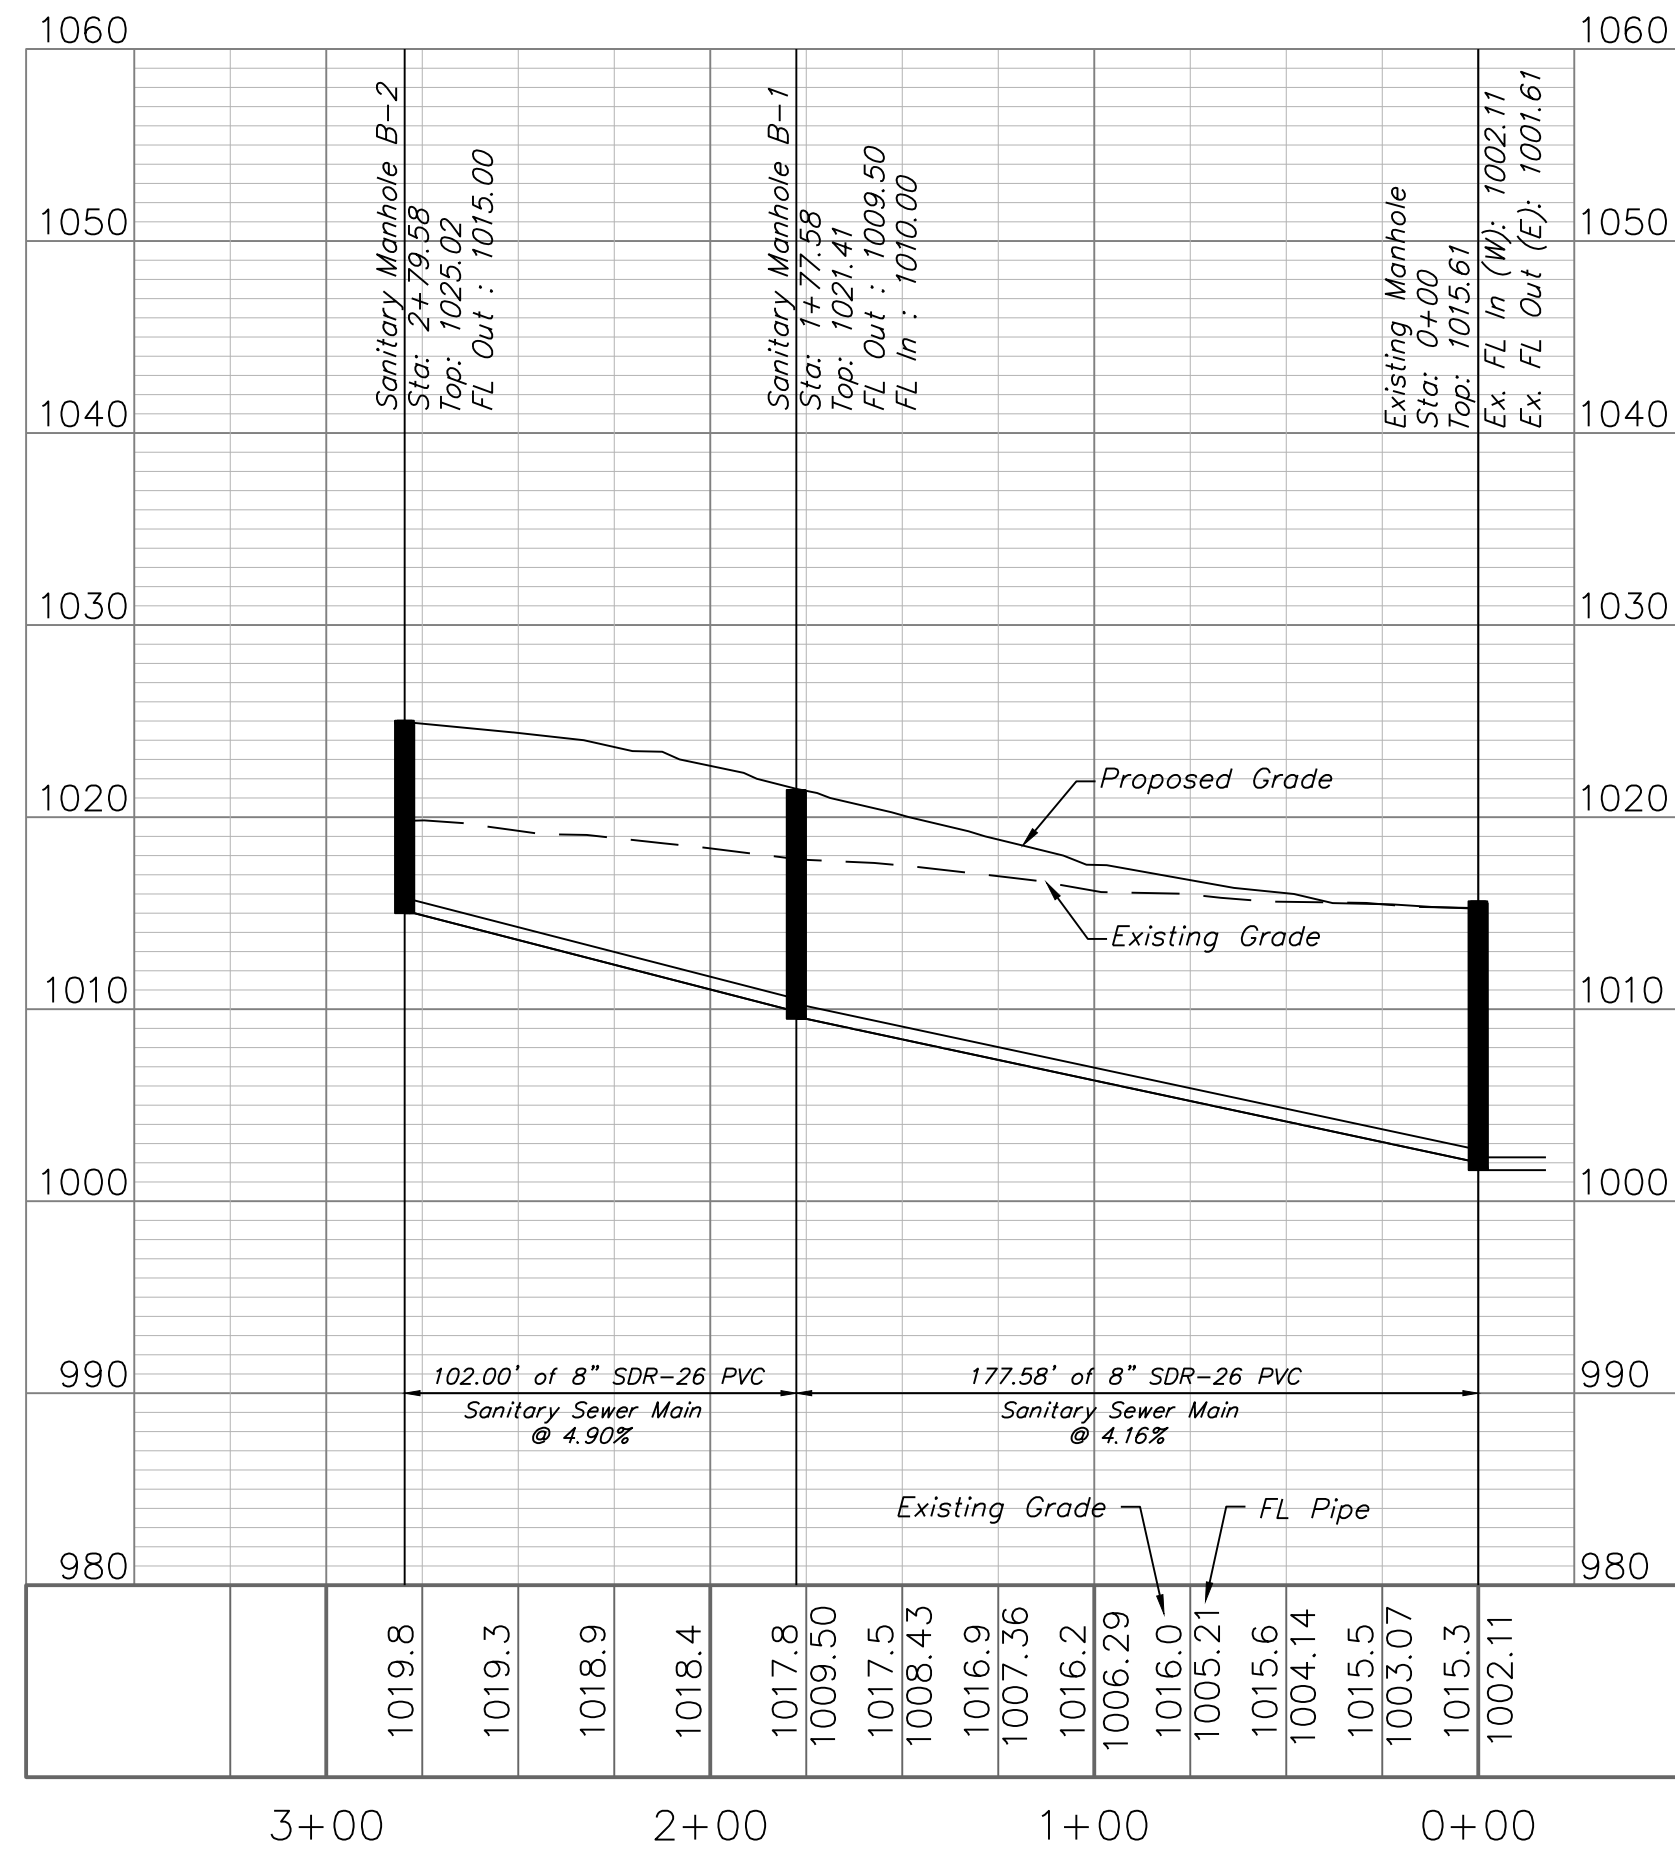

Professional Registration
Missouri
Engineering 2005002186-D
Surveying 2005008319-D
Kansas
Engineering E-1695
Surveying LS-218
Oklahoma
Engineering 6254
Nebraska
Engineering CA2821

Napa Valley 4th Plat
Lee's Summit, Jackson County, Missouri

Project:
NAPA VALLEY LS100
Issue Date:
July 13, 2018

Sanitary Plan and Profile
Construction Plans for:
Napa Valley 4th Plat
Lee's Summit, Jackson County, Missouri

Matthew J. Schlicht
MO PE 2006019708
KS PE 19071
OK PE 25226
NE PE E-14335

REVISIONS

C. 402