
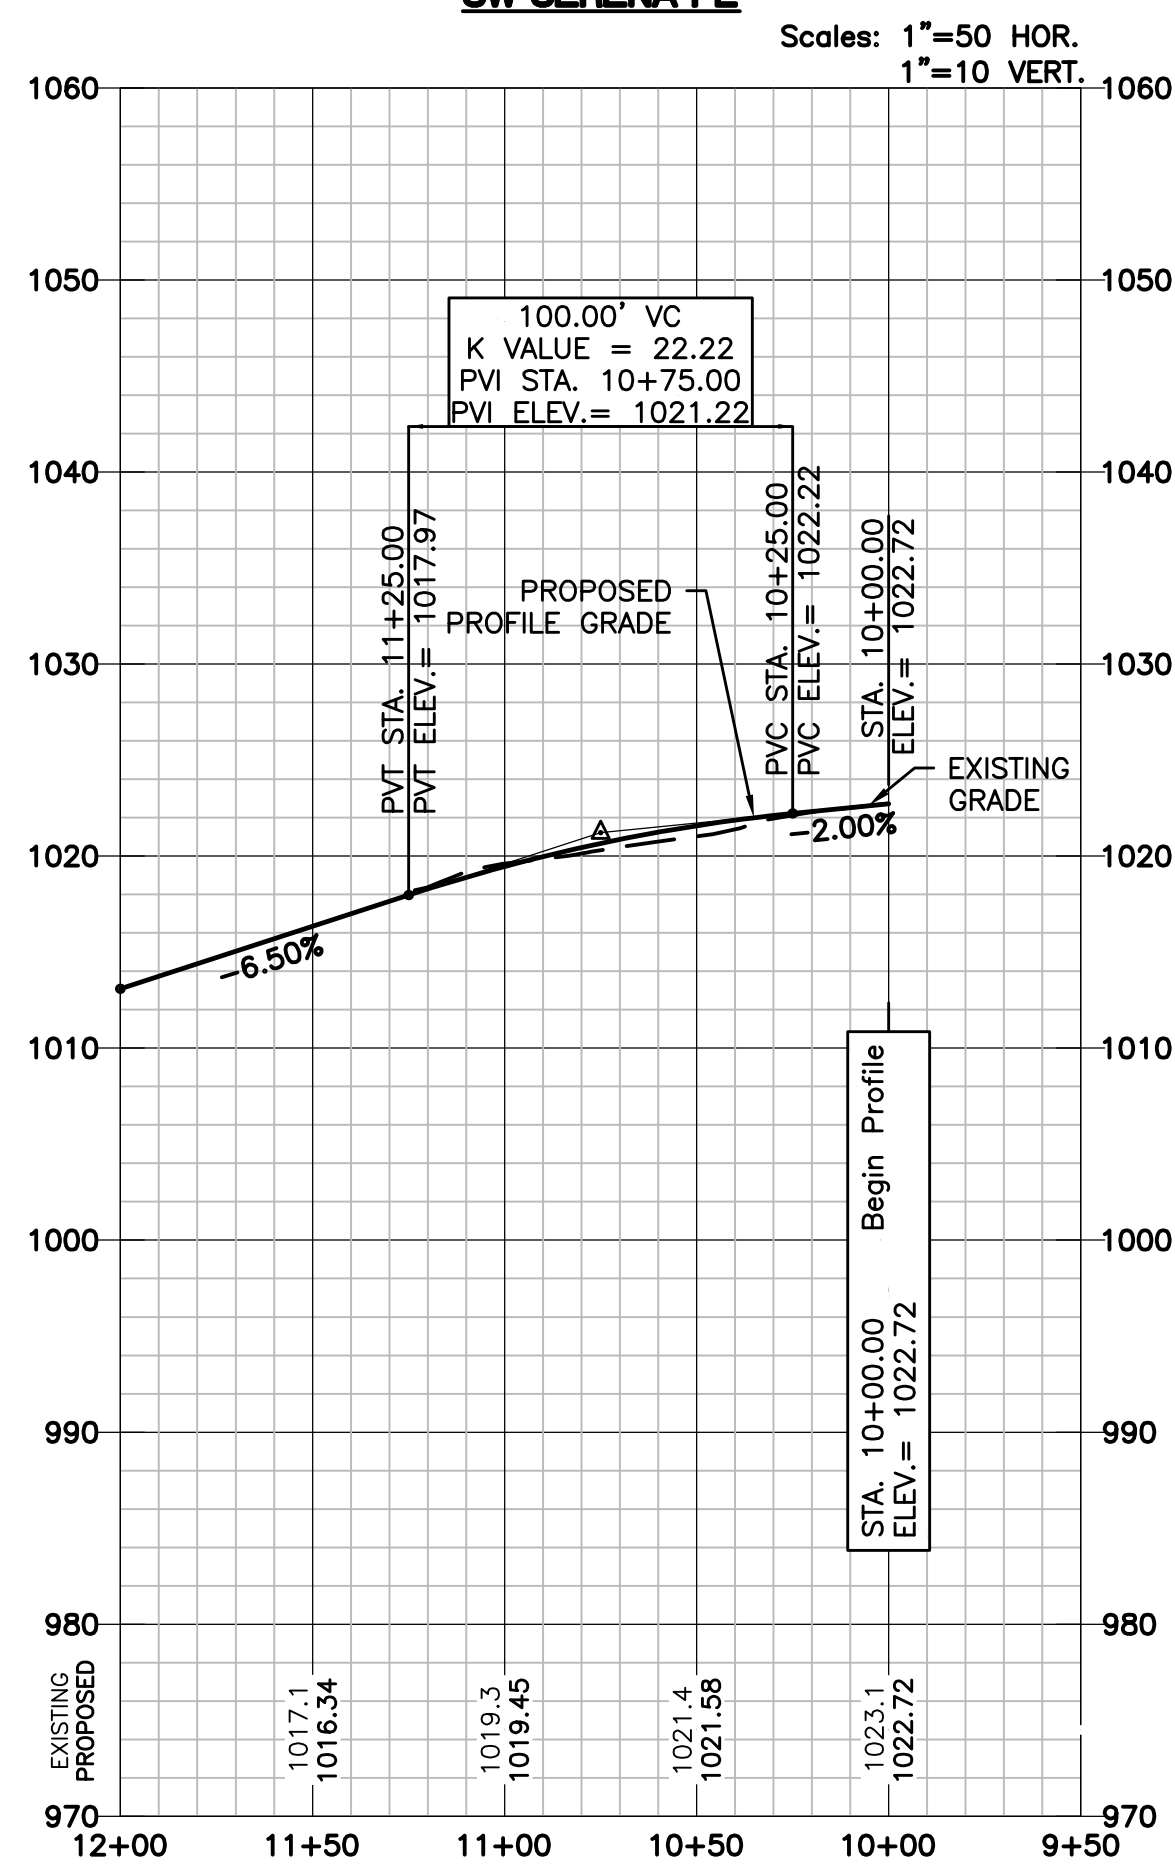
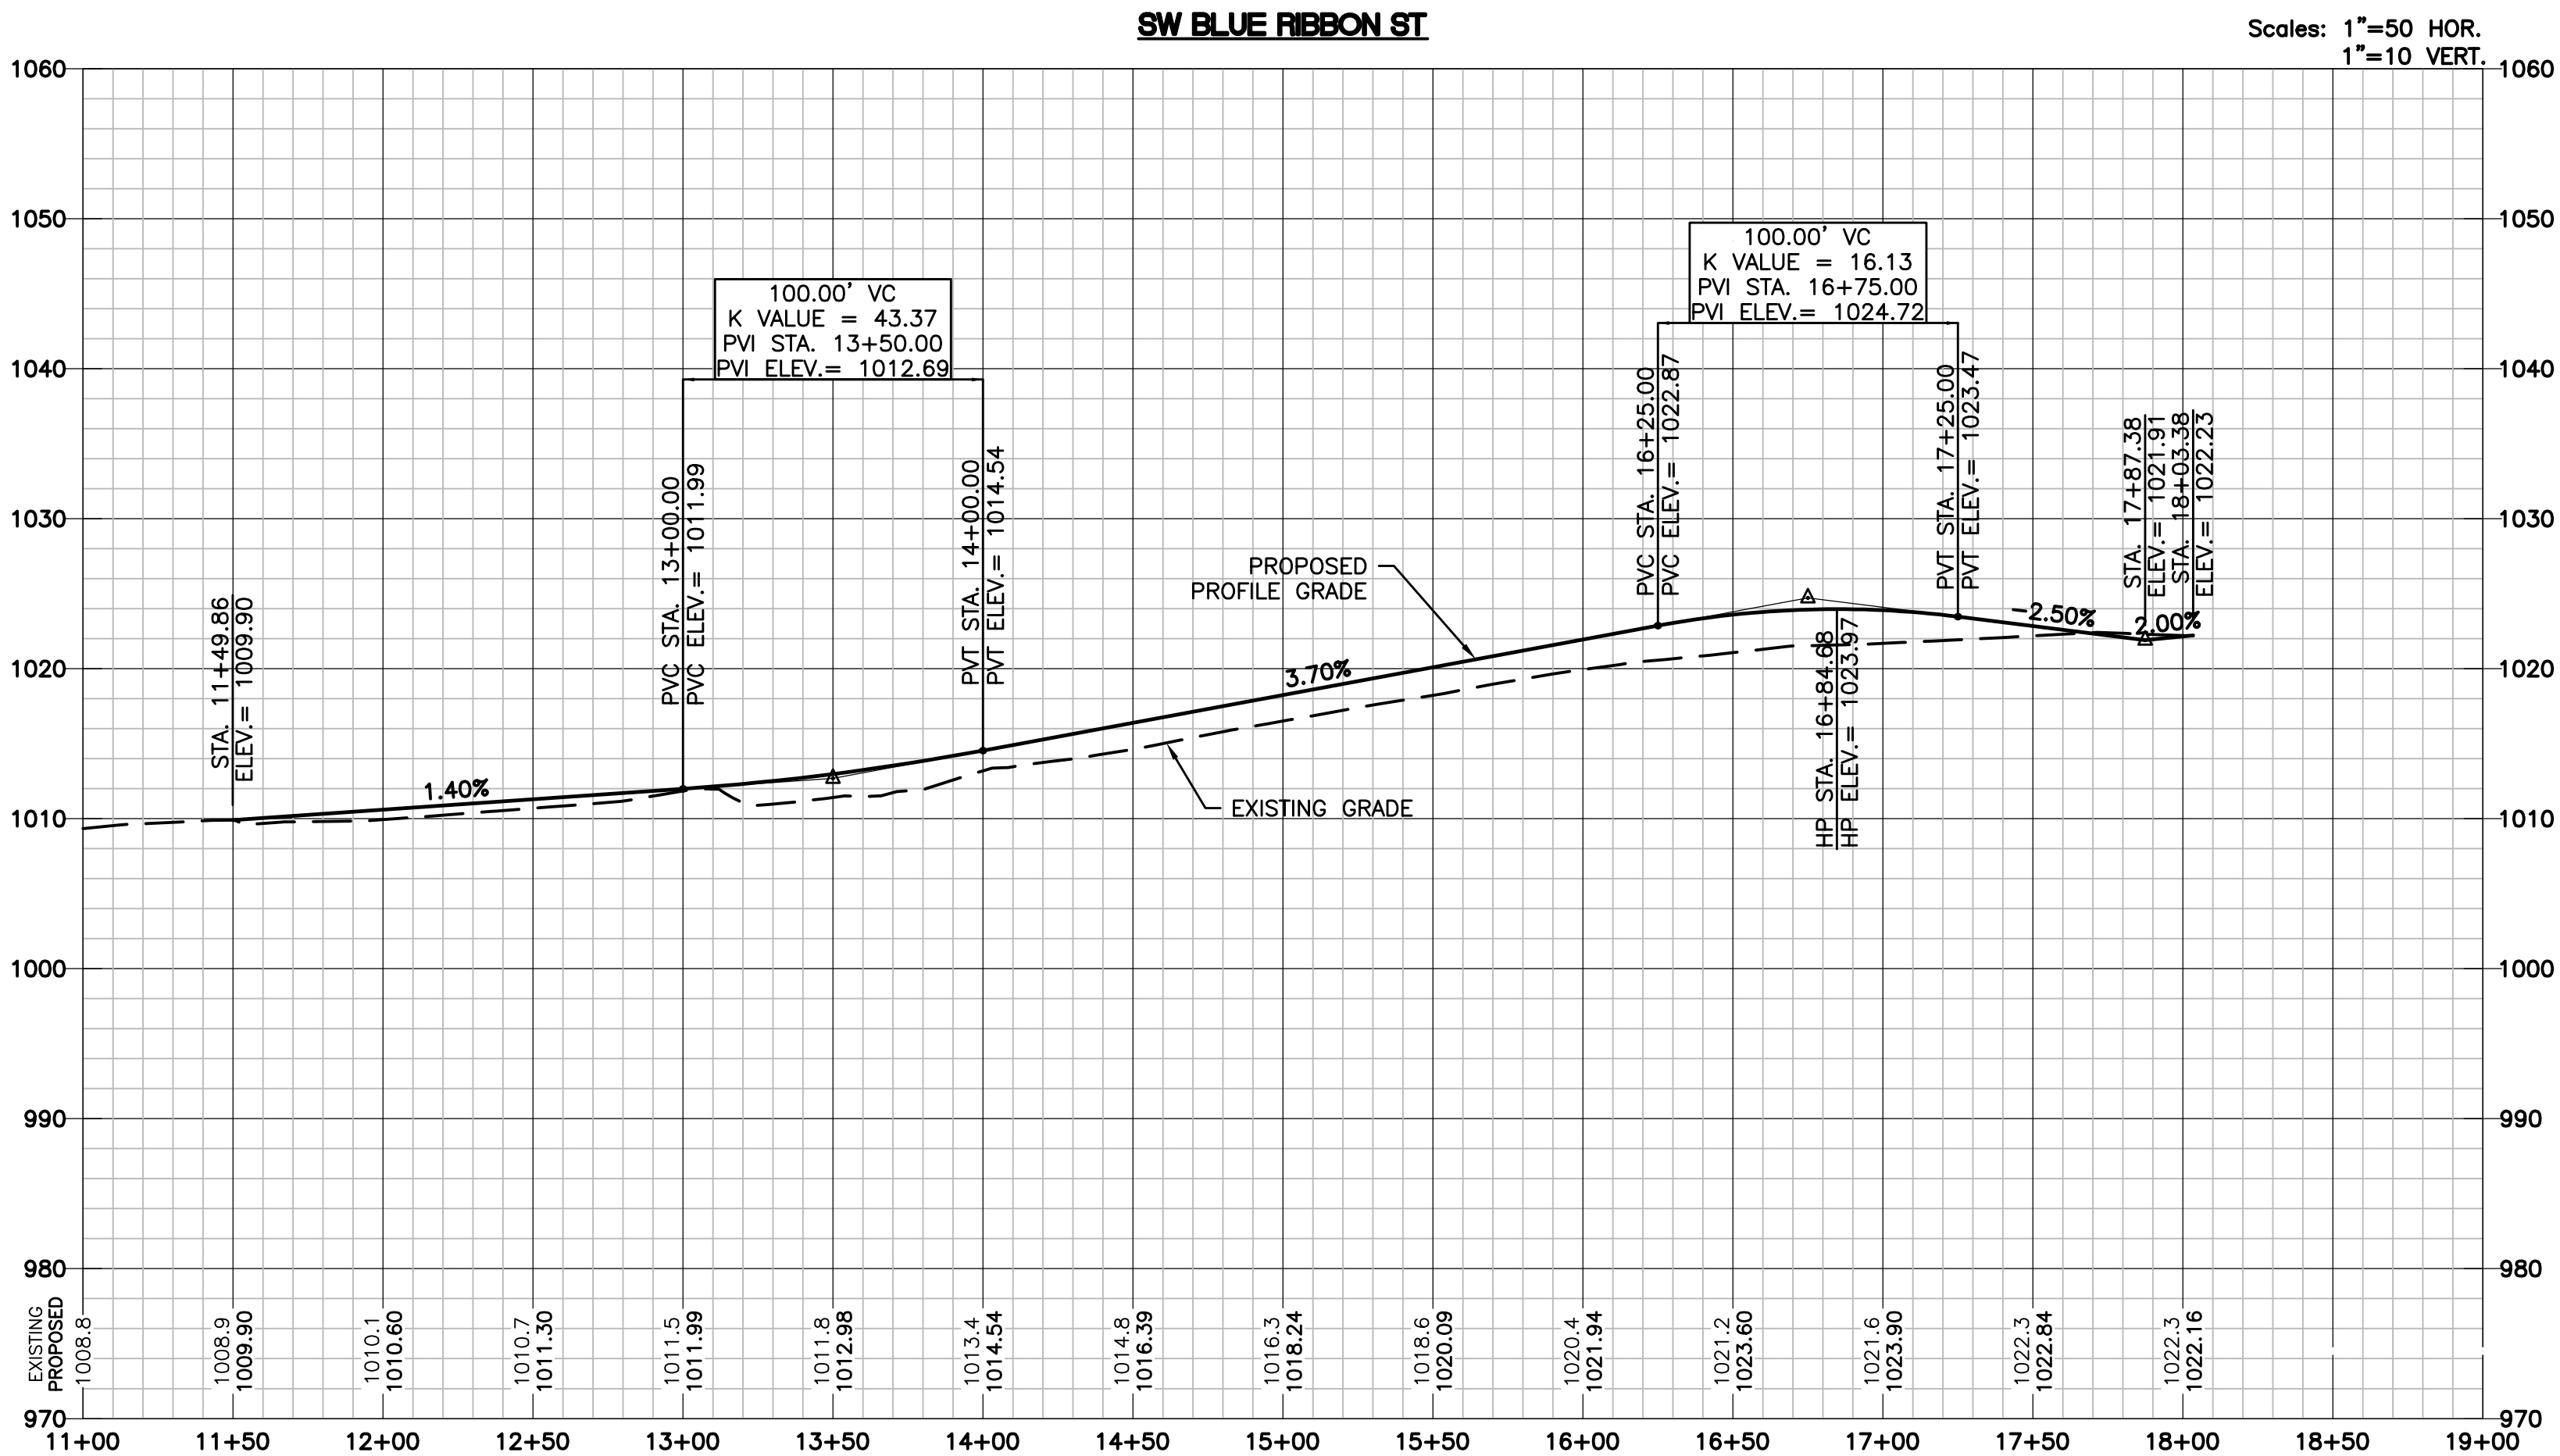
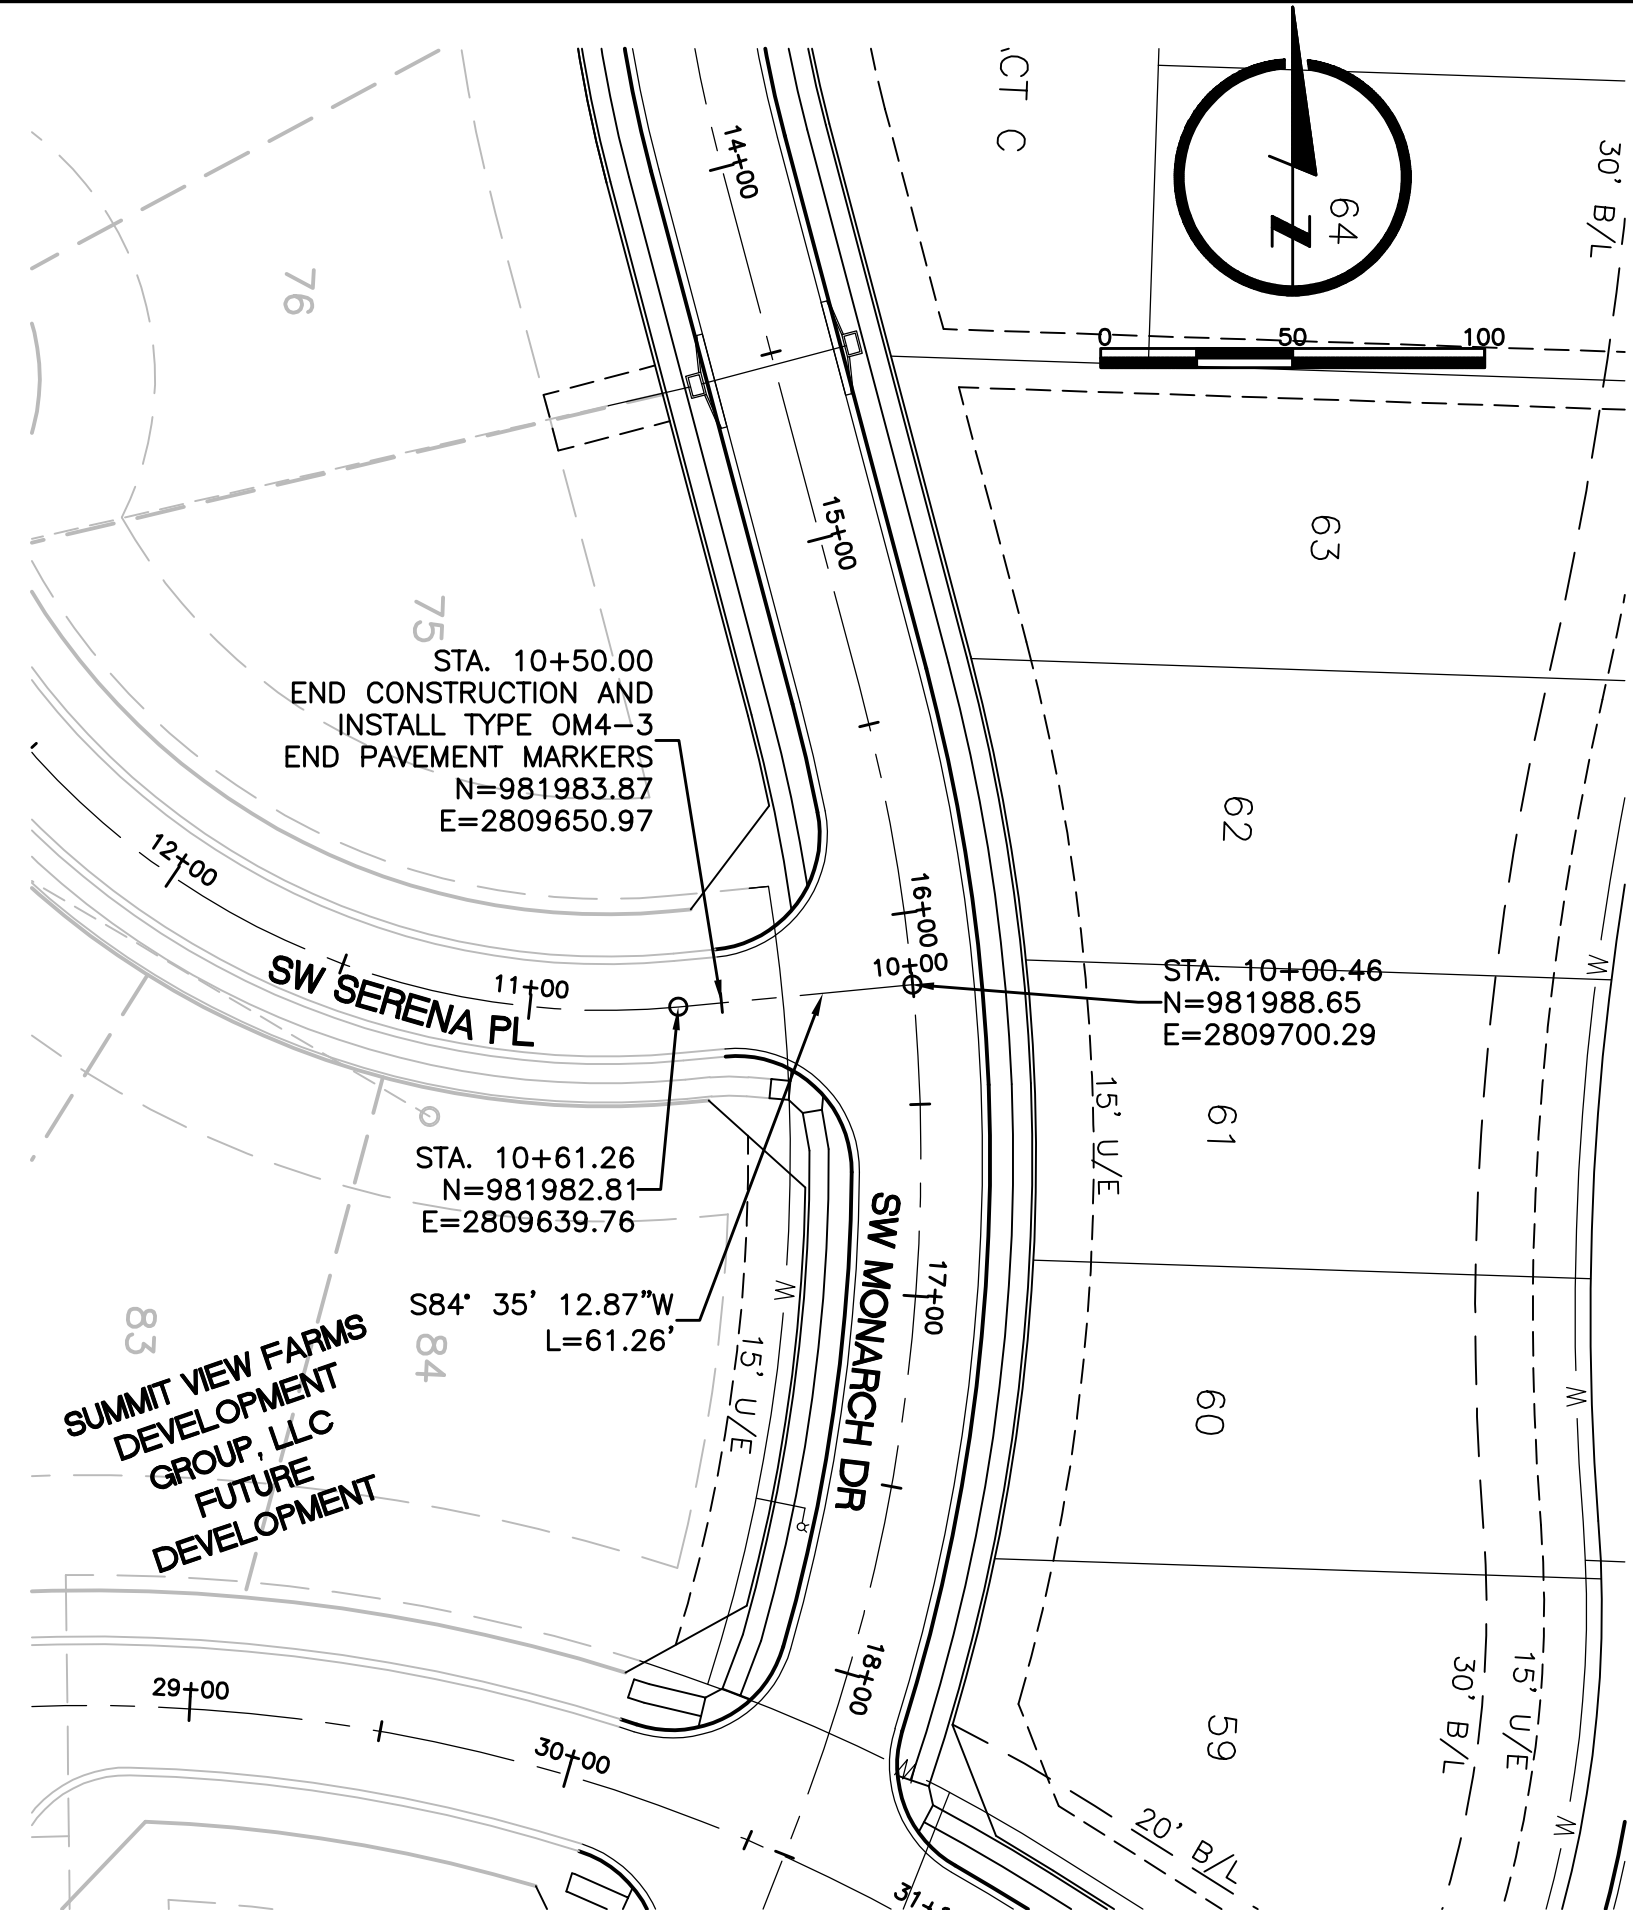


L:\Engineering\031850 SVFD Summit View Forms 3rd Plat\Drawings\CONSTRUCTION DRAWINGS\PAV-PLANS\PAV-PMP-02.dwg, 7/20/2018 9:16:39 AM, JAMIE MCURRY, LAMP RYNEARSON & ASSOCIATES

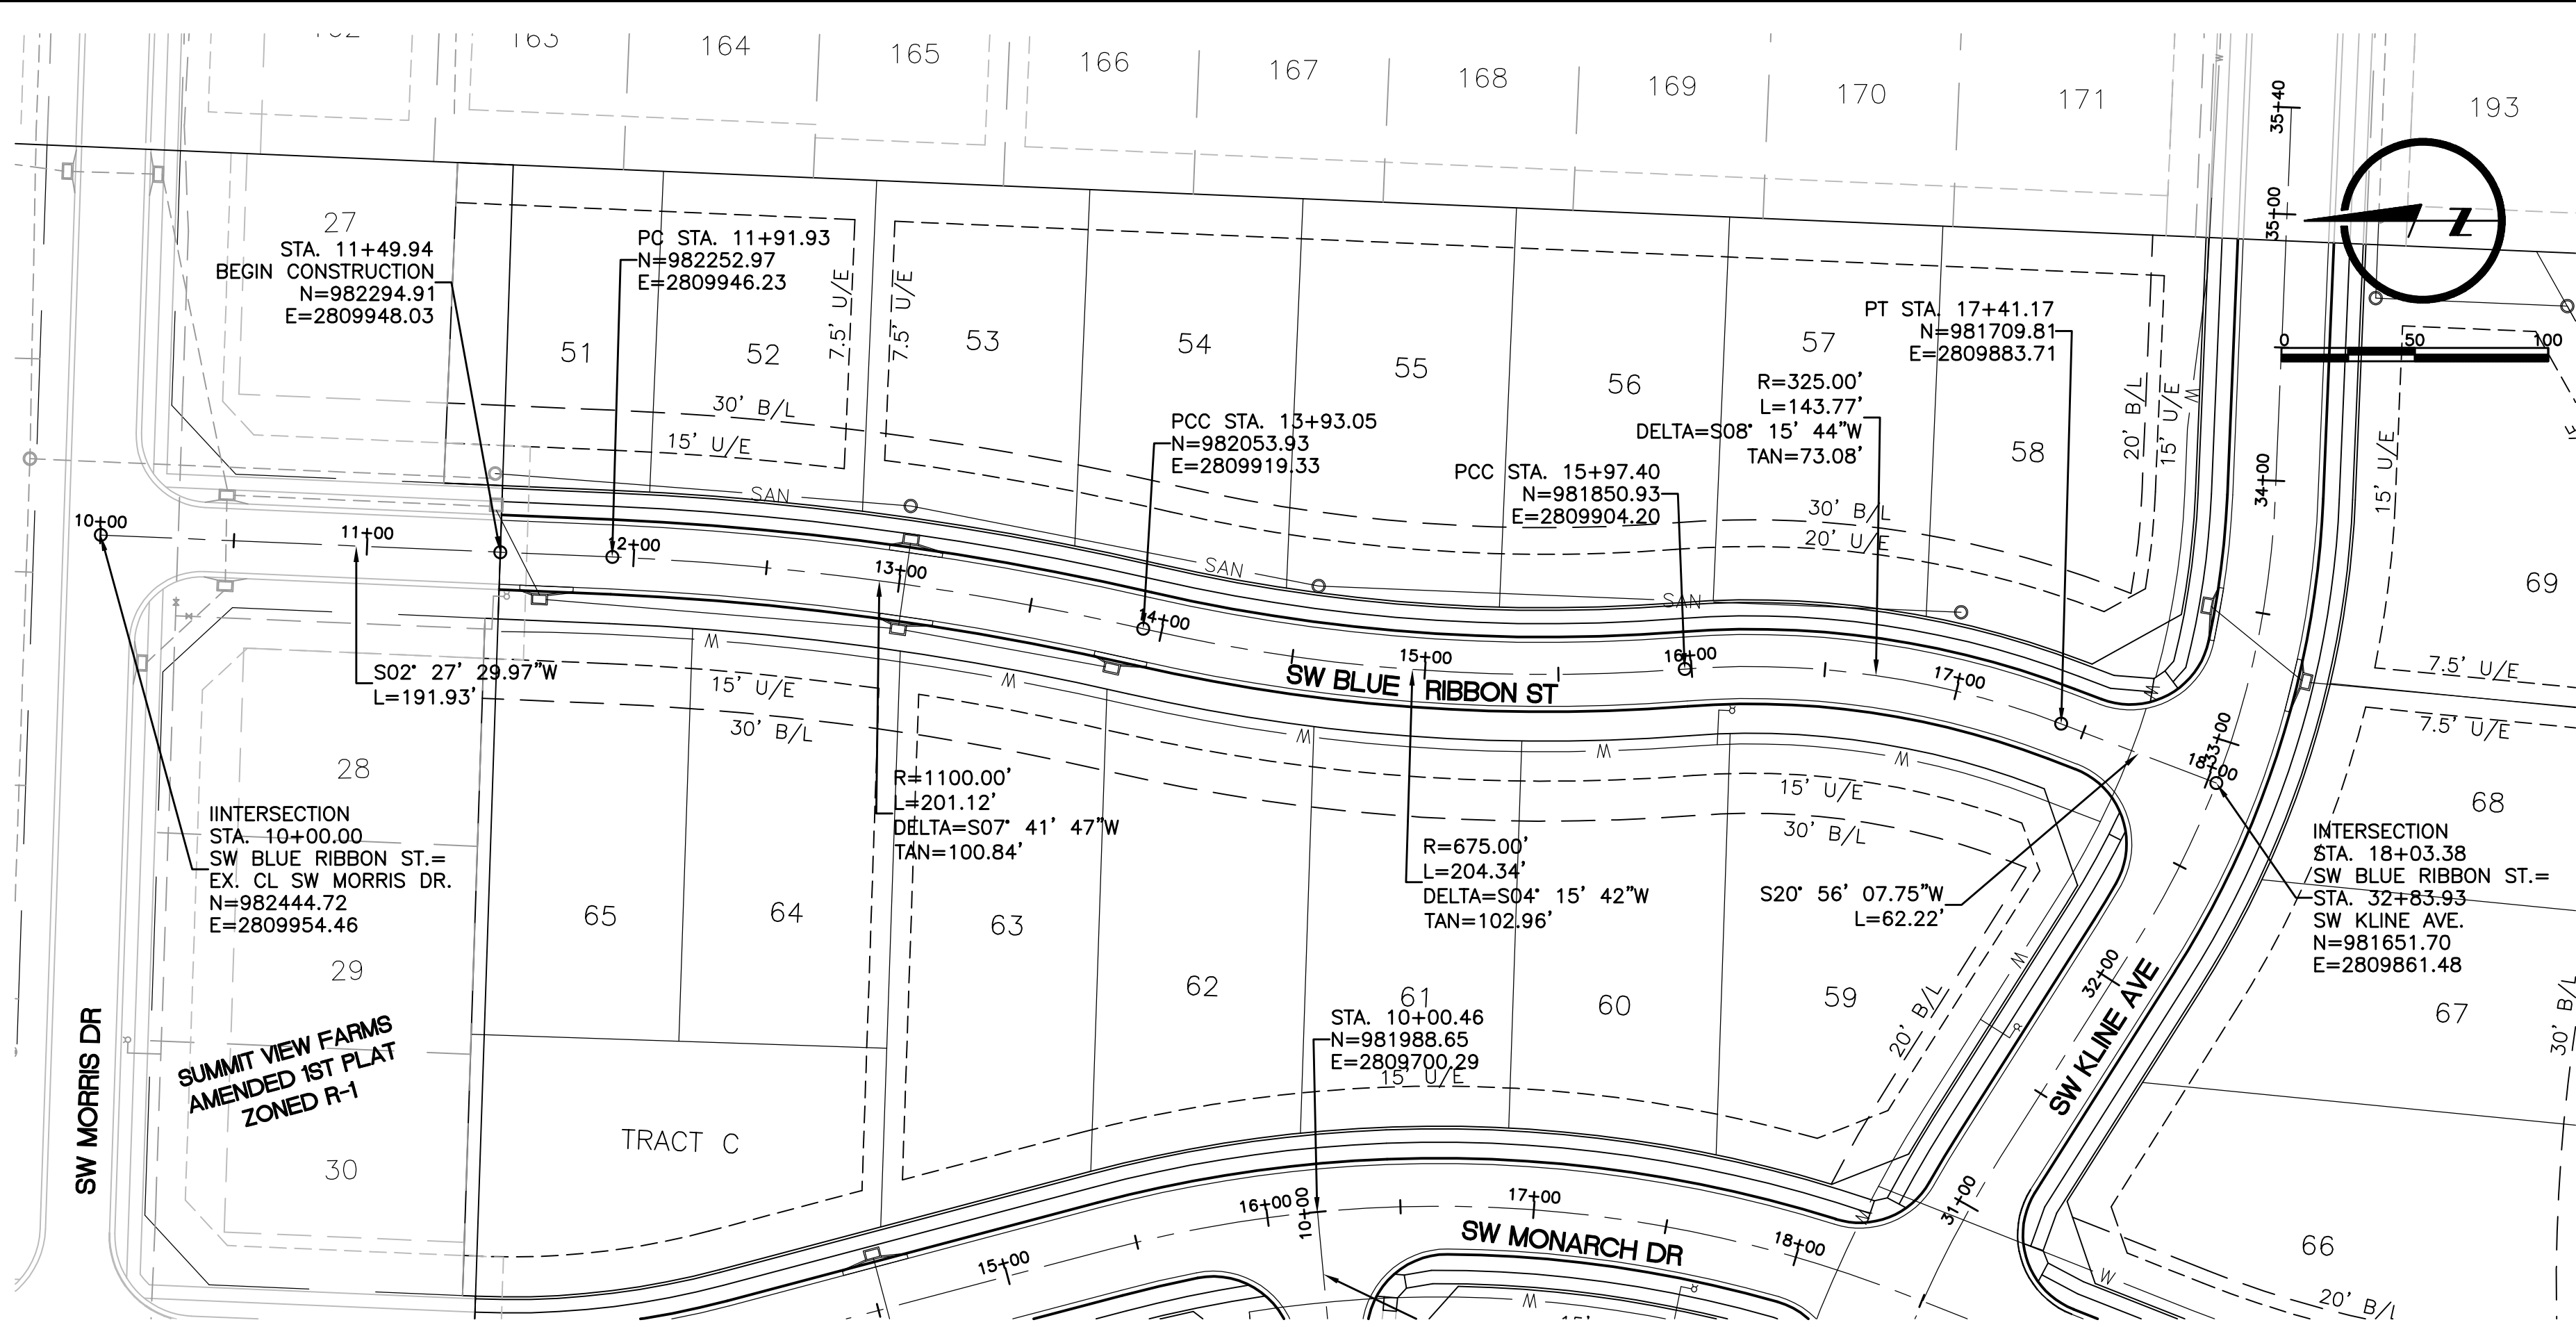

DRAWN BY		DESIGNED BY		DATE		JOB NUMBER-TASKS		BOOK AND PAGE	
JAM		MDM		JULY 20, 2018		031850.01			

LAMP RYNEARSON		SUMMIT VIEW FARMS 3RD PLAT		LEE'S SUMMIT, MISSOURI	
9001 State Line Rd., Suite 200 Kansas City, Missouri 64114 www.LRA-inc.com					

PAVING, STORM AND SANITARY PLANS		SW BLUE RIBBON STREET		STREET PLAN/PROFILE SHEET	
LARKIN LAMP RYNEARSON - ENGINEERS					
MO Certificate of Authority No. 2013011903					
FOR REVIEW					
NOT RELEASED FOR CONSTRUCTION					
MARK DANIEL MCGHEE JR.					
PE - 2008019568					
SHEET					
06 OF 18					